



AIA® Document G731™ – 2019

Change Order, Construction Manager as Adviser Edition

PROJECT: <i>(name and address)</i> Christian County High School 5185 Fort Campbell Blvd Hopkinsville, KY 42240	CONTRACT INFORMATION: Contract For: BP 030-01 (PO) - General Trades Date: September 08, 2023	CHANGE ORDER INFORMATION: Change Order Number: 006 Date: February 9, 2024
OWNER: <i>(name and address)</i> Christian County Board of Education 200 Glass Avenue Hopkinsville, KY 42240	ARCHITECT: <i>(name and address)</i> Hafer PSC 21 Southeast Third St, Ste 800 Evansville, IN 47708	CONSTRUCTION MANAGER: <i>(name and address)</i> Alliance Corporation 116 E. College Street Glasgow, KY 42141
CONTRACTOR: <i>(name and address)</i> Architectural Sales 600 N. 6th Avenue Evansville, IN 47706		

THE CONTRACT IS CHANGED AS FOLLOWS:

(Insert a detailed description of the change and, if applicable, attach or reference specific exhibits. Also include agreed upon adjustments attributable to executed Construction Change Directives.)

Deduct coiling tornado door from purchase order.

The original Contract Sum was	\$ 287,985.00
Net change by previously authorized Change Orders	\$ 0.00
The Contract Sum prior to this Change Order was	\$ 287,985.00
The Contract Sum will be decreased by this Change Order in the amount of	\$ 49,785.00
The new Contract Sum including this Change Order will be	\$ 238,200.00

The Contract Time will be unchanged by Zero (0) days.
The Contractor's Work shall be substantially complete on .

NOTE: This Change Order does not include adjustments to the Contract Sum or Guaranteed Maximum Price, or the Contract Time, that have been authorized by Construction Change Directive until the cost and time have been agreed upon by both the Owner and Contractor, in which case a Change Order is executed to supersede the Construction Change Directive.

NOT VALID UNTIL SIGNED BY THE ARCHITECT, CONSTRUCTION MANAGER, CONTRACTOR, AND OWNER.

Hafer PSC ARCHITECT <i>(Firm name)</i>	Alliance Corporation CONSTRUCTION MANAGER <i>(Firm name)</i>
SIGNATURE Eric Rang, AIA, Senior Associate PRINTED NAME AND TITLE	SIGNATURE Kevin Hitchel, Sr. Project Manager PRINTED NAME AND TITLE
DATE:	DATE:
Architectural Sales CONTRACTOR <i>(Firm name)</i>	Christian County Board of Education OWNER <i>(Firm name)</i>
SIGNATURE Herb Carr PRINTED NAME AND TITLE	SIGNATURE Christopher Bentzel, Superintendent PRINTED NAME AND TITLE
DATE:	DATE:



PROPOSED CHANGE ORDER

PROJECT Christian County High School

CONTRACTOR/SUPPLIER Architectural Sales

BID PACKAGE 030 (PO)

DETAIL ITEM	AMOUNT
LABOR	
MATERIALS	\$ (49,785.00)
PROFIT & OVERHEAD	
BOND INSURANCE	
COST BREAKDOWN TOTAL	\$ (49,785.00)

DESCRIPTION

Deduct Coiling Tornado Door from Purchase Order.

PR # 1 (ATTACH PR)

CHANGE ORDER INITIATED BY:

☒ ARCHITECT/ENGINEER

_____ OWNER

_____ CONTRACTOR

_____ CM

_____ CODE OFFICIAL

_____ OTHER _____

PLEASE INCLUDE THIS FORM WITH EVERY
CHANGE ORDER.

PROPOSAL REQUEST

Project:	Christian County High School 5185 Ft. Campbell Blvd Hopkinsville, KY 42240	PR No.:	001
		Date:	October 13, 2023
Owner:	Christian County Public Schools 222 Glass Ave Hopkinsville, KY 42240	Project Number:	2106-204
		Contract for:	
To:	Tim Geegan Alliance Corporation 116 E. College Steet Glasgow, KY 42141		
RE:	State Required Egress Door Modifications, Misc Door Changes and Minor structural clarifications.		

Please submit an itemized quotation for changes in the Contract Sum and/or Time incidental to proposed modifications to the Contract Documents described herein. THIS IS NOT A CHANGE ORDER NOR A DIRECTION TO PROCEED WITH THE WORK DESCRIBED HEREIN.

Description:


- 1) At Gymnasium B106, add opening B101.09 as shown on attached plans and details and add electrical items as indicated.
- 2) At Gymnasium B106, add opening B101.10 as shown on attached plans and details. Modify concrete portal to accommodate door and add electrical items as indicated.
- 3) At Entry C100C, delete overhead coiling fire-rated tornado door C100C. Add openings C100C.2 and C100C.3 s shown on attached plans and details. Modify concrete portal to accommodate doors. Construct brick wing walls as shown for magnetic hold opens.
- 4) At Corridor B100C, add opening B100D to frame W51 as shown on attached plans and details.
- 5) Change width of door D106 from 3'-0" to 3'-8".
- 6) Provide removable mullions in lieu of rods at exit devices at all pairs of doors in hardware sets #1, #2, #3, #4, #17, #36 & #37.
- 7) Provide removable mullions in lieu of rods at exit devices at doors A100J.2, C101.5 & C101.6 in hardware set #26.
- 8) At E1 & E3, modify openings E1 & E2 to be a pair of exterior doors as shown on attached plans and elevations and details. Modify frame W7 at these openings only to be W7.1.
- 9) See Details 2/PR-1S1, 1/PR-1S3, 1/PR-1S6, 1/PR-1S7, 1/PR-1S9, 1/PR-1S10 for clarification on footing requirements.

- 10) See 1/PR-1S5 for clarification on CMU wall height adjacent to CLs FF/F5
- 11) See 1/PR-1S8 for Area G lintel clarification.

Attachments: PR-1A1 to 1A9;
PR-1S1 to 1S16;
PR-1E1 to 1E15

By: Eric Rang

CC:

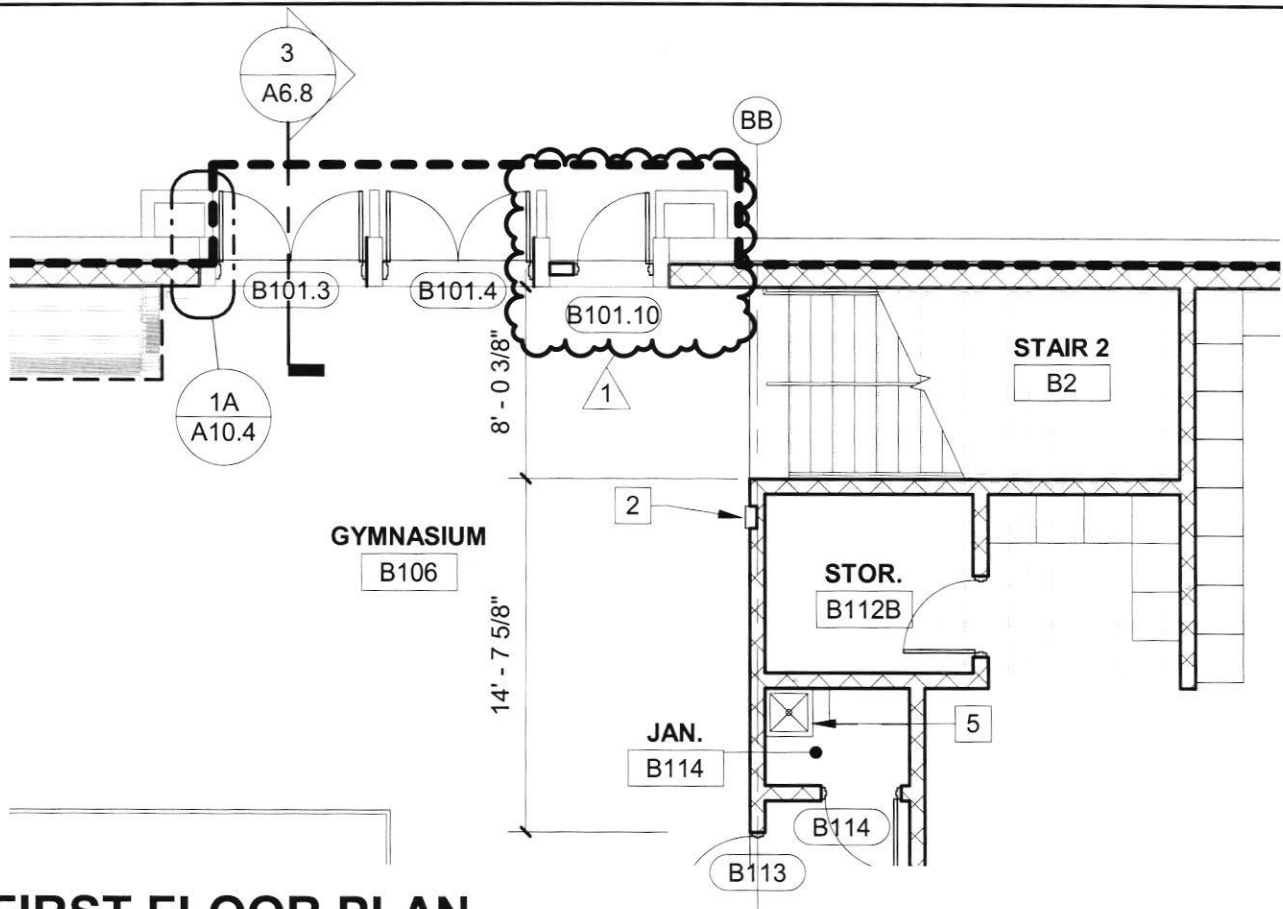


FIRST FLOOR PLAN

ORIGINAL DETAIL 1 / A1.1B Alt

1

1/8" = 1'-0"

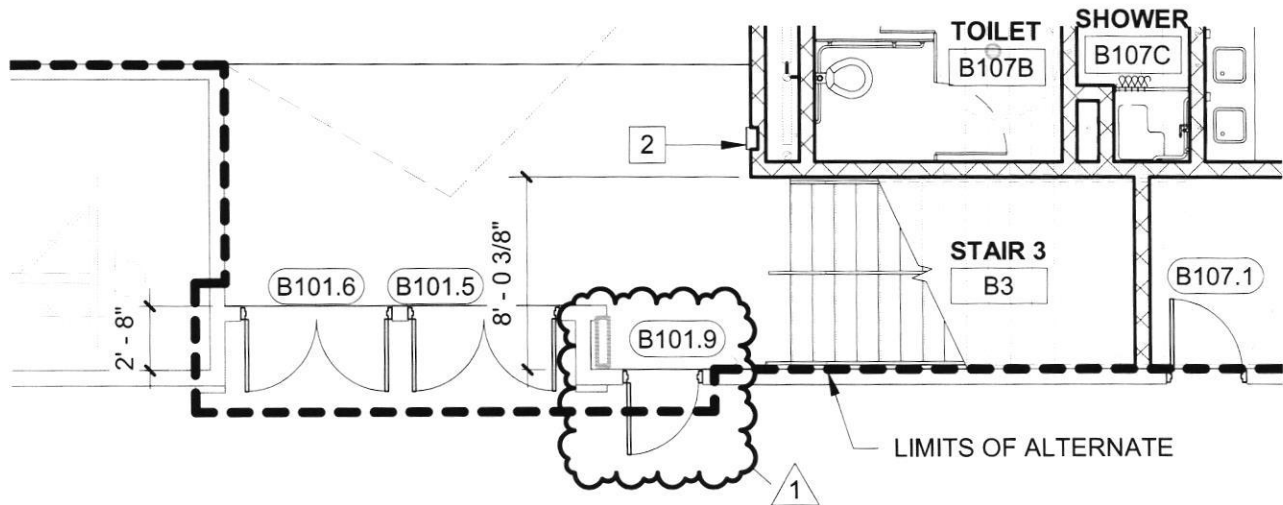

FIRST FLOOR PLAN

ORIGINAL DETAIL 1 / A1.1B Alt

2

1/8" = 1'-0"

HOPKINSVILLE - CHRISTIAN
COUNTY ACADEMY

KDE # : BG 22-104

5185 FT. CAMPBELL BLVD
HOPKINSVILLE, KY 42240

HAFER

architects • designers • engineers

21 SE Third Street,
Suite 800
Evansville, IN 47708

T: 812.422.4187
F: 812.421.6776
www.haferdesign.com

ARCHITECTS PROJECT NO.

2106-204

DATE:

10/05/2023

TYPE OF DRAWING NO.


PR-1A1

1 FIRST FLOOR PLAN - AREA C ORIGINAL DETAIL C / A1.1C

1/8" = 1'-0"

HOPKINSVILLE - CHRISTIAN COUNTY ACADEMY KDE # : BG 22-104 5185 FT. CAMPBELL BLVD HOPKINSVILLE, KY 42240	HAFER architects • designers • engineers 21 SE Third Street, Suite 800 Evansville, IN 47708 T: 812.422.4187 F: 812.421.6776 www.haferdesign.com	<table border="1" style="width: 100%; border-collapse: collapse;"> <tr> <td style="width: 50%;">ARCHITECTS PROJECT NO.</td><td style="width: 50%;">DATE:</td></tr> <tr> <td>2106-204</td><td>10/05/2023</td></tr> <tr> <td colspan="2">TYPE OF DRAWING NO.</td></tr> <tr> <td colspan="2" style="text-align: center; font-size: 2em;">PR-1A2</td></tr> </table>	ARCHITECTS PROJECT NO.	DATE:	2106-204	10/05/2023	TYPE OF DRAWING NO.		PR-1A2	
ARCHITECTS PROJECT NO.	DATE:									
2106-204	10/05/2023									
TYPE OF DRAWING NO.										
PR-1A2										

CORRIDOR
B100C

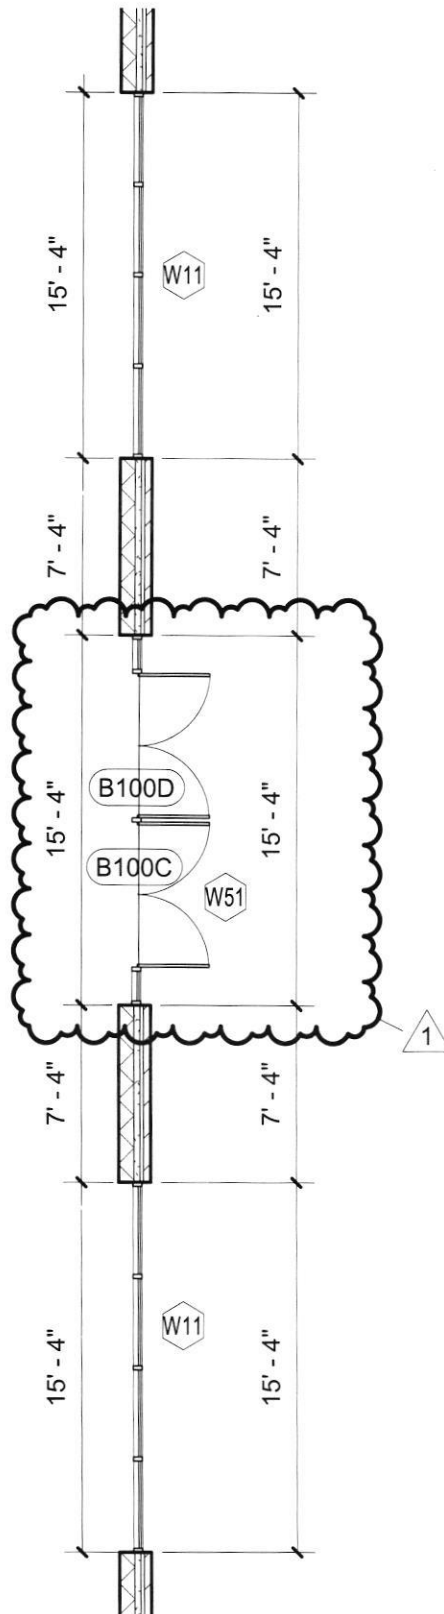

4 A4.8

1

FIRST FLOOR PLAN - AREA E

ORIGINAL DETAIL E / A1.1E

1/8" = 1'-0"

HOPKINSVILLE - CHRISTIAN
COUNTY ACADEMY

KDE # : BG 22-104

5185 FT. CAMPBELL BLVD
HOPKINSVILLE, KY 42240

HAFER
architects • designers • engineers

21 SE Third Street,
Suite 800
Evansville, IN 47708

T: 812.422.4187
F: 812.421.6776
www.haferdesign.com

ARCHITECTS PROJECT NO.


2106-204

DATE:

10/05/2023

TYPE OF DRAWING NO.

PR-1A3

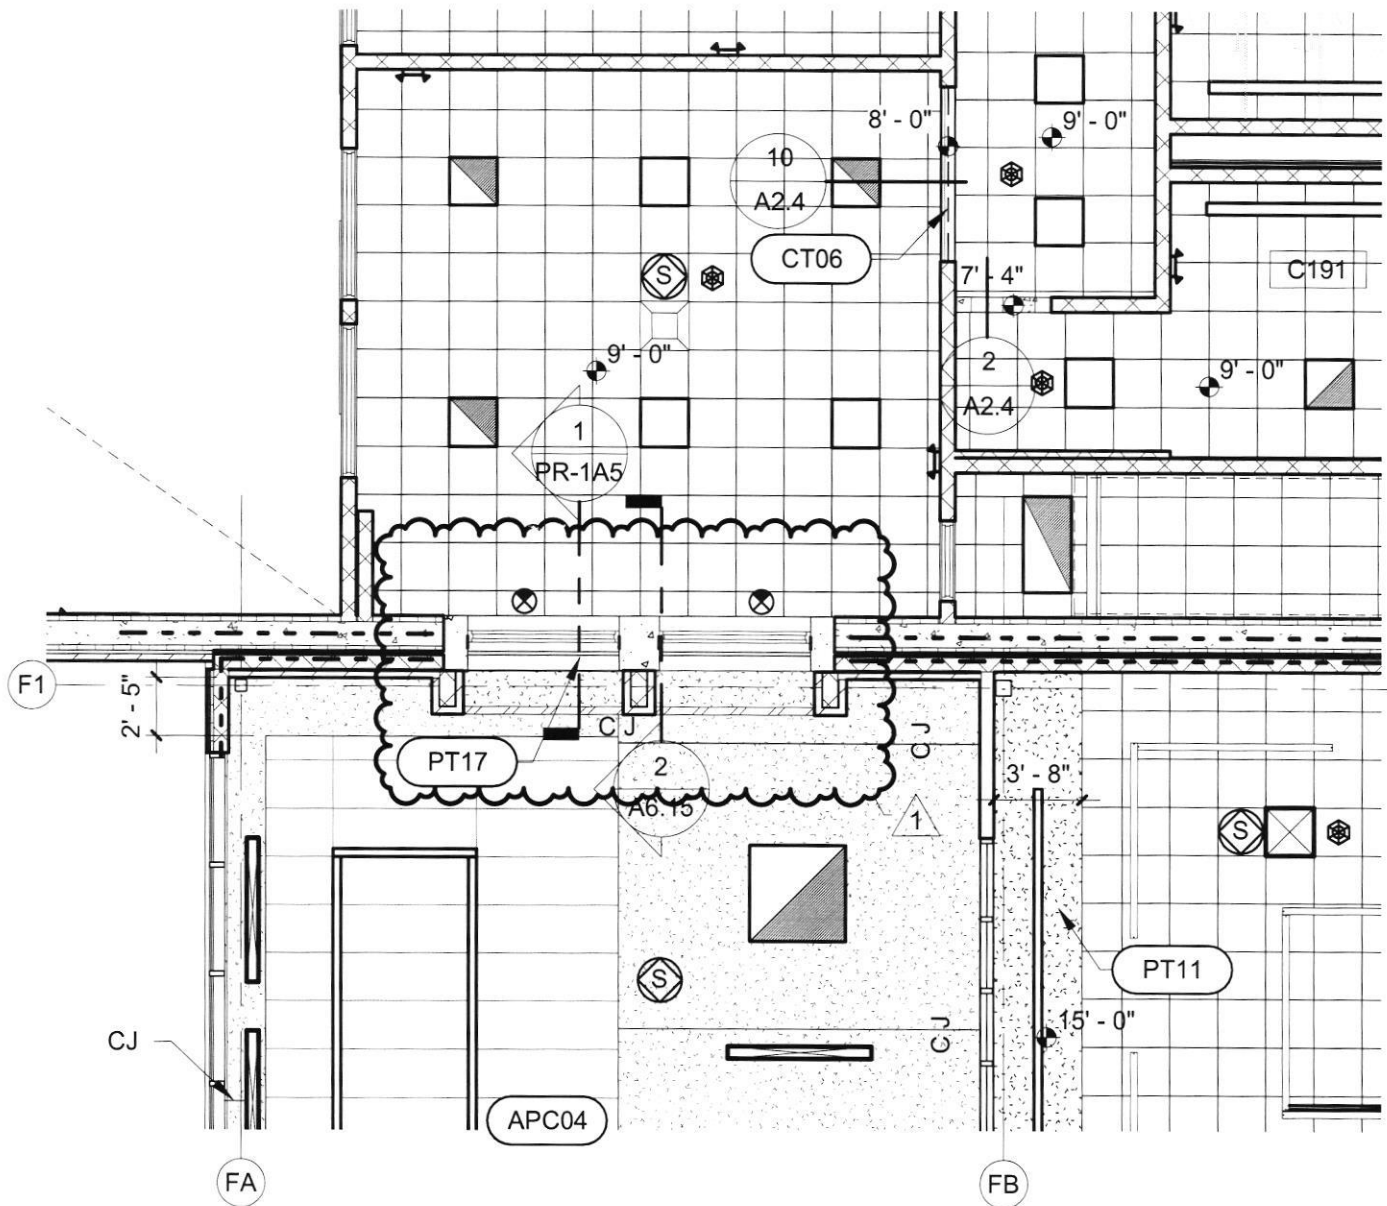

1 FIRST FLOOR REFLECTED CEILING PLAN - AREA C

1/8" = 1'-0"

ORIGINAL DETAIL A / A2.1C

HOPKINSVILLE - CHRISTIAN
COUNTY ACADEMY

KDE # : BG 22-104

5185 FT. CAMPBELL BLVD
HOPKINSVILLE, KY 42240

HA FER
architects • designers • engineers

21 SE Third Street,
Suite 800
Evansville, IN 47708

T: 812.422.4187
F: 812.421.6776
www.haferdesign.com

ARCHITECTS PROJECT NO.


2106-204

DATE:

10/05/2023

TYPE OF DRAWING NO.

PR-1A4

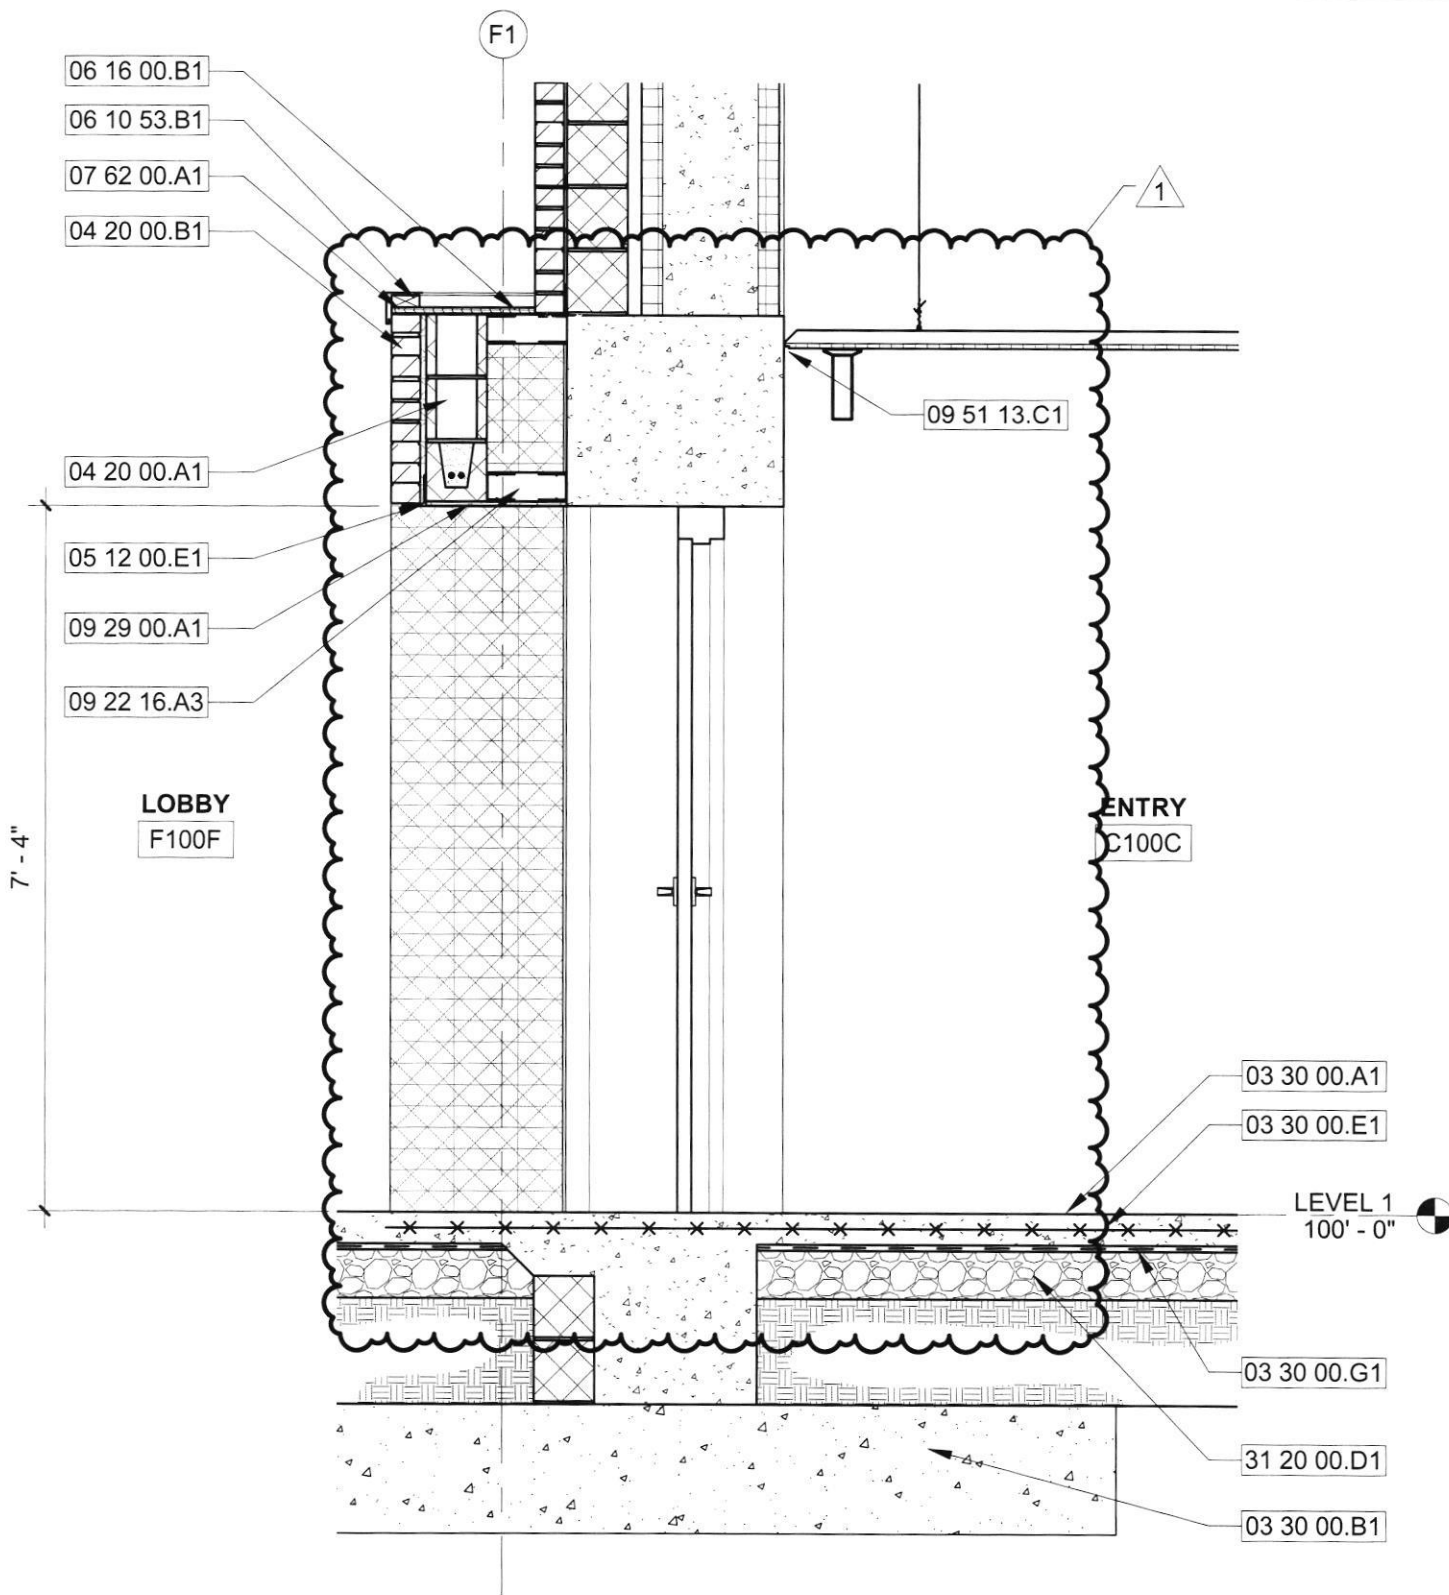

WALL SECTION

ORIGINAL DETAIL 2 / A6.15

1

1/2" = 1'-0"

HOPKINSVILLE - CHRISTIAN
COUNTY ACADEMY

KDE # : BG 22-104

5185 FT. CAMPBELL BLVD
HOPKINSVILLE, KY 42240

HAFER

architects • designers • engineers

21 SE Third Street,
Suite 800
Evansville, IN 47708

T: 812.422.4187
F: 812.421.6776
www.haferdesign.com

ARCHITECTS PROJECT NO.

2106-204


DATE:

10/05/2023

TYPE OF DRAWING NO.

PR-1A5

REFERENCE SHEETS S2.1A & S2.1B ALT

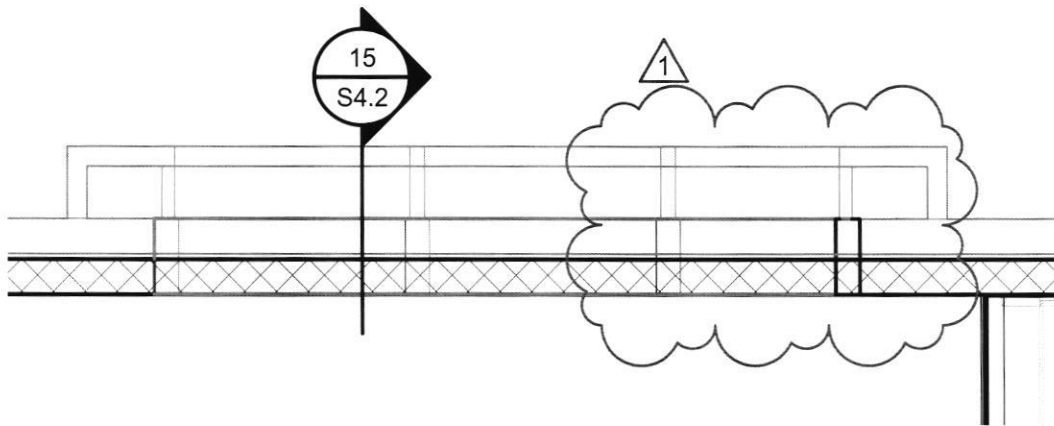

1 LEVEL 2 FRAMING PLAN - AREA A
SCALE: 3/16" = 1'-0"

PLAN NORTH



HOPKINSVILLE - CHRISTIAN
COUNTY ACADEMY

KDE # : BG 22-104

5185 FT. CAMPBELL BLVD
HOPKINSVILLE, KY 42240

HAFER
architects • designers • engineers

21 SE Third Street,
Suite 800
Evansville, IN 47708

T: 812.422.4187
F: 812.421.6776
www.haferdesign.com

ARCHITECTS PROJECT NO.


2106-204

DATE:

10/13/23


TYPE OF DRAWING NO.

PR-1S2

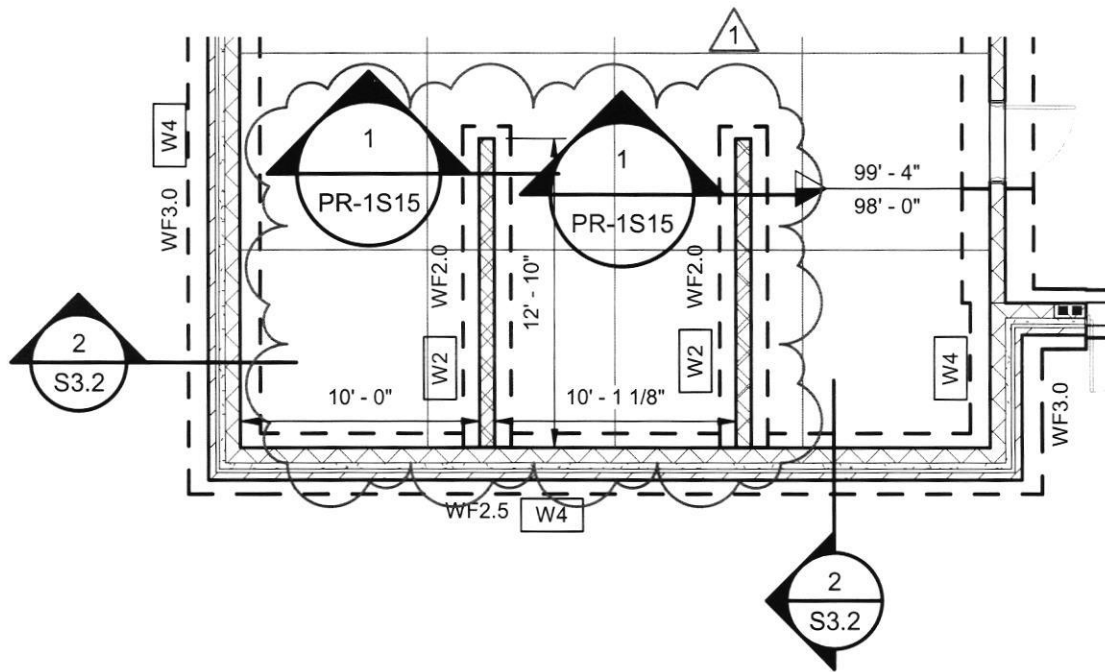

1 FOUNDATION PLAN - AREA G
SCALE: 1/8" = 1'-0"

PLAN NORTH

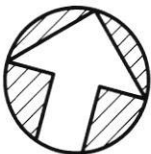

HOPKINSVILLE - CHRISTIAN
COUNTY ACADEMY

KDE # : BG 22-104

5185 FT. CAMPBELL BLVD
HOPKINSVILLE, KY 42240

HAFER
architects • designers • engineers

21 SE Third Street,
Suite 800
Evansville, IN 47708

T: 812.422.4187
F: 812.421.6776
www.haferdesign.com

ARCHITECTS PROJECT NO.


2106-204

DATE:

10/13/23

TYPE OF DRAWING NO.


PR-1S6

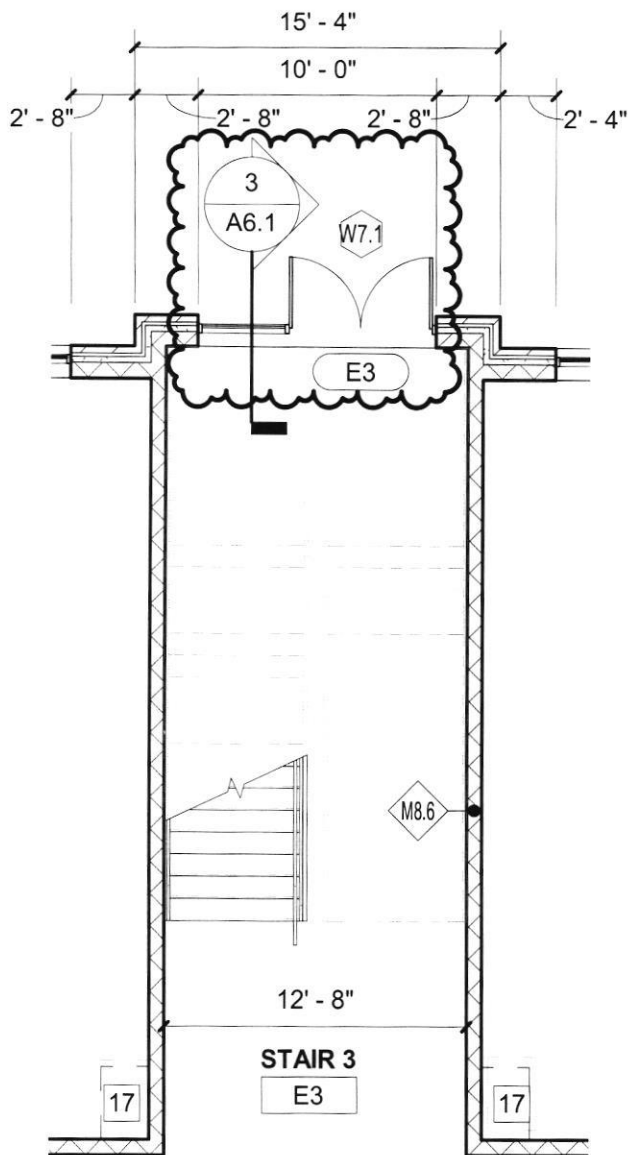

1 FIRST FLOOR PLAN

1/8" = 1'-0"

ORIGINAL DETAIL E / A1.1E

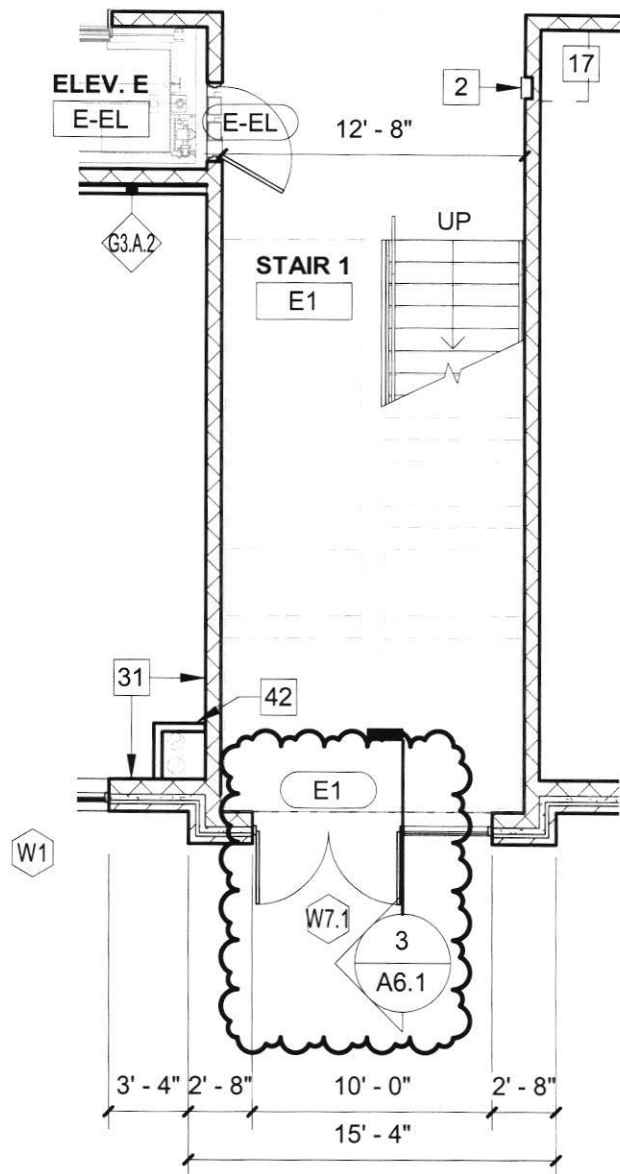

2 FIRST FLOOR PLAN

1/8" = 1'-0"

ORIGINAL DETAIL E / A1.1E

HOPKINSVILLE - CHRISTIAN
COUNTY ACADEMY

KDE # : BG 22-104

5185 FT. CAMPBELL BLVD
HOPKINSVILLE, KY 42240

HAFER
architects • designers • engineers

21 SE Third Street,
Suite 800
Evansville, IN 47708

T: 812.422.4187
F: 812.421.6776
www.haferdesign.com

ARCHITECTS PROJECT NO.

2106-204


DATE:

10/05/2023


TYPE OF DRAWING NO.

PR-1A6

REFERENCE SHEETS S1.1A, S1.1B, & S1.1B ALT

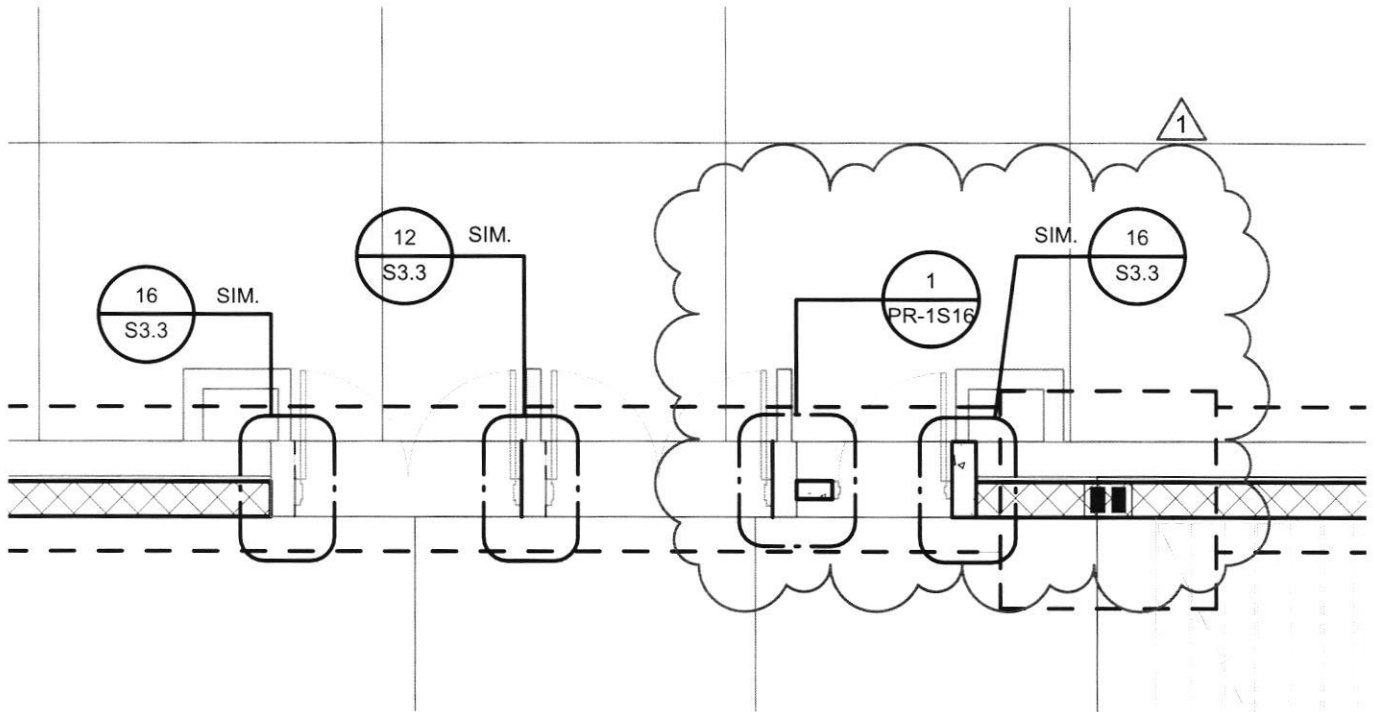

1 FOUNDATION PLAN - AREA A
SCALE: 3/16" = 1'-0"

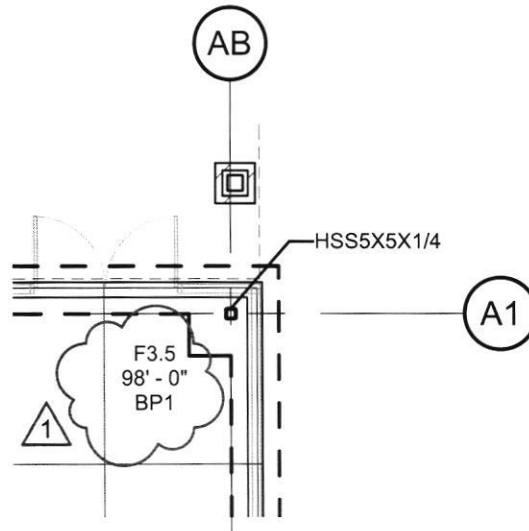

PLAN NORTH



2 FOUNDATION PLAN - AREA A
SCALE: 1/8" = 1'-0"

HOPKINSVILLE - CHRISTIAN
COUNTY ACADEMY

KDE # : BG 22-104

5185 FT. CAMPBELL BLVD
HOPKINSVILLE, KY 42240

HAFER
architects • designers • engineers

21 SE Third Street,
Suite 800
Evansville, IN 47708

T: 812.422.4187
F: 812.421.6776
www.haferdesign.com

ARCHITECTS PROJECT NO.

2106-204


DATE:

10/13/23

TYPE OF DRAWING NO.

PR-1S1

REFERENCE SHEET S1.1C

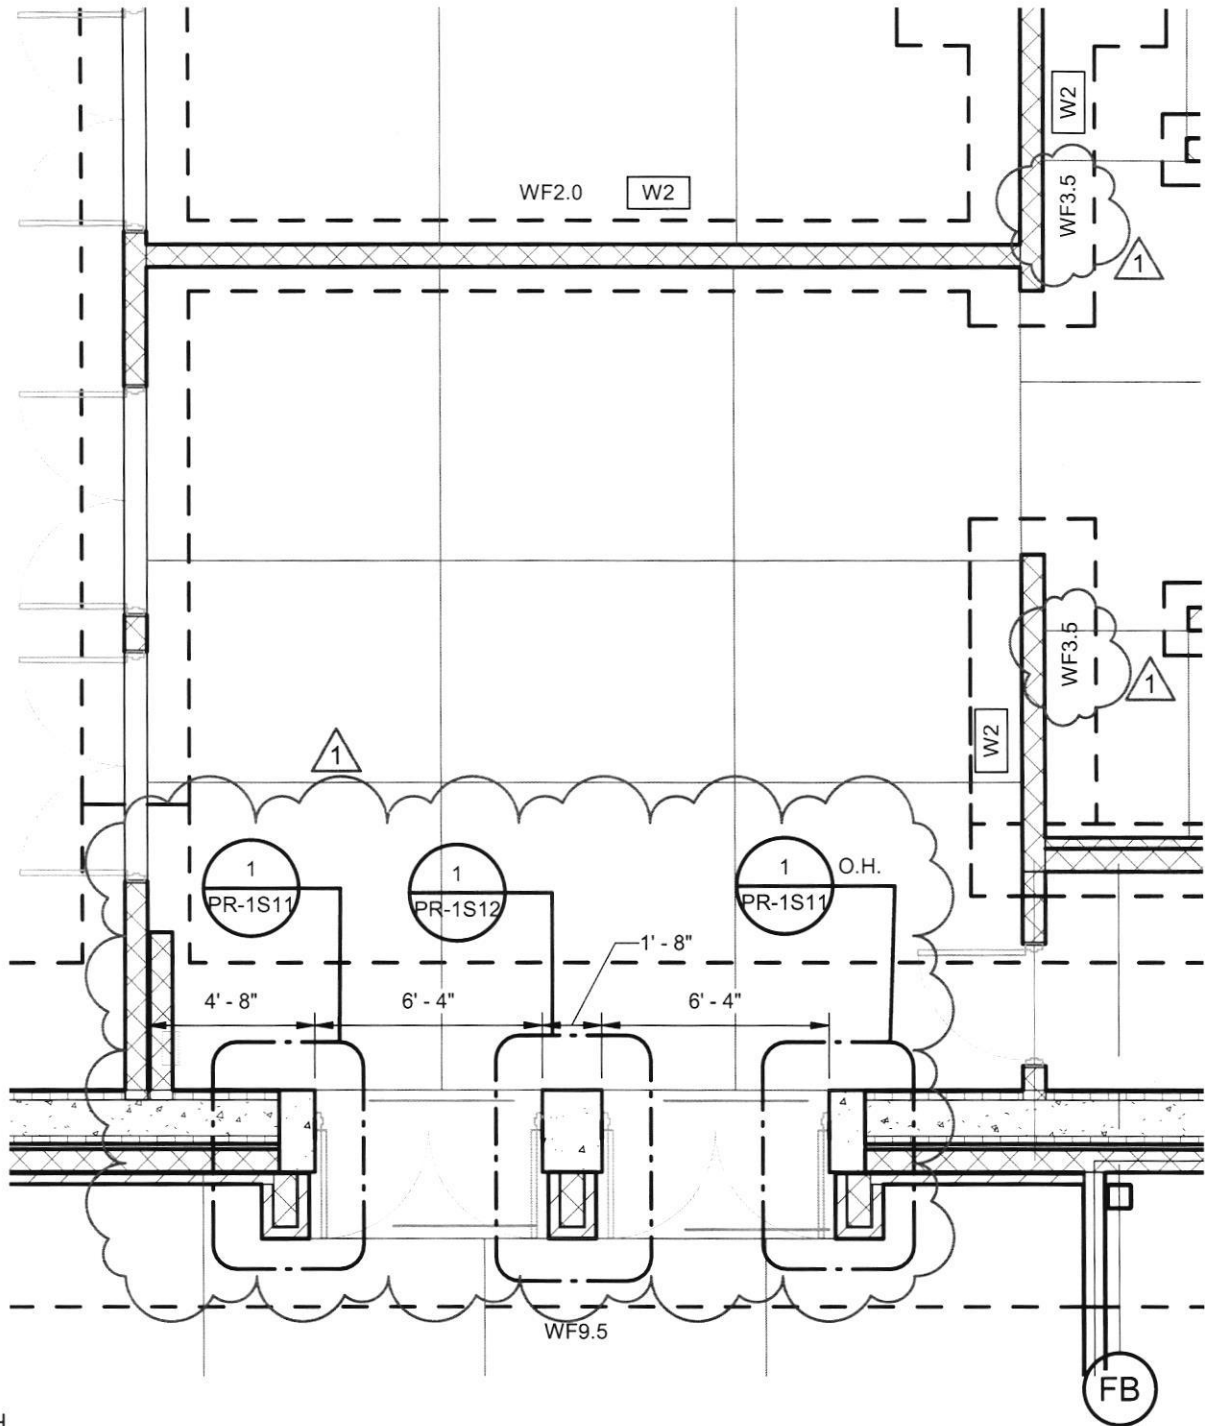

PLAN NORTH



1 FOUNDATION PLAN - AREA C

SCALE: 3/16" = 1'-0"

HOPKINSVILLE - CHRISTIAN
COUNTY ACADEMY

KDE # : BG 22-104

5185 FT. CAMPBELL BLVD
HOPKINSVILLE, KY 42240

HAFER

architects • designers • engineers

21 SE Third Street,
Suite 800
Evansville, IN 47708

T: 812.422.4187
F: 812.421.6776
www.haferdesign.com

ARCHITECTS PROJECT NO.


2106-204

DATE:

10/13/23

TYPE OF DRAWING NO.

PR-1S3

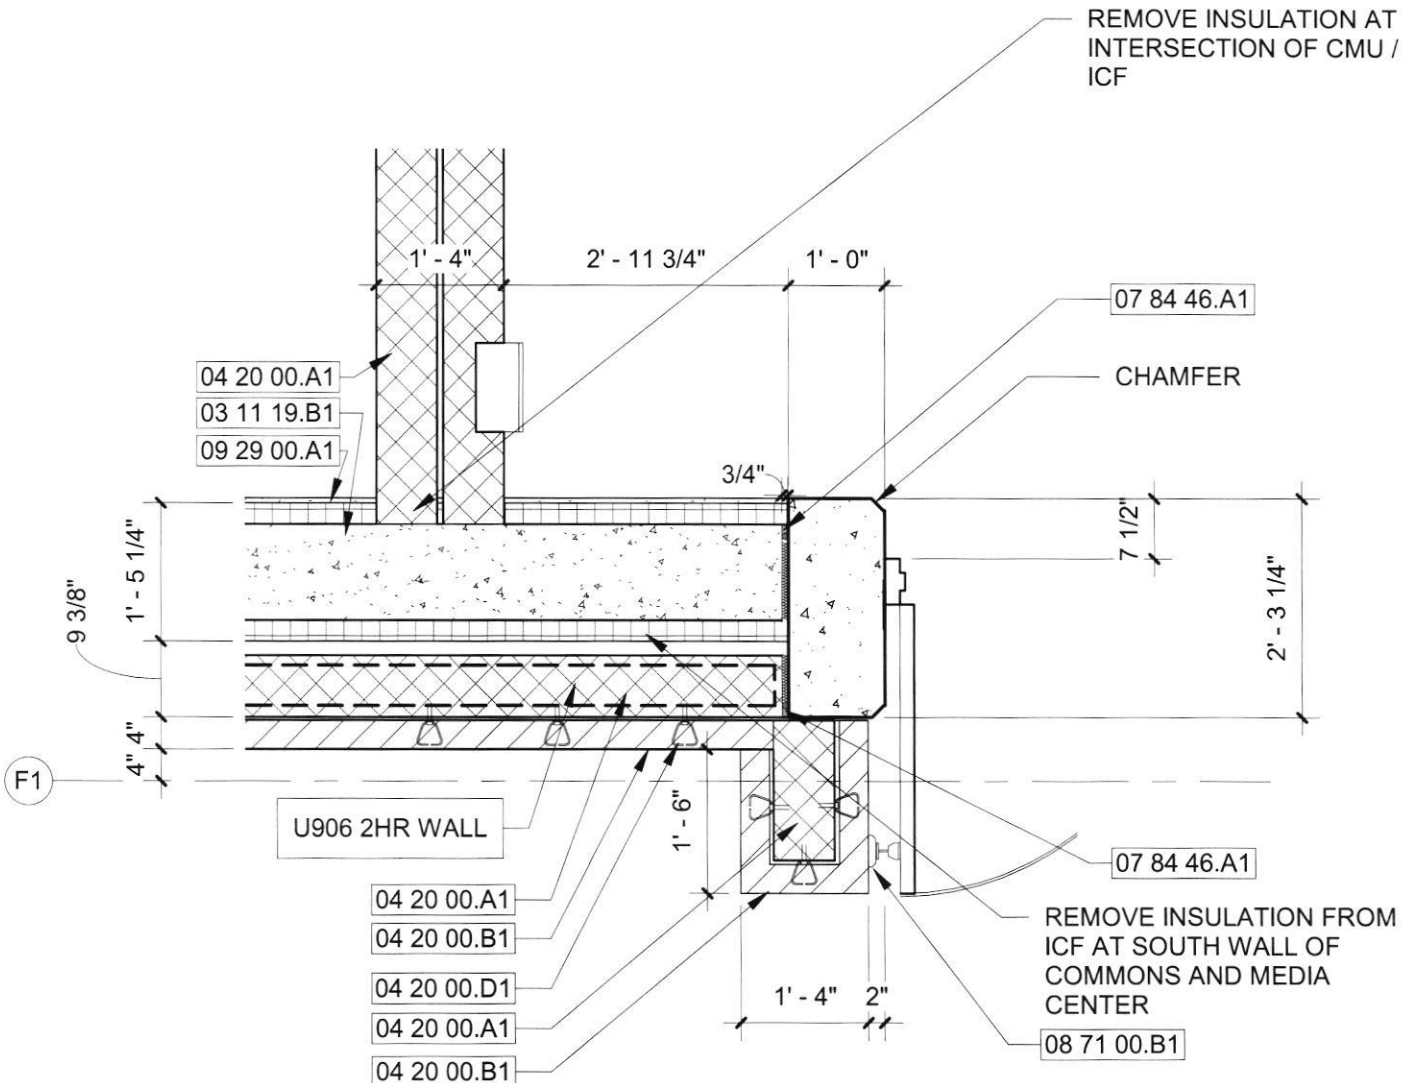

PLAN DETAIL

ORIGINAL DETAIL 7 / A10.2

1

1/2" = 1'-0"

HOPKINSVILLE - CHRISTIAN
COUNTY ACADEMY

KDE # : BG 22-104

5185 FT. CAMPBELL BLVD
HOPKINSVILLE, KY 42240

HAFER
architects • designers • engineers

21 SE Third Street,
Suite 800
Evansville, IN 47708

T: 812.422.4187
F: 812.421.6776
www.haferdesign.com

ARCHITECTS PROJECT NO.



2106-204

DATE:

10/05/2023

TYPE OF DRAWING NO.

PR-1A8

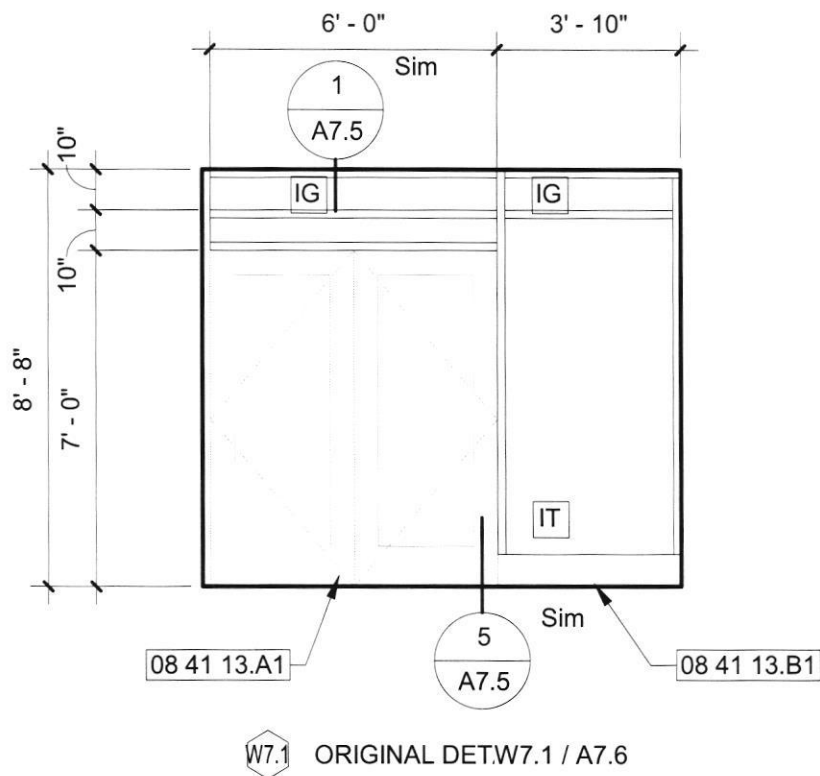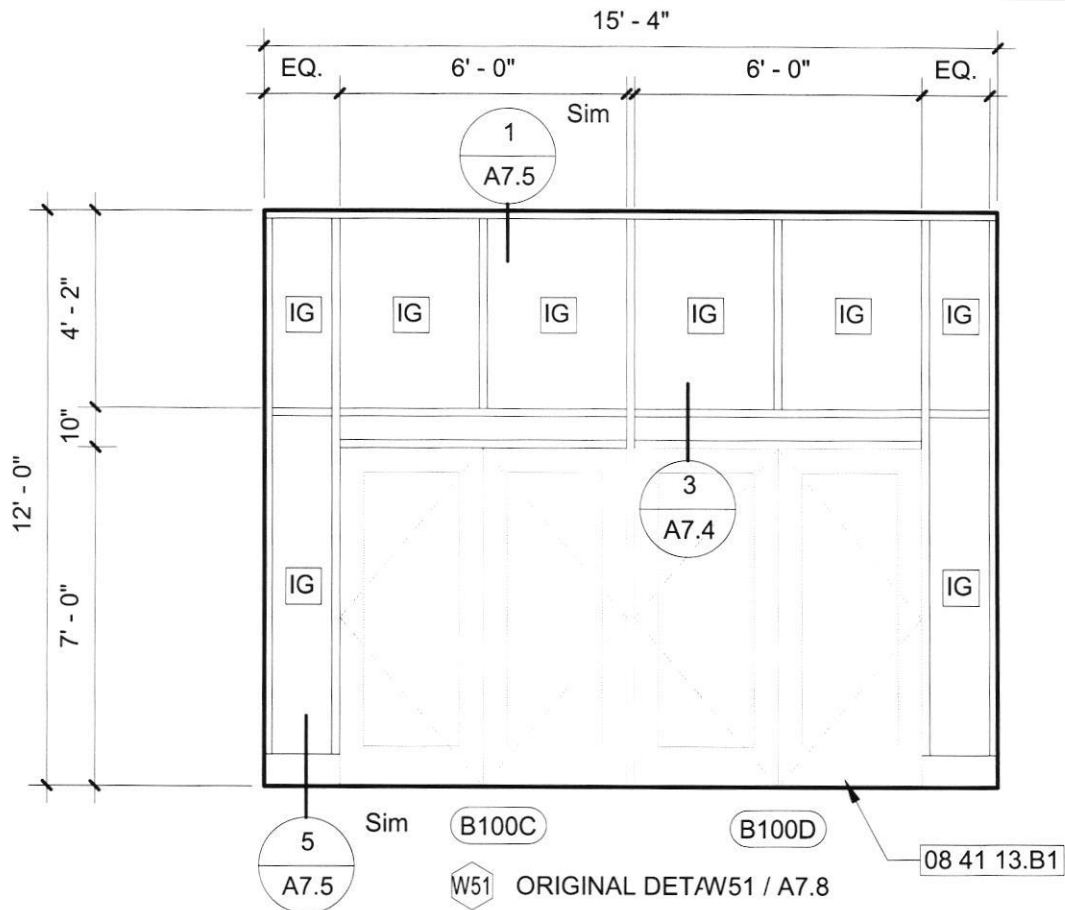

HOPKINSVILLE - CHRISTIAN
COUNTY ACADEMY

KDE # : BG 22-104

5185 FT. CAMPBELL BLVD
HOPKINSVILLE, KY 42240

HAFER
architects • designers • engineers

21 SE Third Street,
Suite 800
Evansville, IN 47708

T: 812.422.4187
F: 812.421.6776
www.haferdesign.com

ARCHITECTS PROJECT NO.

2106-204

DATE:

10/05/2023


TYPE OF DRAWING NO.

PR-1A7

DOOR SCHEDULE - PR1

Door Number	Door Data							Frame Data					Hardware Set	Comments	Door Number
	Fire Rating	Type	Material	Width	Height	Thickness	Glass	Type	Material	Head	Jamb	Depth			
B100D	--	AG	AL	PR 3' - 0"	7' - 0"	1 3/4"	1" INSUL.	W51	AL	AL4	AL4	4 1/2"	#4 - EXTERIOR (P, ALUM) EX	PR1	B100D
B101.9	90 MIN.	F	HM	3' - 0"	7' - 0"	1 3/4"		F2		HM2	HM2	5 3/4"	#17 - PAIR (90) EX, SEE NOTE	PR1	B101.9
B101.10	90 MIN.	F	HM	3' - 0"	8' - 0"	1 3/4"	--	F2		HM3	HM3	5 3/4"	#17 - PAIR (90) EX, SEE NOTE	PR1	B101.10
C100C.2	90 MIN.	F	HM	PR 3' - 0"	7' - 0"	1 3/4"		F2		HM3	HM3	5 3/4"	#37 - PAIR (ICC, 90)	PR1, ICC500	C100C.2
C100C.3	90 MIN.	F	HM	PR 3' - 0"	7' - 0"	1 3/4"		F2		HM3	HM3	5 3/4"	#37 - PAIR (ICC, 90)	PR1, ICC500	C100C.3
D106	--	F	WD	3' - 8"	7' - 0"	1 3/4"	--	F2	HM	HM2	HM2	5 3/4"	#20 - CLASSROOM (S) 50+	PR1	D106
E1	--	AG	AL	PR 3' - 0"	7' - 0"	1 3/4"	1" INSUL.	W7.1	AL	SEE PLAN	SEE PLAN	4 1/2"	#4 - EXTERIOR (P, ALUM) EX	PR1	E1
E3	--	AG	AL	PR 3' - 0"	7' - 0"	1 3/4"	1" INSUL.	W7.1	AL	SEE PLAN	SEE PLAN	4 1/2"	#4 - EXTERIOR (P, ALUM) EX	PR1	E3

NOTE - DOOR B100.9 - PROVIDE HARDWARE SET SIMILAR TO #17, MODIFIED FOR SINGLE DOOR AND PROVIDE MAGNETIC HOLD OPEN.
 - DOOR B100.10- PROVIDE HARDWARE SET SIMILAR TO #17, MODIFIED FOR SINGLE DOOR. NO MAGNETIC HOLD OPEN, AND CLOSER TO NOT HAVE HOLD OPEN.

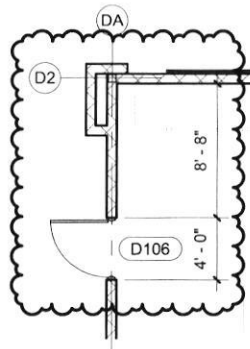

1 **FIRST FLOOR PLAN - AREA D**
 1/8" = 1'-0"

ARCHITECTS PROJECT NO.
2106-204


DATE
10/05/2023

TYPE OF DRAWING NO.
PR-1A9

21 SE Third Street,
 Suite 800
 Evansville, IN 47708
 T: 812.422.4187
 F: 812.421.6776
 www.hafersdesign.com

HAFER
 architects • designers • engineers

HOPKINSVILLE - CHRISTIAN
 COUNTY ACADEMY
 KDE # : BG 22-104
 5185 FT. CAMPBELL BLVD
 HOPKINSVILLE, KY 42240

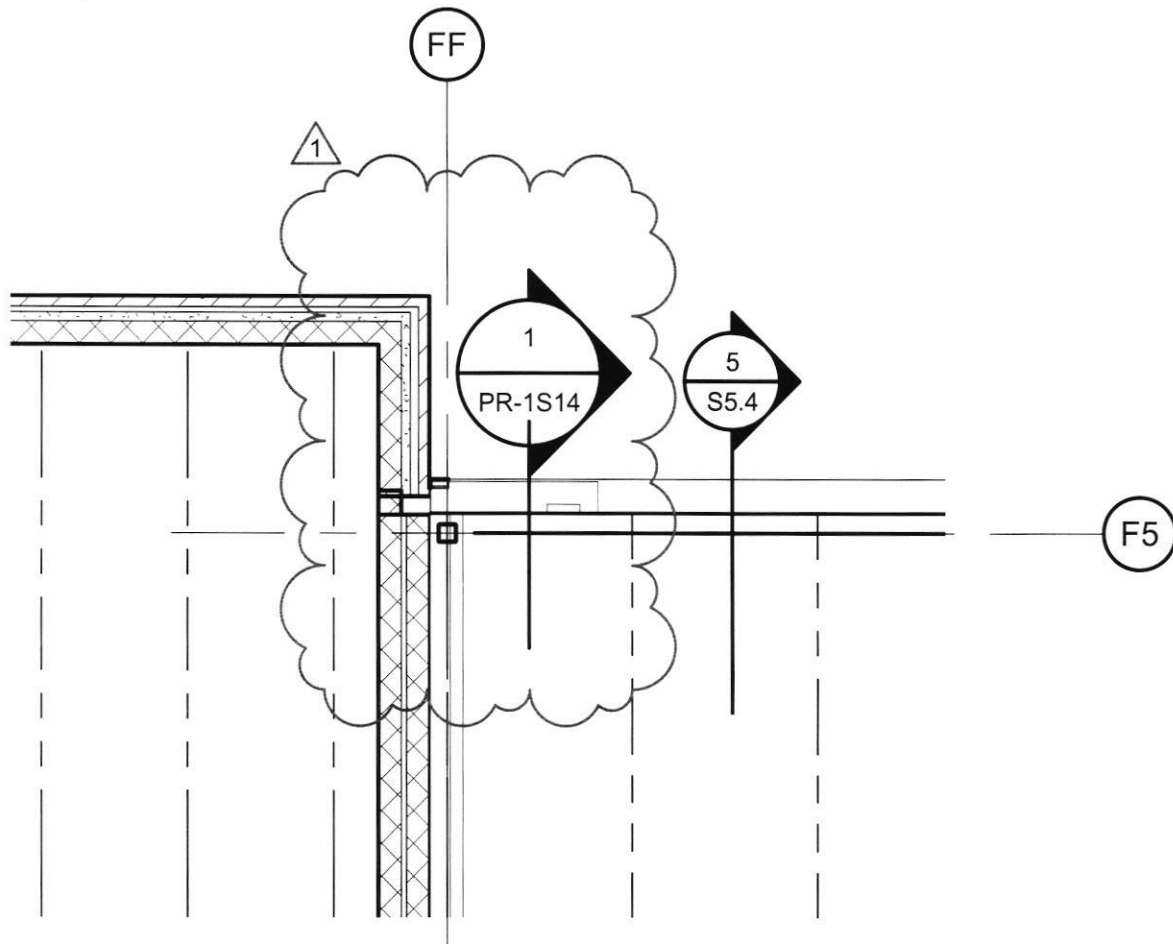

1 ROOF FRAMING PLAN - AREA F
SCALE: 3/16" = 1'-0"

PLAN NORTH



HOPKINSVILLE - CHRISTIAN
COUNTY ACADEMY

KDE #: BG 22-104

5185 FT. CAMPBELL BLVD
HOPKINSVILLE, KY 42240

HAFER

architects • designers • engineers

21 SE Third Street,
Suite 800
Evansville, IN 47708

T: 812.422.4187
F: 812.421.6776
www.haferdesign.com

ARCHITECTS PROJECT NO.


2106-204

DATE:

10/13/23

TYPE OF DRAWING NO.

PR-1S5

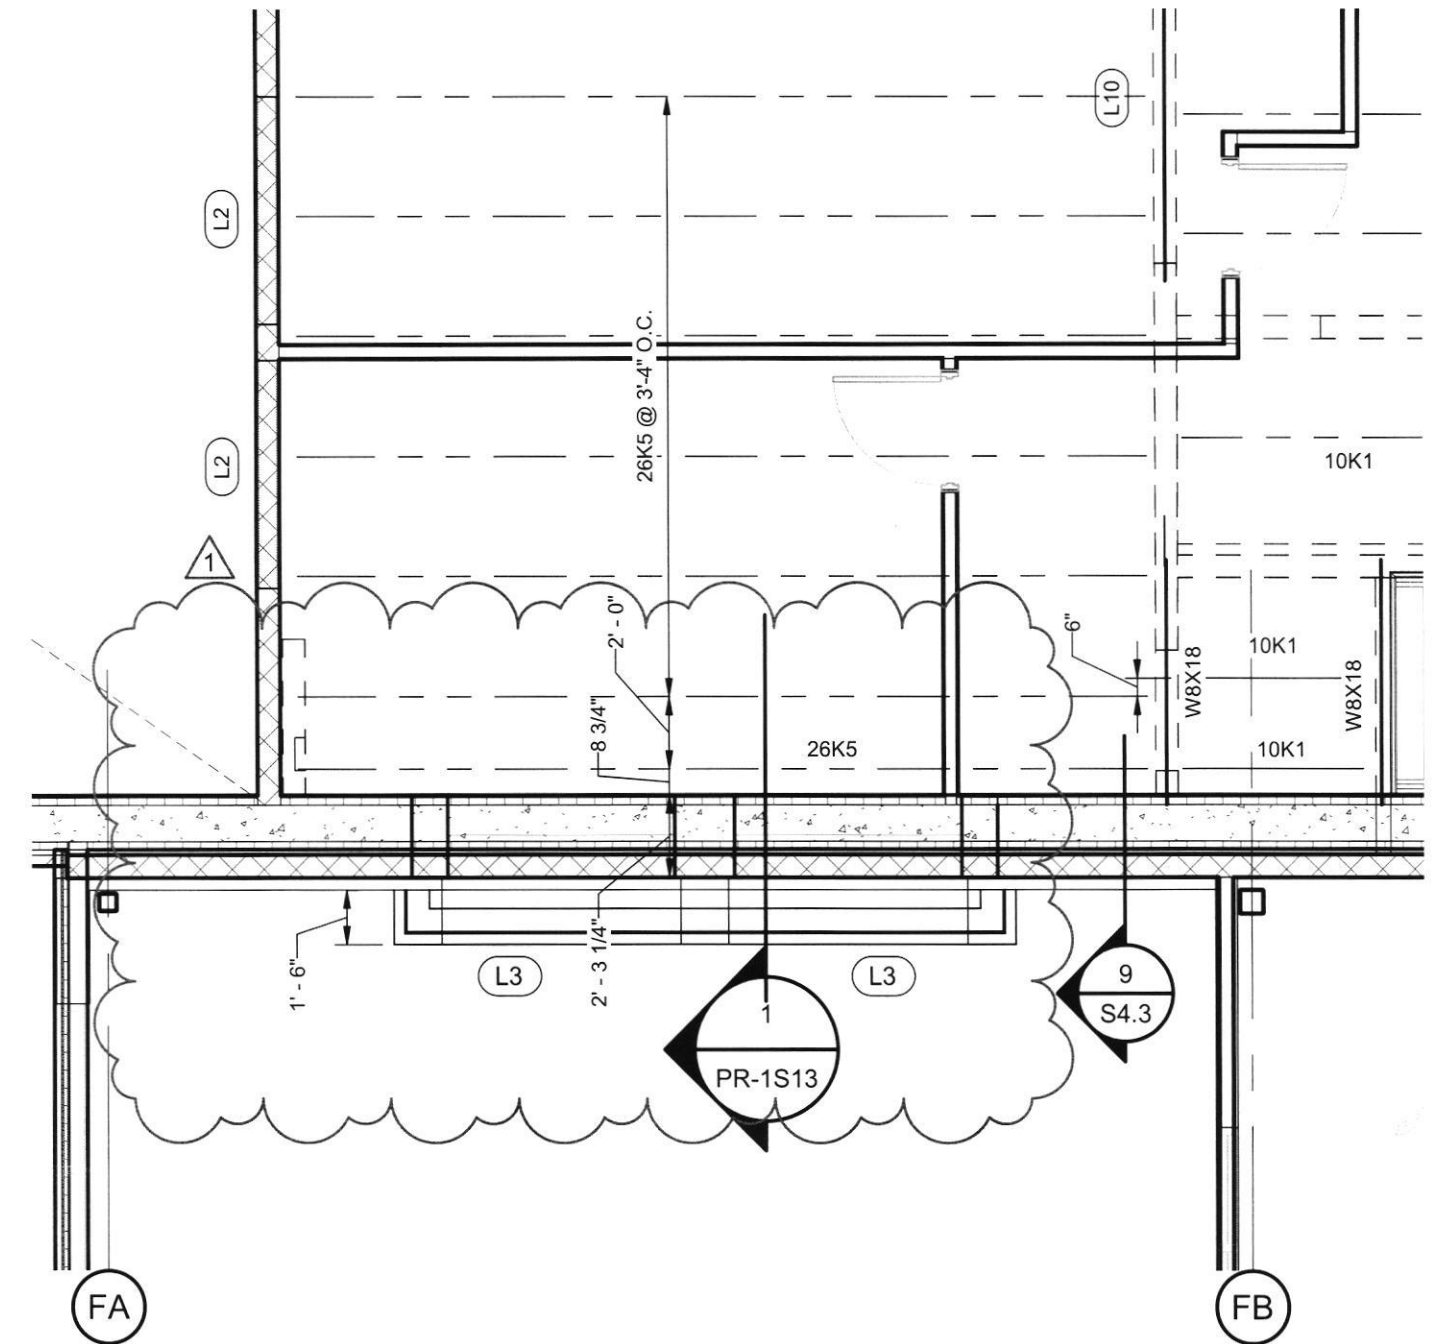

PLAN NORTH



1 LEVEL 2 FRAMING PLAN - AREA C
SCALE: 3/16" = 1'-0"

HOPKINSVILLE - CHRISTIAN
COUNTY ACADEMY

KDE # : BG 22-104

5185 FT. CAMPBELL BLVD
HOPKINSVILLE, KY 42240

HAFER
architects • designers • engineers

21 SE Third Street,
Suite 800
Evansville, IN 47708

T: 812.422.4187
F: 812.421.6776
www.haferdesign.com

ARCHITECTS PROJECT NO.


2106-204

DATE:

10/13/23

TYPE OF DRAWING NO.

PR-1S4

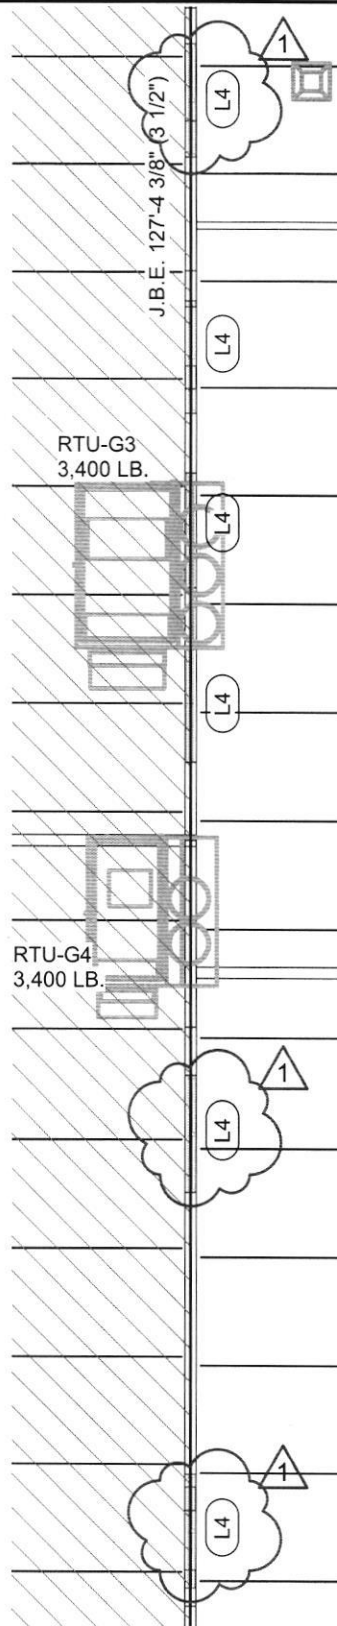

PLAN NORTH



1 ROOF FRAMING PLAN - AREA G

SCALE: 3/32" = 1'-0"

HOPKINSVILLE - CHRISTIAN
COUNTY ACADEMY

KDE # : BG 22-104

5185 FT. CAMPBELL BLVD
HOPKINSVILLE, KY 42240

HAFER
architects • designers • engineers

21 SE Third Street,
Suite 800
Evansville, IN 47708


T: 812.422.4187
F: 812.421.6776
www.haferdesign.com

ARCHITECTS PROJECT NO.
2106-204


DATE:
10/13/23

TYPE OF DRAWING NO.

PR-1S8

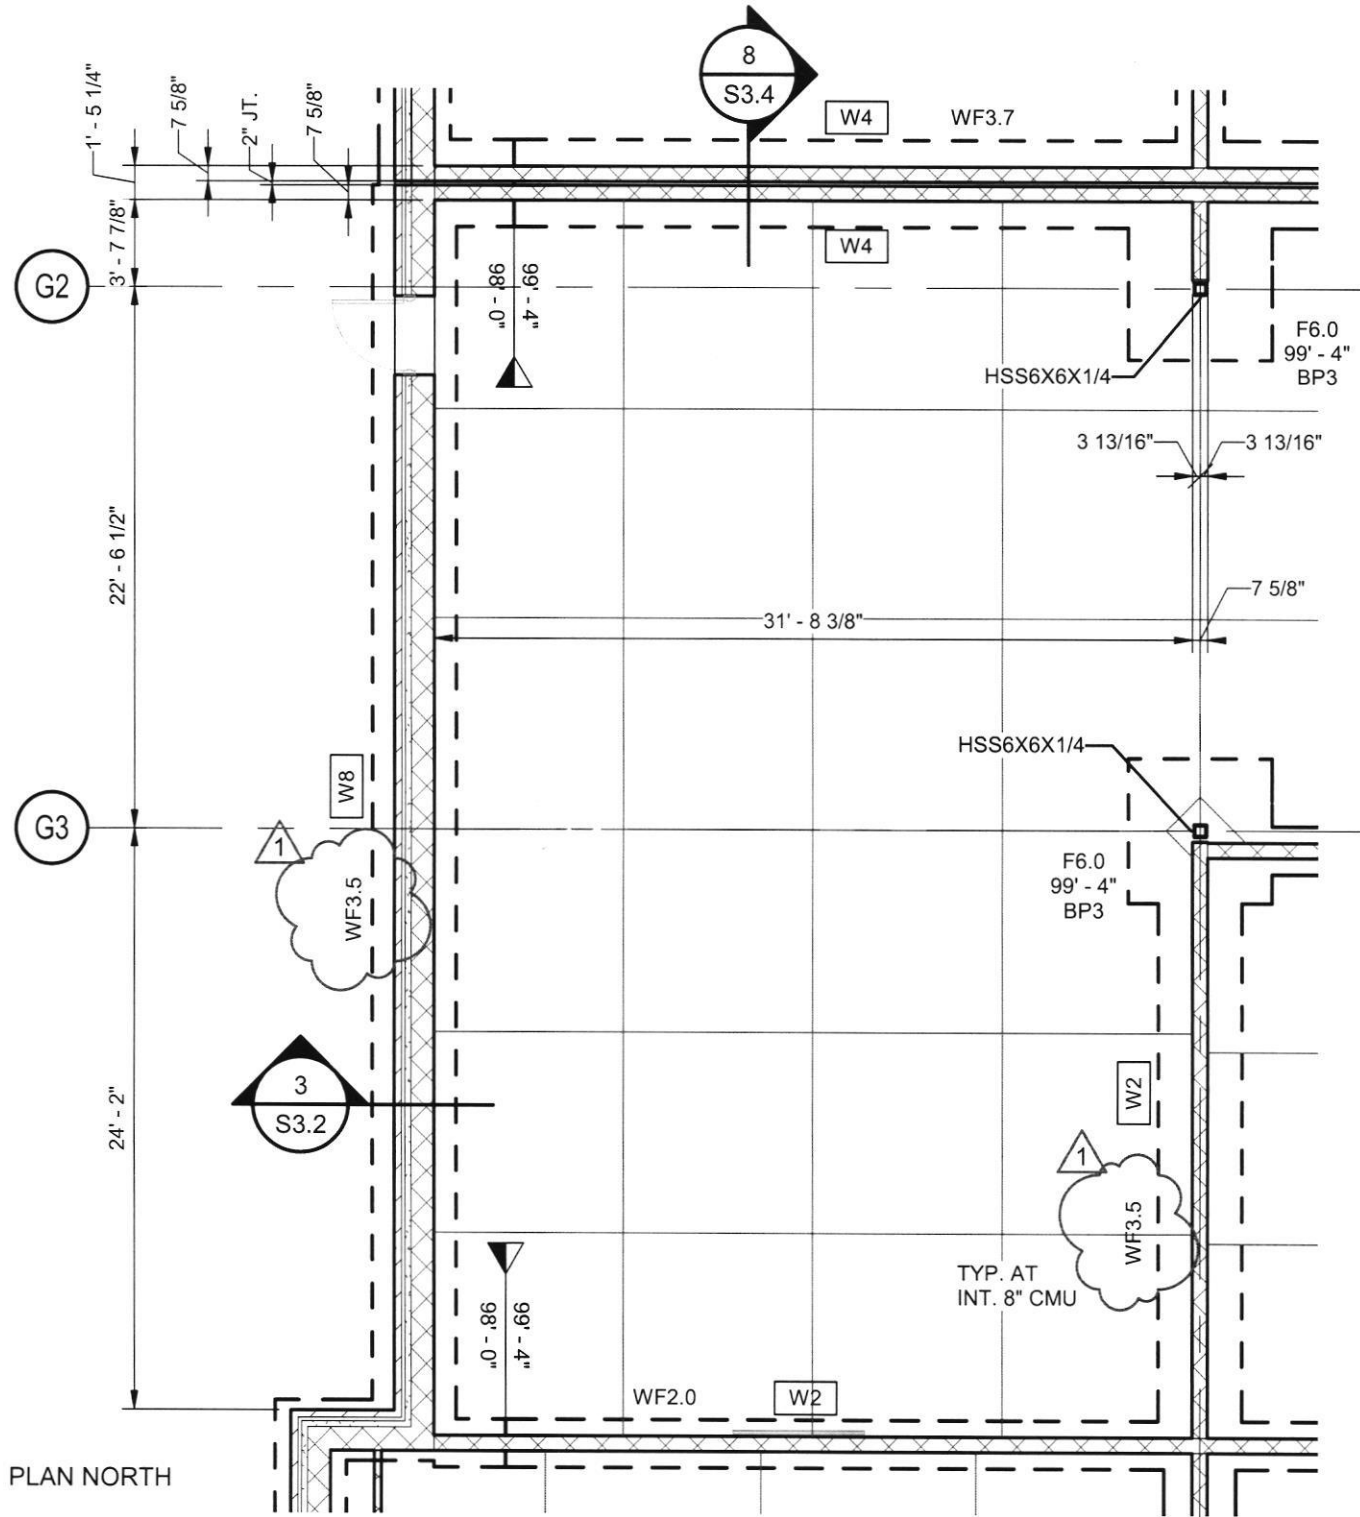

PLAN NORTH

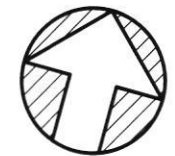

1 FOUNDATION PLAN - AREA G
SCALE: 1/8" = 1'-0"

GA

HOPKINSVILLE - CHRISTIAN
COUNTY ACADEMY

KDE #: BG 22-104

5185 FT. CAMPBELL BLVD
HOPKINSVILLE, KY 42240

HAFFER
architects • designers • engineers

21 SE Third Street,
Suite 800
Evansville, IN 47708


T: 812.422.4187
F: 812.421.6776
www.haferdesign.com

ARCHITECTS PROJECT NO.
2106-204

DATE:
10/13/23

TYPE OF DRAWING NO.

PR-1S7

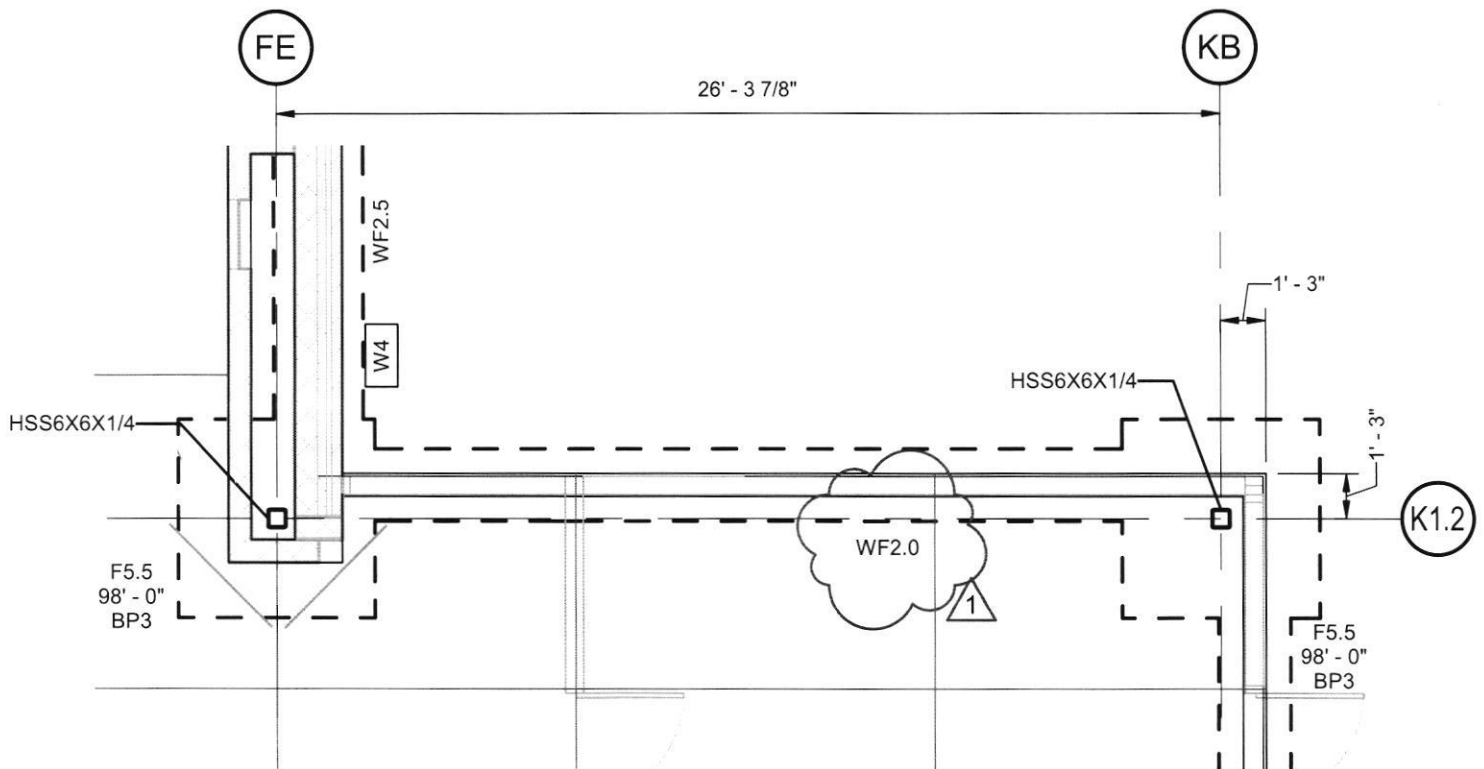

PLAN NORTH



1 FOUNDATION PLAN - AREA K
SCALE: 3/16" = 1'-0"

HOPKINSVILLE - CHRISTIAN
COUNTY ACADEMY

KDE # : BG 22-104

5185 FT. CAMPBELL BLVD
HOPKINSVILLE, KY 42240

HAFER
architects • designers • engineers

21 SE Third Street,
Suite 800
Evansville, IN 47708


T: 812.422.4187
F: 812.421.6776
www.haferdesign.com

ARCHITECTS PROJECT NO.
2106-204

DATE:
10/13/23

TYPE OF DRAWING NO.

PR-1S10

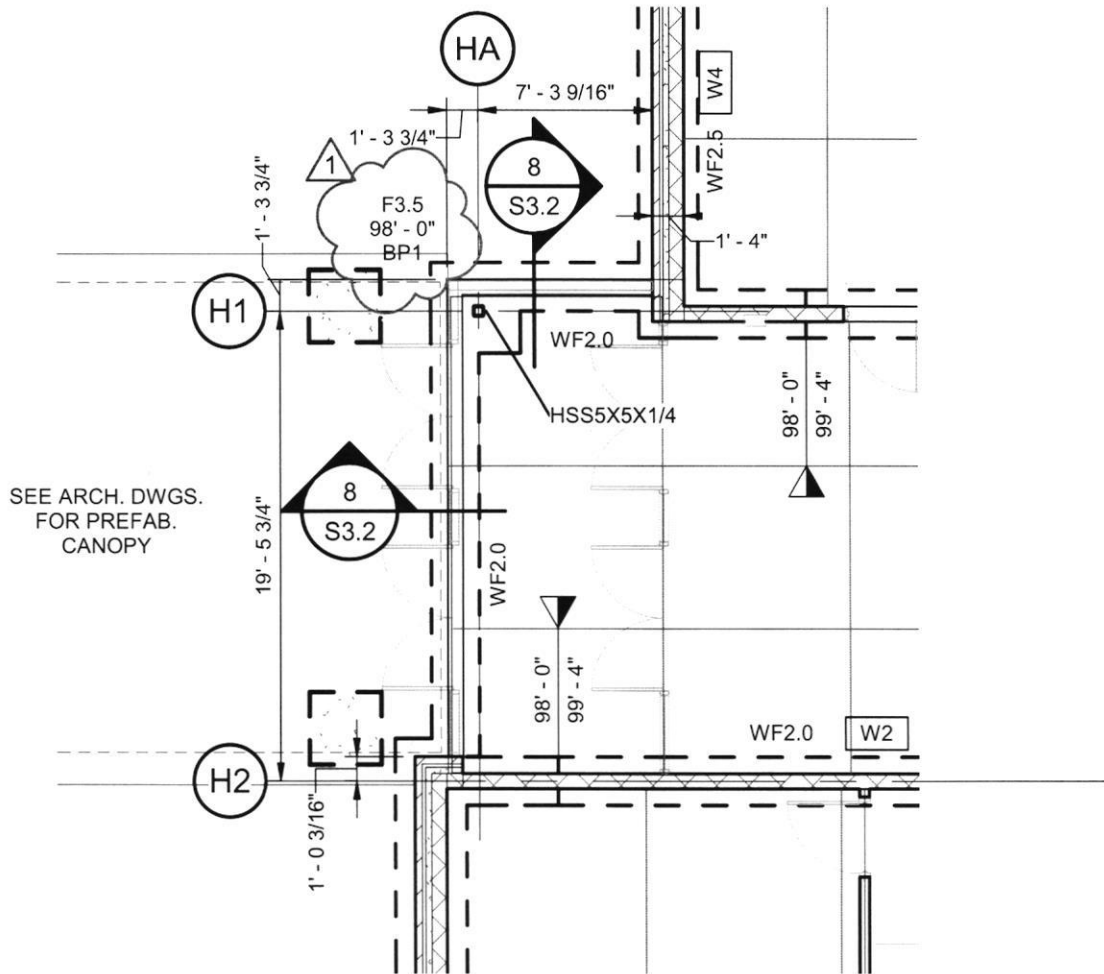

1 FOUNDATION PLAN - AREA H
SCALE: 1/8" = 1'-0"

PLAN NORTH



HOPKINSVILLE - CHRISTIAN
COUNTY ACADEMY

KDE # : BG 22-104

5185 FT. CAMPBELL BLVD
HOPKINSVILLE, KY 42240

HAFER

architects • designers • engineers

21 SE Third Street,
Suite 800
Evansville, IN 47708

T: 812.422.4187
F: 812.421.6776
www.haferdesign.com

ARCHITECTS PROJECT NO.

2106-204


DATE:

10/13/23

TYPE OF DRAWING NO.

PR-1S9

REFERENCE DETAIL 14/S3.3

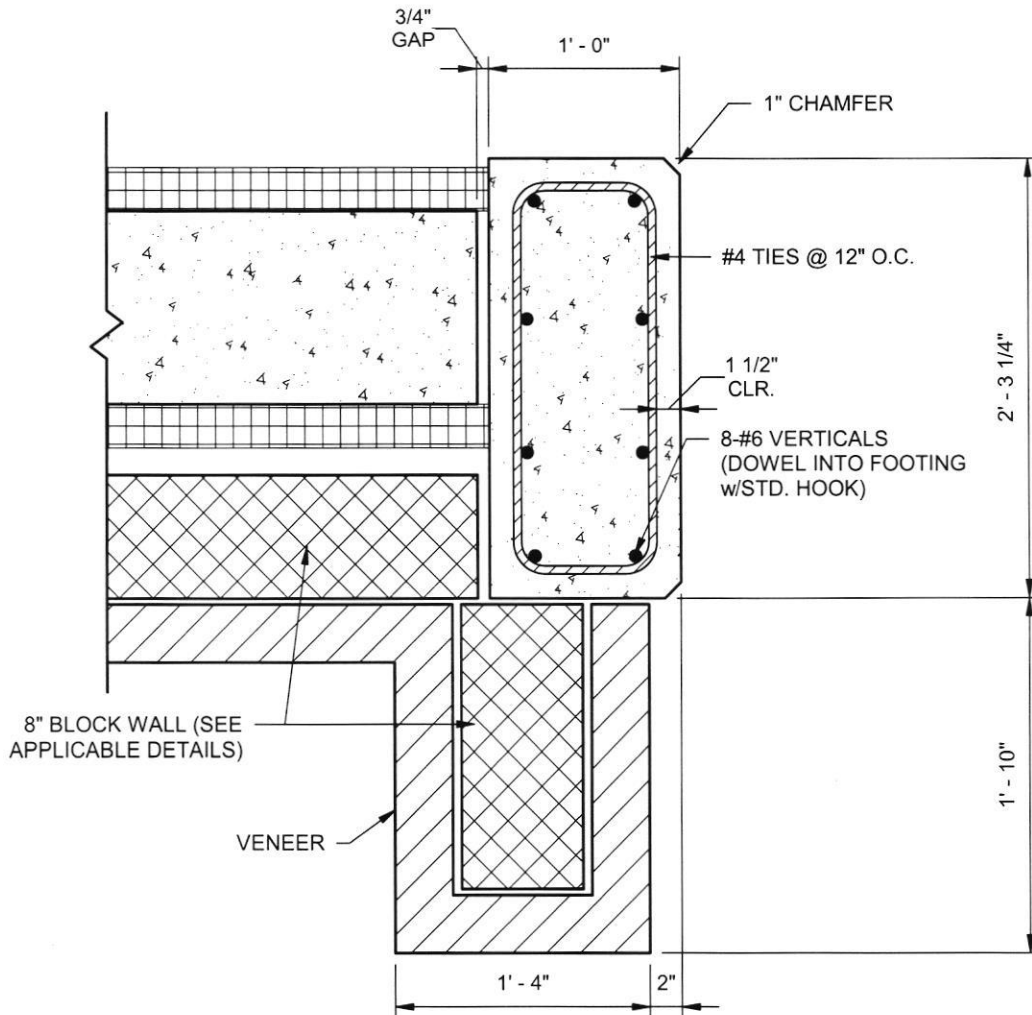

1 CONCRETE COLUMN AT SHELTER
SCALE: 1" = 1'-0"

HOPKINSVILLE - CHRISTIAN
COUNTY ACADEMY

KDE # : BG 22-104

5185 FT. CAMPBELL BLVD
HOPKINSVILLE, KY 42240

HAFER
architects • designers • engineers

21 SE Third Street,
Suite 800
Evansville, IN 47708

T: 812.422.4187
F: 812.421.6776
www.haferdesign.com

ARCHITECTS PROJECT NO.


2106-204

DATE:

10/13/23

TYPE OF DRAWING NO.

PR-1S11

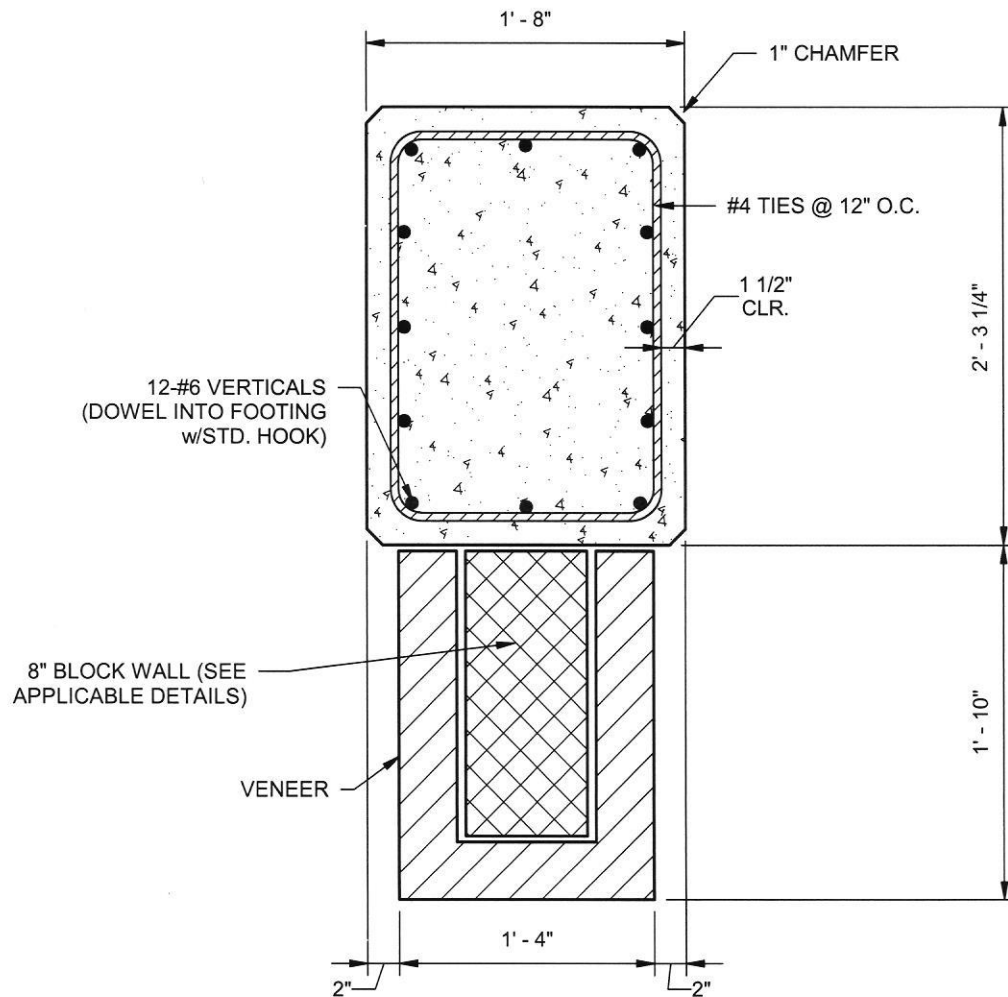

1 CONCRETE COLUMN AT SHELTER

SCALE: 1" = 1'-0"

HOPKINSVILLE - CHRISTIAN
COUNTY ACADEMY

KDE # : BG 22-104

5185 FT. CAMPBELL BLVD
HOPKINSVILLE, KY 42240

HAFER
architects • designers • engineers

21 SE Third Street,
Suite 800
Evansville, IN 47708

T: 812.422.4187
F: 812.421.6776
www.haferdesign.com

ARCHITECTS PROJECT NO.

2106-204

DATE:

10/13/23

TYPE OF DRAWING NO.

PR-1S12


Architectural cross-section drawing of a wall and foundation assembly. The drawing shows a vertical wall section on the left and a foundation section on the right. The wall section includes a veneer, 8-inch block, and various reinforcement bars (#5 horizontals, #6 verticals, #4 dowels). The foundation section shows a concrete beam with #4 stirrups and #5 reinforcement. Dimensions are provided for various components and overall sections. A detail 'L3' is shown for a loose brick lintel. A note at the bottom indicates the embedment of a plate and studs.

Labels and Dimensions:

- #5 HORIZONTALS @ 18" O.C.
- SEE SCHEDULE FOR REINF.
- JT. REINF. @ 16" O.C.
- 8" BLOCK
- VENEER TIES @ 16" O.C.
- VENEER (SEE ARCH. DWGS.)
- 8" HIGH BD. BM. REINF. w/2-#5 CONT.
- CONC. BEAM
- 11 5/8"
- 4 3/8"
- 1' - 0"
- #6 VERTICALS @ 8" O.C. EACH FACE
- INSULATING CONCRETE FORMING SYSTEM (SEE ARCH. DWGS.)
- #4 DOWELS @ 16" O.C. w/ 10" HOOK
- 2'-0"
- 10"
- 2'-0"
- 1 1/2" CLR.
- 3-#6 CONT.
- 9 5/8"
- 9 5/8"
- 4"
- 4"
- #4 STIRRUPS @ 12" O.C.
- 5-#6 CONT.
- 1' - 6"
- 4"
- 2' - 3 1/4"
- B/BEAM ELEV. 109'-4"
- EMBED PL 3/8x2'-7 1/4"xCONT. w/3 ROWS OF 1/2"x6" LONG HD STUDS @ 16" O.C.


Detail L3: 2-#6 CONT. 1/4 LOOSE BRICK LINTEL

 PR-1S13



PR-1S14

NOTE:
 AT CONTRACTOR'S OPTION, HOOKED
 DOWELS MAY BE REPLACED w/STRAIGHT
 DOWELS SECURED TO THICKENED SLAB
 w/HILTI HIT-HY 200 ADHESIVE w/6" EMBED.

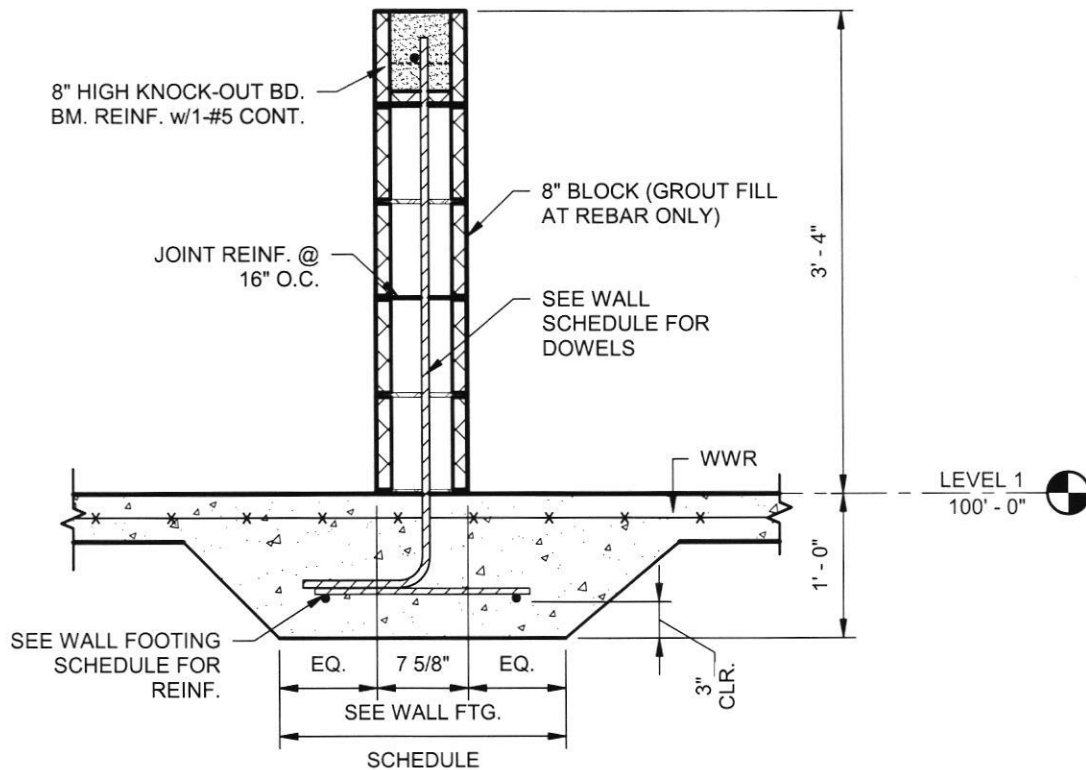

1 THICKENED SLAB AT CMU

SCALE: 3/4" = 1'-0"

HOPKINSVILLE - CHRISTIAN
 COUNTY ACADEMY

KDE # : BG 22-104

5185 FT. CAMPBELL BLVD
 HOPKINSVILLE, KY 42240

HAFER
 architects • designers • engineers

21 SE Third Street,
 Suite 800
 Evansville, IN 47708


T: 812.422.4187
 F: 812.421.6776
 www.haferdesign.com

ARCHITECTS PROJECT NO.
2106-204

DATE:
10/13/23

TYPE OF DRAWING NO.

PR-1S15

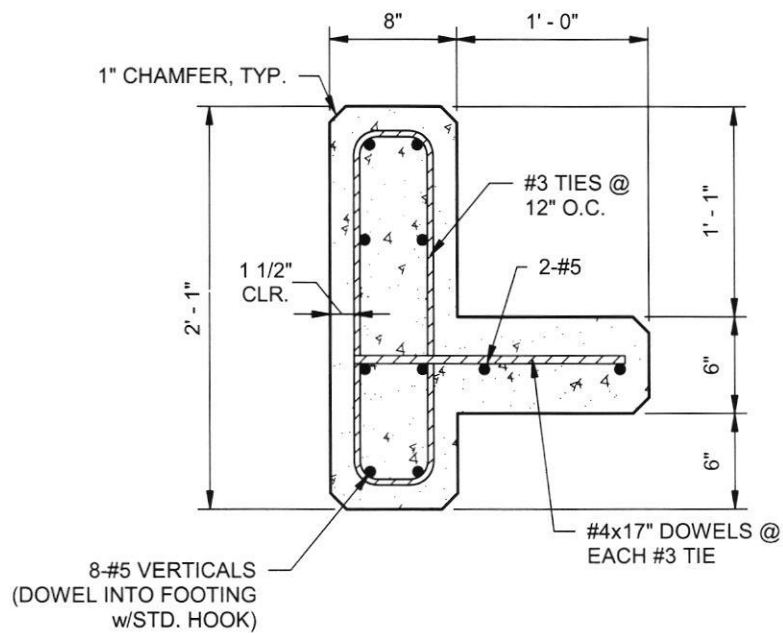

1 CONCRETE COLUMN

SCALE: 1" = 1'-0"

HOPKINSVILLE - CHRISTIAN
COUNTY ACADEMY

KDE # : BG 22-104

5185 FT. CAMPBELL BLVD
HOPKINSVILLE, KY 42240

HAFER
architects • designers • engineers

21 SE Third Street,
Suite 800
Evansville, IN 47708

T: 812.422.4187
F: 812.421.6776
www.haferdesign.com

ARCHITECTS PROJECT NO.

2106-204

DATE:

10/13/23

TYPE OF DRAWING NO.

PR-1S16

TEMPERATURE CONTROL SYSTEM LTG CTRL RELAY PANEL SCHEDULE

Panel ID: LIGHTING CONTROL RELAY PANEL "TCRP11C"

Location: AREA "C" ELEC ROOM B190

Surface/Flush: SURFACE MOUNT

Ctrl Pwr Circuit: PANEL "EH11C" CIRCUIT NO. 12

Description of Loads: (BUILDING INTERIOR COMMON AREAS LTG)

Relay #	Circuit	Description	Ltg Ctrl Requirements
1	H11C-6	ZONE "z" - 2ND FLR AREA "C" CORRIDOR	(SEE NOTES 1 & 2)
2	H11C-12	ZONE "y" - 1ST FLR AREA "C" RESTROOM	
3	H11C-12	ZONE "x" - 1ST FLR AREA "C" RESTROOM	
4	H11C-10	ZONE "w" - 1ST FLR AREA "C" CORRIDOR	(SEE NOTES 1 & 2)
5	H11C-20	ZONE "t" - 1ST FLR AREA "C" CORRIDOR	(SEE NOTES 1 & 2)
6	H11C-7	ZONE "s" - 1ST FLR AREA "C" CORRIDOR	(SEE NOTES 1 & 2)
7	H11C-11	ZONE "r" - 1ST FLR AREA "C" CORRIDOR	(SEE NOTES 1 & 2)
8	H11C-14	ZONE "q" - 1ST FLR AREA "C" CORRIDOR	(SEE NOTES 1 & 2)
9	H11C-16	ZONE "p" - 1ST FLR AREA "C" CORRIDOR	(SEE NOTES 1 & 2)
10	EH11C-10	ZONE "a" - EXTERIOR LIGHTING	(SEE NOTE 3)
11	EH11C-10	ZONE "b" - EXTERIOR LIGHTING	(SEE NOTE 4)
12	H11C-22	EXTERIOR LTG - CANOPY (D-O-E-O)	(SEE NOTE 4)
13	EH11C-16	EXTERIOR LTG - CANOPY (D-T-D)	(SEE NOTE 3)
14	EH11C-19	ZONE "c" - EXTERIOR LIGHTING	(SEE NOTE 3)
15	EH11C-19	ZONE "d" - EXTERIOR LIGHTING	(SEE NOTE 4)
16	—	SPARE	
17	—	SPARE	
18	—	SPARE	

NOTES:

1. LIGHTING ZONE SHALL BE CONTROLLED AS FOLLOWS: LIGHTING SHALL BE TURNED "ON" AND HELD "ON" DURING NORMAL BUSINESS TIME PERIODS. DURING AFTER NORMAL BUSINESS HOURS TIME PERIODS, THE LIGHTING SHALL BE CONTROLLED VIA OCCUPANCY SENSORS WITHIN THE ASSOCIATED ZONE SPACE. ON DETECTION OF OCCUPANCY, THE LIGHTING FIXTURES IN THE ASSOCIATED ZONE SHALL BE TURNED "ON" FOR A TIME PERIOD OF 15 MINUTES. AFTER 15 MINUTES OF LACK-OF-DETECTION-OF-OCCUPANCY, THE LIGHTING FIXTURES SHALL BE TURNED "OFF".

2. CONTRACTOR SHALL COORDINATE THE NORMAL BUSINESS HOURS WITH THE OWNER AND THE OWNER'S TENANT PRIOR TO START OF PROGRAMMING.

3. DUSK-TO-DAWN CONTROL VIA PHOTOCELL. PROVIDE OCCUPANCY SENSOR ON BUILDING EXTERIOR (NORTH SIDE) AWAY FROM ALL SOURCES OF DIRECT ILLUMINATION.

4. DUSK "ON" - EARLY "OFF" CONTROL VIA PHOTOCELL SENSOR AND TIMECLOCK. PROVIDE PHOTOCELL CONTROL DEVICE ON BUILDING EXTERIOR (NORTH SIDE) AWAY FROM ALL SOURCES OF DIRECT ILLUMINATION.

ARCHITECTS PROJECT NO. **2106-204** DATE: **10/13/23**

TYPE OF DRAWING NO.:

PR-1E1

21 SE Third Street,
Suite 800
Evansville, IN 47708


T: 812.422.4187
F: 812.421.6776
www.hafersdesign.com

HAFFER
architects • designers • engineers

**HOPKINSVILLE - CHRISTIAN
COUNTY ACADEMY**

KOE #: BG 22-104


5185 FT. CAMPBELL BLVD
HOPKINSVILLE, KY 42240

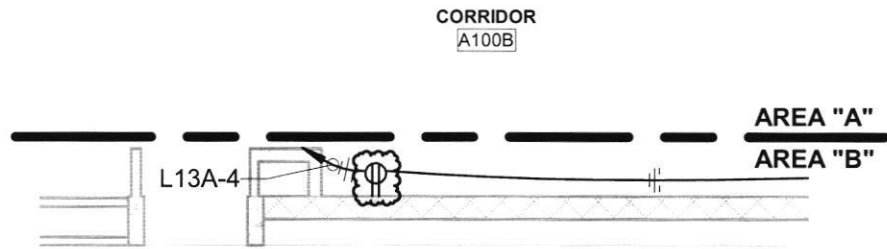

POWER PLAN - FIRST FLOOR - AREA "B"

ORIGINAL DETAIL 2 / E2.1B

1/8" = 1'-0"

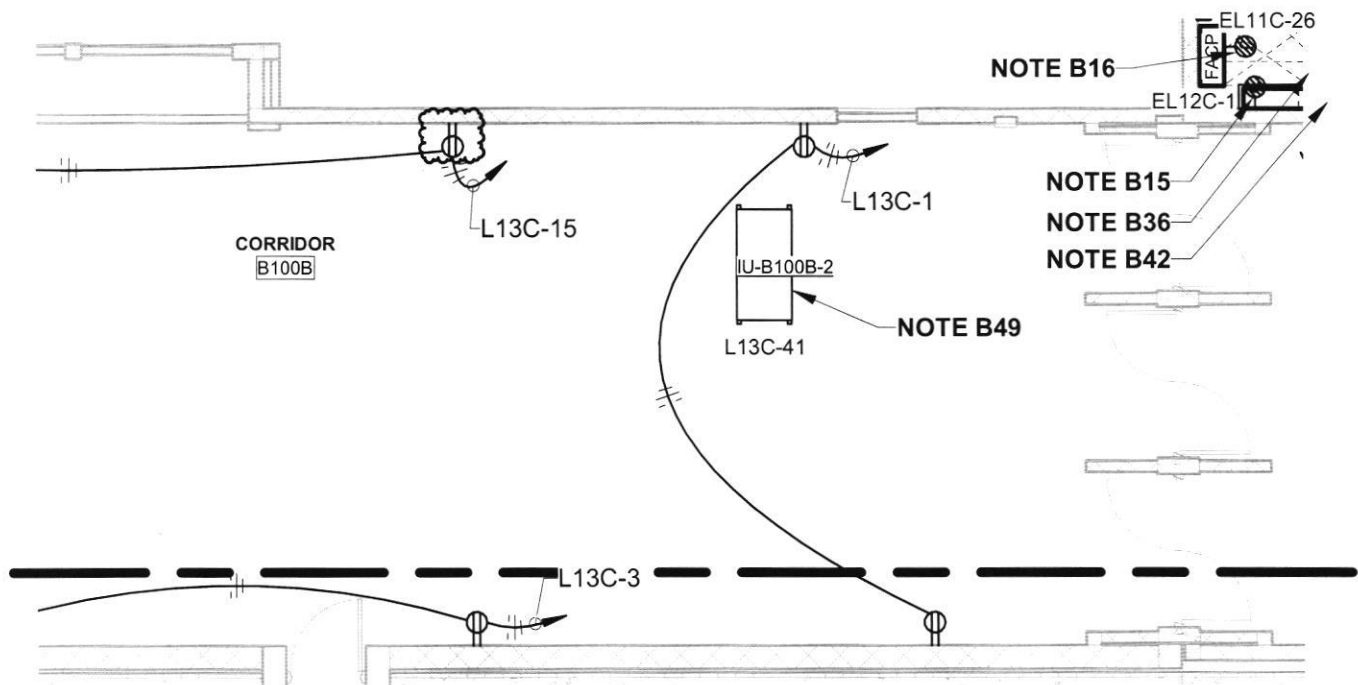

POWER PLAN - FIRST FLOOR - AREA "B"

ORIGINAL DETAIL 2 / E2.1B

1/8" = 1'-0"

HOPKINSVILLE - CHRISTIAN
COUNTY ACADEMY

KDE # : BG 22-104

5185 FT. CAMPBELL BLVD
HOPKINSVILLE, KY 42240

HAFER
architects • designers • engineers

21 SE Third Street,
Suite 800
Evansville, IN 47708

T: 812.422.4187
F: 812.421.6776
www.haferdesign.com

ARCHITECTS PROJECT NO.


2106-204

DATE:

10/13/23

TYPE OF DRAWING NO.


PR-1E2

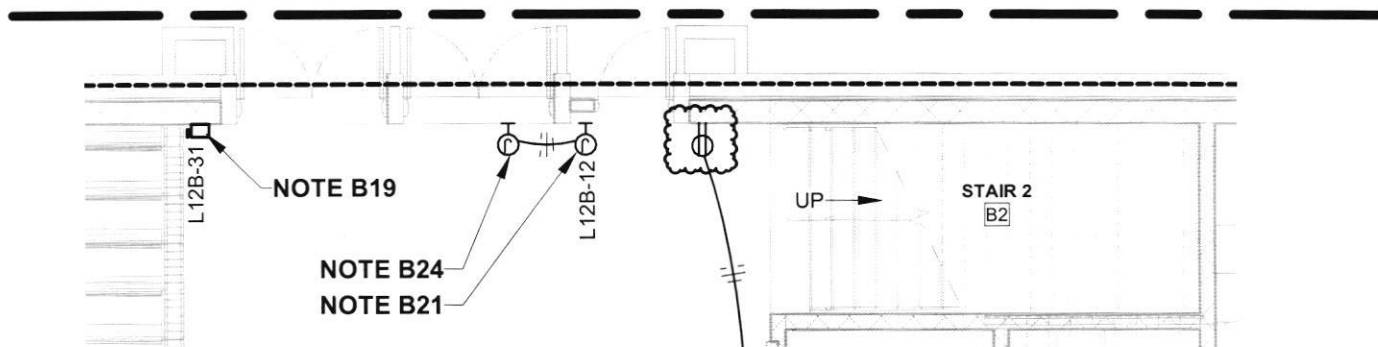

POWER PLAN - FIRST FLOOR - AREA "B" ALT

ORIGINAL DETAIL 1 / E2.1B-Alt

1/8" = 1'-0"

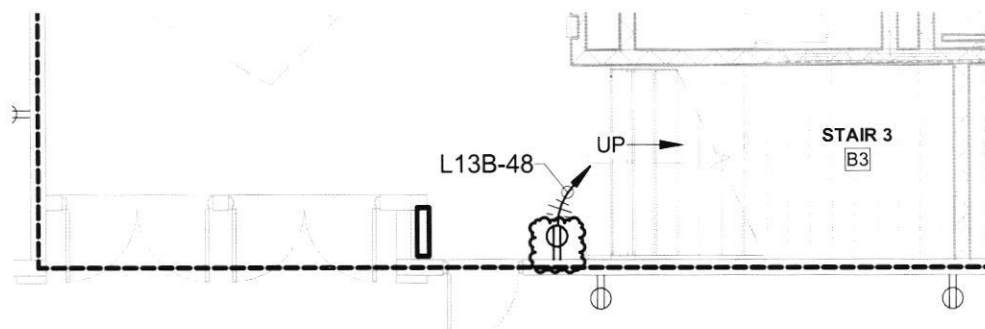

POWER PLAN - FIRST FLOOR - AREA "B" ALT

ORIGINAL DETAIL 1 / E2.1B-Alt

1/8" = 1'-0"

HOPKINSVILLE - CHRISTIAN
COUNTY ACADEMY

KDE # : BG 22-104

5185 FT. CAMPBELL BLVD
HOPKINSVILLE, KY 42240

HAFER

architects • designers • engineers

21 SE Third Street,
Suite 800
Evansville, IN 47708

T: 812.422.4187
F: 812.421.6776
www.haferdesign.com

ARCHITECTS PROJECT NO.


2106-204

DATE:

10/13/23

TYPE OF DRAWING NO.

PR-1E3

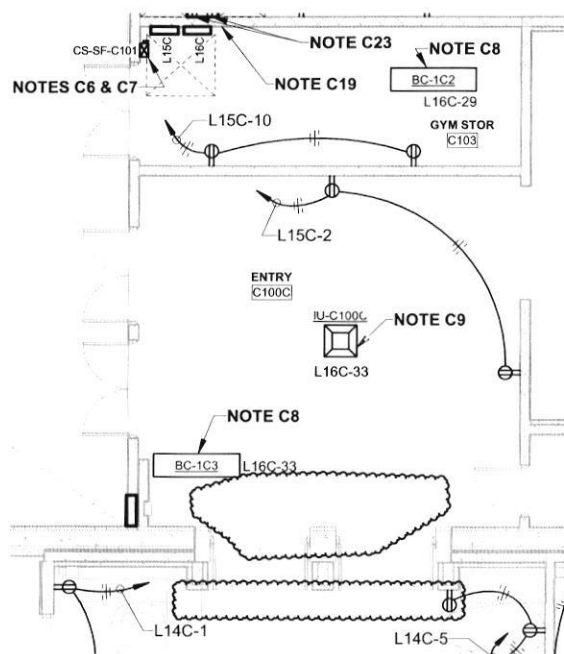

POWER PLAN - FIRST FLOOR AREA "C"

1/8" = 1'-0"

ORIGINAL DETAIL 2 / E2.1C

NOTES (FIRST FLOOR POWER PLAN - AREA "C") [CONT]:

C9. PROVIDE 30A/2 FUSIBLE SAFETY DISCONNECT SWITCH NEAR HVAC UNIT WITHIN THE ACCESSIBLE CEILING CAVITY SPACE. PROVIDE POWER CIRCUIT TO HVAC UNIT (THROUGH DISCONNECT SWITCH) PER THE MANUFACTURER'S REQUIREMENTS. PROVIDE POWER CIRCUIT FROM PANEL AND BRANCH CIRCUIT NO. AS INDICATED USING 2#12, 1#12G IN 3/4" C. PROVIDE FUSING PER THE EQUIPMENT MANUFACTURER'S REQUIREMENTS. COORDINATE REQUIRED INSTALLATION LOCATION IN FIELD WITH THE HVAC UNIT REQUIREMENTS AND ALL OTHER INSTALLATION WITHIN THE AREA.

C10. SEE FIRST FLOOR SYSTEMS & TECHNOLOGY PLAN - AREA "C", SHEET E3.1C, FOR ADDITIONAL REQUIREMENTS.

C11. RECEPTACLE FOR POWER TO AUDIO/VIDEO CONTROL CABINET. COORDINATE THE REQUIRED INSTALLATION LOCATION AND MOUNTING HEIGHT WITH THE INSTALLATION REQUIREMENTS OF THE AUDIO/VIDEO CONTROL CABINET. SEE TYPICAL INSTRUCTOR'S AV ACCESS CABINET LOCATION ELECTRICAL REQUIREMENT DETAIL, SHEET E1.9, FOR ADDITIONAL REQUIREMENTS.

C12. COORDINATE THE REQUIRED INSTALLATION LOCATIONS AND MOUNTING HEIGHT OF ALL INSTALLATION ALONG THIS WALL WITH THE ARCHITECT PRIOR TO START OF ROUGH-IN.

C13. NOTE NOT USED.

C14. PROVIDE #10AWG CONDUCTORS FOR ALL "PHASE", "NEUTRAL" AND EQUIPMENT GROUND CONDUCTORS FOR ENTIRE LENGTH OF BRANCH CIRCUIT.

C15. PROVIDE POWER CIRCUIT TO THE ISOLATED GROUND TYPE DUPLEX RECEPTACLE WITHIN THE FLOOR BOX FROM PANEL "L15C" CIRCUIT NO. 29 USING 2#12, 1#12G, 1#12(G) CONDUCTORS WITHIN A DEDICATED 3/4" CONDUIT FROM PANEL TO THE FLOOR BOX.

HOPKINSVILLE - CHRISTIAN
COUNTY ACADEMY

KDE # : BG 22-104

5185 FT. CAMPBELL BLVD
HOPKINSVILLE, KY 42240


HAFFER
architects • designers • engineers

21 SE Third Street,
Suite 800
Evansville, IN 47708
T: 812.422.4187
F: 812.421.6776
www.hafferdesign.com

ARCHITECT'S PROJECT NO.
2106-204

DATE:
10/13/23

TYPE OF DRAWING NO.
PR-1E4

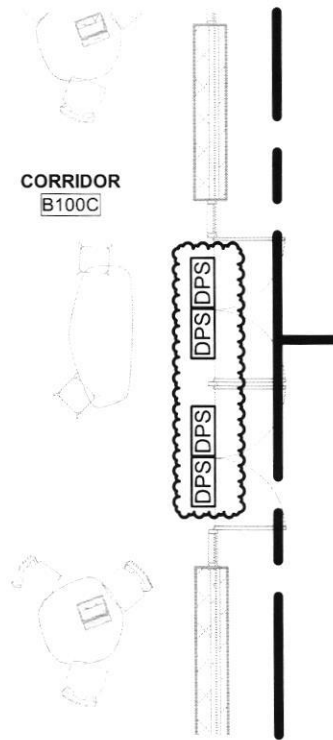

SYSTEMS & TECHNOLOGY - FIRST FLOOR - AREA "B"

ORIGINAL DETAIL 2 / E3.1B

1/8" = 1'-0"

HOPKINSVILLE - CHRISTIAN
COUNTY ACADEMY

KDE # : BG 22-104

5185 FT. CAMPBELL BLVD
HOPKINSVILLE, KY 42240

HAFER

architects • designers • engineers

21 SE Third Street,
Suite 800
Evansville, IN 47708

T: 812.422.4187
F: 812.421.6776
www.haferdesign.com

ARCHITECTS PROJECT NO.


2106-204

DATE:

10/13/23

TYPE OF DRAWING NO.


PR-1E5

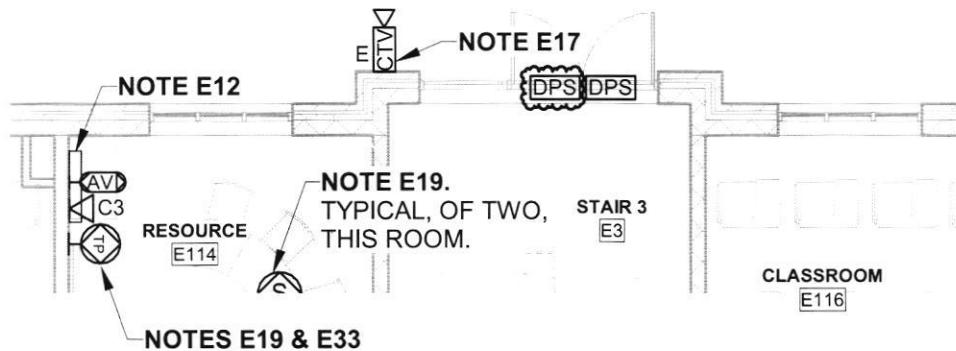

SYSTEMS & TECHNOLOGY - FIRST FLOOR - AREA "E"

ORIGINAL DETAIL 2 / E3.1E

1/8" = 1'-0"

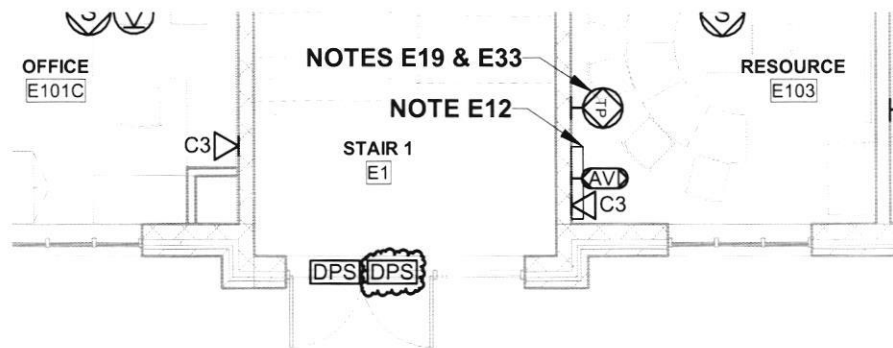

SYSTEMS & TECHNOLOGY - FIRST FLOOR - AREA "E"

ORIGINAL DETAIL 2 / E3.1E

1/8" = 1'-0"

HOPKINSVILLE - CHRISTIAN
COUNTY ACADEMY

KDE # : BG 22-104

5185 FT. CAMPBELL BLVD
HOPKINSVILLE, KY 42240

HAFER
architects • designers • engineers

21 SE Third Street,
Suite 800
Evansville, IN 47708

T: 812.422.4187
F: 812.421.6776
www.haferdesign.com

ARCHITECTS PROJECT NO.

2106-204


DATE:

10/13/23

TYPE OF DRAWING NO.

PR-1E6

NOTES (LIGHTING PLAN - FIRST FLOOR - AREA "B") [CONTINUED]:
B8. PROVIDE BOTH "DUSK-TO-DAWN" AND "DUSK-ON-EARLY-OFF" TYPE CONTROL CIRCUITS TO THIS FIXTURE.
B9. CONNECT TO BRANCH CIRCUIT AS INDICATED THRU LIGHTING CONTROL RELAY PANEL "TCRP11C". SEE LIGHTING CONTROL RELAY PANEL SCHEDULE, SHEET E1.12, FOR ADDITIONAL REQUIREMENTS.

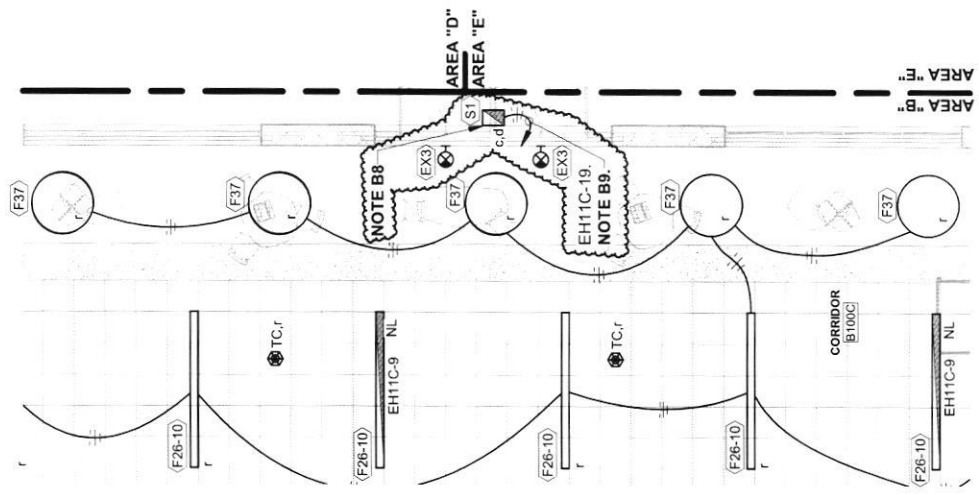


**LIGHTING PLAN - FIRST FLOOR
- AREA "B"**
1/8" = 1'-0"
ORIGINAL DETAIL 1 / E4.1B

HOPKINSVILLE - CHRISTIAN
COUNTY ACADEMY
KDE #: BG 22-104
5185 FT. CAMPBELL BLVD
HOPKINSVILLE, KY 42240

HAFER
architects • designers • engineers
T: 812.422.4187
F: 812.421.6776
www.hafersdesign.com
21 SE Third Street,
Suite 800
Evansville, IN 47708


ARCHITECTS PROJECT NO.:
DATE: 10/13/23
2106-204
TYPE OF DRAWING NO.:
PR-1E7

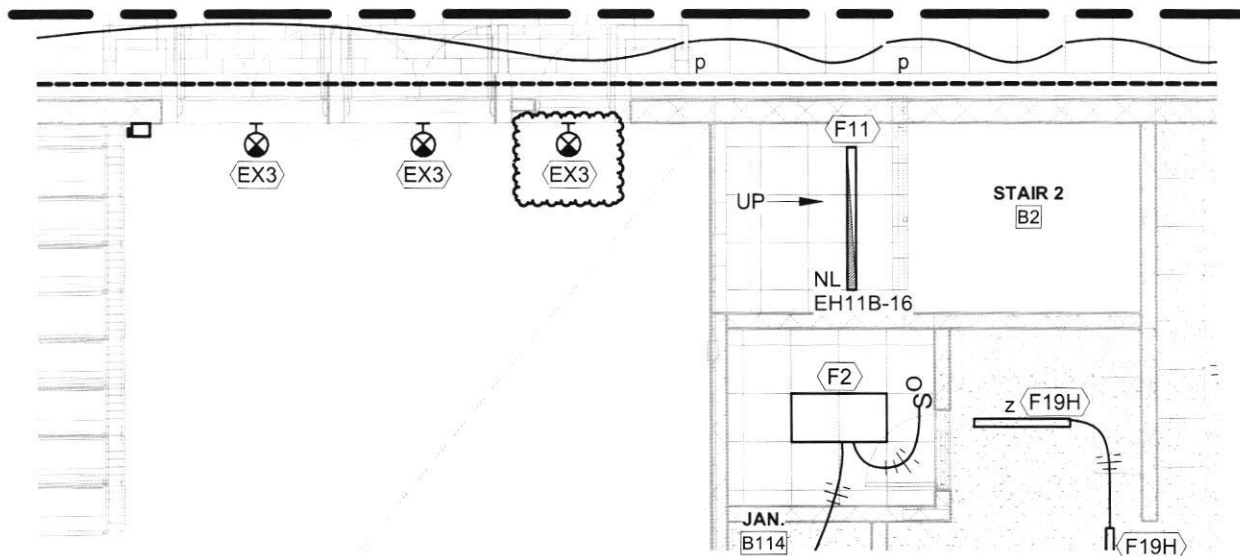

LIGHTING PLAN - FIRST FLOOR AREA "B" ALT

ORIGINAL DETAIL 1 / E4.1B-Alt

1/8" = 1'-0"

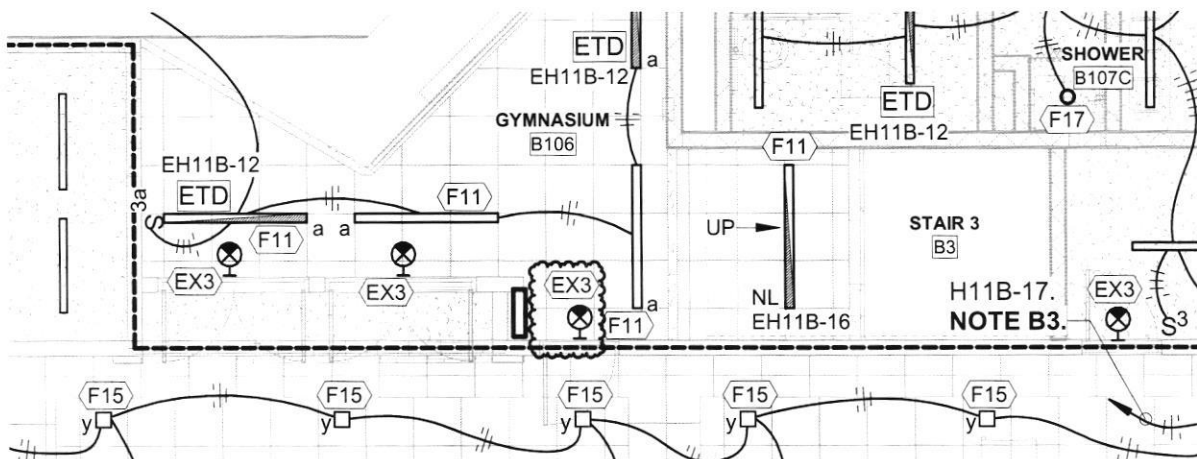

LIGHTING PLAN - FIRST FLOOR AREA "B" ALT

ORIGINAL DETAIL 1 / E4.1B-Alt

1/8" = 1'-0"

HOPKINSVILLE - CHRISTIAN
COUNTY ACADEMY

KDE #: BG 22-104

5185 FT. CAMPBELL BLVD
HOPKINSVILLE, KY 42240

HAFER
architects • designers • engineers

21 SE Third Street,
Suite 800
Evansville, IN 47708

T: 812.422.4187
F: 812.421.6776
www.haferdesign.com

ARCHITECTS PROJECT NO.


2106-204

DATE:

10/13/23

TYPE OF DRAWING NO.

PR-1E8

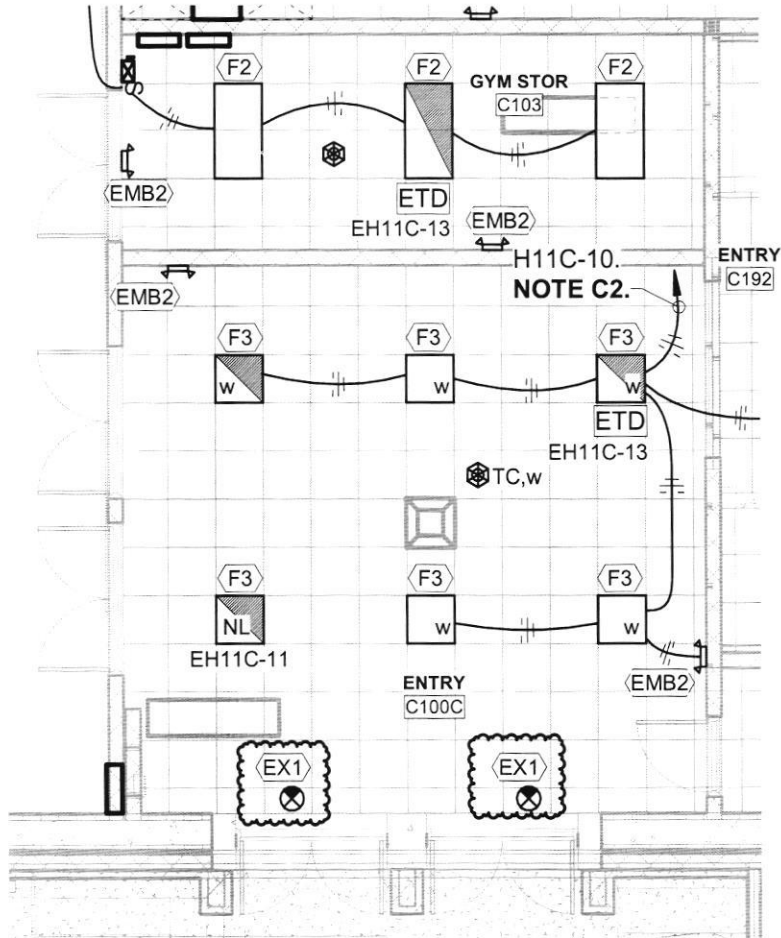

LIGHTING PLAN - FIRST FLOOR AREA "C"

ORIGINAL DETAIL 1 / E4.1C

1/8" = 1'-0"

HOPKINSVILLE - CHRISTIAN
COUNTY ACADEMY

KDE # : BG 22-104

5185 FT. CAMPBELL BLVD
HOPKINSVILLE, KY 42240

HA FER
architects • designers • engineers

21 SE Third Street,
Suite 800
Evansville, IN 47708

T: 812.422.4187
F: 812.421.6776
www.haferdesign.com

ARCHITECTS PROJECT NO.


2106-204

DATE:

10/13/23

TYPE OF DRAWING NO.

PR-1E9

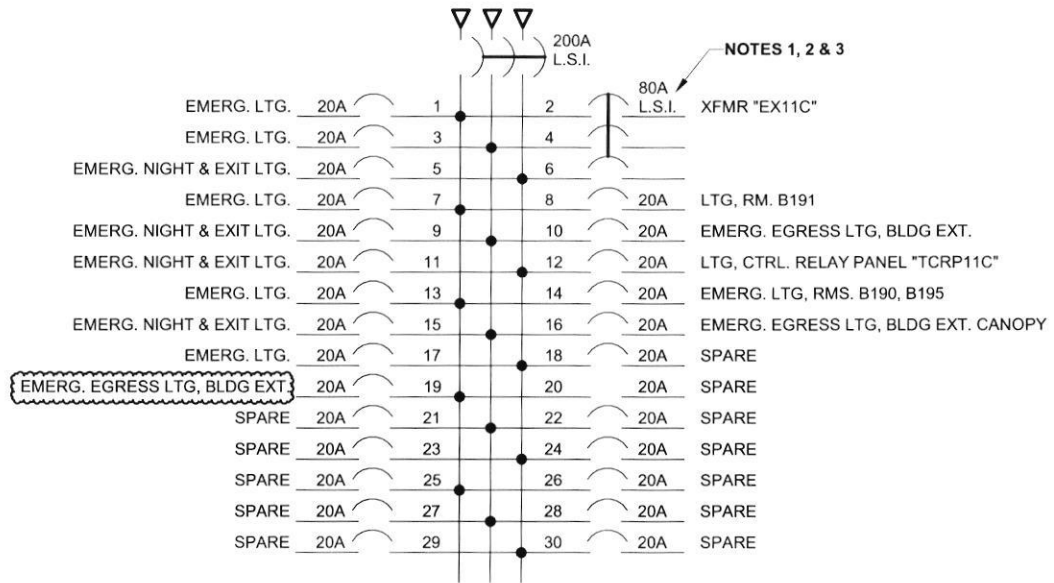


PANEL "EH11C" [NEC700]

200A, 480Y/277V, 3PH, 4W
 SURFACE MOUNT
 30 SPACE
 18,000 A.I.C.
 PROVIDE WITH HINGED COVER ENCLOSURE.

ARCHITECTS PROJECT NO. **2106-204**
 DATE: **10/13/23**
 TYPE OF DRAWING NO. **PR-1E10**

HAFFER
 architects • designers • engineers
 21 SE Third Street,
 Suite 800
 Evansville, IN 47708
 T: 812.422.4187
 F: 812.421.5176
 www.hafferdsgn.com

**HOPKINSVILLE - CHRISTIAN
 COUNTY ACADEMY**
 KDE # : BG 22-104
 5185 FT. CAMPBELL BLVD
 HOPKINSVILLE, KY 42240

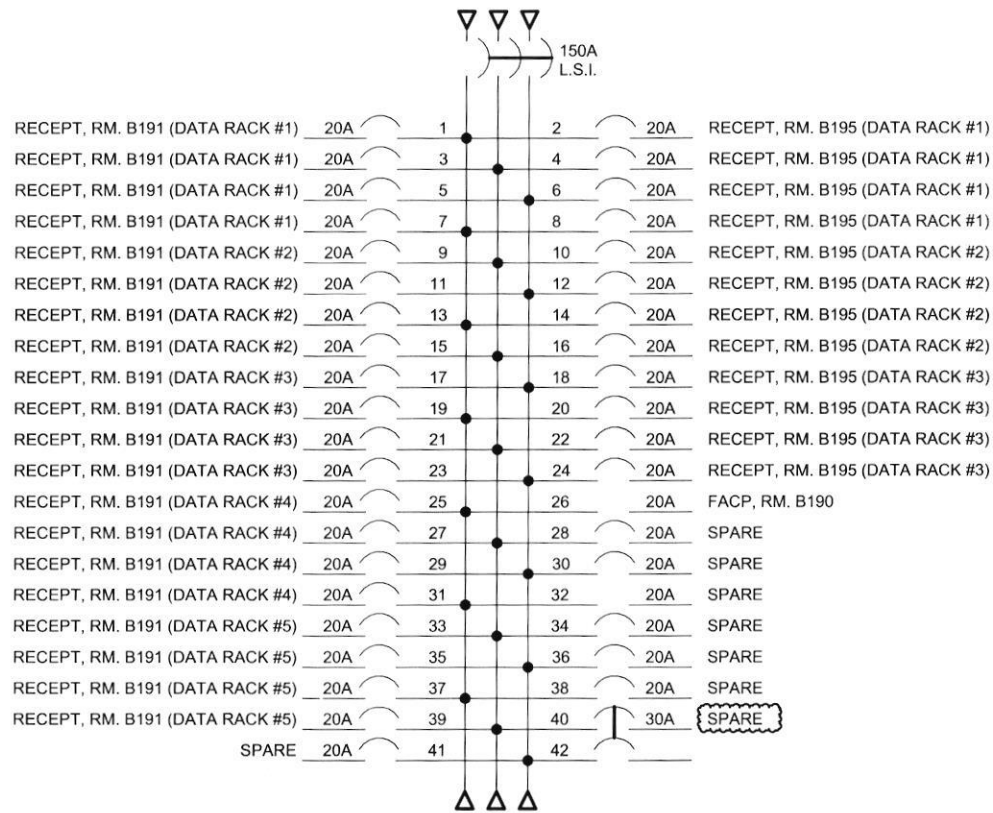



PANEL "EL11C" [NEC700]

150A, 208Y/120V, 3PH, 4W
 SURFACE MOUNT
 42 SPACE
 10,000 A.I.C.
 PROVIDE WITH HINGED COVER ENCLOSURE.
 PROVIDE WITH FEED-THRU LUGS.

ARCHITECTS PROJECT NO. **2106-204** DATE: **10/13/23**
 TYPE OF DRAWING NO. **PR-1E11**

HAFTER
 architects • designers • engineers
 21 SE Third Street,
 Suite 800
 Evansville, IN 47708
 T: 812.422.4187
 F: 812.421.6716
 www.hafterdesign.com

**HOPKINSVILLE - CHRISTIAN
 COUNTY ACADEMY**
 KDE # : BG 22-104
 5185 FT. CAMPBELL BLVD
 HOPKINSVILLE, KY 42240

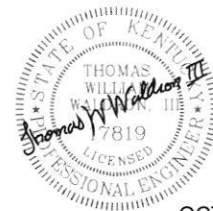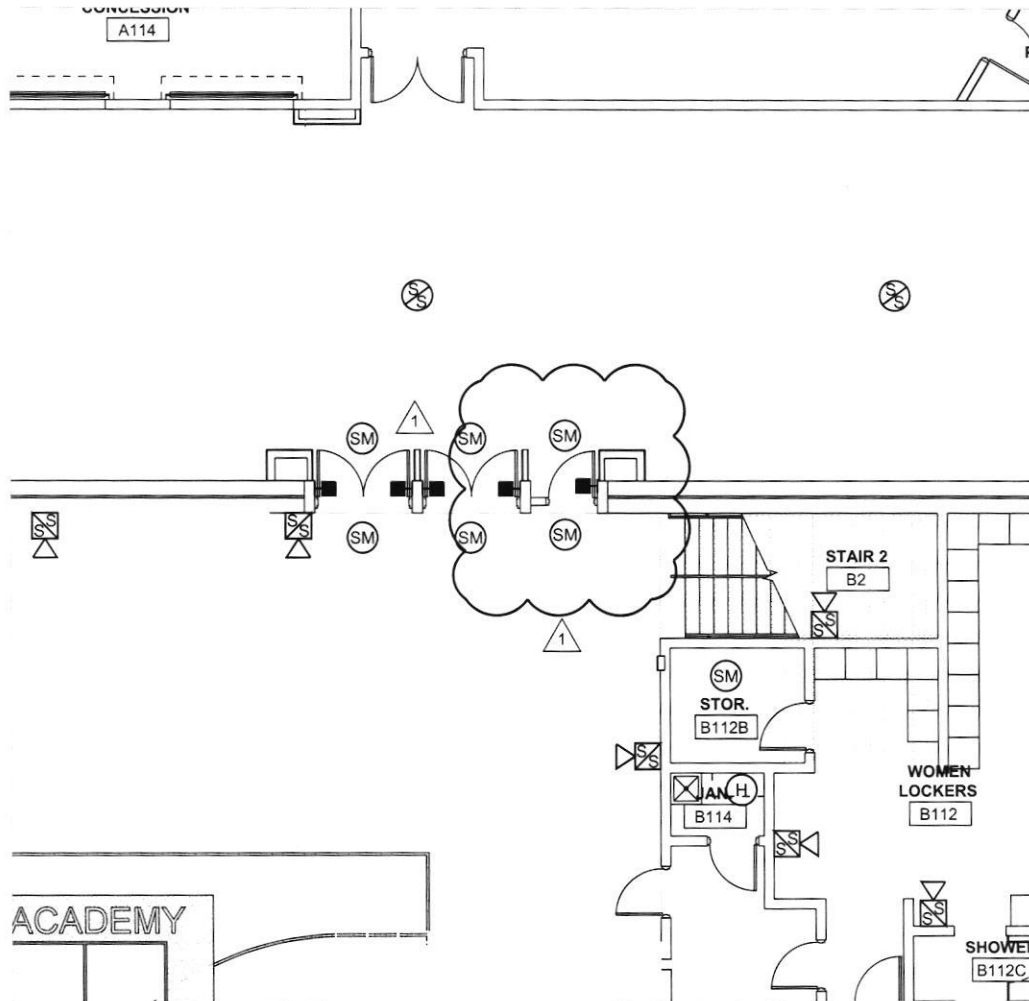

OCT, 2023

HOPKINSVILLE - CHRISTIAN
COUNTY ACADEMY

KDE # : BG 22-104

5185 FT. CAMPBELL BLVD
HOPKINSVILLE, KY 42240



HAFER
architects - designers - engineers

21 SE Third Street,
Suite 800
Evansville, IN 47708
T: 812.422.4187
F: 812.421.6776
www.hafersdesign.com

ARCHITECTS PROJECT NO. DATE
2106-201 **09/23/2023**

TYPE OF DRAWING NO.

PR-1E12

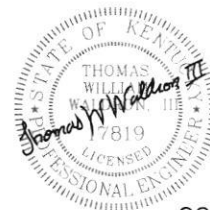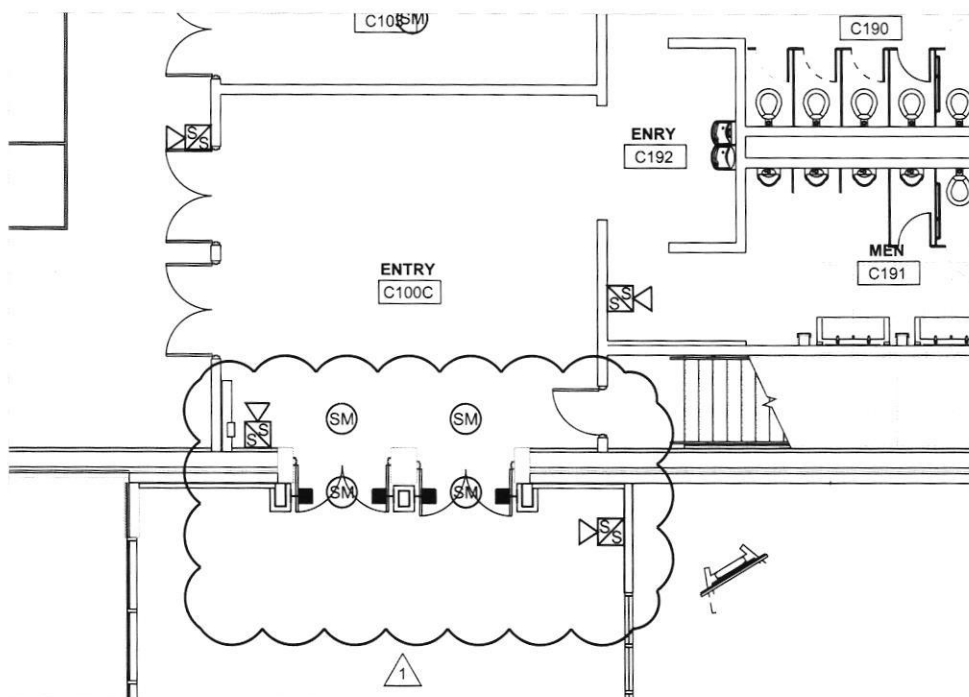

OCT, 2023

HOPKINSVILLE - CHRISTIAN
COUNTY ACADEMY

KDE # : BG 22-104

5185 FT. CAMPBELL BLVD
HOPKINSVILLE, KY 42240

HAFER

architects • designers • engineers



21 SE Third Street,
Suite 800
Evansville, IN 47708

T: 812.422.4187
F: 812.421.5716
www.hafersdesign.com

ARCHITECTS PROJECT NO. DATE
2106-201 09/23/2023

TYPE OF DRAWING NO.

PR-1E13

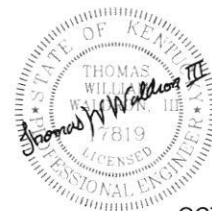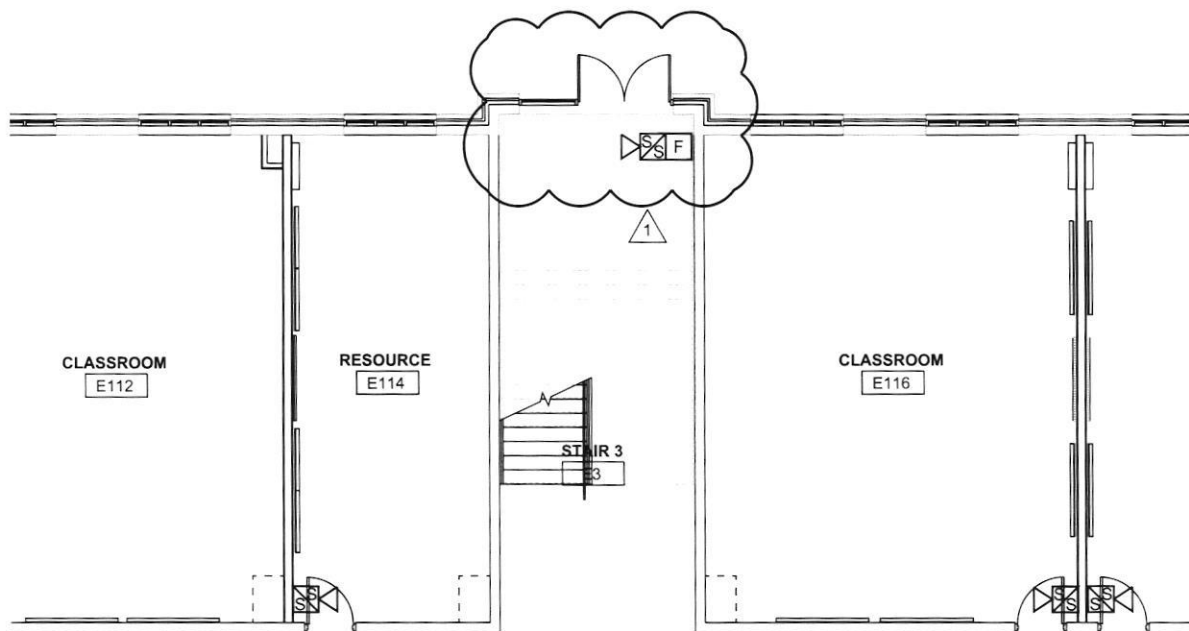

OCT, 2023

HOPKINSVILLE - CHRISTIAN
COUNTY ACADEMY

KDE # : BG 22-104

5185 FT. CAMPBELL BLVD
HOPKINSVILLE, KY 42240



HA FER
architects - designers - engineers

21 SE Third Street,
Suite 800
Evansville, IN 47708
T: 812.422.4187
F: 812.421.6716
www.haferdesign.com

ARCHITECTS PROJECT NO. DATE
2106-201 **09/23/2023**

TYPE OF DRAWING NO.

PR-1E14

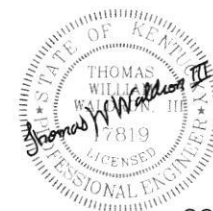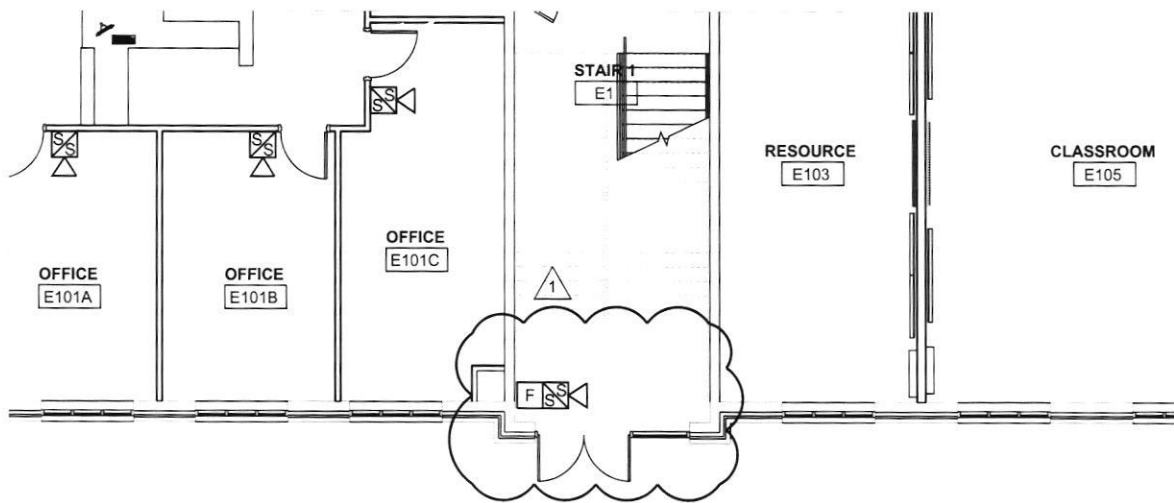

OCT, 2023

HOPKINSVILLE - CHRISTIAN
COUNTY ACADEMY

KDE # : BG 22-104

5185 FT. CAMPBELL BLVD
HOPKINSVILLE, KY 42240

HAFER
architects - designers - engineers

2155 Third Street,
Suite 800,
Evansville, IN 47708

T: 812.422.4187
F: 812.421.6746
www.hafersdesign.com

ARCHITECTS PROJECT NO. DATE:

2106-201

09/23/2023

TYPE OF DRAWING NO.

PR-1E15

Christian County High School
PROPOSAL REQUEST PRICING SHEET
ALLIANCE JOB #22-033

PROPOSED CHANGE REQUEST NO. PR-01 DATE 1/10/2024

DESCRIPTION Remove Coiling Tornado Door

CONTRACTOR A&K Construction BID PKG. 30

WORK DESCRIPTION Deduct 1 Fire Rated Tornado Coiling Door in Area C

A. UNIT PRICING FROM FORM OF PROPOSAL

1. UNIT PRICING	<u> </u> QTY.	<u> </u> U.P.	<u>\$ -</u>	TOTAL COST
2. UNIT PRICING	<u> </u> QTY.	<u> </u> U.P.	<u>\$ -</u>	TOTAL COST
3. UNIT PRICING	<u> </u> QTY.	<u> </u> U.P.	<u>\$ -</u>	TOTAL COST

B. MATERIAL

1. <u> </u> ITEM	<u> </u> QTY.	<u> </u> UNIT	<u>\$ -</u>
2. <u> </u> ITEM	<u> </u> QTY.	<u> </u> UNIT	<u>\$ -</u>
3. <u> </u> ITEM	<u> </u> QTY.	<u> </u> UNIT	<u>\$ -</u>

MATERIAL TOTAL \$ -

LABOR

1. <u> </u> HOURS @ <u> </u>	<u>\$/HR</u>	<u>\$ -</u>
2. <u> </u> HOURS @ <u> </u>	<u>\$/HR</u>	<u>\$ -</u>
3. <u> </u> HOURS @ <u> </u>	<u>\$/HR</u>	<u>\$ -</u>

LABOR TOTAL \$ -

EQUIPMENT

EQUIPMENT TOTAL \$ -

MATERIAL, LABOR & EQUIPMENT SUBTOTAL \$ -

15% OVERHEAD/PROFIT MARK-UP \$ -

DEDUCT DPO (DIRECT PURCHASE ORDER) MATERIAL \$ (49,785.00)

TOTAL ADD/DEDUCT \$ 49,785.00

NOTE: CONTRACTORS ARE TO USE UNIT PRICES WHERE APPLICABLE.

FACPAC PO Change Order Supplemental Information Form (Ref# 59440)

Form Status: Saved

Tier 1 Project: Consolidated High School

BG Number: 22-104

Status: Active

District: Christian County (HB678)

Phase: Project Initiation (View Checklist)

Contract: A&K Construction, Inc. , 0030, General Trades

Type: CM Bid Package

Proposed

Purchase Order Number: 4

Vendor Name: Architectural Sales

Change Order Number	1
Time Extension Required	No
Date Of Change Order	2/9/2024
Change Order Amount To Date	Decrease

Construction Contingency

Calculations below are project wide. Remaining negative Construction Contingency may require the submission of a revised BG1.

Current Approved Amount	\$6,320,436.60
Net Approved COs	\$0.00
Remaining After Approved COs	\$6,320,436.60
Net All COs	\$326,475.91
Remaining After All COs	\$5,993,960.69

This Requested Change Order Amount (\$49,785.00)

+/-

Change In A/E Fee This Change Order

+/-

Change In CM Fee This Change Order \$0.00

+/-

Remaining Construction Contingency \$5,993,960.69

Balance

Contract Change Requested By Architect/Engineer

Contract Change Reason Code Reduction of Scope

Change Order Description And Justification

Deduct coiling tornado door from purchase order.

Cost Benefit To Owner

This will result in a cost savings to the owner.

Contract unit prices have been utilized No
to support the cost associated with this
change order.

Detailed Cost Breakdown

Contract unit prices have not been utilized, provide a detailed cost breakdown which
separates labor, material, profit and overhead.

Detail Item	Amount	Percent of Total
Labor		0.00%
Materials	(\$49,785.00)	100.00%
Profit and Overhead		0.00%
Bond Insurance		0.00%

Cost Breakdown Total:

\$-49,785.00

Cost for this Change Order supported No
by an alternate bid or competitive price
quote

Explain Why

Executed purchase order with supplier.

Change Order Supplemental Information Form Signature Page (Online Form Ref# 59440)

Architect

Date

Construction Manager

Date

Finance Officer

Date

Local Board of Education Designee

Date