

PROJECT:

**HENDERSON COUNTY SCHOOLS
HENDERSON COUNTY HIGH SCHOOL
CAREER AND TECHNICAL EDUCATION – ADDITION AND RENOVATION**

OWNER:

**HENDERSON COUNTY BOARD OF EDUCATION
1805 SECOND STREET
HENDERSON, KENTUCKY 42420**

ARCHITECT:

**R.B.S. DESIGN GROUP, P.S.C.
723 HARVARD DRIVE
OWENSBORO, KENTUCKY 42301
270-683-1158 (F)270-683-2446**

**CIVIL
ENGINEER:**


**AMERICAN ENGINEERS, INC.
308 EAST 25th STREET
OWENSBORO, KENTUCKY 42303
270-478-4610**

**MECHANICAL/
ELECTRICAL
ENGINEER:**

**WBW ENGINEERING, INC.
3000 CANTON STREET
HOPKINSVILLE, KENTUCKY 42240
270-886-2536 (F)270-885-7978**

**STRUCTURAL
ENGINEER:**


**WILKIE STRUCTURAL ENGINEERING, INC.
420 MAIN STREET, SUITE 1010
EVANSVILLE, INDIANA 47708
812-423-6347 (F)812-422-9236**

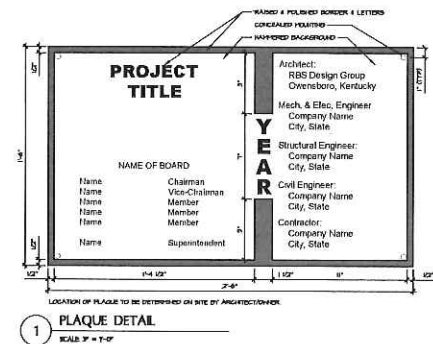

PLAQUE DETAIL
SCALE: 3" = 1'-0"

MATERIALS & GRAPHIC SYMBOLS		ABBREVIATIONS		VICINITY MAP	STRUCTURAL DESIGN DATA	SHEET INDEX	DESIGN DATA
EARTHWORK ADDITIONAL FILL (Hatched) CONCRETE (Hatched) MASSONRY (Hatched) STONE (Hatched) WOOD (Hatched) GLAZING (Hatched) INSULATION (Hatched) PARTITIONS (Hatched) SYMBOLS (Hatched)		ABBREVIATIONS ADDITIONAL FILL (Hatched) CONCRETE (Hatched) MASSONRY (Hatched) STONE (Hatched) WOOD (Hatched) GLAZING (Hatched) INSULATION (Hatched) PARTITIONS (Hatched) SYMBOLS (Hatched)			REFER TO SLI	TITLE SHEET DEMOGRAPHIC ARCHITECTURAL MECHANICAL / ELECTRICAL	DESIGN DATA SCOPE: THE DESIGN CRITERIA PRESENTED BELOW IS FOR CONSTRUCTION ONLY AND SHALL NOT BE USED BY THE CONTRACTOR FOR DESIGN PURPOSES. EXISTING BUILDING: 7 ADDITION: 7 CONSTRUCTION TYPE: 7 USE GROUP: 7 CODE: KBC (2003) RECORD DRAWINGS SET NUMBER

DATE	1/20/20
BY	CH
CHECKED BY	CH
DATE	1/20/20
BY	CH
CHECKED BY	CH
DATE	1/20/20

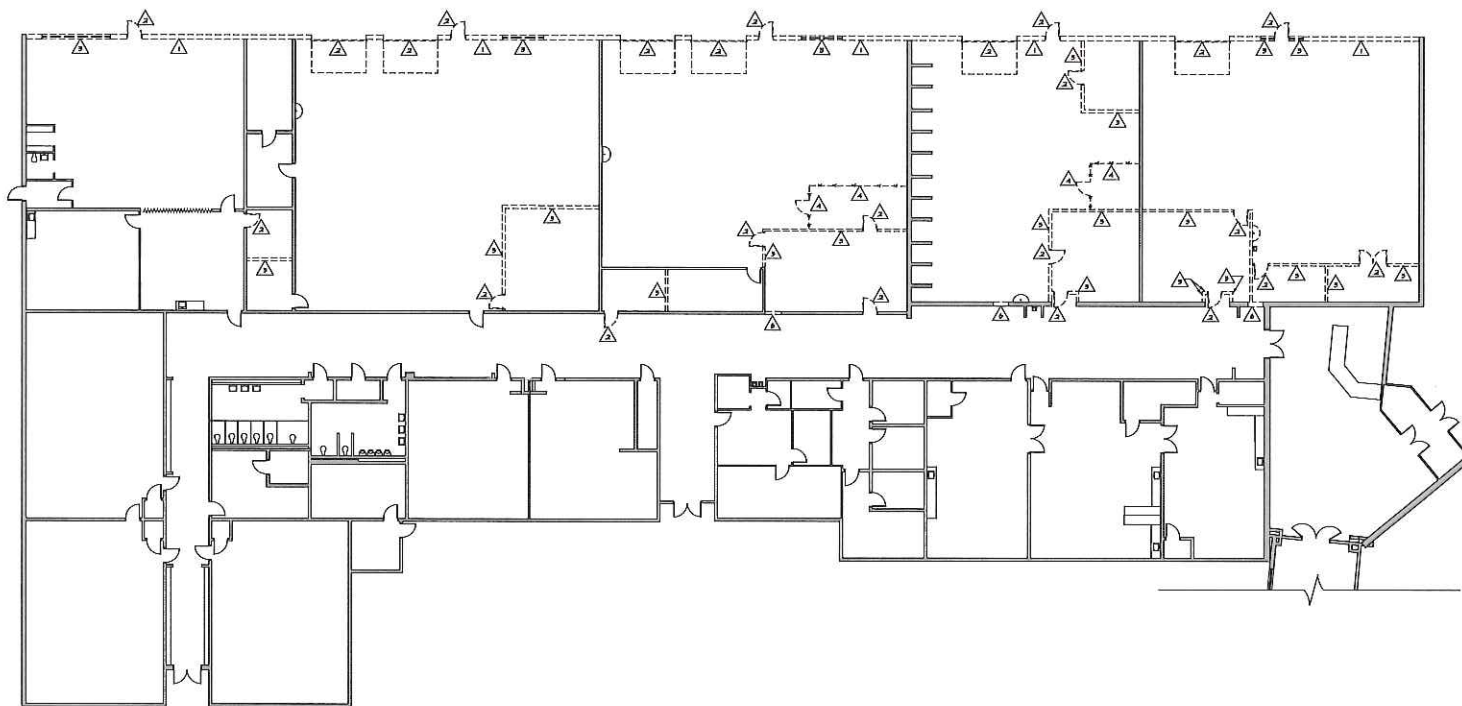

1 DEMOLITION PLAN
SCALE: 3/32" = 1'-0"

0' 10' 20' 30'




DEMOLITION NOTES

- △ REMOVE EXISTING HALL BY ITS ENTIRETY, EXCLUDING BUT NOT LIMITED TO HANDRAILS, WALL BASES, FISTERS, SPOURWAYS, DOORS, WINDOWS AND ANY FEP ITEMS. SEE FEP SHEETS FOR DETAILS.
- △ REMOVE EXISTING DOOR BY ITS ENTIRETY, EXCLUDING BUT NOT LIMITED TO DOOR FRAME AND HANDRAIL.
- △ REMOVE EXISTING WINDOW BY ITS ENTIRETY.
- △ REMOVE EXISTING METAL FENCE AND BARS BY THEIR ENTIRETY.
- △ REMOVE EXISTING HALL BY ITS ENTIRETY, EXCLUDING BUT NOT LIMITED TO FISTERS, WINDOWS AND ANY FEP ITEMS. SEE FEP SHEETS FOR FURTHER DETAILS.
- △ REMOVE PORTION OF EXISTING HALL AS REQUIRED TO INSTALL NEW DOOR AND FRAME.
- △ REMOVE EXISTING TRUCK DRAIN BY ITS ENTIRETY.
- △ REMOVE EXISTING CEILING IN CLASSROOMS/??

GENERAL NOTES

1. CONTRACTOR IS RESPONSIBLE FOR ALL DEMOLITION REQUIRED FOR NEW CONSTRUCTION UNLESS SPECIFICALLY INDICATED ON SET.
2. ALL DEMOLITION ITEMS NOT INDICATED TO BE TYPED OVER TO OWNER SHALL BE DEMOLISHED BY CITY DATE IN A LEGAL MANNER.
3. CONTRACTOR IS TO FULLY VERIFY ALL EXISTING CONDITIONS AND BE RESPONSIBLE FOR SAME PRIOR TO REMOVAL.

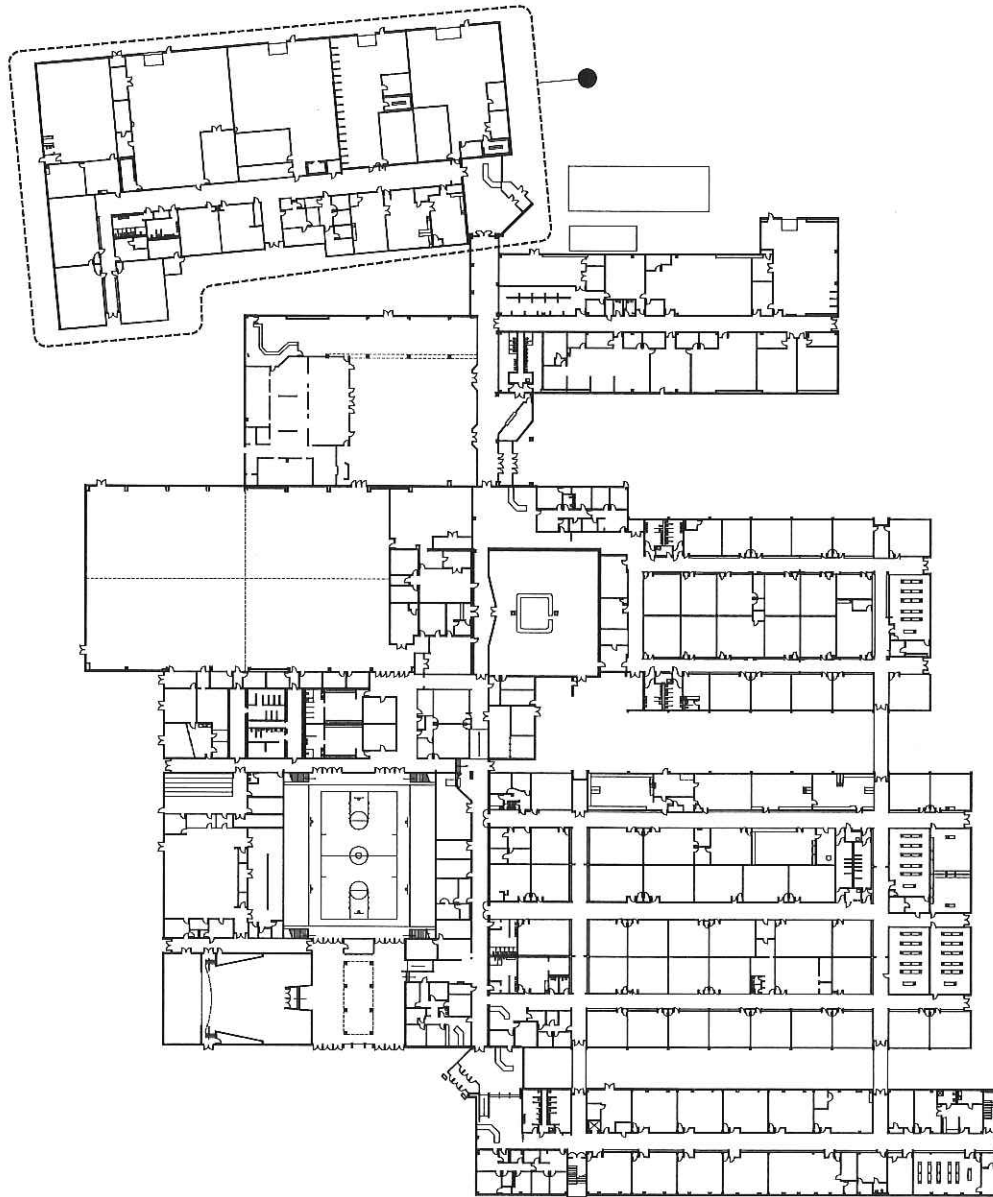

1 HENDERSON COUNTY HIGH SCHOOL - OVERALL FLOOR PLAN
SCALE: 1/8" = 1'-0"

0' 10' 20' 30'




DESIGN DEVELOPMENT - FOR REVIEW ONLY

RBS DESIGN GROUP
Architecture

REVISIONS	DATE	BY	REASON
1			
2			
3			
4			
5			
6			
7			
8			
9			
10			

HENDERSON COUNTY SCHOOLS
HENDERSON COUNTY HIGH SCHOOL
CAREER AND TECHNICAL EDUCATION - ADDITION AND RENOVATION
OVERALL FLOOR PLAN

SHEET NUMBER
A1.0

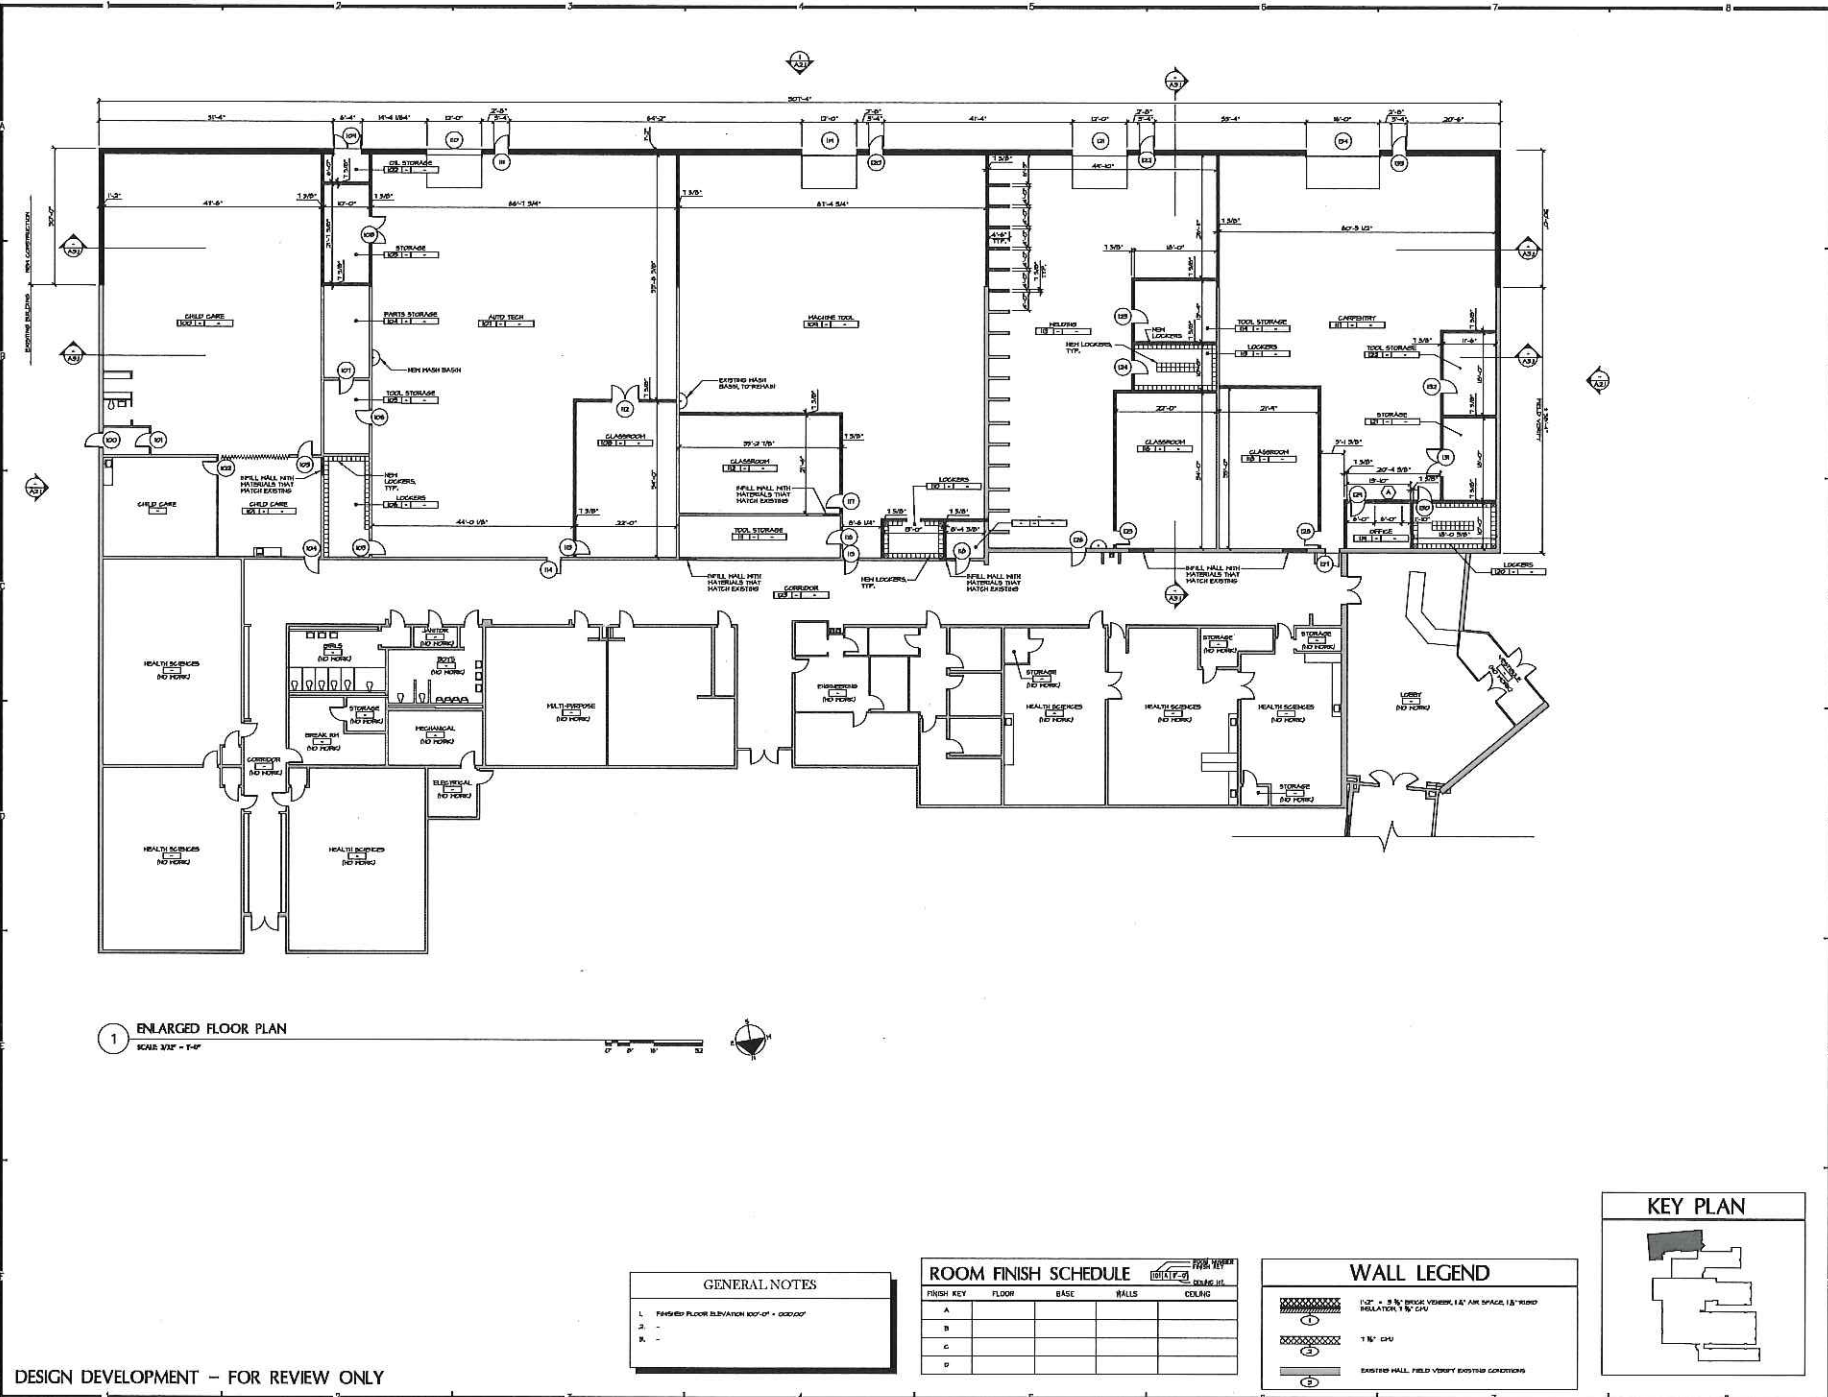

GENERAL NOTES


1. FINISHED FLOOR ELEVATION 100'-0" = 000'-00"
2. -
3. -


ROOM FINISH SCHEDULE

FINISH KEY	FLOOR	BASE	WALLS	CEILING
A				
B				
C				
D				


WALL LEGEND

	1/2" x 3 1/2" BRICK VENEER, 1 1/2" AIR SPACE, 1 1/2" Gypsum Insulation, 5/8" GFI
	1 1/2" GFI
	EXISTING HALL FIELD VENEER EXISTING CONDITIONS

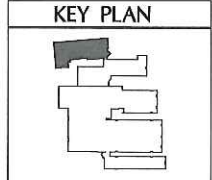


 


1 BUILDING ELEVATION
SCALE 3/32" = 1'-0"

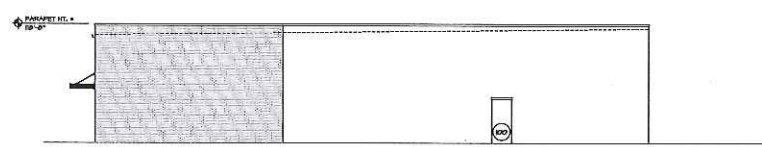


2 BUILDING ELEVATION
SCALE 3/8" = 1'-0"

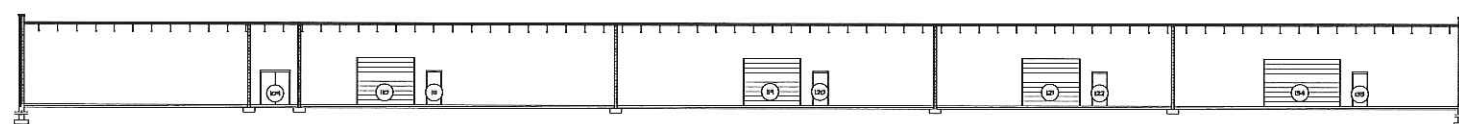


4 BUILDING SECTION
SCALE 3/32" = 1'-0"

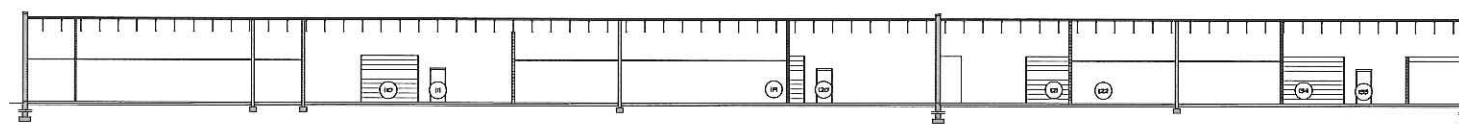

5 BUILDING ELEVATION
SCALE 3/32" = 1'-0"

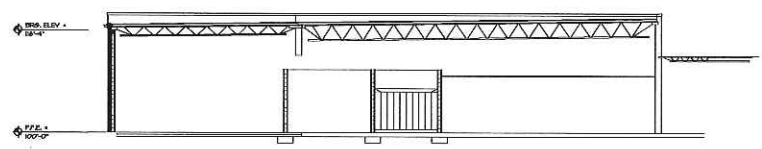

6 BUILDING SECTION
SCALE 3/8" = 1'-0"


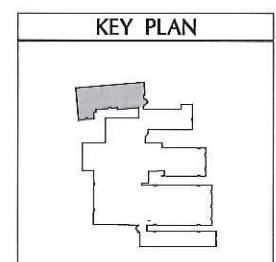


DESIGN DEVELOPMENT - FOR REVIEW ONLY

DOOR AND FRAME SCHEDULE


NO.	LABEL	PR	DOOR			MTRL	TYPE	FRAME			HARDWARE	SIGNAGE	REMARKS
			WD	HGT	THK			TYPE	HEAD	JAMB	SET NO		
100													
101													
102													
103													
104													
105													
106													
107													
108													
109													
110													
111													
112													
113													
114													
115													
116													
117													
118													
119													
120													
121													
122													
123													
124													
125													
126													
127													
128													
129													
130													
131													
132													
133													
134													

 HARDWARE SETS

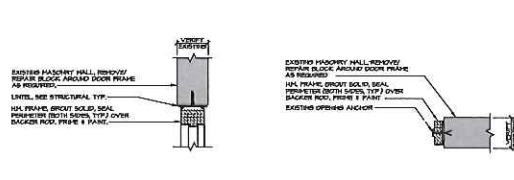


1 HOLLOW METAL HEAD DETAIL
SCALE 1/2" = 1'-0"


2 HOLLOW METAL JAMB DETAIL
SCALE 1/2" = 1'-0"

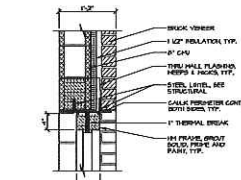


3 HOLLOW METAL HEAD DETAIL
SCALE 1/2" = 1'-0"

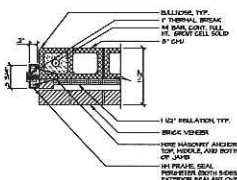


4 HOLLOW METAL JAMB DETAIL
SCALE 1/2" = 1'-0"

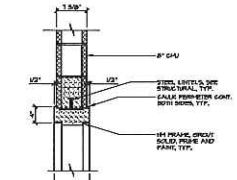


5 HOLLOW METAL HEAD DETAIL
SCALE 1/2" = 1'-0"

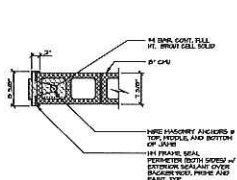


6 HOLLOW METAL JAMB DETAIL
SCALE 1/2" = 1'-0"

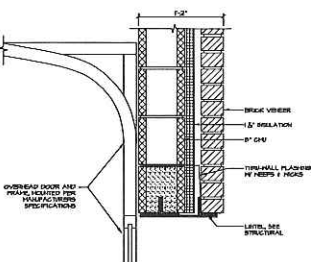


7 OVERHEAD DOOR HEAD
SCALE 1/2" = 1'-0"

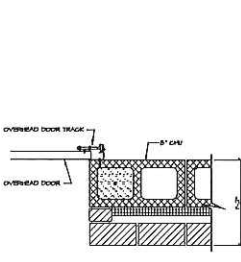


8 OVERHEAD DOOR JAMB
SCALE 1/2" = 1'-0"

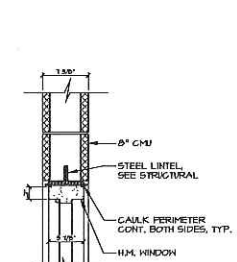


9 H.M. WINDOW HEAD
SCALE 1/2" = 1'-0"

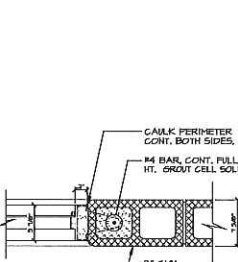

10 H.M. WINDOW JAMB
SCALE 1/2" = 1'-0"

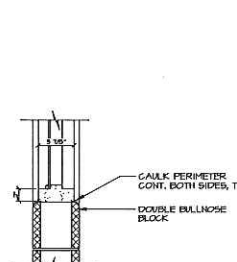


11 H.M. WINDOW SILL
SCALE 1/2" = 1'-0"

 


DOOR AND FRAME TYPES

 SCALE 1/2" = 1'-0"



INTERIOR SIGNAGE

 
SCALE 1/2" = 1'-0"




WINDOW ELEVATION

SCALE 1/2" = 1'-0"

 DESIGN DEVELOPMENT - FOR REVIEW ONLY

[illegible][illegible]

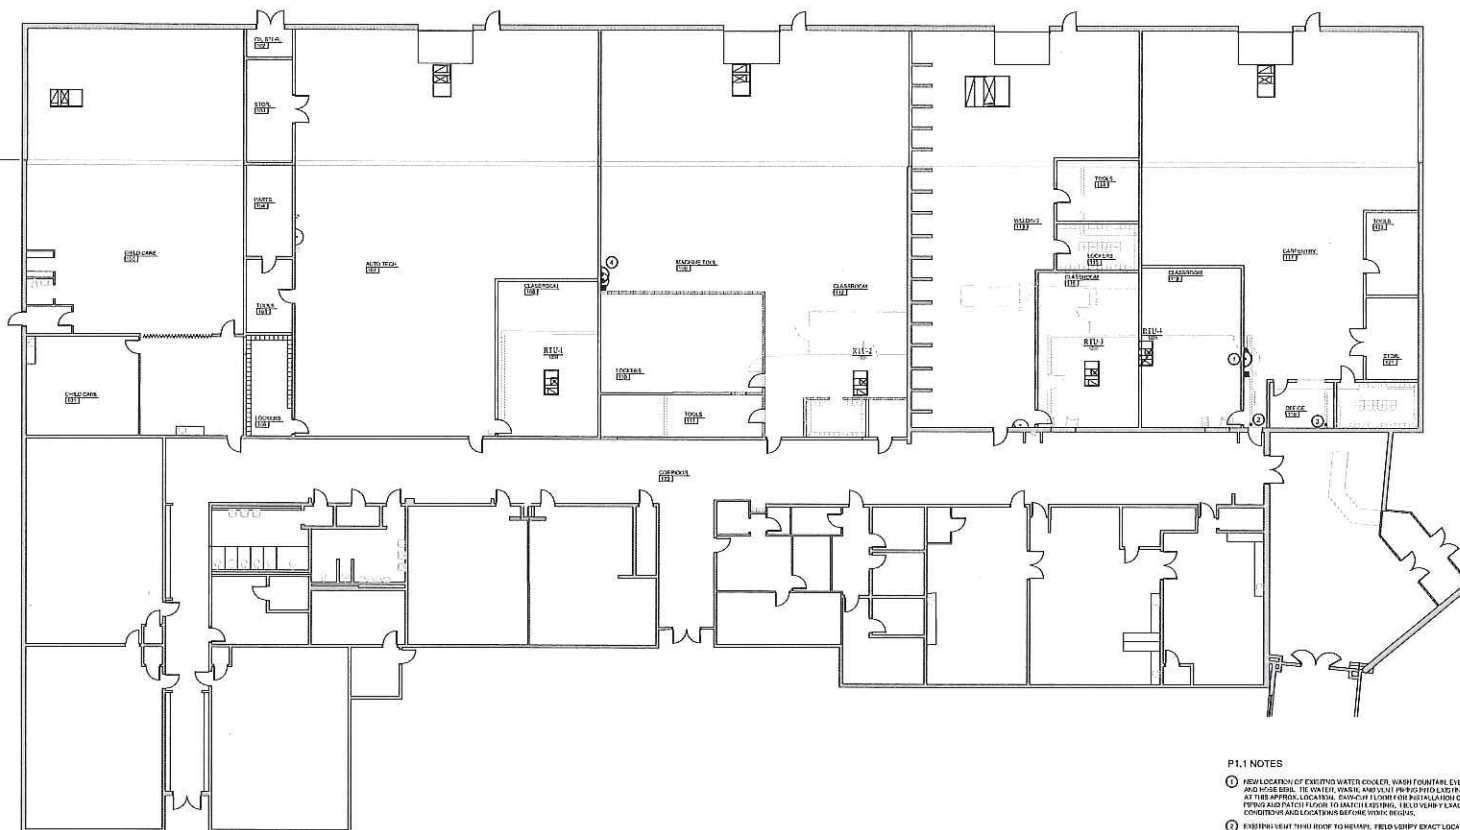


1 PLUMBING PLAN
SCALE 3/32" = 1'-0"




P1.1 NOTES


- ① NEW LOCATION OF EXISTING WATER COOLER, WASH FOUNTAIN, SINKS, AND HOSE BOB. THE WATER, WASH, AND VENT PIPING TO EXISTING FLOOR AT THE EXISTING LOCATION. REMOVE EXISTING PIPING AND PATCH FLOOR TO MATCH EXISTING. FIELD VERIFY EXISTING CONDITIONS AND LOCATION BEFORE NEW INSTALL.
- ② EXISTING VENT "H" ROOF TO REMAIN. FIELD VERIFY EXISTING LOCATION.
- ③ EXISTING VENT STACK "H" ROOF TO REMAIN. FIELD VERIFY EXISTING LOCATION. PROVIDE CHASE FOR VENT STACK.
- ④ NEW LOCATION OF EXISTING WATER COOLER, WASH FOUNTAIN AND SINKS. REMOVE EXISTING PIPING. FIELD VERIFY EXISTING CONDITIONS AND LOCATION BEFORE NEW INSTALL.

WALL LEGEND	
	1/2" x 3/4" BRICK VENEER, 1/2" AIR SPACE, 1/2" RIGID INSULATION, 1/2" GYPSUM
	1/2" GYPSUM
	EXISTING WALL. FIELD VERIFY EXISTING CONDITIONS

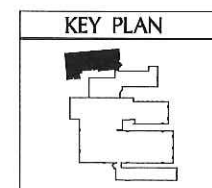


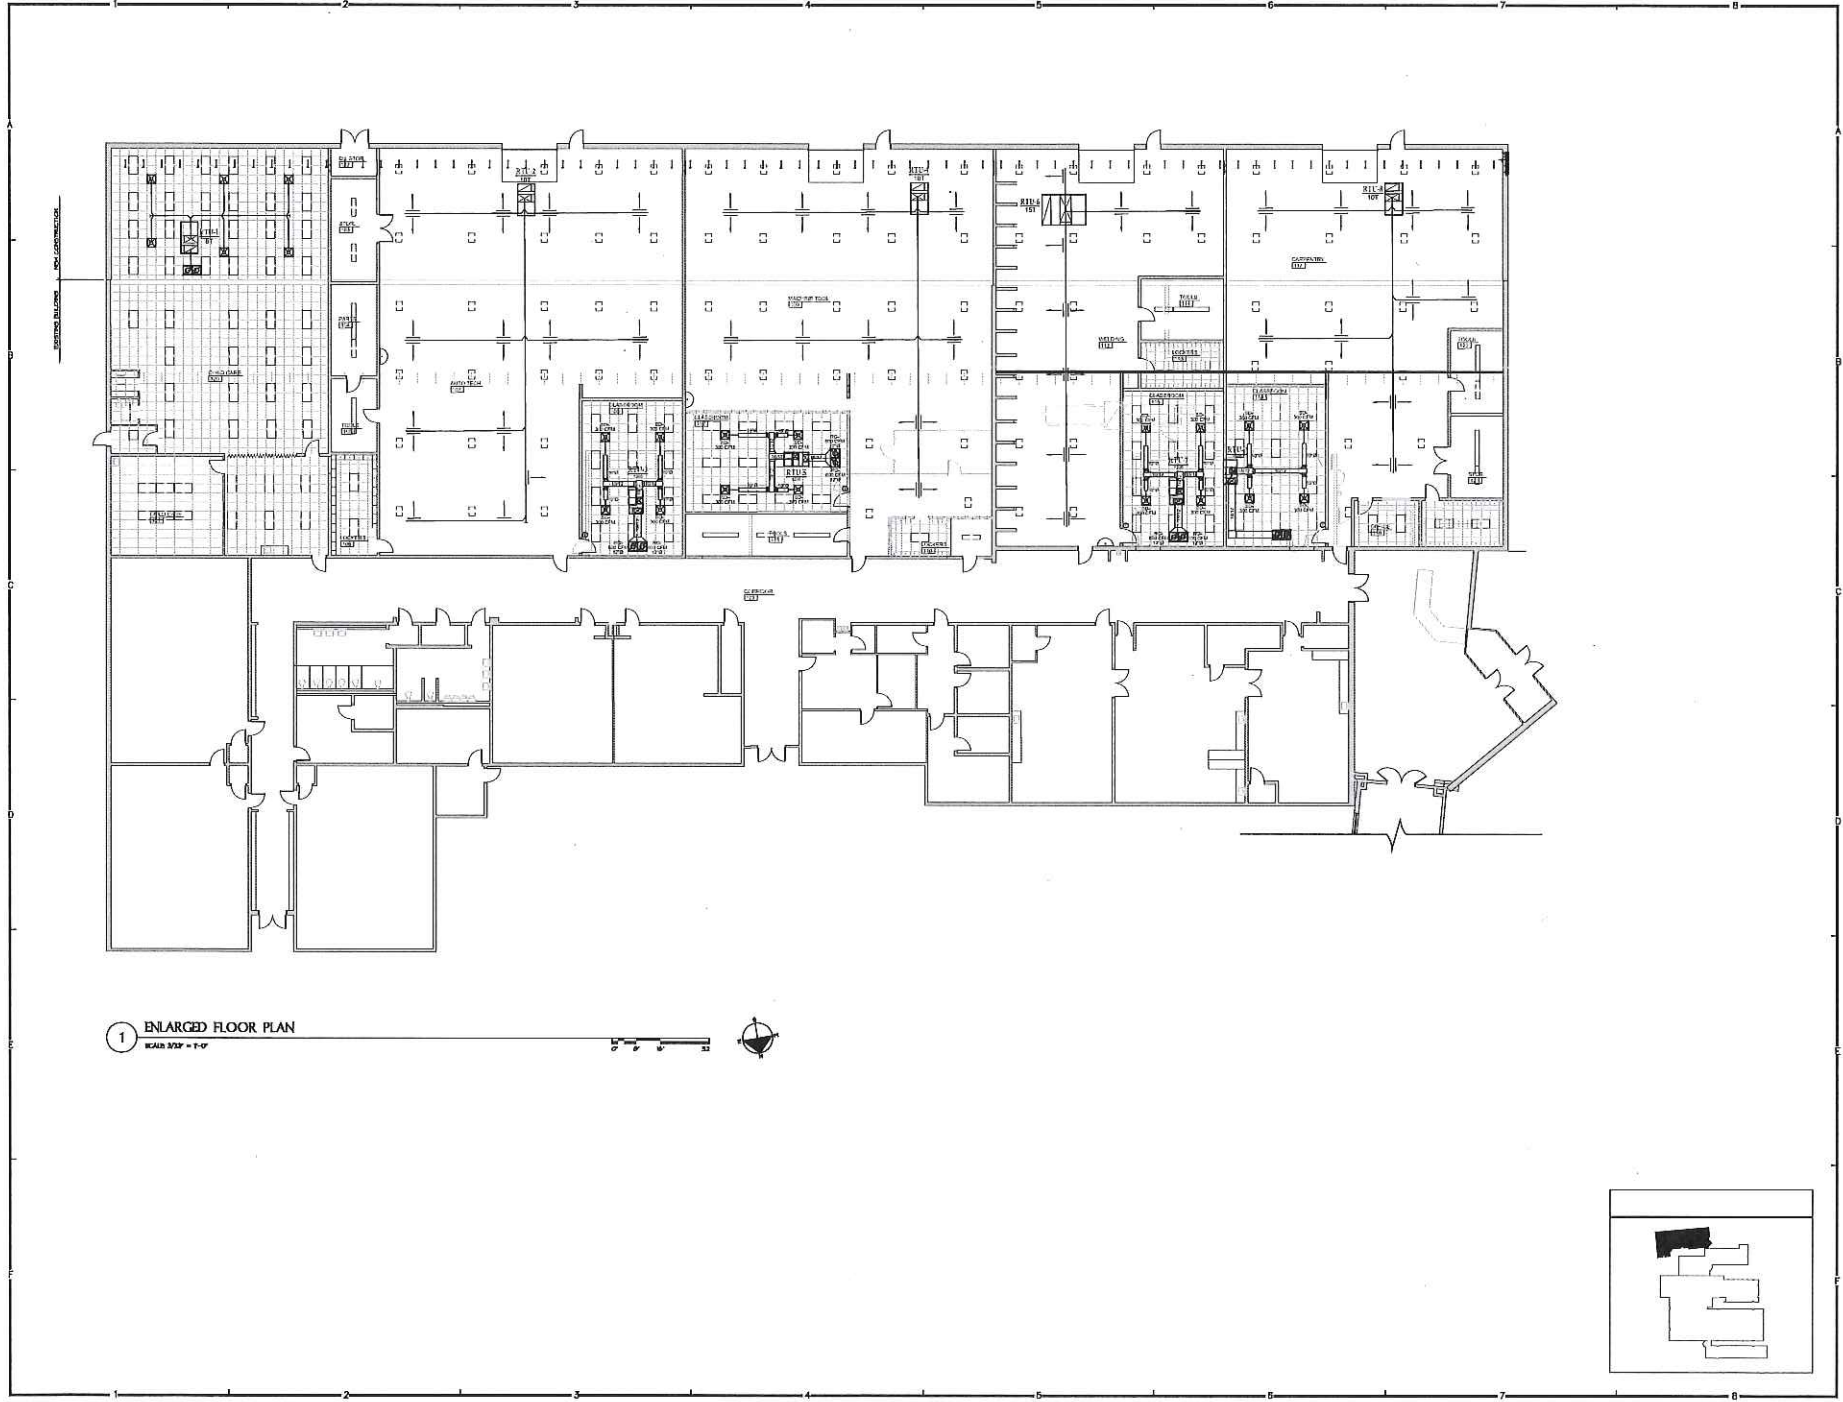

1 ENLARGED FLOOR PLAN
SCALE: 3/32" = 1'-0"

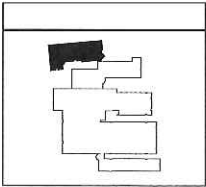


RBS DESIGN GROUP Architecture	
PROJECT: HENDERSON COUNTY SCHOOLS HENDERSON COUNTY HIGH SCHOOL CAREER AND TECHNICAL EDUCATION - ADDITION AND RENOVATION	
SHEET NUMBER M1.1	
REVISIONS NO. DATE 1 10/1/01	JOB NUMBER 100000 DRAWN BY M.A.C. CHECKED BY T.W.C. DATE 10/1/01

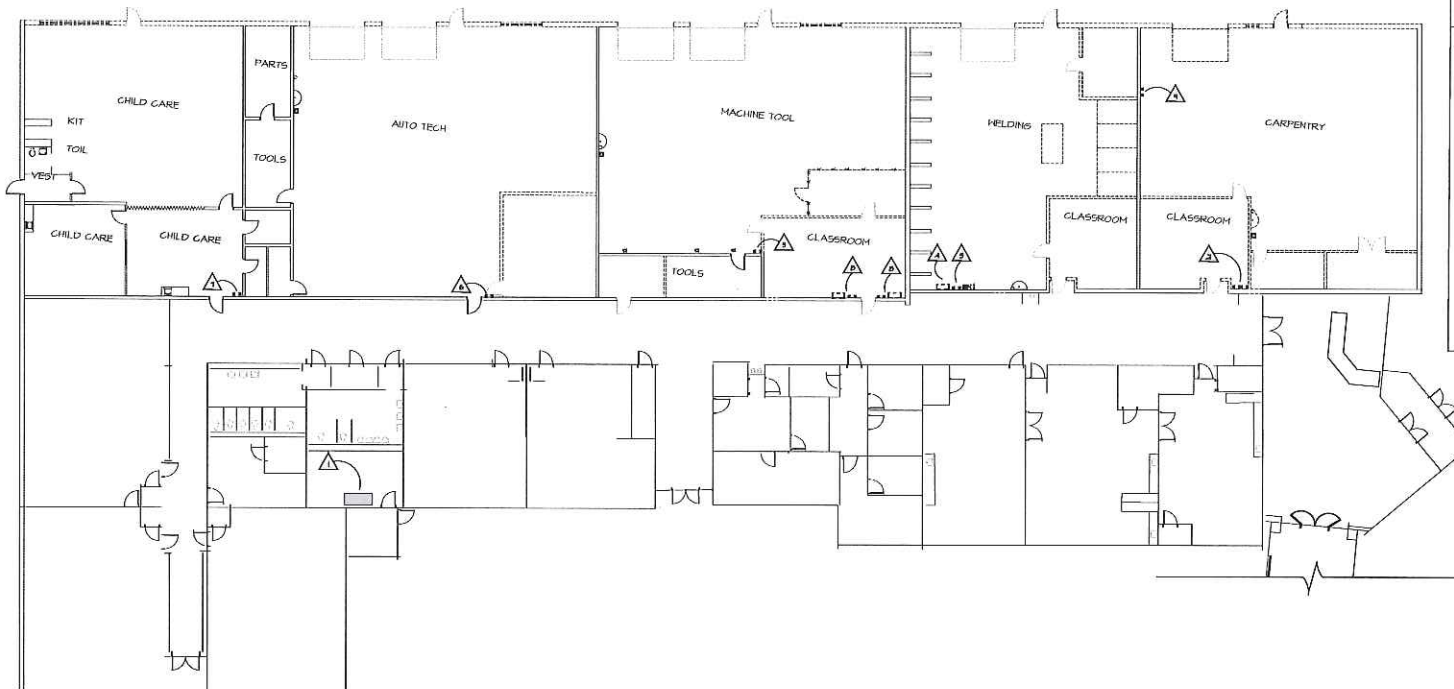

- DEMOLITION NOTES**
- △ EXISTING 1200A MAIN SWITCHGEAR
 - △ EXISTING 225A PANEL
 - △ EXISTING PANEL 10
 - △ EXISTING PANEL 11
 - △ EXISTING PANEL 12
 - △ EXISTING PANEL 13
 - △ EXISTING PANEL 14
 - △ EXISTING PANEL 15
 - △ EXISTING PANEL 16
 - △ EXISTING PANEL

2 POWER DEMOLITION PLAN
SCALE 3/32" = 1'-0"

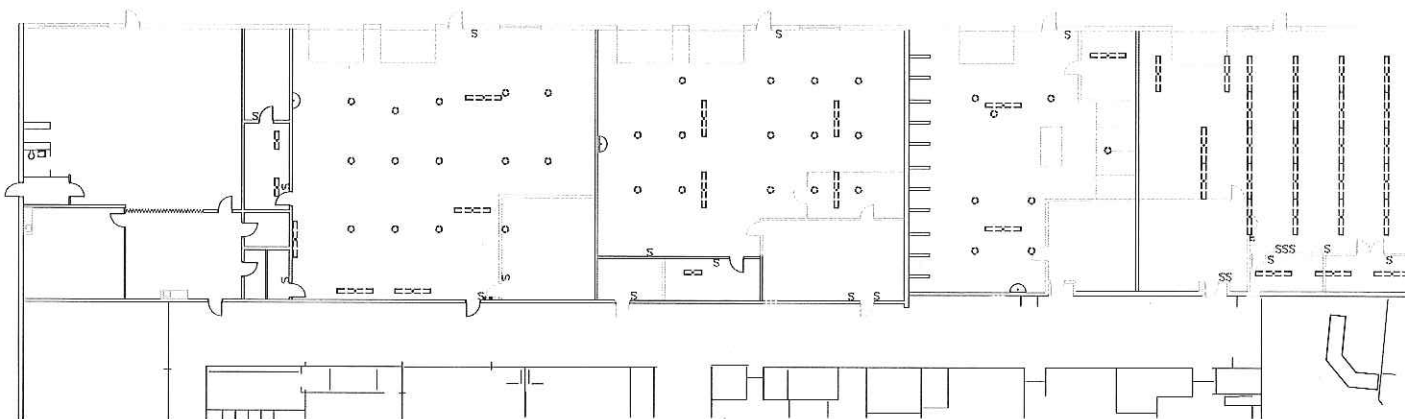

1 LIGHTING DEMOLITION PLAN
SCALE 3/32" = 1'-0"

PROJECT NO.	10000
DATE	2014
DESIGNED BY	
CHECKED BY	
DATE	

