

**SHEET NOTES:**

- 1 REBALANCE EXISTING DIFFUSER TO CFM INDICATED.
- 2 PROVIDE NEW THERMOSTAT IN THIS LOCATION.
- 3 PROVIDE NEW BOILER VENT FROM ROOF DOWN TO BOILER.




OWNER:  
ROBERTSON COUNTY BOARD OF  
EDUCATION

BREATHITT COUNTY  
BOARD OFFICE HVAC  
REPLACEMENT

?????ROAD  
????, KY ???

MECHANICAL / ELECTRICAL ENGINEERS

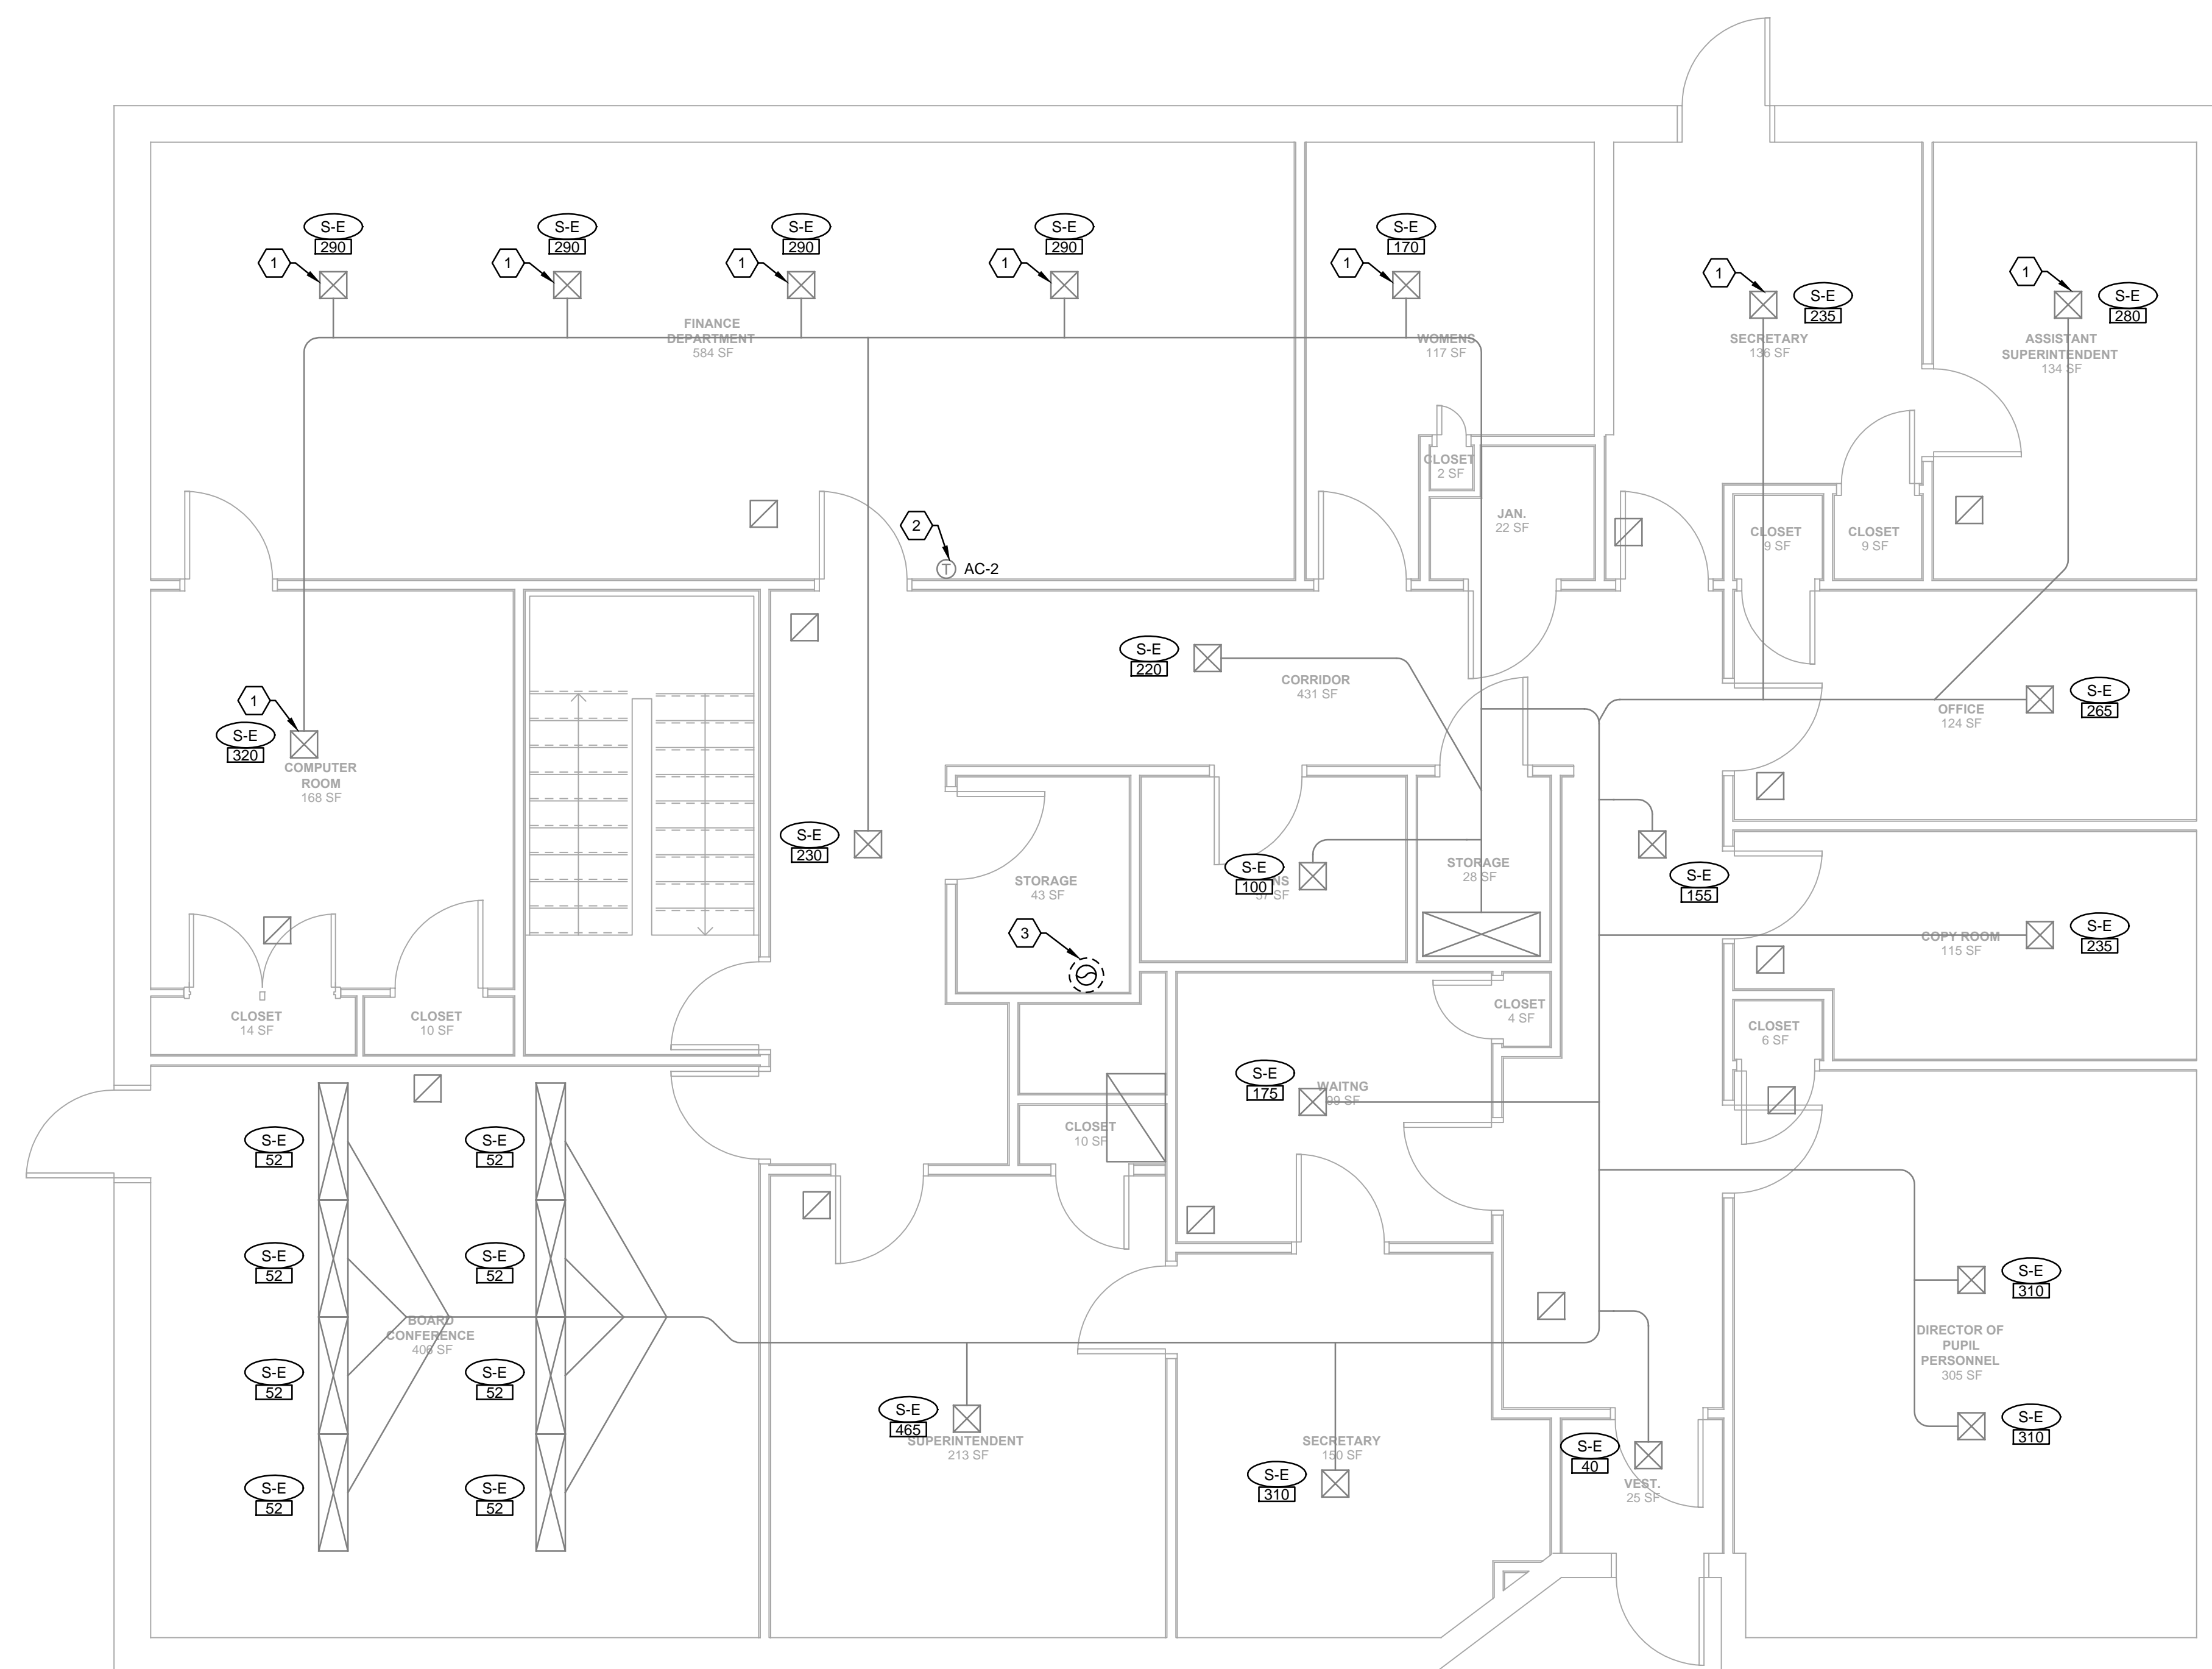

**HVAC FIRST FLOOR PLAN - NEW WORK**  
SCALE: 1/4" = 1'-0"

**SCHEMATIC  
DESIGN**

CONSTRUCTION DOCUMENTS		
NO	ISSUE	DATE

**Sheet Information**

BG Number	???????
Project Number	1822
Drawn	-
Checked	-
Approved	-
Title	

HVAC FIRST FLOOR  
PLAN

Sheet  
**M102**