

Estill County High School Phase 7 Renovations

Irvine, Kentucky

for the

Estill County Board of Education

253 Main St, Irvine, Kentucky 40336

p 606.723.2181

BG # 21-055

RTA # 2025



101 old lafayette avenue
lexington, kentucky 40502
p 859.254.4018
www.rosstarrant.com

enhancing education through great design

STRUCTURAL ENGINEER: STRUCTURAL DESIGN GROUP, INC.
220 Great Circle Road, Suite 106 Nashville, Tennessee 37228
p 615.255.5537

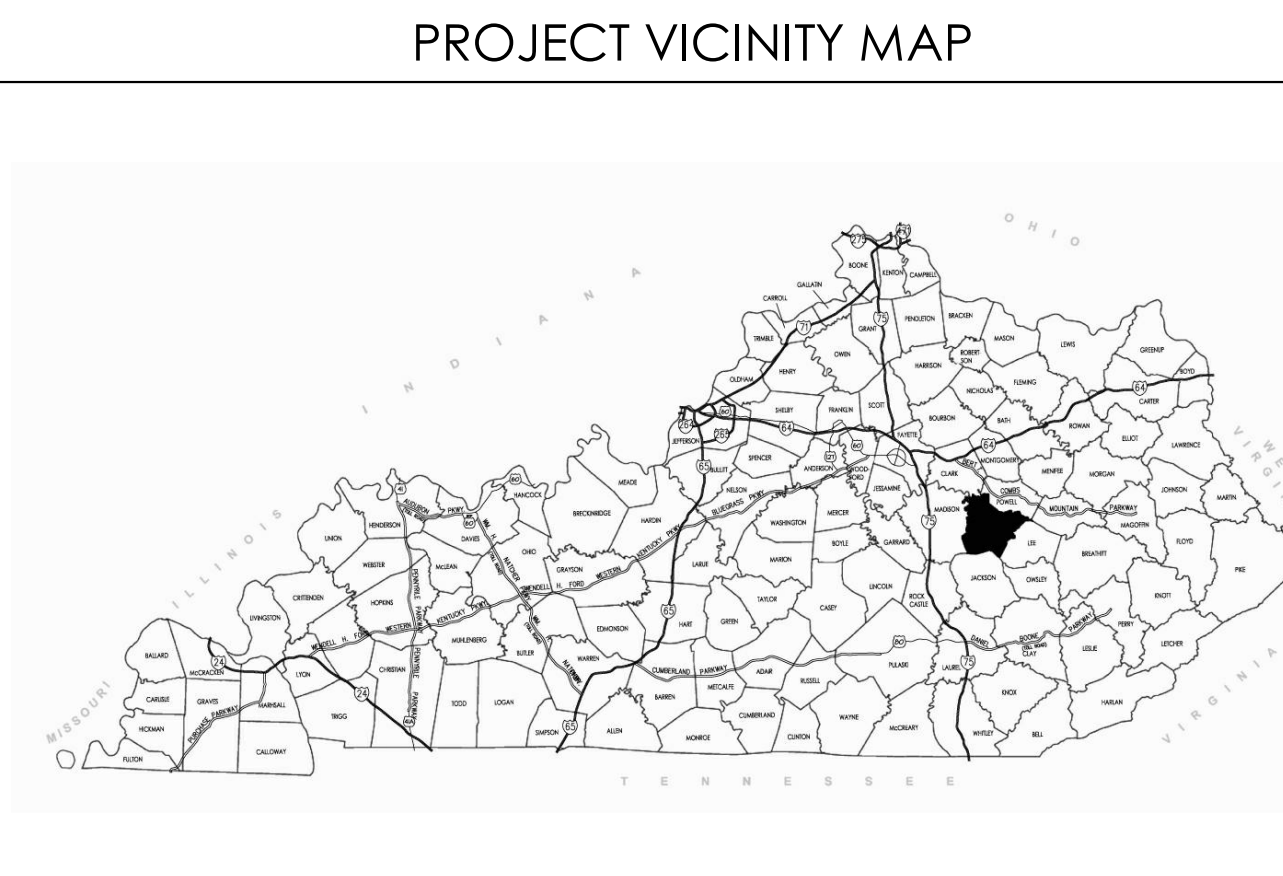
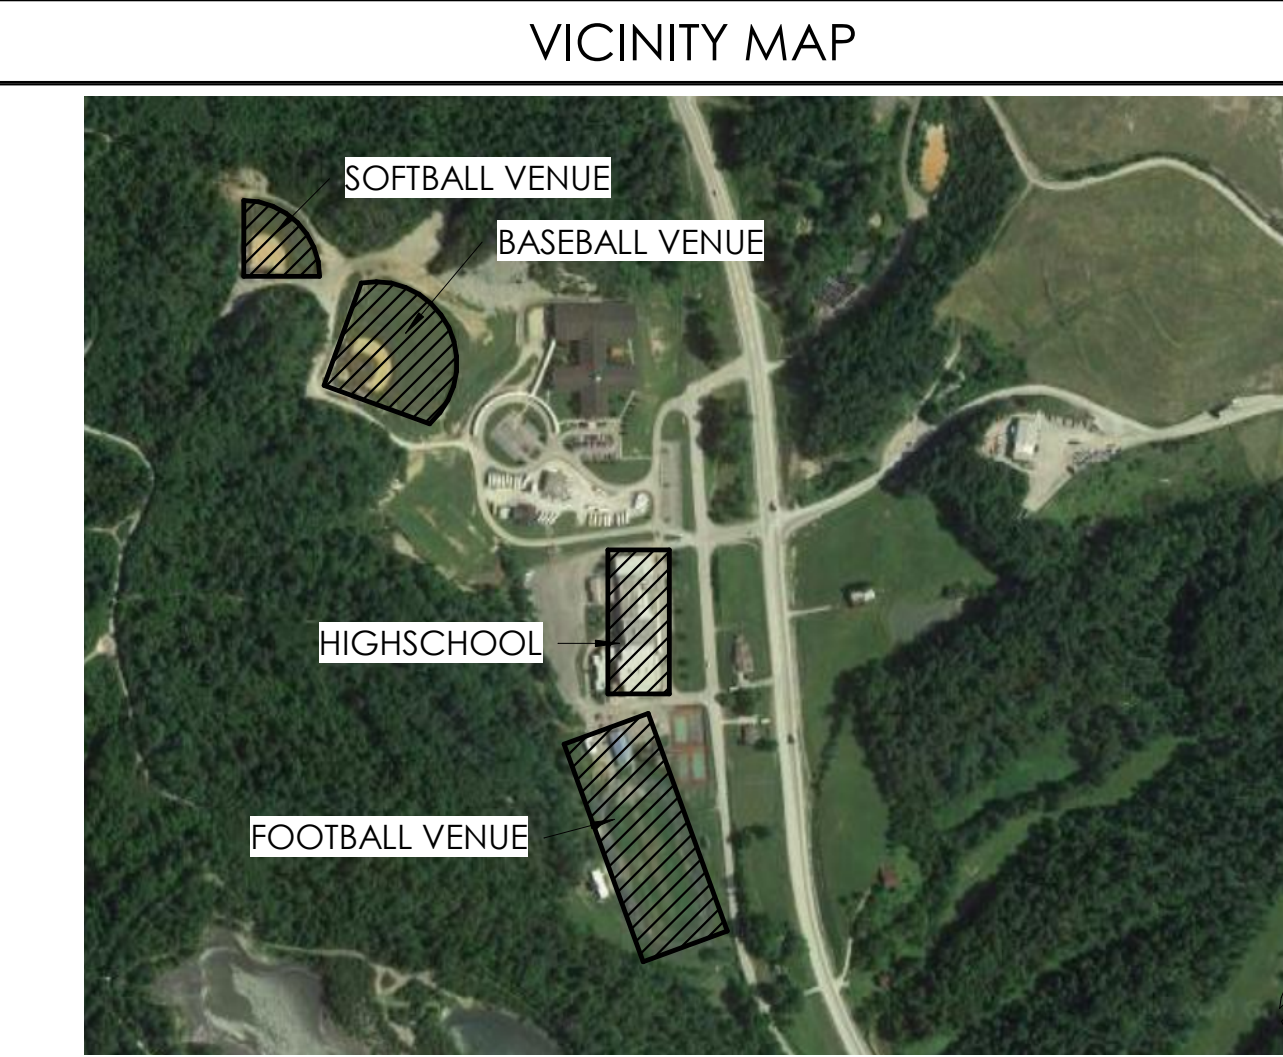
M.E.P. ENGINEER: CMTA, INC.
2429 Members Way Lexington, Kentucky 40504
p 859.253.0892

HARDWARE CONSULTANT: CALVERT INDEPENDENT HARDWARE SPECIFICATIONS, LLC
307 Oakwood Circle Vine Grove, Kentucky 40175
p 502.930.2039

CONSTRUCTION MANAGER: CODELL CONSTRUCTION COMPANY, INC.
P.O. Box 17 Winchester, Kentucky 40392
p 859.744.2222

PROJECT SITE ADDRESS:

397 Engineer Rd,
Irvine, Kentucky
40336



INDEX OF DRAWINGS

COV	COVER SHEET
G1.0	CODE REVIEW - HIGH SCHOOL
G1.1	CODE REVIEW - ATHLETICS FACILITIES & GREENHOUSE
G1.2	CODE REVIEW - BASEBALL VENUE ATHLETICS FACILITIES
G2.0	PHASING PLAN - ATHLETICS FACILITIES
G2.1	PHASING PLAN - HIGH SCHOOL
B1.0	BORING PLAN
SS1.0	SURVEY
SD0.1	EROSION POLLUTION & SEDIMENT CONTROL PLAN
SD0.2	OVERALL SITE DEMOLITION PLAN
SD0.3	SITE DEMOLITION PLAN
SD0.4	SITE DEMOLITION PLAN
SD0.5	SITE DEMOLITION PLAN
SD1.0	OVERALL SITE DEVELOPMENT & LAYOUT PLAN
SD1.1	SITE DEVELOPMENT & LAYOUT PLAN
SD1.2	SITE DEVELOPMENT & LAYOUT PLAN
SD1.3	SITE DEVELOPMENT & LAYOUT PLAN
SD2.0	OVERALL SITE GRADING & DRAINAGE PLAN
SD2.1	SITE GRADING PLAN
SD2.2	SITE GRADING PLAN
SD2.3	SITE GRADING PLAN
SD2.4	SITE DRAINAGE PLAN
SD2.5	SITE DRAINAGE PLAN
SD2.6	SITE DRAINAGE PLAN
SD2.7	ENLARGED SITE PLAN
SD3.1	ENLARGED SITE PLAN
SD3.2	ENLARGED SITE PLAN
SD3.3	ENLARGED SITE PLAN
SD3.4	ENLARGED SITE PLAN
SD3.5	ENLARGED SITE PLAN
SD3.6	ENLARGED SITE PLAN
SD3.7	ENLARGED SITE PLAN
SD4.1	SITE DETAILS
SD4.2	SITE DETAILS
SD4.3	SITE DETAILS
S0.1	STRUCTURAL NOTES
S0.2	STRUCTURAL NOTES CONTINUED
S0.3	STRUCTURAL QUALITY ASSURANCE PLAN
S0.4	NOTES & SCHEDULES
S1.1	FOUNDATION PLAN - ATHLETICS
S1.2	FOUNDATION PLAN - ATHLETICS
S1.3	ROOF FRAMING PLAN - ATHLETICS
S1.4	ROOF FRAMING PLAN - ATHLETICS
S2.1	FOUNDATION SECTIONS AND DETAILS
S2.2	FOUNDATION SECTIONS AND DETAILS
S3.1	MASONRY SECTIONS AND DETAILS
S3.2	MASONRY SECTIONS AND DETAILS
S4.1	FLOOR FRAMING SECTIONS AND DETAILS
S5.1	ROOF FRAMING SECTIONS AND DETAILS
S5.2	ROOF FRAMING SECTIONS AND DETAILS
D1.0	DEMOLITION REFERENCE FLOOR PLANS - HIGH SCHOOL
D1.1	LOWER FLOOR DEMOLITION PLAN - AREA B
D1.2	FIRST FLOOR DEMOLITION - AREA A
D1.3	FIRST FLOOR DEMOLITION PLAN - AREA B
D1.4	SECOND FLOOR DEMOLITION PLAN - AREA A
D1.5	FIELD HOUSE DEMOLITION PLAN, ELEVATION, & ROOF PLAN
D3.1	ROOF DEMOLITION PLAN
A0.1	GENERAL ARCHITECTURAL DETAILS
A1.0	NEW WORK REFERENCE FLOOR PLANS - HIGH SCHOOL
A1.1	LOWER FLOOR PLAN - AREA A
A1.2	LOWER FLOOR PLAN - AREA B
A1.3	FIRST FLOOR PLAN - AREA A
A1.4	FIRST FLOOR PLAN - AREA B
A1.5	SECOND FLOOR PLAN - AREA A
A1.6	FIRST FLOOR PLAN - ATHLETICS FACILITIES
A1.7	ENLARGED FLOOR PLANS - HIGH SCHOOL
A1.8	ENLARGED FLOOR PLANS - ATHLETICS FACILITIES
A1.9	BLEACHER PLANS
A1.10	BLEACHER SECTIONS
A2.0	SCHEDULES & DETAILS
A2.1	LOWER FLOOR PLAN - AREA B - INTERIORS
A2.2	FIRST FLOOR PLAN - AREA A - INTERIORS
A2.3	FIRST FLOOR PLAN - AREA B - INTERIORS
A2.4	SECOND FLOOR PLAN - AREA A & B - INTERIORS
A2.5	ATHLETIC FACILITIES - INTERIORS
A2.6	DETAILS & ELEVATIONS
A3.1	ROOF PLAN - HIGH SCHOOL, FIELDHOUSE, GREENHOUSE
A3.2	ROOF PLAN - DUGOUT, PRESSBOX
A4.1	ATHLETIC FACILITIES & GREENHOUSE ELEVATIONS
A5.1	ATHLETIC FACILITIES SECTIONS
A5.2	WALL SECTIONS - HIGH SCHOOL FOOTBALL ATHLETICS FACILITIES
A5.3	WALL SECTIONS - ATHLETICS FACILITIES
A6.1	DOORS AND FRAME SCHEDULE
A6.2	OPENING ELEVATIONS & DETAILS
A7.1	REFLECTED CEILING PLANS - HIGH SCHOOL
A7.2	REFLECTED CEILING PLANS - ATHLETICS FACILITIES
A8.1	ALTERNATE #6 TICKET BOOTH
A8.2	ALTERNATE #9 - MASONRY STAIN AT EXTG HIGH SCHOOL BRICK
UE1.0	SITE UTILITIES - DEMOLITION
UE2.0	SITE UTILITIES - FOOTBALL AREA
UE2.1	SITE UTILITIES - BASEBALL/SOFTBALL AREA
P1.0	PLUMBING LEGEND
P2.0B	LOWER FLOOR PLUMBING DEMOLITION PLAN - AREA B
P2.1A	FIRST FLOOR PLUMBING DEMOLITION PLAN - AREA A
P2.1B	FIRST FLOOR PLUMBING DEMOLITION PLAN - AREA B
P2.2A	SECOND FLOOR PLUMBING DEMOLITION PLAN - AREA A
P3.0B	LOWER FLOOR UNDERSLAB PLUMBING PLAN - AREA B
P3.1A	FIRST FLOOR UNDERSLAB PLUMBING PLAN - AREA A
P3.1B	RST FLOOR UNDERSLAB PLUMBING PLAN - AREA B
P3.2A	SECOND FLOOR UNDERSLAB PLUMBING PLAN - AREA A
P4.0B	LOWER FLOOR PLUMBING PLAN - AREA B
P4.1A	FIRST FLOOR PLUMBING PLAN - AREA A
P4.1B	FIRST FLOOR PLUMBING PLAN - AREA B
P4.2A	SECOND FLOOR PLUMBING PLAN - AREA A
P5.1	ATHLETIC FACILITIES PLUMBING PLANS
P6.0	SANITARY VENT RISER DIAGRAM
P6.1	SANITARY VENT RISER DIAGRAM
M1.0	MECHANICAL LEGEND
M2.1A	FIRST FLOOR MECHANICAL DEMOLITION PLAN - AREA A
M2.1B	FIRST FLOOR MECHANICAL DEMOLITION PLAN - AREA B
M3.1A	FIRST FLOOR MECHANICAL PLAN - AREA A
M3.1B	FIRST FLOOR MECHANICAL PLAN - AREA B
M4.0A	LOWER FLOOR CONTROLS PLAN - AREA A
M4.0B	LOWER FLOOR CONTROLS PLAN - AREA B
M4.1A	FIRST FLOOR CONTROLS PLAN - AREA A
M4.1B	FIRST FLOOR CONTROLS PLAN - AREA B
M4.2A	SECOND FLOOR CONTROL PLAN - AREA A
M4.2B	SECOND FLOOR CONTROL PLAN - AREA B
M4.3	CONTROLS POINTS AND SEQUENCES
M5.1	ATHLETIC FACILITIES MECHANICAL PLANS
M6.0	MECHANICAL SCHEDULES
E1.0	ELECTRICAL LEGEND
E2.0A	LOWER FLOOR ELECTRICAL DEMOLITION PLAN - AREA A
E2.0B	LOWER FLOOR ELECTRICAL DEMOLITION PLAN - AREA B
E2.1A	FIRST FLOOR ELECTRICAL DEMOLITION PLAN - AREA A
E2.1B	FIRST FLOOR ELECTRICAL DEMOLITION PLAN - AREA B
E2.2A	SECOND FLOOR ELECTRICAL DEMOLITION PLAN - AREA A
E2.2B	SECOND FLOOR ELECTRICAL DEMOLITION PLAN - AREA B
E2.3A	ATHLETIC FACILITIES ELECTRICAL DEMOLITION PLAN
E3.0A	LOWER FLOOR LIGHTING PLAN - AREA A
E3.0B	LOWER FLOOR LIGHTING PLAN - AREA B
E3.1A	FIRST FLOOR LIGHTING PLAN - AREA A
E3.1B	FIRST FLOOR LIGHTING PLAN - AREA B
E3.2A	SECOND FLOOR LIGHTING PLAN - AREA A
E3.2B	SECOND FLOOR LIGHTING PLAN - AREA B
E3.3	ATHLETIC FACILITIES LIGHTING PLANS
E4.0	LOWER FLOOR POWER/SYSTEMS PLAN
E4.1	FIRST FLOOR POWER/SYSTEMS PLAN
E4.2	SECOND FLOOR POWER/SYSTEMS PLAN
E4.3	ATHLETIC FACILITIES POWER/SYSTEMS PLANS
E5.0	ELECTRICAL SCHEDULES
E6.0	ENLARGED ELECTRICAL PLANS



NOT FOR
CONSTRUCTION

COVER SHEET
FOR:
ESTILL COUNTY SCHOOLS
IRVINE, KENTUCKY
ESTILL COUNTY HIGH SCHOOL PHASE 7 RENOVATIONS

M.E.&P. Engineer:
CMTA, Inc.
2429 Members Way
Lexington, KY 40504
p 859.253.0892
Structural Engineer:
Structural Design Group, Inc.
220 Great Circle Rd., Suite 106
Nashville, TN 37228
p 615.255.5537

BG# 21-055

Project No: 2025
Drawn By: JR / KM
Rev'd By: PF

SHEET RELEASE	
1	
2	
3	
4	
5	
6	
7	
8	

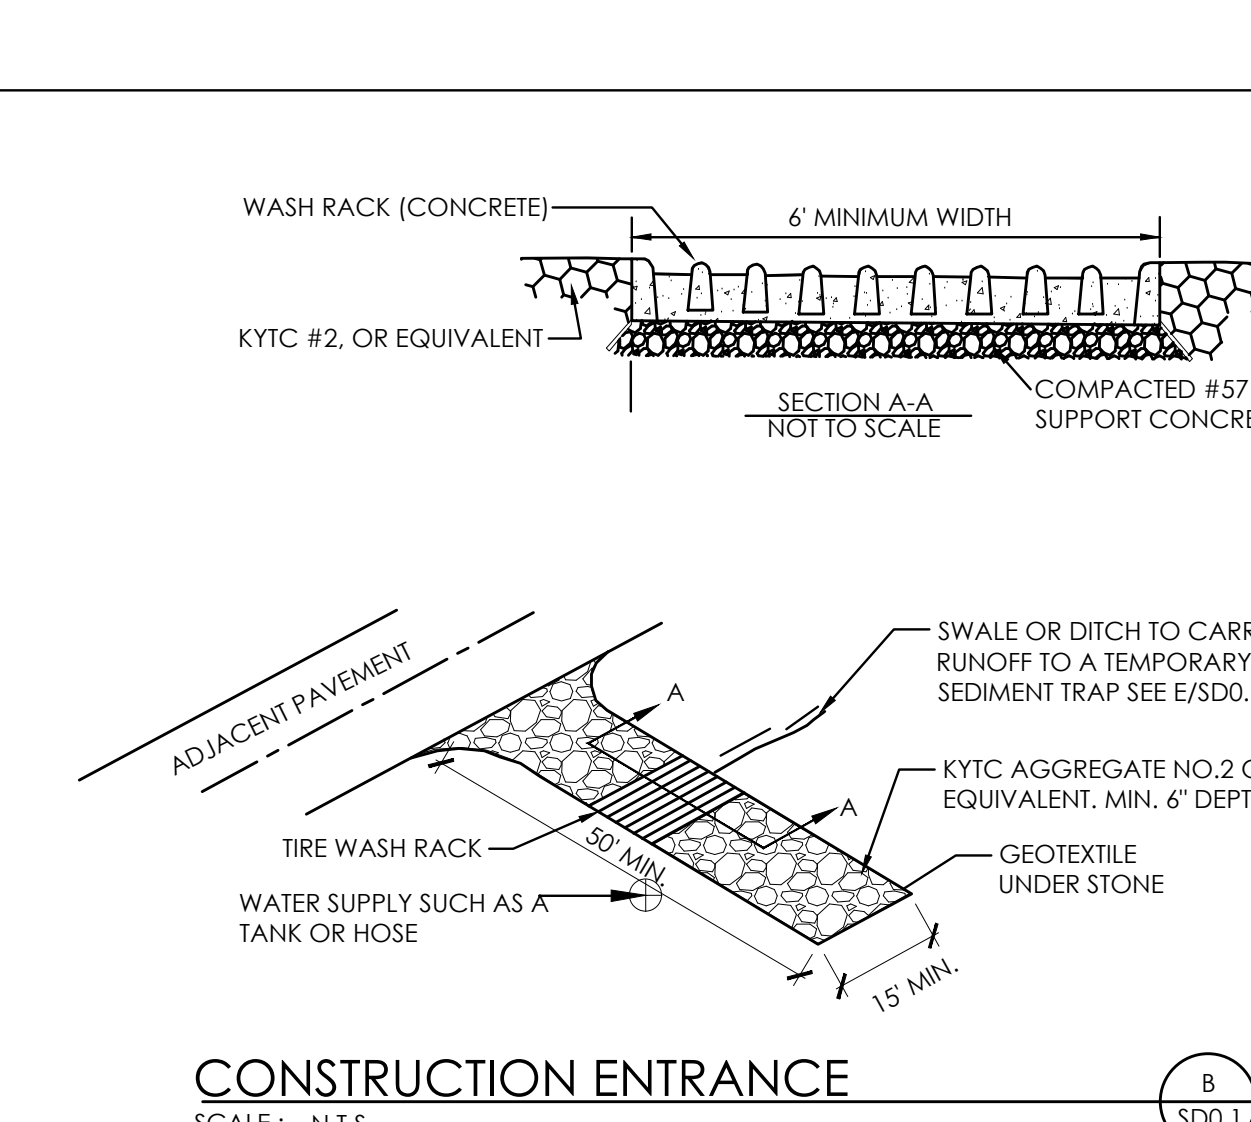
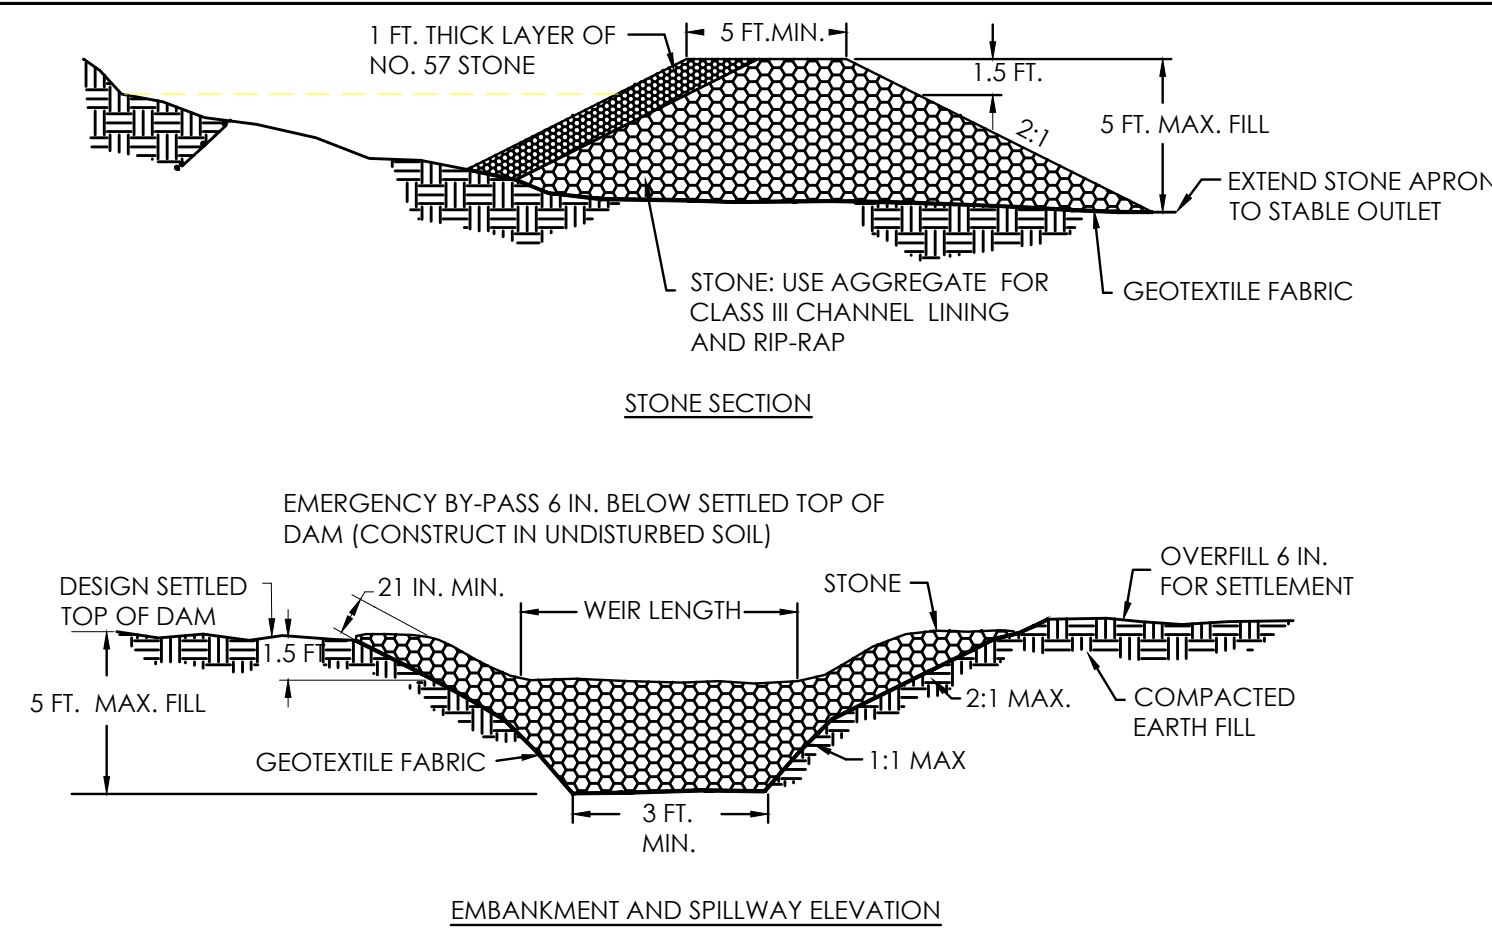
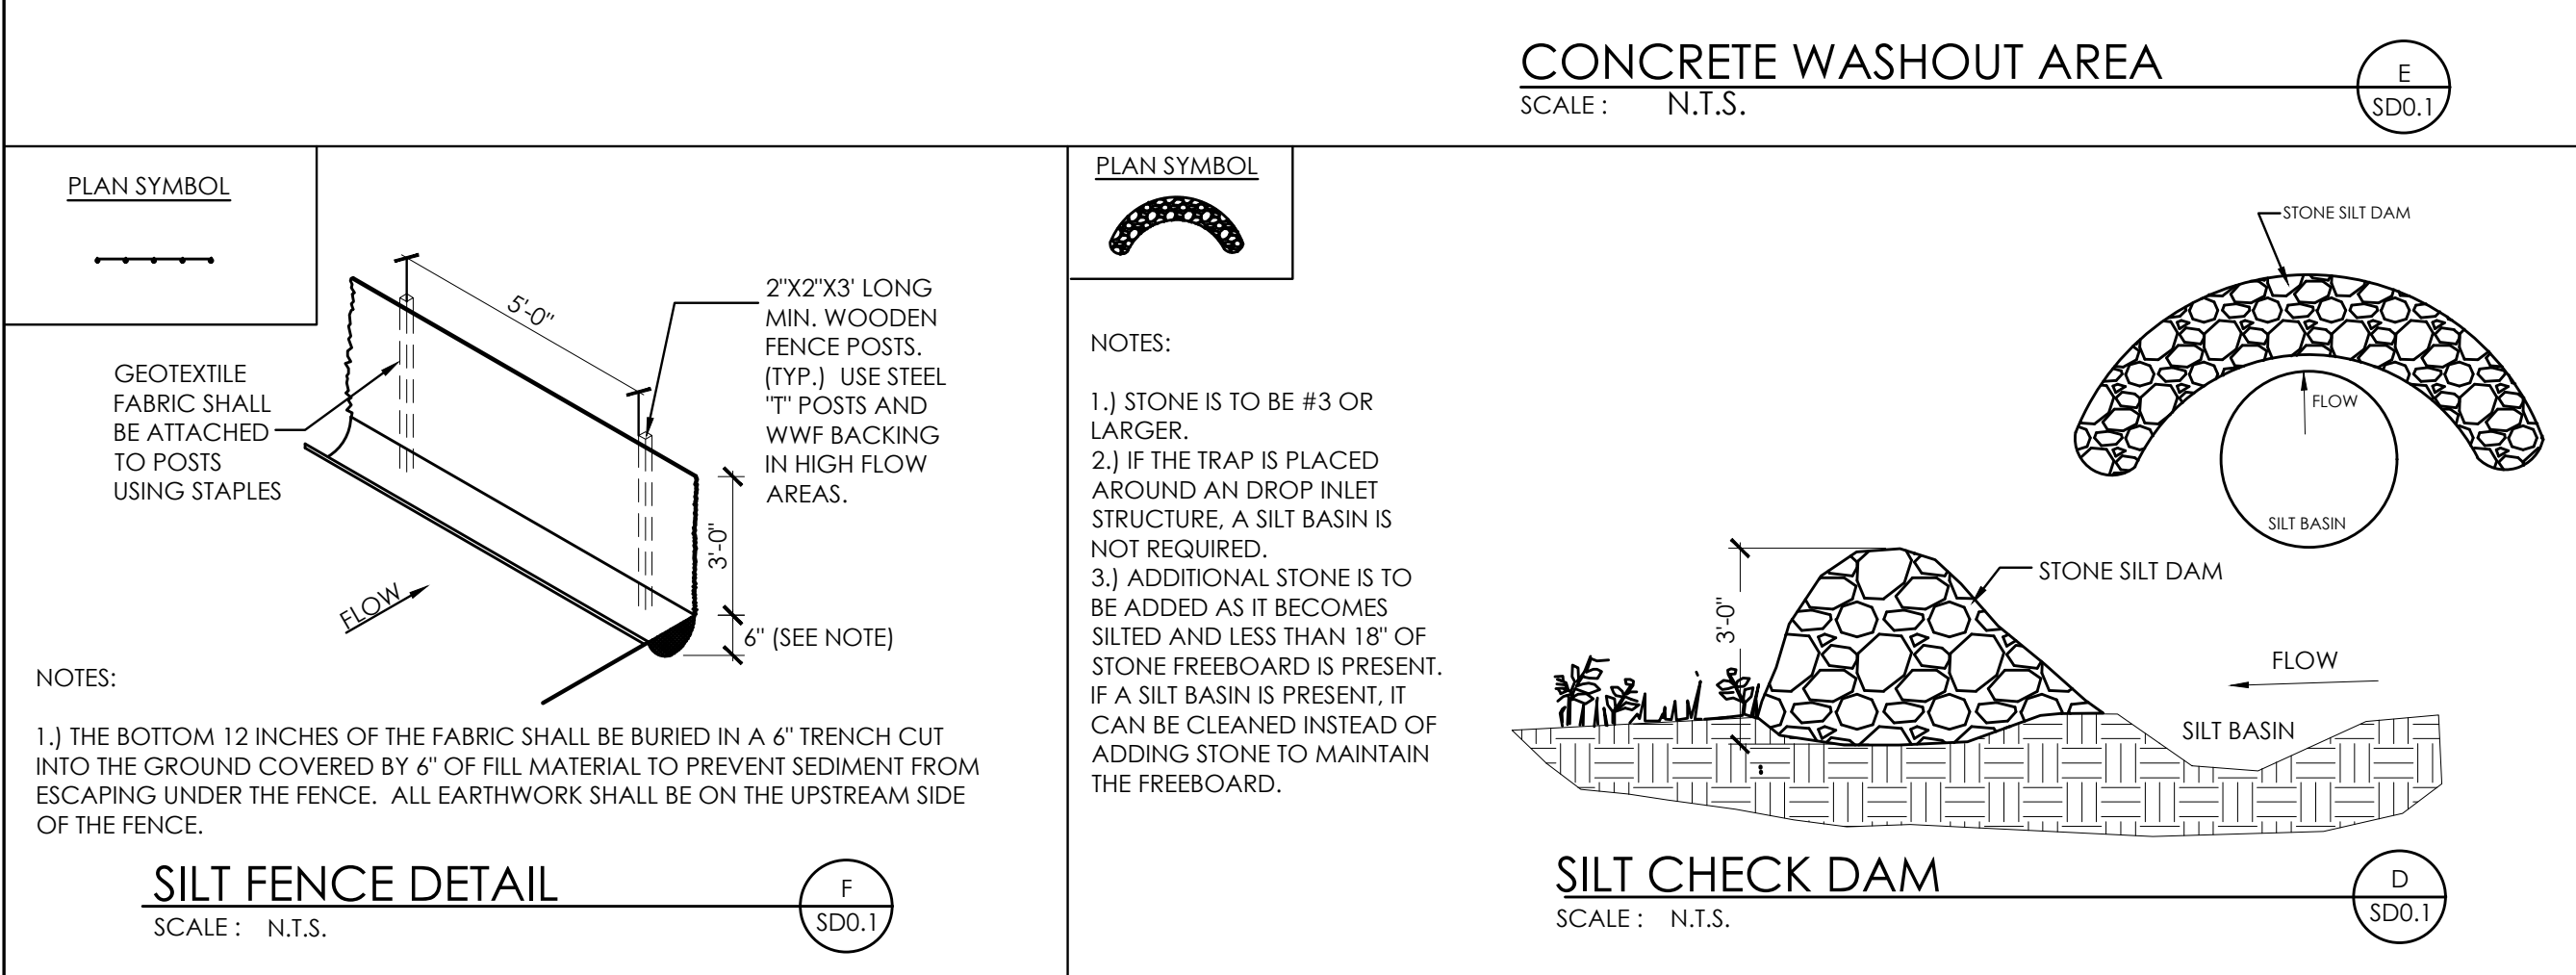
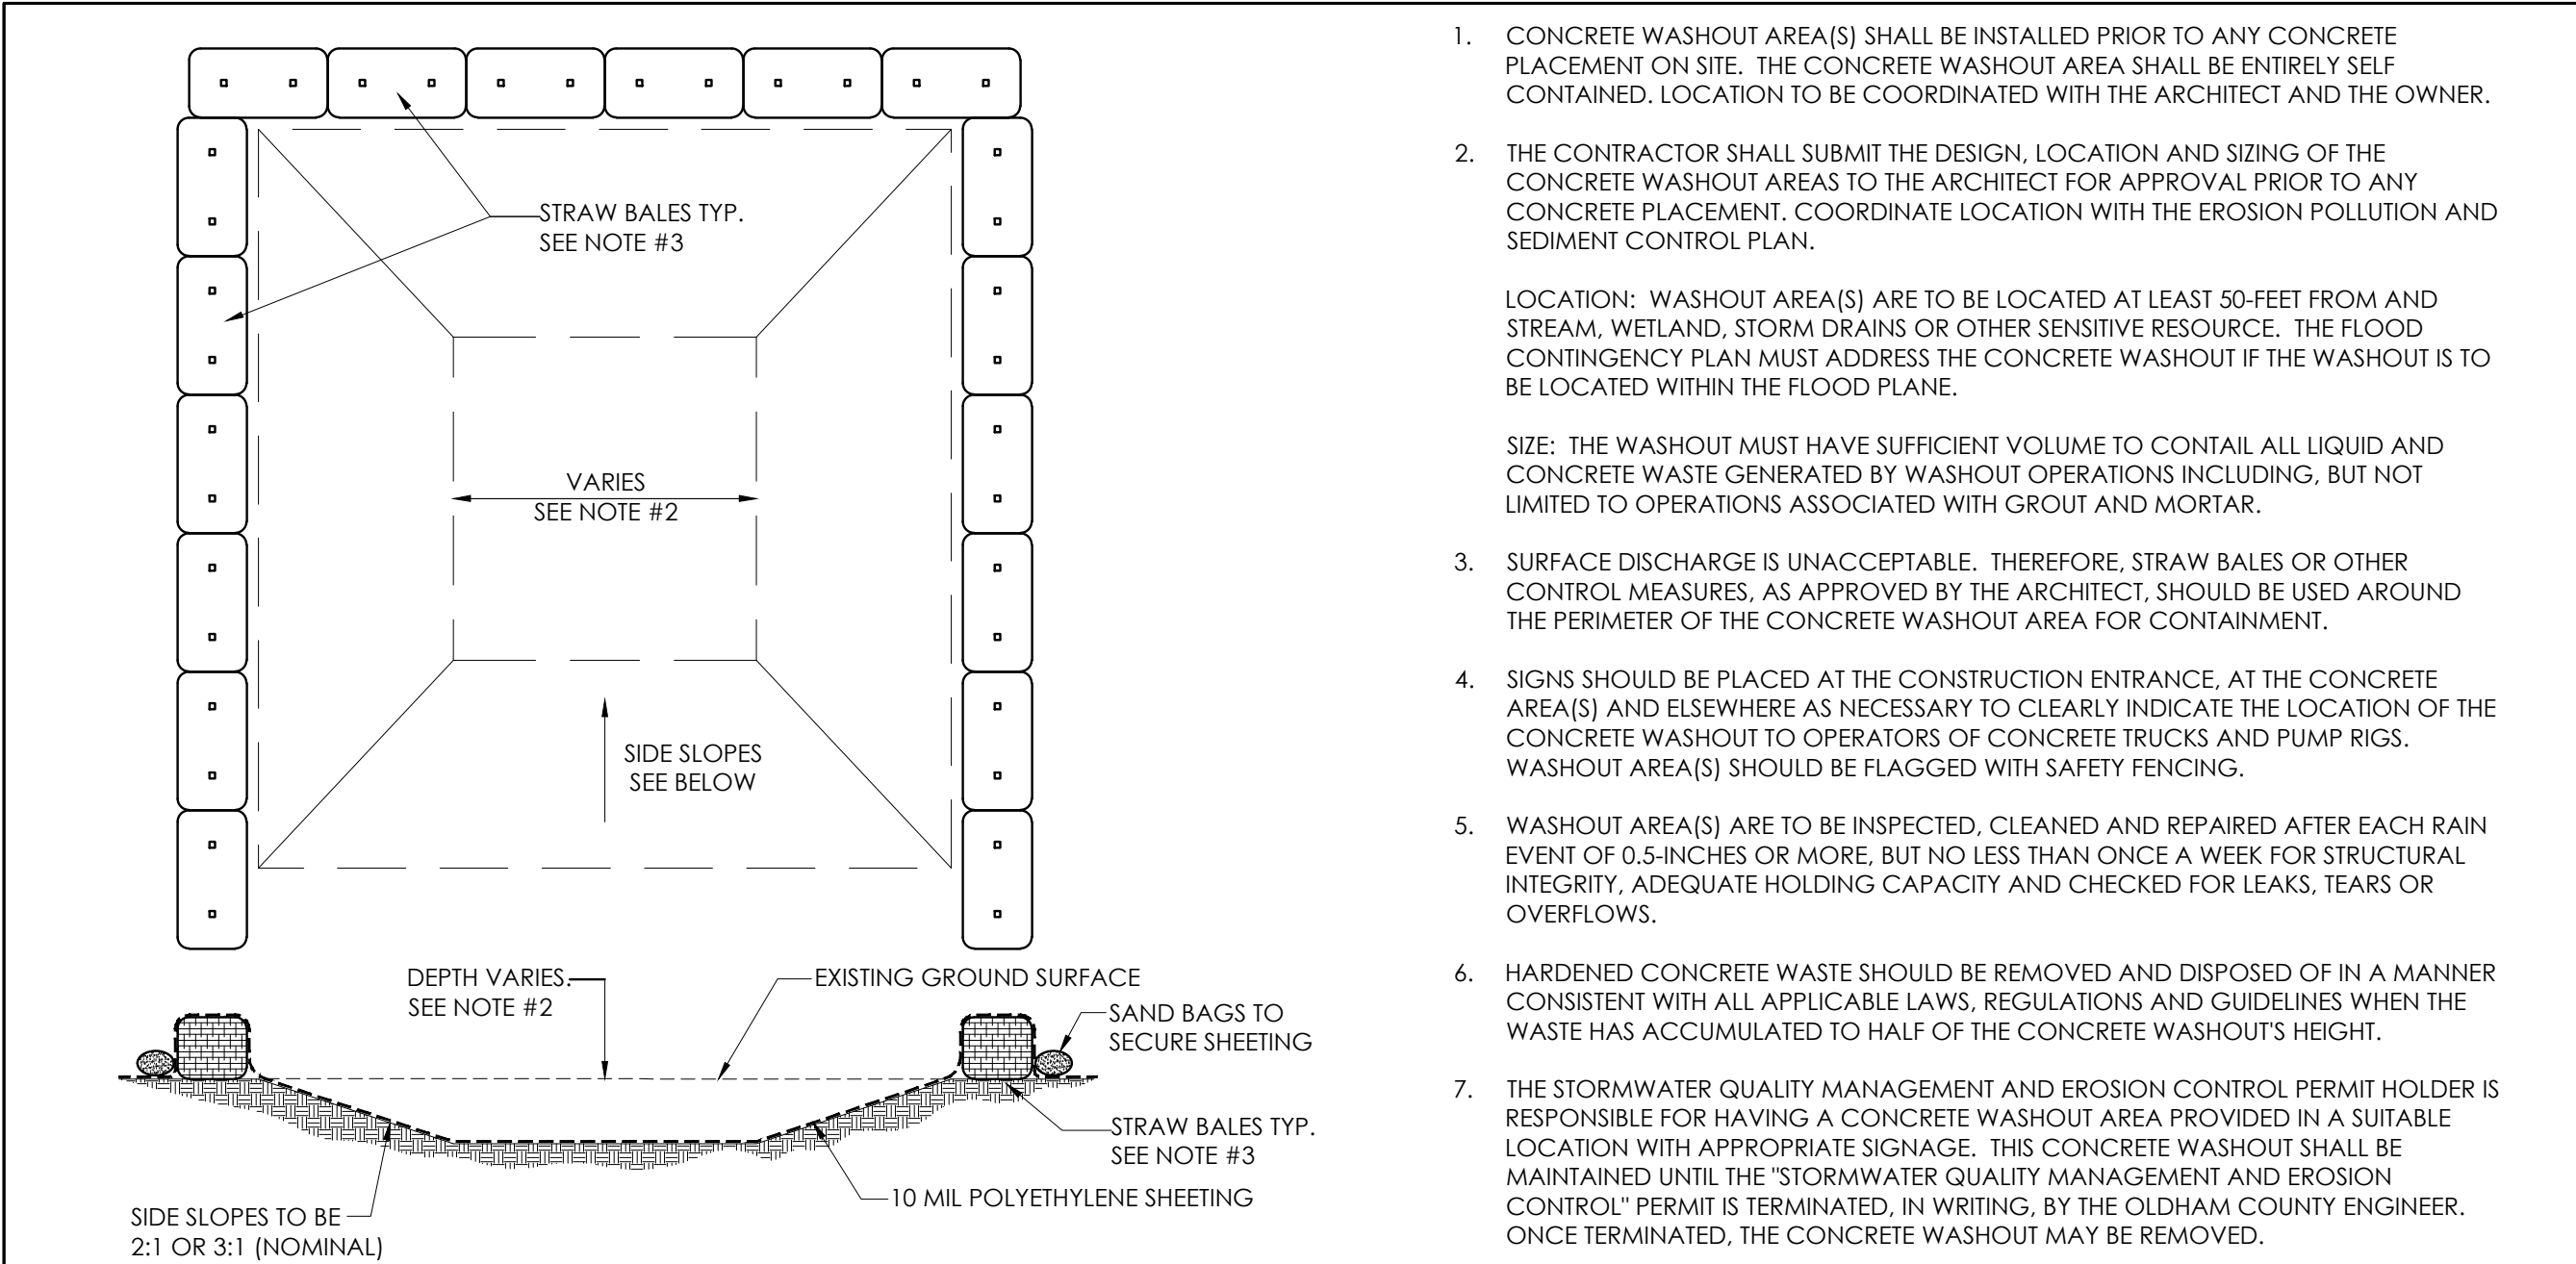
COPYRIGHT © 2020

CONSTRUCTION DOCUMENTS

COV

COVER SHEET

DATE ISSUED:
FEBRUARY 2021



- ### SITE BMP NOTES
- CONTRACTOR IS TO PROVIDE ALL KPDES PERMITS, NOTICES OF INTENT (NOIS) AND NOTICES OF TERMINATION INCLUDING EROSION AND SEDIMENT CONTROL PLANS FOR ALL PHASES OF CONSTRUCTION. ALL KPDES AND RELATED DIVISION OF WATER REQUIREMENTS SHALL BE THE RESPONSIBILITY OF THE CONTRACTOR UNTIL THE PROJECT IS CLOSED OUT AND THE NOTICE OF TERMINATION APPROVED.
 - SEDIMENT CONTROL FENCING SHOWN AND REFERENCES TO SEDIMENT CONTROLS AT STORM WATER STRUCTURES AND ELSEWHERE ON THE DOCUMENTS ARE NOT TO BE USED FOR DIVISION OF WATER REQUIREMENTS. THESE REFERENCES ARE ONLY REQUIRED BY THE DESIGNER FOR PROPER MAINTENANCE OF THE STORM WATER SYSTEM AND TO MINIMIZE CLEANING OF THE SYSTEM AND PAVEMENTS.
 - EXISTING VEGETATION IS TO BE LEFT INTACT UNTIL CONSTRUCTION IN THAT PARTICULAR LOCATION IS REQUIRED. SOIL STABILIZATION PRACTICES (SEEDING, MULCHING, ETC.) ARE TO BE BEGUN WITHIN 14 DAYS OF PERMANENT COMPLETION OR TEMPORARY HALT (21 DAYS OR MORE) OF WORK IN ANY PARTICULAR AREA.
 - PERIMETER SEDIMENT AND EROSION CONTROLS ARE TO BE INSTALLED PRIOR TO THE START OF SITE CLEARING AND GRUBBING. EROSION CONTROLS SHALL BE IN ACCORDANCE WITH KENTUCKY DEPARTMENT OF HIGHWAY STANDARDS. CONTROL SHALL BE ACCOMPLISHED BY USE OF INTERCEPTOR DITCHES, DITCH SILT CHECKS, TEMPORARY SEEDING AND OTHER MEASURES AS MAY BE EFFECTIVE IN ACHIEVING THE DESIRED EFFECT. SILT FENCE SHALL BE INSTALLED TO PREVENT EROSION AND WASH-OFF ONTO WALKS, PAVEMENTS AND ALL ADJOINING PROPERTIES.
 - INSTALL SEDIMENT CONTROL FENCE OR SEDIMENT TRAPS AROUND ALL STORM WATER INLETS AND MAINTAIN UNTIL VEGETATION IS ESTABLISHED OR AREA PAVED AS APPROVED BY THE ARCHITECT. STORM WATER INLET PROTECTION IS TO BE INSTALLED IMMEDIATELY AFTER INSTALLATION OF THE STRUCTURES. REMOVE PROTECTIONS AT THE COMPLETION OF THE PROJECT WHEN CONDITIONS NO LONGER WARRANT THEIR USE. SEE SD4 SHEETS FOR DETAILS.
 - TYPICAL SILT FENCE AND SEDIMENT TRAP INSTALLATION DETAILS ARE SHOWN ON THE SD4 SHEETS. SEE KDOH STANDARDS FOR INFORMATION CONCERNING THE STONE SILT CHECKS.
 - SEDIMENT CONTROLS ARE TO BE INSPECTED, CLEANED AND REPAIRED AFTER EACH RAIN EVENT OF 0.5 INCHES OR MORE, BUT NO LESS THAN ONCE PER WEEK. A LOG OF INSPECTIONS AND CLEANING IS TO BE KEPT ON SITE.
 - THE LOCATIONS OF SEDIMENT CONTROLS SHOWN ARE FOR GENERAL PROTECTION PRACTICES AND NOT AS PART OF A BMP PLAN. IF CONSTRUCTION ACTIVITIES PRODUCE CONDITIONS THAT REQUIRE ADDITIONAL CONTROLS, IT IS THE CONTRACTORS RESPONSIBILITY TO PROVIDE INSTALL AND MAINTAIN THE CONTROLS UNTIL CONDITIONS NO LONGER WARRANT THEIR USE.
 - ALL STORM DRAINAGE CATCH BASINS, CURB INLETS, AND JUNCTIONS BOXES ARE TO RECEIVE PROTECTION FROM SEDIMENTATION. AT A MINIMUM A PERIMETER SILT FENCE SHOULD BE INSTALLED AROUND THE DRAINAGE STRUCTURE AND INSTALLED UNDER THE GRATE.

- ### GENERAL SITE NOTES
- THE SITE PLANS WERE PREPARED BASED UPON TOPOGRAPHIC SURVEYS BY ALAN W. LEAS, S.A.M.E., 2020 LIBERTY ROAD, SUITE 105, LEXINGTON, KY, 40505. REFER TO SITE SURVEY SHEETS.
 - THE CONTRACTOR SHALL FIELD VERIFY ALL EXISTING SITE FEATURES AND CONDITIONS. REPORT ANY DISCREPANCIES TO THE ARCHITECT PRIOR TO THE START OF CONSTRUCTION.
 - THE ARCHITECT AND ARCHITECT'S CONSULTANTS SHALL HAVE NO RESPONSIBILITY FOR THE DISCOVERY, PRESENCE, HANDLING, REMOVAL OR DISPOSAL OF, OR EXPOSURE OF PERSONS TO HAZARDOUS MATERIALS IN ANY FORM AT THE PROJECT SITE, INCLUDING BUT NOT LIMITED TO ASBESTOS, ASBESTOS PRODUCTS, POLYCHLORINATED BIPHENYL (PCB) OR OTHER TOXIC SUBSTANCES.
 - THE CONTRACTOR SHALL USE EXTREME CARE IN WORKING AROUND EXISTING OVERHEAD AND UNDERGROUND UTILITIES. MEASURES SHOULD BE TAKEN TO PROTECT ALL UTILITIES FROM DAMAGE DURING CONSTRUCTION.
 - SEE EROSION POLLUTION AND SEDIMENT CONTROL PLAN ON SD0.1 FOR RECOMMENDED BEST MANAGEMENT PRACTICES INFORMATION AND SEDIMENT CONTROLS.
 - REFER TO CONSTRUCTION MANAGERS PLANS AND SPECIFICATIONS FOR INFORMATION REGARDING CONSTRUCTION SCHEDULE SEQUENCING, CONSTRUCTION FENCING/STAGING, AND LEED SPECIFIC REQUIREMENTS.
- ### LEGEND
- CONSTRUCTION ENTRANCE. SEE DETAIL A/SD0.1.
 - SEDIMENT CONTROL FENCE. ADDITIONAL FENCE MAY BE REQUIRED AT OTHER AREAS DURING CONSTRUCTION. SEE DETAIL F/SD0.1.
 - LIMITS OF CONSTRUCTION
 - SILT CHECK DAM - SEE DETAIL D/SD0.1.
 - INLET FILTER. SEE DETAIL F/SD0.1.



rosrarrant architects
lexington, kentucky 40502 p 859.254.4018
101 old georgetown avenue

NOT FOR CONSTRUCTION

EROSION PROTECTION AND SEDIMENT CONTROL PLAN
ESTILL COUNTY PHASE 7 HS RENOVATIONS
FOR:
ESTILL COUNTY SCHOOLS
IRVINE, KENTUCKY

M.E. & P. Engineer
CMIA, Inc.
2429 Members Way
Lexington, KY 40504
p 859.253.0892

Structural Engineer
Structural Design Group, Inc.
220 Great Circle Rd. Suite 106
Nashville, TN 37228
p 615.255.5537

BG# 21-055

Project No: 2025

Drawn By:

Rev'd By:

SHEET RELEASE	
1	
2	
3	
4	
5	
6	
7	
8	




COPYRIGHT © 2021

CONSTRUCTION DOCUMENTS

SD0.1

EROSION PROTECTION AND SEDIMENT CONTROL PLAN

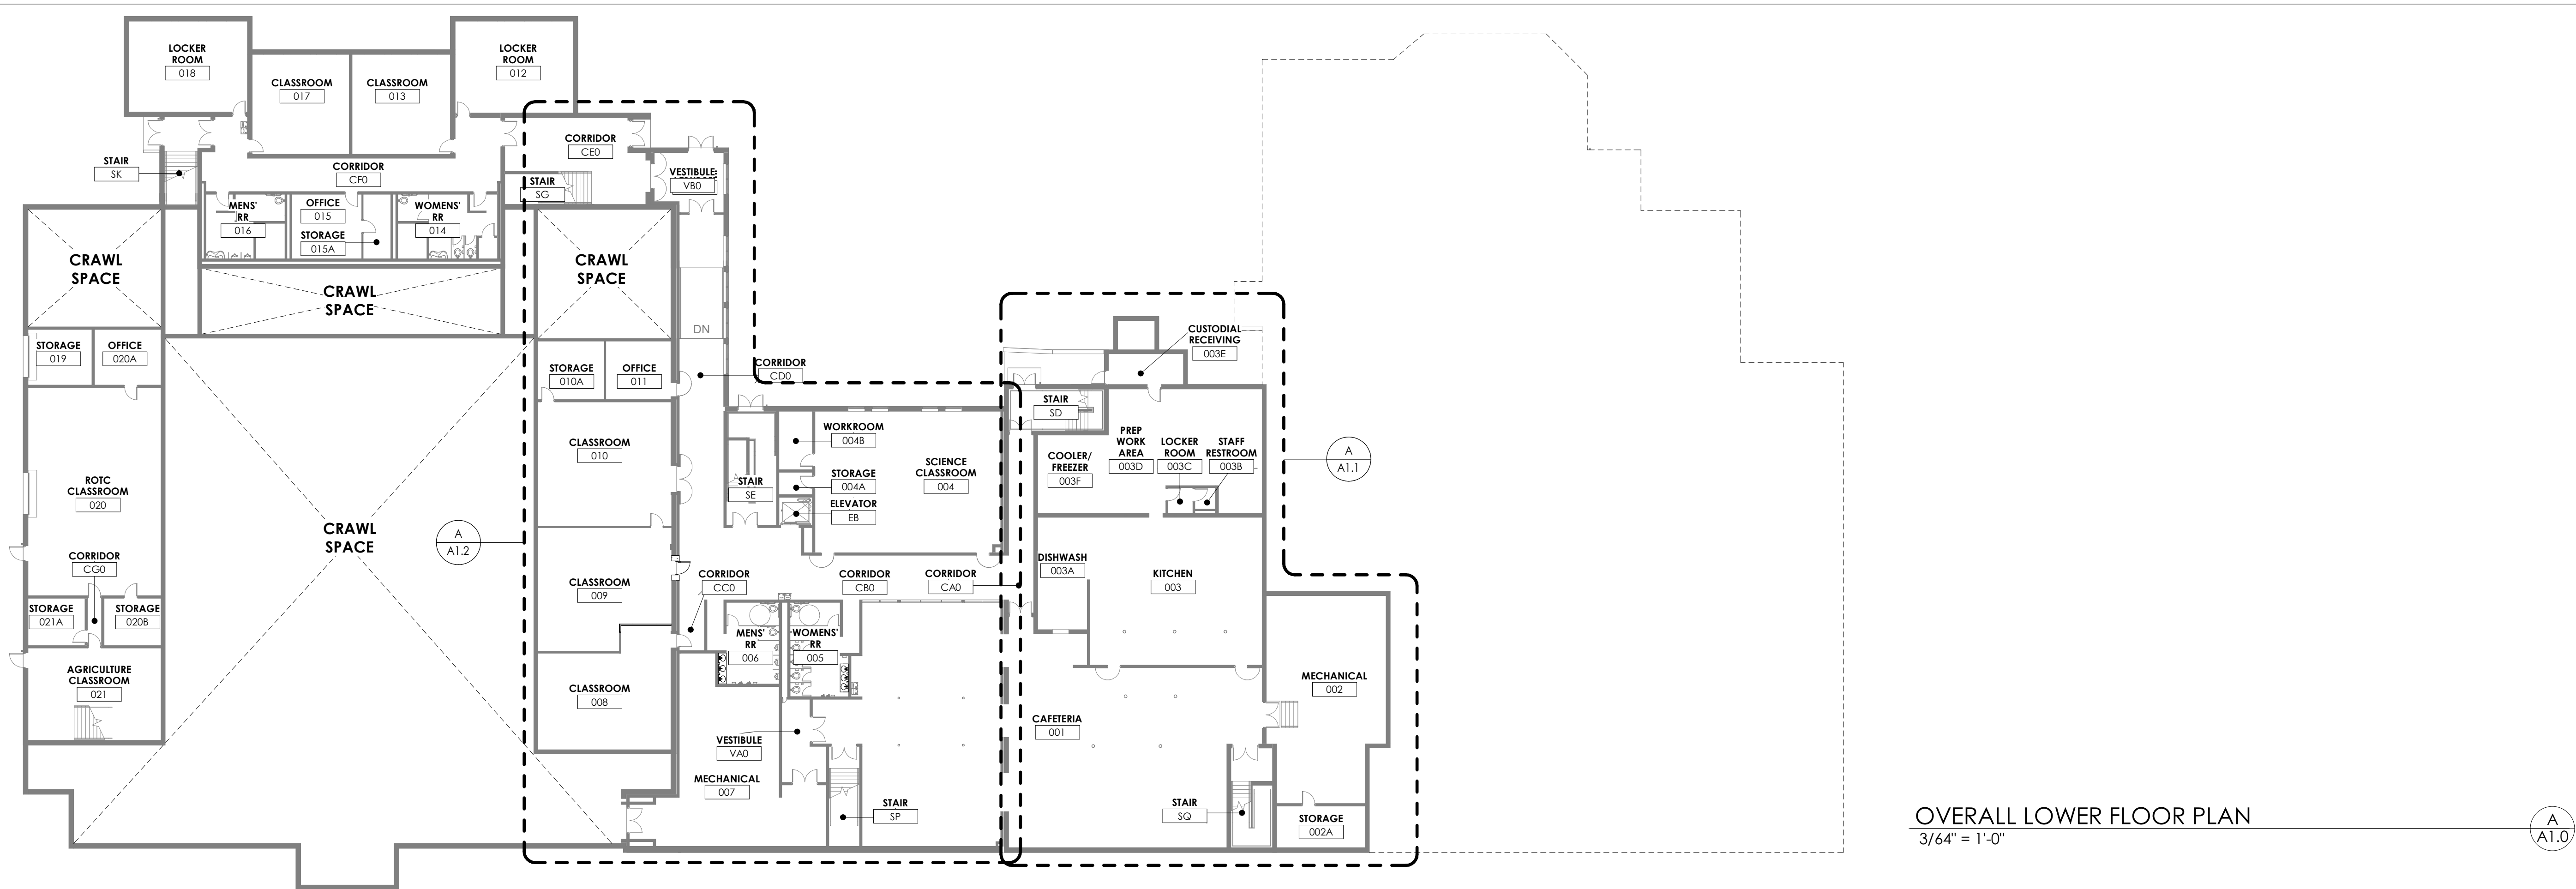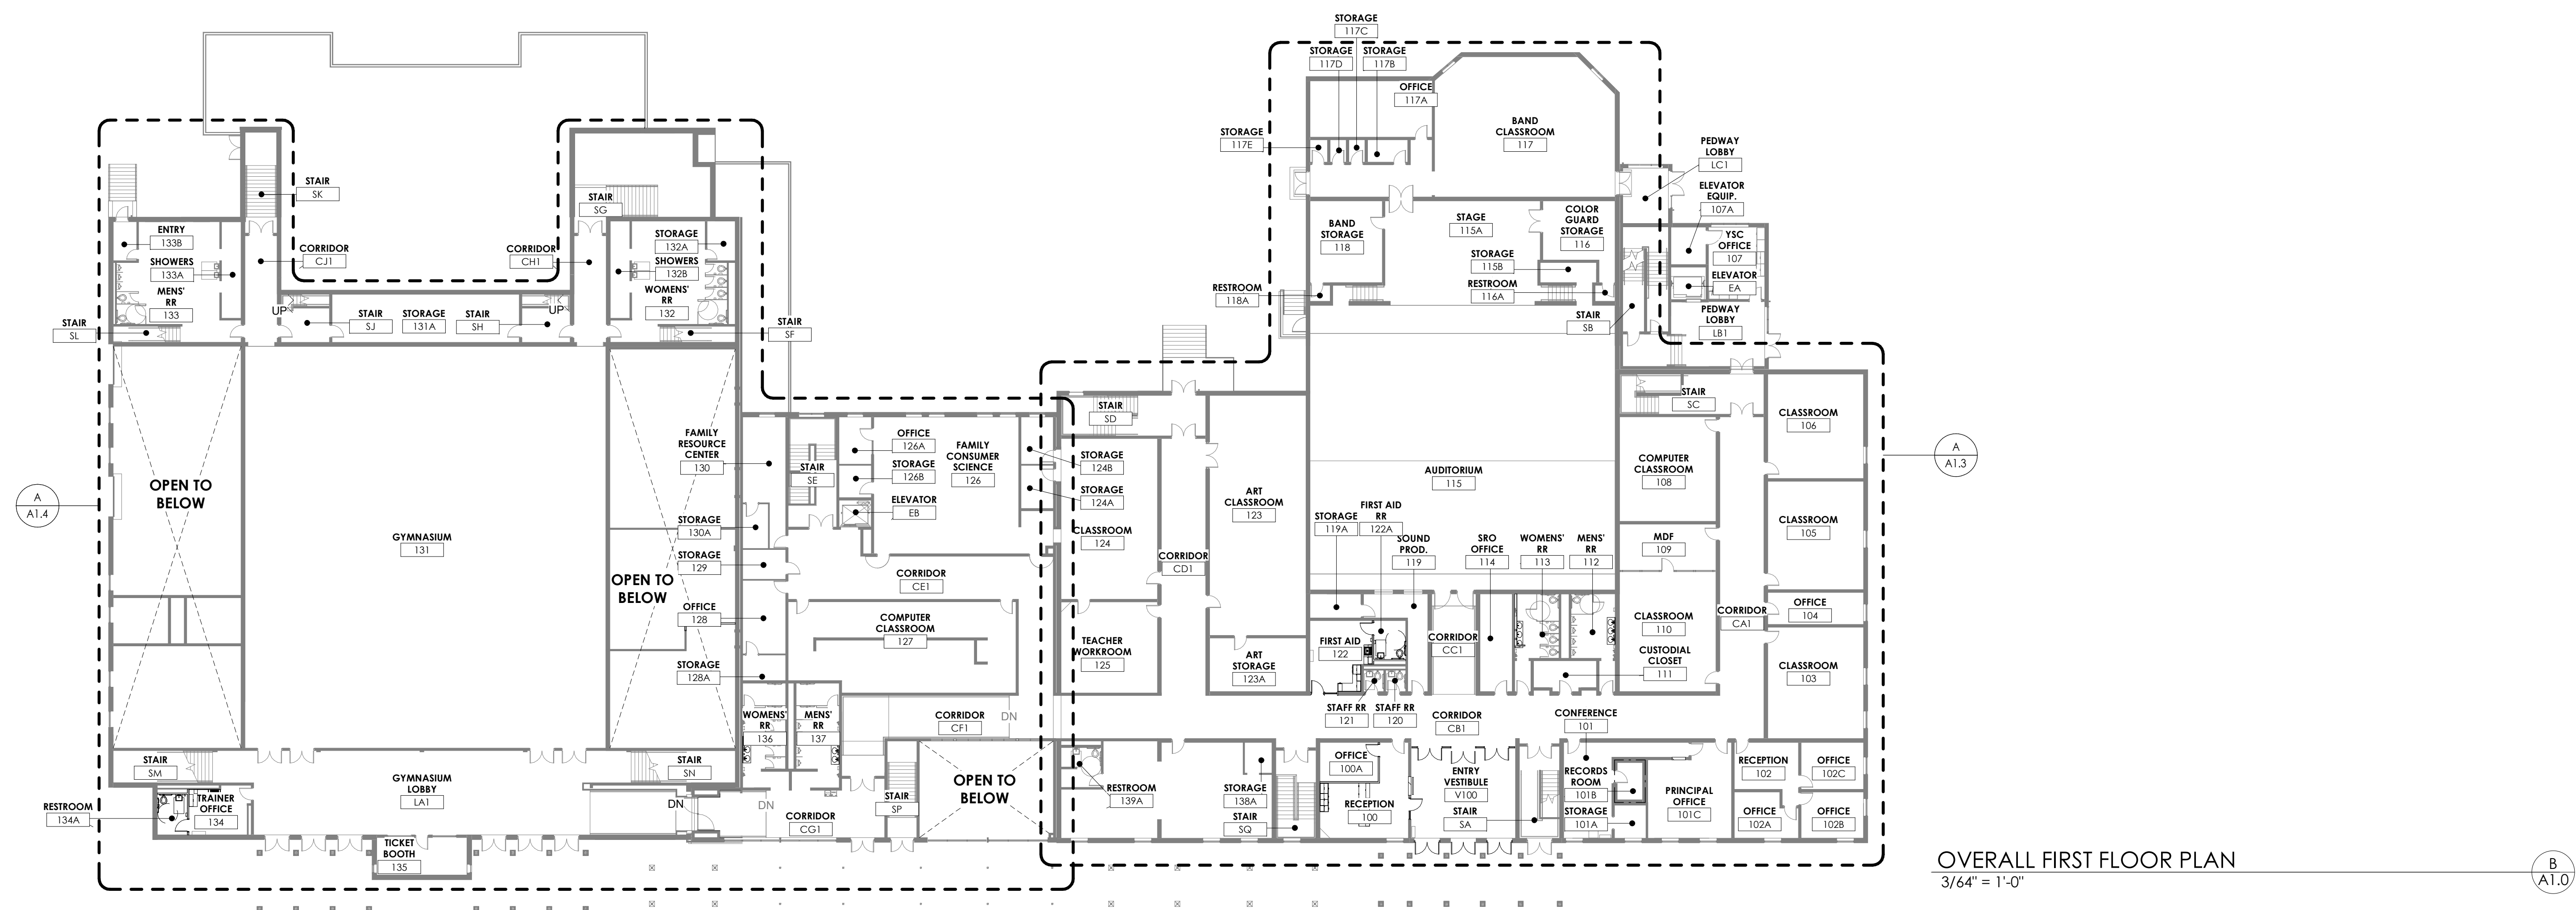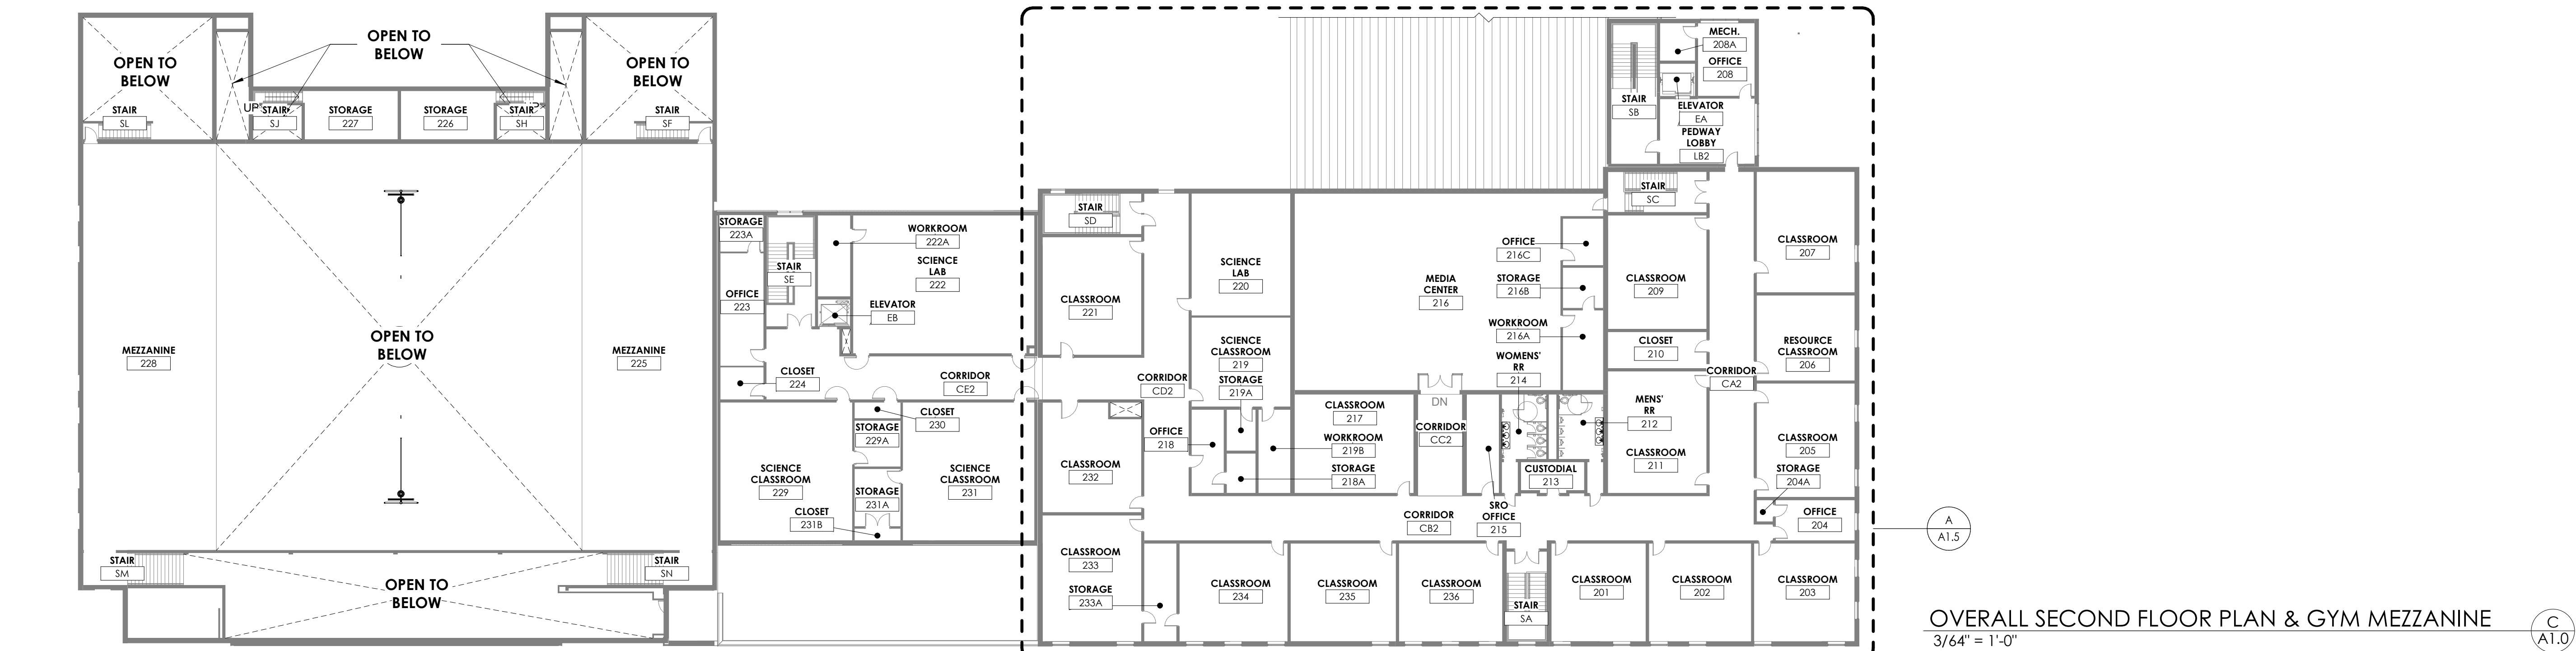DATE ISSUED:
JANUARY 28, 2021

[illegible]

MATERIAL REFERENCE

27 rosARRANT
architects

01 old lafayette avenue lexington, kentucky 40502 p 859.254.4018

NOT FOR
CONSTRUCTION

ESTILL COUNTY HIGH SCHOOL PHASE 7 RENOVATIONS
FOR:
ESTILL COUNTY SCHOOLS
IRVINE, KENTUCKY

M, E & P Engineer:
Staggs & Fisher
3264 Lochness Dr.
Lexington, KY 40517
p 589.271.3246

Structural Engineer:
Structural Design Group, Inc.
2220 Great Circle Rd. Suite 106
Nashville, TN 37228
p 615.255.5537

BG# 21-055

Project No:	2025
Drawn By:	JR / KM
Rev'd By:	PF

SHEET RELEASE		

2		
3		
4		

5		
5		
7		

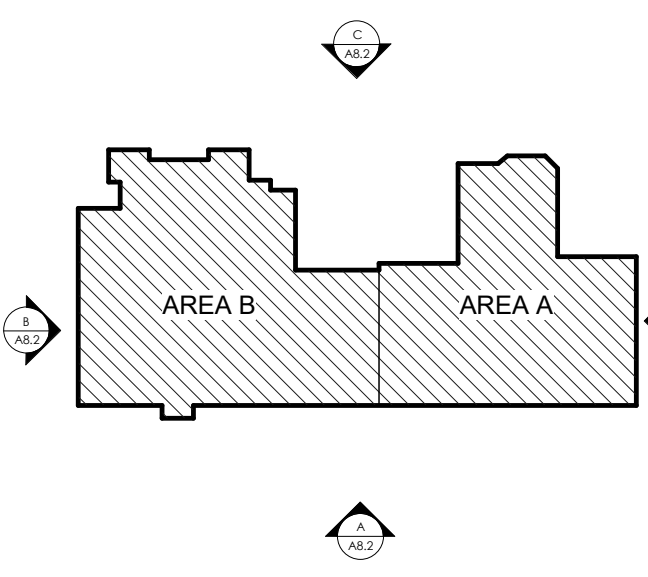
COPYRIGHT © 2020
CONSTRUCTION DOCUMENTS

A10

NEW WORK REFERENCE FLOOR
PLANS - HIGH SCHOOL

DATE ISSUED:
FEBRUARY 2021

KEY PLAN



SCALE: NTS

SITE DEVELOPMENT TAGS

LEGEND

GENERAL SITE NOTES

- 1 EXISTING TO REMAIN. PROTECT THROUGHOUT CONSTRUCTION.
[a] UTILITY LINE/STRUCTURE. REFER TO MEP DRAWINGS FOR ADDITIONAL INFORMATION.
[b] PAVING. PATCH/REPAIR WHERE DAMAGED BY CONSTRUCTION. SAW CUT TO PROVIDE SMOOTH TRANSITION.
[c] CONCRETE CURB.
[d] STORM STRUCTURE/LINE.
[e] TREE/VEGETATION.
[f] SPORTS EQUIPMENT.
[g] FENCE.
[h] SIGN.
[i] BUILDING. SEE ARCHITECTURAL FOR ADDITIONAL INFORMATION.

- 2 GRAVEL PAVING. (323223)
[a] AREA GRAVEL PAVING. SEE DETAIL B/SD4.2
[b] GRAVEL ROAD BASE. SEE DETAIL B/SD4.2

- 3 PERMEABLE CONCRETE PAVERS. (XXXXX) SEE DETAIL C/SD4.2

- 4 CONCRETE PAVEMENT (321313, 321373)
[a] 4" CONCRETE WALK. SEE DETAIL D/SD4.2
[b] 4" CONCRETE WALK. SEE DETAIL D/SD4.2
[c] CONCRETE THRESHOLD. SEE DETAIL E/SD4.2

- 5 CONCRETE CURBS (321313, 321413, 321726)
[a] 9" FLUSH HEADER CURB AT SYNTHETIC TURF. SEE DETAIL L/SD4.3
[b] 6" FLUSH HEADER CURB. SEE DETAIL F/SD4.2
[c] 6" HEIGHT CONCRETE CURB & GUTTER. SEE DETAIL G/SD4.2
[d] 1'-0" W x 1'-0" D CONCRETE FENCE BAND. SEE DETAIL H/SD4.2
[e] ACCESSIBLE DROPPED CURB, TYPE 'B' RAMP. SEE DETAIL I&J/SD4.2

- 6 CONCRETE STAIRS AND RAMP
[a] STAIR A. SEE DETAIL A&B/SD4.4
[b] STAIR B. SEE DETAIL C&D/SD4.4
[c] STAIR C. SEE DETAIL E&F/SD4.4
[d] STAIR D. SEE DETAIL F&G/SD4.4
[e] STAIR E. SEE DETAIL H&I/SD4.4
[f] STAIR F. SEE DETAIL A&B/SD4.5
[g] RAMP. SEE DETAIL C&D/SD4.5

- 7 ASPHALT PAVEMENT (321216)
[a] ASPHALT RUNNING TRACK. SEE DETAIL A/SD4.2 & K/SD4.3
[b] ASPHALT PAVEMENT. SEE DETAIL A/SD4.2
[c] ASPHALT SEAL COAT.

- 8 RETAINING WALL (323223)
[a] SEGMENTAL RETAINING WALL. SEE DETAIL P/SD4.2
[b] CAST IN PLACE CONCRETE RETAINING WALL. SEE DETAIL Q/SD4.2

- 9 ATHLETIC EQUIPMENT (116833.14 & 116833.23)
[a] FOOTBALL GOAL POST PACK. SEE DETAIL G/SD4.3.
[b] SOCCER GOAL AND NET. SEE DETAIL G/SD4.3.
[c] FOOTBALL PYLON
[d] SOCCER CORNER FLAG
[e] LONG/TRIPLE JUMP TAKE OFF BOARD. SEE DETAIL A/SD4.3
[f] POLE VAULT BOX. SEE DETAIL C/SD4.3
[g] SOFTBALL TENSIONED NET BACKSTOP SYSTEM.
[h] BASEBALL TENSIONED NET BACKSTOP SYSTEM.
[i] TENNIS NET. SEE B&C/SD4.4

- 10 MASONRY BACKSTOP WALL. SEE DETAIL R/SD4.2. (042000)

- 11 SHOT PUT PAD, TOE BOARD AND THROW FORM. SEE DETAIL D/SD4.3 (116833.43, 321613.33)
[a] SHOT PUT LANDING AREA. SEE DETAIL M/SD4.3

- 12 DISCUS CAGE, THROW FORM AND RING. SEE DETAIL E/SD4.3

- 13 SYNTHETIC TURF (321823.29). FINAL COLORS TO BE SUBMITTED FOR APPROVAL BY ARCHITECT AND OWNER.
[a] FIELD AREA. COLORS TO BE ALTERNATING GREEN.
[b] CENTER FIELD LOGO. SEE DETAIL J/SD4.3
[c] END ZONE TEXT. SEE DETAIL I/SD4.3
[d] FOOTBALL FIELD NUMBERS AND MARKINGS, WHITE. SEE DETAIL H/SD4.3
[e] SOCCER FIELD MARKINGS. COLOR TO BE BLACK.

- 14 CHAIN LINK FENCING (323113)
[a] 3'-6" HEIGHT VINYL COATED CHAIN LINK FENCE. SEE DETAIL E/SD4.4
[b] 6'-0" HEIGHT VINYL COATED CHAIN LINK FENCE. SEE DETAIL F/SD4.4
[c] 6'-0" HEIGHT, 12'-0" WIDTH VINYL COATED CHAIN LINK DOUBLE GATE. SEE DETAIL G/SD4.4
[d] 6'-0" HEIGHT, 4'-0" WIDTH VINYL COATED CHAIN LINK GATE. SEE DETAIL H/SD4.4
[e] 10'-0" HEIGHT VINYL COATED CHAIN LINK FENCING. SEE DETAIL D/SD4.4
[f] REINSTALL SALVAGED FENCING MESH. SET NEW POSTS AS SHOWN IN F/SD4.4

- 15 ORNAMENTAL FENCING & GATES (XXXX)
[a] 6'-0" HEIGHT ORNAMENTAL FENCE. SEE DETAIL I/SD4.4
[b] 6'-0" HEIGHT, 4'-0" WIDTH ORNAMENTAL GATE. SEE DETAIL J/SD4.4
[c] 6'-0" HEIGHT, 12'-0" WIDTH ORNAMENTAL DOUBLE GATE. SEE DETAIL K/SD4.4

- 16 PAINTED PAVEMENT MARKINGS (321723.13)
[a] 4" PAVING STRIPING, WHITE
[b] 4" PAVING STRIPING, BLUE
[c] PAINTED DISABLED PARKING SYMBOL, BLUE. SEE DETAIL L/SD4.2
[d] 4" PAVING STRIPING, YELLOW

- 17 ATHLETIC COURT COLOR COATING (321823.53)

- 18 TRAFFIC SIGNAGE. (101453)
[a] "VAN ACCESSIBLE ADA PARKING" SIGN. SEE DETAIL L/SD4.2
[b] "NO PARKING ANY TIME" SIGN. SEE DETAIL M/SD4.2
[c] "SERVICE VEHICLES AND STAFF ONLY" SIGN. SEE DETAIL N/SD4.2

- 19 RAILROAD TRACK/RELOCATED CABOOSE. SEE DETAIL O/SD4.2

- 20 RELOCATED RAILROAD CROSSING ARM. SEE MEP DRAWINGS FOR ADDITIONAL INFORMATION.

- 21 UTILITY STRUCTURE. SEE MEP DRAWINGS FOR ADDITIONAL INFORMATION.

- 22 ALT #8 TENNIS COURT LIGHTING. SEE MEP FOR MORE INFORMATION.

- 23 FLAG POLE. (107500) SEE DETAIL N/SD4.2.

- 24 CONCRETE WHEEL STOP. (321713) SEE DETAIL K/SD4.2

- 25 SCOREBOARD. INSTALL PER MANUFACTURER'S RECOMMENDATIONS. FOUNDATIONS TO BE DESIGNED AND SEALED BY ENGINEER LICENSED IN THE STATE OF KENTUCKY. SEE MEP DRAWINGS FOR ADDITIONAL INFORMATION.

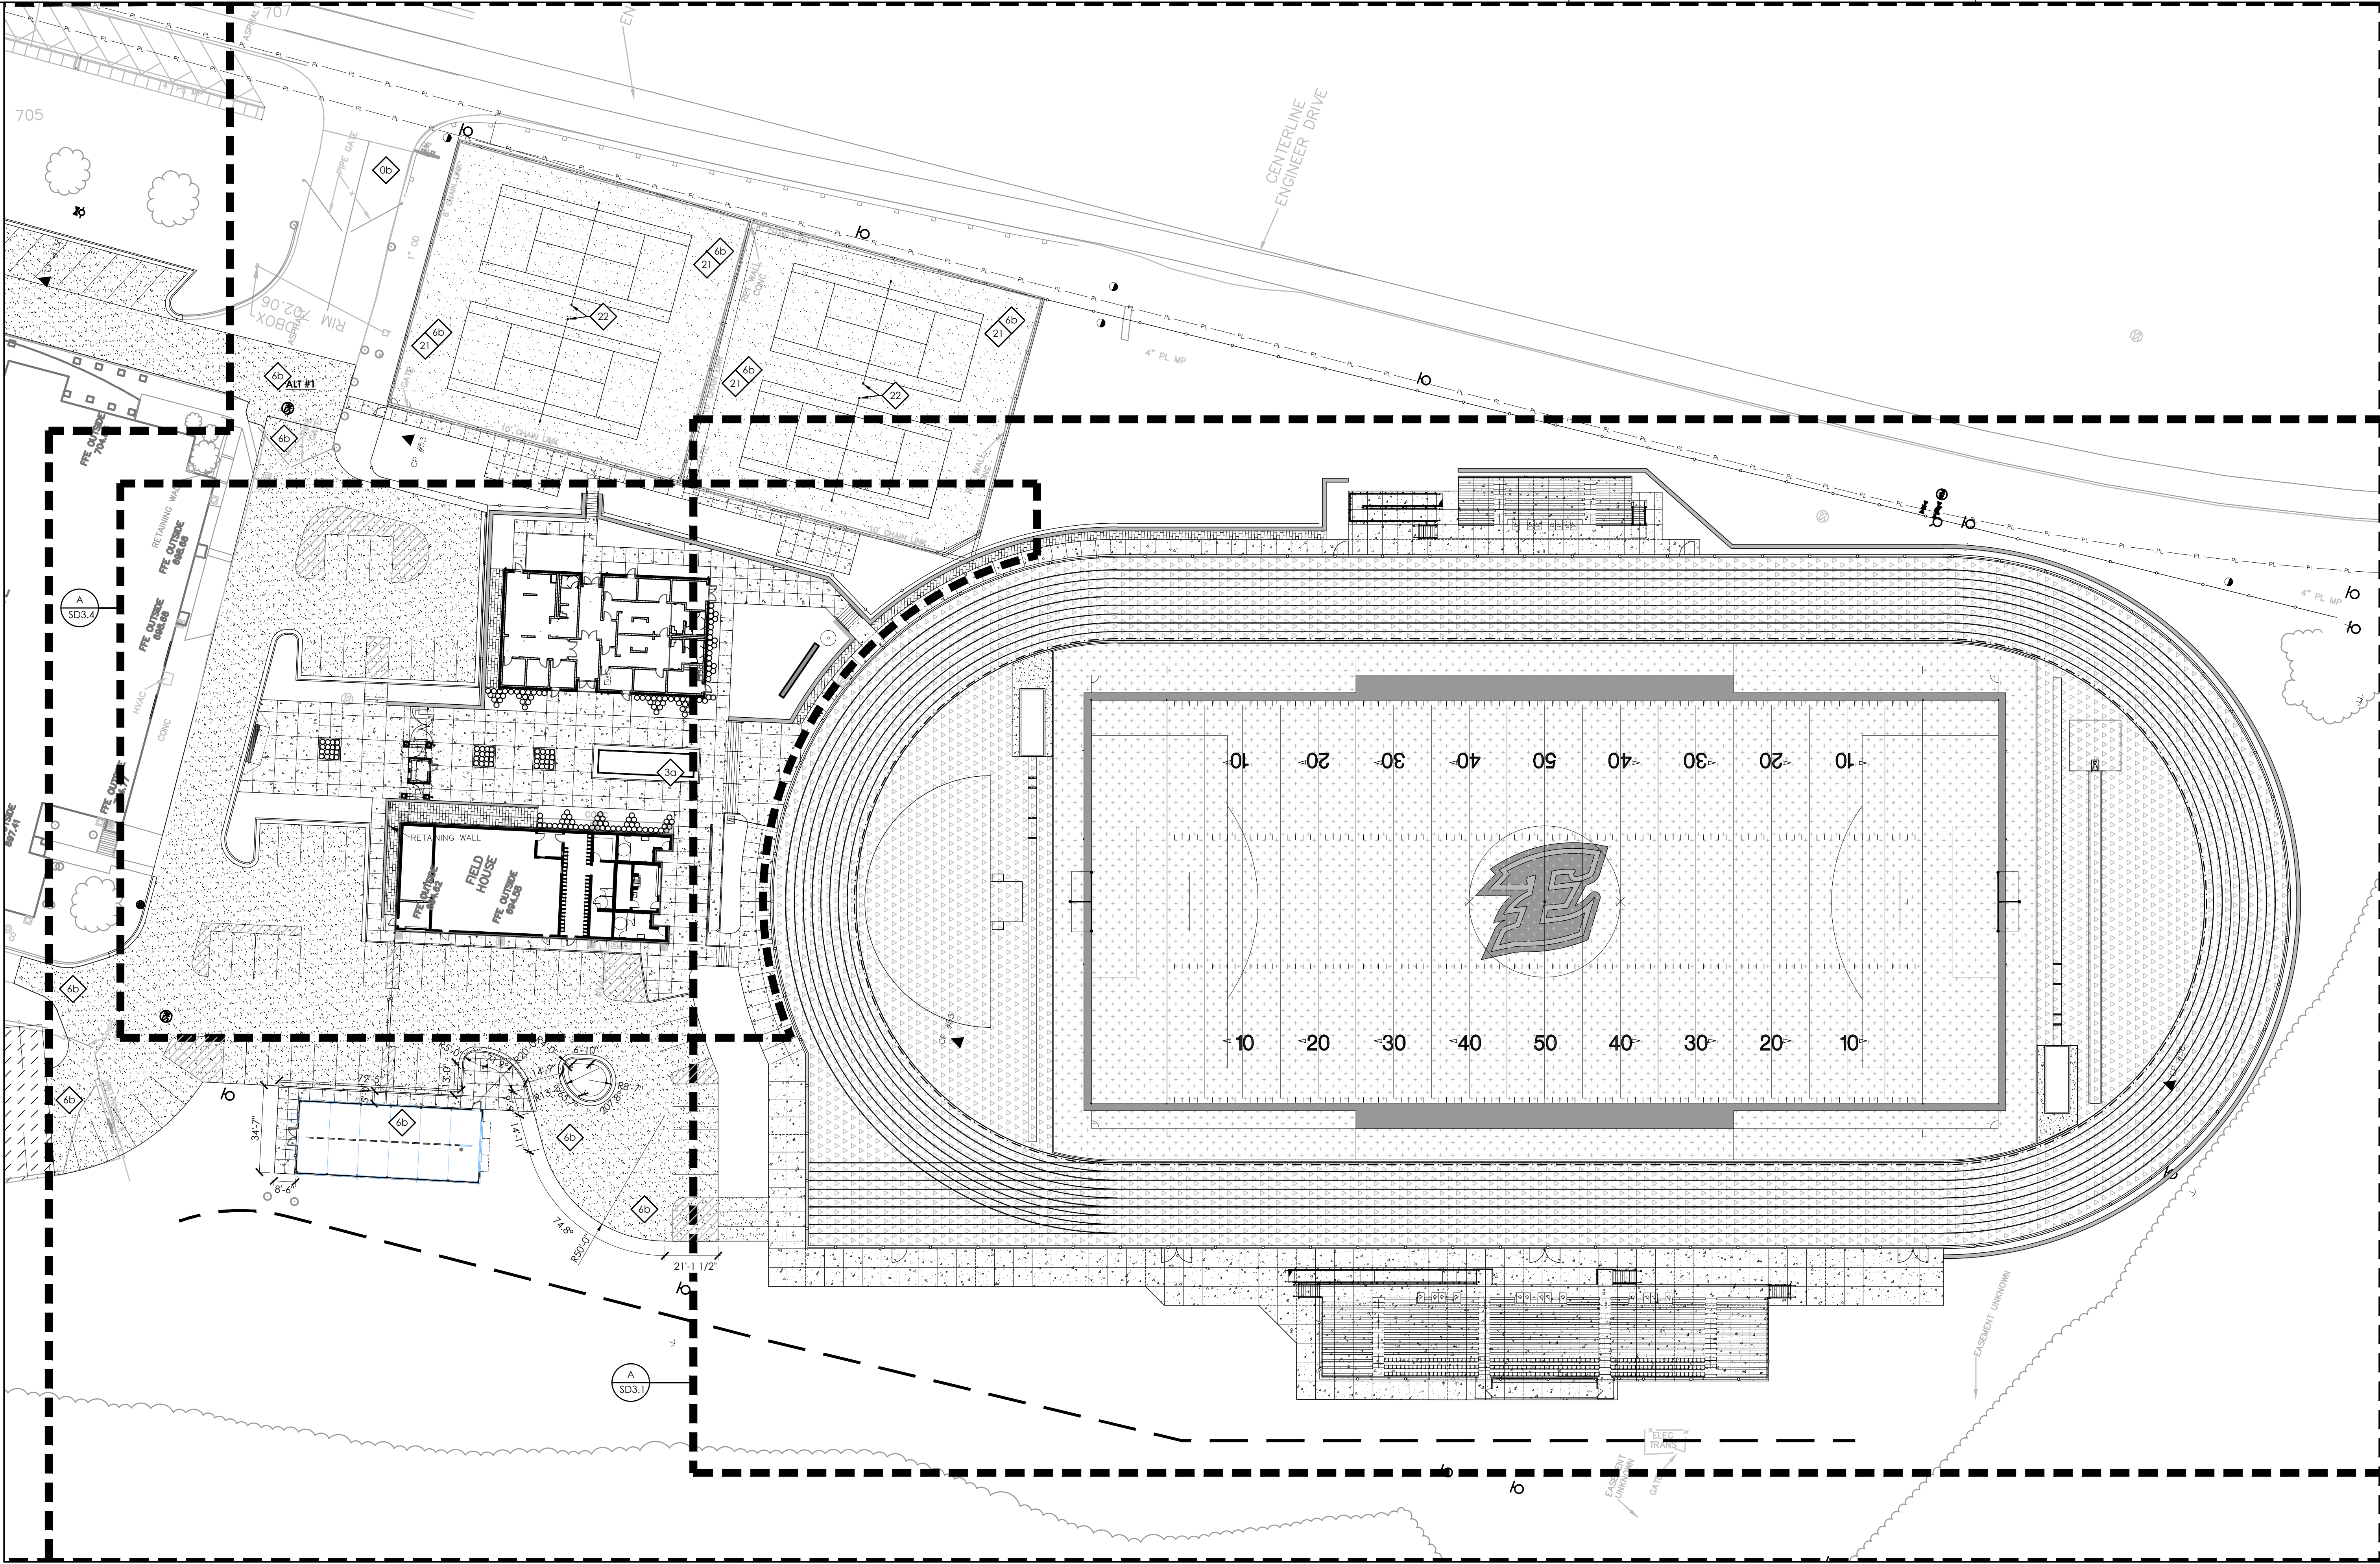
- 26 STRUCTURE. SEE ARCHITECTURAL AND STRUCTURAL DRAWINGS FOR ADDITIONAL INFORMATION.
[a] BUILDING CANOPY. SEE ARCHITECTURAL DRAWINGS FOR ADDITIONAL INFORMATION.

- CONCRETE PAVEMENT
MEDIUM DUTY CONCRETE PAVEMENT
HEAVY DUTY CONCRETE PAVEMENT
ASPHALT PAVEMENT
HEAVY DUTY ASPHALT PAVEMENT
SYNTHETIC TURF
SYNTHETIC TRACK SURFACE
GRAVEL PAVEMENT
ISOLATION JOINT

1. THE SITE PLANS WERE PREPARED BASED UPON TOPOGRAPHIC SURVEYS BY ALAN W. LEAK, SAME, 2020 LIBERTY ROAD, SUITE 105, LEXINGTON, KY, 40505. REFER TO SITE SURVEY SHEETS.
2. THE CONTRACTOR SHALL FIELD VERIFY ALL EXISTING SITE FEATURES AND CONDITIONS. REPORT ANY DISCREPANCIES TO THE ARCHITECT PRIOR TO THE START OF CONSTRUCTION.
3. THE ARCHITECT AND ARCHITECTS CONSULTANTS SHALL HAVE NO RESPONSIBILITY FOR THE DISCOVERY, PRESENCE, HANDLING, REMOVAL OR DISPOSAL OF, OR EXPOSURE OF PERSONS TO HAZARDOUS MATERIALS IN ANY FORM AT THE PROJECT SITE, INCLUDING BUT NOT LIMITED TO ASBESTOS, ASBESTOS PRODUCTS, POLYCHLORINATED BIPHENYL (PCB) OR OTHER TOXIC SUBSTANCES.
4. THE CONTRACTOR SHALL USE EXTREME CARE IN WORKING AROUND EXISTING OVERHEAD AND UNDERGROUND UTILITIES. MEASURES SHOULD BE TAKEN TO PROTECT ALL UTILITIES FROM DAMAGE DURING CONSTRUCTION.
5. SEE EROSION POLLUTION AND SEDIMENT CONTROL PLAN ON SD0.1 FOR RECOMMENDED BEST MANAGEMENT PRACTICES INFORMATION AND SEDIMENT CONTROLS.
6. REFER TO CONSTRUCTION MANAGER'S PLANS AND SPECIFICATIONS FOR INFORMATION REGARDING CONSTRUCTION SCHEDULE/SEQUENCING, CONSTRUCTION FENCING/STAGING, AND LEED SPECIFIC REQUIREMENTS.

rostartant architects
101 old tabberville avenue lexington, kentucky 40502 p 859.254.4018

NOT FOR CONSTRUCTION



SITE DEVELOPMENT AND LAYOUT PLAN
SCALE: 1"=30'

0 30 60 feet

SD1.1

OVERSIGHT DEVELOPMENT AND LAYOUT PLAN
ESTILL COUNTY PHASE 7 HS RENOVATIONS
FOR:
ESTILL COUNTY SCHOOLS
IRVINE, KENTUCKY

M.E.A.P. Engineer
CMWA, Inc.
2429 Members Way
Lexington, KY 40504
p 859.253.0892

Structural Engineer
Structural Design Group, Inc.
220 Great Circle Rd., Suite 106
Nashville, TN 37228
p 615.255.5337

BG# 21-055
Project No: 2025
Drawn By:
Rev'd By:

SHEET RELEASE	
1	
2	
3	
4	
5	
6	
7	
8	

COPYRIGHT © 2021
CONSTRUCTION DOCUMENTS

SD1.1
SITE DEVELOPMENT
AND LAYOUT PLAN
DATE ISSUED:
JANUARY 28, 2021

SITE DEVELOPMENT TAGS

- 1 EXISTING TO REMAIN. PROTECT THROUGHOUT CONSTRUCTION.
[a] UTILITY LINE/STRUCTURE. REFER TO MEP DRAWINGS FOR ADDITIONAL INFORMATION.
[b] PAVING. PATCH/REPAIR WHERE DAMAGED BY CONSTRUCTION. SAW CUT TO PROVIDE SMOOTH TRANSITION.
[c] CONCRETE CURB.
[d] STORM STRUCTURE/LINE.
[e] TREE/VEGETATION.
[f] SPORTS EQUIPMENT
[g] FENCE.
[h] SIGN.
[i] BUILDING. SEE ARCHITECTURAL FOR ADDITIONAL INFORMATION.
- 2 GRAVEL PAVING. (32323)
[a] AREA GRAVEL PAVING. SEE DETAIL B/SD4.2
[b] GRAVEL ROAD BASE. SEE DETAIL B/SD4.2
- 3 PERMEABLE CONCRETE PAVERS. (XXXXX) SEE DETAIL C/SD4.2
- 4 CONCRETE PAVEMENT (321313, 321373)
[a] 4" CONCRETE WALK. SEE DETAIL D/SD4.2
[b] 4" CONCRETE WALK. SEE DETAIL D/SD4.2
[c] CONCRETE THRESHOLD. SEE DETAIL E/SD4.2
- 5 CONCRETE CURBS (321313, 321413, 321726)
[a] 9" FLUSH HEADER CURB AT SYNTHETIC TURF. SEE DETAIL L/SD4.3
[b] 6" FLUSH HEADER CURB. SEE DETAIL F/SD4.2
[c] 6" HEIGHT CONCRETE CURB & GUTTER. SEE DETAIL G/SD4.2
[d] 1'-0" W x 1'-0" D CONCRETE FENCE BAND. SEE DETAIL H/SD4.2
[e] ACCESSIBLE DROPPED CURB, TYPE 'B' RAMP. SEE DETAIL I&J/SD4.2

- 6 CONCRETE STAIRS AND RAMP
[a] STAIR A. SEE DETAIL A&B/SD4.5
[b] STAIR B. SEE DETAIL C&D/SD4.5
[c] STAIR C. SEE DETAIL C&E/SD4.5
[d] STAIR D. SEE DETAIL F&G/SD4.5
[e] STAIR E. SEE DETAIL H&I/SD4.5
[f] STAIR F. SEE DETAIL A&B/SD4.6
[g] RAMP. SEE DETAIL C&D/SD4.6
- 7 ASPHALT PAVEMENT (321216)
[a] ASPHALT RUNNING TRACK. SEE DETAIL A/SD4.2 & K/SD4.3
[b] ASPHALT PAVEMENT. SEE DETAIL A/SD4.2
[c] ASPHALT SEAL COAT.
- 8 RETAINING WALL (323223)
[a] SEGMENTAL RETAINING WALL. SEE DETAIL P/SD4.2
[b] CAST IN PLACE CONCRETE RETAINING WALL. SEE DETAIL Q/SD4.2
- 9 ATHLETIC EQUIPMENT (116833.14 & 116833.23)
[a] FOOTBALL GOAL POST PACK. SEE DETAIL G/SD4.3.
[b] SOCCER GOAL AND NET. SEE DETAIL G/SD4.3.
[c] FOOTBALL PYLON
[d] SOCCER CORNER FLAG
[e] LONG/TRIPLE JUMP TAKE OFF BOARD. SEE DETAIL A/SD4.3
[f] POLE VAULT BOX. SEE DETAIL C/SD4.3
[g] SOFTBALL TENSIONED NET BACKSTOP SYSTEM.
[h] BASEBALL TENSIONED NET BACKSTOP SYSTEM.
[i] TENNIS NET. SEE B&C/SD4.4
- 10 MASONRY BACKSTOP WALL. SEE DETAIL R/SD4.2. (042000)
- 11 SHOT PUT PAD, TOE BOARD AND THROW FORM. SEE DETAIL D/SD4.3 (116833.43, 321613.33)
[a] SHOT PUT LANDING AREA. SEE DETAIL M/SD4.3

- 12 DISCUS CAGE, THROW FORM AND RING. SEE DETAIL E/SD4.3
- 13 SYNTHETIC TURF (321823.29). FINAL COLORS TO BE SUBMITTED FOR APPROVAL BY ARCHITECT AND OWNER.
[a] FIELD AREA. COLORS TO BE ALTERNATING GREEN.
[b] CENTER FIELD LOGO. SEE DETAIL J/SD4.3
[c] END ZONE TEXT. SEE DETAIL I/SD4.3
[d] FOOTBALL FIELD NUMBERS AND MARKINGS, WHITE. SEE DETAIL H/SD4.3
[e] SOCCER FIELD MARKINGS. COLOR TO BE BLACK.
- 14 **ALT #4** SYNTHETIC RUNNING TRACK SURFACING, STRIPING AND MARKINGS (321823.33)
- 15 CHAIN LINK FENCING (323113)
[a] 3'-6" HEIGHT VINYL COATED CHAIN LINK FENCE. SEE DETAIL E/SD4.4
[b] 6'-0" HEIGHT VINYL COATED CHAIN LINK FENCE. SEE DETAIL F/SD4.4
[c] 6'-0" HEIGHT, 12'-0" WIDTH VINYL COATED CHAIN LINK DOUBLE GATE. SEE DETAIL G/SD4.4
[d] 6'-0" HEIGHT, 4'-0" WIDTH VINYL COATED CHAIN LINK GATE. SEE DETAIL H/SD4.4
[e] 10'-0" HEIGHT VINYL COATED CHAIN LINK FENCING. SEE DETAIL D/SD4.4
[f] REINSTALL SALVAGED FENCING MESH. SET NEW POSTS AS SHOWN IN F/SD4.4
- 16 ORNAMENTAL FENCING & GATES (XXXX)
[a] 6'-0" HEIGHT ORNAMENTAL FENCE. SEE DETAIL I/SD4.4
[b] 4'-0" HEIGHT, 4'-0" WIDTH ORNAMENTAL GATE. SEE DETAIL J/SD4.4
[c] 6'-0" HEIGHT, 12'-0" WIDTH ORNAMENTAL DOUBLE GATE. SEE DETAIL K/SD4.4
- 17 PAINTED PAVEMENT MARKINGS (321723.13)
[a] 4" PAVING STRIPING, WHITE
[b] 4" PAVING STRIPING, BLUE
[c] PAINTED DISABLED PARKING SYMBOL, BLUE. SEE DETAIL L/SD4.2.
[d] 4" PAVING STRIPING, YELLOW

- 18 ATHLETIC COURT COLOR COATING (321823.53)
- 19 TRAFFIC SIGNAGE. (101453)
[a] "VAN ACCESSIBLE ADA PARKING" SIGN. SEE DETAIL L/SD4.2
[b] "NO PARKING ANY TIME" SIGN. SEE DETAIL M/SD4.2
[c] "SERVICE VEHICLES AND STAFF ONLY" SIGN. SEE DETAIL N/SD4.2
- 20 RAILROAD TRACK/RELOCATED CABOOSE. SEE DETAIL O/SD4.2
- 21 RELOCATED RAILROAD CROSSING ARM. SEE MEP DRAWINGS FOR ADDITIONAL INFORMATION.
- 22 UTILITY STRUCTURE. SEE MEP DRAWINGS FOR ADDITIONAL INFORMATION.
- 23 **ALT #8** TENNIS COURT LIGHTING. SEE MEP FOR MORE INFORMATION.
- 24 FLAG POLE. (107500) SEE DETAIL N/SD4.2.
- 25 CONCRETE WHEEL STOP. (321713) SEE DETAIL K/SD4.2
- 26 SCOREBOARD. INSTALL PER MANUFACTURER'S RECOMMENDATIONS. FOUNDATIONS TO BE DESIGNED AND SEALED BY ENGINEER LICENSED IN THE STATE OF KENTUCKY. SEE MEP DRAWINGS FOR ADDITIONAL INFORMATION.
- 27 STRUCTURE. SEE ARCHITECTURAL AND STRUCTURAL DRAWINGS FOR ADDITIONAL INFORMATION.
[a] BUILDING CANOPY. SEE ARCHITECTURAL DRAWINGS FOR ADDITIONAL INFORMATION.

LEGEND

- CONCRETE PAVEMENT
- MEDIUM DUTY CONCRETE PAVEMENT
- HEAVY DUTY CONCRETE PAVEMENT
- ASPHALT PAVEMENT
- HEAVY DUTY ASPHALT PAVEMENT
- SYNTHETIC TURF
- SYNTHETIC TRACK SURFACE
- GRAVEL PAVEMENT
- ISOLATION JOINT

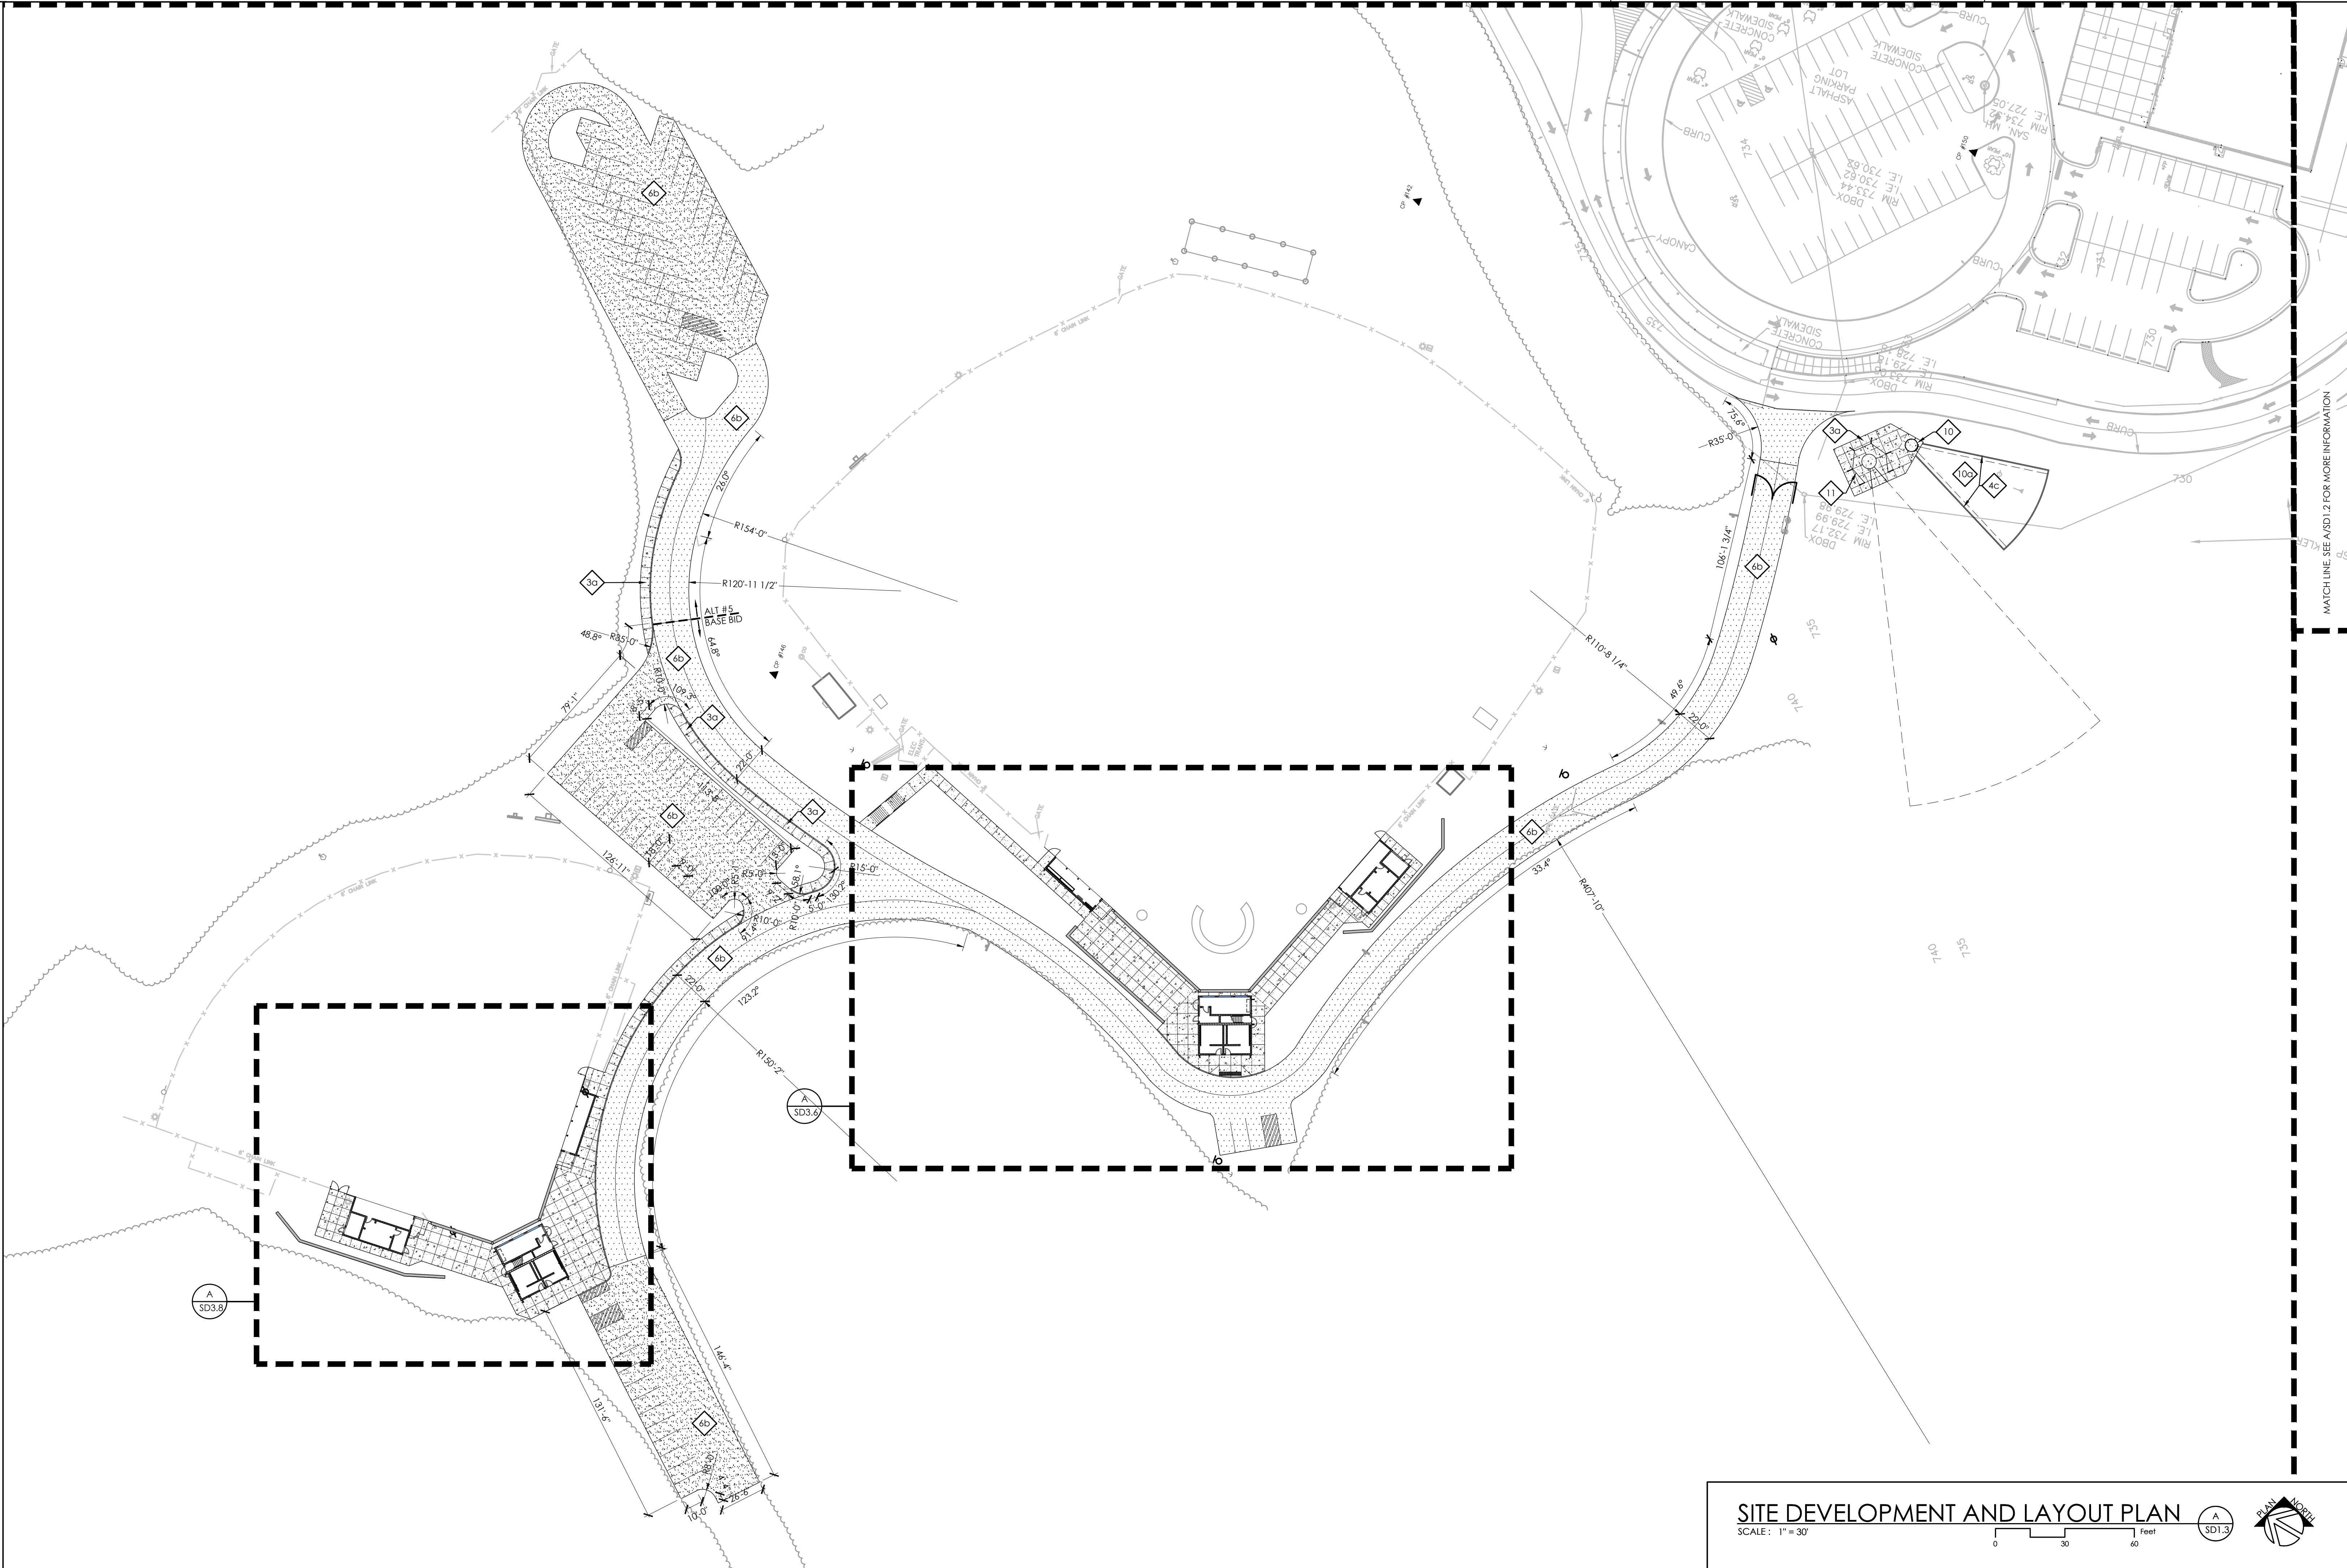
GENERAL SITE NOTES

1. THE SITE PLANS WERE PREPARED BASED UPON TOPOGRAPHIC SURVEYS BY ALAN W. LEAK, S&ME, 2020 LIBERTY ROAD, SUITE 105, LEXINGTON, KY, 40505. REFER TO SITE SURVEY SHEETS.
2. THE CONTRACTOR SHALL FIELD VERIFY ALL EXISTING SITE FEATURES AND CONDITIONS. REPORT ANY DISCREPANCIES TO THE ARCHITECT PRIOR TO THE START OF CONSTRUCTION.
3. THE ARCHITECT AND ARCHITECTS CONSULTANTS SHALL HAVE NO RESPONSIBILITY FOR THE DISCOVERY, PRESENCE, HANDLING, REMOVAL OR DISPOSAL OF, OR EXPOSURE OF PERSONS TO HAZARDOUS MATERIALS IN ANY FORM AT THE PROJECT SITE, INCLUDING BUT NOT LIMITED TO ASBESTOS, ASBESTOS PRODUCTS, POLYCHLORINATED BIPHENYL (PCB) OR OTHER TOXIC SUBSTANCES.
4. THE CONTRACTOR SHALL USE EXTREME CARE IN WORKING AROUND EXISTING OVERHEAD AND UNDERGROUND UTILITIES. MEASURES SHOULD BE TAKEN TO PROTECT ALL UTILITIES FROM DAMAGE DURING CONSTRUCTION.
5. SEE EROSION POLLUTION AND SEDIMENT CONTROL PLAN ON SD0.1 FOR RECOMMENDED BEST MANAGEMENT PRACTICES INFORMATION AND SEDIMENT CONTROLS.
6. REFER TO CONSTRUCTION MANAGER'S PLANS AND SPECIFICATIONS FOR INFORMATION REGARDING CONSTRUCTION SCHEDULE/SEQUENCING, CONSTRUCTION FENCING/STAGING, AND LEED SPECIFIC REQUIREMENTS.

rostartant architects

101 old tabbette avenue lexington, kentucky 40502 p 859.254.4018


NOT FOR CONSTRUCTION



SITE DEVELOPMENT AND LAYOUT PLAN

SCALE: 1" = 30'

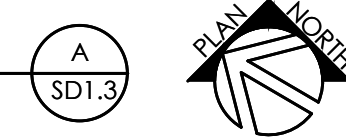0 30 60 feet



SITE DEVELOPMENT AND LAYOUT PLAN
ESTILL COUNTY PHASE 7 HS RENOVATIONS
FOR:
ESTILL COUNTY SCHOOLS
IRVINE, KENTUCKY

M.E.&P Engineer
CMTA, Inc.
2429 Members Way
Lexington, KY 40504
p 859.253.0892

Structural Engineer
Structural Design Group, Inc.
220 Great Circle Rd., Suite 106
Nashville, TN 37228
p 615.255.5537

BG# 21-055

Project No: 2025

Drawn By:

Rev'd By:













SHEET RELEASE	
1	
2	
3	
4	
5	
6	
7	
8	

COPYRIGHT © 2021

CONSTRUCTION DOCUMENTS

SD1.3

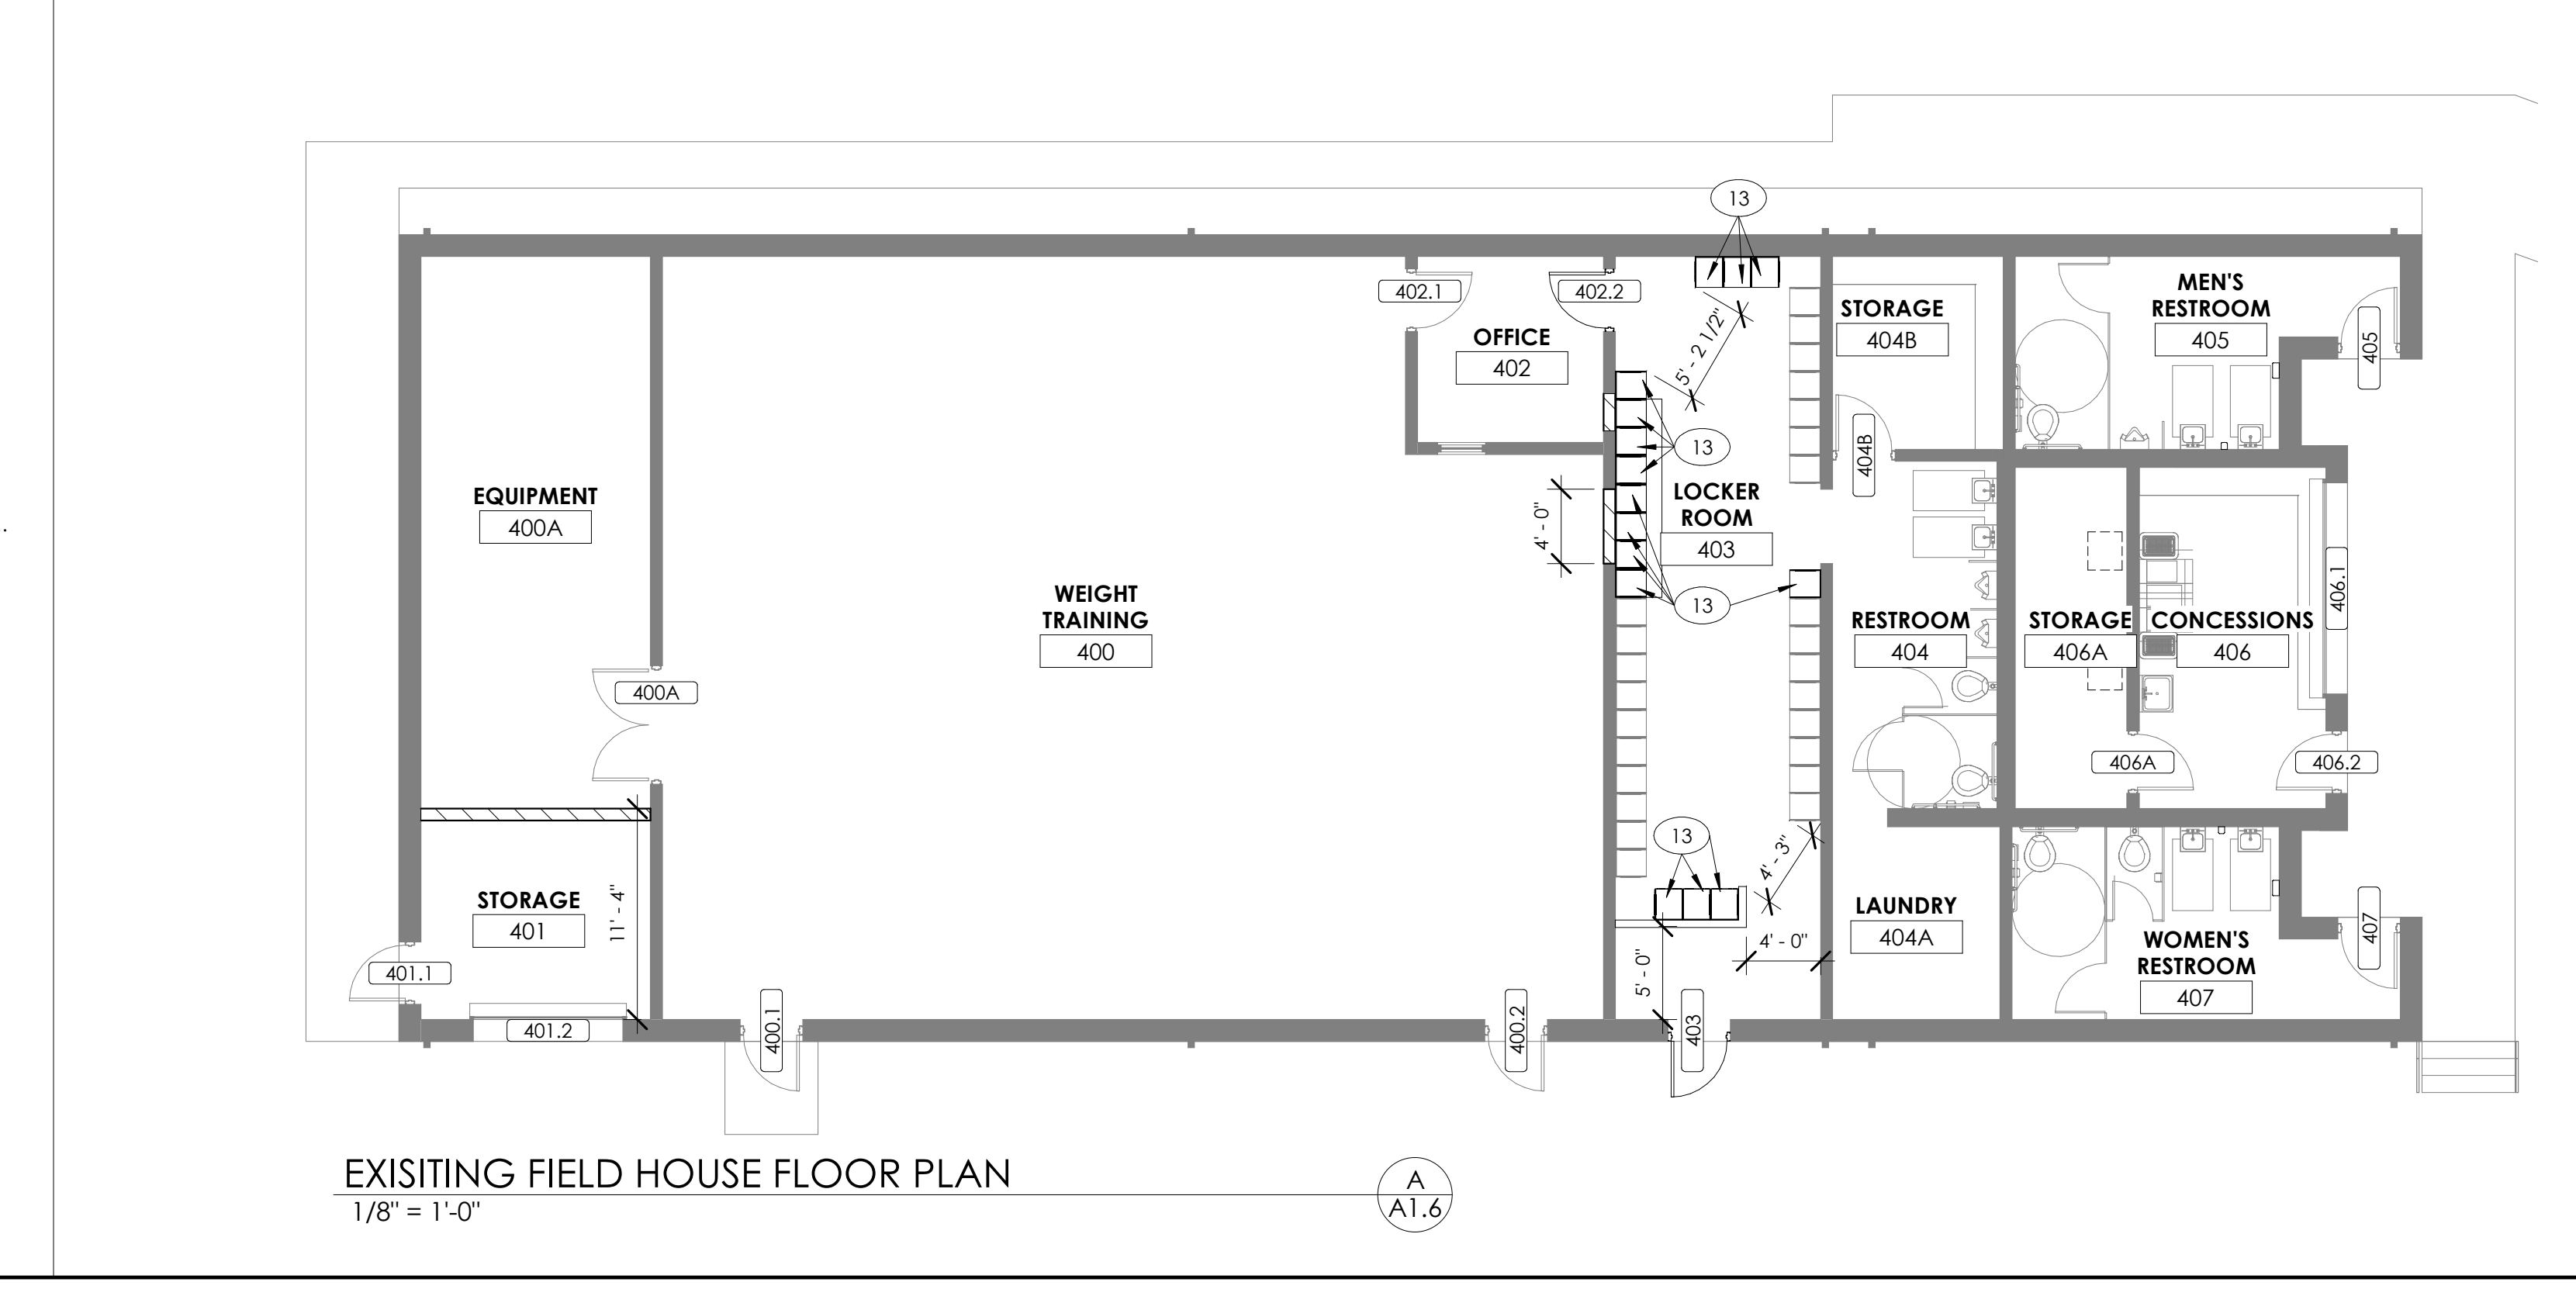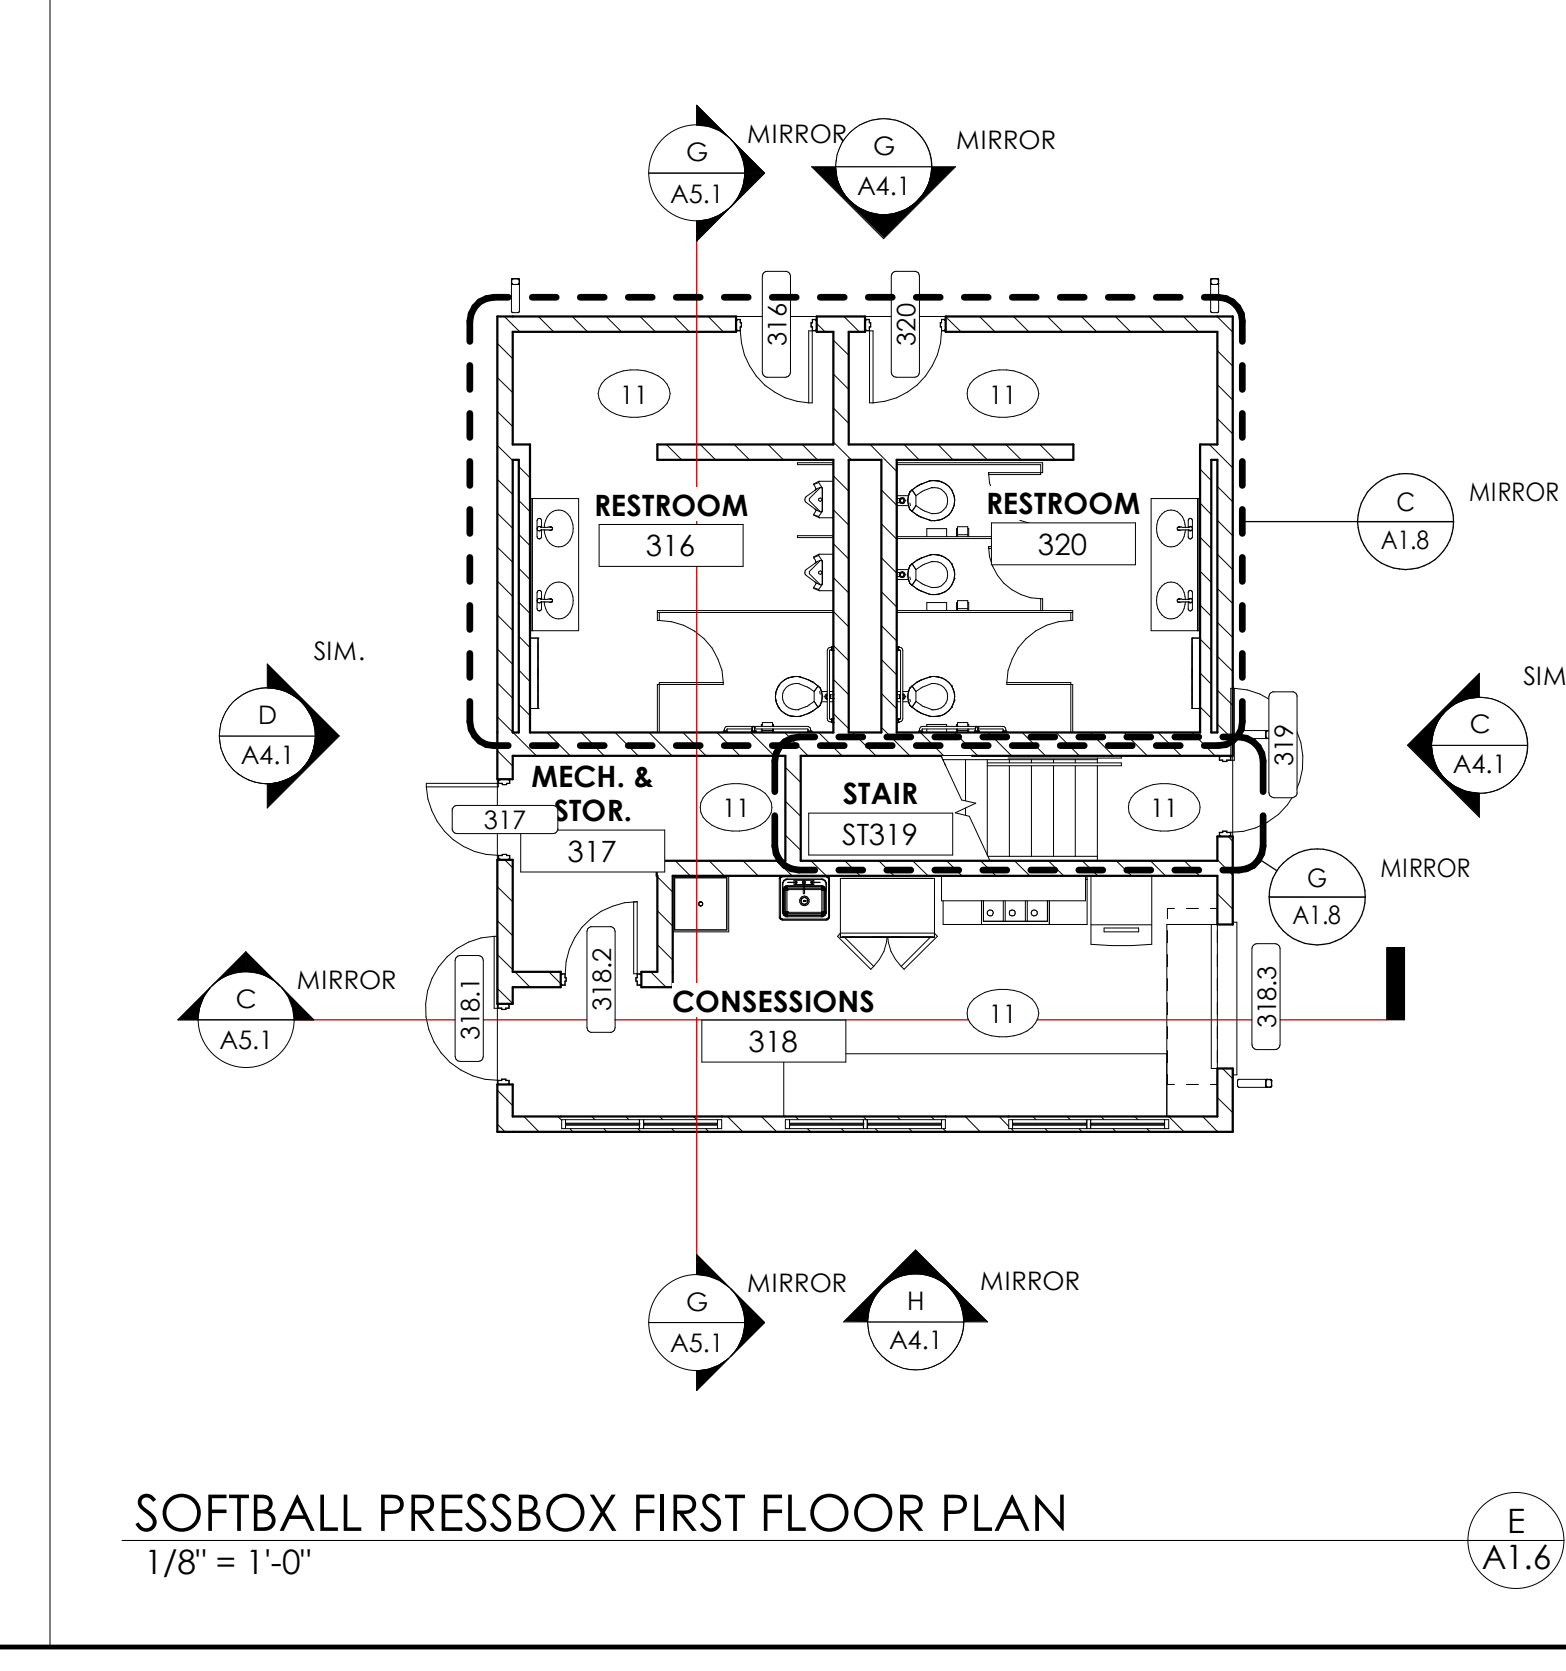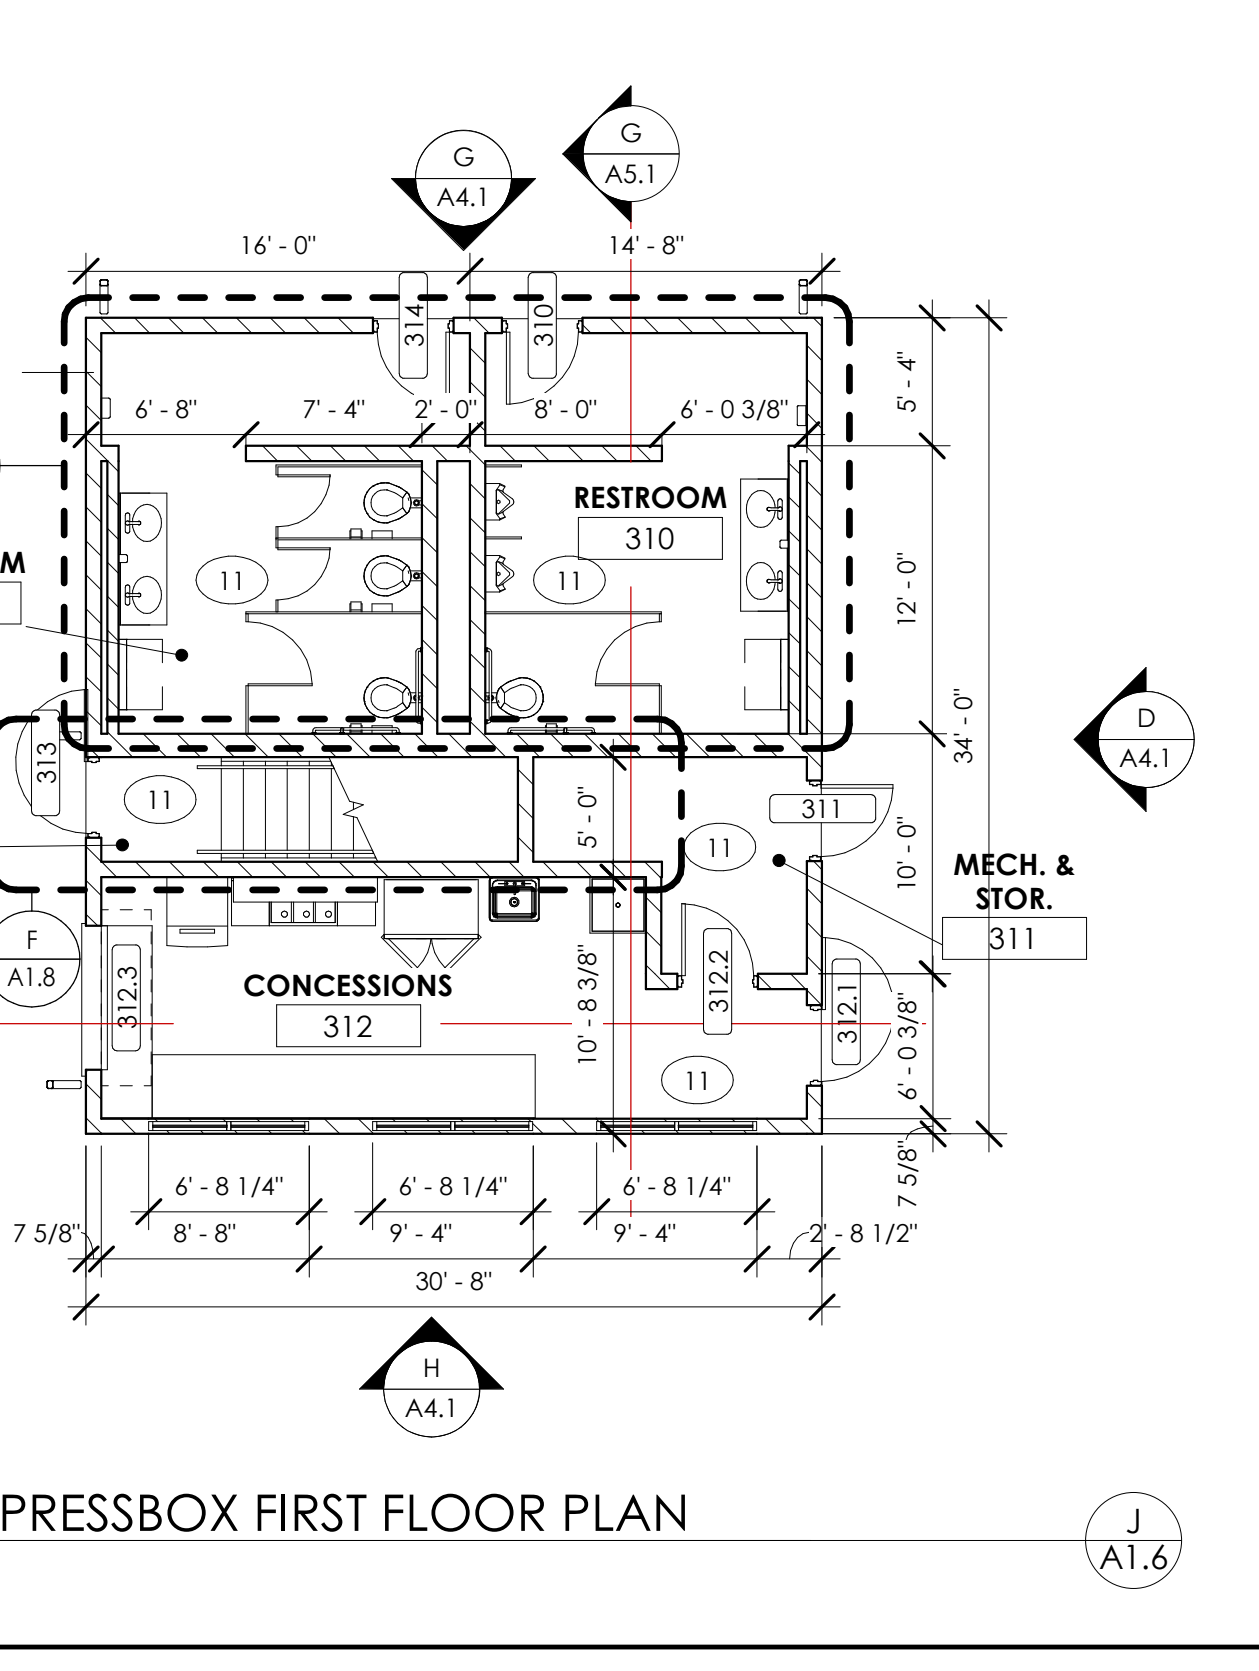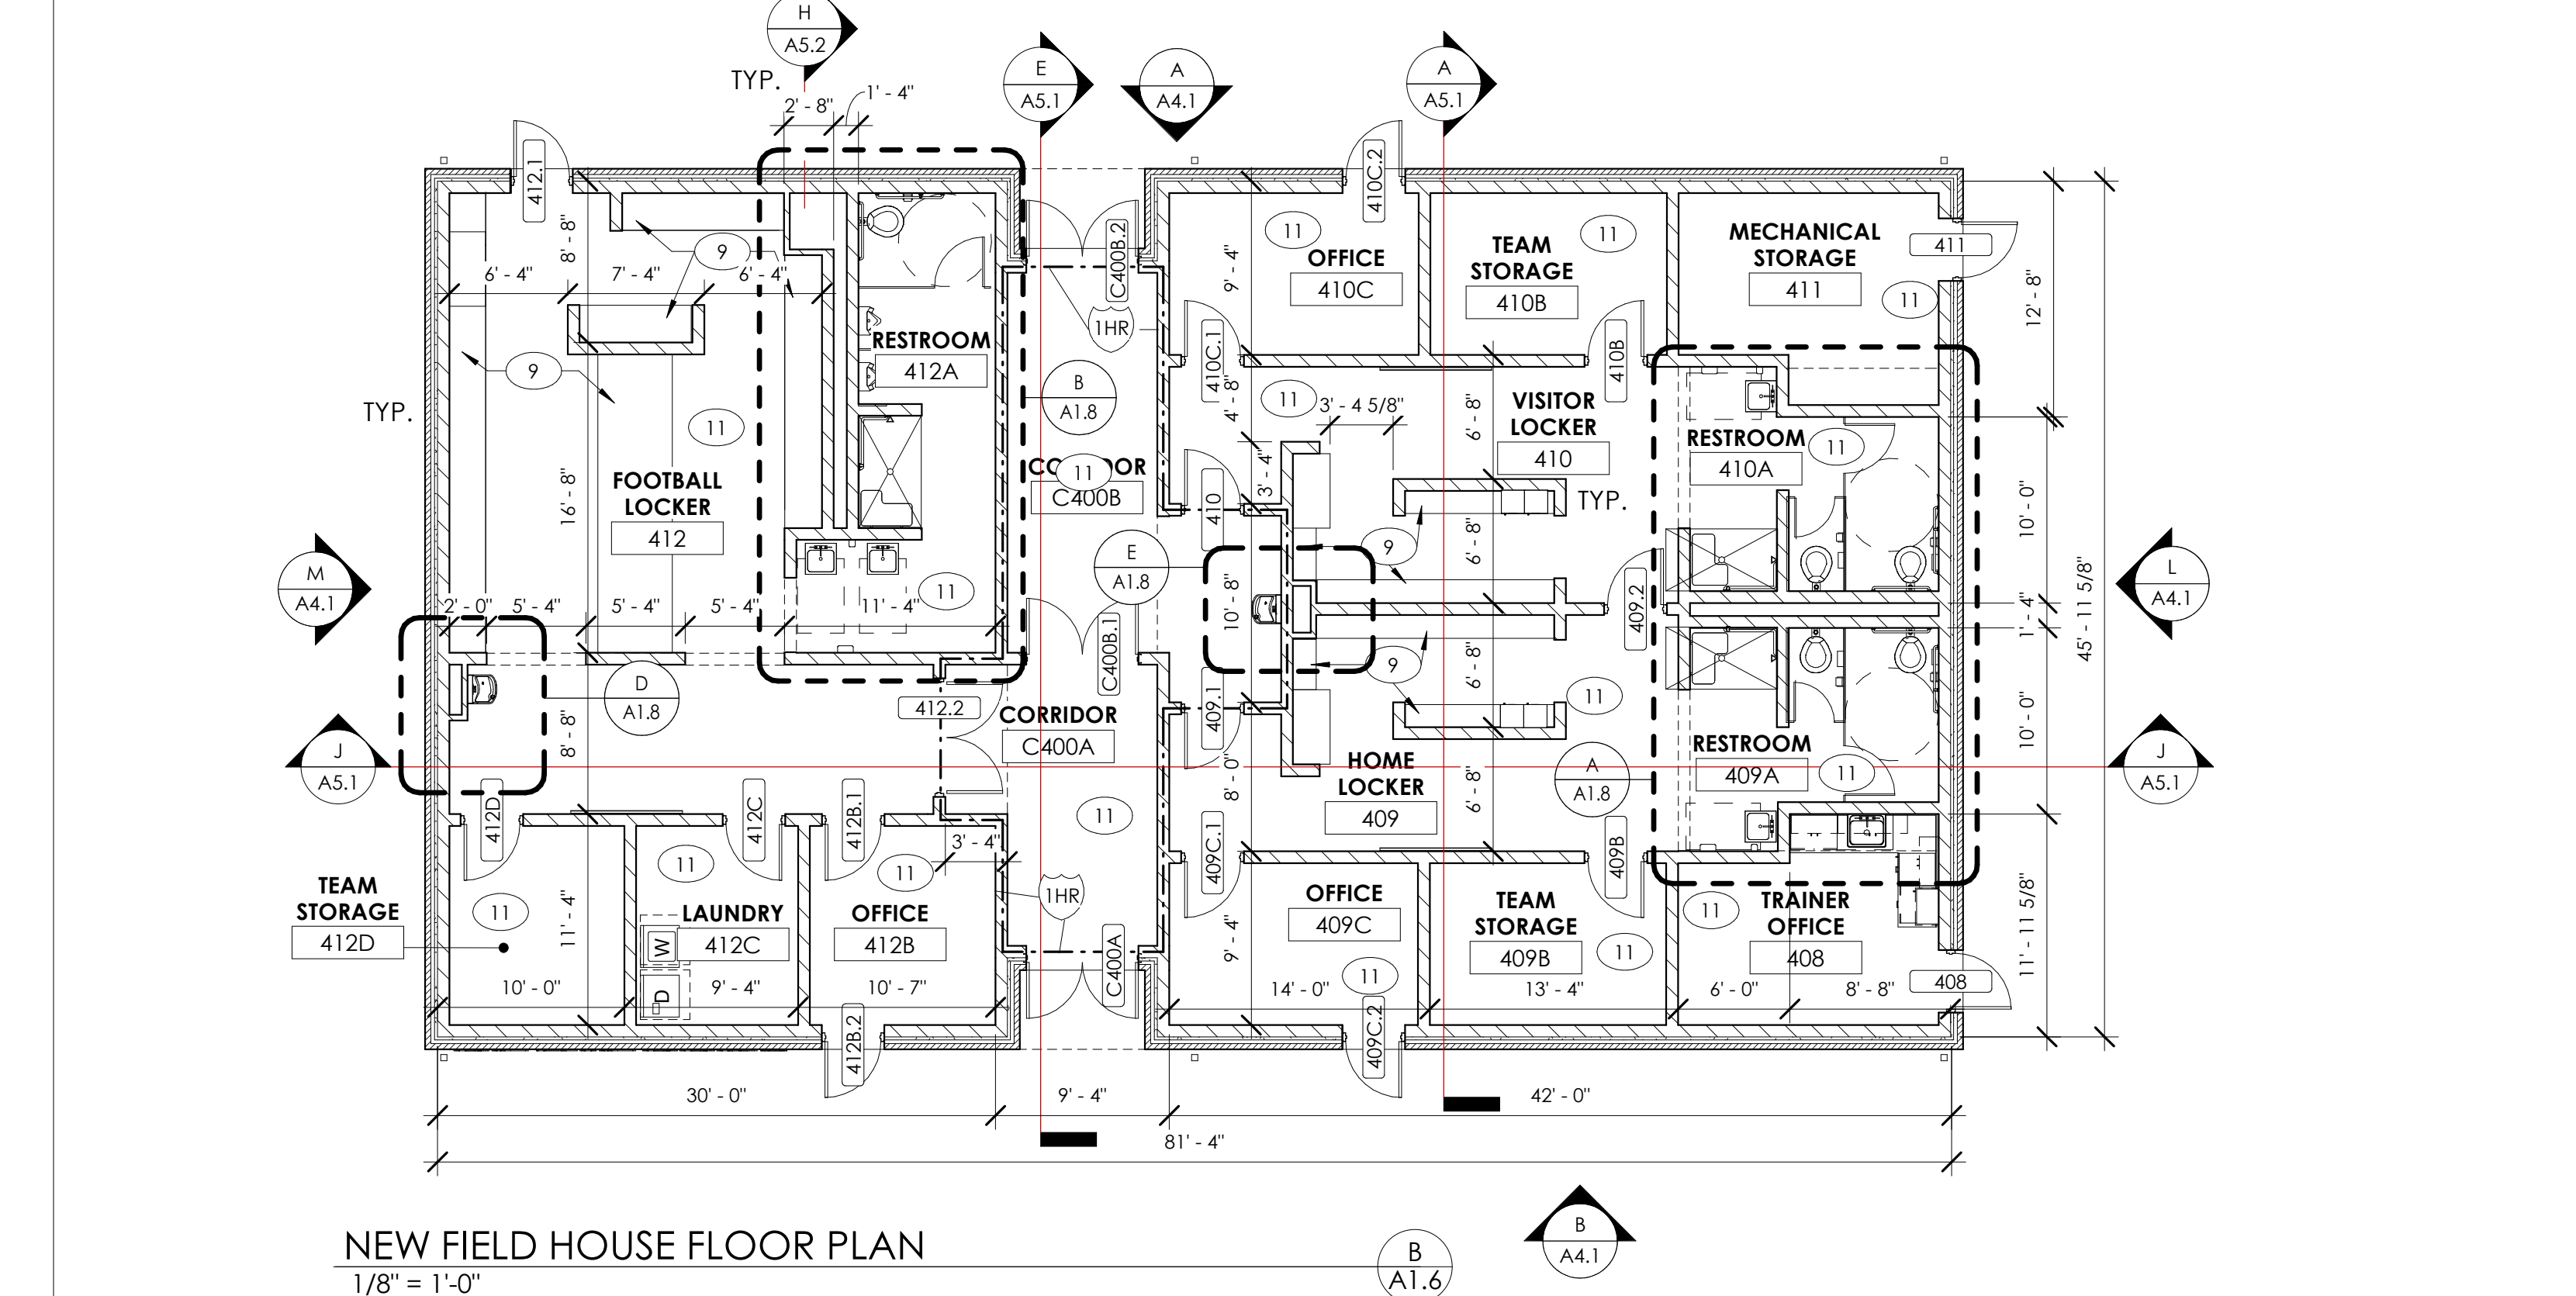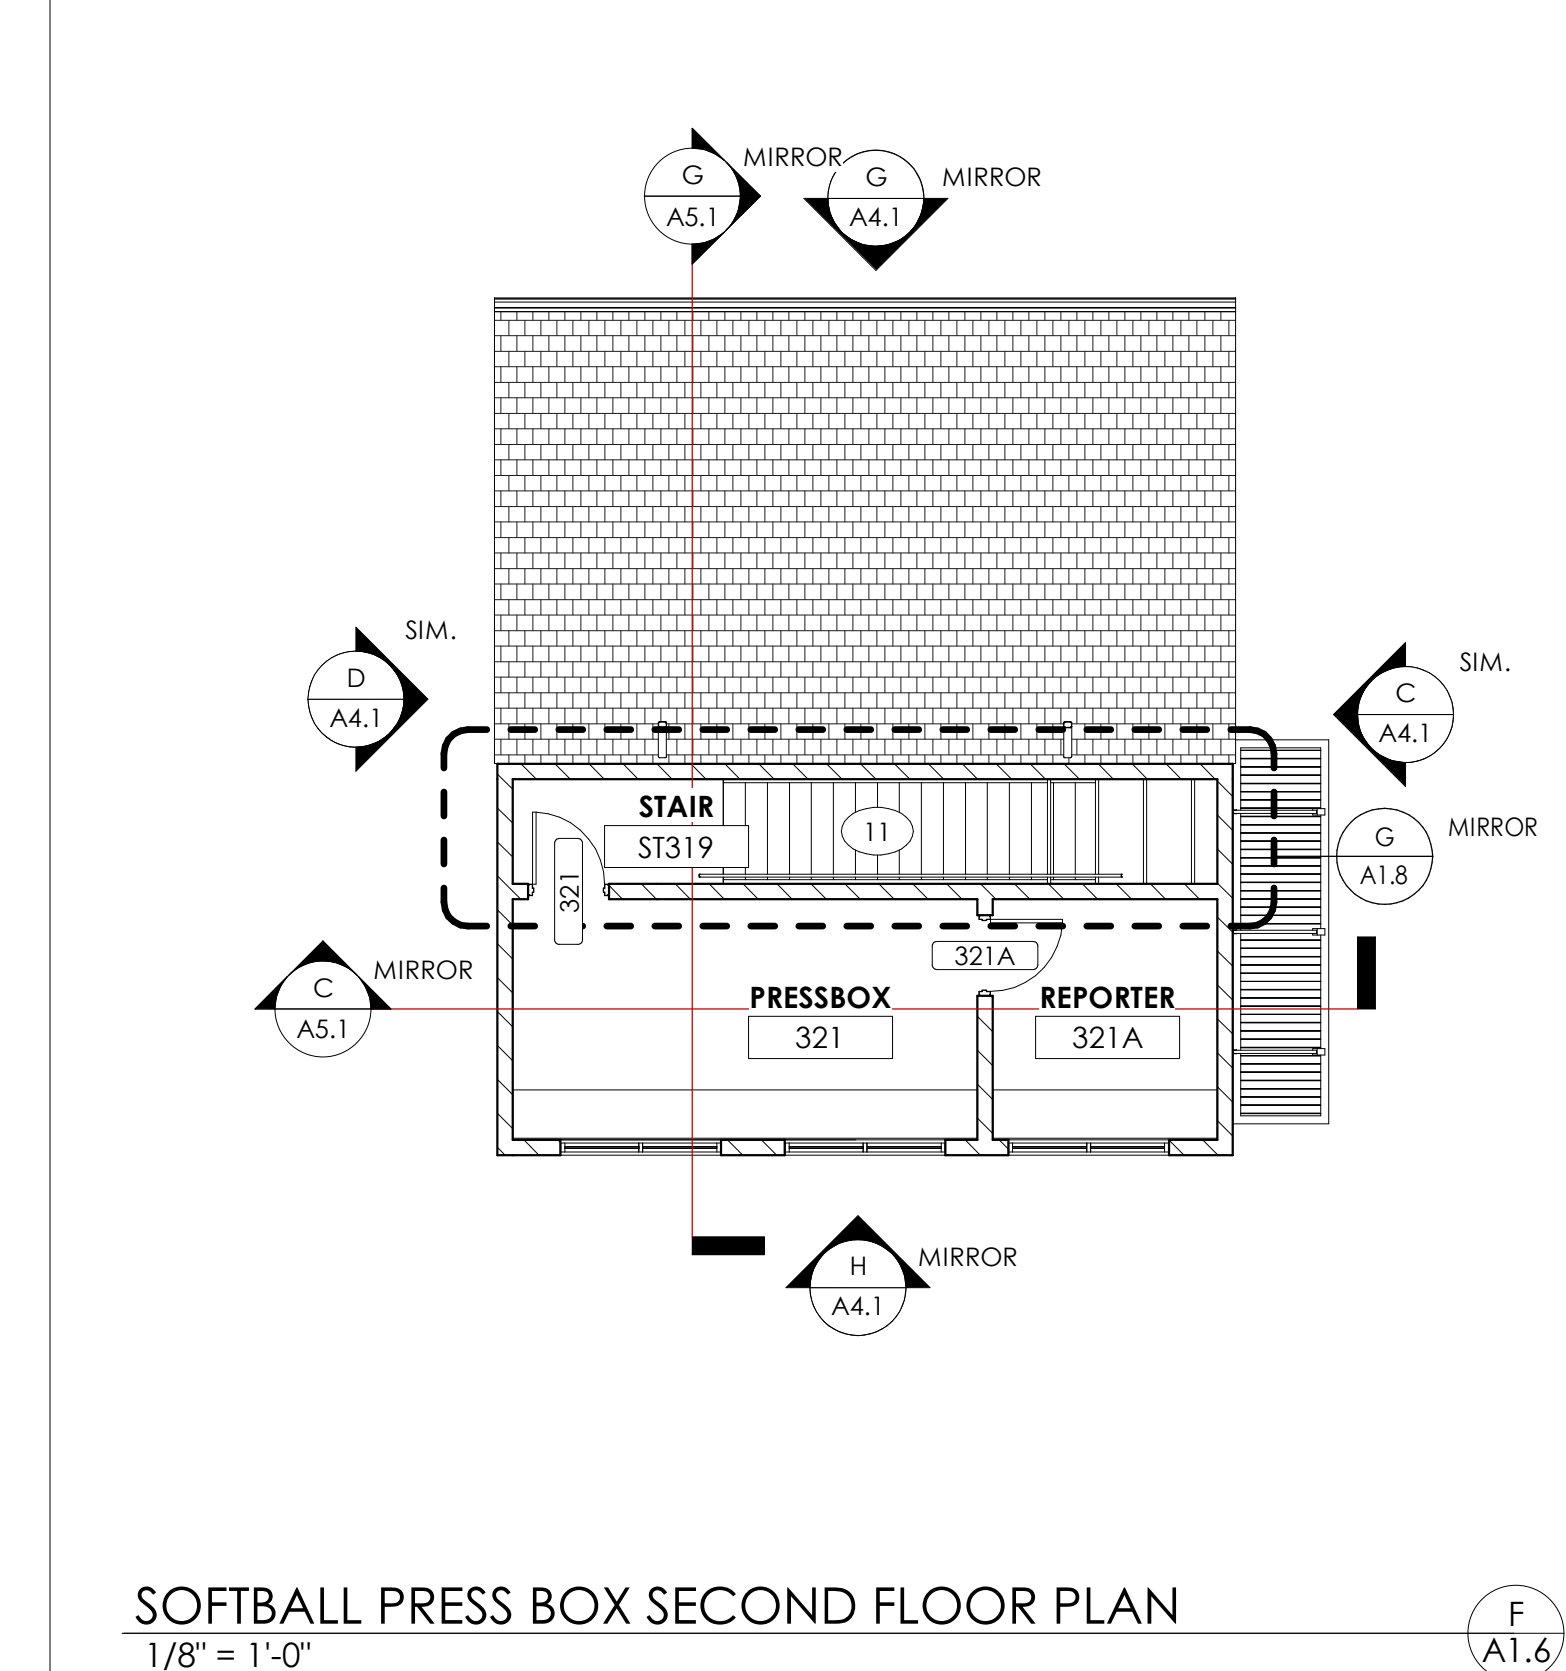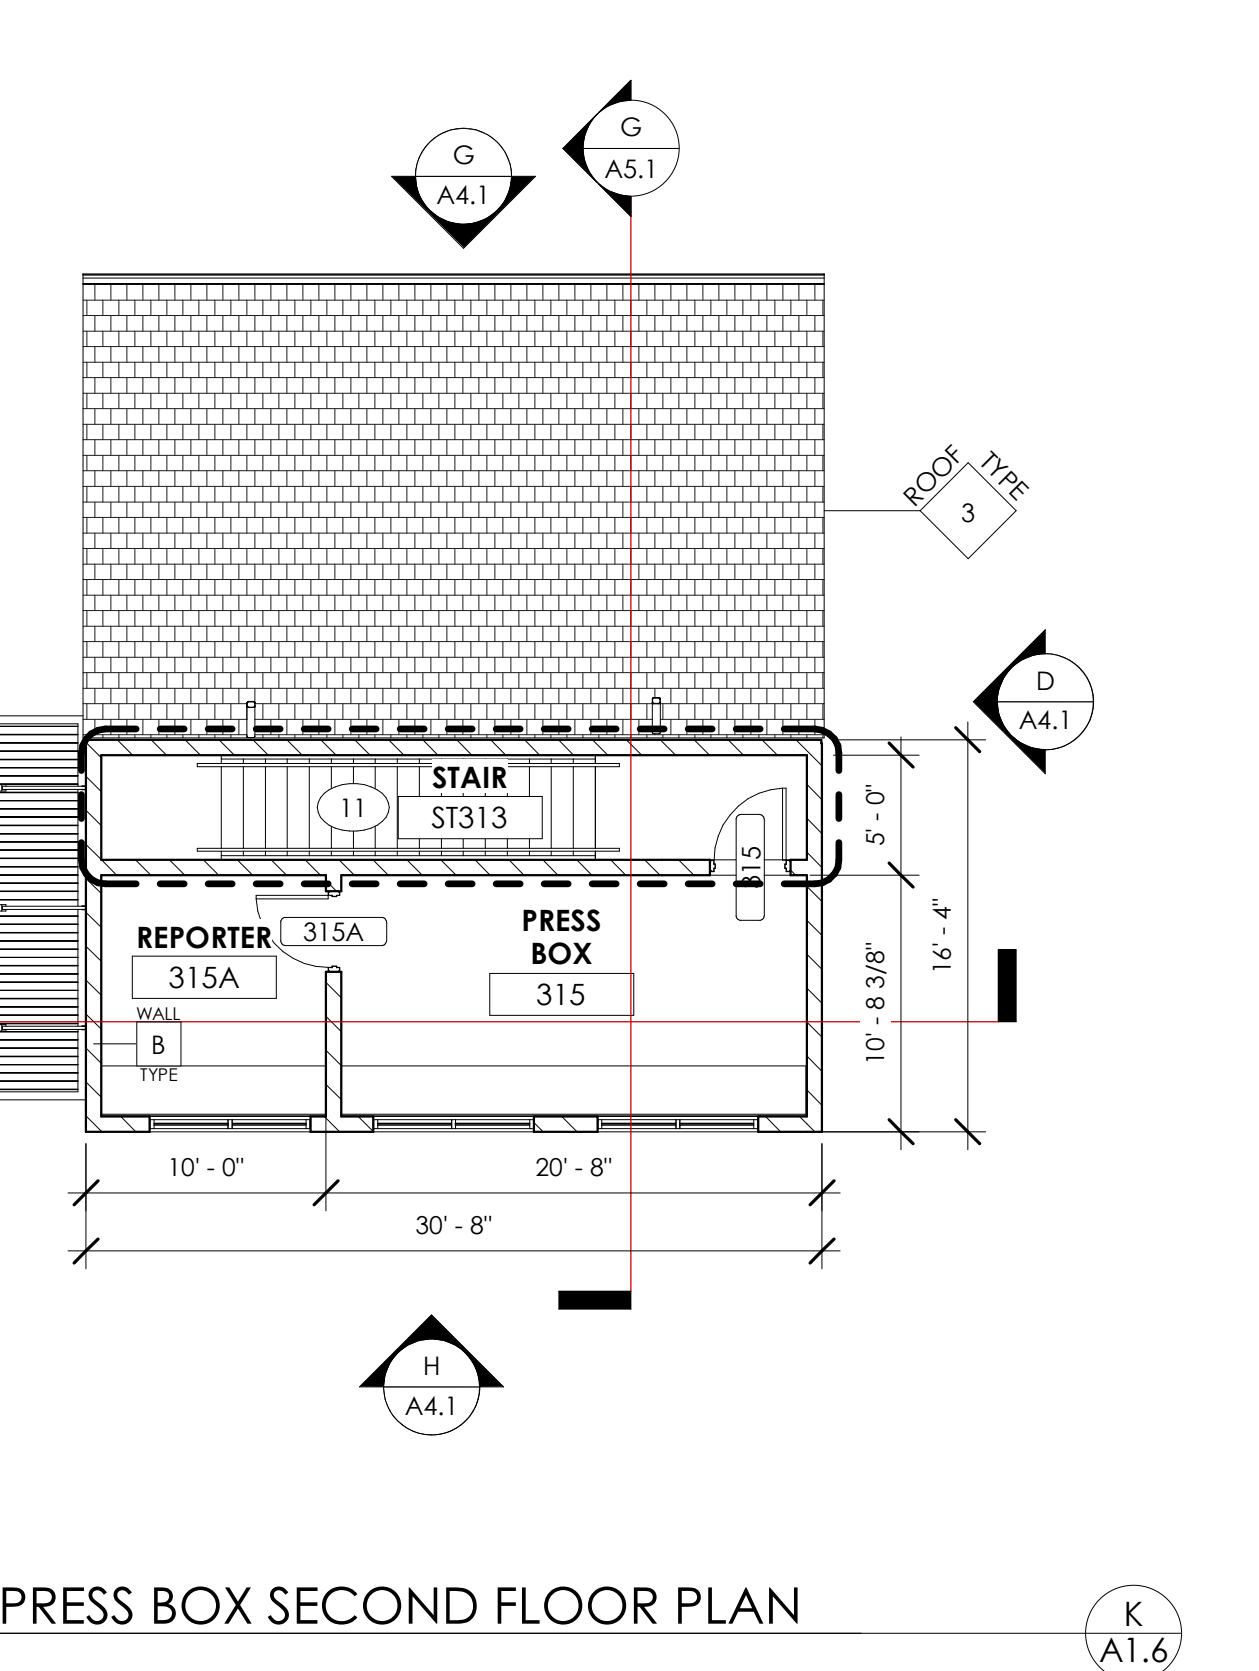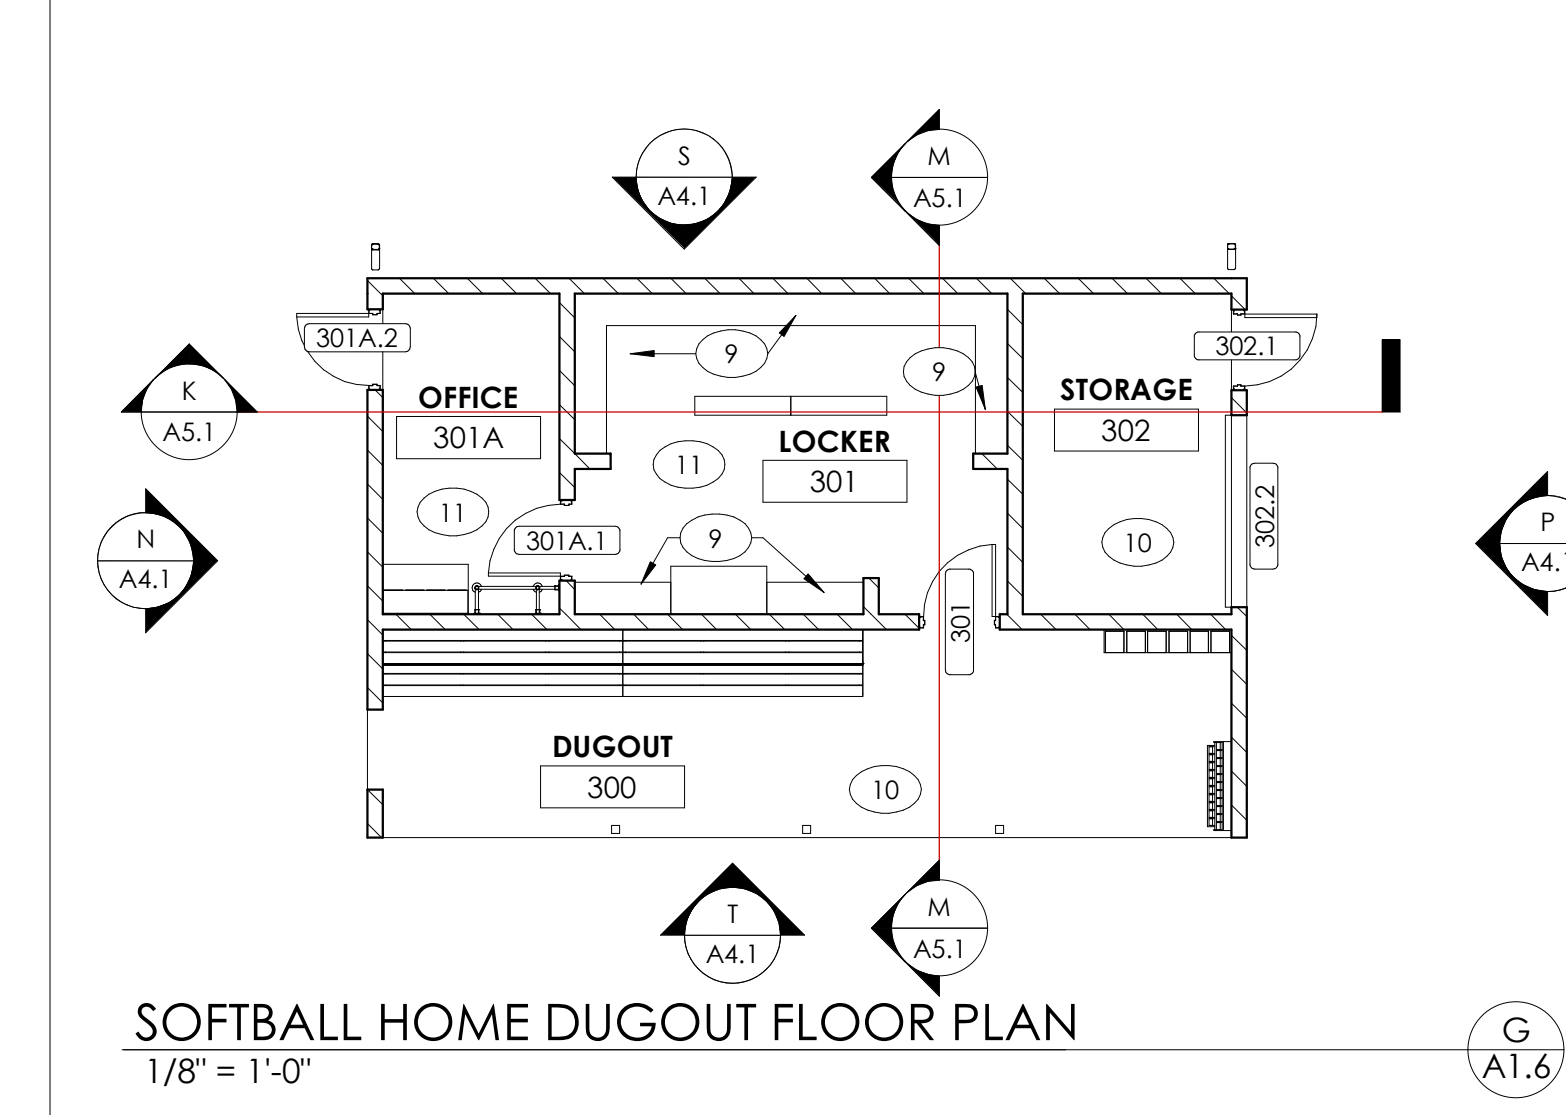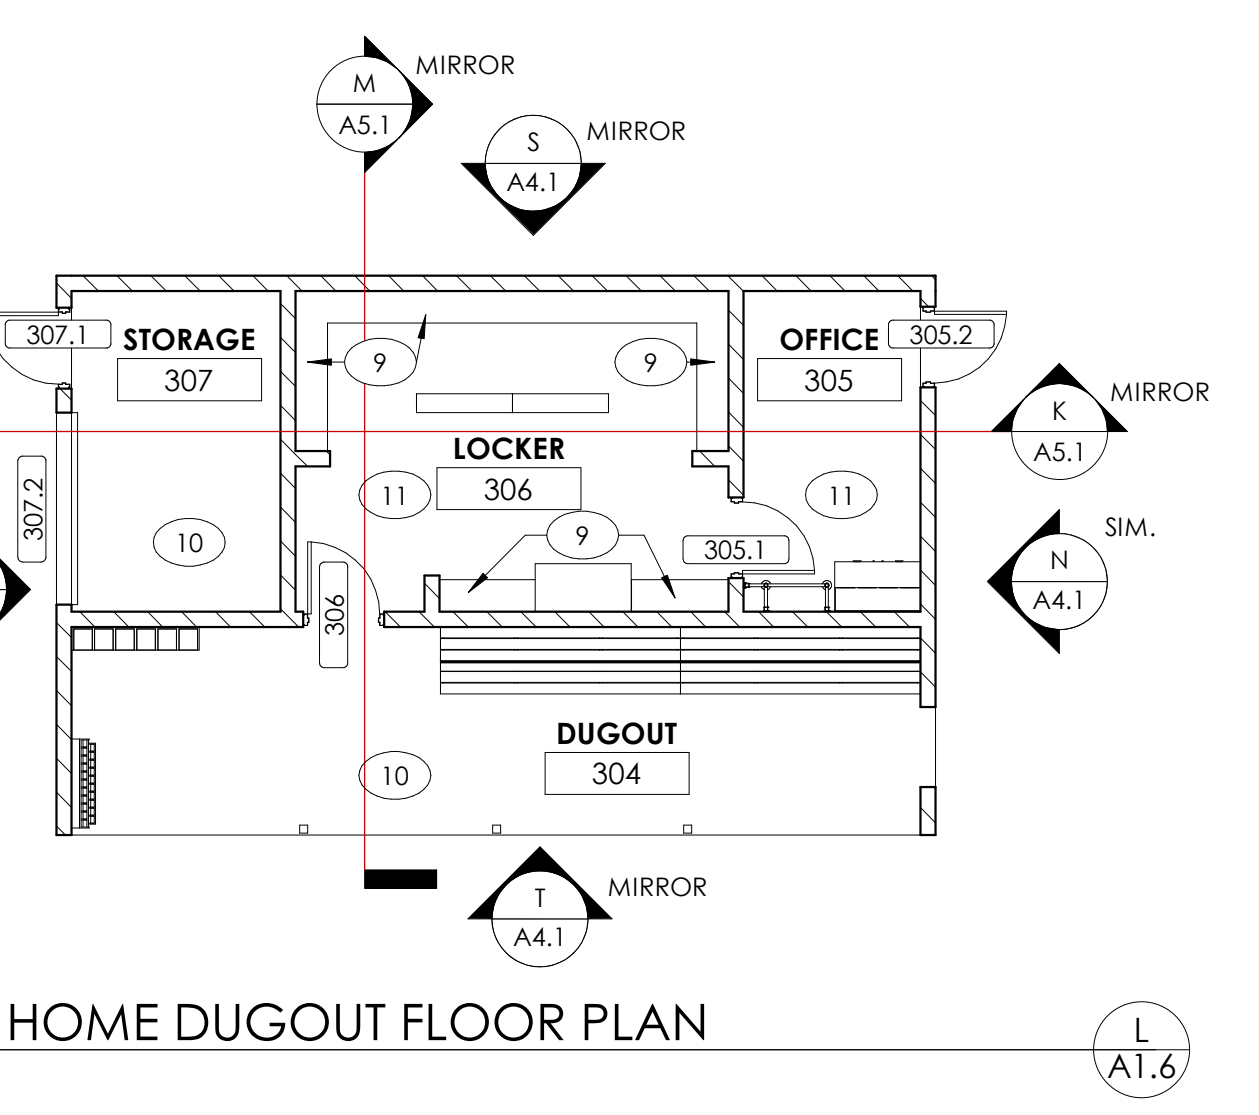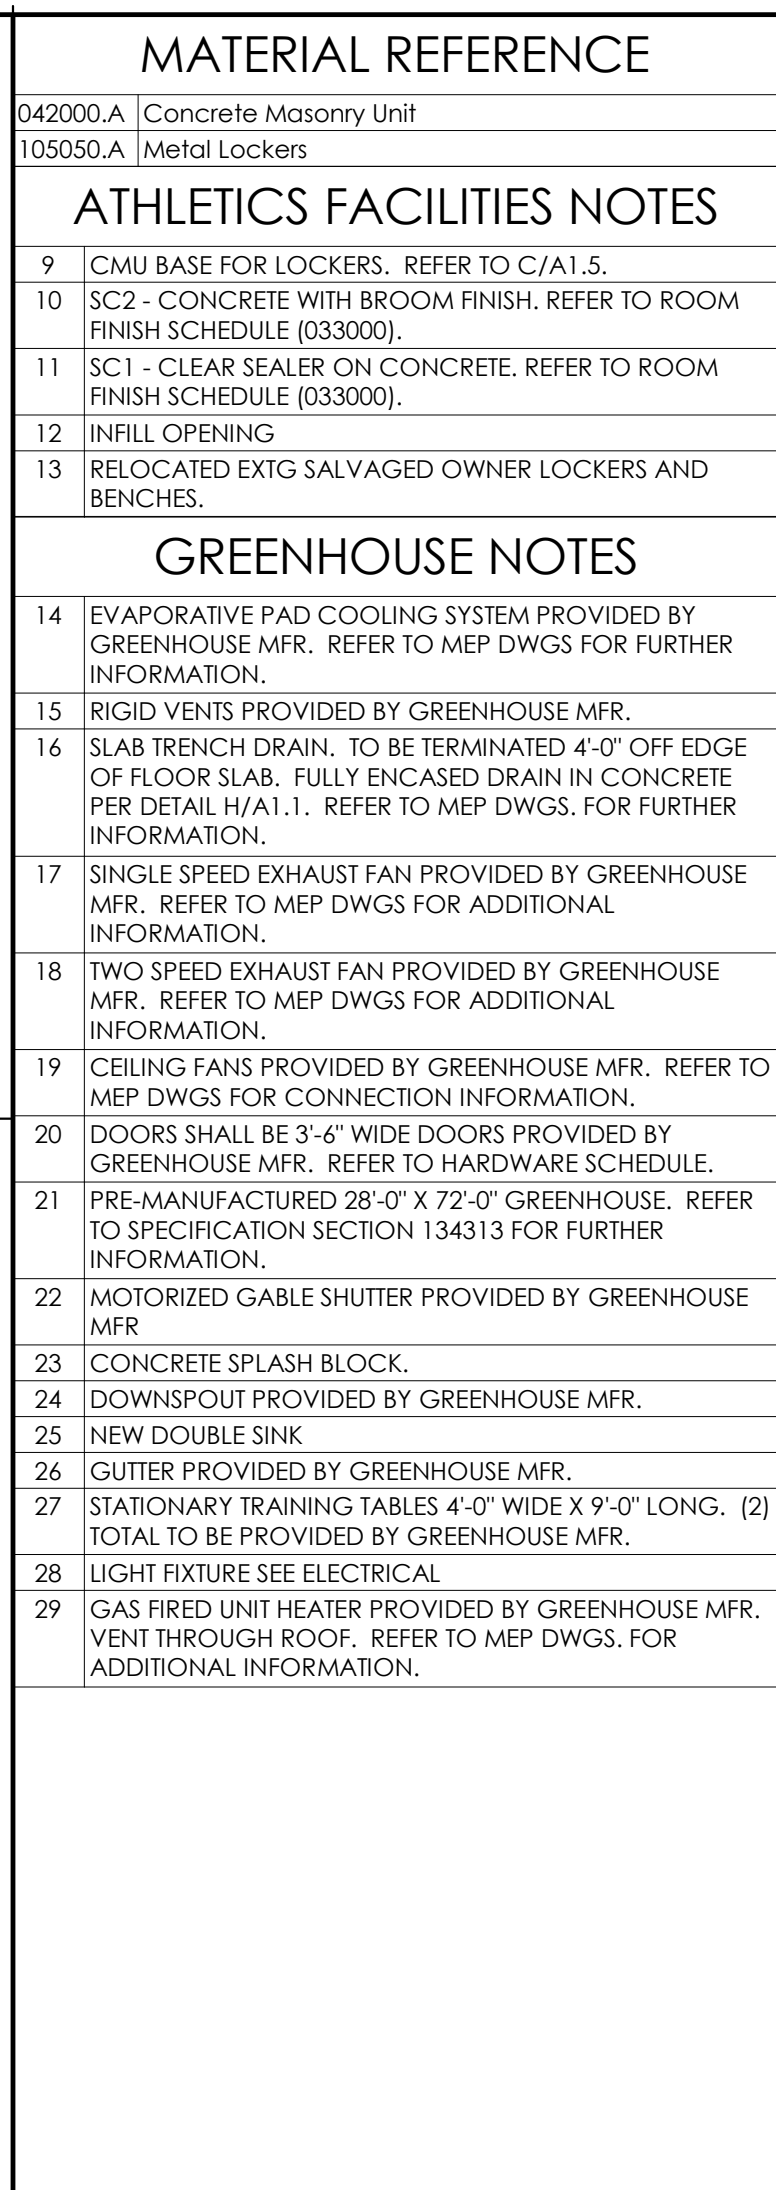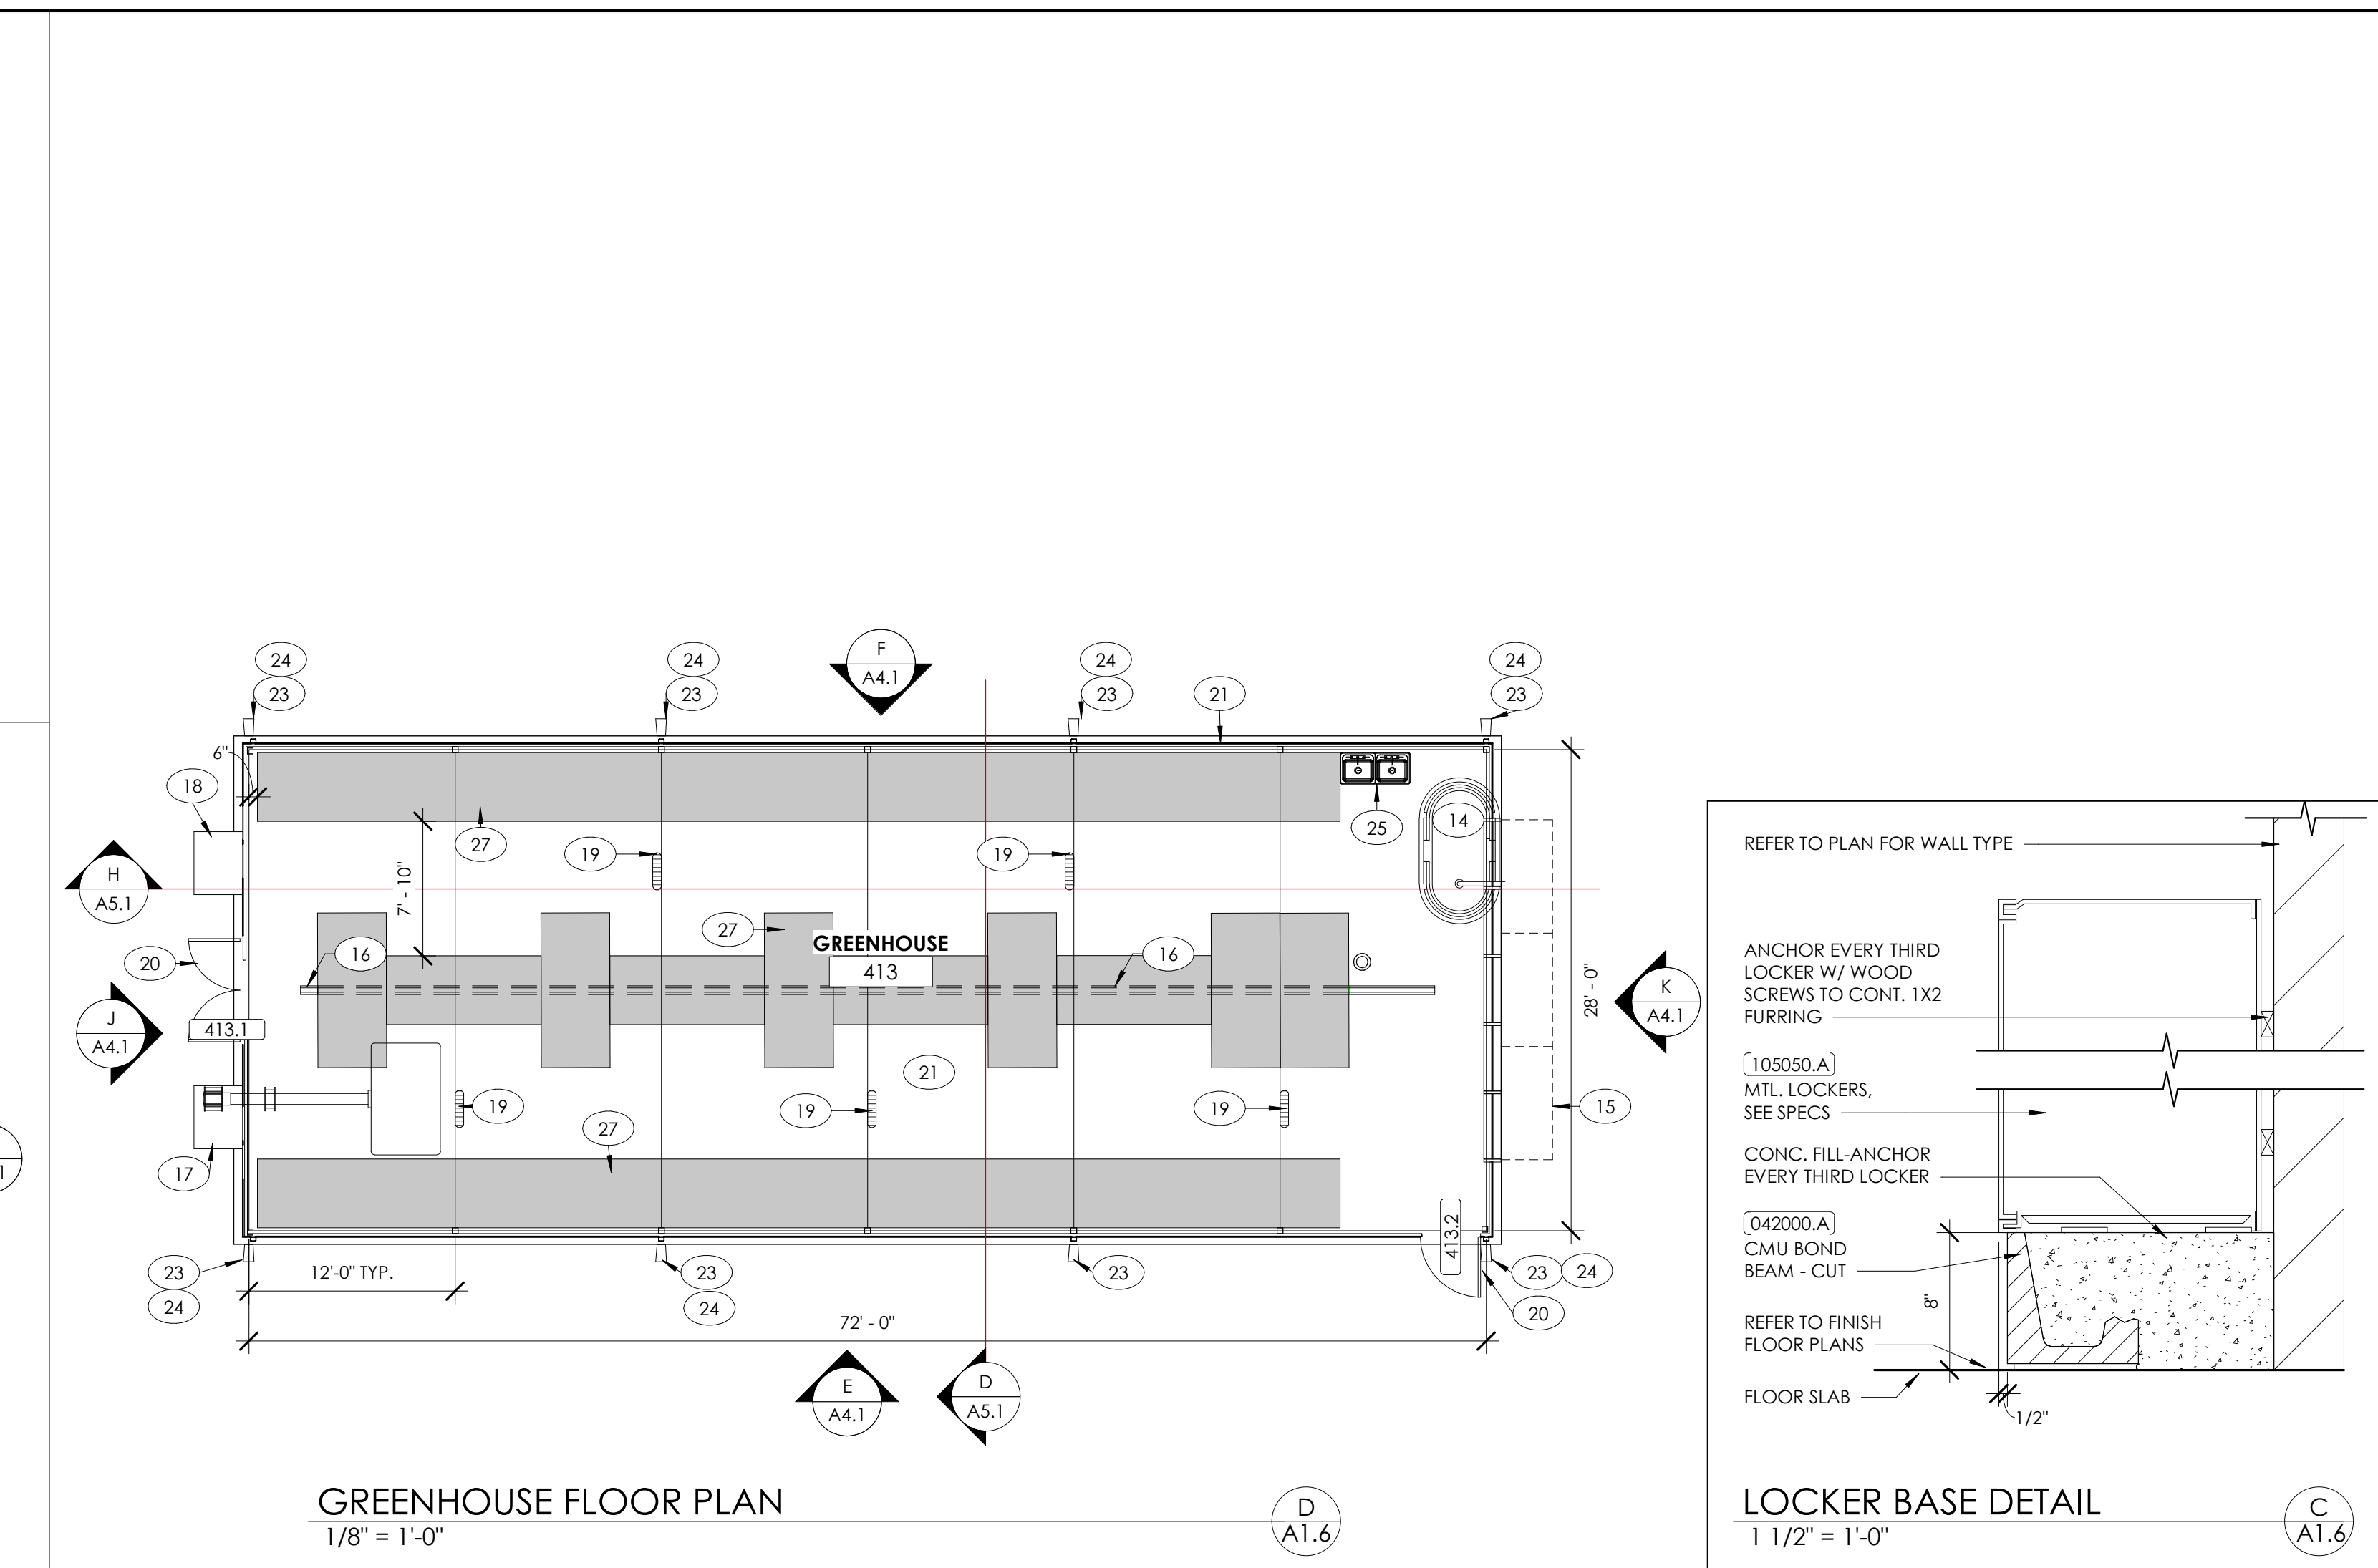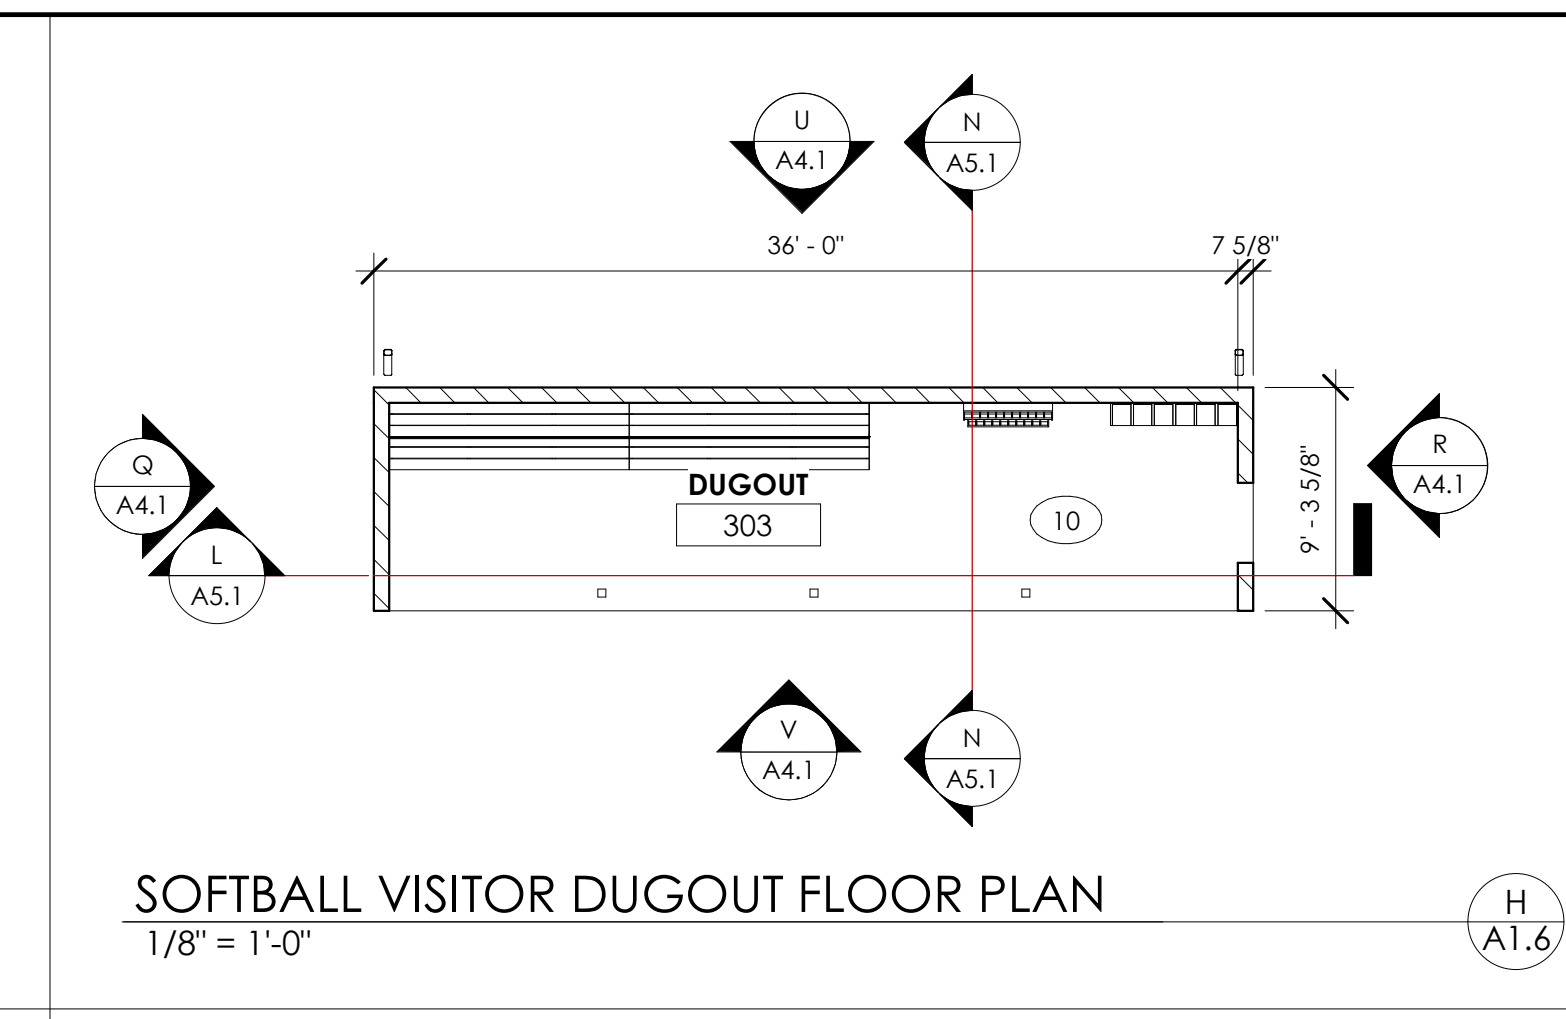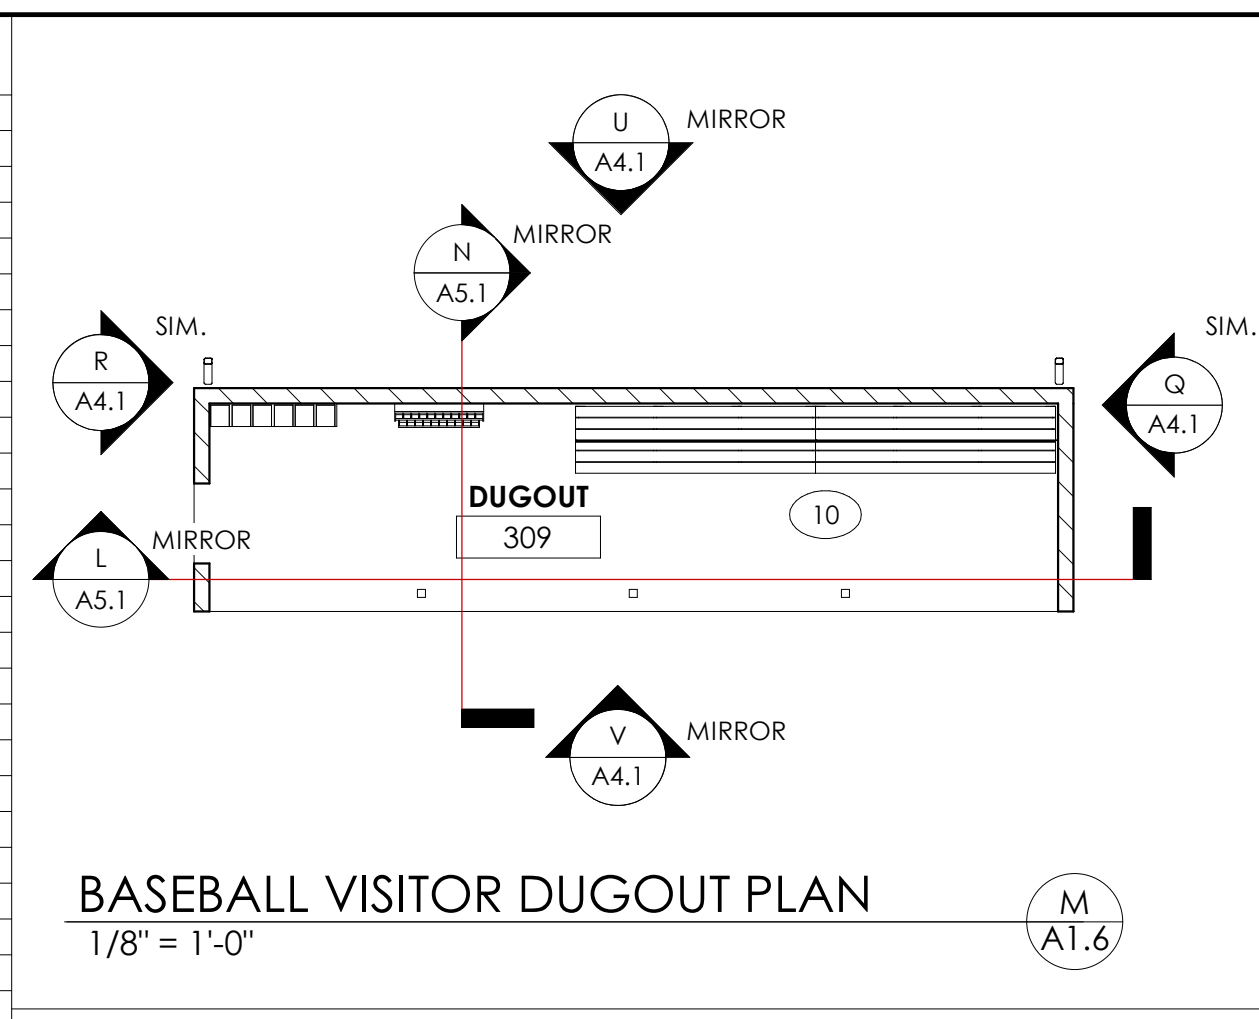SITE DEVELOPMENT
AND LAYOUT PLAN
DATE ISSUED:
JANUARY 28, 2021


[illegible]

 101 old layette avenue leeington, kentucky 40502 p 859.254.4018		NOT FOR CONSTRUCTION	
FIRST FLOOR PLAN - ATHLETICS FACILITIES		ESTILL COUNTY HIGH SCHOOL PHASE 7 RENOVATIONS	
FOR:		ESTILL COUNTY SCHOOLS IRVINE, KENTUCKY	
M.E & P Engineer: Stagg & Fisher 3344 Leachness Dr Lexington, KY 40517 p 859.271.3246 Structural Engineer: Structural Design Group, Inc. 220 Great Circle Rd., Suite 106 Nashville, TN 37228 p 615.255.5537			
BG#		21-055	
Project No: 2025 Drawn By: JR / KM Rev'd by: PF			
SHEET RELEASE			
1			
2			
3			
4			
5			
6			
7			
8			
COPYRIGHT © 2020			
CONSTRUCTION DOCUMENTS			
A1.6			
FIRST FLOOR PLAN - ATHLETICS FACILITIES			
DATE ISSUED: FEBRUARY 2021			

092116A

TICKET BOOTH
414

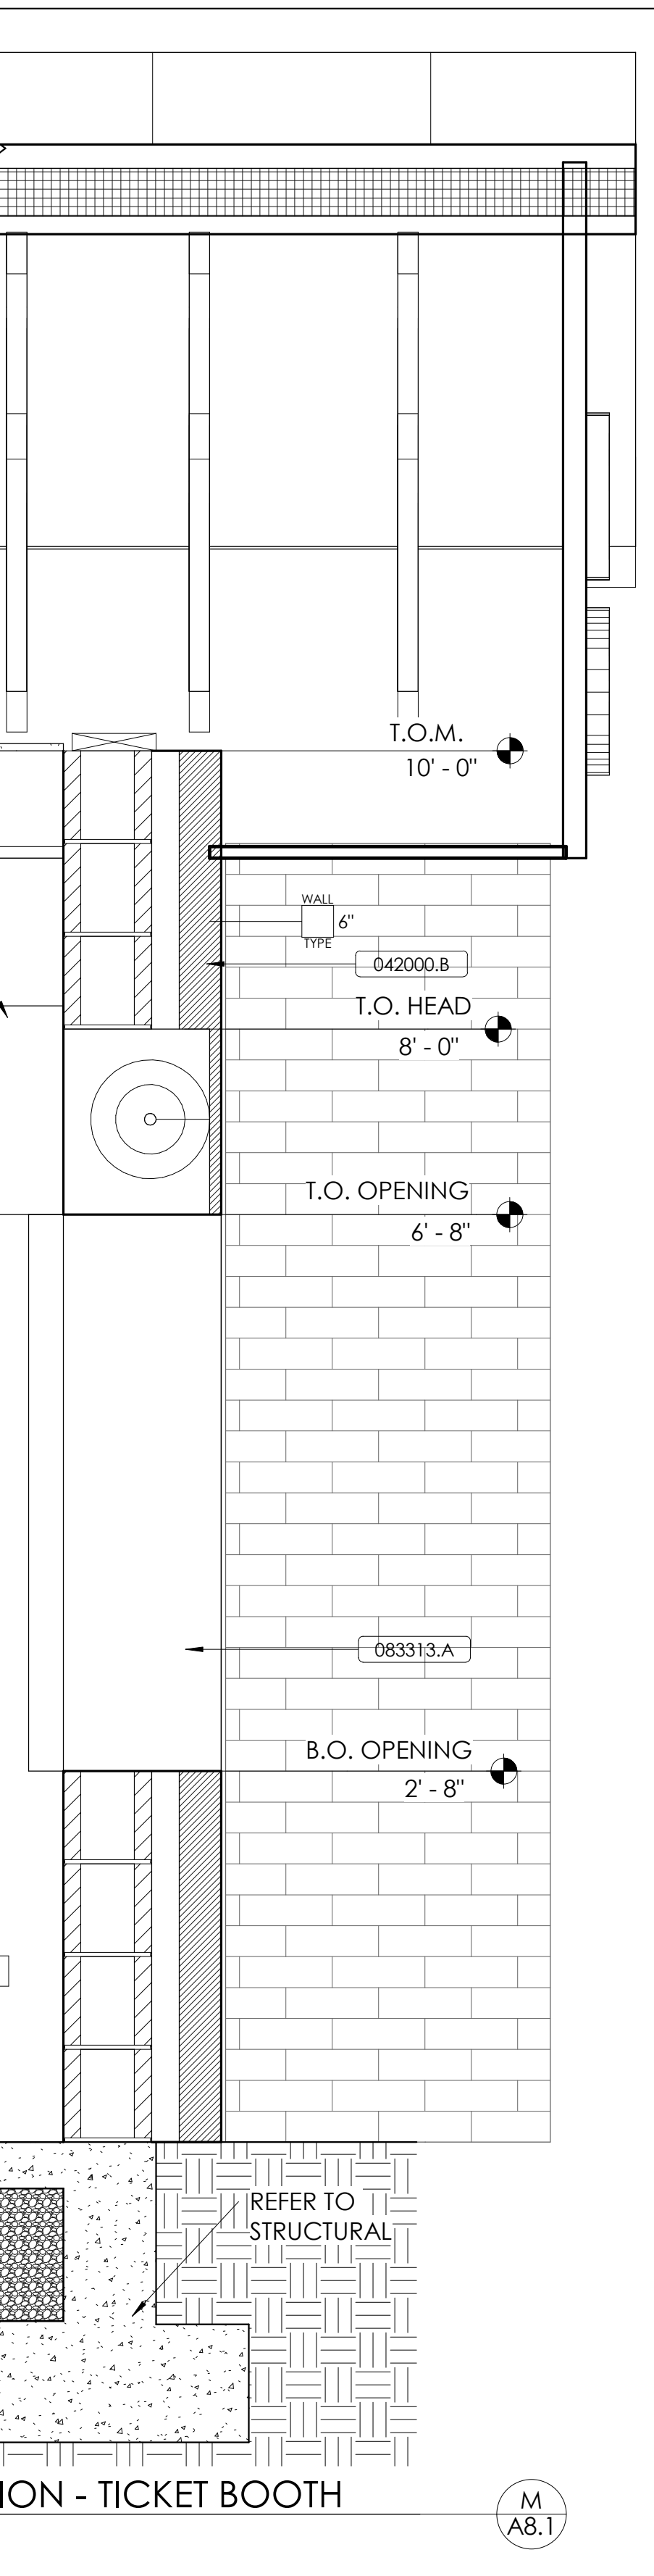WALL SECTION
1" = 1'-0"



073113.D

073113.G
WALL PANELS

B.O. PANEL
9' - 3"

077123.A
061000.A
077123.B

REFER TO SITE DWGS.
FOR FENCE AND
GATE INFO.

042000.B

FF 0"

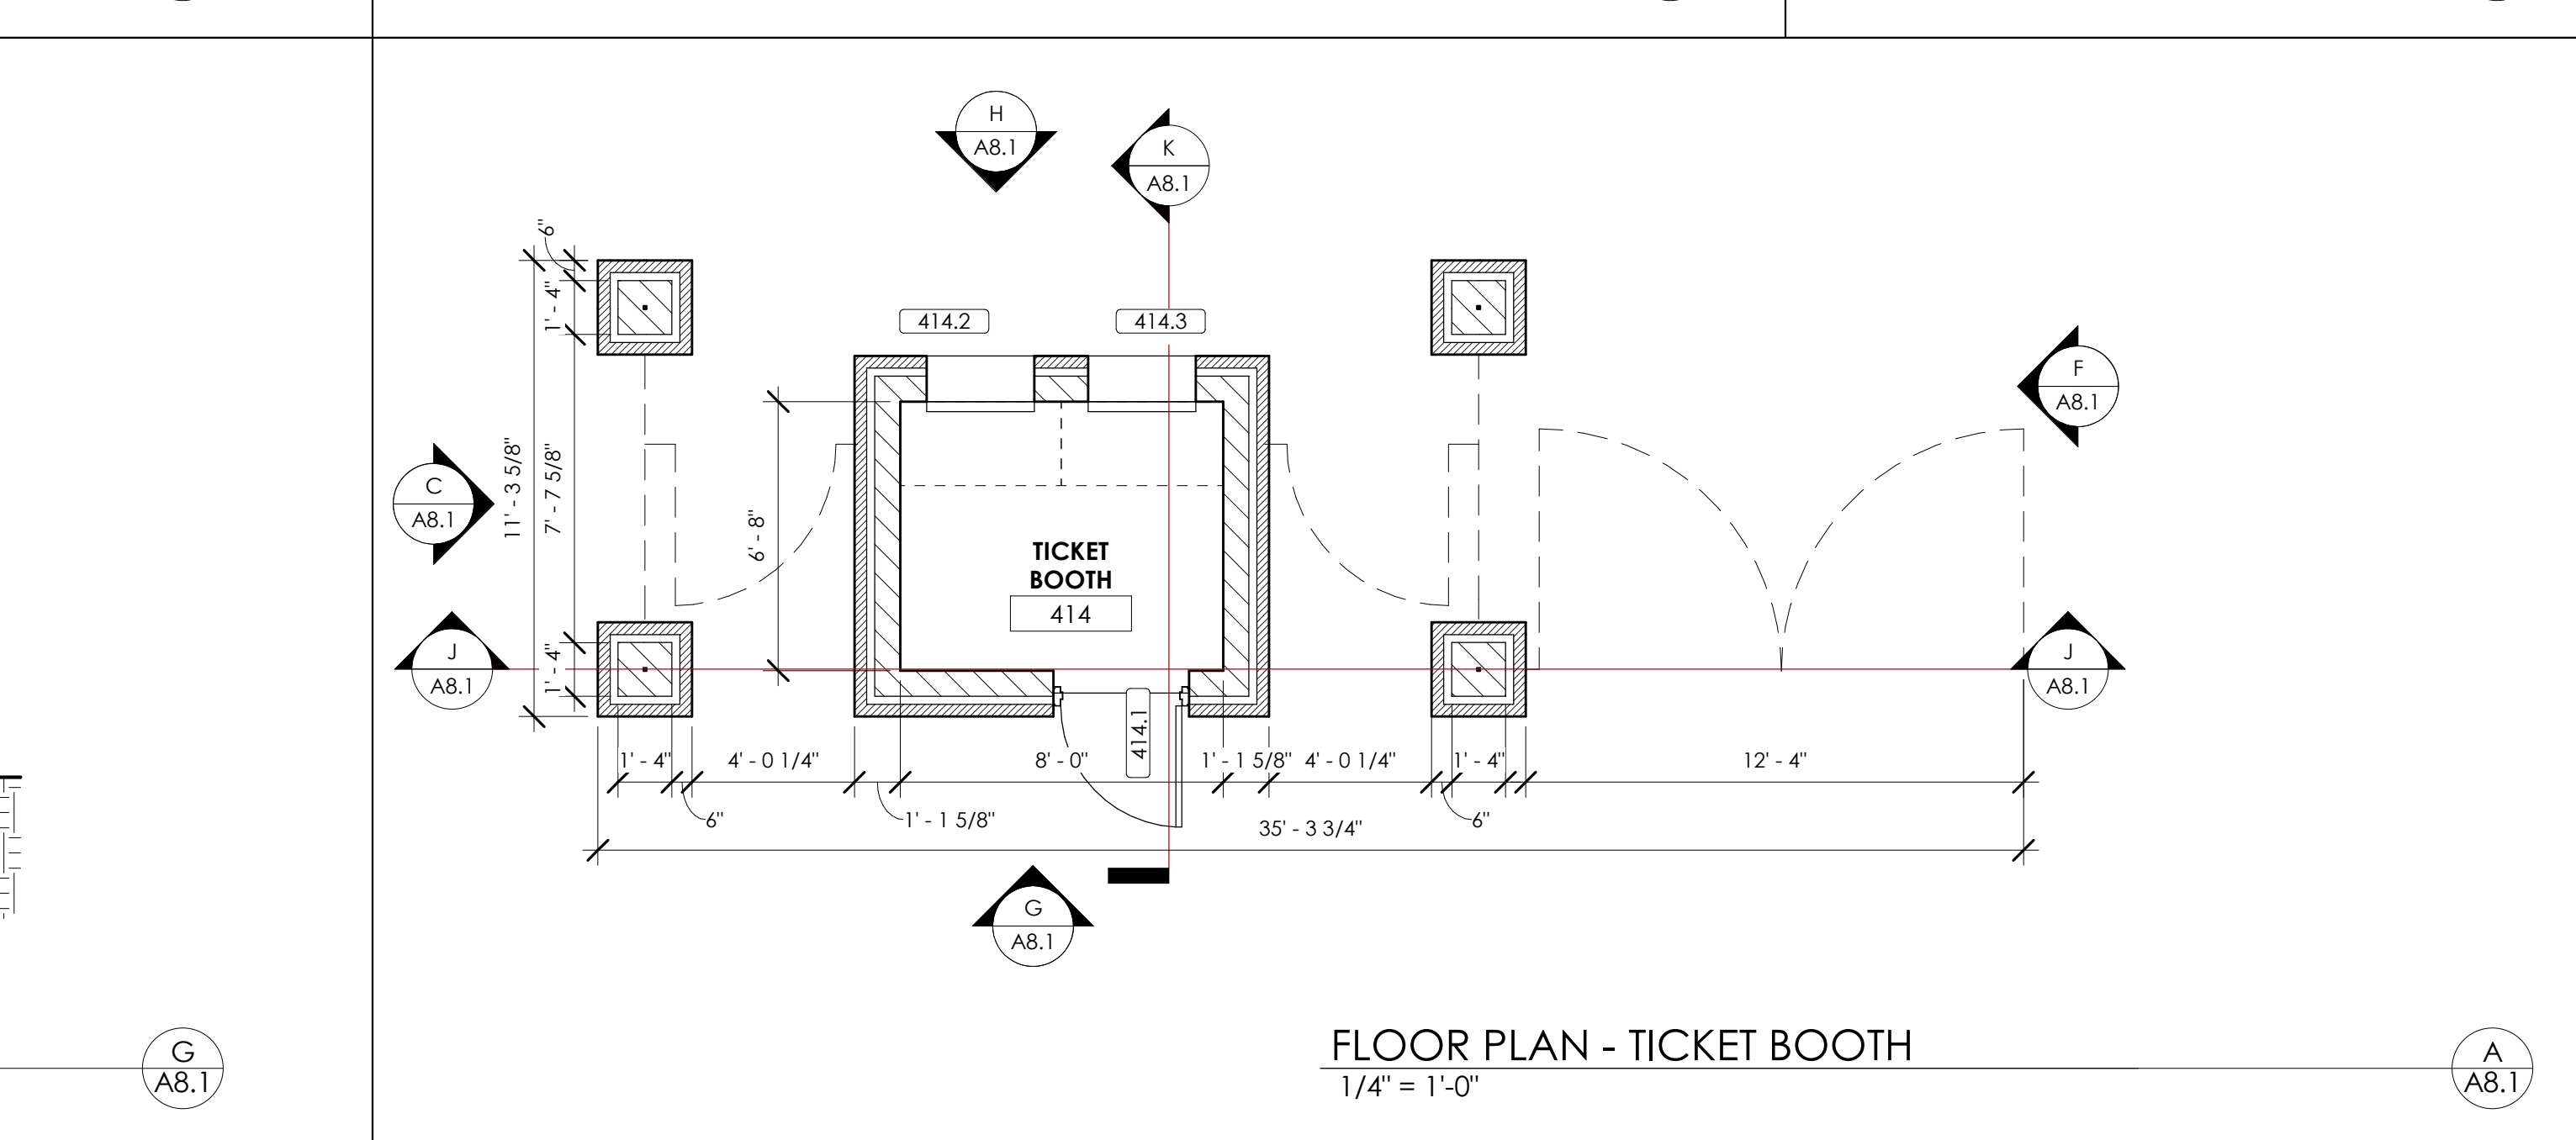
4 1/2"

REFER TO STRUCTURAL DWGS.
FOR FOUNDATION INFO.

NOTE: COORDINATE DOWNSPOUT
LOCATIONS WITH SITE DWGS.

ROOF TYPE
1

NORTH ELEVATION - TICKET BOOTH
1/4" = 1'-0"

[illegible]

 rosstarrant architects 101 old clayette avenue lexington, kentucky 40502 p 859.254.4018		NOT FOR CONSTRUCTION	
ALTERNATE #6-TICKET BOOTH		ESTILL COUNTY HIGH SCHOOL PHASE 7 RENOVATIONS	
FOR:		ESTILL COUNTY SCHOOLS IRVINE, KENTUCKY	
M.E.&P Engineer: Stogatz & Fisher 3054 Lochness Dr. Lexington, KY 40517 p 859.271.3246		Structural Engineer: Structural Design Group, Inc. 220 Great Circle Rd., Suite 106 Nashville, TN 37228 p 615.255.5537	
BG#		21-055	
Project No: 2025		Drawn By: JR / KM	
Rev'd By: PF		SHEET RELEASE	
1			
2			
3			
4			
5			
6			
7			
8			
COPYRIGHT © 2020			
CONSTRUCTION DOCUMENTS			
A8.1			
ALTERNATE #6-TICKET BOOTH			
DATE ISSUED: FEBRUARY 2021			