

UPPER LEVEL HVAC SCOPE

MARCUM
ENGINEERING, LLC

500 SOUTH 17TH STREET,
PADUCH, KENTUCKY 40062
PHONE: 270.444.9274
WWW.MARCUMENGINEERING.NET
COPYRIGHT © 2021, MARCUM ENGINEERING, LLC

RBS DESIGN GROUP
Architecture

723 Harvard Drive, Owensboro, KY 42301
Phone: 270.647.1800 Fax: 270.648.5446
Email: info@rbsdesigngroup.com

ALL RIGHTS RESERVED.
NO PART OF THIS DOCUMENT SHALL BE REPRODUCED OR TRANSMITTED IN ANY FORM OR BY ANY MEANS, ELECTRONIC OR MECHANICAL, INCLUDING PHOTOCOPYING, RECORDING, OR BY ANY INFORMATION STORAGE AND RETRIEVAL SYSTEM, WITHOUT PERMISSION IN WRITING FROM RBS DESIGN GROUP.


20294	20294
20294	20294

NO.	DATE	CHECKED BY	DATE



DAWSON SPRINGS INDEPENDENT SCHOOLS
DAWSON SPRINGS HIGH SCHOOL
DAWSON SPRINGS, KENTUCKY

SHEET NUMBER

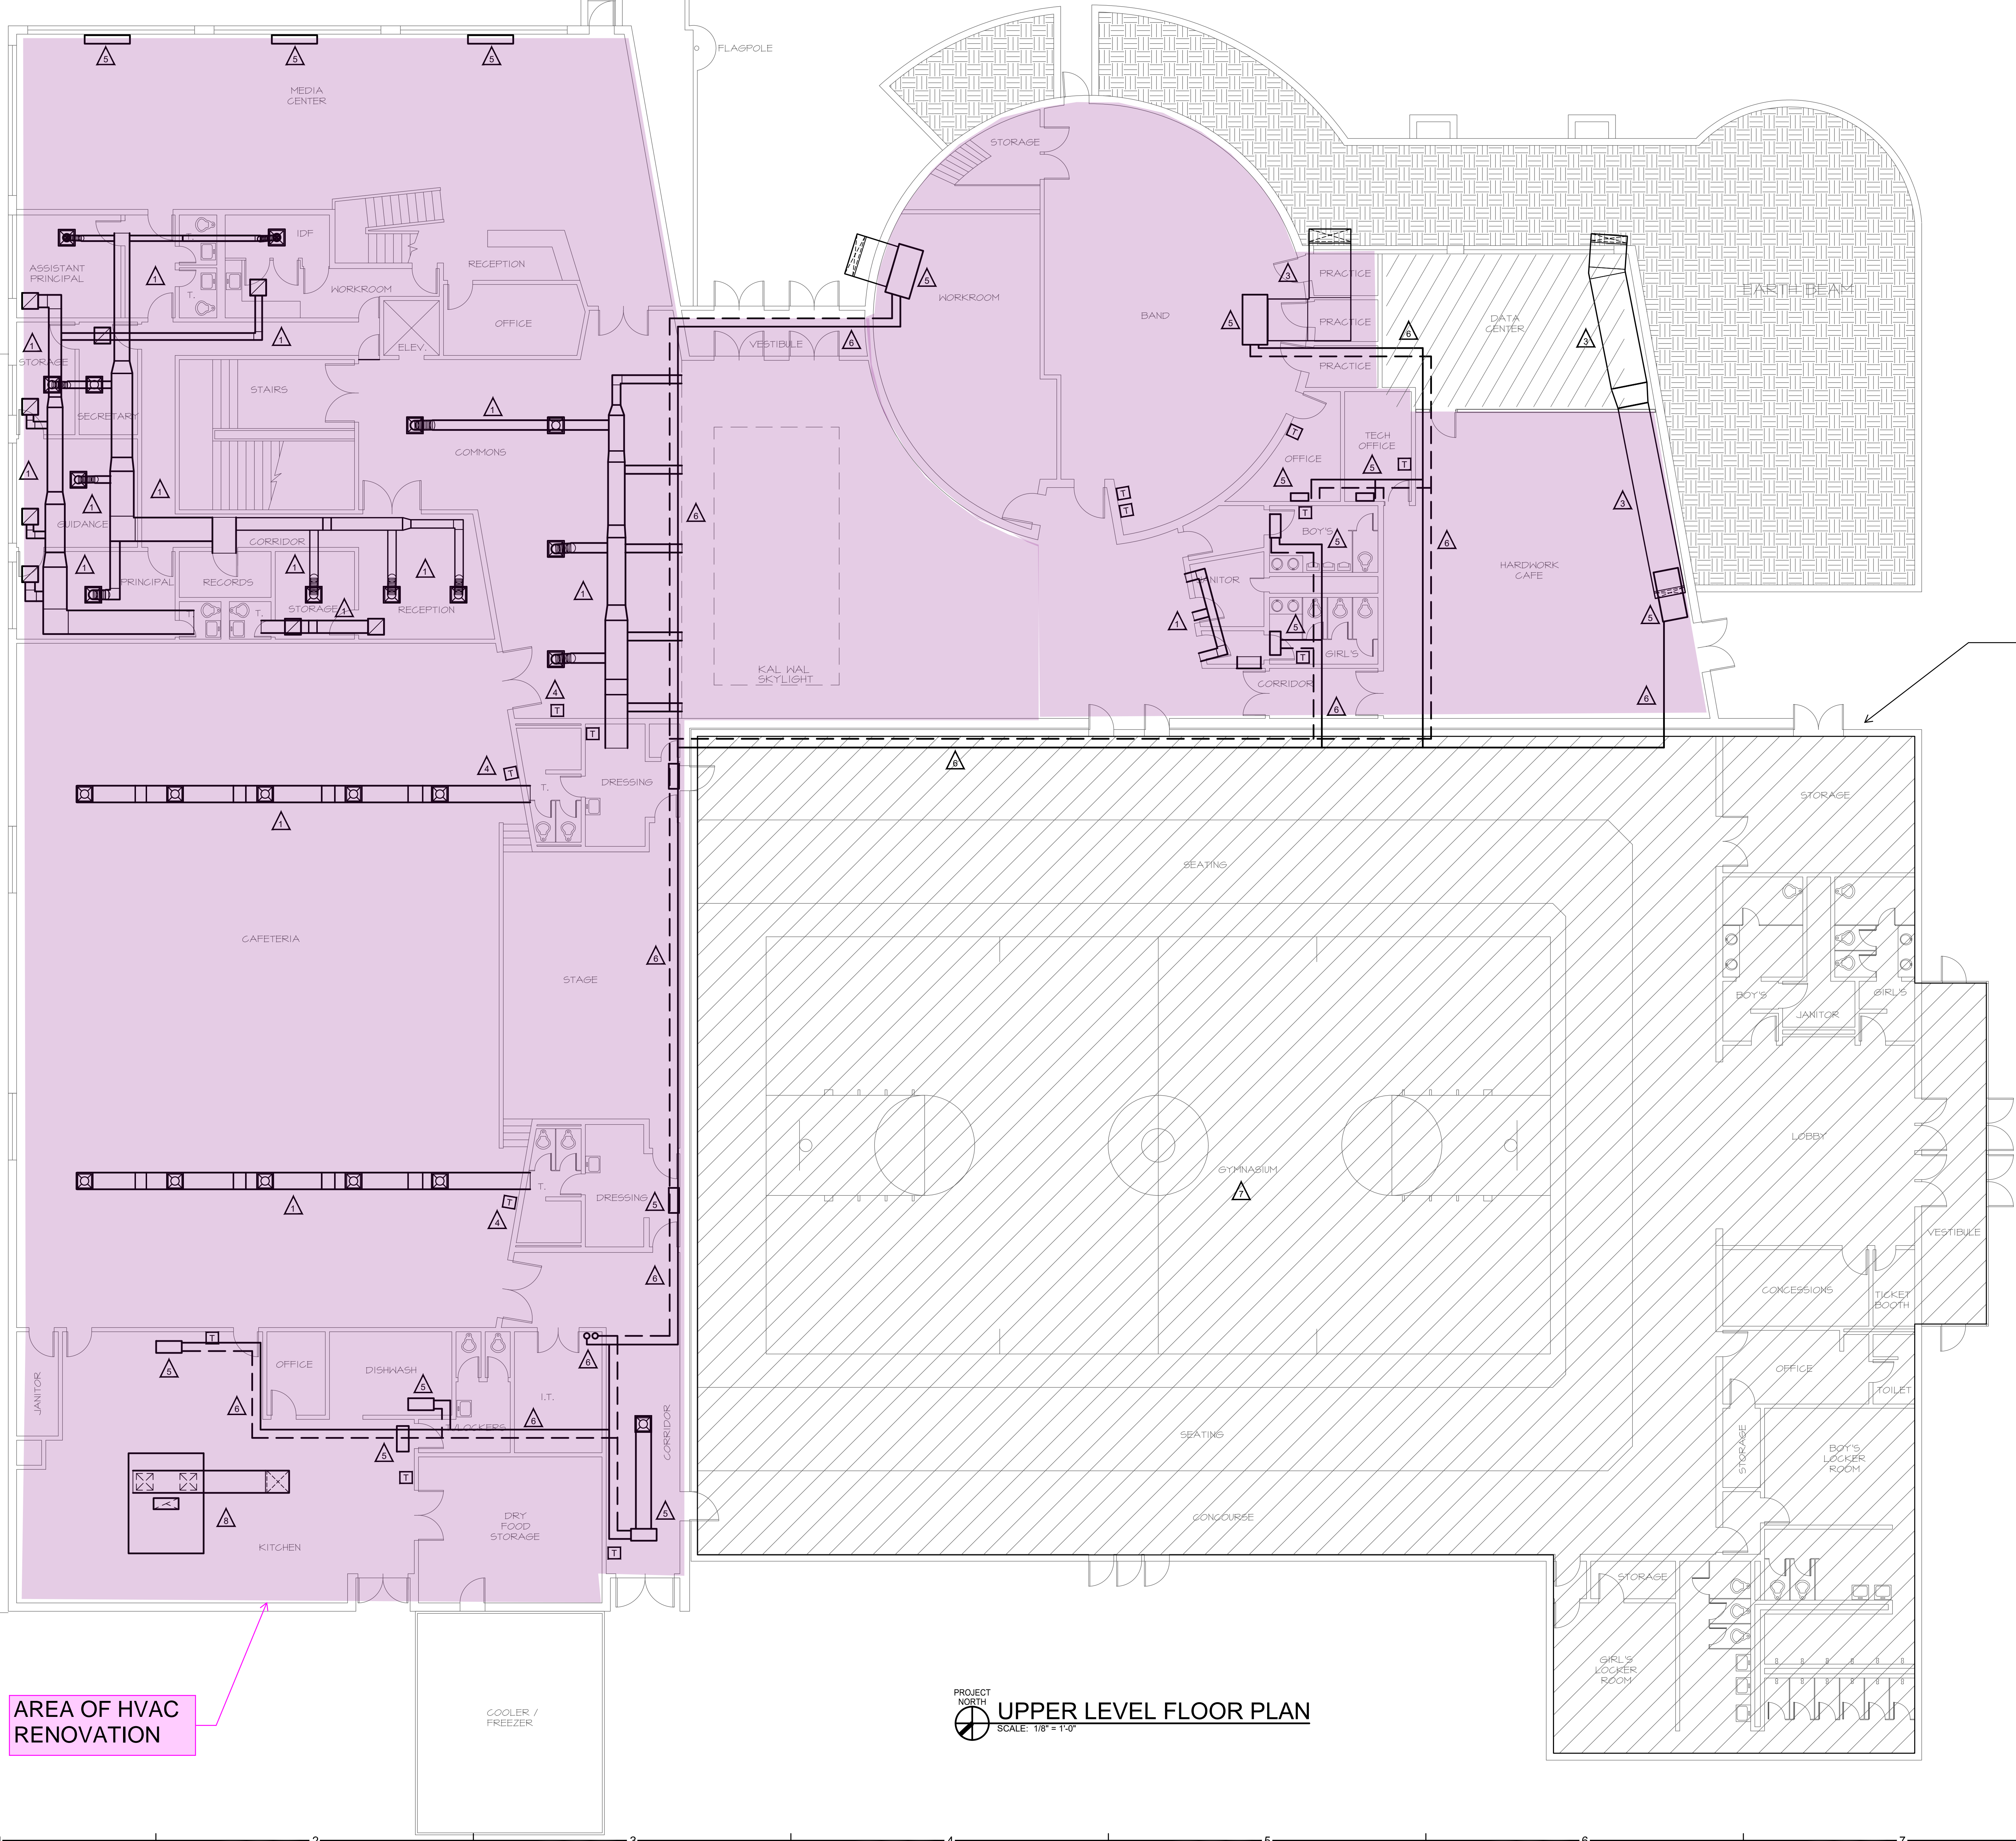


NEW DDC
CONTROLS FOR
AREAS OF HVAC
RENOVATION PLUS
EXISTING GYM
AND GYM
SUPPORT SPACES.

AREA OF HVAC
RENOVATION


PROJECT
NORTH
UPPER LEVEL FLOOR PLAN
SCALE: 1/8" = 1'-0"

LOWER LEVEL HVAC SCOPE


AREA OF HVAC RENOVATION

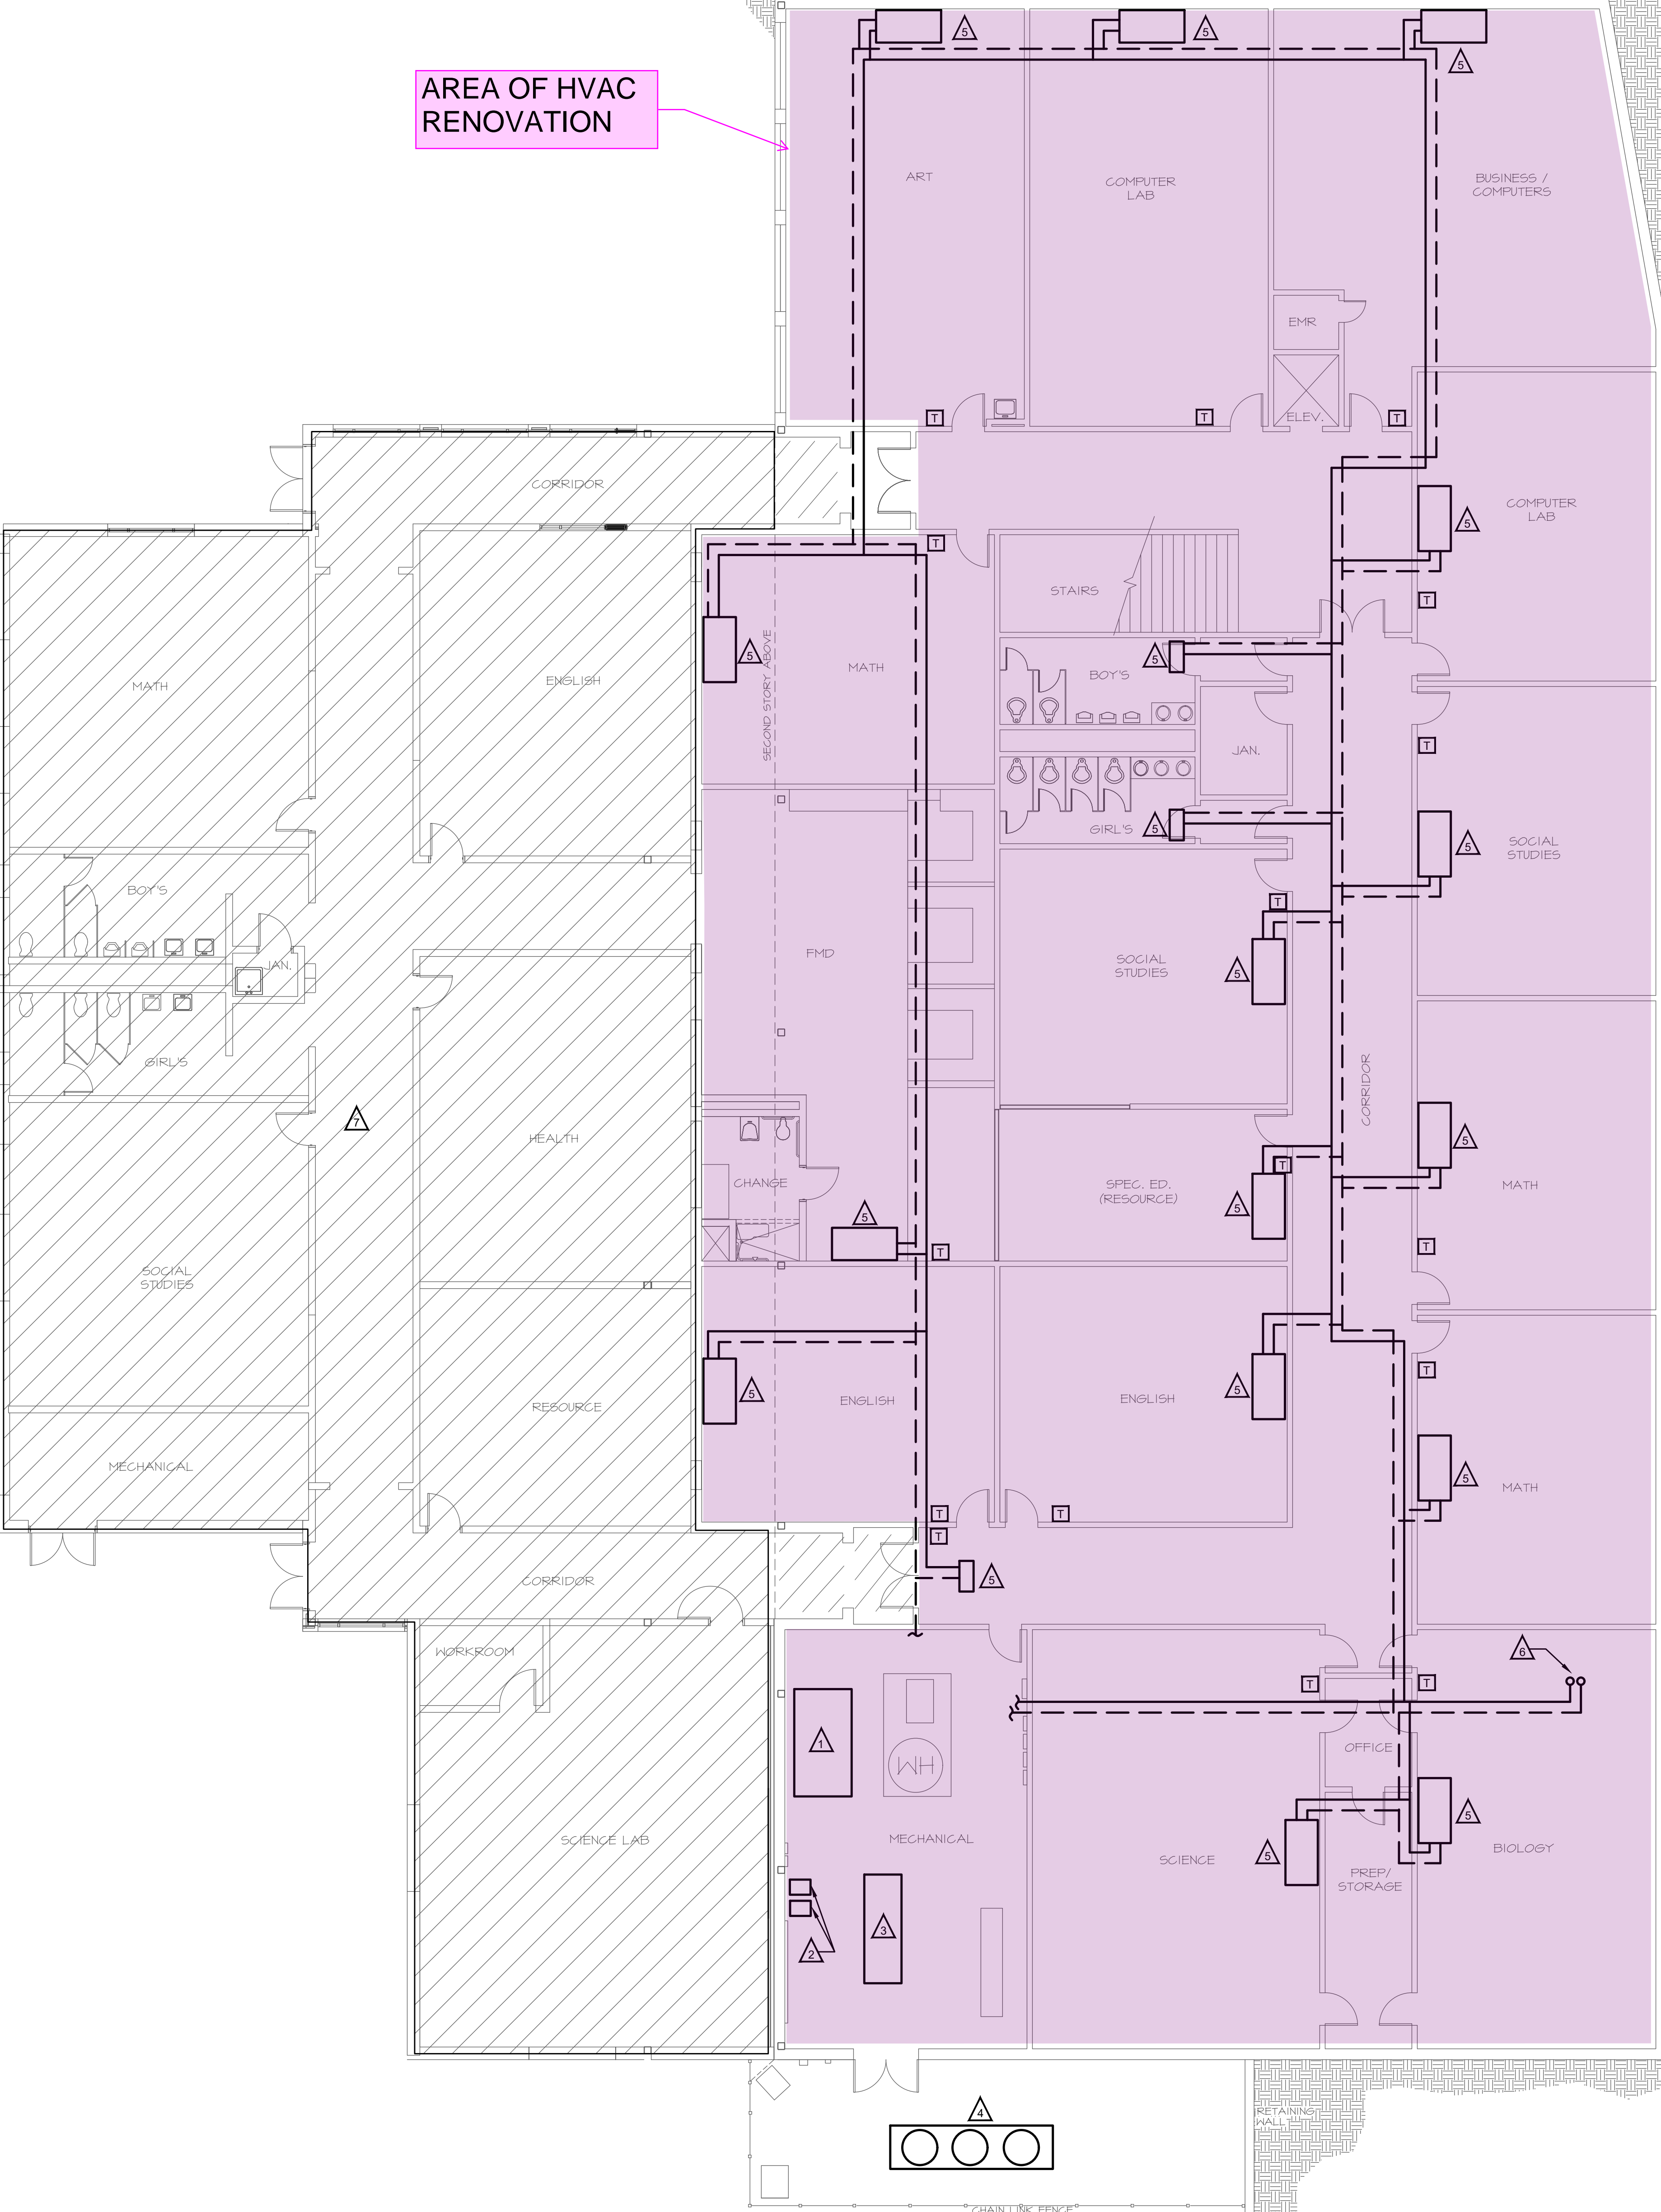


PROJECT NORTH
SCALE: 1/8" = 1'-0"
LOWER LEVEL FLOOR PLAN

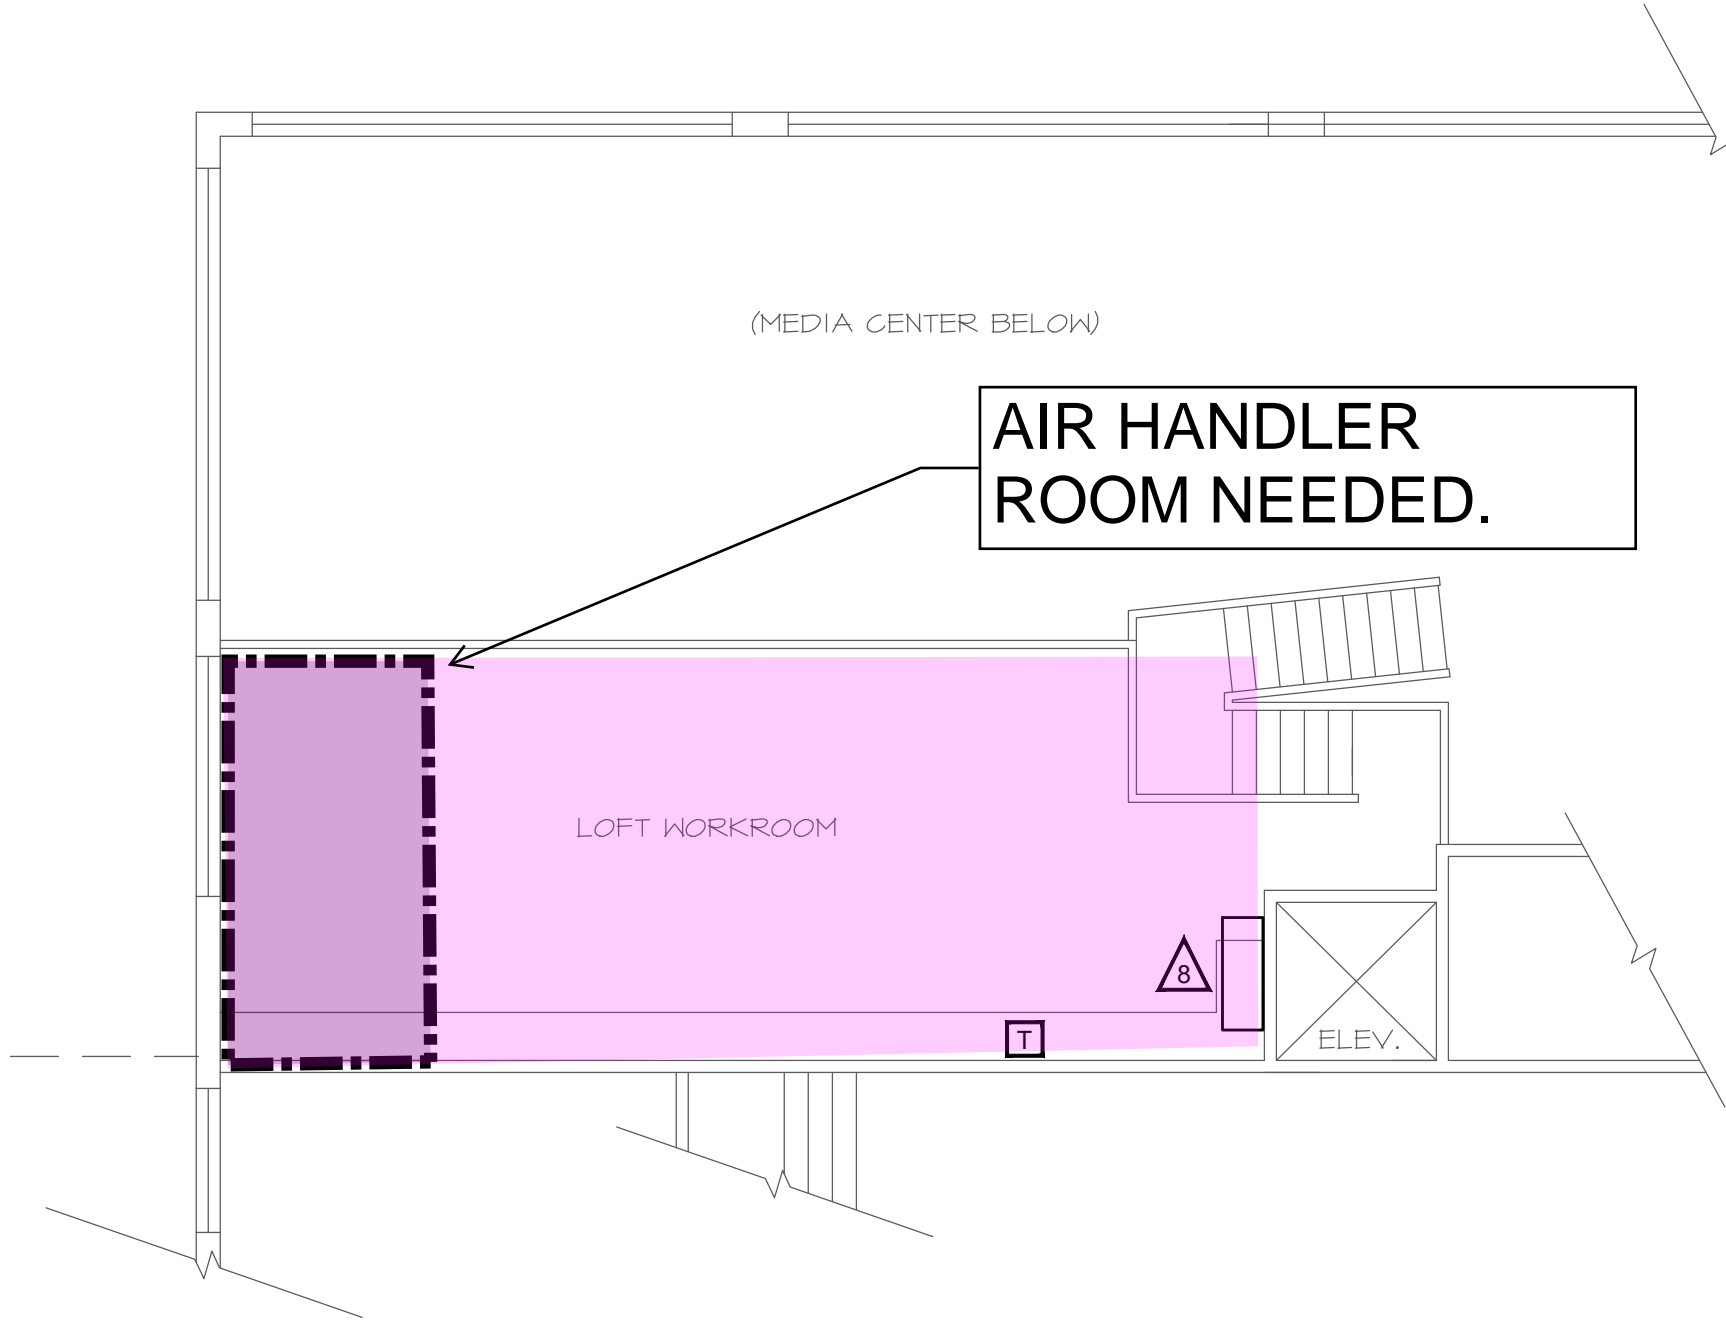

PROJECT NORTH
SCALE: 1/8" = 1'-0"
UPPER LEVEL LOFT/WORKROOM PLAN
(ABOVE MEDIA CENTER)

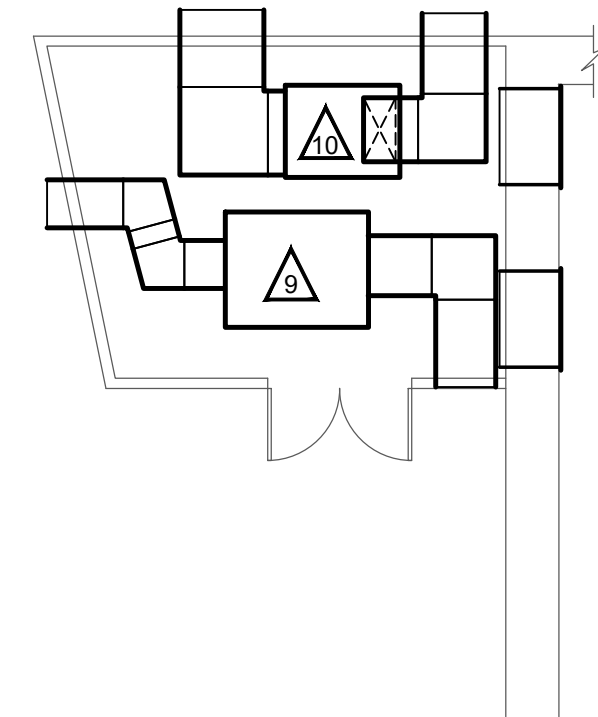

PROJECT NORTH
SCALE: 1/8" = 1'-0"
UPPER LEVEL MEZZANINE PLANS
(ABOVE DRESSING ROOMS)

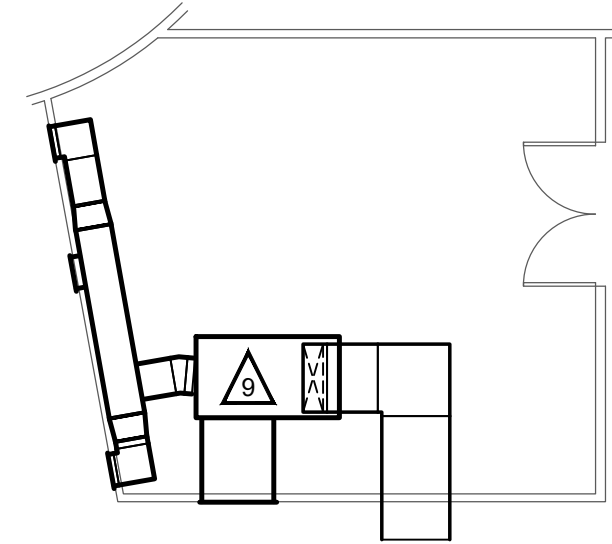

PROJECT NORTH
SCALE: 1/8" = 1'-0"
UPPER LEVEL MEZZANINE PLAN
(ABOVE COMMONS AREA)

PROJECT NORTH
SCALE: 1/8" = 1'-0"
UPPER LEVEL MEZZANINE PLAN
(ABOVE RECORDS AREA)

MARCUM
ENGINEERING, LLC
500 SOUTH 17TH STREET,
PADUCH, KENTUCKY 40062
PHONE: 270.444.9274
WWW.MARCUMENGINEERING.NET
COPYRIGHT © 2021 MARCUM ENGINEERING, LLC

RBS DESIGN GROUP
Architecture
723 Harvard Drive, Owensboro, KY 42301
Phone: 270.647.1800 Fax: 270.648.5446
Email: info@rbsdesign.com

ALL RIGHTS RESERVED.
NO PART OF THIS DOCUMENT SHALL BE REPRODUCED OR TRANSMITTED IN ANY FORM OR BY ANY MEANS, ELECTRONIC OR MECHANICAL, WITHOUT PERMISSION IN WRITING FROM RBS DESIGN GROUP.
DO NOT SCALE DIMENSIONS.
NOT A CONTRACT DOCUMENT.
CONSULT THE CONTRACT DOCUMENTS FOR ALL DIMENSIONS AND NOTES.

JOB NUMBER	20204
DRAWN BY	
CHECKED BY	
DATE	MAY 17, 2021

REVISIONS	NO.	DATE



DAWSON SPRINGS INDEPENDENT SCHOOLS
DAWSON SPRINGS HIGH SCHOOL
DAWSON SPRINGS, KENTUCKY

SHEET NUMBER

UPPER LEVEL LIGHTING SCOPE

MARCUM
ENGINEERING, LLC

500 SOUTH 17TH STREET,
PADUCH, KENTUCKY 40062
PHONE: 270.444.9274
WWW.MARCUMENGINEERING.NET
COPYRIGHT © 2021 MARCUM ENGINEERING, LLC

RBS DESIGN GROUP
Architecture

723 Harvard Drive, Owensboro, KY 42301
Phone: 270.647.1951 Fax: 270.648.5446
www.rbsdesigngroup.com

ALL RIGHTS RESERVED.
NO PART OF THIS DOCUMENT SHALL BE REPRODUCED OR TRANSMITTED IN ANY FORM OR BY ANY MEANS, ELECTRONIC OR MECHANICAL, INCLUDING PHOTOCOPYING, RECORDING, OR BY ANY INFORMATION STORAGE AND RETRIEVAL SYSTEM, WITHOUT PERMISSION IN WRITING FROM RBS DESIGN GROUP.


JOB NUMBER	20204
DRAWN BY	
CHECKED BY	
DATE	MAY 17, 2021

REVISIONS	NO.	DATE



DAWSON SPRINGS INDEPENDENT SCHOOLS
DAWSON SPRINGS HIGH SCHOOL
DAWSON SPRINGS, KENTUCKY

SHEET NUMBER


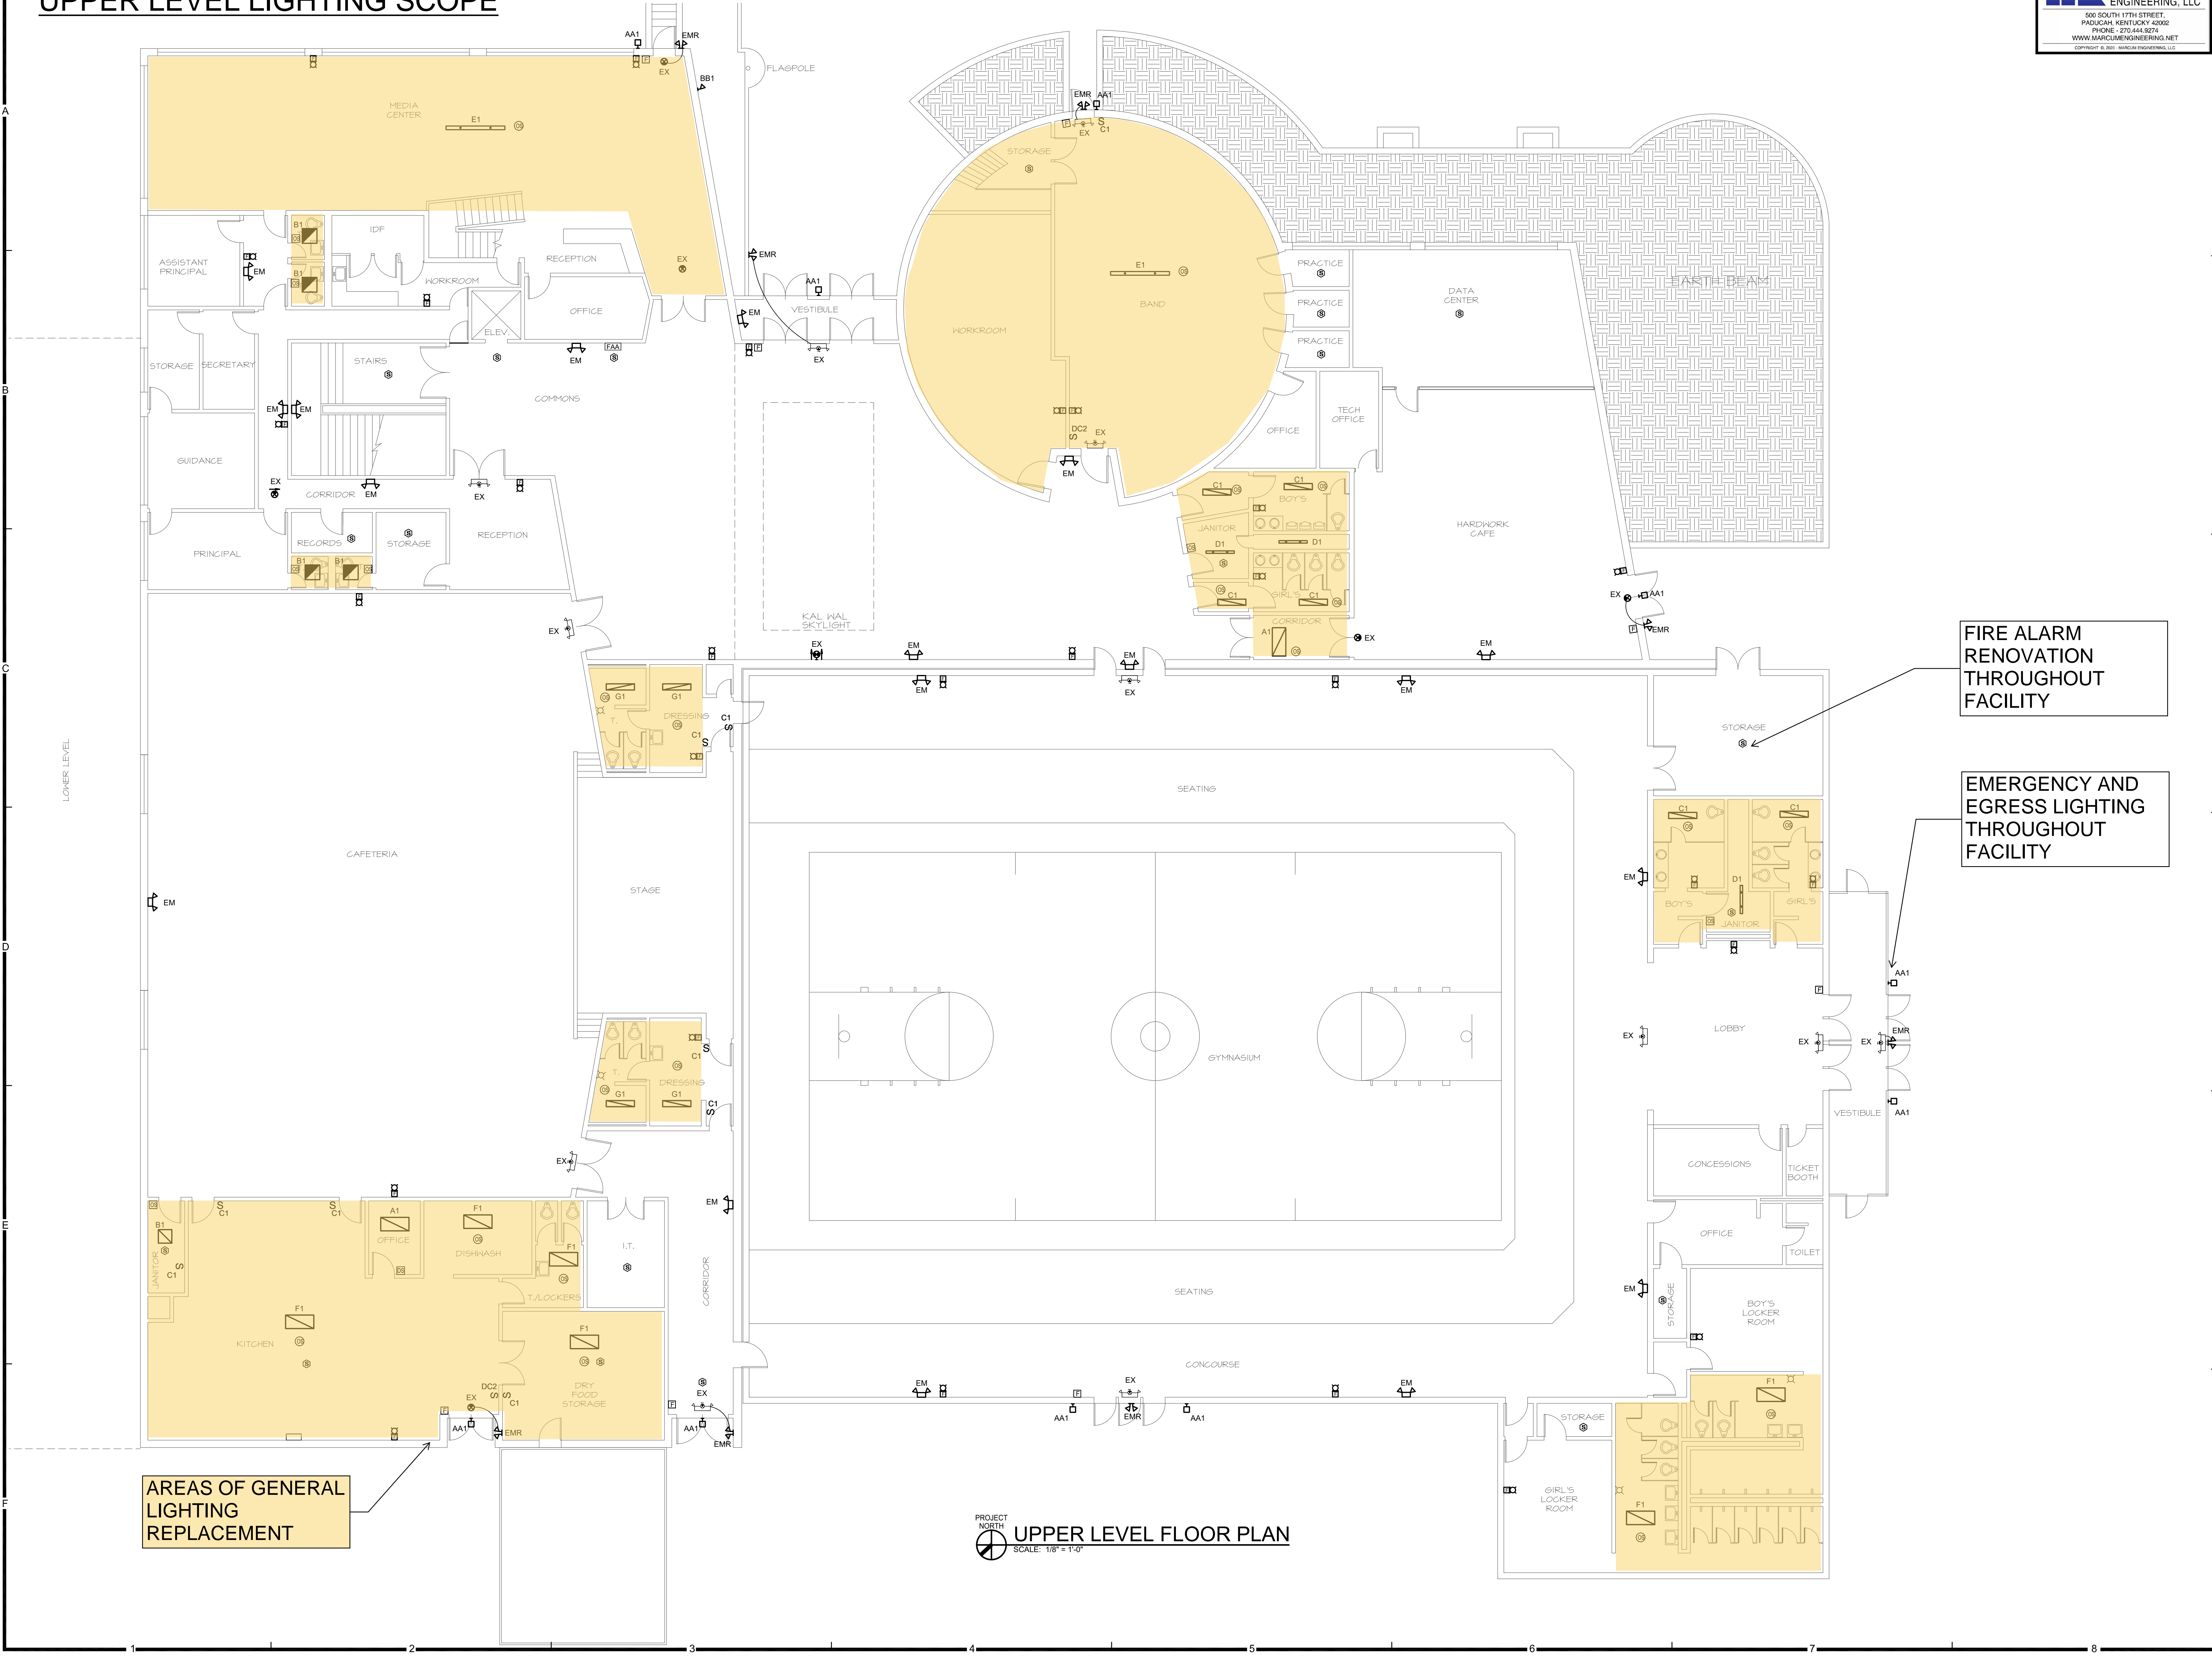



LOWER LEVEL LIGHTING SCOPE



MARCUM
ENGINEERING, LLC

500 SOUTH 17TH STREET,
PADUCH, KENTUCKY 40062
PHONE: 270.444.9274
WWW.MARCUMENGINEERING.NET
COPYRIGHT © 2021, MARCUM ENGINEERING, LLC

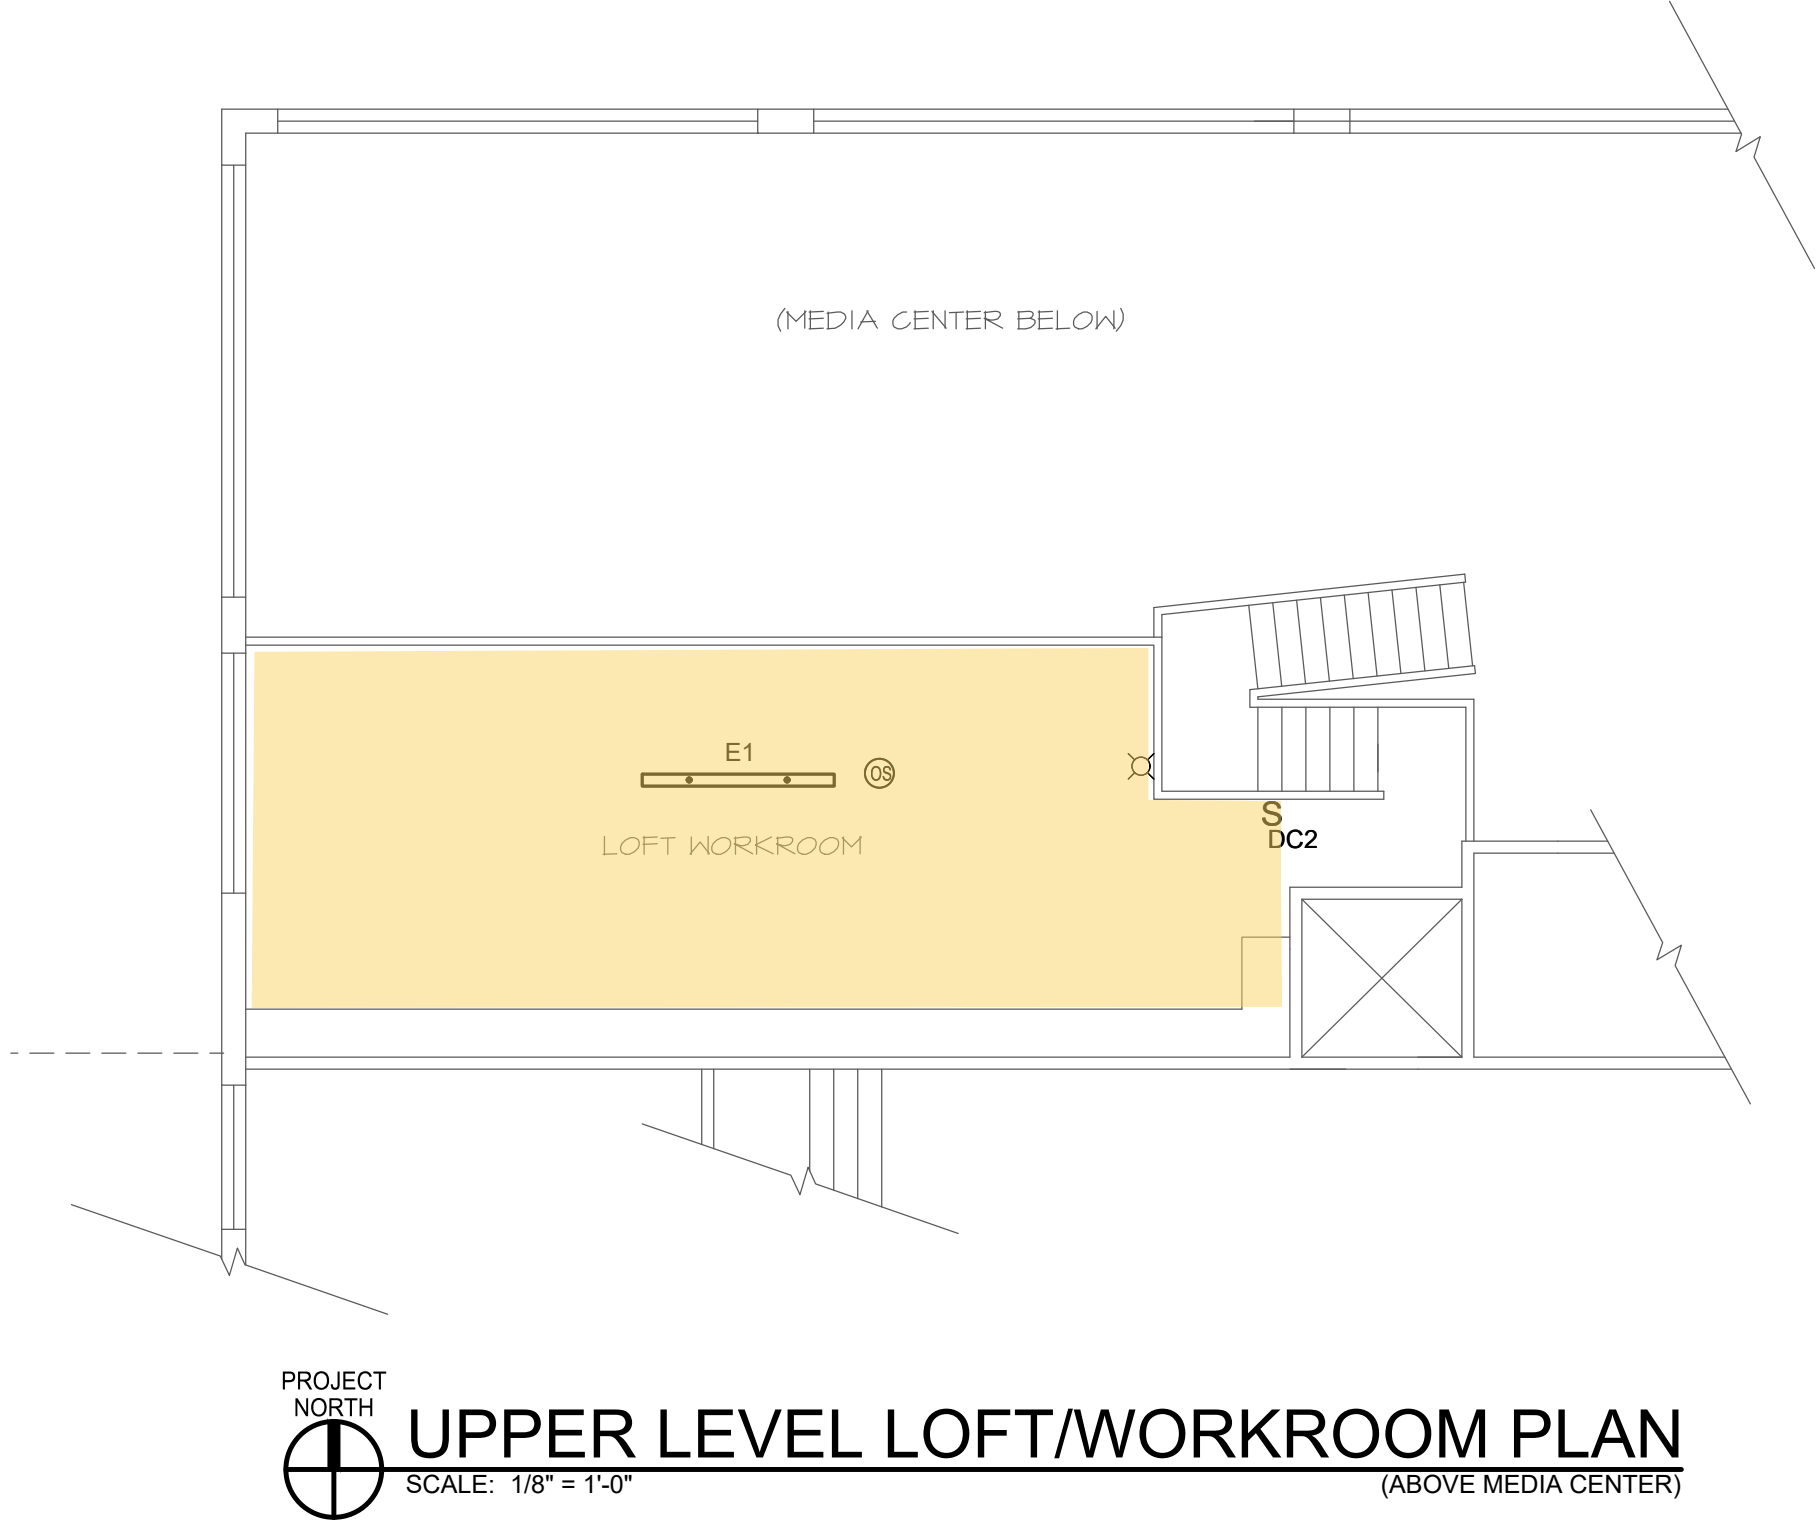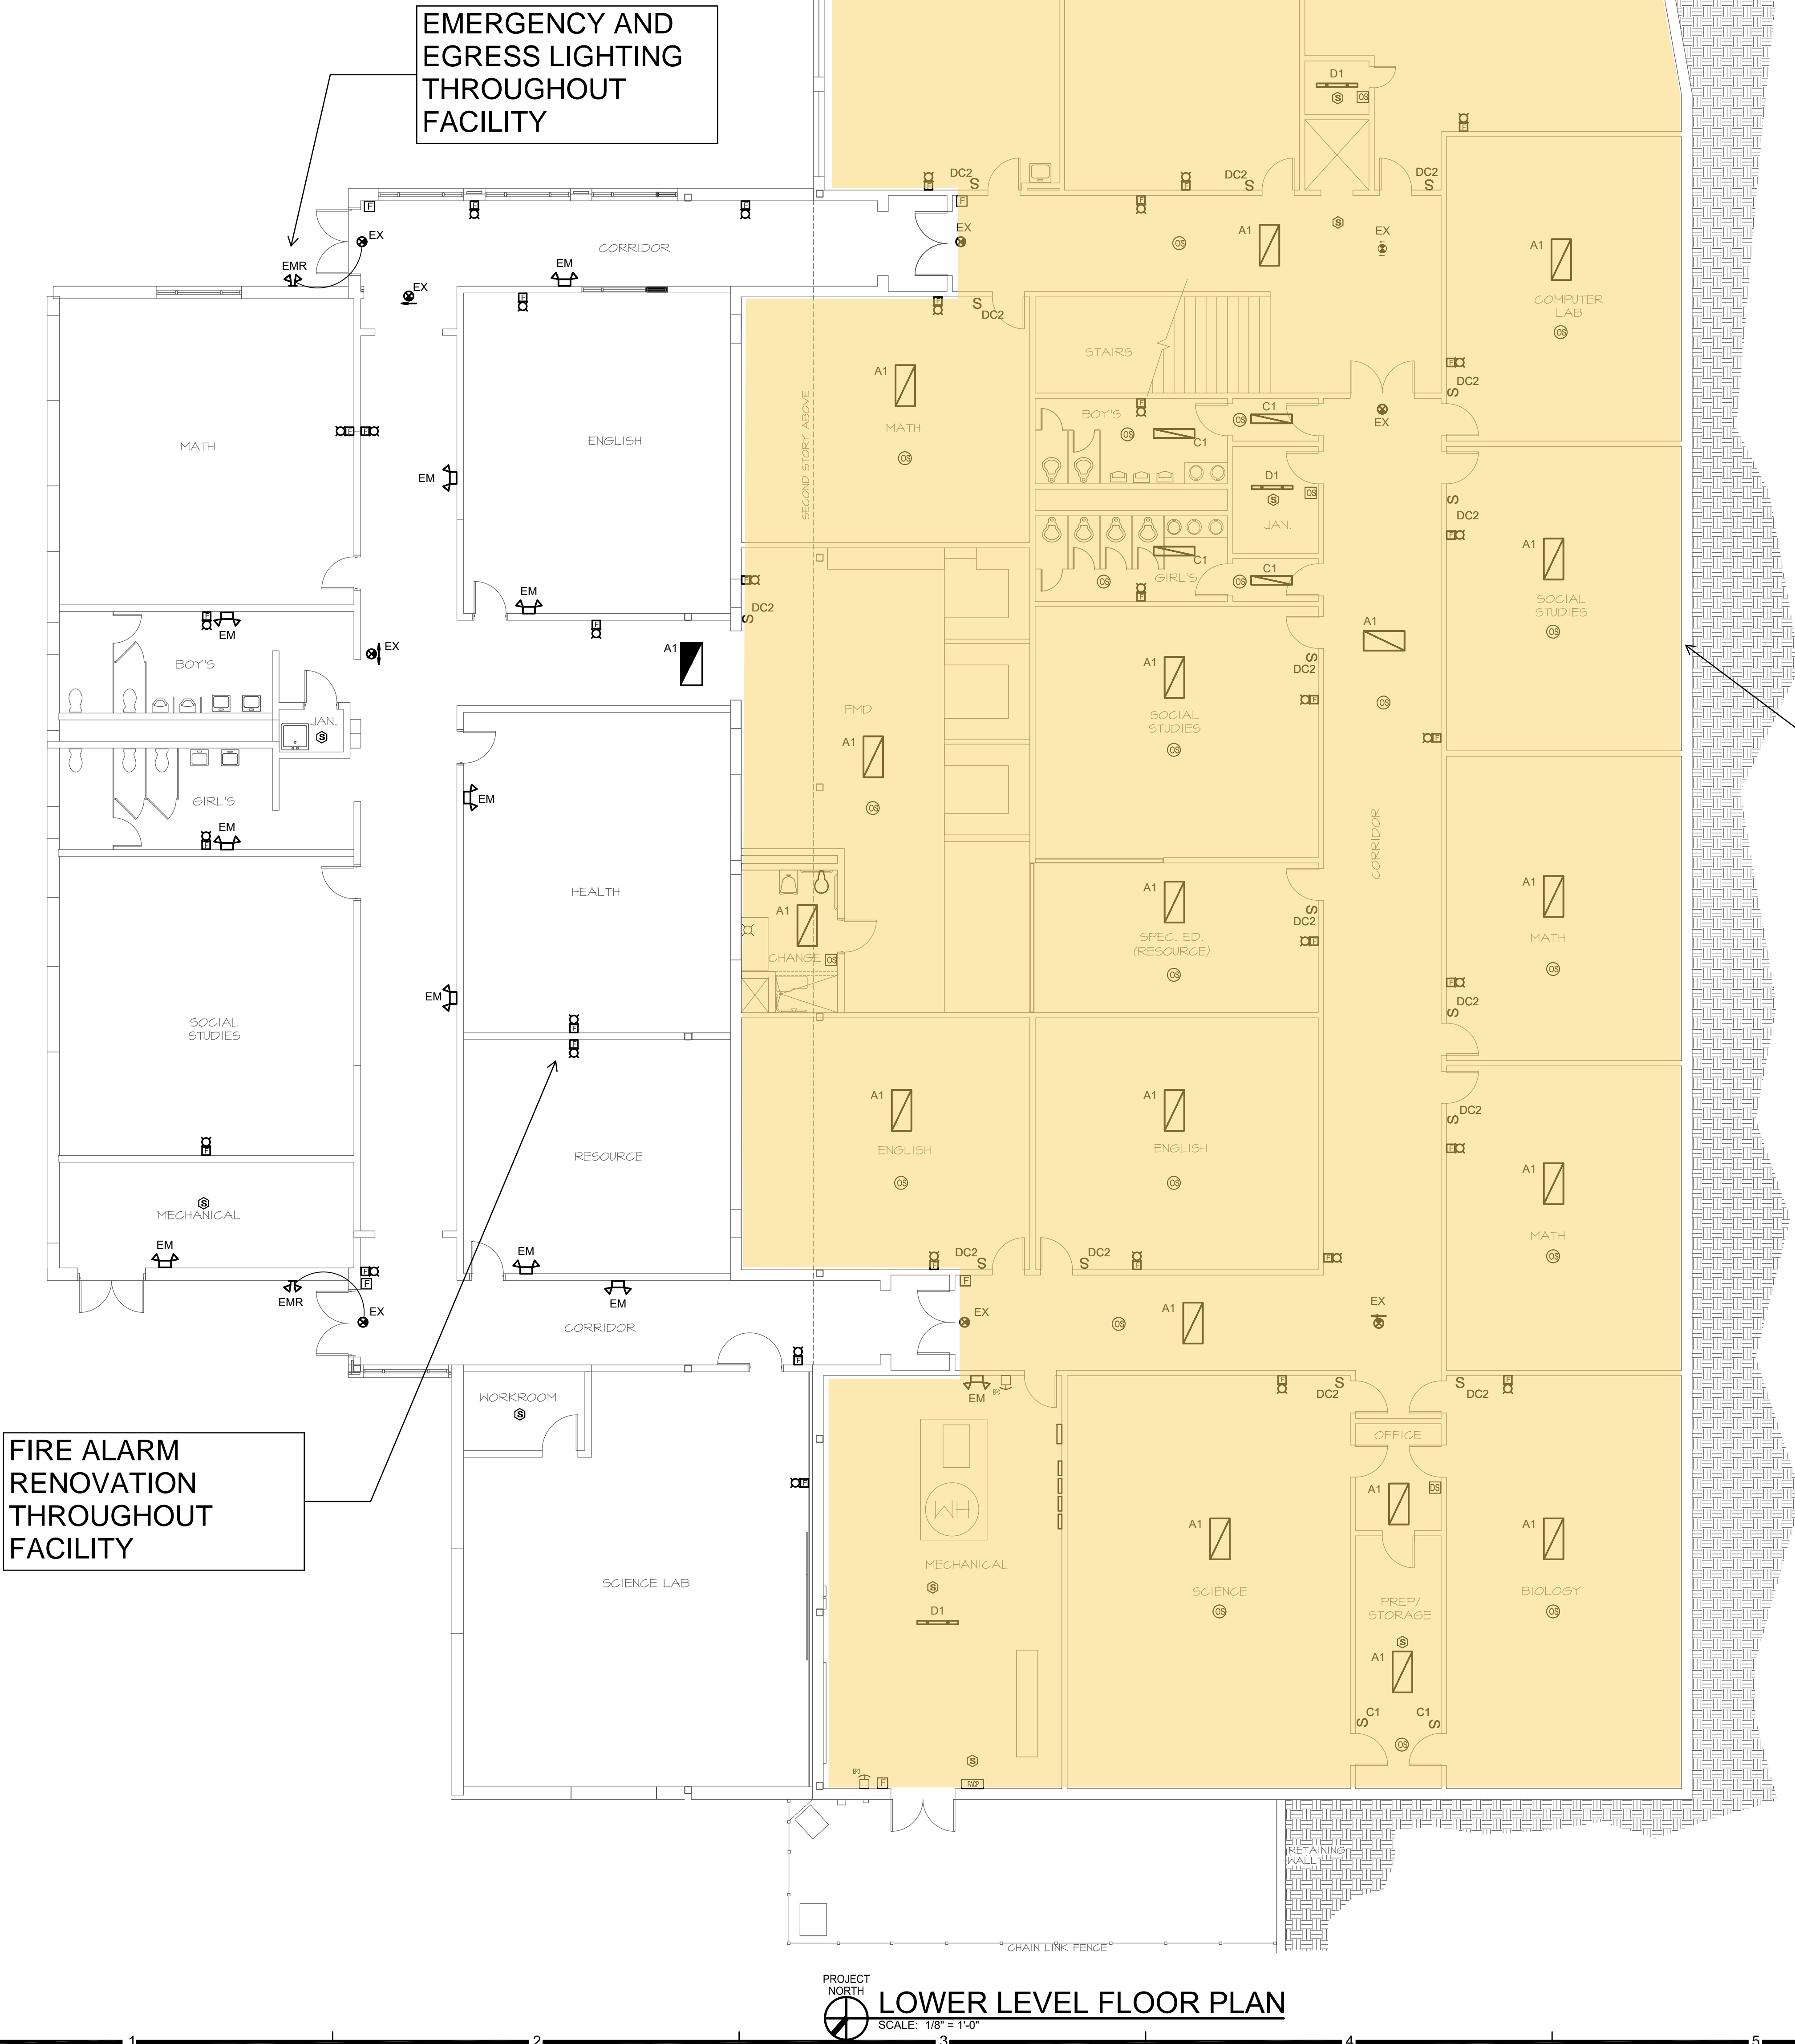

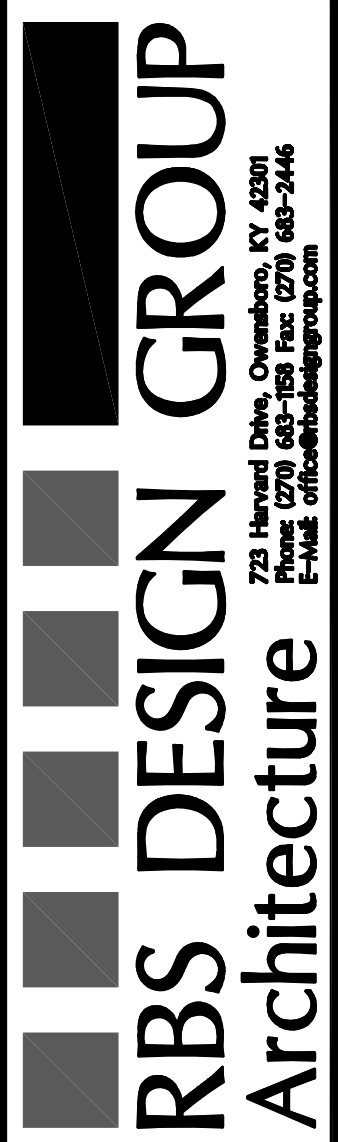

RBS DESIGN GROUP
Architecture

723 Harvard Drive, Owensboro, KY 42301
Phone: 270.647.1958 Fax: 270.648-5446
Email: info@rbsdesigngroup.com

ALL RIGHTS RESERVED.
NO PART OF THIS DOCUMENT SHALL BE REPRODUCED OR TRANSMITTED IN ANY FORM OR BY ANY MEANS, ELECTRONIC OR MECHANICAL, WITHOUT PERMISSION IN WRITING FROM RBS DESIGN GROUP.
THIS DOCUMENT IS THE PROPERTY OF RBS DESIGN GROUP AND IS TO BE USED ONLY FOR THE PROJECT AND SITE SPECIFICALLY IDENTIFIED HEREIN.
IT IS THE USER'S RESPONSIBILITY TO OBTAIN ALL NECESSARY PERMITS AND APPROVALS FROM THE APPROPRIATE AGENCIES.

JOB NUMBER	20594
DRAWN BY	
CHECKED BY	
DATE	MAY 17, 2021

REVISIONS	NO.	DATE
	1	
	2	
	3	
	4	



DAWSON SPRINGS INDEPENDENT SCHOOLS
DAWSON SPRINGS HIGH SCHOOL
DAWSON SPRINGS, KENTUCKY

SHEET NUMBER