

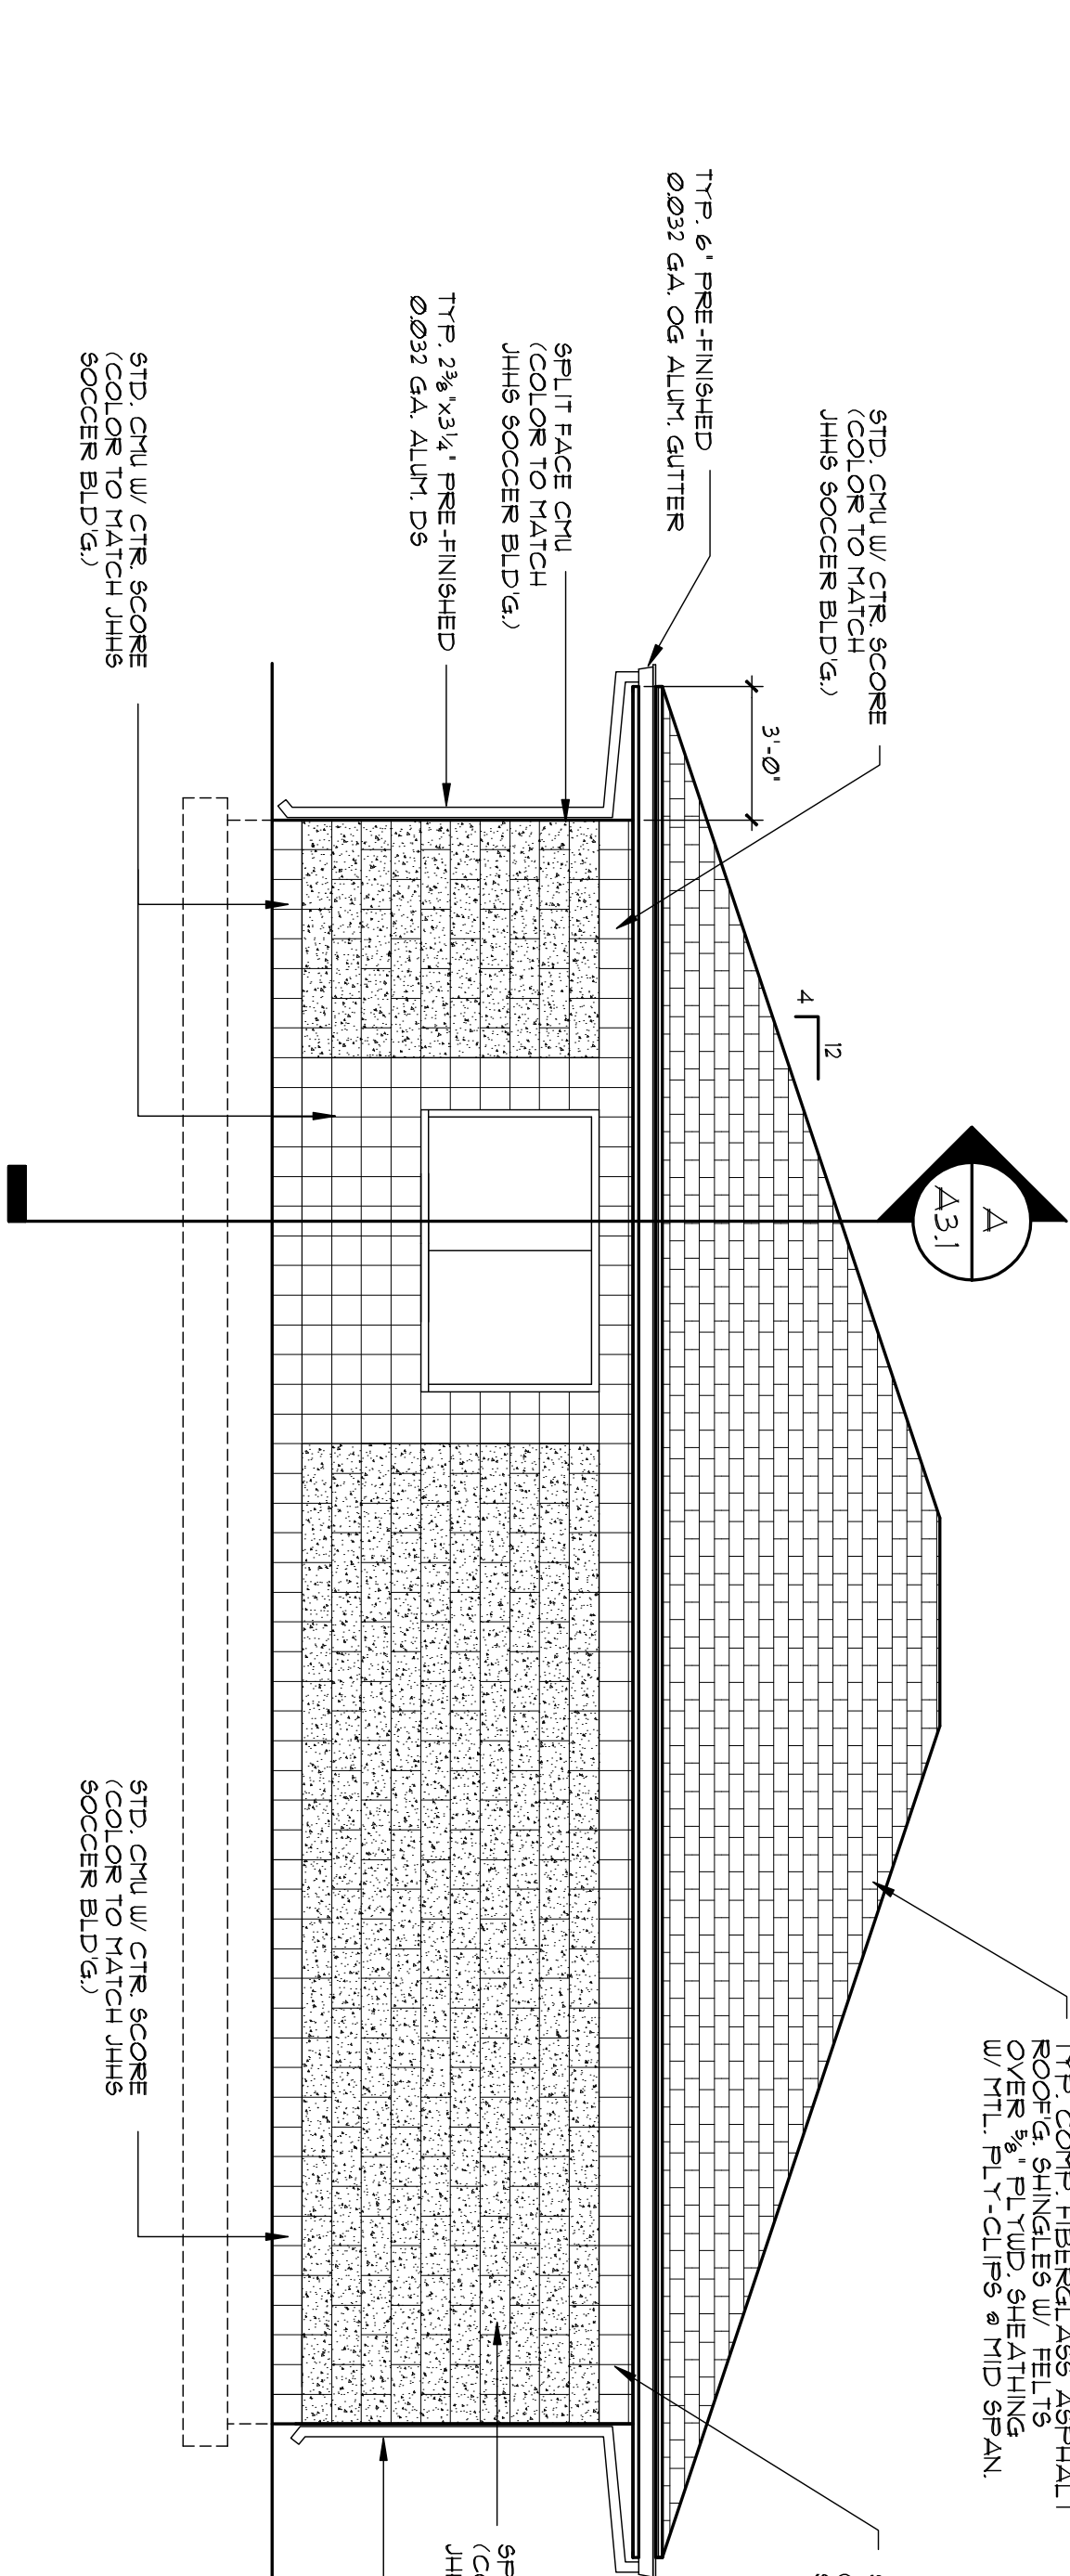
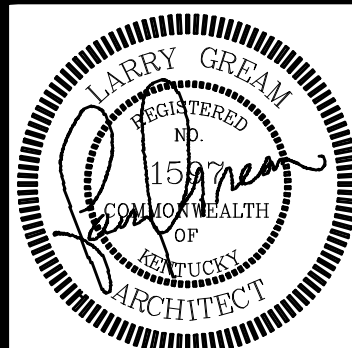


TOILET ACCESSORIES SCHEDULE		
NO.	DESCRIPTION	MANUFACTURER MODEL NUMBER MOUNTING INSTRUCT.
TA-1	MIRROR	BOBERICK B-230 24x6
TA-2	GRAB BAR	BOBERICK B-5507 x 18
TA-3	GRAB BAR	BOBERICK B-5507 x 36
TA-4	GRAB BAR	BOBERICK B-5507 x 42
TA-5	HAND DRYER (SEE NOTE 3)	WORLD (SUPPLIED BY ELECTRICAL CONTRACTOR)
TA-6	SANITARY NAPKIN DISPOSAL	BOBERICK B-354
TA-7	SANITARY NAPKIN DISPOSAL	BOBERICK B-35303
TA-11	SURFACE MOUNTED BABY CHANGING STATION	BOBERICK K-2100-SB-UTB-265


GENERAL NOTES:
1. SEE PLUMBING DRAWINGS FOR MOUNTING HEIGHTS
2. SEE PLUMBING DRAWINGS FOR TOILET ACCESSORIES
AND PLUMBING FIXTURES COORDINATE WITH OWNER ON
OWNER SUPPLIED TOILET ACCESSORIES
3. HAND DRYERS ARE SPECIFIED UNDER DIVISION 8
AND PROVIDED BY ELECTRICAL.

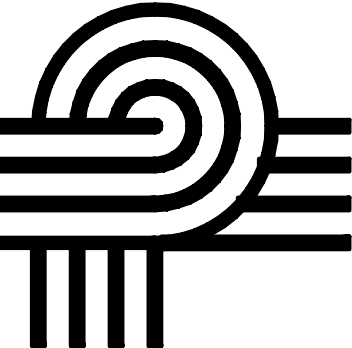


A FRONT (BASEBALL) ELEVATION
SCALE: 1/4" = 1'-0"

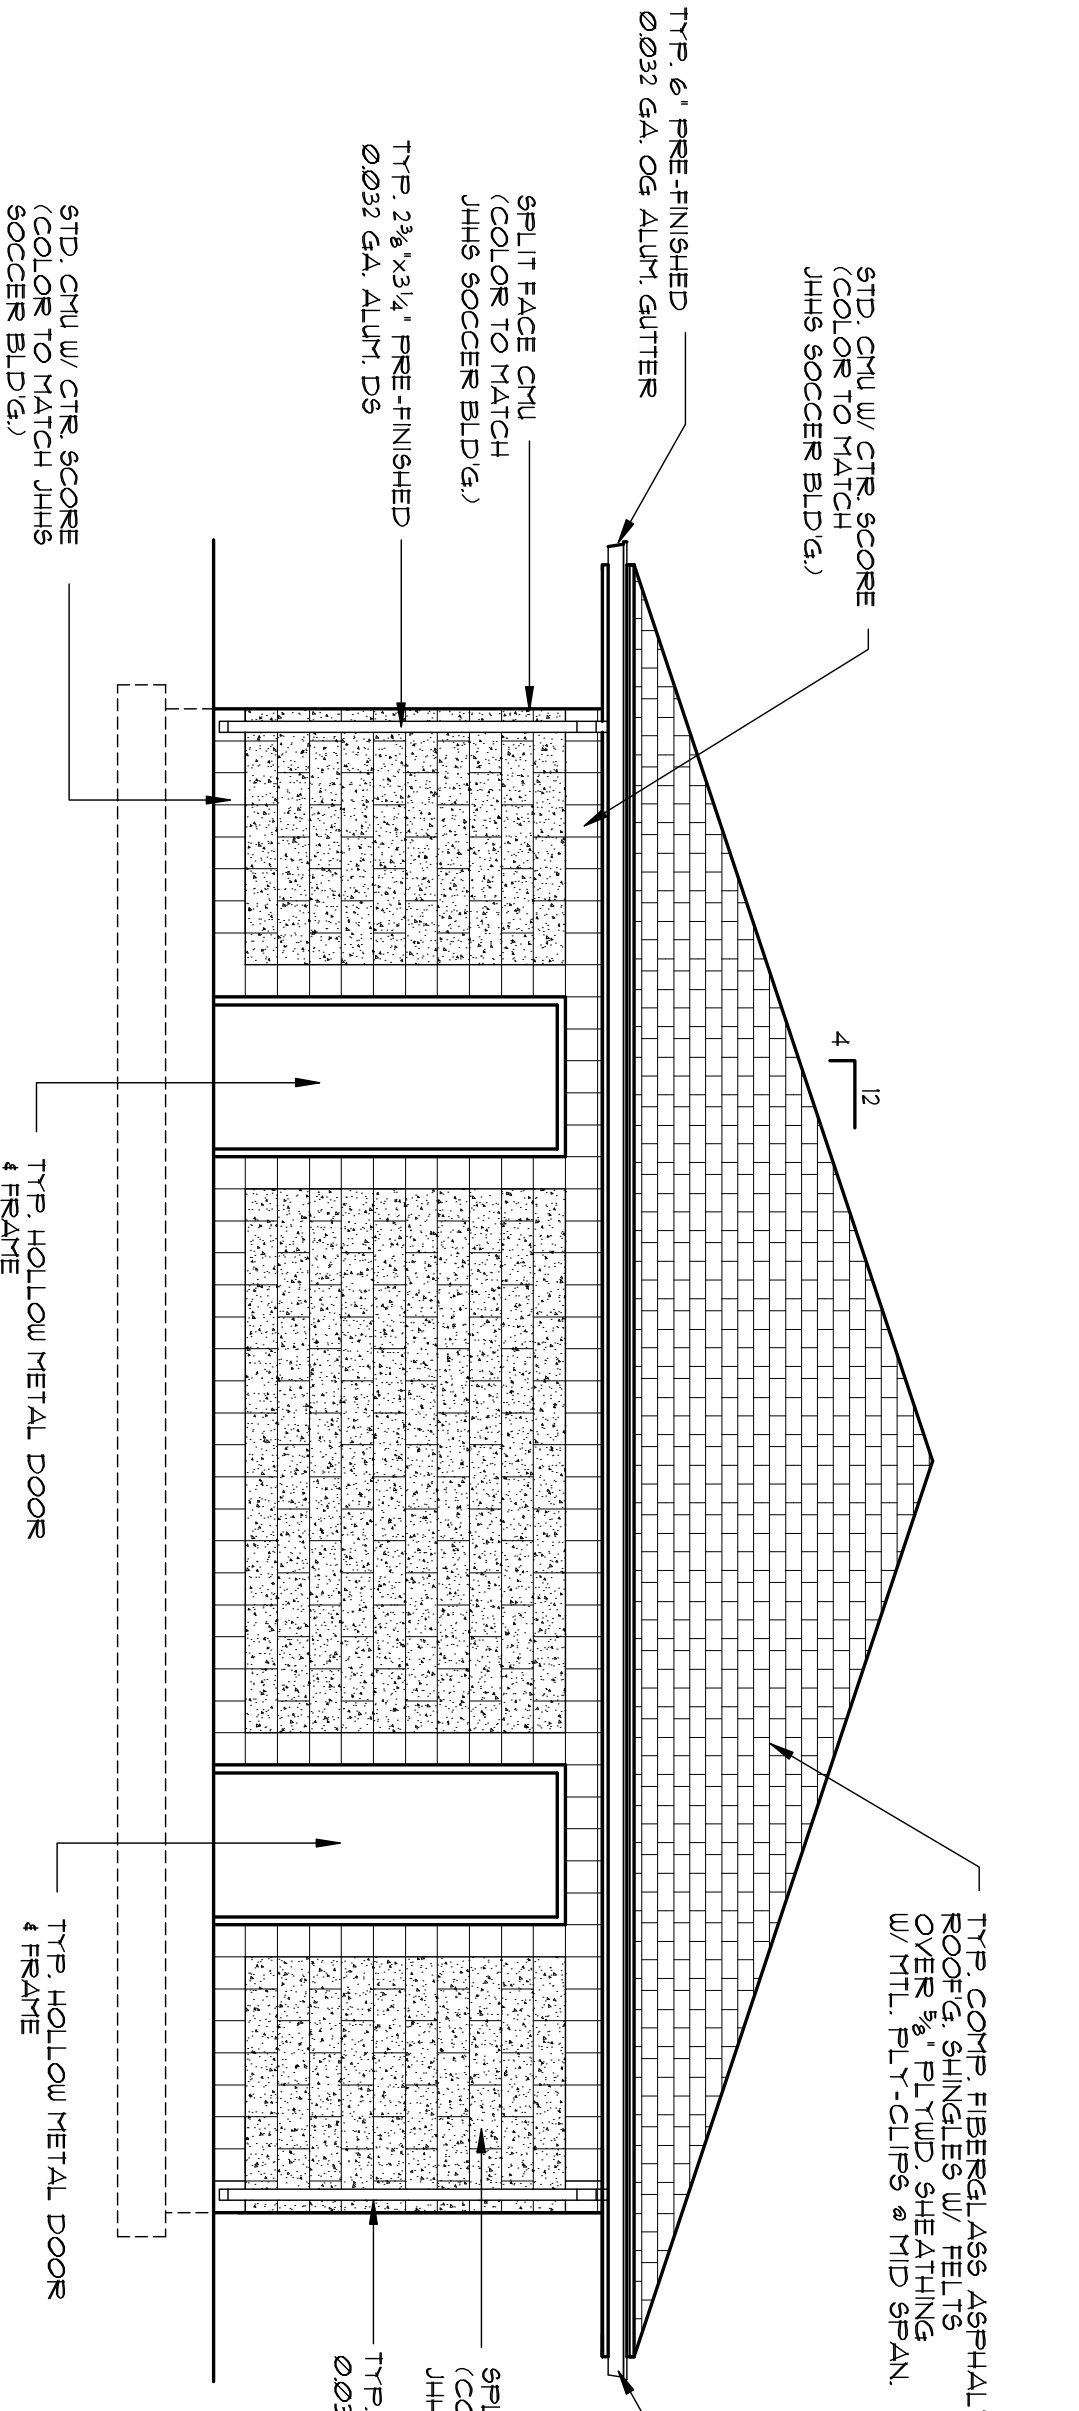


D SIDE ELEVATION
SCALE: 1/4" = 1'-0"

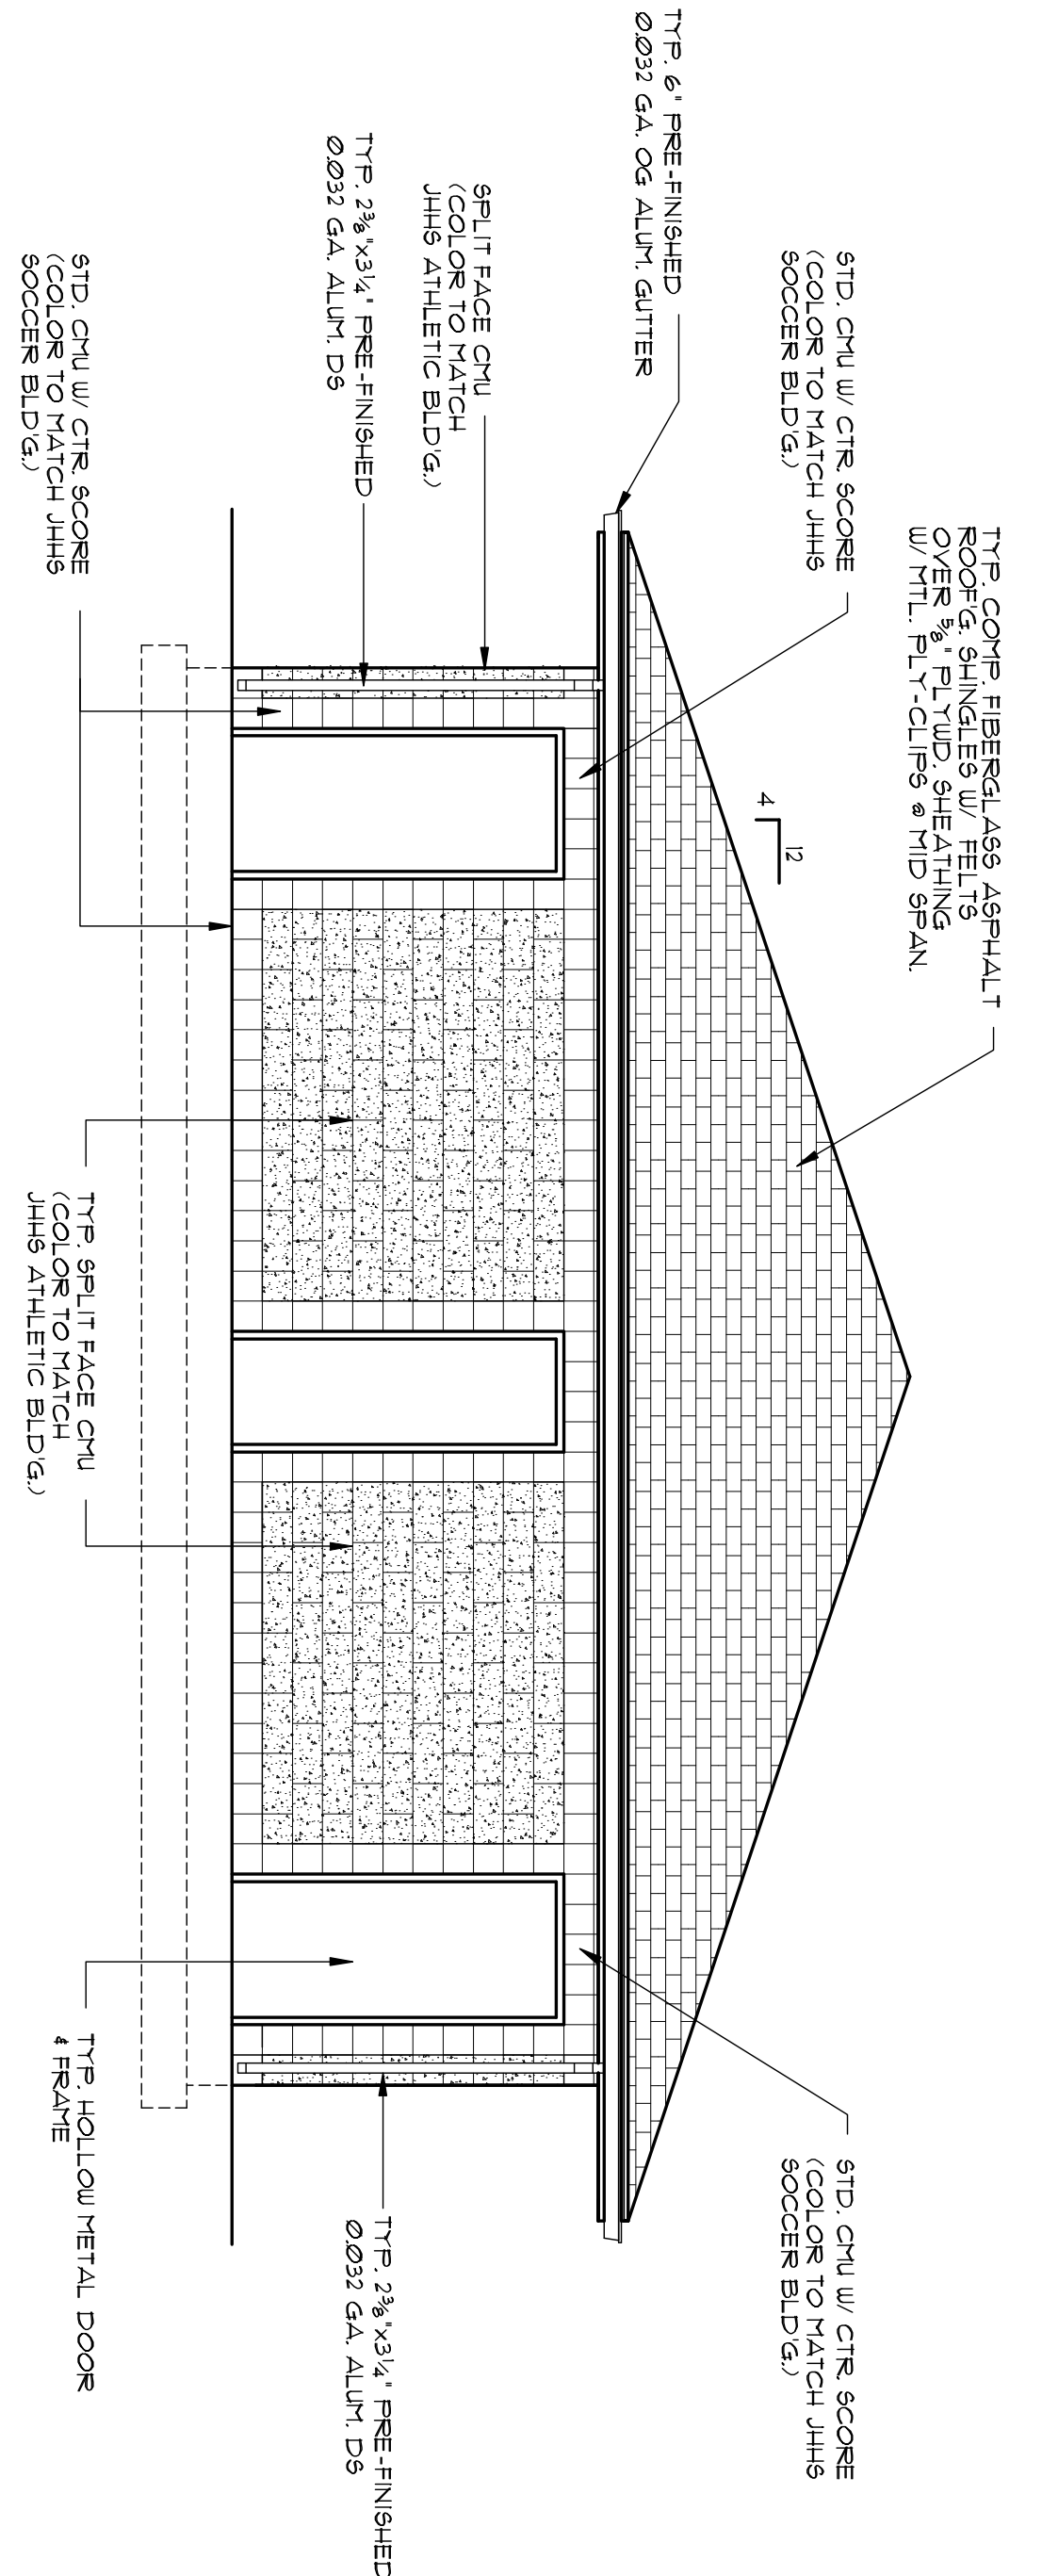



B SIDE ELEVATION
SCALE: 1/4" = 1'-0"

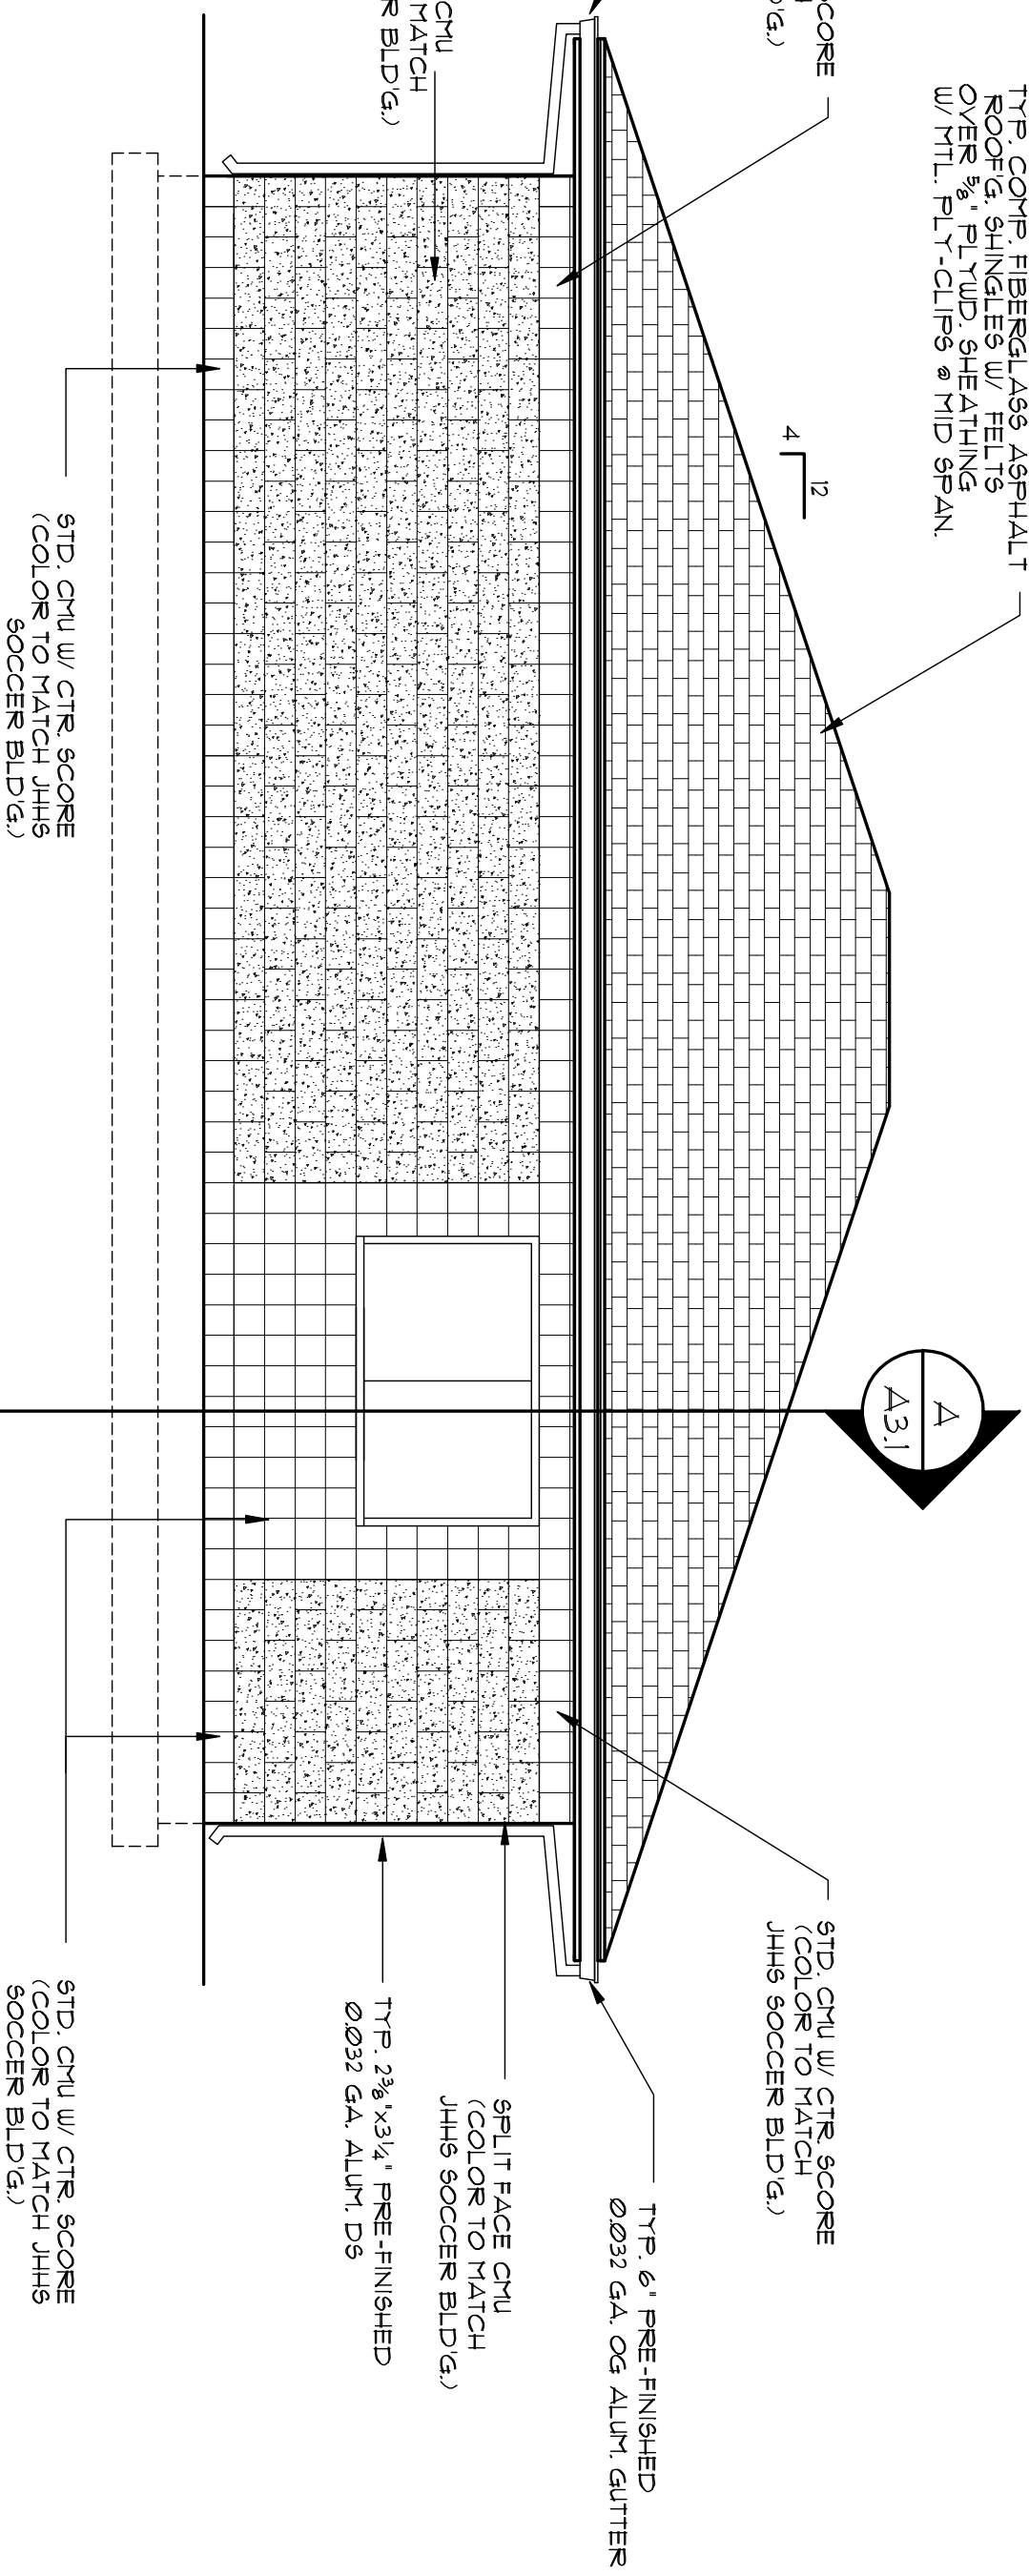


C FRONT (SOFTBALL) ELEVATION
SCALE: 1/4" = 1'-0"

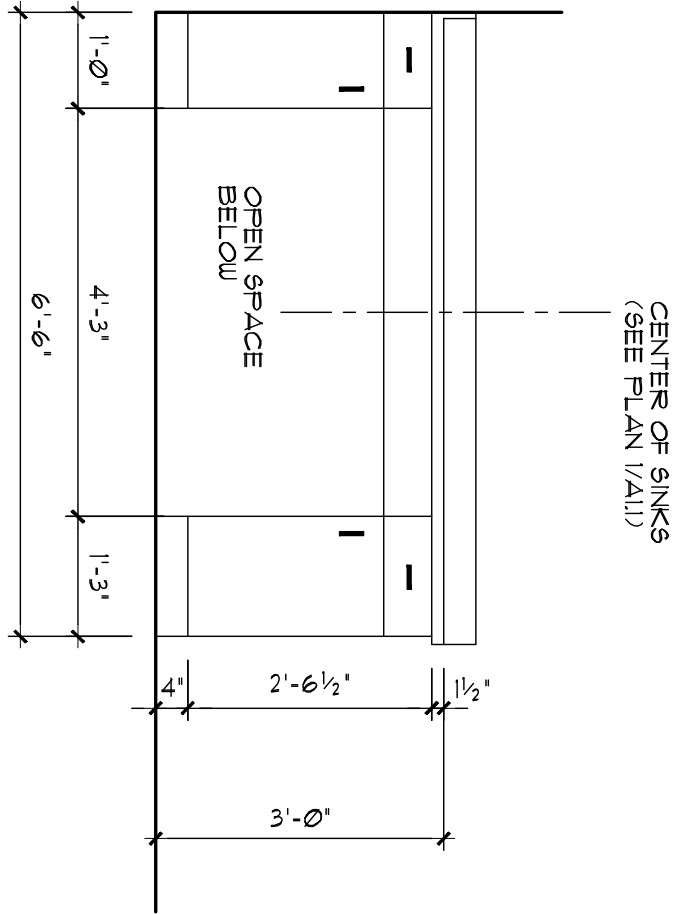


5 ELEVATION OF SINK
MILLWORK
SCALE: 1/2" = 1'-0"

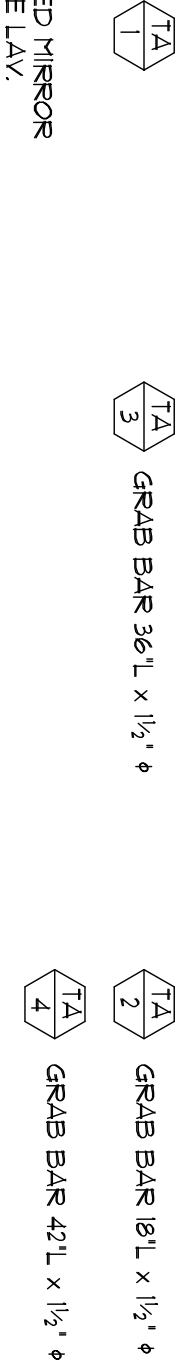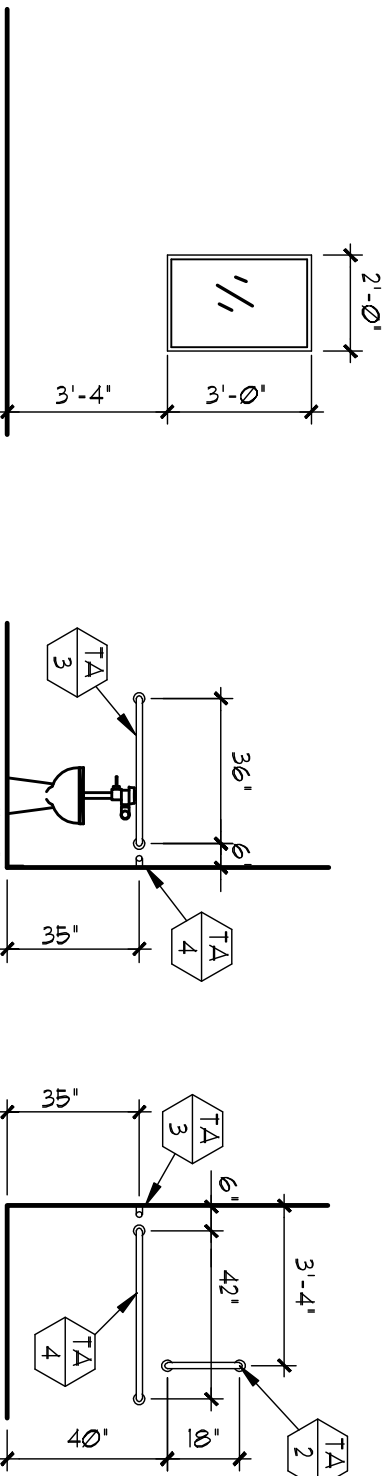


MOUNTING LOCATIONS FOR TOILET ACCESSORIES

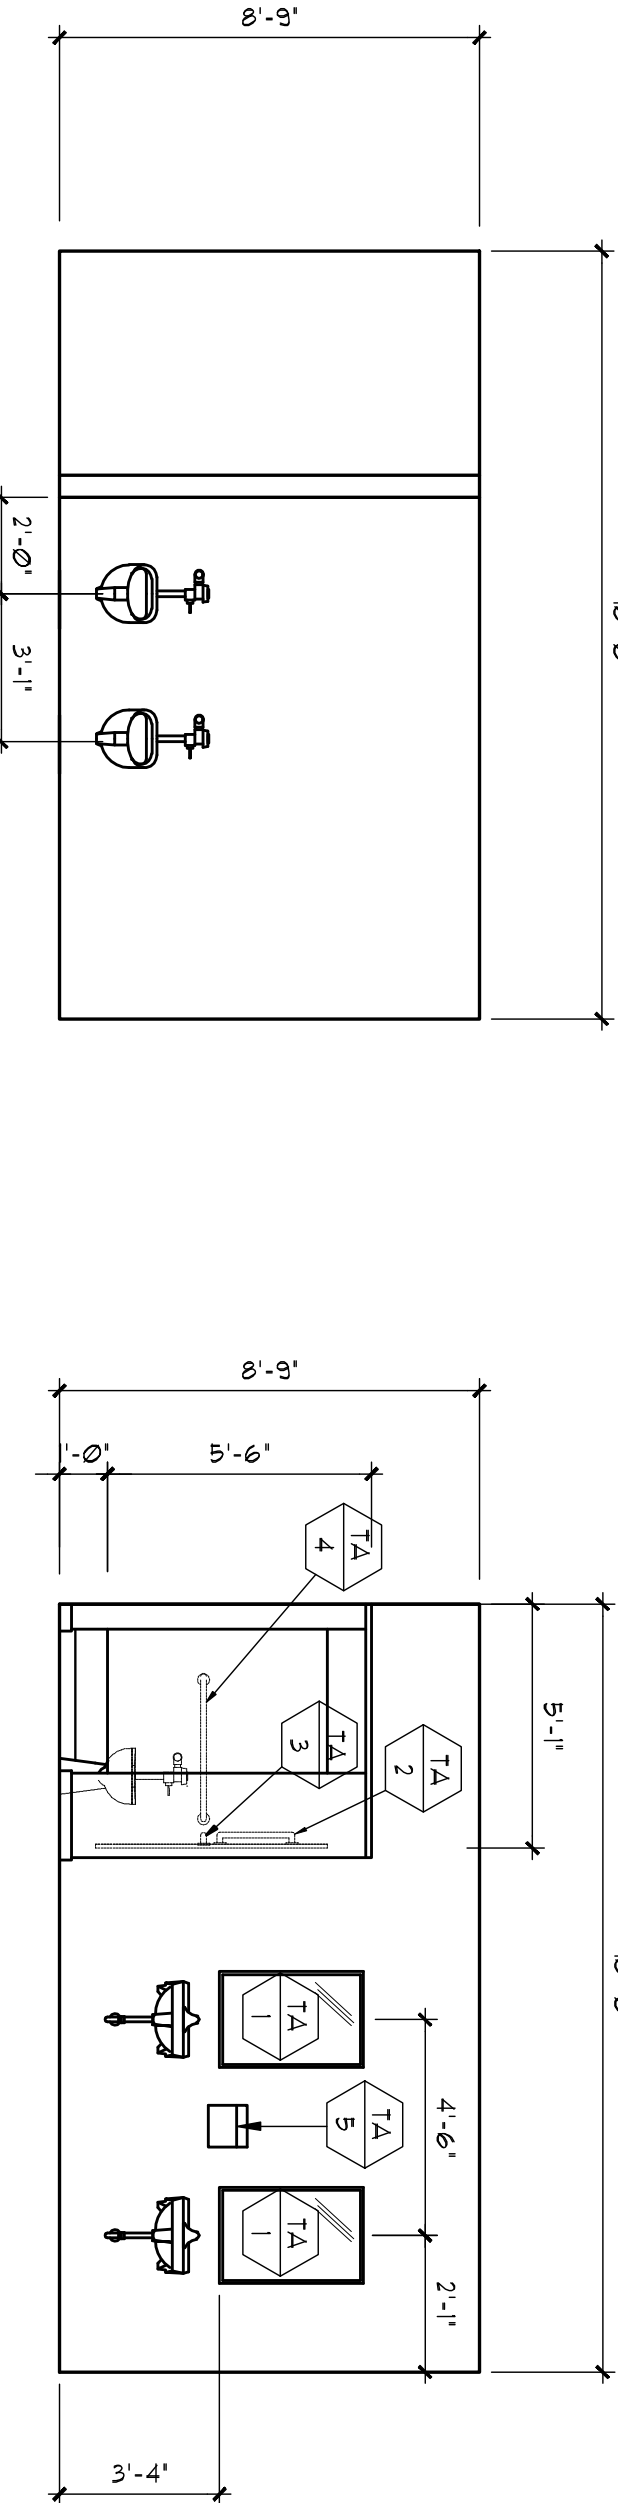


2 ELEVATION
SCALE: 1/4" = 1'-0"

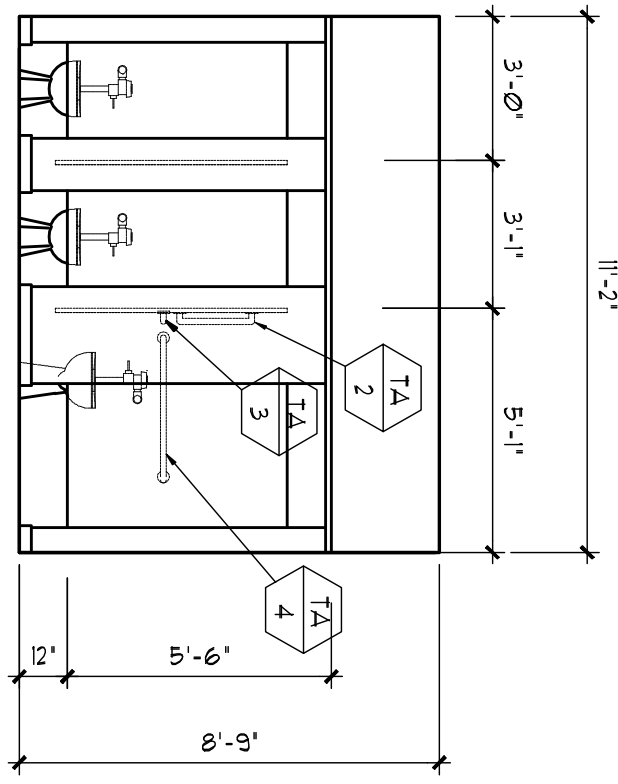

4 ELEVATION
SCALE: 1/4" = 1'-0"

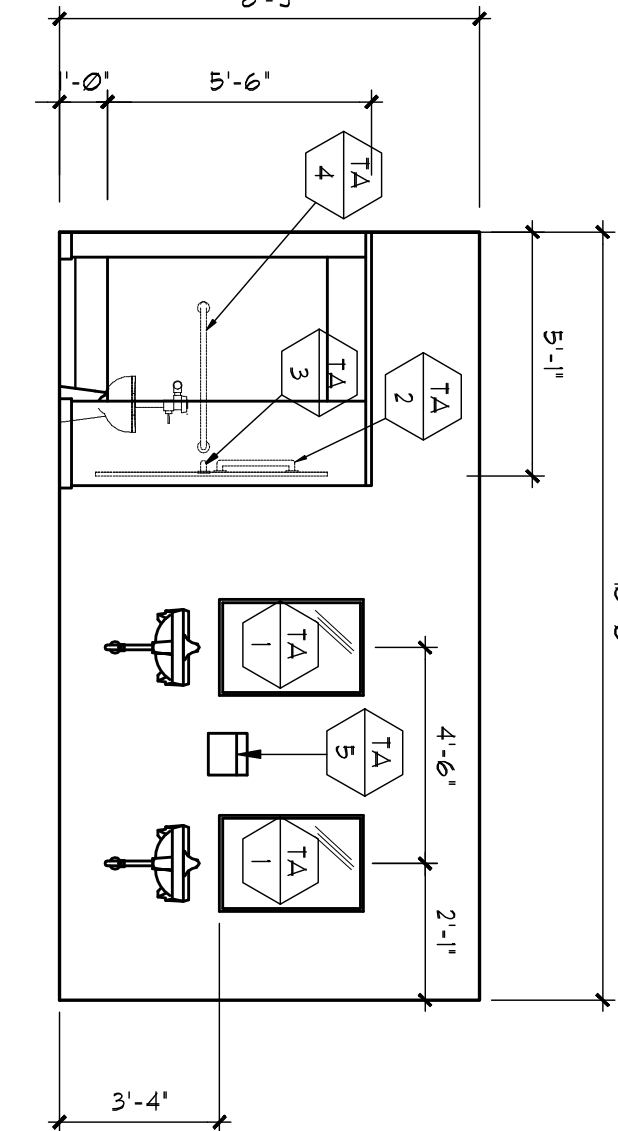

1 ELEVATION
SCALE: 1/4" = 1'-0"

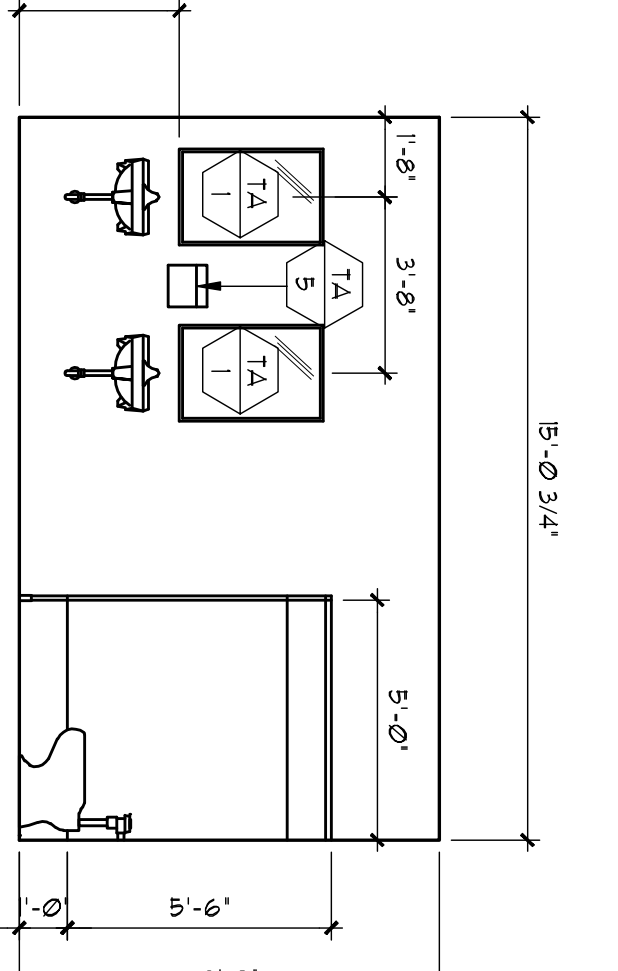

3 ELEVATION
SCALE: 1/4" = 1'-0"

INTERIOR ELEVATIONS