

INDEX TO DRAWINGS

CODE INFORMATION

C0.1 BUILDING CODE INFORMATION
C0.2 BUILDING CODE INFORMATION
C0.3 BUILDING CODE INFORMATION

SITE

C1 EXISTING TOPOGRAPHY
C2.0 SITE LAYOUT (OVERALL)
C2.0 SITE LAYOUT (OVERALL)

STRUCTURAL

S0.0 STRUCTURAL NOTES
S1.0 100 - GYM PLANS - FOUNDATION PLANS
S1.1 100 - GYM PLANS - ROOF PLANS
S1.2 200 - FIELD HOUSE PLANS
S1.3 300 - CONCESSIONS BASEBALL / SOFTBALL PLANS
S1.4 400 - BOYS LOCKER ROOM
S1.5 500 - GIRL'S LOCKER ROOM
S1.6 600 - GRANDSTAND PLANS
S1.7 700 - MISCELLANEOUS PLANS
S1.8 800 - ATHLETIC COMPLEX
S1.9 800 - ATHLETIC COMPLEX ROOF PLAN
S2.0 TYPICAL CONCRETE DETAILS + FOUNDATION SCHEDULES
S2.1 AUXILIARY GYMNASIUM ADDITION FOUNDATION SECTIONS and DETAILS
S2.2 AUXILIARY GYMNASIUM ADDITION FOUNDATION SECTIONS and DETAILS
S2.3 AUXILIARY GYMNASIUM ADDITION FOUNDATION SECTIONS and DETAILS
S2.4 AUXILIARY GYMNASIUM ADDITION FOUNDATION SECTIONS and DETAILS
S3.0 TYPICAL BAR JOIST, METAL DECK and STEEL FRAMING DETAILS STEEL BEAM SCHEDULE
S3.1 TYPICAL STEEL FRAMING DETAILS
S4.0 MASONRY HEADER BEAM SCHEDULE TYPICAL MASONRY DETAILS
S4.1 TYPICAL MASONRY DETAILS
S4.2 TYPICAL MASONRY DETAILS
S5.1 ROOF FRAMING SECTIONS and DETAILS LIGHT-GAUGE METAL TRUSSES
S5.2 ROOF FRAMING SECTIONS and DETAILS LIGHT-GAUGE METAL TRUSSES
S5.3 ROOF FRAMING SECTIONS and DETAILS ENGINEERED LUMBER - LVL
S5.4 ROOF FRAMING SECTIONS and DETAILS METAL PLATE CONNECTED WOOD TRUSSES
S6.1 ROOF FRAMING SECTIONS and DETAILS
S8.1 LIGHT-GAUGE METAL FRAMING DETAILS

ARCHITECTURAL

A0.0 GENERAL INFORMATION
A0.1 TYPICAL RESTROOM DETAILS
A0.2 TYPICAL ROOF DETAILS
A0.3 TYPICAL DETAILS
A0.4 TYPICAL CEILING DETAILS
A0.5 DOOR SCHEDULE AND DETAILS
A1.0 AUXILIARY GYMNASIUM ADDITION DEMOLITION PLANS
A1.1 AUXILIARY GYMNASIUM ADDITION FLOOR PLANS
A1.2 AUXILIARY GYMNASIUM ADDITION BUILDING ELEVATIONS
A1.3 AUXILIARY GYMNASIUM ADDITION ROOF PLAN & DETAILS
A1.4 AUXILIARY GYMNASIUM ADDITION BUILDING SECTIONS
A1.5 AUXILIARY GYMNASIUM ADDITION ENLARGED RESTROOM PLAN & DETAILS
A2.0 FIELD HOUSE NEW WORK PLANS
A2.1 FIELD HOUSE BUILDING ELEVATIONS
A2.2 FIELD HOUSE ROOF PLAN & BUILDING SECTIONS
A2.3 FIELD HOUSE REFLECTED CEILING PLAN
A3.0 CONCESSIONS NEW WORK PLANS, REFLECTED CEILING PLAN, & ROOF PLAN
A3.1 CONCESSIONS BUILDING ELEVATIONS AND SECTIONS
A4.0 BASEBALL LOCKER & DUGOUT
A4.1 BASEBALL VISITOR DUGOUT
A4.2 BASEBALL GRANDSTANDS FLOOR PLANS AND EXTERIOR ELEVATIONS
A5.0 SOFTBALL LOCKER ROOM & DUGOUT
A5.1 SOFTBALL VISITOR DUGOUT
A5.2 SOFTBALL GRANDSTANDS FLOOR PLANS AND EXTERIOR ELEVATIONS
A6.0 GRANDSTANDS DEMOLITION PLANS
A6.1 GRANDSTANDS NEW WORK PLANS
A6.2 GRANDSTANDS BUILDING ELEVATIONS & SECTIONS
A6.3 GRANDSTANDS REFLECTED CEILING PLAN & ROOF PLAN
A6.4 GRANDSTANDS FLOOR PLAN AND SECTIONS
A7.0 SOCCER GRANDSTANDS PLAN
A8.0 ATHLETIC COMPLEX DEMOLITION PLAN
A8.1 ATHLETIC COMPLEX NEW WORK PLAN
A8.2 ATHLETIC COMPLEX REFLECTED CEILING PLAN

FIRE PROTECTION

F110 AUXILIARY GYMNASIUM ADDITION - FIRE PROTECTION
F210 FIELD HOUSE - FIRE PROTECTION

PLUMBING

P001 PLUMBING LEGEND & GENERAL NOTES
P110 AUXILIARY GYMNASIUM ADDITION - SANITARY SEWER
P120 AUXILIARY GYMNASIUM ADDITION - DOMESTIC WATER
P210 FIELD HOUSE - PLUMBING

MECHANICAL

M001 MECHANICAL LEGEND & GENERAL NOTES
M110 AUXILIARY GYMNASIUM ADDITION - HVAC
M120 AUXILIARY GYMNASIUM ADDITION - HVAC
M210 FIELD HOUSE - HVAC
M220 FIELD HOUSE - HVAC
MP300 MECHANICAL AND PLUMBING LEGEND & GENERAL NOTES
MP310 CONCESSIONS - MECHANICAL & PLUMBING
MP410 BASEBALL - MECHANICAL & PLUMBING
MP510 SOFTBALL - MECHANICAL & PLUMBING
MD610 GRANDSTANDS - MECHANICAL & PLUMBING
MP610 GRANDSTANDS - MECHANICAL & PLUMBING
MD810 ATHLETICS COMPLEX DEMOLITION PLAN - MECHANICAL & PLUMBING
MP810 ATHLETICS COMPLEX PLAN - MECHANICAL & PLUMBING

ELECTRICAL

E001 GENERAL ELECTRICAL NOTES
E002 ELECTRICAL LEGEND
ED100 AUXILIARY GYMNASIUM ADDITION - ELECTRICAL DEMOLITION
E110 AUXILIARY GYMNASIUM ADDITION - LIGHTING
E120 AUXILIARY GYMNASIUM ADDITION - POWER AND SYSTEMS
E210 FIELD HOUSE - ELECTRICAL
E310 CONCESSIONS - ELECTRICAL
E410 BASEBALL - ELECTRICAL
E510 SOFTBALL - ELECTRICAL
E610 GRANDSTANDS - ELECTRICAL
ED810 ATHLETICS COMPLEX DEMOLITION PLAN - ELECTRICAL
E810 ATHLETICS COMPLEX PLAN - ELECTRICAL
E901 ELECTRICAL DETAILS
E902 ELECTRICAL DETAILS
E903 ELECTRICAL DETAILS

ALLEN COUNTY - SCOTTSVILLE HIGH SCHOOL ATHLETIC COMPLEX

1545 BOWLING GREEN RD, SCOTTSVILLE, KY 42164

BG# 25-250

DESIGN DEVELOPMENT DOCUMENTS

DECEMBER 15, 2025

OWNER:

ALLEN COUNTY BOARD OF EDUCATION

570 W OLIVER ST, SCOTTSVILLE, KY 42164

SCB PROJECT NUMBER: 2459

TRAVIS HAMBY - SUPERINTENDENT
BRIAN CELSOR - BOARD CHAIRMAN
AL BARMAN - BOARD VICE CHAIRMAN
STACY COFFEY - BOARD MEMBER
BERLINDA BAZZELL - BOARD MEMBER
BILLY TURNER - BOARD MEMBER



SHERMAN CARTER BARNHART ARCHITECTS, PLLC

144 TURNER COMMONS WAY
SUITE 110
LEXINGTON, KY 40508
PHONE: 859.224.1351

www.scbarchitects.com

MECHANICAL/ELECTRICAL ENGINEER

SHROUT TATE WILSON
CONSULTING ENGINEERS
628 WINCHESTER RD.
LEXINGTON, KY 40505
P (859) 277-8177 F (859) 277-8372

CIVIL ENGINEER

 
 
 
 
ARNOLD CONSULTING ENGINEERING SERVICES, INC.
1136 S PARK DRIVE, UNIT 201
BOWLING GREEN, KY 42103
P (270) 780-9445

CONSTRUCTION MANAGER

ALLIANCE CORPORATION
116 E. COLLEGE ST.
GLASGOW, KY 42141
P (270) 651-8848 F (270) 651-2915


STRUCTURAL ENGINEER

SHERMAN CARTER BARNHART
9300 SHELBYVILLE ROAD, SUITE #502
LOUISVILLE, KY 40222
P (502) 721-6100 F (859) 721-6111



GENERAL INFORMATION :

CODE: KENTUCKY BUILDING CODE (2018, 3RD EDITION)
USE GROUP: E / A-3
CAPACITY: REFER TO OCCUPANCY CALCULATIONS
CONSTRUCTION TYPE: TYPE II B (NON-COMBUSTIBLE)
FIRE PROTECTION: SPRINKLERED
FIRE BARRIERS: (SEE MINIMUM FIRE RESISTANCE RATINGS, IF ANY, THIS SHEET)
DEAD END CORRIDORS: 50 FEET MAX, OR LESS THAN 2.5 TIMES LEAST CORRIDOR WIDTH (SECTION 1018.4; EXCEPTIONS 2 & 3)
COMMON PATH OF EGRESS TRAVEL: 75 FEET MAX (SECTION 1014.3)

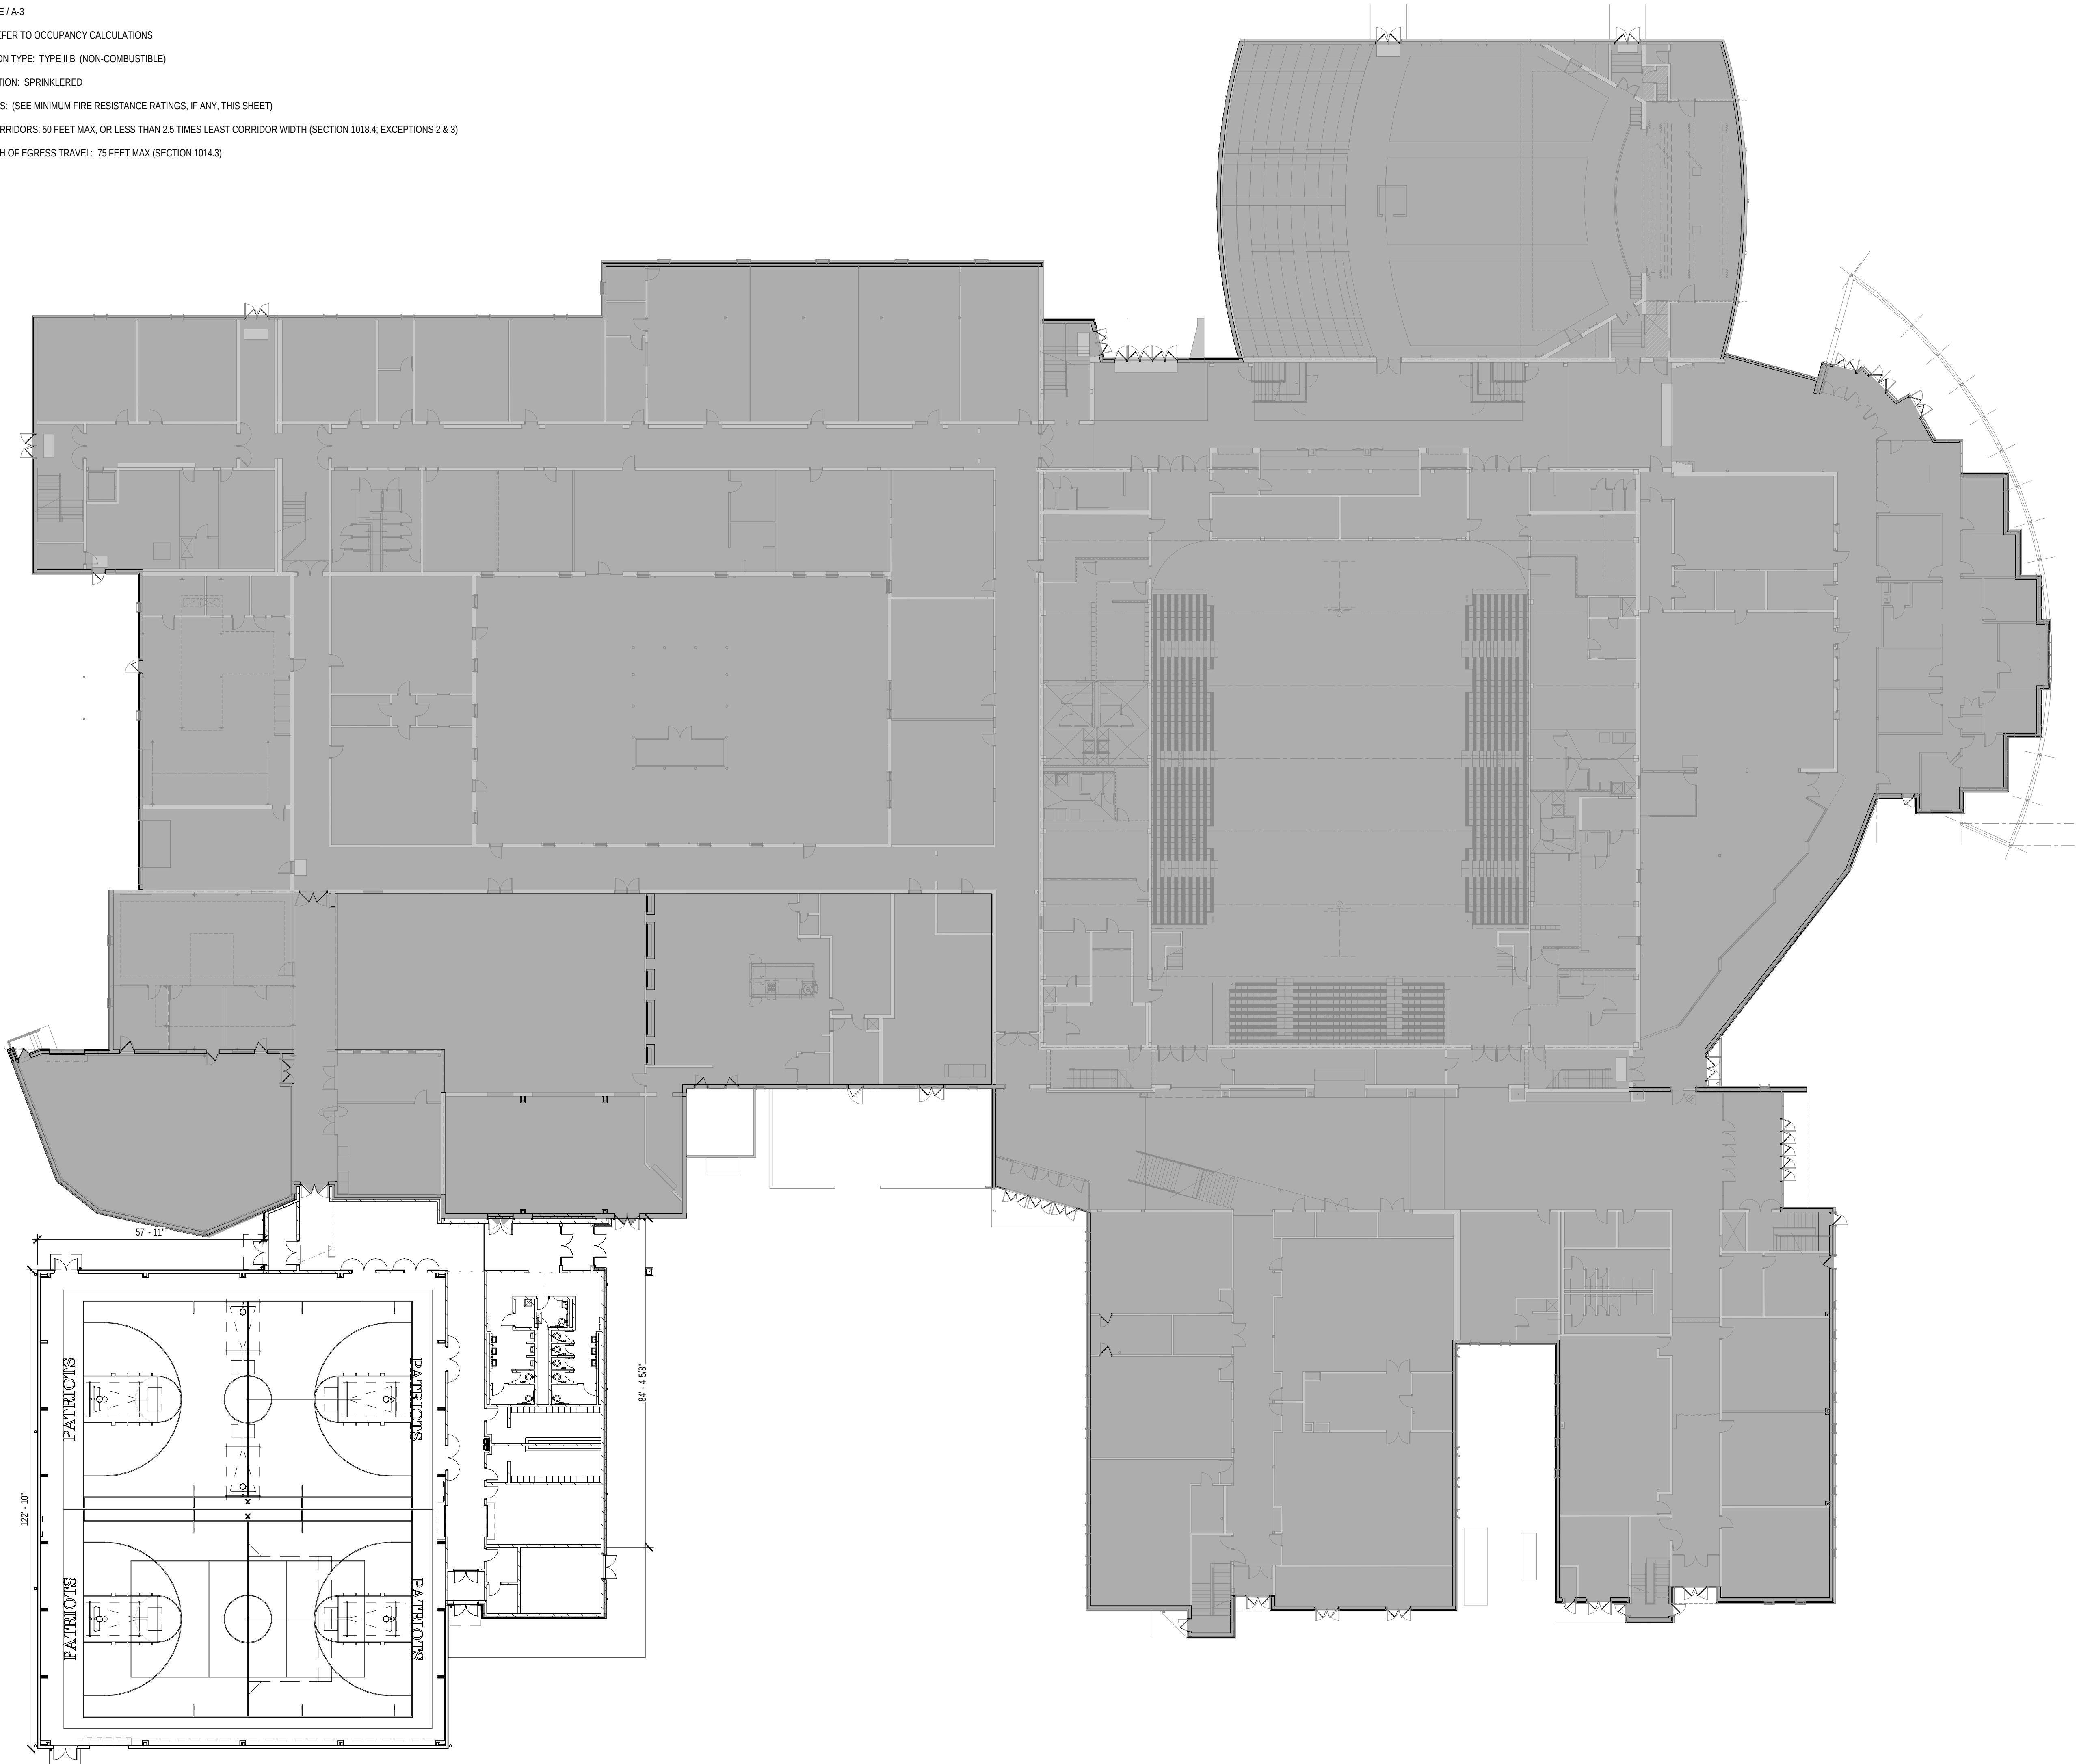

BUILDING HEIGHT CALCULATIONS :

ALLOWABLE HEIGHT = 3 STORIES / 75'-0" (PER TABLE 504.3 AND 504.4)
ACTUAL BUILDING HEIGHT = 1 STORY / 23'-6"

ALLOWABLE AREA CALCULATIONS :

FRONTAGE INCREASE: $I_f = \left[\frac{E}{P} - 25 \right] \frac{30}{80}$
 $I_f = \left[\frac{2,210.875}{2579.19} - 25 \right] \frac{30}{80}$
 $I_f = 0.607$
SPRINKLER INCREASE: $I_s = 200\%$
ALLOWABLE AREA PER STORY: $A_1 = 43,500$ SQ. FT. (PER TABLE 506.2)
ALLOWABLE AREA TOTAL: $A_a = A_1 + [A_1 \times I_f] + [A_1 \times I_s]$
 $A_a = 43,500 + [43,500 \times 0.607] + [43,500 \times 2]$
 $A_a = 43,500 + 26,404.5 + 87,000$
 $A_a = 156,904.5$ SQUARE FEET (TOTAL ALLOWABLE) / FLOOR

ACTUAL AREA CALCULATIONS:

(TOTAL TABULATIONS PER FLOOR PLAN ABOVE)

AREA EXISTING FIRST FLOOR: 125,183 SQ. FT.
AREA NEW ADDITION: 15,394 SQ. FT.
TOTAL AREA FIRST FLOOR: 140,577 SQ. FT.

AUX GYM ASSEMBLY AREAS OCCUPANT LOADS :

EXERCISE ROOMS / LOCKER ROOMS
50 SF PER OCCUPANT (TABLE 1004.1.2)
MAXIMUM CALCULATED OCCUPANCY = 307 OCCUPANTS FOR 11,025 SQ. FT.


JOB NO.	2459
DATE	12/15/2025
DRAWN	CAH
CHECKED	RJV, ASC

COPYRIGHT © 2025
SHERMAN CARTER BARNHART
ARCHITECTS, PLLC

REVISIONS		
No.	Description	Date

SHEET

GENERAL INFORMATION :
CODE: KENTUCKY BUILDING CODE (2018, 3RD EDITION)
USE GROUP: E / A-3
CAPACITY: REFER TO OCCUPANCY CALCULATIONS
CONSTRUCTION TYPE: TYPE II B (NON-COMBUSTIBLE)
FIRE PROTECTION: SPRINKLERED
FIRE BARRIERS: (SEE MINIMUM FIRE RESISTANCE RATINGS, IF ANY, THIS SHEET)
DEAD END CORRIDORS: 50 FEET MAX. OR LESS THAN 2.5 TIMES LEAST CORRIDOR WIDTH (SECTION 1018.4, EXCEPTIONS 2 & 3)
COMMON PATH OF EGRESS TRAVEL: 75 FEET MAX (SECTION 1014.3)

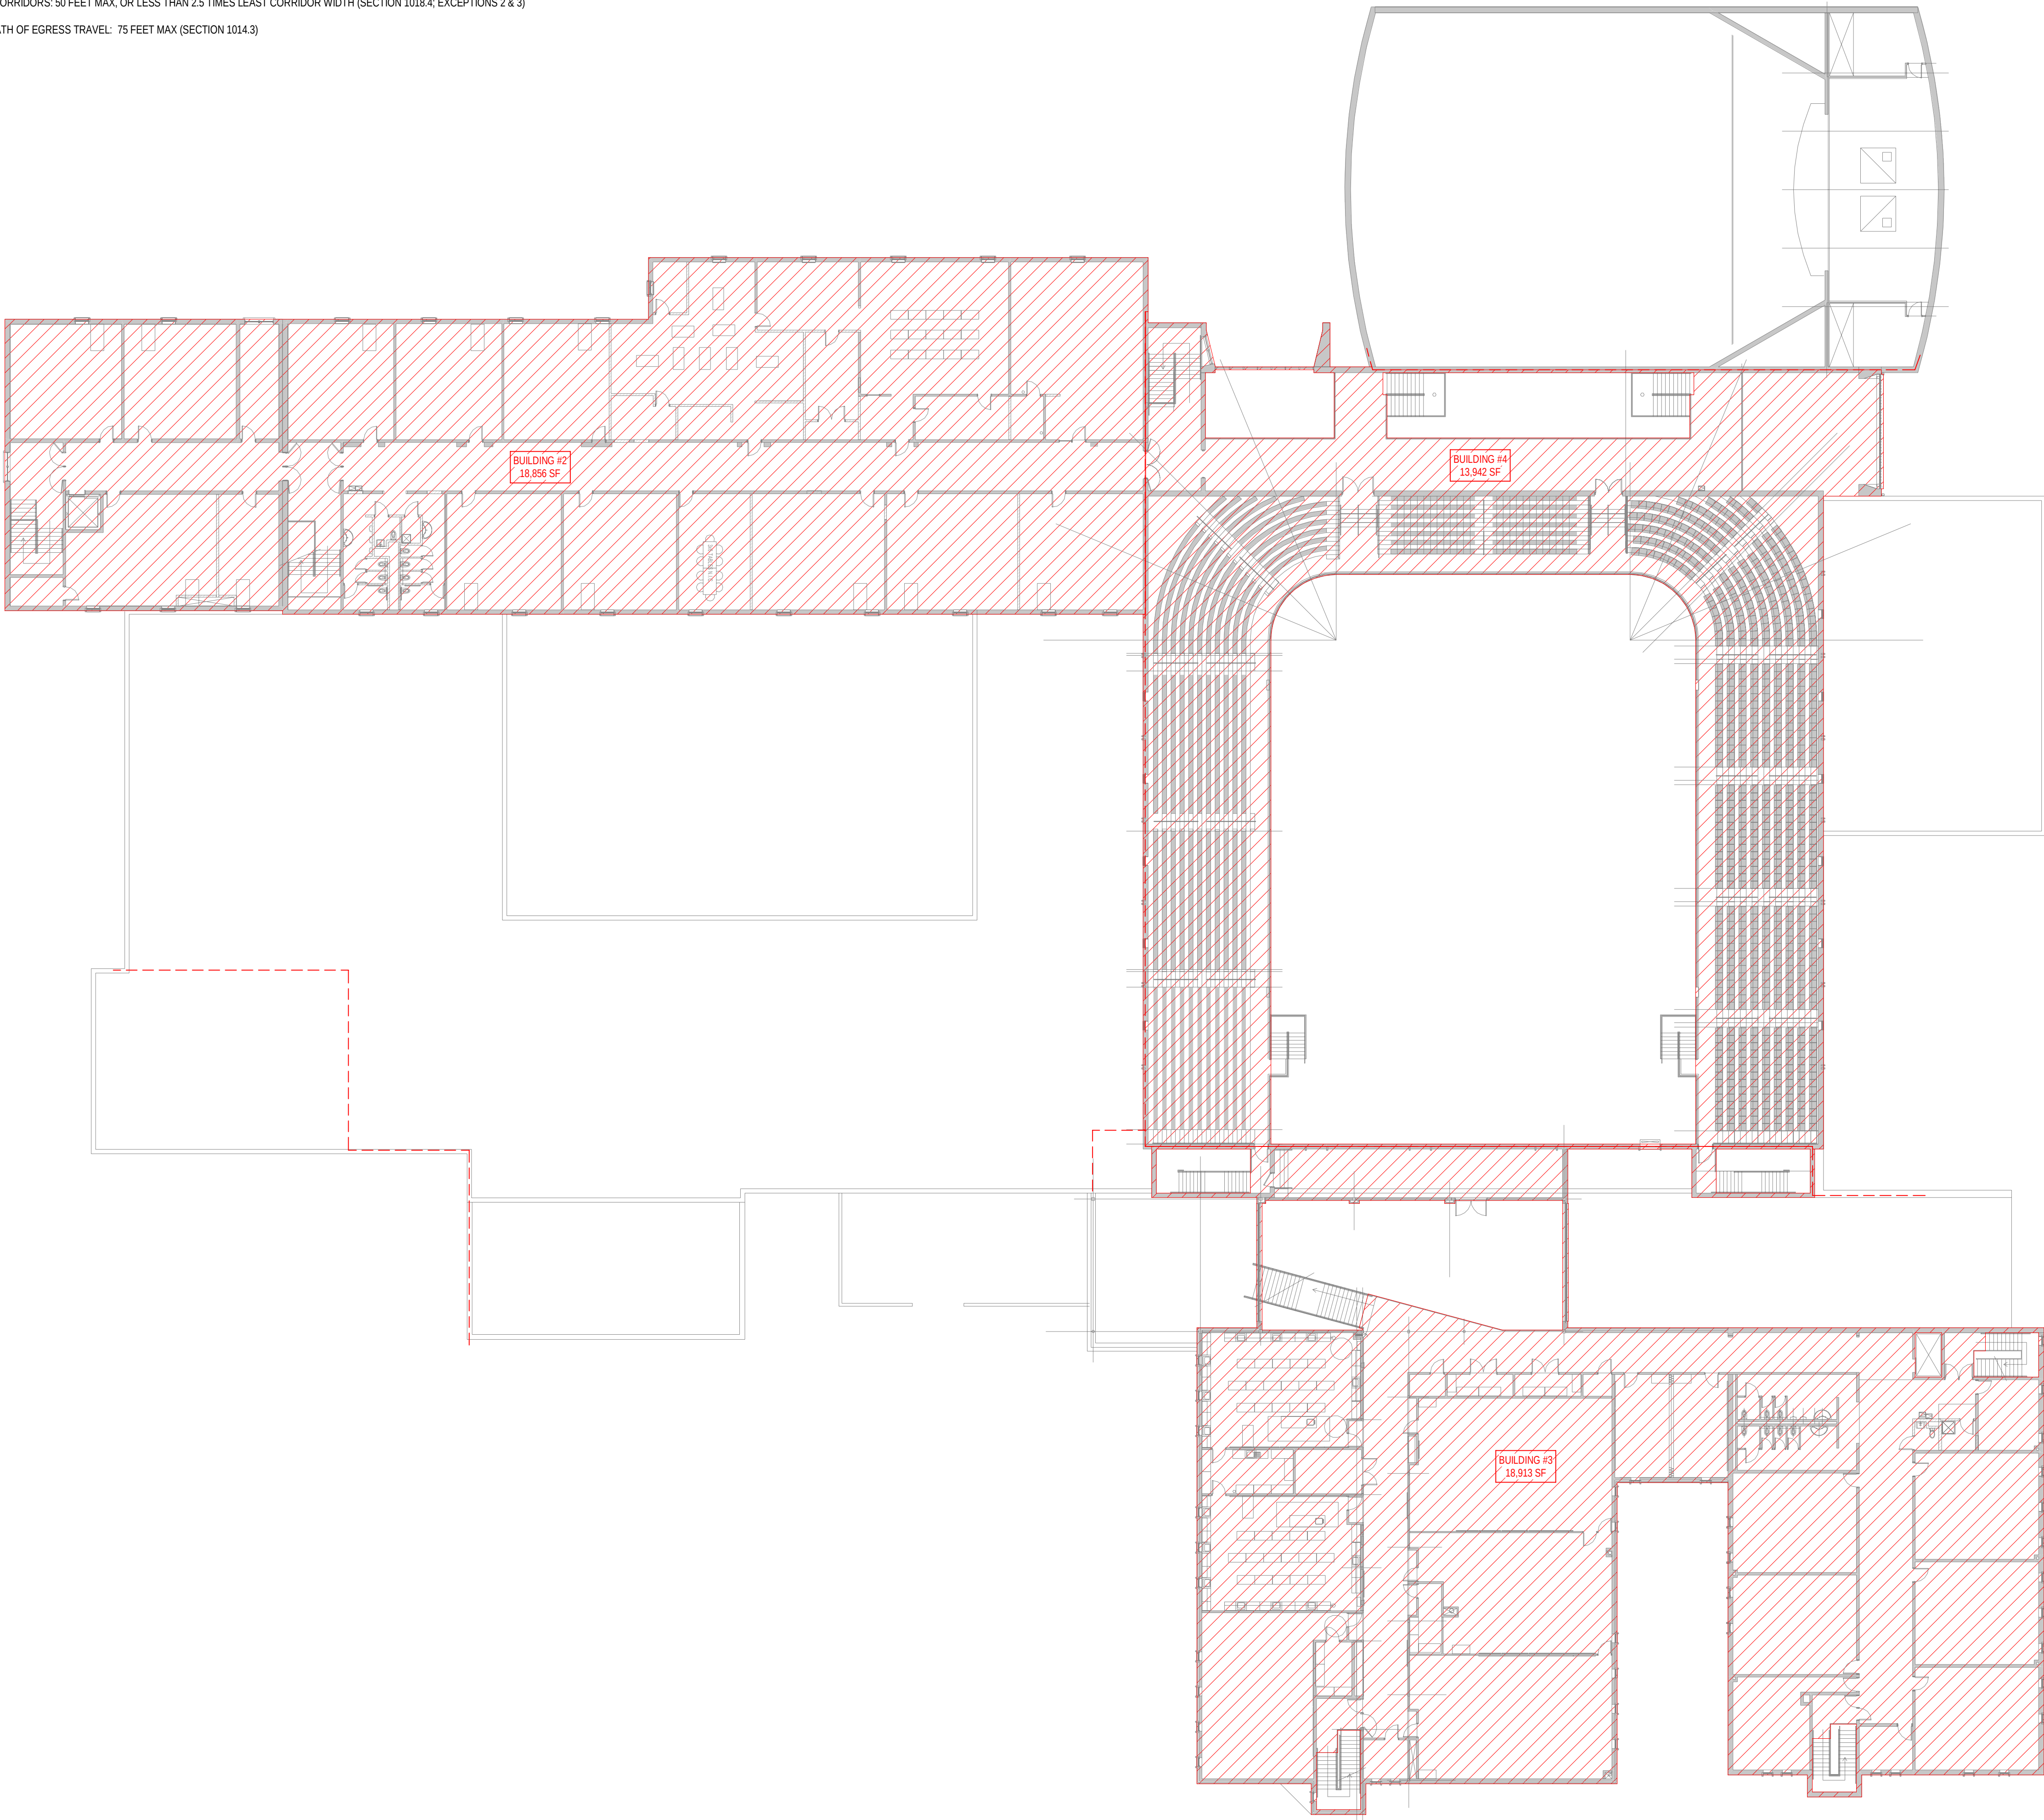

BUILDING HEIGHT CALCULATIONS :

ALLOWABLE HEIGHT = 3 STORIES / 75'-0" (PER TABLE 504.3 AND 504.4)
ACTUAL BUILDING HEIGHT = 1 STORY / 23'-6"

ALLOWABLE AREA CALCULATIONS :

FRONTAGE INCREASE: $I_f = \left[\frac{F}{P} - 25 \right] \frac{30}{30}$
 $I_f = \left[\frac{2,210.975}{2,579.19} - 25 \right] \frac{30}{30}$
 $I_f = 0.607$
SPRINKLER INCREASE: $I_s = 200\%$

ALLOWABLE AREA PER STORY: $A_1 = 43,500$ SQ. FT. (PER TABLE 506.2)
ALLOWABLE AREA TOTAL: $A_a = A_1 + [A_1 \times I_f] + [A_1 \times I_s]$
ALLOWABLE AREA TOTAL: $A_a = 43,500 + [43,500 \times 0.607] + [43,500 \times 2]$

$A_a = 43,500 + 26,404.5 + 87,000$
 $A_a = 156,904.5$ SQUARE FEET (TOTAL ALLOWABLE) / FLOOR

100 - SECOND FLOOR PLAN

1" = 20'-0"

ACTUAL AREA CALCULATIONS:

(TOTAL TABULATIONS PER FLOOR PLAN ABOVE)

AREA EXISTING FIRST FLOOR: 125,183 SQ. FT.

AREA NEW ADDITION: 15,394 SQ. FT.

TOTAL AREA FIRST FLOOR: 140,577 SQ. FT.

AUX GYM ASSEMBLY AREAS OCCUPANT LOADS :

EXERCISE ROOMS / LOCKER ROOMS
50 SF PER OCCUPANT (TABLE 1004.1.2)
MAXIMUM CALCULATED OCCUPANCY = 307 OCCUPANTS FOR 11,025 SQ. FT.

JOB NO.	2459
DATE	12/15/2025
DRAWN	Author
CHECKED	RJV, ASC

COPYRIGHT © 2025
SHERMAN CARTER BARNHART
ARCHITECTS, PLLC

REVISIONS

No.	Description	Date

SHEET

200 - FIELD HOUSE

GENERAL INFORMATION :

CODE: KENTUCKY BUILDING CODE (2018, 3RD EDITION)

USE GROUP: UNSEPARATED MIXED USE A-3/B (A-3 GOVERNS)



CONSTRUCTION TYPE: TYPE II B (NON-COMBUSTIBLE)

FIRE PROTECTION: SINKERLED

FIRE BARRIERS: (SEE MINIMUM FIRE RESISTANCE RATINGS, IF ANY, THIS SHEET)

DEAD END CORRIDORS: 50 FEET MAX, OR LESS THAN 2.5 TIMES LEAST CORRIDOR WIDTH (SECTION 1018.4, EXCEPTIONS 2 & 3)

COMMON PATH OF EGRESS TRAVEL: 75 FEET MAX (SECTION 1014.3)

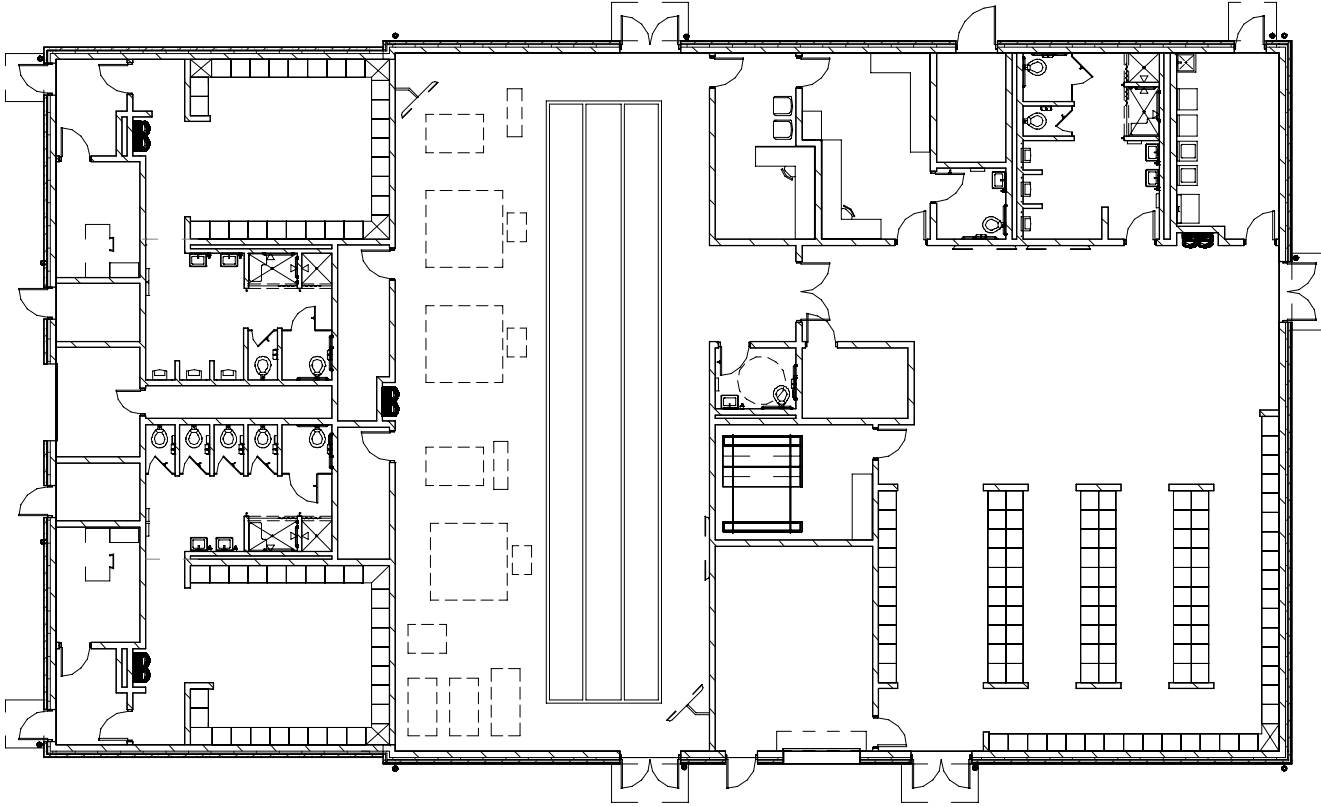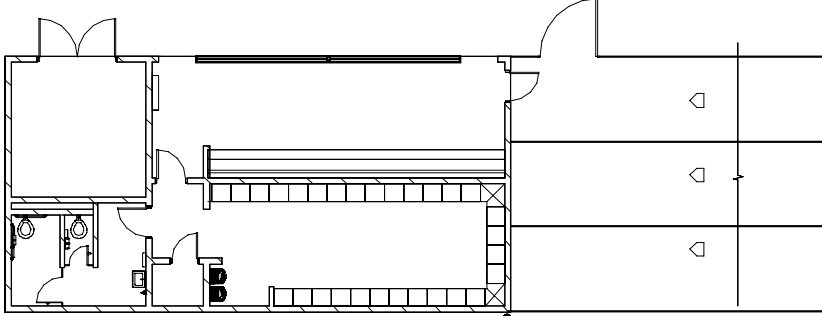

BUILDING HEIGHT CALCULATIONS :

<u>ALLOWABLE HEIGHT</u>	= 2 STORIES / 55'-0" (PER TABLE 504.3 AND 504.4)
<u>ACTUAL BUILDING HEIGHT</u>	= 1 STORY / 23'-6"

ALLOWABLE AREA :	ACTUAL AREA :
ALLOWABLE AREA PER STORY : A1 = 38,000 SF (PER TABLE 503)	(TOTAL TABULATIONS PER FLOOR PLAN ABOVE)
	AREA FIRST LEVEL: 9,620 SF

FIELDHOUSE ASSEMBLY AREAS OCCUPANT LOAD

EXERCISE ROOMS / LOCKER ROOMS
50 SF PER OCCUPANT (TABLE 1004.1.2)
MAXIMUM CALCULATED OCCUPANCY = 178 OCCUPANTS FOR 8,934 SF

300 - CONCESSIONS

GENERAL INFORMATION :

CODE: KENTUCKY BUILDING CODE (2018, 3RD EDITION)

USE GROUP: U


CONSTRUCTION TYPE: TYPE II B (NON-COMBUSTIBLE)

FIRE PROTECTION: NON-SPRINKLERED

FIRE BARRIERS: (SEE MINIMUM FIRE RESISTANCE RATINGS, IF ANY, THIS SHEET)

DEAD END CORRIDORS: 50 FEET MAX, OR LESS THAN 2.5 TIMES LEAST CORRIDOR WIDTH (SECTION 1018.4, EXCEPTIONS 2 & 3)

COMMON PATH OF EGRESS TRAVEL: 75 FEET MAX (SECTION 1014.3)

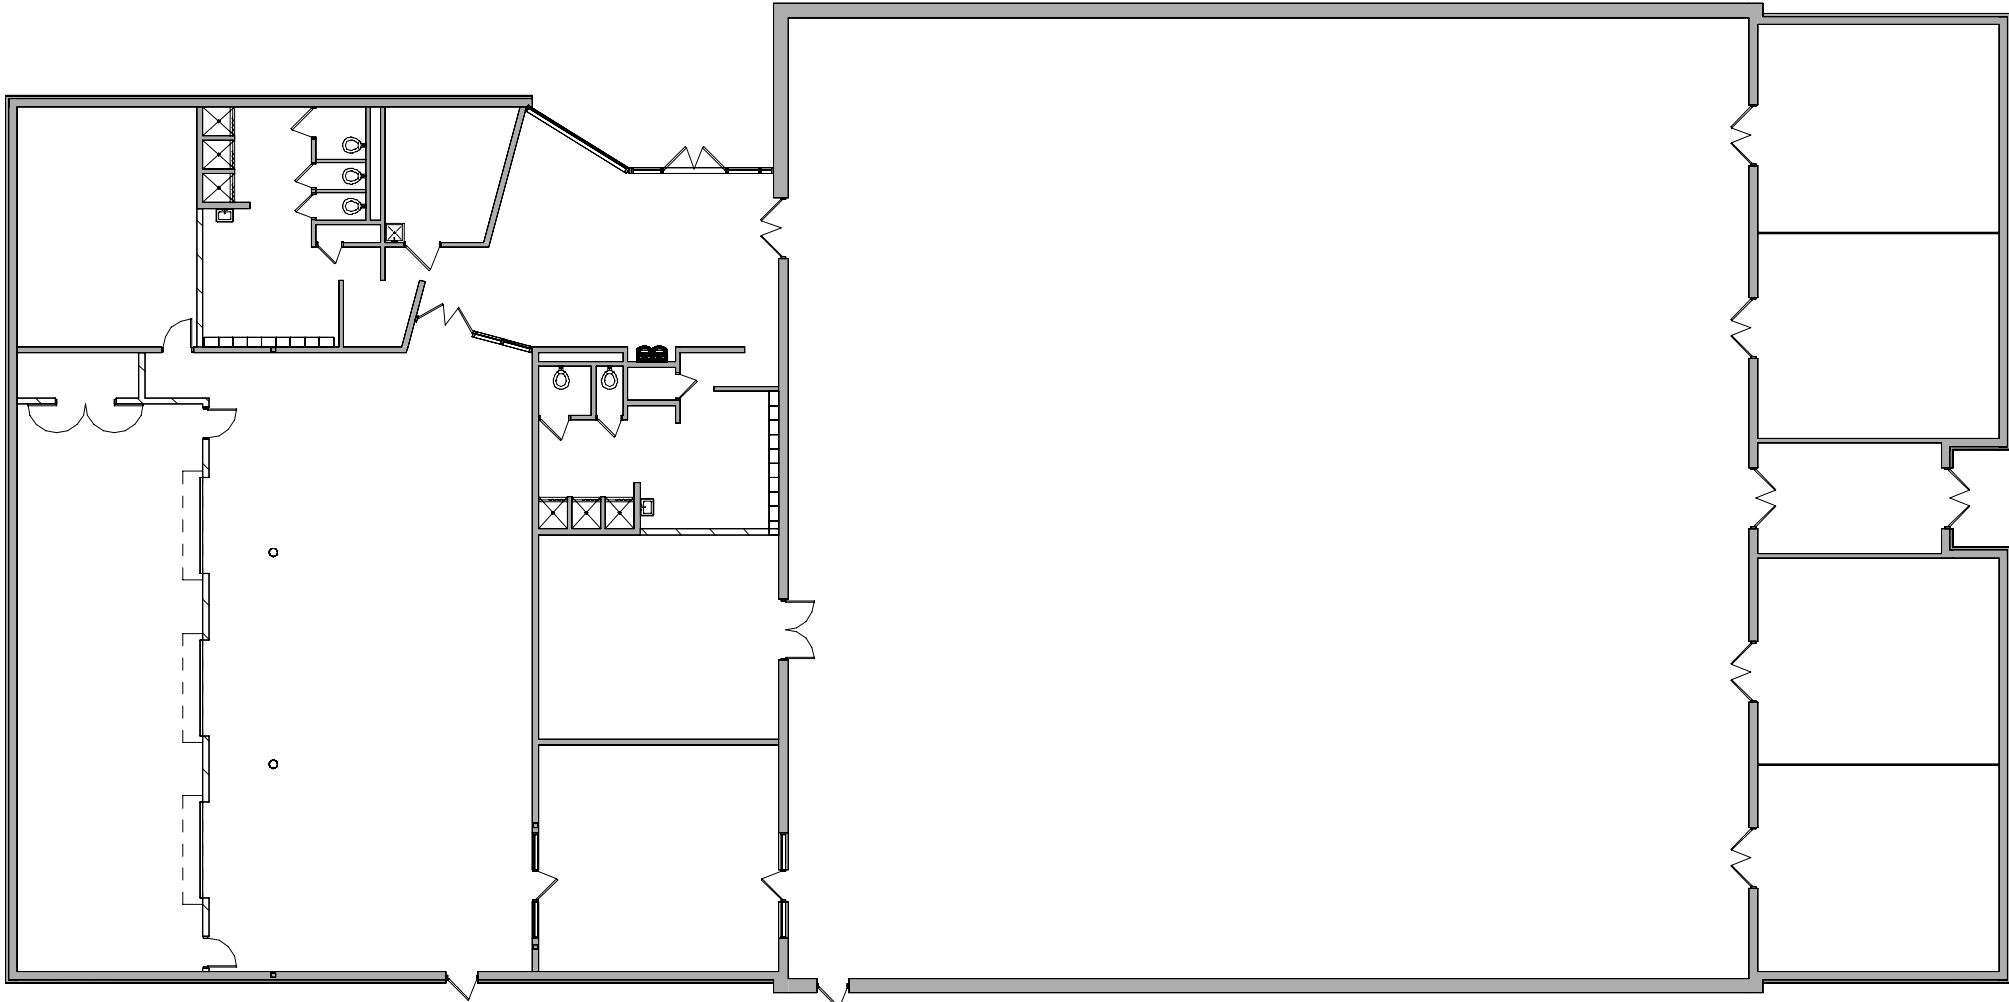

BUILDING HEIGHT CALCULATIONS :

<u>ALLOWABLE HEIGHT</u>	= 2 STORIES / 55'-0" (PER TABLE 503: TYPE III B)
<u>ACTUAL BUILDING HEIGHT</u>	= 1 STORY / 23'-6"

ALLOWABLE AREA :	ACTUAL AREA :
ALLOWABLE AREA PER STORY : A1 = 8,500 SQ.FT. (PER TABLE 506.2)	(TOTAL TABULATIONS PER FLOOR PLAN ABOVE)
	AREA FIRST LEVEL: 1,350 SQ.FT.

The architectural floor plan illustrates the interior layout of the National Stadium. The plan is divided into several sections by structural walls and columns. On the left side, there are two long, narrow seating areas, each labeled "800 BLEACHER SEATS". In the center, there is a large, rectangular area labeled "61 BLEACHER SEATS". To the right of this central area, there is a smaller, irregularly shaped section labeled "176 CHAIR SEATS". The plan also shows various structural details, including columns, walls, and a complex network of lines representing the seating arrangement and structural elements.

400 - BASEBALL

GENERAL INFORMATION :

CODE: KENTUCKY BUILDING CODE (2013, 4TH EDITION)

USE GROUP: A-3

CAPACITY: REFER TO OCCUPANCY CALCULATIONS


CONSTRUCTION TYPE: TYPE II-B (NON-COMBUSTIBLE)

FIRE PROTECTION: NON-SPRINKLERED

FIRE BARRIERS: (SEE MINIMUM FIRE RESISTANCE RATINGS, IF ANY, THIS SHEET)

DEAD END CORRIDORS: 50 FEET MAX, OR LESS THAN 2.5 TIMES LEAST CORRIDOR WIDTH (SECTION 1013.4; EXCEPTIONS 2 & 3)


COMMON PATH OF EGRESS TRAVEL: 75 FEET MAX (SECTION 1014.3)

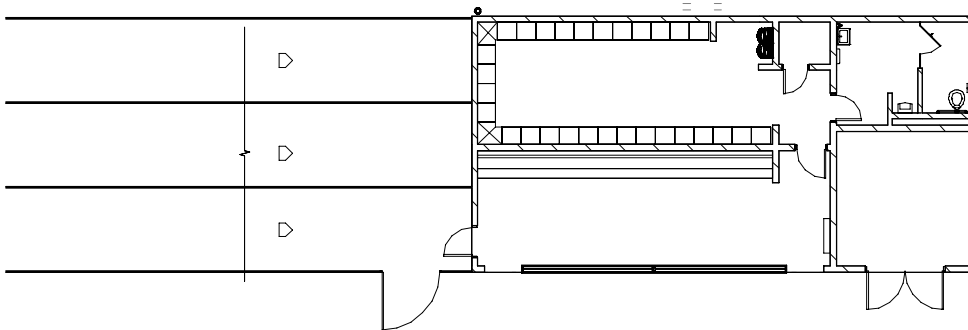

BUILDING HEIGHT CALCULATIONS :

<u>ALLOWABLE HEIGHT</u>	= 2 STORIES / 55'-0" (PER TABLE 503: TYPE II B)
<u>ACTUAL BUILDING HEIGHT</u>	= 1 STORY / 23'-6"

ALLOWABLE AREA :	ACTUAL AREA :
ALLOWABLE AREA PER STORY : A1 = 8,500 SQ.FT. (PER TABLE 506.2)	(TOTAL TABULATIONS PER FLOOR PLAN ABOVE)
	AREA FIRST LEVEL: 1,765 SQ.FT.

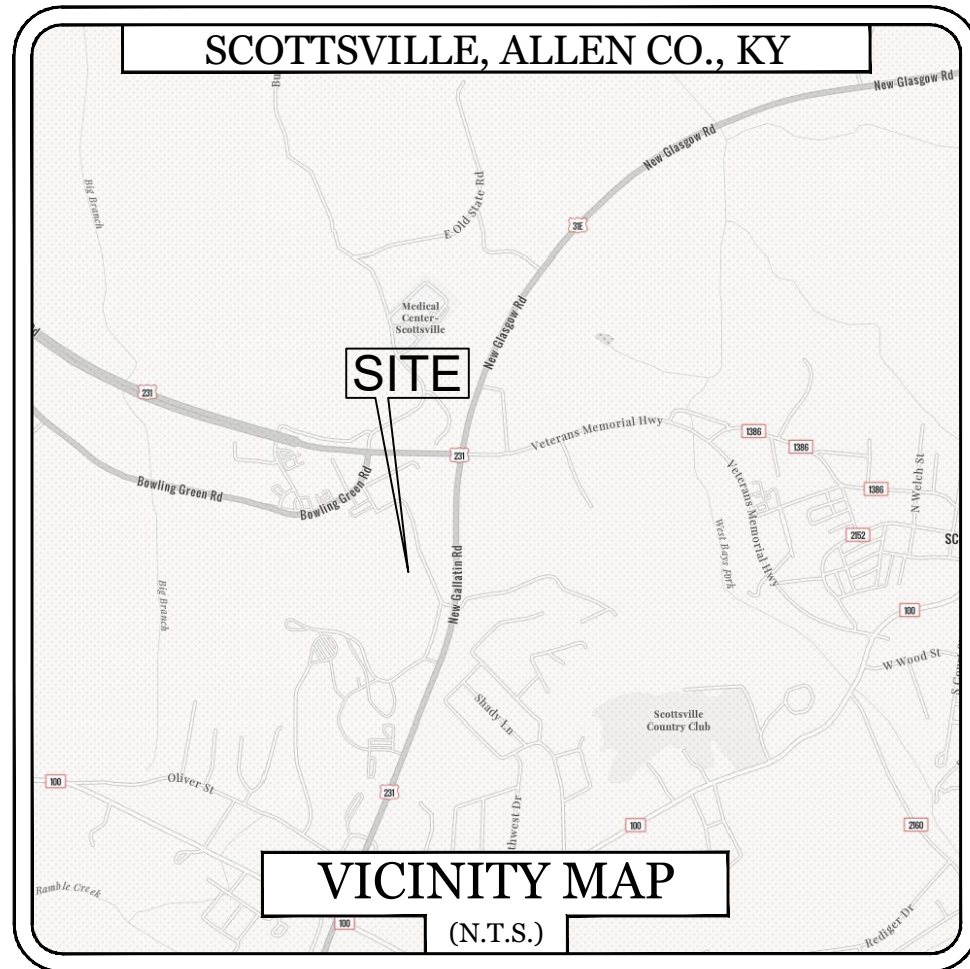

FLOODPLAIN INFORMATION

THE PROPERTY SHOWN HEREON DOES NOT LIE IN A FLOOD PRONE AREA ACCORDING TO (FIRM) FLOOD INSURANCE RATE MAP FOR ALLEN COUNTY, KENTUCKY. SAID AREA IS SHOWN ON MAP #21003C0140C & 21003C0255C, WITH AN EFFECTIVE DATE OF JULY 4, 2011.

COPYRIGHTS AND DISCLAIMERS

THE COPYRIGHTS TO ALL DESIGNS AND DRAWINGS ARE THE PROPERTY OF ACES. REPRODUCTION OR USE FOR ANY PURPOSE OTHER THAN THAT AUTHORIZED BY ACES IS FORBIDDEN.

ACES ASSUMES NO RESPONSIBILITY FOR DATA SUPPLIED IN AN ELECTRONIC FORMAT. DATA IS PROVIDED ELECTRONICALLY AS A CONVENIENCE AND THE RECIPIENT IS RESPONSIBLE FOR VERIFYING ACCURACY TO THE HARD COPY OF THE CURRENT DESIGN DRAWINGS WHICH HAVE BEEN SEALED AND SIGNED. IN THE EVENT OF INCONSISTENCIES BETWEEN THE ELECTRONIC AND THE HARD COPY DATA, THE RECIPIENT IS RESPONSIBLE FOR OBTAINING CLARIFICATION ON WHICH PREVAILS.

THE RECIPIENT RELEASES ACES, ITS EMPLOYEES, CONSULTANTS AND AGENTS FROM ANY AND ALL CLAIMS ARISING IN ANY WAY FROM THE CONTENT OR PROVISION OF THE ELECTRONIC DATA.


NOTHING SHALL REDUCE OR DIMINISH ACES'S OWNERSHIP OF OR COPYRIGHT IN THE DATA OR ITS COMPILATION OR ARRANGEMENT. ANY ANALYSIS, SOFTWARE OR FORMATTING IN THE ELECTRONIC DATA IS CONSIDERED PROPERTY OF ACES.

THE RECIPIENT OF ELECTRONIC DATA IS PROHIBITED FROM REDISTRIBUTING OR USING ANY DESIGN OR DRAWING INFORMATION WITHIN THE FILES FOR ANY REASON OTHER THAN IT WAS ORIGINALLY DESIGNED WITHOUT THE WRITTEN CONSENT OF ACES.

BENCHMARK DATA:

BENCHMARK 1
MAGNAIL
N: 1793205.31
E: 1503785.27
ELEV: 756.82'

BENCHMARK 2
MAGNAIL
N: 1792672.53
E: 1504001.98
ELEV: 773.71'

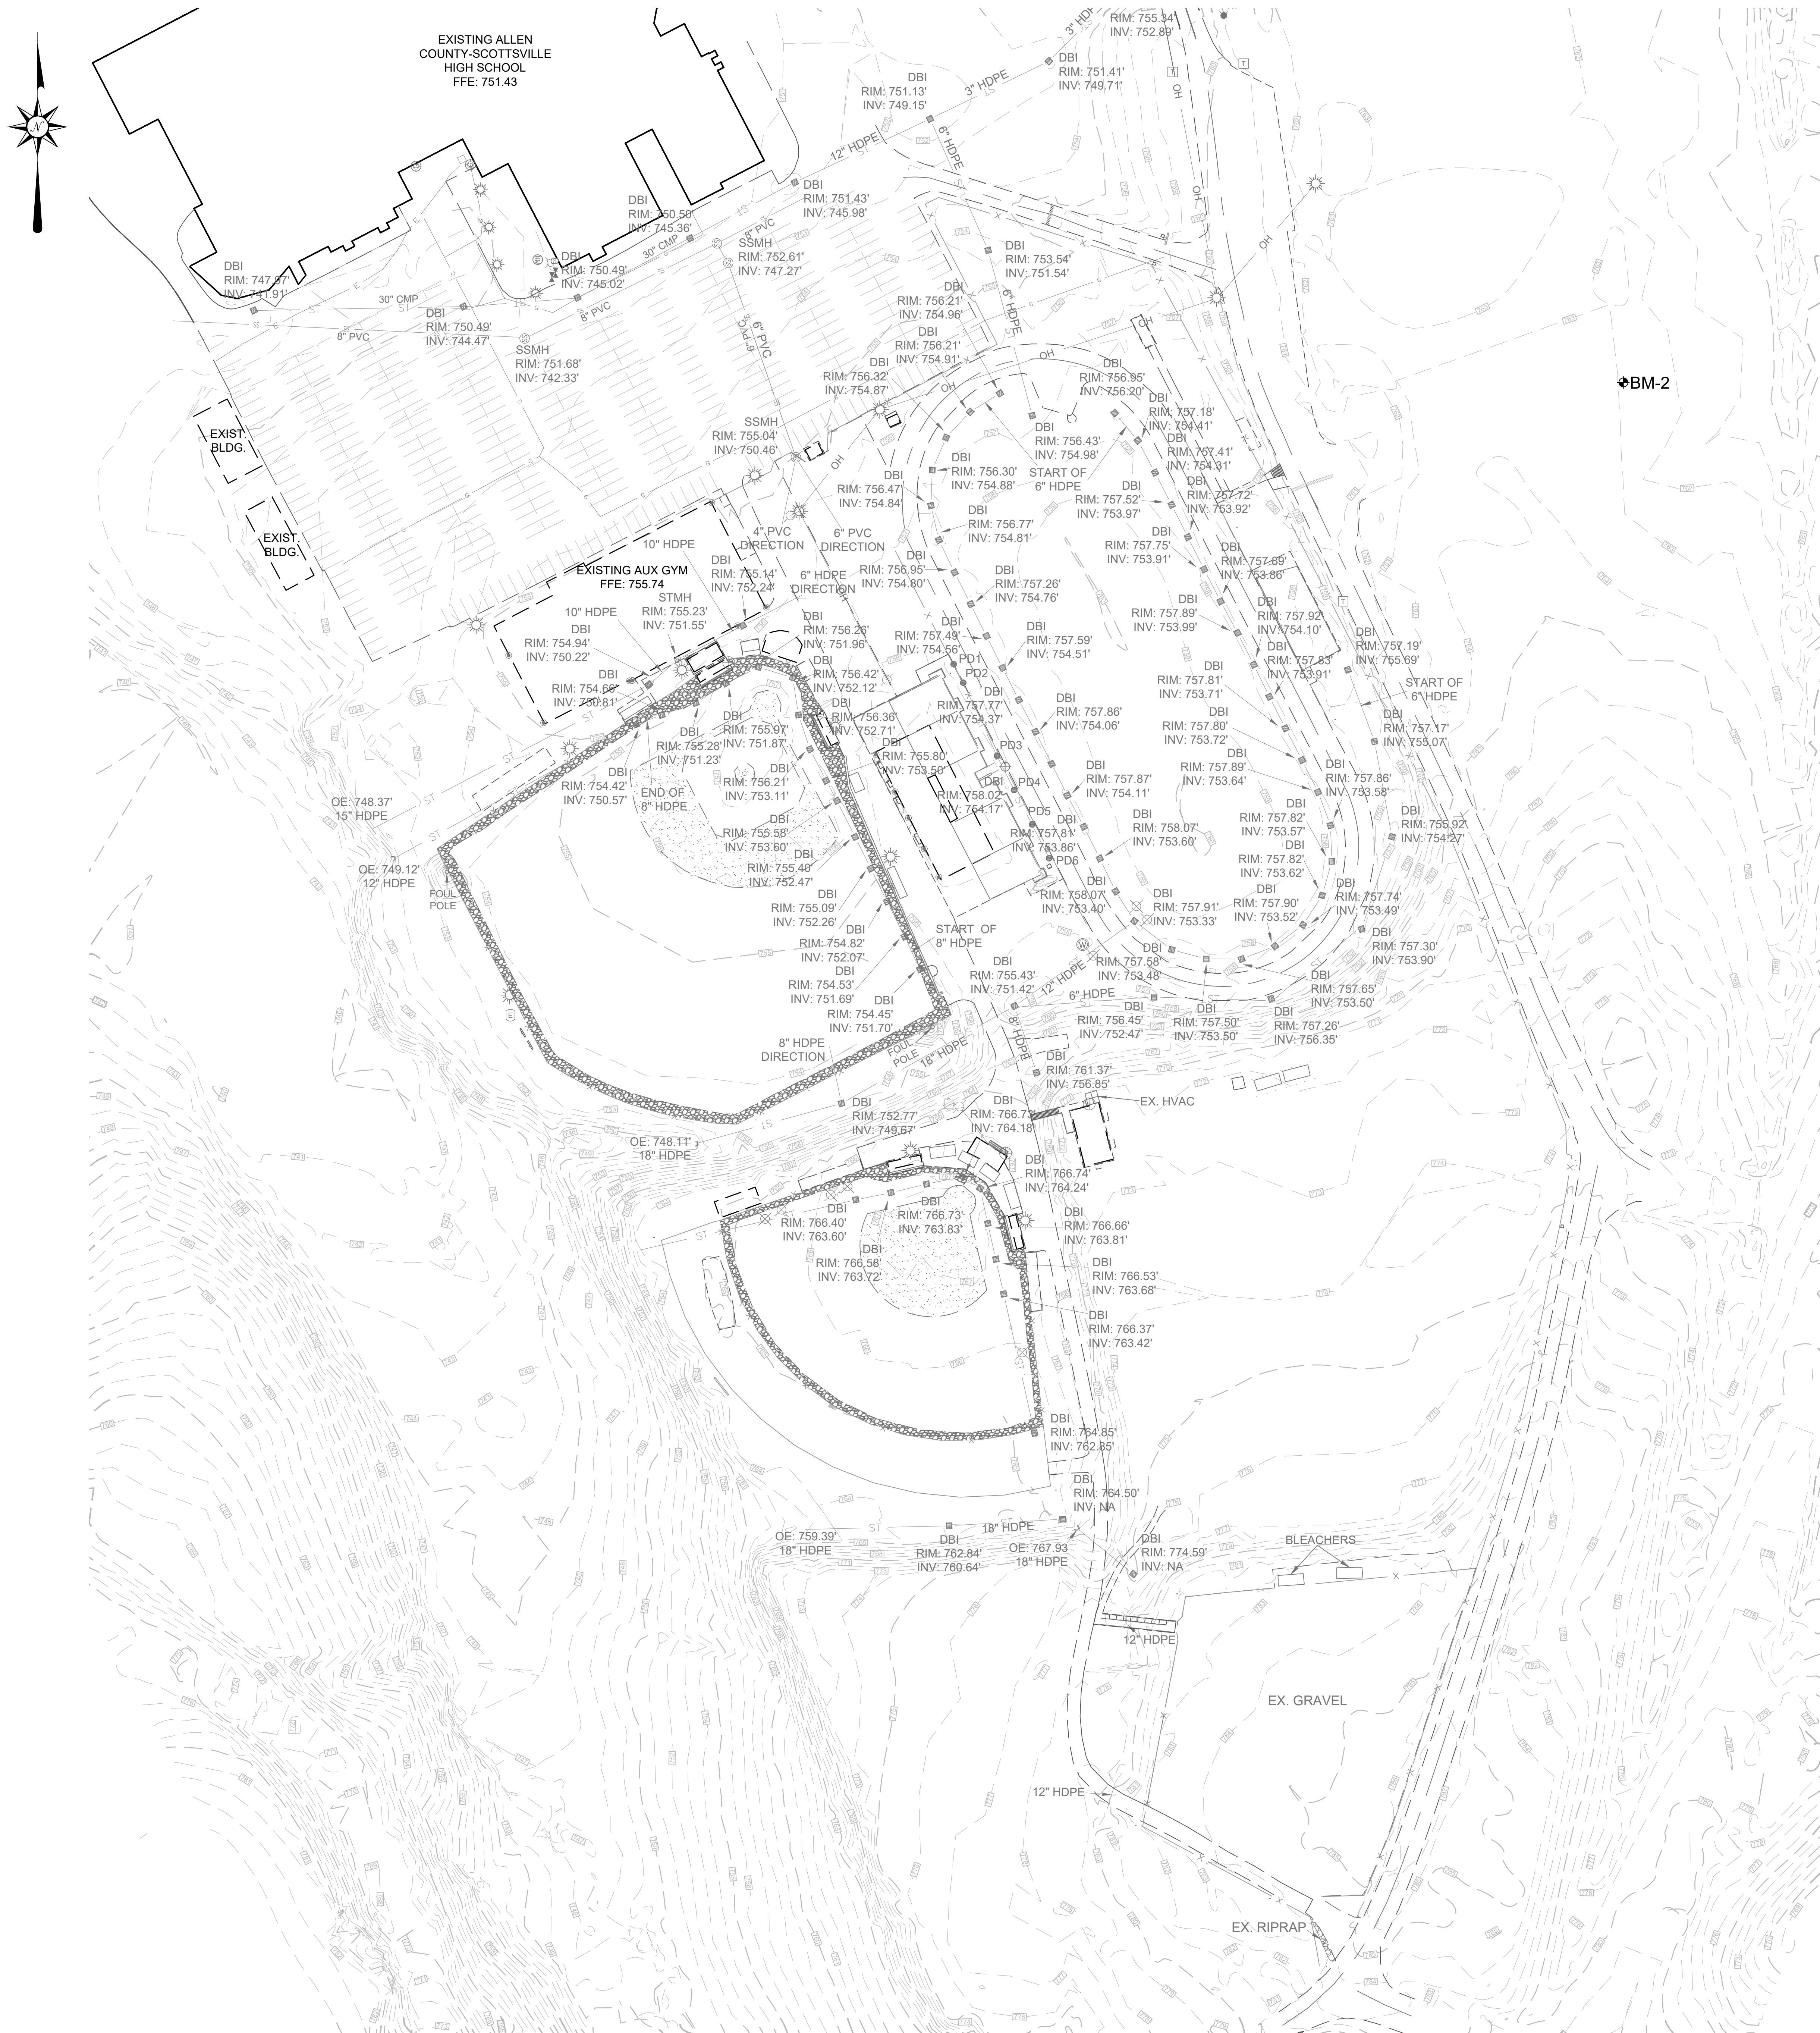

- LEGEND**
- BENCHMARK
 - IRON PIN FOUND
 - IRON PIN SET
 - CONCRETE R/W MONUMENT
 - SANITARY SEWER MANHOLE
 - SANITARY SEWER CLEAN OUT
 - ANCHOR
 - UTILITY POLE
 - SIGNAL POLE
 - ELECTRIC BOX
 - ELECTRIC METER
 - GAS VALVE
 - WATER VALVE
 - WATER METER
 - FIRE HYDRANT
 - GAS METER
 - TELEPHONE PEDESTAL
 - STORM SEWER MANHOLE
 - DROP BOX INLET
 - CURB BOX INLET
 - PIPE BOLLARD
 - GUTTER OUTLET
 - ROAD SIGN
 - TREE
 - MAILBOX
 - LAMP POLE
 - BSBL BUILDING SET BACK LINE
 - ESOL EACH SIDE OF LINE
 - PUE PUBLIC UTILITY EASEMENT
 - FFE FINISHED FLOOR ELEVATION
- PROPERTY LINE
 - SETBACK LINE
 - EASEMENTS
 - LOT LINE TO BE ABANDONED
 - CENTERLINE
 - UNDERGROUND ELECTRIC
 - GAS LINE
 - OH OVERHEAD UTILITIES
 - BURIED TELEPHONE
 - SANITARY SEWER LINE
 - WATER LINE
 - STORM SEWER LINE
 - FENCE LINE
 - DRAINAGE ESMT.



GENERAL NOTES

- THIS EXHIBIT IS A TOPOGRAPHIC SURVEY ONLY, AND IS NOT TO BE USED AS A BOUNDARY SURVEY, OR AS AN INSTRUMENT TO TRANSFER TITLE. THE BOUNDARY OF THE PROPERTY DEPICTED ON THIS SURVEY IS BASED ON DEED BOOK XXX PAGE XXX AS FOUND IN THE OFFICE OF THE ALLEN COUNTY CLERK.
- THE LOCATION OF ALL UTILITIES SHOWN HEREON ARE BASED ON THE FIELD LOCATION OF FOUND VISIBLE STRUCTURES OR AS FLAGGED OR MARKED BY THEIR RESPECTIVE UTILITY COMPANIES. THERE MAY BE OTHER UNDERGROUND UTILITIES LOCATED ON THE PROPERTY SHOWN HEREON. NO GUARANTEE IS EXPRESSED OR IMPLIED TO THE ACTUAL LOCATION OF SAID UTILITIES.
- THIS TOPOGRAPHIC SURVEY IS SUBJECT TO ANY AND ALL FACTS THAT MAY BE DISCLOSED BY A FULL AND ACCURATE TITLE SEARCH.
- THE PROPERTY SHOWN HEREON IS SUBJECT TO ANY AND ALL LEGAL EASEMENTS AND RIGHT-OF-WAYS RECORDED AND UNRECORDED, INCLUDING BUT NOT LIMITED TO THOSE SHOWN HEREON.
- AT THE TIME OF THE RECORD RESEARCH CONDUCTED FOR THIS SURVEY, THE SUBJECT PROPERTY DID NOT HAVE A DESIGNATED PHYSICAL ADDRESS. *****REMOVE THIS NOTE AND ADD ADDRESS IF AVAILABLE*****
- THE DATUM FOR THIS SURVEY IS GRID NORTH AS ESTABLISHED BY KENTUCKY STATE PLANE COORDINATES, SOUTH ZONE 1602. THE VERTICAL DATUM FOR THIS SURVEY IS NAVD 88 AS OBTAINED FROM KYCORS OBSERVATION.

SHERMAN
CARTER
BARNHART
ARCHITECTS

ACES
ARCHITECTURAL CONSULTING
ENGINEERING SERVICES, INC.
P.O. BOX 1388
BOWLING GREEN, KY 42401
PHONE: 606/786-9445

ALLEN COUNTY -
SCOTTSVILLE HIGH SCHOOL
ATHLETIC COMPLEX
SCOTTSVILLE, KENTUCKY

EXISTING TOPOGRAPHY

JOB NO.	--
DATE	11/14/2025
DRAWN	T. EWING
CHECKED	L. CONWAY


COPYRIGHT © 2025
SHERMAN CARTER BARNHART
ARCHITECTS, P.L.C.

REVISIONS	No.	Description	Date

SHEET

C1



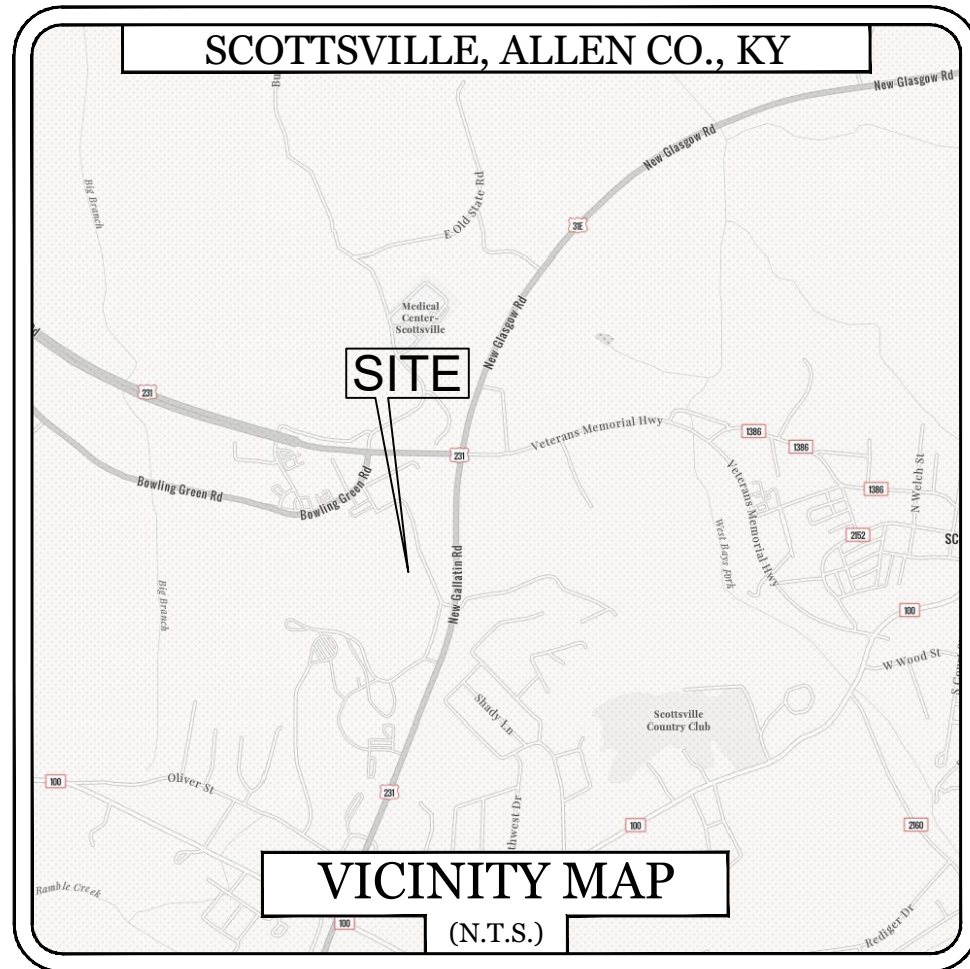

FLOODPLAIN INFORMATION

THE PROPERTY SHOWN HEREON DOES NOT LIE IN A FLOOD PRONE AREA ACCORDING TO (FIRM) FLOOD INSURANCE RATE MAP FOR ALLEN COUNTY, KENTUCKY. SAID AREA IS SHOWN ON MAP #21003C0140C & 21003C0255C, WITH AN EFFECTIVE DATE OF JULY 4, 2011.

COPYRIGHTS AND DISCLAIMERS

THE COPYRIGHTS TO ALL DESIGNS AND DRAWINGS ARE THE PROPERTY OF ACES. REPRODUCTION OR USE FOR ANY PURPOSE OTHER THAN THAT AUTHORIZED BY ACES IS FORBIDDEN.

ACES ASSUMES NO RESPONSIBILITY FOR DATA SUPPLIED IN AN ELECTRONIC FORMAT. DATA IS PROVIDED ELECTRONICALLY AS A CONVENIENCE AND THE RECIPIENT IS RESPONSIBLE FOR VERIFYING ACCURACY TO THE HARD COPY OF THE CURRENT DESIGN DRAWINGS WHICH HAVE BEEN SEALED AND SIGNED. IN THE EVENT OF INCONSISTENCIES BETWEEN THE ELECTRONIC AND THE HARD COPY DATA, THE RECIPIENT IS RESPONSIBLE FOR OBTAINING CLARIFICATION ON WHICH PREVAILS.

THE RECIPIENT RELEASES ACES, ITS EMPLOYEES, CONSULTANTS AND AGENTS FROM ANY AND ALL CLAIMS ARISING IN ANY WAY FROM THE CONTENT OR PROVISION OF THE ELECTRONIC DATA.


NOTHING SHALL REDUCE OR DIMINISH ACES'S OWNERSHIP OF OR COPYRIGHT IN THE DATA OR ITS COMPILATION OR ARRANGEMENT. ANY ANALYSIS, SOFTWARE OR FORMATTING IN THE ELECTRONIC DATA IS CONSIDERED PROPERTY OF ACES.

THE RECIPIENT OF ELECTRONIC DATA IS PROHIBITED FROM REDISTRIBUTING OR USING ANY DESIGN OR DRAWING INFORMATION WITHIN THE FILES FOR ANY REASON OTHER THAN IT WAS ORIGINALLY DESIGNED WITHOUT THE WRITTEN CONSENT OF ACES.

BENCHMARK DATA:

➤ BENCHMARK 1
MAGNAIL
N: 1793205.31
E: 1503785.27
ELEV: 756.82'


➤ BENCHMARK 2
MAGNAIL
N: 1792672.53
E: 1504001.98
ELEV: 773.71'

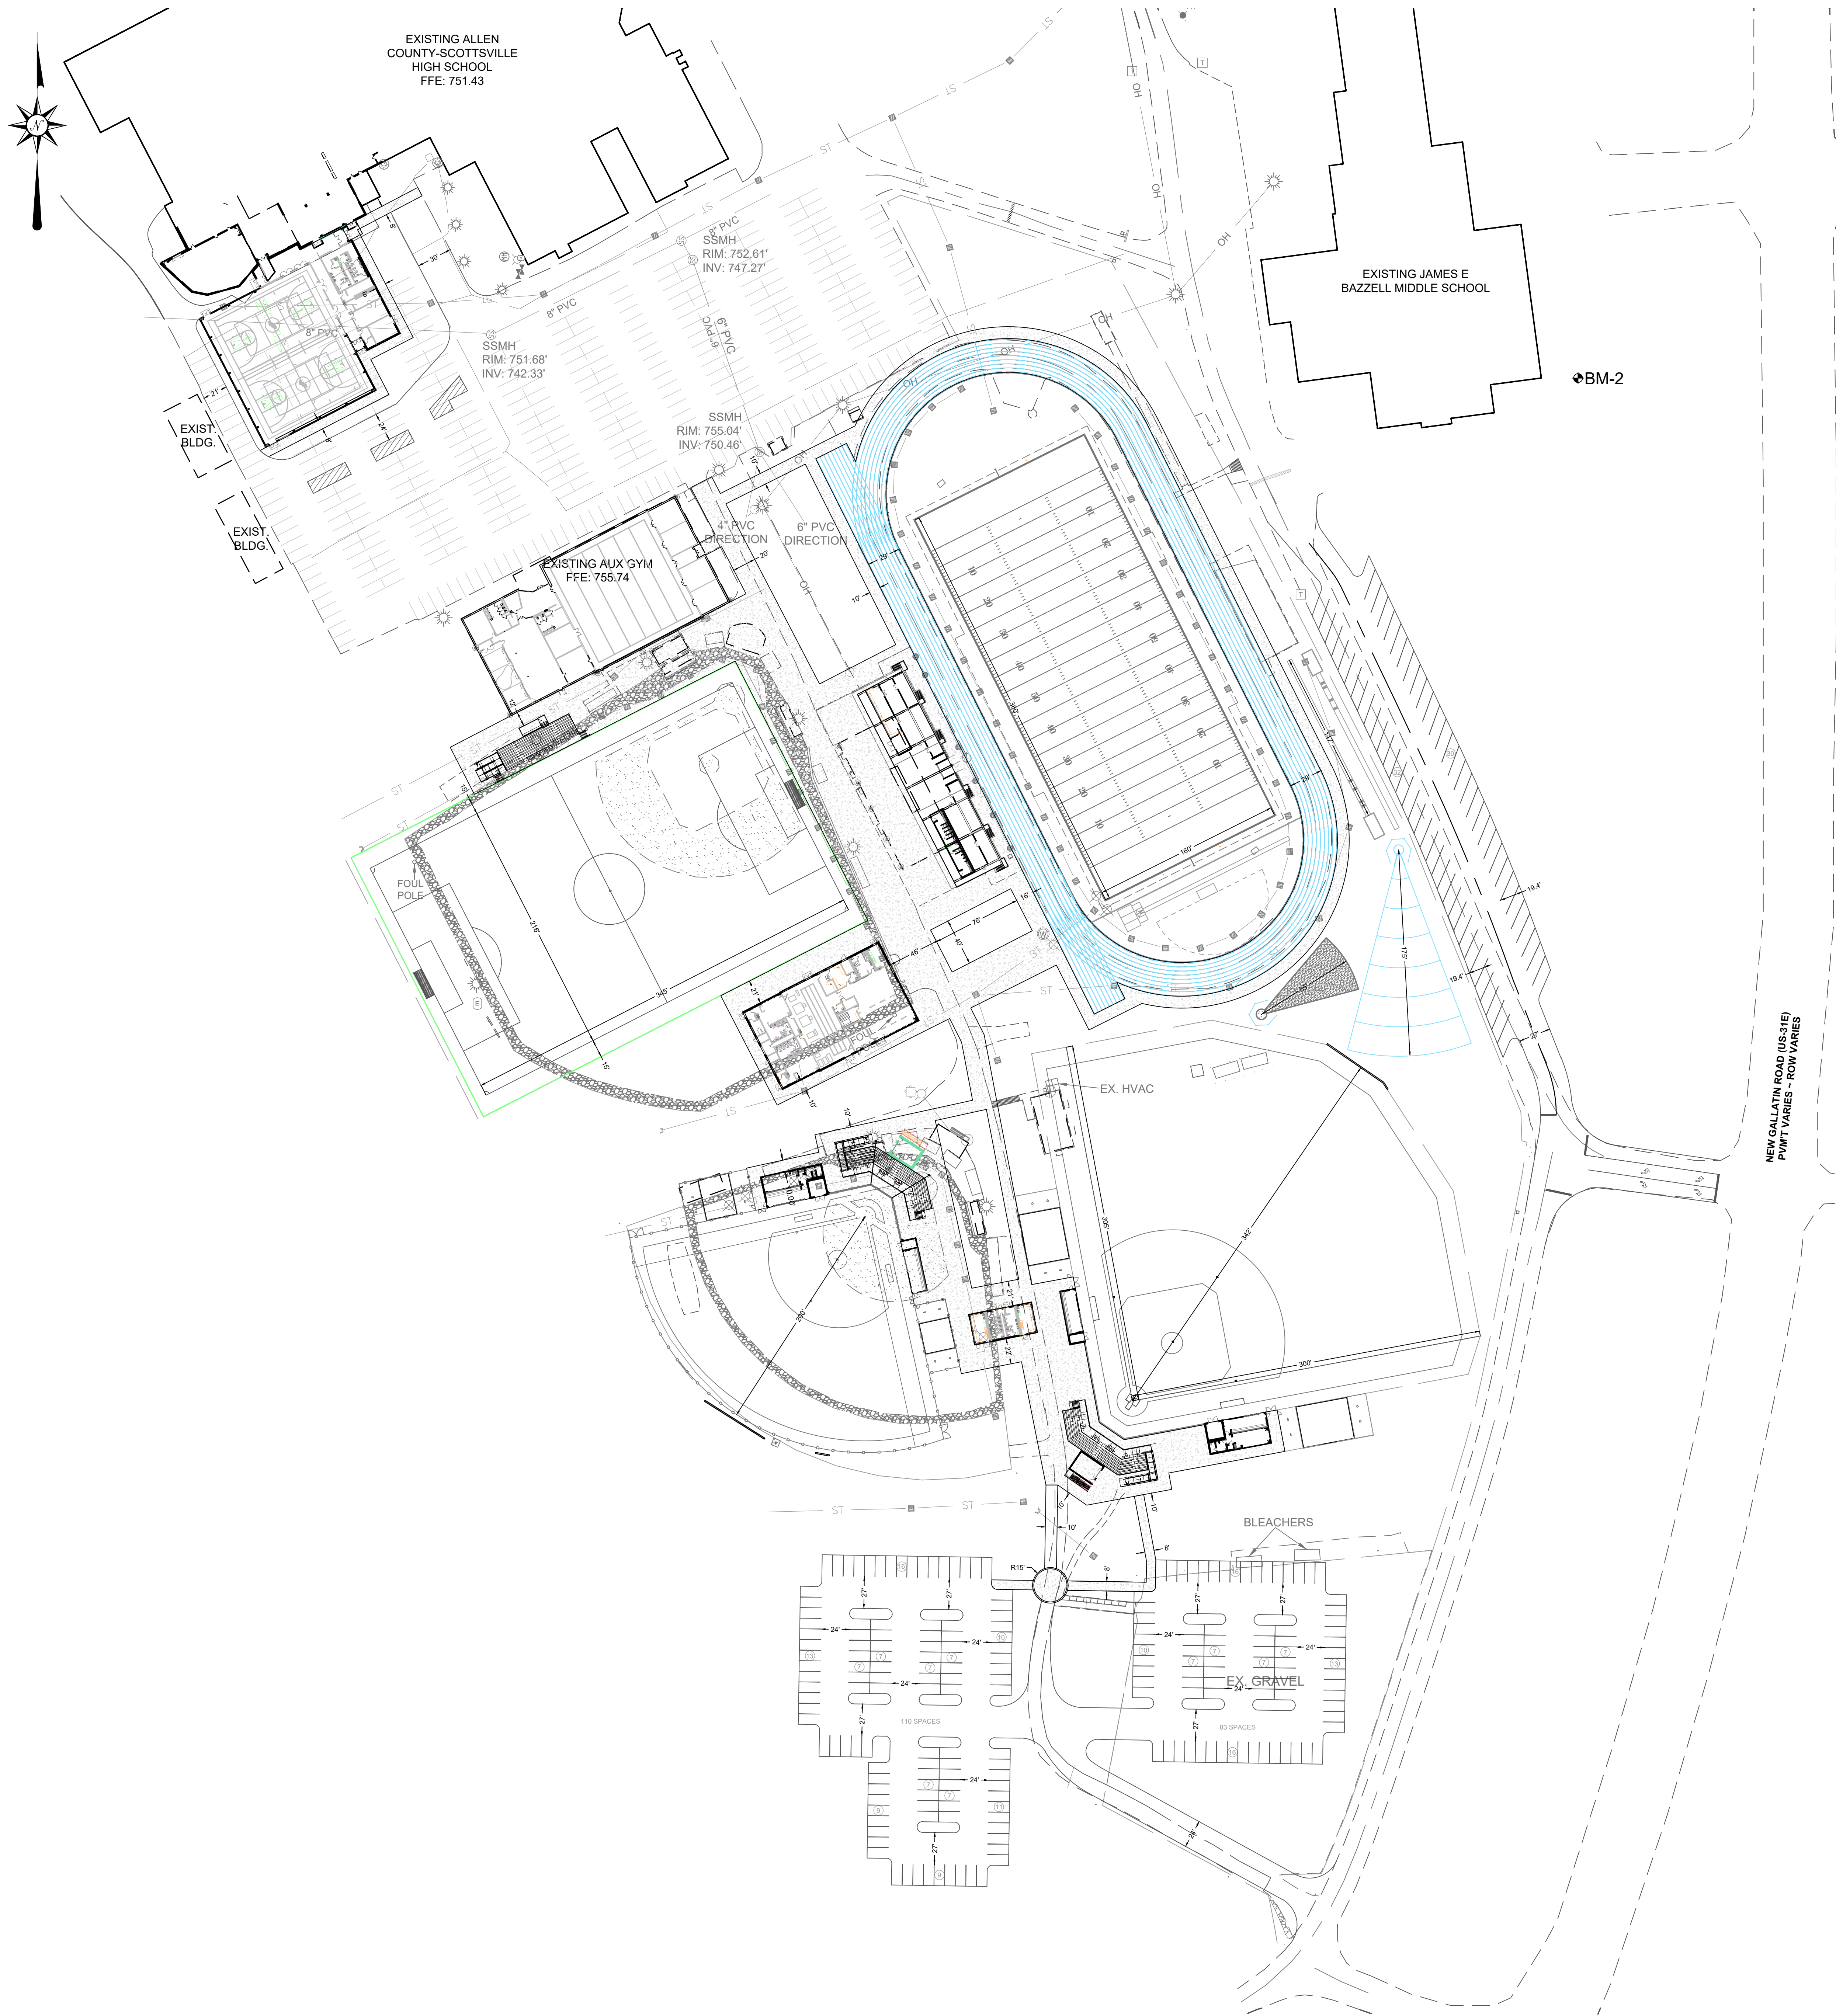

JOB NO.	--
DATE	11/14/2025
DRAWN	A. ARNOLD
CHECKED	A. ARNOLD

COPYRIGHT © 2025
SHERMAN CARTER BARNHART
ARCHITECTS, PLLC

REVISIONS		
No.	Description	Date

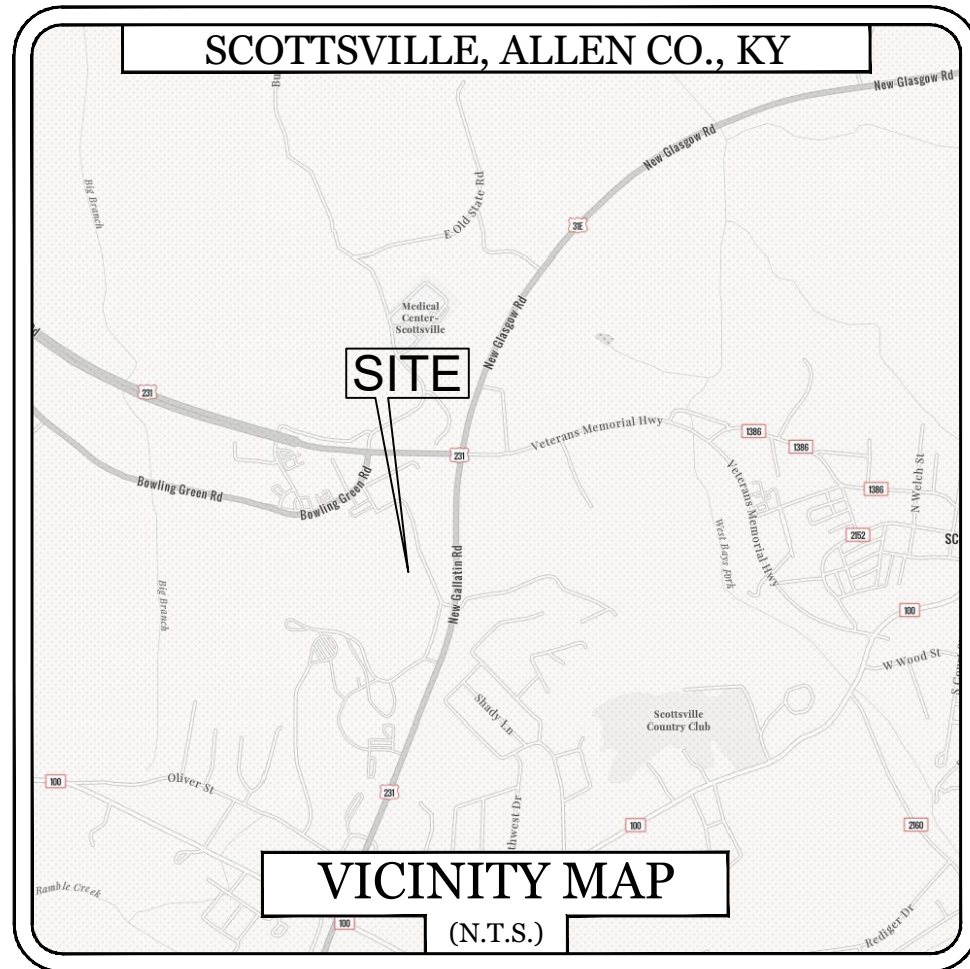

FLOODPLAIN INFORMATION

THE PROPERTY SHOWN HEREON DOES NOT LIE IN A FLOOD PRONE AREA ACCORDING TO (FIRM) FLOOD INSURANCE RATE MAP FOR ALLEN COUNTY, KENTUCKY. SAID AREA IS SHOWN ON MAP #21003C0140C & 21003C0255C, WITH AN EFFECTIVE DATE OF JULY 4, 2011.

COPYRIGHTS AND DISCLAIMERS

THE COPYRIGHTS TO ALL DESIGNS AND DRAWINGS ARE THE PROPERTY OF ACES. REPRODUCTION OR USE FOR ANY PURPOSE OTHER THAN THAT AUTHORIZED BY ACES IS FORBIDDEN.

ACES ASSUMES NO RESPONSIBILITY FOR DATA SUPPLIED IN AN ELECTRONIC FORMAT. DATA IS PROVIDED ELECTRONICALLY AS A CONVENIENCE AND THE RECIPIENT IS RESPONSIBLE FOR VERIFYING ACCURACY TO THE HARD COPY OF THE CURRENT DESIGN DRAWINGS WHICH HAVE BEEN SEALED AND SIGNED. IN THE EVENT OF INCONSISTENCIES BETWEEN THE ELECTRONIC AND THE HARD COPY DATA, THE RECIPIENT IS RESPONSIBLE FOR OBTAINING CLARIFICATION ON WHICH PREVAILS.

THE RECIPIENT RELEASES ACES, ITS EMPLOYEES, CONSULTANTS AND AGENTS FROM ANY AND ALL CLAIMS ARISING IN ANY WAY FROM THE CONTENT OR PROVISION OF THE ELECTRONIC DATA.


NOTHING SHALL REDUCE OR DIMINISH ACES'S OWNERSHIP OF OR COPYRIGHT IN THE DATA OR ITS COMPILATION OR ARRANGEMENT. ANY ANALYSIS, SOFTWARE OR FORMATTING IN THE ELECTRONIC DATA IS CONSIDERED PROPERTY OF ACES.

THE RECIPIENT OF ELECTRONIC DATA IS PROHIBITED FROM REDISTRIBUTING OR USING ANY DESIGN OR DRAWING INFORMATION WITHIN THE FILES FOR ANY REASON OTHER THAN IT WAS ORIGINALLY DESIGNED WITHOUT THE WRITTEN CONSENT OF ACES.

BENCHMARK DATA:

➤ BENCHMARK 1
MAGNAIL
N: 1793205.31
E: 1503785.27
ELEV: 756.82'

➤ BENCHMARK 2
MAGNAIL
N: 1792672.53
E: 1504001.98
ELEV: 773.71'

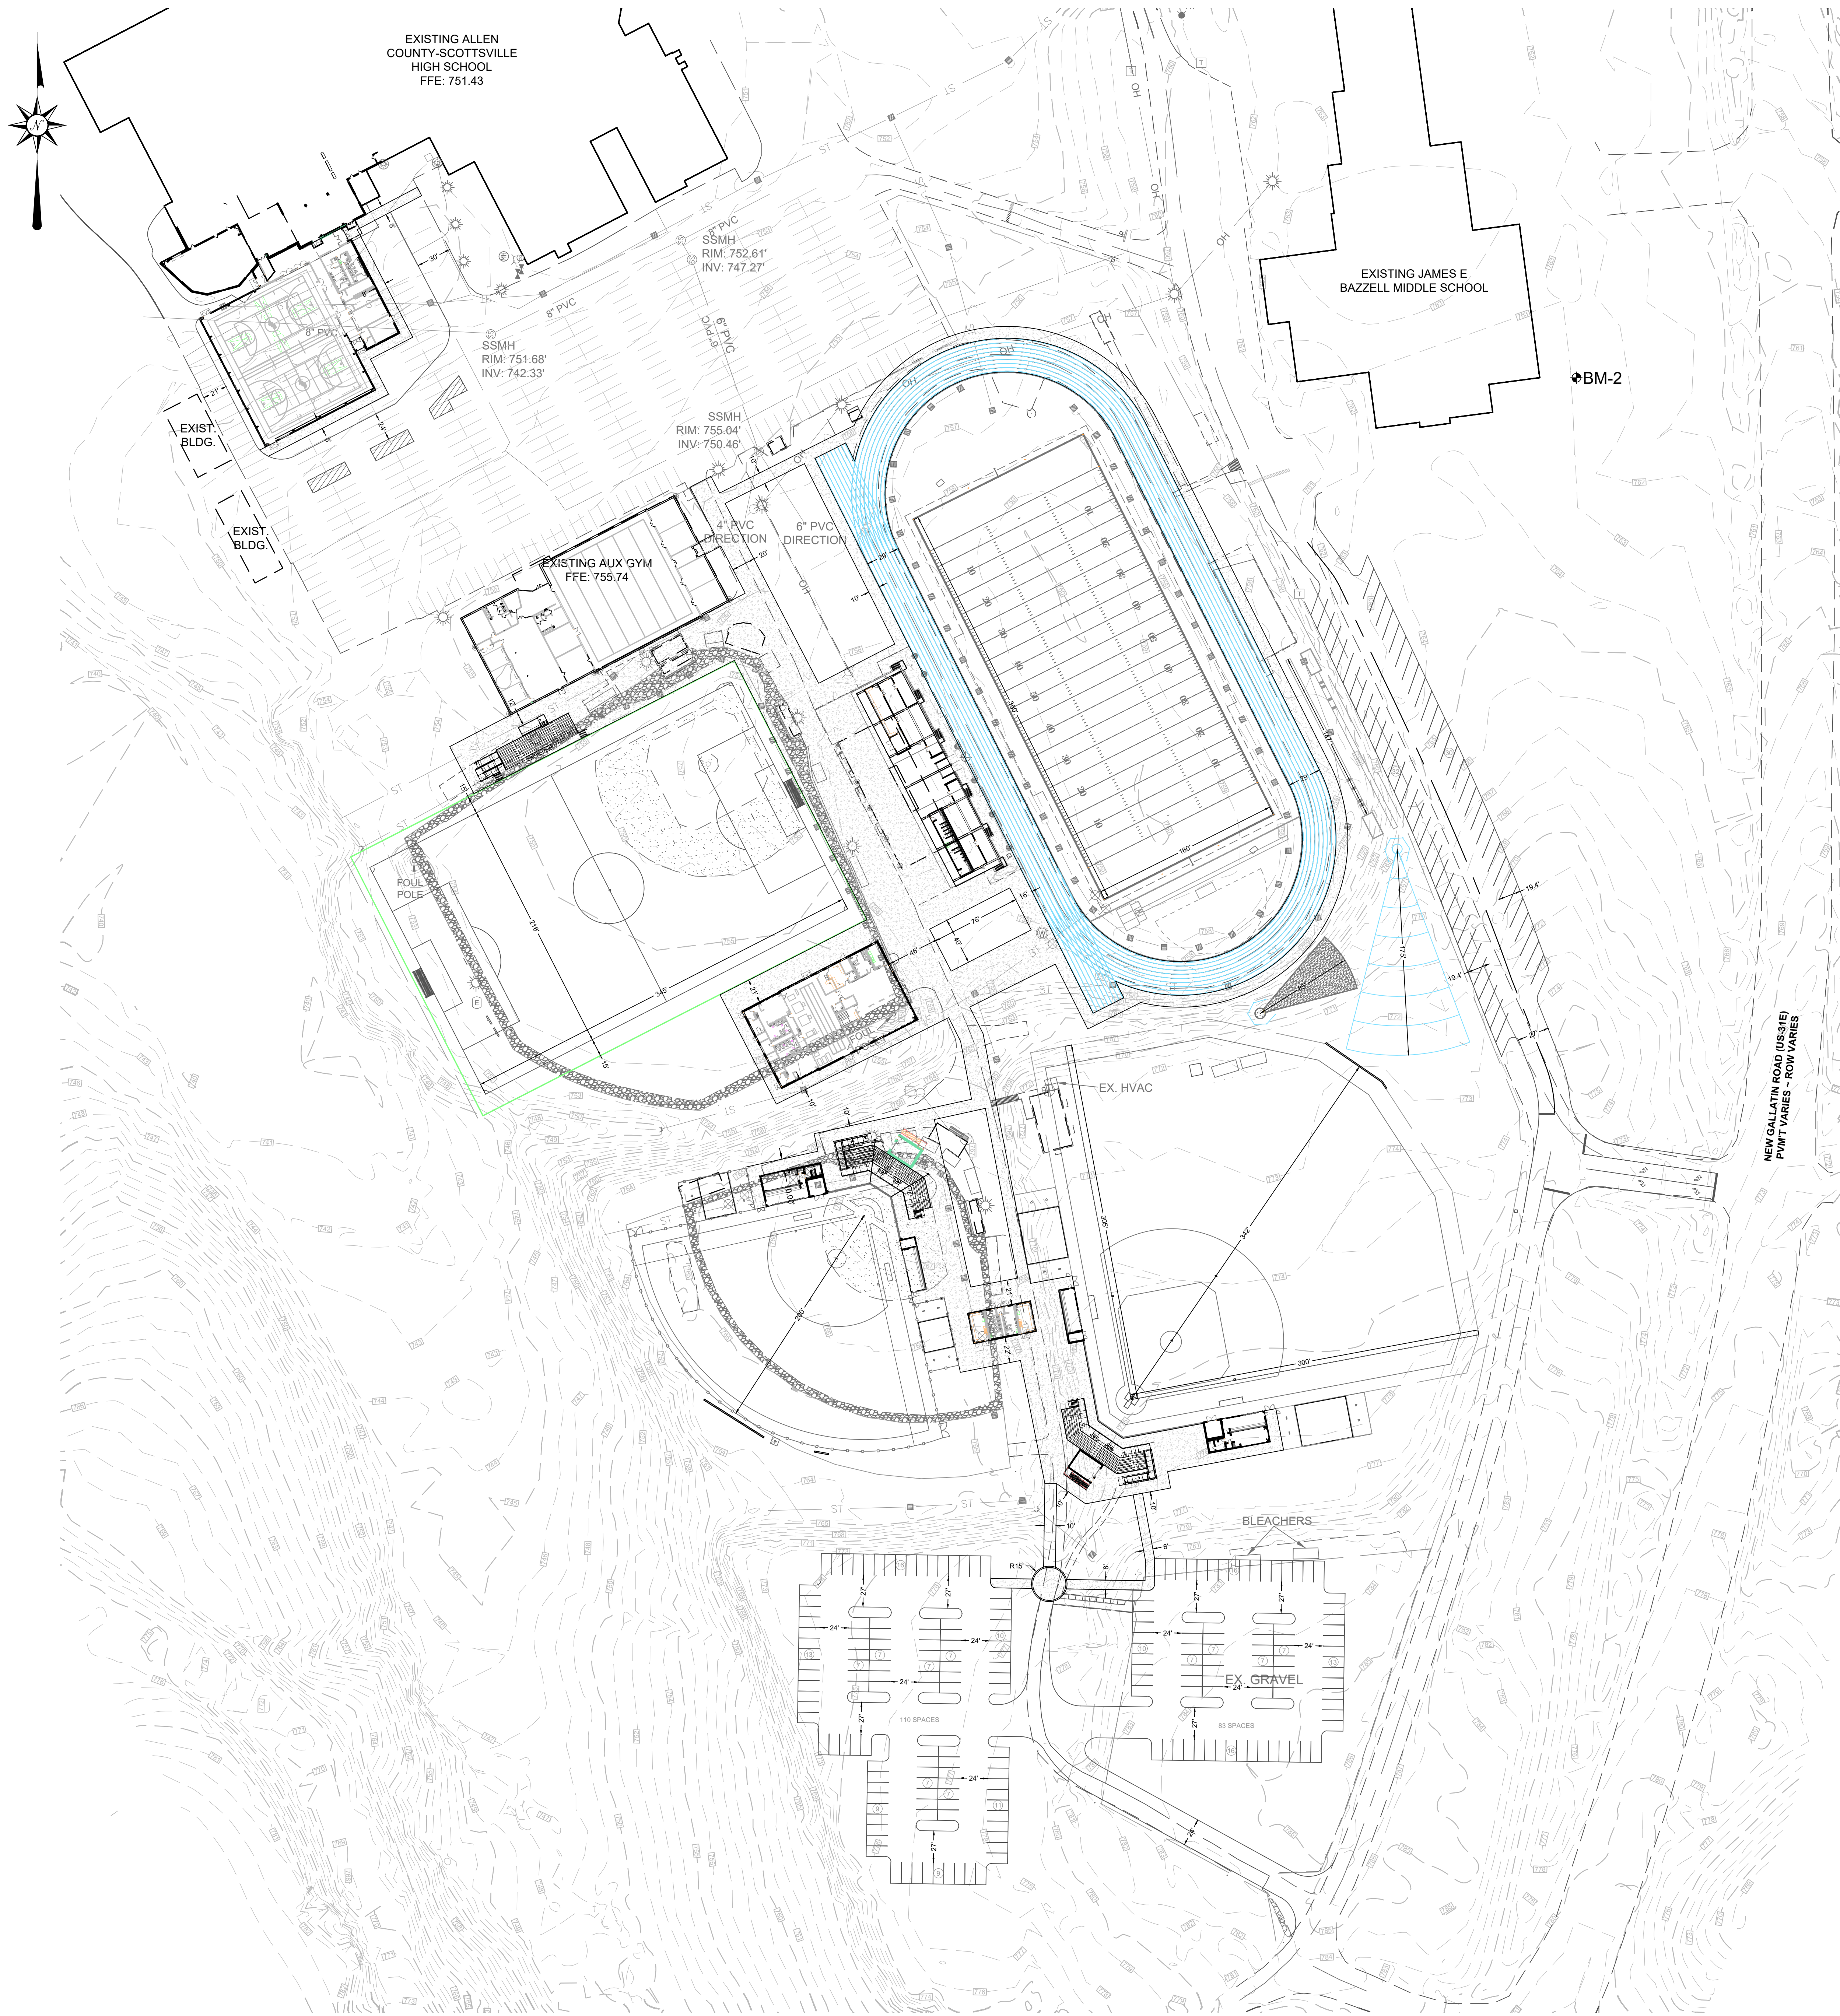

JOB NO.	--
DATE	11/14/2025
DRAWN	A. ARNOLD
CHECKED	A. ARNOLD


COPYRIGHT © 2025
SHERMAN CARTER BARNHART
ARCHITECTS, PLLC

REVISIONS	No.	Description	Date

ABBREVIATIONS


Ø	AT	L	ANGLE, LONG
AB	ANCHOR BOLT	LAM.	LAMINATE
AC	AND	LF	LIGHT FIXTURE, LINEAR FEET
ACC	AIR CONDITIONING	LD	LEFT HAND
ACCU	ACOUSTICAL	LLV	LONG LEG VERTICAL
ACT	ACTUAL	LOC	LOCATION
ADA	AMERICANS WITH DISABILITIES ACT	LT	LIGHT
		LTW	LIGHTWEIGHT
ADJ.	ADJUST, ADJUSTABLE	M	
ADH.	ADHESIVE	M.F.	MASONRY
AGG.	ABOVE FLOOR	MATL.	MATERIAL
AHU	AIR HANDLING UNIT	MAX.	MAXIMUM
ALUM.	ALUMINUM	MB	MARKER BOARD
ANCH.	ANCHOR	MC	MISCELLANEOUS CHANNEL
AP	ACCESS PANEL	MDO	MEDIUM DENSITY OVERLAY
APPROX.	APPROXIMATE	MECH.	MECHANICAL
ASSY	ASSEMBLY	MED.	MEDIUM, MEDICINE
AUTO	AUTOMATIC	MTL.	METAL
		MFR.	MANUFACTURER
B		MH	MANHOLE
BD.	BOARD	MIN.	MINIMUM, MINUTE
BTWN.	BETWEEN	MISC.	MISCELLANEOUS
BEV.	BEVELED	ML 4 P	METAL LATH AND PLASTER
BLK.	BLACK	M.O.	MASONRY OPENING
BLKG.	BLOCKING	MOUNT	MOUNT
BM	BEAM	MTD.	MOUNTED
B.O.	BOTTOM OF	MTG.	MOUNTING
BO. OR BTM.	BOTTOM	MULL.	MULLION
BUR.	BUILT UP ROOFING	N	
BRG. OR BRNG.	BEARING	NA	NOT APPLICABLE
		NET	MEANS EXACT DIMENSION REQUIRED
CAB.	CABINET	NIC	NOT IN CONTRACT
CB	CATCH BASIN, CHALKBOARD	NO. OR #	NUMBER
CC	CENTER TO CENTER (SAME MEANING AS OC)	NOM	NOMINAL
		NTS	NOT TO SCALE
CEM	CEMENT	O	
CF	CERAMIC TILE	O.C.	ON CENTER
CFI	CONTRACTOR FURNISHED AND INSTALLED	O.D.	OUTSIDE DIAMETER
CHAN.	CHANNEL	O.F.	OUTSIDE FACE
CI	CAST IRON	OFI	OWNER FURNISHED AND INSTALLED
CLJ.	CONTROL JOINT	OF-CI	OWNER FURNISHED.
CLG.	CLOSING	O.H.	CONTRACTOR INSTALLED
CLOS.	CLOSING	OH	OPPOSITE HAND
CLR.	CLEAR	OPNG.	OPENING
CSG	CONCRETE MASONRY UNIT	OPP.	OPPOSITE
COL	COLUMN	P	
CONC.	CONCRETE	PART	PARTITION
COND.	CONDENSATION, CONDENSER	PART BD.	PARTICLE BOARD
CONST.	CONSTRUCTION	PASS	PASSAGE
CONT.	CONTINUOUS	PC	PRECAST
CONTR.	CONTRACTOR	PIC	POURED CONCRETE
CORRUG.	CORRUGATED	PERF	PERFORATED
CR	COLD ROLLED	PERIM	PERIMETER
CSG	CASING	PERP.	PERPENDICULAR
CTSK	COUNTERSINK	PF CMU	PRECAST CONC. MAS. UNIT
CUB.	CUBIC	PH	PHASE
CULV.	CULVERT	PLAS	PLASTER
CW	COLD WATER, CLOCKWISE	PLUMB.	PLUMBING
CY	CUBIC YARD	PLYWD.	PLYWOOD
		POLY	POLISHED
D		POLY CARB.	POLYCARBONATE SHEET
DBL.	DOUBLE	PRFAS.	PREFABRICATED
DET.	DETAILED	PROJ.	PROJECT, PROJECTED
DEP.	DEPRESSION	FR	FAIR
DI.	DRAINING	PSMB	PENCIL SHARPENER BLOCK
DIA.	DIAMETER	P.T.	PRESSURE TREATED
DM.	DIAMETER	PVC	POLYVINYL CHLORIDE
DOWN.	DOWN	PVHT	PAVED
DO	DITTO	PWG	POLISHED WIRE GLASS
DOS	DOWNSPOUT	+	PLUS OR MINUS
DWG(S)	DRAWING(S)	Q	
		Q.T.	QUARRY TILE
E		R	
EA.	EACH	R.	RISER, RADIUS
EJ	EXPANSION JOINT	R. OR RAD.	RADIUS
EL. OR ELEV.	ELEVATION	RCP	REINFORCED CONCRETE PIPE
ELEC	ELECTRIC, ELECTRICAL	RD	ROOF DRAIN
EMER.	EMERGENCY	REBAR	REINFORCING BAR
ENCL.	ENCLOSURE	REIRC	RECORDULATE
ENT	ENTRANCE	REF.	REFERENCE, REFER
EQU.	EQUAL	REFR.	REFRIGERATOR
EQV.	EQUIVALENT	REFIN.	REINFORCE, REINFORCED, REINFORCING
ESMT	EASEMENT	REQD.	REQUIRED
EW	EACH WAY	RET.	RETAINING, RETURN
EWC	ELECTRIC WATER COOLER (SEE MECH DWGS)	RESIL	RESILIENT
EXIST. OR EX.	EXISTING	RH	RIGHT HAND, ROUND HEAD
EXT.	EXTERIOR	R.O. OR R/W	ROUGH OPENING
		RRT	RIGHT OF WAY
F		RAW	RAISED RADIAL TILE
FAB.	FABRICATE	S	
FC	FIRE CODE	SC	SOLID CORE
FD	FLOOR DRAIN (SEE MECH DWGS)	SCHD.	SCHEDULE
FDN.	FOUNDATION	SECTOR	SECTOR
FE	FIRE EXTINGUISHER	SEP	SEPARATE, SEPARATION
FEF	FIRE EXTINGUISHER CABINET	SF	SQUARE FEET, SAND FILL
F.F.E.	FINISHED FLOOR ELEVATION	SH	SHEATHING
PH	FULL HEIGHT	SHEET	SHEET
FIN.	FINISH, FINISHED	SIM.	SIMILAR
FLR.	FLOOR	S.M.	SHEET METAL
FLASH	FLASHING	SPA	SPEAK(S)
FLEX.	FLEXIBLE	SPEC(S)	SPECIFICATIONS
FRT	FIRE RETARDANT TREATED	SPM	SINGLE-PLY MEMBRANE
FTG.	FOOTING	SQ.	SQUARE
FURR.	FURRING	S.S.	STAINLESS STEEL
F.V.	FIELD VISION	STA	STATION
G		STD	STANDARD
GA	GAUGE	STL.	STEEL
GALV.	GALVANIZED	STOR.	STORAGE
GRAD.	GRAD BAR	STRUCT.	STRUCTURAL
GEN.	GENERATOR	SUSP.	SUSPENDED
GF CMU	GROUND FACE CONC. MAS. UNIT	SYMM	SYMMETRICAL
GI	GALVANIZED IRON	T	
GL	GROUND FAULT INTERRUPT	T.	TREAD, THICK
GL	GLASS, GLAZING	TB	TACKBOARD
GLUE LAM	GLUE-LAMINATED	TC	TOP OF CURB
GND	GROUND	TCE	TOP OF CURB ELEVATION
GR	GRADE	TDS	TURNED DOWN SLAB
GST	GLAZED STRUCTURAL TILE	TEL	TELEPHONE
GYP	GYPSONUM	TFE	TOP OF FOOTING ELEVATION
H		T & G	TONGUE AND GROOVE
HARDENED	HIGH	THK	THICK, THICKNESS
HARD	HUGE BIB	THRESH	THRESHOLD
HC	HOLLOW CORE	T.O.	TOP OF
HD BD	HARD BOARD	TOC	TOP OF CONCRETE
HND	HANDICAPPED	TOILET	TOILET
HDR	HEADER	TOL	TOP OF MASONRY
HDWE	HARDWARE	TOS	TOP OF STEEL
HURD	HARDWOOD	TS	TACK STRIP
HEX	HEXAGONAL	TST	STRUCTURAL STEEL TUBING
HT	HEIGHT	TOW	TOP OF WALL
HOLLOW	HOLLOW	TYP.	TYPICAL
HM OR H.M.	HOLLOW METAL	U	
HORIZ.	HORIZONTAL	UL	UNDERGROUND
HTR	HOT WATER, HARD WHITE	UNFIN.	UNFINISHED
		U.N.O.	UNLESS NOTED OTHERWISE
I		V	
ID	INSIDE DIAMETER	VAC	VACUUM
INC.	INSIDE FACE	VB	VAPOR BARRIER
INCL	INCLUDED	VCT	VINYL COMPOSITION TILE
INSUL.	INSULATION	VERT.	VERTICAL
INT	INTERIOR	V.I.F.	VERIFY IN FIELD
INV	INVERT	W	
		W	WIDE
JB	JUNCTION BOX	W.R.	WATER RESISTANT
JST.	JOIST	WWF	WELDED WIRE FABRIC
K		X	
KBC	KENTUCKY BUILDING CODE	X	BY
		YD	YARD

WALL / PARTITION SCHEDULE

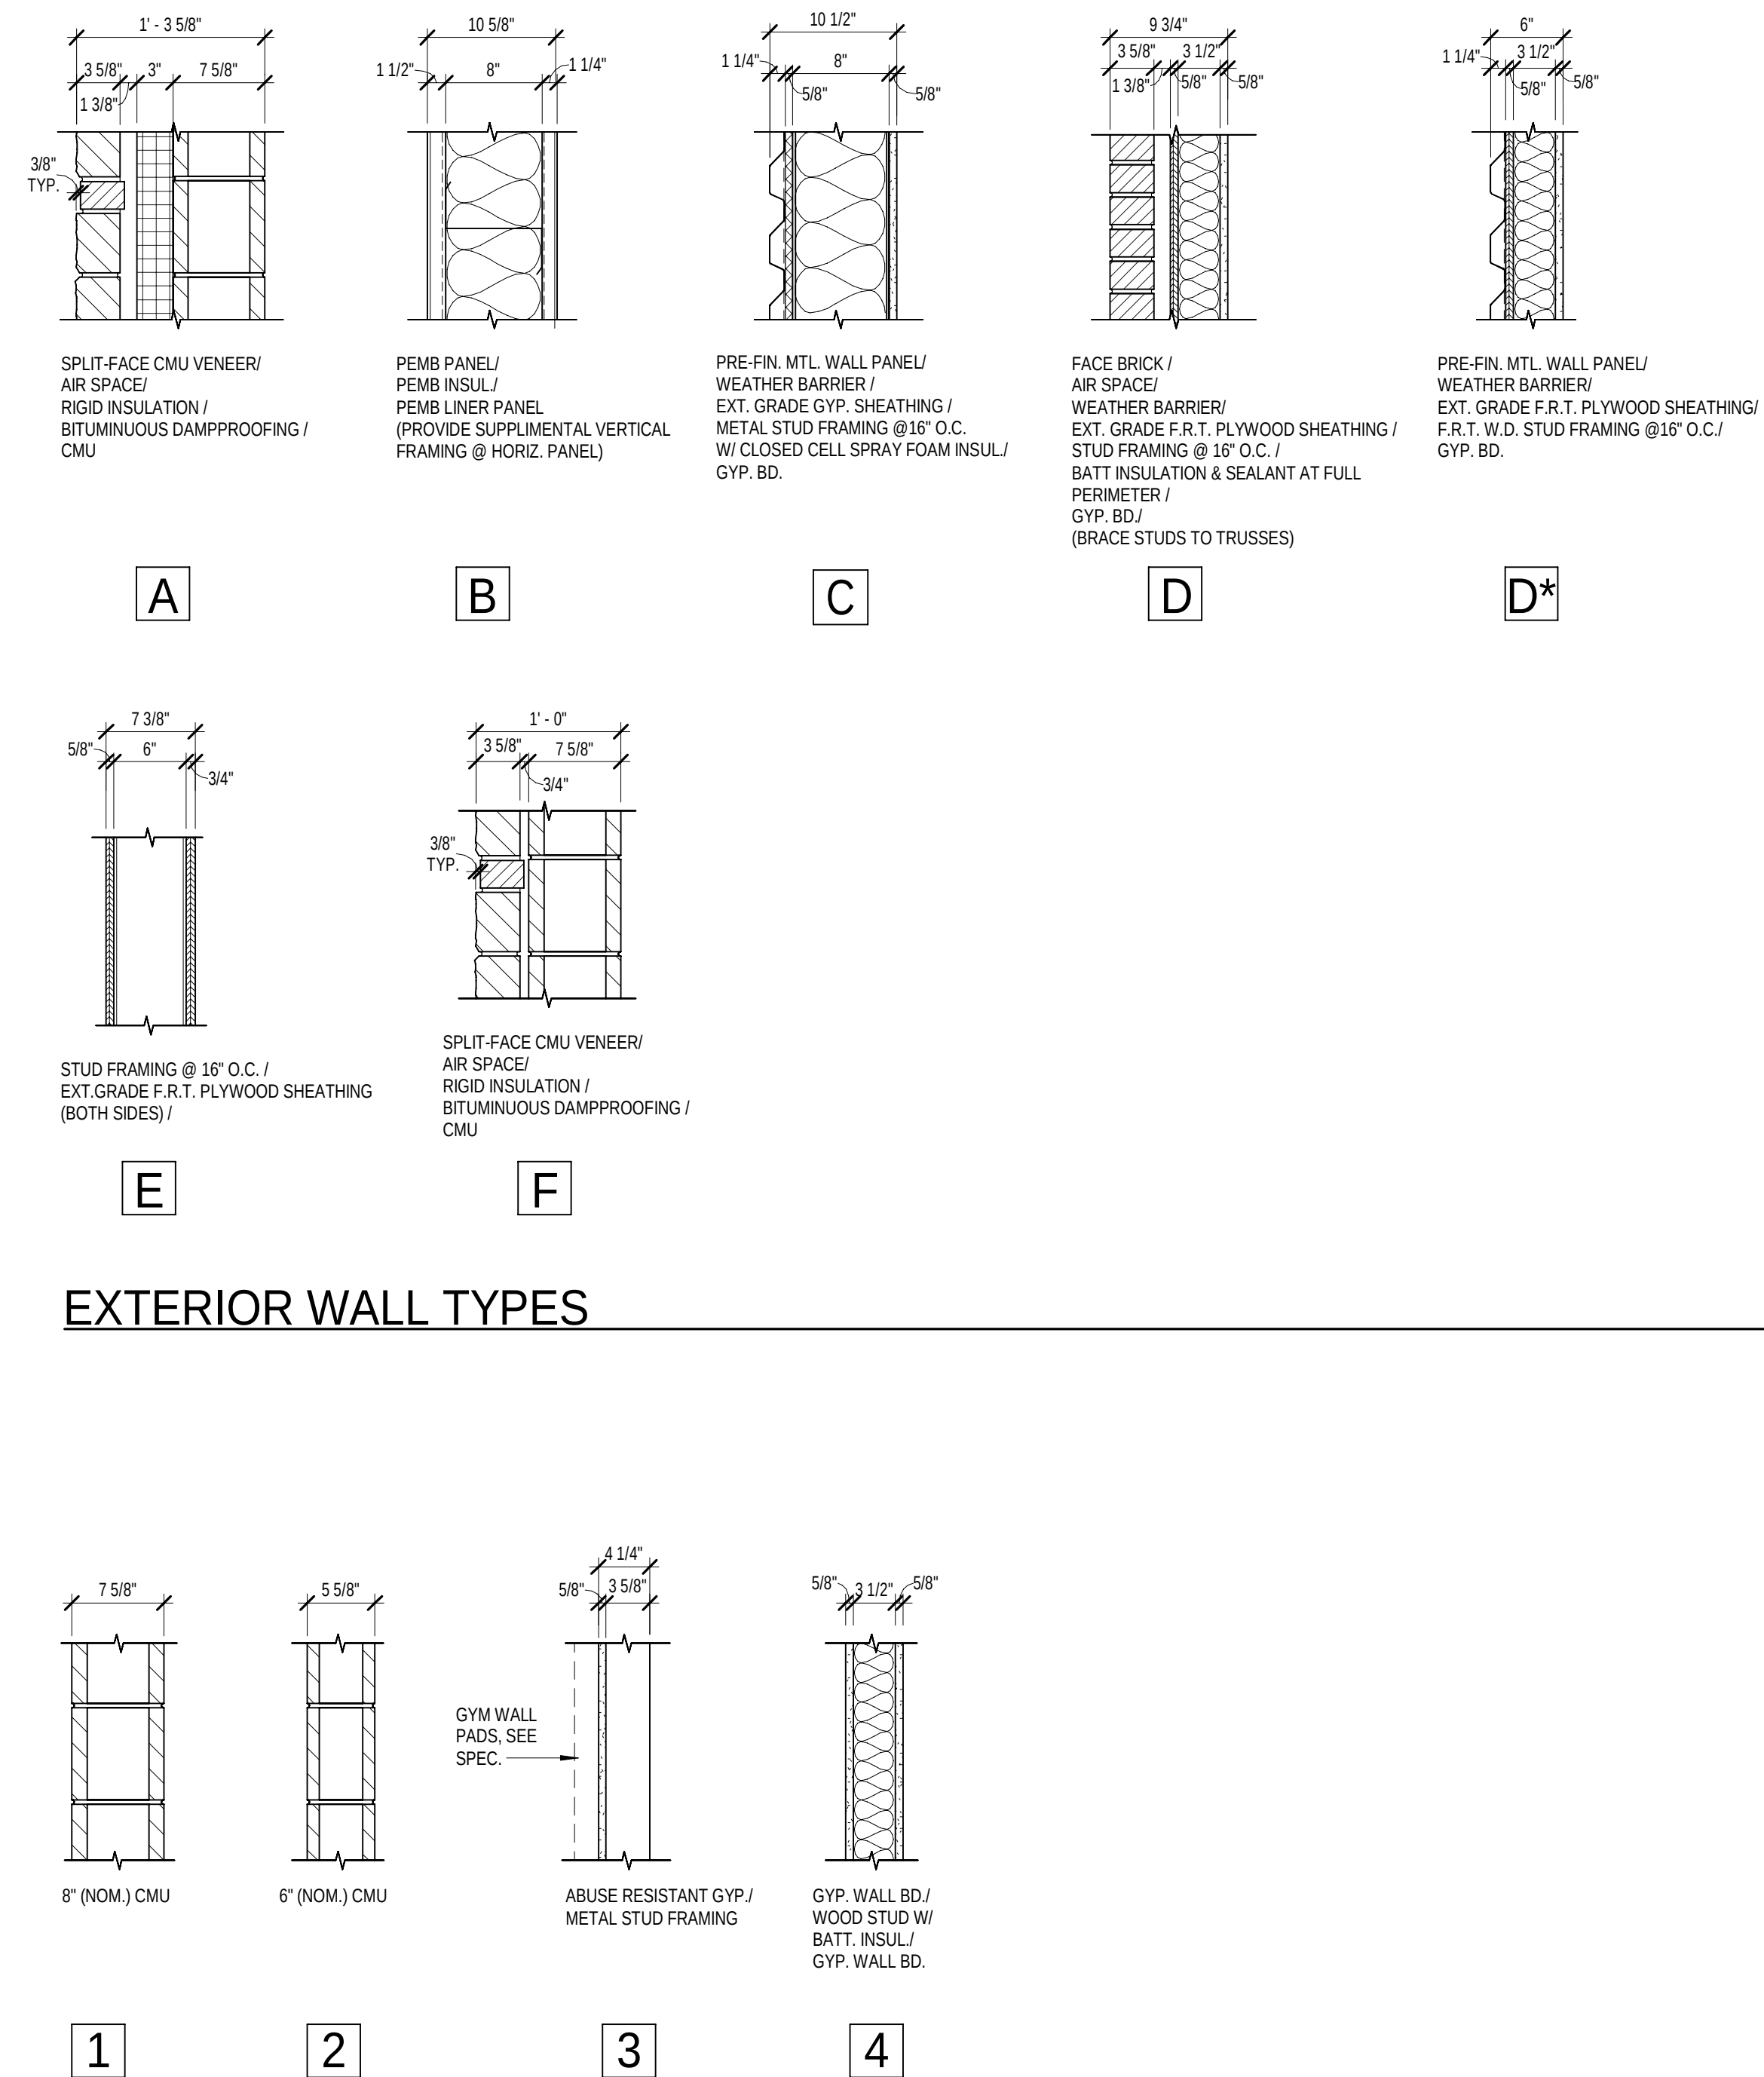


INTERIOR WALL TYPES


ROOM SIGNAGE SCHEDULE

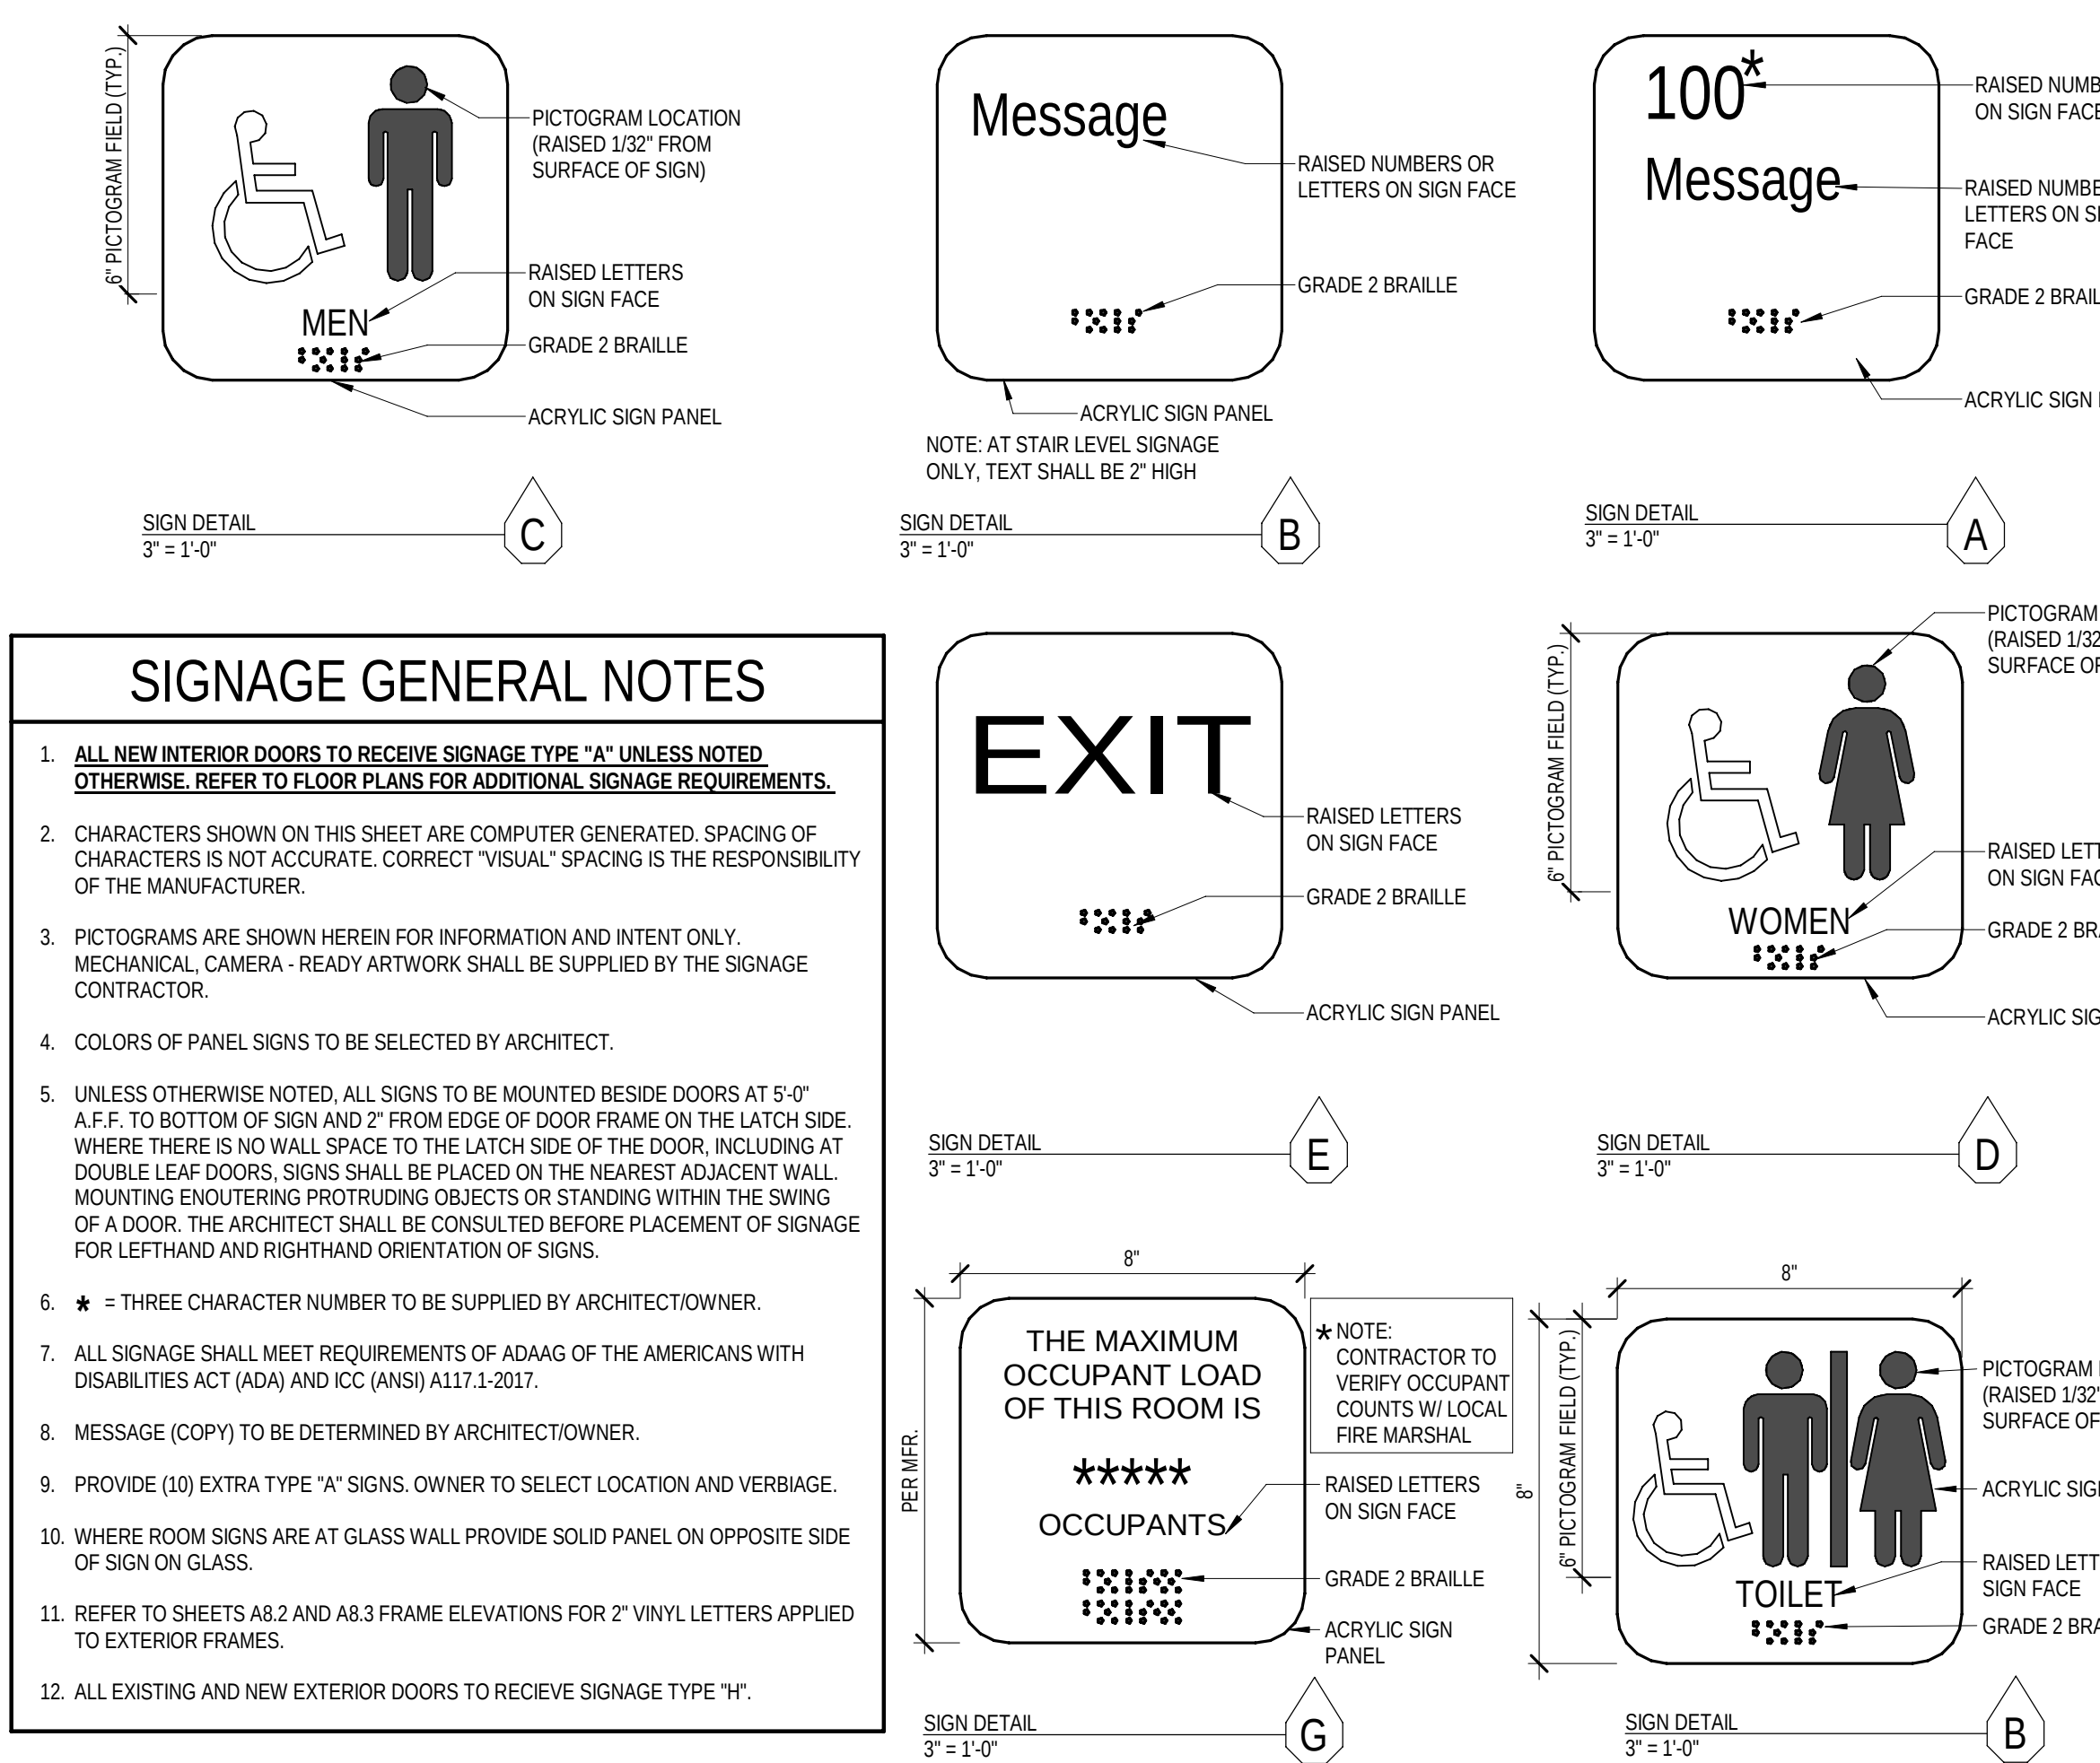


PARTITION TYPE GENERAL NOTES

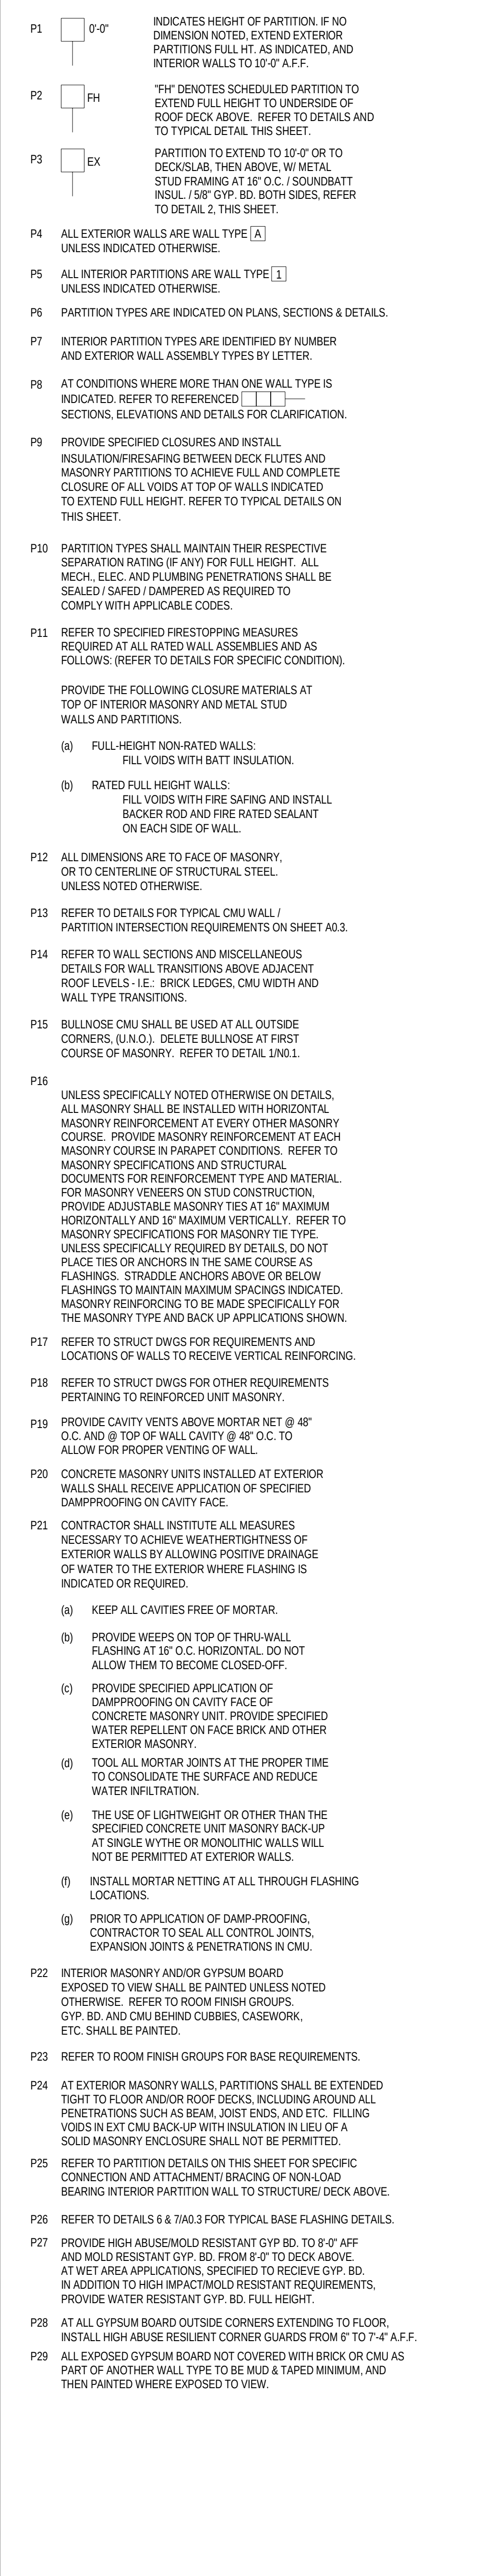


ROOM FINISH GROUPS





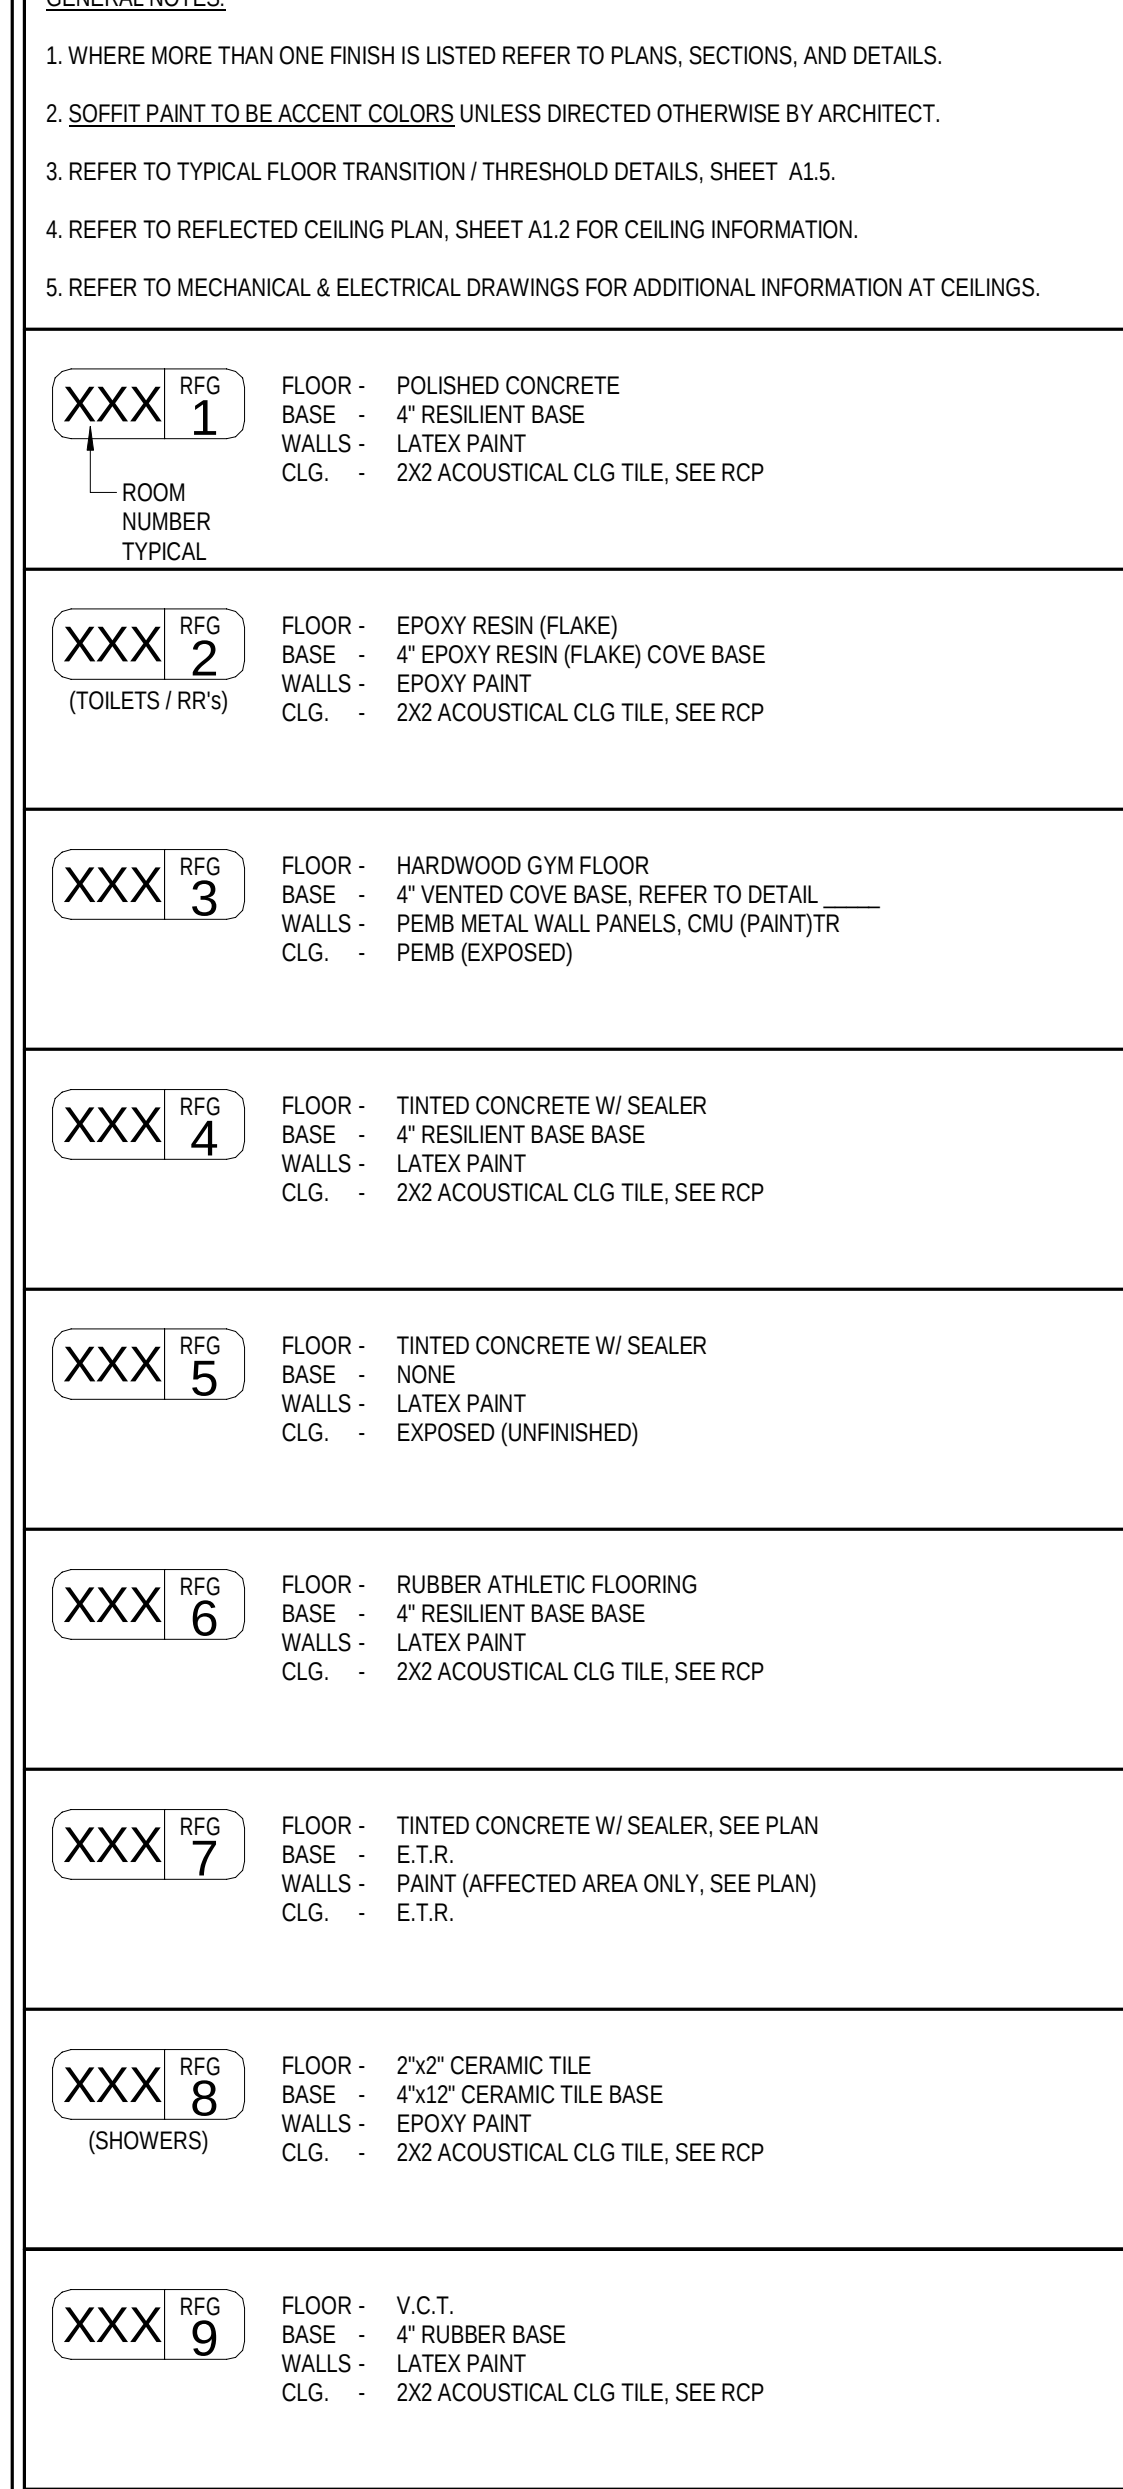


SYMBOL LEGEND

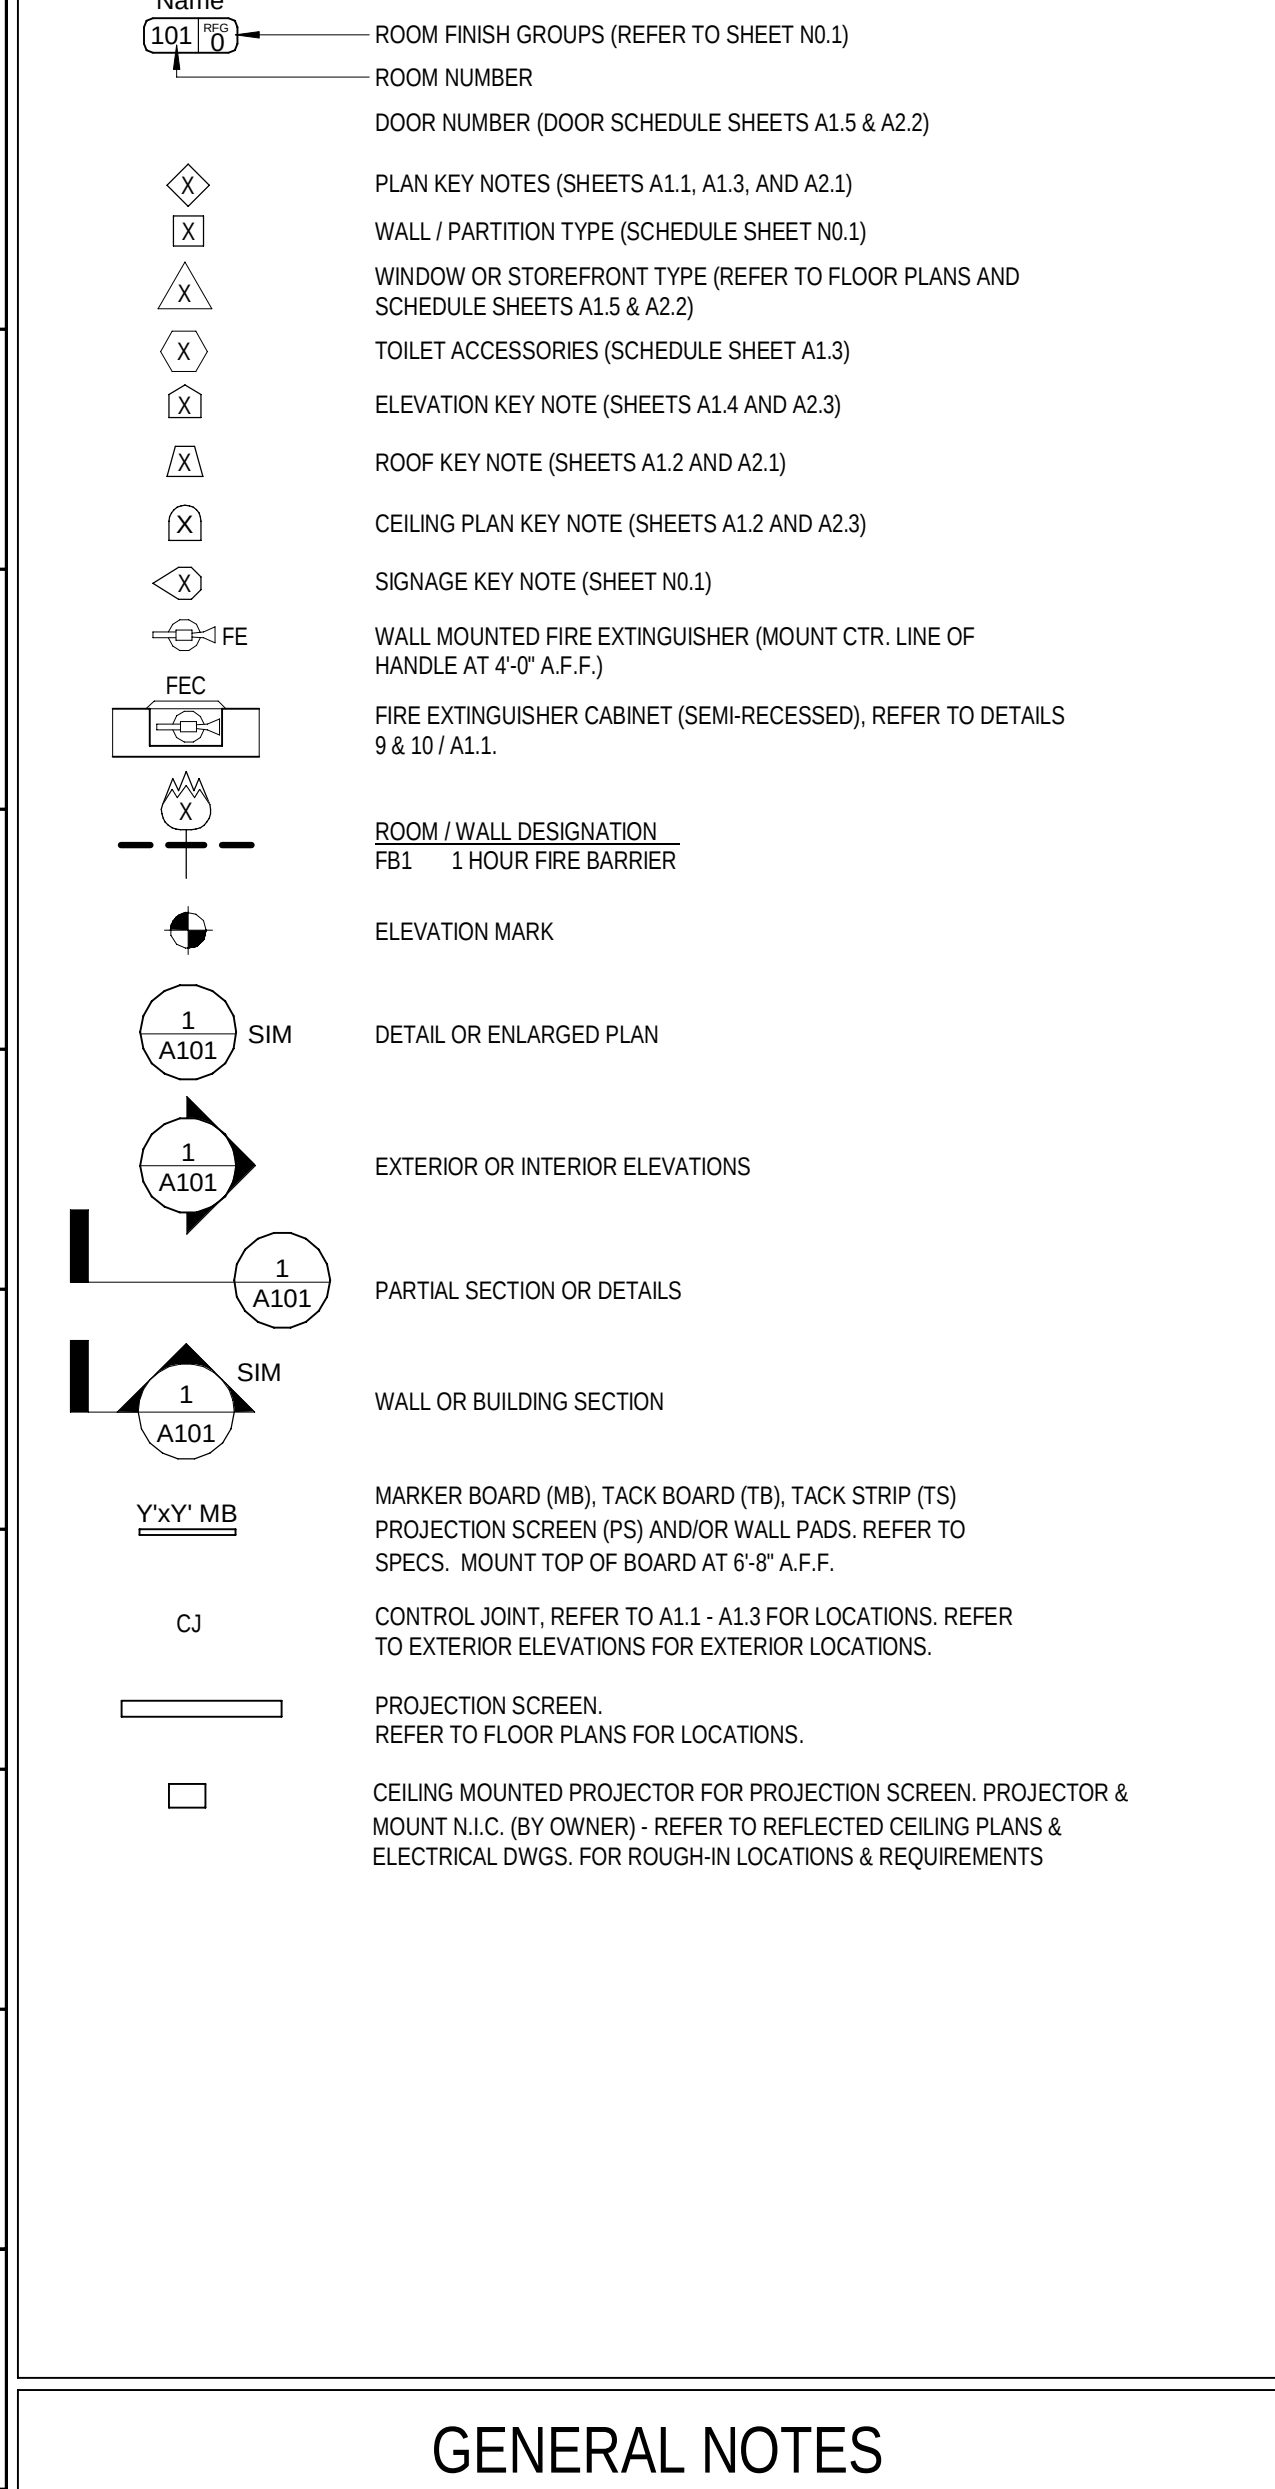


GENERAL NOTES

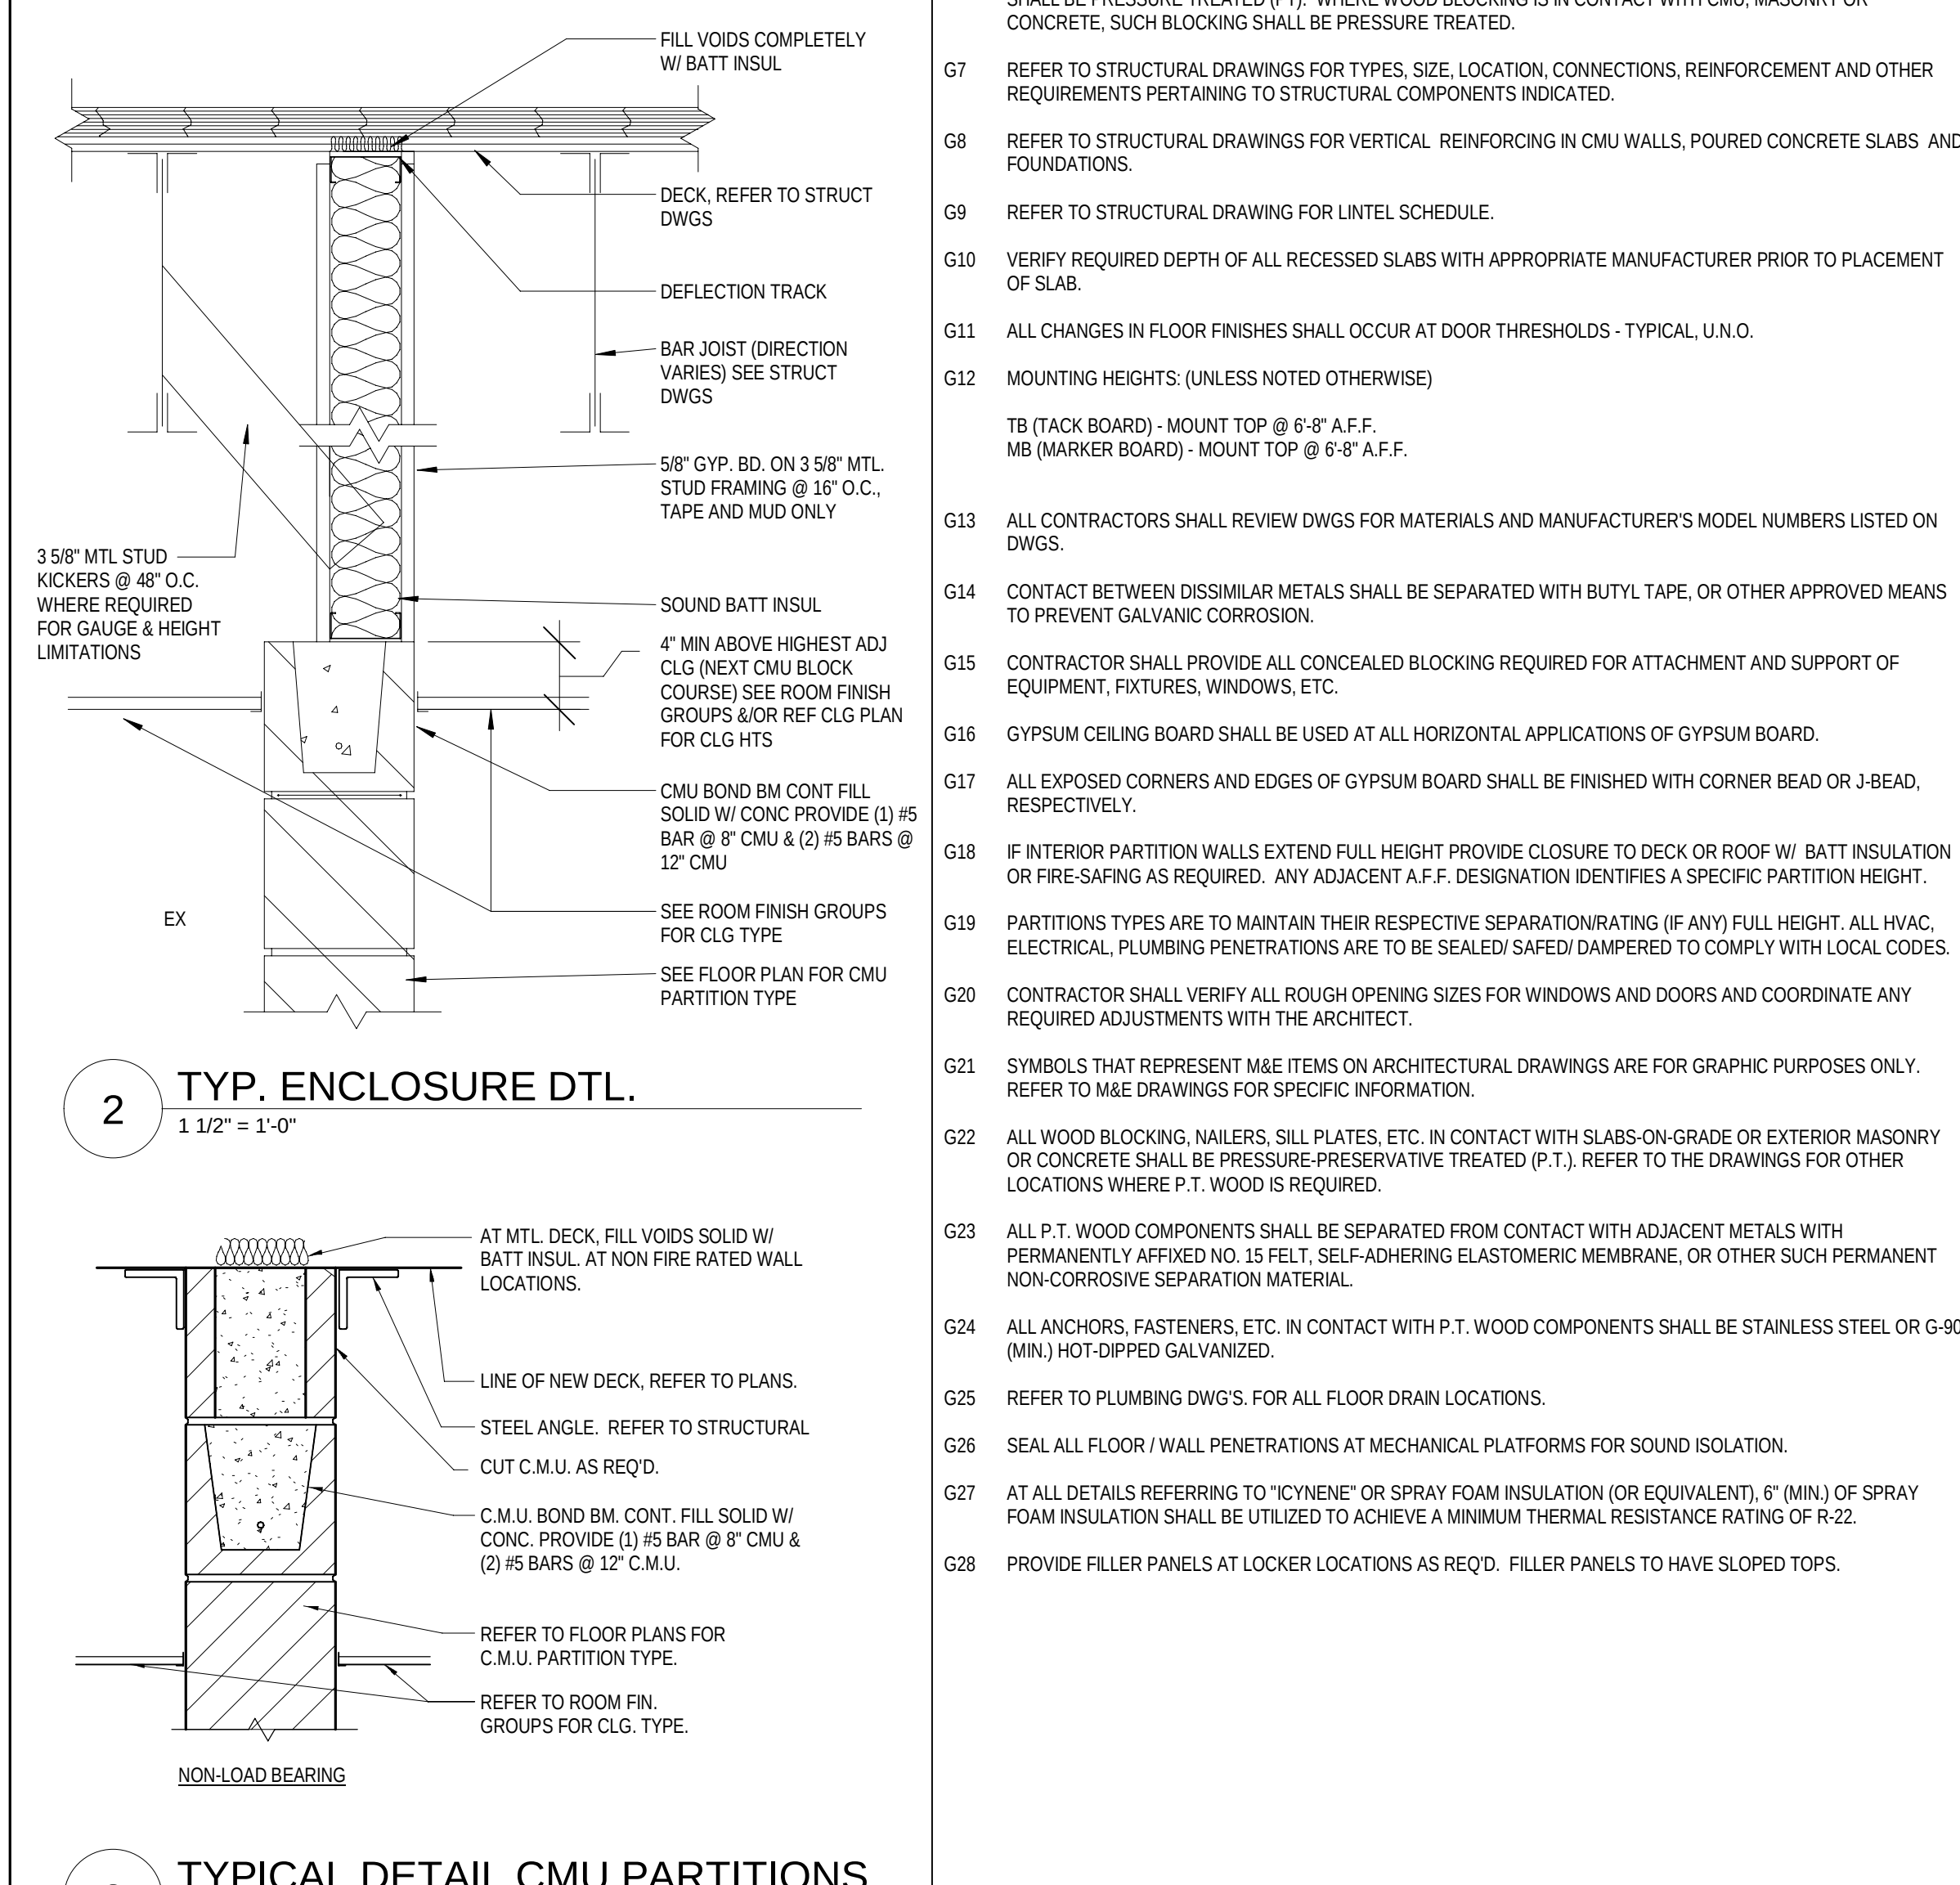

     


GENERAL TOILET ACCESSORY NOTES


- | | | |
|----|---|--|
| 1 | MODEL NOS. DENOTE TOOL ACCESSORIES PRODUCTS OFFERED BY AMERICAN SPECIALTIES, INC.' (ASI) AND REPRESENT THE | |
| 2 | LEVEL OF QUALITY REQUIRED AND SHALL BE USED AS A BASIS OF DESIGN. | |
| 3 | ALL ITEMS SHALL BE IDENTIFIED HORIZONTALLY AND MOUNTED TO SPECIFIC POINT ABOVE FINISH FLOOR SURFACE IN | |
| 4 | CONCRETE AT THE FOLLOWING LOCATIONS: ALL ACCESSORIES AND GRAB BARS WITH GRAB BARS DCT (ADA) - ASI A117.1 - 2009 | |
| 5 | REFER TO MEP DWG. AND SPECIFICATIONS FOR PLUMBING FIXTURES, CONTROLS AND FLOOR DRAIN LOCATIONS. | |
| 6 | ALL EXPOSED PIPING AT LAVATORIES / H.C. LAVS SHALL BE INSULATED AND COVERED WITH A PRE MOLDED RIGID INSULATION | |
| 7 | JACKET | |
| 8 | 5. ALL TOOL ACCESSORIES TO INCLUDE VANDAL RESISTANT OPTION. | |
| 9 | REFER TO ALL FLOOR PLAN SHEETS FOR ACCESSORIES REQUIRED AT OTHER LOCATIONS. | |
| 10 | INSTALL GRAB BARS TO ALLOW 1" GIP BETWEEN GRAB BARS AND WALL. | |
| 11 | REFER TO TYPICAL ADA COMPLIANT GRAB BAR SIAJ01.1 | |

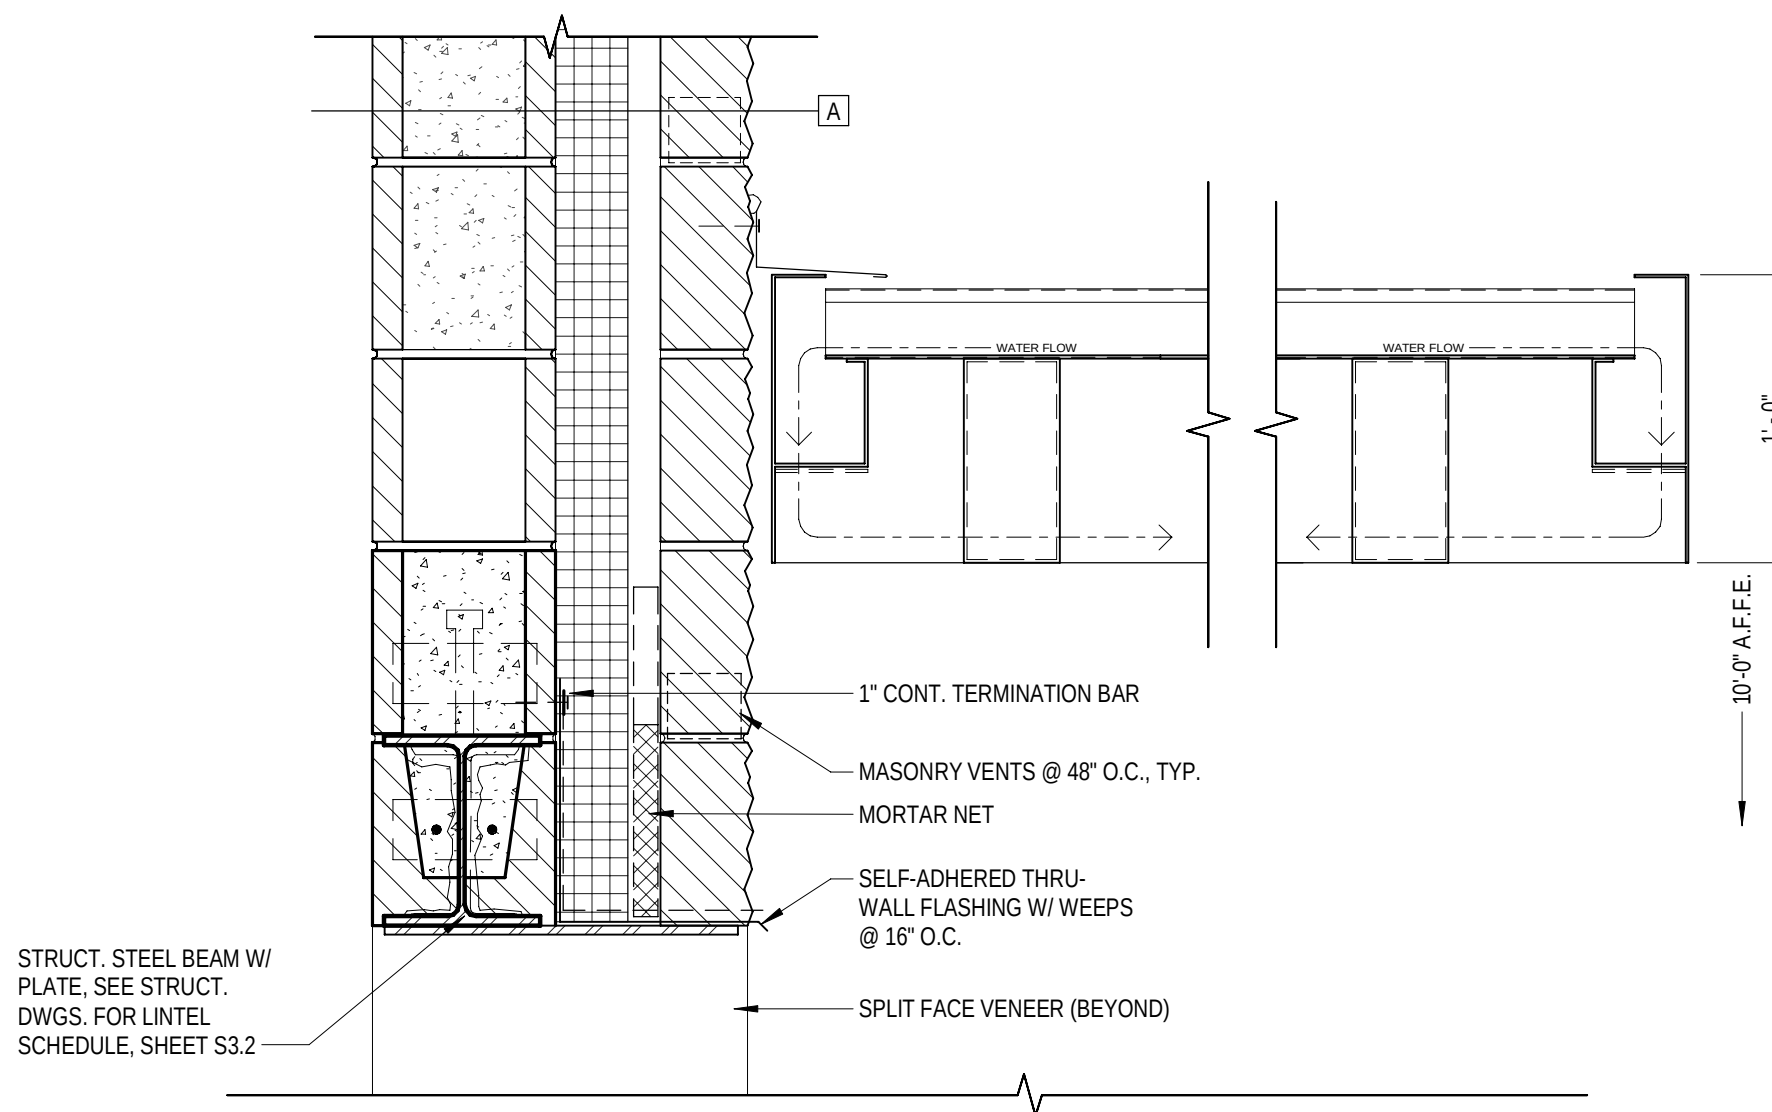


11 CANOPY DETAIL

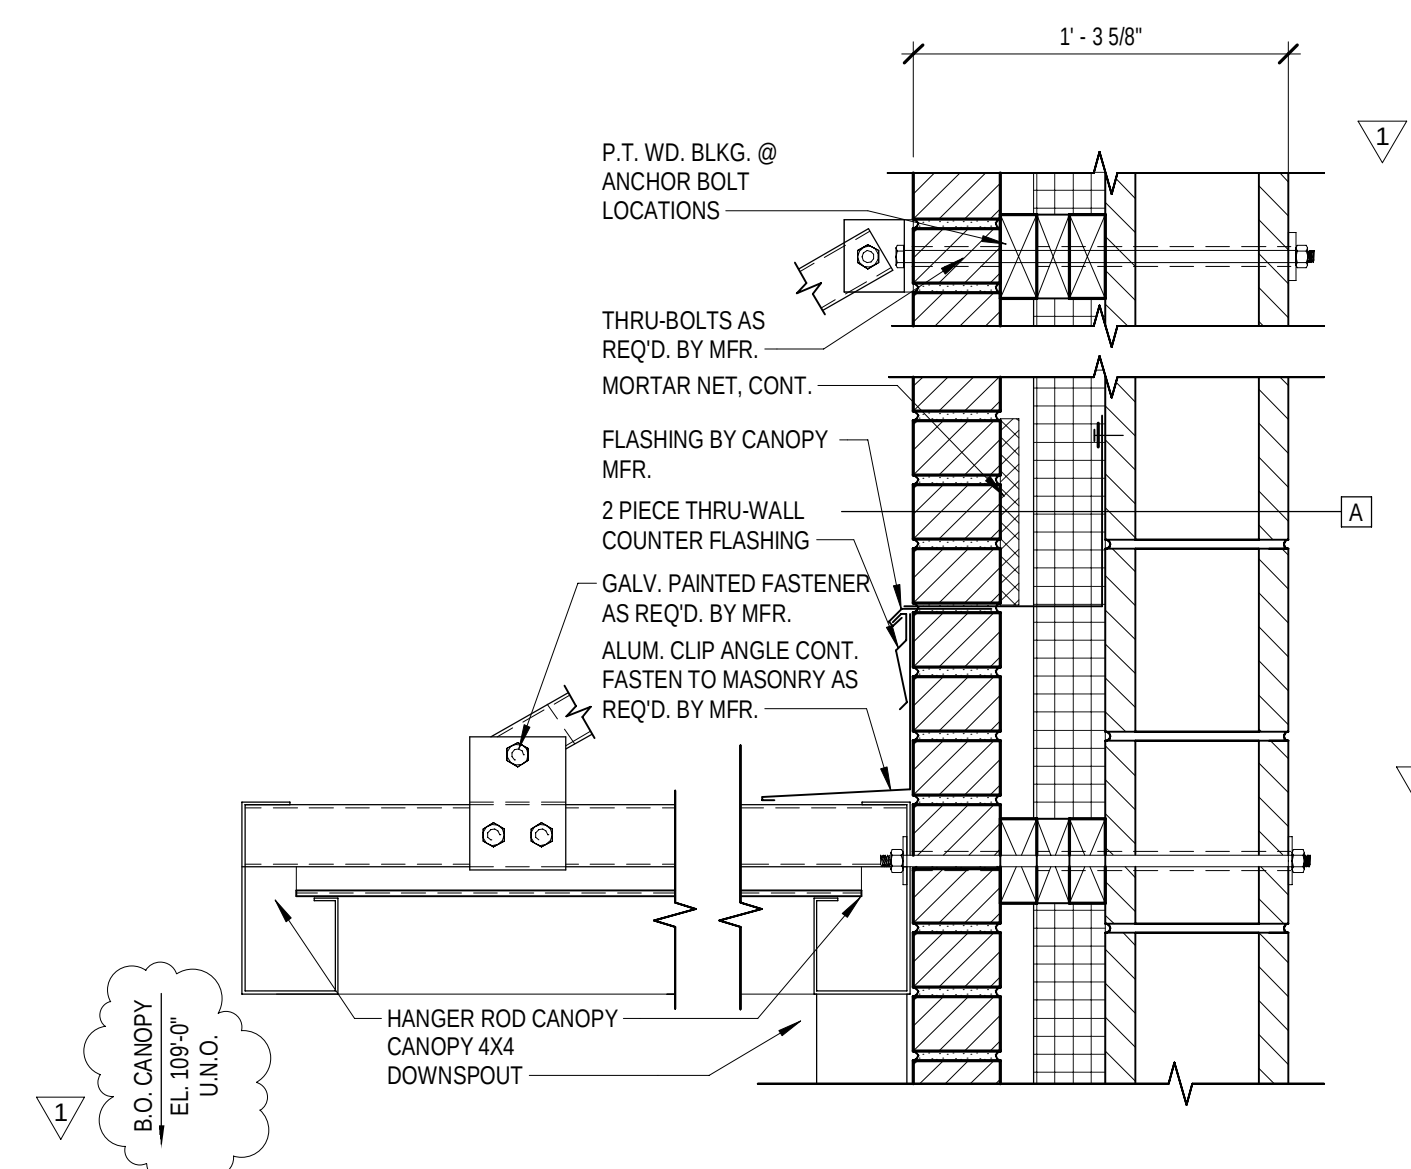


12 ALUMINUM CANOPY DETAIL
1 1/2" = 1'-0"

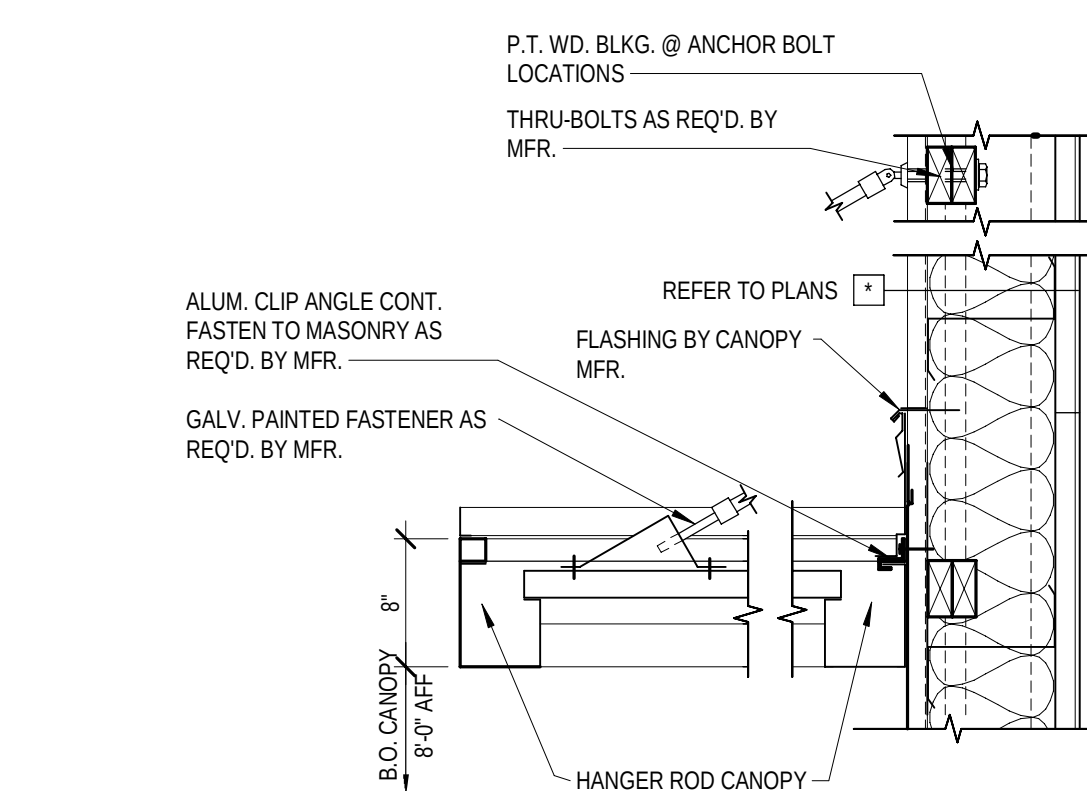


13 DETAIL
1" = 1'-0"

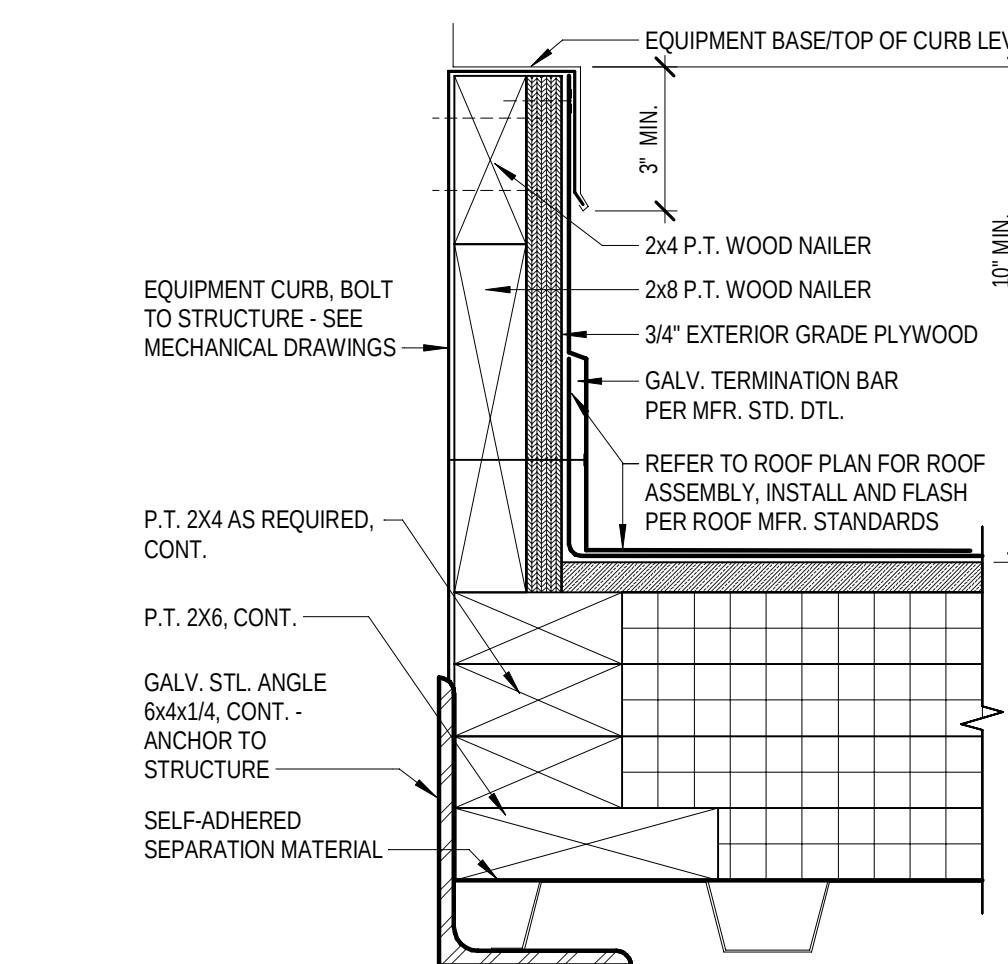


14 TYP. COPING DETAIL
3" = 1'-0"

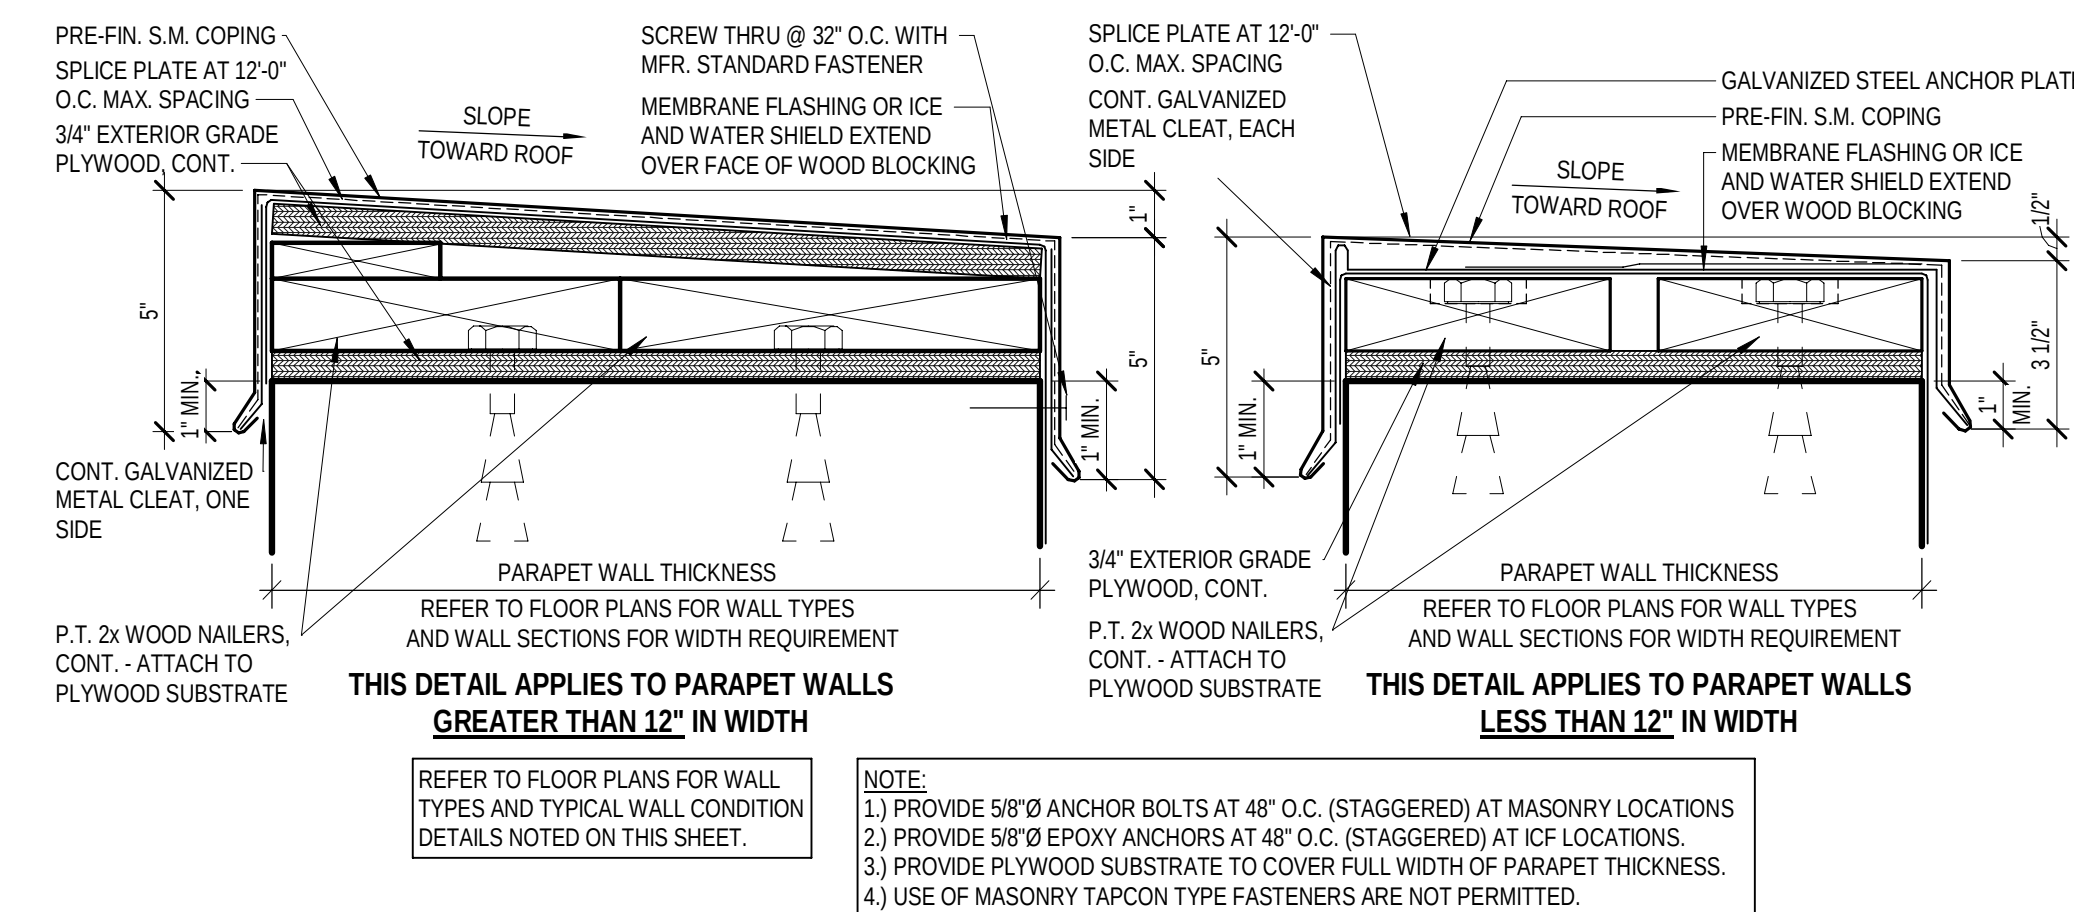


1 TYP. COPING DETAIL
3" = 1'-0"

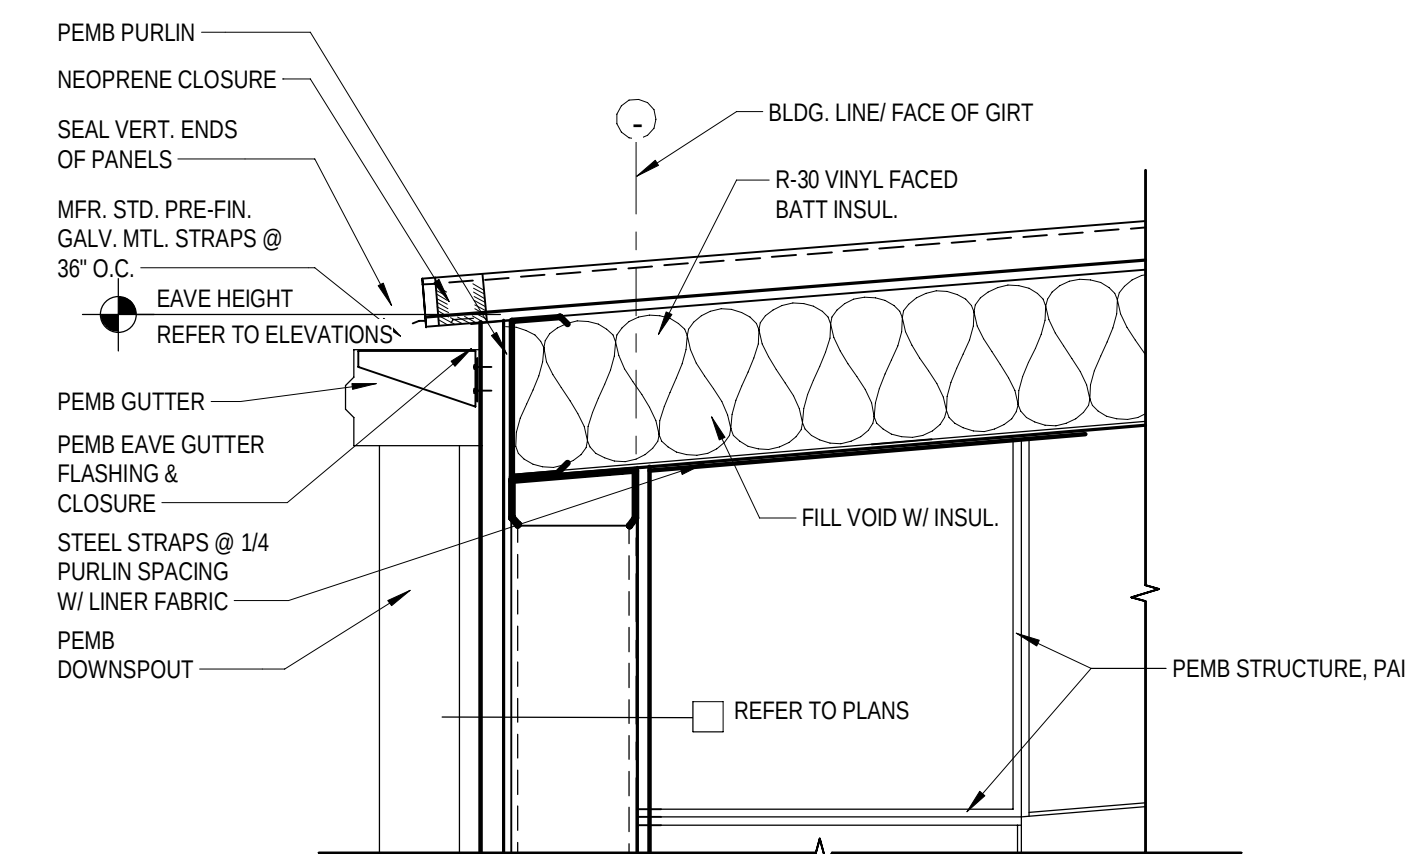


7 ROOF DETAIL @ PEMB GUTTER
1" = 1'-0"

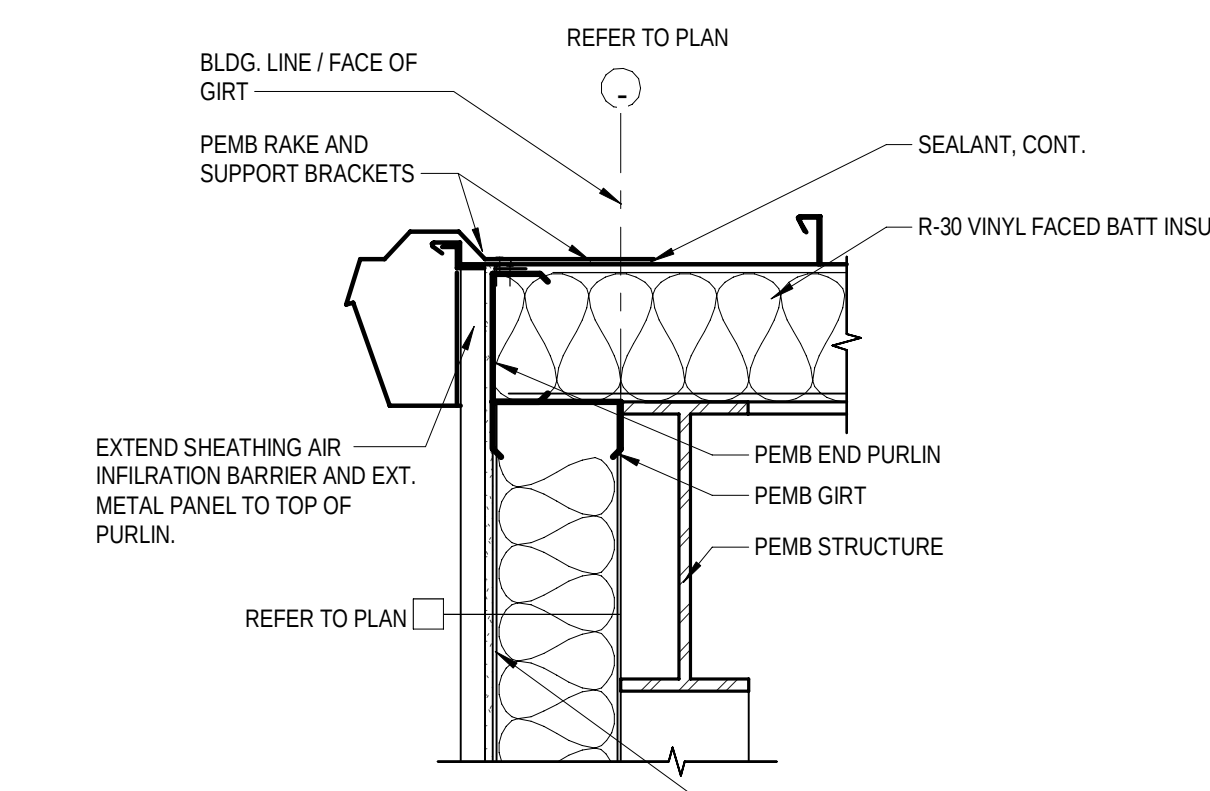


8 RAKE @ PEMB
1" = 1'-0"

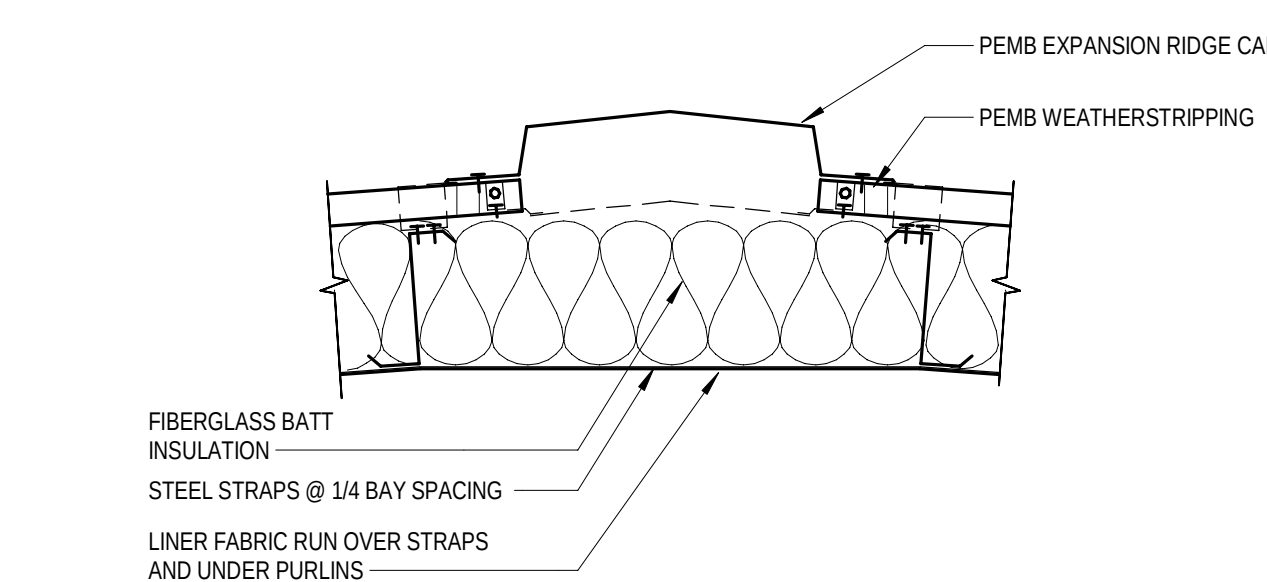


9 PEMB RIDGE CAP DETAIL @ ROOF TYPE 'B'
1" = 1'-0"

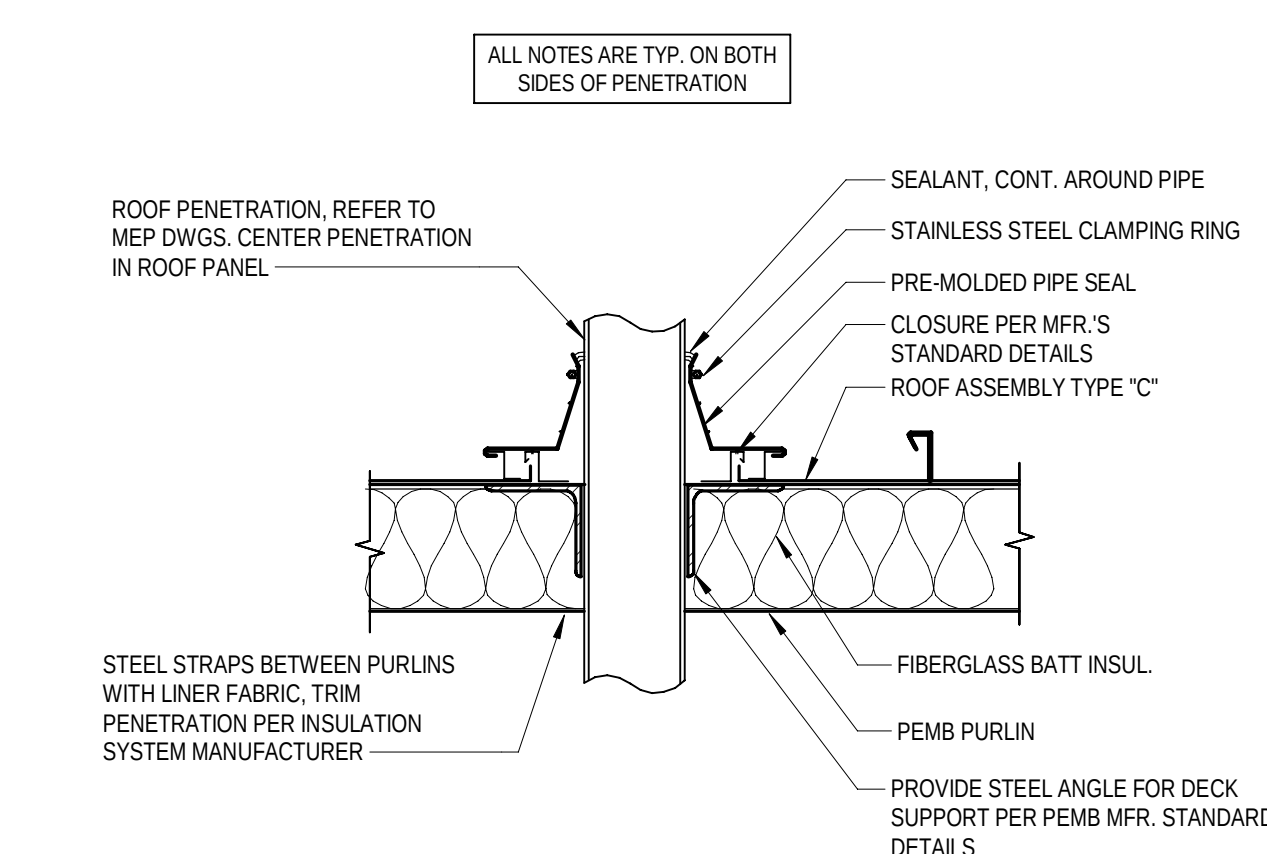


10 TYP. VENT THRU ROOF @ ROOF TYPE 'C'
1" = 1'-0"

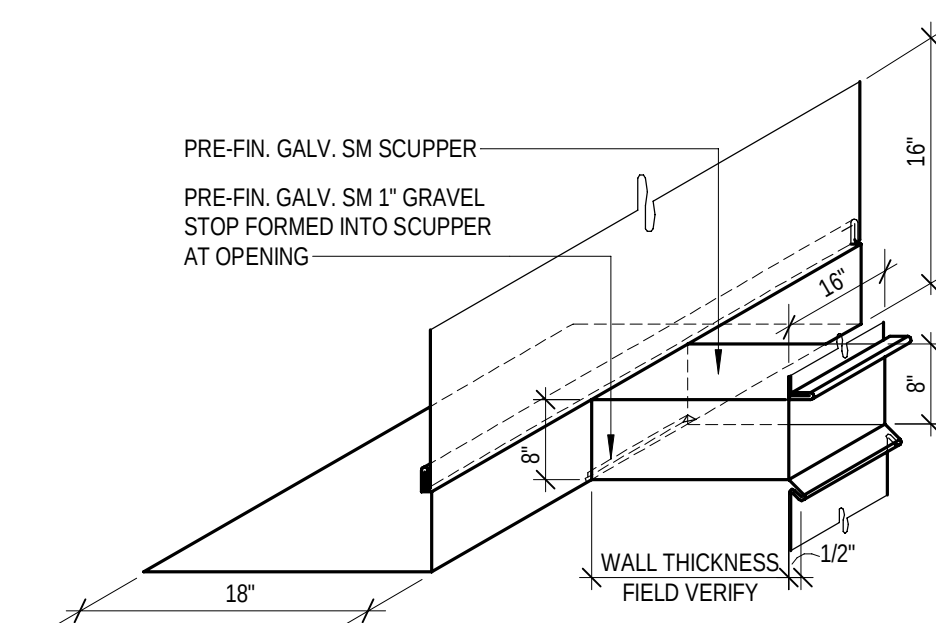


2 TYP. SCUPPER DETAIL
1 1/2" = 1'-0"

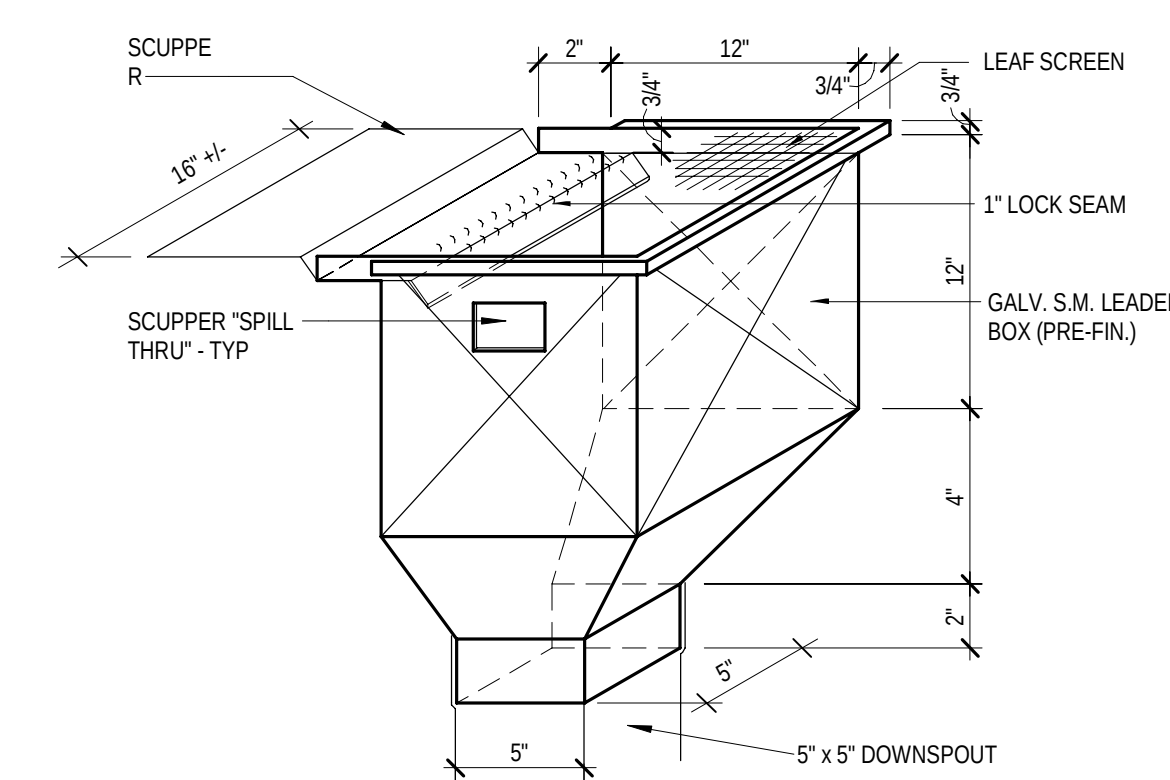


3 CONDUCTOR HEAD DETAIL

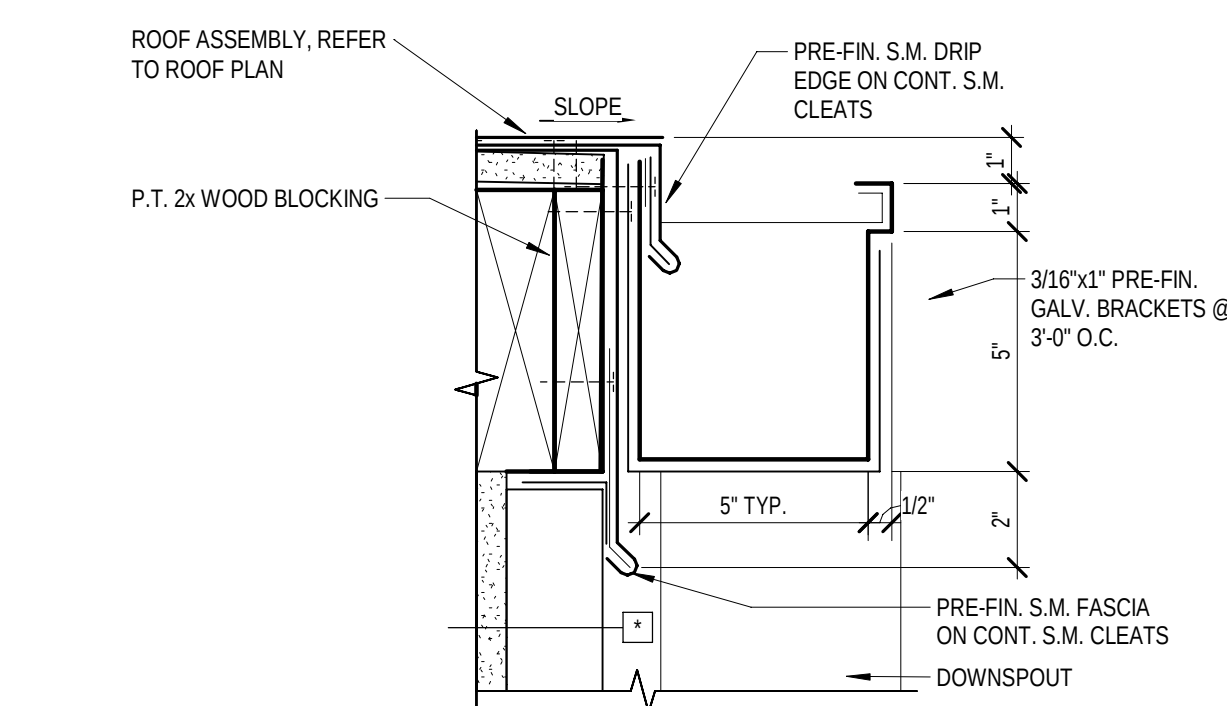


4 TYP. GUTTER DETAIL
3" = 1'-0"

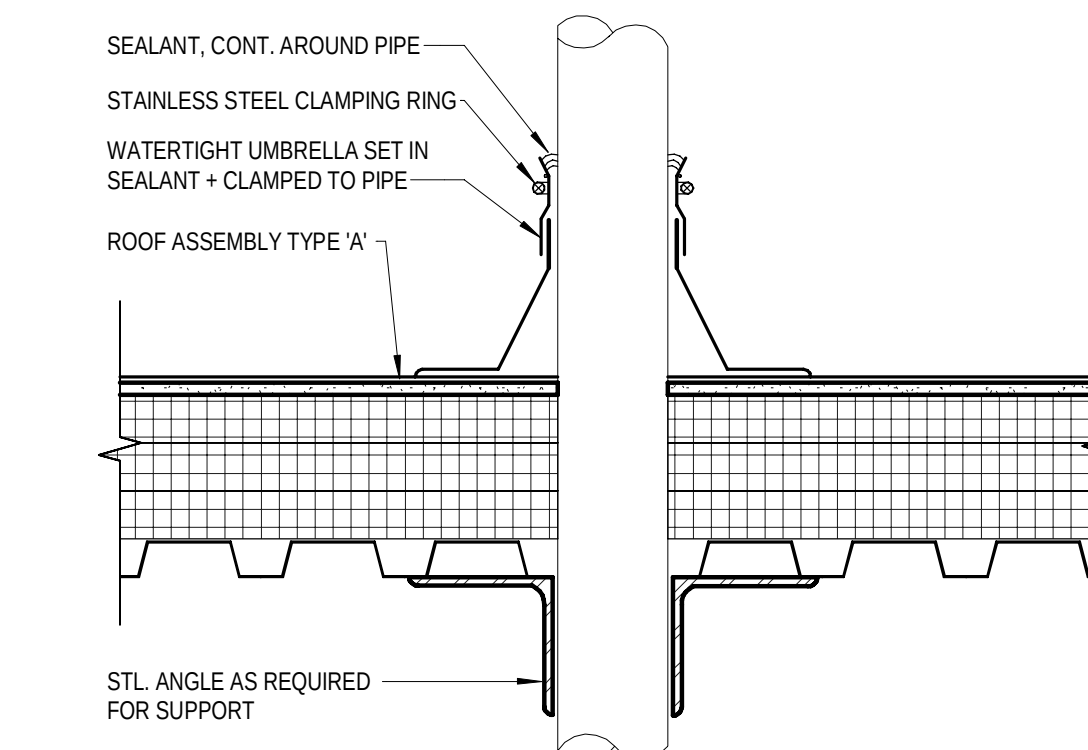


5 TYP. ROOF PENETRATION @ ROOF TYPE 'A'

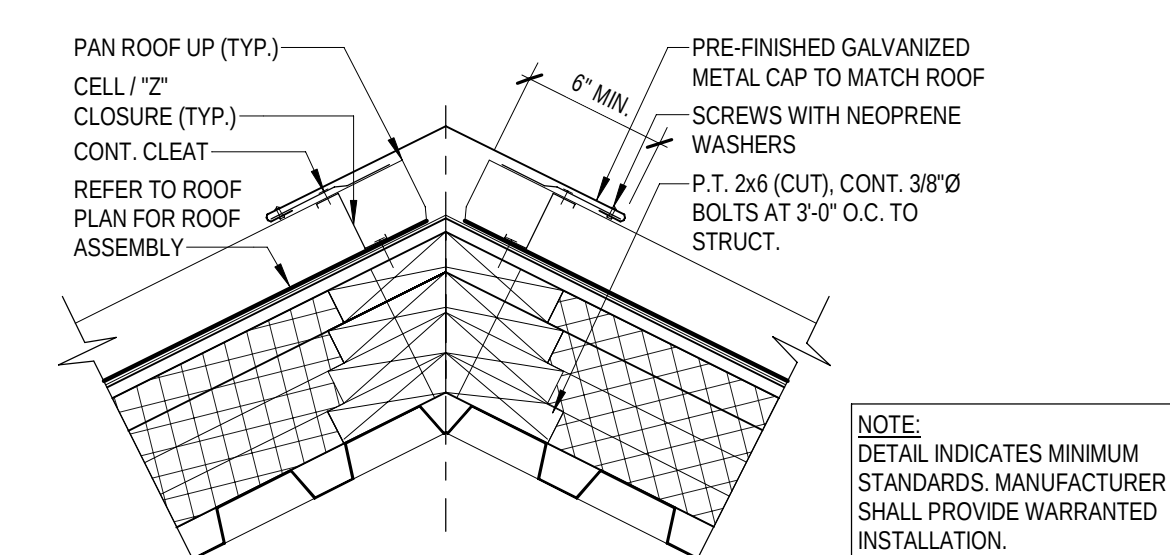


6 RIDGE CAP @ ROOF TYPE 'C'
1 1/2" = 1'-0"

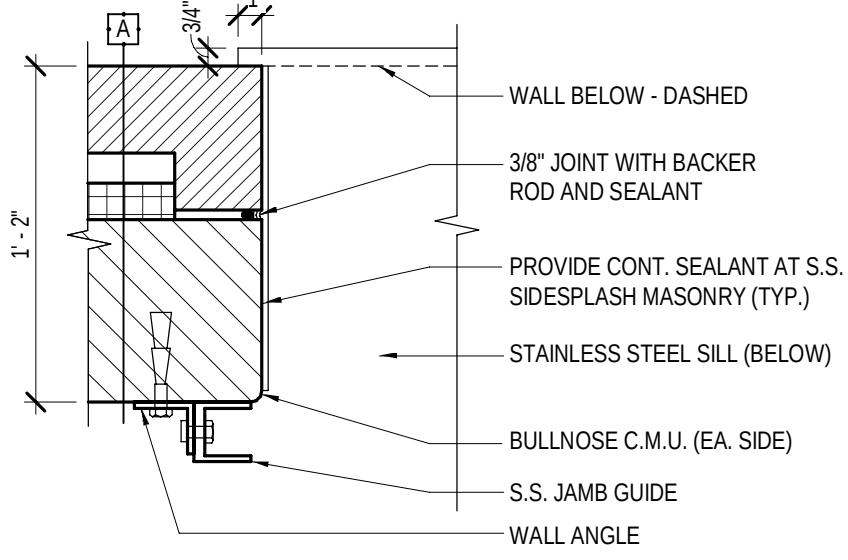


12 COILING SHUTTER COUNTER JAMB DETAIL
1 1/2" = 1'-0"

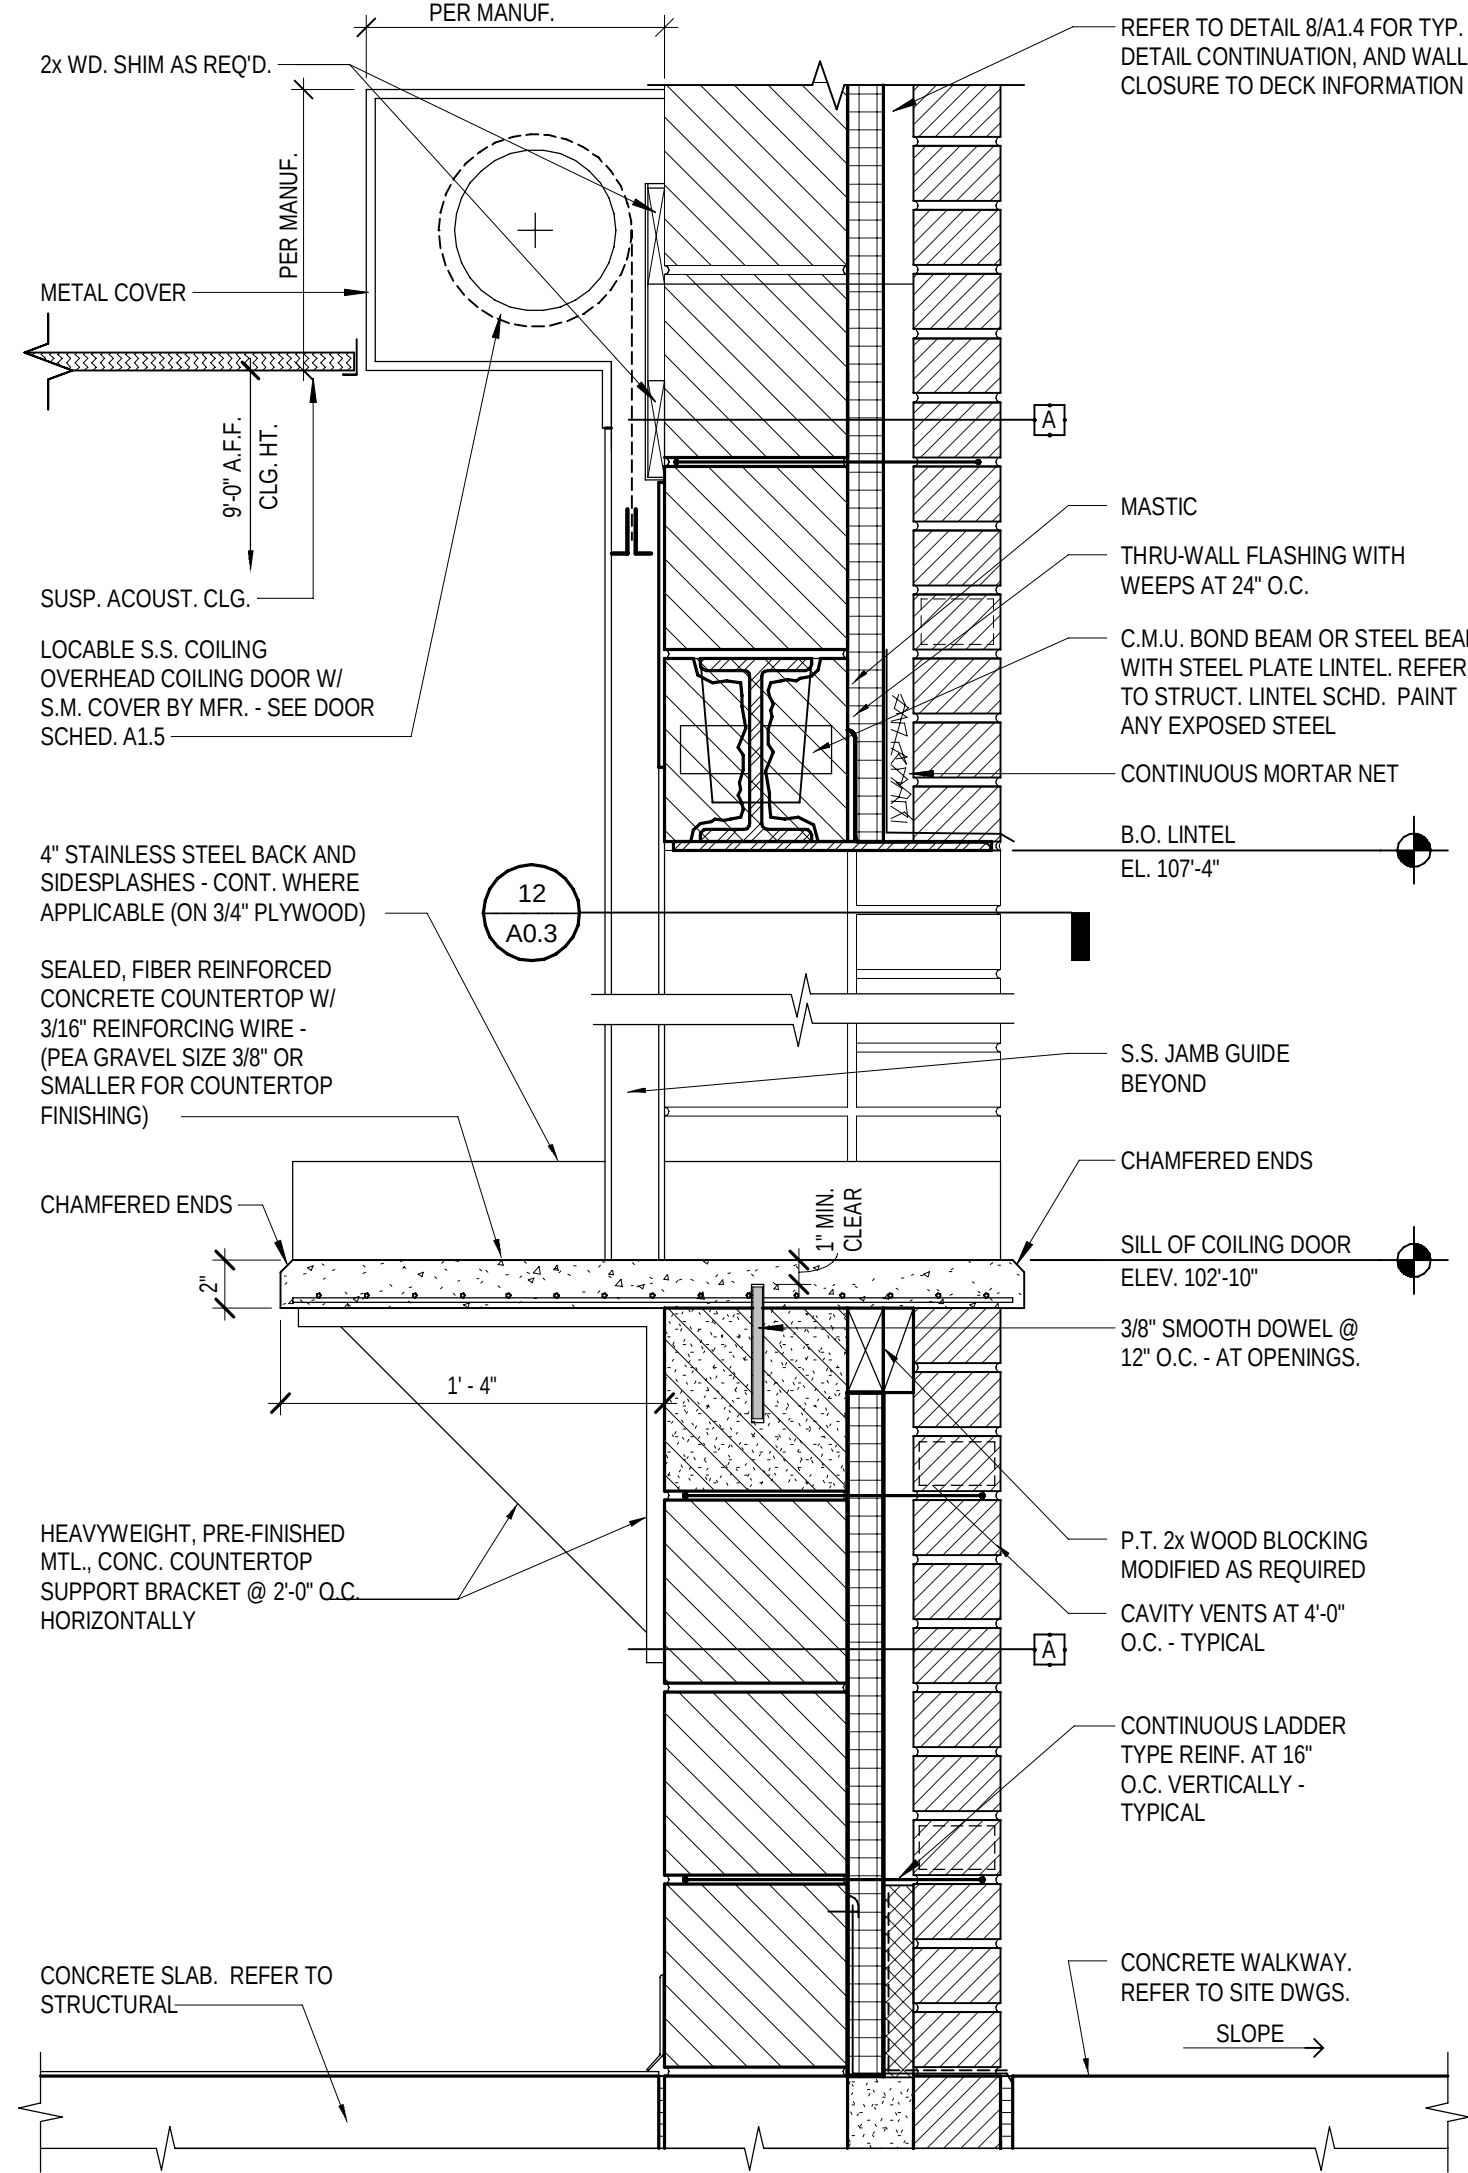


10 COILING SHUTTER COUNTER DETAIL - CONCRETE COUNTER
1 1/2" = 1'-0"

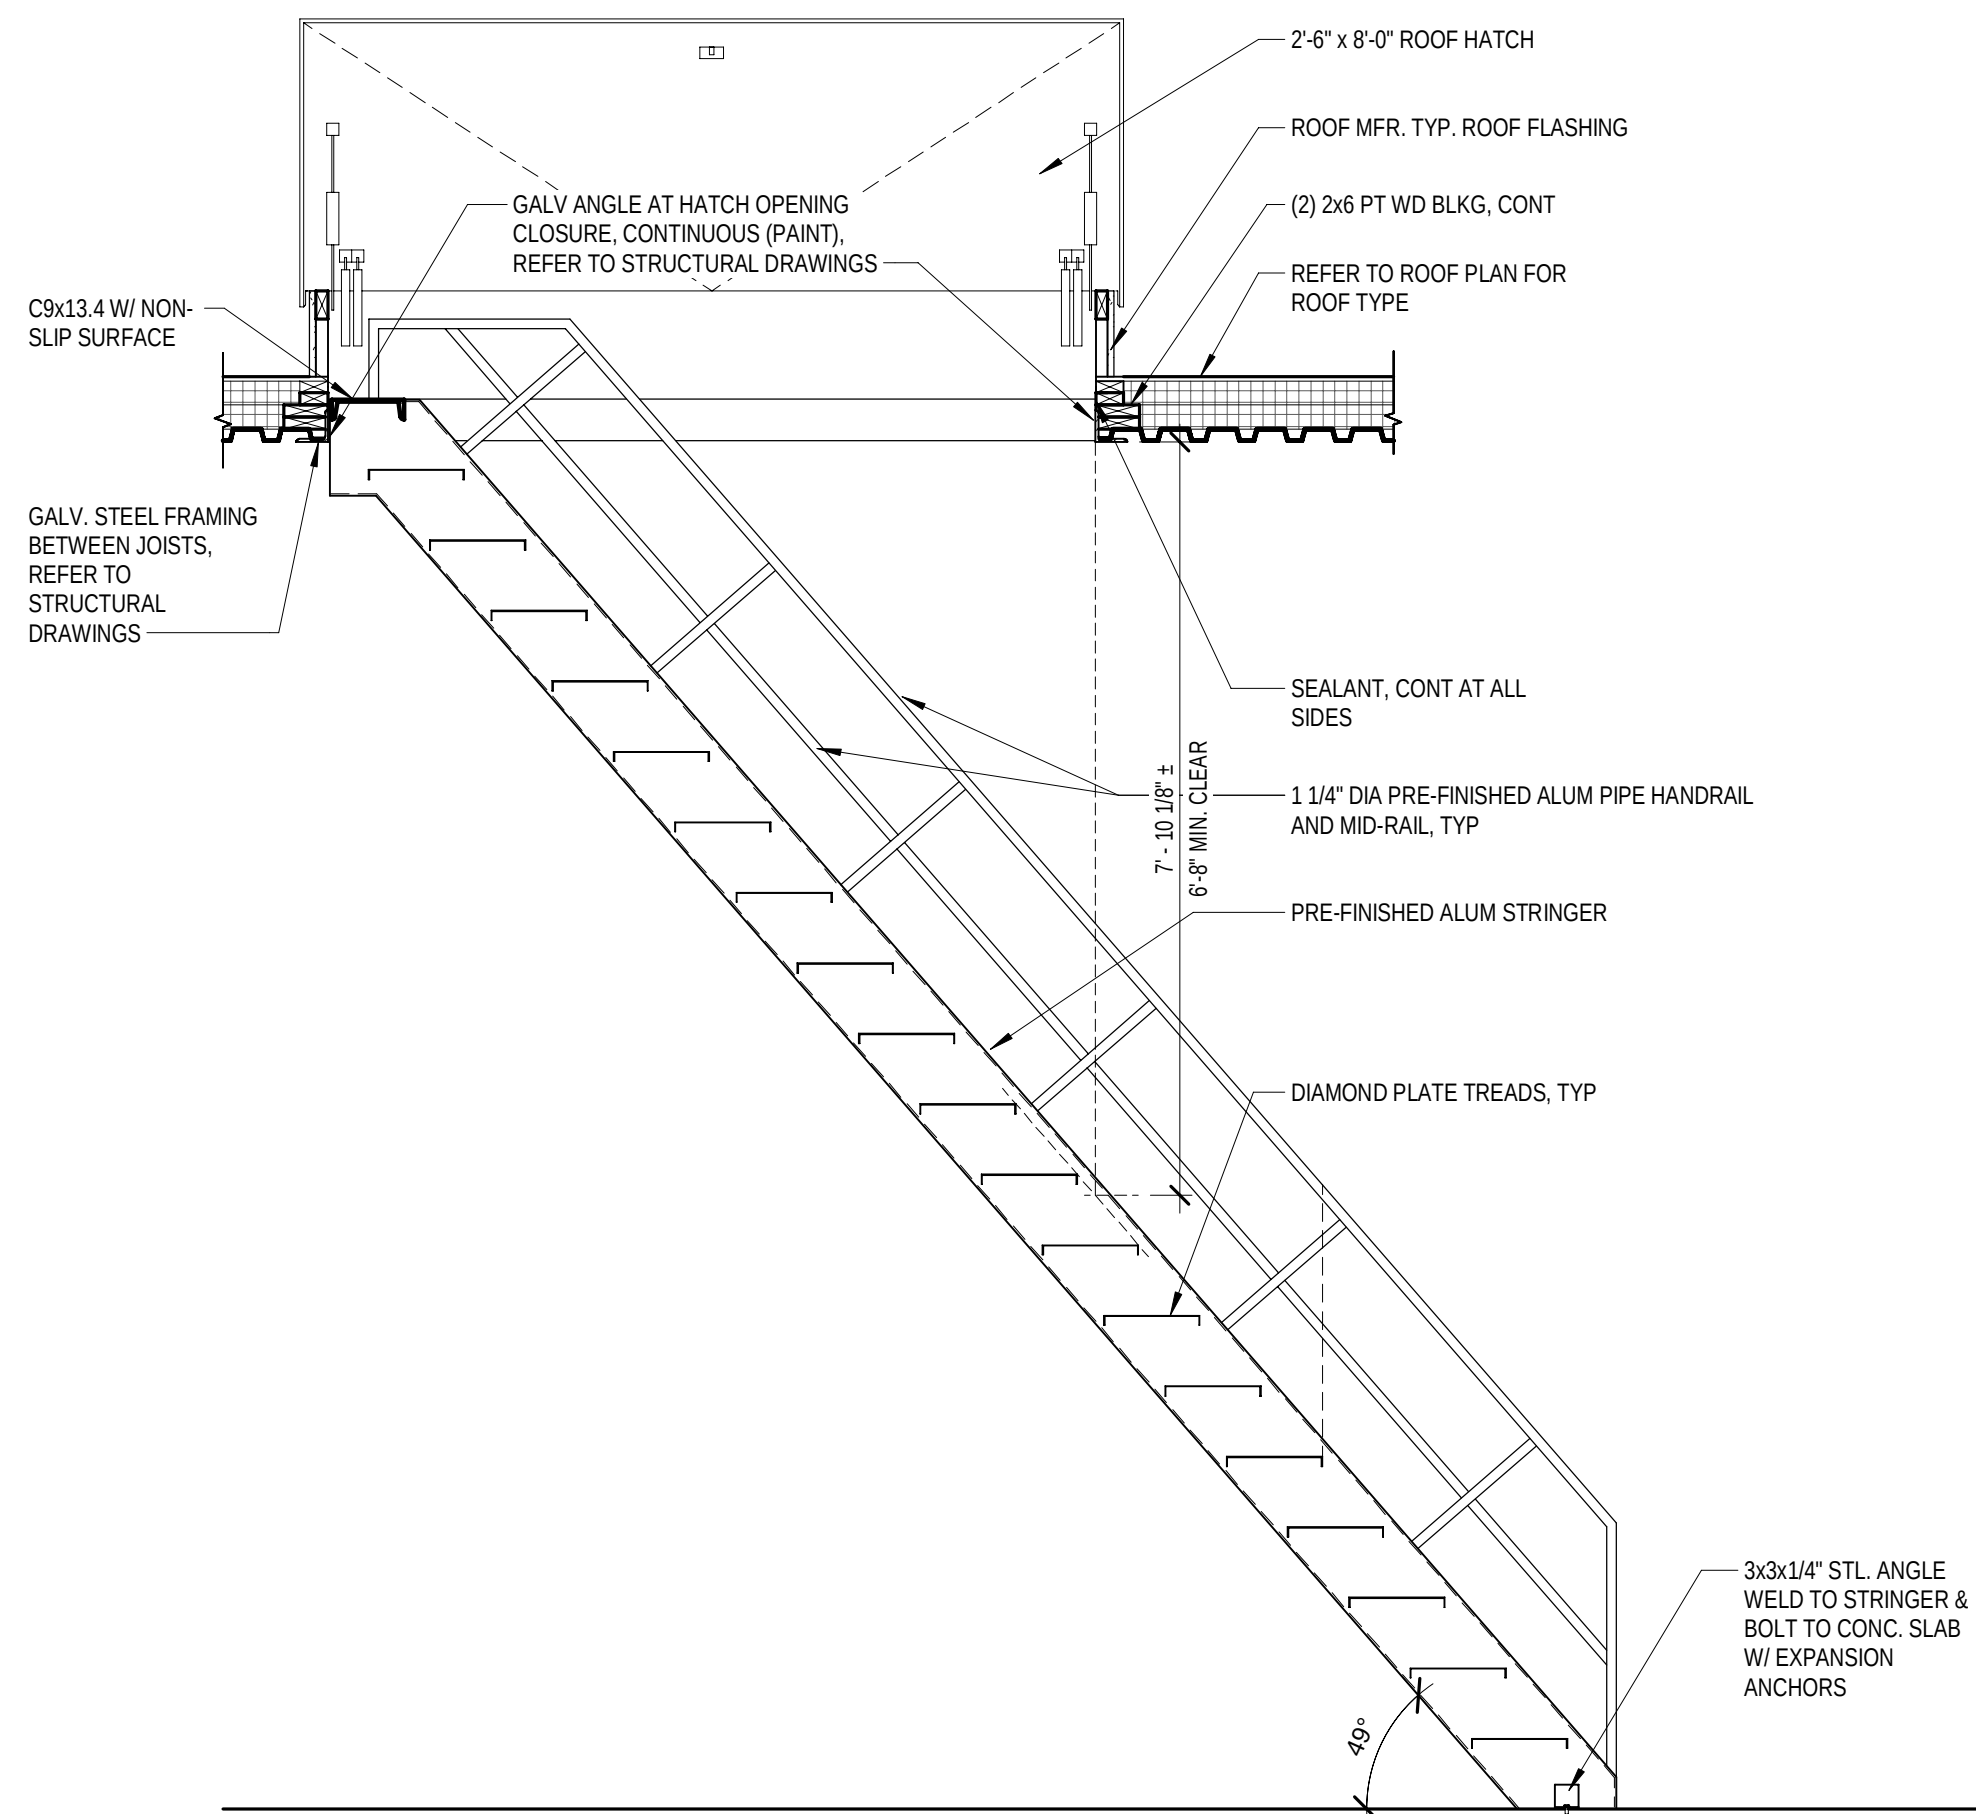


11 INDUSTRIAL STAIR DETAIL
1/2" = 1'-0"

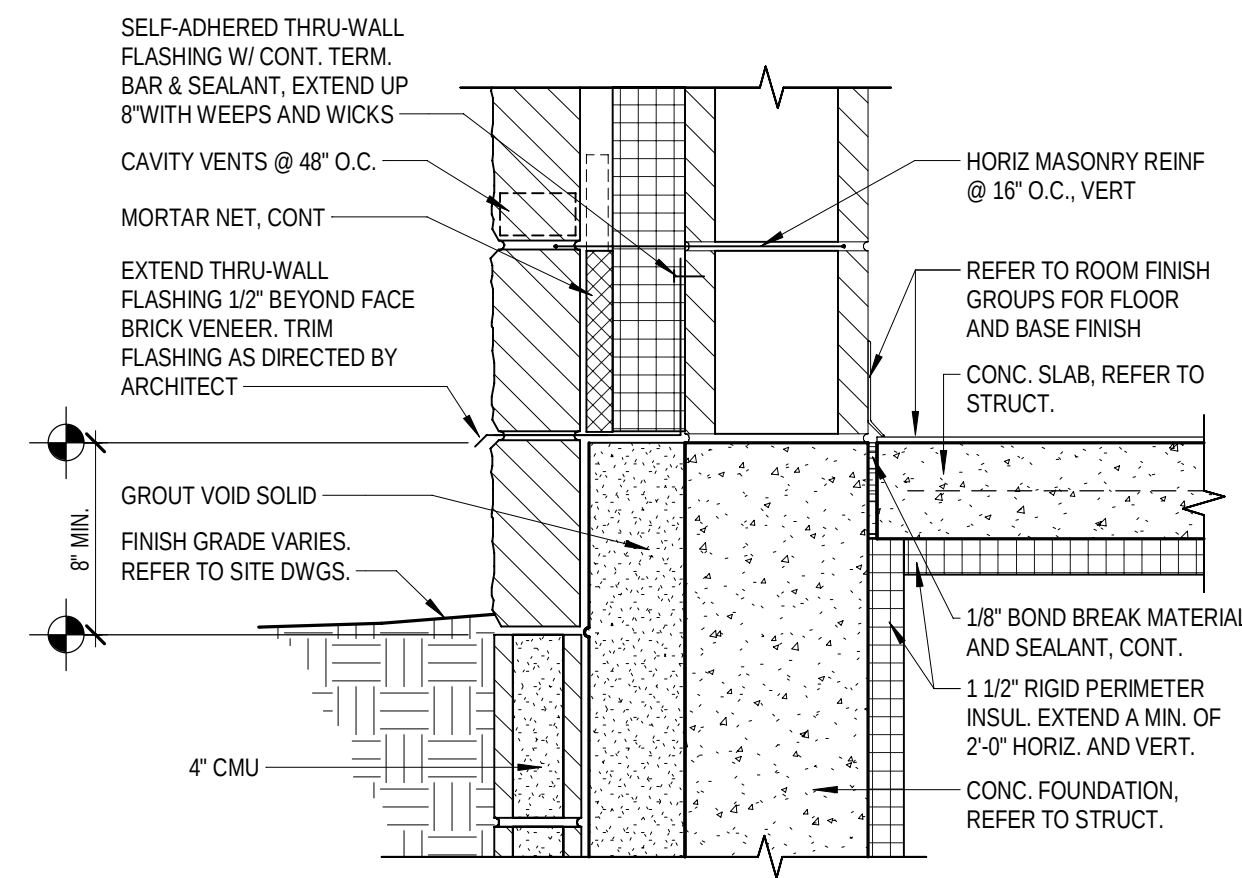


6 BASE FLASHING DETAIL
1 1/2" = 1'-0"

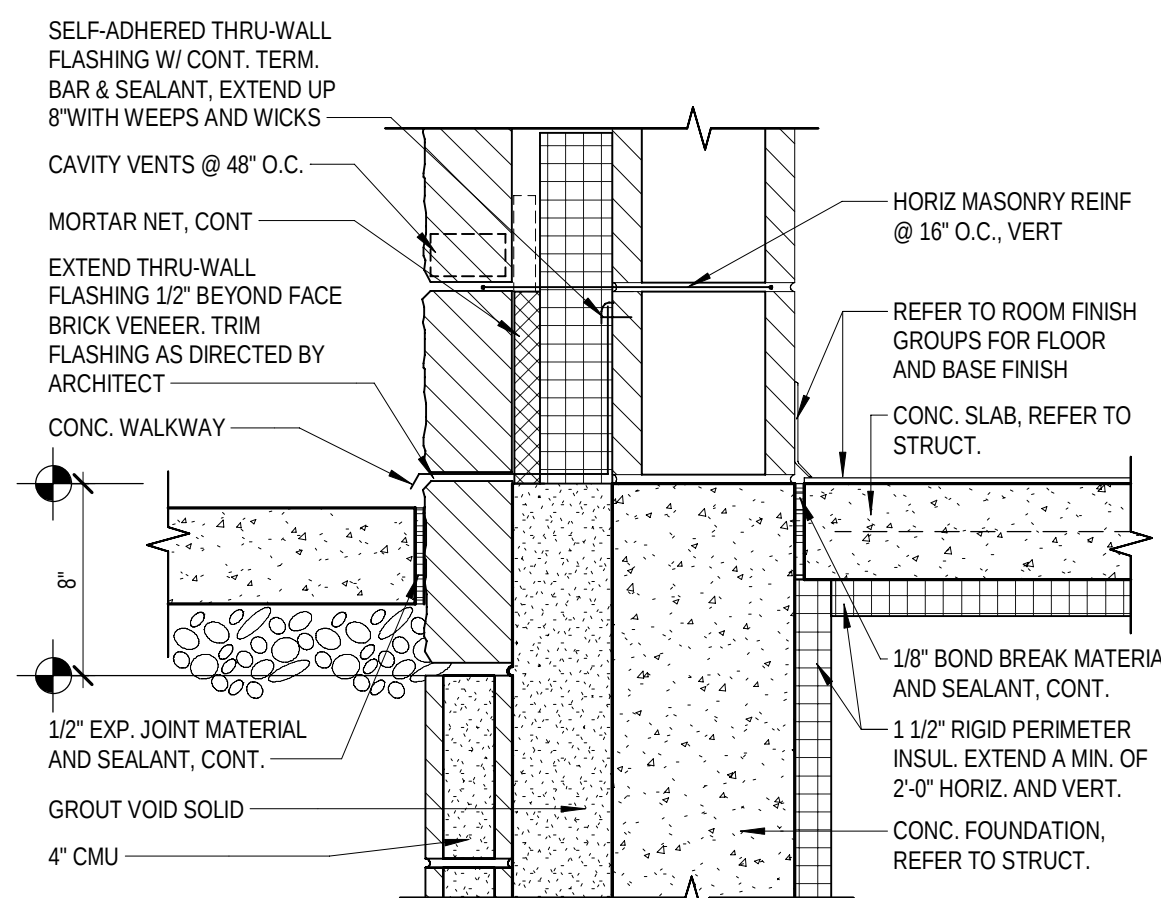


7 BASE FLASHING DETAIL
1 1/2" = 1'-0"

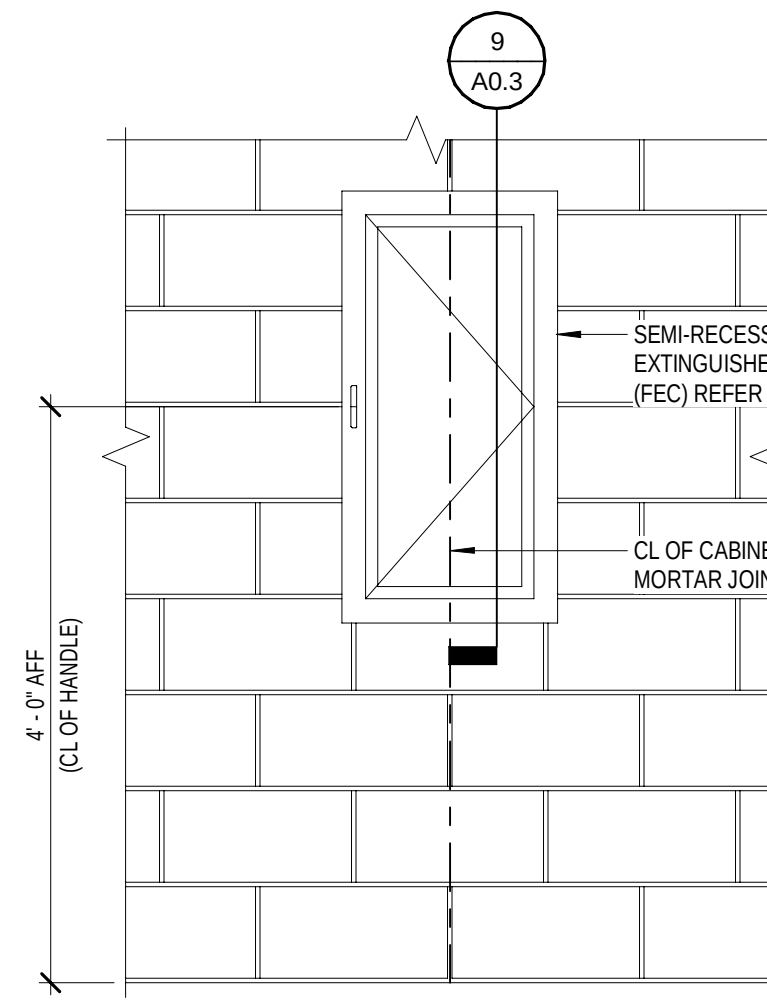


8 TYP. FEC ELEVATION @ INTERIOR CMU WALL
3/4" = 1'-0"

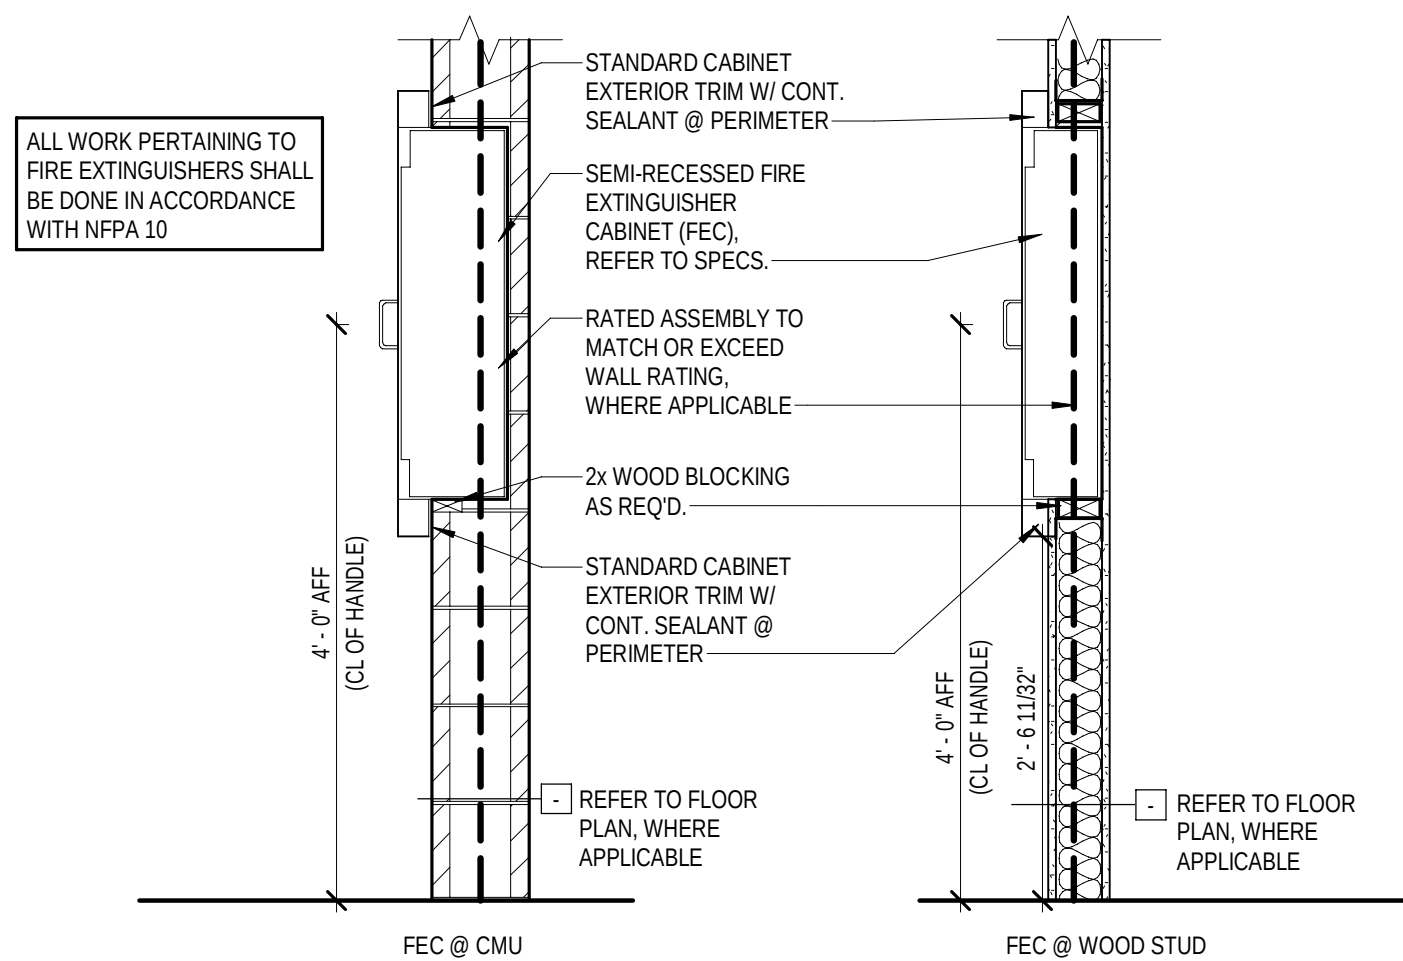


9 TYP. FEC SECTION
3/4" = 1'-0"

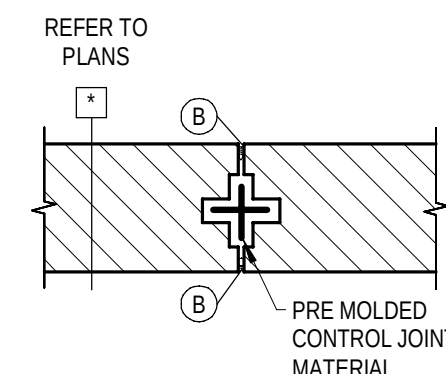


1 TYP. CONTROL JOINT @ INTERIOR CMU WALL
1" = 1'-0"

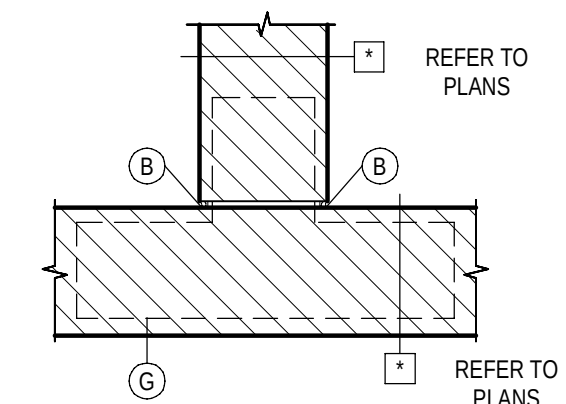


2 TYP. CMU PERP. TO CMU
1" = 1'-0"

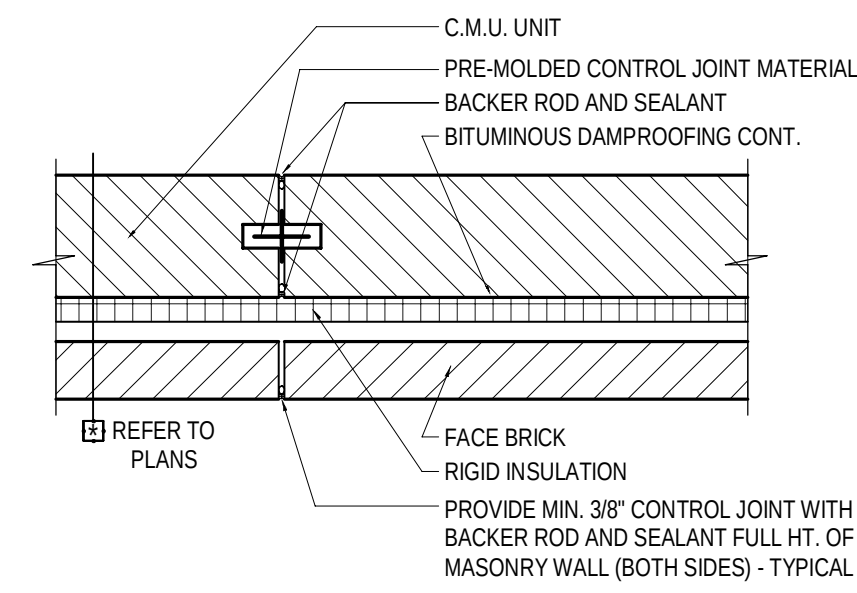

3 TYP. CONTROL JOINT @ EXTERIOR WALL TYPE 'A'
1" = 1'-0"

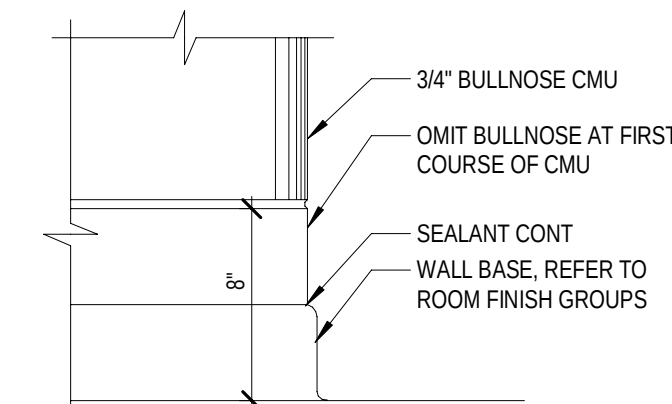

4 TYP. CMU BASE DETAIL
1 1/2" = 1'-0"

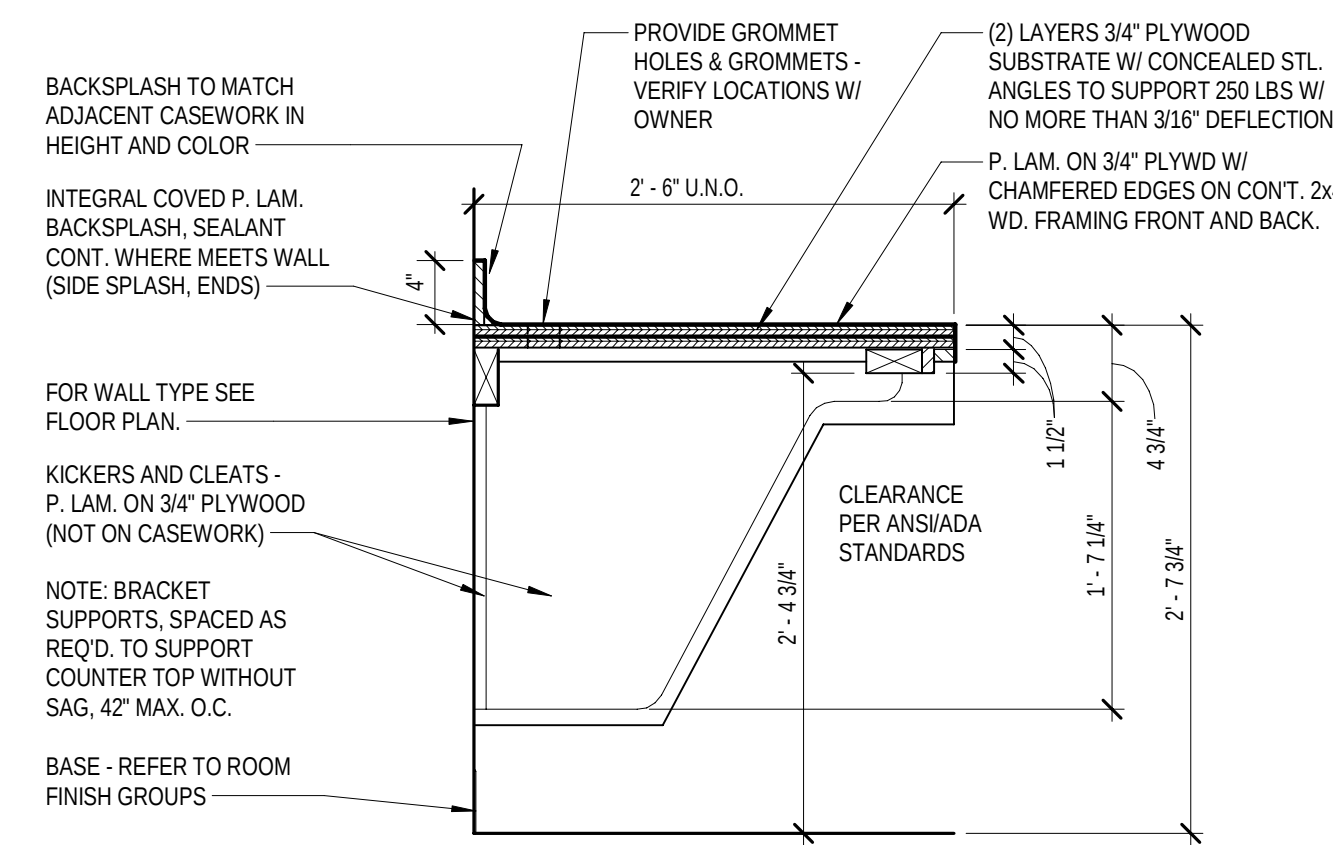


5 COUNTERTOP DETAIL
1" = 1'-0"

JOB NO.	2469
DATE	12/15/2025
DRAWN	CAH
CHECKED	RJV, ASC

COPYRIGHT © 2025
SHERMAN CARTER BARNHART
ARCHITECTS, PLLC


REVISIONS		
No.	Description	Date

SHEET

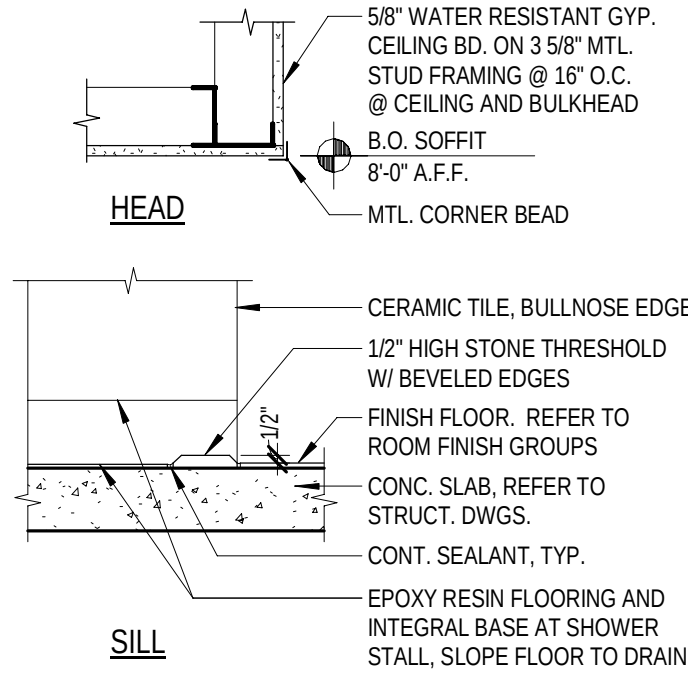


6
1" = 1'-0"

SHOWER SOFFIT DETAIL

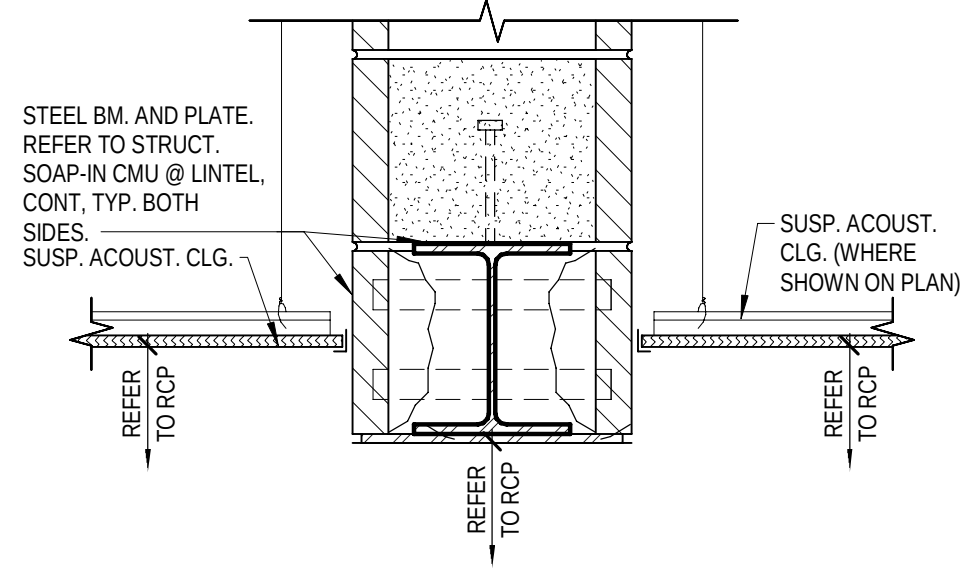


1
1 1/2" = 1'-0"

CEILING DETAIL

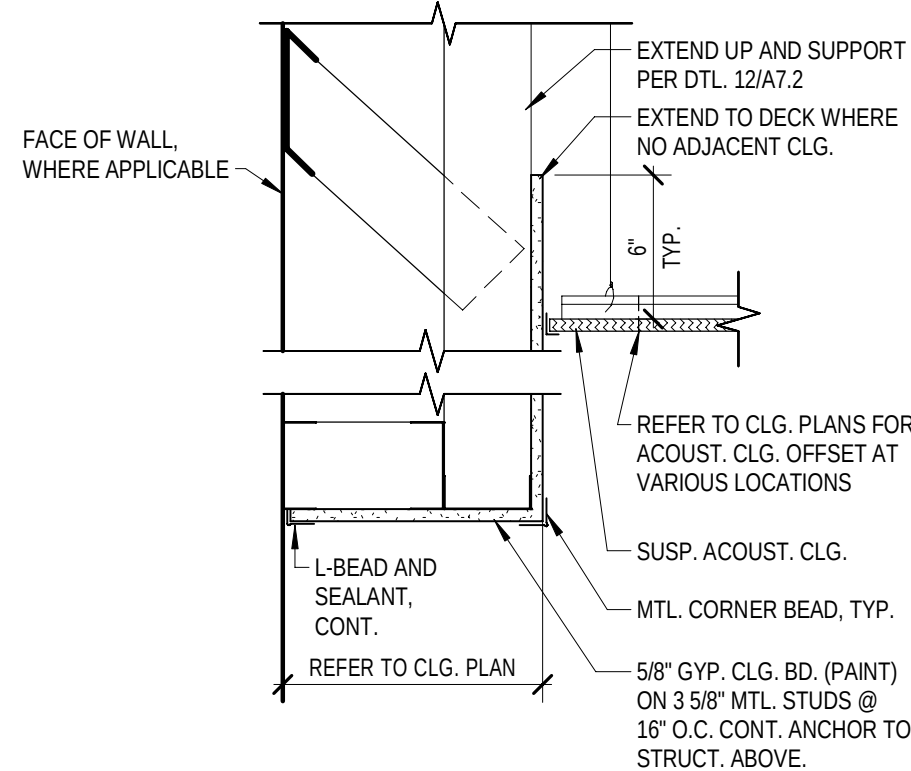



2
1 1/2" = 1'-0"

TYP. SOFFIT DETAIL

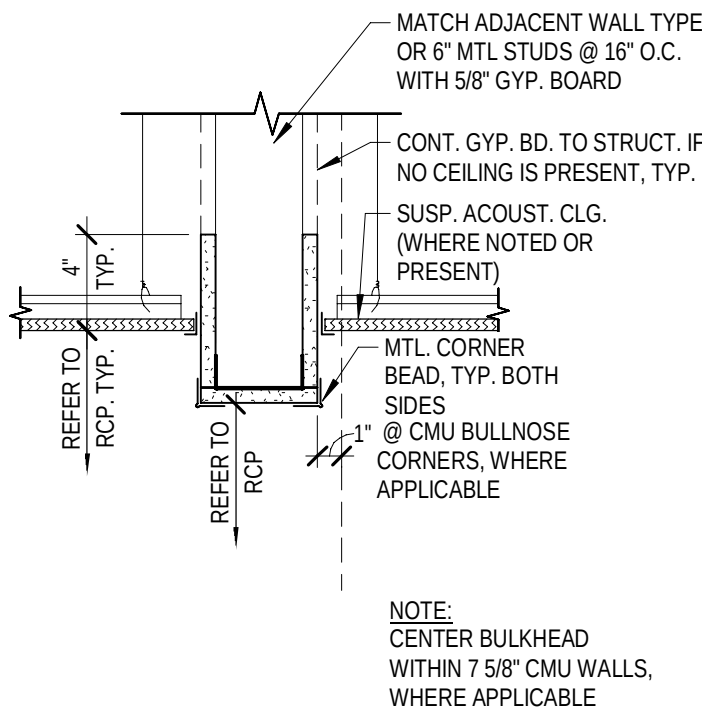


3
1 1/2" = 1'-0"

TYP. BULKHEAD DETAIL

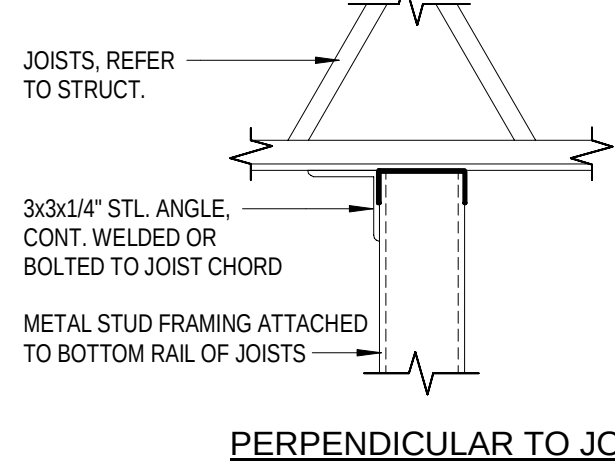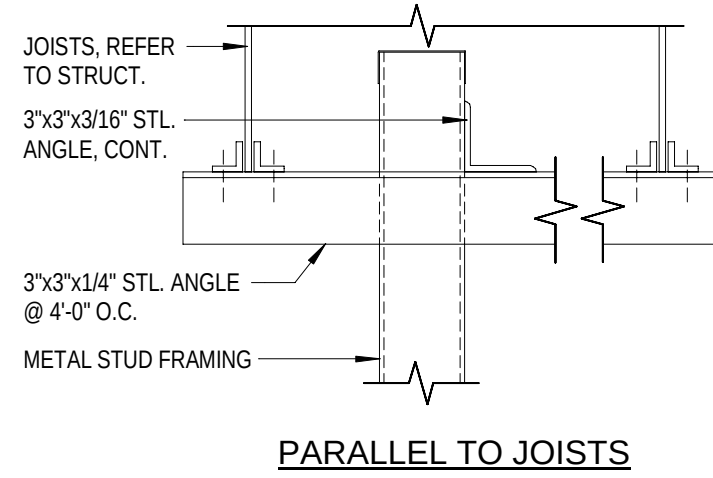

4
1 1/2" = 1'-0"

TYP. SOFFIT SUPPORT

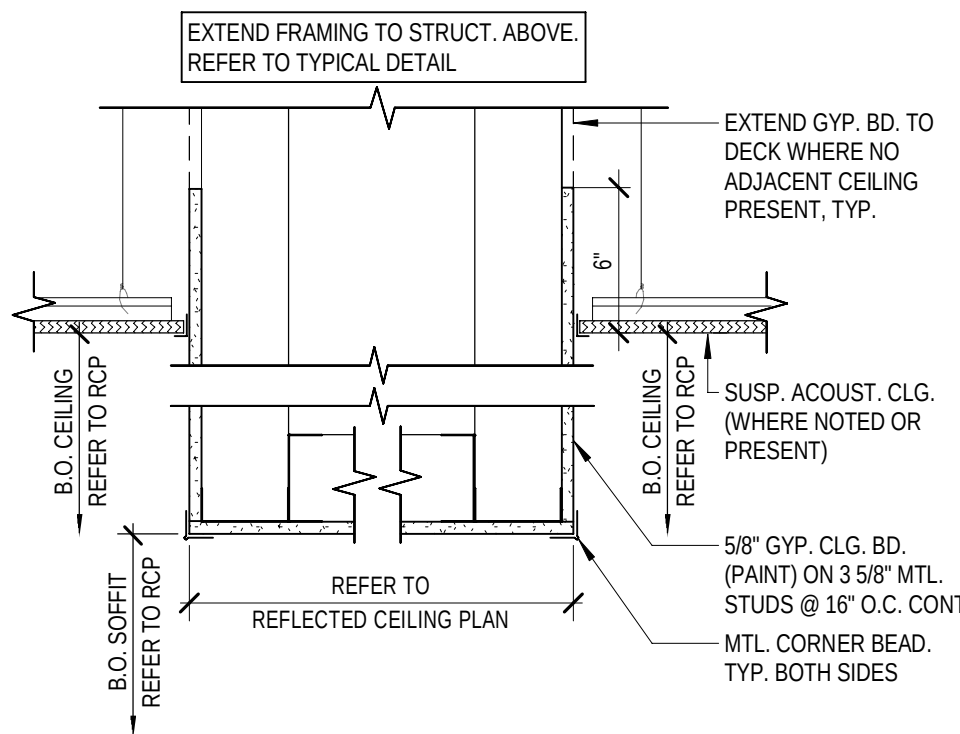

5
1 1/2" = 1'-0"

TYP. SOFFIT DETAIL

JOB NO.	2459	
DATE	12/15/2025	
DRAWN	CAH	
CHECKED	RJV, ASC	
COPYRIGHT © 2025 SHERMAN CARTER BARNHART ARCHITECTS, PLLC		
REVISIONS 		
No.	Description	Date

GENERAL NOTES:

1. REFER TO ROOM FINISH GROUPS AND FLOOR PLANS FOR FINISHES. IT IS THE CONTRACTOR'S RESPONSIBILITY TO MAKE SURE THE PROPER THRESHOLD IS USED.
2. PROVIDE RESILIENT TRANSITION STRIPS OR REDUCERS BETWEEN ALL DIFFERING FLOOR FINISH MATERIALS IE CARPET TO TILE.
3. PROVIDE STRP OR REDUCER PROFILE AS RECOMMENDED BY MANUFACTURER FOR APPLICATION.
4. ALL INTERIOR SECTIONS OF DIFFERENT FLOOR FINISHES MUST OCCUR UNDER DOOR.

Diagram 1: THINSET TILE V.C.T., CARPET, OR CONC. STONE TRANSITION STRIP. Shows a cross-section of a door threshold with a thinset tile, V.C.T., carpet, or concrete stone transition strip.

Diagram 2: SAME. Shows a cross-section of a door threshold with a thinset tile, V.C.T., carpet, or concrete stone transition strip.


Diagram 3: HARDENER ON CONCRETE V.C.T. RESILIENT REDUCER STRIP. Shows a cross-section of a door threshold with a hardener on concrete V.C.T. and a resilient reducer strip.

Diagram 4: CARPET VINYL EDGE TRIM V.C.T. PROVIDE RESIL. ACCENT STRIP IN ALL LOCATIONS WHERE DOOR IS ON CARPET SIDE OF FRAME. Shows a cross-section of a door threshold with a carpet vinyl edge trim, V.C.T., and a resilient accent strip.


Diagram 5: SCHEDULED DOOR SEALANT METAL THRESHOLD INSTALL IN CONTINUOUS BED OF SEALANT. TYPICAL EXTERIOR DOOR. 1/2" MAX. 1/2" MAX. HT. Shows a cross-section of a typical exterior door with a scheduled door sealant and a metal threshold installed in a continuous bed of sealant. The height of the threshold is 1/2" max. and the height of the door is 1/2" max. HT.

DOOR AND FRAME SCHEDULE REMARKS

1. GALVANIZED DOOR.
2. INSULATED DOOR.
3. MAGNETIC HOLD OPEN TIED TO FIRE ALARM SYSTEM.
4. PAND DEVICE.
5. CARD READER. REFER TO DOOR HARDWARE SPECS AND ELEC. DWGS.
6. MANUAL HOLD OPEN DEVICE.
7. PAND LOOKS TIED TO REMOTE SWITCHES. REFER TO DOOR HARDWARE SPECS AND ELEC. DWGS.
8. AUTOMATIC DOOR OPERATOR W/ ADA PUSH PAD.
9. WIRE TO CONSOLE UNIT. REFER TO DOOR HARDWARE SPECS AND ELEC. DWGS.
10. PROVIDE DOOR POSITION SWITCH.
11. ASTRIGAL.
12. REMOVABLE MULLION.
13. EXISTING FRAME WITH NEW DOOR AND HARDWARE.
14. EXISTING DOOR AND FRAME. PAINT.
15. PROVIDE SOUND SEALS.

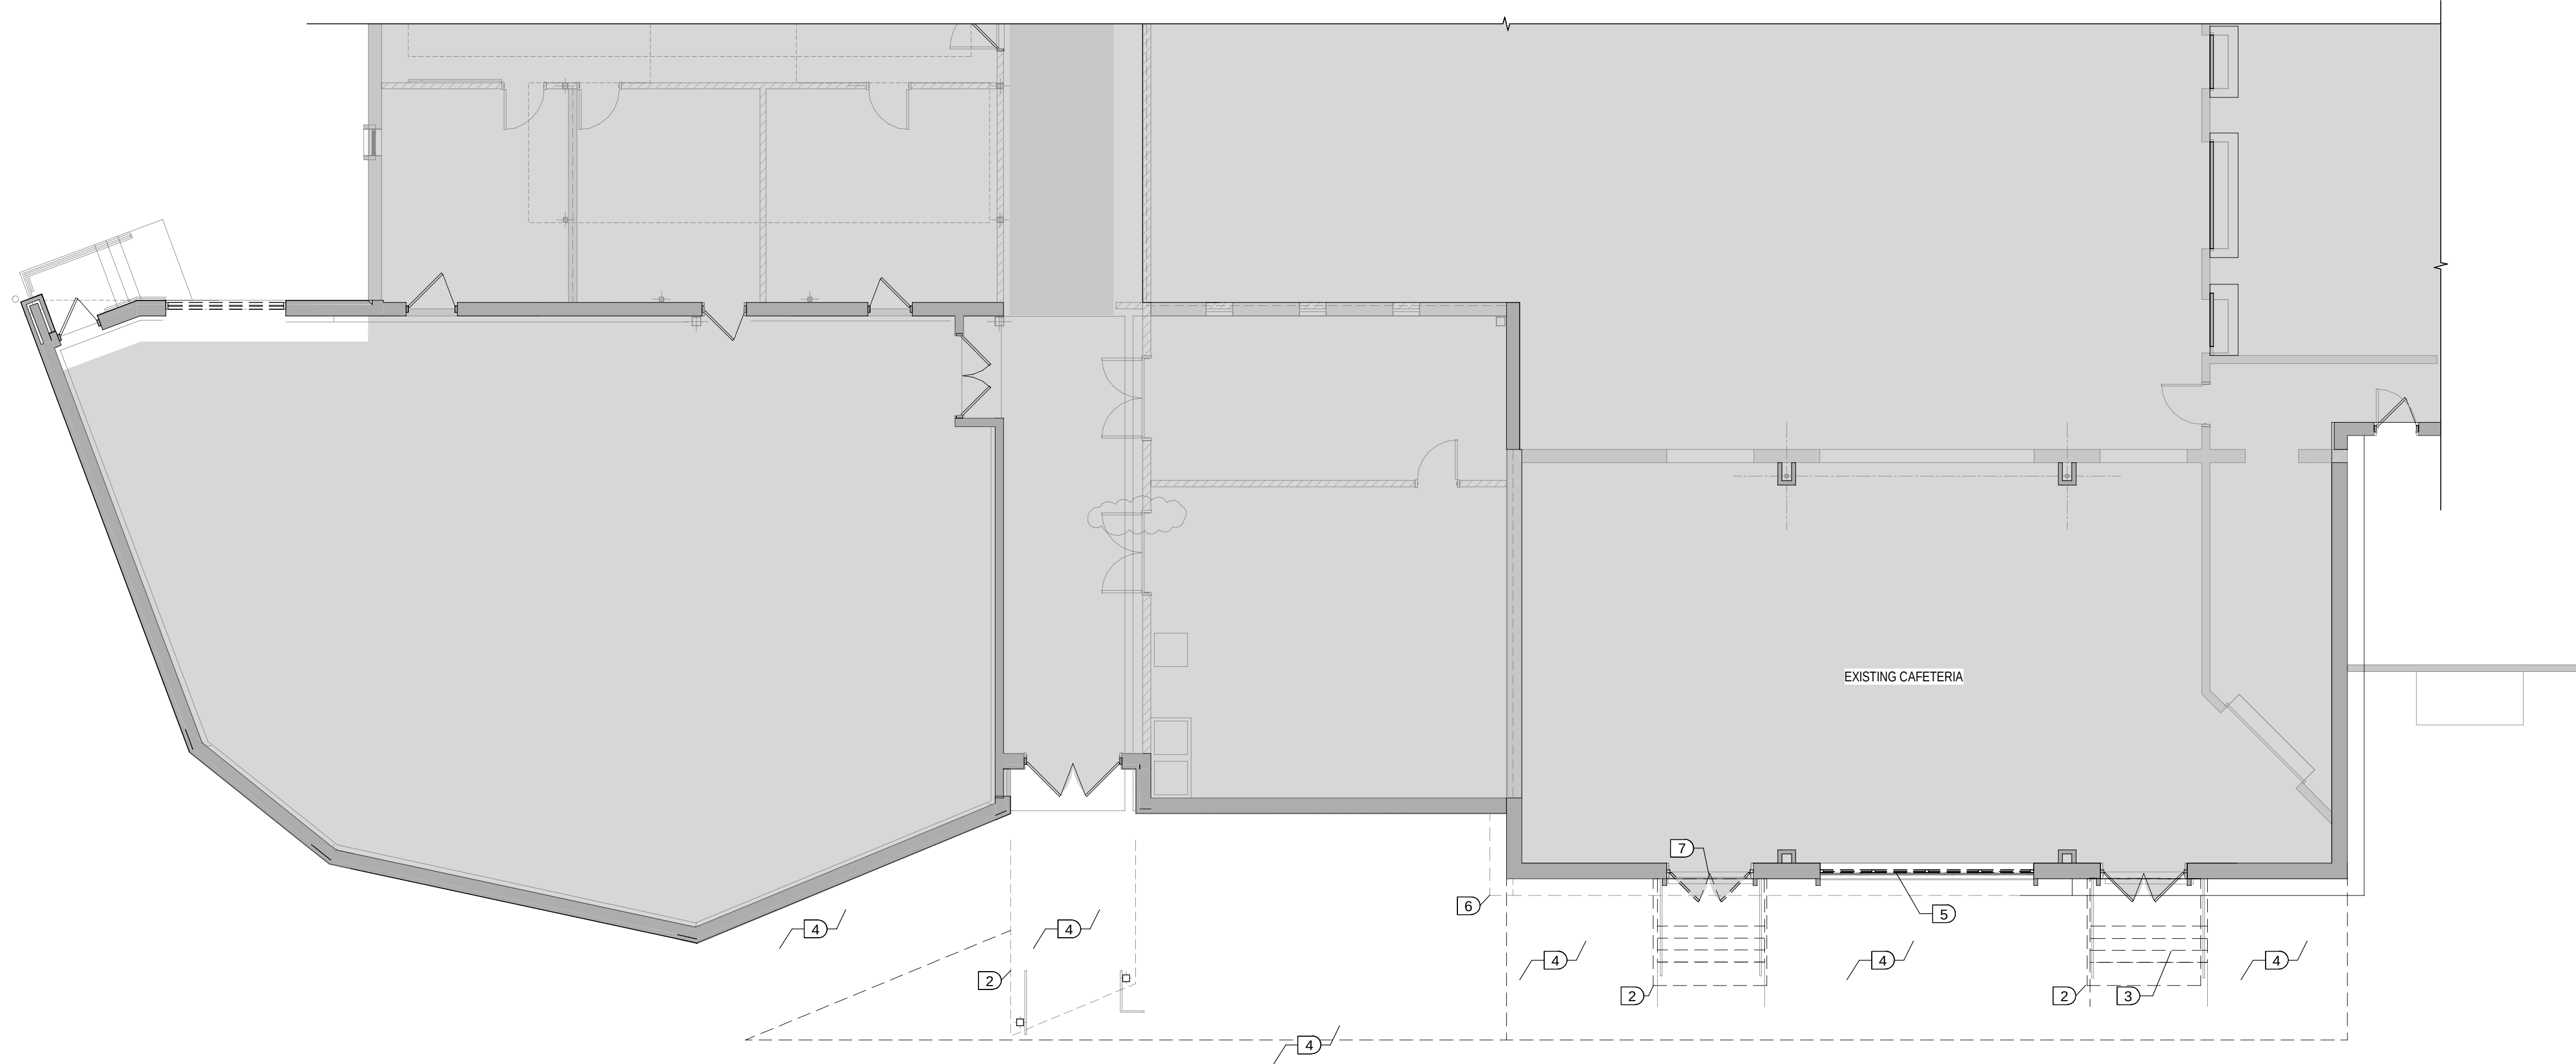

1 100 - FIRST FLOOR DEMOLITION PLAN
1/8" = 1'-0"

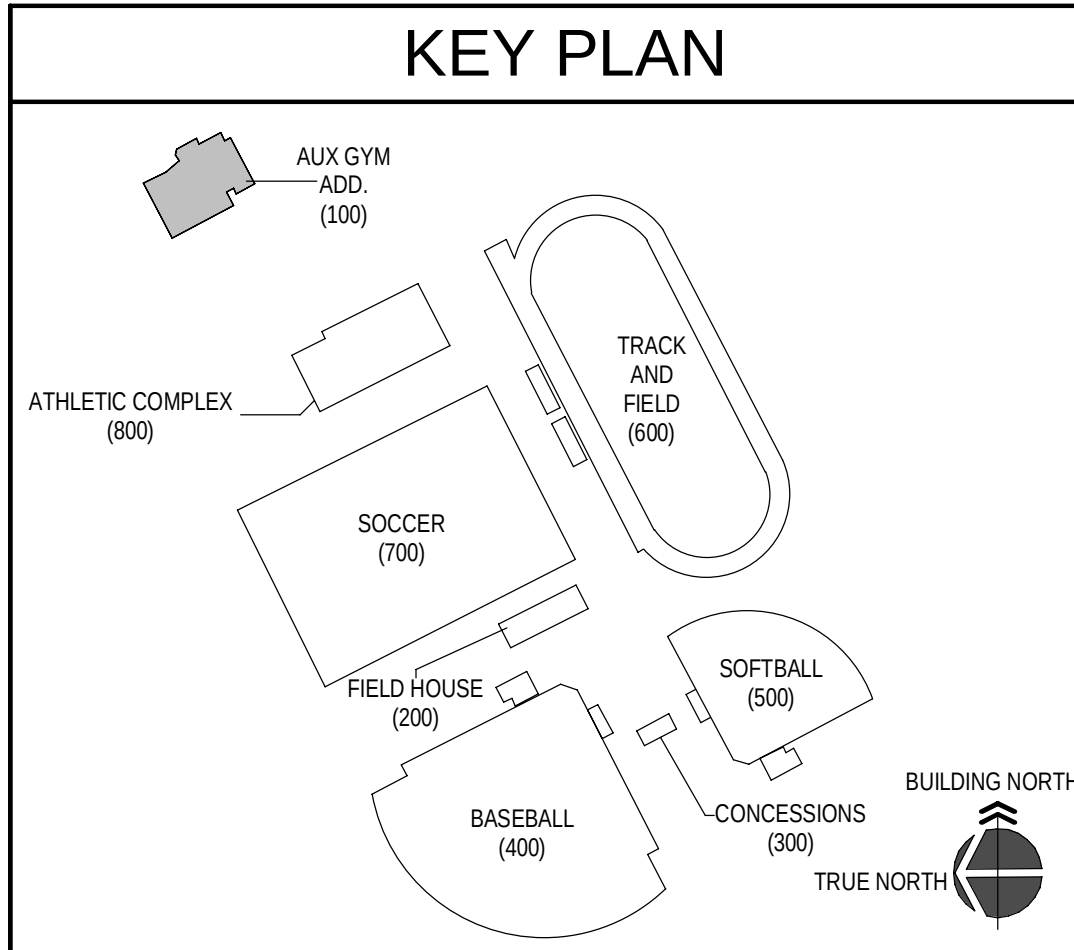

D	DEMOLITION KEY NOTES
	1. DEMOLISH EXISTING HANDRAILS IN THEIR ENTIRETY. 2. DEMOLISH EXISTING CANOPY STRUCTURE AND ALL COMPONENTS TO FACILITATE NEW WORK IN THIS AREA. 3. REMOVE EXISTING CORNICE STOOP & STEPS, REFER TO SITE DEMOLITION DWGS FOR ADDITIONAL INFO. 4. REMOVE EXISTING CONCRETE SIDEWALK, REFER TO SITE DEMOLITION DWGS. 5. REMOVE EXISTING ALUMINUM STOREFRONT WINDOW SYSTEM. 6. REMOVE A PORTION OF EXISTING EIFS SOFFIT @ EXTERIOR OF EXISTING CAFETERIA. 7. REMOVE EXISTING ALUMINUM STOREFRONT DOOR SYSTEM.
	GENERAL DEMOLITION NOTES
	A. ALL EXISTING SUSPENDED CEILINGS TO BE REMOVED, COORDINATE WITH PHASING PLANS AND MEP WORK. B. DEMOLITION REFERENCE NOTES FOR THIS PROJECT ARE INTENDED TO GENERALLY IDENTIFY THE SELECTIVE REMOVAL OF EXISTING ITEMS AT LOCATIONS WHERE REQUIRED BUT, SHALL IN NO WAY RELIEVE THE CONTRACTOR OF THE FULL RESPONSIBILITY FOR EXAMINING AND VERIFYING THE FULL EXTENT OF EXISTING CONDITIONS PRIOR TO BIDDING THE PROJECT. C. THE INTENT OF THE DEMOLITION NOTES IS TO PROVIDE A GENERAL OUTLINE FOR THE CONTRACTOR OF ITEMS TO BE REMOVED AND/OR TURNED OVER TO THE OWNER AND TO ALLOW FOR THE NEW CONSTRUCTION AS OUTLINED ELSEWHERE IN THE CONTRACT DOCUMENTS. THE CONTRACTOR SHALL BE RESPONSIBLE FOR ALL DEMOLITION AND REMOVAL OF ITEMS TO ALLOW FOR NEW CONSTRUCTION SHOWN OR NOT SHOWN ON DEMOLITION PLANS AS MAY BE REQUIRED. D. CAVITY WALLS AND SPACES BEHIND EXTERIOR FINISHES OR PARTIALLY REMOVED WALLS/ROOFS, ETC. SHALL BE PROTECTED FROM EXPOSURE TO WEATHER BY THE CONTRACTOR. WALLS/ROOFS, ETC. SHALL BE PROTECTED. THE CONTRACTOR SHALL BE RESPONSIBLE FOR ANY DAMAGED WALLS, ROOFS, EQUIPMENT, ETC. CAUSED BY THIS DEMOLITION OR WEATHER EXPOSURE OF ITEMS THAT ARE TO REMAIN. E. INFORMATION AND DRAWINGS INCLUDED IN THESE CONTRACT DOCUMENTS PERTAINING TO THIS RENOVATION PROJECT HAVE BEEN OBTAINED FROM ORIGINAL DRAWINGS PROVIDED BY MEADE COUNTY BOARD OF EDUCATION AND FIELD OBSERVATIONS. THIS INFORMATION IS INCLUDED HEREIN WITH THE INTENT TO PROVIDE THE CONTRACTOR WITH A BASIC UNDERSTANDING OF EXISTING CONDITIONS. ACTUAL CONDITIONS AND DIMENSIONS MAY VARY FROM THOSE INDICATED ON DRAWINGS. F. REFER TO STRUCTURAL DRAWINGS FOR SPECIFIC REQUIREMENTS AT EXISTING CONDITIONS REQUIRING PARTIAL OR COMPLETE REMOVAL AND/OR MODIFICATION TO COMPONENTS OR ASSEMBLIES PERTAINING TO EXISTING BUILDING STRUCTURE. G. REFER TO MECHANICAL AND/OR ELECTRICAL DRAWINGS AND SPECIFICATIONS FOR SPECIFIC REQUIREMENTS PERTAINING TO THE REMOVAL, RELOCATION AND/OR MODIFICATION OF ITEMS RELATED TO EXISTING MECHANICAL AND ELECTRICAL SYSTEMS. H. SHOULD THE CONTRACTOR ENCOUNTER ANY MATERIALS DURING SELECTIVE DEMOLITION AND NEW WORK WHICH ARE SUSPECTED BY THE CONTRACTOR TO BE OF AN UNKNOWN OR QUESTIONABLE COMPOSITION WITH RESPECT TO CONTAINING CONTAMINANTS WHICH MAY BE HAZARDOUS TO HUMAN HEALTH, THE CONTRACTOR SHALL IMMEDIATELY NOTIFY THE OWNER OF SUCH FINDINGS. I. WHERE AN EXISTING WALL IS REMOVED AND NO NEW WALL IS SHOWN TO BE INSTALLED, REMOVE EXISTING WALL TO 8 INCHES BELOW ADJACENT FLOOR SLAB. PATCH AND REPAIR SLAB AS REQUIRED FOR INSTALLATION OF NEW FLOOR FINISH. REFER TO NEW WORK PLANS. J. ALL AREAS LEFT EXPOSED AS A RESULT OF DEMOLITION AND/OR EQUIPMENT REMOVAL SHALL BE PATCHED AND REPAIRED TO RESULT IN A FLUSH SMOOTH SURFACE PREPARED TO RECEIVE NEW FINISHES AS SCHEDULED. ANY AREAS OF OPENINGS IN MASONRY WALLS LARGER THAN 2' EXPOSED TO VIEW SHALL BE PATCHED WITH SCAPOED IN CMU UNITS TOOTHED-IN INTO EXISTING MASONRY. K. CONTRACTOR SHALL BE RESPONSIBLE FOR ALL PATCHING AND REPAIRING DUE TO DEMOLITION AND/OR REMOVAL OF EQUIPMENT TO CREATE A FLUSH, SMOOTH SURFACE PROPERLY PREPARED TO RECEIVE NEW FINISHES AS SCHEDULED. CONTRACTOR SHALL SOAP IN NEW CMU TO MATCH EXISTING ADJACENT AREAS. L. REFER TO MECH/ELEC DRAWINGS FOR SPECIFIC NOTES REGARDING REMOVAL OF EXISTING MECH/ELEC ITEMS NOT SHOWN ON THIS SHEET. M. REFER TO STRUCTURAL DRAWINGS FOR NEW WORK (I.E. NEW FOOTING, ETC.) WHICH MAY REQUIRE DEMOLITION WORK IN ADDITION TO ITEMS NOTED ON THE ARCHITECTURAL DRAWINGS ALL SUCH WORK SHALL BE PERFORMED BY THE CONTRACTOR. N. REFER TO CIVIL/SITE DRAWINGS FOR ADDITIONAL DEMOLITION OF SITE/CIVIL ITEMS NOT SHOWN.
	HAZARDOUS MATERIAL NOTES
	DUE TO THE AGE OF THE EXISTING BUILDING, IT IS POSSIBLE HAZARDOUS MATERIALS MAY EXIST, INCLUDING, BUT NOT LIMITED TO ASBESTOS PRODUCTS, POLYCHLORINATED BIPHENYL (PCB) AND OTHER TOXIC SUBSTANCES. IF ANY WORK PERSON ENCOUNTERS ANY MATERIAL WHICH THEY SUSPECT MIGHT BE HAZARDOUS OR TOXIC, THEY SHALL IMMEDIATELY ADVISE THE OWNER. THE CONTRACTOR SHALL TAKE IMMEDIATE AND APPROPRIATE ACTION TO PROTECT THE BUILDING USERS AND WORKERS IN ACCORDANCE WITH FEDERAL, STATE AND LOCAL LAWS, CODES AND REGULATIONS. THE ARCHITECT AND ARCHITECTS CONSULTANTS SHALL HAVE NO RESPONSIBILITY FOR THE DISCOVERY, PRESENCE, HANDLING, REMOVAL OR DISPOSAL OF OR EXPOSURE OF PERSONS TO HAZARDOUS MATERIALS IN ANY FORM AT THE PROJECT SITE, INCLUDING BUT NOT LIMITED TO ASBESTOS, ASBESTOS PRODUCTS, POLYCHLORINATED BIPHENYL (PCB) OR OTHER TOXIC SUBSTANCES. 1. THE CONTRACTOR IS HEREBY ADVISED THAT SHERMAN-CARTER-BARNHART, PLLC IS NOT A DESIGN PROFESSIONAL IN THE DETERMINATION OF THE PRESENCE OF HAZARDOUS MATERIALS, NOR IS SHERMAN-CARTER-BARNHART, PLLC A DESIGN PROFESSIONAL INVOLVED IN MAKING RECOMMENDATIONS REGARDING THE TESTING, REMOVAL, ENCAPSULATION OR OTHER CORRECTIVE MEASURES PERTAINING TO HAZARDOUS MATERIALS. 2. IF THE WORK WHICH IS TO BE PERFORMED UNDER THE CONTRACT INTERFACES IN ANY WAY WITH THE EXISTING COMPONENTS WHICH CONTAIN HAZARDOUS MATERIALS, IT IS THE CONTRACTOR'S RESPONSIBILITY TO CONTACT THE OWNER'S ENVIRONMENTAL CONSULTANT REGARDING THE PROPER MEANS AND METHODS TO BE UTILIZED WITH HAZARDOUS MATERIALS. 3. BY EXECUTION OF THE CONTRACT FOR CONSTRUCTION, THE CONTRACTOR HEREBY AGREES TO BRING NO CLAIM FOR NEGLIGENCE, BREACH OF CONTRACT, INDEMNITY OR OTHERWISE AGAINST THE ARCHITECT, HIS PRINCIPALS, EMPLOYEES, AGENTS OR CONSULTANTS IF SUCH A CLAIM IN ANY WAY WOULD INVOLVE THE INVESTIGATION OF OR REMEDIAL WORK RELATED TO HAZARDOUS MATERIALS IN THE PROJECT. 4. BY EXECUTION OF THE CONTRACT FOR CONSTRUCTION, THE CONTRACTOR FURTHER AGREES TO DEFEND, INDEMNIFY AND HOLD THE ARCHITECT, HIS PRINCIPALS, EMPLOYEES, AGENTS AND CONSULTANTS HARMLESS FROM ANY SUCH ASBESTOS OR OTHER HAZARDOUS MATERIALS RELATED CLAIMS THAT MAY BE BROUGHT BY THE CONTRACTOR'S SUBCONTRACTORS, SUPPLIERS OR OTHER THIRD PARTIES WHO MAY BE ACTING UNDER THE DIRECTION OF THE CONTRACTOR PURSUANT TO THIS PROJECT.
	DEMOLITION SYMBOL LEGEND
	X DEMOLITION KEY NOTE EXISTING WALL / CONSTRUCTION TO REMAIN EXISTING CONSTRUCTION TO BE REMOVED - FULL HEIGHT U.N.O. SEE SELECTIVE DEMOLITION NOTES & EXISTING DOOR / DOOR & FRAME TO REMAIN & EXISTING DOOR / DOOR & FRAME TO BE REMOVED, U.N.O. LIMITED TO NO ARCHITECTURAL WORK. EXISTING FINISHES TO REMAIN U.N.O. REFER TO MEP FOR MEP WORK THAT MAY BE REQUIRED.

JOB NO.	2469
DATE	12/15/2025
DRAWN	CAH, JCG
CHECKED	RJV, ASC

COPYRIGHT © 2025
SHERMAN CARTER BARNHART
ARCHITECTS, PLLC

REVISIONS		
No.	Description	Date

FLOOR PLAN KEYNOTES

1. OWNER PROVIDED FURNITURE OR EQUIPMENT (N.I.C.)
2. LINE OF SOFFIT / BULKHEAD ABOVE, REFER TO REFLECTED CEILING PLAN.
3. PRE-MFR. PREF-IN SUSPENDED ALUMINUM CANOPY. REFER TO DETAIL 11J4.2.
4. EXTERIOR CONCRETE WALK, REFER TO SITE DRAWINGS.
5. HIGH / LOW ADA COMPLIANT WATER COOLER UNIT, REFER TO MECH. / ELEC. DRAWINGS.
6. MOP SINK. REFER TO PLUMBING DRAWINGS.
7. KNOX-BOX RECESSED IN BRICK, REFER TO DOOR HARDWARE SPECIFICATIONS.
8. FLOOR TRANSITION, REFER TO SHEET A8.1 FOR DETAILS.
9. SHIP'S LADDER, REFER TO DETAIL 11J4.3.
10. DIVIDER CURTAIN, MOTORIZED OPERATOR, REFER TO ELEC. DWGS.
11. 7'-0" TALL X 2" THICK WOOD PAD WITH WOOD BACKING. ATTACH TO WALLS / COLUMNS WITH MANUFACTURER'S STANDARD "2" CLIP SYSTEM.
12. ELECTRIC PUSH-BUTTON ADA DOOR OPERATOR, REFER TO ELEC. DWGS.


GENERAL NOTES

1. (OF-CI) OWNER FURNISHED CONTRACTOR INSTALLED.
2. EXISTING TO REMAIN INTERIOR WALLS THAT ARE EXPOSED IN AREAS OF RENOVATION TO BE CLEANED, REPAIRED, PRIMED, AND PAINTED FOR LIKE NEW FINISH.
3. DO NOT SCALE DWGS, WRITTEN DIMENSIONS TAKE PRECEDENCE OVER SCALED DIMENSIONS.
4. INTERIOR MASONRY CONTROL JOINTS TO OCCUR EVERY 20'-0" MAX.
5. NOTE: MARKER BOARD (MB) AND TACK BOARD (TB) INDICATE WIDTH AND ARE TO BE 48" H.

SYMBOL LEGEND


- | | |
|--|---|
| | ROOM FINISH GROUPS (REFER TO KEY PLAN SHEETS) |
| | ROOM NUMBER |
| | DOOR NUMBER (DOOR SCHEDULE SHEET AB.1) |
| | KEY NOTES (SHEETS A1.3 THROUGH A2.8) |
| | WALL TYPE (SCHEDULE SHEET AD.1) |
| | ALUMINUM OR HOLLOW METAL WINDOW OR STOREFRONT TYPE
(REFER TO FLOOR PLANS AND SCHEDULE SHEETS AB.2) |
| | TILET ACCESSORIES (SCHEDULE SHEET AD.7) |
| | ELEVATION KEY NOTE (SCHEDULES A3.1) |
| | ROOF KEY NOTE (SHEET AD.1) |
| | CEILING PLAN KEY NOTE (SHEETS AT.1 THROUGH AT.7) |
| | SIGNAGE KEY NOTE (REFER TO KEY PLAN SHEETS) |
| | WALLS / PARTITION DESIGNATION
FW2 2 HOUR RATED FIRE WALL
FW2 EXISTING 2 HOUR RATED FIRE WALL |
| | MASONRY CONTROL JOINT FULL HEIGHT OF WALL REFER TO FLOOR
PLANS AND EXTERIOR ELEVATION A3.1 FOR LOCATIONS |

KEY PLAN

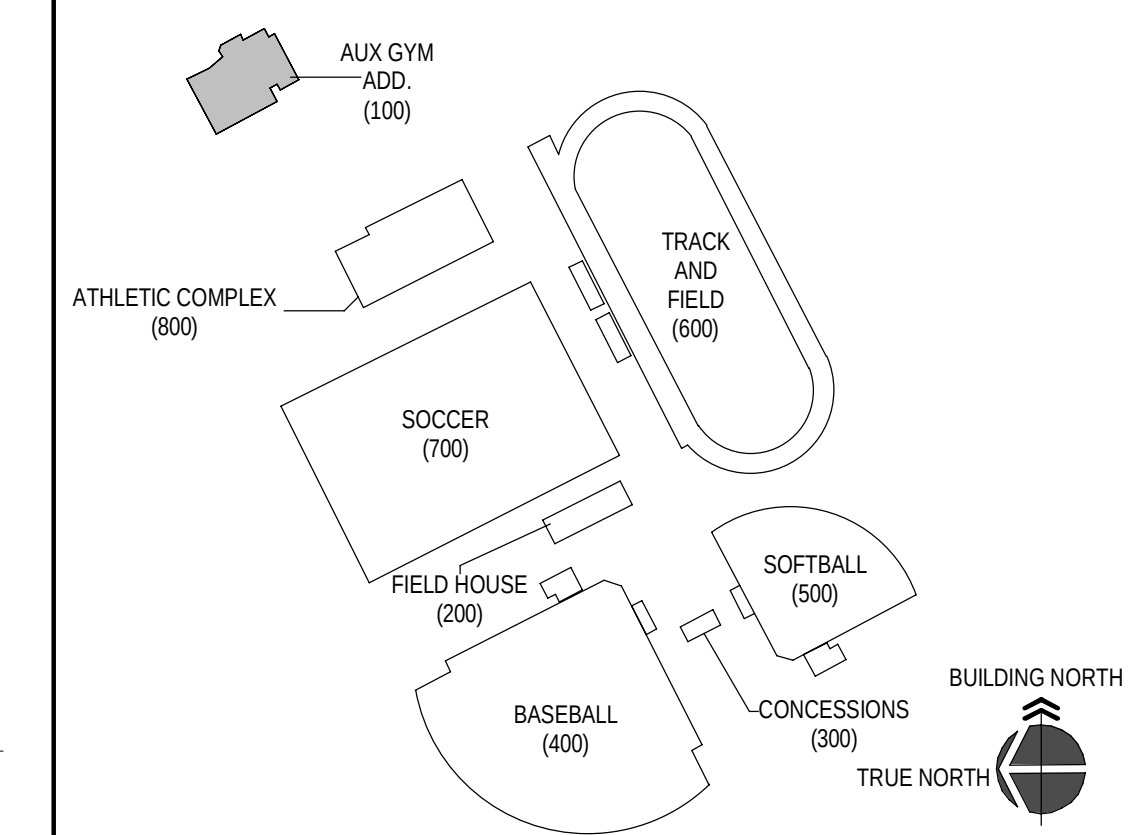

1 100 - FIRST FLOOR NEW WORK PLAN
1/8" = 1'-0"

2 ENLARGED PILASTER DETAIL @ GRID LINES 2 & 7
1" = 1'-0"

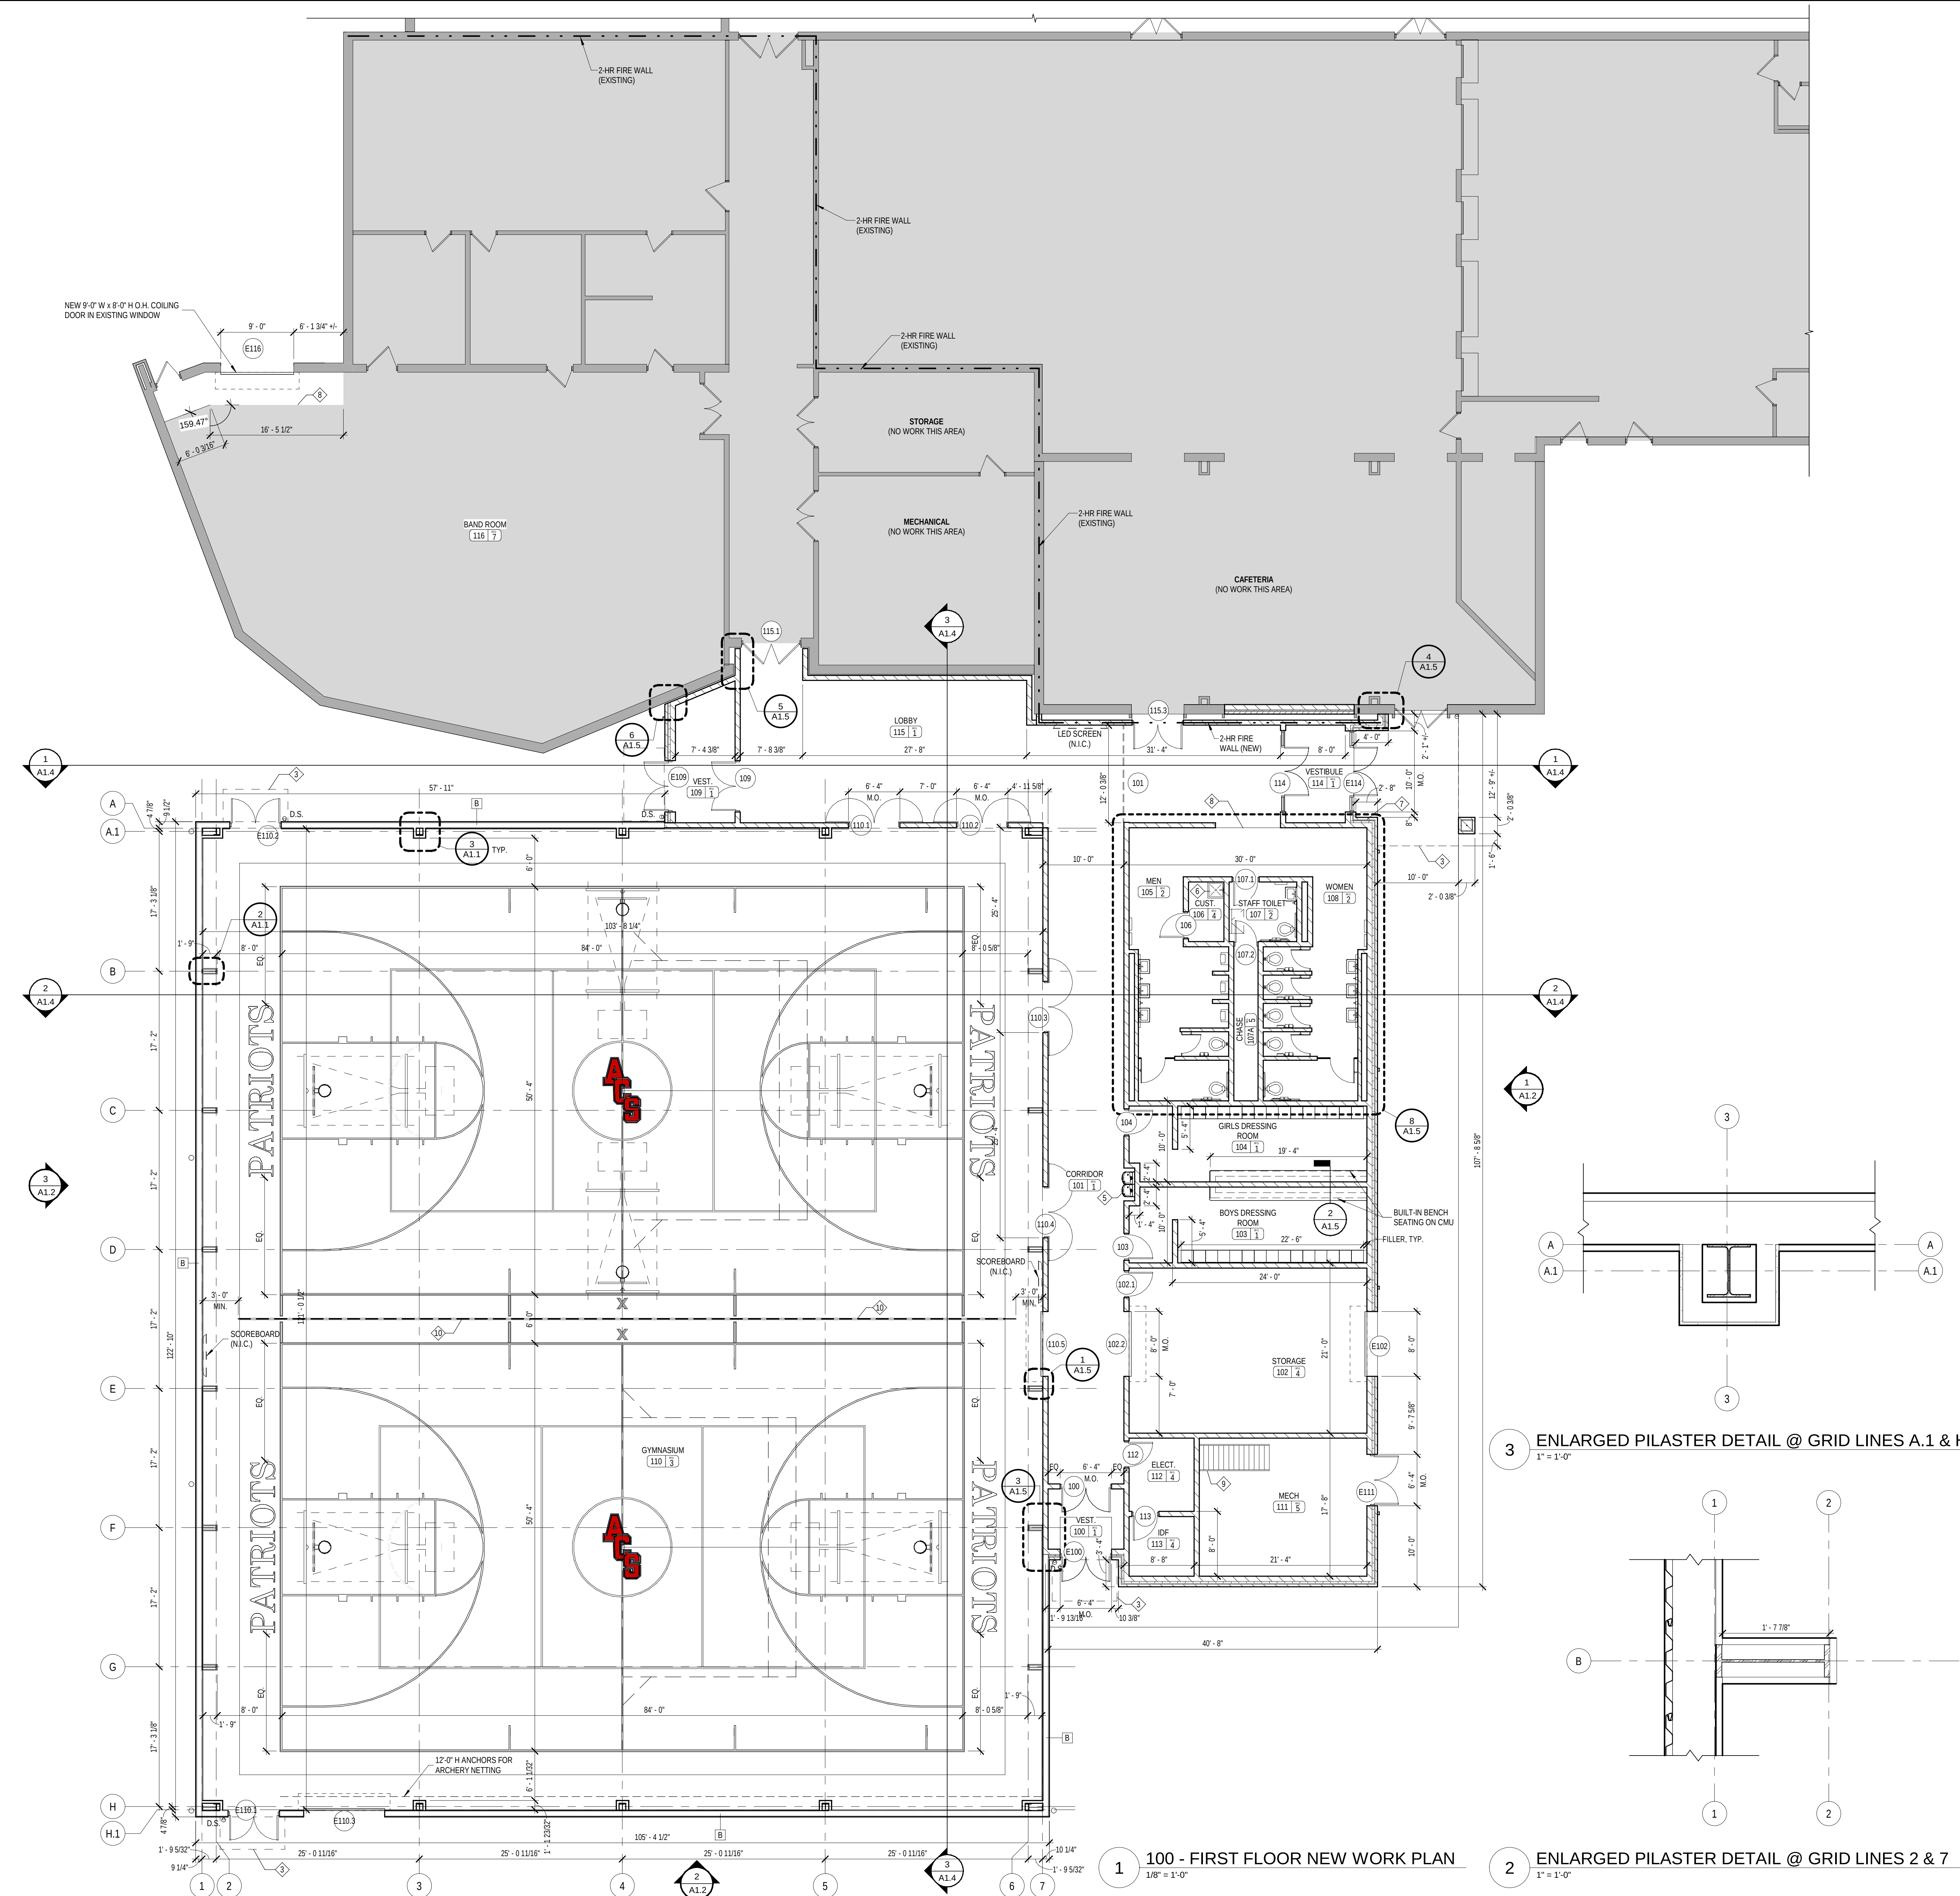

GENERAL ELEVATION NOTES


BUILDING ELEVATIONS SHOWN ON THIS DRAWING ARE INTENDED FOR GENERAL REFERENCE PURPOSES ONLY. REFER TO REFERENCED SECTIONS AND DETAILS FOR MORE FULLY DESCRIBED CONDITIONS AND REQUIREMENTS.

- A. MATERIALS INDICATIONS AND DESCRIPTIONS, VERTICAL AND OTHER DIMENSIONS SHOWN ON ONE BUILDING ELEVATION APPLY TO OTHER BUILDING ELEVATIONS WHERE SHOWN UNLESS NOTED OTHERWISE.
- B. LINES REPRESENTING PAVING AND FINISH GRADES ARE APPROXIMATE AND ARE SHOWN FOR REFERENCE PURPOSES ONLY. REFER TO SITE PLANS FOR SPECIFIC GRADE AND SPOT ELEVATIONS AT EACH RESPECTIVELY.
- C. REFER TO FLOOR PLANS FOR LOCATION AND DOOR SCHEDULE FOR FULL EXTENT AND COMPLETE DESCRIPTION OF DOOR AND FRAME TYPES. PORTIONS OF DOORS, WINDOWS STOREFRONTS, AND CURTAIN WALLS MAY BE CONCEALED BY OTHER BUILDING FEATURES SHOWN.
- D. REFER TO FLOOR PLANS FOR SPECIFIC ALUMINUM WINDOW TYPES AND WINDOW ELEVATIONS.
- E. LOCATIONS OF CONTROL/EXPANSION JOINTS IN MASONRY WALLS ARE SHOWN ON THIS DRAWING. SEE TYPICAL DETAILS ON SHEET A6.2 FOR SPECIFIC REQUIREMENTS AT RESPECTIVE LOCATIONS.
- F. ALL EXPOSED NEW EXTERIOR MASONRY SHALL RECEIVE APPLICATION OF SPECIFIED WATER REPELLENT.
- G. ALL EXPOSED EXTERIOR METAL SUCH AS FLASHINGS, COPINGS, GUTTERS DOWNSPOUTS AND LADDERS SHALL RECEIVE THE SPECIFIED FIELD OR SHOP APPLIED FINISH COATING.


ELEVATION KEY NOTES

NOTE: NOT ALL NOTES APPLY TO THIS SHEET.


- 8" (NOM.) SPLIT-FACE CMU
- 8" (NOM.) GROUND-FACE CMU
- BRICK ACCENT BAND (1 ROW)
- CONTROL JOINT
- GALV. INSULATED H.M. DOOR & FRAME (PRIMED, PAINT BY OTHERS)
- WALL MOUNTED LIGHT, REFER TO ELECTRICAL DRAWINGS
- FINISH GRADE - VARIES, REFER TO SITE DRAWINGS
- PRE-FINISHED S.M. GUTTER
- PRE-FINISHED DOWNSPOUT - TIE INTO BOOT, CONNECT TO BELOW GRADE DRAINAGE SYSTEM, REFER TO SITE DETAILS.
- INSULATED COILING OVERHEAD DOOR WITH PRE-FIN. S.M. COVER, REFER TO SPECIFICATIONS.
- PRE-FINISHED METAL WALL PANEL. REFER TO SPECIFICATIONS.
- SIGNAGE, REFER TO SPECS.
- ALUM. STOREFRONT
- CANOPY SYSTEM - REFER TO DETAIL 15/A1.1
- RECESS BRICK BAND 1/2" (TYP.)
- GUTTER.
- PEMB RAKE TRIM
- PEMB GUTTER
- PEMB DOWNSPOUT
- PEMB RIDGE CAP
- PEMB METAL WALL PANEL
- S.M. COPING
- EXTERIOR GRADE PLYWOOD, PAINTED, REFER TO DETAIL 6/A5.2.

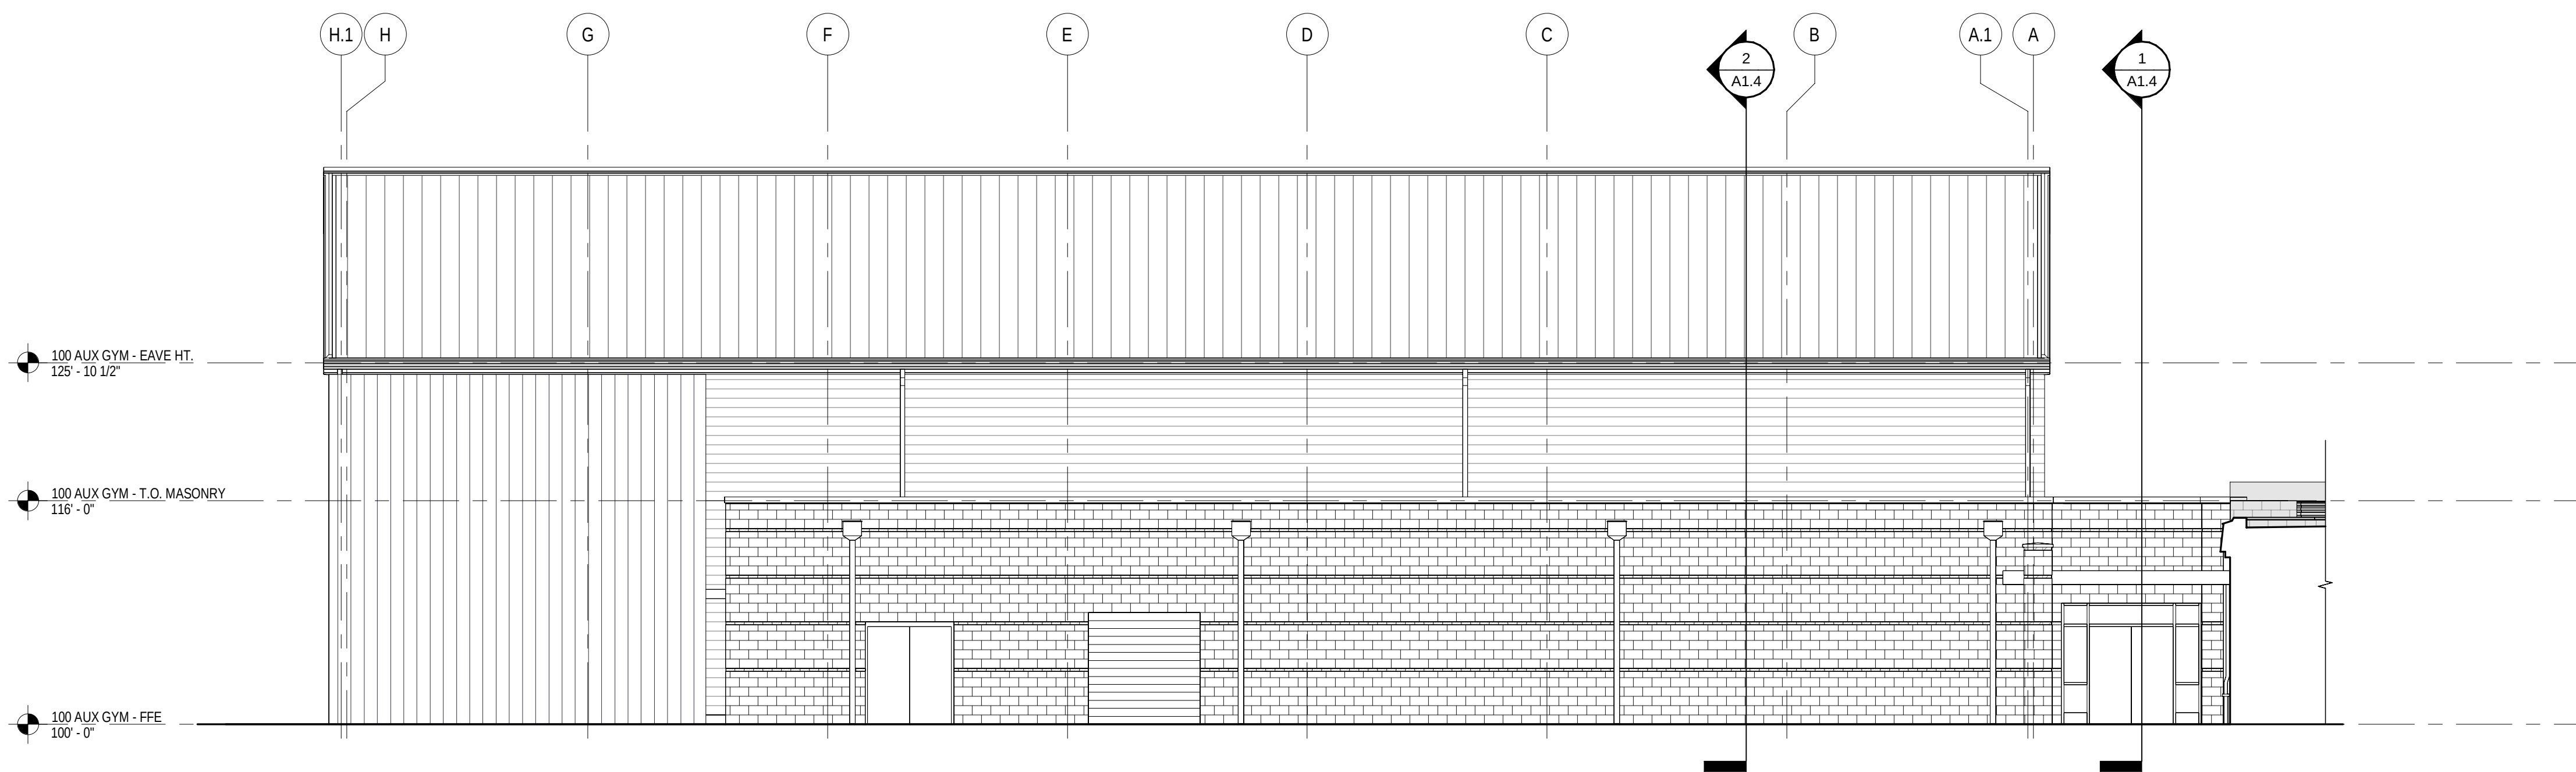

1 100 - BUILDING ELEVATION - EAST
1/8" = 1'-0"

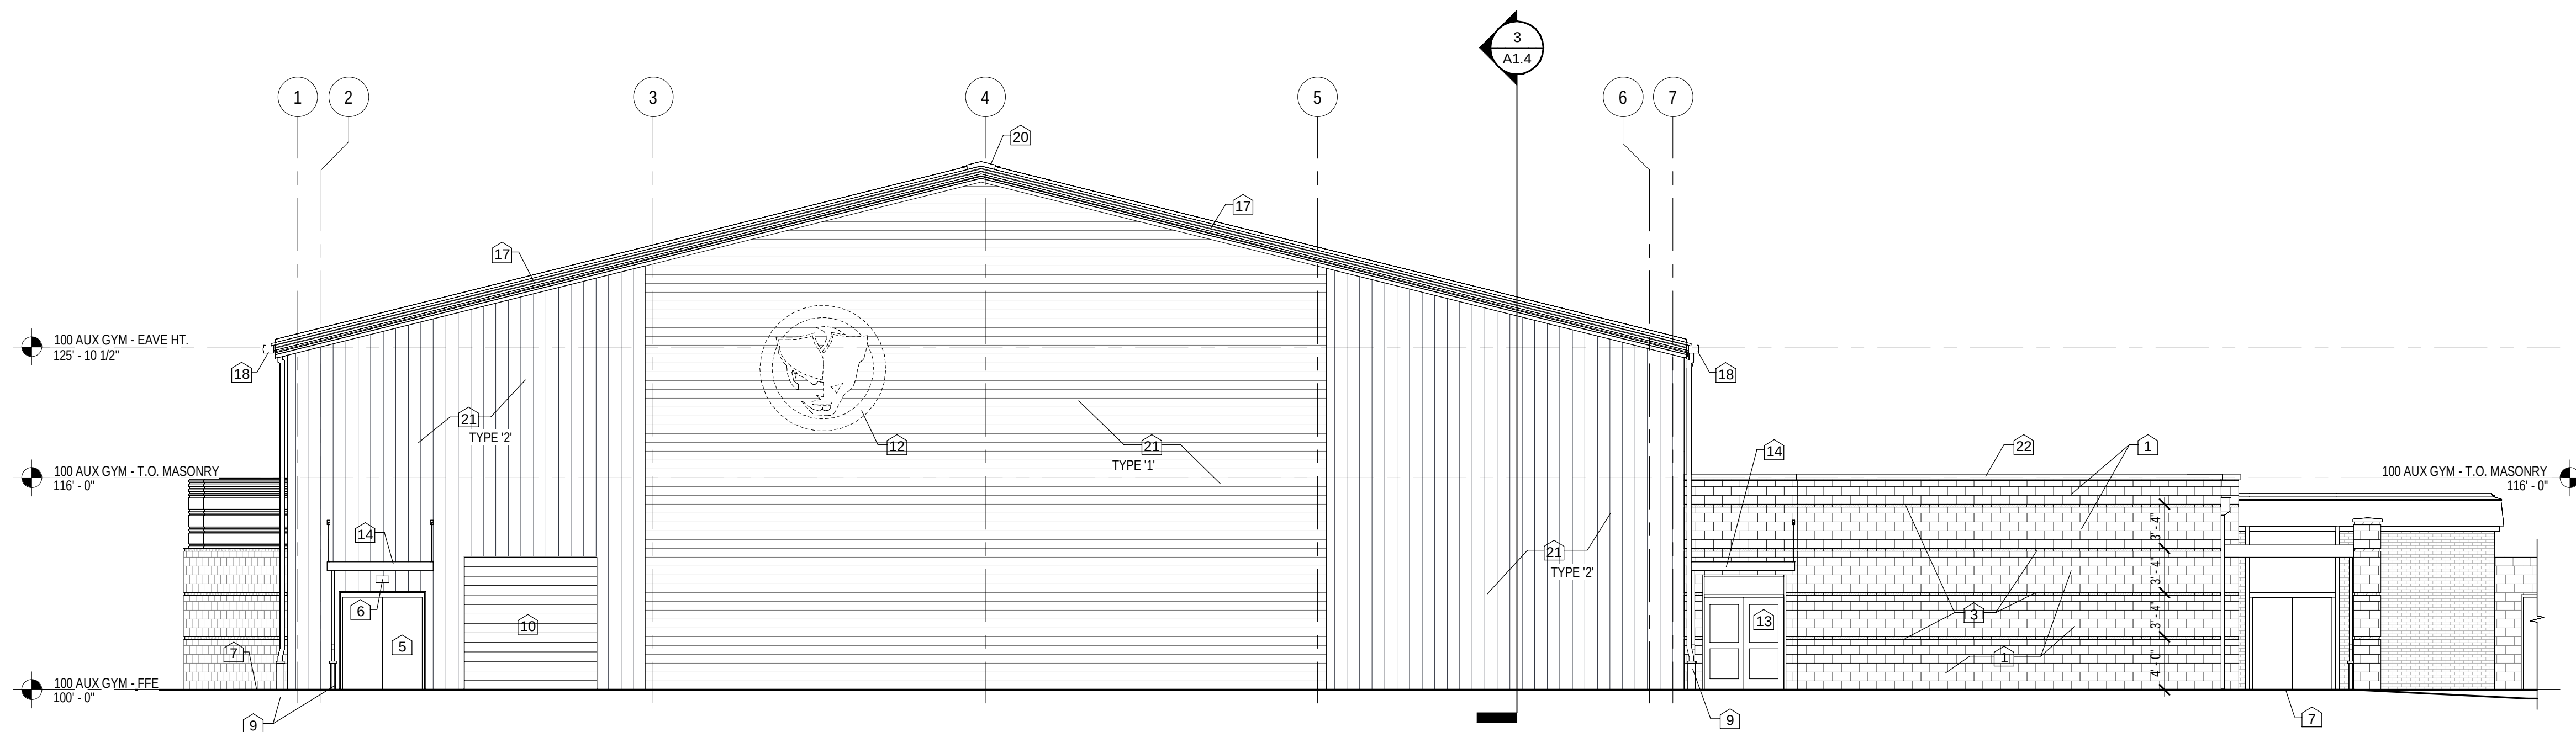


2 100 - BUILDING ELEVATION - SOUTH
1/8" = 1'-0"

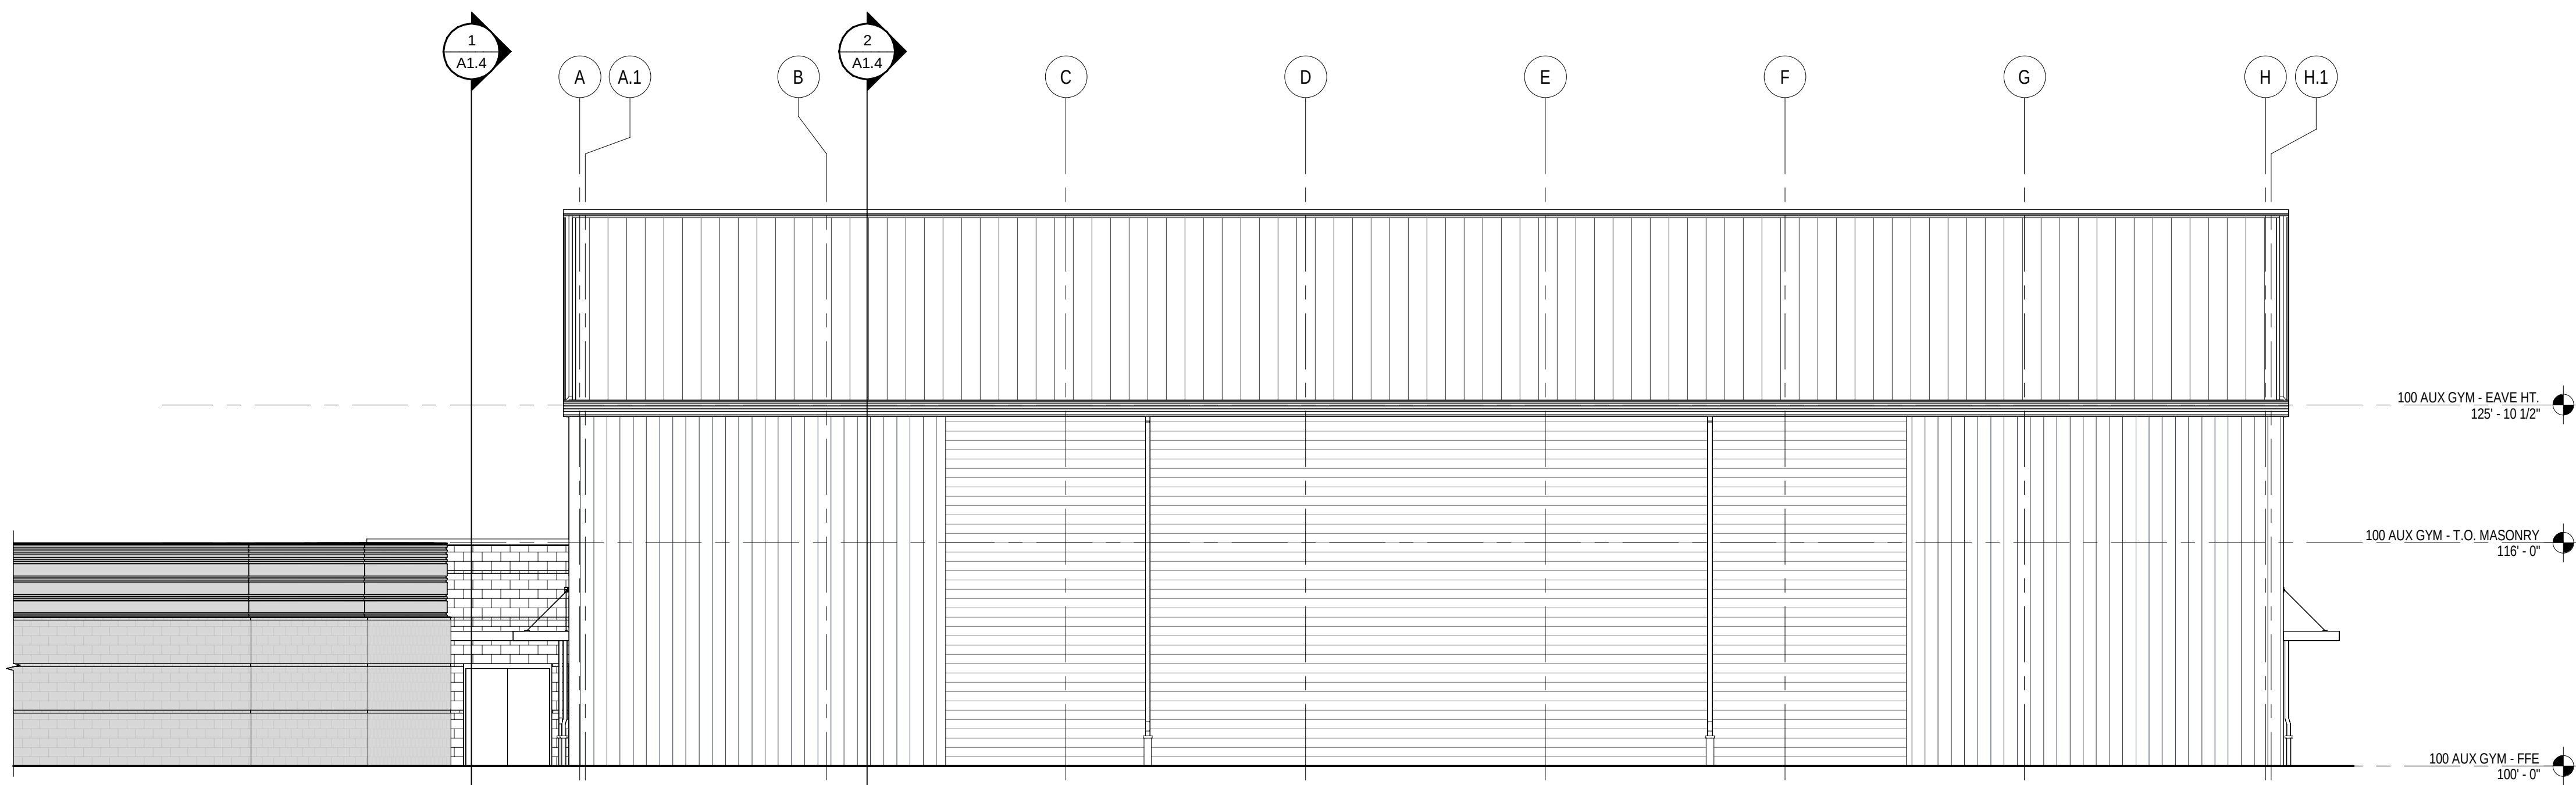



3 100 - BUILDING ELEVATION - WEST
1/8" = 1'-0"


SHEET


A1.3

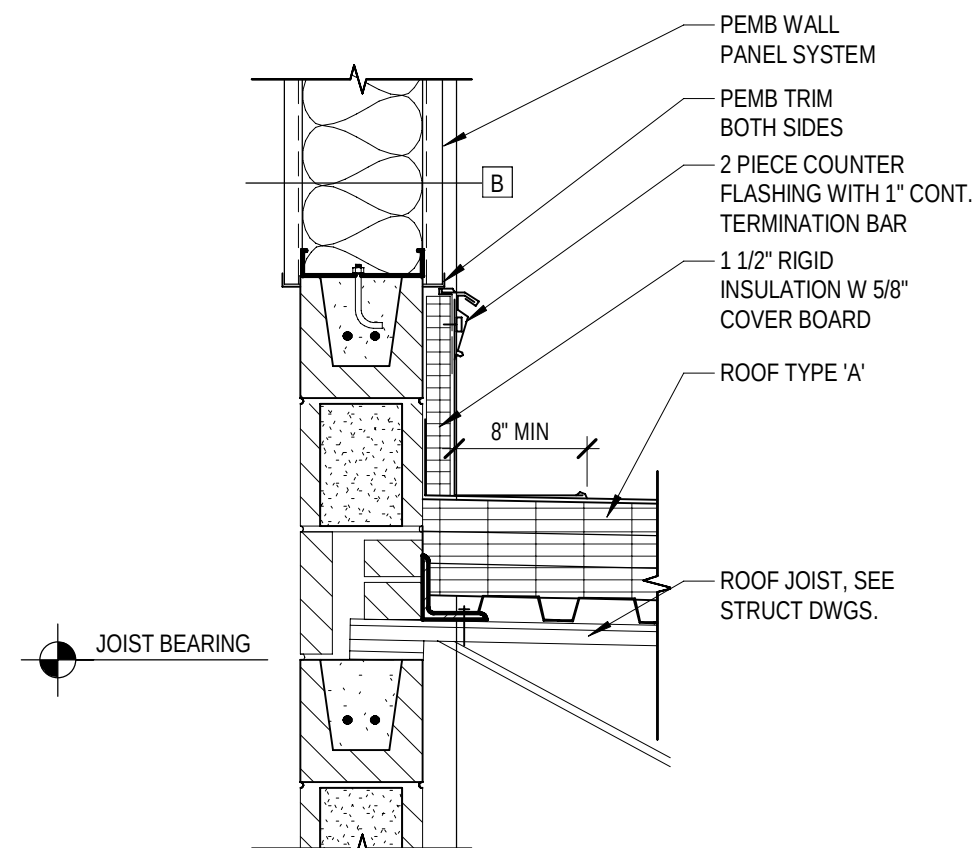


1 100 - ROOF PLAN
1/8" = 1'-0"

  - ROOF ASSEMBLY - TYPE 'A'**
THERMOPLASTIC POLYOLEFIN SINGLE PLY MEMBRANE ROOFING OVER 7/16" COVER DECK OVER (4) LAYERS OF 1 1/2" RIGID POLYSTYRORENE INSULATION STAGGERED (6" THICKNESS) ON METAL DECK. PROVIDE FINISHED 1/4" SLOPE PER 1' 0".
- ROOF ASSEMBLY - TYPE 'B'**
PEMB. METAL ROOF OVER METAL PURLINS, WITH R-5 METAL BLOCKS, 8" LOWER LAYER FIBERGLASS BATT INSULATION AND 3" UPPER LAYER FIBERGLASS BATT INSULATION WITH A TOTAL PRE-INSTALLED R-VALUE OF 35. SUSPEND WITH STEEL STRAP AND FABRIC SYSTEM. SLOPE 3:12.
- ROOF ASSEMBLY - TYPE 'C'**
STANDING SEAM METAL ROOF SYSTEM OVER SINGLE LAYER OF CONTINUOUS ICE & WATER SHEILD ON SPECIFIED ROOF DECKING OVER LIGHT GA. METAL TRUSSES.
- ROOF ASSEMBLY - TYPE 'D'**
STANDING SEAM METAL ROOF SYSTEM OVER SINGLE LAYER OF CONTINUOUS ICE & WATER SHEILD ON SPECIFIED PLYWOOD SHEATHING OVER WD. RAFTERS.
- -- INDICATES 3/4" FIRE WALL, SEE PLAN A.11.
-  INDICATES CRICKET, SLOPE 1/4" PER FOOT IN DIRECTION OF ARROW
-  APPROXIMATE AREA OF ROOF REPAIR, TO BE INVESTIGATED AND REPAIRED BY CONTRACTOR
- DS DOWNSPOUT.
- ≡ SC SCUPPER AND CONDUCTOR HEAD.
- EDS EXISTING DOWNSPOUT.
- RD ROOF DRAIN, REFER TO DETAIL 1/4A.2.
- ORD OVERFLOW ROOF DRAIN, REFER TO DETAIL 1/4A.2.
- VTR VENT THRU ROOF, REFER TO DETAIL 2/4A.2.
- RTU ROOF TOP UNIT, REFER TO MECHANICAL DWGS. AND CURB DETAIL 3/4A.2.
- ☒ EXHAUST FAN (OA) HOOD, REFER TO MECH. DWGS.

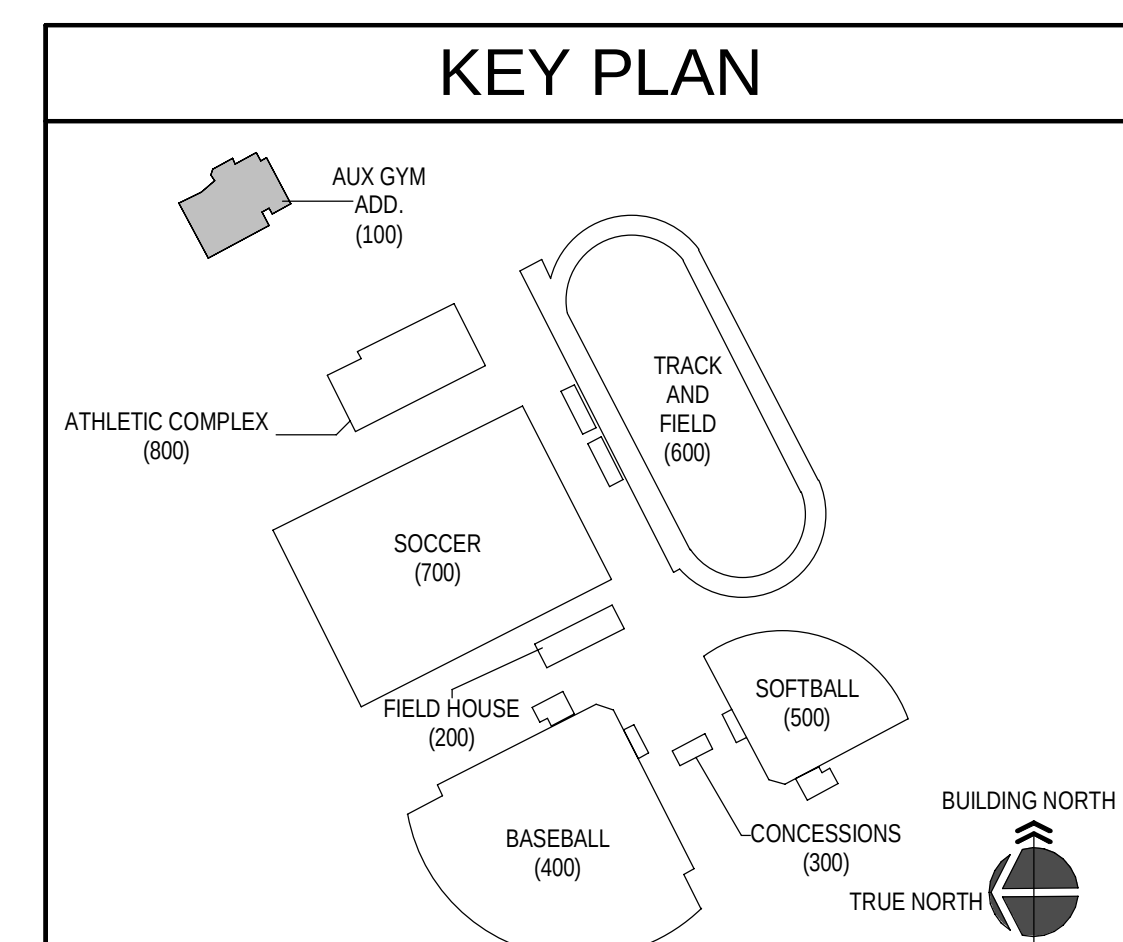


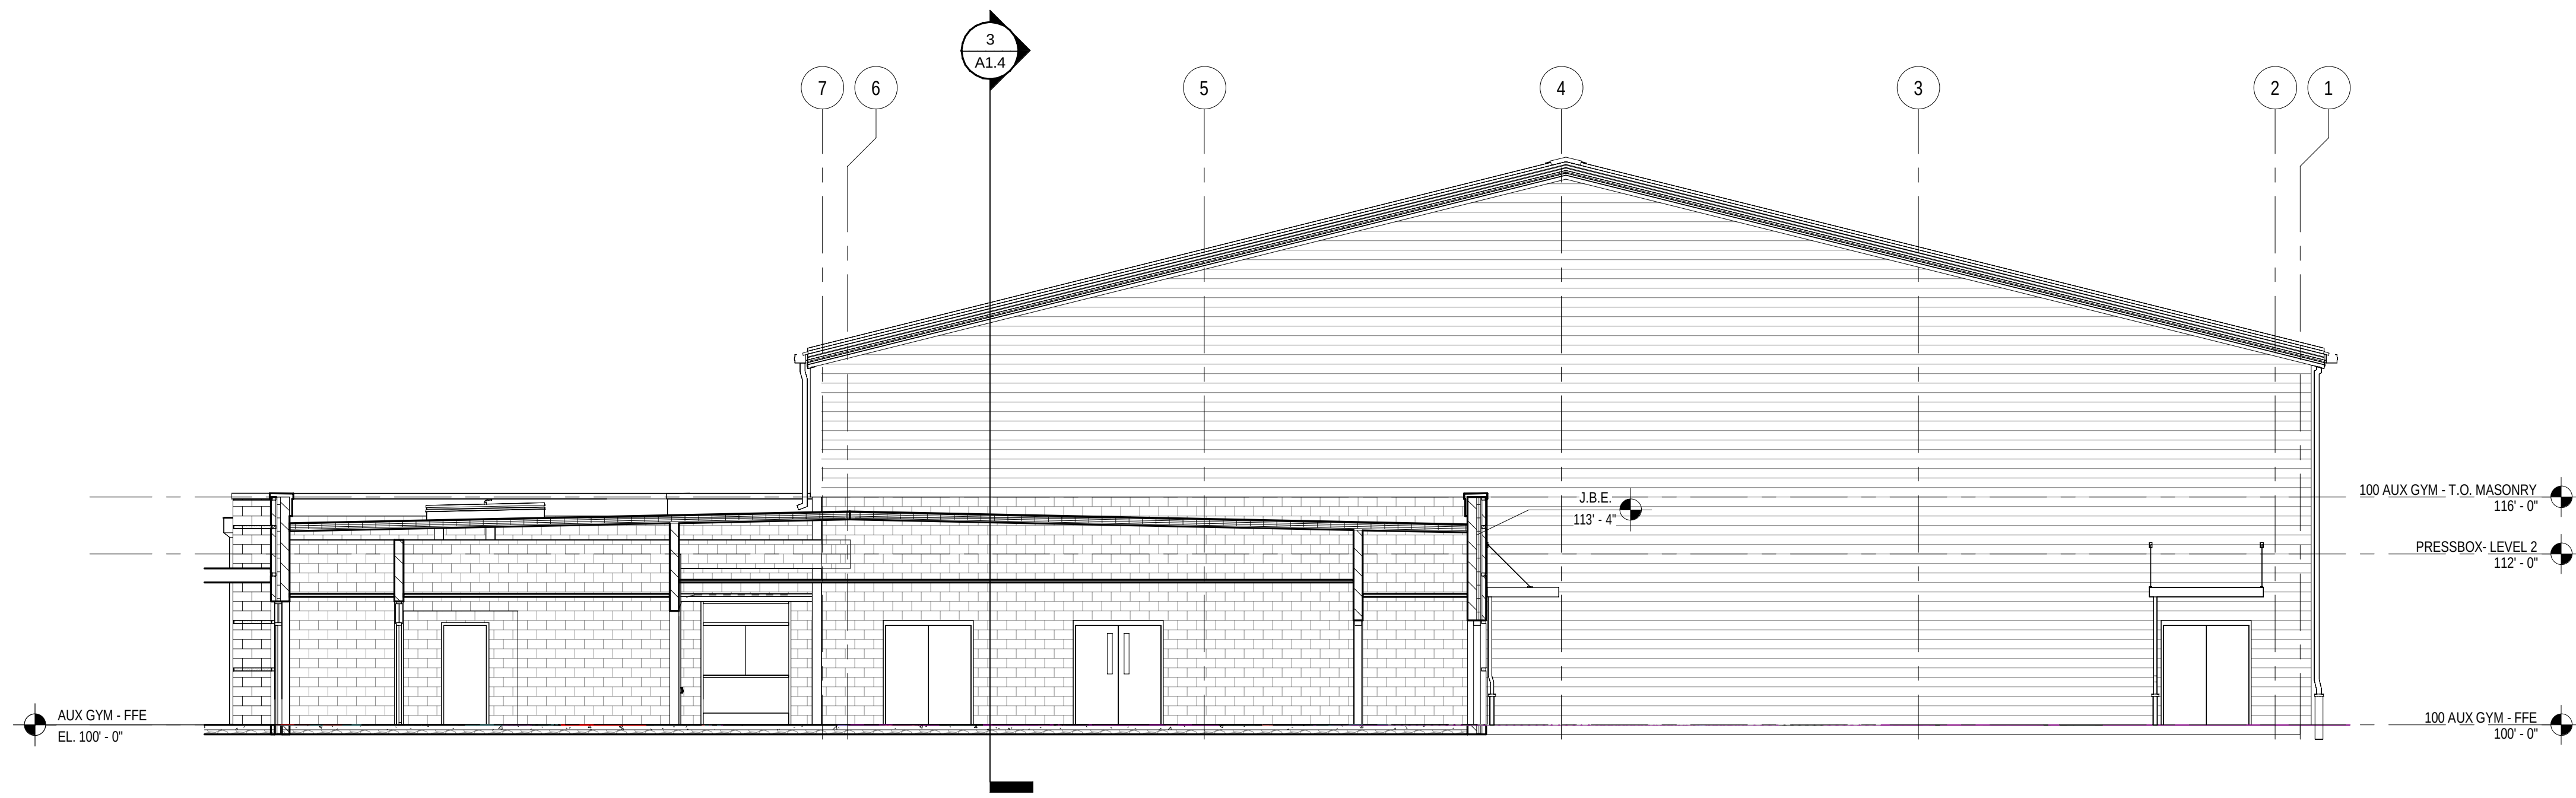

1 100 - BUILDING SECTION
1/8" = 1'-0"

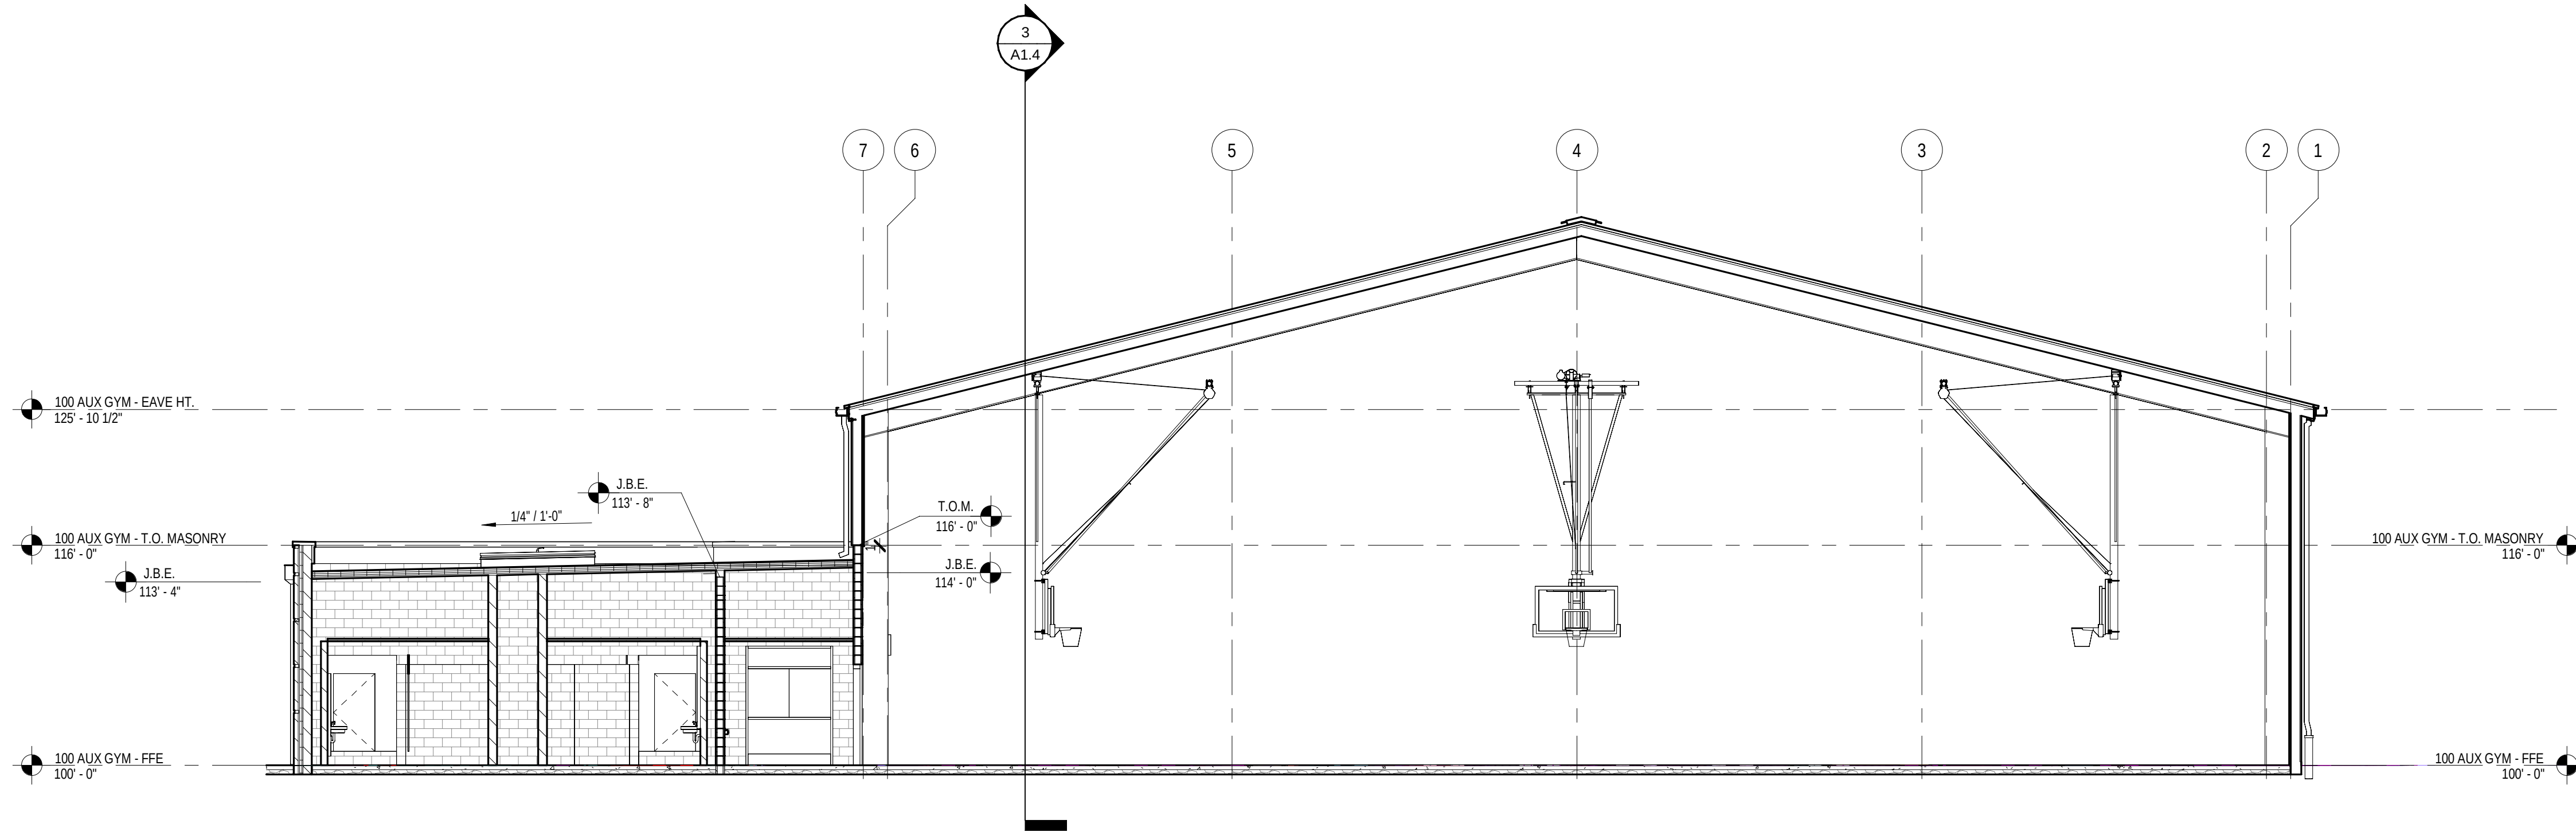

2 100 - BUILDING SECTION
1/8" = 1'-0"

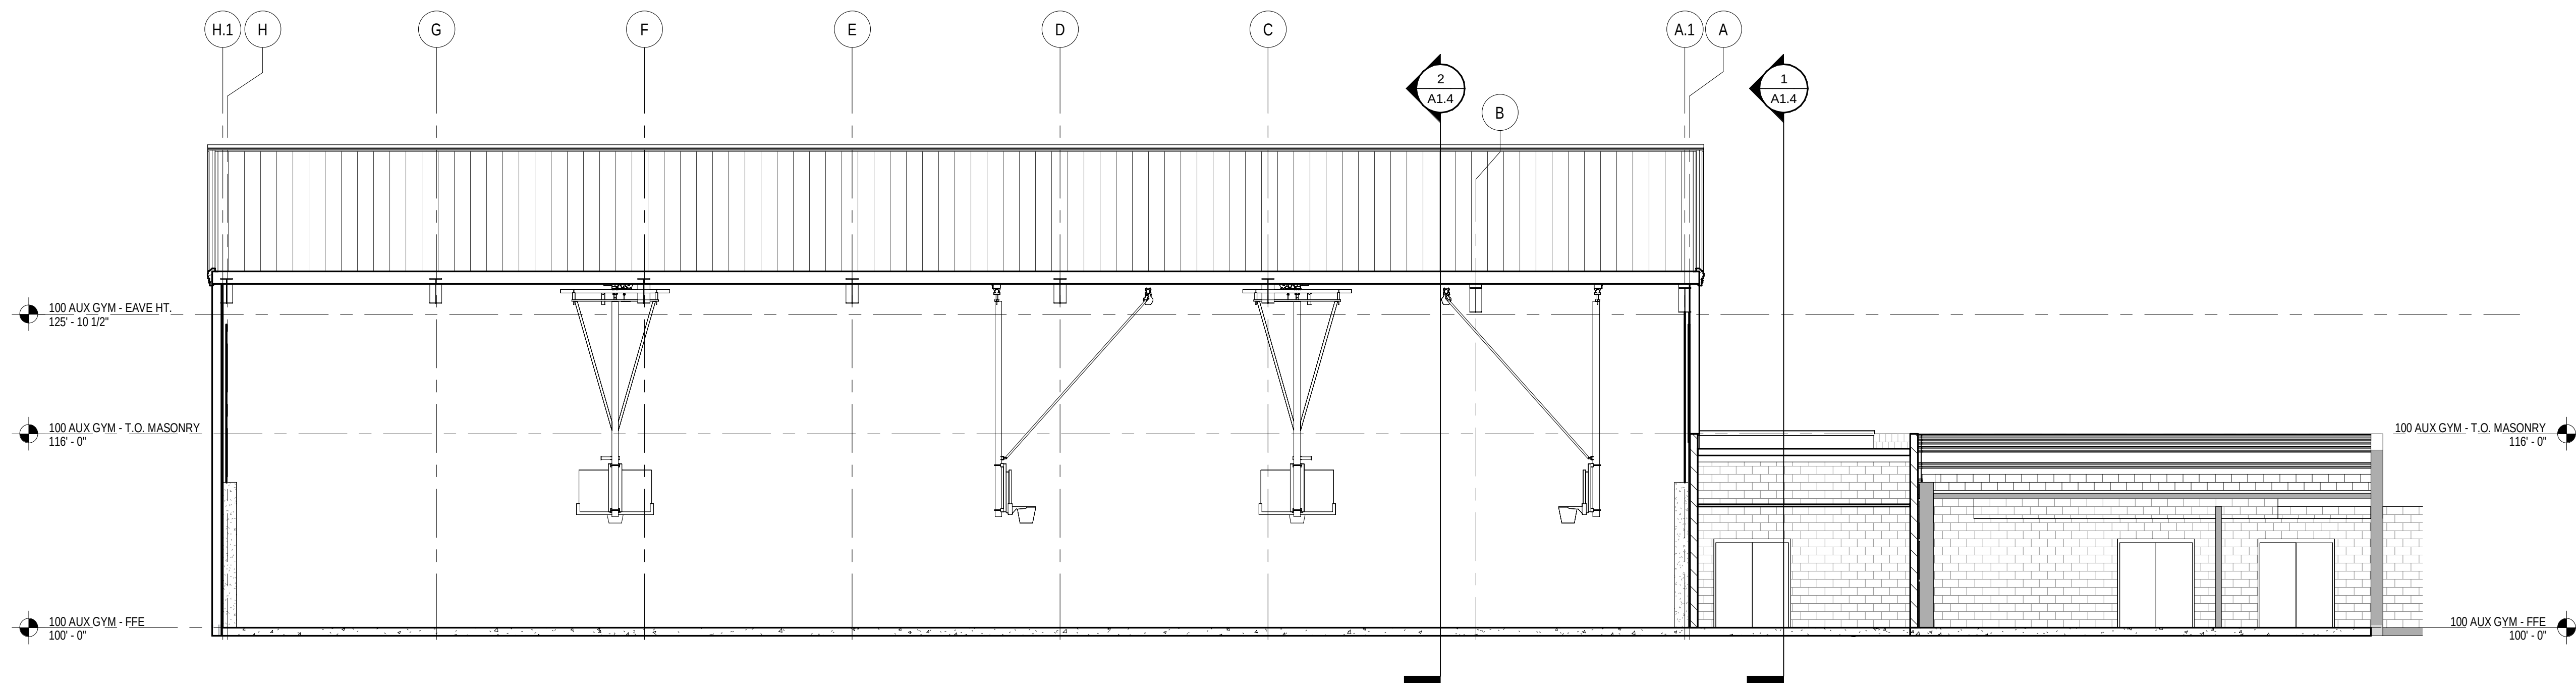

3 100 - BUILDING SECTION
1/8" = 1'-0"

JOB NO.	2459
DATE	12/15/2025
DRAWN	CAH, JCG
CHECKED	RJV, ASC

COPYRIGHT © 2025
SHERMAN CARTER BARNHART
ARCHITECTS, PLLC

REVISIONS		
No.	Description	Date

SHEET

COPYRIGHT © 2025
 HERMAN CARTER BARNHART
 ARCHITECTS, PLLC

HEET



GENERAL TOILET ACCESSORY NOTES

- 7 100 - REFLECTED CEILING PLAN
1/8" = 1'-0"



FLOOR PLAN KEYNOTES

- OWNER PROVIDED FURNITURE OR EQUIPMENT (N.I.C.).
- LINE OF SOFFIT / BULKHEAD ABOVE, REFER TO REFLECTED CEILING PLAN.
- PRE-MFR, PRE-FIN SUSPENDED ALUMINUM CANOPY, REFER TO DETAIL 11A4.2.
- EXTERIOR CONCRETE WALK, REFER TO SITE DRAWINGS.
- HIGH / LOW ADA COMPLIANT WATER COOLER UNIT, REFER TO MECH / ELEC. DRAWINGS.
- MOP SINK, REFER TO PLUMBING DRAWINGS.
- KNOX BOX RECESSED IN BRICK, REFER TO DOOR HARDWARE SPECIFICATIONS.
- FLOOR TRANSITION, REFER TO SHEET A8.1 FOR DETAILS.
- SHIPS LADDER, REFER TO DETAIL 11A0.3.
- DIVIDER CURTAIN, MOTORIZED OPERATOR, REFER TO ELEC. DWGS.
- 7'-0" TALL X 2" THICK WALL PAD WITH WOOD BACKING. ATTACH TO WALLS / COLUMNS WITH MANUFACTURER'S STANDARD "Z" CLIP SYSTEM.
- ELECTRIC PUSH-BUTTON ADA DOOR OPERATOR, REFER TO ELEC. DWGS.


GENERAL NOTES

- (OF-C) OWNER FURNISHED CONTRACTOR INSTALLED.
- EXISTING TO REMAIN INTERIOR WALLS THAT ARE EXPOSED IN AREAS OF RENOVATION TO BE CLEANED, REPAIRED, PRIMED, AND PAINTED FOR LIKE NEW FINISH.
- DO NOT SCALE DWGS. WRITTEN DIMENSIONS TAKE PRECEDENCE OVER SCALED DIMENSIONS.
- INTERIOR MASONRY CONTROL JOINTS TO OCCUR EVERY 20'-0" MAX.
- NOTE: MARKER BOARD (MB) AND TACK BOARD (TB) INDICATE WIDTH AND ARE TO BE 48" H.

SYMBOL LEGEND

- ROOM FINISH GROUPS (REFER TO KEY PLAN SHEETS)
- ROOM NUMBER
- DOOR NUMBER (DOOR SCHEDULE SHEET A8.1)
- KEY NOTES (SHEETS A1.3 THROUGH A2.8)
- WALL TYPE (SCHEDULE SHEET A0.1)
- ALUMINUM OR HOLLOW METAL WINDOW OR STOREFRONT TYPE (REFER TO FLOOR PLANS AND SCHEDULE SHEETS A8.2)
- TOILET ACCESSORIES (SCHEDULE SHEET A2.7)
- ELEVATION KEY NOTE (SHEETS A3.1)
- ROOF KEY NOTE (SHEET A4.1)
- CEILING PLAN KEY NOTE (SHEETS A7.1 THROUGH A7.7)
- SIGNAGE KEY NOTE (REFER TO KEY PLAN SHEETS)
- WALL / PARTITION DESIGNATION
- FW2 2 HOUR RATED FIRE WALL
- EPW2 EXISTING 2 HOUR RATED FIRE WALL
- MASONRY CONTROL JOINT FULL HEIGHT OF WALL. REFER TO FLOOR PLANS AND EXTERIOR ELEVATION A3.1 FOR LOCATIONS

KEY PLAN

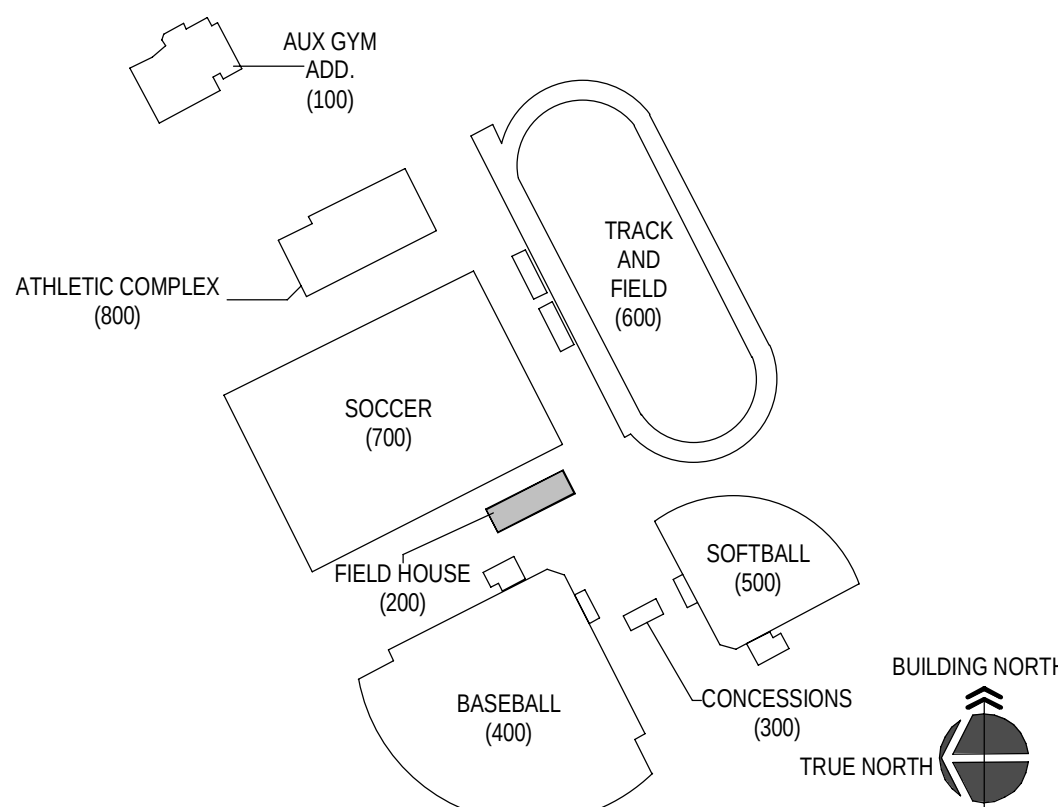


TOILET ACCESSORY SCHEDULE


ACCESSORY	MTG. HT.	MFR.
1 COAT HOOK AND BUMPER	48" TOP OF HOOK	ASI 0714
2 S.S. SOAP DISPENSER	40" TO VALVE	ASI 8943
3 DOUBLE ROLL TOILET PAPER DISPENSER W/ VANDAL RESISTANT SPINDLE (SURFACE MOUNTED)	24" TO CENTER LINE	ASI 0284-12
4 42" S.S. GRAB BAR (1-1/4")	33" TO CENTERLINE	ASI 3401-42P
5 36" S.S. GRAB BAR (1-1/4")	33" TO CENTERLINE	ASI 3401-36P
6 18" VERTICAL S.S. GRAB BAR (1-1/4")	40" TO BOTTOM CENTERLINE	ASI 3401-18P
7 SANITARY NAPKIN DISPOSAL (SURFACE MOUNTED)	24" TO TOP (28" FOR ADA)	ASI 0852
8 MIRROR W/ S.S. FRAME - 24"x36"	40" TO BOTTOM	ASI 0600-B2436
9 PAPER TOWEL DISPENSER (SURFACE MOUNTED)	46" TO DISPENSER SLOT	ASI 20210
10 48" S.S. GRAB BAR (1-1/4")	33" TO CENTERLINE	ASI 3401-48P
11 MOP / BROOM HOLDER (36" WIDE)	72" TO TOP	SEE PLUMBING
12 MOP SINK	FLOOR MOUNTED	SEE PLUMBING
13 MIRROR W/ S.S. FRAME - 108"x72"	40" TO BOTTOM	
14 BABY CHANGING TABLE	33" MAX. TO CHANGE SURFACE IN OPEN POSITION	ASI 9013-9
15 SHOWER CURTAIN	72" STANDARD HEIGHT	ASI 1200-V
16 TOWEL HOOKS	54" TO CENTERLINE	ASI 0740-Z
17 24" S.S. GRAB BAR (1-1/4")	33" TO CENTERLINE	ASI 3401 SERIES
18 ADA COMPLIANT FOLDING SEAT	REFER TO DETAIL THIS SHEET	ASI 8203
19 SOAP DISH WITH DRAIN	38" TO TOP OF DISH	ASI 0720-Z

GENERAL TOILET ACCESSORY NOTES


- MODEL NOS. DENOTE TOILET ACCESSORIES PRODUCTS OFFERED BY "AMERICAN SPECIALTIES, INC." (ASI) AND REPRESENT THE LEVEL OF QUALITY REQUIRED AND SHALL BE USED AS A BASIS OF DESIGN.
- ALL ITEMS SHALL BE LOCATED HORIZONTALLY AND MOUNTED TO SPECIFIC POINT ABOVE FINISH FLOOR SURFACES IN ACCORDANCE WITH ALL APPLICABLE REQUIREMENTS OF THE AMERICANS WITH DISABILITIES ACT (ADA) - ANSI A117.1 - 2009.
- REFER TO MEP DWGS. AND SPECIFICATIONS FOR PLUMBING FIXTURES, CONTROLS AND FLOOR DRAIN LOCATIONS.
- ALL EXPOSED PIPING AT LAVATORIES (N.I.C.) SHALL BE INSULATED AND COVERED WITH A PRE MOLDED RIGID INSULATION JACKET.
- ALL TOILET ACCESSORIES TO INCLUDE VANDAL RESISTANT OPTION.
- REFER TO ALL FLOOR PLAN SHEETS FOR ACCESSORIES REQUIRED AT OTHER LOCATIONS.
- INSTALL GRAB BARS TO ALLOW 1-1/2" BETWEEN GRAB BAR AND WALL.
- REFER TO TYPICAL ADA COMPLIANT GRAB BAR LAYOUT 1A0.1.

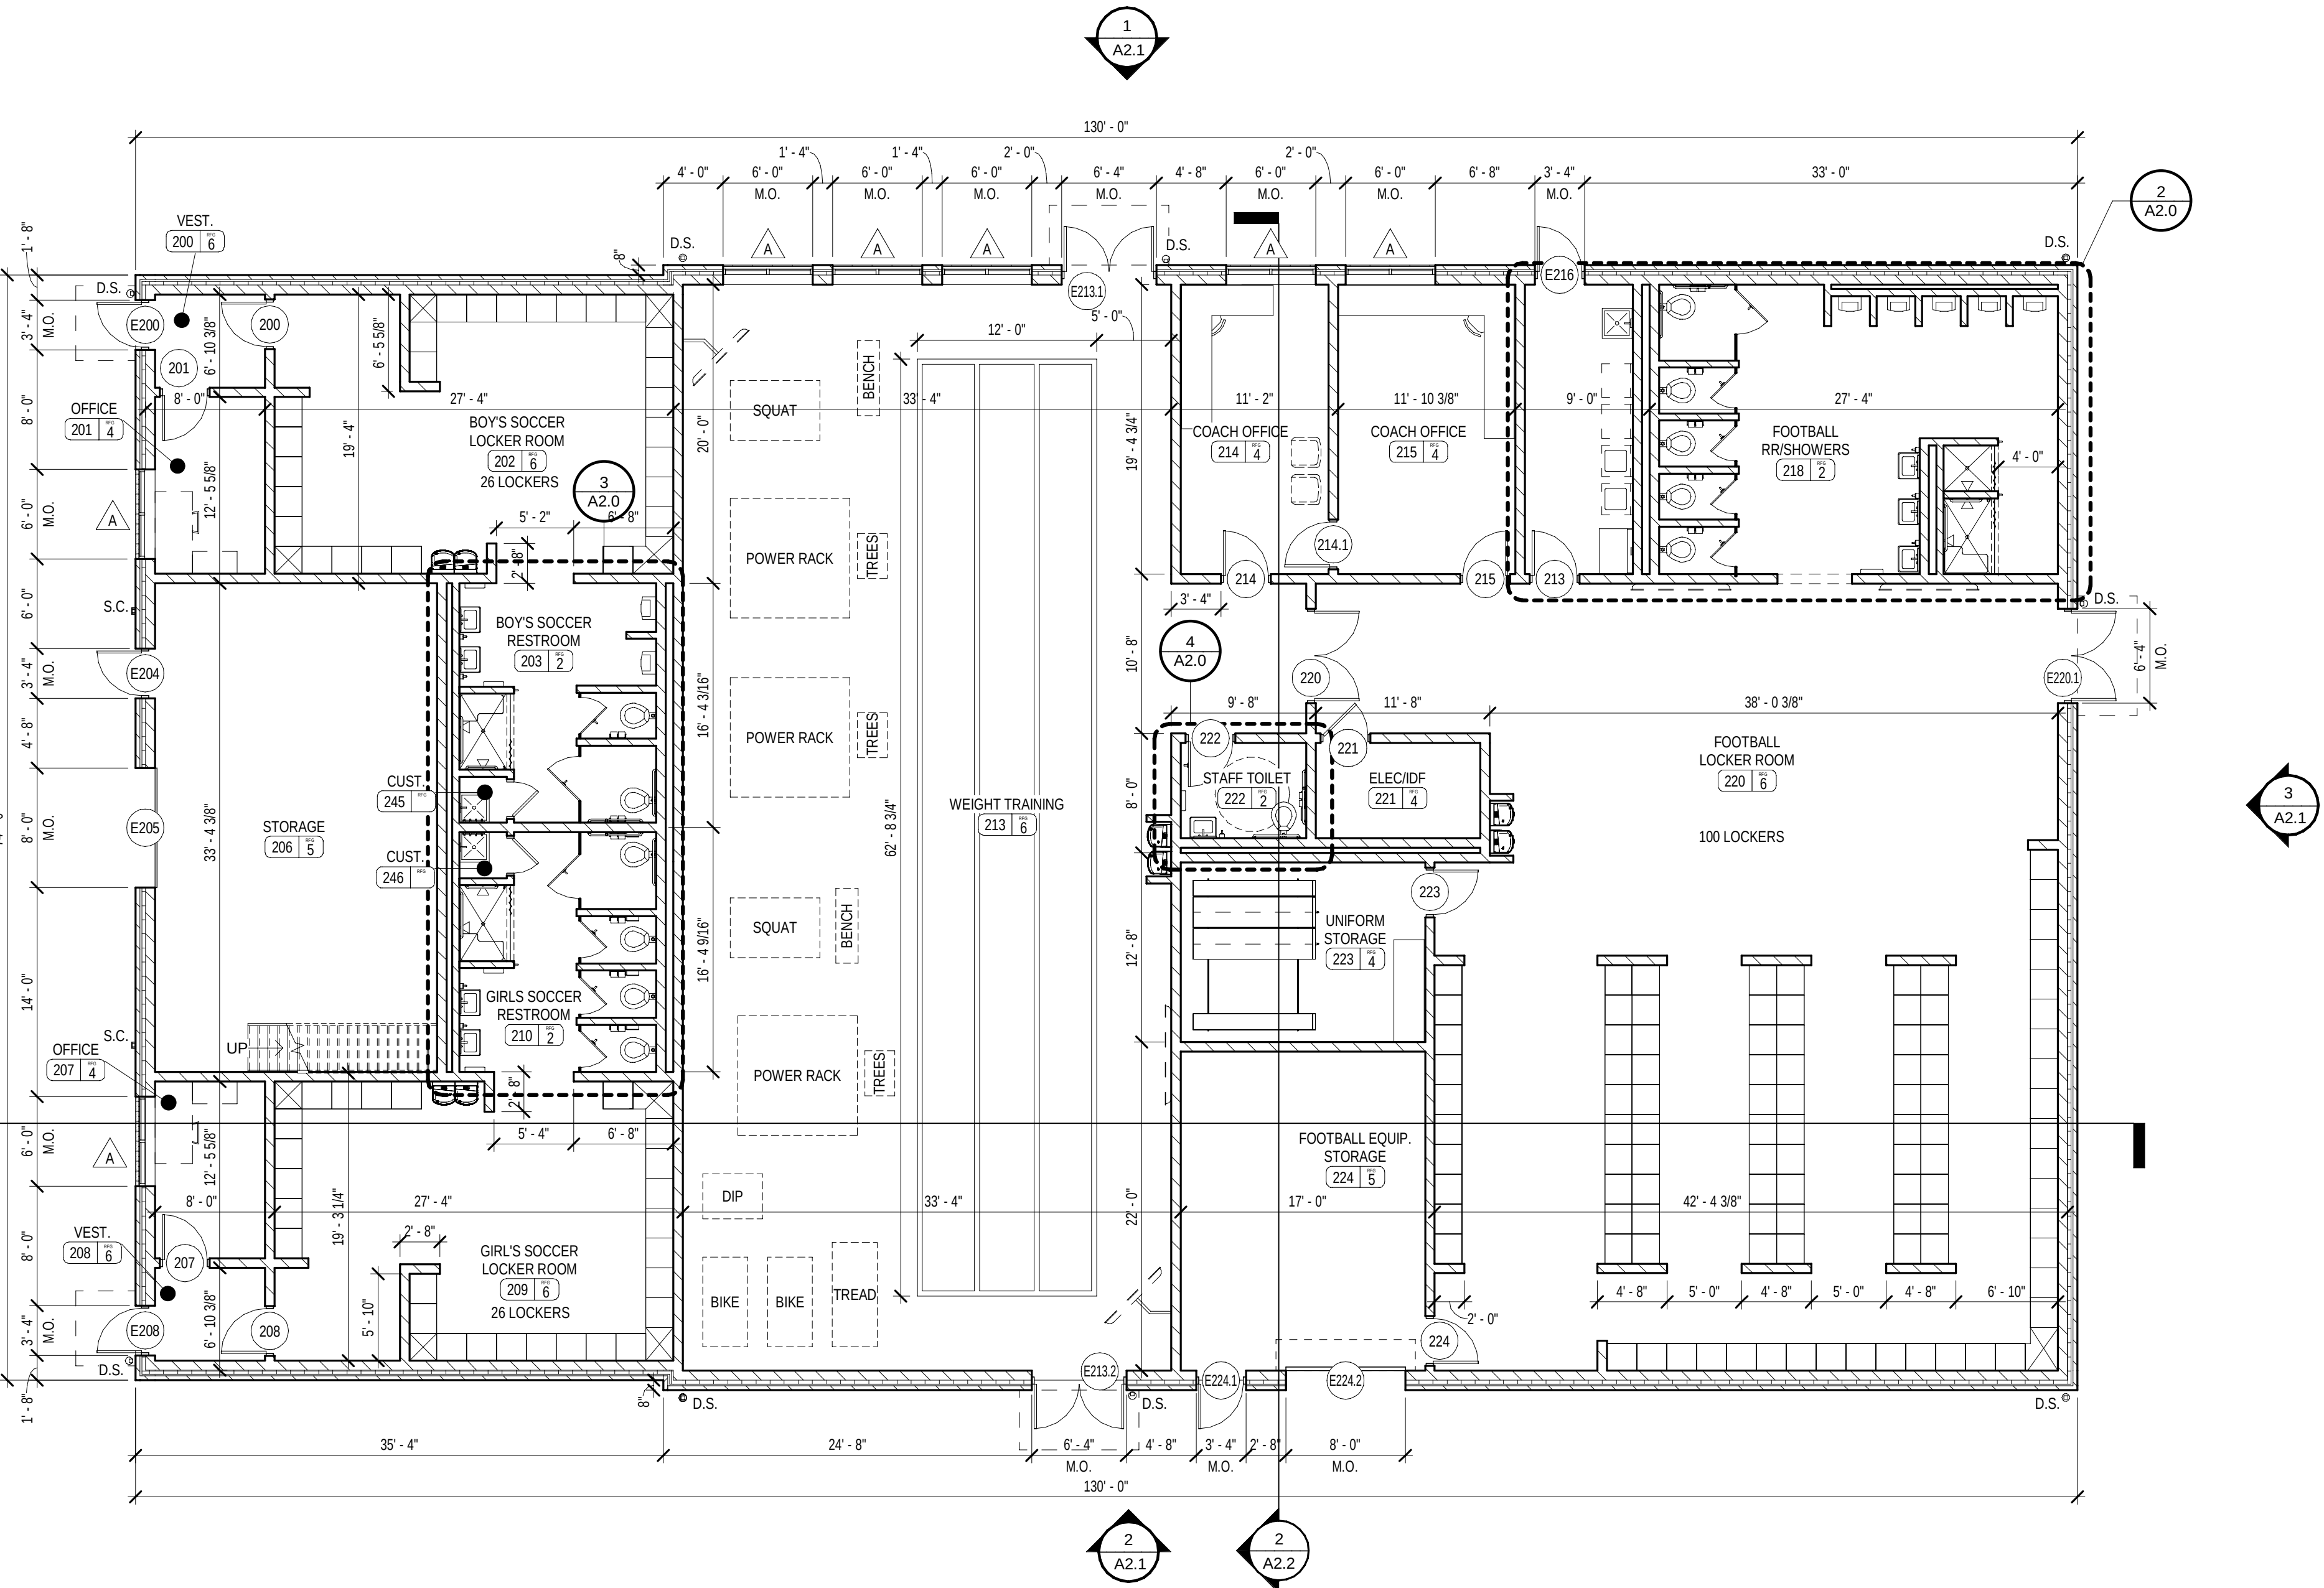


200 - FIRST FLOOR NEW WORK PLAN
1/8" = 1'-0"

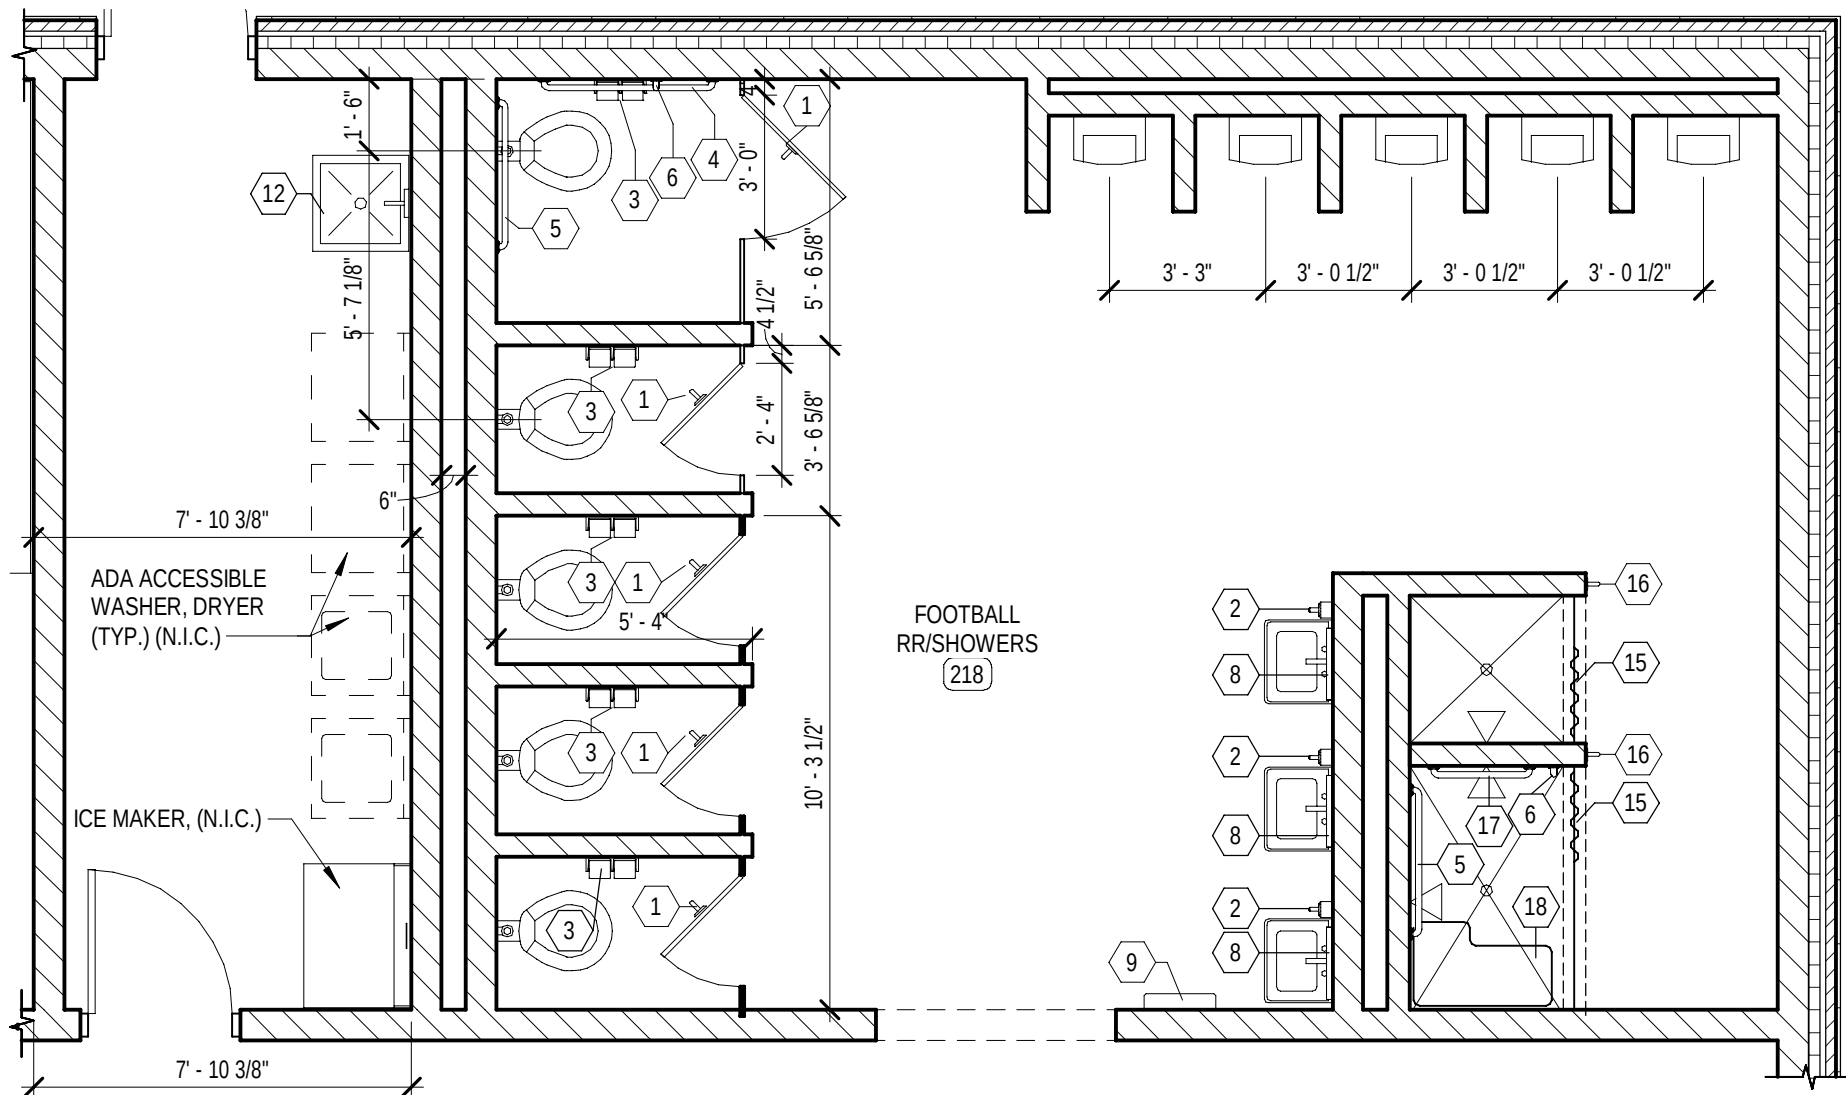


200 - ENLARGED RESTROOM PLAN
1/4" = 1'-0"

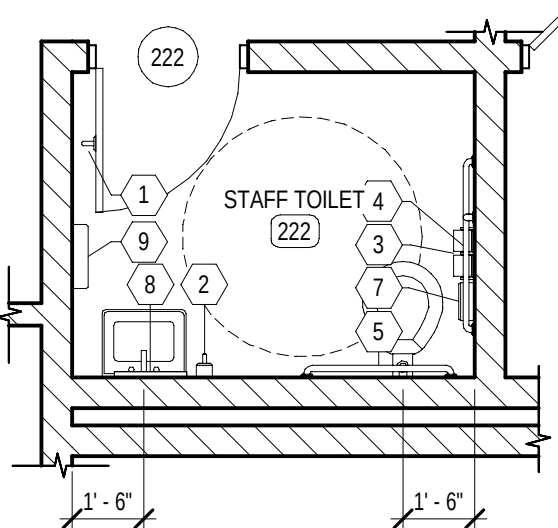


200 - ENLARGED RESTROOM PLAN
1/4" = 1'-0"

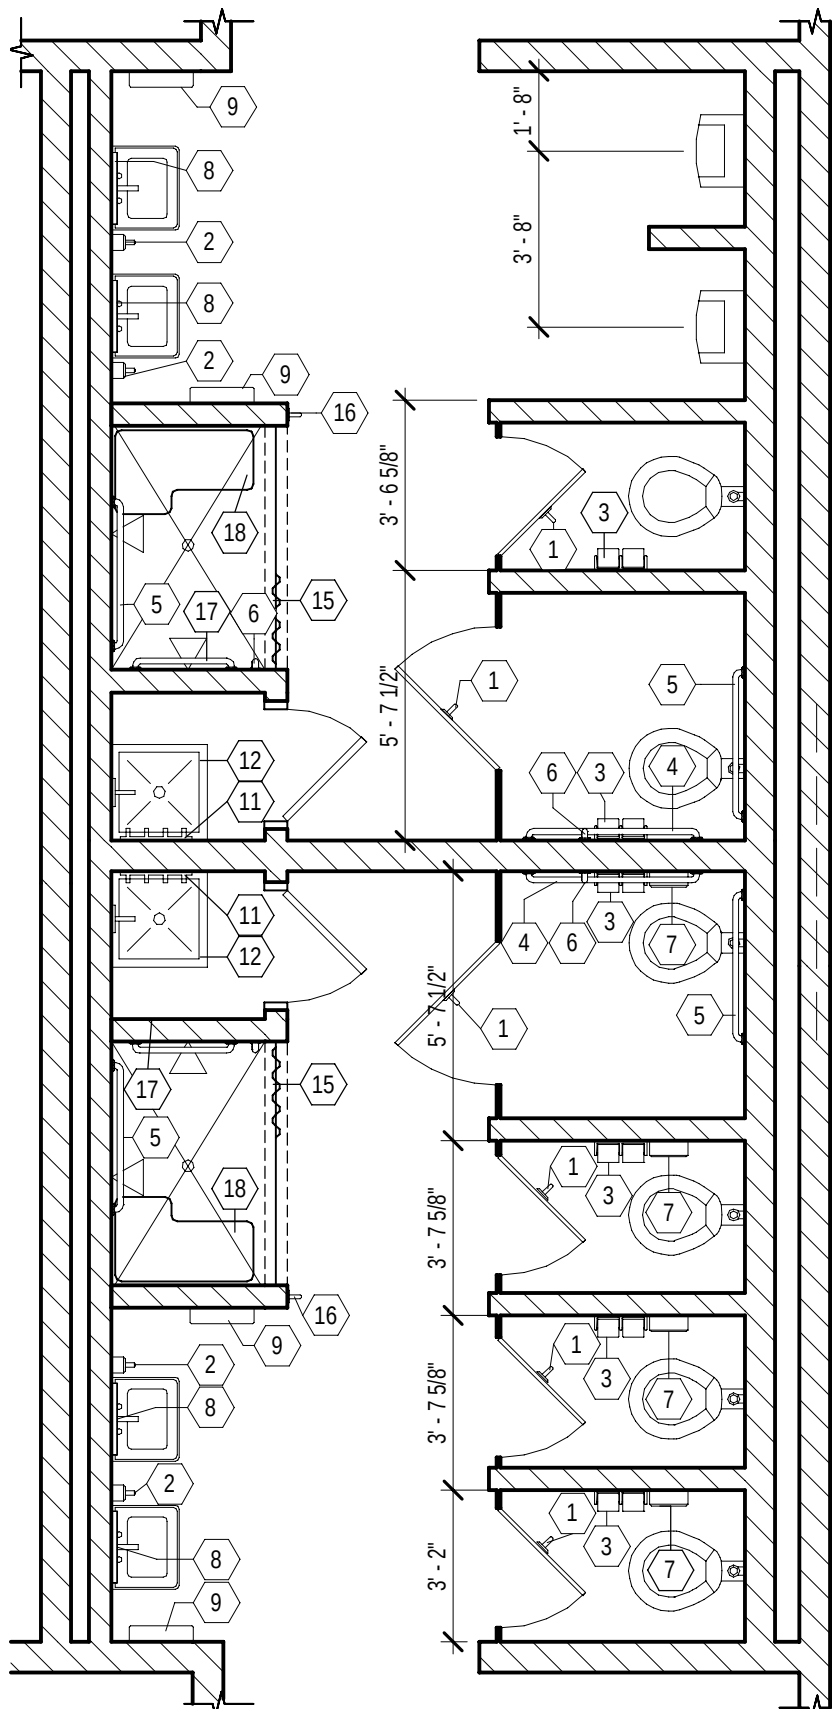


200 - ENLARGED RESTROOM PLAN
1/4" = 1'-0"

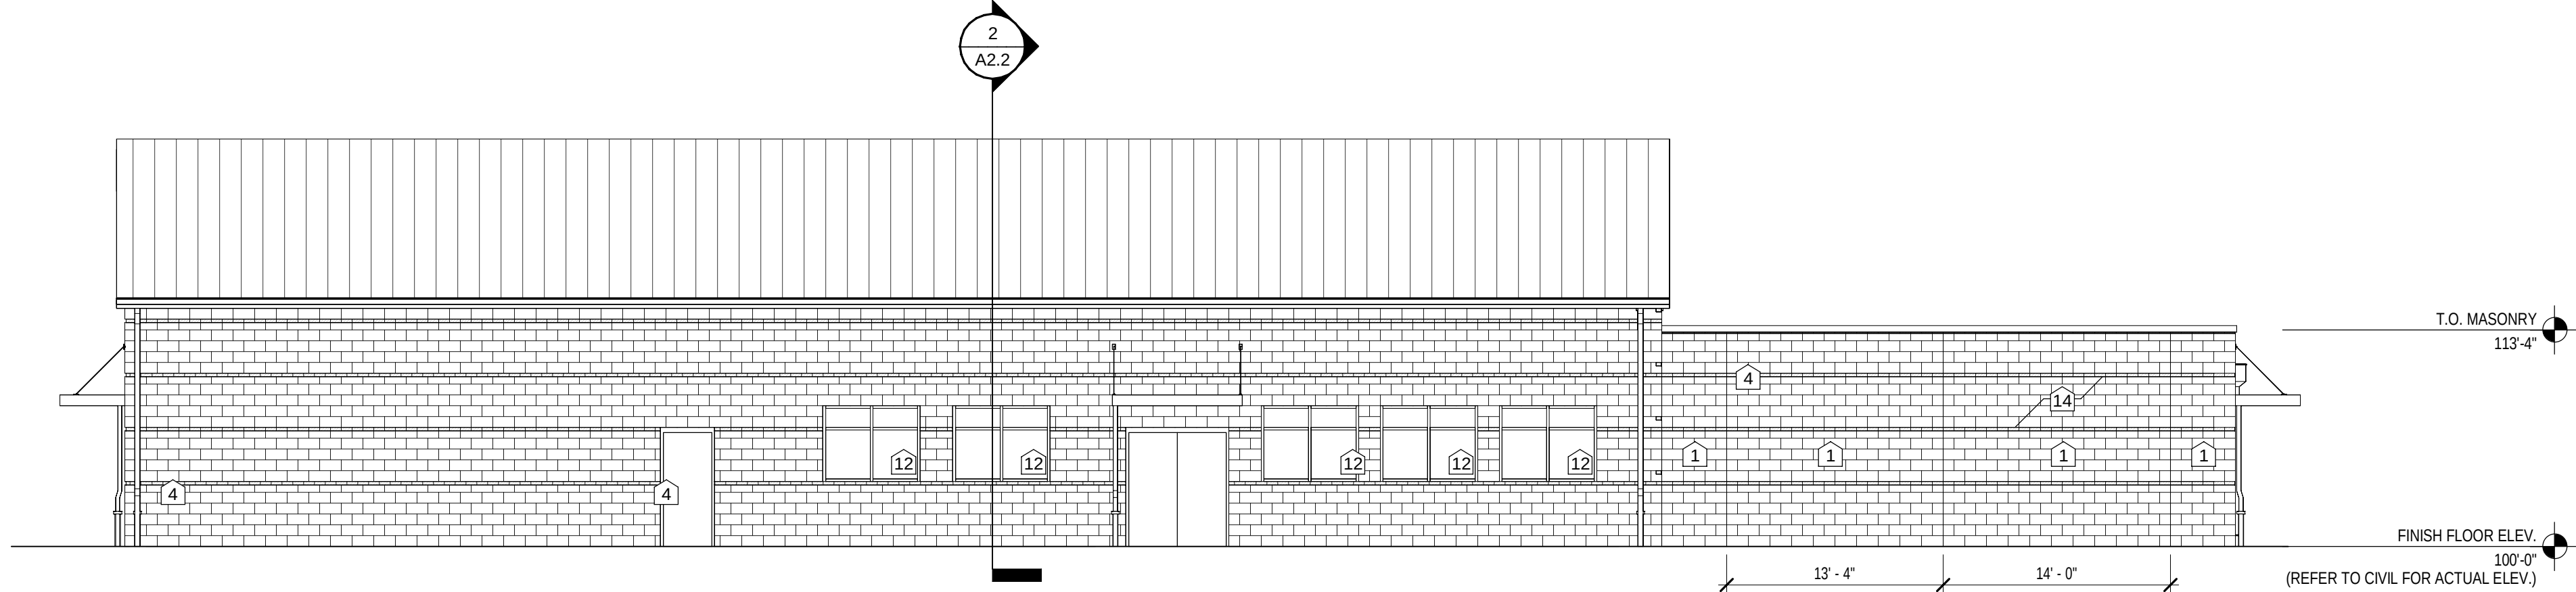


1 200 - BUILDING ELEVATION - NORTH
1/8" = 1'-0"

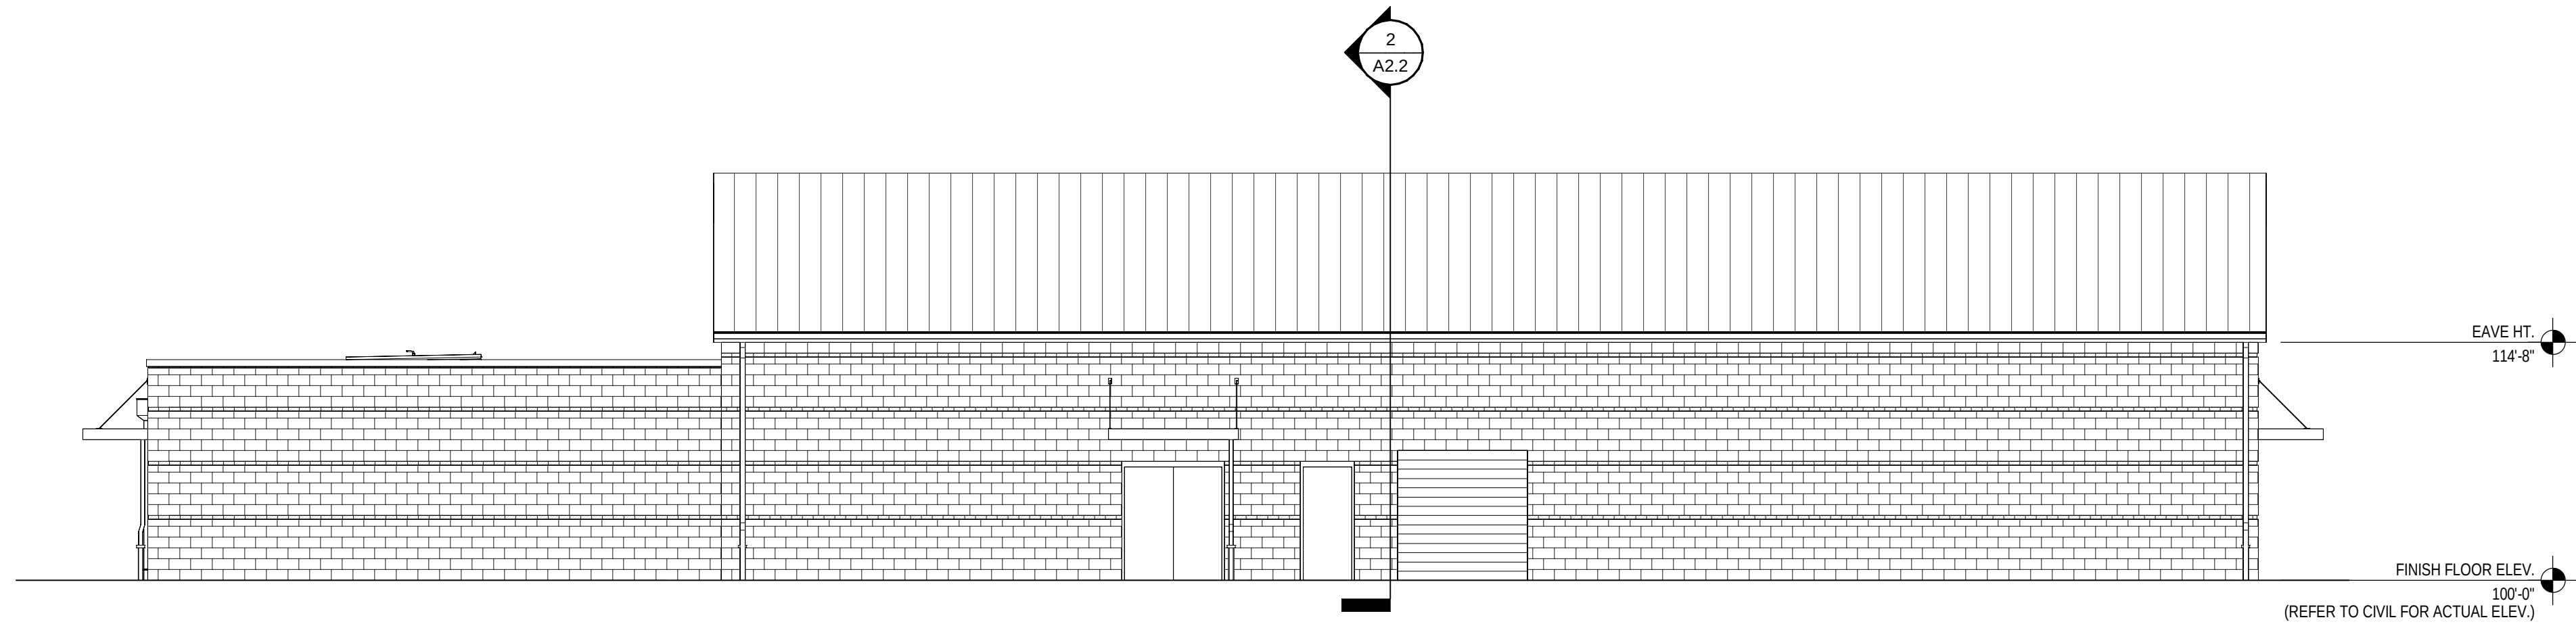

2 200 - BUILDING ELEVATION - SOUTH
1/8" = 1'-0"

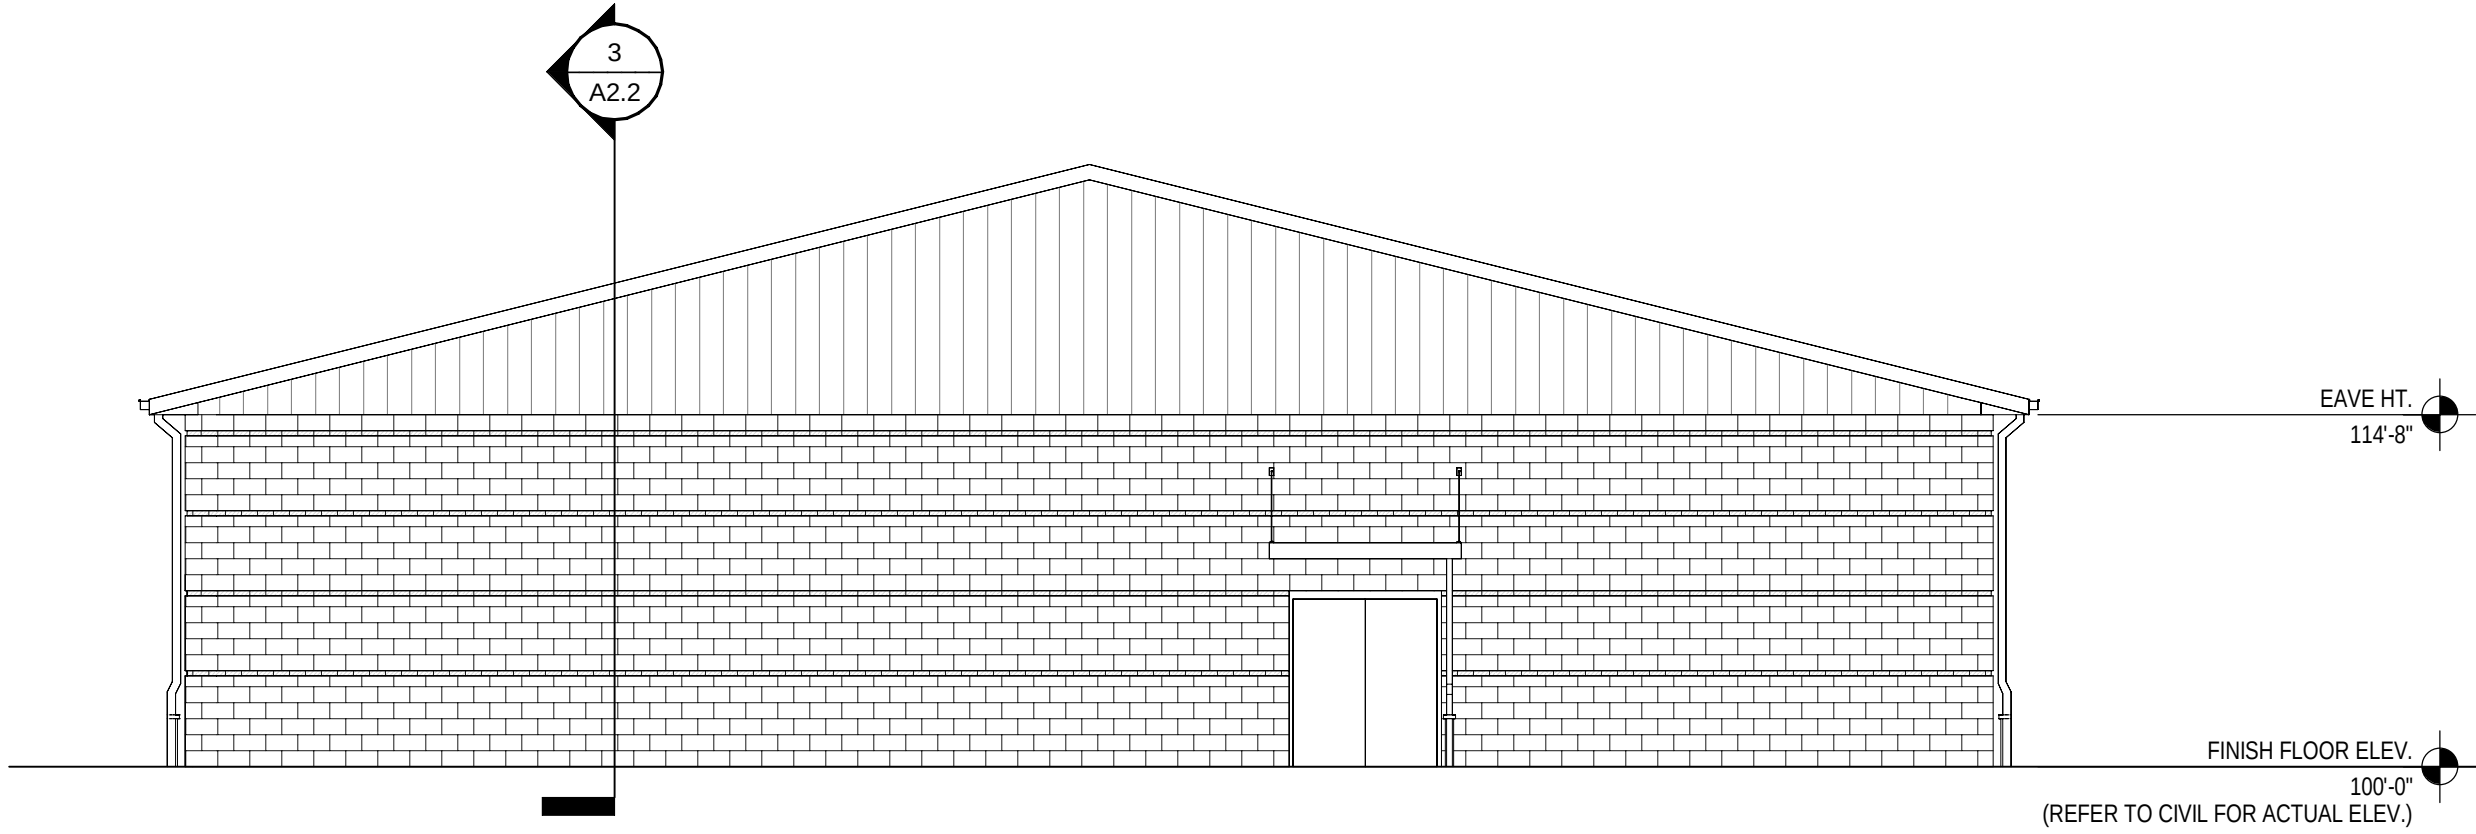

3 200 - BUILDING ELEVATION - EAST
1/8" = 1'-0"

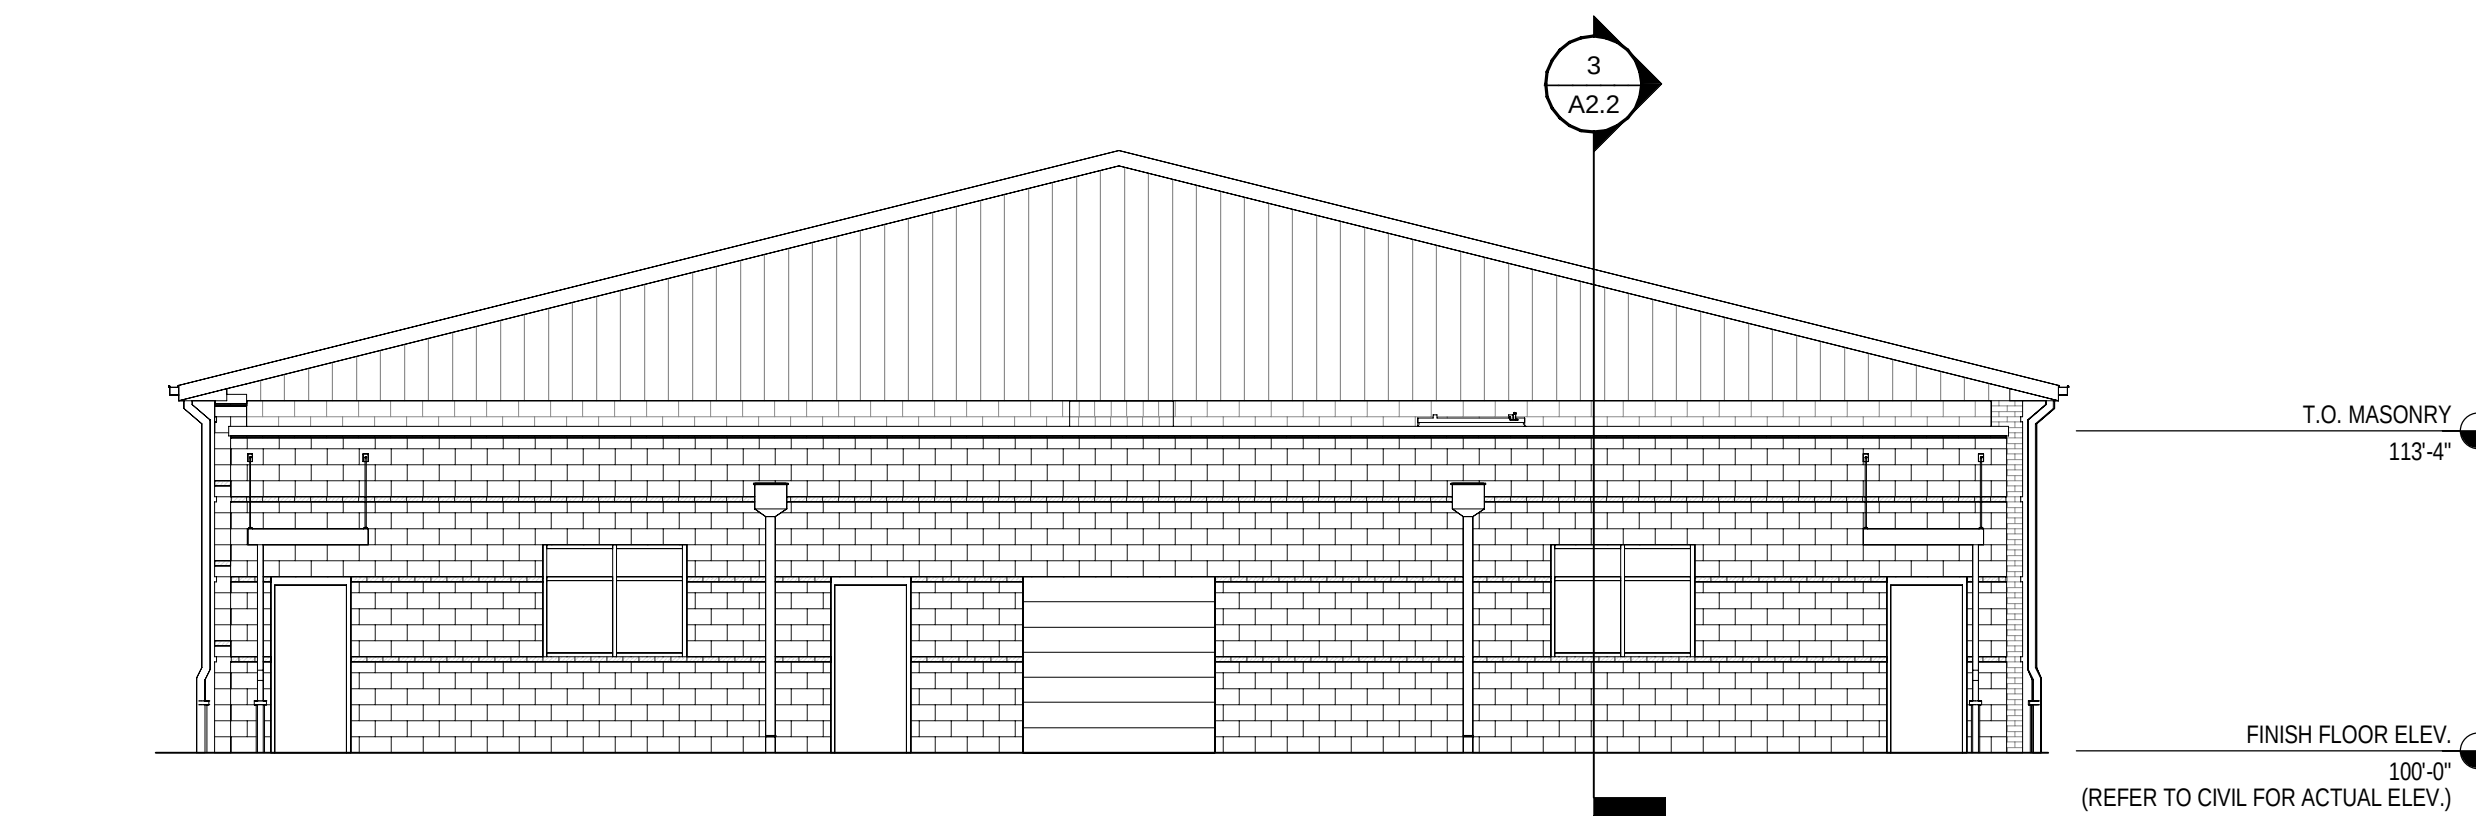

4 200 - BUILDING ELEVATION - WEST
1/8" = 1'-0"

GENERAL ELEVATION NOTES

BUILDING ELEVATIONS SHOWN ON THIS DRAWING ARE INTENDED FOR GENERAL REFERENCE PURPOSES ONLY. REFER TO REFERENCED SECTIONS AND DETAILS FOR MORE FULLY DESCRIBED CONDITIONS AND REQUIREMENTS.

- A. MATERIALS INDICATIONS AND DESCRIPTIONS, VERTICAL AND OTHER DIMENSIONS SHOWN ON ONE BUILDING ELEVATION APPLY TO OTHER BUILDING ELEVATIONS WHERE SHOWN UNLESS NOTED OTHERWISE.
- B. LINES REPRESENTING PAVING AND FINISH GRADES ARE APPROXIMATE AND ARE SHOWN FOR REFERENCE PURPOSES ONLY. REFER TO SITE PLANS FOR SPECIFIC GRADE AND SPOT ELEVATIONS AT EACH RESPECTIVELY.
- C. REFER TO FLOOR PLANS FOR LOCATION AND DOOR SCHEDULE FOR FULL EXTENT AND COMPLETE DESCRIPTION OF DOOR AND FRAME TYPES. PORTIONS OF DOORS, WINDOWS STOREFRONTS, AND CURTAIN WALLS MAY BE CONCEALED BY OTHER BUILDING FEATURES SHOWN.
- D. REFER TO FLOOR PLANS FOR SPECIFIC ALUMINUM WINDOW TYPES AND WINDOW ELEVATIONS.
- E. LOCATIONS OF CONTROLUEXPANSION JOINTS IN MASONRY WALLS ARE SHOWN ON THIS DRAWING. SEE TYPICAL DETAILS ON SHEET A6.2 FOR SPECIFIC REQUIREMENTS AT RESPECTIVE LOCATIONS.
- F. ALL EXPOSED NEW EXTERIOR MASONRY SHALL RECEIVE APPLICATION OF SPECIFIED WATER REPELLENT.
- G. ALL EXPOSED EXTERIOR METAL SUCH AS FLASHINGS, COPINGS, GUTTERS DOWNSPOUTS AND LADDERS SHALL RECEIVE THE SPECIFIED FIELD OR SHOP APPLIED FINISH COATING.

ELEVATION KEY NOTES

- NOTE: NOT ALL NOTES APPLY TO THIS SHEET.
1. 8" (NOM.) SPURT-FACE CMU
2. 6" (NOM.) GROUND-FACE CMU
3. BRICK ACCENT BAND (1 ROW)
4. CONTROL JOINT
5. GALV. INSULATED H.M. DOOR & FRAME (PRIMED, PAINT BY OTHERS)
6. WALL MOUNTED LIGHT, REFER TO ELECTRICAL DRAWINGS
7. FINISH GRADE - VARIES, REFER TO SITE DRAWINGS
8. PRE-FINISHED S.M. GUTTER
9. PRE-FINISHED DOWNSPOUT - TIE INTO BOOT, CONNECT TO BELOW GRADE DRAINAGE SYSTEM, REFER TO SITE DETAILS.
10. INSULATED COILING OVERHEAD DOOR WITH PRE-FIN. S.M. COVER, REFER TO SPECIFICATIONS.
11. PRE-FINISHED METAL WALL PANEL. REFER TO SPECIFICATIONS.
12. SIGNAGE, REFER TO SPECS.
13. ALUM. STOREFRONT
14. CANOPY SYSTEM - REFER TO DETAIL 15/A1.1
15. RECESS BRICK BAND 1/2" (TYP.)
16. GUTTER.
17. PEMB RAKE TRIM
18. PEMB GUTTER
19. PEMB DOWNSPOUT
20. PEMB RIDGE CAP
21. PEMB METAL WALL PANEL
22. S.M. COPING
23. EXTERIOR GRADE PLYWOOD, PAINTED, REFER TO DETAIL 6/A5.2.

JOB NO.	2459
DATE	12/15/2025
DRAWN	CAH
CHECKED	RJV, ASC

COPYRIGHT © 2025
SHERMAN CARTER BARNHART
ARCHITECTS, PLLC


REVISIONS

No.	Description	Date


SHEET

A2.1


2469
ALLEN COUNTY - SCOTTSVILLE HIGH SCHOOL ATHLETIC COMPLEX
12/15/2025 9:55:27 AM

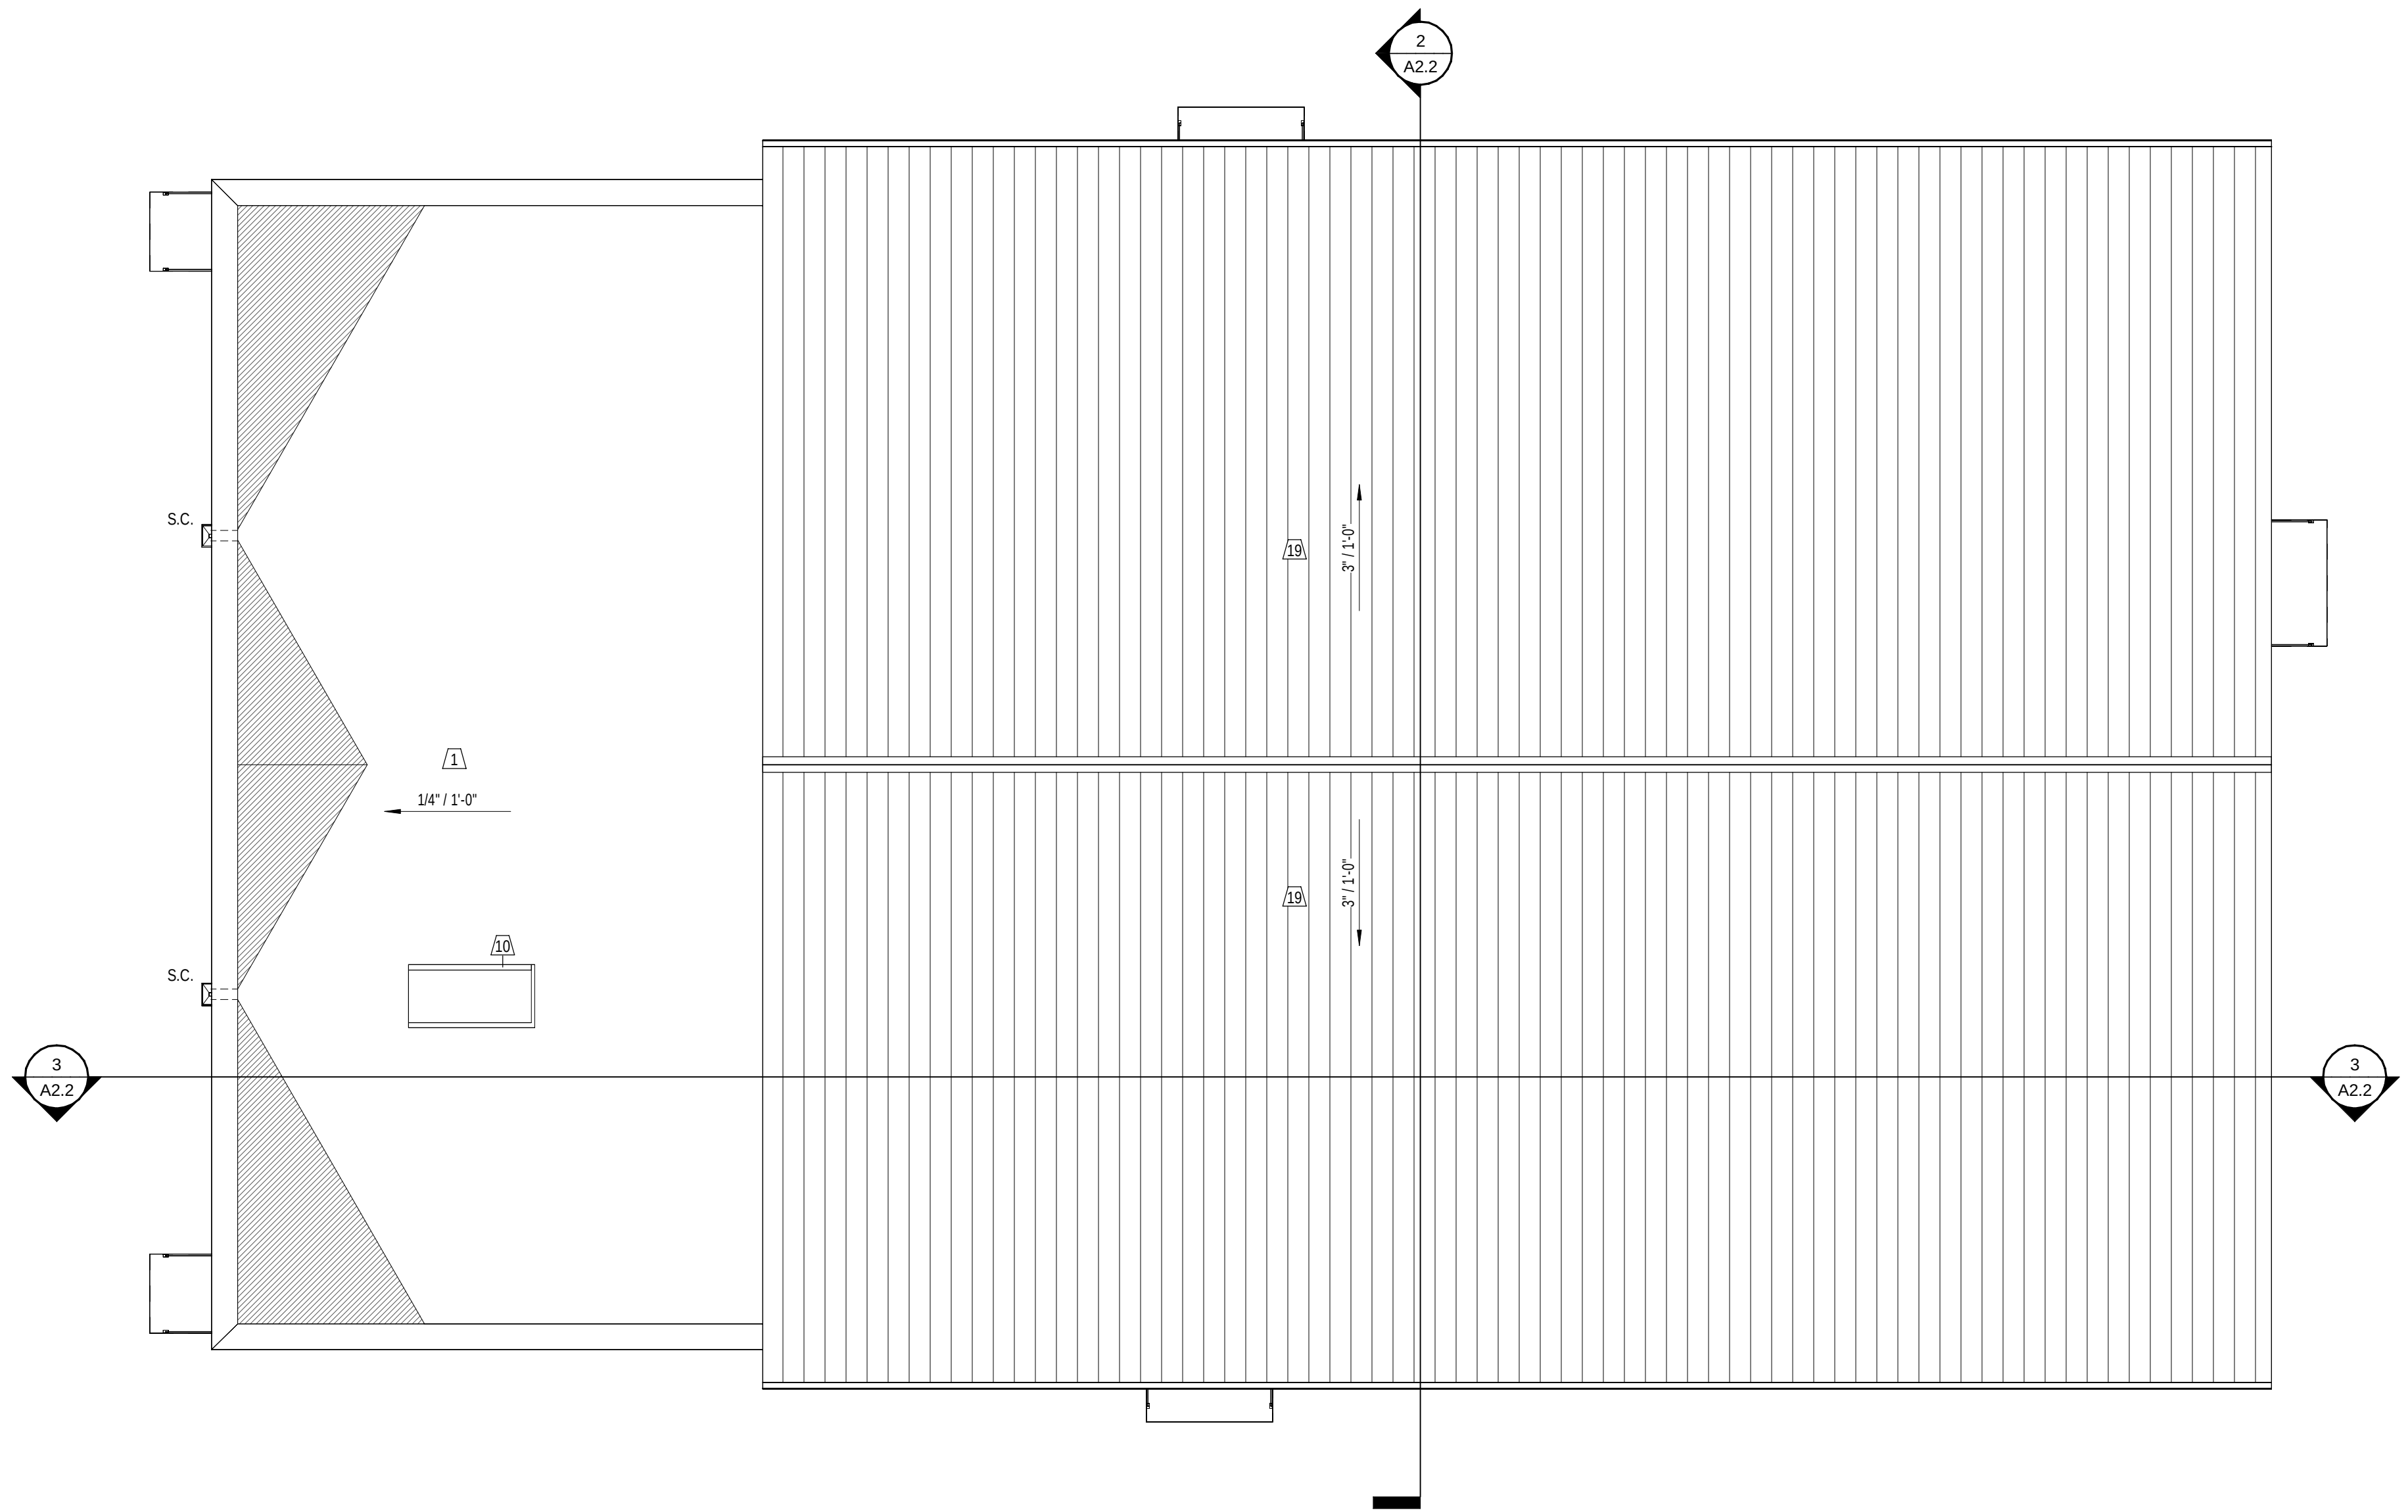

1 200 - ROOF PLAN
1/8" = 1'-0"

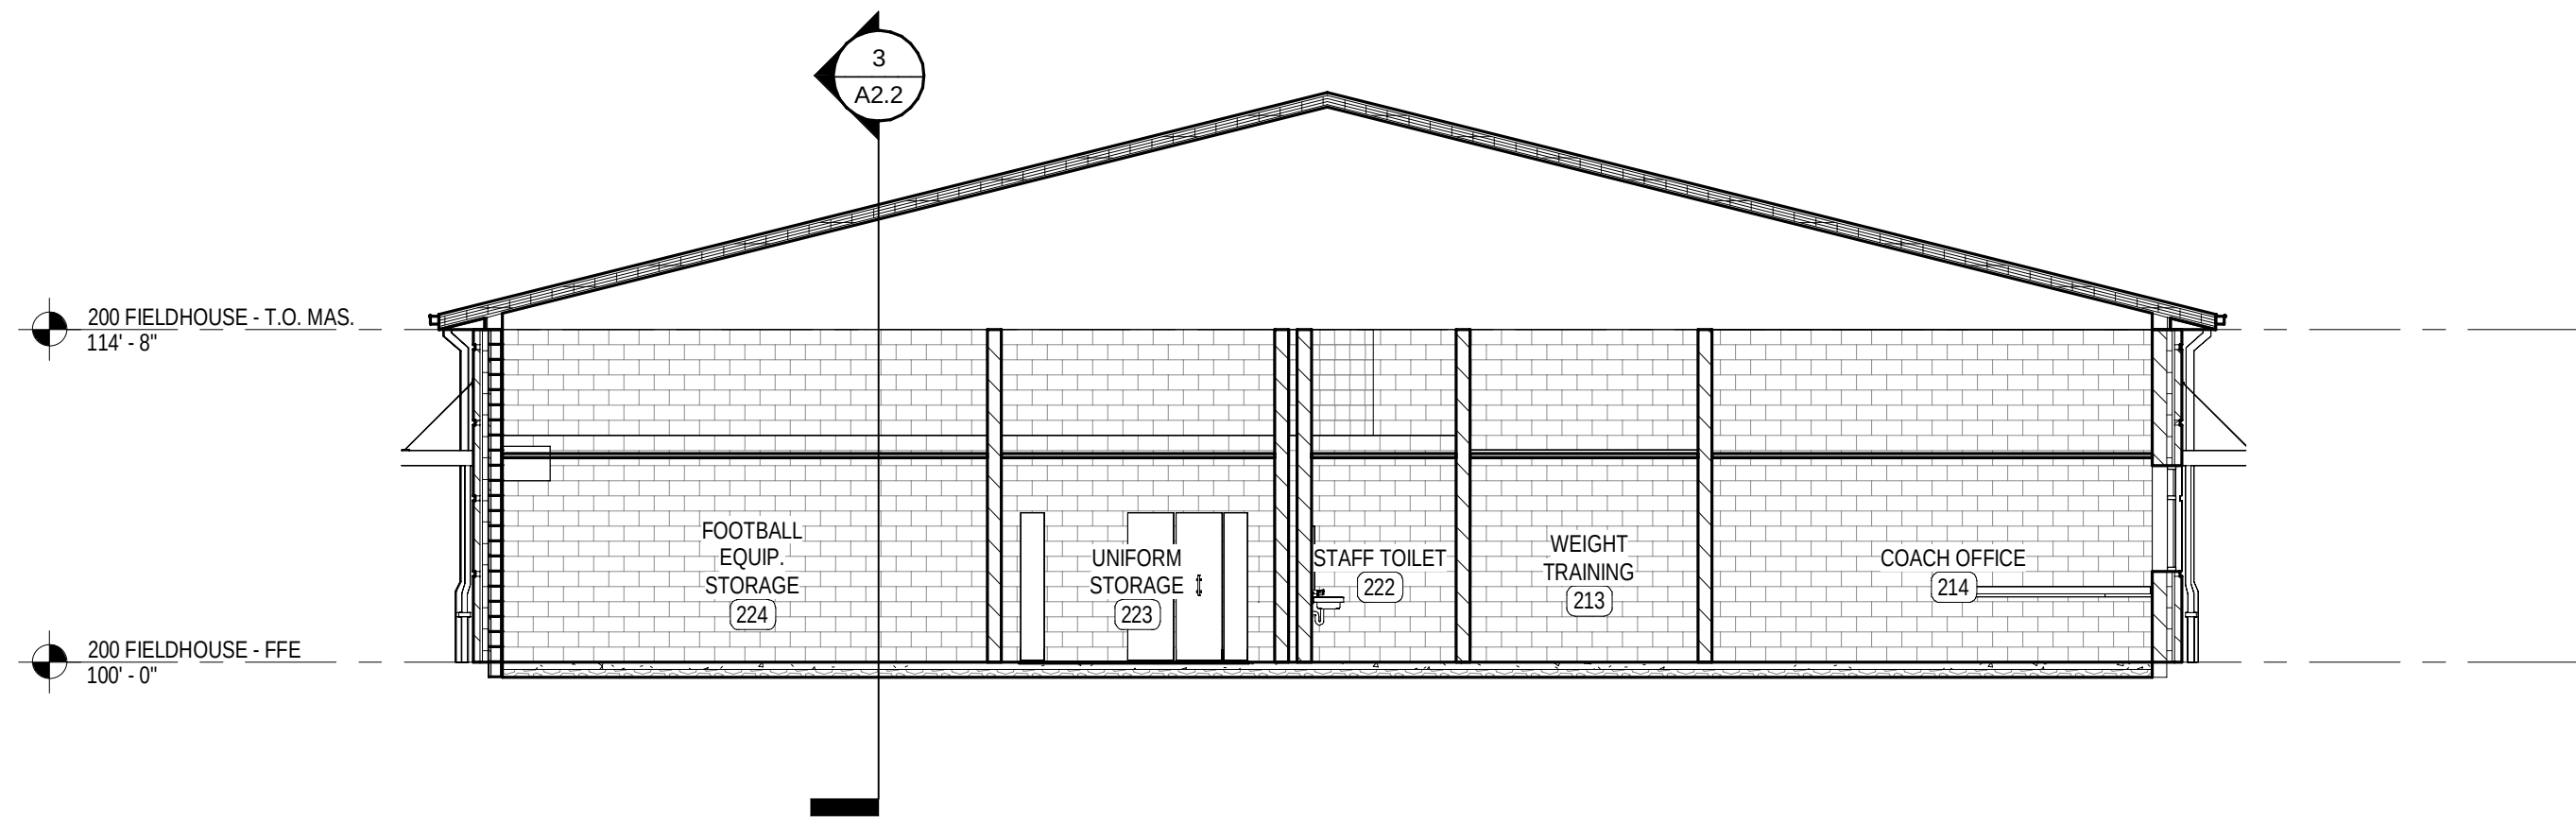

2 200 - BUILDING SECTION
1/8" = 1'-0"

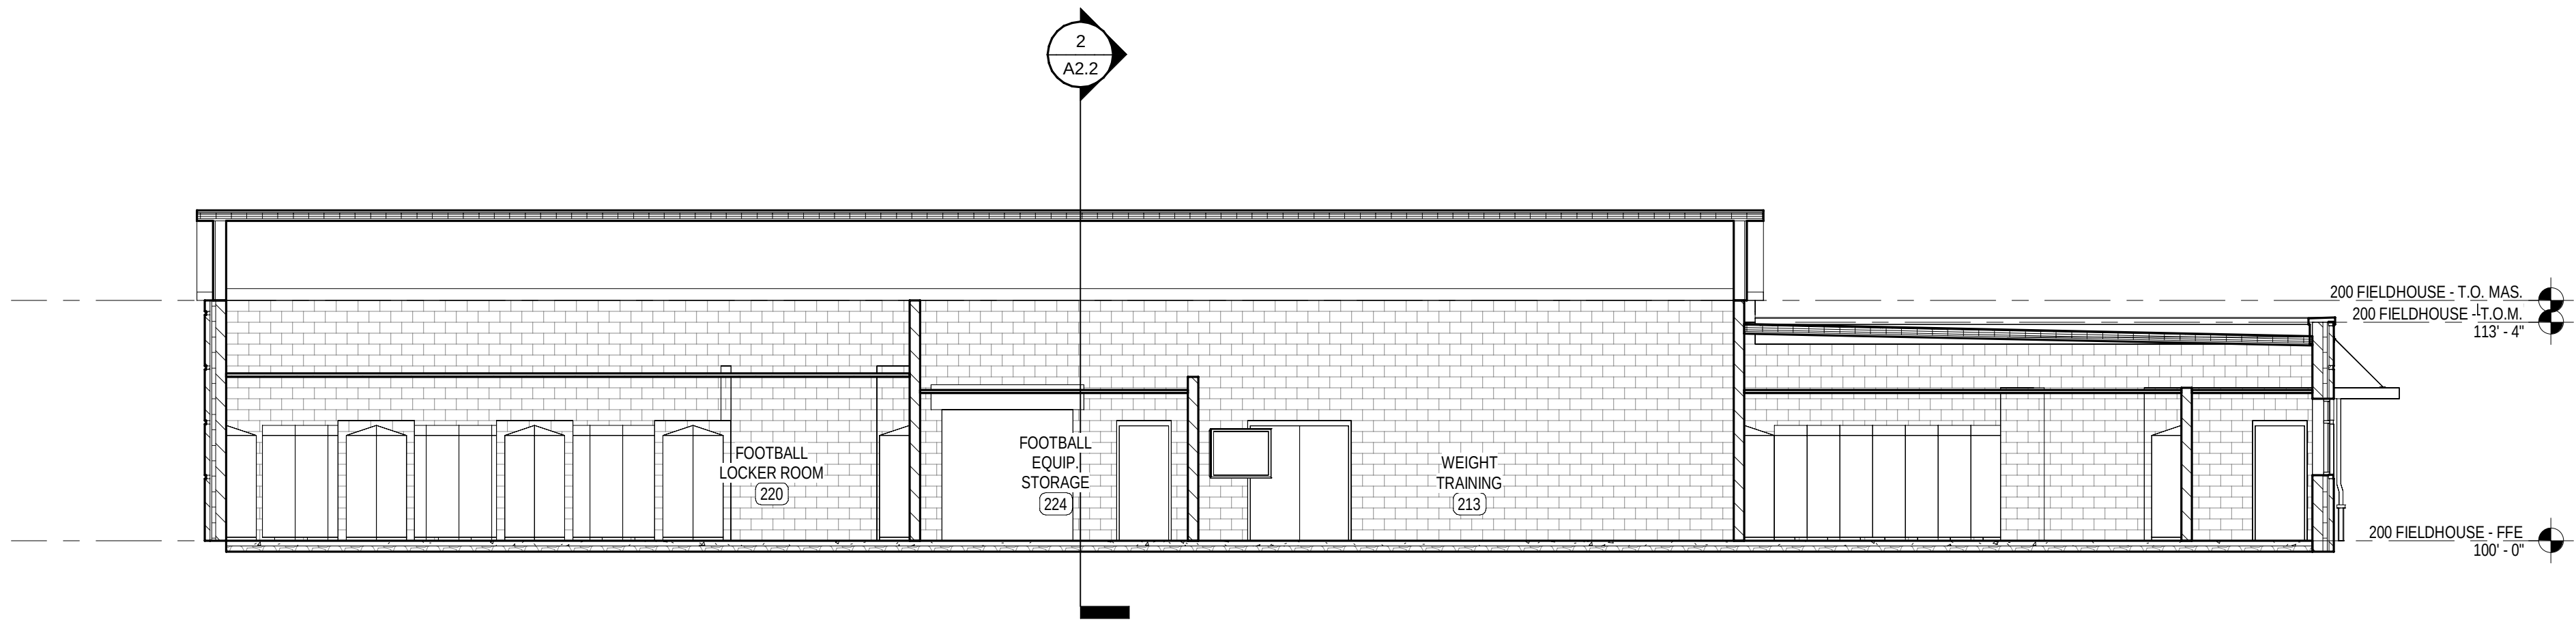

3 200 - BUILDING SECTION
1/8" = 1'-0"

1

ROOF KEYNOTES

1.

ROOF TYPE 'A' REFER TO ROOF LEGEND.

2.

ROOF TYPE 'B' REFER TO ROOF LEGEND.

3.

PRE-FIN METAL COPING, REFER TO TYP. DETAIL 1/A0.2.

4.

PRE-FIN METAL SCUPPER AND DOWNSPOUT, REFER TO DETAILS 2, 3, AND 4/A0.2.

5.

PRE-MANUFACTURED WALKWAY COVER, REFER TO DETAIL 11/A0.2.

6.

PRE-MANUFACTURED WALL SUPPORTED ALUMINUM CANOPY WITH INTEGRAL DOWNSPOUT 8'-0" x 5'-0" U.N.D. REFER TO DETAILS 12 AND 13/A0.2.

7.

MASONRY PIER WITH CAST STONE CAP, REFER TO DETAIL ____.

8.

ROOF EXPANSION JOINT, REFER TO DETAIL ____.

9.

ROOF EXPANSION JOINT AT 2HR FIRE WALL, REFER TO DETAIL ____.

10.

ROOF HATCH, REFER TO DETAIL 11/A0.3.

11.

WALKWAY PADS, REFER TO SPECIFICATIONS.

12.

CRICKET, TAPER INSULATION 1/4" PER FT. FOR POSITIVE DRAINAGE TO SCUPPER.

13.

CRICKET FOR POSITIVE DRAINAGE AROUND ROOF CURB.

14.

HVAC UNIT, REFER TO MECHANICAL. SEE 1/A0.2 FOR MECH CURB DETAIL.

15.

PEMB RIDGE CAP.

16.

PEMB GUTTER ASSEMBLY.

17.

PEMB RAKE TRIM ASSEMBLY.

18.

PEMB DOWNSPOUT. SEE ELEVATIONS.

19.

ROOF TYPE 'C' REFER TO ROOF LEGEND.

20.

ROOF TYPE 'D' REFER TO ROOF LEGEND.

21.

PRE-FIN METAL, VENTED RIDGE CAP.

22.

PRE-FIN METAL, RAKE TRIM.

23.

PRE-FIN METAL GUTTER.

24.

PRE-FIN METAL DOWNSPOUT.

25.

SNOW GUARD.

GENERAL ROOF NOTES

1.

ROOF SLOPES ARE 1/4" / 12" UNLESS NOTED OTHERWISE.

2.

ALL FLASHING WORK SHALL BE DONE SUCH THAT A WATERTIGHT INSTALLATION IS ACHIEVED AND MAINTAINED.

3.

REFER TO STRUCTURAL DWGS. FOR SPECIFIC STRUCTURAL ELEVATION.

4.

REFER TO MPE DWGS. FOR ROOF TOP ITEMS NOT SHOWN IN THIS PLAN.

5.

FLASH ALL ROOF PENETRATIONS PER MANUFACTURER'S STANDARD DETAILS.

6.

REFER TO TYPICAL ROOF DETAILS, SHEET A0.2.

7.

CONTRACTOR SHALL NOT COVER ANY WEEPS, BRICK VENTS, EXPANSION JOINTS, FLASHING, OR COPING. ROOFING SHALL TERMINATE AS SHOWN ON DETAILS.

8.

CONTRACTOR TO COORDINATE INSTALLATION OF ROOFING/ FLASHING WITH OTHER TRADES FOR ADDITIONAL WORK REQ'D. (I.E. FLASHING OF EQUIPMENT CURBS.)

9.

INSTALL ROOF FLASHING TO EXTEND UP FULL HEIGHT OF PARAPET WALLS AND OVER NAILERS UNDER COPING UNLESS NOTED OTHERWISE.

ROOF SYMBOLS LEGEND

ROOF ASSEMBLY - TYPE 'A'

THERMOPLASTIC POLYOLEFIN SINGLE PLY MEMBRANE ROOFING OVER 7/16" COVER DECK OVER (4) LAYERS OF 1 1/2" RIGID POLYSTYRORENE INSULATION STAGGERED (8" THICKNESS) ON METAL DECK. PROVIDE FINISHED 1/4" SLOPE PER 1'-0".

ROOF ASSEMBLY - TYPE 'B'

PEMB METAL ROOF OVER METAL PURLINS, WITH R-5 THERMAL BLOCKS, 8" LOWER LAYER FIBERGLASS BATT INSULATION AND 3" UPPER LAYER FIBERGLASS BATT INSULATION WITH A TOTAL PRE-INSTALLED R-VALUE OF 35. SUSPEND WITH STEEL STRAP AND FABRIC SYSTEM. SLOPE 3/12.

ROOF ASSEMBLY - TYPE 'C'

STANDING SEAM METAL ROOF SYSTEM OVER SINGLE LAYER OF CONTINUOUS ICE & WATER SHIELD ON SPECIFIED ROOF DECKING OVER LIGHT GA. METAL TRUSSES.

ROOF ASSEMBLY - TYPE 'D'

STANDING SEAM METAL ROOF SYSTEM OVER SINGLE LAYER OF CONTINUOUS ICE & WATER SHIELD ON SPECIFIED PLYWOOD SHEATHING OVER WD. RAFTERS.

--- --

INDICATES 2HR FIRE WALL. SEE PLAN A1.1.

INDICATES CRICKET, SLOPE 1/4" PER FOOT IN DIRECTION OF ARROW

APPROXIMATE AREA OF ROOF REPAIR, TO BE INVESTIGATED AND REPAIRED BY CONTRACTOR

■ DS

DOWNSPOUT.

SC

SCUPPER AND CONDUCTOR HEAD.

EDS

EXISTING DOWNSPOUT.

RD

ROOF DRAIN, REFER TO DETAIL 1/A4.2.

ORD

OVERFLOW ROOF DRAIN, REFER TO DETAIL 1/A4.2.

VTR

VENT THRU ROOF, REFER TO DETAIL 2/A4.2.

RTU

ROOF TOP UNIT, REFER TO MECHANICAL DWGS. AND CURB DETAIL 3/A4.2.

EXHAUST FAN / OA HOOD, REFER TO MECH. DWGS.

KEY PLAN

ATHLETIC COMPLEX (800)

AUX GYM ADD. (100)

SOCCER (700)

FIELD HOUSE (200)

BASEBALL (400)


CONCESSIONS (300)

SOFTBALL (500)

TRACK AND FIELD (600)

BUILDING NORTH

TRUE NORTH

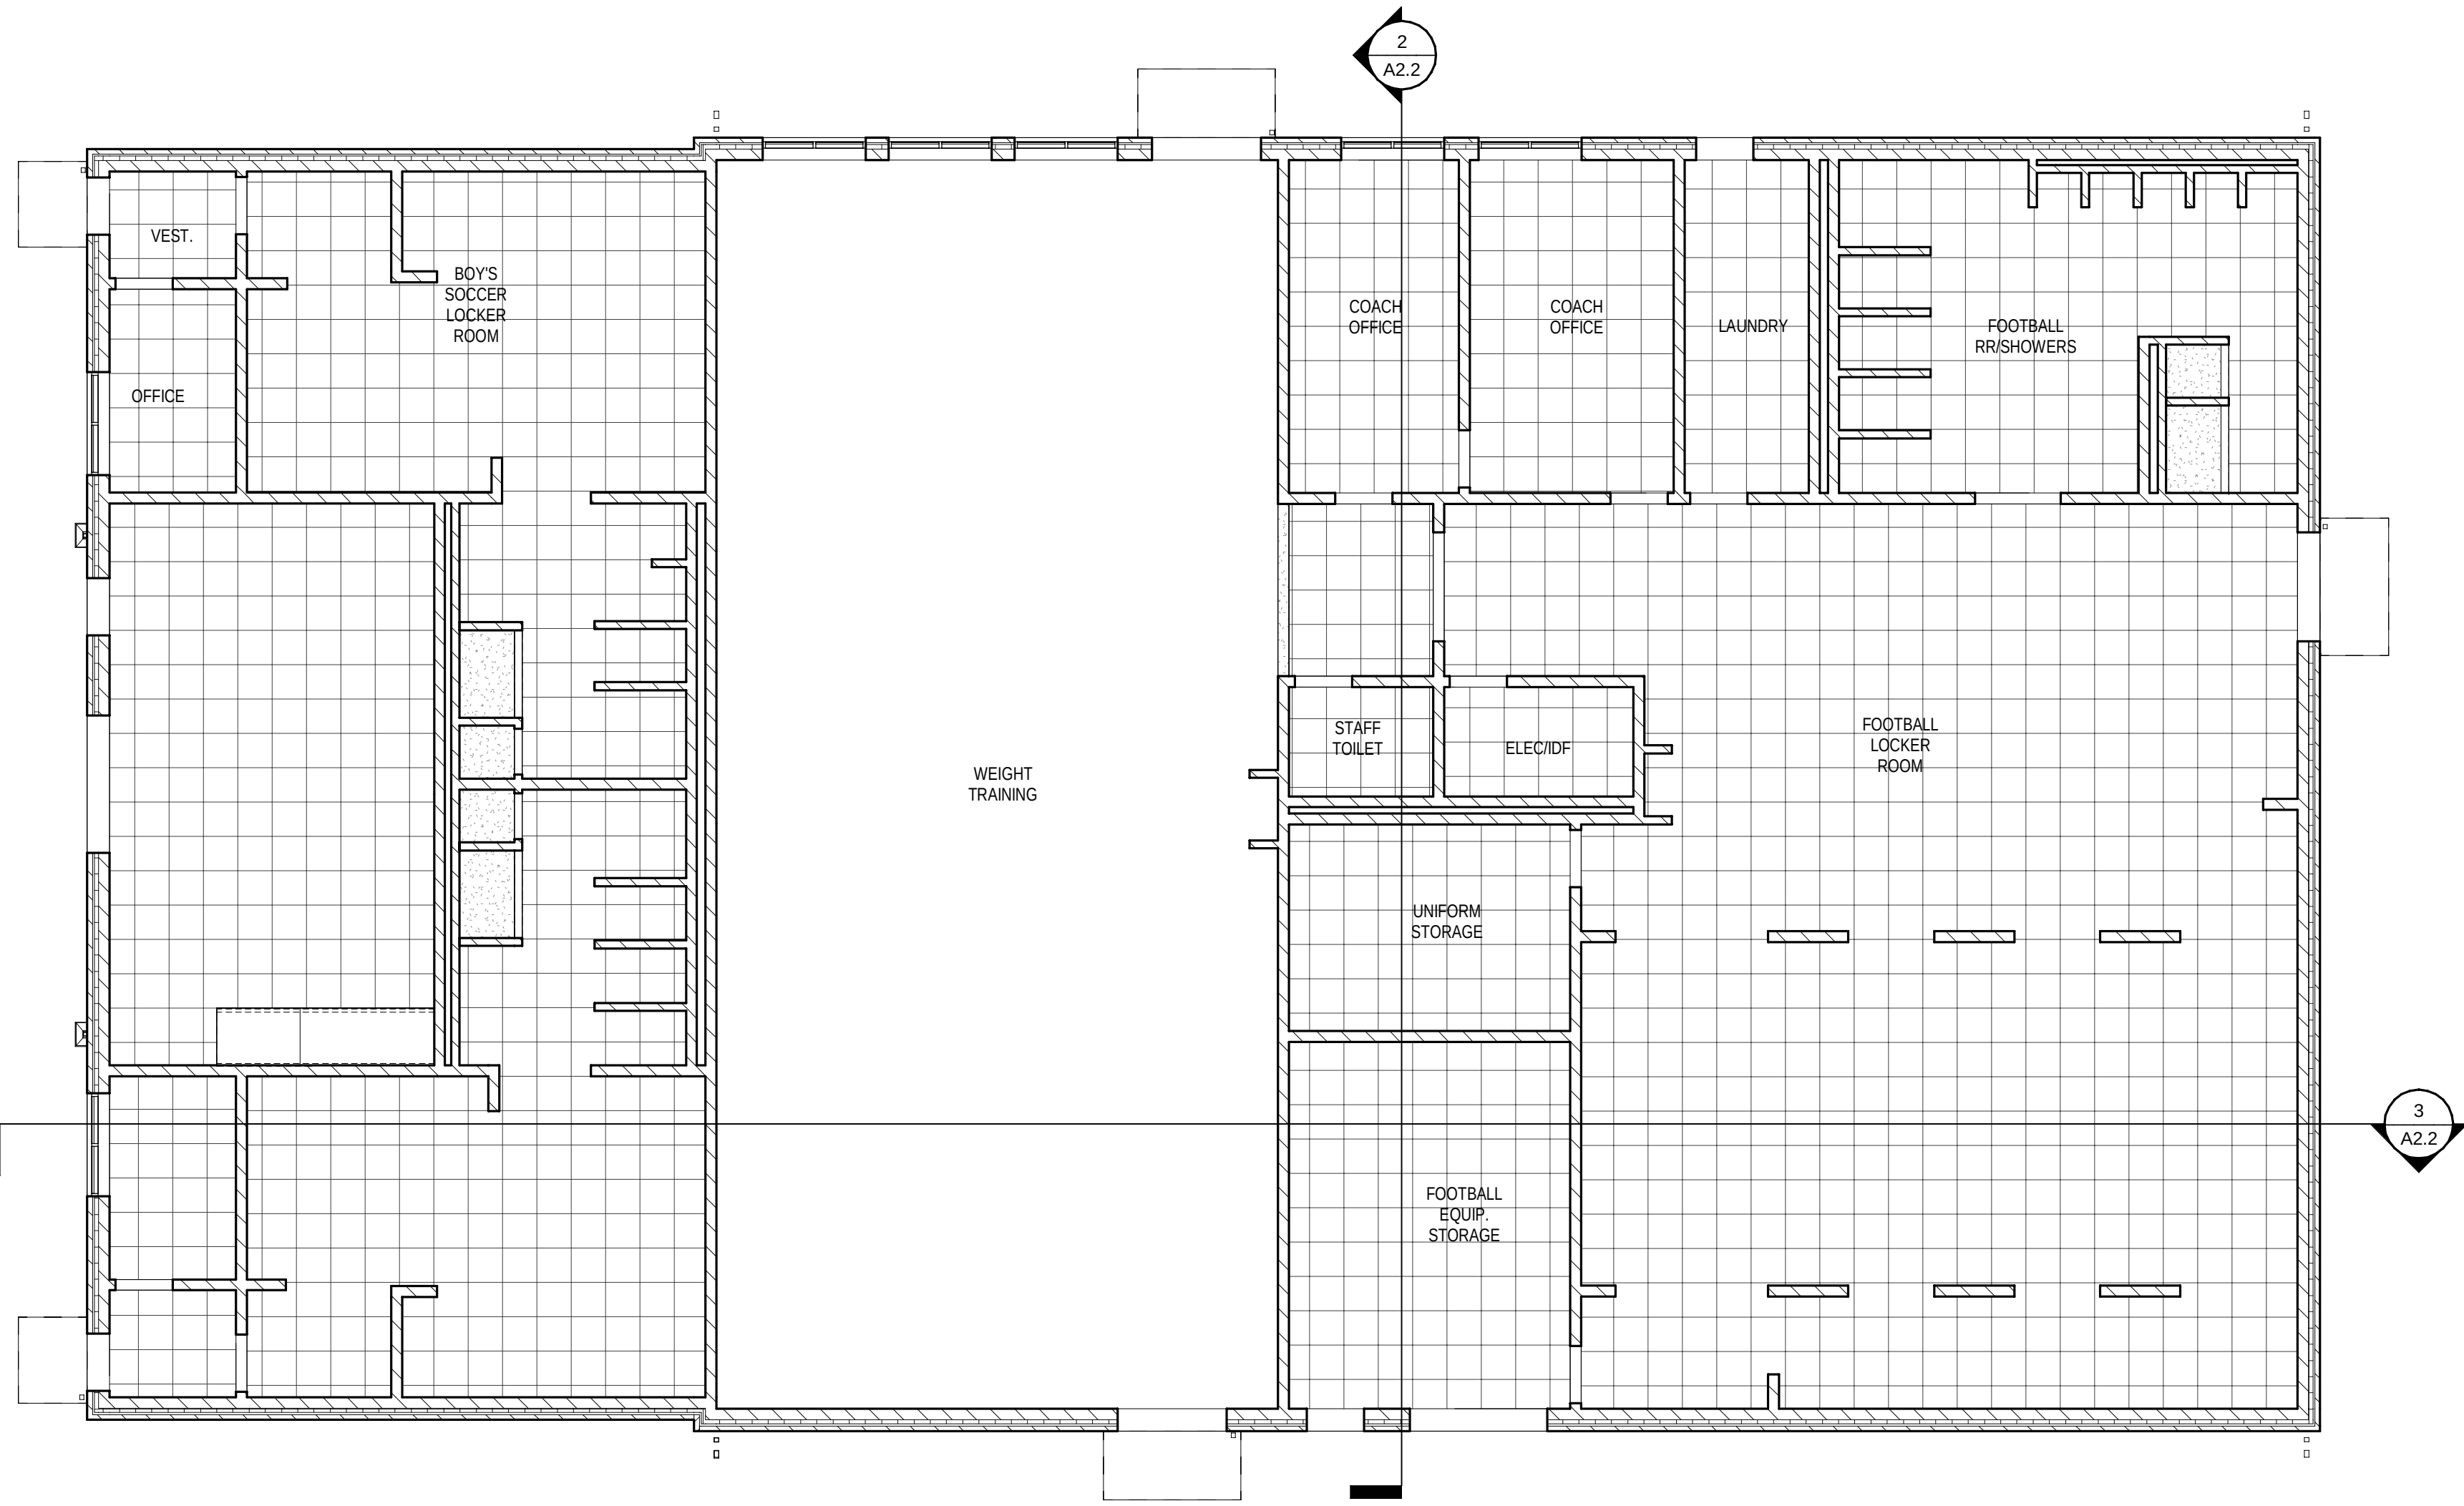

1 200 - REFLECTED CEILING PLAN
1/8" = 1'-0"

RCP KEYNOTES

NOTE: ALL NOTES MAY NOT APPLY TO THIS SHEET.

- METAL SOFFIT AT EXTERIOR. REFER TO DETAILS.
- OPEN TO STRUCTURE. PAINT STRUCTURE & STEEL DECK. PAINT ALL EXPOSED, NON PRE-FINISHED MEP ITEMS.
- EXPOSED STRUCTURE AND DECK, NO FINISH.
- METAL PANEL CONTROL JOINT, PAINT. EXTEND JOINT UP VERTICAL SIDES OF SOFFIT.
- ROOF HATCH.
- ALUMINUM COMPOSITE PANEL CEILING.
- ALIGN EDGE OF NEW GYP BD. SOFFIT WITH ADJACENT WALL.
- 4'-0" HIGH ACOUSTICAL WALL PANELS BOTTOM OF PANEL @ 18'-0" AFF.
- INTERIOR GYP. BD. SOFFIT. PAINT. REFER TO DETAIL 31A7.7.
- INTERIOR GYP. BD. BULKHEAD. PAINT. REFER TO DETAIL 31A7.7.

RCP GENERAL NOTES

R1 = KEYNOTES (WHERE APPLICABLE)

R2 CEILING RELATED MECHANICAL AND ELECTRICAL ITEMS ARE NOT SHOWN ON REFLECTED CEILING PLANS. SEE MECHANICAL AND/OR ELECTRICAL DRAWINGS FOR TYPE, SIZE, AND OTHER REQUIREMENTS PERTAINING SPECIFICALLY TO THESE ITEMS - EPOXY PAINT ALL EXPOSED, NON PRE-FINISHED MEP ITEMS.

R3 REFER TO PLUMBING, MECHANICAL AND ELECTRICAL DRAWINGS FOR ADDITIONAL FIXTURES NOT SHOWN.

R4 REFER TO WALL TYPES FOR DESCRIPTION OF WALLS EXTENDING (OR NOT) TO UNDERSIDE OF DECKING AND/OR STRUCTURE ABOVE.

R5 INSTALL SPRINKLER HEADS IN CENTER OF 2x2 CEILING PANELS.

R6 INSTALL ALL SPRINKLER HEADS ON SWING ARM NIPPLES. REFER TO MECHANICAL DRAWINGS FOR SPECIFIC REQUIREMENTS.

R7 SOFFIT DIMENSIONS SHOWN ARE FROM FACE OF WALL OR FACE OF GYPSUM BOARD TO FACE OF GYPSUM BOARD.

R8 REFER TO DOOR, FRAME DETAILS AND STRUCTURAL DRAWINGS FOR SPECIFIC LINTEL LOCATIONS. PAINT EXPOSED STEEL LINTELS (GALV. AT EXTERIOR LOCATIONS)

R9 UNLESS SPECIFICALLY LOCATED, GYPSUM BOARD CONTROL JOINTS AS REQUIRED BY INDUSTRY STANDARDS OR SPECS. WHICHEVER IS MORE RESTRICTIVE. CONFIRM LOCATIONS WITH ARCHITECT.

R10 ALL CEILINGS SHALL BE ACT TYPE A, U.N.O.

REFLECTED CEILING LEGEND

X' - X'	CEILING HEIGHT, A.F.F. NOTE: REFER TO SECTIONS AND DETAILS FOR EXTERIOR CEILING HEIGHTS NOT SHOWN.
	2x2' SUSPENDED ACOUSTICAL CEILING (ACT-A) @ 9' - 0" A.F.F. U.N.O., REFER TO SPECS.
	2x2' SUSPENDED ACOUSTICAL CEILING (ACT-B) @ 9' - 0" A.F.F. U.N.O., REFER TO SPECS.
	GYPSUM BOARD SOFFIT OR BULKHEAD @ 8' - 8" A.F.F. U.N.O., PAINT.
	LINEAR METAL CEILING.
	EXISTING BUILDING TO REMAIN.
	PAINTED, 5/8" EXTERIOR GRADE PLYWOOD
	NO CEILING. DECK / STRUCTURE ABOVE TO BE PAINTED.

KEY PLAN

JOB NO.

2459

DATE

12/15/2025

DRAWN

CAH

CHECKED

RJV, ASC

COPYRIGHT © 2025
SHERMAN CARTER BARNHART
ARCHITECTS, PLLC

REVISIONS

No.	Description	Date

SHEET

A2.3

SHERMAN
CARTER
BARNHART
ARCHITECTS

DD SET
- NOT FOR -
CONSTRUCTION

ALLEN COUNTY - SCOTTSVILLE
HIGH SCHOOL ATHLETIC
COMPLEX
SCOTTSVILLE, KENTUCKY

FIELD HOUSE REFLECTED CEILING
PLAN

JOB NO.

2459

DATE

12/15/2025

DRAWN

CAH

CHECKED

RJV, ASC


COPYRIGHT © 2025
SHERMAN CARTER BARNHART
ARCHITECTS, PLLC

REVISIONS


No.	Description	Date

SHEET


A2.3

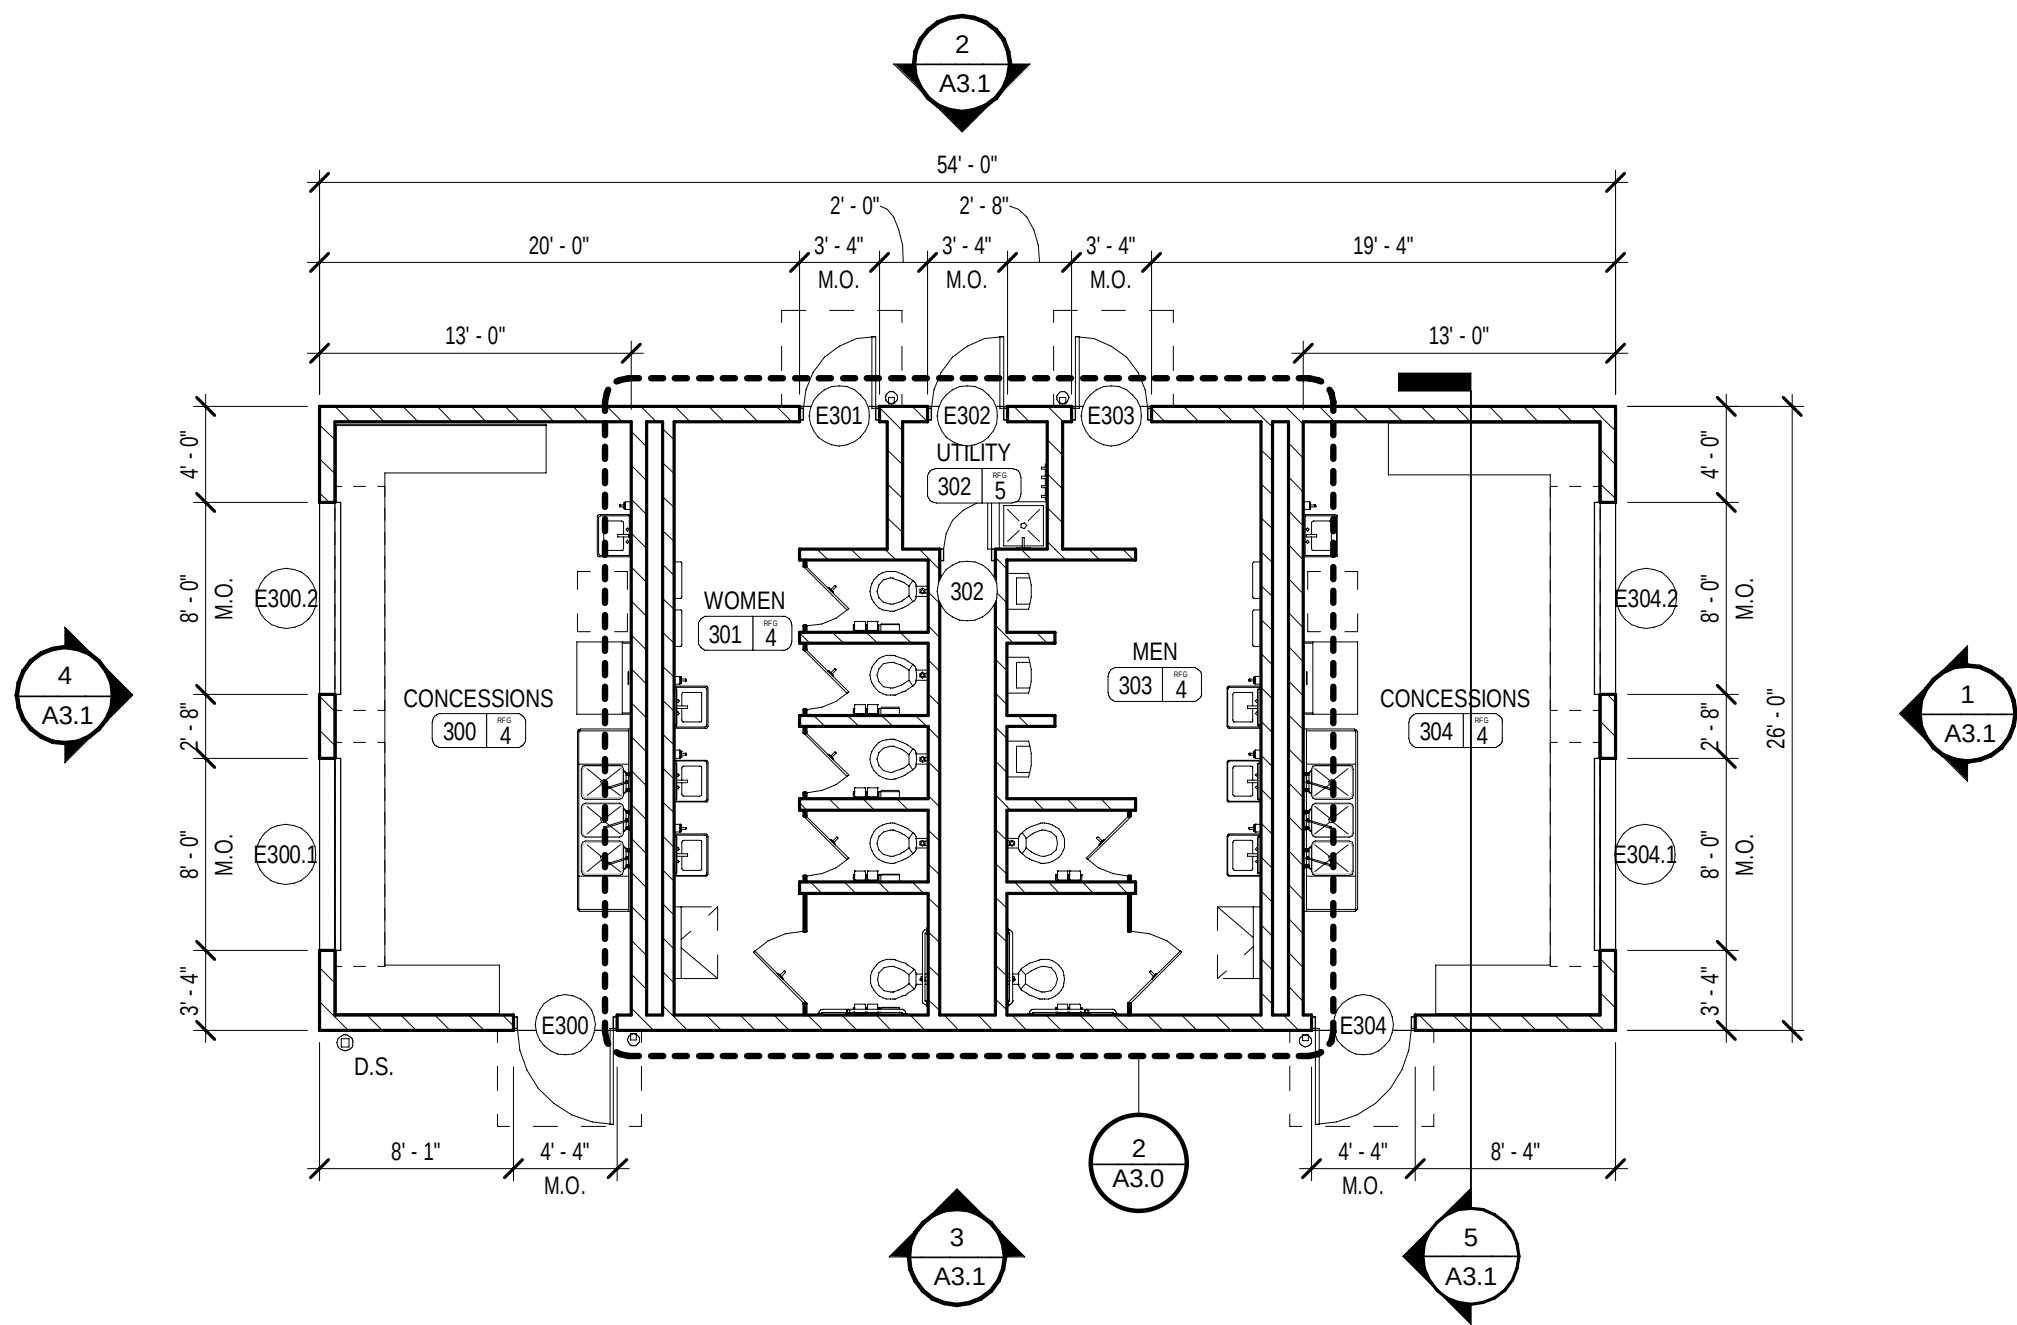


1 300 - FIRST FLOOR NEW WORK PLAN
1/8" = 1'-0"

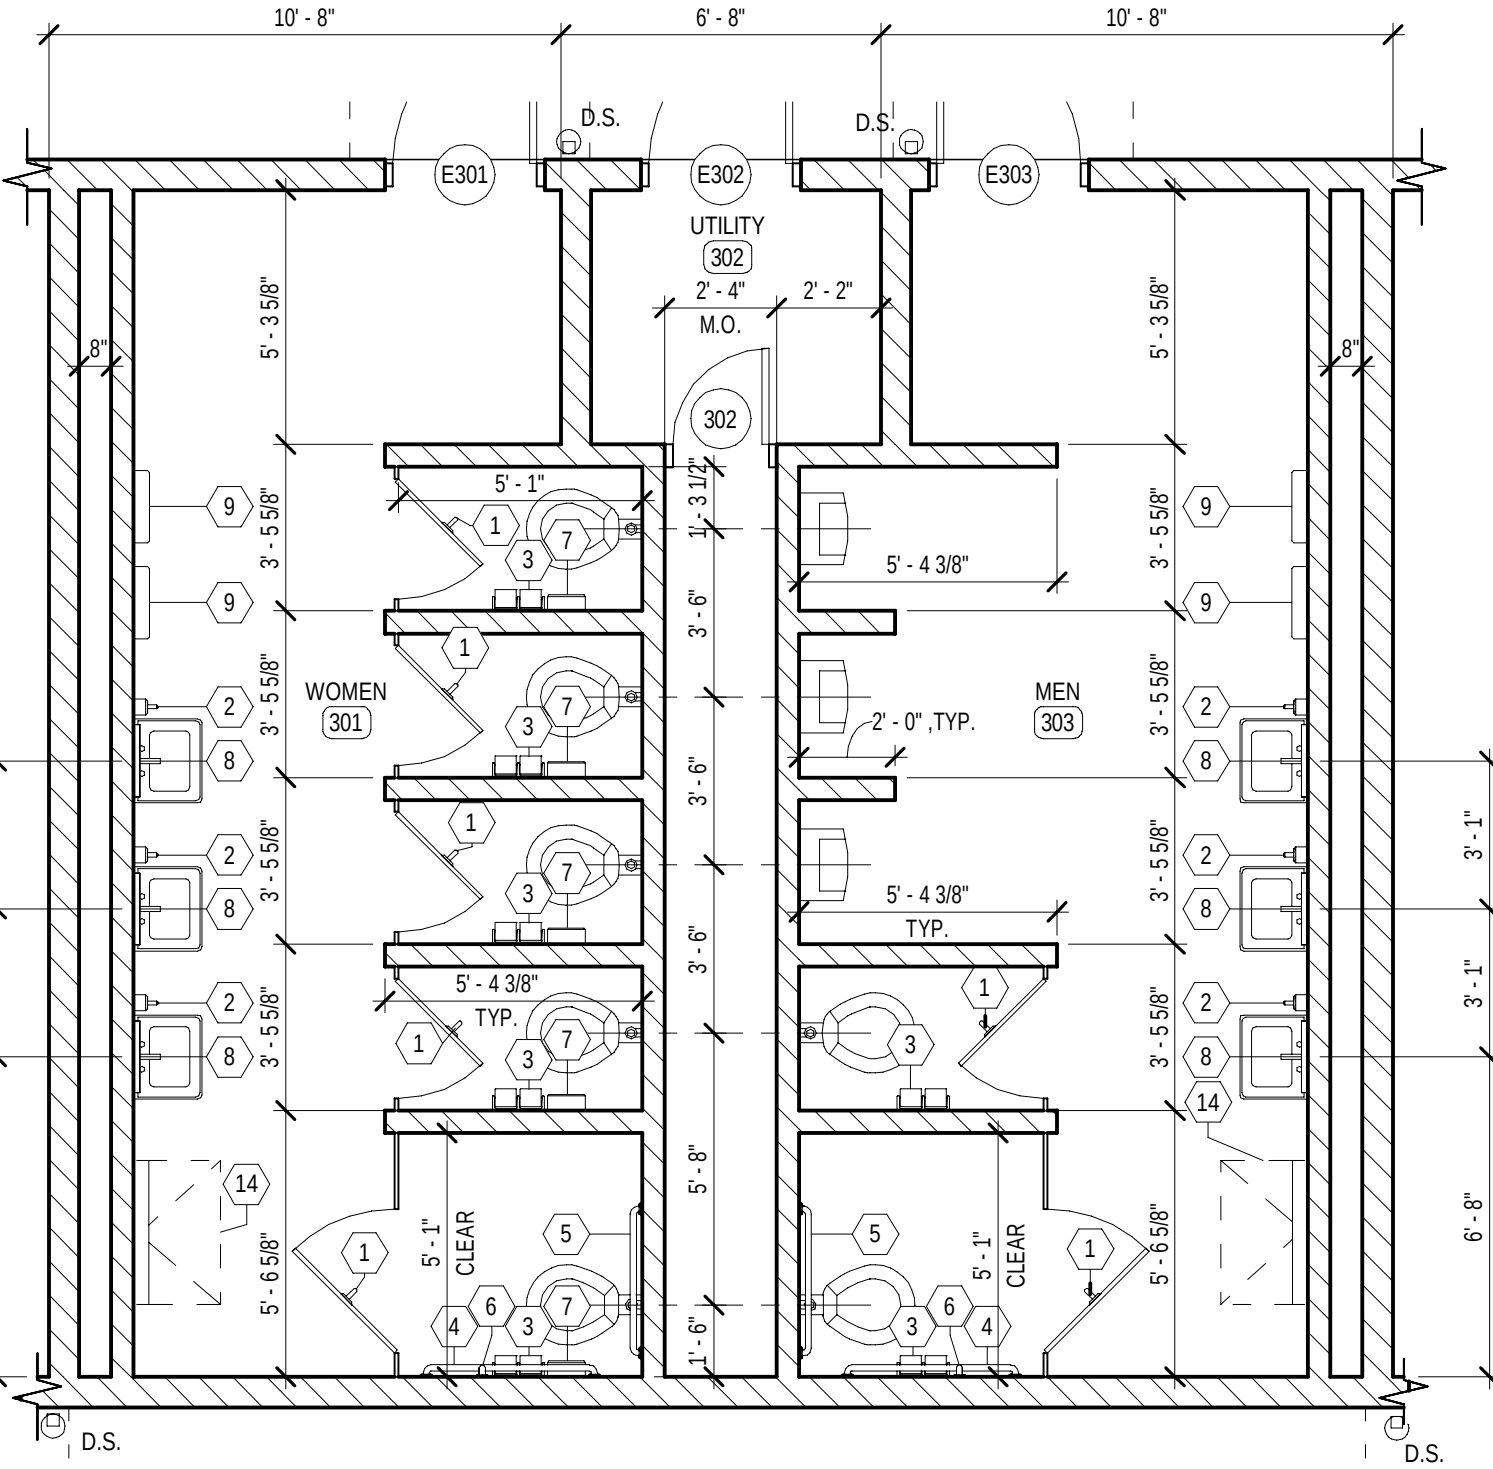

2 300 - ENLARGED RESTROOM PLAN
1/4" = 1'-0"

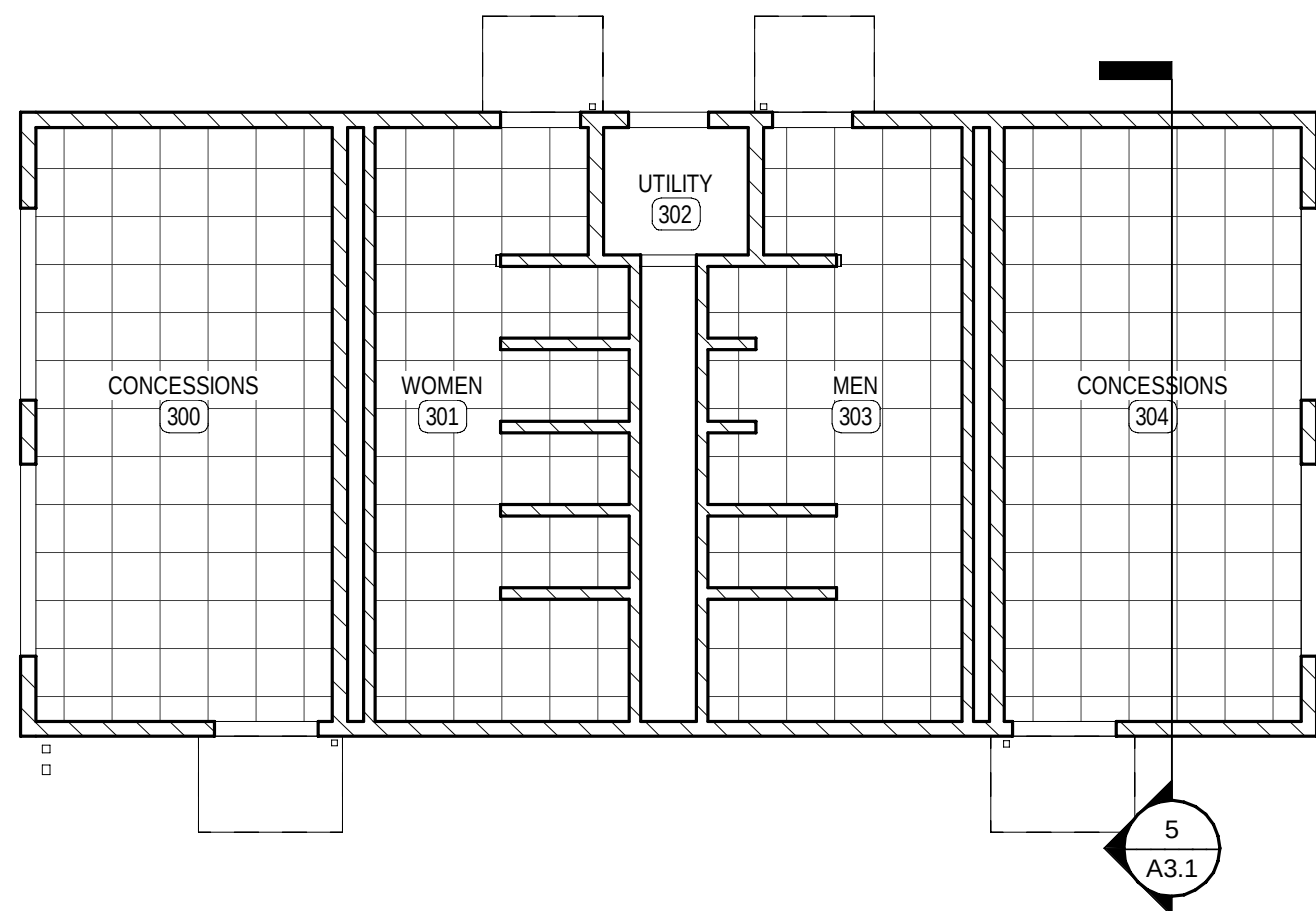

3 300 - REFLECTED CEILING PLAN
1/8" = 1'-0"

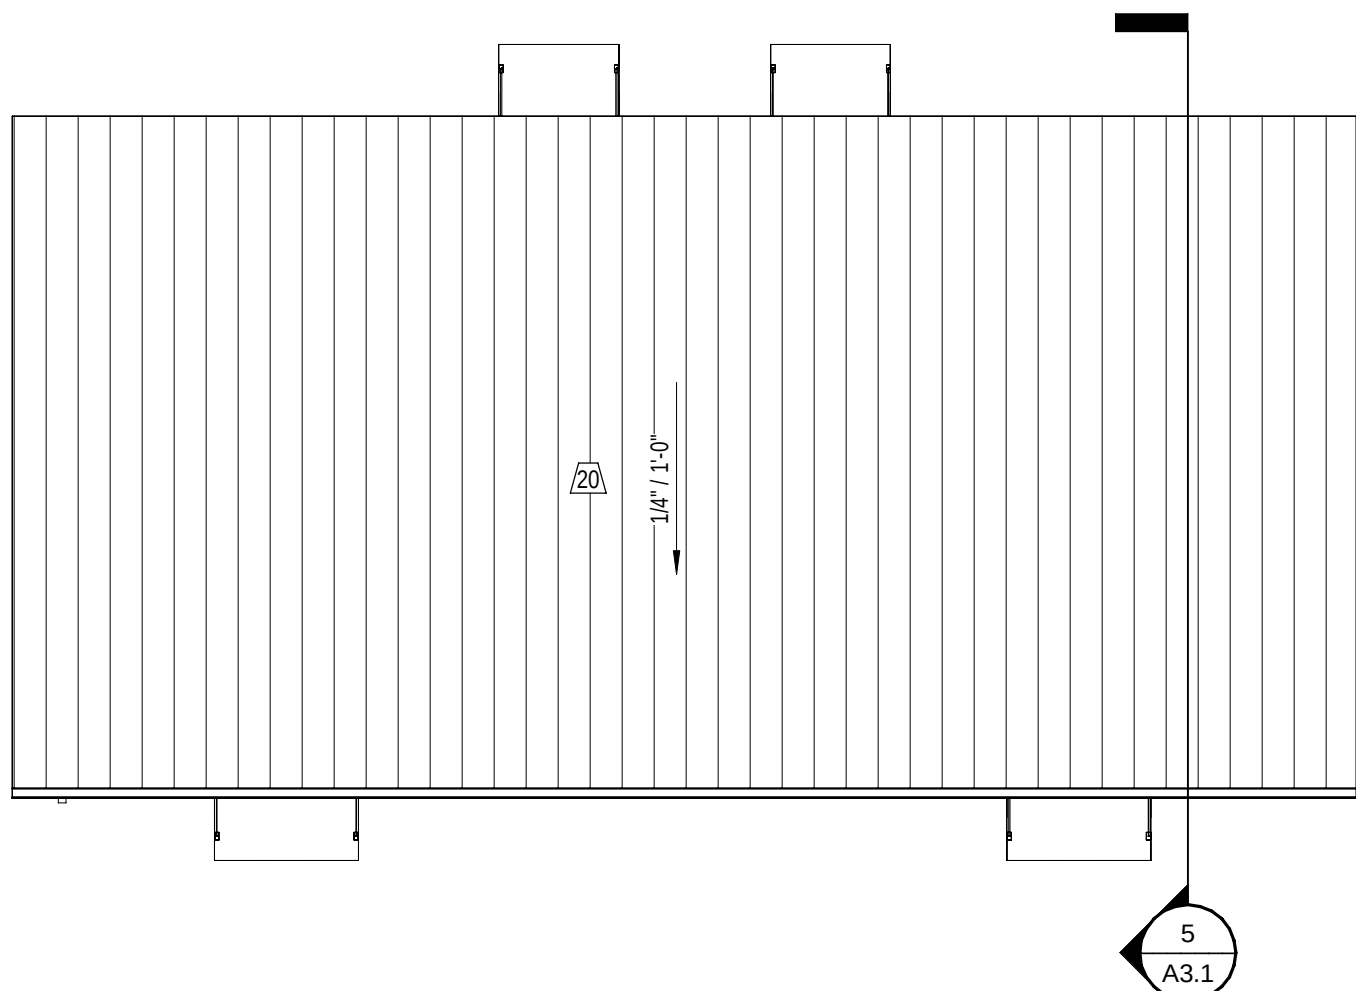

4 300 - ROOF PLAN
1/8" = 1'-0"

RCP KEYNOTES

NOTE: ALL NOTES MAY NOT APPLY TO THIS SHEET.

- METAL SOFFIT AT EXTERIOR. REFER TO DETAILS.
- OPEN TO STRUCTURE, PAINT STRUCTURE & STEEL DECK. PAINT ALL EXPOSED, NON PRE-FINISHED MEP ITEMS.
- EXPOSED STRUCTURE AND DECK, NO FINISH.
- METAL PANEL CONTROL JOINT, PAINT. EXTEND JOINT UP VERTICAL SIDES OF SOFFIT.
- ROOF HATCH.
- ALUMINUM COMPOSITE PANEL CEILING.
- ALIGN EDGE OF NEW GYP BD. SOFFIT WITH ADJACENT WALL.
- 4'-0" HIGH ACOUSTICAL WALL PANELS BOTTOM OF PANEL @ 16'-0" AFF.
- INTERIOR GYP. BD. SOFFIT, PAINT. REFER TO DETAIL 3147.7.
- INTERIOR GYP. BD. BULKHEAD, PAINT. REFER TO DETAIL 3147.7.

RCP GENERAL NOTES

- R1 = KEYNOTES (WHERE APPLICABLE)
- R2 CEILING RELATED MECHANICAL AND ELECTRICAL ITEMS ARE NOT SHOWN ON REFLECTED CEILING PLANS. SEE MECHANICAL AND/OR ELECTRICAL DRAWINGS FOR TYPE, SIZE, AND OTHER REQUIREMENTS PERTAINING SPECIFICALLY TO THESE ITEMS. -- EPOXY PAINT ALL EXPOSED, NON PRE-FINISHED MEP ITEMS.
- R3 REFER TO PLUMBING, MECHANICAL AND ELECTRICAL DRAWINGS FOR ADDITIONAL FIXTURES NOT SHOWN.
- R4 REFER TO WALL TYPES FOR DESCRIPTION OF WALLS EXTENDING (OR NOT) TO UNDERSIDE OF DECKING AND/OR STRUCTURE ABOVE.
- R5 INSTALL SPRINKLER HEADS IN CENTER OF 2x2 CEILING PANELS.
- R6 INSTALL ALL SPRINKLER HEADS ON SWING ARM NIPPLES. REFER TO MECHANICAL DRAWINGS FOR SPECIFIC REQUIREMENTS.
- R7 SOFFIT DIMENSIONS SHOWN ARE FROM FACE OF WALL OR FACE OF GYPSUM BOARD TO FACE OF GYPSUM BOARD.
- R8 REFER TO DOOR, FRAME DETAILS AND STRUCTURAL DRAWINGS FOR SPECIFIC LINTEL LOCATIONS. PAINT EXPOSED STEEL LINTELS (GALV. AT EXTERIOR LOCATIONS)
- R9 UNLESS SPECIFICALLY LOCATED, GYPSUM BOARD CONTROL JOINTS AS REQUIRED BY INDUSTRY STANDARDS OR SPECS. WHICHEVER IS MORE RESTRICTIVE. CONFIRM LOCATIONS WITH ARCHITECT.
- R10 ALL CEILINGS SHALL BE ACT TYPE A, U.N.O.

REFLECTED CEILING LEGEND

- X' - X' CEILING HEIGHT, A.F.F.
NOTE: REFER TO SECTIONS AND DETAILS FOR EXTERIOR CEILING HEIGHTS NOT SHOWN.
- 2'x2' SUSPENDED ACOUSTICAL CEILING (ACT-A) @ 9'-0" A.F.F. U.N.O., REFER TO SPECS.
- 2'x2' SUSPENDED ACOUSTICAL CEILING (ACT-B) @ 9'-0" A.F.F. U.N.O., REFER TO SPECS.
- GYPSUM BOARD SOFFIT OR BULKHEAD @ 8'-8" A.F.F. U.N.O., PAINT.
- LINEAR METAL CEILING.
- EXISTING BUILDING TO REMAIN.
-

ROOF KEYNOTES

- ROOF TYPE 'A' REFER TO ROOF LEGEND.
- ROOF TYPE 'B' REFER TO ROOF LEGEND.
- PRE-FIN METAL COPING. REFER TO TYP. DETAIL 11A0.2.
- PRE-FIN METAL SCUPPER AND DOWNSPOUT, REFER TO DETAILS 2, 3, AND 4A0.2.
- PRE-MANUFACTURED WALKWAY COVER, REFER TO DETAIL 11A0.2.
- PRE-MANUFACTURED WALL SUPPORTED ALUMINUM CANOPY WITH INTEGRAL DOWNSPOUT 8'-0" x 5'-0" U.N.O. REFER TO DETAILS 12 AND 13A0.2.
- MASONRY PIER WITH CAST STONE CAP. REFER TO DETAIL ____.
- ROOF EXPANSION JOINT. REFER TO DETAIL ____.
- ROOF EXPANSION JOINT AT 2HR FIRE WALL. REFER TO DETAIL ____.
- ROOF HATCH. REFER TO DETAIL 11A0.3.
- WALKWAY PADS. REFER TO SPECIFICATIONS.
- CRICKET. TAPER INSULATION 1/4" PER FT. FOR POSITIVE DRAINAGE TO SCUPPER.
- CRICKET FOR POSITIVE DRAINAGE AROUND ROOF CURB.
- HVAC UNIT. REFER TO MECHANICAL. SEE 11A0.2 FOR MECH CURB DETAIL.
- PEMB RIDGE CAP.
- PEMB GUTTER ASSEMBLY.
- PEMB RAKE TRIM ASSEMBLY.
- PEMB DOWNSPOUT. SEE ELEVATIONS.
- ROOF TYPE 'C' REFER TO ROOF LEGEND.
- ROOF TYPE 'D' REFER TO ROOF LEGEND.
- PRE-FIN METAL VENTED RIDGE CAP.
- PRE-FIN METAL RAKE TRIM.
- PRE-FIN METAL GUTTER.
- PRE-FIN METAL DOWNSPOUT.
- SNOW GUARD.

GENERAL ROOF NOTES

- ROOF SLOPES ARE 1/4" / 12" UNLESS NOTED OTHERWISE.
- ALL FLASHING WORK SHALL BE DONE SUCH THAT A WATERTIGHT INSTALLATION IS ACHIEVED AND MAINTAINED.
- REFER TO STRUCTURAL DWGS. FOR SPECIFIC STRUCTURAL ELEVATION.
- REFER TO MPE DWGS. FOR ROOF TOP ITEMS NOT SHOWN IN THIS PLAN.
- FLASH ALL ROOF PENETRATIONS PER MANUFACTURER'S STANDARD DETAILS.
- REFER TO TYPICAL ROOF DETAILS, SHEET A0.2.
- CONTRACTOR SHALL NOT COVER ANY WEEPS, BRICK VENTS, EXPANSION JOINTS, FLASHING, OR COPING. ROOFING SHALL TERMINATE AS SHOWN ON DETAILS.
- CONTRACTOR TO COORDINATE INSTALLATION OF ROOFING/ FLASHING WITH OTHER TRADES FOR ADDITIONAL WORK REQ'D. (I.E. FLASHING OF EQUIPMENT CURBS.)
- INSTALL ROOF FLASHING TO EXTEND UP FULL HEIGHT OF PARAPET WALLS AND OVER NAILERS UNDER COPING UNLESS NOTED OTHERWISE.

ROOF SYMBOLS LEGEND

- ROOF ASSEMBLY - TYPE 'A'
THERMOPLASTIC POLYOLEFIN SINGLE PLY MEMBRANE ROOFING OVER 7/16" COVER DECK OVER (4) LAYERS OF 1 1/2" RIGID POLYISOCYANURATE INSULATION STAGGERED (8" THICKNESS) ON METAL DECK. PROVIDE FINISHED 1/4" SLOPE PER 1'-0".
- ROOF ASSEMBLY - TYPE 'B'
METAL ROOF OVER METAL PURLINS, WITH R-5 THERMAL BLOCKS, 8" LOWER LAYER FIBERGLASS BATT INSULATION AND 3" UPPER LAYER FIBERGLASS BATT INSULATION WITH A TOTAL PRE-INSTALLED R-VALUE OF 35. SUSPEND WITH STEEL STRAP AND FABRIC SYSTEM. SLOPE 3:12.
- ROOF ASSEMBLY - TYPE 'C'
STANDING SEAM METAL ROOF SYSTEM OVER SINGLE LAYER OF CONTINUOUS ICE & WATER SHIELD ON SPECIFIED ROOF DECKING OVER LIGHT GA. METAL TRUSSES.
- ROOF ASSEMBLY - TYPE 'D'
STANDING SEAM METAL ROOF SYSTEM OVER SINGLE LAYER OF CONTINUOUS ICE & WATER SHIELD ON SPECIFIED PLYWOOD SHEATHING OVER WD. RAFTERS.
- INDICATES 2HR FIRE WALL, SEE PLAN A1.1.
- INDICATES CRICKET, SLOPE 1/4" PER FOOT IN DIRECTION OF ARROW
- APPROXIMATE AREA OF ROOF REPAIR, TO BE INVESTIGATED AND REPAIRED BY CONTRACTOR
- DS DOWNSPOUT.
- SC SCUPPER AND CONDUCTOR HEAD.
- EDS EXISTING DOWNSPOUT.
- RD ROOF DRAIN. REFER TO DETAIL 11A4.2.
- ORD OVERFLOW ROOF DRAIN. REFER TO DETAIL 11A4.2.
- VTR VENT THRU ROOF. REFER TO DETAIL 21A4.2.
- RTU ROOF TOP UNIT, REFER TO MECHANICAL DWGS. AND CURB DETAIL 31A4.2.
- EXHAUST FAN / OA HOOD. REFER TO MECH. DWGS.

FLOOR PLAN KEYNOTES

- OWNER PROVIDED FURNITURE OR EQUIPMENT (N.I.C.).
- LINE OF SOFFIT / BULKHEAD ABOVE, REFER TO REFLECTED CEILING PLAN.
- PRE-MFR, PRE-FIN SUSPENDED ALUMINUM CANOPY. REFER TO DETAIL 11A4.2.
- EXTERIOR CONCRETE WALK, REFER TO SITE DRAWINGS.
- HIGH / LOW ADA COMPLIANT WATER COOLER UNIT. REFER TO MECH. / ELEC. DRAWINGS.
- MOP SINK. REFER TO PLUMBING DRAWINGS.
- KNOX BOX RECESSED IN BRICK. REFER TO DOOR HARDWARE SPECIFICATIONS.
- FLOOR TRANSITION. REFER TO SHEET A8.1 FOR DETAILS.
- SHIPS LADDER. REFER TO DETAIL 11A0.3.
- DIVIDER CURTAIN, MOTORIZED OPERATOR, REFER TO ELEC. DWGS.
- 7'-0" TALL X 2" THICK WALL PAD WITH WOOD BACKING. ATTACH TO WALLS / COLUMNS WITH MANUFACTURER'S STANDARD "Z" CLIP SYSTEM.
- ELECTRIC PUSH-BUTTON ADA DOOR OPERATOR. REFER TO ELEC. DWGS.


GENERAL NOTES

- (OF-C) OWNER FURNISHED CONTRACTOR INSTALLED.
- EXISTING TO REMAIN INTERIOR WALLS THAT ARE EXPOSED IN AREAS OF RENOVATION TO BE CLEANED, REPAIRED, PRIMED, AND PAINTED FOR LIKE NEW FINISH.
- DO NOT SCALE DWGS. WRITTEN DIMENSIONS TAKE PRECEDENCE OVER SCALED DIMENSIONS.
- INTERIOR MASONRY CONTROL JOINTS TO OCCUR EVERY 20'-0" MAX.
- NOTE: MARKER BOARD (MB) AND TACK BOARD (TB) INDICATE WIDTH AND ARE TO BE 48" H.

SYMBOL LEGEND

- ROOM FINISH GROUPS (REFER TO KEY PLAN SHEETS)
- ROOM NUMBER
- DOOR NUMBER (DOOR SCHEDULE SHEET A8.1)
- KEY NOTES (SHEETS A1.3 THROUGH A2.8)
- WALL TYPE (SCHEDULE SHEET A0.1)
- ALUMINUM OR HOLLOW METAL WINDOW OR STOREFRONT TYPE (REFER TO FLOOR PLANS AND SCHEDULE SHEETS A8.2)
- TOILET ACCESSORIES (SCHEDULE SHEET A2.7)
- ELEVATION KEY NOTE (SHEETS A3.1)
- ROOF KEY NOTE (SHEET A4.1)
- CEILING PLAN KEY NOTE (SHEETS A7.1 THROUGH A7.7)
- SIGNAGE KEY NOTE (REFER TO KEY PLAN SHEETS)
- WALL / PARTITION DESIGNATION
- FW2 2 HOUR RATED FIRE WALL
- EPW2 EXISTING 2 HOUR RATED FIRE WALL
- MASONRY CONTROL JOINT FULL HEIGHT OF WALL. REFER TO FLOOR PLANS AND EXTERIOR ELEVATION A3.1 FOR LOCATIONS

KEY PLAN

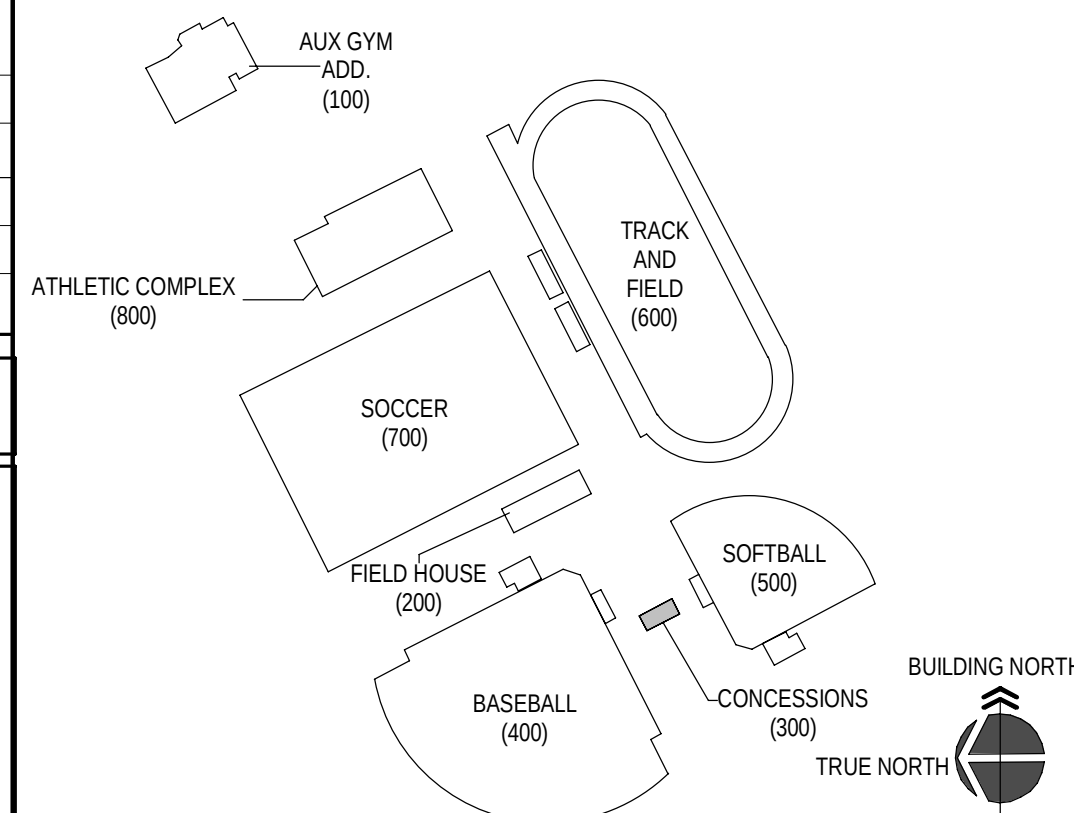


TOILET ACCESSORY SCHEDULE

ACCESSORY	MTG. HT.	MFR.
(1) COAT HOOK AND BUMPER	48" TOP OF HOOK	ASI 0714
(2) S.S. SOAP DISPENSER	40" TO VALVE	ASI 5343
(3) DOUBLE ROLL TOILET PAPER DISPENSER W/ VANDAL RESISTANT SPINDLE (SURFACE MOUNTED)	24" TO CENTER LINE	ASI 0264-12
(4) 42" S.S. GRAB BAR (1-1/4")	33" TO CENTERLINE	ASI 3401-42P
(5) 36" S.S. GRAB BAR (1-1/4")	33" TO CENTERLINE	ASI 3401-36P
(6) 18" VERTICAL S.S. GRAB BAR (1-1/4")	40" TO BOTTOM CENTERLINE	ASI 3401-18P
(7) SANITARY NAPKIN DISPOSAL (SURFACE MOUNTED)	24" TO TOP (28" FOR ADA)	ASI 0852
(8) MIRROR W/ S.S. FRAME - 24"x36"	40" TO BOTTOM	ASI 0600-B2436
(9) PAPER TOWEL DISPENSER (SURFACE MOUNTED)	46" TO DISPENSER SLOT	ASI 20210
(10) 48" S.S. GRAB BAR (1-1/4")	33" TO CENTERLINE	ASI 3401-48P
(11) MOP / BROOM HOLDER (36" WIDE)	72" TO TOP	SEE PLUMBING
(12) MOP SINK	FLOOR MOUNTED	SEE PLUMBING
(13) MIRROR W/ S.S. FRAME - 108"x72"	40" TO BOTTOM	
(14) BABY CHANGING TABLE	33" MAX. TO CHANGE SURFACE IN OPEN POSITION	ASI 9013-9
(15) SHOWER CURTAIN	72" STANDARD HEIGHT	ASI 1200-V
(16) TOWEL HOOKS	54" TO CENTERLINE	ASI 0740-Z
(17) 24" S.S. GRAB BAR (1-1/4")	33" TO CENTERLINE	ASI 3401 SERIES
(18) ADA COMPLIANT FOLDING SEAT	REFER TO DETAIL THIS SHEET	ASI 8203
(19) SOAP DISH WITH DRAIN	38" TO TOP OF DISH	ASI 0720-Z


GENERAL TOILET ACCESSORY NOTES

- MODEL NOS. DENOTE TOILET ACCESSORIES PRODUCTS OFFERED BY "AMERICAN SPECIALTIES, INC." (ASI) AND REPRESENT THE LEVEL OF QUALITY REQUIRED AND SHALL BE USED AS A BASIS OF DESIGN.
- ALL ITEMS SHALL BE LOCATED HORIZONTALLY AND MOUNTED TO SPECIFIC POINT ABOVE FINISH FLOOR SURFACES IN ACCORDANCE WITH ALL APPLICABLE REQUIREMENTS OF THE AMERICANS WITH DISABILITIES ACT (ADA) - ANSI A117.1 - 2009.
- REFER TO MEP DWGS. AND SPECIFICATIONS FOR PLUMBING FIXTURES, CONTROLS AND FLOOR DRAIN LOCATIONS.
- ALL EXPOSED PIPING AT LAVATORIES (H.C. LAVS) SHALL BE INSULATED AND COVERED WITH A PRE MOLDED RIGID INSULATION JACKET.
- ALL TOILET ACCESSORIES TO INCLUDE VANDAL RESISTANT OPTION.
- REFER TO ALL FLOOR PLAN SHEETS FOR ACCESSORIES REQUIRED AT OTHER LOCATIONS.
- INSTALL GRAB BARS TO ALLOW 1 1/2" BETWEEN GRAB BAR AND WALL.
- REFER TO TYPICAL ADA COMPLIANT GRAB BAR LAYOUT 11A0.1.


No.	Description	Date

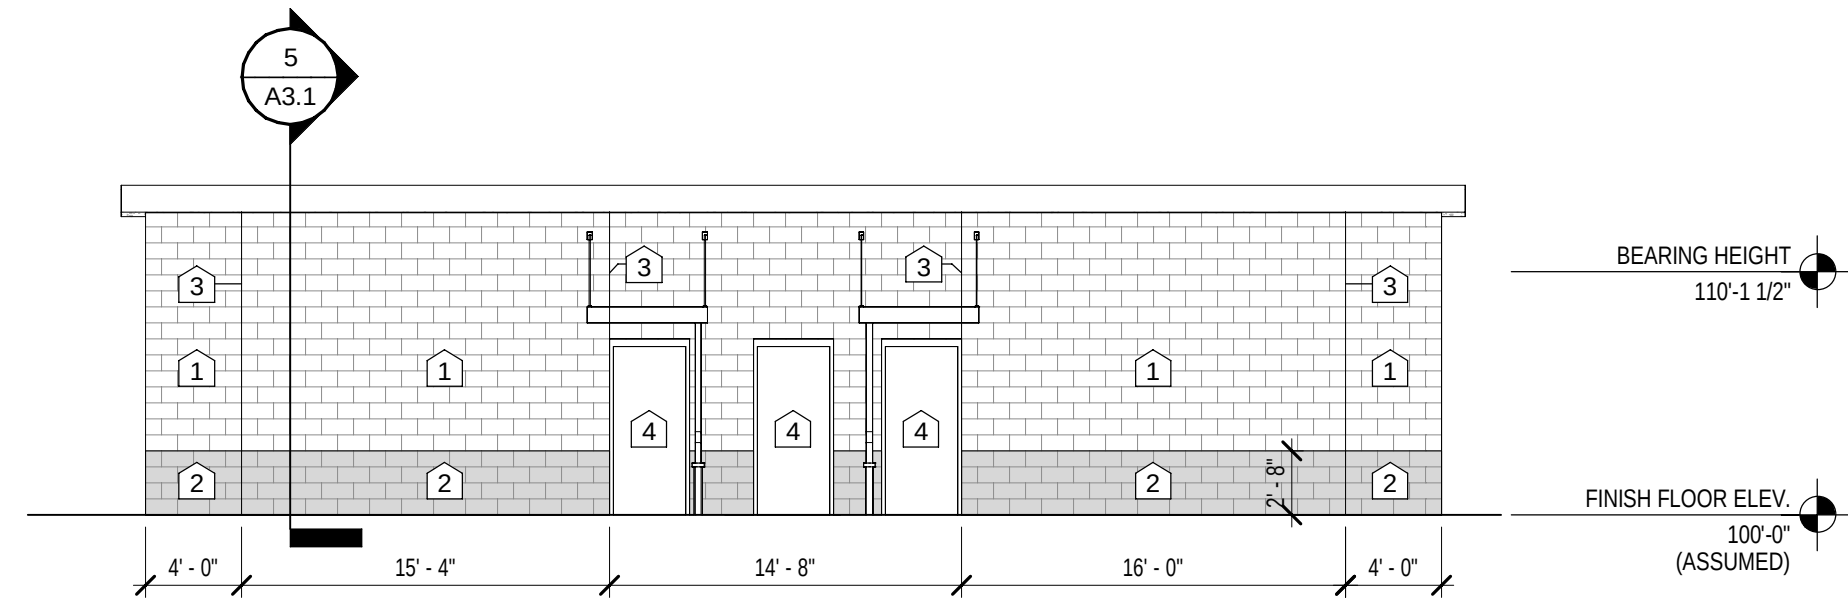


2 300 - BUILDING ELEVATION - NORTH
1/8" = 1'-0"

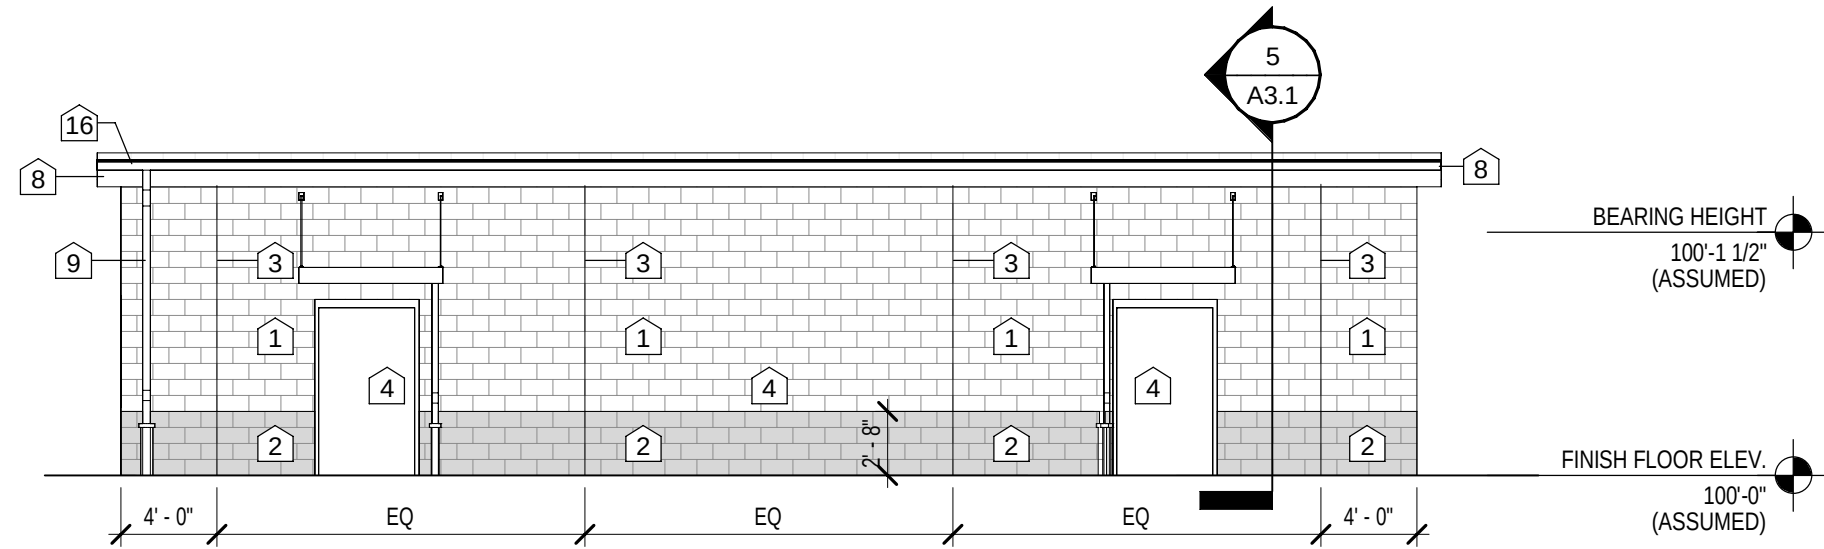


3 300 - BUILDING ELEVATION - SOUTH
1/8" = 1'-0"

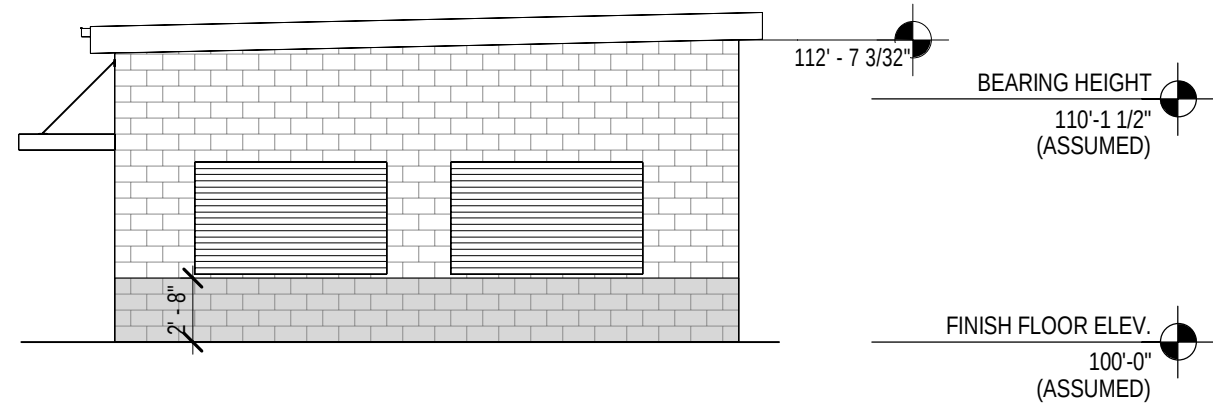

1 300 - BUILDING ELEVATION - EAST
1/8" = 1'-0"

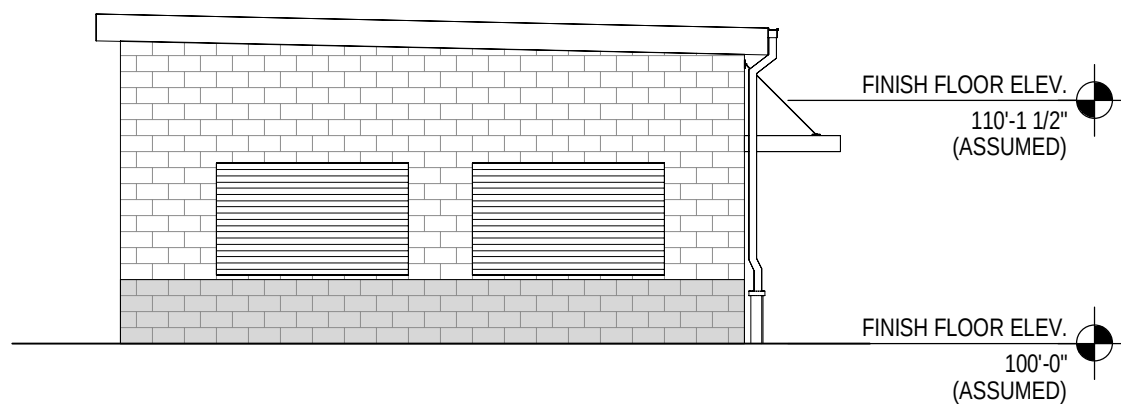

4 300 - BUILDING ELEVATION - WEST
1/8" = 1'-0"

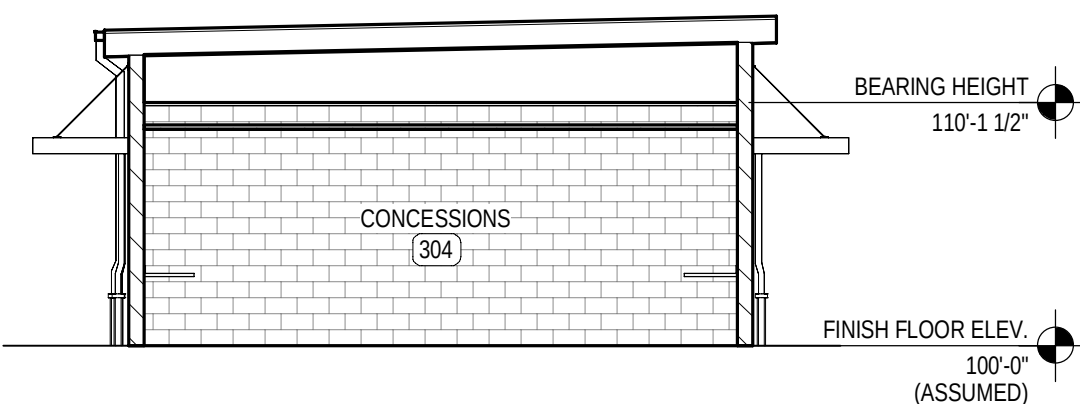

5 300 - BUILDING SECTION
1/8" = 1'-0"

GENERAL ELEVATION NOTES

BUILDING ELEVATIONS SHOWN ON THIS DRAWING ARE INTENDED FOR GENERAL REFERENCE PURPOSES ONLY. REFER TO REFERENCED SECTIONS AND DETAILS FOR MORE FULLY DESCRIBED CONDITIONS AND REQUIREMENTS.

- MATERIALS INDICATIONS AND DESCRIPTIONS, VERTICAL AND OTHER DIMENSIONS SHOWN ON ONE BUILDING ELEVATION APPLY TO OTHER BUILDING ELEVATIONS WHERE SHOWN UNLESS NOTED OTHERWISE.
- LINE REPRESENTING PAVING AND FINISH GRADES ARE APPROXIMATE AND ARE SHOWN FOR REFERENCE PURPOSES ONLY. REFER TO SITE PLANS FOR SPECIFIC GRADE AND SPOT ELEVATIONS AT EACH RESPECTIVELY.
- REFER TO FLOOR PLANS FOR LOCATION AND DOOR SCHEDULE FOR FULL EXTENT AND COMPLETE DESCRIPTION OF DOOR AND FRAME TYPES. PORTIONS OF DOORS, WINDOWS STOREFRONTS, AND CURTAIN WALLS MAY BE CONCEALED BY OTHER BUILDING FEATURES SHOWN.
- REFER TO FLOOR PLANS FOR SPECIFIC ALUMINUM WINDOW TYPES AND WINDOW ELEVATIONS.
- LOCATIONS OF CONTROL/EXPANSION JOINTS IN MASONRY WALLS ARE SHOWN ON THIS DRAWING. SEE TYPICAL DETAILS ON SHEET A6.2 FOR SPECIFIC REQUIREMENTS AT RESPECTIVE LOCATIONS.
- ALL EXPOSED NEW EXTERIOR MASONRY SHALL RECEIVE APPLICATION OF SPECIFIED WATER REPELLENT.
- ALL EXPOSED EXTERIOR METAL SUCH AS FLASHINGS, COPINGS, GUTTERS, DOWNSPOUTS AND LADDERS SHALL RECEIVE THE SPECIFIED FIELD OR SHOP APPLIED FINISH COATING.

ELEVATION KEY NOTES

NOTE: NOT ALL NOTES APPLY TO THIS SHEET.

- 8" (NOM.) SPLIT-FACE CMU
- 8" (NOM.) GROUND-FACE CMU
- BRICK ACCENT BAND (1 ROW)
- CONTROL JOINT
- GALV. INSULATED H.M. DOOR & FRAME (PRIMED, PAINT BY OTHERS)
- WALL MOUNTED LIGHT, REFER TO ELECTRICAL DRAWINGS
- FINISH GRADE - VARIES, REFER TO SITE DRAWINGS
- PRE-FINISHED S.M. GUTTER
- PRE-FINISHED DOWNSPOUT - TIE INTO BOOT. CONNECT TO BELOW GRADE DRAINAGE SYSTEM. REFER TO SITE DETAILS.
- INSULATED COILING OVERHEAD DOOR WITH PRE-FIN. S.M. COVER, REFER TO SPECIFICATIONS.
- PRE-FINISHED METAL WALL PANEL. REFER TO SPECIFICATIONS.
- SIGNAGE, REFER TO SPECS.
- ALUM. STOREFRONT
- CANOPY SYSTEM - REFER TO DETAIL 15A1.1
- RECESS BRICK BAND 1/2" (TYP.)
- GUTTER.
- PEMB RAKE TRIM
- PEMB GUTTER
- PEMB DOWNSPOUT
- PEMB RIDGE CAP
- PEMB METAL WALL PANEL
- S.M. COPING
- EXTERIOR GRADE PLYWOOD, PAINTED, REFER TO DETAIL 6/A5.2.

FLOOR PLAN KEYNOTES

- OWNER PROVIDED FURNITURE OR EQUIPMENT (N.I.C.).
- LINE OF SOFFIT / BULKHEAD ABOVE, REFER TO REFLECTED CEILING PLAN.
- PRE-MFR, PRE-FIN SUSPENDED ALUMINUM CANOPY, REFER TO DETAIL 11/A4.2.
- EXTERIOR CONCRETE WALK, REFER TO SITE DRAWINGS.
- HIGH / LOW ADA COMPLIANT WATER COOLER UNIT, REFER TO MECH. / ELEC. DRAWINGS.
- MOP SINK, REFER TO PLUMBING DRAWINGS.
- KNOX-BOX RECESSED IN BRICK, REFER TO DOOR HARDWARE SPECIFICATIONS.
- FLOOR TRANSITION, REFER TO SHEET A8.1 FOR DETAILS.
- SHIPS LADDER, REFER TO DETAIL 11/A0.3.
- DIVIDER CURTAIN, MOTORIZED OPERATOR, REFER TO ELEC. DWGS.
- 7'-0" TALL X 2" THICK WALL PAD WITH WOOD BACKING. ATTACH TO WALLS / COLUMNS WITH MANUFACTURER'S STANDARD "Z" CLIP SYSTEM.
- ELECTRIC PUSH-BUTTON ADA DOOR OPERATOR. REFER TO ELEC. DWGS.


GENERAL NOTES

- (OF-C) OWNER FURNISHED CONTRACTOR INSTALLED.
- EXISTING TO REMAIN INTERIOR WALLS THAT ARE EXPOSED IN AREAS OF RENOVATION TO BE CLEANED, REPAIRED, PRIMED, AND PAINTED FOR LIKE NEW FINISH.
- DO NOT SCALE DWGS, WRITTEN DIMENSIONS TAKE PRECEDENCE OVER SCALED DIMENSIONS.
- INTERIOR MASONRY CONTROL JOINTS TO OCCUR EVERY 20'-0" MAX.
- NOTE: MARKER BOARD (MB) AND TACK BOARD (TB) INDICATE WIDTH AND ARE TO BE 48" H.

SYMBOL LEGEND

- ROOM FINISH GROUPS (REFER TO KEY PLAN SHEETS)
- ROOM NUMBER
- DOOR NUMBER (DOOR SCHEDULE SHEET A8.1)
- KEY NOTES (SHEETS A1.3 THROUGH A2.8)
- WALL TYPE (SCHEDULE SHEET A0.1)
- ALUMINUM OR HOLLOW METAL WINDOW OR STOREFRONT TYPE (REFER TO FLOOR PLANS AND SCHEDULE SHEETS A8.2)
- TOILET ACCESSORIES (SCHEDULE SHEET A2.7)
- ELEVATION KEY NOTE (SHEETS A3.1)
- ROOF KEY NOTE (SHEET A4.1)
- CEILING PLAN KEY NOTE (SHEETS A7.1 THROUGH A7.7)
- SIGNAGE KEY NOTE (REFER TO KEY PLAN SHEETS)
- WALL / PARTITION DESIGNATION
- FW2 2 HOUR RATED FIRE WALL
- EPW2 EXISTING 2 HOUR RATED FIRE WALL
- MASONRY CONTROL JOINT FULL HEIGHT OF WALL. REFER TO FLOOR PLANS AND EXTERIOR ELEVATION A3.1 FOR LOCATIONS

KEY PLAN

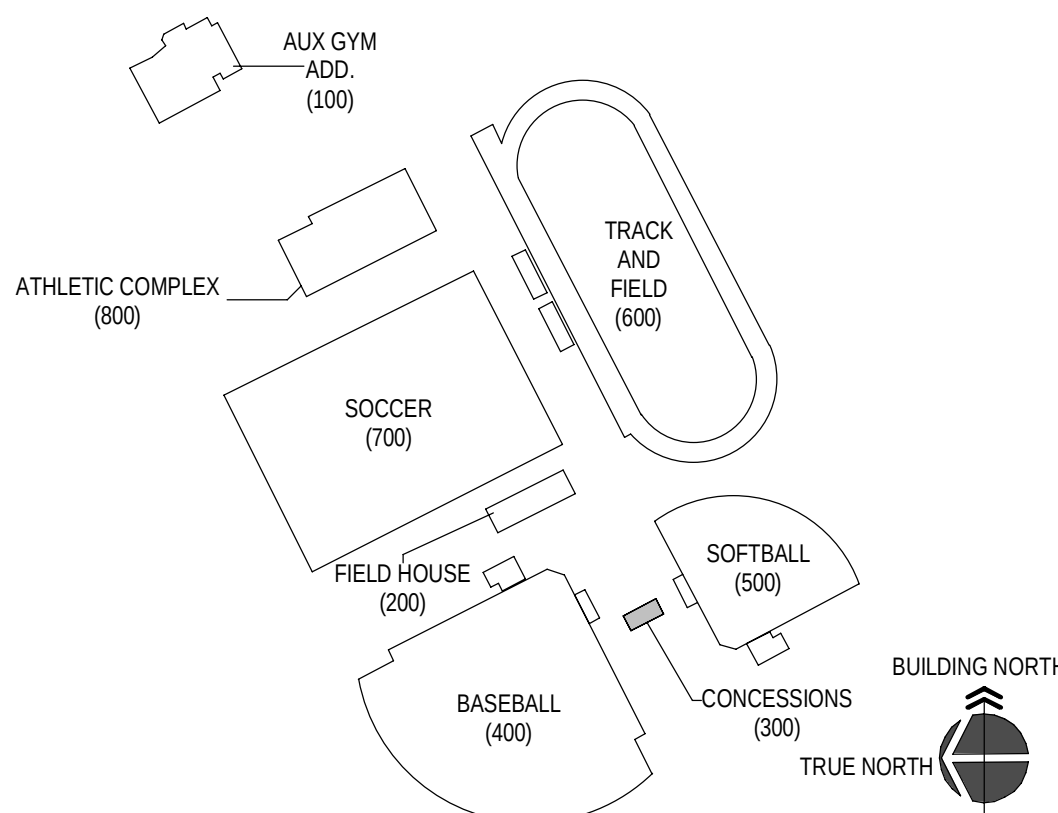

SHERMAN
CARTER
BARNHART
ARCHITECTS

DD SET
- NOT FOR -
CONSTRUCTION

ALLEN COUNTY - SCOTTSVILLE
HIGH SCHOOL ATHLETIC
COMPLEX
SCOTTSVILLE, KENTUCKY

CONCESSIONS BUILDING ELEVATIONS
AND SECTIONS

JOB NO. 2469

DATE 12/15/2025

DRAWN CAH

CHECKED RJV, ASC

COPYRIGHT © 2025
SHERMAN CARTER BARNHART
ARCHITECTS, PLLC


REVISIONS

No.	Description	Date


SHEET

A3.1




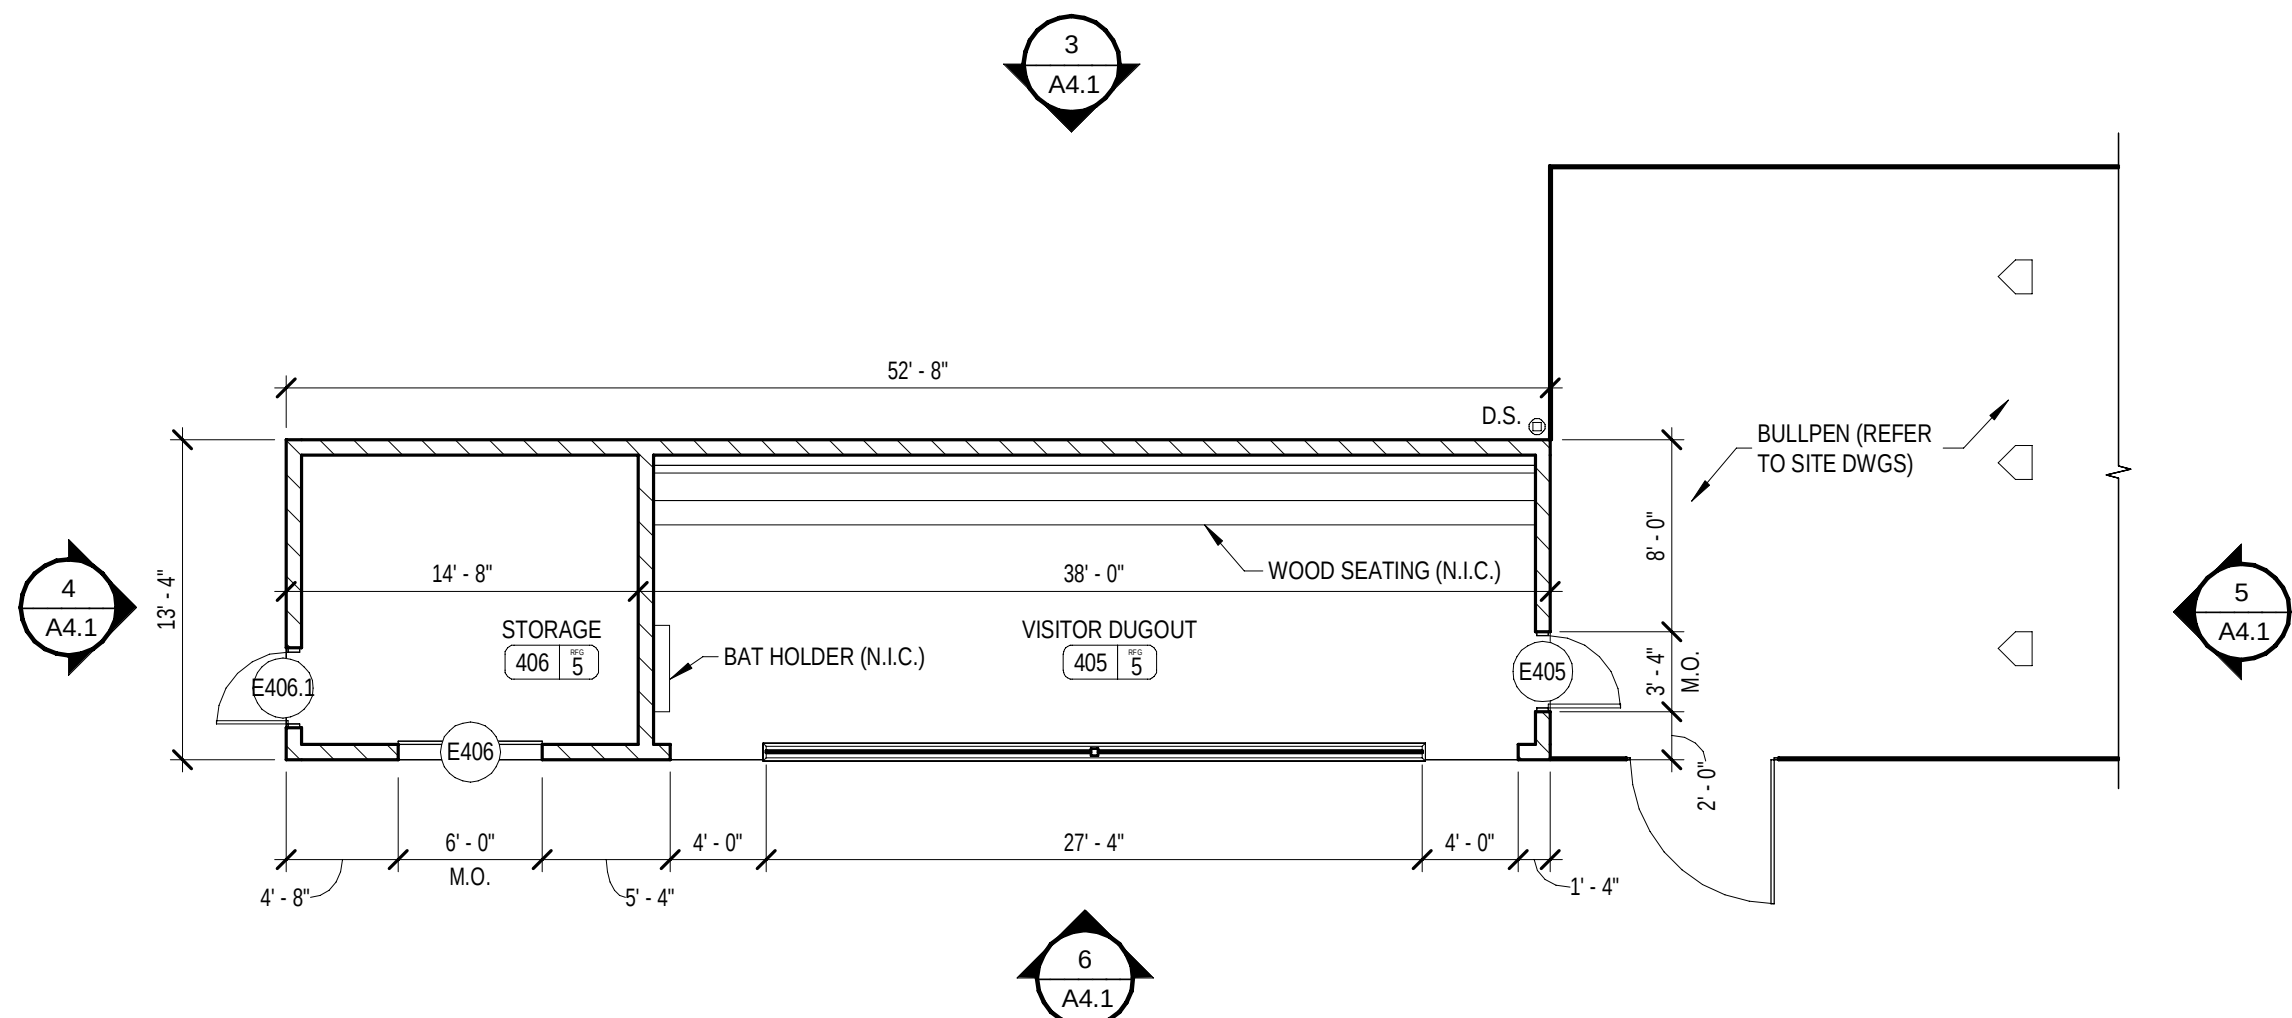

1 400 - VISITOR TEAM DUGOUT
1/8" = 1'-0"

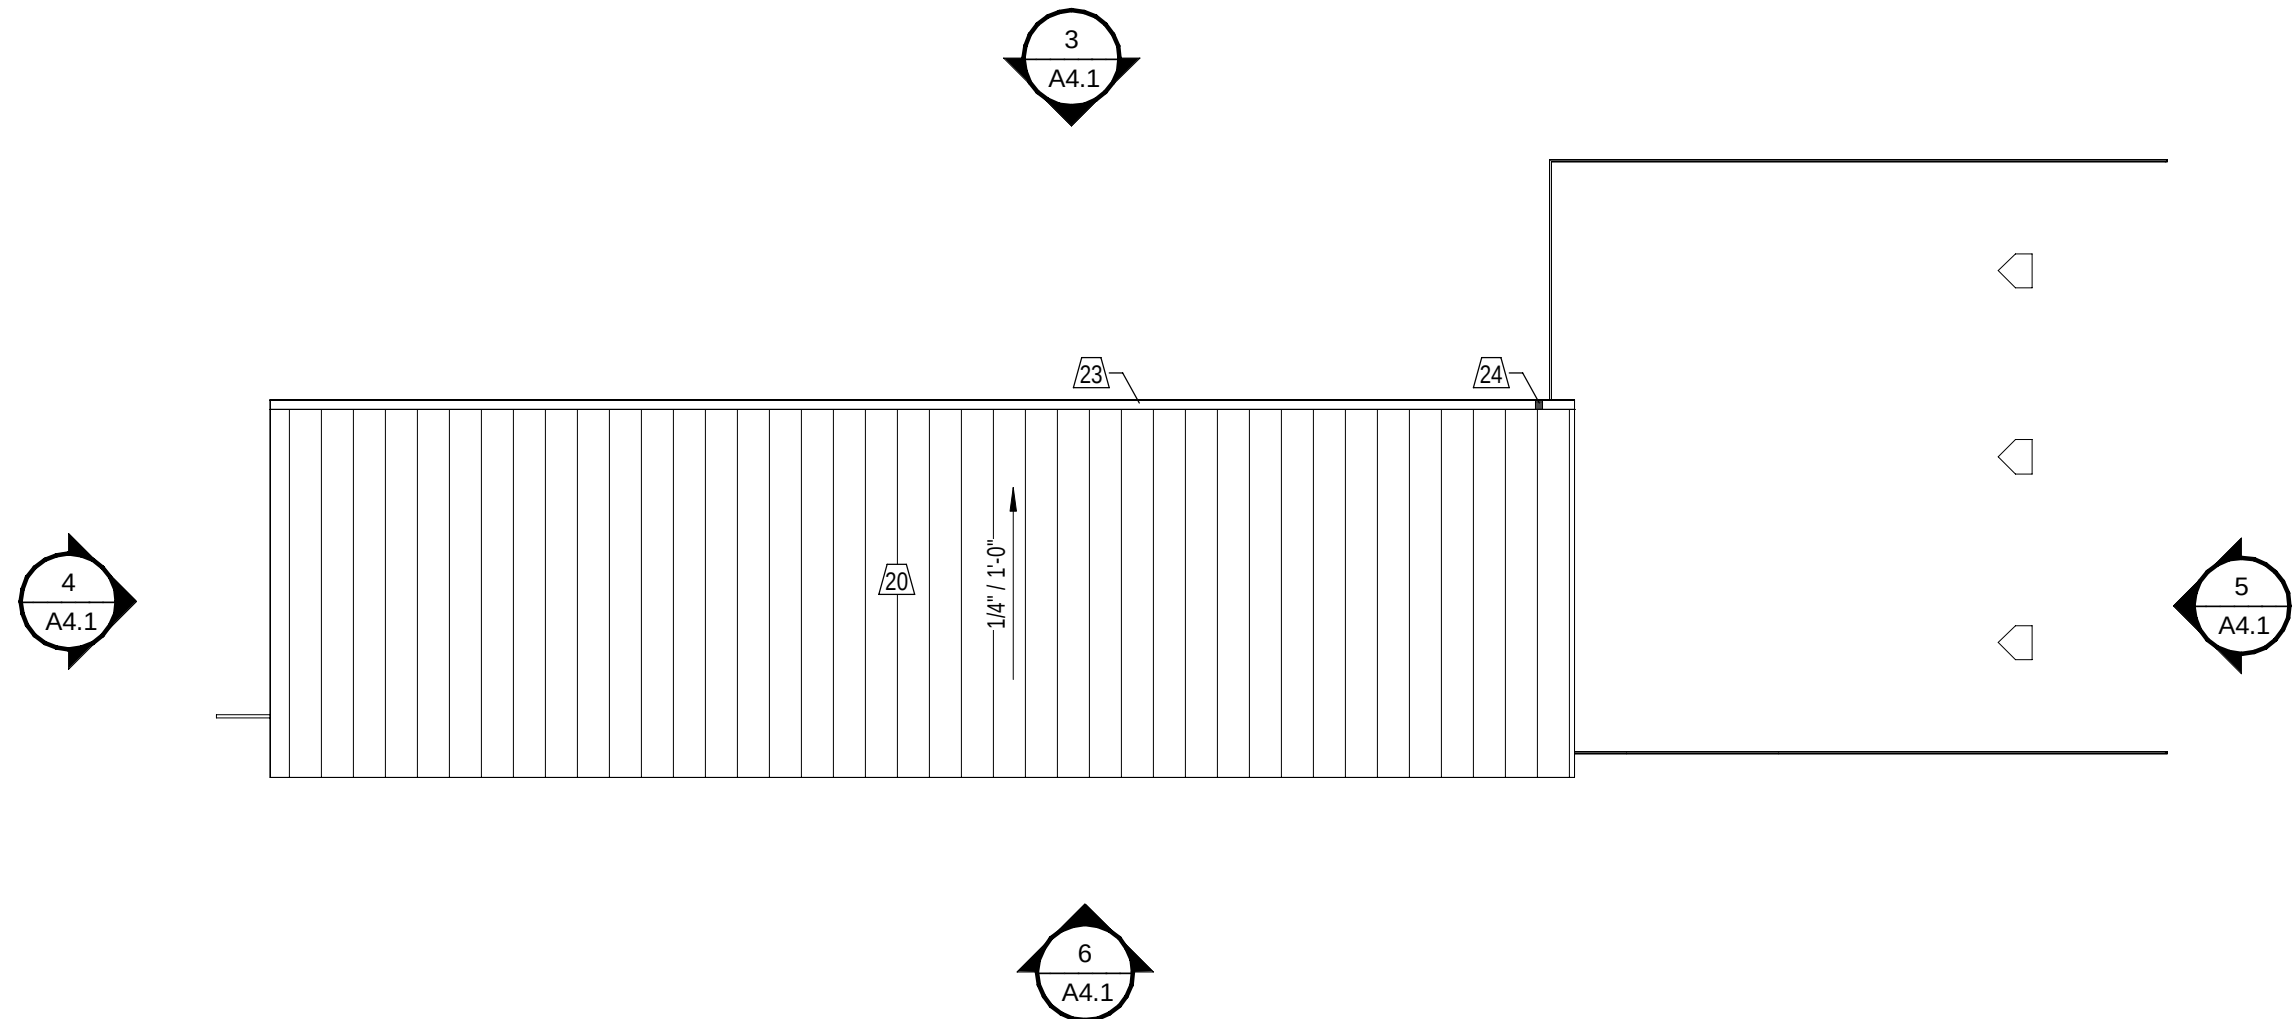


2 400 - VISITOR TEAM DUGOUT - ROOF PLAN
1/8" = 1'-0"

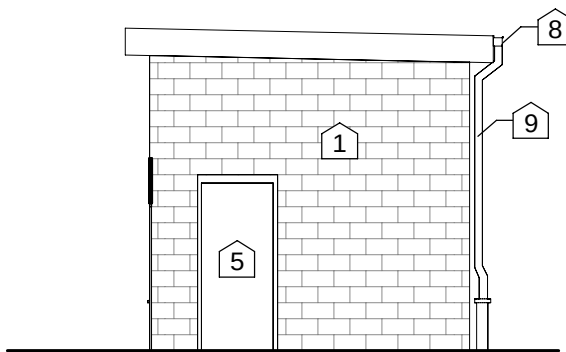


5 400 - VISITOR DUGOUT - EAST ELEVATION
1/8" = 1'-0"

3 400 - VISITOR DUGOUT - NORTH ELEVATION
1/8" = 1'-0"

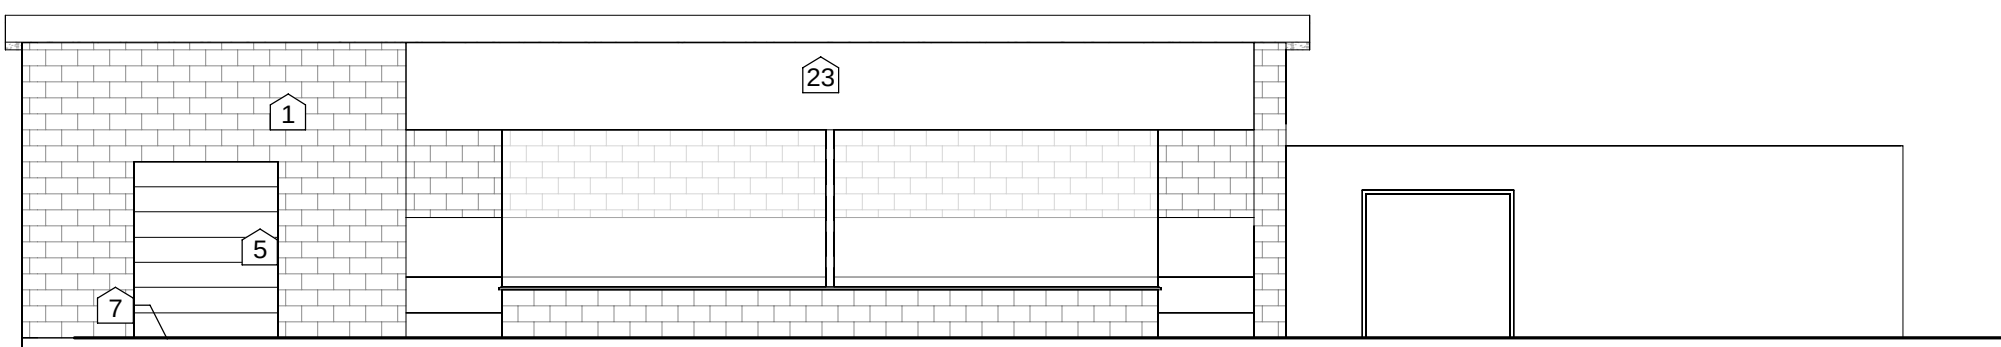

6 400 - VISITOR DUGOUT - SOUTH ELEVATION
1/8" = 1'-0"

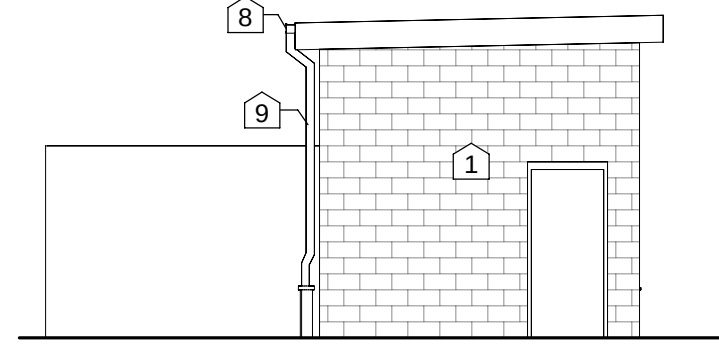

4 400 - VISITOR DUGOUT - WEST ELEVATION
1/8" = 1'-0"

GENERAL ELEVATION NOTES

BUILDING ELEVATIONS SHOWN ON THIS DRAWING ARE INTENDED FOR GENERAL REFERENCE PURPOSES ONLY. REFER TO REFERENCED SECTIONS AND DETAILS FOR MORE FULLY DESCRIBED CONDITIONS AND REQUIREMENTS.

- MATERIALS INDICATIONS AND DESCRIPTIONS, VERTICAL AND OTHER DIMENSIONS SHOWN ON ONE BUILDING ELEVATION APPLY TO OTHER BUILDING ELEVATIONS WHERE SHOWN UNLESS NOTED OTHERWISE.
- LINES REPRESENTING PAVING AND FINISH GRADES ARE APPROXIMATE AND ARE SHOWN FOR REFERENCE PURPOSES ONLY. REFER TO SITE PLANS FOR SPECIFIC GRADE AND SPOT ELEVATIONS AT EACH RESPECTIVELY.
- REFER TO FLOOR PLANS FOR LOCATION AND DOOR SCHEDULE FOR FULL EXTENT AND COMPLETE DESCRIPTION OF DOOR AND FRAME TYPES. PORTIONS OF DOORS, WINDOWS, STOREFRONTS, AND CURTAIN WALLS MAY BE CONCEALED BY OTHER BUILDING FEATURES SHOWN.
- REFER TO FLOOR PLANS FOR SPECIFIC ALUMINUM WINDOW TYPES AND WINDOW ELEVATIONS.
- LOCATIONS OF CONTROL/EXPANSION JOINTS IN MASONRY WALLS ARE SHOWN ON THIS DRAWING. SEE TYPICAL DETAILS ON SHEET A6.2 FOR SPECIFIC REQUIREMENTS AT RESPECTIVE LOCATIONS.
- ALL EXPOSED NEW EXTERIOR MASONRY SHALL RECEIVE APPLICATION OF SPECIFIED WATER REPELLENT.
- ALL EXPOSED EXTERIOR METAL SUCH AS FLASHINGS, COPINGS, GUTTERS, DOWNSPOUTS AND LADDERS SHALL RECEIVE THE SPECIFIED FIELD OR SHOP APPLIED FINISH COATING.

ELEVATION KEY NOTES

NOTE: NOT ALL NOTES APPLY TO THIS SHEET.

- 8" (NOM.) SPILT-FACE CMU
- 8" (NOM.) GROUND-FAÇE CMU
- BRICK ACCENT BAND (1 ROW)
- CONTROL JOINT
- GALV. INSULATED H.M. DOOR & FRAME (PRIMED, PAINT BY OTHERS)
- WALL MOUNTED LIGHT, REFER TO ELECTRICAL DRAWINGS
- FINISH GRADE - VARIES, REFER TO SITE DRAWINGS
- PRE-FINISHED S.M. GUTTER
- PRE-FINISHED DOWNSPOUT - TIE INTO BOOT. CONNECT TO BELOW GRADE DRAINAGE SYSTEM. REFER TO SITE DETAILS.
- INSULATED COILING OVERHEAD DOOR WITH PRE-FIN. S.M. COVER, REFER TO SPECIFICATIONS.
- PRE-FINISHED METAL WALL PANEL, REFER TO SPECIFICATIONS.
- SIGNAGE, REFER TO SPECS.
- ALUM. STOREFRONT
- CANOPY SYSTEM - REFER TO DETAIL 15A1.1
- RECESS BRICK BAND 1/2" (TYP.)
- GUTTER
- PEMB RAKE TRIM
- PEMB GUTTER
- PEMB DOWNSPOUT
- PEMB RIDGE CAP
- PEMB METAL WALL PANEL
- S.M. COPING
- EXTERIOR GRADE PLYWOOD, PAINTED, REFER TO DETAIL 6/A5.2.

ROOF KEYNOTES

- ROOF TYPE 'A' REFER TO ROOF LEGEND.
- ROOF TYPE 'B' REFER TO ROOF LEGEND.
- PRE-FIN METAL COPING, REFER TO TYP. DETAIL 1/A0.2.
- PRE-FIN METAL SCUPPER AND DOWNSPOUT, REFER TO DETAILS 2, 3, AND 4/A0.2.
- PRE-MANUFACTURED WALKWAY COVER, REFER TO DETAIL 11/A0.2.
- PRE-MANUFACTURED WALL SUPPORTED ALUMINUM CANOPY WITH INTEGRAL DOWNSPOUT 8'-0" x 5'-0" U.N.O. REFER TO DETAILS 12 AND 13/A0.2.
- MASONRY PIER WITH CAST STONE CAP, REFER TO DETAIL ____.
- ROOF EXPANSION JOINT, REFER TO DETAIL ____.
- ROOF EXPANSION JOINT AT 2HR FIRE WALL, REFER TO DETAIL ____.
- ROOF HATCH, REFER TO DETAIL 11/A0.3.
- WALKWAY PADS, REFER TO SPECIFICATIONS.
- CRICKET, TAPER INSULATION 1/4" PER FT. FOR POSITIVE DRAINAGE TO SCUPPER.
- CRICKET FOR POSITIVE DRAINAGE AROUND ROOF CURB.
- HVAC UNIT, REFER TO MECHANICAL. SEE 1/A0.2 FOR MECH CURB DETAIL.
- PEMB RIDGE CAP.
- PEMB GUTTER ASSEMBLY.
- PEMB RAKE TRIM ASSEMBLY.
- PEMB DOWNSPOUT. SEE ELEVATIONS.
- ROOF TYPE 'C' REFER TO ROOF LEGEND.
- ROOF TYPE 'D' REFER TO ROOF LEGEND.
- PRE-FIN METAL VENTED RIDGE CAP.
- PRE-FIN METAL RAKE TRIM.
- PRE-FIN METAL GUTTER.
- PRE-FIN METAL DOWNSPOUT.
- SNOW GUARD.

GENERAL ROOF NOTES

- ROOF SLOPES ARE 1/4" / 12" UNLESS NOTED OTHERWISE.
- ALL FLASHING WORK SHALL BE DONE SUCH THAT A WATERTIGHT INSTALLATION IS ACHIEVED AND MAINTAINED.
- REFER TO STRUCTURAL DWGS. FOR SPECIFIC STRUCTURAL ELEVATION.
- REFER TO MECH DWGS. FOR ROOF TOP ITEMS NOT SHOWN IN THIS PLAN.
- FLASH ALL ROOF PENETRATIONS PER MANUFACTURER'S STANDARD DETAILS.
- REFER TO TYPICAL ROOF DETAILS, SHEET A0.2.
- CONTRACTOR SHALL NOT COVER ANY WEEPS, BRICK VENTS, EXPANSION JOINTS, FLASHING, OR COPING. ROOFING SHALL TERMINATE AS SHOWN ON DETAILS.
- CONTRACTOR TO COORDINATE INSTALLATION OF ROOFING/ FLASHING WITH OTHER TRADES FOR ADDITIONAL WORK REQ'D. (I.E. FLASHING OF EQUIPMENT CURBS.)
- INSTALL ROOF FLASHING TO EXTEND UP FULL HEIGHT OF PARAPET WALLS AND OVER NAILERS UNDER COPING UNLESS NOTED OTHERWISE.

ROOF SYMBOLS LEGEND

ROOF ASSEMBLY - TYPE 'A':
THERMOPLASTIC POLYOLEFIN SINGLE PLY MEMBRANE ROOFING OVER 7/16" COVER DECK OVER (4) LAYERS OF 1 1/2" RIGID POLYSTYRENAURATE INSULATION STAGGERED (Ø" THICKNESS) ON METAL DECK. PROVIDE FINISHED 1/4" SLOPE PER 1'-0".

ROOF ASSEMBLY - TYPE 'B':
PEMB METAL ROOF OVER METAL PURLINS, WITH R-5 THERMAL BLOCKS, 8" LOWER LAYER FIBERGLASS BATT INSULATION AND 3" UPPER LAYER FIBERGLASS BATT INSULATION WITH A TOTAL PRE-INSTALLED R-VALUE OF 35. SUSPEND WITH STEEL STRAP AND FABRIC SYSTEM. SLOPE 3/12.

ROOF ASSEMBLY - TYPE 'C':
STANDING SEAM METAL ROOF SYSTEM OVER SINGLE LAYER OF CONTINUOUS ICE & WATER SHIELD ON SPECIFIED ROOF DECKING OVER W.D. RAFTERS.

ROOF ASSEMBLY - TYPE 'D':
STANDING SEAM METAL ROOF SYSTEM OVER SINGLE LAYER OF CONTINUOUS ICE & WATER SHIELD ON SPECIFIED PLYWOOD SHEATHING OVER W.D. RAFTERS.

- INDICATES 2HR FIRE WALL, SEE PLAN A1.1.
- INDICATES CRICKET, SLOPE 1/4" PER FOOT IN DIRECTION OF ARROW
- APPROXIMATE AREA OF ROOF REPAIR, TO BE INVESTIGATED AND REPAIRED BY CONTRACTOR

- DS DOWNSPOUT.
- SC SCUPPER AND CONDUCTOR HEAD.
- EDS EXISTING DOWNSPOUT.
- RD ROOF DRAIN, REFER TO DETAIL 1/A4.2.
- ORD OVERFLOW ROOF DRAIN, REFER TO DETAIL 1/A4.2.
- VTR VENT THRU ROOF, REFER TO DETAIL 2/A4.2.
- RTU ROOF TOP UNIT, REFER TO MECHANICAL DWGS. AND CURB DETAIL 3/A4.2.
- EXHAUST FAN / OA HOOD, REFER TO MECH. DWGS.

FLOOR PLAN KEYNOTES

- OWNER PROVIDED FURNITURE OR EQUIPMENT (N.I.C.).
- LINE OF SOFFIT / BULKHEAD ABOVE, REFER TO REFLECTED CEILING PLAN.
- PRE-MFR, PRE-FIN SUSPENDED ALUMINUM CANOPY, REFER TO DETAIL 11/A4.2.
- EXTERIOR CONCRETE WALK, REFER TO SITE DRAWINGS.
- HIGH / LOW ADA COMPLIANT WATER COOLER UNIT, REFER TO MECH. / ELEC. DRAWINGS.
- MOP SINK, REFER TO PLUMBING DRAWINGS.
- KNOX-BOX RECESSED IN BRICK, REFER TO DOOR HARDWARE SPECIFICATIONS.
- FLOOR TRANSITION, REFER TO SHEET A8.1 FOR DETAILS.
- SHIPS LADDER, REFER TO DETAIL 11/A0.3.
- DIVIDER CURTAIN, MOTORIZED OPERATOR, REFER TO ELEC. DWGS.
- 7'-0" TALL X 2" THICK WALL PAD WITH WOOD BACKING. ATTACH TO WALLS / COLUMNS WITH MANUFACTURER'S STANDARD "Z" CLIP SYSTEM.
- ELECTRIC PUSH-BUTTON ADA DOOR OPERATOR, REFER TO ELEC. DWGS.


GENERAL NOTES

- (OF-C) OWNER FURNISHED CONTRACTOR INSTALLED.
- EXISTING TO REMAIN INTERIOR WALLS THAT ARE EXPOSED IN AREAS OF RENOVATION TO BE CLEANED, REPAIRED, PRIMED, AND PAINTED FOR LIKE NEW FINISH.
- DO NOT SCALE DWGS. WRITTEN DIMENSIONS TAKE PRECEDENCE OVER SCALED DIMENSIONS.
- INTERIOR MASONRY CONTROL JOINTS TO OCCUR EVERY 20'-0" MAX.
- NOTE: MARKER BOARD (MB) AND TACK BOARD (TB) INDICATE WIDTH AND ARE TO BE 48" H.


SYMBOL LEGEND

- ROOM FINISH GROUPS (REFER TO KEY PLAN SHEETS)
- ROOM NUMBER
- DOOR NUMBER (DOOR SCHEDULE SHEET A8.1)
- KEY NOTES (SHEETS A1.3 THROUGH A2.8)
- WALL TYPE (SCHEDULE SHEET A0.1)
- ALUMINUM OR HOLLOW METAL WINDOW OR STOREFRONT TYPE (REFER TO FLOOR PLANS AND SCHEDULE SHEETS A8.2)
- TOILET ACCESSORIES (SCHEDULE SHEET A2.7)
- ELEVATION KEY NOTE (SHEETS A3.1)
- ROOF KEY NOTE (SHEET A4.1)
- CEILING PLAN KEY NOTE (SHEETS A7.1 THROUGH A7.7)
- SIGNAGE KEY NOTE (REFER TO KEY PLAN SHEETS)
- WALL / PARTITION DESIGNATION
FW2 2 HOUR RATED FIRE WALL
EFW2 EXISTING 2 HOUR RATED FIRE WALL
- MASONRY CONTROL JOINT FULL HEIGHT OF WALL, REFER TO FLOOR PLANS AND EXTERIOR ELEVATION A3.1 FOR LOCATIONS


KEY PLAN

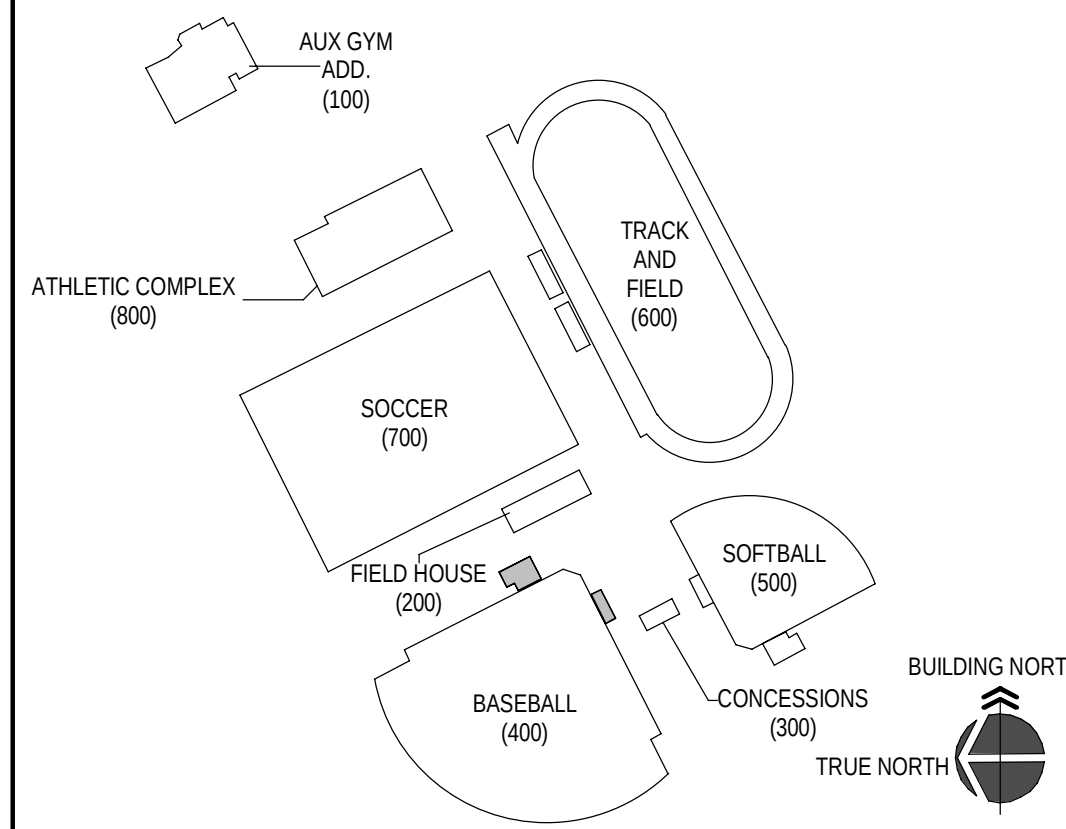


No.	Description	Date

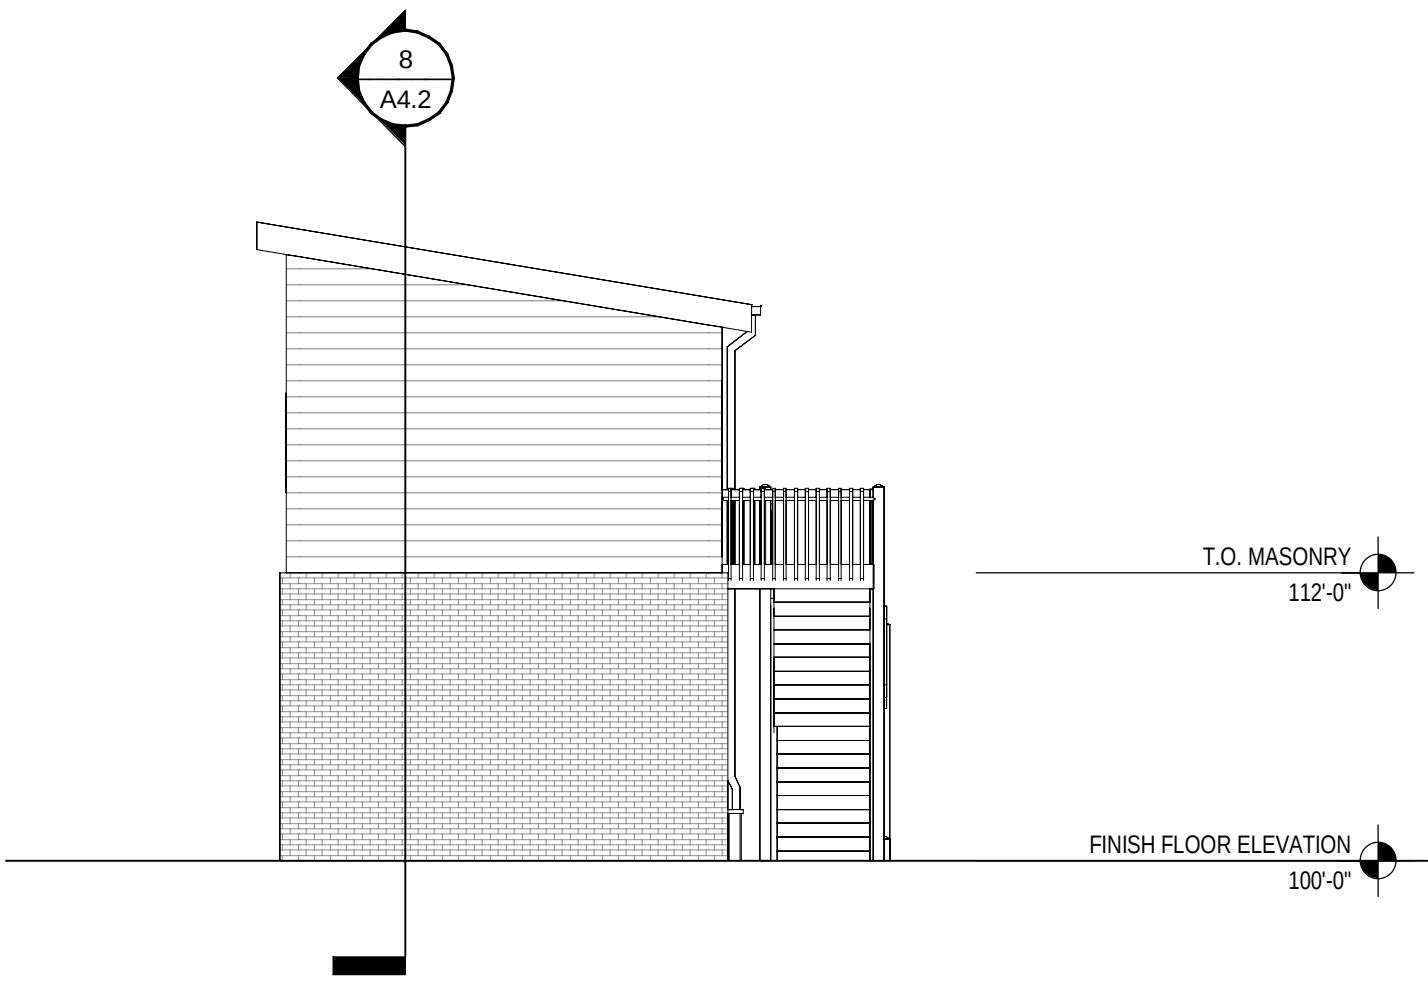


5 400 - BASEBALL PRESSBOX - EAST ELEVATION
1/8" = 1'-0"

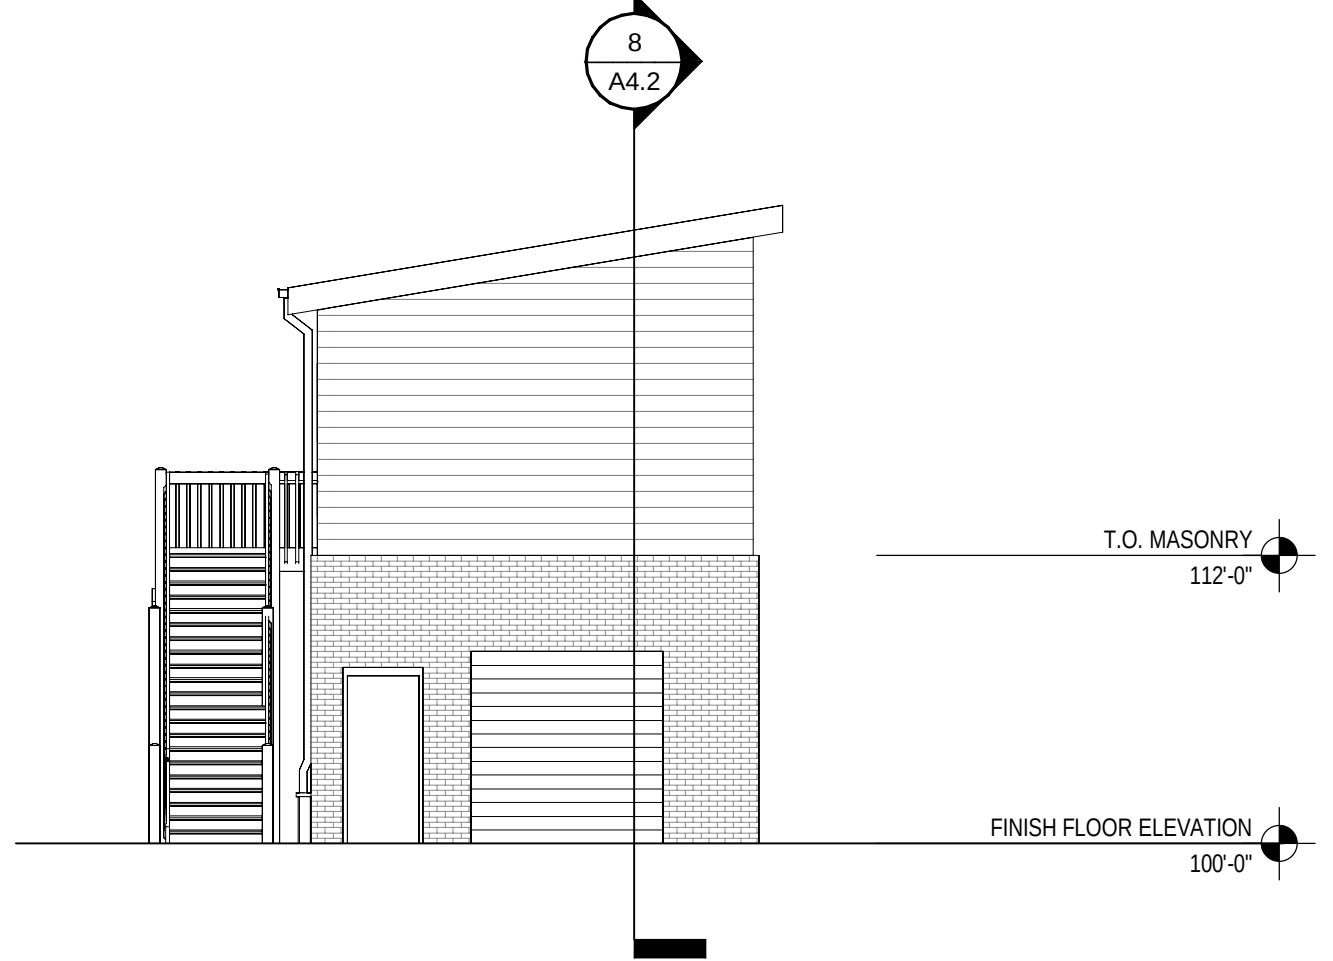


6 400 - BASEBALL PRESSBOX - WEST ELEVATION
1/8" = 1'-0"

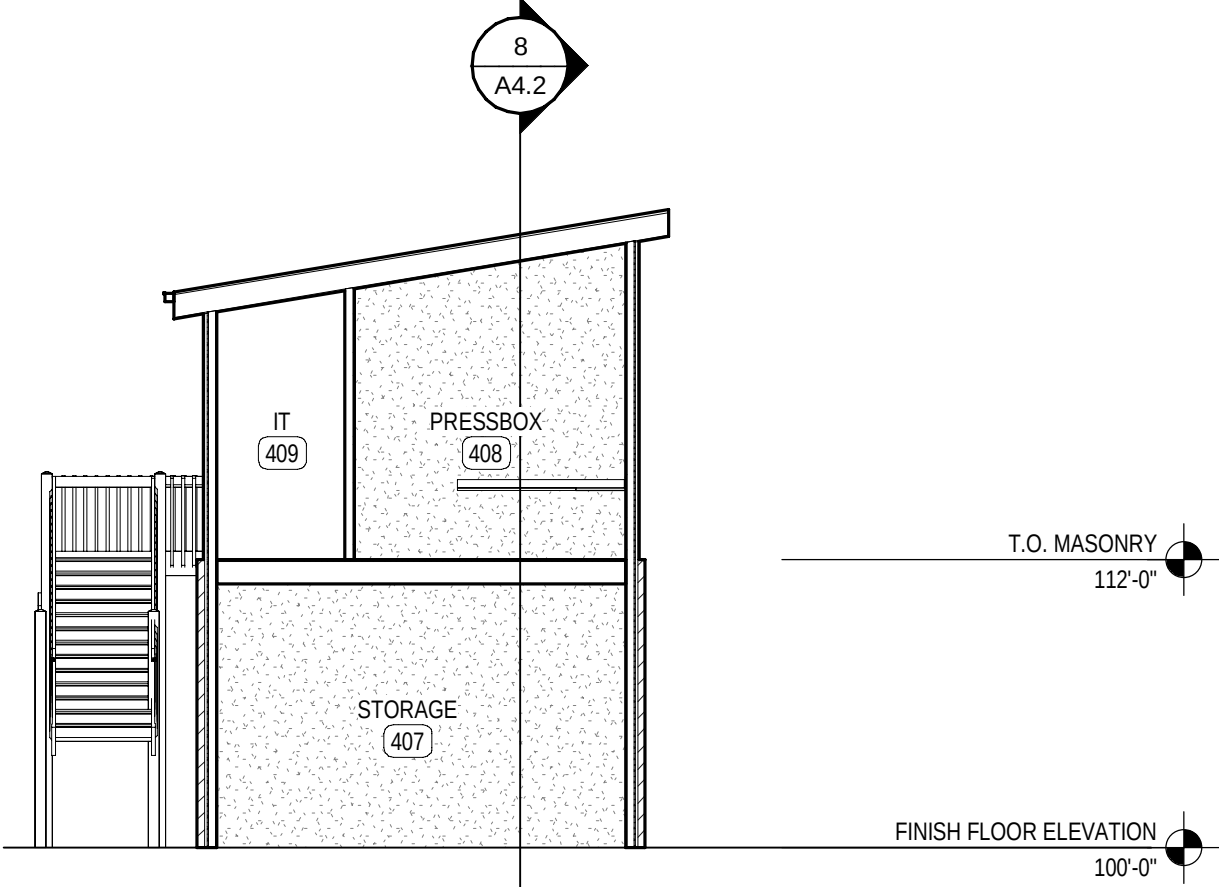


7 400 - PRESSBOX SECTION 01
1/8" = 1'-0"

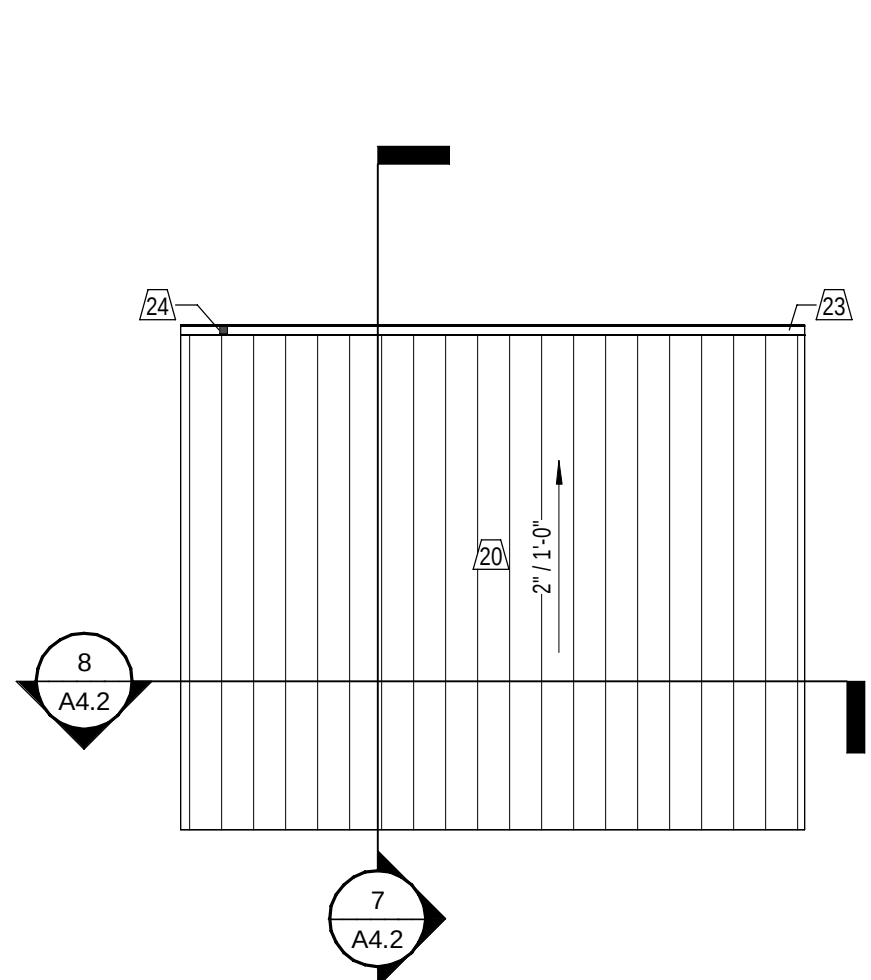


9 SECOND FLOOR NEW WORK PLAN - OPTION 2
1/8" = 1'-0"

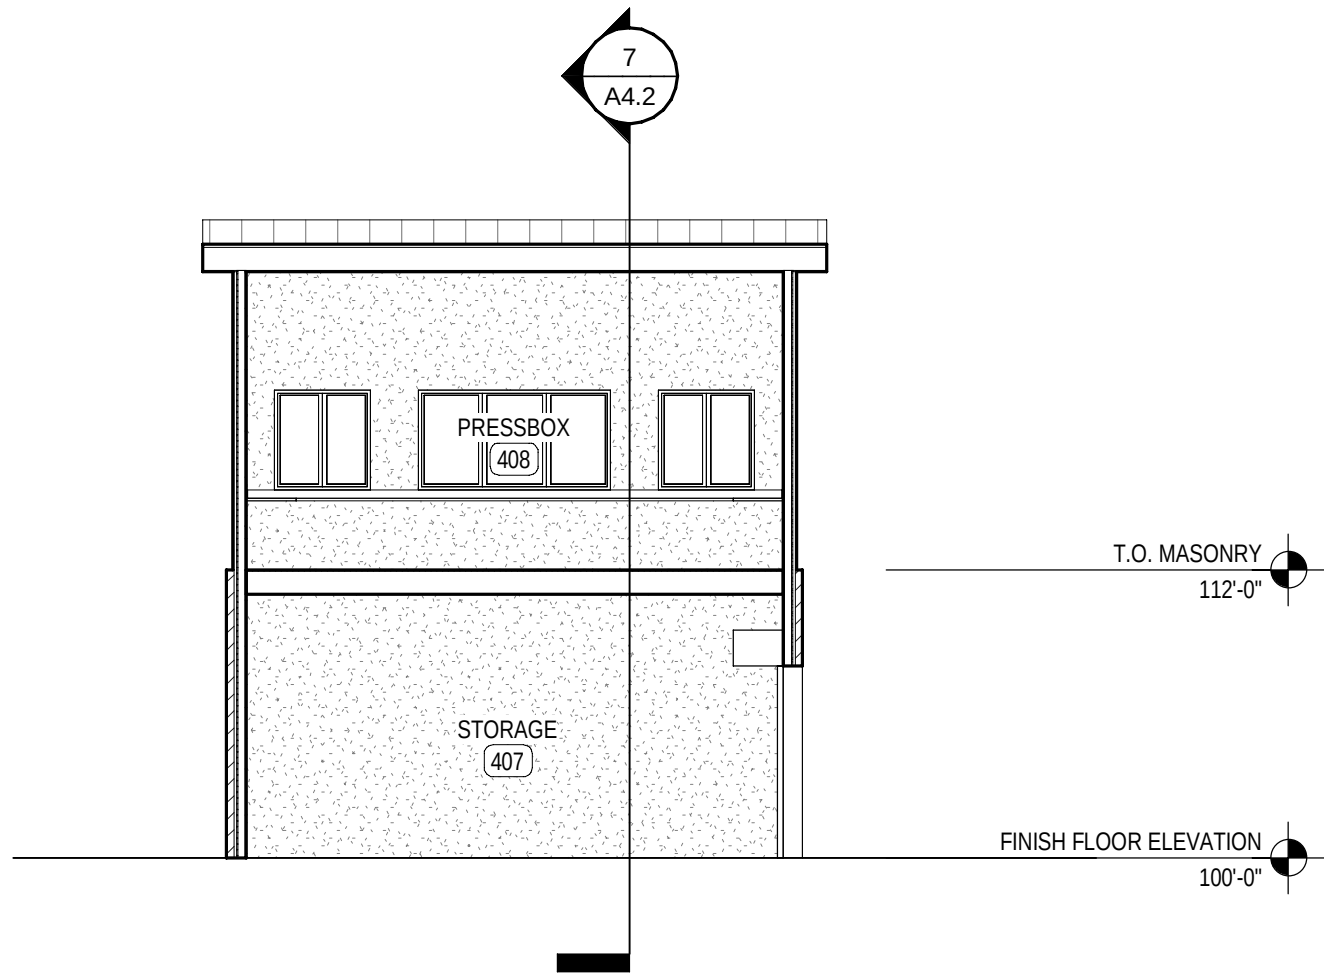

8 400 - PRESSBOX SECTION 02
1/8" = 1'-0"

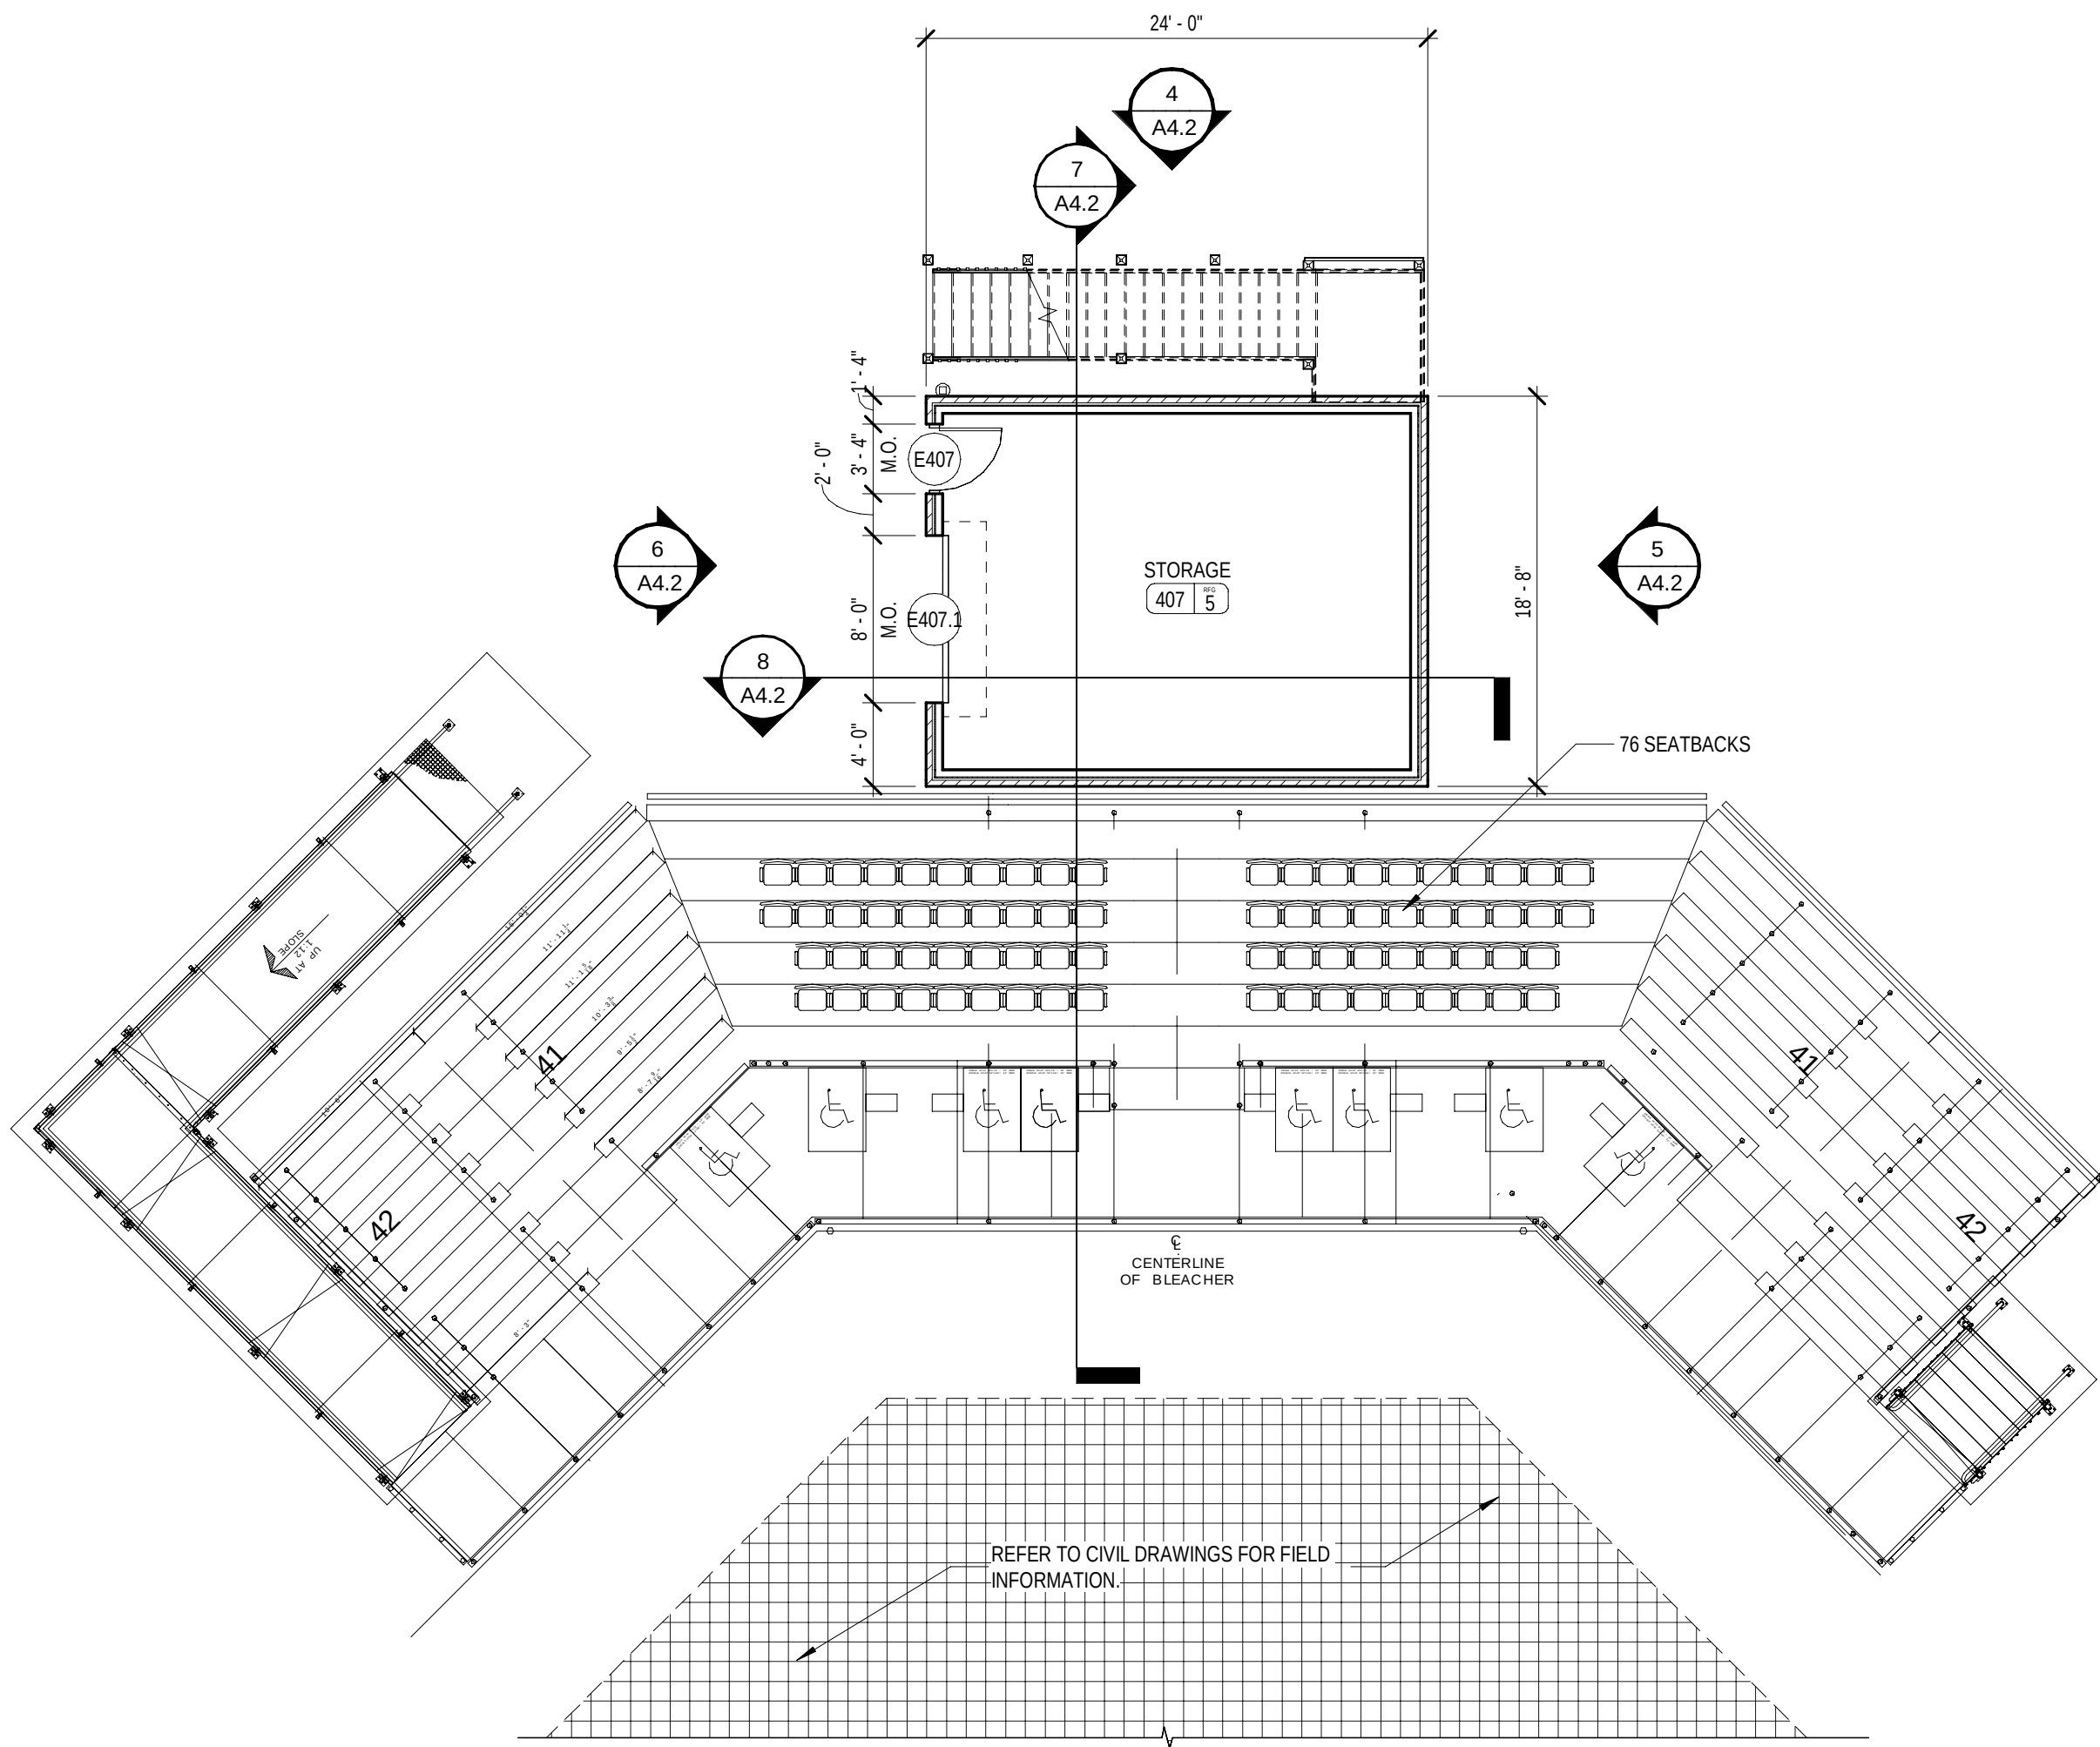


2 FIRST FLOOR NEW WORK PLAN - OPTION 2
1/8" = 1'-0"

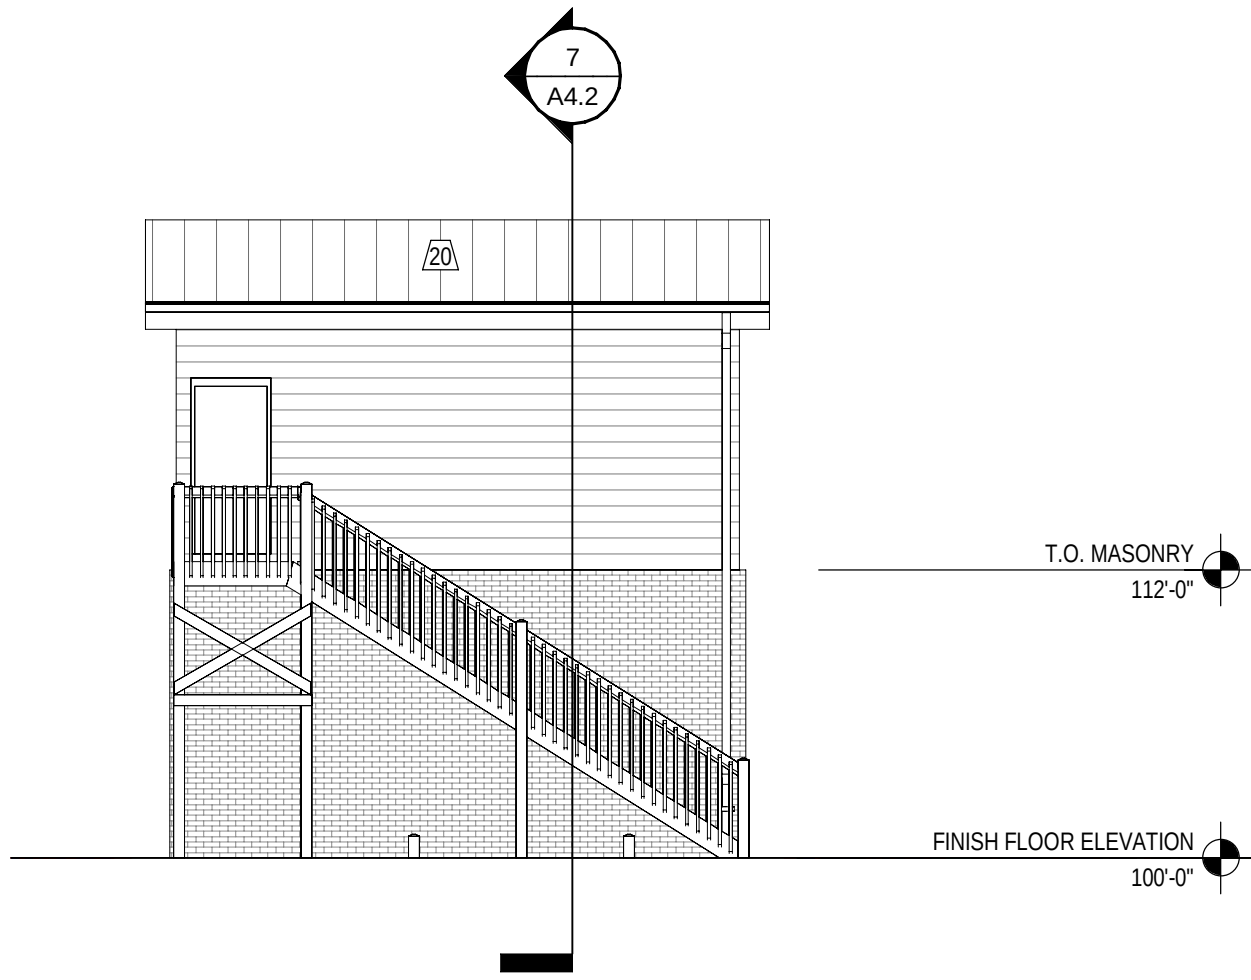



4 400 - BASEBALL PRESSBOX - NORTH ELEVATION
1/8" = 1'-0"


ROOF KEYNOTES
1. ROOF TYPE 'A' REFER TO ROOF LEGEND. 2. ROOF TYPE 'B' REFER TO ROOF LEGEND. 3. PRE-FIN METAL COPING. REFER TO TYP. DETAIL 1/A0.2. 4. PRE-FIN METAL SCUPPER AND DOWNSPOUT. REFER TO DETAILS 2, 3, AND 4/A0.2. 5. PRE-MANUFACTURED WALKWAY COVER. REFER TO DETAIL 11/A0.2. 6. PRE-MANUFACTURED WALL SUPPORTED ALUMINUM CANOPY WITH INTEGRAL DOWNSPOUT 8'-0" x 5'-0" U.N.O. REFER TO DETAILS 12 AND 13/A0.2. 7. MASONRY PIER WITH CAST STONE CAP. REFER TO DETAIL ____. 8. ROOF EXPANSION JOINT. REFER TO DETAIL ____. 9. ROOF EXPANSION JOINT AT 2HR FIRE WALL. REFER TO DETAIL ____. 10. ROOF HATCH. REFER TO DETAIL 11/A0.3. 11. WALKWAY PADS. REFER TO SPECIFICATIONS. 12. CRICKET. TAPER INSULATION 1/4" PER FT. FOR POSITIVE DRAINAGE TO SCUPPER. 13. CRICKET FOR POSITIVE DRAINAGE AROUND ROOF CURB. 14. HVAC UNIT. REFER TO MECHANICAL. SEE 14/A0.2 FOR MECH CURB DETAIL. 15. PEMB RIDGE CAP. 16. PEMB GUTTER ASSEMBLY. 17. PEMB RAKE TRIM ASSEMBLY. 18. PEMB DOWNSPOUT. SEE ELEVATIONS. 19. ROOF TYPE 'C' REFER TO ROOF LEGEND. 20. ROOF TYPE 'D' REFER TO ROOF LEGEND. 21. PRE-FIN METAL, VENTED RIDGE CAP. 22. PRE-FIN METAL, RAKE TRIM. 23. PRE-FIN METAL GUTTER. 24. PRE-FIN METAL DOWNSPOUT. 25. SNOW GUARD.
GENERAL ROOF NOTES
1. ROOF SLOPES ARE 1/4" / 12" UNLESS NOTED OTHERWISE. 2. ALL FLASHING WORK SHALL BE DONE SUCH THAT A WATERTIGHT INSTALLATION IS ACHIEVED AND MAINTAINED. 3. REFER TO STRUCTURAL DWGS. FOR SPECIFIC STRUCTURAL ELEVATION. 4. REFER TO MPE DWGS. FOR ROOF TOP ITEMS NOT SHOWN IN THIS PLAN. 5. FLASH ALL ROOF PENETRATIONS PER MANUFACTURER'S STANDARD DETAILS. 6. REFER TO TYPICAL ROOF DETAILS, SHEET A0.2. 7. CONTRACTOR SHALL NOT COVER ANY WEEPS, BRICK VENTS, EXPANSION JOINTS, FLASHING, OR COPING. ROOFING SHALL TERMINATE AS SHOWN ON DETAILS. 8. CONTRACTOR TO COORDINATE INSTALLATION OF ROOFING/ FLASHING WITH OTHER TRADES FOR ADDITIONAL WORK REQ'D. (I.E. FLASHING OF EQUIPMENT CURBS.) 9. INSTALL ROOF FLASHING TO EXTEND UP FULL HEIGHT OF PARAPET WALLS AND OVER NAILERS UNDER COPING UNLESS NOTED OTHERWISE.
ROOF SYMBOLS LEGEND
ROOF ASSEMBLY - TYPE 'A' THERMOPLASTIC POLYOLEFIN SINGLE PLY MEMBRANE ROOFING OVER 7/16" COVER DECK OVER (4) LAYERS OF 1.2" RIGID POLYISOCYANURATE INSULATION STAGGERED (8" THICKNESS) ON METAL DECK. PROVIDE FINISHED 1/4" SLOPE PER 1'-0". ROOF ASSEMBLY - TYPE 'B' PEMB. METAL ROOF OVER METAL PURLINS, WITH R-5 THERMAL BLOCKS, 8" LOWER LAYER FIBERGLASS BATT INSULATION AND 3" UPPER LAYER FIBERGLASS BATT INSULATION WITH A TOTAL PRE-INSTALLED R-VALUE OF 35. SUSPEND WITH STEEL STRAP AND FABRIC SYSTEM. SLOPE 3:12. ROOF ASSEMBLY - TYPE 'C' STANDING SEAM METAL ROOF SYSTEM OVER SINGLE LAYER OF CONTINUOUS ICE & WATER SHIELD ON SPECIFIED ROOF DECKING OVER LIGHT GA. METAL TRUSSES. ROOF ASSEMBLY - TYPE 'D' STANDING SEAM METAL ROOF SYSTEM OVER SINGLE LAYER OF CONTINUOUS ICE & WATER SHIELD ON SPECIFIED PLYWOOD SHEATHING OVER WD. RAFTERS. --- -- INDICATES 2HR FIRE WALL. SEE PLAN A1.1. INDICATES CRICKET. SLOPE 1/4" PER FOOT IN DIRECTION OF ARROW APPROXIMATE AREA OF ROOF REPAIR, TO BE INVESTIGATED AND REPAIRED BY CONTRACTOR DS DOWNSPOUT. SC SCUPPER AND CONDUCTOR HEAD. EDS EXISTING DOWNSPOUT. RD ROOF DRAIN. REFER TO DETAIL 1/A4.2. ORD OVERFLOW ROOF DRAIN. REFER TO DETAIL 1/A4.2. VTR VENT THRU ROOF. REFER TO DETAIL 2/A4.2. RTU ROOF TOP UNIT. REFER TO MECHANICAL DWGS. AND CURB DETAIL 3/A4.2. EXHAUST FAN / QA HOOD. REFER TO MECH. DWGS.

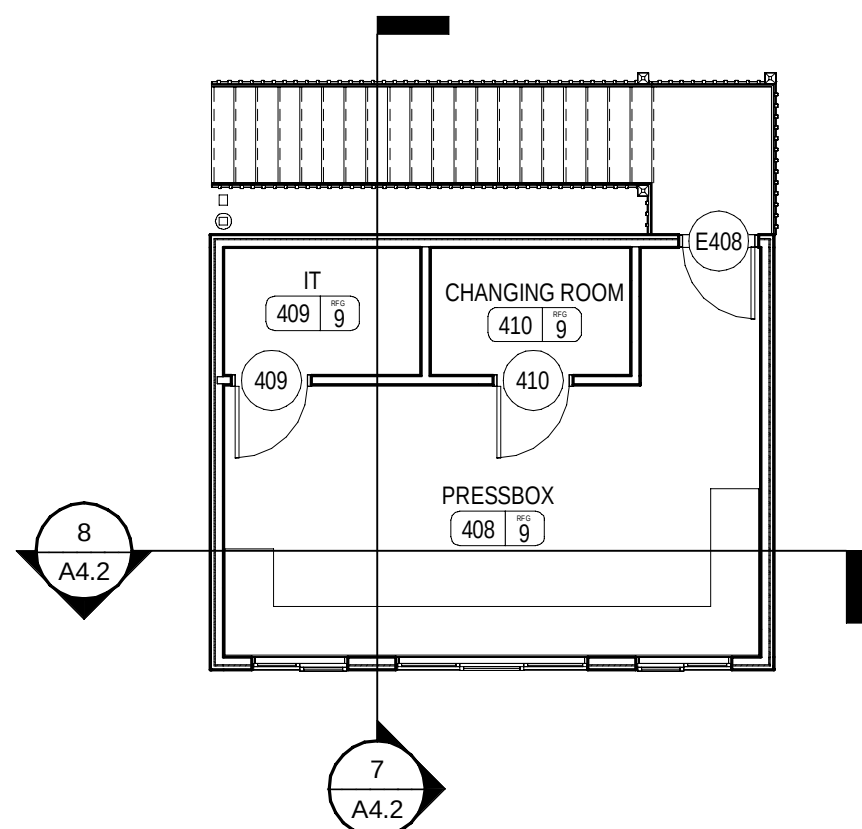


3 SECOND FLOOR NEW WORK PLAN - OPTION 2
1/8" = 1'-0"

FLOOR PLAN KEYNOTES
1. OWNER PROVIDED FURNITURE OR EQUIPMENT (N.I.C.). 2. LINE OF SOFFIT / BULKHEAD ABOVE, REFER TO REFLECTED CEILING PLAN. 3. PRE-MFR. PRE-FIN SUSPENDED ALUMINUM CANOPY. REFER TO DETAIL 11/A4.2. 4. EXTERIOR CONCRETE WALK. REFER TO SITE DRAWINGS. 5. HIGH / LOW ADA COMPLIANT WATER COOLER UNIT. REFER TO MECH. / ELEC. DRAWINGS. 6. MOP SINK. REFER TO PLUMBING DRAWINGS. 7. KNOX-BOX RECESSED IN DOOR. REFER TO DOOR HARDWARE SPECIFICATIONS. 8. FLOOR TRANSITION. REFER TO SHEET A8.1 FOR DETAILS. 9. SHIPS LADDER. REFER TO DETAIL 11/A0.3. 10. DIVIDER CURTAIN. MOTORIZED OPERATOR. REFER TO ELEC. DWGS. 11. 7'-0" TALL X 2" THICK WALL PAD WITH WOOD BACKING. ATTACH TO WALLS / COLUMNS WITH MANUFACTURER'S STANDARD "Z" CLIP SYSTEM. 12. ELECTRIC PUSH-BUTTON ADA DOOR OPERATOR. REFER TO ELEC. DWGS.
GENERAL NOTES
1. (OF-C) OWNER FURNISHED CONTRACTOR INSTALLED. 2. EXISTING TO REMAIN INTERIOR WALLS THAT ARE EXPOSED IN AREAS OF RENOVATION TO BE CLEANED, REPAIRED, PRIMED, AND PAINTED FOR LIKE NEW FINISH. 3. DO NOT SCALE DWGS. WRITTEN DIMENSIONS TAKE PRECEDENCE OVER SCALED DIMENSIONS. 4. INTERIOR MASONRY CONTROL JOINTS TO OCCUR EVERY 20'-0" MAX. 5. NOTE: MARKER BOARD (MB) AND TACK BOARD (TB) INDICATE WIDTH AND ARE TO BE 48" H.
SYMBOL LEGEND
ROOM FINISH GROUPS (REFER TO KEY PLAN SHEETS) ROOM NUMBER DOOR NUMBER (DOOR SCHEDULE SHEET A8.1) KEY NOTES (SHEETS A1.3 THROUGH A2.8) WALL TYPE (SCHEDULE SHEET A0.1) ALUMINUM OR HOLLOW METAL WINDOW OR STOREFRONT TYPE (REFER TO FLOOR PLANS AND SCHEDULE SHEETS A8.2) TOILET ACCESSORIES (SCHEDULE SHEET A2.7) ELEVATION KEY NOTE (SHEETS A3.1) ROOF KEY NOTE (SHEET A4.1) CEILING PLAN KEY NOTE (SHEETS A7.1 THROUGH A7.7) SIGNAGE KEY NOTE (REFER TO KEY PLAN SHEETS) WALL / PARTITION DESIGNATION FW2 2 HOUR RATED FIRE WALL EPW2 EXISTING 2 HOUR RATED FIRE WALL MASONRY CONTROL JOINT FULL HEIGHT OF WALL. REFER TO FLOOR PLANS AND EXTERIOR ELEVATION A3.1 FOR LOCATIONS
KEY PLAN
ATHLETIC COMPLEX (800) AUX GYM ADD. (100) SOCCER (700) FIELD HOUSE (200) BASEBALL (400) CONCESSIONS (300) TRACK AND FIELD (600) SOFTBALL (500) BUILDING NORTH TRUE NORTH

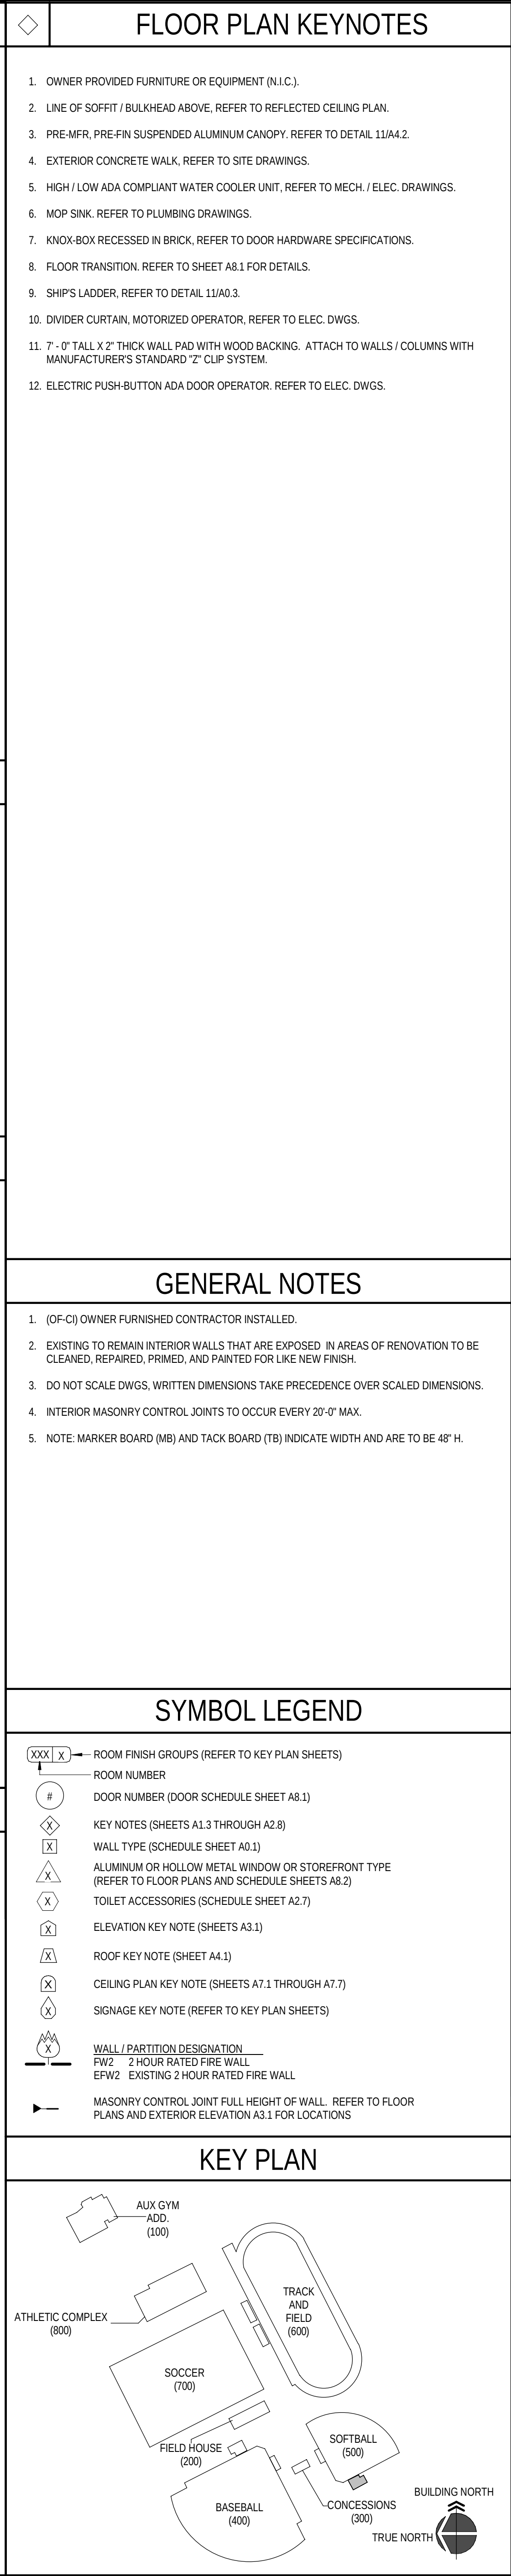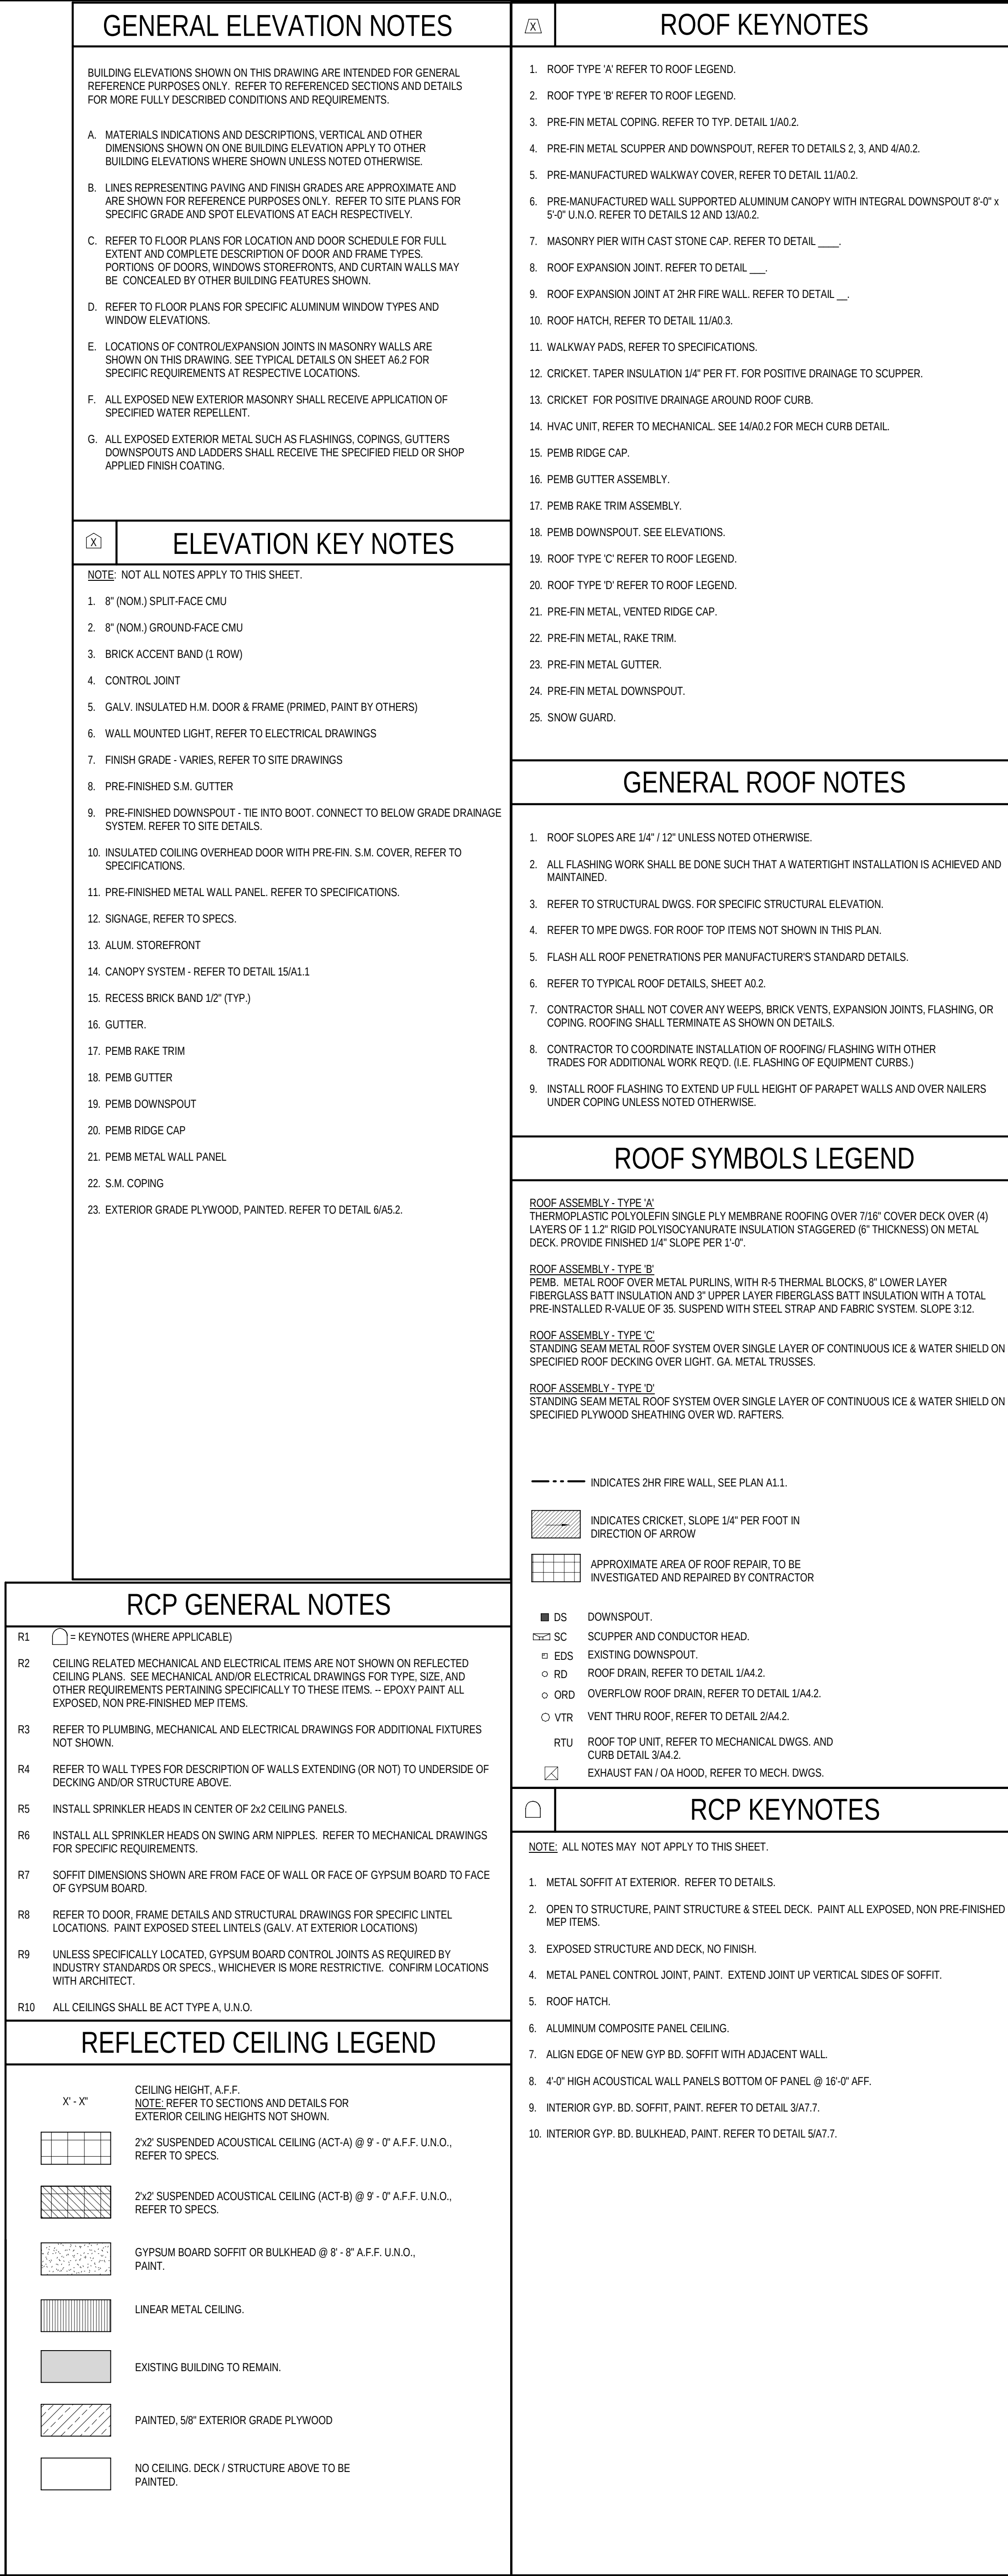


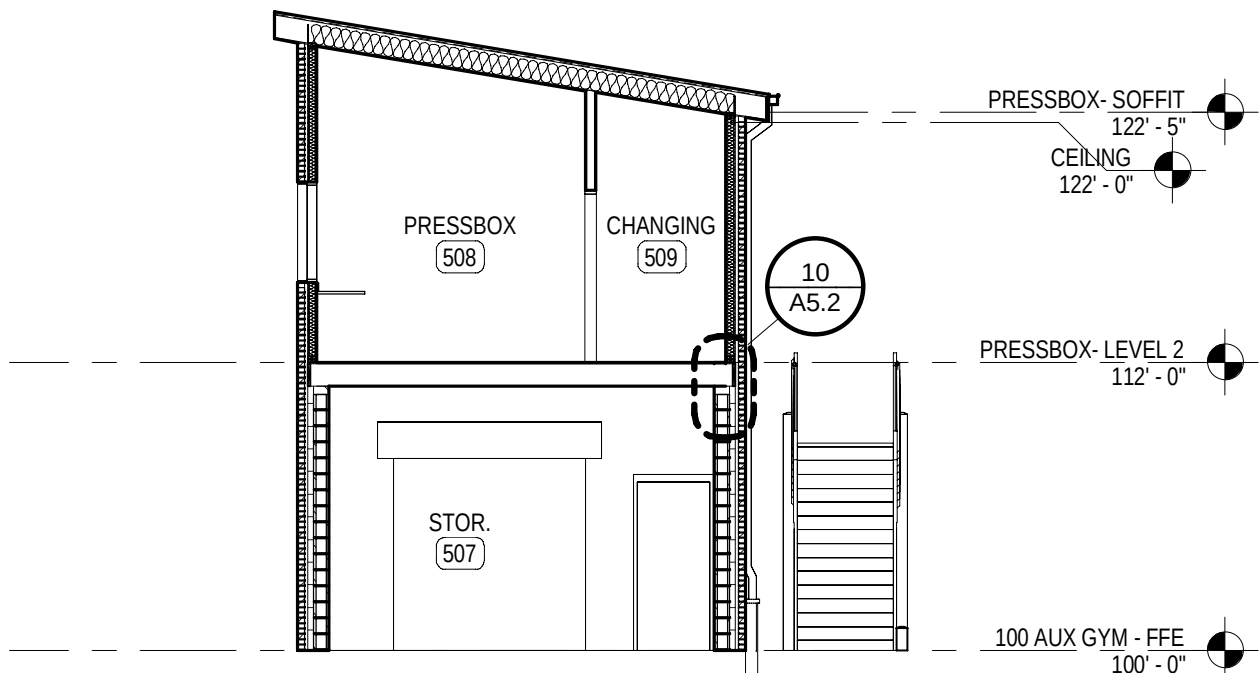


8 500 - SOFTBALL PRESSBOX SECTION 02
1/8" = 1'-0"

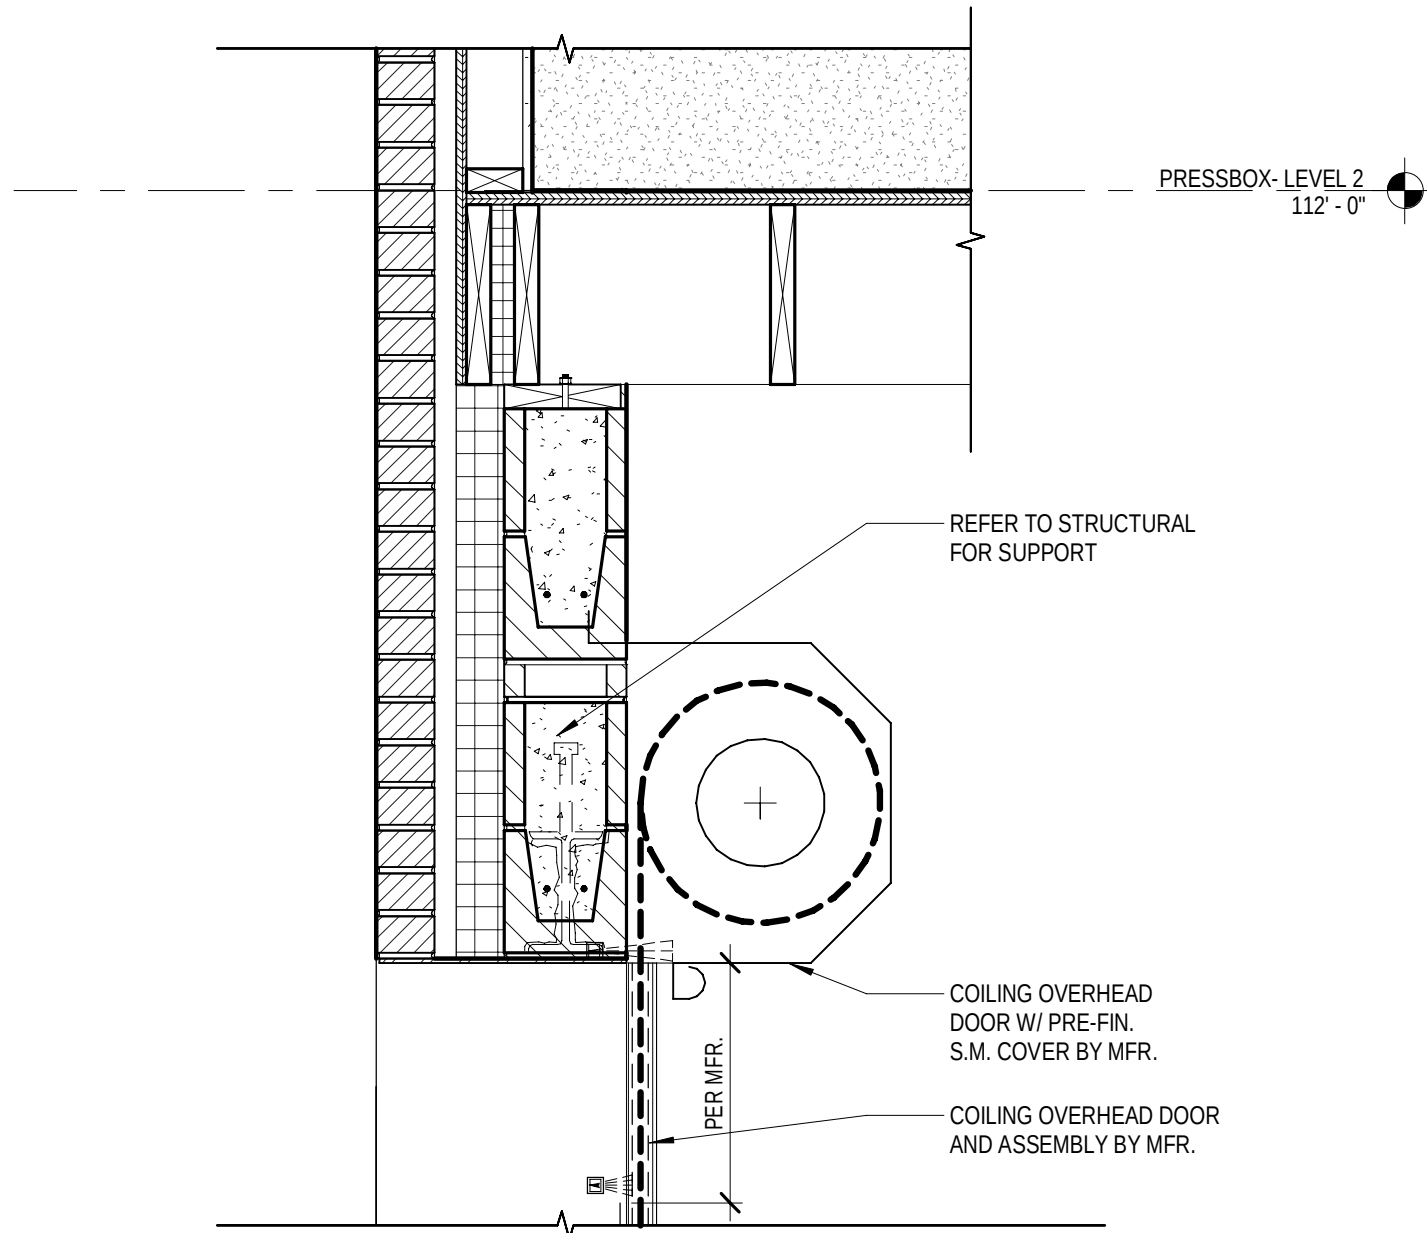


9 SECTION @ COILING DOOR
1" = 1'-0"

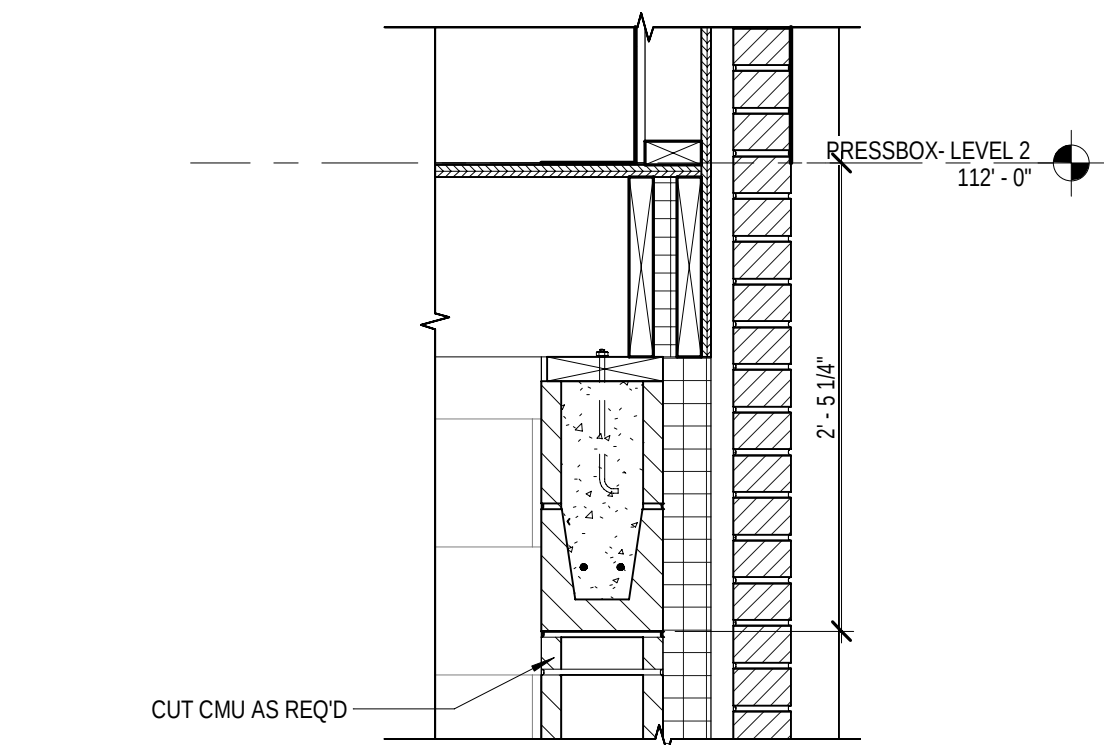


10 DETAIL
1" = 1'-0"

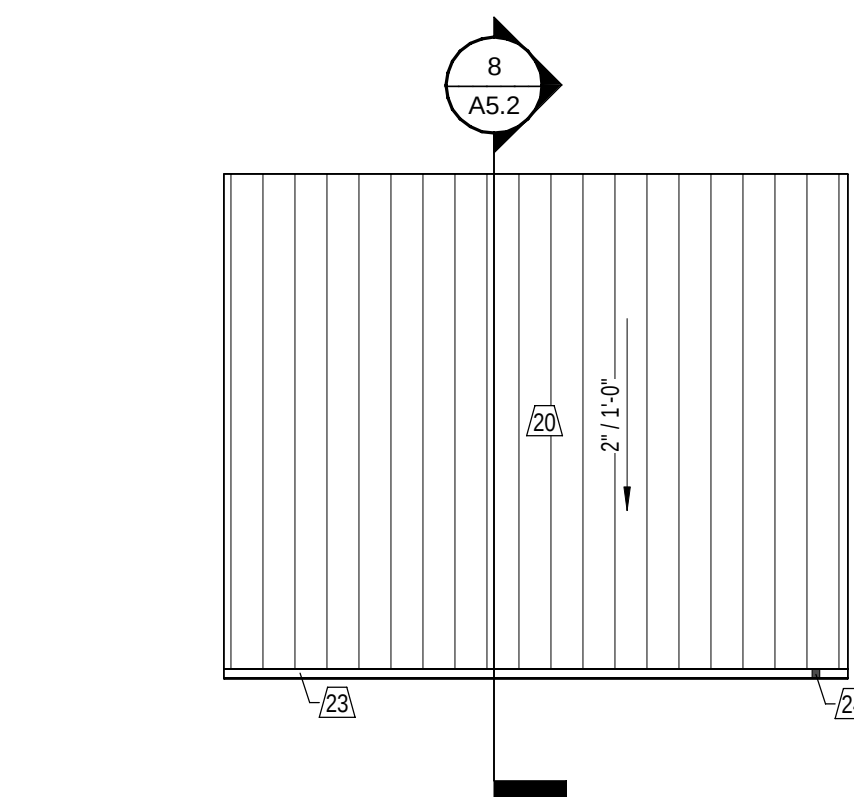


11 500 - SOFTBALL PRESSBOX - ROOF PLAN
1/8" = 1'-0"

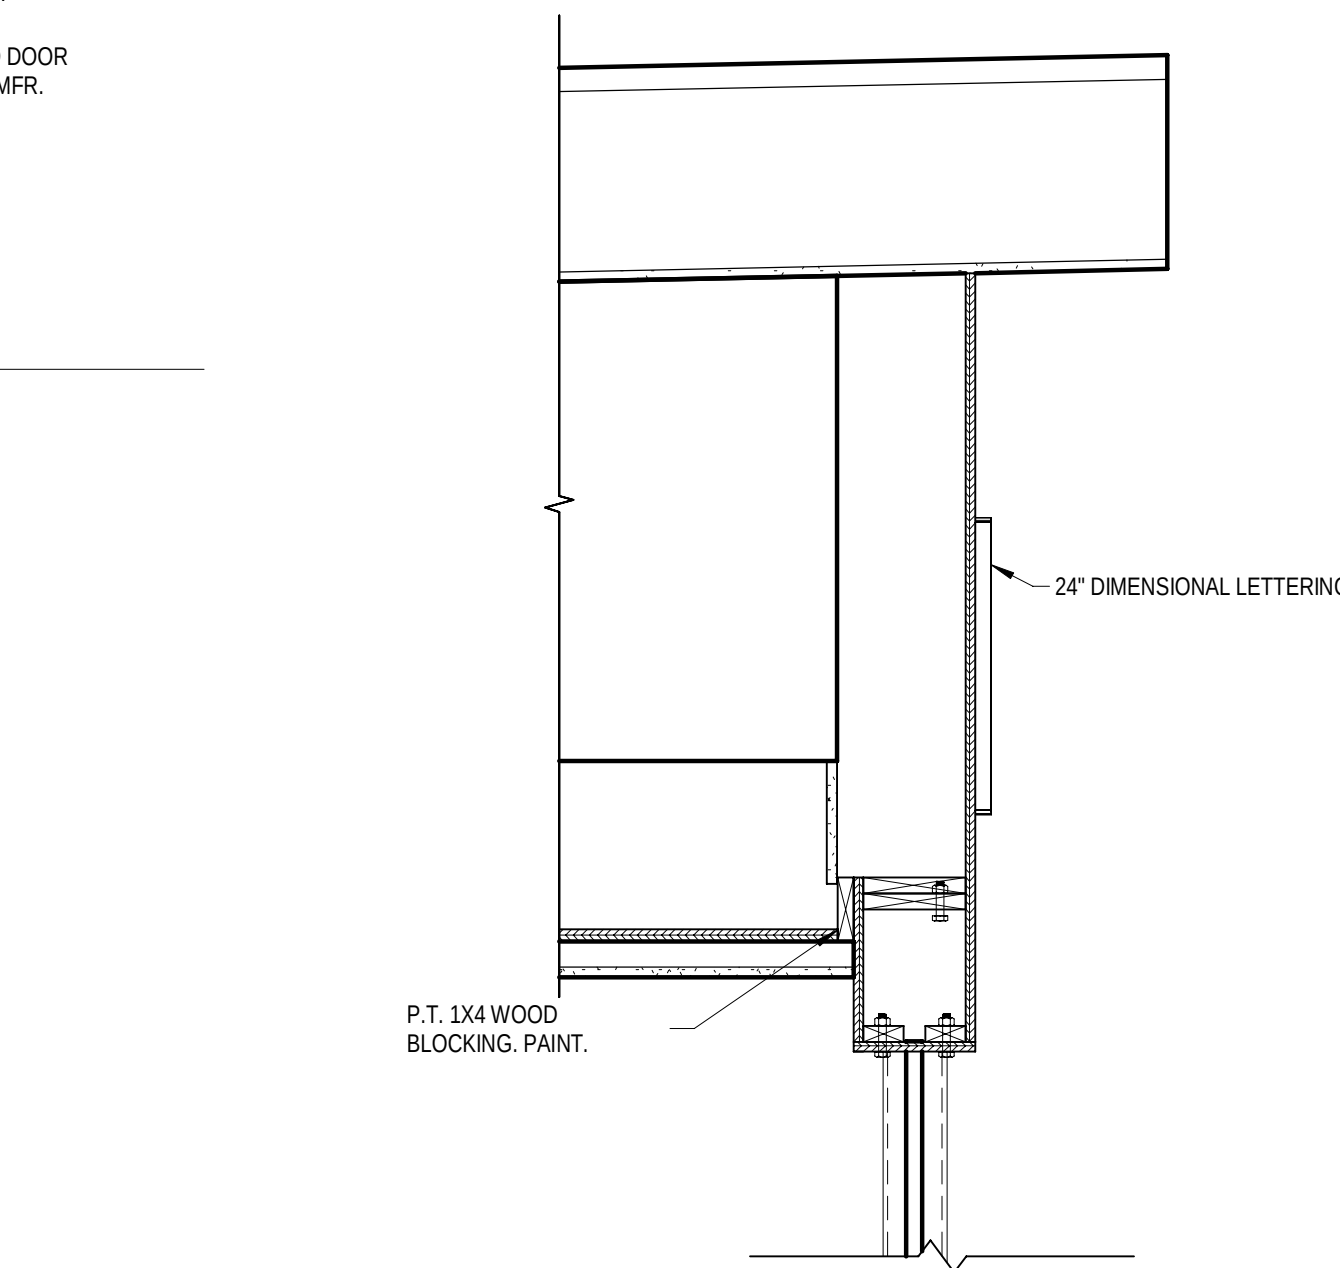


6 400 - DUGOUT SECTION DETAIL
1" = 1'-0"

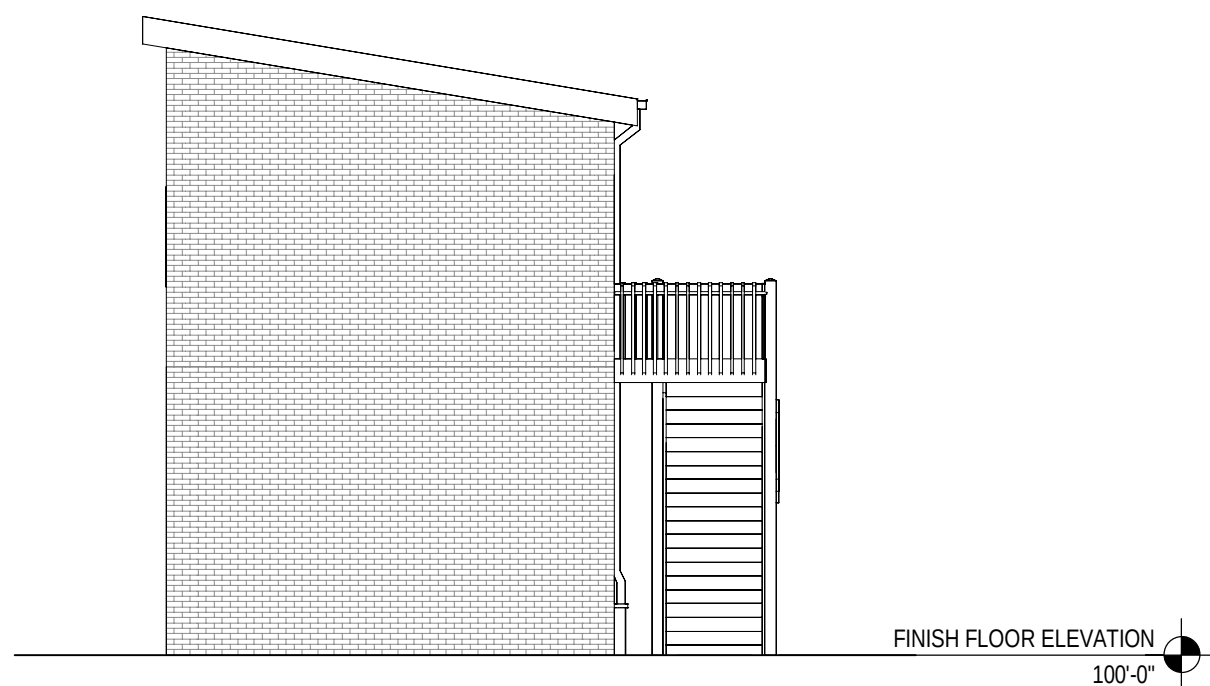


7 500 - SOFTBALL PRESSBOX - WEST ELEVATION
1/8" = 1'-0"

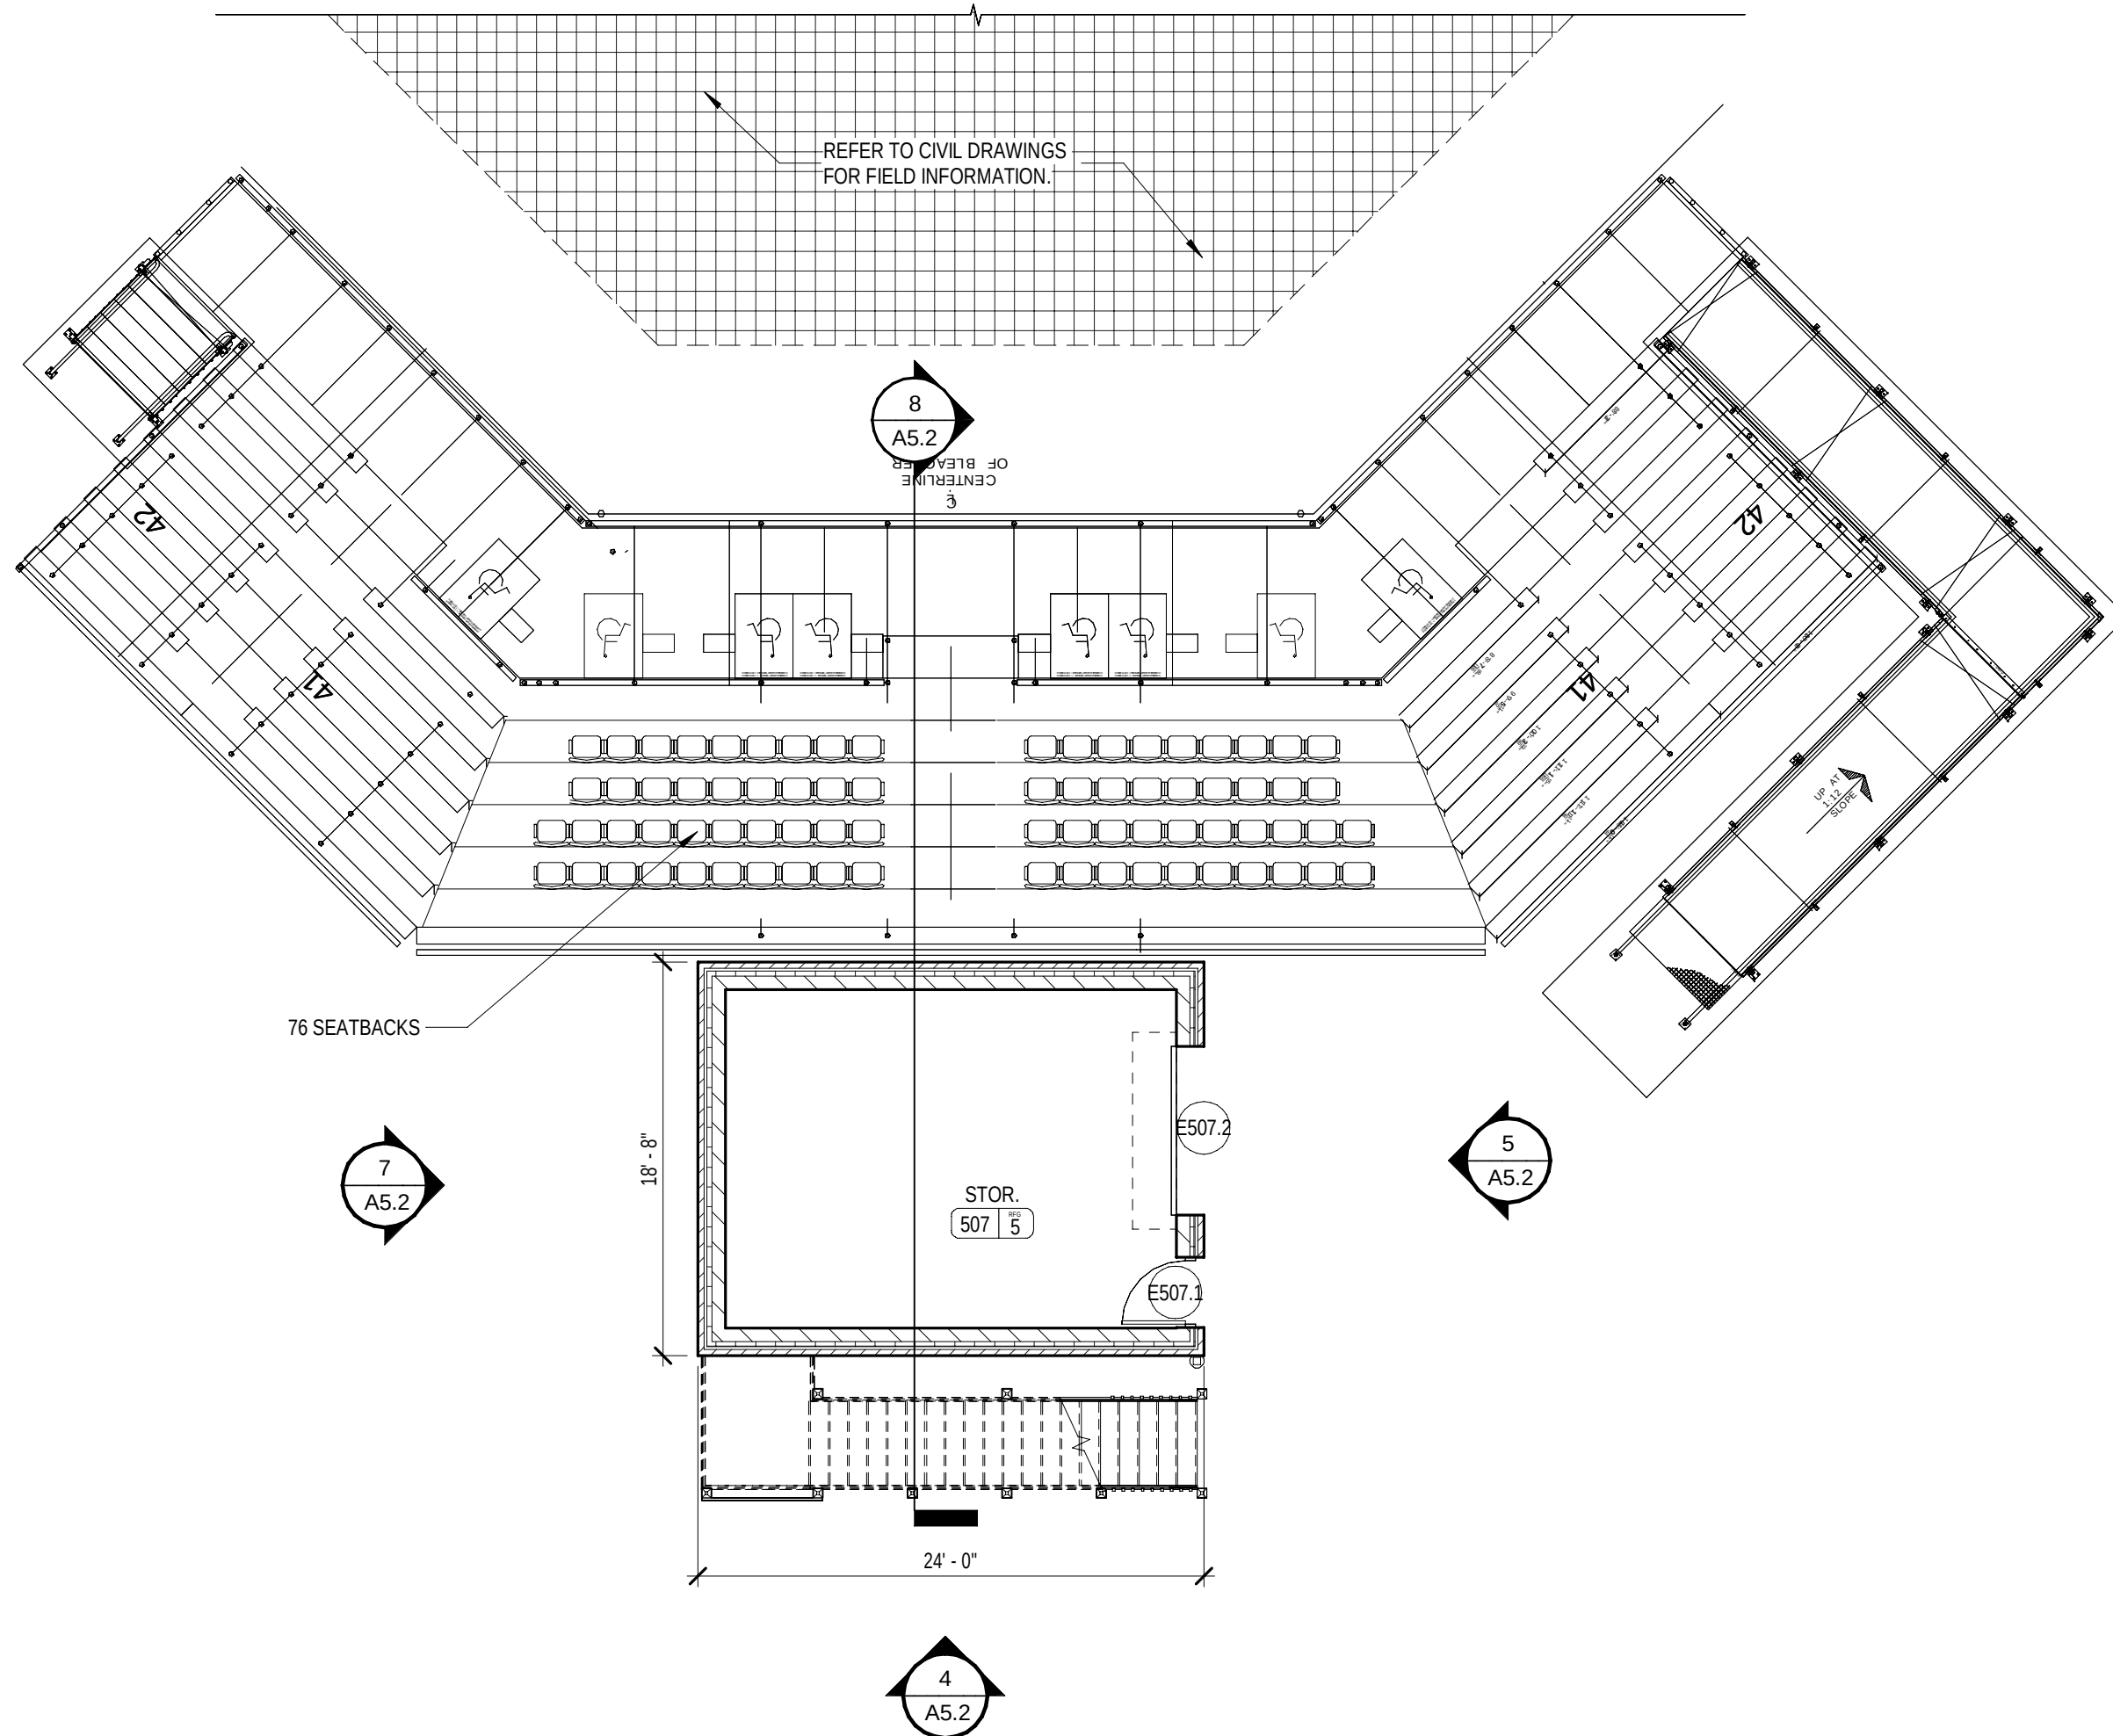

2 FIRST FLOOR NEW WORK PLAN - OPTION 2
1/8" = 1'-0"

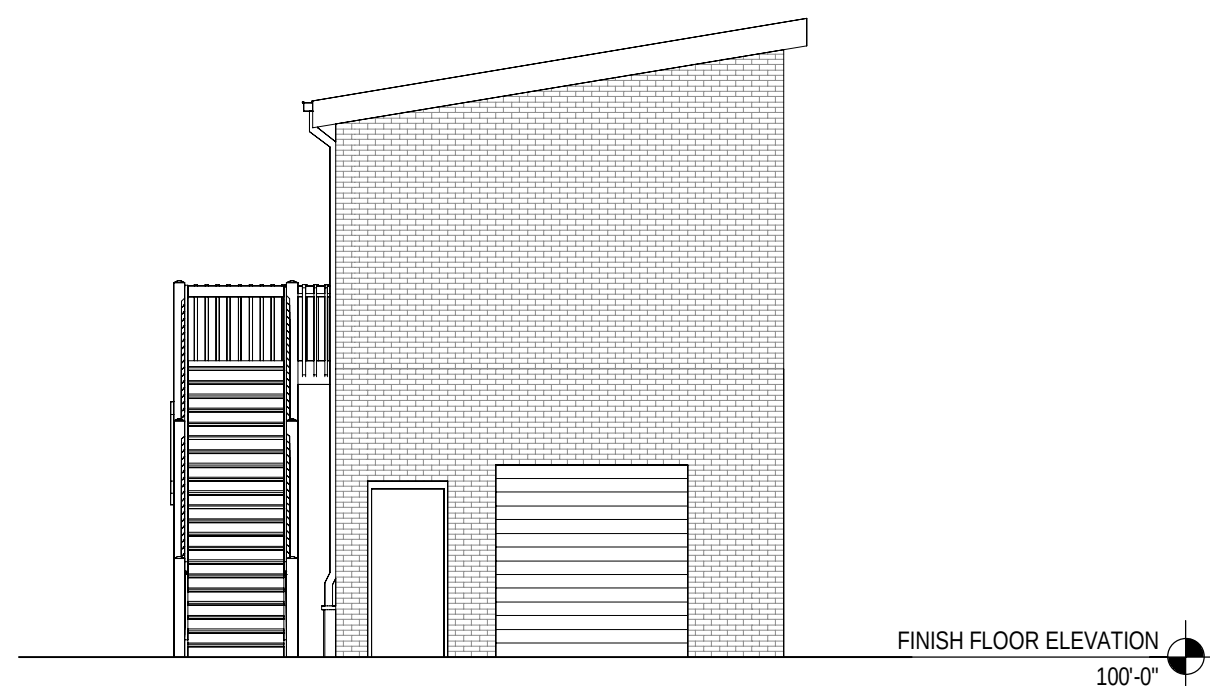

5 500 - SOFTBALL PRESSBOX - EAST ELEVATION
1/8" = 1'-0"

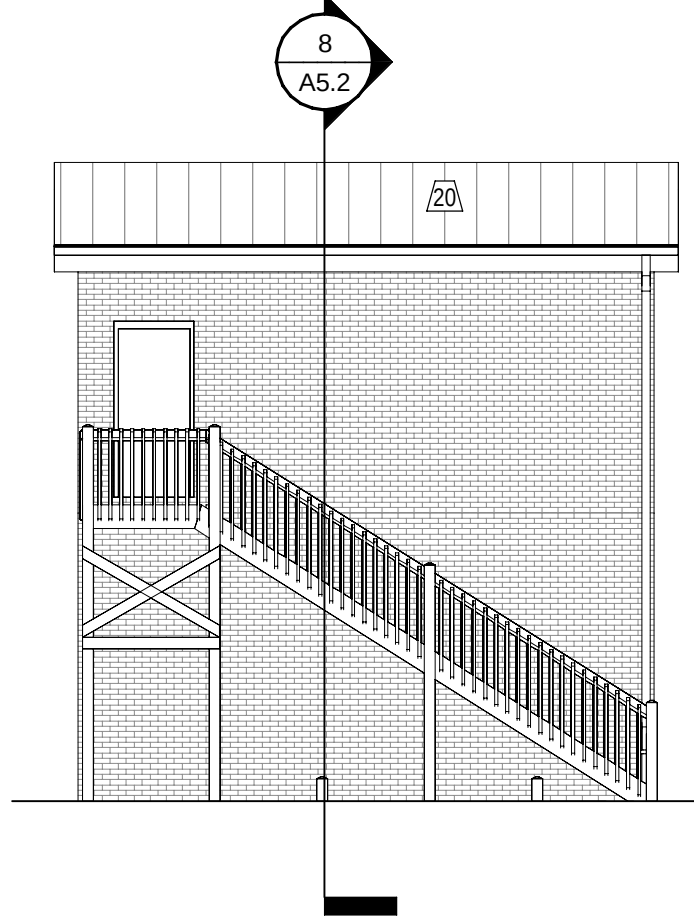

4 500 - SOFTBALL PRESSBOX - SOUTH ELEVATION
1/8" = 1'-0"

ROOF KEYNOTES

1. ROOF TYPE 'A' REFER TO ROOF LEGEND.
2. ROOF TYPE 'B' REFER TO ROOF LEGEND.
3. PRE-FIN METAL COPING, REFER TO TYP. DETAIL 1/A0.2.
4. PRE-FIN METAL SCUPPER AND DOWNSPOUT, REFER TO DETAILS 2, 3, AND 4/A0.2.
5. PRE-MANUFACTURED WALKWAY COVER, REFER TO DETAIL 11/A0.2.
6. PRE-MANUFACTURED WALL SUPPORTED ALUMINUM CANOPY WITH INTEGRAL DOWNSPOUT 8'-0" x 5'-0" U.N.O. REFER TO DETAILS 12 AND 13/A0.2.
7. MASONRY PIER WITH CAST STONE CAP, REFER TO DETAIL ____.
8. ROOF EXPANSION JOINT, REFER TO DETAIL ____.
9. ROOF EXPANSION JOINT AT 2HR FIRE WALL, REFER TO DETAIL ____.
10. ROOF HATCH, REFER TO DETAIL 11/A0.3.
11. WALKWAY PADS, REFER TO SPECIFICATIONS.
12. CRICKET, TAPER INSULATION 1/4" PER FT. FOR POSITIVE DRAINAGE TO SCUPPER.
13. CRICKET FOR POSITIVE DRAINAGE AROUND ROOF CURB.
14. HVAC UNIT, REFER TO MECHANICAL. SEE 14/A0.2 FOR MECH CURB DETAIL.
15. PEMB RIDGE CAP.
16. PEMB GUTTER ASSEMBLY.
17. PEMB RAKE TRIM ASSEMBLY.
18. PEMB DOWNSPOUT, SEE ELEVATIONS.
19. ROOF TYPE 'C' REFER TO ROOF LEGEND.
20. ROOF TYPE 'D' REFER TO ROOF LEGEND.
21. PRE-FIN METAL VENTED RIDGE CAP.
22. PRE-FIN METAL RAKE TRIM.
23. PRE-FIN METAL GUTTER.
24. PRE-FIN METAL DOWNSPOUT.
25. SNOW GUARD.

GENERAL ROOF NOTES

1. ROOF SLOPES ARE 1/4" / 12" UNLESS NOTED OTHERWISE.
2. ALL FLASHING WORK SHALL BE DONE SUCH THAT A WATERTIGHT INSTALLATION IS ACHIEVED AND MAINTAINED.
3. REFER TO STRUCTURAL DWGS. FOR SPECIFIC STRUCTURAL ELEVATION.
4. REFER TO MPE DWGS. FOR ROOF TOP ITEMS NOT SHOWN IN THIS PLAN.
5. FLASH ALL ROOF PENETRATIONS PER MANUFACTURER'S STANDARD DETAILS.
6. REFER TO TYPICAL ROOF DETAILS, SHEET A0.2.
7. CONTRACTOR SHALL NOT COVER ANY WEEPS, BRICK VENTS, EXPANSION JOINTS, FLASHING, OR COPING. ROOFING SHALL TERMINATE AS SHOWN ON DETAILS.
8. CONTRACTOR TO COORDINATE INSTALLATION OF ROOFING/ FLASHING WITH OTHER TRADES FOR ADDITIONAL WORK REQ'D. (I.E. FLASHING OF EQUIPMENT CURBS.)
9. INSTALL ROOF FLASHING TO EXTEND UP FULL HEIGHT OF PARAPET WALLS AND OVER NAILERS UNDER COPING UNLESS NOTED OTHERWISE.

ROOF SYMBOLS LEGEND

- ROOF ASSEMBLY - TYPE 'A': THERMOPLASTIC POLYOLEFIN SINGLE PLY MEMBRANE ROOFING OVER 7/16" COVER DECK OVER (4) LAYERS OF 1 1/2" RIGID POLYISOCYANURATE INSULATION STAGGERED (6" THICKNESS) ON METAL DECK, PROVIDE FINISHED 1/4" SLOPE PER 1'-0".
- ROOF ASSEMBLY - TYPE 'B': METAL ROOF OVER METAL PURLINS, WITH R-5 THERMAL BLOCKS, 8" LOWER LAYER FIBERGLASS BATT INSULATION AND 3" UPPER LAYER FIBERGLASS BATT INSULATION WITH A TOTAL PRE-INSTALLED R-VALUE OF 35. SUSPEND WITH STEEL STRAP AND FABRIC SYSTEM, SLOPE 3:12.
- ROOF ASSEMBLY - TYPE 'C': STANDING SEAM METAL ROOF SYSTEM OVER SINGLE LAYER OF CONTINUOUS ICE & WATER SHIELD ON SPECIFIED ROOF DECKING OVER LIGHT, GA. METAL TRUSSES.
- ROOF ASSEMBLY - TYPE 'D': STANDING SEAM METAL ROOF SYSTEM OVER SINGLE LAYER OF CONTINUOUS ICE & WATER SHIELD ON SPECIFIED PLYWOOD SHEATHING OVER WD. RAFTERS.
- INDICATES 2HR FIRE WALL, SEE PLAN A1.1.
- INDICATES CRICKET, SLOPE 1/4" PER FOOT IN DIRECTION OF ARROW
- APPROXIMATE AREA OF ROOF REPAIR, TO BE INVESTIGATED AND REPAIRED BY CONTRACTOR
- DS DOWNSPOUT.
- SC SCUPPER AND CONDUCTOR HEAD.
- EDS EXISTING DOWNSPOUT.
- RD ROOF DRAIN, REFER TO DETAIL 1/A4.2.
- ORD OVERFLOW ROOF DRAIN, REFER TO DETAIL 1/A4.2.
- VTR VENT THRU ROOF, REFER TO DETAIL 2/A4.2.
- RTU ROOF TOP UNIT, REFER TO MECHANICAL DWGS. AND CURB DETAIL 3/A4.2.
- EXHAUST FAN / OA HOOD, REFER TO MECH. DWGS.

FLOOR PLAN KEYNOTES

1. OWNER PROVIDED FURNITURE OR EQUIPMENT (N.I.C.).
2. LINE OF SOFFIT / BULKHEAD ABOVE, REFER TO REFLECTED CEILING PLAN.
3. PRE-MFR, PRE-FIN SUSPENDED ALUMINUM CANOPY, REFER TO DETAIL 11/A4.2.
4. EXTERIOR CONCRETE WALK, REFER TO SITE DRAWINGS.
5. HIGH / LOW ADA COMPLIANT WATER COOLER UNIT, REFER TO MECH. / ELEC. DRAWINGS.
6. MOP SINK, REFER TO PLUMBING DRAWINGS.
7. KNOX-BOX RECESSED IN BRICK, REFER TO DOOR HARDWARE SPECIFICATIONS.
8. FLOOR TRANSITION, REFER TO SHEET A8.1 FOR DETAILS.
9. SHIPS LADDER, REFER TO DETAIL 11/A0.3.
10. DIVIDER CURTAIN, MOTORIZED OPERATOR, REFER TO ELEC. DWGS.
11. 7'-0" TALL X 2" THICK WALL PAD WITH WOOD BACKING, ATTACH TO WALLS / COLUMNS WITH MANUFACTURER'S STANDARD "Z" CLIP SYSTEM.
12. ELECTRIC PUSH-BUTTON ADA DOOR OPERATOR, REFER TO ELEC. DWGS.


GENERAL NOTES

1. (OF-C) OWNER FURNISHED CONTRACTOR INSTALLED.
2. EXISTING TO REMAIN INTERIOR WALLS THAT ARE EXPOSED IN AREAS OF RENOVATION TO BE CLEANED, REPAIRED, PRIMED, AND PAINTED FOR LIKE NEW FINISH.
3. DO NOT SCALE DWGS, WRITTEN DIMENSIONS TAKE PRECEDENCE OVER SCALED DIMENSIONS.
4. INTERIOR MASONRY CONTROL JOINTS TO OCCUR EVERY 20'-0" MAX.
5. NOTE: MARKER BOARD (MB) AND TACK BOARD (TB) INDICATE WIDTH AND ARE TO BE 48" H.

SYMBOL LEGEND

- ROOM FINISH GROUPS (REFER TO KEY PLAN SHEETS)
- ROOM NUMBER
- DOOR NUMBER (DOOR SCHEDULE SHEET A8.1)
- KEY NOTES (SHEETS A1.3 THROUGH A2.8)
- WALL TYPE (SCHEDULE SHEET A0.1)
- ALUMINUM OR HOLLOW METAL WINDOW OR STOREFRONT TYPE (REFER TO FLOOR PLANS AND SCHEDULE SHEETS A8.2)
- TOILET ACCESSORIES (SCHEDULE SHEET A2.7)
- ELEVATION KEY NOTE (SHEETS A3.1)
- ROOF KEY NOTE (SHEET A4.1)
- CEILING PLAN KEY NOTE (SHEETS A7.1 THROUGH A7.7)
- SIGNAGE KEY NOTE (REFER TO KEY PLAN SHEETS)
- WALL / PARTITION DESIGNATION
- FW2 2 HOUR RATED FIRE WALL
- EFW2 EXISTING 2 HOUR RATED FIRE WALL
- MASONRY CONTROL JOINT FULL HEIGHT OF WALL, REFER TO FLOOR PLANS AND EXTERIOR ELEVATION A3.1 FOR LOCATIONS

KEY PLAN

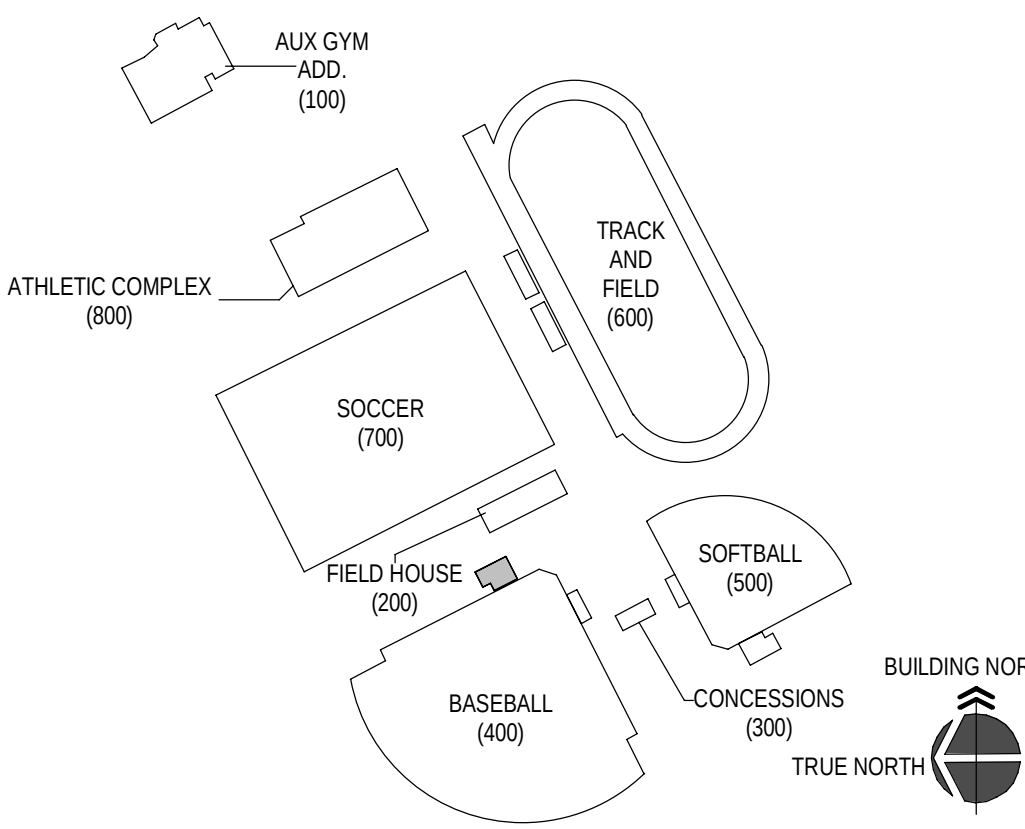

JOB NO.	2469
DATE	12/15/2025
DRAWN	CAH
CHECKED	RJV, ASC

COPYRIGHT © 2025
SHERMAN CARTER BARNHART
ARCHITECTS, PLLC


REVISIONS

No.	Description	Date



SHEET

2469 ALLEN COUNTY - SCOTTSVILLE HIGH SCHOOL ATHLETIC COMPLEX
12/15/2025 9:56:18 AM

2 600 - DEMOLITION PLAN
1/8" = 1'-0"

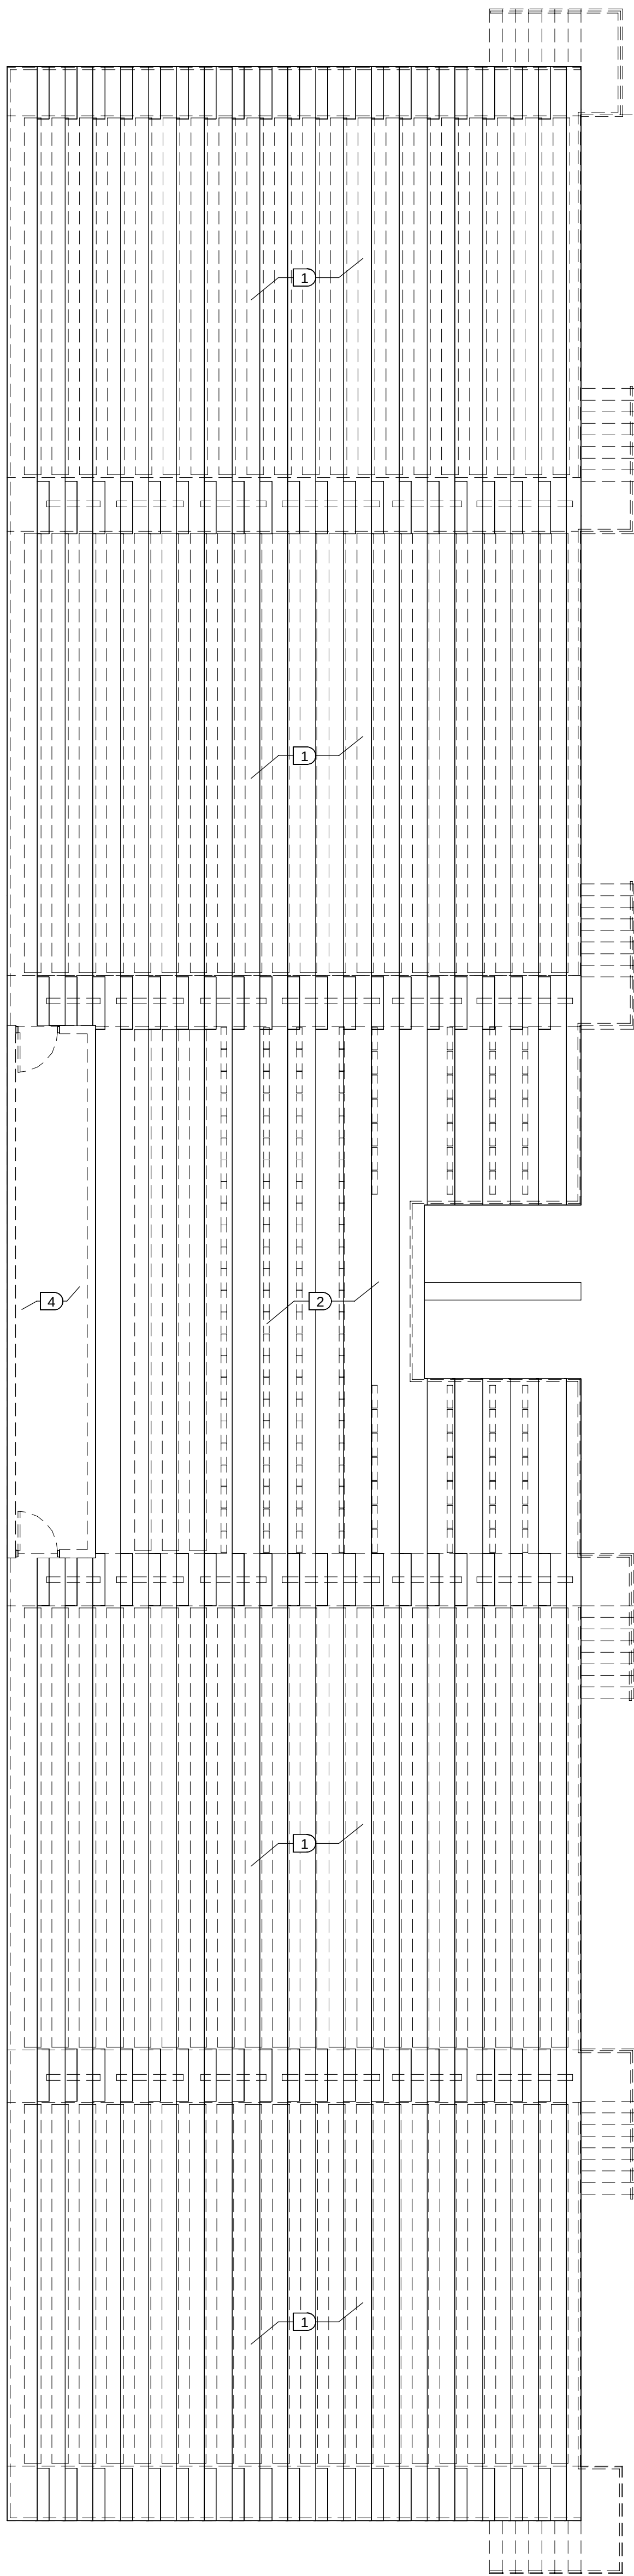

1 600 - FIRST FLOOR DEMOLITION PLAN
1/8" = 1'-0"

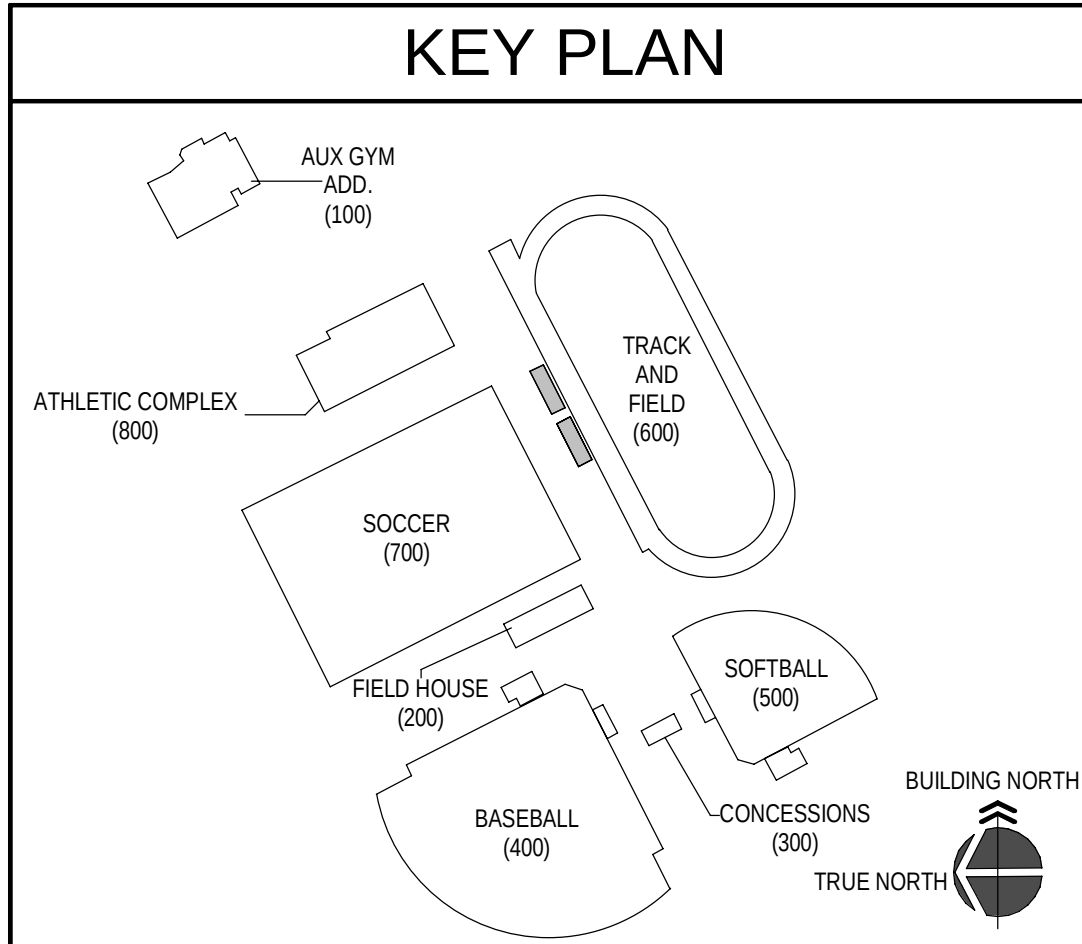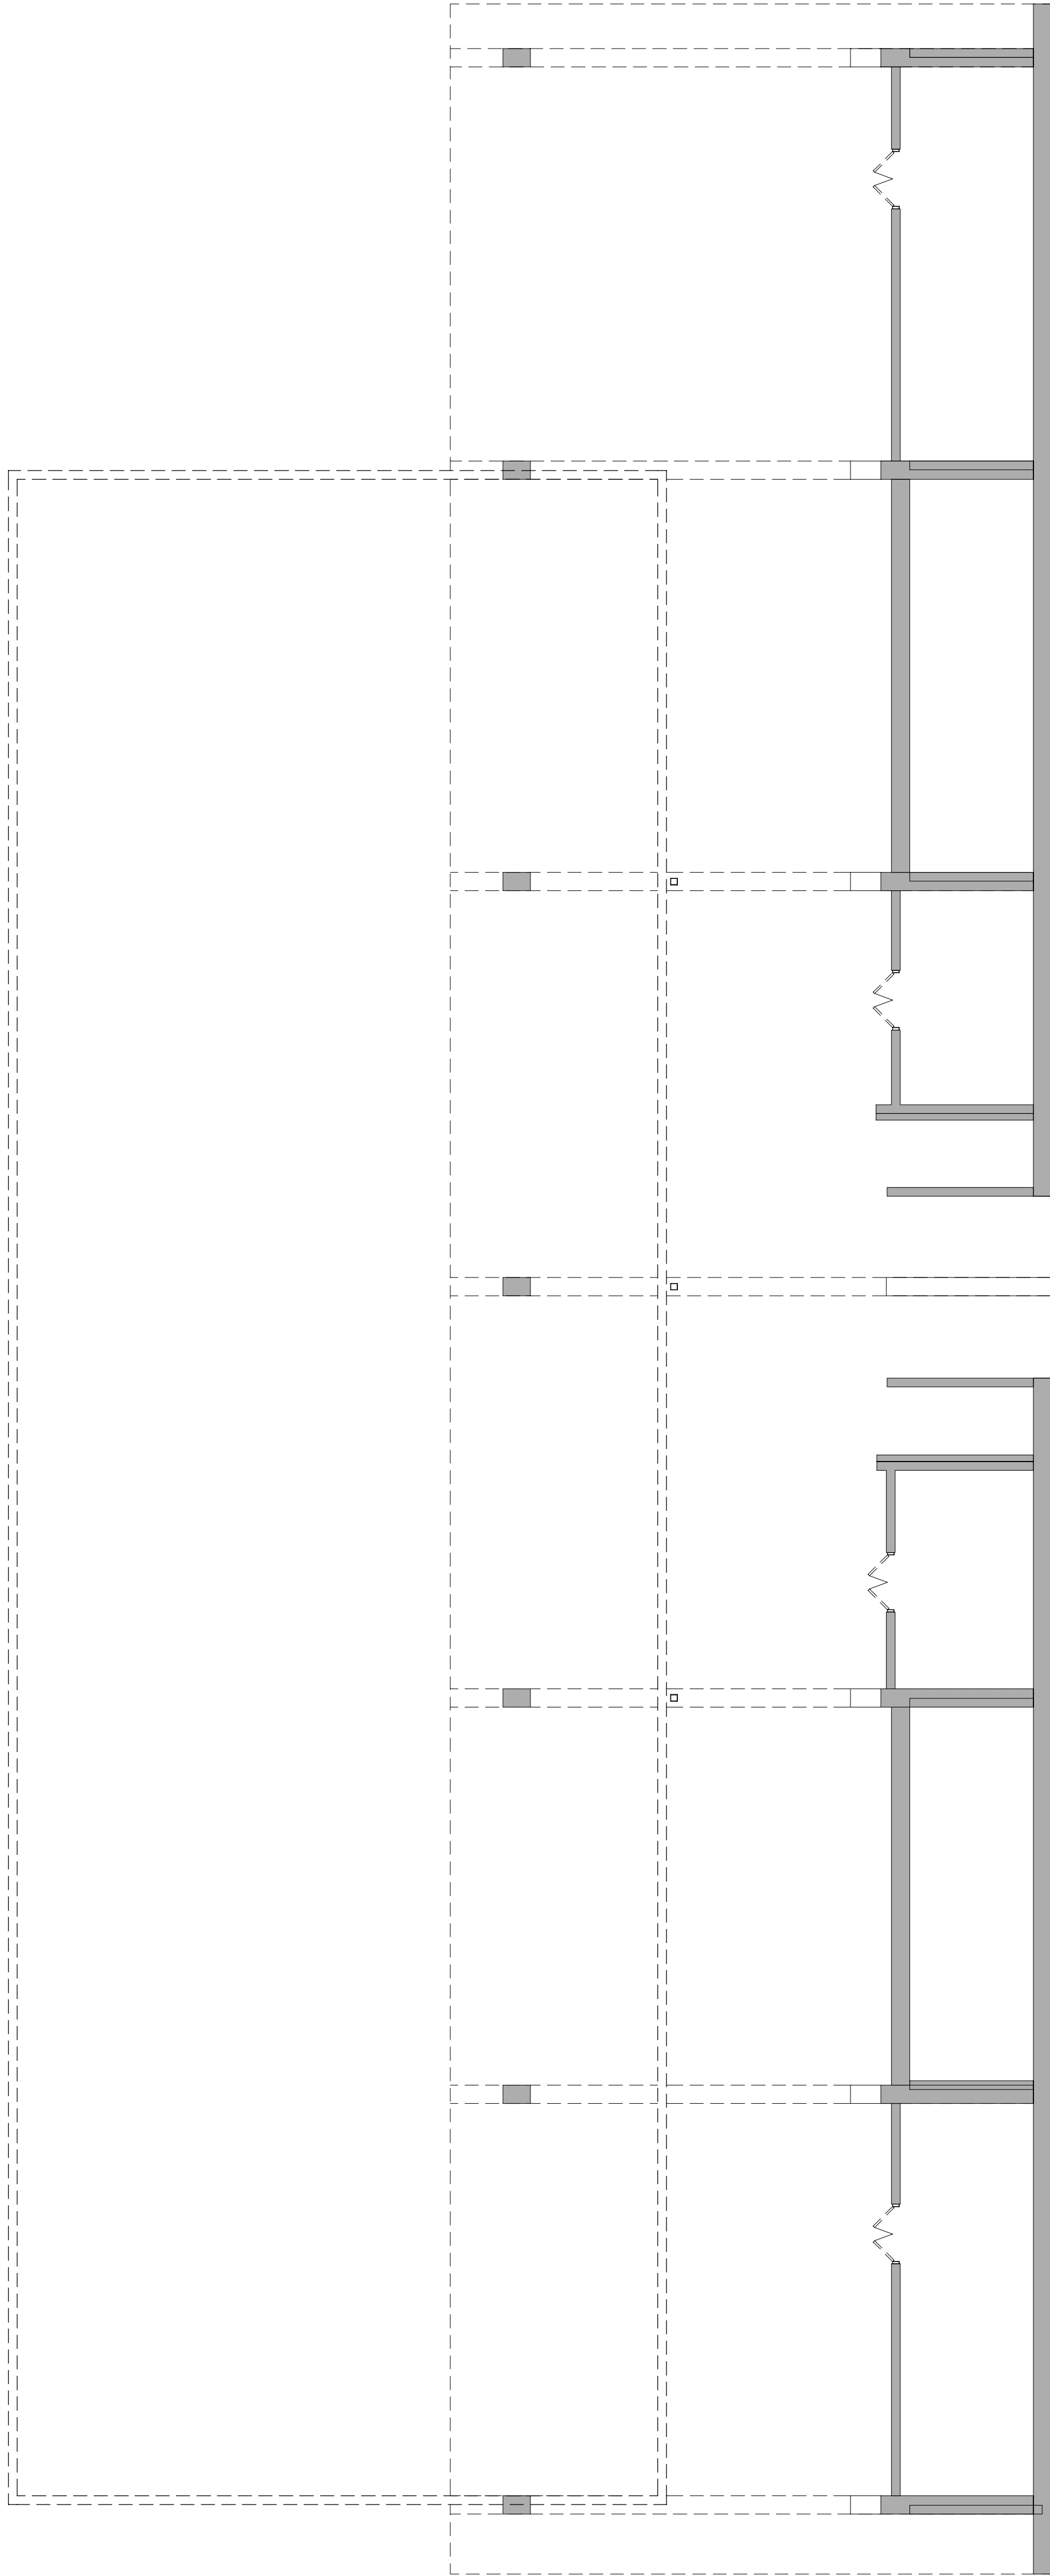

D	DEMOLITION KEY NOTES
	1. DEMOLISH EXISTING HANDRAILS IN THEIR ENTIRETY. 2. DEMOLISH EXISTING CANOPY STRUCTURE AND ALL COMPONENTS TO FACILITATE NEW WORK IN THIS AREA. 3. REMOVE EXISTING CORNICE STOOP & STEPS, REFER TO SITE DEMOLITION DWGS FOR ADDITIONAL INFO. 4. REMOVE EXISTING CONCRETE SIDEWALK, REFER TO SITE DEMOLITION DWGS. 5. REMOVE EXISTING ALUMINUM STOREFRONT WINDOW SYSTEM. 6. REMOVE A PORTION OF EXISTING EIFS SOFFIT @ EXTERIOR OF EXISTING CAFETERIA. 7. REMOVE EXISTING ALUMINUM STOREFRONT DOOR SYSTEM.
	GENERAL DEMOLITION NOTES
	A. ALL EXISTING SUSPENDED CEILINGS TO BE REMOVED, COORDINATE WITH PHASING PLANS AND MEP WORK. B. DEMOLITION REFERENCE NOTES FOR THIS PROJECT ARE INTENDED TO GENERALLY IDENTIFY THE SELECTIVE REMOVAL OF EXISTING ITEMS AT LOCATIONS WHERE REQUIRED BUT, SHALL IN NO WAY RELIEVE THE CONTRACTOR OF THE FULL RESPONSIBILITY FOR EXAMINING AND VERIFYING THE FULL EXTENT OF EXISTING CONDITIONS PRIOR TO BIDDING THE PROJECT. C. THE INTENT OF THE DEMOLITION NOTES IS TO PROVIDE A GENERAL OUTLINE FOR THE CONTRACTOR OF ITEMS TO BE REMOVED AND/OR TURNED OVER TO THE OWNER AND TO ALLOW FOR THE NEW CONSTRUCTION AS OUTLINED ELSEWHERE IN THE CONTRACT DOCUMENTS. THE CONTRACTOR SHALL BE RESPONSIBLE FOR ALL DEMOLITION AND REMOVAL OF ITEMS TO ALLOW FOR NEW CONSTRUCTION SHOWN OR NOT SHOWN ON DEMOLITION PLANS AS MAY BE REQUIRED. D. CAVITY WALLS AND SPACES BEHIND EXTERIOR FINISHES OR PARTIALLY REMOVED WALLS/ROOFS, ETC. SHALL BE PROTECTED FROM EXPOSURE TO WEATHER BY THE CONTRACTOR. WALLS/ROOFS, ETC. SHALL BE PROTECTED. THE CONTRACTOR SHALL BE RESPONSIBLE FOR ANY DAMAGED WALLS, ROOFS, EQUIPMENT, ETC. CAUSED BY THIS DEMOLITION OR WEATHER EXPOSURE OF ITEMS THAT ARE TO REMAIN. E. INFORMATION AND DRAWINGS INCLUDED IN THESE CONTRACT DOCUMENTS PERTAINING TO THIS RENOVATION PROJECT HAVE BEEN OBTAINED FROM ORIGINAL DRAWINGS PROVIDED BY MEADE COUNTY BOARD OF EDUCATION AND FIELD OBSERVATIONS. THIS INFORMATION IS INCLUDED HEREIN WITH THE INTENT TO PROVIDE THE CONTRACTOR WITH A BASIC UNDERSTANDING OF EXISTING CONDITIONS. ACTUAL CONDITIONS AND DIMENSIONS MAY VARY FROM THOSE INDICATED ON DRAWINGS. F. REFER TO STRUCTURAL DRAWINGS FOR SPECIFIC REQUIREMENTS AT EXISTING CONDITIONS REQUIRING PARTIAL OR COMPLETE REMOVAL AND/OR MODIFICATION TO COMPONENTS OR ASSEMBLIES PERTAINING TO EXISTING BUILDING STRUCTURE. G. REFER TO MECHANICAL AND/OR ELECTRICAL DRAWINGS AND SPECIFICATIONS FOR SPECIFIC REQUIREMENTS PERTAINING TO THE REMOVAL, RELOCATION AND/OR MODIFICATION OF ITEMS RELATED TO EXISTING MECHANICAL AND ELECTRICAL SYSTEMS. H. SHOULD THE CONTRACTOR ENCOUNTER ANY MATERIALS DURING SELECTIVE DEMOLITION AND NEW WORK WHICH ARE SUSPECTED BY THE CONTRACTOR TO BE OF AN UNKNOWN OR QUESTIONABLE COMPOSITION WITH RESPECT TO CONTAINING CONTAMINANTS WHICH MAY BE HAZARDOUS TO HUMAN HEALTH, THE CONTRACTOR SHALL IMMEDIATELY NOTIFY THE OWNER OF SUCH FINDINGS. I. WHERE AN EXISTING WALL IS REMOVED AND NO NEW WALL IS SHOWN TO BE INSTALLED, REMOVE EXISTING WALL TO 8 INCHES BELOW ADJACENT FLOOR SLAB. PATCH AND REPAIR SLAB AS REQUIRED FOR INSTALLATION OF NEW FLOOR FINISH. REFER TO NEW WORK PLANS. J. ALL AREAS LEFT EXPOSED AS A RESULT OF DEMOLITION AND/OR EQUIPMENT REMOVAL SHALL BE PATCHED AND REPAIRED TO RESULT IN A FLUSH SMOOTH SURFACE PREPARED TO RECEIVE NEW FINISHES AS SCHEDULED. ANY AREAS OF OPENINGS IN MASONRY WALLS LARGER THAN 2' EXPOSED TO VIEW SHALL BE PATCHED WITH SOAPED IN CMU UNITS TOOTHED-IN INTO EXISTING MASONRY. K. CONTRACTOR SHALL BE RESPONSIBLE FOR ALL PATCHING AND REPAIRING DUE TO DEMOLITION AND/OR REMOVAL OF EQUIPMENT TO CREATE A FLUSH, SMOOTH SURFACE PROPERLY PREPARED TO RECEIVE NEW FINISHES AS SCHEDULED. CONTRACTOR SHALL SOAP IN NEW CMU TO MATCH EXISTING ADJACENT AREAS. L. REFER TO MECHELEC DRAWINGS FOR SPECIFIC NOTES REGARDING REMOVAL OF EXISTING MECHELEC ITEMS NOT SHOWN ON THIS SHEET. M. REFER TO STRUCTURAL DRAWINGS FOR NEW WORK (I.E. NEW FOOTING, ETC.) WHICH MAY REQUIRE DEMOLITION WORK IN ADDITION TO ITEMS NOTED ON THE ARCHITECTURAL DRAWINGS ALL SUCH WORK SHALL BE PERFORMED BY THE CONTRACTOR. N. REFER TO CIVIL/SITE DRAWINGS FOR ADDITIONAL DEMOLITION OF SITE/CIVIL ITEMS NOT SHOWN.
	HAZARDOUS MATERIAL NOTES
	DUE TO THE AGE OF THE EXISTING BUILDING, IT IS POSSIBLE HAZARDOUS MATERIALS MAY EXIST, INCLUDING, BUT NOT LIMITED TO ASBESTOS PRODUCTS, POLYCHLORINATED BIPHENYL (PCB) AND OTHER TOXIC SUBSTANCES. IF ANY WORK PERSON ENCOUNTERS ANY MATERIAL WHICH THEY SUSPECT MIGHT BE HAZARDOUS OR TOXIC, THEY SHALL IMMEDIATELY ADVISE THE OWNER. THE CONTRACTOR SHALL TAKE IMMEDIATE AND APPROPRIATE ACTION TO PROTECT THE BUILDING USERS AND WORKERS IN ACCORDANCE WITH FEDERAL, STATE AND LOCAL LAWS, CODES AND REGULATIONS. THE ARCHITECT AND ARCHITECT'S CONSULTANTS SHALL HAVE NO RESPONSIBILITY FOR THE DISCOVERY, PRESENCE, HANDLING, REMOVAL OR DISPOSAL OF OR EXPOSURE OF PERSONS TO HAZARDOUS MATERIALS IN ANY FORM AT THE PROJECT SITE, INCLUDING BUT NOT LIMITED TO ASBESTOS, ASBESTOS PRODUCTS, POLYCHLORINATED BIPHENYL (PCB) OR OTHER TOXIC SUBSTANCES. 1. THE CONTRACTOR IS HEREBY ADVISED THAT SHERMAN-CARTER-BARNHART, PLLC IS NOT A DESIGN PROFESSIONAL IN THE DETERMINATION OF THE PRESENCE OF HAZARDOUS MATERIALS, NOR IS SHERMAN-CARTER-BARNHART, PLLC A DESIGN PROFESSIONAL INVOLVED IN MAKING RECOMMENDATIONS REGARDING THE TESTING, REMOVAL, INCAPSULATION OR OTHER CORRECTIVE MEASURES PERTAINING TO HAZARDOUS MATERIALS. 2. IF THE WORK WHICH IS TO BE PERFORMED UNDER THE CONTRACT INTERFACES IN ANY WAY WITH THE EXISTING COMPONENTS WHICH CONTAIN HAZARDOUS MATERIALS, IT IS THE CONTRACTOR'S RESPONSIBILITY TO CONTACT THE OWNER'S ENVIRONMENTAL CONSULTANT REGARDING THE PROPER MEANS AND METHODS TO BE UTILIZED WITH HAZARDOUS MATERIALS. 3. BY EXECUTION OF THE CONTRACT FOR CONSTRUCTION, THE CONTRACTOR HEREBY AGREES TO BRING NO CLAIM FOR NEGLIGENCE, BREACH OF CONTRACT, INDEMNITY OR OTHERWISE AGAINST THE ARCHITECT, HIS PRINCIPALS, EMPLOYEES, AGENTS OR CONSULTANTS IF SUCH A CLAIM IN ANY WAY WOULD INVOLVE THE INVESTIGATION OF OR REMEDIAL WORK RELATED TO HAZARDOUS MATERIALS IN THE PROJECT. 4. BY EXECUTION OF THE CONTRACT FOR CONSTRUCTION, THE CONTRACTOR FURTHER AGREES TO DEFEND, INDEMNIFY AND HOLD THE ARCHITECT, HIS PRINCIPALS, EMPLOYEES, AGENTS AND CONSULTANTS HARMLESS FROM ANY SUCH ASBESTOS OR OTHER HAZARDOUS MATERIALS RELATED CLAIMS THAT MAY BE BROUGHT BY THE CONTRACTOR'S SUBCONTRACTORS, SUPPLIERS OR OTHER THIRD PARTIES WHO MAY BE ACTING UNDER THE DIRECTION OF THE CONTRACTOR PURSUANT TO THIS PROJECT.
	DEMOLITION SYMBOL LEGEND
	DEMOLITION KEY NOTE EXISTING WALL / CONSTRUCTION TO REMAIN EXISTING CONSTRUCTION TO BE REMOVED - FULL HEIGHT U.N.O. SEE SELECTIVE DEMOLITION NOTES EXISTING DOOR / DOOR & FRAME TO REMAIN EXISTING DOOR / DOOR & FRAME TO BE REMOVED, U.N.O. LIMITED TO NO ARCHITECTURAL WORK - EXISTING FINISHES TO REMAIN U.N.O. REFER TO MEP FOR MEP WORK THAT MAY BE REQUIRED.

SHERMAN
CARTER
BARNHART
ARCHITECTS

DD SET
- NOT FOR -
CONSTRUCTION


ALLEN COUNTY - SCOTTSVILLE
HIGH SCHOOL ATHLETIC
COMPLEX
SCOTTSVILLE, KENTUCKY

GRANDSTANDS DEMOLITION PLANS


JOB NO.	2459	
DATE	12/15/2025	
DRAWN	CAH	
CHECKED	RJV , ASC	
COPYRIGHT © 2025 SHERMAN CARTER BARNHART ARCHITECTS, PLLC		
REVISIONS		
No.	Description	Date

SHEET


A6.0

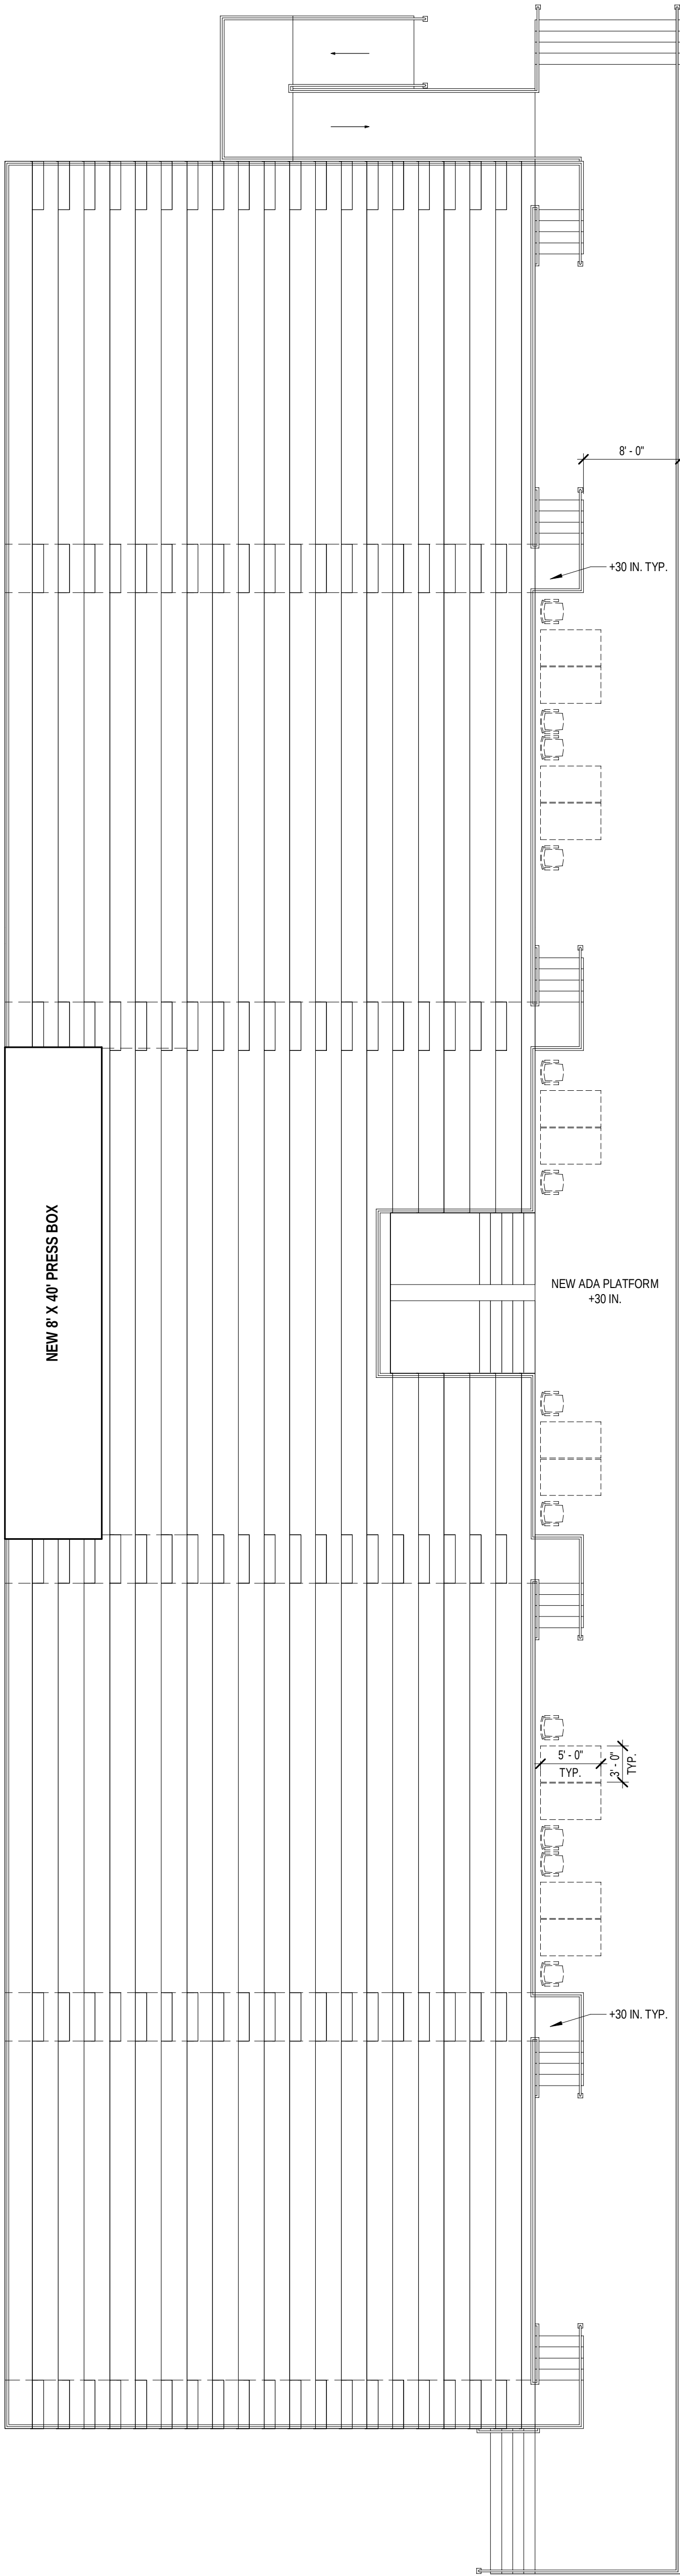

3 600 - NEW WORK PLAN
1/8" = 1'-0"

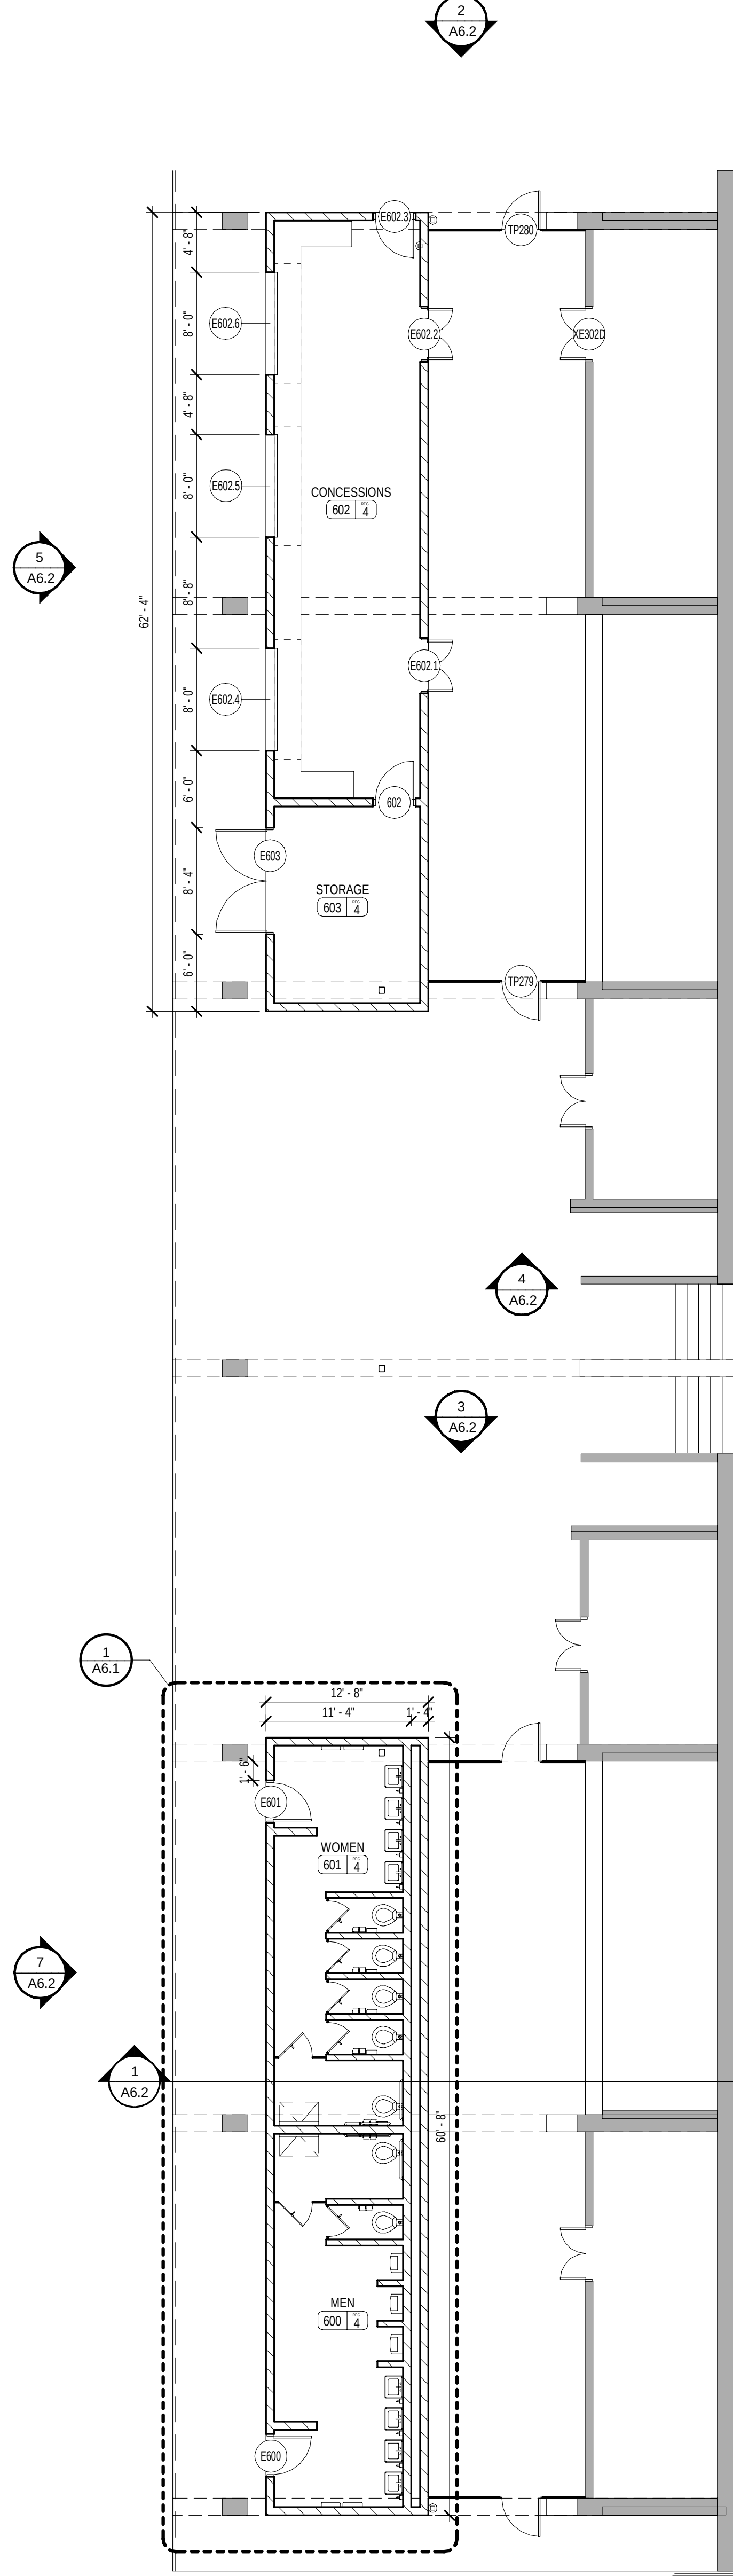

2 600 - FIRST FLOOR NEW WORK PLAN
1/8" = 1'-0"

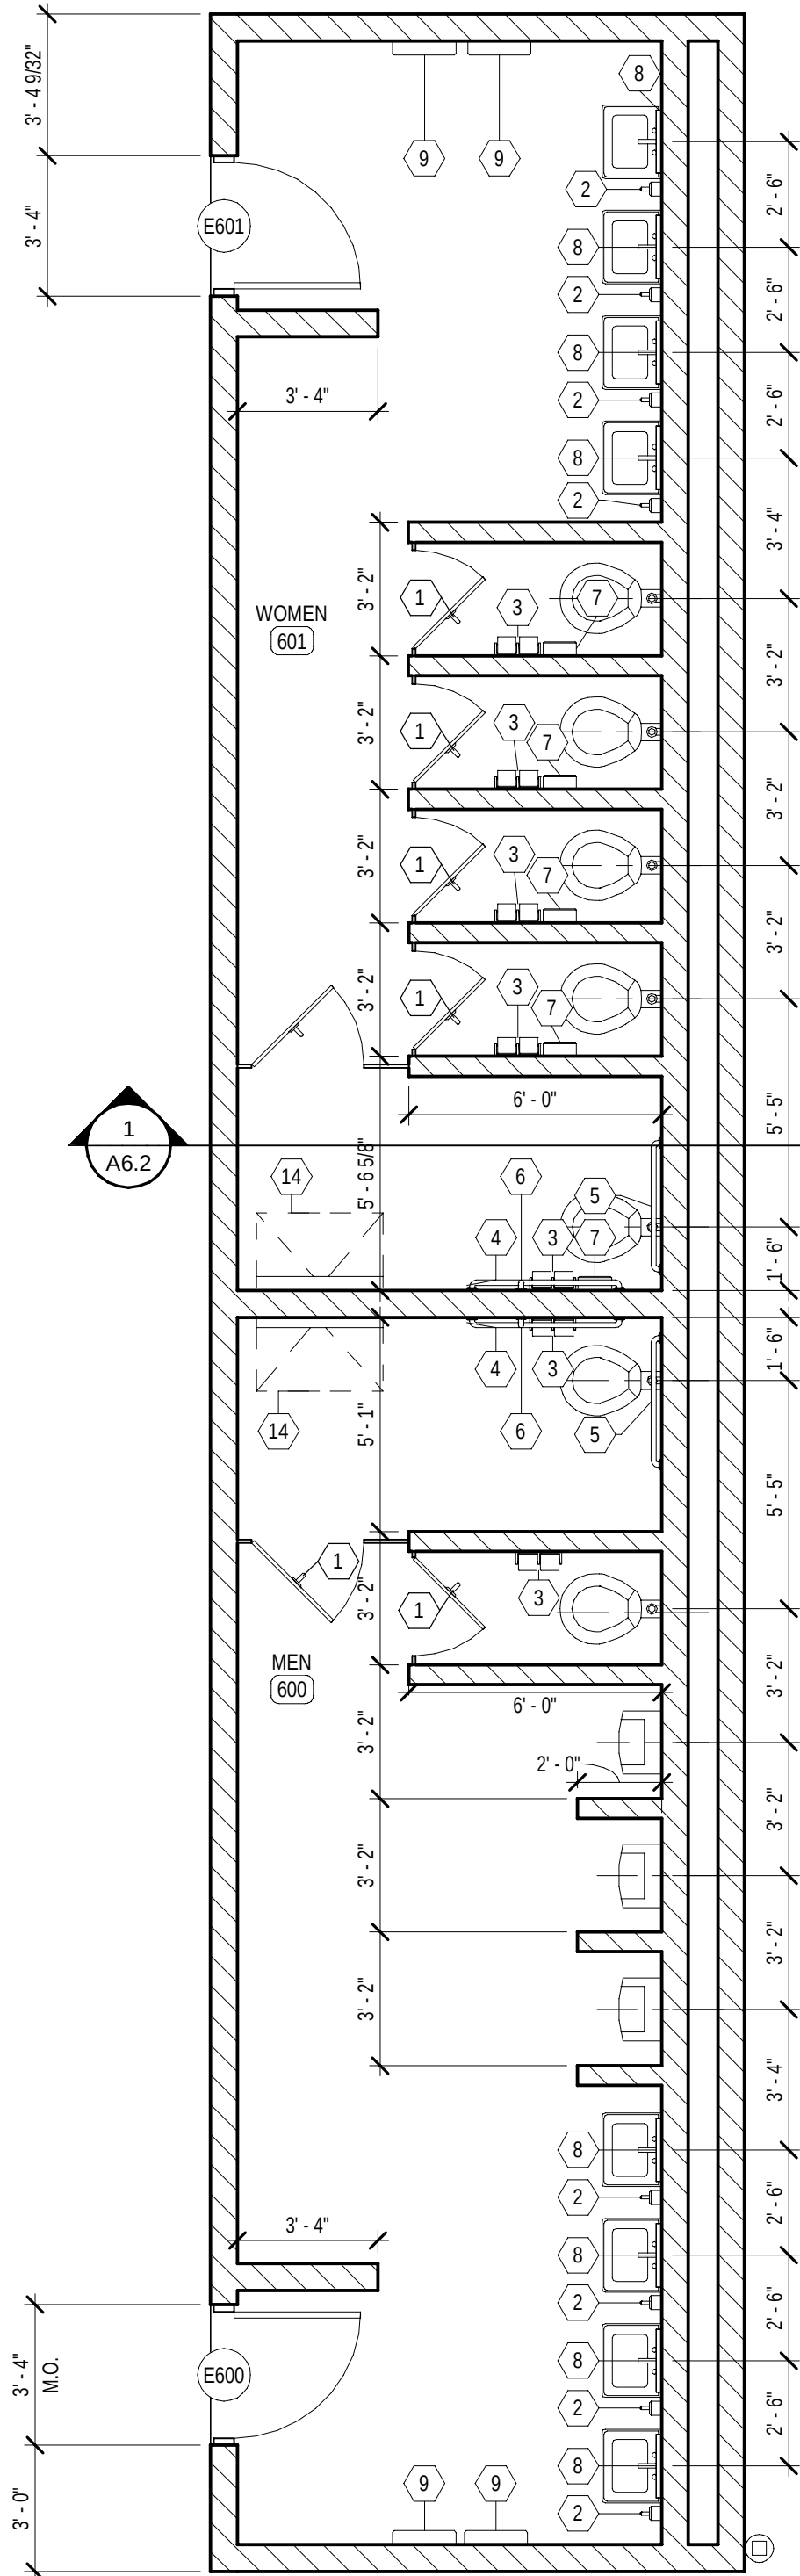

1 600 - ENLARGED RESTROOM PLAN
1/4" = 1'-0"

TOILET ACCESSORY SCHEDULE			
ACCESSORY	MTG. HT.	MFR.	
1 COAT HOOK AND BUMPER	48" TOP OF HOOK	ASI 0714	
2 S.S. SOAP DISPENSER	40" TO VALVE	ASI 8943	
3 DOUBLE ROLL TOILET PAPER DISPENSER W/ VANDAL RESISTANT SPINDLE (SURFACE MOUNTED)	24" TO CENTER LINE	ASI 0284-12	
4 42" S.S. GRAB BAR (1-1/4")	33" TO CENTERLINE	ASI 3401-42P	
5 36" S.S. GRAB BAR (1-1/4")	33" TO CENTERLINE	ASI 3401-36P	
6 18" VERTICAL S.S. GRAB BAR (1-1/4")	40" TO BOTTOM CENTERLINE	ASI 3401-18P	
7 SANITARY NAPKIN DISPOSAL (SURFACE MOUNTED)	24" TO TOP (28" FOR ADA)	ASI 0852	
8 MIRROR W/ S.S. FRAME - 24"x36"	40" TO BOTTOM	ASI 0600-B2436	
9 PAPER TOWEL DISPENSER (SURFACE MOUNTED)	46" TO DISPENSER SLOT	ASI 20210	
10 48" S.S. GRAB BAR (1-1/4")	33" TO CENTERLINE	ASI 3401-48P	
11 MOP / BROOM HOLDER (36" WIDE)	72" TO TOP	SEE PLUMBING	
12 MOP SINK	FLOOR MOUNTED	SEE PLUMBING	
13 MIRROR W/ S.S. FRAME - 108"x72"	40" TO BOTTOM		
14 BABY CHANGING TABLE	33" MAX. TO CHANGE SURFACE IN OPEN POSITION	ASI 9013-9	
15 SHOWER CURTAIN	72" STANDARD HEIGHT	ASI 1200-V	
16 TOWEL HOOKS	54" TO CENTERLINE	ASI 0740-Z	
17 24" S.S. GRAB BAR (1-1/4")	33" TO CENTERLINE	ASI 3401 SERIES	
18 ADA COMPLIANT FOLDING SEAT	REFER TO DETAIL THIS SHEET	ASI 8203	
19 SOAP DISH WITH DRAIN	38" TO TOP OF DISH	ASI 0720-Z	

GENERAL TOILET ACCESSORY NOTES

- MODEL NOS. DENOTE TOILET ACCESSORIES PRODUCTS OFFERED BY "AMERICAN SPECIALTIES, INC." (ASI) AND REPRESENT THE LEVEL OF QUALITY REQUIRED AND SHALL BE USED AS A BASIS OF DESIGN.
- ALL ITEMS SHALL BE LOCATED HORIZONTALLY AND MOUNTED TO SPECIFIC POINT ABOVE FINISH FLOOR SURFACES IN ACCORDANCE WITH ALL APPLICABLE REQUIREMENTS OF THE AMERICANS WITH DISABILITIES ACT (ADA) - ANSI A117.1 - 2009.
- REFER TO MEP DWGS. AND SPECIFICATIONS FOR PLUMBING FIXTURES, CONTROLS AND FLOOR DRAIN LOCATIONS.
- ALL EXPOSED PIPING AT LAVATORIES (H/LAVS) SHALL BE INSULATED AND COVERED WITH A PIRE MOLDED RIGID INSULATION JACKET.
- ALL TOILET ACCESSORIES TO INCLUDE VANDAL RESISTANT OPTION.
- REFER TO ALL FLOOR PLAN SHEETS FOR ACCESSORIES REQUIRED AT OTHER LOCATIONS.
- INSTALL GRAB BARS TO ALLOW 1 1/2" BETWEEN GRAB BAR AND WALL.
- REFER TO TYPICAL ADA COMPLIANT GRAB BAR LAYOUT 11A0.1.

FLOOR PLAN KEYNOTES

- OWNER PROVIDED FURNITURE OR EQUIPMENT (N.I.C.).
- LINE OF SOFFIT / BULKHEAD ABOVE, REFER TO REFLECTED CEILING PLAN.
- PRE-MFR, PRE-FIN SUSPENDED ALUMINUM CANOPY, REFER TO DETAIL 11A0.2.
- EXTERIOR CONCRETE WALK, REFER TO SITE DRAWINGS.
- HIGH / LOW ADA COMPLIANT WATER COOLER UNIT, REFER TO MECH / ELEC. DRAWINGS.
- MOP SINK, REFER TO PLUMBING DRAWINGS.
- KNOX BOX RECESSED IN BRICK, REFER TO DOOR HARDWARE SPECIFICATIONS.
- FLOOR TRANSITION, REFER TO SHEET A8.1 FOR DETAILS.
- SHIPS LADDER, REFER TO DETAIL 11A0.3.
- DIVIDER CURTAIN, MOTORIZED OPERATOR, REFER TO ELEC. DWGS.
- 7'-0" TALL X 2" THICK WALL PAD WITH WOOD BACKING. ATTACH TO WALLS / COLUMNS WITH MANUFACTURER'S STANDARD "Z" CLIP SYSTEM.
- ELECTRIC PUSH-BUTTON ADA DOOR OPERATOR, REFER TO ELEC. DWGS.


GENERAL NOTES

- (OF-C) OWNER FURNISHED CONTRACTOR INSTALLED.
- EXISTING TO REMAIN INTERIOR WALLS THAT ARE EXPOSED IN AREAS OF RENOVATION TO BE CLEANED, REPAIRED, PRIMED, AND PAINTED FOR LIKE NEW FINISH.
- DO NOT SCALE DWGS. WRITTEN DIMENSIONS TAKE PRECEDENCE OVER SCALED DIMENSIONS.
- INTERIOR MASONRY CONTROL JOINTS TO OCCUR EVERY 20'-0" MAX.
- NOTE: MARKER BOARD (MB) AND TACK BOARD (TB) INDICATE WIDTH AND ARE TO BE 48" H.

SYMBOL LEGEND

- ROOM FINISH GROUPS (REFER TO KEY PLAN SHEETS)
- ROOM NUMBER
- DOOR NUMBER (DOOR SCHEDULE SHEET A8.1)
- KEY NOTES (SHEETS A1.3 THROUGH A2.8)
- WALL TYPE (SCHEDULE SHEET A0.1)
- ALUMINUM OR HOLLOW METAL WINDOW OR STOREFRONT TYPE (REFER TO FLOOR PLANS AND SCHEDULE SHEETS A8.2)
- TOILET ACCESSORIES (SCHEDULE SHEET A2.7)
- ELEVATION KEY NOTE (SHEETS A3.1)
- ROOF KEY NOTE (SHEET A4.1)
- CEILING PLAN KEY NOTE (SHEETS A7.1 THROUGH A7.7)
- SIGNAGE KEY NOTE (REFER TO KEY PLAN SHEETS)
- WALL / PARTITION DESIGNATION
- FW2 2 HOUR RATED FIRE WALL
- EPW2 EXISTING 2 HOUR RATED FIRE WALL
- MASONRY CONTROL JOINT FULL HEIGHT OF WALL. REFER TO FLOOR PLANS AND EXTERIOR ELEVATION A3.1 FOR LOCATIONS

KEY PLAN

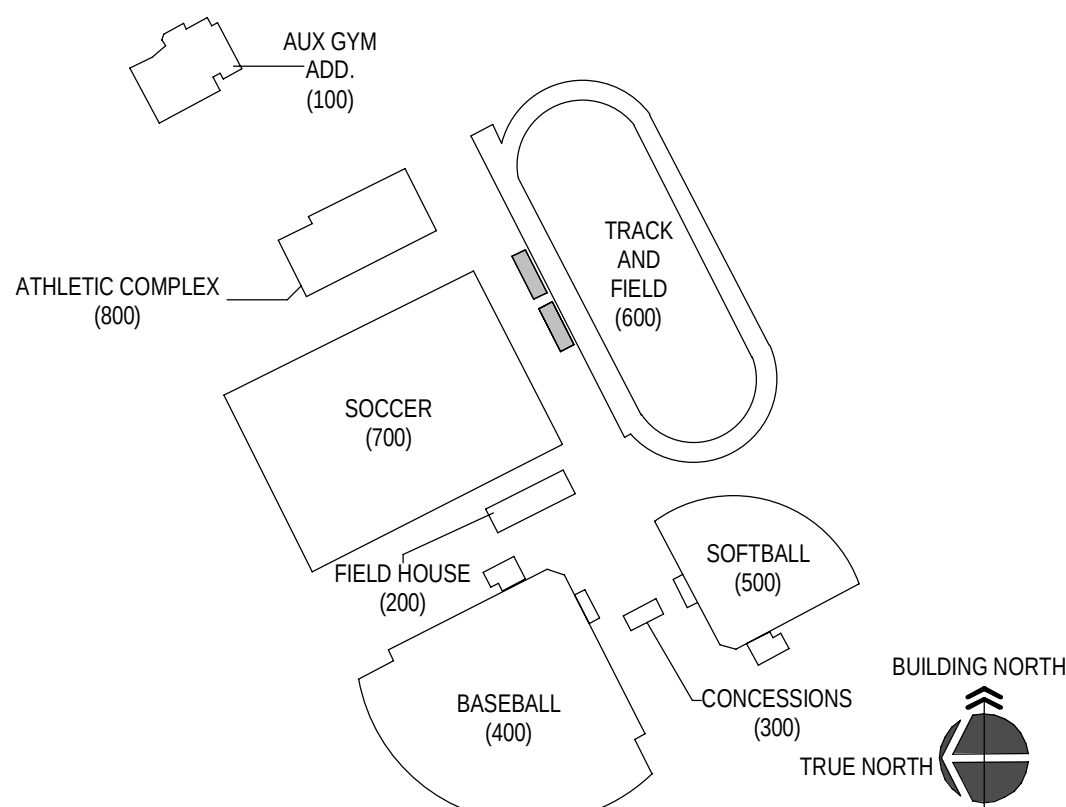

JOB NO.	2469
DATE	12/15/2025
DRAWN	CAH
CHECKED	RJV, ASC

COPYRIGHT © 2025
SHERMAN CARTER BARNHART
ARCHITECTS, PLLC

REVISIONS		
No.	Description	Date

SHEET

A6.2

GENERAL ELEVATION NOTES

BUILDING ELEVATIONS SHOWN ON THIS DRAWING ARE INTENDED FOR GENERAL REFERENCE PURPOSES ONLY. REFER TO REFERENCED SECTIONS AND DETAILS FOR MORE FULLY DESCRIBED CONDITIONS AND REQUIREMENTS.


- MATERIALS INDICATIONS AND DESCRIPTIONS, VERTICAL AND OTHER DIMENSIONS SHOWN ON ONE BUILDING ELEVATION APPLY TO OTHER BUILDING ELEVATIONS WHERE SHOWN UNLESS NOTED OTHERWISE.
- LINE REPRESENTING PAVING AND FINISH GRADES ARE APPROXIMATE AND ARE SHOWN FOR REFERENCE PURPOSES ONLY. REFER TO SITE PLANS FOR SPECIFIC GRADE AND SPOT ELEVATIONS AT EACH RESPECTIVELY.
- REFER TO FLOOR PLANS FOR LOCATION AND DOOR SCHEDULE FOR FULL EXTENT AND COMPLETE DESCRIPTION OF DOOR AND FRAME TYPES. PORTIONS OF DOORS, WINDOWS STOREFRONTS, AND CURTAIN WALLS MAY BE CONCEALED BY OTHER BUILDING FEATURES SHOWN.
- REFER TO FLOOR PLANS FOR SPECIFIC ALUMINUM WINDOW TYPES AND WINDOW ELEVATIONS.
- LOCATIONS OF CONTROLEXPANSION JOINTS IN MASONRY WALLS ARE SHOWN ON THIS DRAWING. SEE TYPICAL DETAILS ON SHEET A6.2 FOR SPECIFIC REQUIREMENTS AT RESPECTIVE LOCATIONS.
- ALL EXPOSED NEW EXTERIOR MASONRY SHALL RECEIVE APPLICATION OF SPECIFIED WATER REPELLENT.
- ALL EXPOSED EXTERIOR METAL SUCH AS FLASHINGS, COPINGS, GUTTERS DOWNSPOUTS AND LADDERS SHALL RECEIVE THE SPECIFIED FIELD OR SHOP APPLIED FINISH COATING.

(X)


ELEVATION KEY NOTES

NOTE: NOT ALL NOTES APPLY TO THIS SHEET.


- 8" (NOM.) SPLIT-FACE CMU
- 8" (NOM.) GROUND-FACE CMU
- BRICK ACCENT BAND (1 ROW)
- CONTROL JOINT
- GALV. INSULATED H.M. DOOR & FRAME (PRIMED, PAINT BY OTHERS)
- WALL MOUNTED LIGHT, REFER TO ELECTRICAL DRAWINGS
- FINISH GRADE - VARIES, REFER TO SITE DRAWINGS
- PRE-FINISHED S.M. GUTTER
- PRE-FINISHED DOWNSPOUT - TIE INTO BOOT. CONNECT TO BELOW GRADE DRAINAGE SYSTEM, REFER TO SITE DETAILS.
- INSULATED COILING OVERHEAD DOOR WITH PRE-FIN. S.M. COVER, REFER TO SPECIFICATIONS.
- PRE-FINISHED METAL WALL PANEL. REFER TO SPECIFICATIONS.
- SIGNAGE, REFER TO SPECS.
- ALUM. STOREFRONT
- CANOPY SYSTEM - REFER TO DETAIL 15A1.1
- RECESS BRICK BAND 1/2" (TYP.)
- GUTTER.
- PEMB RAKE TRIM
- PEMB GUTTER
- PEMB DOWNSPOUT
- PEMB RIDGE CAP
- PEMB METAL WALL PANEL
- S.M. COPING
- EXTERIOR GRADE PLYWOOD, PAINTED, REFER TO DETAIL 6/A5.2.

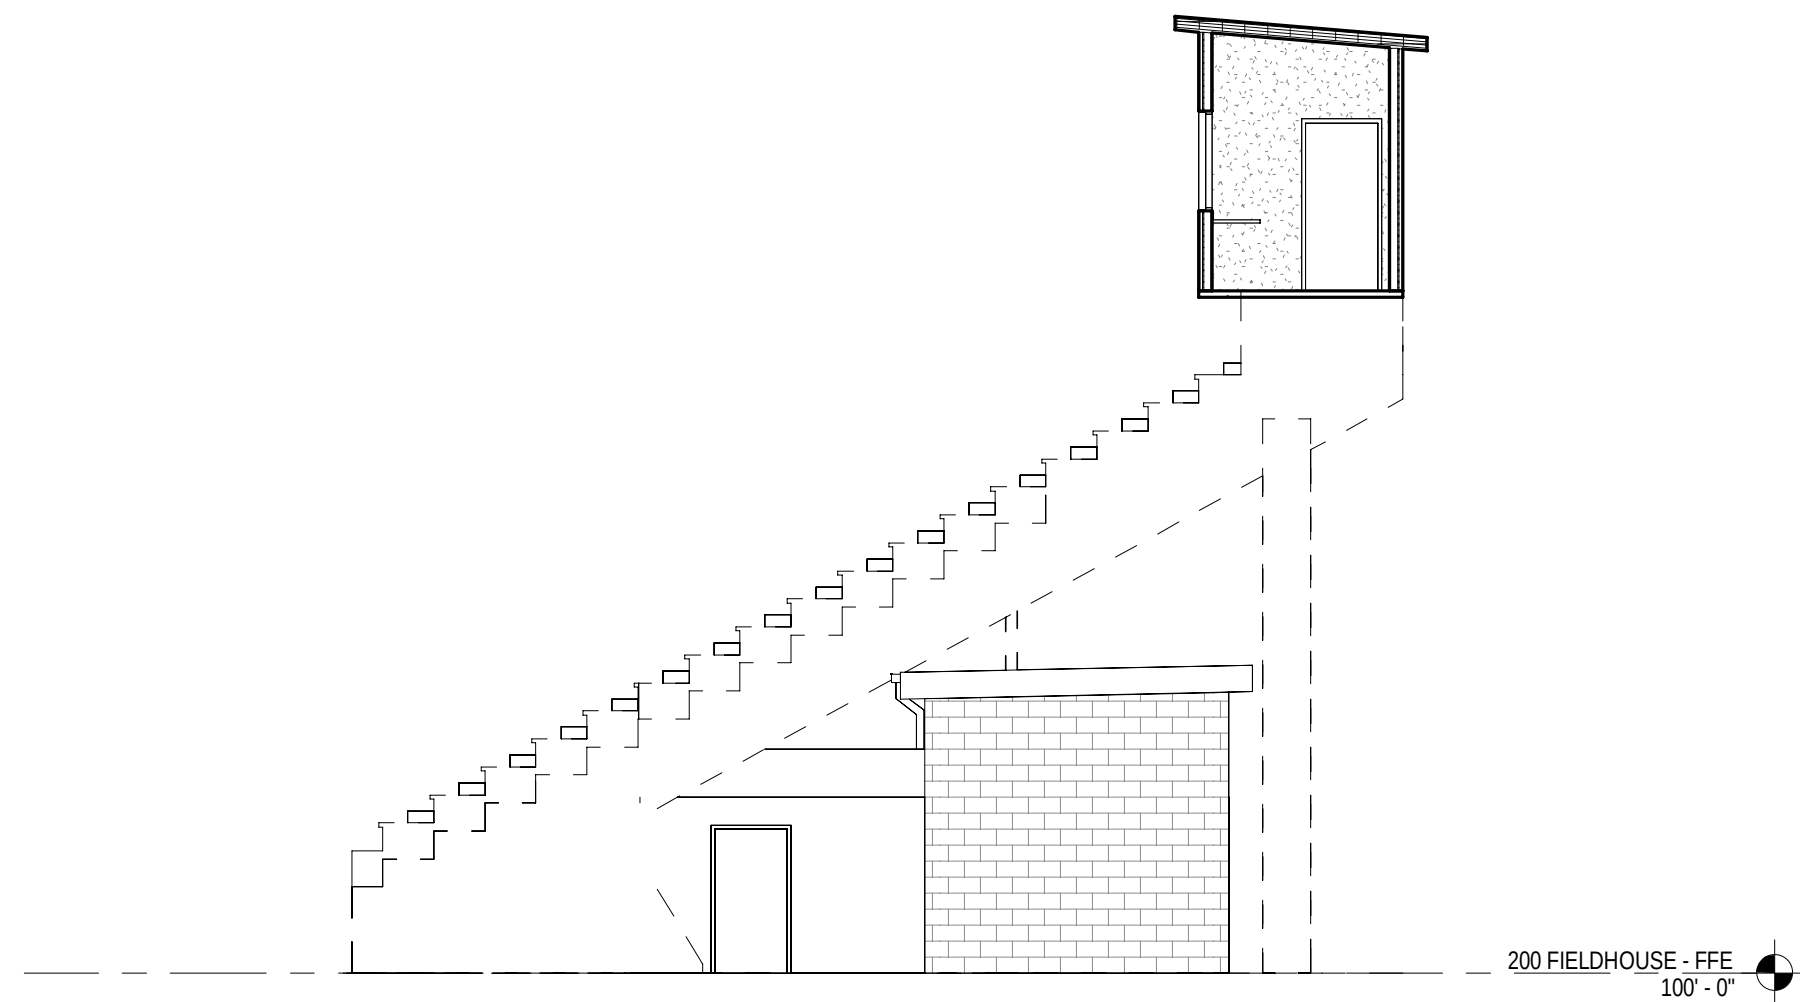


3 600 - RESTROOM BUILDING ELEVATION - NORTH
1/8" = 1'-0"

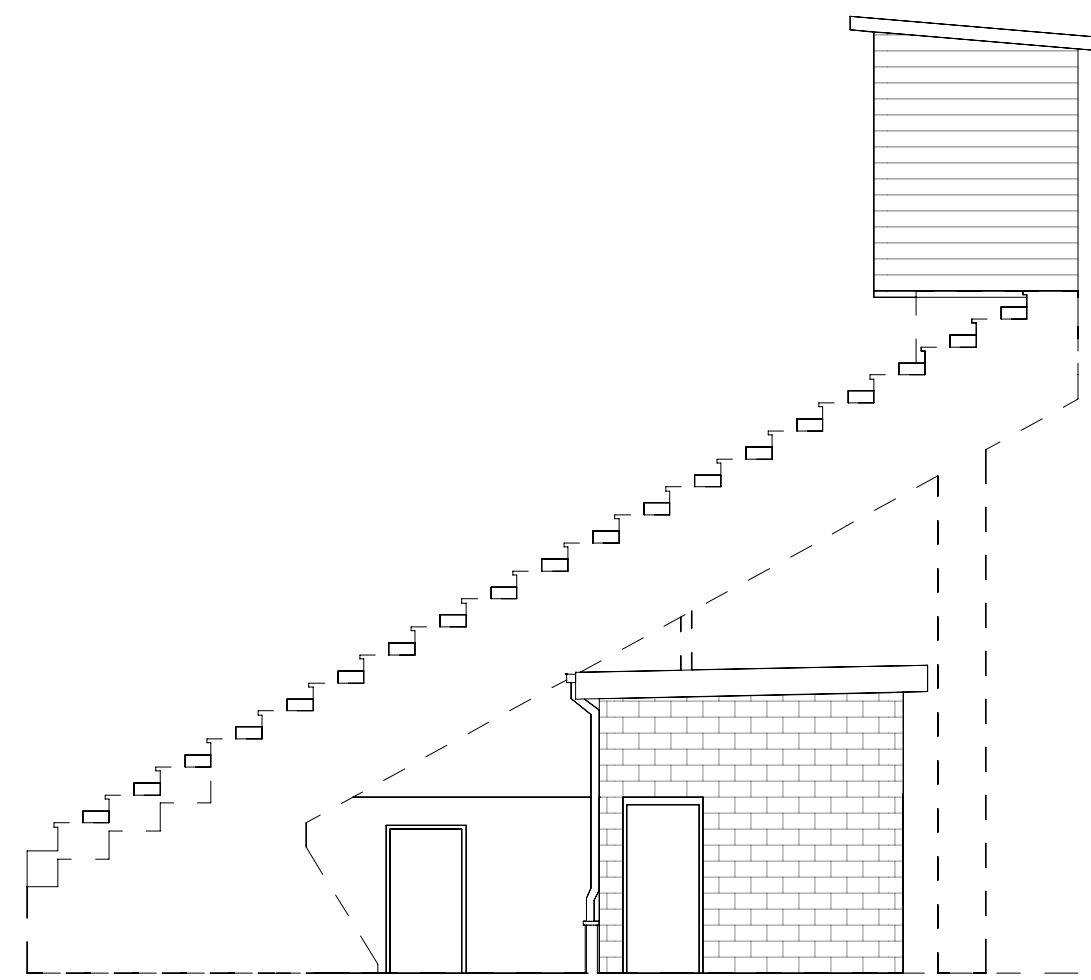


2 600 - CONCESSION BUILDING ELEVATION - NORTH
1/8" = 1'-0"

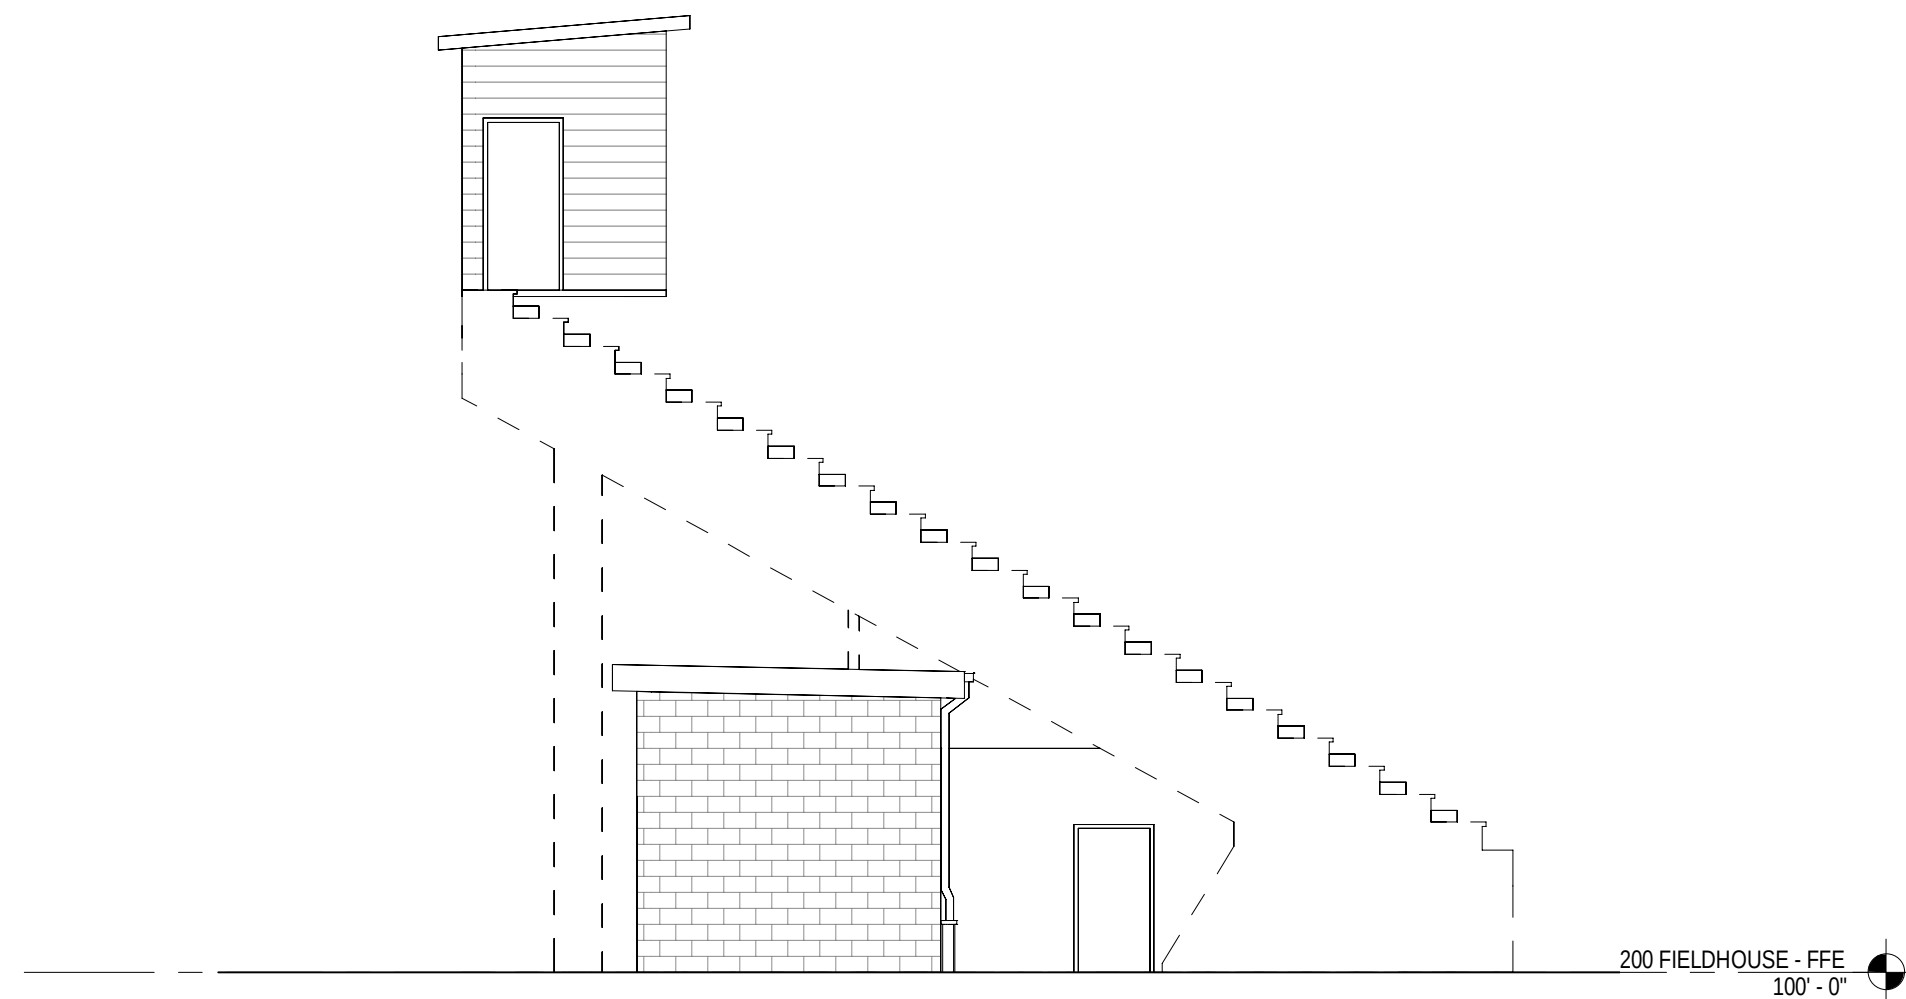


6 600 - RESTROOM BUILDING ELEVATION - SOUTH
1/8" = 1'-0"

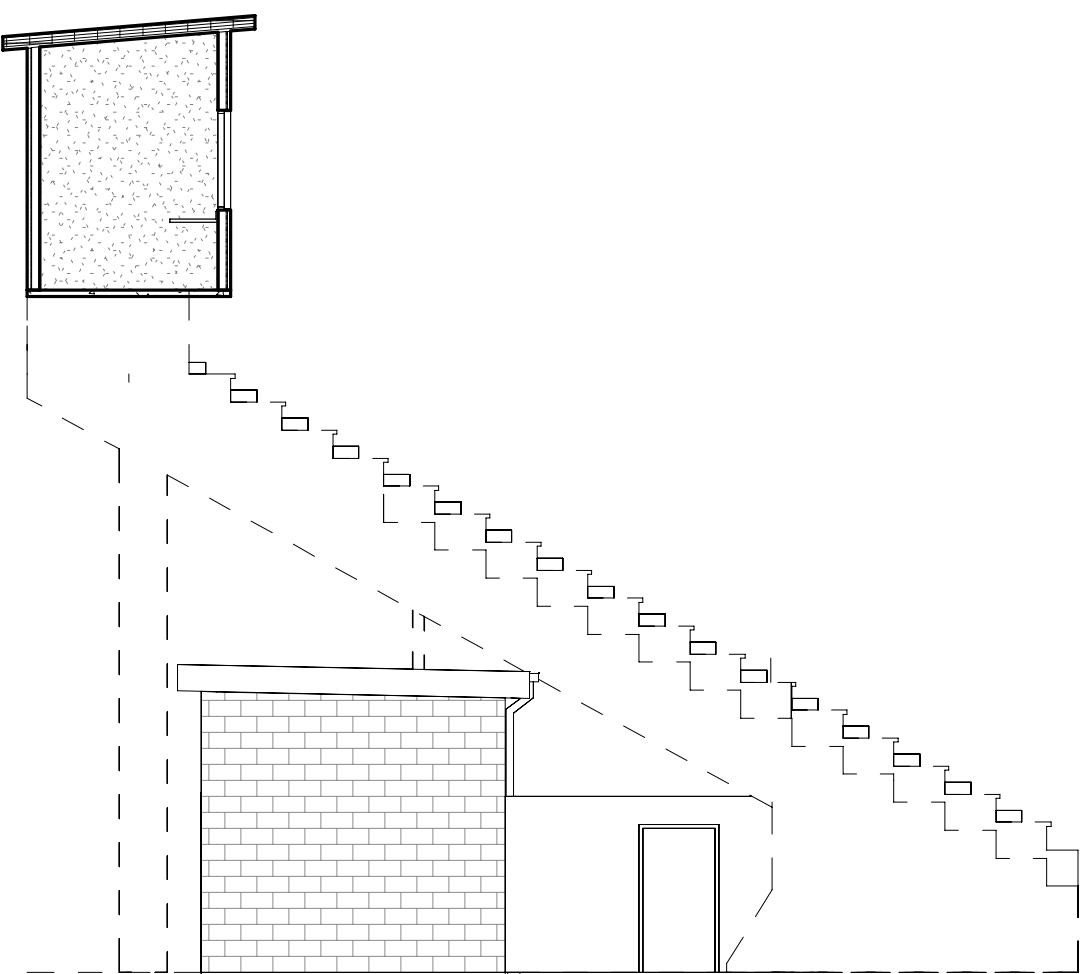


4 600 - CONCESSION BUILDING ELEVATION - SOUTH
1/8" = 1'-0"

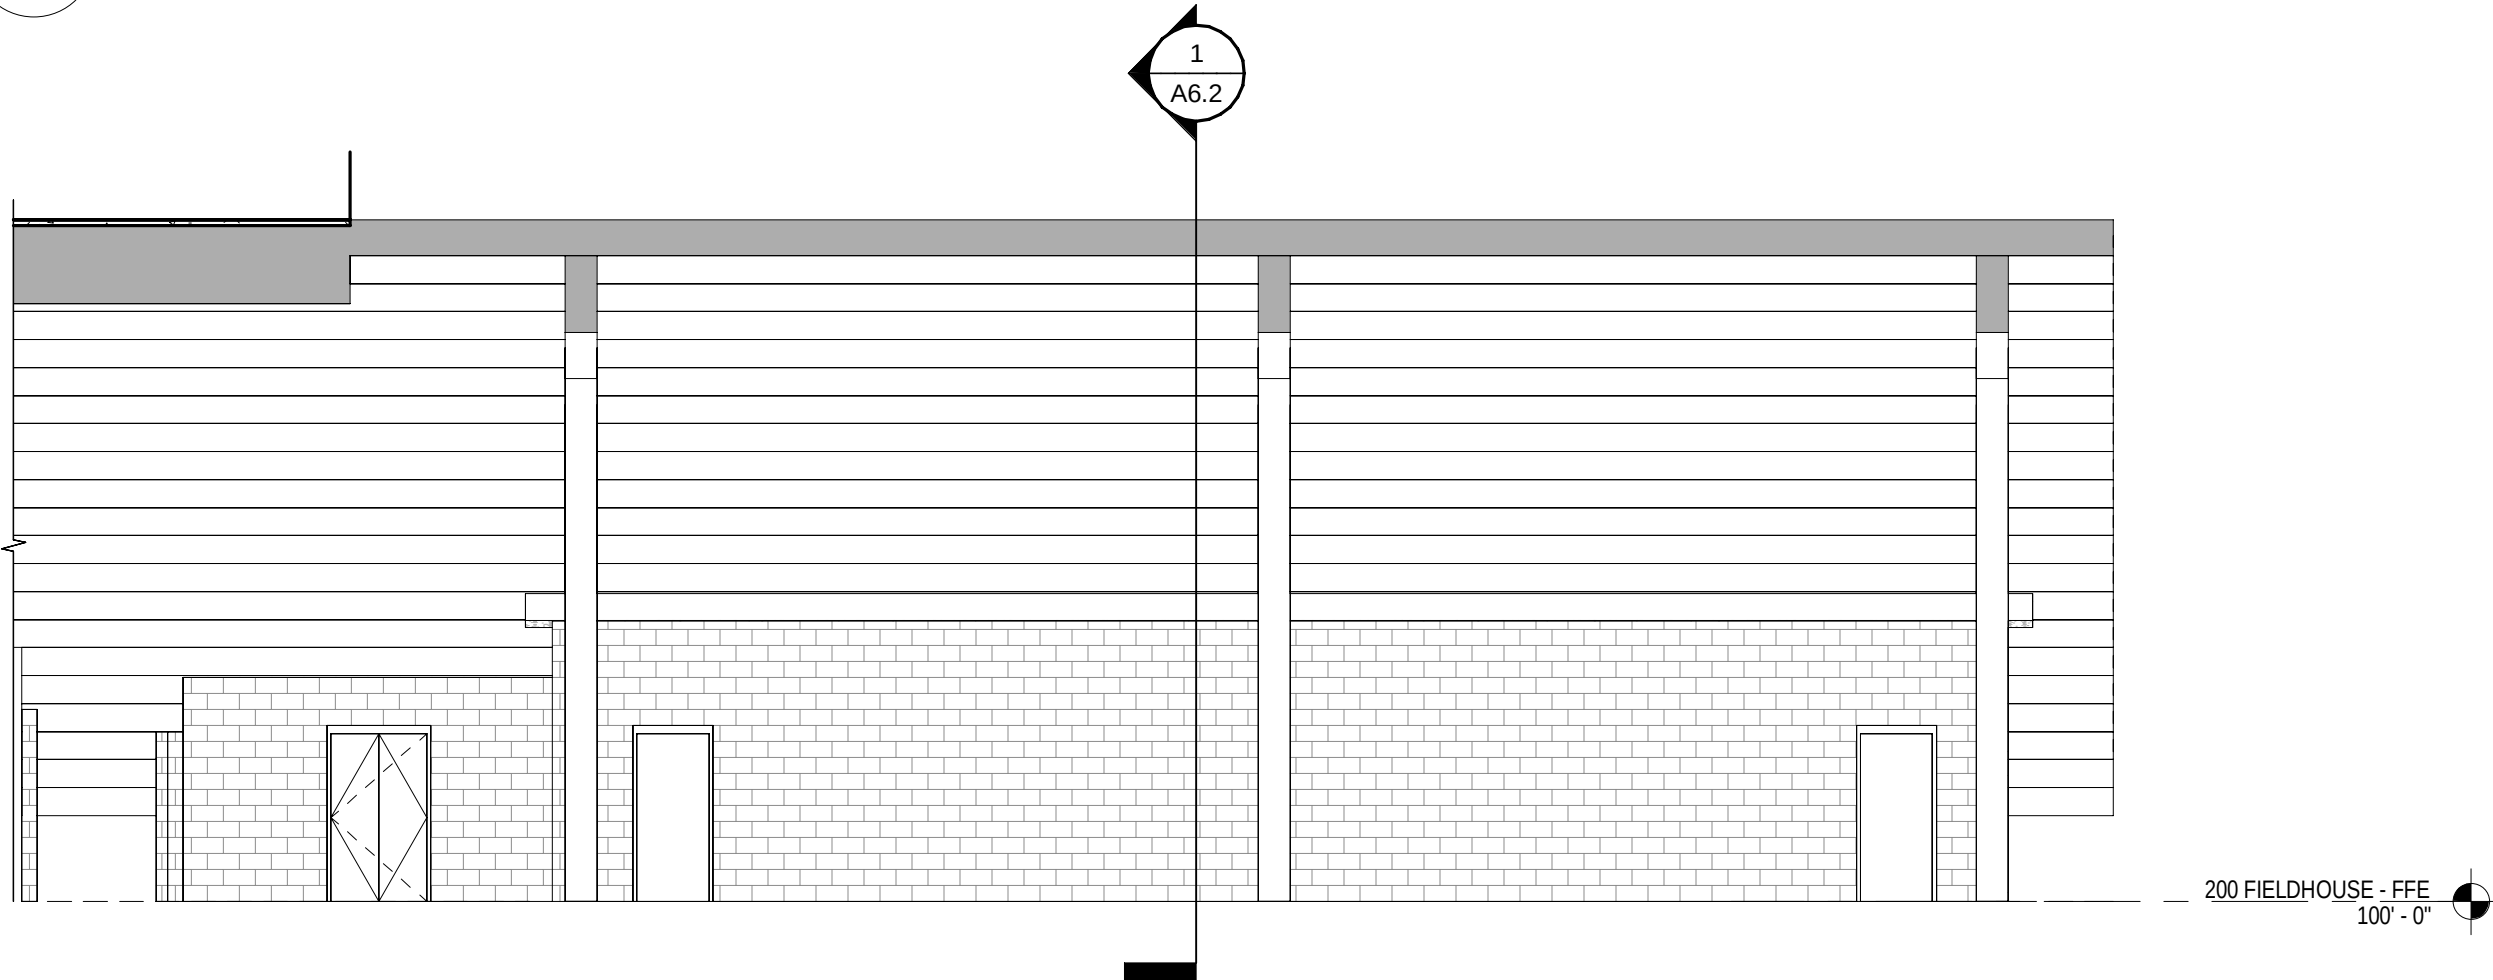


7 600 - RESTROOM BUILDING ELEVATION - WEST
1/8" = 1'-0"

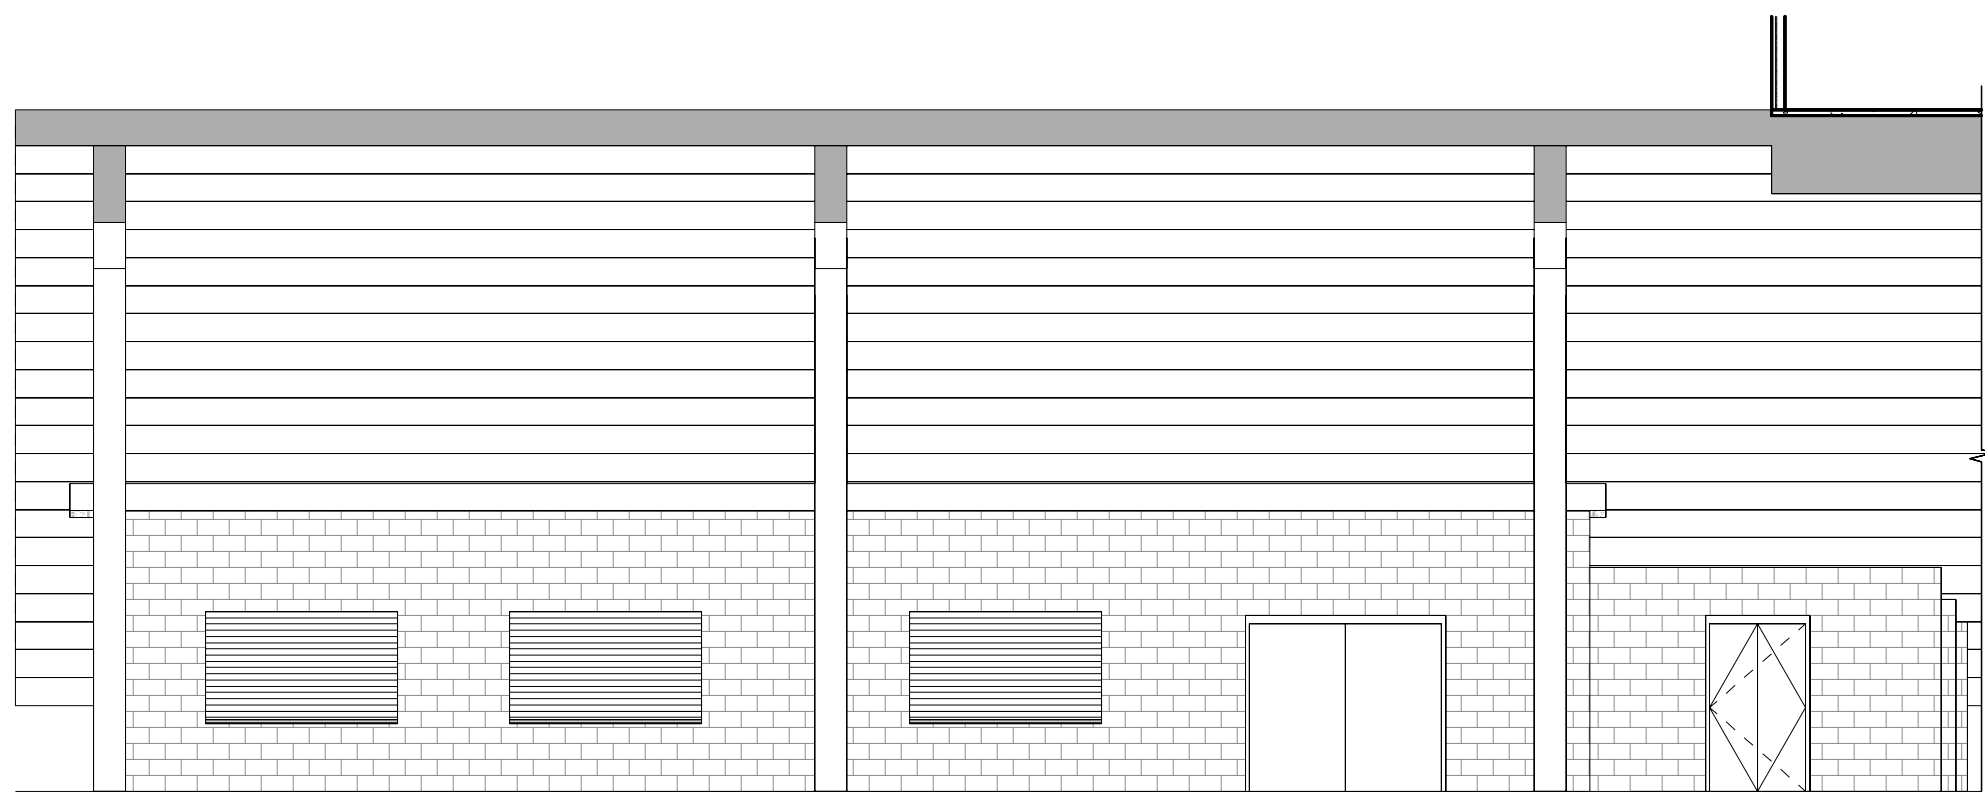

5 600 - CONCESSION BUILDING ELEVATION - WEST
1/8" = 1'-0"

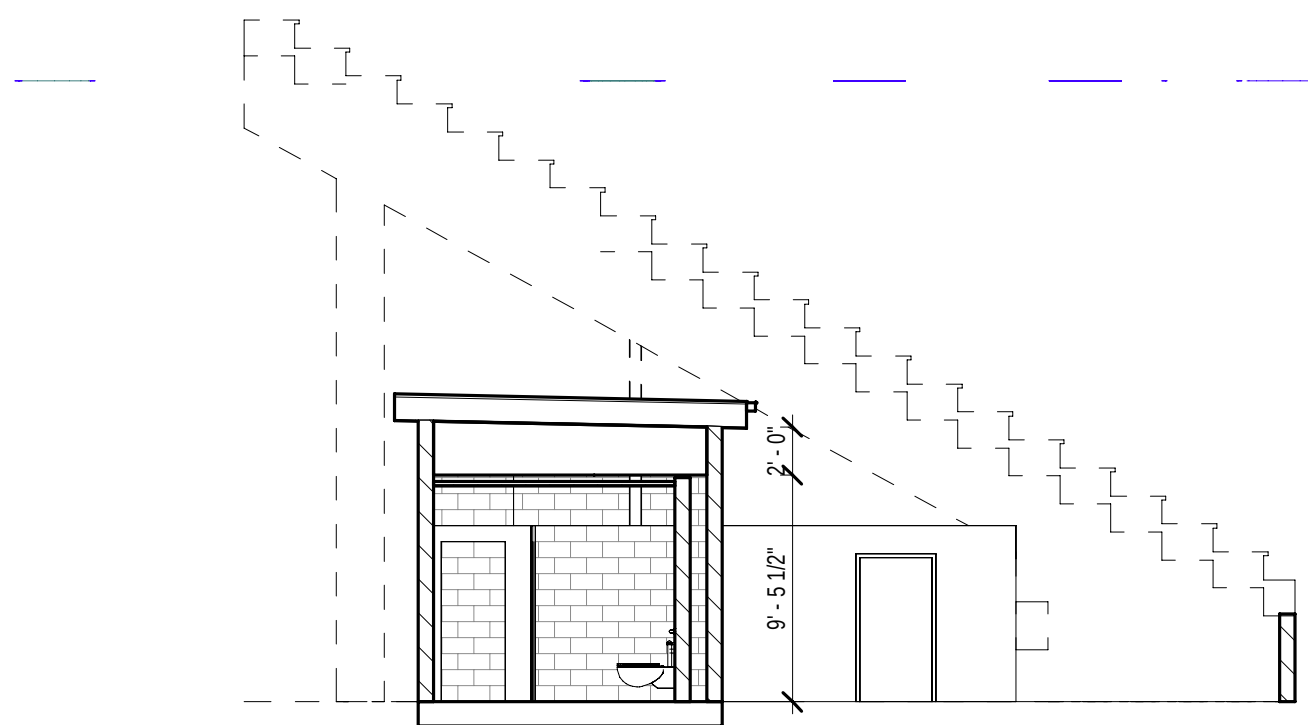


1 GRANDSTAND - BUILDING SECTION 01
1/8" = 1'-0"

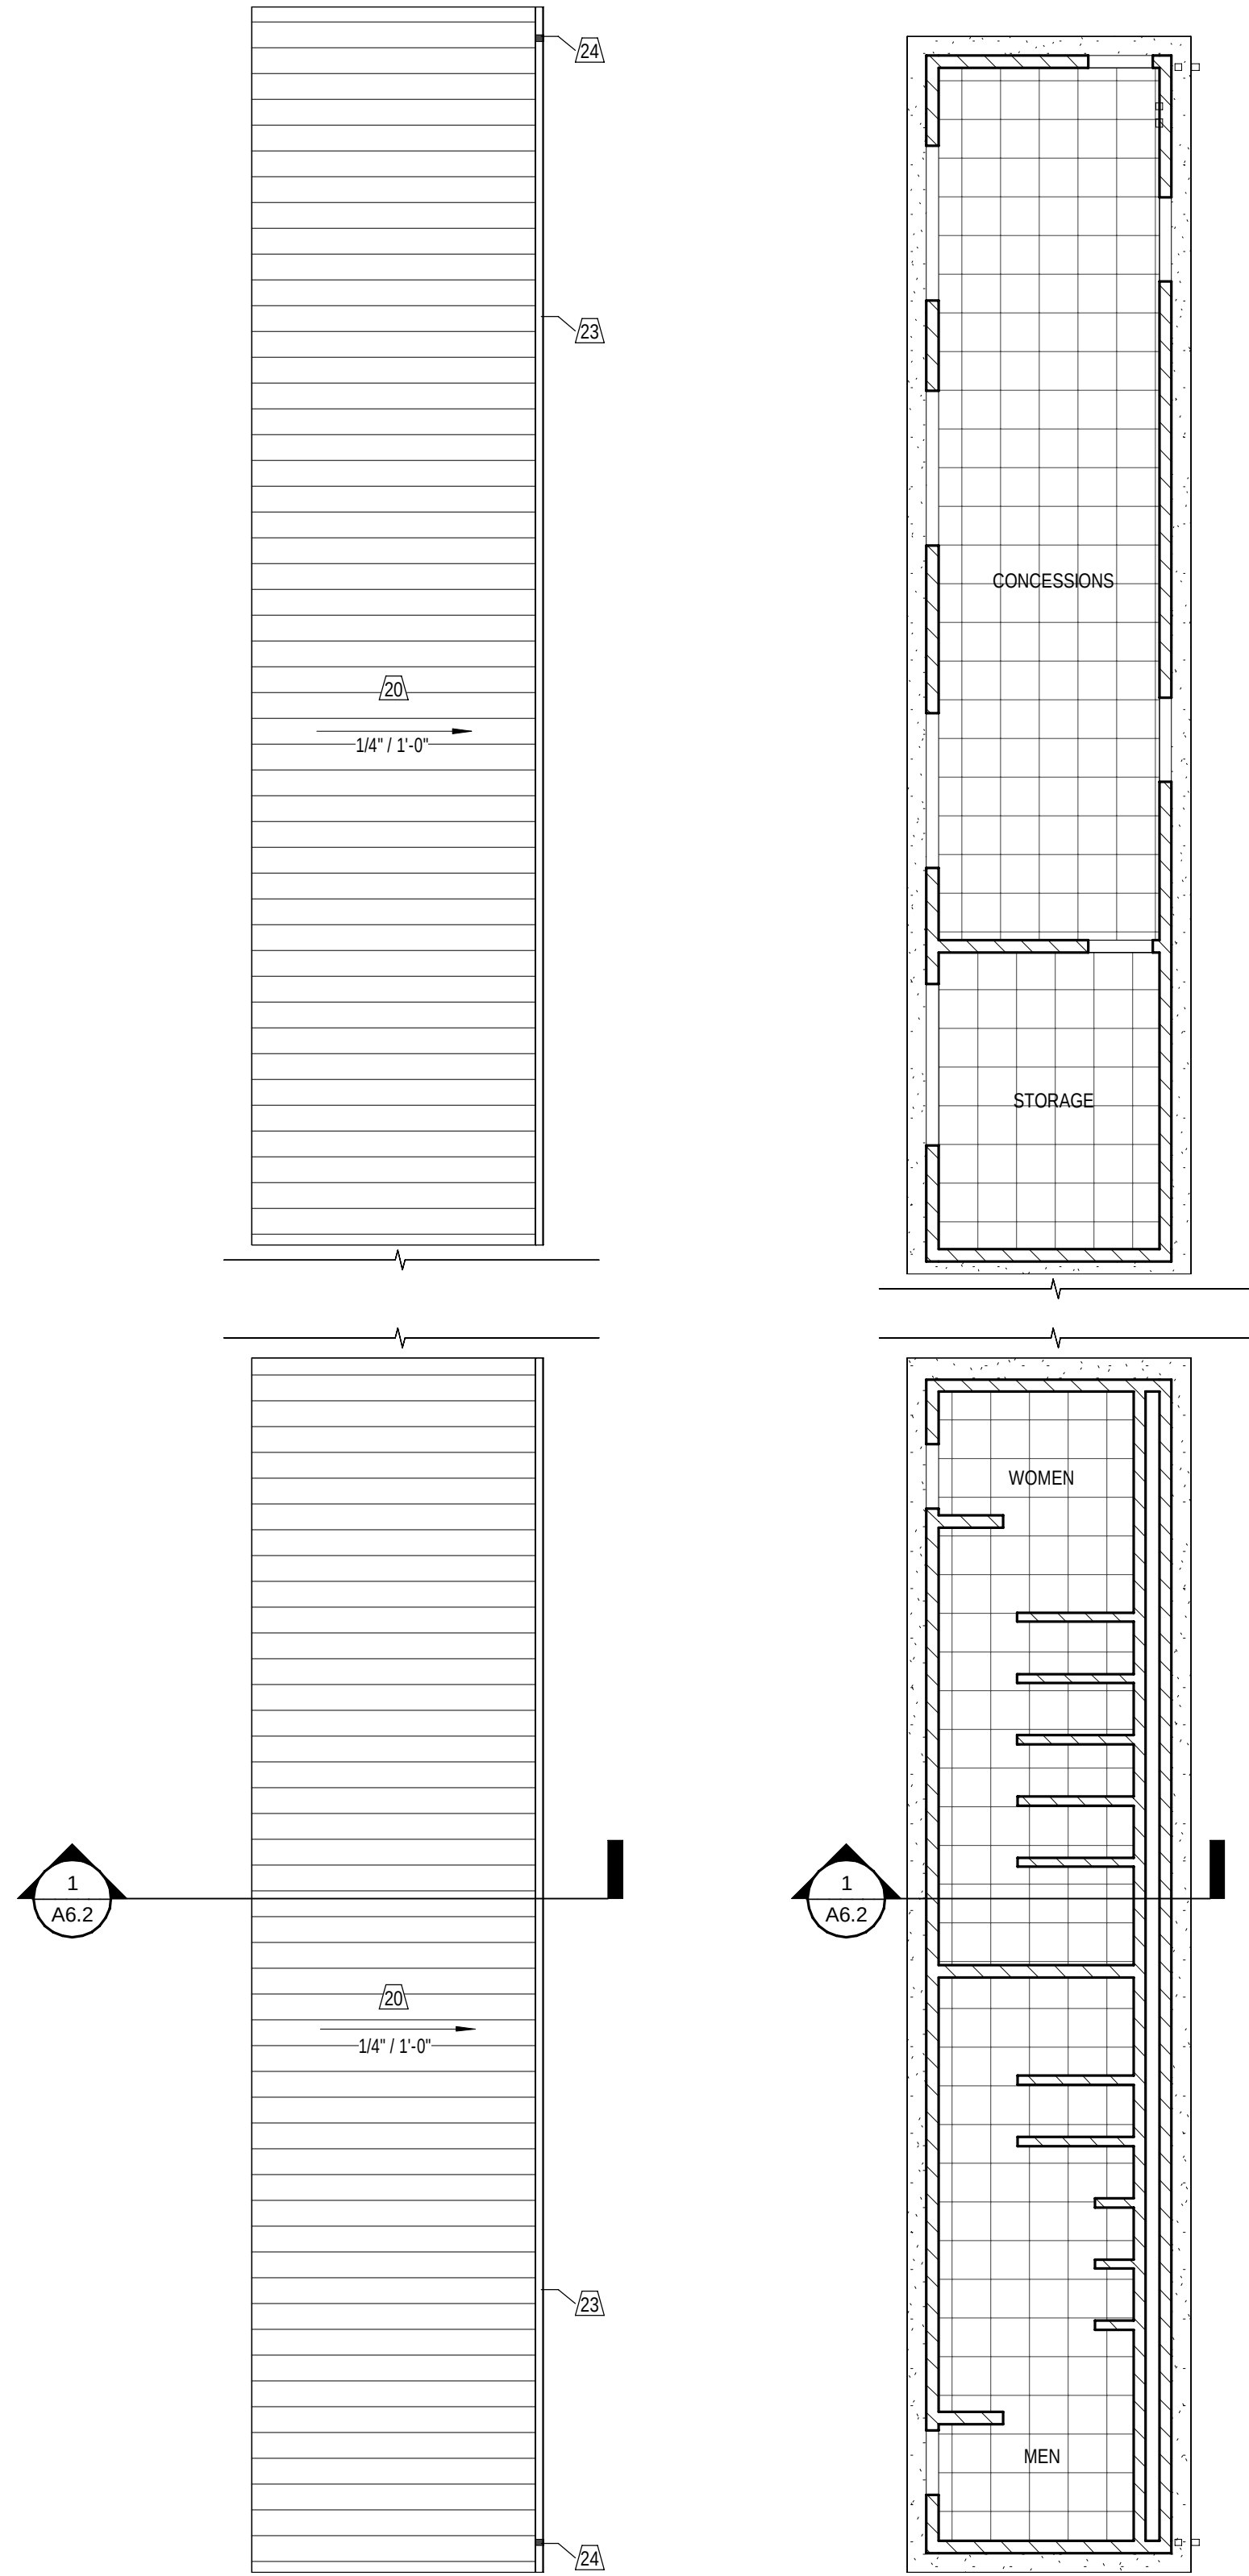

2 600 - ROOF PLAN
1/8\" = 1'-0"

1 600 - REFLECTED CEILING PLAN
1/8\" = 1'-0"

ROOF KEYNOTES	RCP KEYNOTES
1. ROOF TYPE 'A' REFER TO ROOF LEGEND. 2. ROOF TYPE 'B' REFER TO ROOF LEGEND. 3. PRE-FIN METAL COPING, REFER TO TYP. DETAIL 1/A0.2. 4. PRE-FIN METAL SCUPPER AND DOWNSPOUT, REFER TO DETAILS 2, 3, AND 4/A0.2. 5. PRE-MANUFACTURED WALKWAY COVER, REFER TO DETAIL 11/A0.2. 6. PRE-MANUFACTURED WALL-SUPPORTED ALUMINUM CANOPY WITH INTEGRAL DOWNSPOUT 8'-0" x 5'-0" U.N.O. REFER TO DETAILS 12 AND 13/A0.2. 7. MASONRY PIER WITH CAST STONE CAP, REFER TO DETAIL ____. 8. ROOF EXPANSION JOINT, REFER TO DETAIL ____. 9. ROOF EXPANSION JOINT AT 2HR FIRE WALL, REFER TO DETAIL ____. 10. ROOF HATCH, REFER TO DETAIL 11/A0.3. 11. WALKWAY PADS, REFER TO SPECIFICATIONS. 12. CRICKET, TAPER INSULATION 1/4" PER FT. FOR POSITIVE DRAINAGE TO SCUPPER. 13. CRICKET FOR POSITIVE DRAINAGE AROUND ROOF CURB. 14. HVAC UNIT, REFER TO MECHANICAL. SEE 14/A0.2 FOR MECH CURB DETAIL. 15. PEMB RIDGE CAP. 16. PEMB GUTTER ASSEMBLY. 17. PEMB RAKE TRIM ASSEMBLY. 18. PEMB DOWNSPOUT, SEE ELEVATIONS. 19. ROOF TYPE 'C' REFER TO ROOF LEGEND. 20. ROOF TYPE 'D' REFER TO ROOF LEGEND. 21. PRE-FIN METAL, VENTED RIDGE CAP. 22. PRE-FIN METAL, RAKE TRIM. 23. PRE-FIN METAL GUTTER. 24. PRE-FIN METAL DOWNSPOUT. 25. SNOW GUARD.	NOTE: ALL NOTES MAY NOT APPLY TO THIS SHEET. 1. METAL SOFFIT AT EXTERIOR. REFER TO DETAILS. 2. OPEN TO STRUCTURE, PAINT STRUCTURE & STEEL DECK. PAINT ALL EXPOSED, NON PRE-FINISHED MEP ITEMS. 3. EXPOSED STRUCTURE AND DECK, NO FINISH. 4. METAL PANEL CONTROL JOINT, PAINT. EXTEND JOINT UP VERTICAL SIDES OF SOFFIT. 5. ROOF HATCH. 6. ALUMINUM COMPOSITE PANEL CEILING. 7. ALIGN EDGE OF NEW GYP BD, SOFFIT WITH ADJACENT WALL. 8. 4'-0" HIGH ACOUSTICAL WALL PANELS BOTTOM OF PANEL @ 16'-0" AFF. 9. INTERIOR GYP. BD, SOFFIT, PAINT, REFER TO DETAIL 3/A7.7. 10. INTERIOR GYP. BD, BULKHEAD, PAINT, REFER TO DETAIL 5/A7.7.
GENERAL ROOF NOTES	RCP GENERAL NOTES
1. ROOF SLOPES ARE 1/4" / 12" UNLESS NOTED OTHERWISE. 2. ALL FLASHING WORK SHALL BE DONE SUCH THAT A WATERTIGHT INSTALLATION IS ACHIEVED AND MAINTAINED. 3. REFER TO STRUCTURAL DWGS. FOR SPECIFIC STRUCTURAL ELEVATION. 4. REFER TO MPE DWGS. FOR ROOF TOP ITEMS NOT SHOWN IN THIS PLAN. 5. FLASH ALL ROOF PENETRATIONS PER MANUFACTURER'S STANDARD DETAILS. 6. REFER TO TYPICAL ROOF DETAILS, SHEET A0.2. 7. CONTRACTOR SHALL NOT COVER ANY WEEPS, BRICK VENTS, EXPANSION JOINTS, FLASHING, OR COPING. ROOFING SHALL TERMINATE AS SHOWN ON DETAILS. 8. CONTRACTOR TO COORDINATE INSTALLATION OF ROOFING/ FLASHING WITH OTHER TRADES FOR ADDITIONAL WORK REQ'D. (I.E. FLASHING OF EQUIPMENT CURBS.) 9. INSTALL ROOF FLASHING TO EXTEND UP FULL HEIGHT OF PARAPET WALLS AND OVER NAILERS UNDER COPING UNLESS NOTED OTHERWISE.	R1 = KEYNOTES (WHERE APPLICABLE) R2 CEILING RELATED MECHANICAL AND ELECTRICAL ITEMS ARE NOT SHOWN ON REFLECTED CEILING PLANS. SEE MECHANICAL AND/OR ELECTRICAL DRAWINGS FOR TYPE, SIZE, AND OTHER REQUIREMENTS PERTAINING SPECIFICALLY TO THESE ITEMS - EPOXY PAINT ALL EXPOSED, NON PRE-FINISHED MEP ITEMS. R3 REFER TO PLUMBING, MECHANICAL AND ELECTRICAL DRAWINGS FOR ADDITIONAL FIXTURES NOT SHOWN. R4 REFER TO WALL TYPES FOR DESCRIPTION OF WALLS EXTENDING (OR NOT) TO UNDERSIDE OF DECKING AND/OR STRUCTURE ABOVE. R5 INSTALL SPRINKLER HEADS IN CENTER OF 2x2 CEILING PANELS. R6 INSTALL ALL SPRINKLER HEADS ON SWING ARM NIPPLES. REFER TO MECHANICAL DRAWINGS FOR SPECIFIC REQUIREMENTS. R7 SOFFIT DIMENSIONS SHOWN ARE FROM FACE OF WALL OR FACE OF GYPSUM BOARD TO FACE OF GYPSUM BOARD. R8 REFER TO DOOR, FRAME DETAILS AND STRUCTURAL DRAWINGS FOR SPECIFIC LINTEL LOCATIONS. PAINT EXPOSED STEEL LINTELS (GALV. AT EXTERIOR LOCATIONS) R9 UNLESS SPECIFICALLY LOCATED, GYPSUM BOARD CONTROL JOINTS AS REQUIRED BY INDUSTRY STANDARDS OR SPECS, WHICHEVER IS MORE RESTRICTIVE. CONFIRM LOCATIONS WITH ARCHITECT. R10 ALL CEILINGS SHALL BE ACT TYPE A, U.N.O.
ROOF SYMBOLS LEGEND	REFLECTED CEILING LEGEND
ROOF ASSEMBLY - TYPE 'A' THERMOPLASTIC POLYOLEFIN SINGLE PLY MEMBRANE ROOFING OVER 7/16" COVER DECK OVER (4) LAYERS OF 1 1/2" RIGID POLYISOCYANURATE INSULATION STAGGERED (6" THICKNESS) ON METAL DECK, PROVIDE FINISHED 1/4" SLOPE PER 1'-0". ROOF ASSEMBLY - TYPE 'B' PEMB, METAL ROOF OVER METAL PURLINS, WITH R-5 THERMAL BLOCKS, 8" LOWER LAYER FIBERGLASS BATT INSULATION AND 3" UPPER LAYER FIBERGLASS BATT INSULATION WITH A TOTAL PRE-INSTALLED R-VALUE OF 35. SUSPEND WITH STEEL STRAP AND FABRIC SYSTEM, SLOPE 3/12. ROOF ASSEMBLY - TYPE 'C' STANDING SEAM METAL ROOF SYSTEM OVER SINGLE LAYER OF CONTINUOUS ICE & WATER SHIELD ON SPECIFIED ROOF DECKING OVER LIGHT, GA. METAL TRUSSES. ROOF ASSEMBLY - TYPE 'D' STANDING SEAM METAL ROOF SYSTEM OVER SINGLE LAYER OF CONTINUOUS ICE & WATER SHIELD ON SPECIFIED PLYWOOD SHEATHING OVER WD. RAFTERS. --- INDICATES 2HR FIRE WALL, SEE PLAN A1.1. INDICATES CRICKET, SLOPE 1/4" PER FOOT IN DIRECTION OF ARROW APPROXIMATE AREA OF ROOF REPAIR, TO BE INVESTIGATED AND REPAIRED BY CONTRACTOR DS DOWNSPOUT. SC SCUPPER AND CONDUCTOR HEAD. EDS EXISTING DOWNSPOUT. RD ROOF DRAIN, REFER TO DETAIL 1/A4.2. ORD OVERFLOW ROOF DRAIN, REFER TO DETAIL 1/A4.2. VTR VENT THRU ROOF, REFER TO DETAIL 2/A4.2. RTU ROOF TOP UNIT, REFER TO MECHANICAL DWGS. AND CURB DETAIL 3/A4.2. EXHAUST FAN / OA HOOD, REFER TO MECH. DWGS.	X' - X' CEILING HEIGHT, A.F.F. NOTE: REFER TO SECTIONS AND DETAILS FOR EXTERIOR CEILING HEIGHTS NOT SHOWN. 2x2' SUSPENDED ACOUSTICAL CEILING (ACT-A) @ 9' - 0" A.F.F. U.N.O., REFER TO SPECS. 2x2' SUSPENDED ACOUSTICAL CEILING (ACT-B) @ 9' - 0" A.F.F. U.N.O., REFER TO SPECS. GYPSUM BOARD SOFFIT OR BULKHEAD @ 8' - 8" A.F.F. U.N.O., PAINT. LINEAR METAL CEILING. EXISTING BUILDING TO REMAIN. PAINTED, 5/8" EXTERIOR GRADE PLYWOOD NO CEILING, DECK / STRUCTURE ABOVE TO BE PAINTED.

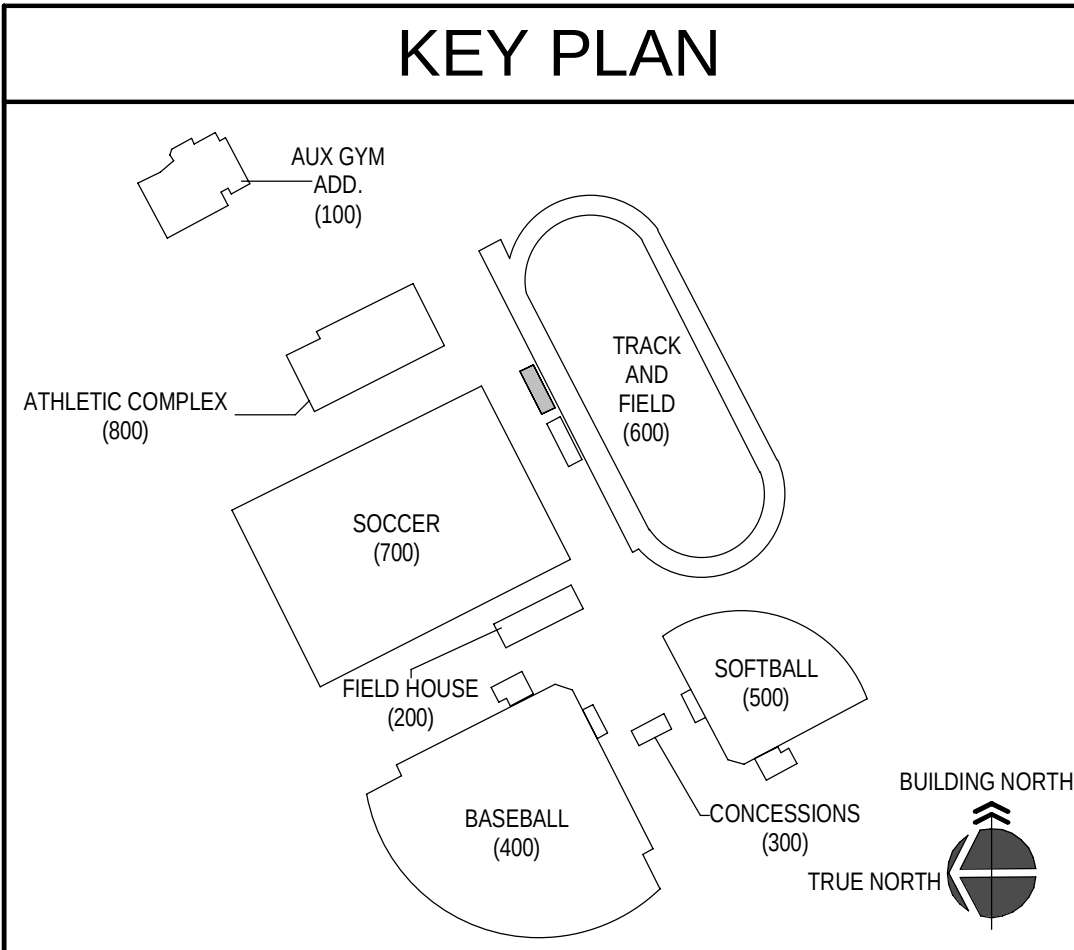

JOB NO.	2469
DATE	12/15/2025
DRAWN	CAH
CHECKED	RJV, ASC

COPYRIGHT © 2025
SHERMAN CARTER BARNHART
ARCHITECTS, PLLC

REVISIONS		
No.	Description	Date

SHEET

A6.3


ALLEN COUNTY - SCOTTSVILLE
HIGH SCHOOL ATHLETIC
COMPLEX
SCOTTSVILLE, KENTUCKY

GRANDSTANDS REFLECTED CEILING
PLAN & ROOF PLAN


DD SET
-- NOT FOR --
CONSTRUCTION

SHERMAN
CARTER
BARNHART
ARCHITECTS

2469
ALLEN COUNTY - SCOTTSVILLE HIGH SCHOOL ATHLETIC COMPLEX
12/15/2025 9:56:35 AM

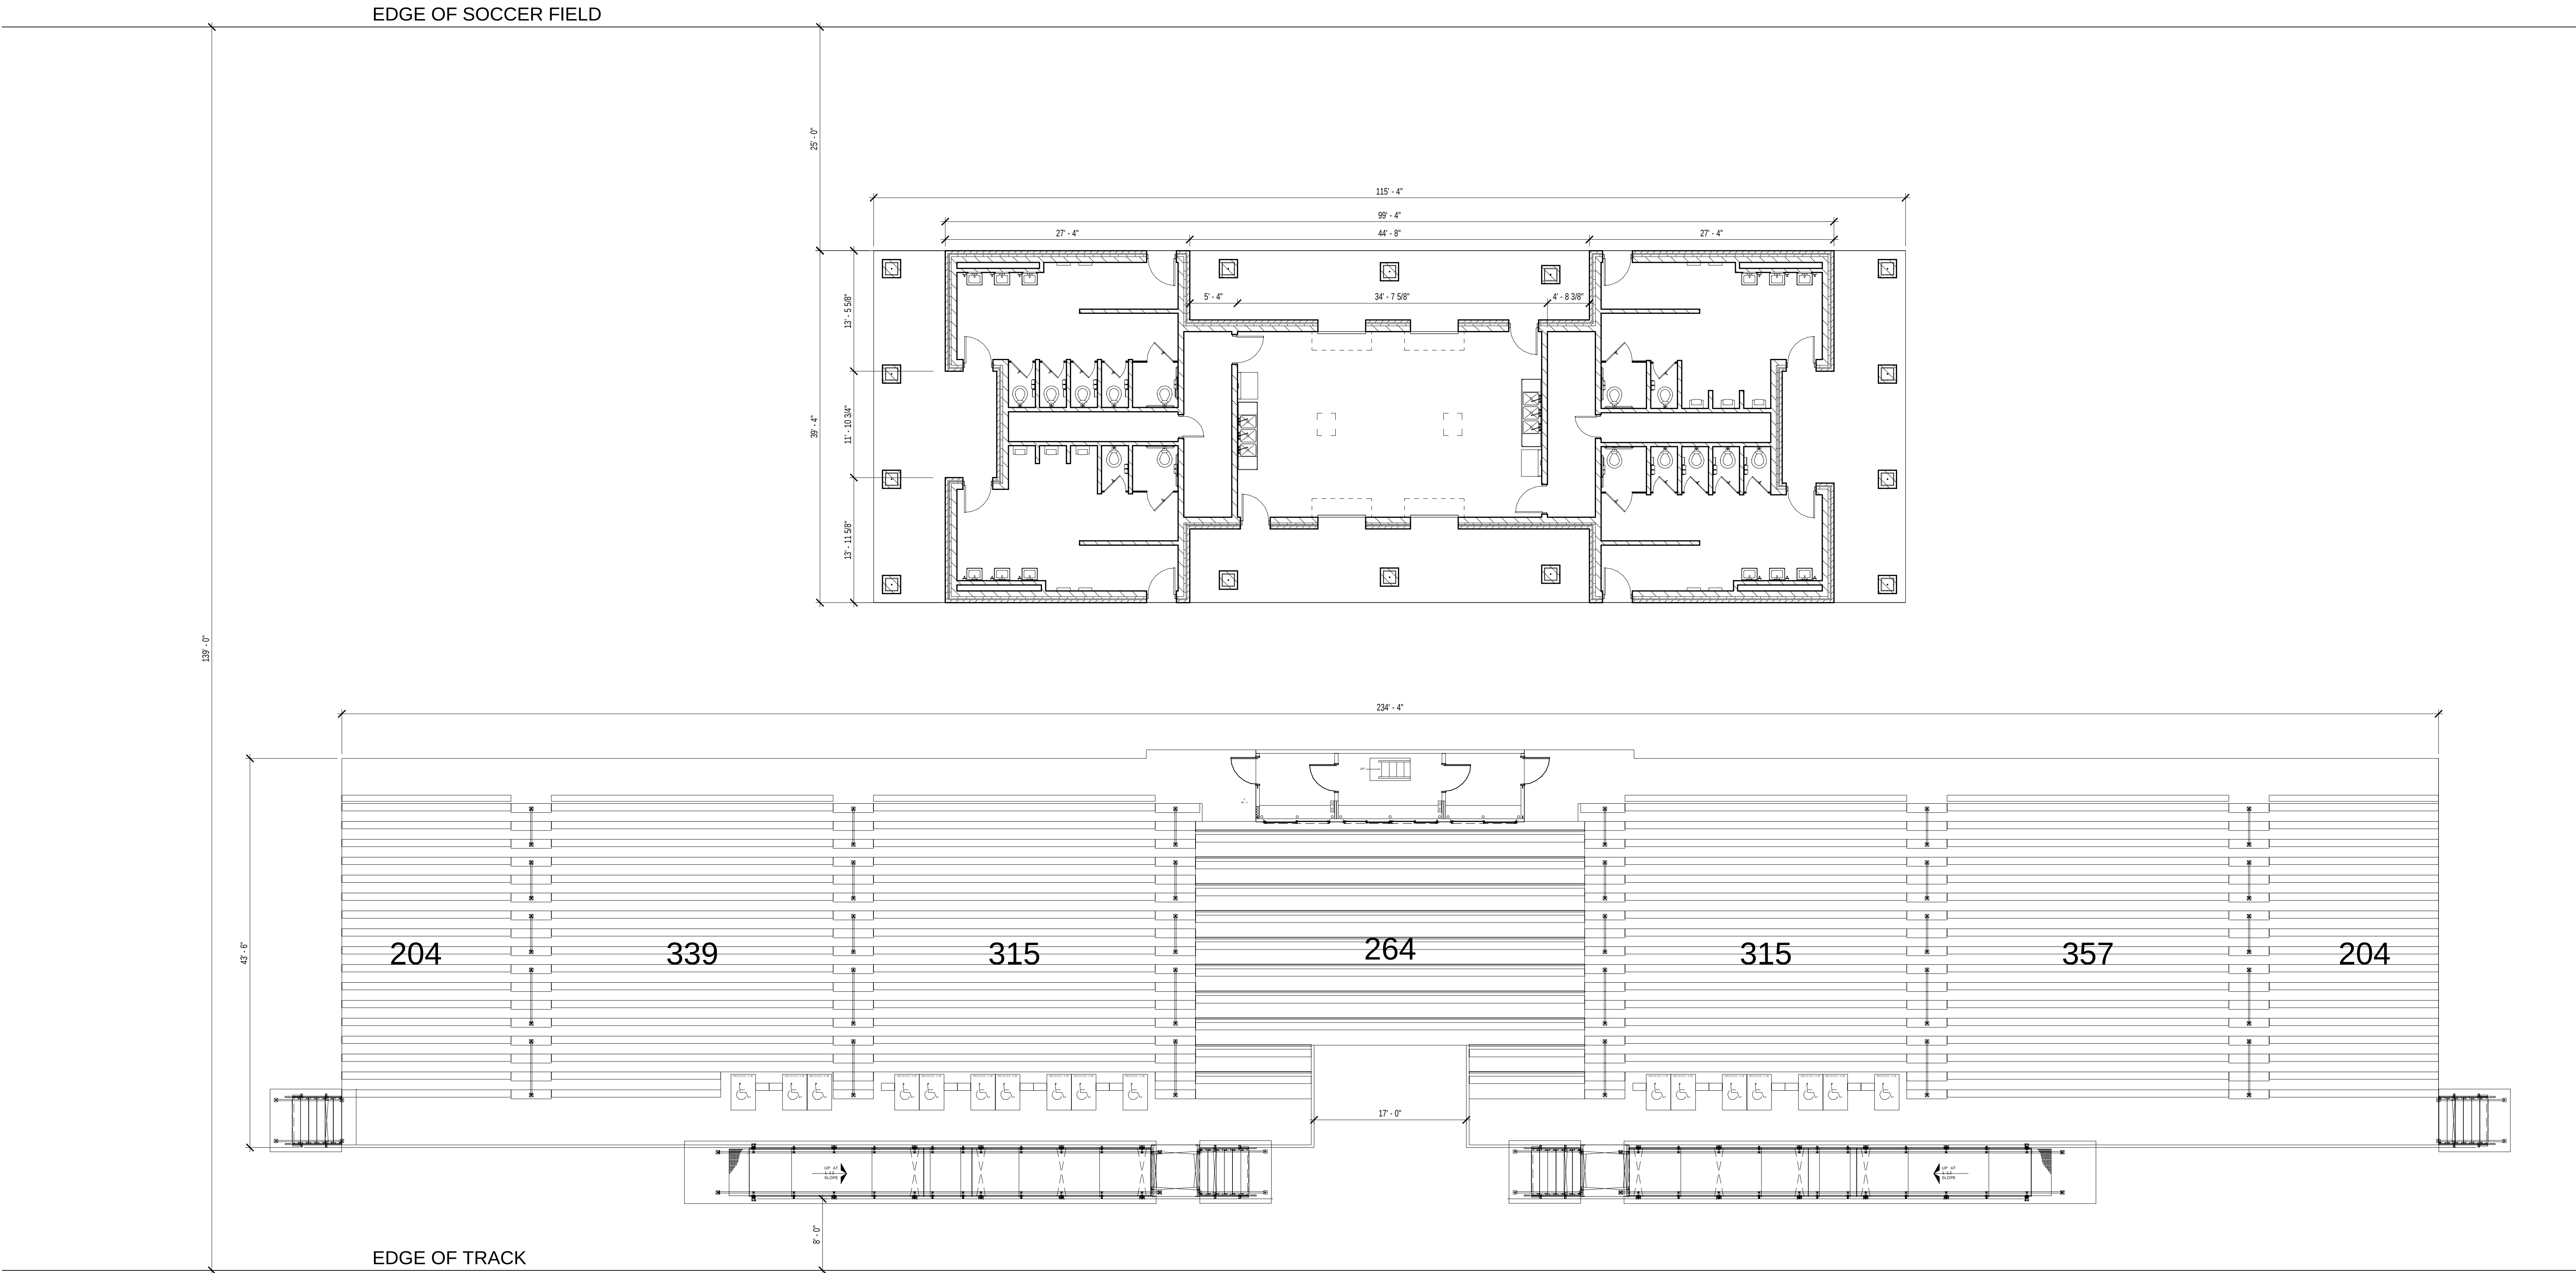


1 NEW FOOTBALL GRANDSTANDS- TOADVINE PROPOSAL
1/8" = 1'-0"

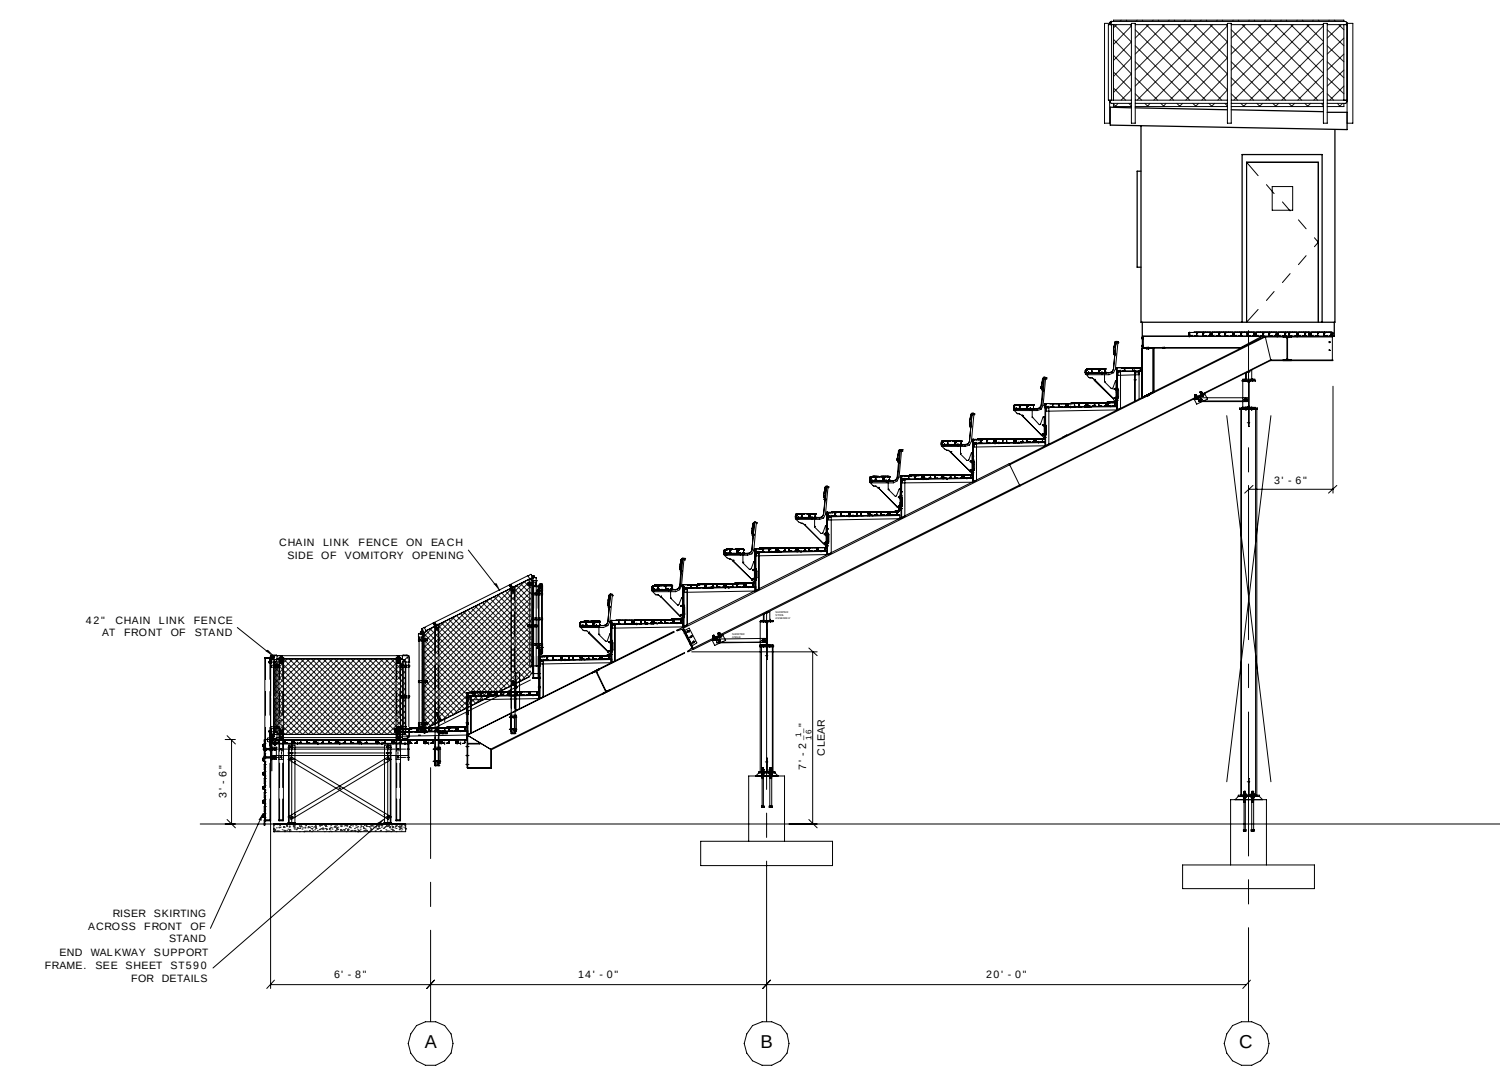


2 NEW FOOTBALL GRANDSTANDS SECTION- TOADVINE
1/8" = 1'-0"

JOB NO.	2459	
DATE	12/15/2025	
DRAWN	CAH	
CHECKED	RJV , ASC	
COPYRIGHT © 2025 SHERMAN CARTER BARNHART ARCHITECTS, PLLC		
REVISIONS		
No.	Description	Date

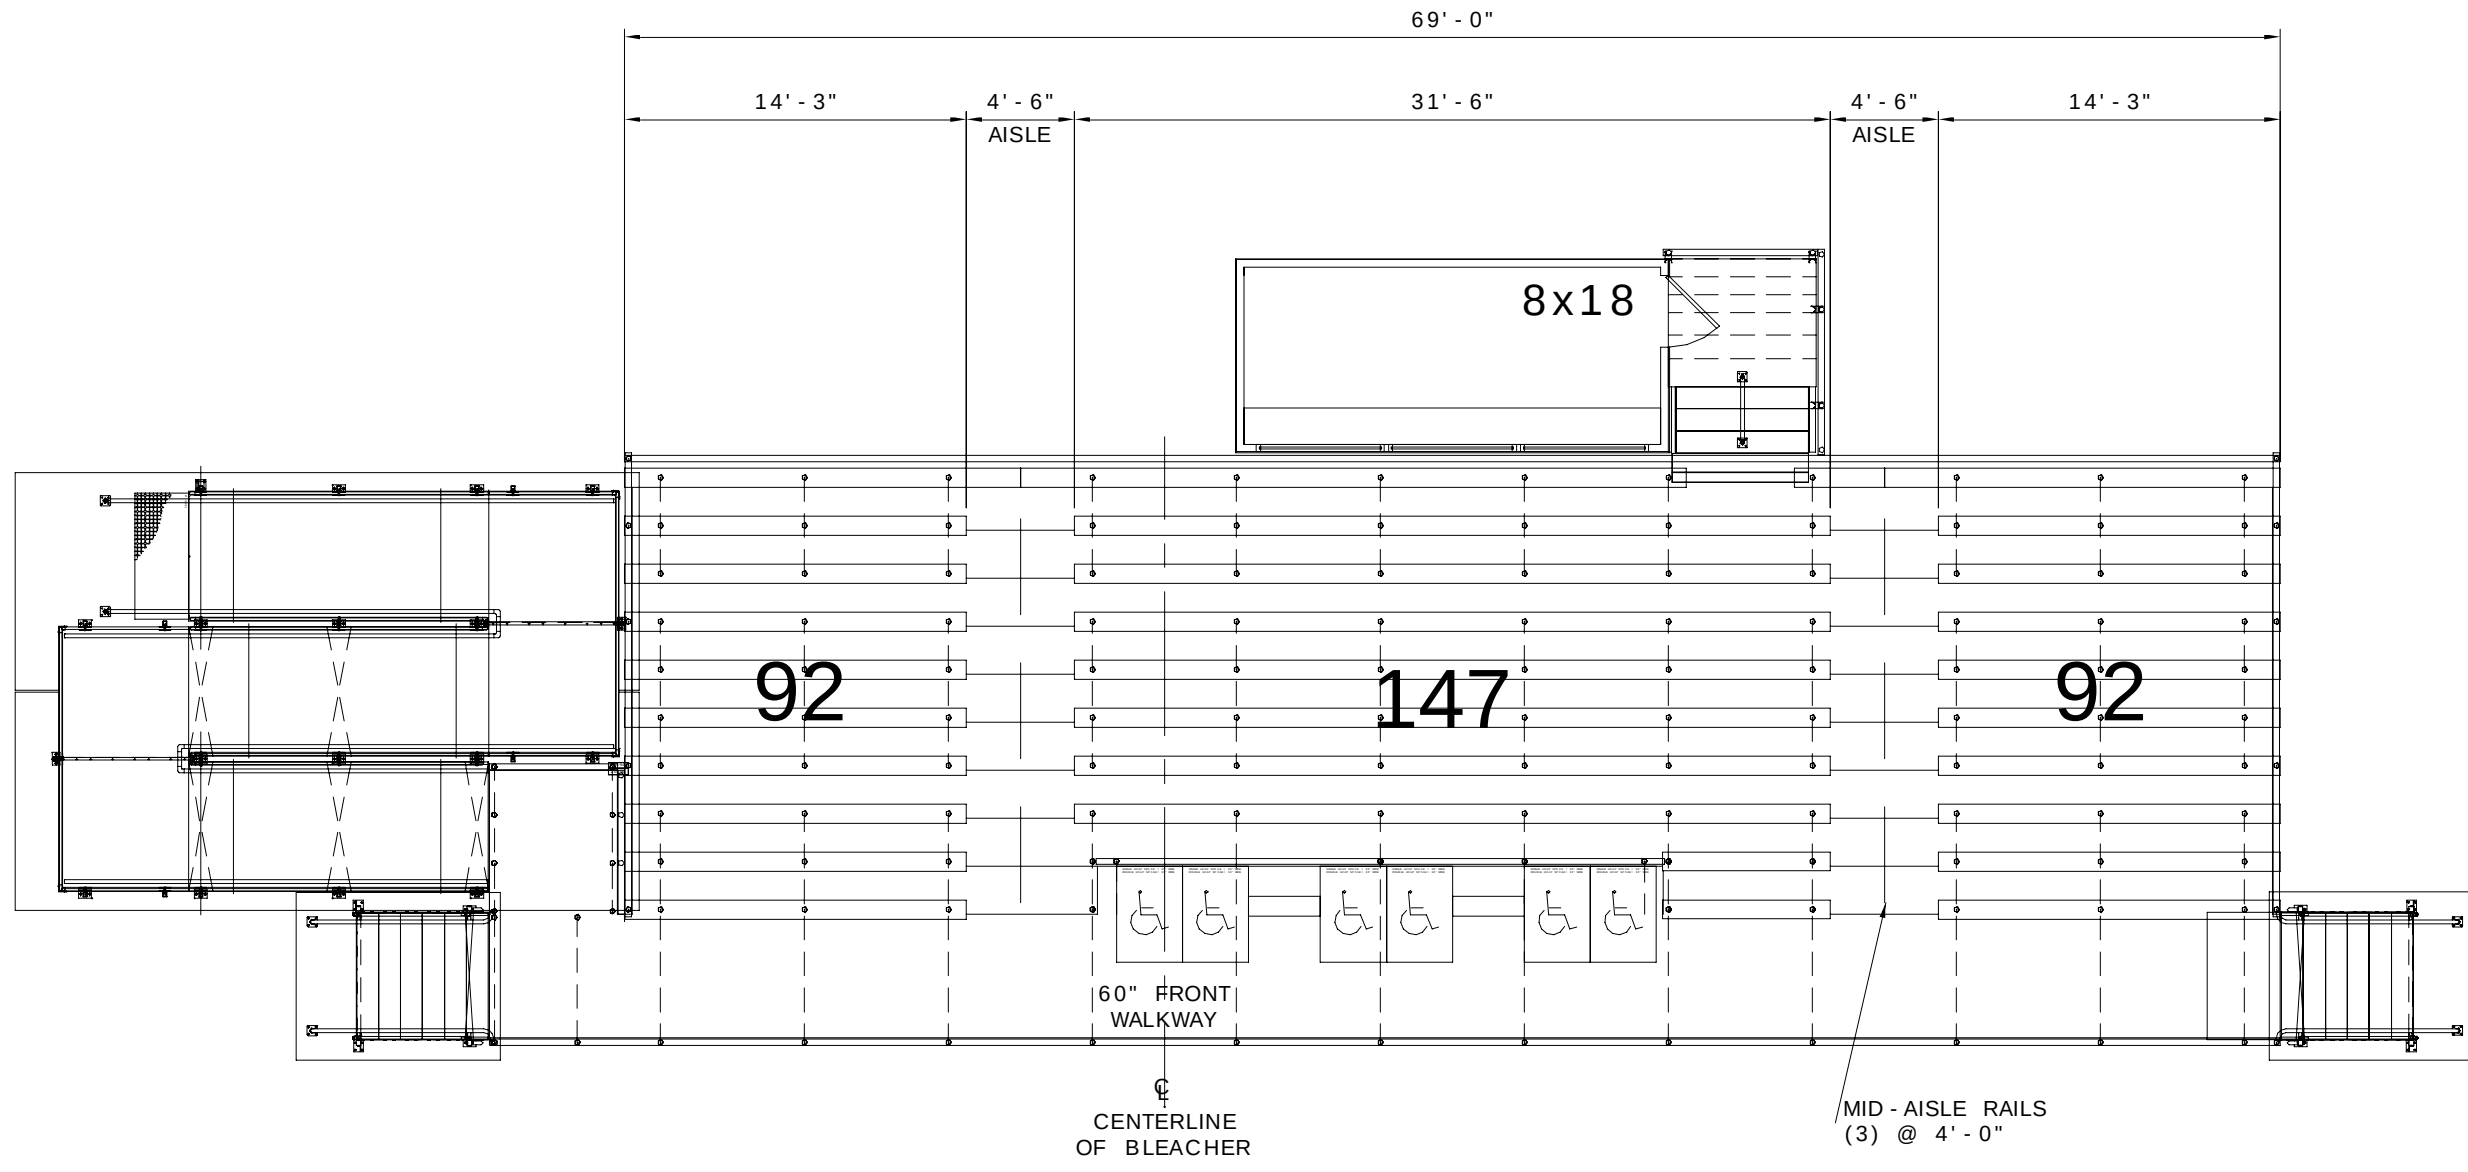

1 SOCCER GRANDSTANDS- TOADVINE
1/8" = 1'-0"

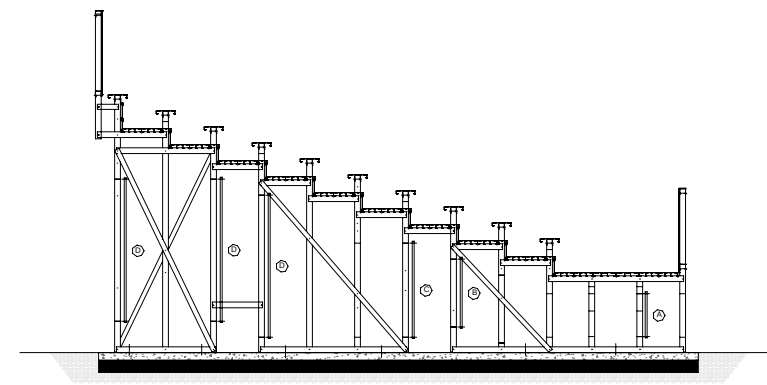

2 GRANDSTAND TYP. SECTION - TOADVINE
1/8" = 1'-0"

FLOOR PLAN KEYNOTES

1. OWNER PROVIDED FURNITURE OR EQUIPMENT (N.I.C.).
2. LINE OF SOFFIT / BULKHEAD ABOVE, REFER TO REFLECTED CEILING PLAN.
3. PRE-MFR, PRE-FIN SUSPENDED ALUMINUM CANOPY, REFER TO DETAIL 11JA4.2.
4. EXTERIOR CONCRETE WALK, REFER TO SITE DRAWINGS.
5. HIGH / LOW ADA COMPLIANT WATER COOLER UNIT, REFER TO MECH. / ELEC. DRAWINGS.
6. MOP SINK, REFER TO PLUMBING DRAWINGS.
7. KNOX BOX RECESSED IN BRICK, REFER TO DOOR HARDWARE SPECIFICATIONS.
8. FLOOR TRANSITION, REFER TO SHEET A8.1 FOR DETAILS.
9. SHIPS LADDER, REFER TO DETAIL 11JA0.3.
10. DIVIDER CURTAIN, MOTORIZED OPERATOR, REFER TO ELEC. DWGS.
11. 7'-0" TALL X 2" THICK WALL PAD WITH WOOD BACKING. ATTACH TO WALLS / COLUMNS WITH MANUFACTURER'S STANDARD 1/2" CLIP SYSTEM.
12. ELECTRIC PUSH-BUTTON ADA DOOR OPERATOR, REFER TO ELEC. DWGS.


GENERAL NOTES

1. (OF-C) OWNER FURNISHED CONTRACTOR INSTALLED.
2. EXISTING TO REMAIN INTERIOR WALLS THAT ARE EXPOSED IN AREAS OF RENOVATION TO BE CLEANED, REPAIRED, PRIMED, AND PAINTED FOR LIKE NEW FINISH.
3. DO NOT SCALE DWGS, WRITTEN DIMENSIONS TAKE PRECEDENCE OVER SCALED DIMENSIONS.
4. INTERIOR MASONRY CONTROL JOINTS TO OCCUR EVERY 20'-0" MAX.
5. NOTE: MARKER BOARD (MB) AND TACK BOARD (TB) INDICATE WIDTH AND ARE TO BE 48" H.

SYMBOL LEGEND

- ROOM FINISH GROUPS (REFER TO KEY PLAN SHEETS)
- ROOM NUMBER
- DOOR NUMBER (DOOR SCHEDULE SHEET A8.1)
- KEY NOTES (SHEETS A1.3 THROUGH A2.8)
- WALL TYPE (SCHEDULE SHEET A0.1)
- ALUMINUM OR HOLLOW METAL WINDOW OR STOREFRONT TYPE (REFER TO FLOOR PLANS AND SCHEDULE SHEETS A8.2)
- TOILET ACCESSORIES (SCHEDULE SHEET A2.7)
- ELEVATION KEY NOTE (SHEETS A3.1)
- ROOF KEY NOTE (SHEET A4.1)
- CEILING PLAN KEY NOTE (SHEETS A7.1 THROUGH A7.7)
- SIGNAGE KEY NOTE (REFER TO KEY PLAN SHEETS)
- WALL / PARTITION DESIGNATION
- FW2 2 HOUR RATED FIRE WALL
- EPW2 EXISTING 2 HOUR RATED FIRE WALL
- MASONRY CONTROL JOINT FULL HEIGHT OF WALL. REFER TO FLOOR PLANS AND EXTERIOR ELEVATION A3.1 FOR LOCATIONS

KEY PLAN

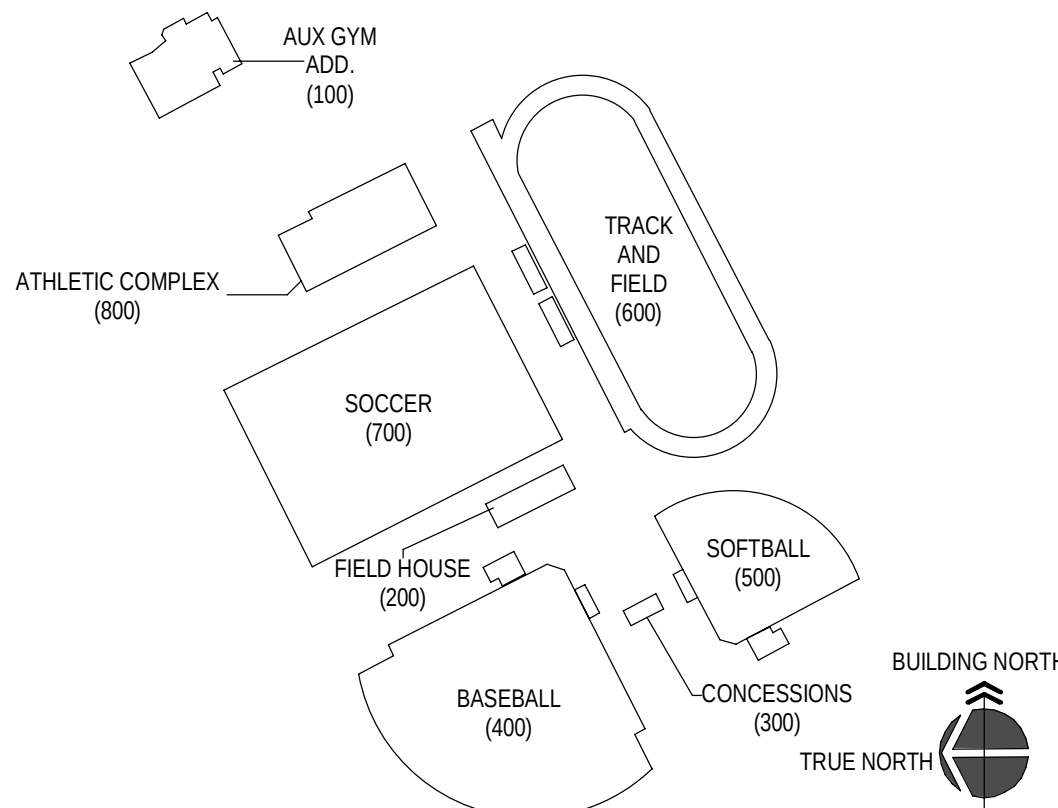

JOB NO.	2459	
DATE	12/15/2025	
DRAWN	CAH	
CHECKED	RJV, ASC	
COPYRIGHT © 2025 SHERMAN CARTER BARNHART ARCHITECTS, PLLC		
REVISIONS		
No.	Description	Date

JOB NO.	2459	
DATE	12/15/2025	
DRAWN	CAH	
CHECKED	RJV , ASC	
COPYRIGHT © 2025 SHERMAN CARTER BARNHART ARCHITECTS, PLLC		
REVISIONS		
No.	Description	Date

SHEET

A8.0

DEMOLITION KEY NOTES

- DEMOLISH EXISTING HANDRAILS IN THEIR ENTIRETY.
- DEMOLISH EXISTING CANOPY STRUCTURE AND ALL COMPONENTS TO FACILITATE NEW WORK IN THIS AREA.
- REMOVE EXISTING CORNICE STOOP & STEPS, REFER TO SITE DEMOLITION DWGS FOR ADDITIONAL INFO.
- REMOVE EXISTING CONCRETE SIDEWALK, REFER TO SITE DEMOLITION DWSS.
- REMOVE EXISTING ALUMINUM STOREFRONT WINDOW SYSTEM.
- REMOVE A PORTION OF EXISTING EIFS SOFFIT @ EXTERIOR OF EXISTING CAFETERIA.
- REMOVE EXISTING ALUMINUM STOREFRONT DOOR SYSTEM.

GENERAL DEMOLITION NOTES

- A. ALL EXISTING SUSPENDED CEILINGS TO BE REMOVED, COORDINATE WITH PHASING PLANS AND MEP WORK.
- B. DEMOLITION REFERENCE NOTES FOR THIS PROJECT ARE INTENDED TO GENERALLY IDENTIFY THE SELECTIVE REMOVAL OF EXISTING ITEMS AT LOCATIONS WHERE REQUIRED BUT, SHALL IN NO WAY RELIEVE THE CONTRACTOR OF THE FULL RESPONSIBILITY FOR EXAMINING AND VERIFYING THE FULL EXTENT OF EXISTING CONDITIONS PRIOR TO BIDDING THE PROJECT.
- C. THE INTENT OF THE DEMOLITION NOTES IS TO PROVIDE A GENERAL OUTLINE FOR THE CONTRACTOR OF ITEMS TO BE REMOVED AND/OR TURNED OVER TO THE OWNER AND TO ALLOW FOR THE NEW CONSTRUCTION AS OUTLINED ELSEWHERE IN THE CONTRACT DOCUMENTS. THE CONTRACTOR SHALL BE RESPONSIBLE FOR ALL DEMOLITION AND REMOVAL OF ITEMS TO ALLOW FOR NEW CONSTRUCTION SHOWN OR NOT SHOWN ON DEMOLITION PLANS AS MAY BE REQUIRED.
- D. CAVITY WALLS AND SPACES BEHIND EXTERIOR FINISHES OR PARTIALLY REMOVED WALLS/ROOFS, ETC. SHALL BE PROTECTED FROM EXPOSURE TO WEATHER BY THE CONTRACTOR. WALLS/ROOFS, ETC. SHALL BE PROTECTED. THE CONTRACTOR SHALL BE RESPONSIBLE FOR ANY DAMAGED WALLS, ROOFS, EQUIPMENT, ETC. CAUSED BY THIS DEMOLITION OR WEATHER EXPOSURE OF ITEMS THAT ARE TO REMAIN.
- E. INFORMATION AND DRAWINGS INCLUDED IN THESE CONTRACT DOCUMENTS PERTAINING TO THIS RENOVATION PROJECT HAVE BEEN OBTAINED FROM ORIGINAL DRAWINGS PROVIDED BY MEADE COUNTY BOARD OF EDUCATION AND FIELD OBSERVATIONS. THIS INFORMATION IS INCLUDED HEREIN WITH THE INTENT TO PROVIDE THE CONTRACTOR WITH A BASIC UNDERSTANDING OF EXISTING CONDITIONS. ACTUAL CONDITIONS AND DIMENSIONS MAY VARY FROM THOSE INDICATED ON DRAWINGS.
- F. REFER TO STRUCTURAL DRAWINGS FOR SPECIFIC REQUIREMENTS AT EXISTING CONDITIONS REQUIRING PARTIAL OR COMPLETE REMOVAL AND/OR MODIFICATION TO COMPONENTS OR ASSEMBLIES PERTAINING TO EXISTING BUILDING STRUCTURE.
- G. REFER TO MECHANICAL AND/OR ELECTRICAL DRAWINGS AND SPECIFICATIONS FOR SPECIFIC REQUIREMENTS PERTAINING TO THE REMOVAL, RELOCATION AND/OR MODIFICATION OF ITEMS RELATED TO EXISTING MECHANICAL AND ELECTRICAL SYSTEMS.
- H. SHOULD THE CONTRACTOR ENCOUNTER ANY MATERIALS DURING SELECTIVE DEMOLITION AND NEW WORK WHICH ARE SUSPECTED BY THE CONTRACTOR TO BE OF AN UNKNOWN OR QUESTIONABLE COMPOSITION WITH RESPECT TO CONTAINING CONTAMINANTS WHICH MAY BE HAZARDOUS TO HUMAN HEALTH, THE CONTRACTOR SHALL IMMEDIATELY NOTIFY THE OWNER OF SUCH FINDINGS.
- I. WHERE AN EXISTING WALL IS REMOVED AND NO NEW WALL IS SHOWN TO BE INSTALLED, REMOVE EXISTING WALL TO 8 INCHES BELOW ADJACENT FLOOR SLAB. PATCH AND REPAIR SLAB AS REQUIRED FOR INSTALLATION OF NEW FLOOR FINISH. REFER TO NEW WORK PLANS.
- J. ALL AREAS LEFT EXPOSED AS A RESULT OF DEMOLITION AND/OR EQUIPMENT REMOVAL SHALL BE PATCHED AND REPAIRED TO RESULT IN A FLUSH SMOOTH SURFACE PREPARED TO RECEIVE NEW FINISHES AS SCHEDULED. ANY AREAS/OPENINGS IN MASONRY WALLS LARGER THAN 2" EXPOSED TO VIEW SHALL BE PATCHED WITH SOAPED IN CMU UNITS TOOTHED-IN INTO EXISTING MASONRY.
- K. CONTRACTOR SHALL BE RESPONSIBLE FOR ALL PATCHING AND REPAIRING DUE TO DEMOLITION AND/OR REMOVAL OF EQUIPMENT TO CREATE A FLUSH, SMOOTH SURFACE PROPERLY PREPARED TO RECEIVE NEW FINISHES AS SCHEDULED. CONTRACTOR SHALL SOAP IN NEW CMU TO MATCH EXISTING ADJACENT AREAS.
- L. REFER TO MECH/ELEC DRAWINGS FOR SPECIFIC NOTES REGARDING REMOVAL OF EXISTING MECH/ELEC ITEMS NOT SHOWN ON THIS SHEET.
- M. REFER TO STRUCTURAL DRAWINGS FOR NEW WORK (I.E. NEW FOOTING, ETC.) WHICH MAY REQUIRE DEMOLITION WORK IN ADDITION TO ITEMS NOTED ON THE ARCHITECTURAL DRAWINGS ALL SUCH WORK SHALL BE PERFORMED BY THE CONTRACTOR.
- N. REFER TO CIVIL/SITE DRAWINGS FOR ADDITIONAL DEMOLITION OF SITE/CIVIL ITEMS NOT SHOWN.


HAZARDOUS MATERIAL NOTES

DUE TO THE AGE OF THE EXISTING BUILDING, IT IS POSSIBLE HAZARDOUS MATERIALS MAY EXIST, INCLUDING, BUT NOT LIMITED TO ASBESTOS PRODUCTS, POLYCHLORINATED BIPHENYL (PCB) AND OTHER TOXIC SUBSTANCES. IF ANY WORK PERSON ENCOUNTERS ANY MATERIAL WHICH THEY SUSPECT MIGHT BE HAZARDOUS OR TOXIC, THEY SHALL IMMEDIATELY ADVISE THE OWNER. THE CONTRACTOR SHALL TAKE IMMEDIATE AND APPROPRIATE ACTION TO PROTECT THE BUILDING USERS AND WORKERS IN ACCORDANCE WITH FEDERAL, STATE AND LOCAL LAWS, CODES AND REGULATIONS. THE ARCHITECT AND ARCHITECT'S CONSULTANTS SHALL HAVE NO RESPONSIBILITY FOR THE DISCOVERY, PRESENCE, HANDLING, REMOVAL OR DISPOSAL OF OR EXPOSURE OF PERSONS TO HAZARDOUS MATERIALS IN ANY FORM AT THE PROJECT SITE, INCLUDING BUT NOT LIMITED TO ASBESTOS, ASBESTOS PRODUCTS, POLYCHLORINATED BIPHENYL (PCB) OR OTHER TOXIC SUBSTANCES.

- THE CONTRACTOR IS HEREBY ADVISED THAT SHERMAN-CARTER-BARNHART, PLLC IS NOT A DESIGN PROFESSIONAL IN THE DETERMINATION OF THE PRESENCE OF HAZARDOUS MATERIALS, NOR IS SHERMAN-CARTER-BARNHART, PLLC A DESIGN PROFESSIONAL INVOLVED IN MAKING RECOMMENDATIONS REGARDING THE TESTING, REMOVAL, ENCLOSURE OR OTHER CORRECTIVE MEASURES PERTAINING TO HAZARDOUS MATERIALS.
- IF THE WORK WHICH IS TO BE PERFORMED UNDER THE CONTRACT INTERFACES IN ANY WAY WITH THE EXISTING COMPONENTS WHICH CONTAIN HAZARDOUS MATERIALS, IT IS THE CONTRACTOR'S RESPONSIBILITY TO CONTACT THE OWNER'S ENVIRONMENTAL CONSULTANT REGARDING THE PROPER MEANS AND METHODS TO BE UTILIZED WITH HAZARDOUS MATERIALS.
- BY EXECUTION OF THE CONTRACT FOR CONSTRUCTION, THE CONTRACTOR HEREBY AGREES TO BRING NO CLAIM FOR NEGLIGENCE, BREACH OF CONTRACT, INDEMNITY OR OTHERWISE AGAINST THE ARCHITECT, HIS PRINCIPALS, EMPLOYEES, AGENTS OR CONSULTANTS IF SUCH A CLAIM IN ANY WAY WOULD INVOLVE THE INVESTIGATION OF OR REMEDIAL WORK RELATED TO HAZARDOUS MATERIALS IN THE PROJECT.
- BY EXECUTION OF THE CONTRACT FOR CONSTRUCTION, THE CONTRACTOR FURTHER AGREES TO DEFEND, INDEMNIFY AND HOLD THE ARCHITECT, HIS PRINCIPALS, EMPLOYEES, AGENTS AND CONSULTANTS HARMLESS FROM ANY SUCH ASBESTOS OR OTHER HAZARDOUS MATERIALS RELATED CLAIMS THAT MAY BE BROUGHT BY THE CONTRACTOR'S SUBCONTRACTORS, SUPPLIERS OR OTHER THIRD PARTIES WHO MAY BE ACTING UNDER THE DIRECTION OF THE CONTRACTOR PURSUANT TO THIS PROJECT.

DEMOLITION SYMBOL LEGEND

- [X] DEMOLITION KEY NOTE
- [---] EXISTING WALL / CONSTRUCTION TO REMAIN
- [---] EXISTING CONSTRUCTION TO BE REMOVED - FULL HEIGHT U.N.O. SEE SELECTIVE DEMOLITION NOTES
- [---] & [---] EXISTING DOOR / DOOR & FRAME TO REMAIN
- [---] & [---] EXISTING DOOR / DOOR & FRAME TO BE REMOVED, U.N.O.
- [---] LIMITED TO NO ARCHITECTURAL WORK. EXISTING FINISHES TO REMAIN U.N.O. REFER TO MEP FOR MEP WORK THAT MAY BE REQUIRED.

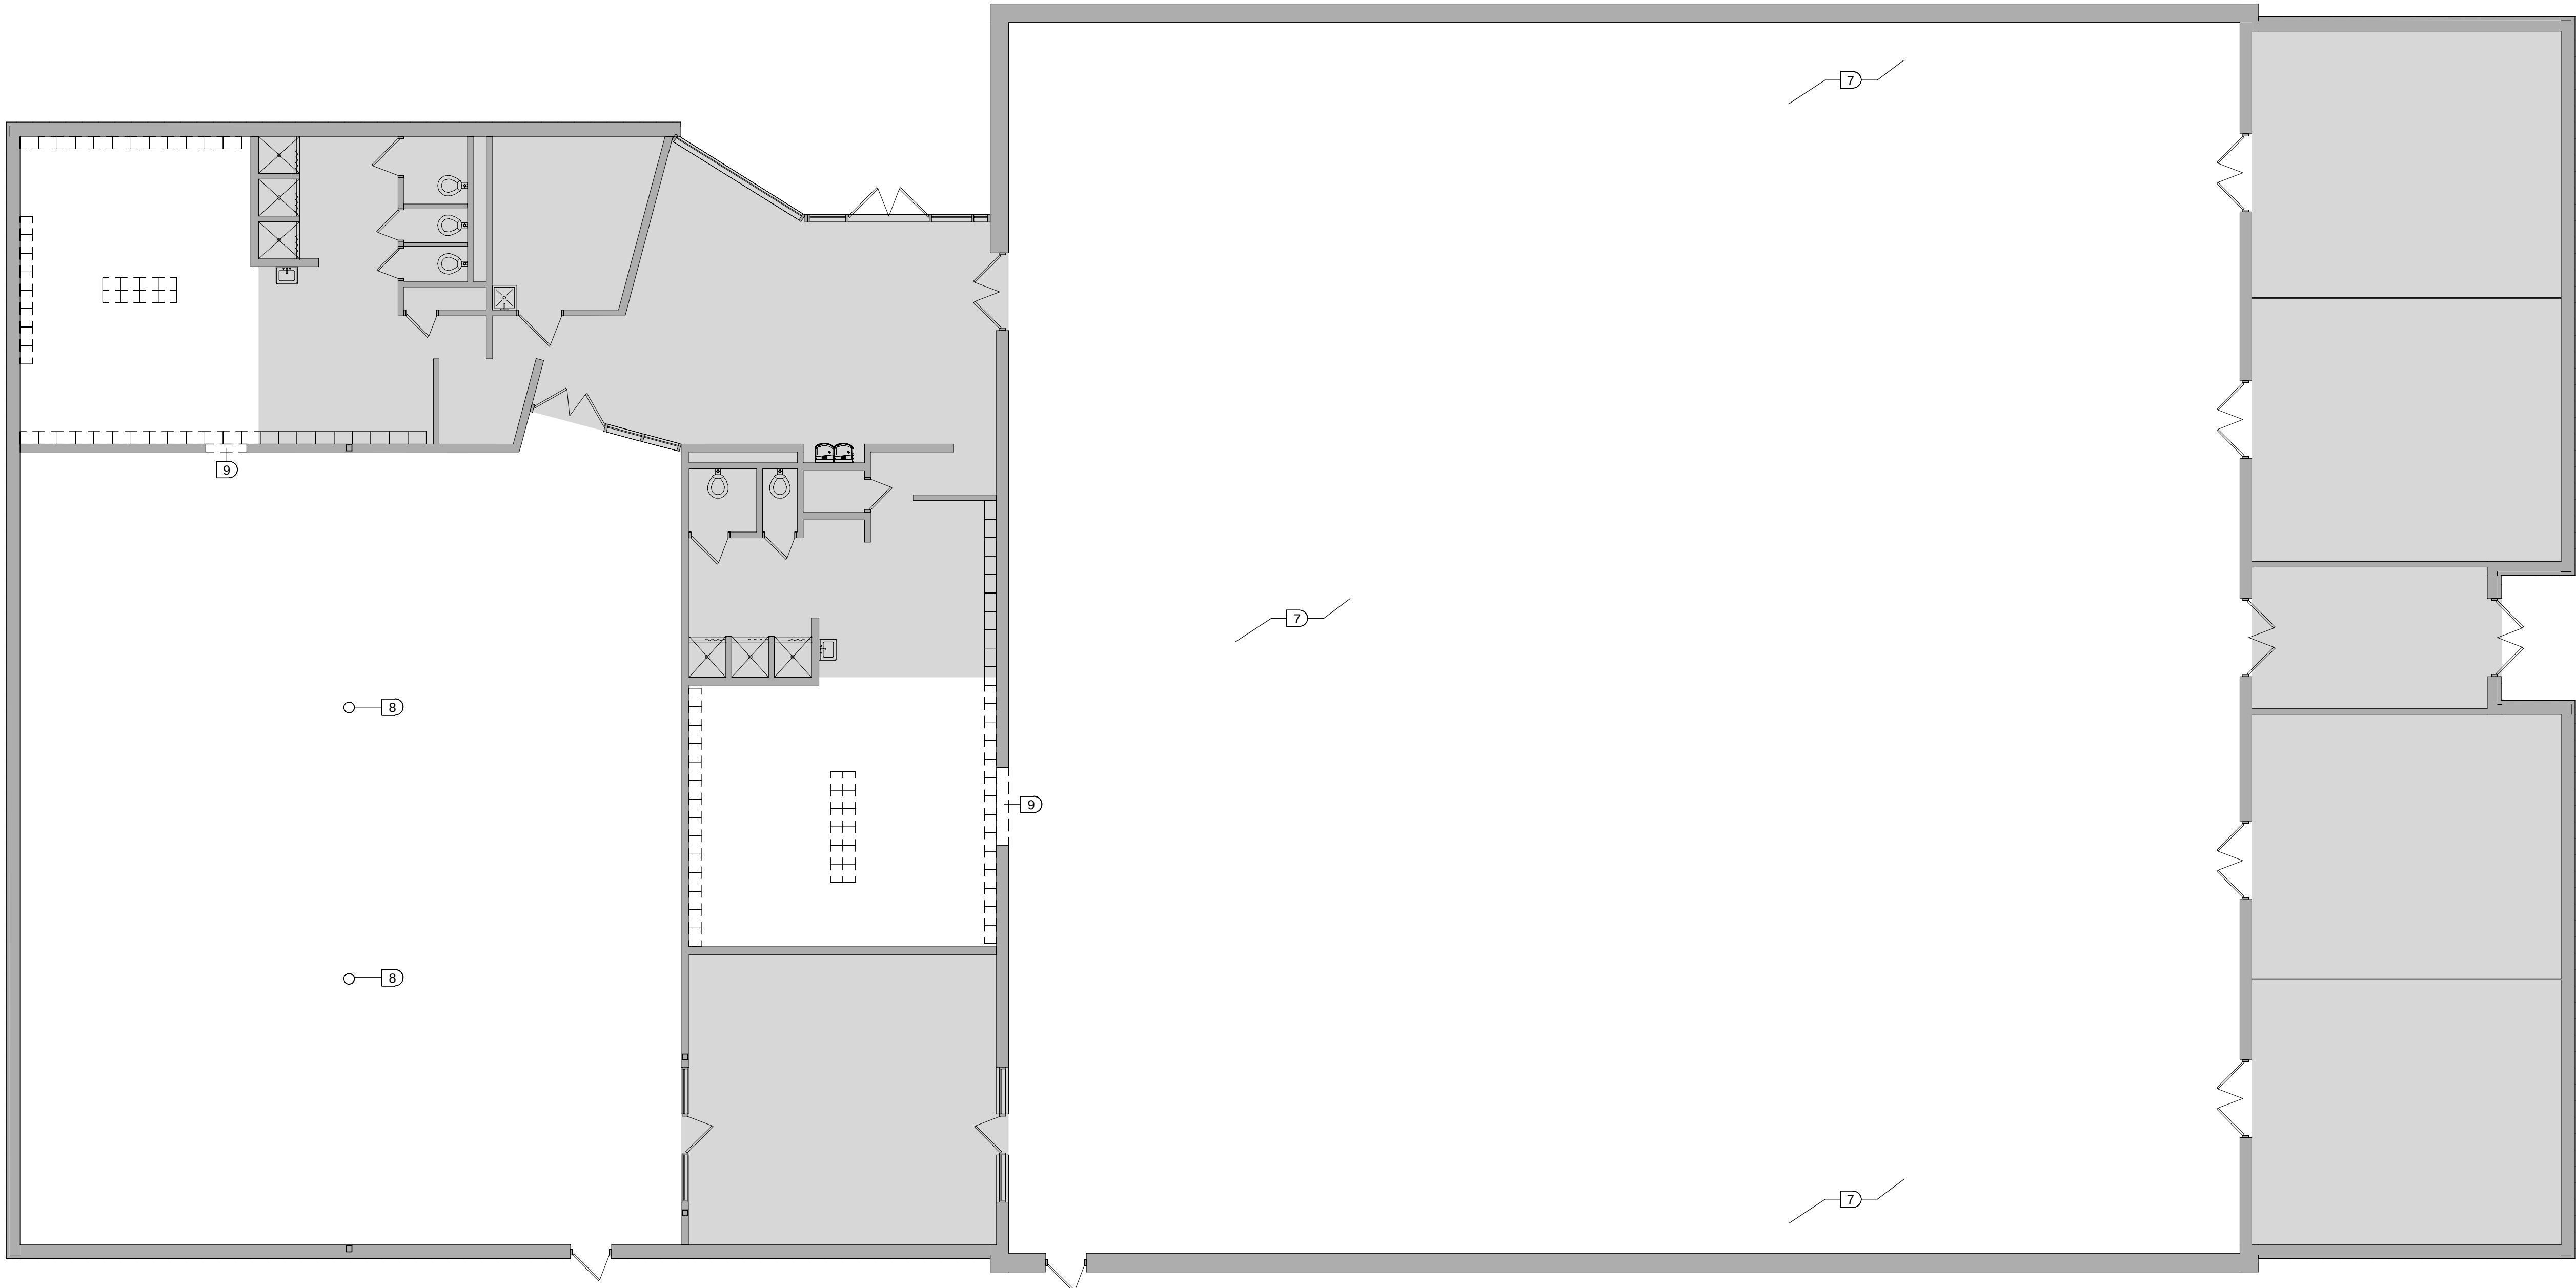


1 800 - FIRST FLOOR DEMOLITION PLAN
1/8" = 1'-0"




2 DEMOLITION - ATHLETIC COMPLEX 01
NO SCALE



3 DEMOLITION - ATHLETIC COMPLEX 02
NO SCALE

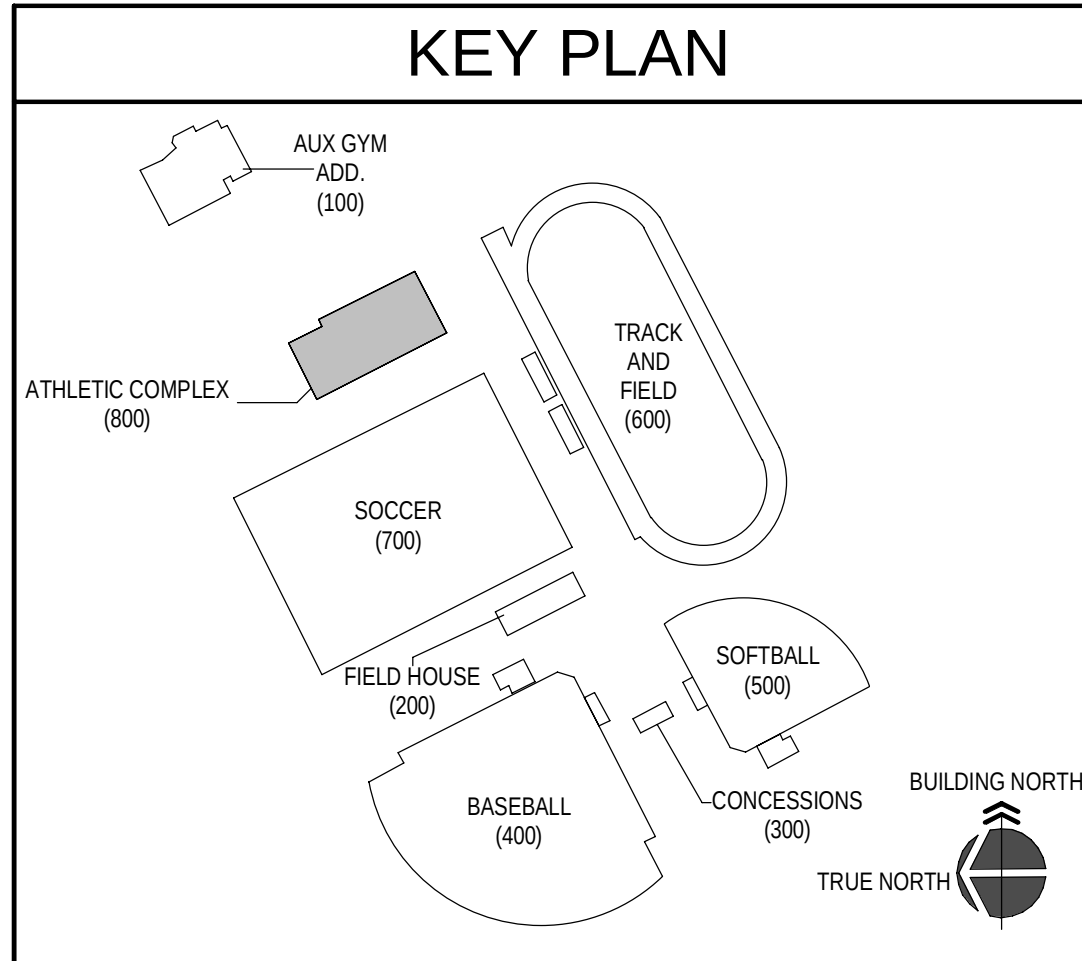

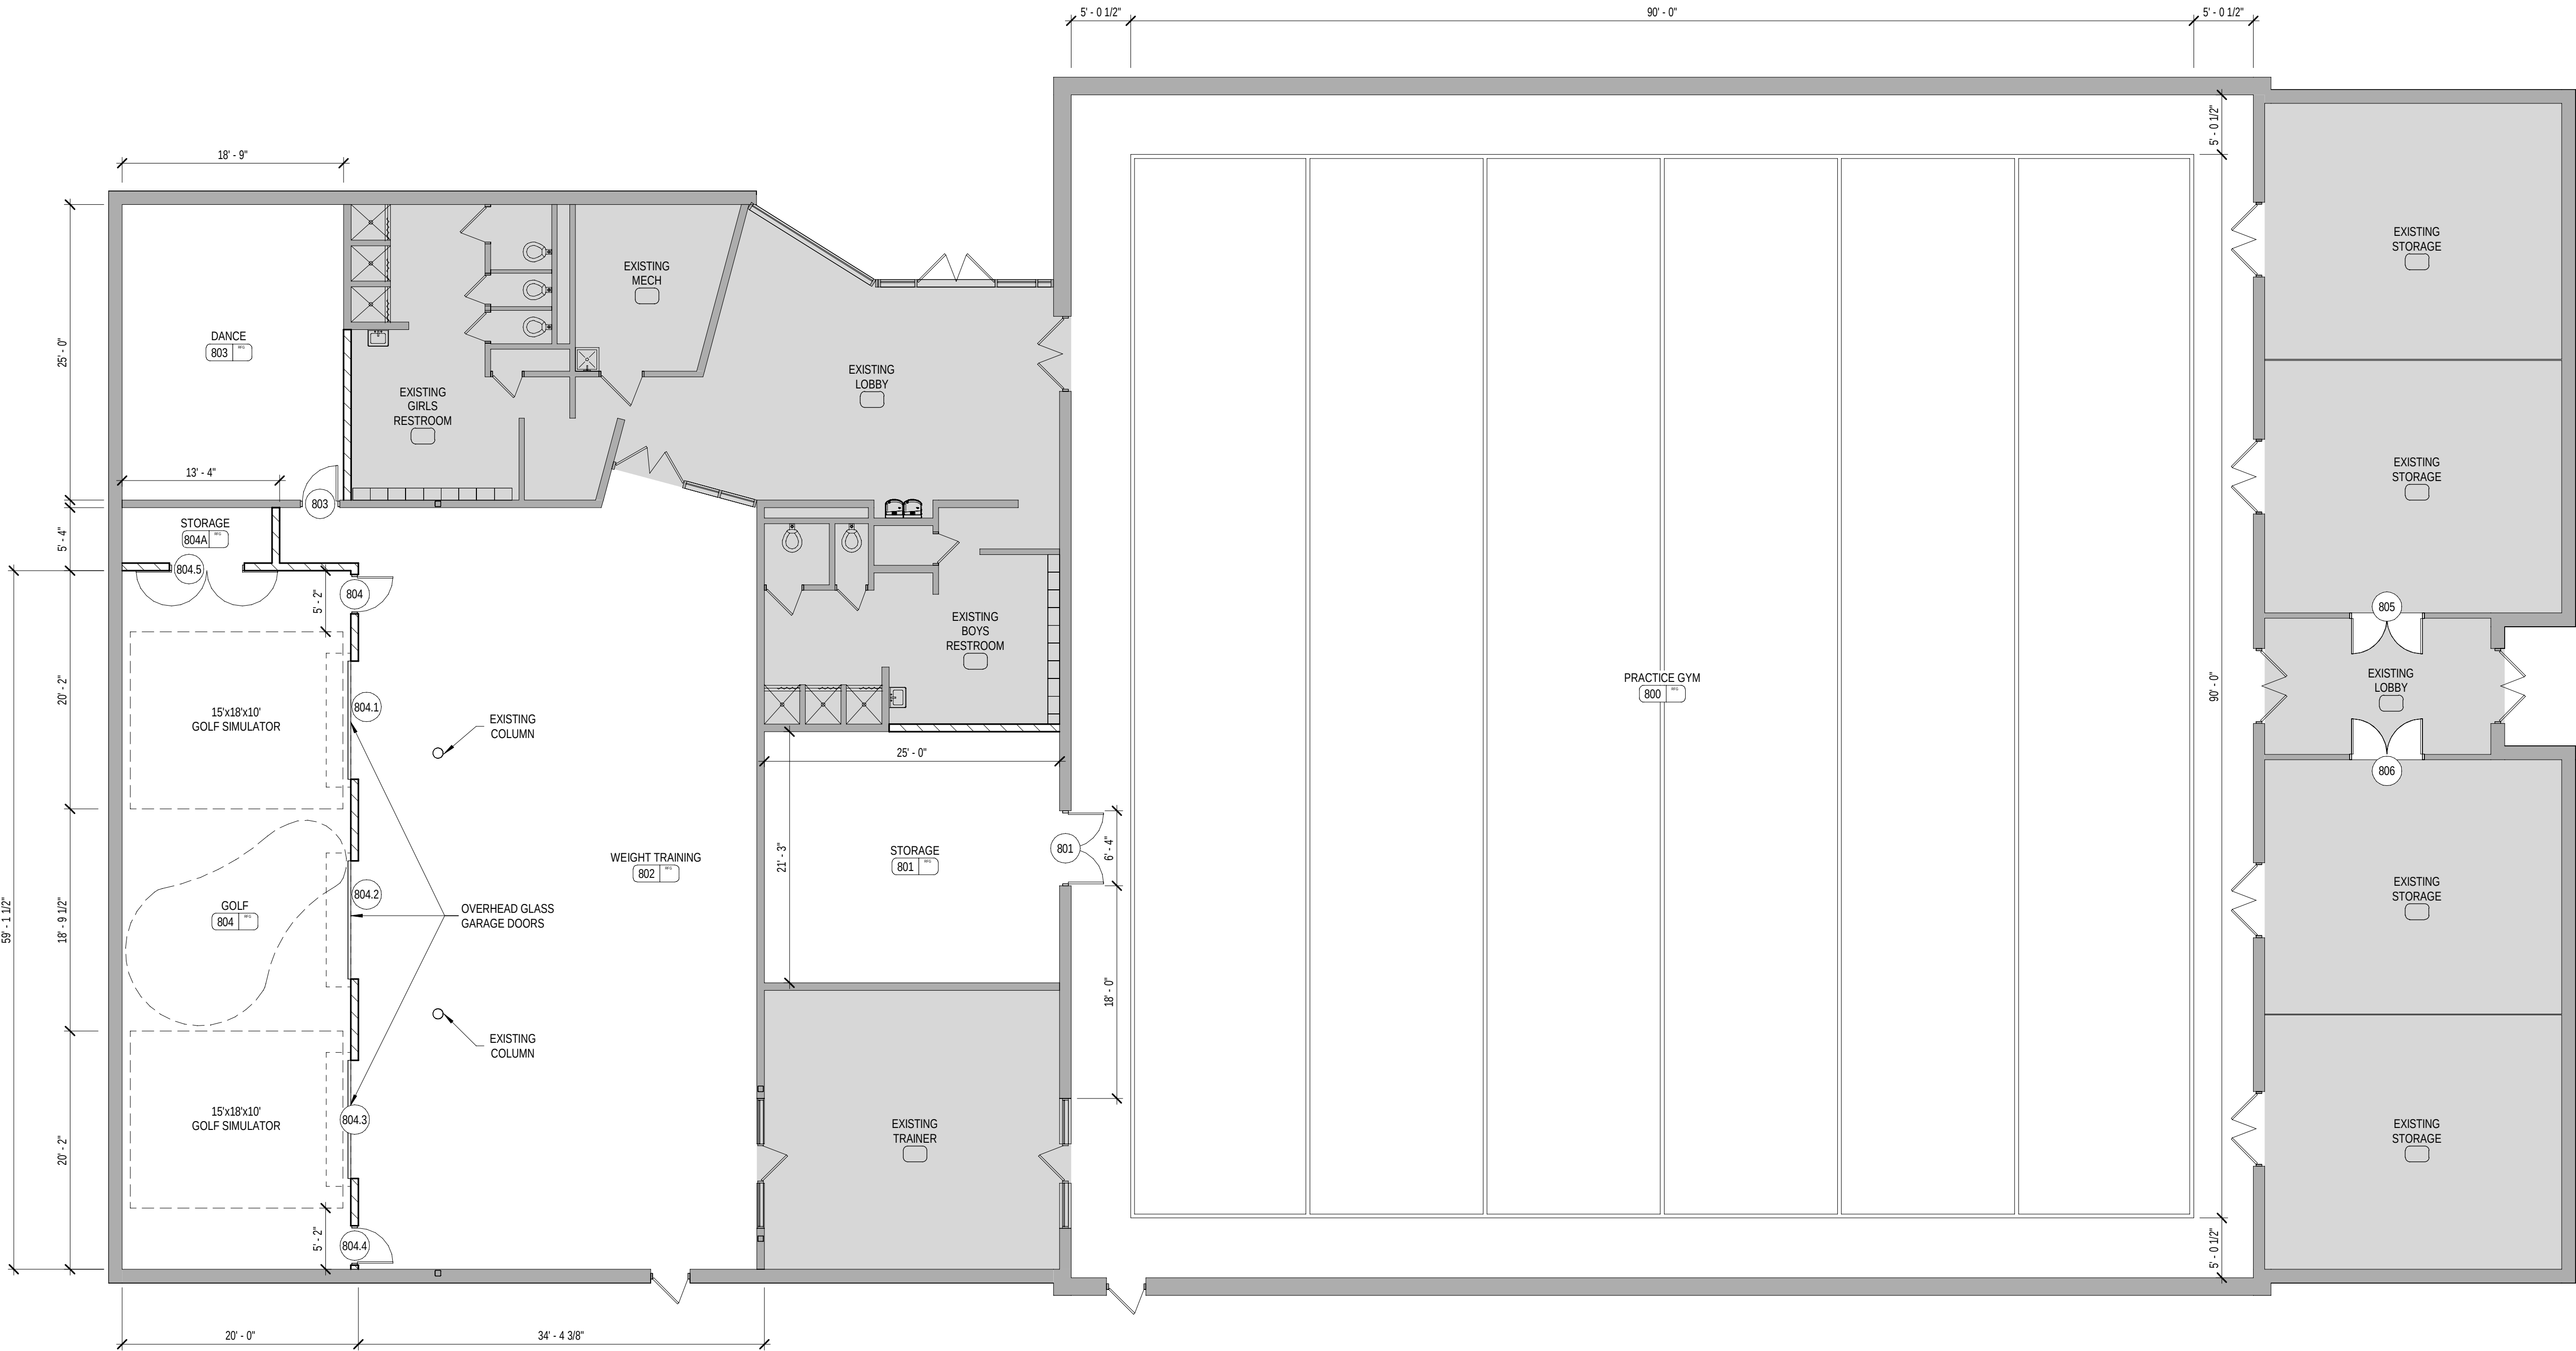

1 800 - NEW WORK FLOOR PLAN
1/8" = 1'-0"

FLOOR PLAN KEYNOTES

1. OWNER PROVIDED FURNITURE OR EQUIPMENT (N.I.C.).
2. LINE OF SOFFIT / BULKHEAD ABOVE, REFER TO REFLECTED CEILING PLAN.
3. PRE-MFR, PRE-FIN SUSPENDED ALUMINUM CANOPY, REFER TO DETAIL 11/A.2.
4. EXTERIOR CONCRETE WALK, REFER TO SITE DRAWINGS.
5. HIGH / LOW ADA COMPLIANT WATER COOLER UNIT, REFER TO MECH. / ELEC. DRAWINGS.
6. MOP SINK, REFER TO PLUMBING DRAWINGS.
7. KNOX-BOX RECESSED IN BRICK, REFER TO DOOR HARDWARE SPECIFICATIONS.
8. FLOOR TRANSITION, REFER TO SHEET A8.1 FOR DETAILS.
9. SHIP'S LADDER, REFER TO DETAIL 11/A0.3.
10. DIVIDER CURTAIN, MOTORIZED OPERATOR, REFER TO ELEC. DWGS.
11. 7'-0" TALL X 2" THICK WALL PAD WITH WOOD BACKING. ATTACH TO WALLS / COLUMNS WITH MANUFACTURER'S STANDARD "Z" CLIP SYSTEM.
12. ELECTRIC PUSH-BUTTON ADA DOOR OPERATOR, REFER TO ELEC. DWGS.


GENERAL NOTES

1. (OF-CI) OWNER FURNISHED CONTRACTOR INSTALLED.
2. EXISTING TO REMAIN INTERIOR WALLS THAT ARE EXPOSED IN AREAS OF RENOVATION TO BE CLEANED, REPAIRED, PRIMED, AND PAINTED FOR LIKE NEW FINISH.
3. DO NOT SCALE DWGS. WRITTEN DIMENSIONS TAKE PRECEDENCE OVER SCALED DIMENSIONS.
4. INTERIOR MASONRY CONTROL JOINTS TO OCCUR EVERY 20'-0" MAX.
5. NOTE: MARKER BOARD (MB) AND TACK BOARD (TB) INDICATE WIDTH AND ARE TO BE 48" H.

SYMBOL LEGEND

- ROOM FINISH GROUPS (REFER TO KEY PLAN SHEETS)
- ROOM NUMBER
- DOOR NUMBER (DOOR SCHEDULE SHEET A8.1)
- KEY NOTES (SHEETS A1.3 THROUGH A2.8)
- WALL TYPE (SCHEDULE SHEET A0.1)
- ALUMINUM OR HOLLOW METAL WINDOW OR STOREFRONT TYPE (REFER TO FLOOR PLANS AND SCHEDULE SHEETS A8.2)
- TOILET ACCESSORIES (SCHEDULE SHEET A2.7)
- ELEVATION KEY NOTE (SHEETS A3.1)
- ROOF KEY NOTE (SHEET A4.1)
- CEILING PLAN KEY NOTE (SHEETS A7.1 THROUGH A7.7)
- SIGNAGE KEY NOTE (REFER TO KEY PLAN SHEETS)
- WALL / PARTITION DESIGNATION
- FW2 - 2 HOUR RATED FIRE WALL
- EPW2 - EXISTING 2 HOUR RATED FIRE WALL
- MASONRY CONTROL JOINT FULL HEIGHT OF WALL. REFER TO FLOOR PLANS AND EXTERIOR ELEVATION A3.1 FOR LOCATIONS

KEY PLAN

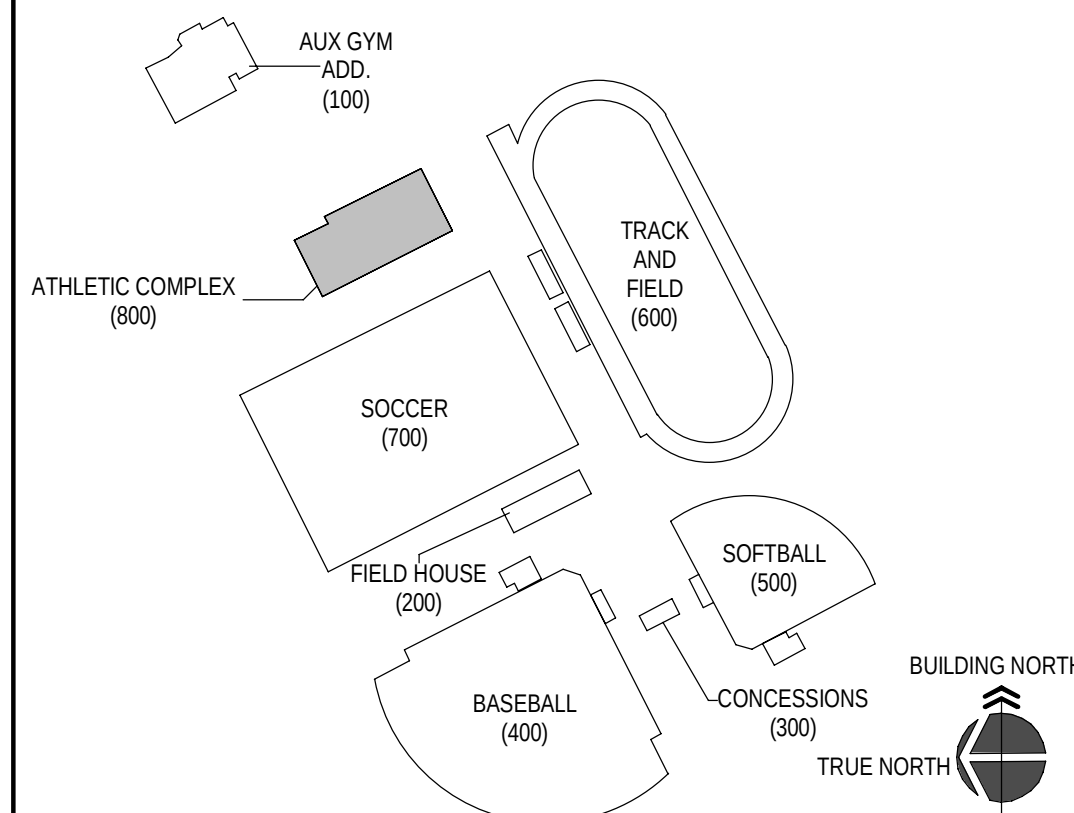


JOB NO.	2469
DATE	12/15/2025
DRAWN	CAH
CHECKED	RJV, ASC

COPYRIGHT © 2025
SHERMAN CARTER BARNHART
ARCHITECTS, PLLC

REVISIONS	No.	Description	Date

SHEET

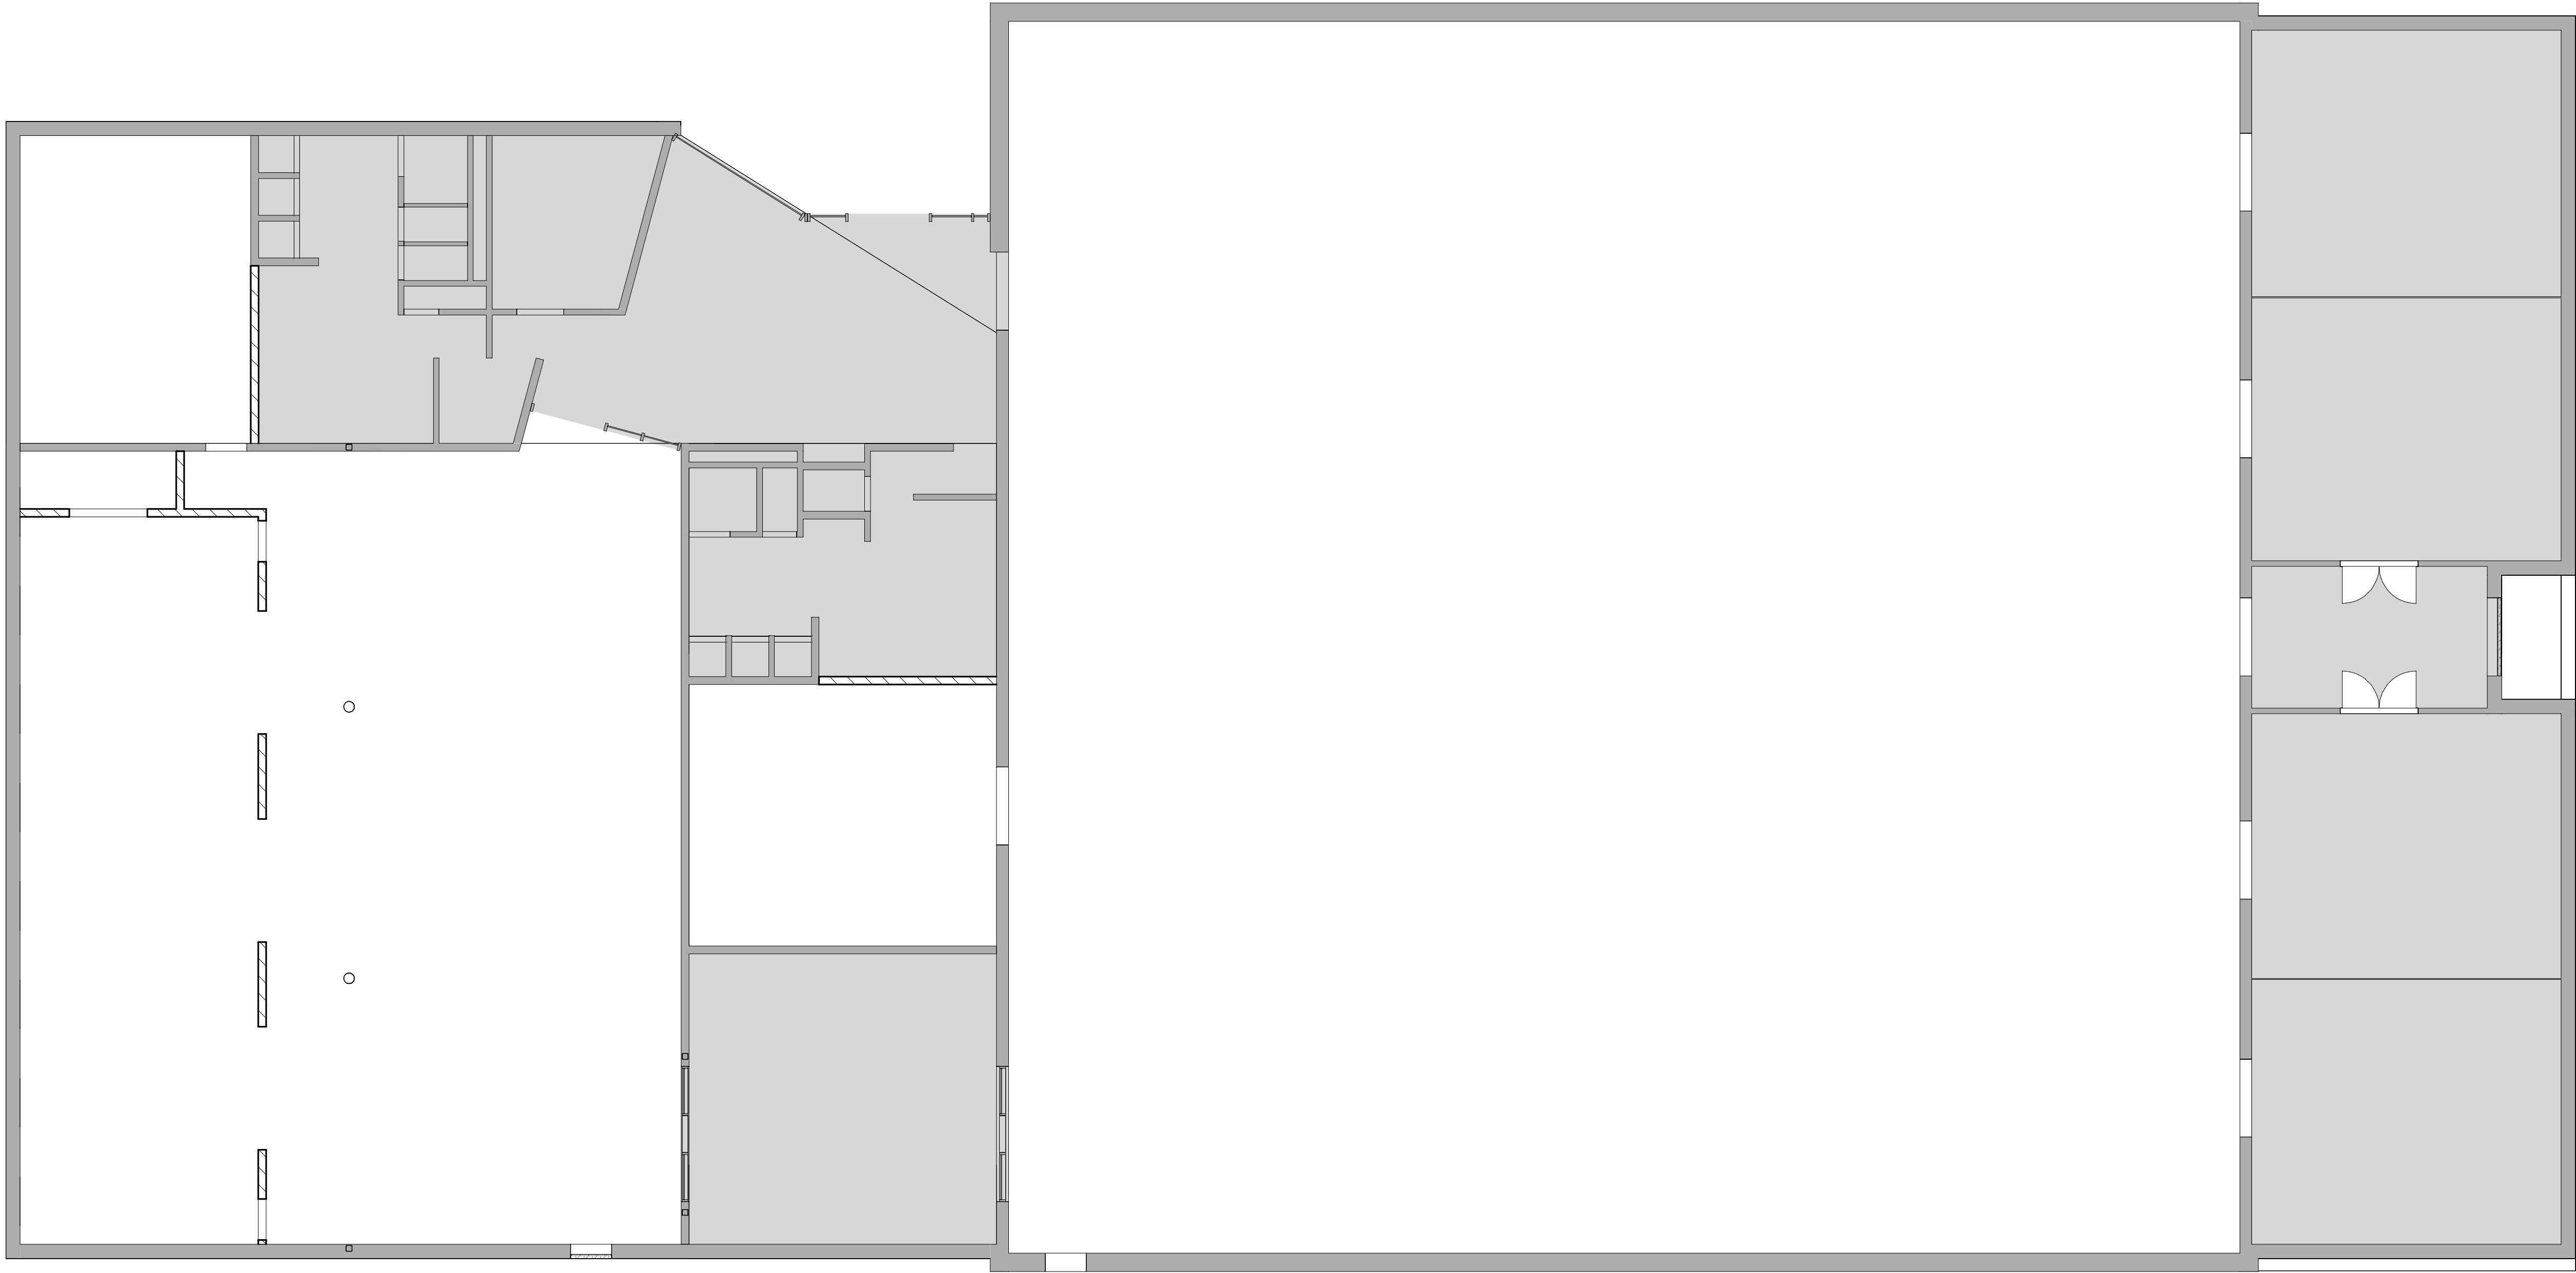

RCP KEYNOTES

NOTE: ALL NOTES MAY NOT APPLY TO THIS SHEET.

- METAL SOFFIT AT EXTERIOR. REFER TO DETAILS.
- OPEN TO STRUCTURE, PAINT STRUCTURE & STEEL DECK. PAINT ALL EXPOSED, NON PRE-FINISHED MEP ITEMS.
- EXPOSED STRUCTURE AND DECK, NO FINISH.
- METAL PANEL CONTROL JOINT, PAINT. EXTEND JOINT UP VERTICAL SIDES OF SOFFIT.
- ROOF HATCH.
- ALUMINUM COMPOSITE PANEL CEILING.
- ALIGN EDGE OF NEW GYP BD. SOFFIT WITH ADJACENT WALL.
- 4'-0" HIGH ACOUSTICAL WALL PANELS BOTTOM OF PANEL @ 16'-0" AFF.
- INTERIOR GYP. BD. SOFFIT, PAINT. REFER TO DETAIL 3/A7.7.
- INTERIOR GYP. BD. BULKHEAD, PAINT. REFER TO DETAIL 5/A7.7.

RCP GENERAL NOTES

R1

= KEYNOTES (WHERE APPLICABLE)

R2

CEILING RELATED MECHANICAL AND ELECTRICAL ITEMS ARE NOT SHOWN ON REFLECTED CEILING PLANS. SEE MECHANICAL AND/OR ELECTRICAL DRAWINGS FOR TYPE, SIZE, AND OTHER REQUIREMENTS PERTAINING SPECIFICALLY TO THESE ITEMS. - EPOXY PAINT ALL EXPOSED, NON PRE-FINISHED MEP ITEMS.

R3

REFER TO PLUMBING, MECHANICAL AND ELECTRICAL DRAWINGS FOR ADDITIONAL FIXTURES NOT SHOWN.

R4

REFER TO WALL TYPES FOR DESCRIPTION OF WALLS EXTENDING (OR NOT) TO UNDERSIDE OF DECKING AND/OR STRUCTURE ABOVE.

R5

INSTALL SPRINKLER HEADS IN CENTER OF 2x2 CEILING PANELS.

R6

INSTALL ALL SPRINKLER HEADS ON SWING ARM NIPPLES. REFER TO MECHANICAL DRAWINGS FOR SPECIFIC REQUIREMENTS.

R7

SOFFIT DIMENSIONS SHOWN ARE FROM FACE OF WALL OR FACE OF GYPSUM BOARD TO FACE OF GYPSUM BOARD.

R8

REFER TO DOOR, FRAME DETAILS AND STRUCTURAL DRAWINGS FOR SPECIFIC LINTEL LOCATIONS. PAINT EXPOSED STEEL LINTELS (GALV. AT EXTERIOR LOCATIONS)

R9

UNLESS SPECIFICALLY LOCATED, GYPSUM BOARD CONTROL JOINTS AS REQUIRED BY INDUSTRY STANDARDS OR SPECS. WHICHEVER IS MORE RESTRICTIVE. CONFIRM LOCATIONS WITH ARCHITECT.

R10

ALL CEILINGS SHALL BE ACT TYPE A. U.N.O.

REFLECTED CEILING LEGEND

X' - X'

CEILING HEIGHT, A.F.F.
NOTE: REFER TO SECTIONS AND DETAILS FOR EXTERIOR CEILING HEIGHTS NOT SHOWN.

2x2 SUSPENDED ACOUSTICAL CEILING (ACT-A) @ 9' - 0" A.F.F. U.N.O., REFER TO SPECS.

2x2 SUSPENDED ACOUSTICAL CEILING (ACT-B) @ 9' - 0" A.F.F. U.N.O., REFER TO SPECS.

GYPSUM BOARD SOFFIT OR BULKHEAD @ 8' - 8" A.F.F. U.N.O., PAINT.

LINEAR METAL CEILING.

EXISTING BUILDING TO REMAIN.

PAINTED, 5/8" EXTERIOR GRADE PLYWOOD

NO CEILING. DECK / STRUCTURE ABOVE TO BE PAINTED.

KEY PLAN

JOB NO.

2469

DATE

12/15/2025

DRAWN

CAH

CHECKED

RJV, ASC

COPYRIGHT © 2025
SHERMAN CARTER BARNHART
ARCHITECTS, PLLC

REVISIONS

No.	Description	Date

SHEET

A8.2

1 800 - REFLECTED CEILING PLAN
1/8" = 1'-0"


GENERAL NOTES

- A. THIS PROJECT SITE IS IN SEISMIC DESIGN CATEGORY "C".
- B. PERIODIC INSPECTIONS WILL BE MADE BY THE SPECIAL INSPECTIONS AGENT RETAINED FOR THIS PROJECT FOR THE ANCHORAGE OF ELECTRICAL EQUIPMENT FOR EMERGENCY OR STANDBY EQUIPMENT, PIPING SYSTEMS AND ASSOCIATED MECHANICAL UNITS DESIGNED TO CARRY HAZARDOUS MATERIALS INCLUDING WELDING SHOP GAS PIPING, ANCHORAGE OF DUCT SYSTEMS CARRYING HAZARDOUS MATERIALS INCLUDING EXHAUST SYSTEMS IN THE WELDING SHOP, AND FOR MECHANICAL VIBRATION ISOLATION SYSTEMS USED IN THE PROJECT.
- C. ALL OTHER "QUALITY CONTROL" INSPECTIONS SPECIFIED IN THE MECHANICAL SECTIONS ARE NOT PROVIDED BY THE SPECIAL INSPECTOR.
- D. REFER TO SPECIFICATIONS AND THE CONTRACT DOCUMENTS FOR ADDITIONAL INFORMATION.
- E. ALL FIRE-SUPPRESSION WORK SHALL BE PERFORMED BY A LICENSED FIRE-SUPPRESSION CONTRACTOR WITH A MINIMUM OF 5 YEARS EXPERIENCE DESIGN AND ERECTING FIRE-SUPPRESSION SYSTEMS.
- F. THE FIRE-SUPPRESSION CONTRACTOR SHALL HYDRAULICALLY DESIGN AND SIZE THE MAIN SERVICE AND SPRINKLER SYSTEM TO FULLY PROTECT THE ENTIRE BUILDING IN COMPLIANCE WITH THE KENTUCKY BUILDING CODE, NFPA-13, NFPA-14, NFPA-20, NFPA-24, AND LOCAL CODES. THE FIRE-SUPPRESSION CONTRACTOR SHALL PROVIDE AND SUBMIT DRAWINGS AND HYDRAULIC CALCULATIONS TO THE MECHANICAL ENGINEER FOR REVIEW AND THE STATE FOR CODE APPROVAL.
- G. FIRE-SUPPRESSION CONTRACTOR SHALL OBTAIN A COPY OF THE ENTIRE SET OF CONTRACT DOCUMENTS AND SHALL COORDINATE ROUTING AND INSTALLATION WITH ALL OTHER DISCIPLINES AND TRADES INCLUDING BUT NOT LIMITED TO CIVIL, ARCHITECTURAL, STRUCTURAL, PLUMBING/HVAC, AND ELECTRICAL IN THE LAY-OUT OF SPRINKLER PIPING AND HEADS. COORDINATE HEAD TYPES WITH ARCHITECTURAL CEILING TYPES. STRUCTURAL MEMBERS SHALL NOT BE CUT OR COMPROMISED IN ANY WAY. DO NOT MOUNT SPRINKLER HEADS OR HANG PIPING SO AS TO BLOCK ACCESS TO HVAC OR ELECTRICAL EQUIPMENT. DO NOT INSTALL PIPING OVER ELECTRICAL PANELS/SWITCHGEAR OR THE 36" CLEARANCE IN FRONT OF THESE ELECTRICAL ITEMS. COORDINATE ADDITIONAL REQUIREMENTS WITH NEC. FIRE-SUPPRESSION CONTRACTOR SHALL COORDINATE AND SCHEDULE ALL FIRE-SUPPRESSION WORK WITH THE GENERAL CONTRACTOR AND ACCOMMODATE CONSTRUCTION PHASING REQUIREMENTS AND ALL OTHER TRADES AS REQUIRED.
- H. THE CONTRACTOR IS RESPONSIBLE FOR REVIEWING ALL BELOW SLAB / UNDERGROUND PIPING WITH STRUCTURAL COMPONENTS AND COORDINATING ALL STEPPED FOOTINGS OR SLEEVES WHERE REQUIRED.
- I. CENTER SPRINKLER HEADS (EACH WAY) IN CEILING TILES. SPRINKLER HEADS SHALL BE CENTERED IN 2x2' SECTIONS OF 2x4' CEILING TILES WHERE INSTALLED IN A LAY-IN CEILING. REFER TO FIRE-SUPPRESSION DETAILS FOR CLARIFICATION. REFER TO ARCHITECTURAL FOR FINAL REFLECTED CEILING PLANS TO CLARIFY CEILING TYPES AND CEILING GRIDS. COORDINATE HEAD LOCATIONS WITH LIGHTING AND AIR DEVICES.
- J. INSTALL CAPPED DRAIN VALVES AND ANY AND ALL ADDITIONAL DRAIN VALVES AS REQUIRED TO COMPLETELY DRAIN THE FIRE-SUPPRESSION SYSTEM. INSTALL ALL REQUIRED DRAIN PIPING TO FLOW TEST POINTS. DISCHARGE ALL DRAIN PIPING TO OUTDOORS OR TO AN APPROVED LOCATION. PROVIDE LISTED AIR RELEASE FOR ALL TRAPPED RUNS OF FIRE-SUPPRESSION PIPING.
- K. ALL FIRE-SUPPRESSION COMPONENTS INCLUDING BUT NOT LIMITED TO VALVES, PIPE, FITTINGS, CONTROL SYSTEMS, AND TRIM SHALL BE UL AND/OR FM LISTED FOR FIRE SERVICE AS REQUIRED BY THE KENTUCKY BUILDING CODE AND/OR THE AUTHORITY HAVING JURISDICTION.
- L. PROVIDE GUARDS AND/OR SPECIAL HEADS AS REQUIRED FOR A COMPLETE AND FUNCTIONAL DESIGN AND INSTALLATION AND AS REQUIRED TO COMPLY WITH NFPA-13. PROVIDE HIGH TEMPERATURE HEADS FOR AREAS NEAR SPACE HEATING OUTLETS AND EQUIPMENT AS REQUIRED.
- M. NEW OPENINGS FOR FIRE-SUPPRESSION ITEMS SHALL BE CUT, SLEEVED, ETC. BY THE FIRE-SUPPRESSION CONTRACTOR. ALL OPENINGS SHALL BE CORE DRILLED OR SAW-CUT. ALLOWED NO HAMMER DRILLING.
- N. INSTALL FIRE/SMOKE STOPPING FOR ALL FIRE-SUPPRESSION PIPING PENETRATIONS THRU FIRE/SMOKE RATED ASSEMBLIES INCLUDING BUT NOT LIMITED TO PARTITIONS, WALLS, AND SLABS. ALL PENETRATION INSTALLATIONS SHALL BE CONSTRUCTED PER AN APPROVED UL AND/OR FM LISTED PENETRATION ASSEMBLY. THE FIRE-SUPPRESSION CONTRACTOR SHALL COORDINATE THE SIZE AND LOCATION OF ALL OPENINGS FOR SPRINKLER PIPING WITH THE GENERAL CONTRACTOR AND OTHER TRADES AS REQUIRED FOR A COMPLETE INSTALLATION.
- O. CERTAIN AREAS ON THE DRAWINGS MAY ILLUSTRATE A SPRINKLER HEAD TYPE AND/OR LOCATION. THE INTENT WITH THIS SCENARIO IS TO ILLUSTRATE CONCEPTUAL REQUIREMENTS. ANY ADDITIONAL DETAILS THAT MAY BE REQUIRED TO COMPLY WITH NFPA-13 IS THE RESPONSIBILITY OF THE FIRE-SUPPRESSION CONTRACTOR. ALL AREAS NOT SHOWN TO BE SPRINKLERED BUT REQUIRED TO BE SPRINKLERED PER NFPA-13 SHALL BE SPRINKLERED IN COMPLIANCE WITH THE CONTRACT DOCUMENTS AND AS PART OF THE DELEGATED DESIGN AND INSTALLATION PROCESS.

SHEET KEYNOTES

1. SHEET NOTES

FLOW TEST	
STATIC PRESSURE	XX PSI
RESIDUAL PRESSURE	XX PSI
FLOW	XXX GPM
DATE	XXXX
FLOW TEST RESULTS PROVIDED BY: XXXXX	
THE FIRE SUPPRESSION CONTRACTOR SHALL CONDUCT HIS OWN FLOW TEST FOR USE IN SHOP DRAWING / HYDRAULIC CALCULATIONS. THE TEST SHALL BE FULLY COORDINATED WITH THE OWNER, UTILITY COMPANY AND WITNESSED BY THE ARCHITECT/ENGINEER.	

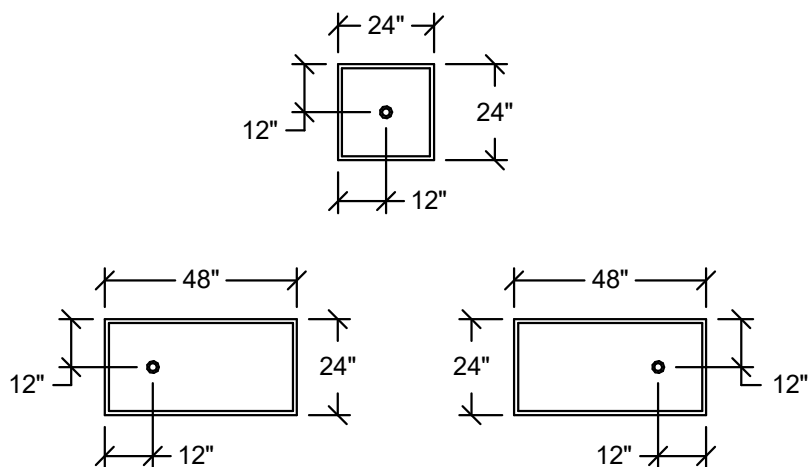

HEAD PLACEMENT
IN ACOUSTICAL TILE

HEAD TYPES

ALL SPRINKLER HEADS TO BE QUICK RESPONSE TYPE.


ROOMS WITH GYPSUM CEILINGS SHALL HAVE CONCEALED SPRINKLER HEADS. COLOR/FINISH SHALL BE SELECTED BY ARCHITECT.

ROOMS WITH ACOUSTICAL TILE (ACT) LAY-IN CEILINGS SHALL HAVE SEMI-RECESSED SPRINKLERS. COLOR/FINISH SHALL BE SELECTED BY ARCHITECT.

ROOM WITH NO CEILINGS (MECHANICAL ROOMS, ETC.) SHALL BE UPRIGHT SPRINKLER HEADS.


REFER TO ARCHITECTURAL CEILING PLANS. COORDINATE SPRINKLER PIPING WITH DUCTWORK, DIFFUSERS, LIGHTING, STRUCTURAL AND ALL OTHER TRADES PRIOR TO INSTALLATION.

BUILDING SHALL BE 100% SPRINKLERED IN COMPLIANCE WITH NFPA 13, AS APPLICABLE AND AS PART OF A DELEGATED DESIGN.

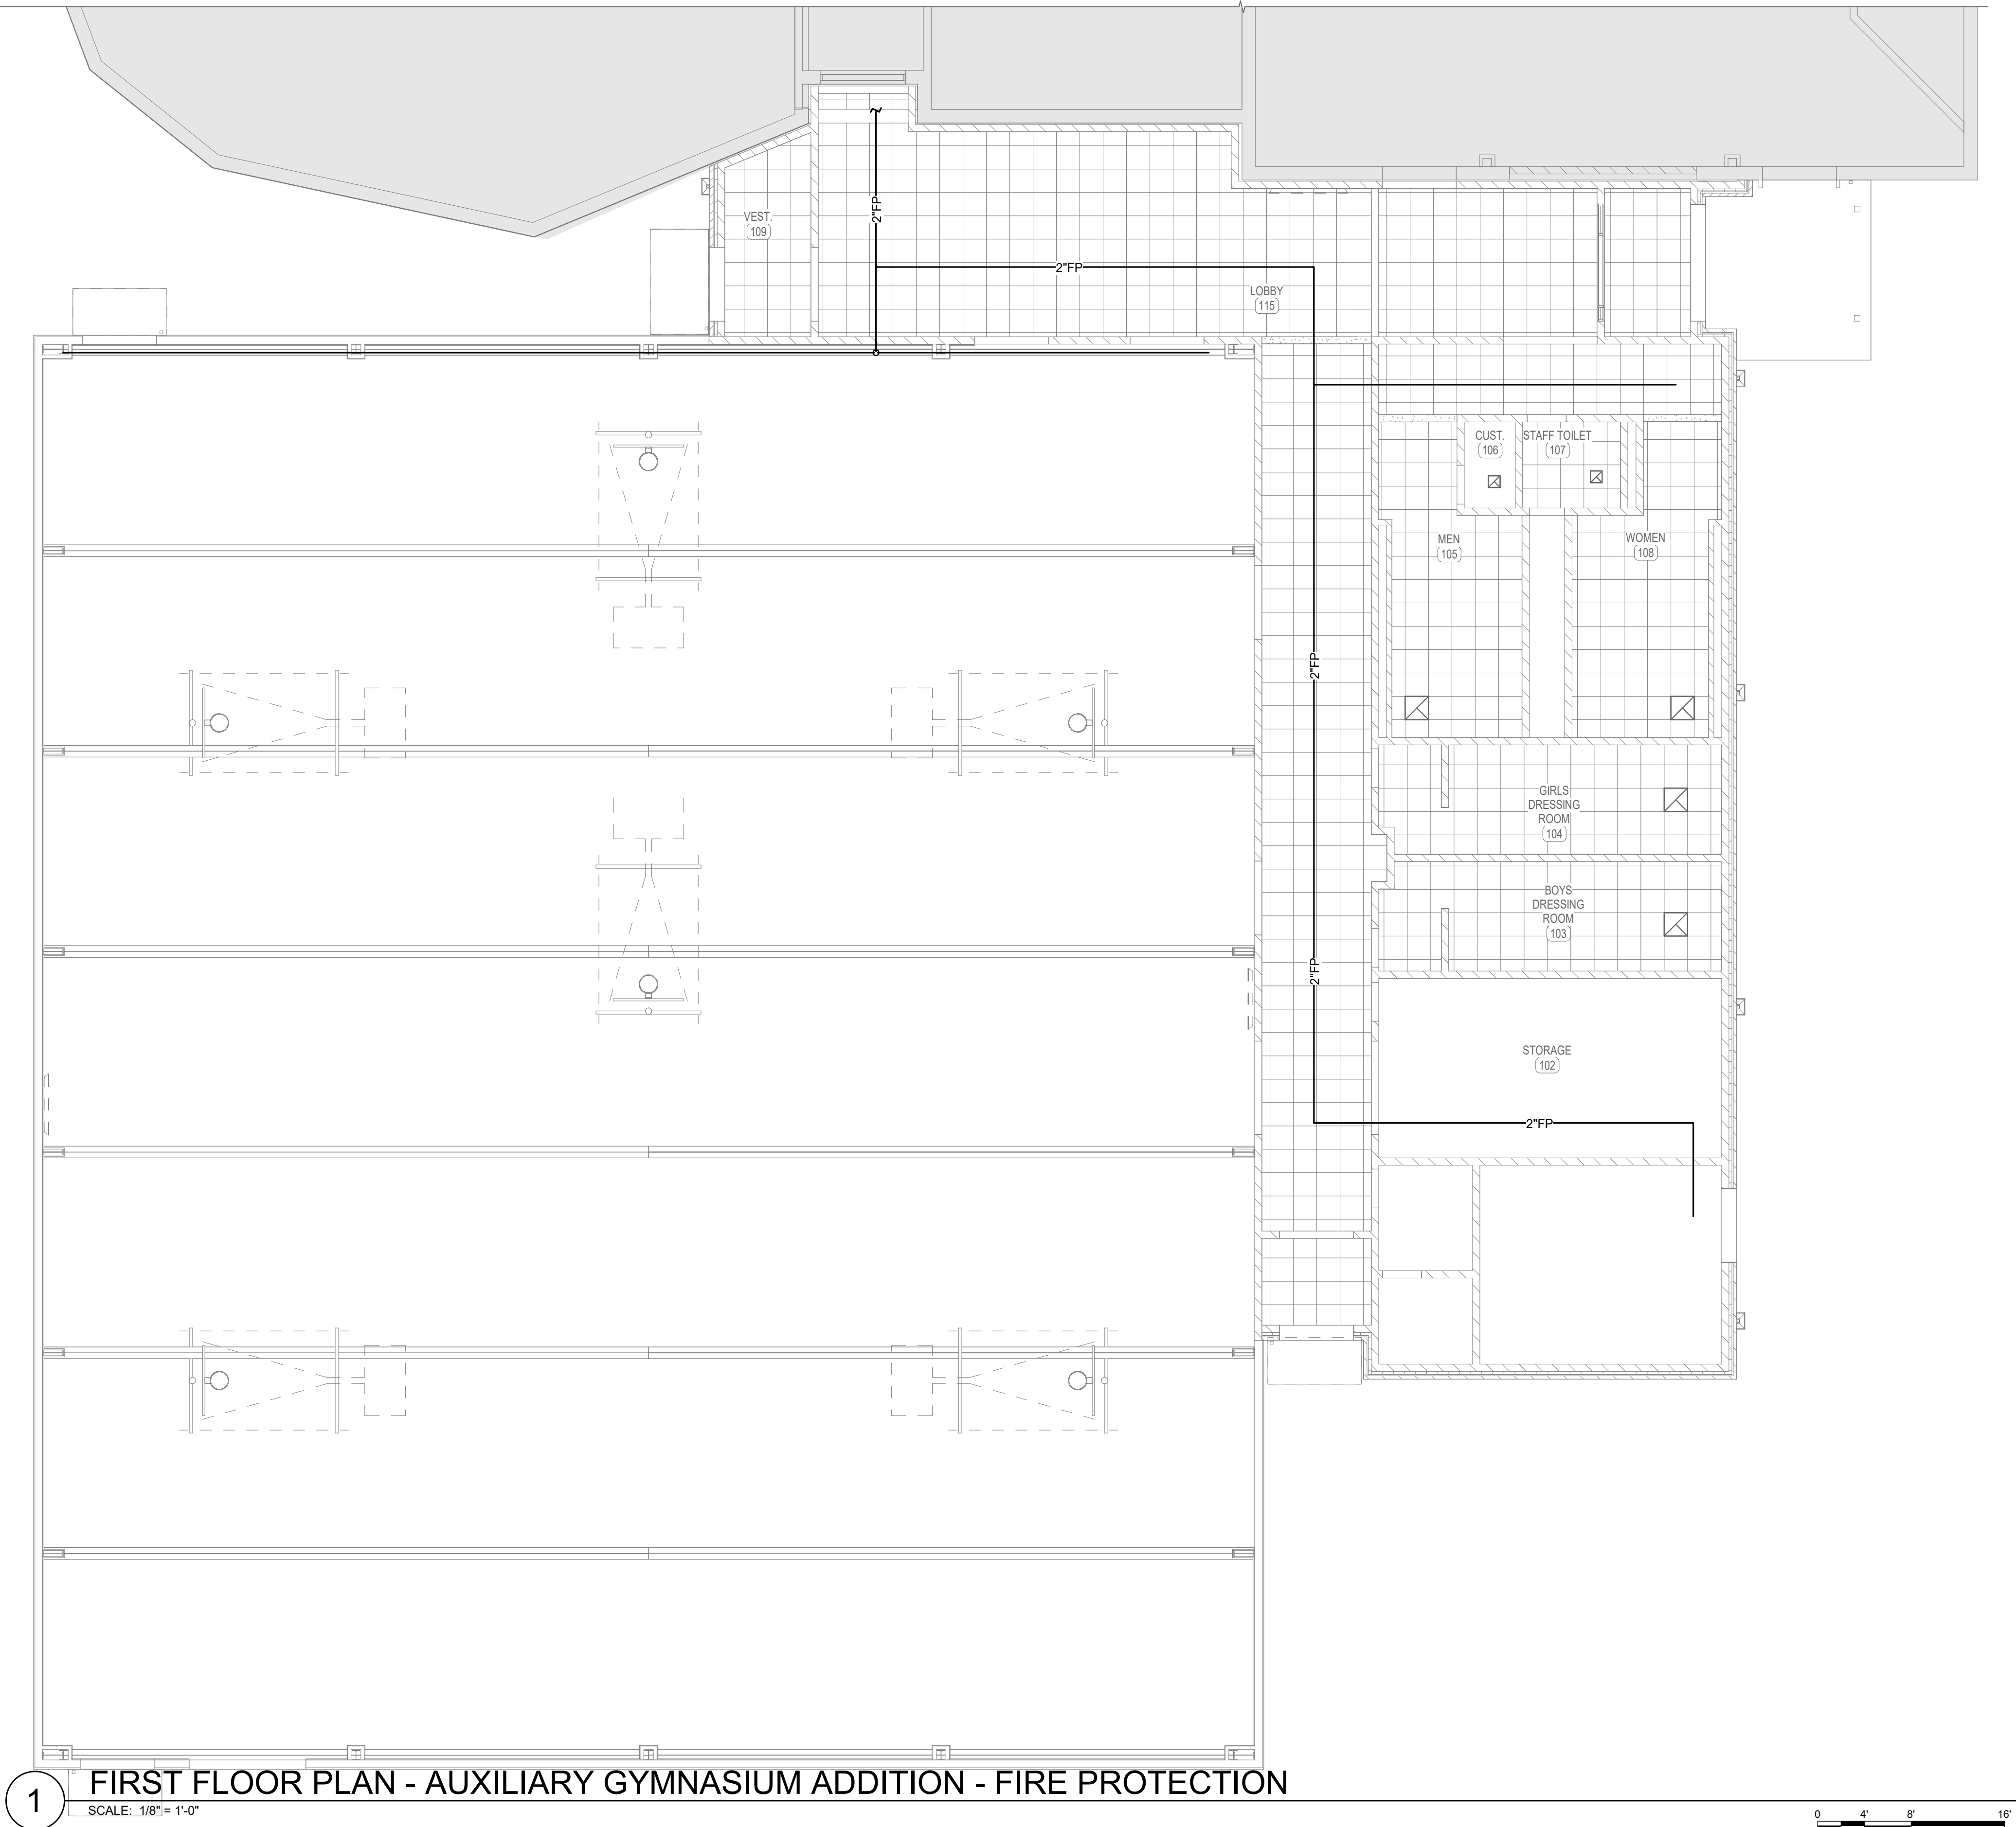

1 FIRST FLOOR PLAN - AUXILIARY GYMNASIUM ADDITION - FIRE PROTECTION
SCALE: 1/8" = 1'-0"

KEY PLAN

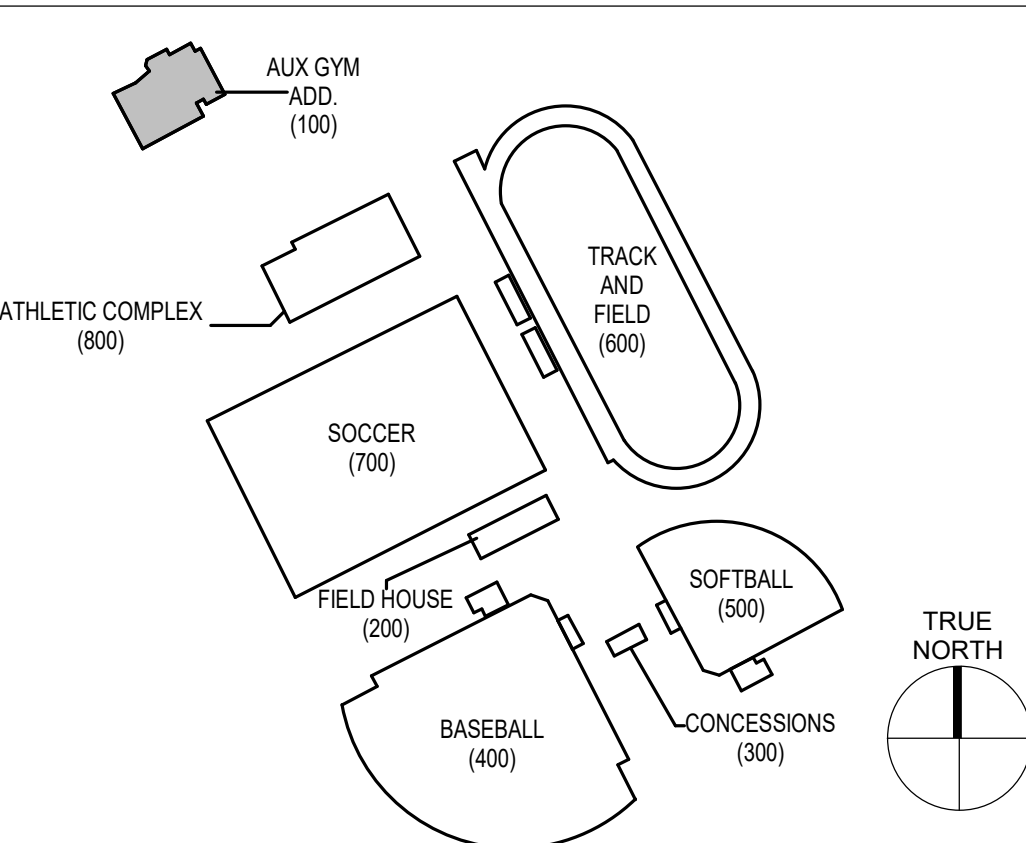


GENERAL NOTES

- THIS PROJECT SITE IS IN SEISMIC DESIGN CATEGORY "C".
- a. PERIODIC INSPECTIONS WILL BE MADE BY THE SPECIAL INSPECTIONS AGENT RETAINED FOR THIS PROJECT FOR THE ANCHORAGE OF ELECTRICAL EQUIPMENT FOR EMERGENCY OR STANDBY EQUIPMENT, PIPING SYSTEMS AND MECHANICAL AND MECHANICAL UNITS AND ALL OTHER SPECIAL INSPECTION MATERIALS INCLUDING WELDING SHOP GAS PIPING, ANCHORAGE OF DUCT SYSTEMS CARRYING HAZARDOUS MATERIALS INCLUDING EXHAUST SYSTEMS AND EXHAUST DUCTS, AND FOR MECHANICAL VIBRATION ISOLATION SYSTEMS USED IN THE PROJECT.
- b. ALL OTHER "QUALITY CONTROL" INSPECTIONS SPECIFIED IN THE MECHANICAL SECTIONS ARE NOT PROVIDED BY THE SPECIAL INSPECTOR.
- B. REFER TO SPECIFICATIONS AND THE CONTRACT DOCUMENTS FOR ADDITIONAL INFORMATION.
- C. ALL FIRE-SUPPRESSION WORK SHALL BE PERFORMED BY A LICENSED FIRE-SUPPRESSION CONTRACTOR WITH A MINIMUM OF 5 YEARS EXPERIENCE DESIGN AND ERECTING FIRE-SUPPRESSION SYSTEMS.
- D. PROVIDE A COMPLETE FIRE-SUPPRESSION SYSTEM INCLUDING MODIFICATIONS TO EXISTING WORK, NEW PIPING AND ACCESSORIES, AND TESTING AS REQUIRED TO MEET THE REQUIREMENTS OF THE KENTUCKY BUILDING CODE AND ALL APPLICABLE NFPA CODES.
- E. THE FIRE-SUPPRESSION CONTRACTOR SHALL HYDRAULICALLY DESIGN AND SIZE THE MAIN SERVICE AND SPRINKLER SYSTEM TO FULLY PROTECT THE ENTIRE BUILDING IN COMPLIANCE WITH THE KENTUCKY BUILDING CODE, NFPA-13, NFPA-14, NFPA-15, NFPA-1963, AND ALL OTHER CODES. THE FIRE-SUPPRESSION CONTRACTOR SHALL PROVIDE AND SUBMIT DRAWINGS AND HYDRAULIC CALCULATIONS TO THE MECHANICAL ENGINEER FOR REVIEW AND THE STATE FOR CODE APPROVAL.
- F. FIRE-SUPPRESSION CONTRACTOR SHALL OBTAIN A COPY OF THE ENTIRE SET OF CONTRACT DOCUMENTS AND SHALL COORDINATE ROUTING AND INSTALLATION WITH ALL OTHER TRADES, INCLUDING BUT NOT LIMITED TO, MECHANICAL, CIVIL, ARCHITECTURAL, STRUCTURAL, PLUMBING, HVAC, AND ELECTRICAL IN THE LAYOUT OF SPRINKLER PIPING AND HEADS. COORDINATE HEAD TYPES WITH ALL MECHANICAL, CIVIL, ARCHITECTURAL, AND ELECTRICAL TRADES. HEADS SHALL NOT BE CUT OR COMPROMISED IN ANY WAY. DO NOT MOUNT SPRINKLER HEADS OR HANG PIPING SO AS TO BLOCK ACCESS TO HVAC OR ELECTRICAL EQUIPMENT. DO NOT INSTALL PIPING OR EQUIPMENT IN ANY MANNER THAT COULD CAUSE INTERFERENCE IN FRONT OF THESE ELECTRICAL ITEMS. COORDINATE ADDITIONAL REQUIREMENTS WITH NEC. FIRE-SUPPRESSION CONTRACTOR SHALL COORDINATE AND SCHEDULE ALL FIRE-SUPPRESSION WORK WITH THE GENERAL CONTRACTOR AND ACCOMMODATE CONSTRUCTION PHASING REQUIREMENTS AND ALL OTHER TRADES AS REQUIRED.
- G. THE CONTRACTOR IS RESPONSIBLE FOR REVIEWING ALL BELOW SLAB / UNDERGROUND PIPING WITH STRUCTURAL COMPONENTS AND COORDINATING ALL STRUCTURAL FOOTINGS.
- H. CENTER SPRINKLER HEADS (EACH WAY IN CEILING TILES. SPRINKLER HEADS SHALL BE CENTERED IN 2' x 2' SECTIONS OF 2" x 4" CEILING TILES WHERE INSTALLED IN A LAY-IN CEILING. REFER TO FIRE-SUPPRESSION DETAILS FOR CLARIFICATION. PROVIDE AN INTEGRATED FINISH FLOOR REFLECTED CEILING PLANS TO CLARIFY CEILING TYPES AND CEILING GRID. COORDINATE HEAD LOCATIONS WITH LIGHTING AND AIR SERVICES.
- I. INSTALL CAPPED DRAIN VALVES AND ANY AND ALL ADDITIONAL DRAIN VALVES AS REQUIRED TO COMPLETELY DRAIN THE FIRE-SUPPRESSION SYSTEM. INSTALL ALL DRAIN VALVES WITH CAPS AND DRAIN PIPING TO THE OUTSIDE OF THE BUILDING OR TO OUTDOORS OR TO AN APPROVED LOCATION. PROVIDE LISTED AIR RESISTAL FOR ALL TRAPPED RUNS OF FIRE-SUPPRESSION PIPING.
- J. ALL FIRE-SUPPRESSION COMPONENTS INCLUDING BUT NOT LIMITED TO VALVES, PIPE, FITTINGS, CONTROL SYSTEMS, AND TRIM SHALL BE UL AND/OR FM LISTED AND APPROVED BY THE STATE OF THE KENTUCKY BUILDING CODE AND/OR THE AUTHORITY HAVING JURISDICTION.
- K. PROVIDE GUARDS AND/OR SPECIAL HEADS AS REQUIRED FOR A COMPLETE AND FUNCTIONAL DESIGN AND INSTALLATION AND AS REQUIRED TO COMPLY WITH NFPA-13. PROVIDE HIGH TEMPERATURE HEADS FOR AREAS NEAR SPACE HEATING OUTLETS AND EQUIPMENT AS REQUIRED.
- NEW OPENINGS FOR FIRE-SUPPRESSION ITEMS SHALL BE CUT, SLEEVED, ETC. BY THE FIRE-SUPPRESSION CONTRACTOR. ALL OPENINGS SHALL BE CORE DRILLED OR SAW-CUT. ALLOWED. NO HAMMER DRILLING
- M. INSTALL FIRE/SMOKE STOPPING FOR ALL FIRE-SUPPRESSION PIPING PENETRATIONS THRU FIRE/SMOKE RATED ASSEMBLIES INCLUDING BUT NOT LIMITED TO PARTITIONS, WALLS, AND SLABS. ALL PENETRATION INSTALLATIONS SHALL BE IN ACCORDANCE WITH THE KENTUCKY BUILDING CODE AND NFPA-13. THE FIRE-SUPPRESSION CONTRACTOR SHALL COORDINATE THE SIZE AND LOCATION OF ALL OPENINGS FOR SPRINKLER PIPING WITH THE GENERAL CONTRACTOR AND ALL OTHER TRADES AS REQUIRED FOR A COMPLETE INSTALLATION.
- N. CERTAIN AREAS ON THE DRAWINGS MAY ILLUSTRATE A SPRINKLER HEAD TYPE AND/OR LOCATION. THE INTENT WITH THIS SCENARIO IS TO ILLUSTRATE CONCEPTUAL REQUIREMENTS. ANY ADDITIONAL HEADS THAT MAY BE REQUIRED SHALL BE DETERMINED BY THE FIRE-SUPPRESSION CONTRACTOR. ALL AREAS NOT SHOWN TO BE SPRINKLERED BUT REQUIRED TO BE SPRINKLERED PER NFPA-13 SHALL BE SPRINKLERED IN COMPLIANCE WITH THE KENTUCKY BUILDING CODE AND AS PART OF THE DELEGATED DESIGN AND INSTALLATION PROCESS.

SHEET KEYNOTES

- ## 1. SHEET NOTES

FLOW TEST	
STATIC PRESSURE	XX PSI
RESIDUAL PRESSURE	XX PSI
FLOW	XXX GPM
DATE	XXXX
FLOW TEST RESULTS PROVIDED BY: XXXXX	
THE FIRE SUPPRESSION CONTRACTOR SHALL CONDUCT HIS OWN FLOW TEST FOR USE IN SHOP DRAWING / HYDRAULIC CALCULATIONS. THE TEST SHALL BE FULLY COORDINATED WITH THE OWNER, UTILITY COMPANY AND WITNESSED BY THE ARCHITECT/ENGINEER	

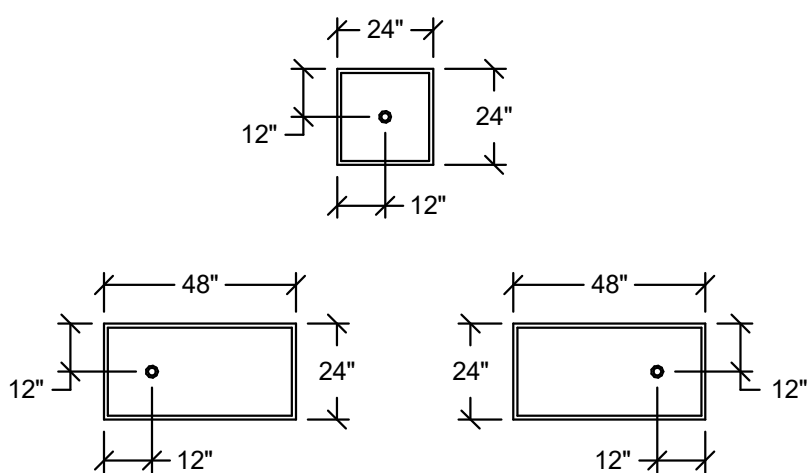

HEAD PLACEMENT IN ACOUSTICAL TILE

HEAD TYPES

ALL SPRINKLER HEADS TO BE QUICK RESPONSE TYPE.


ROOMS WITH GYPSUM CEILINGS SHALL HAVE CONCEALED SPRINKLER HEADS. COLOR/FINISH SHALL BE SELECTED BY ARCHITECT.

ROOMS WITH ACOUSTICAL TILE (ACT) LAY-IN CEILINGS SHALL HAVE SEMI-RECESSED SPRINKLERS. COLOR/FINISH SHALL BE SELECTED BY ARCHITECT.


ROOM WITH NO CEILINGS (MECHANICAL ROOMS, ETC.) SHALL BE UPRIGHT SPRINKLER HEADS.

REFER TO ARCHITECTURAL CEILING PLANS. COORDINATE SPRINKLER PIPING WITH DUCTWORK, DIFFUSERS, LIGHTING, STRUCTURAL AND ALL OTHER TRADES PRIOR TO INSTALLATION.


BUILDING SHALL BE 100% SPRINKLERED IN COMPLIANCE WITH NFPA 13, AS APPLICABLE AND AS PART OF A DELEGATED DESIGN.

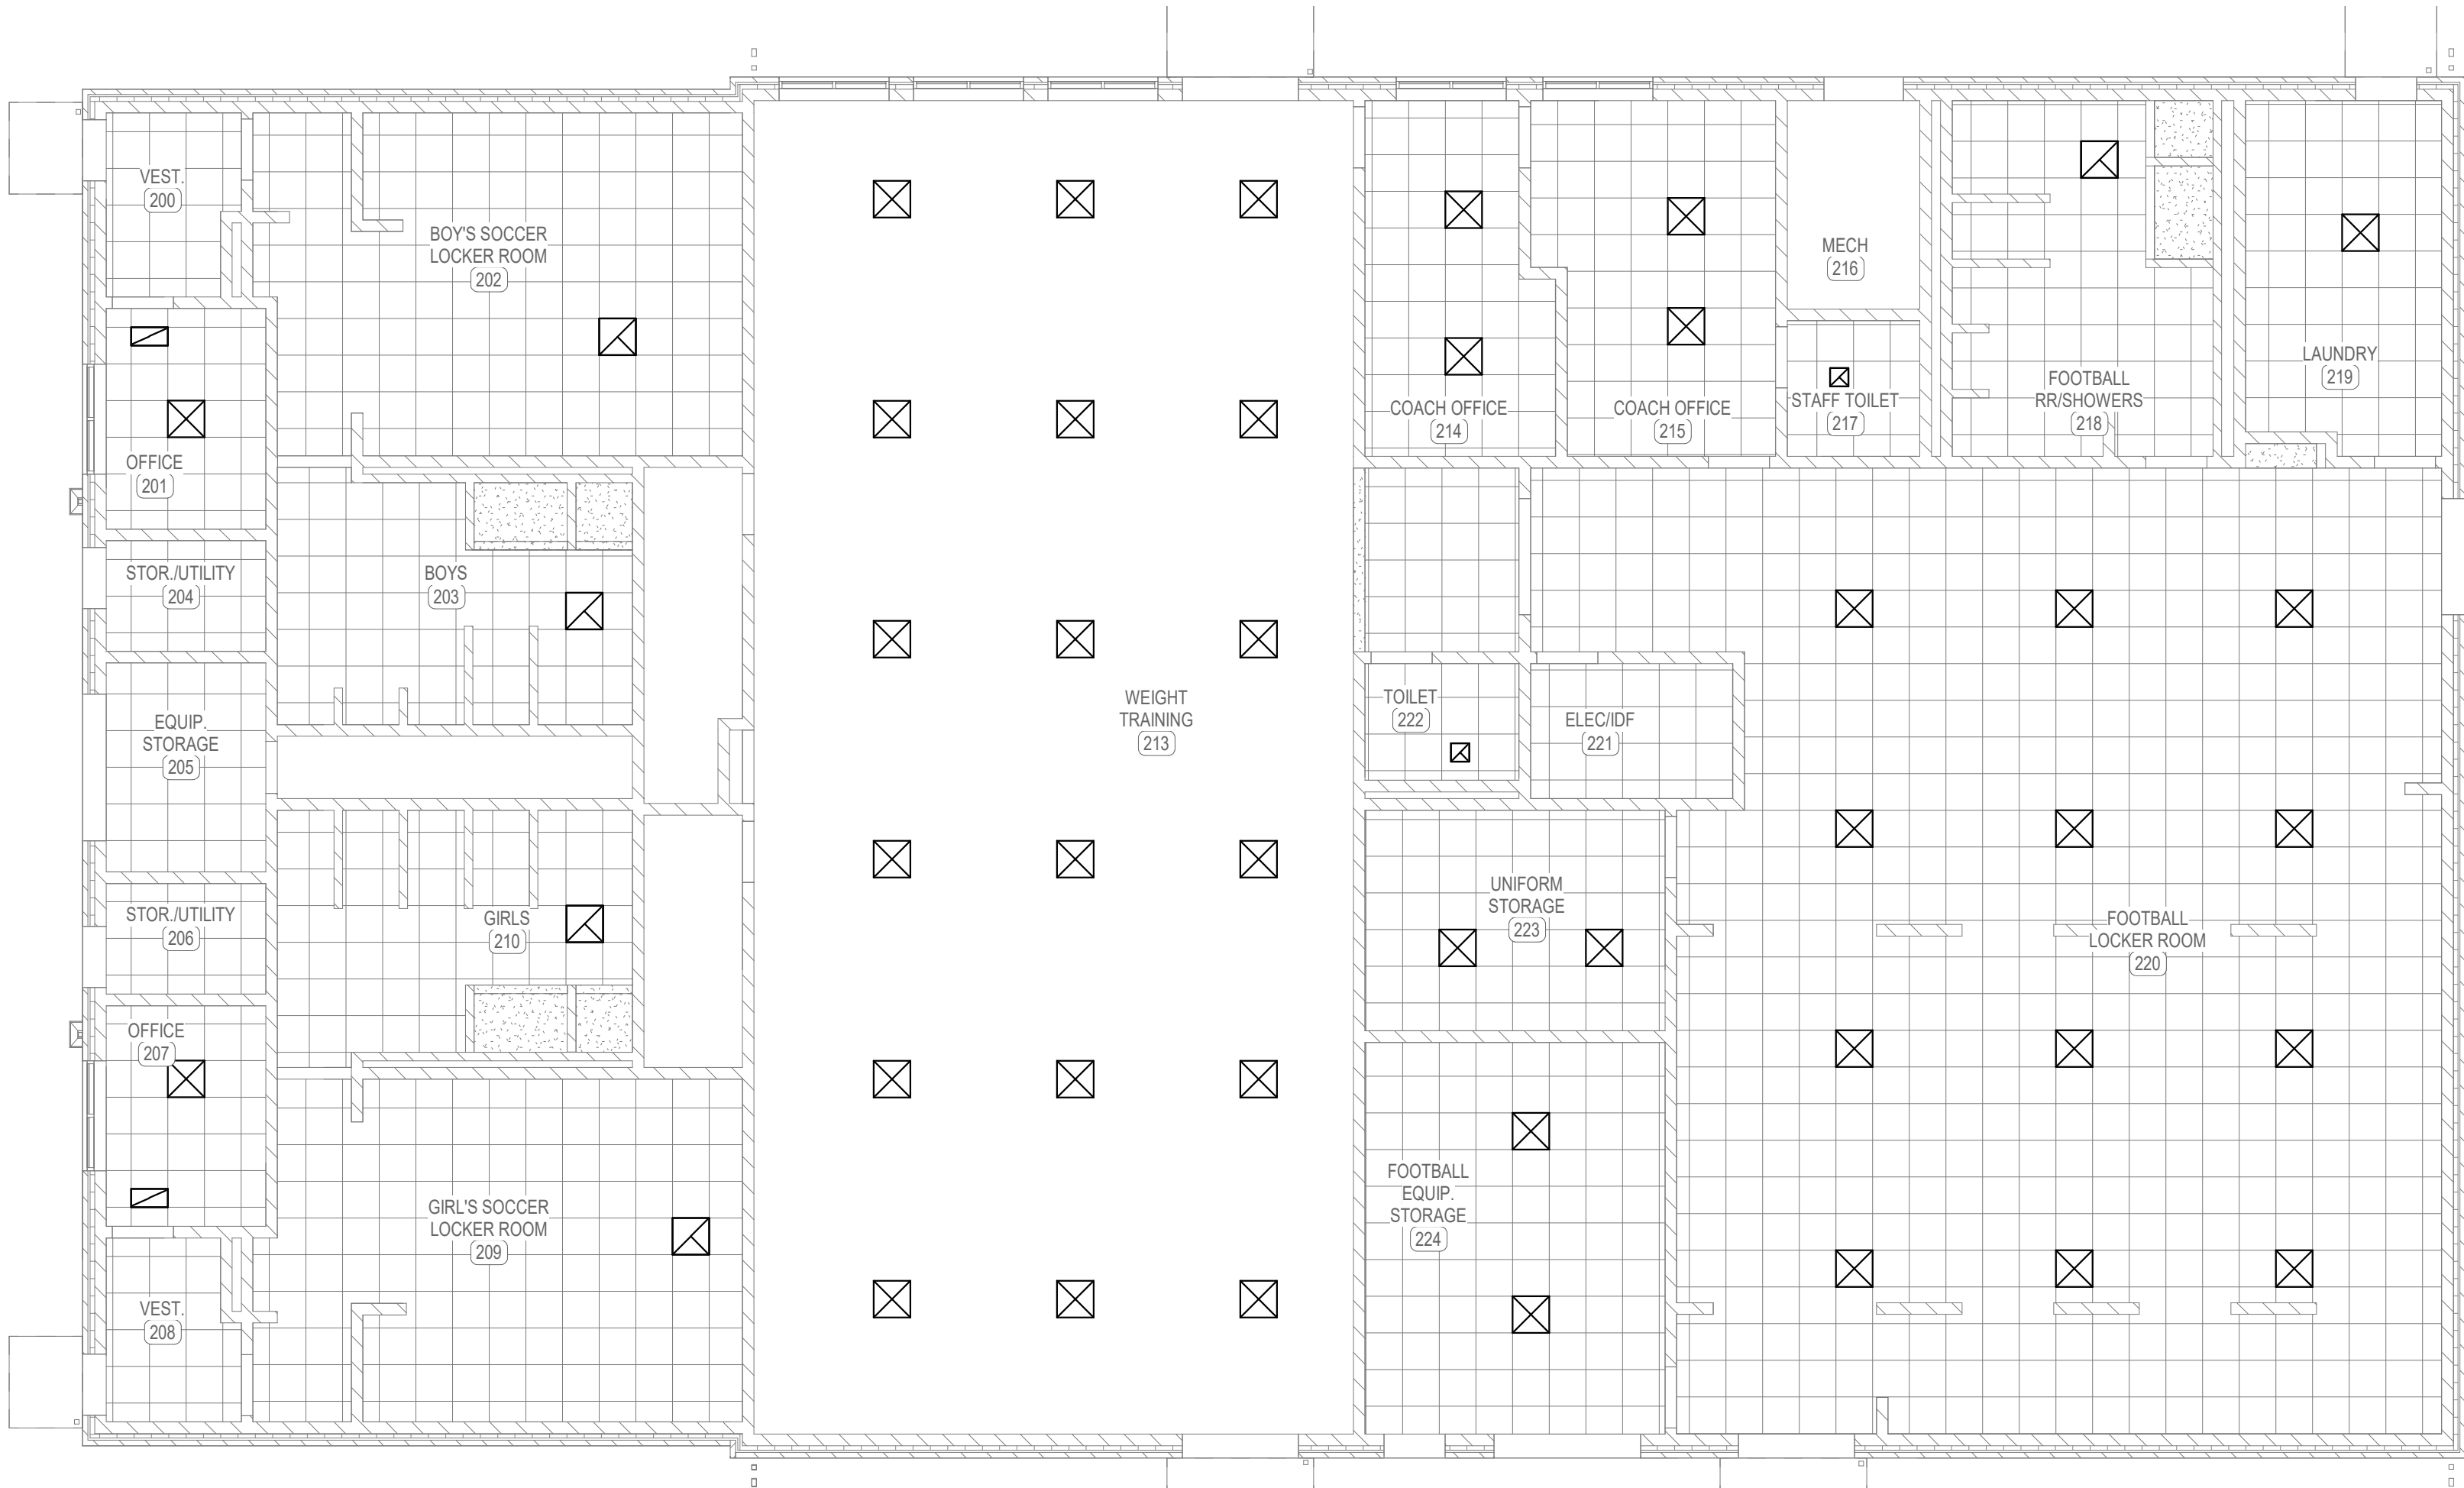

 1 FIRST FLOOR PLAN - FIELD HOUSE - FIRE PROTECTION
SCALE: 1/8" = 1'-0"















KEY PLAN

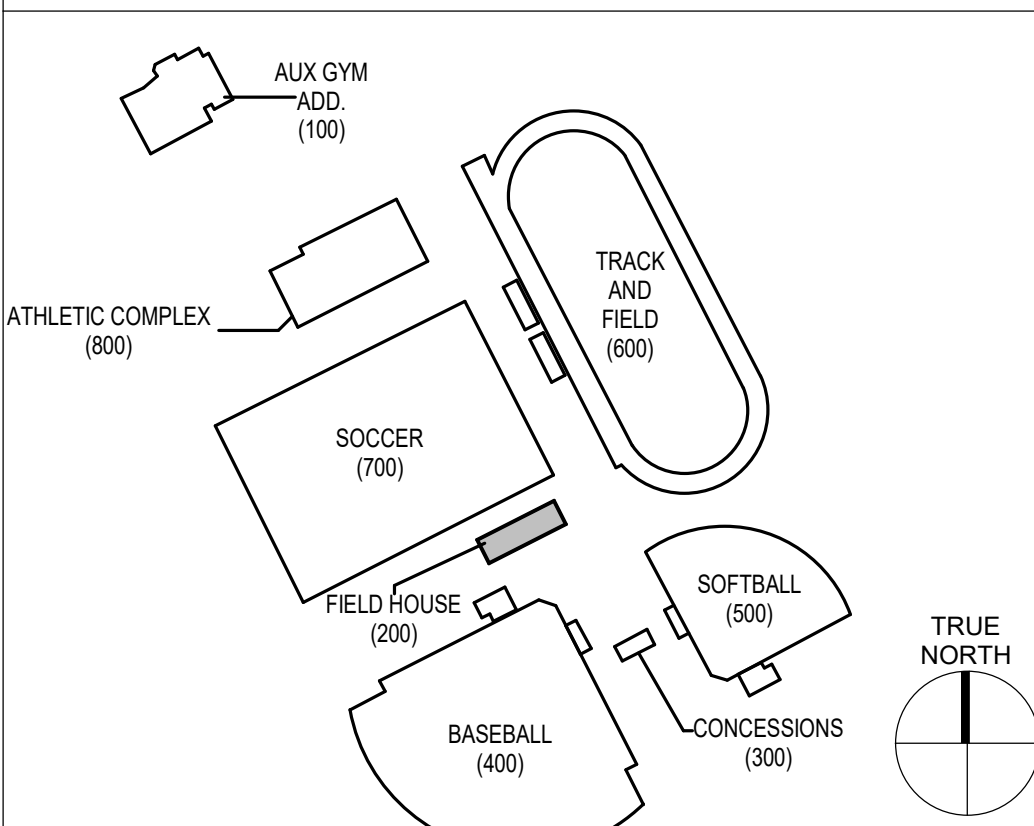

2459 ALLEN COUNTY - SCOTTSVILLE HIGH SCHOOL ATHLETIC COMPLEX
Autodesk Docs (2459 Allen County Athletic Fields and Facilities)25008-Allen Co. 026 MEP.rvt
1/11/2025 3:04:15 PM

            PLUMBING LEGEND

PLUMBING SYMBOLS	
SYMBOL	DESCRIPTION
	PIPE DOWN
	PIPE UP
	TEE DOWN
	TEE UP
	CONTINUATION
	CAP
	HAMMER ARRESTOR
	BALANCING VALVE
	BALL VALVE
	BUTTERFLY VALVE
	ELECTRIC CONTROL VALVE
	PRESSURE REDUCING VALVE
	CHECK VALVE
	GATE VALVE
	PLUG VALVE
	REDUCER
	UNION
	VALVE IN VERTICAL
	PRESSURE GAUGE
	STRAINER
	FLOW INDICATOR
	CLEANOUT
	FLOOR CLEANOUT
	THERMOMETER
	RECIRC. BALANCING STATION
	FLOW SWITCH
	TAMPER SWITCH ON VALVE
	PUMP, INLINE
	SUMP PUMP
	GAS METER
	WATER METER
	THRUST BLOCK
	GAS REGULATOR
	FLOOR DRAIN
	P-TRAP
	FLOOR DRAIN GRATE
	FIRE PROTECTION RISER
	FIRE PROTECTION CONNECTION (DOUBLE)
	FIRE PROTECTION CONNECTION (SINGLE)
	SHEET NOTE
	DEMOLITION NOTE
	CONNECT NEW TO EXISTING
	EXTENT OF DEMOLITION
	EQUIPMENT TAG
	RISER IDENTIFICATION TAG

ABBREVIATIONS	
ADP	ACID DILUTION PIT
AFF	ABOVE FINISHED FLOOR
AFG	ABOVE FINISHED GRADE
AG	AIR GAP
AV	ACID VENT
AW	ACID WASTE
BFF	BELOW FINISHED FLOOR
BFG	BELOW FINISHED GRADE
BTU	BRITISH THERMAL UNIT
CA	COMPRESSED AIR
CFH	CUBIC FEET/HOUR
CI	CAST IRON
CRD	COMBINATION ROOF DRAIN
CO	CLEANOUT
CON	CONDENSATE
CW	COLD WATER
D	DISPOSAL
DD	DECK DRAIN
DI	DUCTILE IRON
DF	DRINKING FOUNTAIN
DSN	DOWNSPOUT NOZZLE
ECO	EXTERIOR CLEANOUT
EEW	EMERGENCY EYE WASH
ESEW	EMERGENCY SHOWER / EYE WASH
ET	EXPANSION TANK
ETP	ELECTRONIC TRAP PRIMER
EW	ELECTRIC WATER COOLER
EW	ELECTRIC WATER HEATER
FCO	FLOOR CLEANOUT
FD	FLOOR DRAIN
FS	FLOOR SINK
FS	FLOW SWITCH
G	NATURAL GAS
GPM	GALLONS PER MINUTE
GR	GREASE
GRV	GREASE VENT
GT	GREASE TRAP
GWH	GAS WATER HEATER
HA	HAMMER ARRESTOR
HB	HOSE BIBB
HW	HOT WATER
HWR	HOT WATER RETURN
I.E.	INVERT ELEVATION
IMB	ICE MAKER BOX
LAV	LAVATORY
LPG	LIQUID PETROLEUM GAS
LT	LAUNDRY TUB
MA	MEDICAL AIR
MB	MOP BASIN
MBH	1,000 BTU
MG	MEDICAL GAS
MH	MANHOLE
MIN	MINIMUM
MS	MOP SINK
N2	NITROGEN
O2	OXYGEN
OR	OPEN RECEPTACLE
ORD	OVERFLOW ROOF DRAIN
ORL	OVERFLOW ROOF LEADER
OWS	OIL WATER SEPARATOR
PD	PUMP DISCHARGE
PDI	PLUMBING DRAINAGE INSTITUTE

ABBREVIATIONS CONT.	
PRV	PRESSURE REDUCING VALVE
PSI	POUNDS PER SQUARE INCH
PT	PLASTER TRAP
RBS	RECIRC. BALANCE STATION
RD	ROOF DRAIN
RL	ROOF LEADER
RP	RECIRCULATION PUMP
RPZ	REDUCED PRESSURE ZONE BACKFLOW PREVENTER
S	SINK
SAN	SANITARY
SCO	STACK CLEANOUT
SP	SUMP PUMP
SS	SERVICE SINK
ST	STORAGE TANK
STM	STORM
TB	THRUST BLOCK
TD	TRENCH DRAIN
TP	TRAP PRIMER
TMV	THERMOSTATIC MIXING VALVE
T&P	TEMPERATURE & PRESSURE
TS	TAMPER SWITCH
U	URINAL
UT	UTILITY TUB
V	VENT
VB	VACUUM BREAKER
VTR	VENT THROUGH ROOF
WB	WASHER BOX
WC	WATER CLOSET
W.C.	WATER COLUMN
WCO	WALL CLEANOUT
WH	WALL HYDRANT
WS	WASH STATION
WS	WATER SOFTENER
X	EXISTING


PLUMBING LINETYPES	
SYMBOL	DESCRIPTION
-----1"CW-----	UNDER SLAB COLD WATER PIPING WITH SIZE
-----1"CW-----	COLD WATER PIPING WITH SIZE
-----1"HW-----	HOT WATER PIPING WITH SIZE
-----1"HW-----	HOT WATER RETURN PIPING WITH SIZE
-----1"SAN-----	UNDER SLAB SANITARY PIPING WITH SIZE
-----1"SAN-----	SANITARY PIPING WITH SIZE
-----1"V-----	UNDER SLAB VENT PIPING WITH SIZE
-----1"V-----	VENT PIPING WITH SIZE
-----1"GR-----	UNDER SLAB GREASE PIPING WITH SIZE
-----1"GRV-----	UNDER SLAB GREASE VENT PIPING WITH SIZE
-----1"GRV-----	GREASE VENT PIPING WITH SIZE
-----1"AW-----	UNDER SLAB ACID WASTE PIPING WITH SIZE
-----1"AW-----	ACID WASTE PIPING WITH SIZE
-----1"AV-----	UNDER SLAB ACID VENT PIPING WITH SIZE
-----1"AV-----	ACID VENT PIPING WITH SIZE
-----1"RL-----	ROOF LEADER PIPING WITH SIZE
-----1"STM-----	UNDER SLAB STORM WITH SIZE
-----1"G-----	UNDER SLAB GAS PIPING WITH SIZE (SLEEVED)
-----1"G-----	GAS PIPING WITH SIZE
-----1"TW-----	TEMPERED WATER PIPING WITH SIZE
-----1"TW-----	FIRE PROTECTION PIPE
-----1"CA-----	COMPRESSED AIR PIPING WITH SIZE
-----1"VAC-----	VACUUM PIPING WITH SIZE

GENERAL NOTES - PLUMBING:

- A. CONSTRUCTION PHASING: ALL WORK SHALL BE COORDINATED AND SCHEDULED WITH THE GENERAL CONTRACTOR, OTHER TRADES, THE OWNER, RELATED UTILITY COMPANIES SHALL COINCIDE WITH CONSTRUCTION PHASING PER THE ARCHITECTURAL DOCUMENTS. CONTACT THE ARCHITECT/ENGINEER IN THE EVENT OF A CONFLICT.
- B. NEW UTILITIES: THE CONTRACTOR SHALL BE RESPONSIBLE FOR ALL NEW UTILITY SERVICES AND COSTS UNDER THIS CONTRACT. COORDINATE AND SCHEDULE ALL RELATED WORK WITH THE UTILITY COMPANIES.
- C. MAINTAIN SITE UTILITIES: THE CONTRACTOR SHALL MAINTAIN ALL EXISTING SITE UTILITIES AT ALL TIMES. THE CONTRACTOR SHALL WORK CONTINUOUSLY TO RESTORE ANY OUTAGE. SCHEDULED SHUT-DOWNS SHALL REQUIRE 48 HOUR PRIOR NOTIFICATION WITH OWNER. COORDINATE ALL RELATED WORK WITH THE OWNER AND THE UTILITY COMPANIES AS REQUIRED.
- D. VERIFY UTILITIES: FIELD VERIFY THE LOCATIONS AND ELEVATIONS OF EXISTING UTILITIES WHERE REQUIRED FOR CONNECTIONS OF NEW WORK PRIOR TO CONSTRUCTION AND FABRICATION. DOCUMENT ON THE AS-BUILT DRAWINGS, THE TYPE, SIZE, MATERIAL, LOCATION AND INVERT ELEVATIONS OF ALL UTILITIES ENCOUNTERED. COORDINATE ALL RELATED WORK WITH ALL PARTIES INVOLVED. CONTACT THE ENGINEER IN THE EVENT OF A CONFLICT.
- E. CONTACT B.U.D.: THE EXISTING UTILITIES, EQUIPMENT, AND PIPING SHOWN ON THESE DRAWINGS ARE FROM RECORD DRAWINGS AND VISUAL INSPECTION OF THE SITE. THE NUMBER, LOCATION, SIZE, AND TYPE OF UTILITIES SHOWN ARE APPROXIMATE, AND THERE MAY BE OTHER UTILITIES NOT SHOWN. THE CONTRACTOR SHALL CONTACT ALL AFFECTED UTILITY COMPANIES AND KENTUCKY B.U.D. PRIOR TO BEGINNING EXCAVATION.
- F. PERMITS, TESTING, AND INSPECTIONS: THE CONTRACTOR SHALL BE RESPONSIBLE FOR ALL PERMITS, TESTING AND SCHEDULES INSPECTIONS.
- G. REMOVAL OF EXISTING UTILITIES: REMOVE UNUSED/ABANDONED EQUIPMENT, PIPING, ETC. AS NECESSARY TO INSTALL THE NEW WORK. CAP THE ENDS OF ALL LINES AND ABANDONED IN PLACE.
- H. TEMPORARY CONSTRUCTION HEAT: PROVIDE TEMPORARY HEAT IN CONSTRUCTION AREAS AS REQUIRED TO PREVENT FREEZING OF WATER PIPING DURING CONSTRUCTION.
- I. PATCHING AND REPAIRING: PATCH AND REPAIR ALL AREAS WHERE WALLS, SLABS, PAVEMENT, CURBS, VEGETATION AND MATERIALS HAVE BEEN CUT, REMOVED, DISTURBED AND OR MODIFIED. MATCH EXISTING MATERIALS, RATINGS, AND FINISHES.
- J. CUTTING EXISTING MATERIALS: CUTTING OF EXISTING PAVEMENT, SLABS, CONCRETE MASONRY, WALLS, ETC. SHALL BE SAW-CUT OR CORE DRILLED. NO "HAMMER DRILLING" WILL BE ALLOWED.
- K. ROOFING PENETRATIONS: ALL ROOF PENETRATIONS SHALL BE IN COMPLIANCE WITH THE ROOFING MANUFACTURER'S GUIDELINES, THE AMERICAN ROOFING COUNCIL, AND MAINTAIN ALL WARRANTIES.
- L. WALL PENETRATIONS: SEAL ALL PIPING PENETRATIONS THROUGH EXTERIOR WALLS WITH SILICONE SEALANT AS REQUIRED TO MAKE WATER/WEATHER TIGHT.
- M. EXISTING WALL OPENINGS: EXISTING OPENINGS IN WALLS THAT ARE NOT BEING RE-USED SHALL BE PATCHED/CLOSED BY THE GENERAL CONTRACTOR.
- N. NEW OPENINGS: NEW OPENINGS FOR PLUMBING PENETRATIONS THROUGH FIRE/SMOKE RATED WALLS, ASSEMBLIES AND SLABS SHALL BE BY THE GENERAL CONTRACTOR. THE PLUMBING CONTRACTOR SHALL COORDINATE THE SIZE AND LOCATION OF ALL OPENINGS WITH THE GENERAL CONTRACTOR AND OTHER TRADES.
- O. STRUCTURAL COORDINATION: THE CONTRACTOR IS RESPONSIBLE FOR REVIEWING ALL BELOW SLAB / UNDERGROUND PIPING WITH STRUCTURAL COMPONENTS AND COORDINATING ALL STEPPED FOOTINGS OR SLEEVES WHERE REQUIRED.
- P. FIRE AND SMOKE STOPPING: ALL PLUMBING PENETRATIONS THROUGH FIRE/SMOKE RATED WALLS, ASSEMBLIES AND SLABS SHALL BE THE RESPONSIBILITY OF THE GENERAL CONTRACTOR. THE PLUMBING CONTRACTOR SHALL COORDINATE THE SIZE AND LOCATION OF ALL OPENINGS WITH THE GENERAL CONTRACTOR AND OTHER TRADES.
- Q. INSULATION: INSULATE ALL DOMESTIC HOT/COLD WATER, RECIRCULATION PIPING, AND ROOF LEADERS.
- R. HAMMER ARRESTOR: ALL HAMMER ARRESTORS SHOWN ON FLOOR PLANS, BUT NOT ON RISERS OR VICE VERSA SHALL BE PROVIDED AND INSTALLED AS SHOWN ON BOTH.
- S. VALVES: ALL VALVES SHOWN ON FLOOR PLANS, BUT NOT ON RISERS OR VICE VERSA, SHALL BE PROVIDED AND INSTALLED AS IF SHOWN ON BOTH.
- T. ELECTRICAL PANELS AND EQUIPMENT: PLUMBING PIPING, SYSTEMS, AND EQUIPMENT SHALL BE INSTALLED TO MAINTAIN THE DEDICATED WORKING/ELECTRICAL SPACE ABOVE, BELOW, AND IN FRONT OF ELECTRICAL PANELS AND EQUIPMENT PER THE REQUIREMENTS OF THE N.E.C. (NATIONAL ELECTRIC CODE).

GENERAL DEMOLITION NOTES:

- A. GENERAL PLUMBING DEMOLITION NOTES APPLY TO ALL PLUMBING SHEETS.
- B. SEE ARCHITECTURAL DRAWINGS FOR BUILDING FLOOR PLAN LAYOUT.
- C. THE EXISTING CONDITIONS REPRESENTED ON PLANS DEPICT APPROXIMATE LOCATIONS AND SIZES OF EQUIPMENT AND COMPONENTS. FIELD-VERIFY ACTUAL CONDITIONS AND DETERMINE ACTUAL LOCATIONS AND SIZES OF EQUIPMENT PRIOR TO COMMENCING WORK.
- D. SUBSTANTIAL DEVIATIONS BETWEEN THE CONTRACT DOCUMENTS DEMOLITION SCOPE AND ACTUAL CONDITIONS SHALL BE REPORTED TO THE ARCHITECT/ENGINEER IN THE FORM OF A REQUEST FOR INFORMATION WITH THE DESCRIPTIONS AND SKETCHES.
- E. SCHEDULING OF ALL DEMOLITION OPERATIONS SHALL BE COORDINATED WITH OWNER NO LATER THAN THE DATE OF THE PROJECT PRECONSTRUCTION MEETING.
- F. PROVIDE DEMOLITION WORK SHOWN ON THE DRAWINGS AND ALL INCIDENTAL DEMOLITION WORK REQUIRED TO COMPLETE NEW CONSTRUCTION WORK.
- G. PROTECT EXISTING EQUIPMENT, PIPING, DUCTWORK, AIR OPENINGS, ETC. FROM DIRT AND DAMAGE DURING DEMOLITION AND CONSTRUCTION.
- H. COMPLETELY REMOVE ALL COMPONENTS INDICATED ON PLANS FOR DEMOLITION INCLUDING REMOVAL OF ALL SUPPORTS, HANGERS, PIPING, WIRING, ECT. THAT ARE ASSOCIATED WITH THE COMPONENT BEING REMOVED, UNLESS OTHERWISE STATED.
- I. CONTRACTOR SHALL PATCH AND REPAIR ALL DAMAGE ASSOCIATED WITH DEMOLITION. ALL FINISHED SURFACES (FLOORS, WALLS, CEILINGS, ROOF, ETC.) SHALL MATCH EXISTING CONDITIONS.
- J. PROVIDE 1-HOUR FIRE RATED DUST PROOF BARRIERS (UL DESIGN U309) TO SEPARATE DEMOLITION AREA FROM THE REST OF THE FACILITY.
- K. WHERE DUST CREATED DURING DEMOLITION MAY ENTER AN HVAC SYSTEM RETURN AIR DUCT, PROVIDE TEMPORARY FILTERS AS REQUIRED TO PREVENT DUST INTRUSION.
- L. MAINTAIN OPERATION OF ALL EXISTING SERVICES AND UTILITIES SERVING AREAS THAT ARE OCCUPIED OR IN OPERATION DURING DEMOLITION WORK. COORDINATE AND SCHEDULE ALL DISRUPTIONS TO SERVICES OR UTILITIES WITH OWNER TWO WEEKS IN ADVANCE OF INTERRUPTION.
- M. REMOVE, RELOCATE AND REINSTALL ANY COMPONENTS WHEN REQUIRED TO ACCOMMODATE DEMOLITION OR NEW WORK SCOPE. COMMUNICATE TO ARCHITECT/ENGINEER THE EXTENT OF ITEMS TO BE REMOVED PRIOR TO BEGINNING THE WORK.
- N. STORE AND PROTECT ALL EXISTING ITEMS WHICH ARE TO BE RELOCATED OR REUSED.
- O. WHERE DEMOLITION/RE-WORK OF EXISTING MEP ITEMS CONTAINING HAZARDOUS MATERIALS OCCUR, THE CONTRACTOR SHALL NOTIFY THE ARCHITECT/ENGINEER FOR ABATEMENT AND REMEDIATION AS REQUIRED.

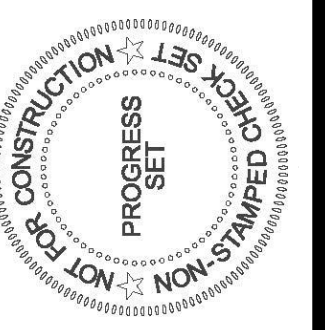


JOB NO.	2459
DATE	NOV 17, 2025
DRAWN	BRN
CHECKED	NCM


COPYRIGHT © 2025
SHERMAN CARTER BARNHART
ARCHITECTS, PLLC


REVISIONS		
No.	Description	Date

 SHEET




SCALE: 1/8" = 1'-0"

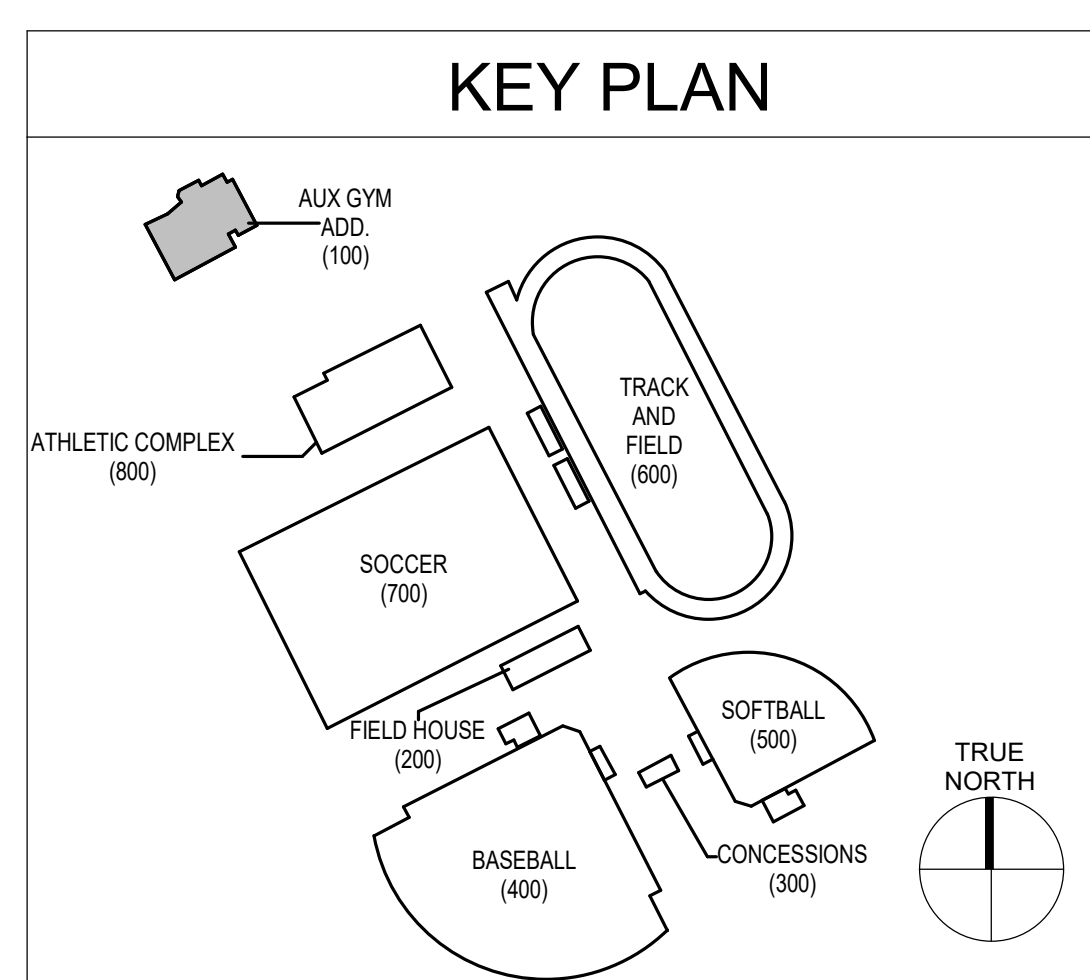

 

1 FIRST FLOOR PLAN - AUXILIARY GYMNASIUM ADDITION - DOMESTIC WATER
SCALE: 1/8" = 1'-0"

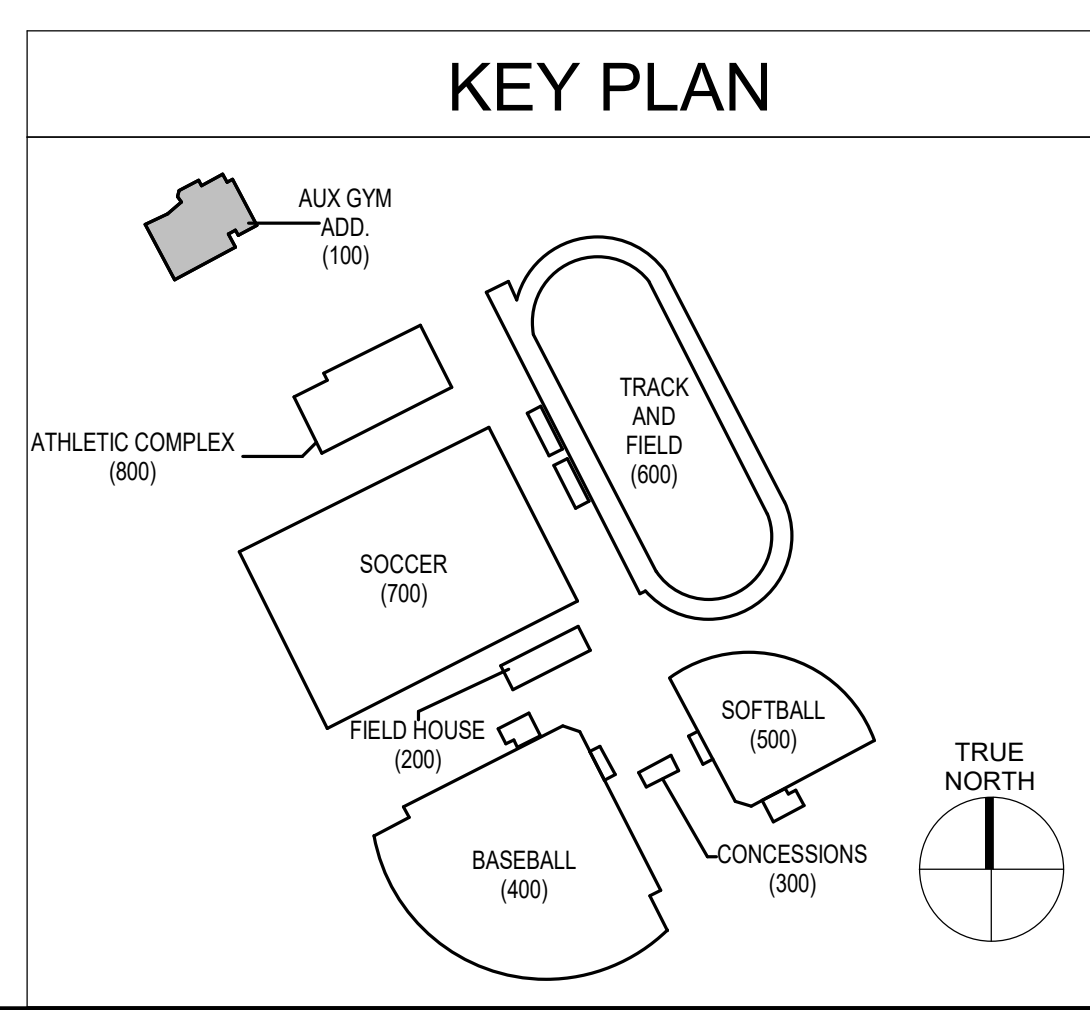

JOB NO.	2459	
DATE	NOV 17, 2025	
DRAWN	BRN	
CHECKED	NCM	
COPYRIGHT © 2025 SHERMAN CARTER BARNHART ARCHITECTS, PLLC		
REVISIONS		
No.	Description	Date


SHEET

P210

GENERAL NOTES


A. REFER TO SHEET P001 FOR PLUMBING LEGEND AND
GENERAL NOTES.

SHEET KEYNOTES

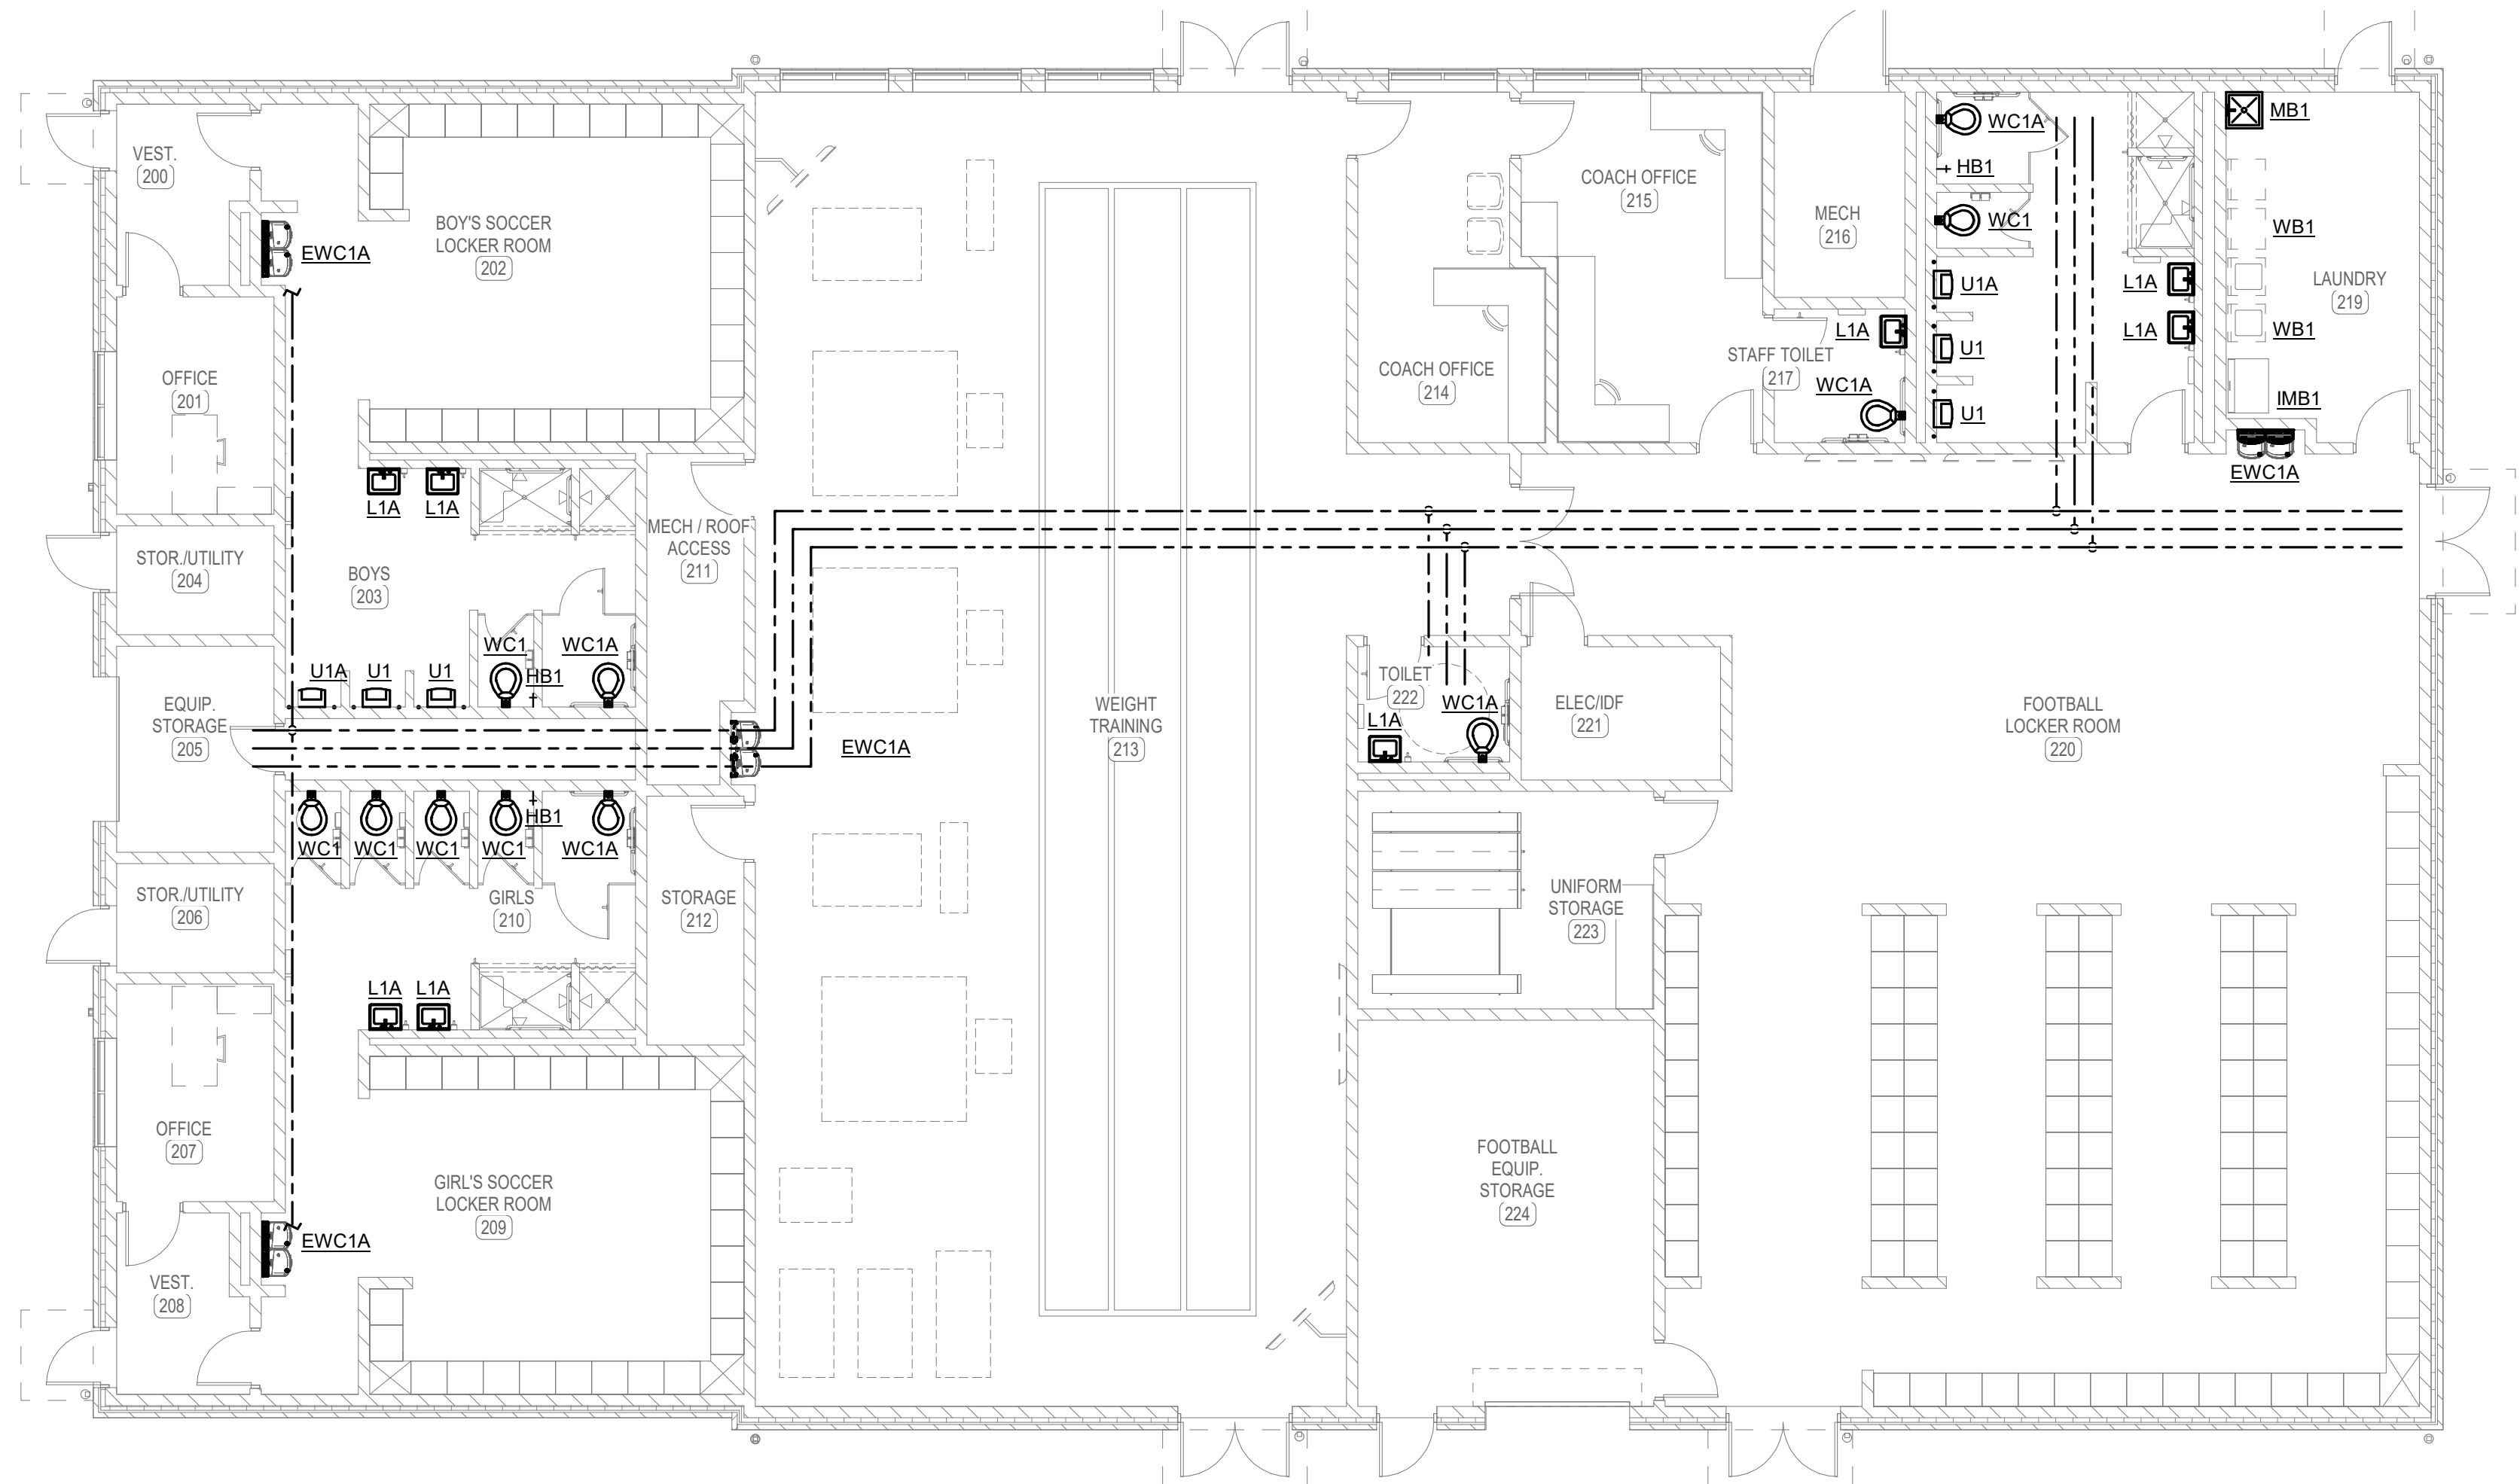1. REFER TO PLUMBING SITE UTILITIES PLAN FOR
CONTINUATION.

2 FIRST FLOOR PLAN - FIELD HOUSE - DOMESTIC WATER
SCALE: 1/8" = 1'-0"


0 4' 8' 16'

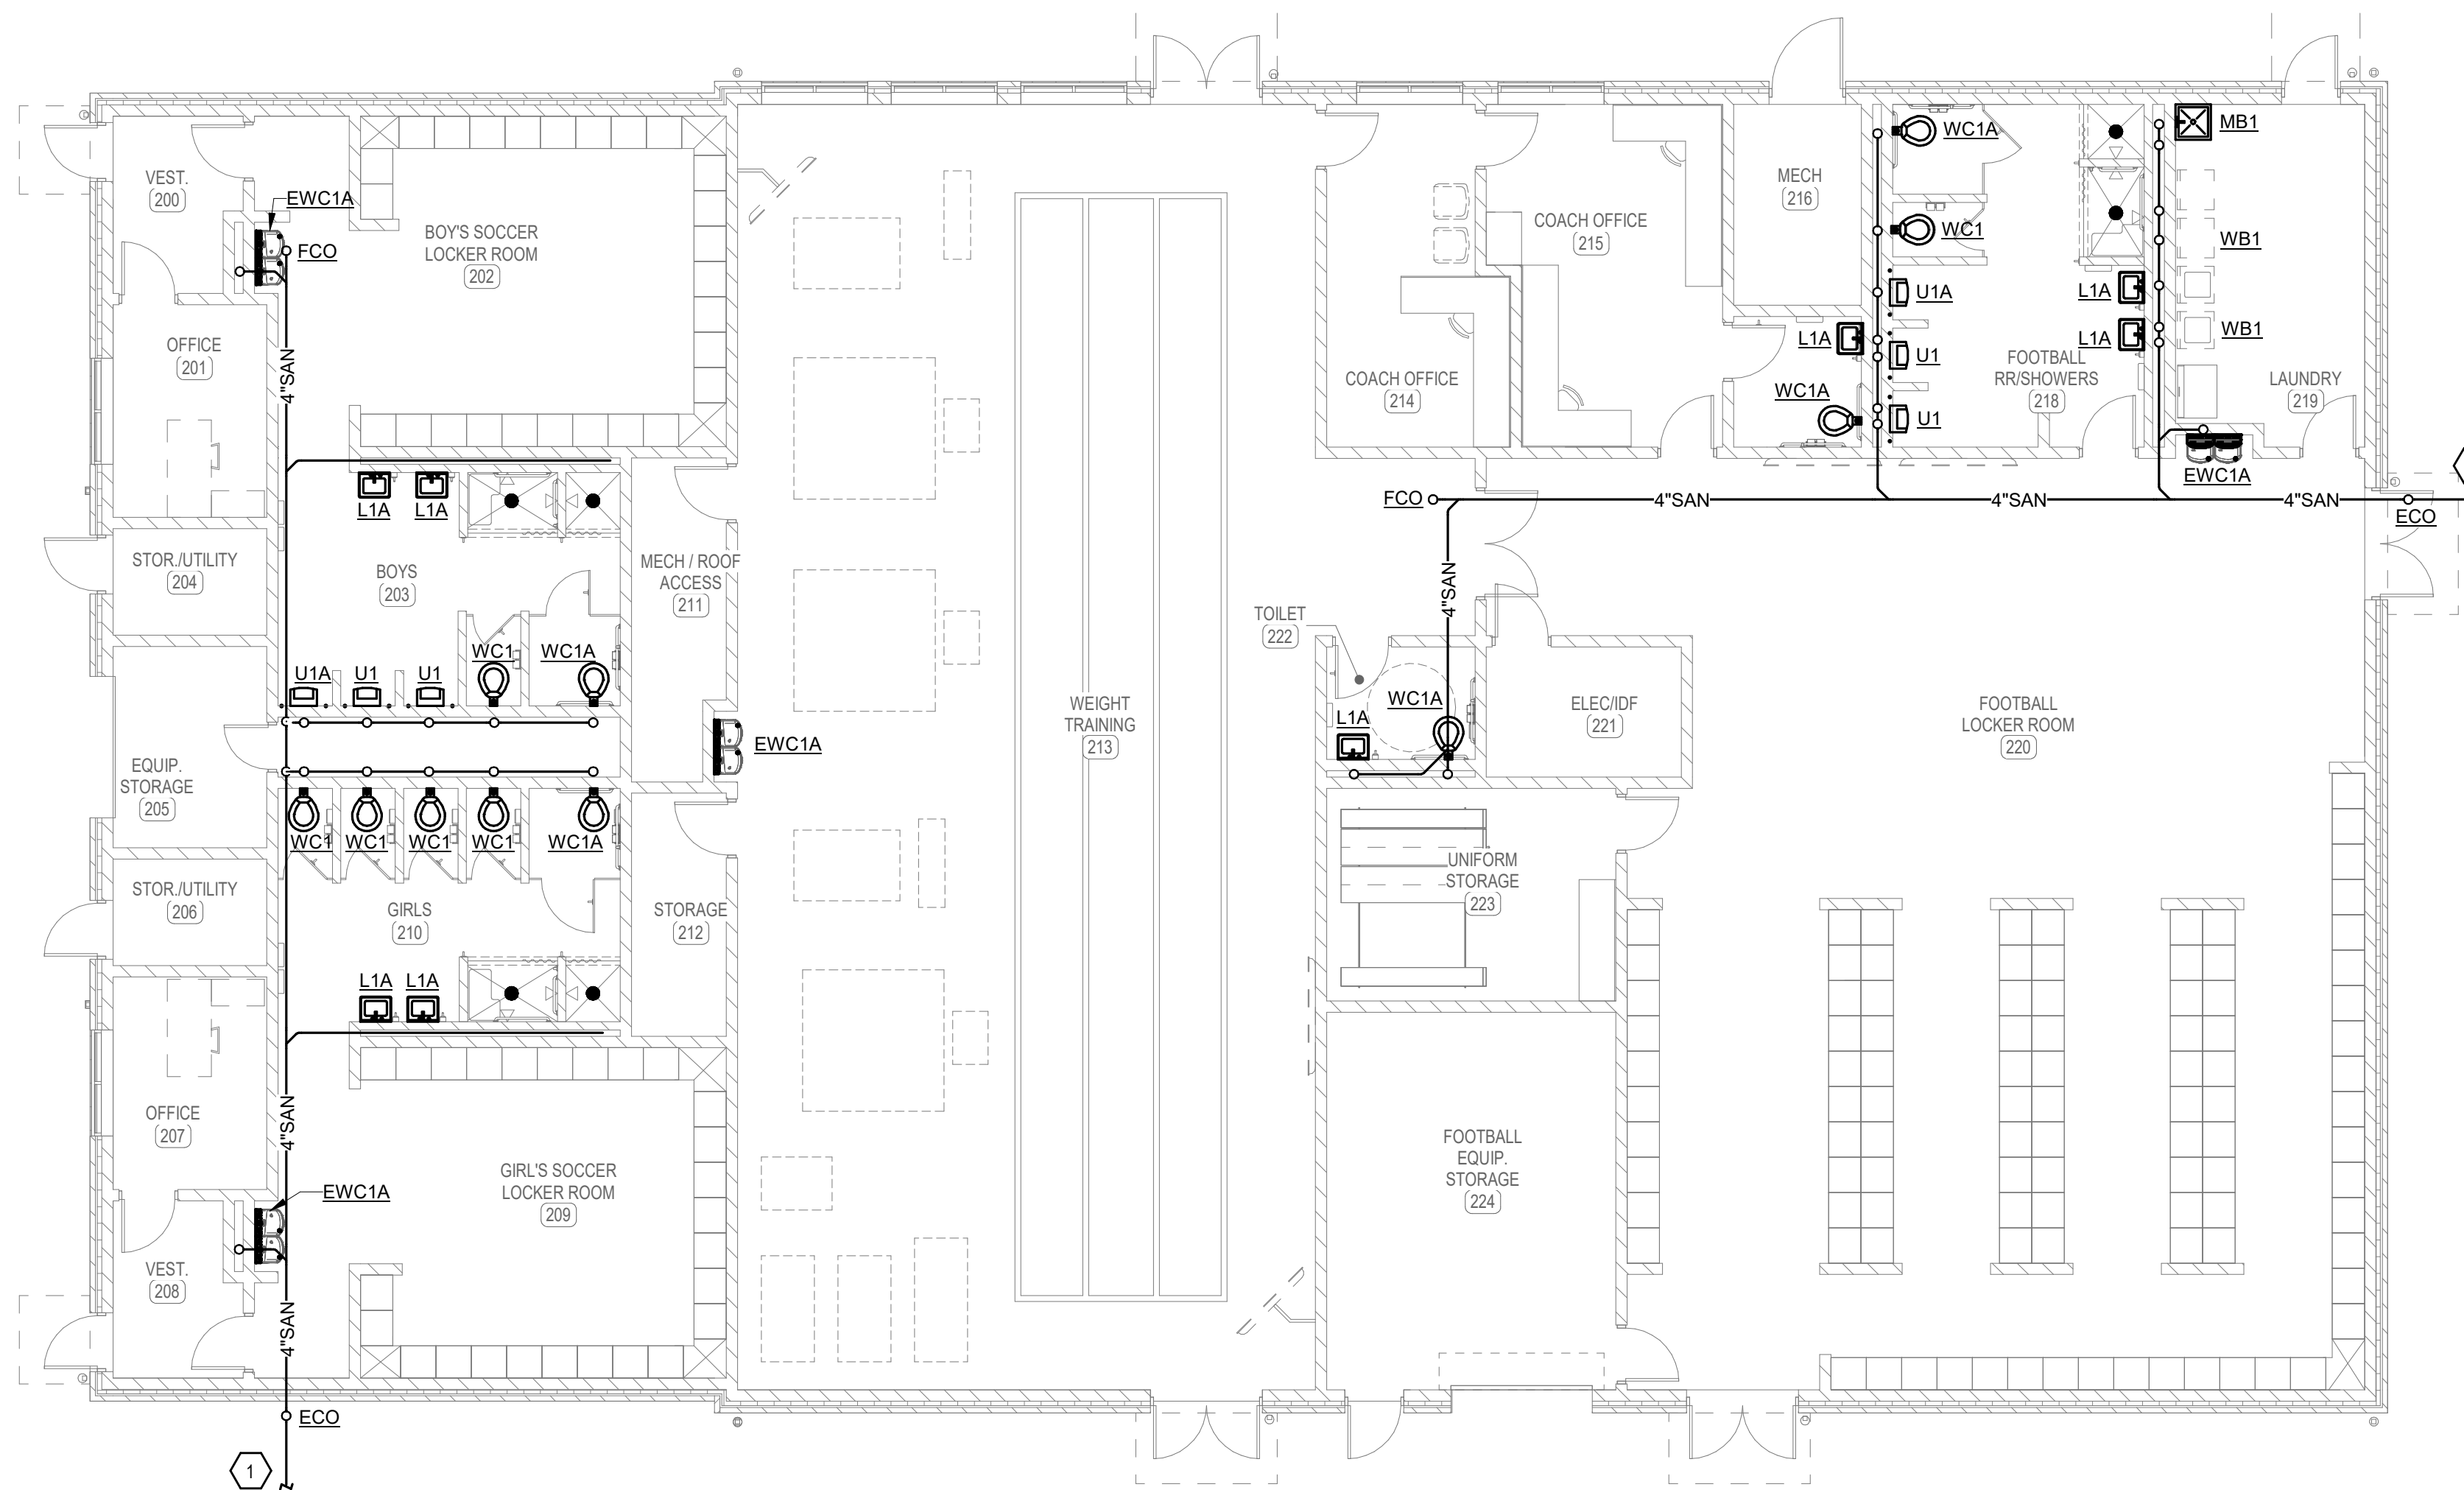







1 FIRST FLOOR PLAN - FIELD HOUSE - SANITARY SEWER
SCALE: 1/8" = 1'-0"





0 4' 8' 16'
















KEY PLAN

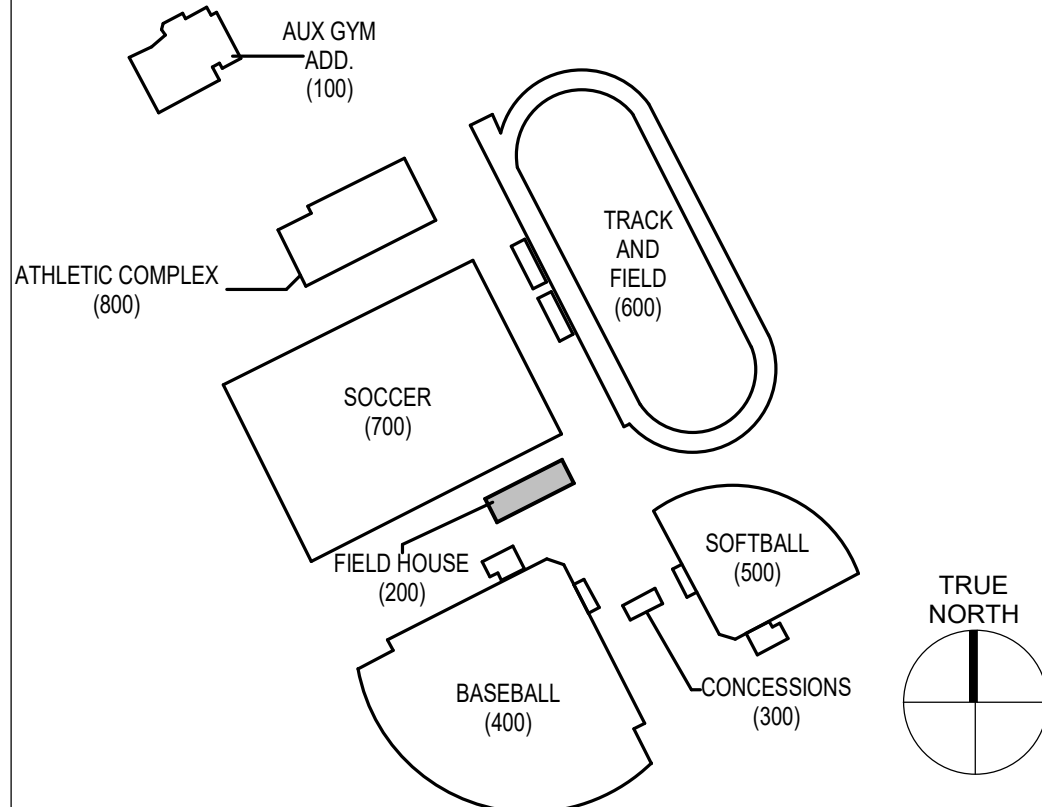

MECHANICAL LEGEND

      HVAC	
SYMBOL	DESCRIPTION
	SUPPLY AIR DIFFUSER (4-WAY, 3-WAY, 2-WAY, 1-WAY)
	SUPPLY AIR DIFFUSER (ROUND)
	RETURN GRILLES
	EXHAUST GRILLES
	FLEXIBLE CONNECTION
	SUPPLY AIR DUCT (UP-, DOWN)
	RETURN AIR DUCT (UP-, DOWN)
	EXHAUST AIR DUCT (UP-, DOWN)
	ACCESS DOOR
	RECTANGULAR TO ROUND DUCTWORK TRANSITION
	RECTANGULAR TO RECTANGULAR TRANSITION
	DUCT CHANGE IN ELEVATION; R= RISE, D= DROP
	DUCT SIZE BACKDRAFT DAMPER (ARROW INDICATES FLOW DIRECTION)
	FIRE DAMPER
	MANUAL VOLUME CONTROL BALANCE DAMPER
	SMOKE DAMPER
	MOTORIZED DAMPER
	COMBINATION - FIRE / SMOKE DAMPER
	ELBOW WITH TURNING VANES
	ELBOW ROUND
	CONNECT NEW TO EXISTING
	INDICATES AIR FLOW DIRECTION
	GATE VALVE (HORIZ. - VERT.)
	GLOBE VALVE (HORIZ. - VERT.)
	BUTTERFLY VALVE (HORIZ. - VERT.)
	BALL VALVE (HORIZ. - VERT.)
	CONTROL VALVE (2-WAY, 3-WAY)
	TRIPLE-DUTY VALVE
	PRESSURE GAUGE
	TEMPERATURE GAUGE / THERMOMETER
	PRESSURE REDUCING VALVE
	STRAINER
	CHECK VALVE
	FLOW INDICATOR
	BALANCE VALVE
	EXISTING PIPING/DUCT/EQUIPMENT TO REMAIN
	EXISTING PIPING/DUCT/EQUIPMENT TO BE REMOVED
	CAP OR PLUG
	PIPE DOWN, PIPE UP
	INCREASER / REDUCER
	FLOW SWITCH (FS)
	FLOW METER (FM)(DDC)
	TEMPERATURE SENSOR (TS)(DDC)
	PRESSURE SENSOR (TS)(DDC)
	MANUAL AIR VENT
	AUTOMATIC AIR VENT
	ROOM THERMOSTAT OR DUCT STAT
	SENSOR (CO, CO2, ETC.)
	HUMIDISTAT
	SUPPLY AIR DEVICE (S-1) / AIRFLOW (CFM)
	EQUIPMENT IDENTIFICATION
	DETAIL NO. / SHEET NO.
	SECTION NO. / SHEET NO.
	INDICATED TAG OR SHEET NOTE
	DEMOLITION NOTE
	REVISION TAG
	EXTENT OF DEMOLITION
	EXPANSION JOINT

    HVAC	
SYMBOL	DESCRIPTION
	PIPE ANCHOR
	COMBINATION FLOW INDICATOR / BALANCING (4\" data-bbox="255 117 281 127"/>
	COMBINATION FLOW INDICATOR / BALANCING (5\" data-bbox="255 130 281 140"/>
	TEMP. / PRESS. RELIEF VALVE
	FLANGED CONNECTION
	UNION
	FLEXIBLE CONNECTION
	PUMP

               HVAC	
SYMBOL	DESCRIPTION
	CONDENSATE DRAIN LINE
	CHILLED WATER RETURN PIPING
	CHILLED WATER SUPPLY PIPING
	EXHAUST AIR DUCTWORK
	HYDRONIC RETURN PIPING
	HYDRONIC SUPPLY PIPING
	HIGH PRESSURE RETURN
	HIGH PRESSURE STEAM
	HOT WATER RETURN PIPING
	HOT WATER SUPPLY PIPING
	LOW PRESSURE RETURN
	LOW PRESSURE STEAM
	MEDIUM PRESSURE RETURN
	MEDIUM PRESSURE STEAM
	OUTSIDE AIR DUCTWORK
	REFRIGERANT LINE SET PIPING
	RETURN AIR DUCTWORK
	SUPPLY AIR DUCTWORK

ABBREVIATIONS	
AFC	ABOVE FINISHED CEILING
AFF	ABOVE FINISHED FLOOR
AFG	ABOVE FINISHED GRADE
AHU-X	AIR HANDLING UNIT
AS-X	AIR SEPARATOR
ATV	AUTO. TEMPERING VALVE
B-X	BOILER
BTU	BRITISH THERMAL UNIT
BTUH	BRITISH THERMAL UNITS PER HOUR
C	COMMON
CAS-X	VARIABLE REFRIGERANT CASSETTE UNIT
CFM	CUBIC FEET PER MINUTE
CH-X	CHILLER
CT-X	COOLING TOWER
CU-X	CONDENSING UNIT
E-X	EXHAUST AIR DEVICE
EF-X	EXHAUST FAN DESIGNATION
EH-X	ELECTRIC HEATER
ERU-X	ENERGY RECOVERY UNIT
ESP	EXTERNAL STATIC PRESSURE
EXT-X	EXPANSION TANK
FC-X	CLOSED-CIRCUIT FLUID COOLER
FCU-X	FAN COIL UNIT
FZT	FREEZESTAT
GBD	GRAVITY BACKDRAFT DAMPER
GH-X	GRAVITY HOOD
GPM	GALLONS PER MINUTE
HP	HORSEPOWER
HP-X	HEAT PUMP UNIT
HT-X	HEAT TRACE
HX-X	HEAT EXCHANGER
KH-X	KITCHEN HOOD
KW	KILOWATT
L-X	LOUVER DESIGNATION
MAU-X	MAKE-UP AIR UNIT
MBH	THOUSAND BRITISH THERMAL UNITS PER HOUR
MOU-X	MINISPLIT OUTDOOR UNIT
NC	NORMALLY CLOSED
NO	NORMALLY OPEN
P-X	PUMP
PRV	PRESSURE REDUCING VALVE
R-X	RETURN AIR DEVICE
RH-X	RADIANT HEATER
RTU-X	ROOFTOP UNIT
S-X	SUPPLY AIR DEVICE
SF-X	SUPPLY FAN DESIGNATION
SP	TOTAL STATIC PRESSURE
T-X	TRANSFER AIR DEVICE
VAV-X	VARIABLE AIR VOLUME BOX
VEF-X	VEHICLE EXHAUST FAN
X	EXISTING

GENERAL NOTES:

- A. REFER TO SPECIFICATIONS AND THE CONTRACT DOCUMENTS FOR ADDITIONAL INFORMATION AND REQUIREMENTS.
- B. ALL MECHANICAL WORK SHALL BE PERFORMED BY A LICENSED MECHANICAL CONTRACTOR.
- C. ALL WORK SHALL BE COORDINATED AND SCHEDULED WITH THE CONSTRUCTION MANAGER (CM) OR GENERAL CONTRACTOR (GC), OTHER TRADES, THE OWNER, AND RELATED UTILITY COMPANIES. ALL WORK SHALL COINCIDE WITH THE CONSTRUCTION PHASING PER THE CONTRACT DOCUMENTS OR CONSTRUCTION DOCUMENTS AND/OR AS MODIFIED BY THE CM/GC AND APPROVED BY THE OWNER AND DESIGN TEAM. THE MECHANICAL CONTRACTOR SHALL COORDINATE AND DEVELOP A PHASING PLAN WHERE ONE IS NOT EXPLICITLY SHOWN AND SHALL ENSURE THAT SAID PHASING PLAN IS APPROVED PRIOR TO PROCEEDING WITH WORK. ANY AND ALL DEMOLITION SHALL NOT PERMIT INTERRUPTION OF SERVICE IN AN OCCUPIED BUILDING UNLESS COORDINATED AND APPROVED.
- D. ALL DRAWINGS ARE DIAGRAMMATIC AND INDICATE THE GENERAL ARRANGEMENTS OR GEOMETRICAL RELATIONSHIPS OF DUCTWORK, PIPING, EQUIPMENT, AND SERVICES. THEY ARE NOT INTENDED TO SPECIFY OR SHOW EVERY OFFSET, SEQUENCE, DEVICE, OPTION, FITTING, VALVE, OR COMPONENT. CONTRACTOR TO PROVIDE ANY ADDITIONAL DUCT OR PIPING OFFSETS AND/OR FITTINGS, INCLUDING DIVIDED DUCTS AND FLATTENED DUCTS, REQUIRED FOR PROPER INSTALLATION AND TO MAINTAIN CLEARANCES AS ENCOUNTERED IN THE FIELD.
- E. THE MECHANICAL CONTRACTOR SHALL OBTAIN A COPY OF THE ENTIRE SET OF CONTRACT DOCUMENTS PRIOR TO BID AND SHALL COORDINATE ROUTING AND INSTALLATION OF MECHANICAL DUCTWORK, PIPING, AND EQUIPMENT WITH ALL OTHER DISCIPLINES AND TRADES INCLUDING BUT NOT LIMITED TO CIVIL, ARCHITECTURAL, STRUCTURAL, FIRE SUPPRESSION, PLUMBING, AND ELECTRICAL.
- F. REFER TO THE ENTIRE SET OF CONTRACT DOCUMENTS FOR DETAILS OF CONSTRUCTION AND INSTALLATION REQUIREMENTS. FURNISH ALL LABOR, MATERIAL, AND EQUIPMENT REQUIRED FOR COMPLETION AND OPERATION OF A FULLY FUNCTIONAL MECHANICAL SYSTEM AND IN ACCORDANCE WITH ALL APPLICABLE CODES AND STANDARDS INCLUDING BUT NOT LIMITED TO THE KENTUCKY BUILDING CODE, ASHRAE, IMC, IECC, SMACNA, AND NFPA.
- G. THE EXACT LOCATIONS OF ALL EQUIPMENT, DUCTS, DIFFUSERS, ETC. SHALL BE COORDINATED WITH ALL OTHER TRADES. CEILING MOUNTED LIGHTING AND ELECTRICAL REQUIREMENTS TAKE PRECEDENCE OVER CEILING MOUNTED MECHANICAL EQUIPMENT. SEE ARCHITECTURAL REFLECTED CEILING PLANS FOR CEILING GRID AND LIGHTING LAYOUT FOR COORDINATION OF FINAL DIFFUSER LOCATIONS.
- H. THE CONTRACTOR IS RESPONSIBLE FOR REVIEWING ALL BELOW SLAB / UNDERGROUND PIPING WITH STRUCTURAL COMPONENTS AND COORDINATING ALL STEPPED FOOTINGS OR SLEEVES WHERE REQUIRED.
- I. THE MECHANICAL DRAWINGS REFLECT A "BASIS OF DESIGN" HVAC SYSTEM THAT HAS BEEN DESIGNED AROUND SPECIFIC PRODUCTS/MANUFACTURERS (SEE SCHEDULES). THE SELECTION OF A "BASIS OF DESIGN" HAS INFLUENCED THE DESIGNS OF OTHER TRADES (ELECTRICAL, STRUCTURAL, ETC.). THE CONTRACTOR MAY USE "NON-BASIS OF DESIGN" PRODUCTS/MANUFACTURERS AS PERMITTED BY THE SPECIFICATIONS AND/OR CONTRACT DOCUMENTS. COORDINATION OF ALL MODIFICATIONS TO EACH DISCIPLINE WHICH RESULT FROM THE USE OF "NON-BASIS OF DESIGN" EQUIPMENT OR MATERIALS SHALL BE THE RESPONSIBILITY OF THE MECHANICAL CONTRACTOR. IF "NON-BASIS OF DESIGN" MANUFACTURERS, SIZES, OR MODEL NUMBERS ARE BID, SUBMITTED, OR INSTALLED, IT IS THE RESPONSIBILITY OF THE MECHANICAL CONTRACTOR AND ALL OF HIS OR HER SUBCONTRACTORS TO COORDINATE ALL DIFFERENCES PRIOR TO BID. ALL COSTS OF ALL TRADES ASSOCIATED WITH THE USE OF "NON-BASIS OF DESIGN" EQUIPMENT SHALL BE THE RESPONSIBILITY OF THE MECHANICAL CONTRACTOR AND SHALL BE INCLUDED IN THE BID. SUBSEQUENTLY, ANY ADDITIONAL COST BORE BY THE ENGINEER (MECHANICAL, ELECTRICAL, ETC.) TO ACCOMMODATE "NON-BASIS OF DESIGN" EQUIPMENT SHALL BE BORE BY THE CONTRACTOR AND PAID TO THE ENGINEER OF RECORD DURING SUBMITTALS.
- J. EQUIPMENT OR MATERIALS AS ALLOWED BY THE SPECIFICATIONS AND/OR CONTRACT DOCUMENTS, WHICH ARE INSTALLED BEFORE AND SUBSEQUENTLY VIEWED UNSATISFACTORY BY THE OWNER AND REPLACED WITHIN THE WARRANTY PERIOD, SHALL BE REMOVED COMPLETELY BY THE CONTRACTOR AND REPLACED WITH THE ORIGINAL DESIGN OR CORRECTED AS DIRECTED BY THE ENGINEER WITHOUT ADDITIONAL COST TO THE OWNER.
- K. CONTRACTOR SHALL VISIT THE JOB SITE, FIELD VERIFY FIT, COORDINATE WITH OTHER TRADES, AND BECOME FAMILIAR WITH ALL PROJECT CONDITIONS PRIOR TO FABRICATING DUCTWORK, INSTALLING EQUIPMENT, ETC. NO ALLOWANCES WILL BE MADE FOR LACK THEREOF.
- L. THE CONTRACTOR SHALL BE RESPONSIBLE FOR COORDINATION AND COSTS FOR ALL PERMITS, TESTING, AND INSPECTIONS.
- M. CONTRACTOR TO REMOVE UNUSED/ABANDONED HVAC SYSTEMS AND EQUIPMENT UNLESS INDICATED OTHERWISE ON THE CONTRACT DOCUMENTS.
- N. COORDINATE WITH THE CONTRACT DOCUMENTS AND PROVIDE TEMPORARY HEAT AS REQUIRED.
- O. INFORMATION AND COMPONENTS SHOWN ON RISER DIAGRAMS OR DETAILS BUT NOT SHOWN ON PLANS AND VICE VERSA, SHALL BE PROVIDED AS IF REQUIRED BY BOTH.
- P. THE ENTIRE MECHANICAL INSTALLATION SHALL BE AS REQUIRED TO MAINTAIN FIRE/SMOKE RATINGS AND/OR "UL" ASSEMBLY RATINGS AS REQUIRED BY THE CONTRACT DOCUMENTS AND AS SHOWN ON THE ARCHITECTURAL AND MECHANICAL DRAWINGS. SEAL AROUND ALL PENETRATIONS THROUGH ALL FIRE/SMOKE SEPARATIONS AND/OR "UL" RATED ASSEMBLIES. COORDINATE ALL PENETRATIONS WITH THE CONSTRUCTION MANAGER AND/OR GENERAL CONTRACTOR. PROVIDE ADDITIONAL FIRE DAMPERS, SMOKE DETECTORS, AND SMOKE DAMPERS (INCLUSIVE OF WIRING) AS REQUIRED FOR A FULLY FUNCTIONAL AND CODE COMPLIANT SYSTEM.
- Q. ALL DUCTWORK, PIPING, AND MECHANICAL EQUIPMENT SHALL BE SUPPORTED DIRECTLY FROM THE STRUCTURE. NO OTHER TRADES, I.E. ELECTRICAL, CEILING, PLUMBING, ETC., SHALL BE SUSPENDED, HUNG, OR SUPPORTED FROM MECHANICAL DUCTWORK OR MECHANICAL PIPING.
- R. ALL BUILDING PENETRATIONS MUST BE COORDINATED WITH THE ARCHITECT AND SHALL BE FLASHED AND SEALED WEATHERTIGHT. ALL MATERIALS AND COLORS MUST BE PRE-APPROVED BY THE ARCHITECT. NEW OPENINGS AND/OR PENETRATIONS FOR MECHANICAL ITEMS SHALL BE CUT, SLEEVED, ETC. BY THE MECHANICAL CONTRACTOR. ALL OPENINGS SHALL BE CORE DRILLED OR SAW-CUT. NO "HAMMER DRILLING" WILL BE ALLOWED.
- S. ROUTE DUCTWORK AS HIGH AS POSSIBLE TO FACILITATE ACCESS TO ABOVE CEILING SPACE. COORDINATE ROUTING WITH OTHER SERVICES AND TRADES. PROVIDE ADDITIONAL DUCTWORK OFFSETS, ETC. TO ACCOMMODATE FIELD CONDITIONS AS REQUIRED FOR A COMPLETE AND FUNCTIONING SYSTEM AT NO ADDITIONAL COST. ADDITIONAL OFFSETS REQUIRE APPROVAL FROM THE ENGINEER. ROUTE DUCTWORK BETWEEN JOISTS WHERE POSSIBLE.
- T. ALL AIR DEVICES LOCATED ABOVE GYPBOARD OR HARD CEILINGS SHALL HAVE ACCESSIBLE BALANCING DAMPERS.
- U. ALL DUCTWORK SHALL BE CONSTRUCTED AND INSTALLED PER SMACNA HVAC DUCT CONSTRUCTION STANDARDS.
- V. PROVIDE AND INSTALL DUCT ACCESS DOORS FOR INSPECTION OF ALL INSTALLED FIRE DAMPERS AS DIRECTED BY SMACNA HVAC CONSTRUCTION STANDARDS.
- W. MAXIMUM FLEXIBLE DUCT LENGTH SHALL BE 5'-0" ALL FLEXIBLE DUCT SHALL CONFORM TO THE REQUIREMENTS OF UL 181 FLEXIBLE AIR DUCTS. SUPPORT TO ELIMINATE SAGGING AND KINKING. INSULATED FLEXIBLE DUCTS SHALL MEET MINIMUM R-VALUES REQUIRED BY THE IECC.
- X. ALL HVAC EQUIPMENT TO BE INSTALLED PER MANUFACTURER'S REQUIREMENTS. UTILIZE FACTORY FILTERS DURING CONSTRUCTION.
- Y. THE MECHANICAL CONTRACTOR SHALL BALANCE SYSTEM TO AIR QUANTITIES INDICATED ON PLANS AND PROVIDE OWNERS REPRESENTATIVES WITH COMPLETE NEBB/AABC BALANCE REPORT. THE MECHANICAL CONTRACTOR SHALL PROVIDE AS MANY ADDITIONAL SITE VISITS BY THE LICENSED TAB CONTRACTOR AS REQUIRED BY THE ENGINEER FOR A COMPLETE AND FUNCTIONING AND APPROVED SYSTEM IN COMPLIANCE WITH THE CONTRACT DOCUMENTS.
- Z. ALL RECTANGULAR 90 DEG. AND 45 DEG. ELBOWS SHALL HAVE TURNING VANES.
- AA. PROVIDE A MANUAL VOLUME DAMPER AT ALL BRANCH TAKE-OFFS ON SUPPLY, RETURN, AND OUTSIDE AIR DUCTWORK AT NO ADDITIONAL COST. PROVIDE A MAIN RETURN DAMPER UPSTREAM OF OUTSIDE AIR CONNECTIONS IN RETURN AIR PLENUM DESIGNS. COORDINATE ADDITIONAL MANUAL VOLUME DAMPER LOCATIONS REQUIRED FOR A FULLY FUNCTIONAL SYSTEM WITH THE ENGINEER PRIOR TO ORDER, FABRICATION, OR INSTALLATION.
- BB. ALL DUCT DIMENSIONS SHOWN ARE INTERIOR "CLEAR" DUCT DIMENSIONS.
- CC. MAINTAIN 10'-0" MINIMUM CLEARANCE BETWEEN OUTDOOR AIR INTAKES AND EXHAUST, PLUMBING VENTS, ETC. AND/OR AS REQUIRED BY IMC, WHICHEVER IS MORE STRINGENT.
- DD. MAINTAIN 10'-0" MINIMUM CLEARANCE FROM EDGE OF ROOFTOP EQUIPMENT TO ROOF EDGE UNLESS RAILING OR PARAPET OF SUFFICIENT HEIGHT IS TO BE PROVIDED IN ACCORDANCE WITH ALL APPLICABLE CODES INCLUDING BUT NOT LIMITED TO: IRC, IMC, LOCAL CODES, OSHA GUIDELINES (WHERE APPLICABLE). REFER TO ARCHITECTURAL.
- EE. PROVIDE CONDUIT, BOXES AND CONTROL WIRING IN COMPLIANCE WITH THE NEC AND DIVISION 26.
- FF. MECHANICAL CONTRACTOR SHALL COORDINATE WITH ELECTRICAL CONTRACTOR AND DRAWINGS FOR CONNECTIONS AND LOCATION OF ALL EQUIPMENT.
- GG. CONTRACTOR SHALL PROVIDE ADDITIONAL OFFSETS OR BENDS IN PIPING AS REQUIRED TO ALLOW FOR EXPANSION AND CONTRACTION DUE TO TEMPERATURE CHANGES AND DIFFERENCES IN THE AMBIENT TEMPERATURE WHEN PIPING AND EQUIPMENT IS INSTALLED.
- HH. PROVIDE MANUAL AIR VENTS AT HIGH POINTS AND DRAIN VALVES AT LOW POINTS OF ALL HYDRONIC PIPING. AUTOMATIC AIR VENTS SHALL BE INSTALLED WHERE INDICATED IN THE CONTRACT DOCUMENTS AND/OR AS REQUIRED FOR A FULLY FUNCTIONAL SYSTEM.
- II. MECHANICAL CONTRACTOR SHALL COORDINATE WITH THE ARCHITECTURAL PLANS AND GC/CM ALL AREAS WHERE MECHANICAL/ ELECTRICAL EQUIPMENT AND DEVICES ARE INDICATED TO BE DEMOLISHED AND THE REQUIRED REPAIR AND RESTORATION OF ALL WALLS, ROOFS, CEILINGS, FLOORS, ETC. SHALL BE INCLUDED IN THEIR BID.
- JJ. ALL ROOF PENETRATIONS SHALL BE IN COMPLIANCE WITH THE ROOFING MANUFACTURER'S GUIDELINES AND THE AMERICAN ROOFING COUNCIL. CONTRACTOR SHALL BE RESPONSIBLE FOR COMPLIANCE AS NECESSARY TO MAINTAIN ALL WARRANTIES.
- KK. STRUCTURAL MEMBERS SHALL NOT BE CUT OR COMPROMISED IN ANY WAY.
- LL. DO NOT BLOCK ACCESS TO HVAC OR ELECTRICAL EQUIPMENT. DO NOT INSTALL PIPING, DUCTWORK, OR EQUIPMENT OVER ELECTRICAL PANELS/SWITCHGEAR OR THE 30" x 42" (W x D) CLEARANCE IN FRONT OF THESE ELECTRICAL ITEMS. COORDINATE ADDITIONAL REQUIREMENTS WITH NEC.

GENERAL DEMOLITION NOTES:

- A. GENERAL MECHANICAL DEMOLITION NOTES APPLY TO ALL MECHANICAL SHEETS.
- B. SEE ARCHITECTURAL DRAWINGS FOR BUILDING FLOOR PLAN LAYOUT.
- C. THE EXISTING CONDITIONS REPRESENTED ON PLANS DEPECT APPROXIMATE LOCATIONS AND SIZES OF EQUIPMENT AND COMPONENTS. FIELD-VERIFY ACTUAL CONDITIONS AND DETERMINE ACTUAL LOCATIONS AND SIZES OF EQUIPMENT PRIOR TO COMMENCING WORK.
- D. SUBSTANTIAL DEVIATIONS BETWEEN THE CONTRACT DOCUMENTS DEMOLITION SCOPE AND ACTUAL CONDITIONS SHALL BE REPORTED TO THE ARCHITECT/ENGINEER IN THE FORM OF A REQUEST FOR INFORMATION WITH THE DESCRIPTIONS AND SKETCHES.
- E. SCHEDULING OF ALL DEMOLITION OPERATIONS SHALL BE COORDINATED WITH OWNER NO LATER THAN THE DATE OF THE PROJECT PRECONSTRUCTION MEETING.
- F. PROVIDE DEMOLITION WORK SHOWN ON THE DRAWINGS AND ALL INCIDENTAL DEMOLITION WORK REQUIRED TO COMPLETE NEW CONSTRUCTION WORK.
- G. PROTECT EXISTING EQUIPMENT, PIPING, DUCTWORK, AIR OPENINGS, ETC. FROM DIRT AND DAMAGE DURING DEMOLITION AND CONSTRUCTION.
- H. COMPLETELY REMOVE ALL COMPONENTS INDICATED ON PLANS FOR DEMOLITION INCLUDING REMOVAL OF ALL SUPPORTS, HANGERS, PIPING, WIRING, ECT. THAT ARE ASSOCIATED WITH THE COMPONENT BEING REMOVED, UNLESS OTHERWISE STATED.
- I. CONTRACTOR SHALL PATCH AND REPAIR ALL DAMAGE ASSOCIATED WITH DEMOLITION. ALL FINISHED SURFACES (FLOORS, WALLS, CEILINGS, ROOF, ETC.) SHALL MATCH EXISTING CONDITIONS.
- J. PROVIDE 1-HOUR FIRE RATED DUST PROOF BARRIERS (UL DESIGN U399) TO SEPARATE DEMOLITION AREA FROM THE REST OF THE FACILITY.
- K. WHERE DUST CREATED DURING DEMOLITION MAY ENTER AN HVAC SYSTEM RETURN AIR DUCT, PROVIDE TEMPORARY FILTERS AS REQUIRED TO PREVENT DUST INTRUSION.
- L. MAINTAIN OPERATION OF ALL EXISTING SERVICES AND UTILITIES SERVING AREAS THAT ARE OCCUPIED OR IN OPERATION DURING DEMOLITION WORK. COORDINATE AND SCHEDULE ALL DISRUPTIONS TO SERVICES OR UTILITIES WITH OWNER TWO WEEKS IN ADVANCE OF INTERRUPTION.
- M. REMOVE, RELOCATE AND REINSTALL ANY COMPONENTS WHEN REQUIRED TO ACCOMMODATE DEMOLITION OR NEW WORK SCOPE. COMMUNICATE TO ARCHITECT/ENGINEER THE EXTENT OF ITEMS TO BE REMOVED PRIOR TO BEGINNING THE WORK.
- N. STORE AND PROTECT ALL EXISTING ITEMS WHICH ARE TO BE RELOCATED OR REUSED.
- O. WHERE DEMOLITION/RE-WORK OF EXISTING MEP ITEMS CONTAINING HAZARDOUS MATERIALS OCCUR, THE CONTRACTOR SHALL NOTIFY THE ARCHITECT/ENGINEER FOR ABATEMENT AND REMEDIATION AS REQUIRED.



SHROUT
TATE
WILSON
MECHANICAL AND
ELECTRICAL ENGINEERS
PROGRESS
REGISTERED
Lanington - Louisville - Charleston
www.shrw.com

ALLEN COUNTY - SCOTTSVILLE
HIGH SCHOOL ATHLETIC
COMPLEX
SCOTTSVILLE, KENTUCKY

MECHANICAL LEGEND & GENERAL
NOTES

JOB NO.	2489
DATE	NOV 17, 2025
DRAWN	BRN
CHECKED	NCM


COPYRIGHT © 2025
SHERMAN CARTER BARNHART
ARCHITECTS, PLLC

REVISIONS


No.	Description	Date

SHEET

 M001




SCALE: 1/8" = 1'-0"

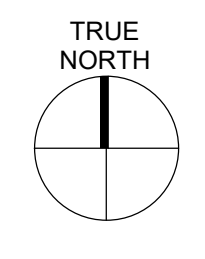

2459 ALLEN COUNTY - SCOTTSVILLE HIGH SCHOOL ATHLETIC COMPLEX
Autodesk Docs: 2459 Allen County Athletic Fields and Facilities/25008-Allen Co. V08 MEP.rvt
11/14/2025 3:04:24 PM

1 ROOF PLAN - AUXILIARY GYMNASIUM ADDITION - HVAC
SCALE: 1/8" = 1'-0"

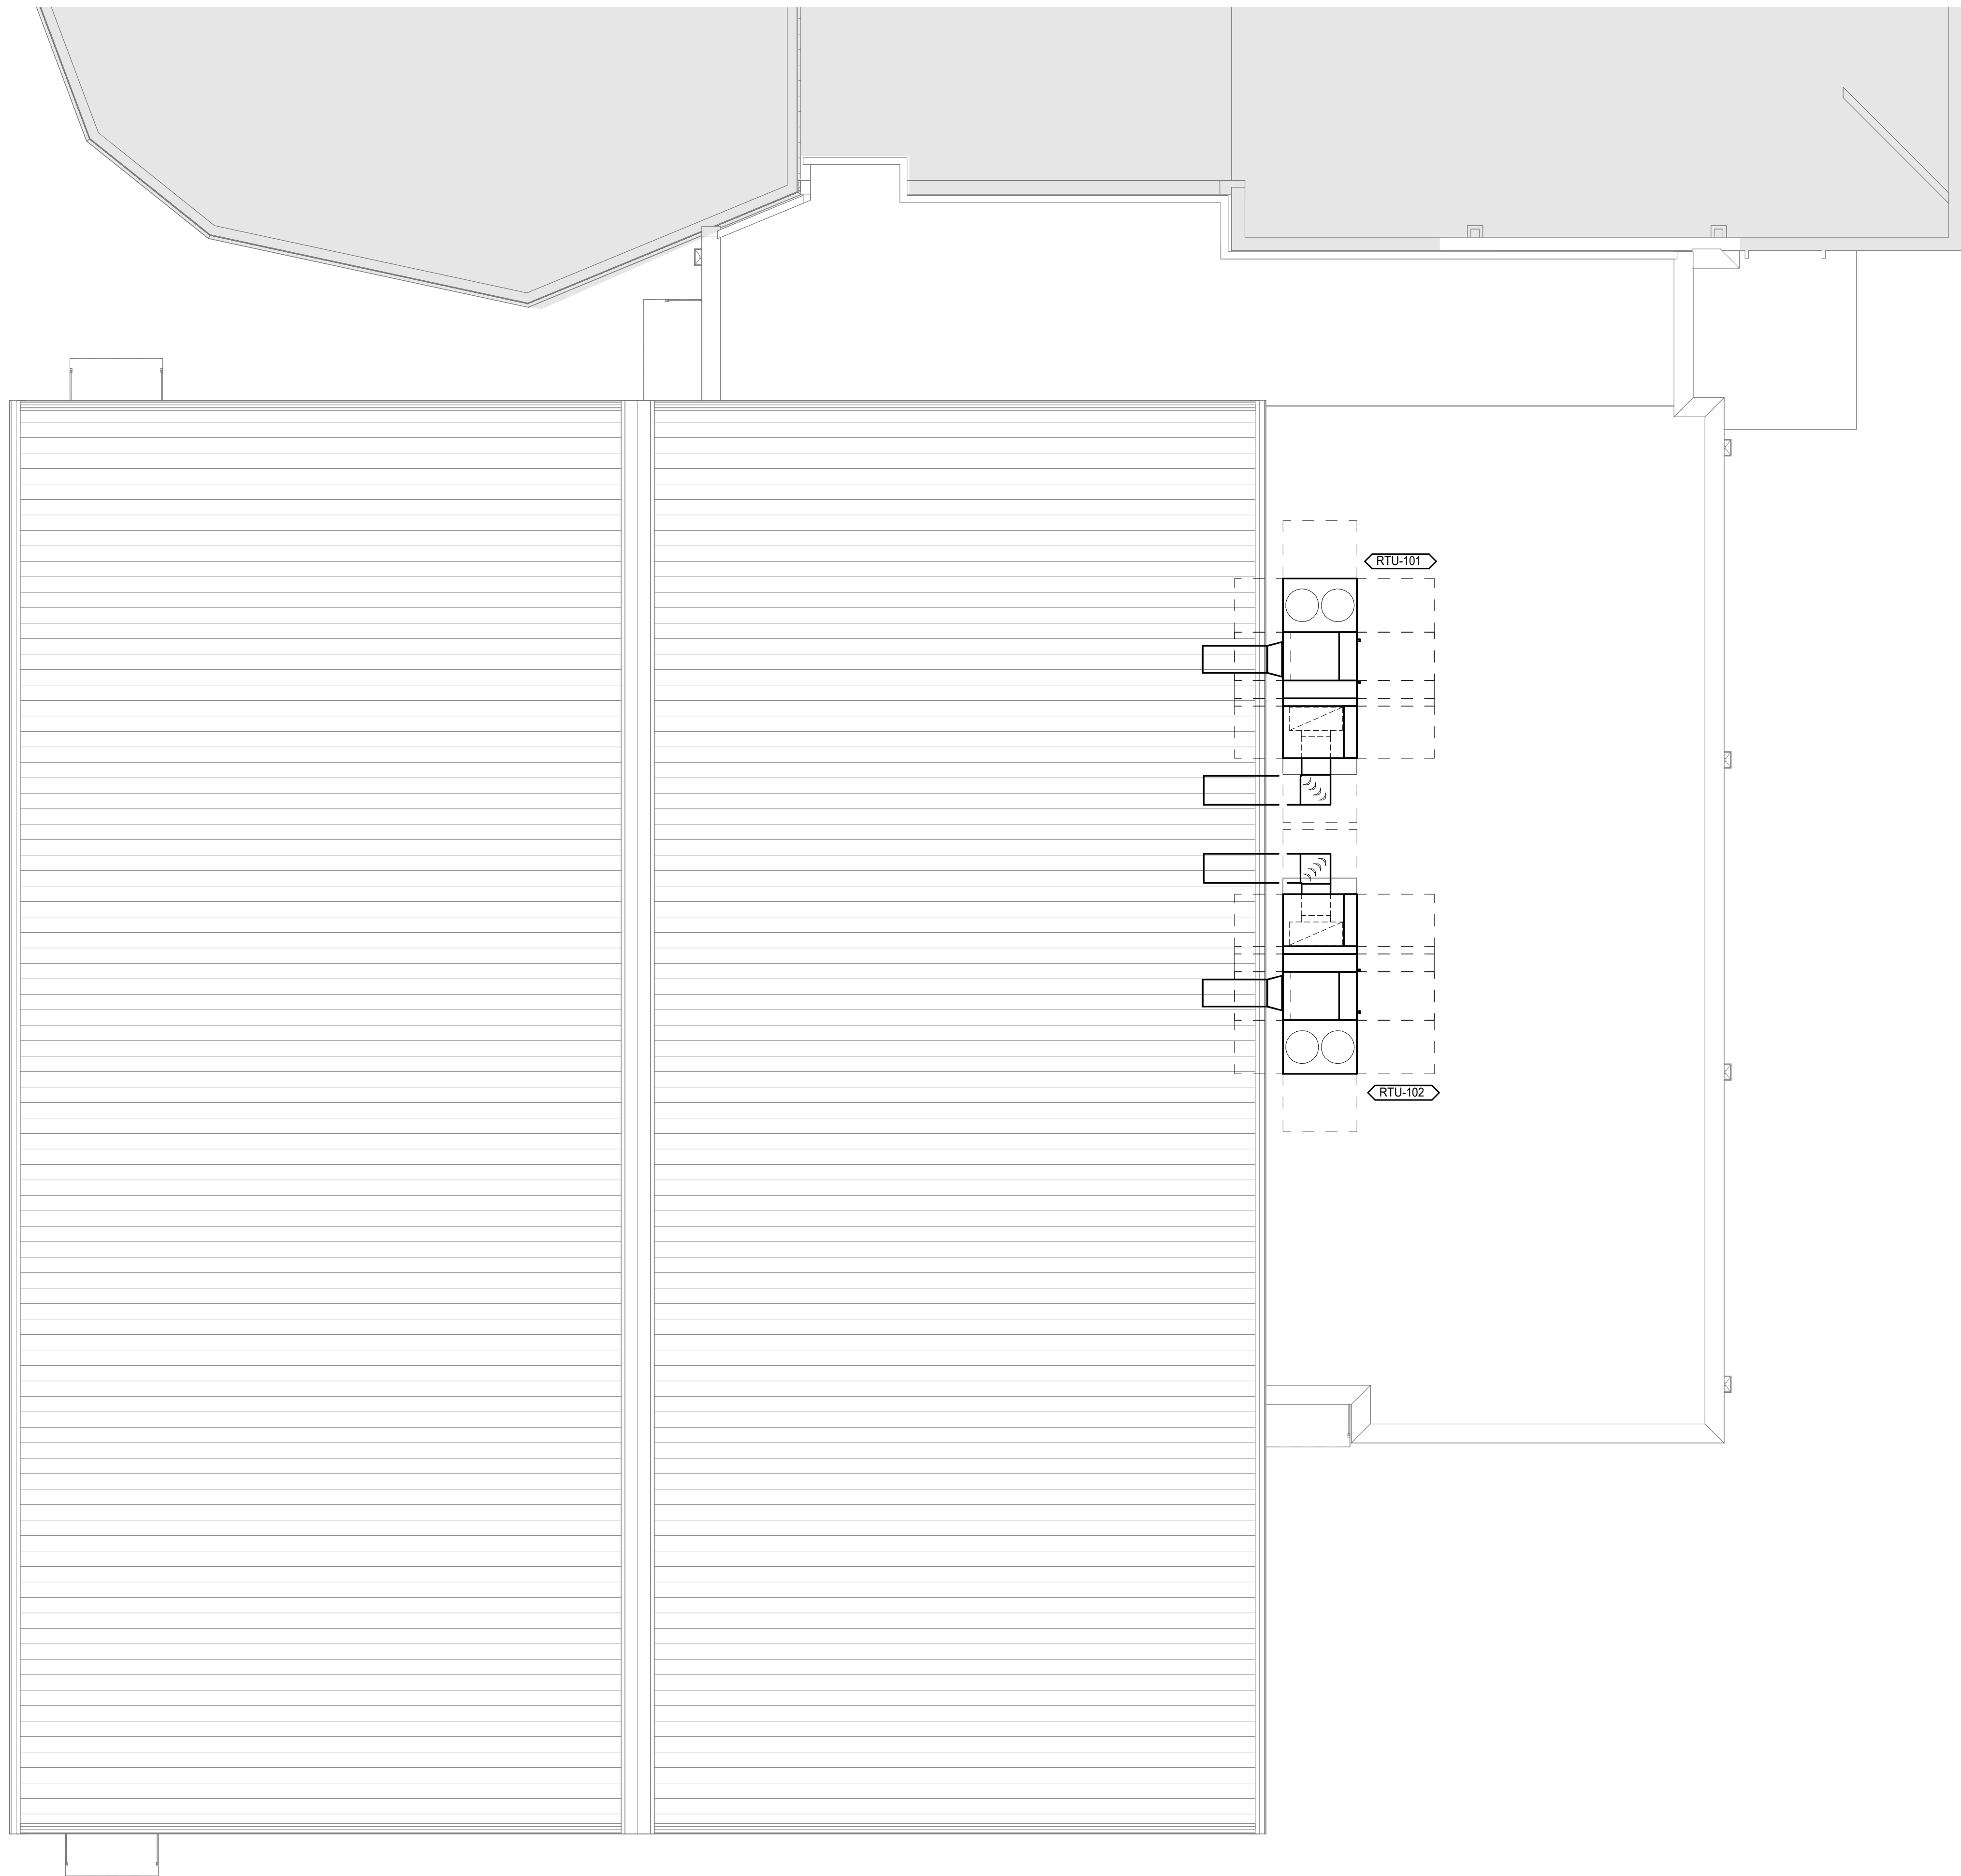


GENERAL NOTES

A. REFER TO SHEET M001 FOR MECHANICAL LEGEND AND GENERAL NOTES.

SHEET KEYNOTES

1. SHEET NOTES

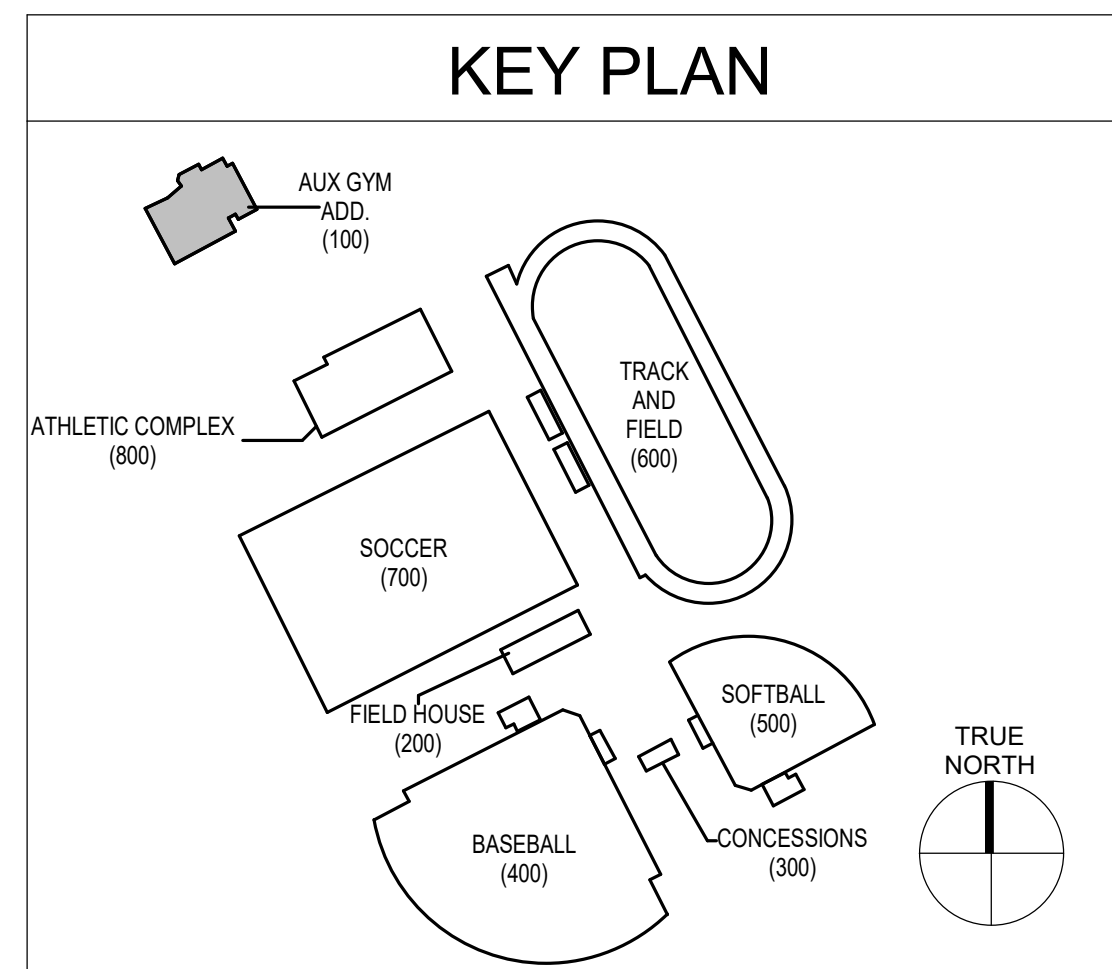

JOB NO.	2459
DATE	NOV 17, 2025
DRAWN	BRN
CHECKED	NCM

COPYRIGHT © 2025
SHERMAN CARTER BARNHART
ARCHITECTS, PLLC


REVISIONS		
No.	Description	Date

GENERAL NOTES


A. REFER TO SHEET M001 FOR MECHANICAL LEGEND AND GENERAL NOTES.

SHEET KEYNOTES


1. SHEET NOTES

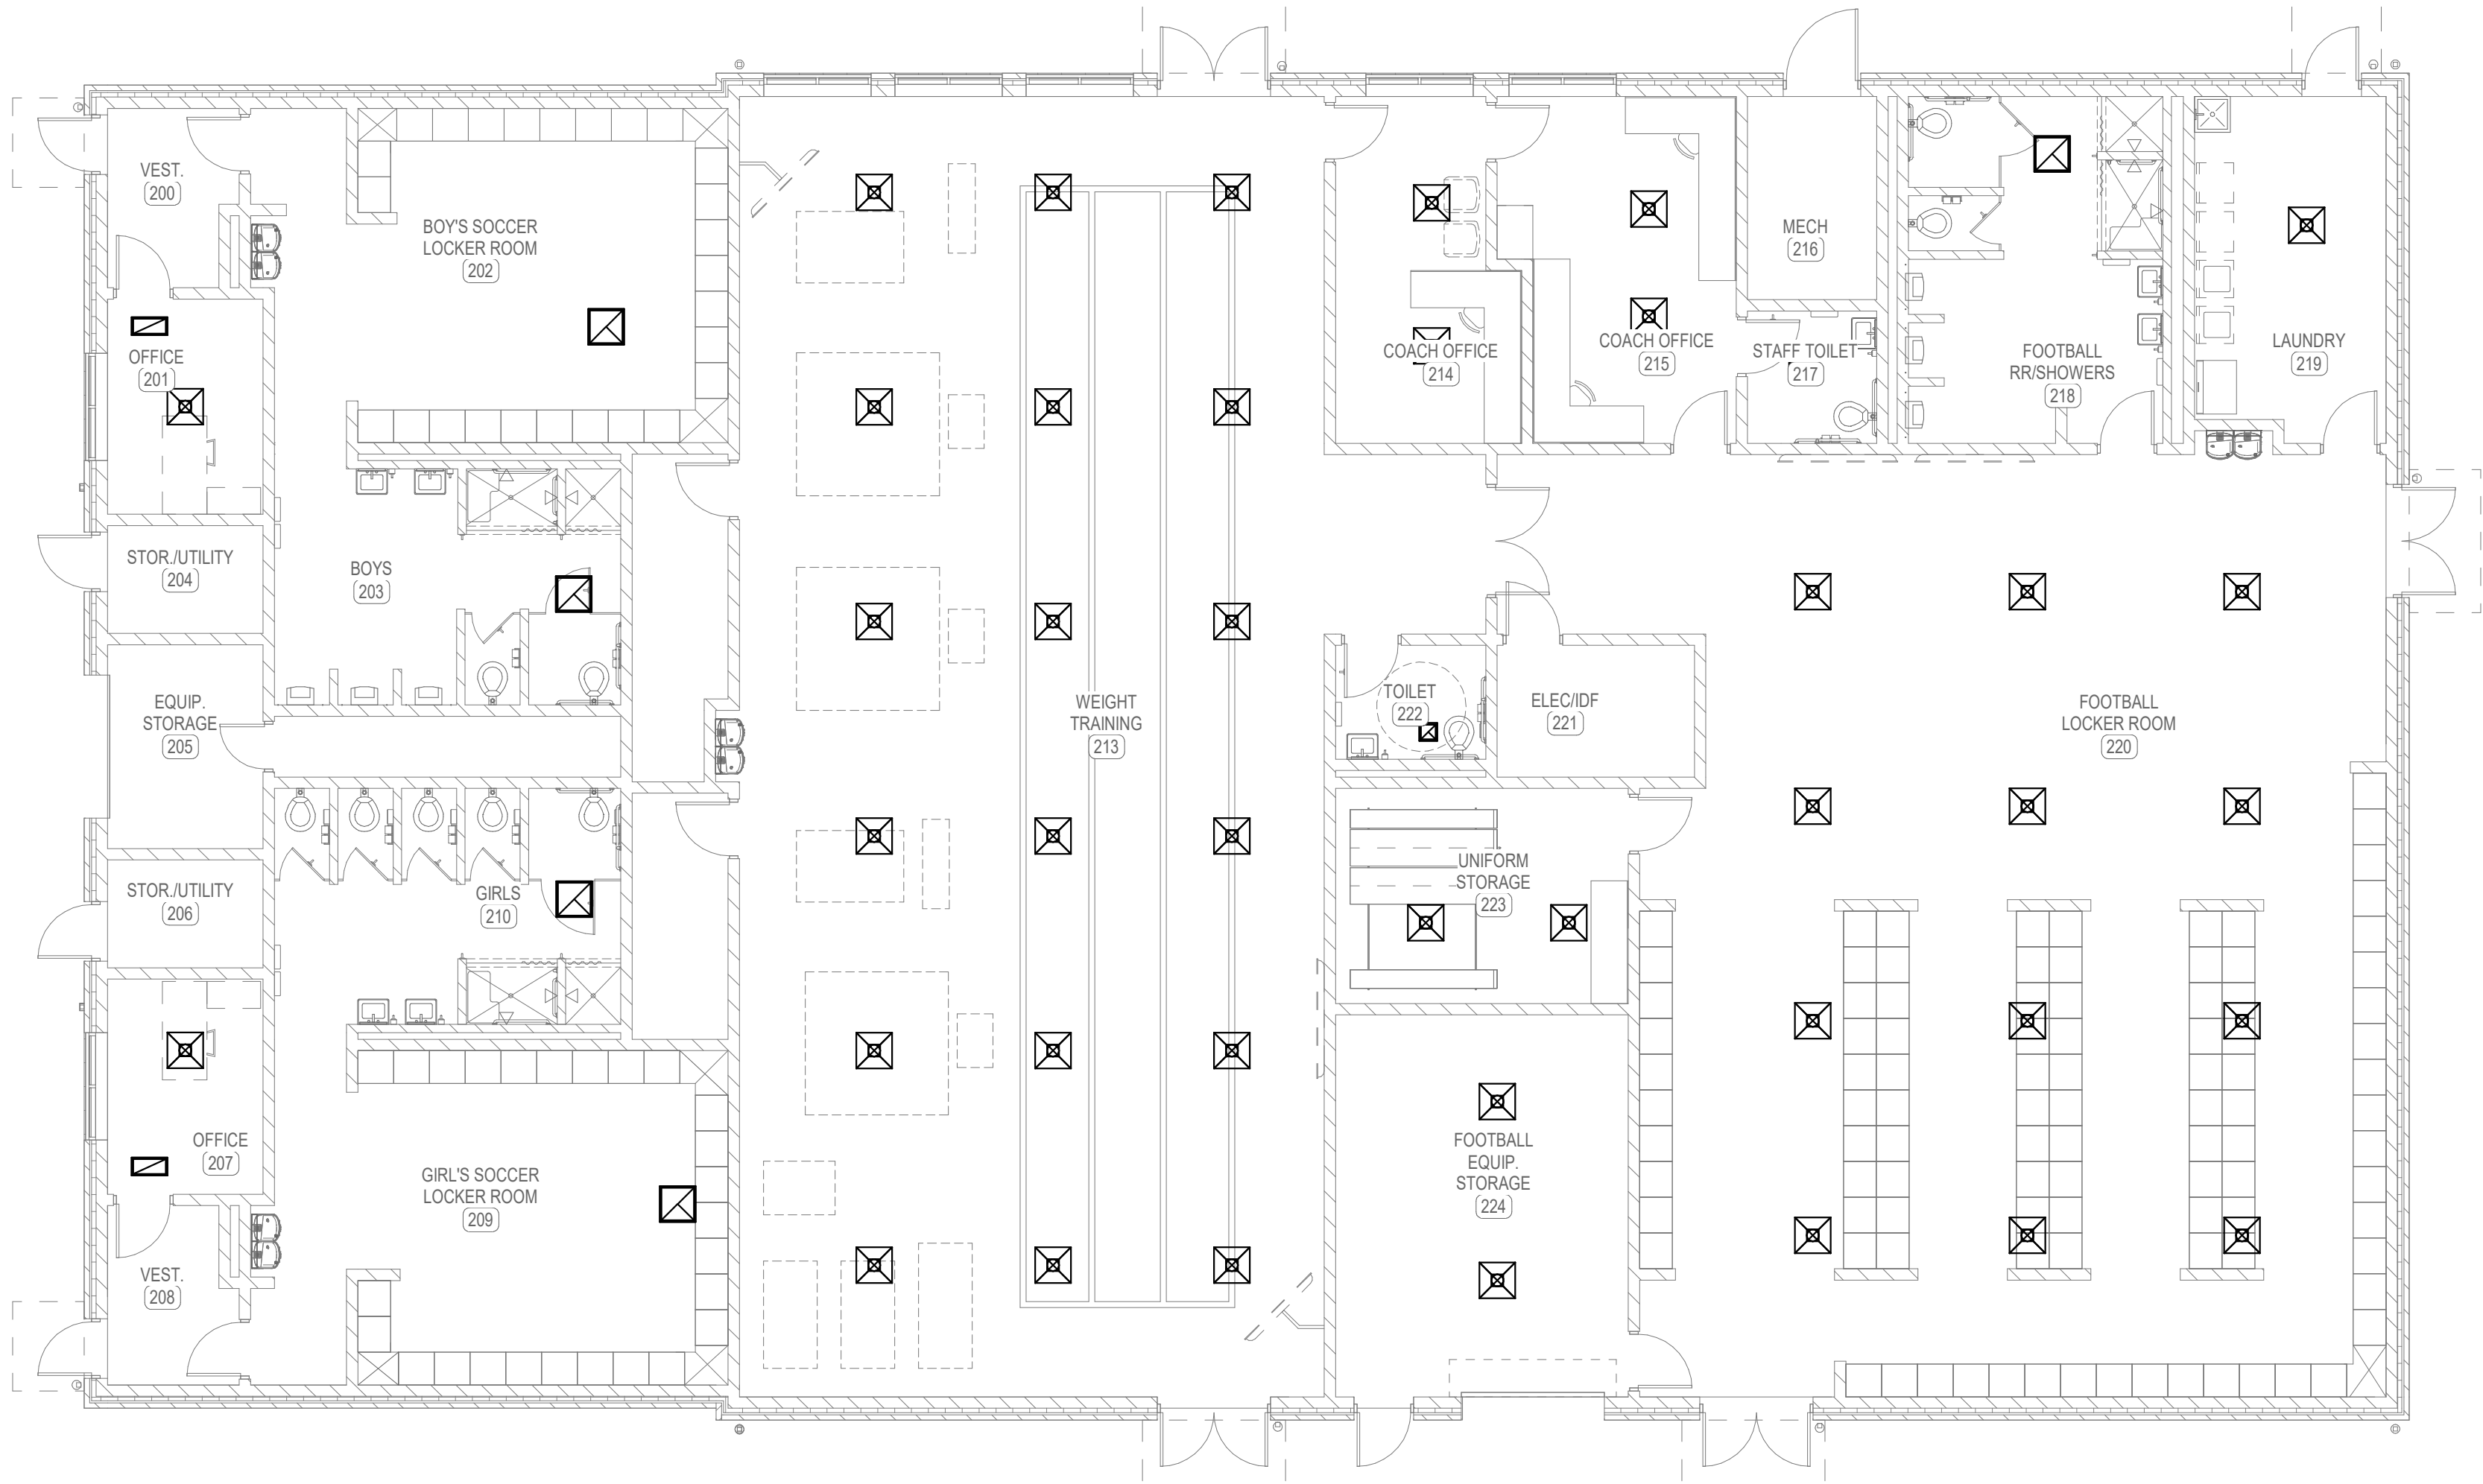

 
1 FIRST FLOOR PLAN - FIELD HOUSE - HVAC
SCALE: 1/8" = 1'-0"




KEY PLAN

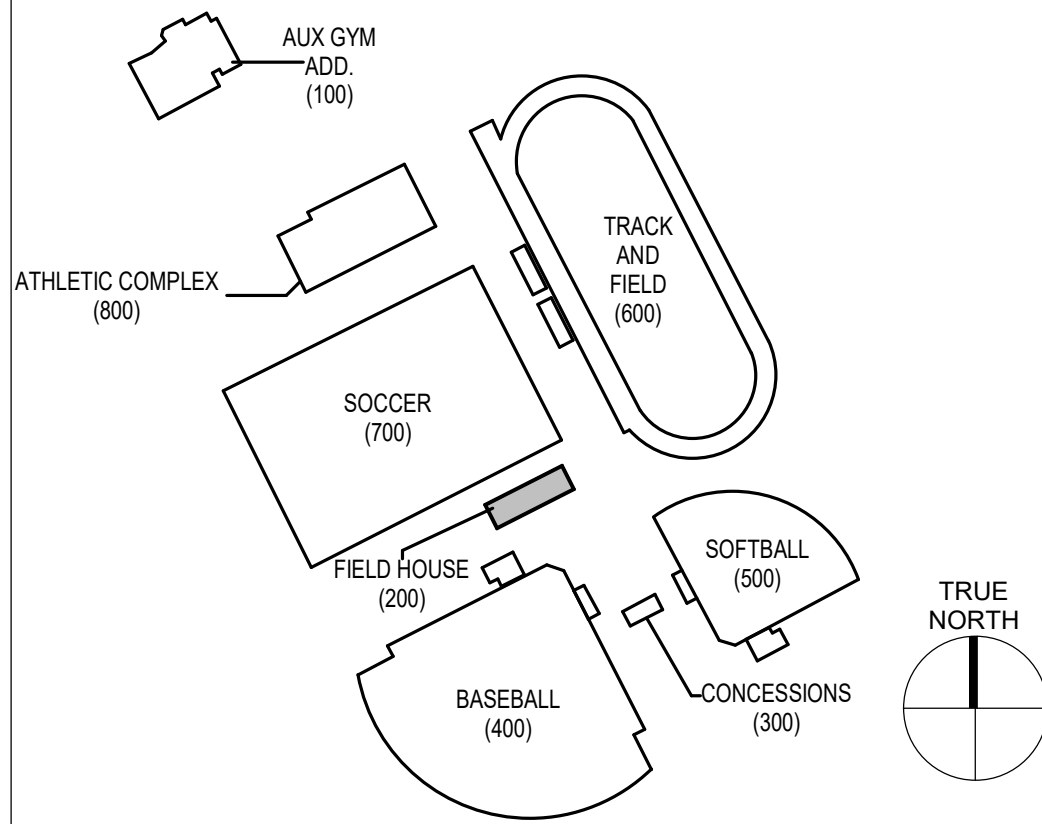

2459 ALLEN COUNTY - SCOTTSVILLE HIGH SCHOOL ATHLETIC COMPLEX
Autodesk Docs: 2459 Allen County Athletic Fields and Facilities/25008-Allen Co. v28 MEP.rvt
11/14/2025 3:04:26 PM

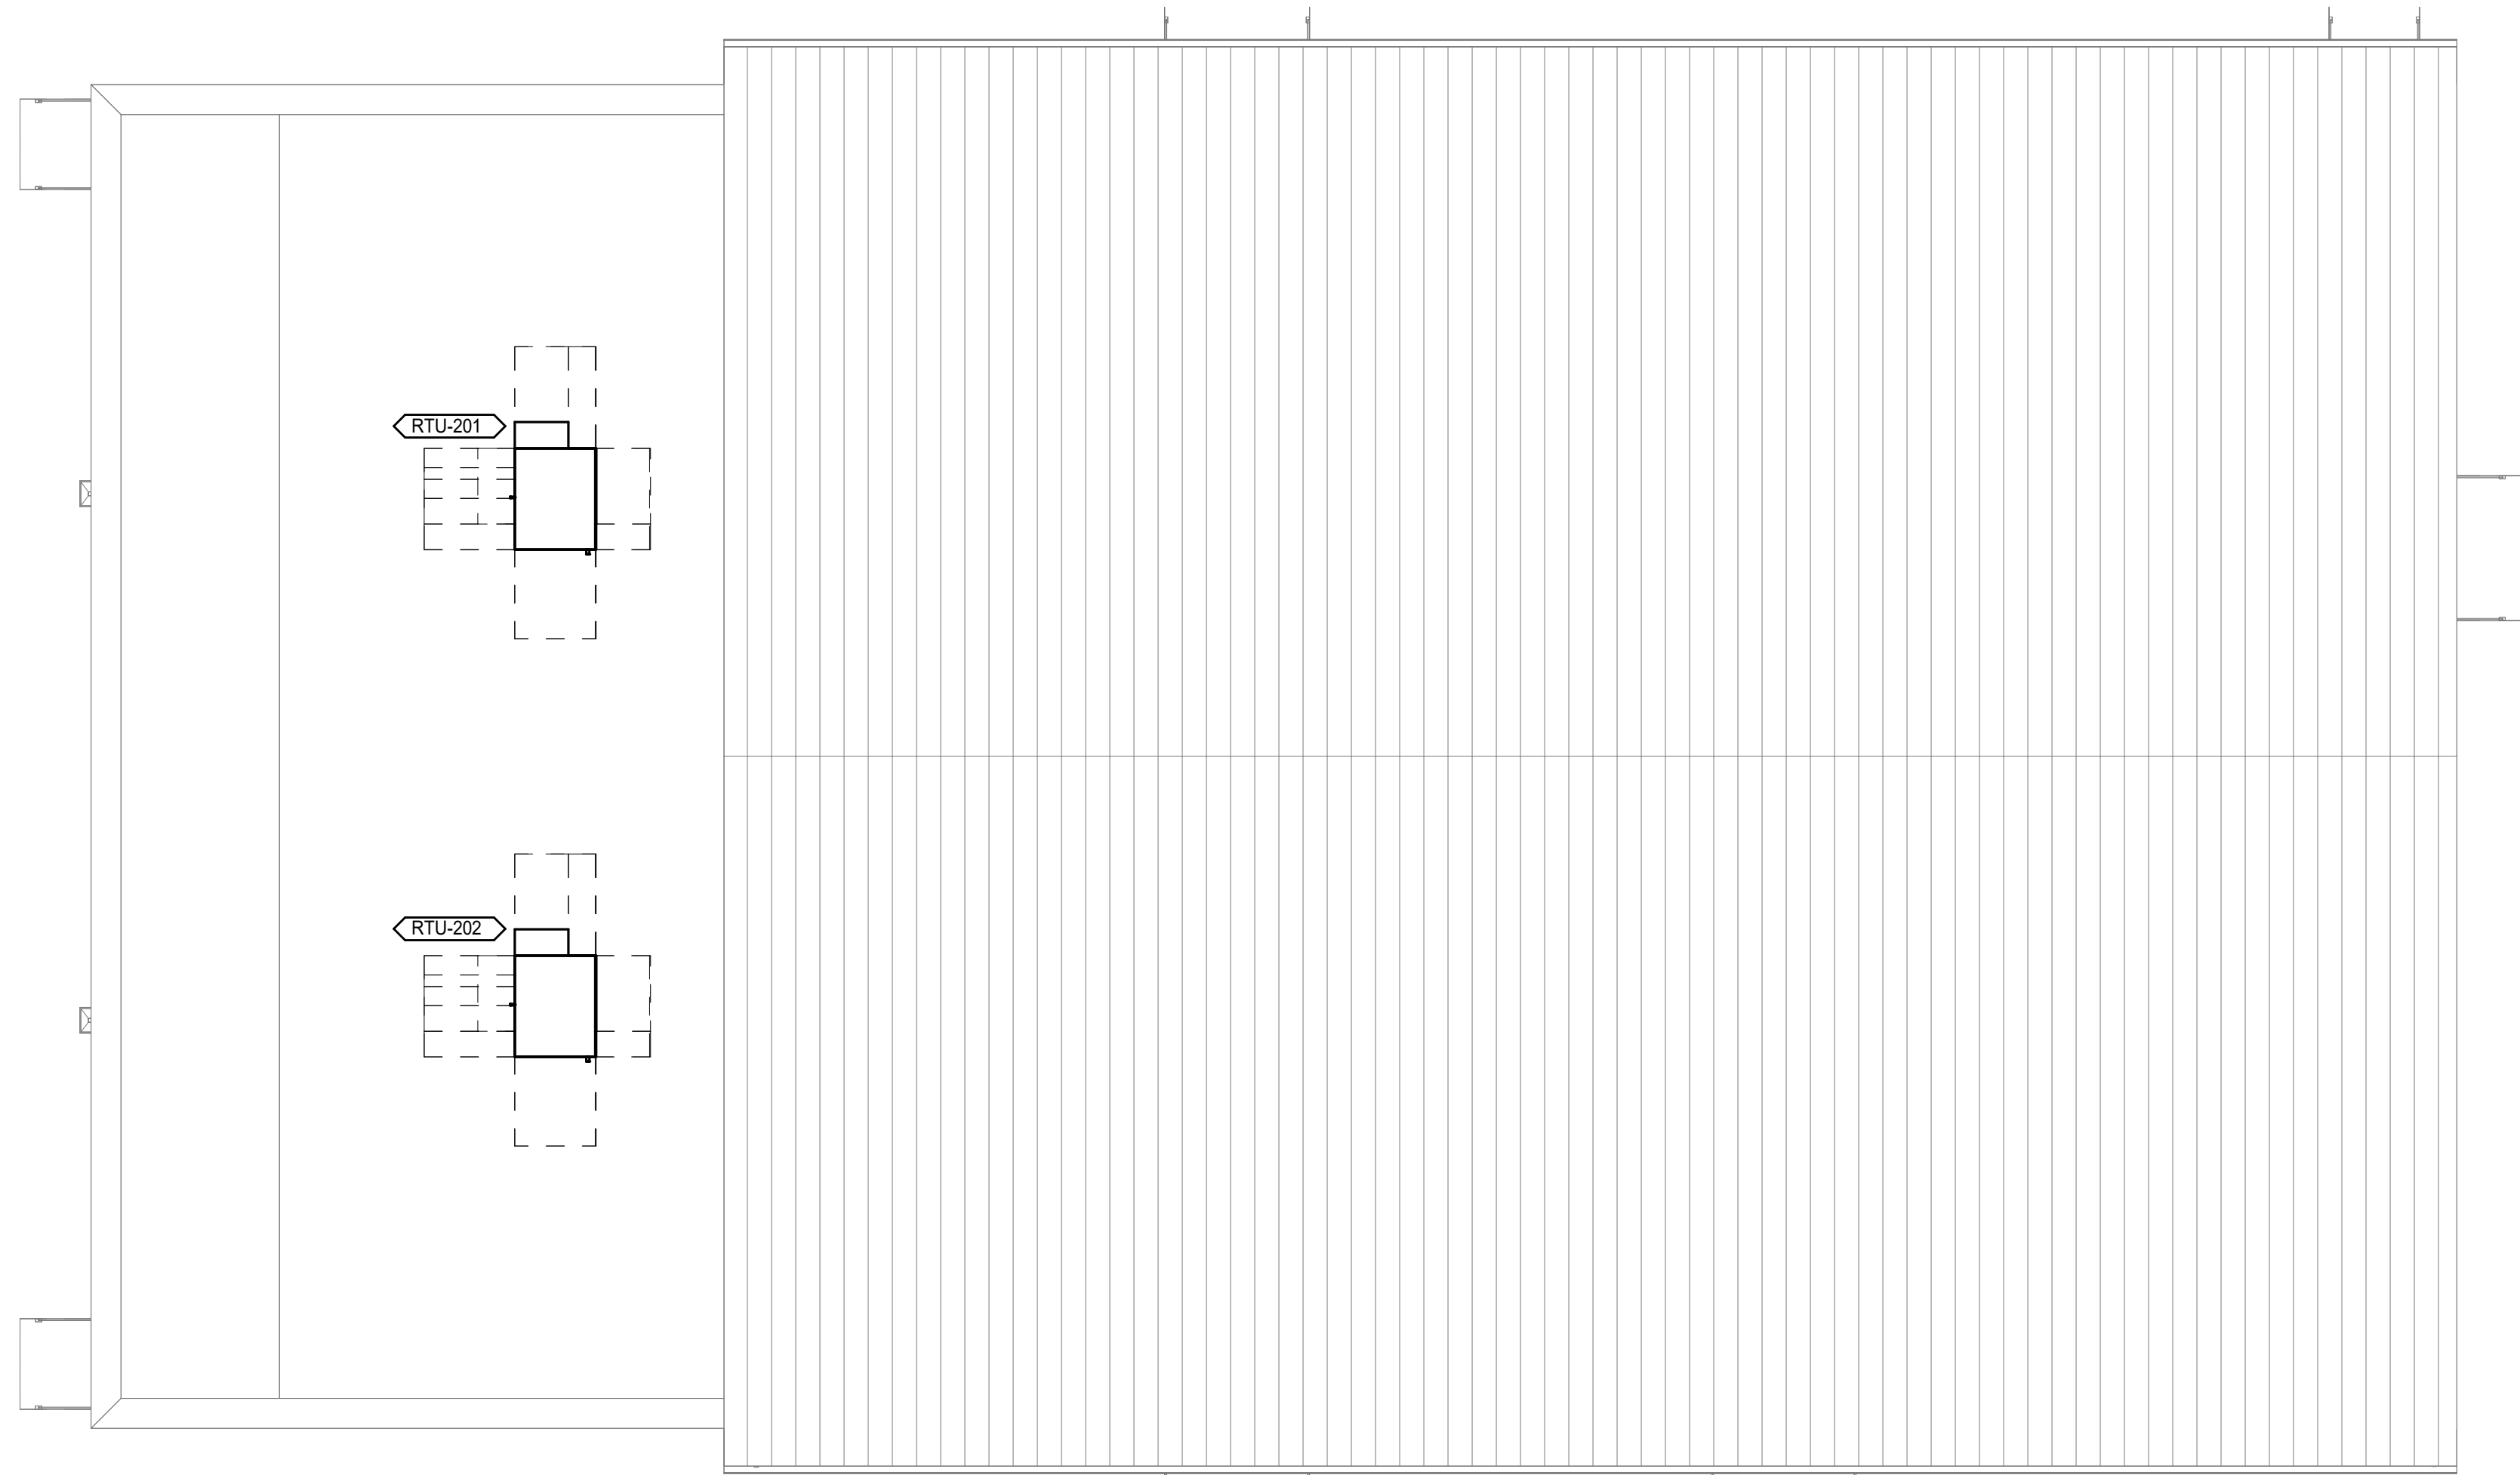

 1 ROOF PLAN - FIELD HOUSE - HVAC
SCALE: 1/8" = 1'-0"





GENERAL NOTES

A. REFER TO SHEET M001 FOR MECHANICAL LEGEND AND GENERAL NOTES.

SHEET KEYNOTES

1. SHEET NOTES

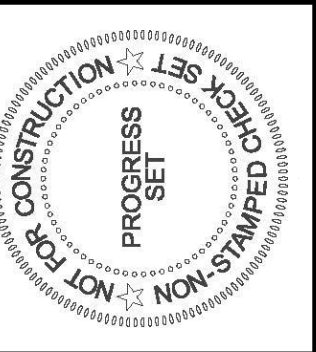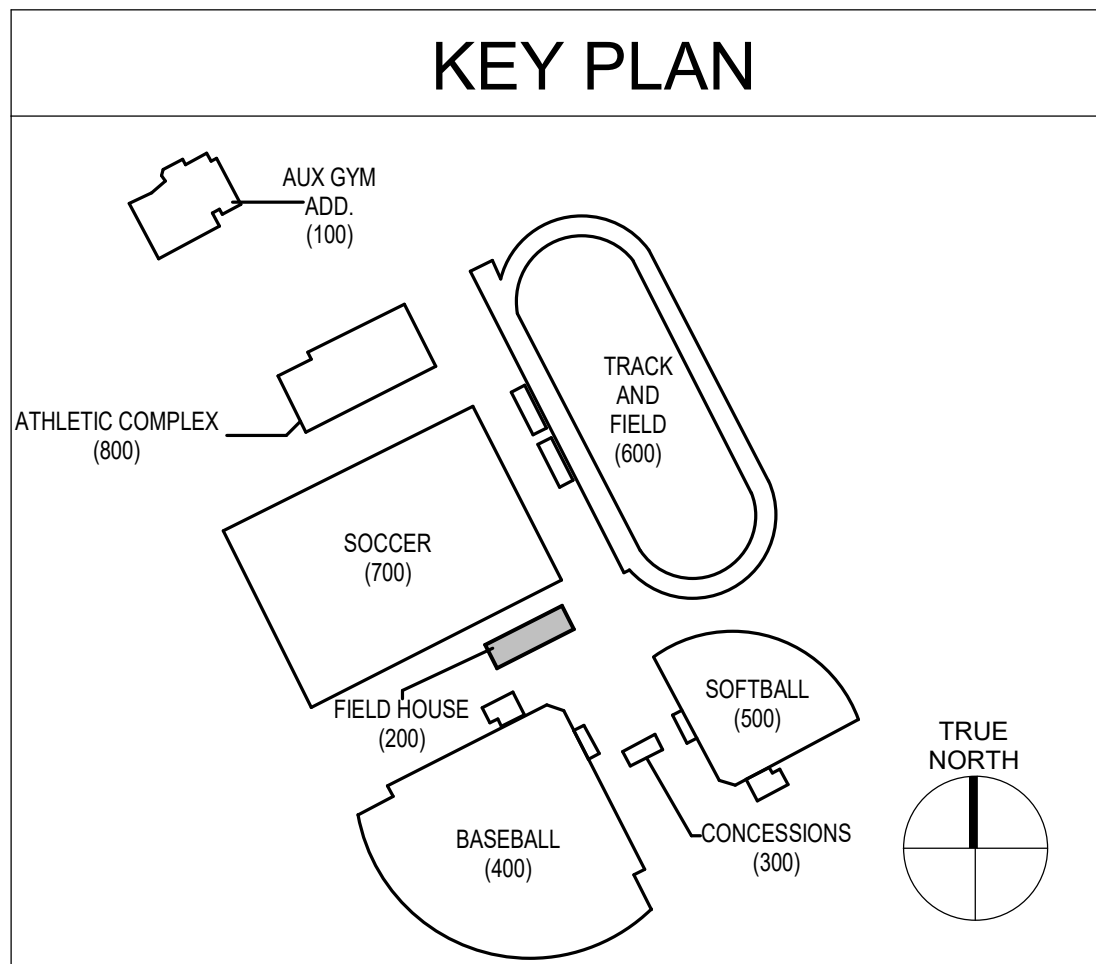

JOB NO.	2459
DATE	NOV 17, 2025
DRAWN	BRN
CHECKED	NCM

COPYRIGHT © 2025
SHERMAN CARTER BARNHART
ARCHITECTS, PLLC


REVISIONS		
No.	Description	Date

GENERAL NOTES

A. REFER TO SHEET P001 AND M001 FOR PLUMBING AND MECHANICAL LEGENDS AND GENERAL NOTES.


SHEET KEYNOTES

1. REFER TO PLUMBING SITE UTILITIES PLAN FOR CONTINUATION.

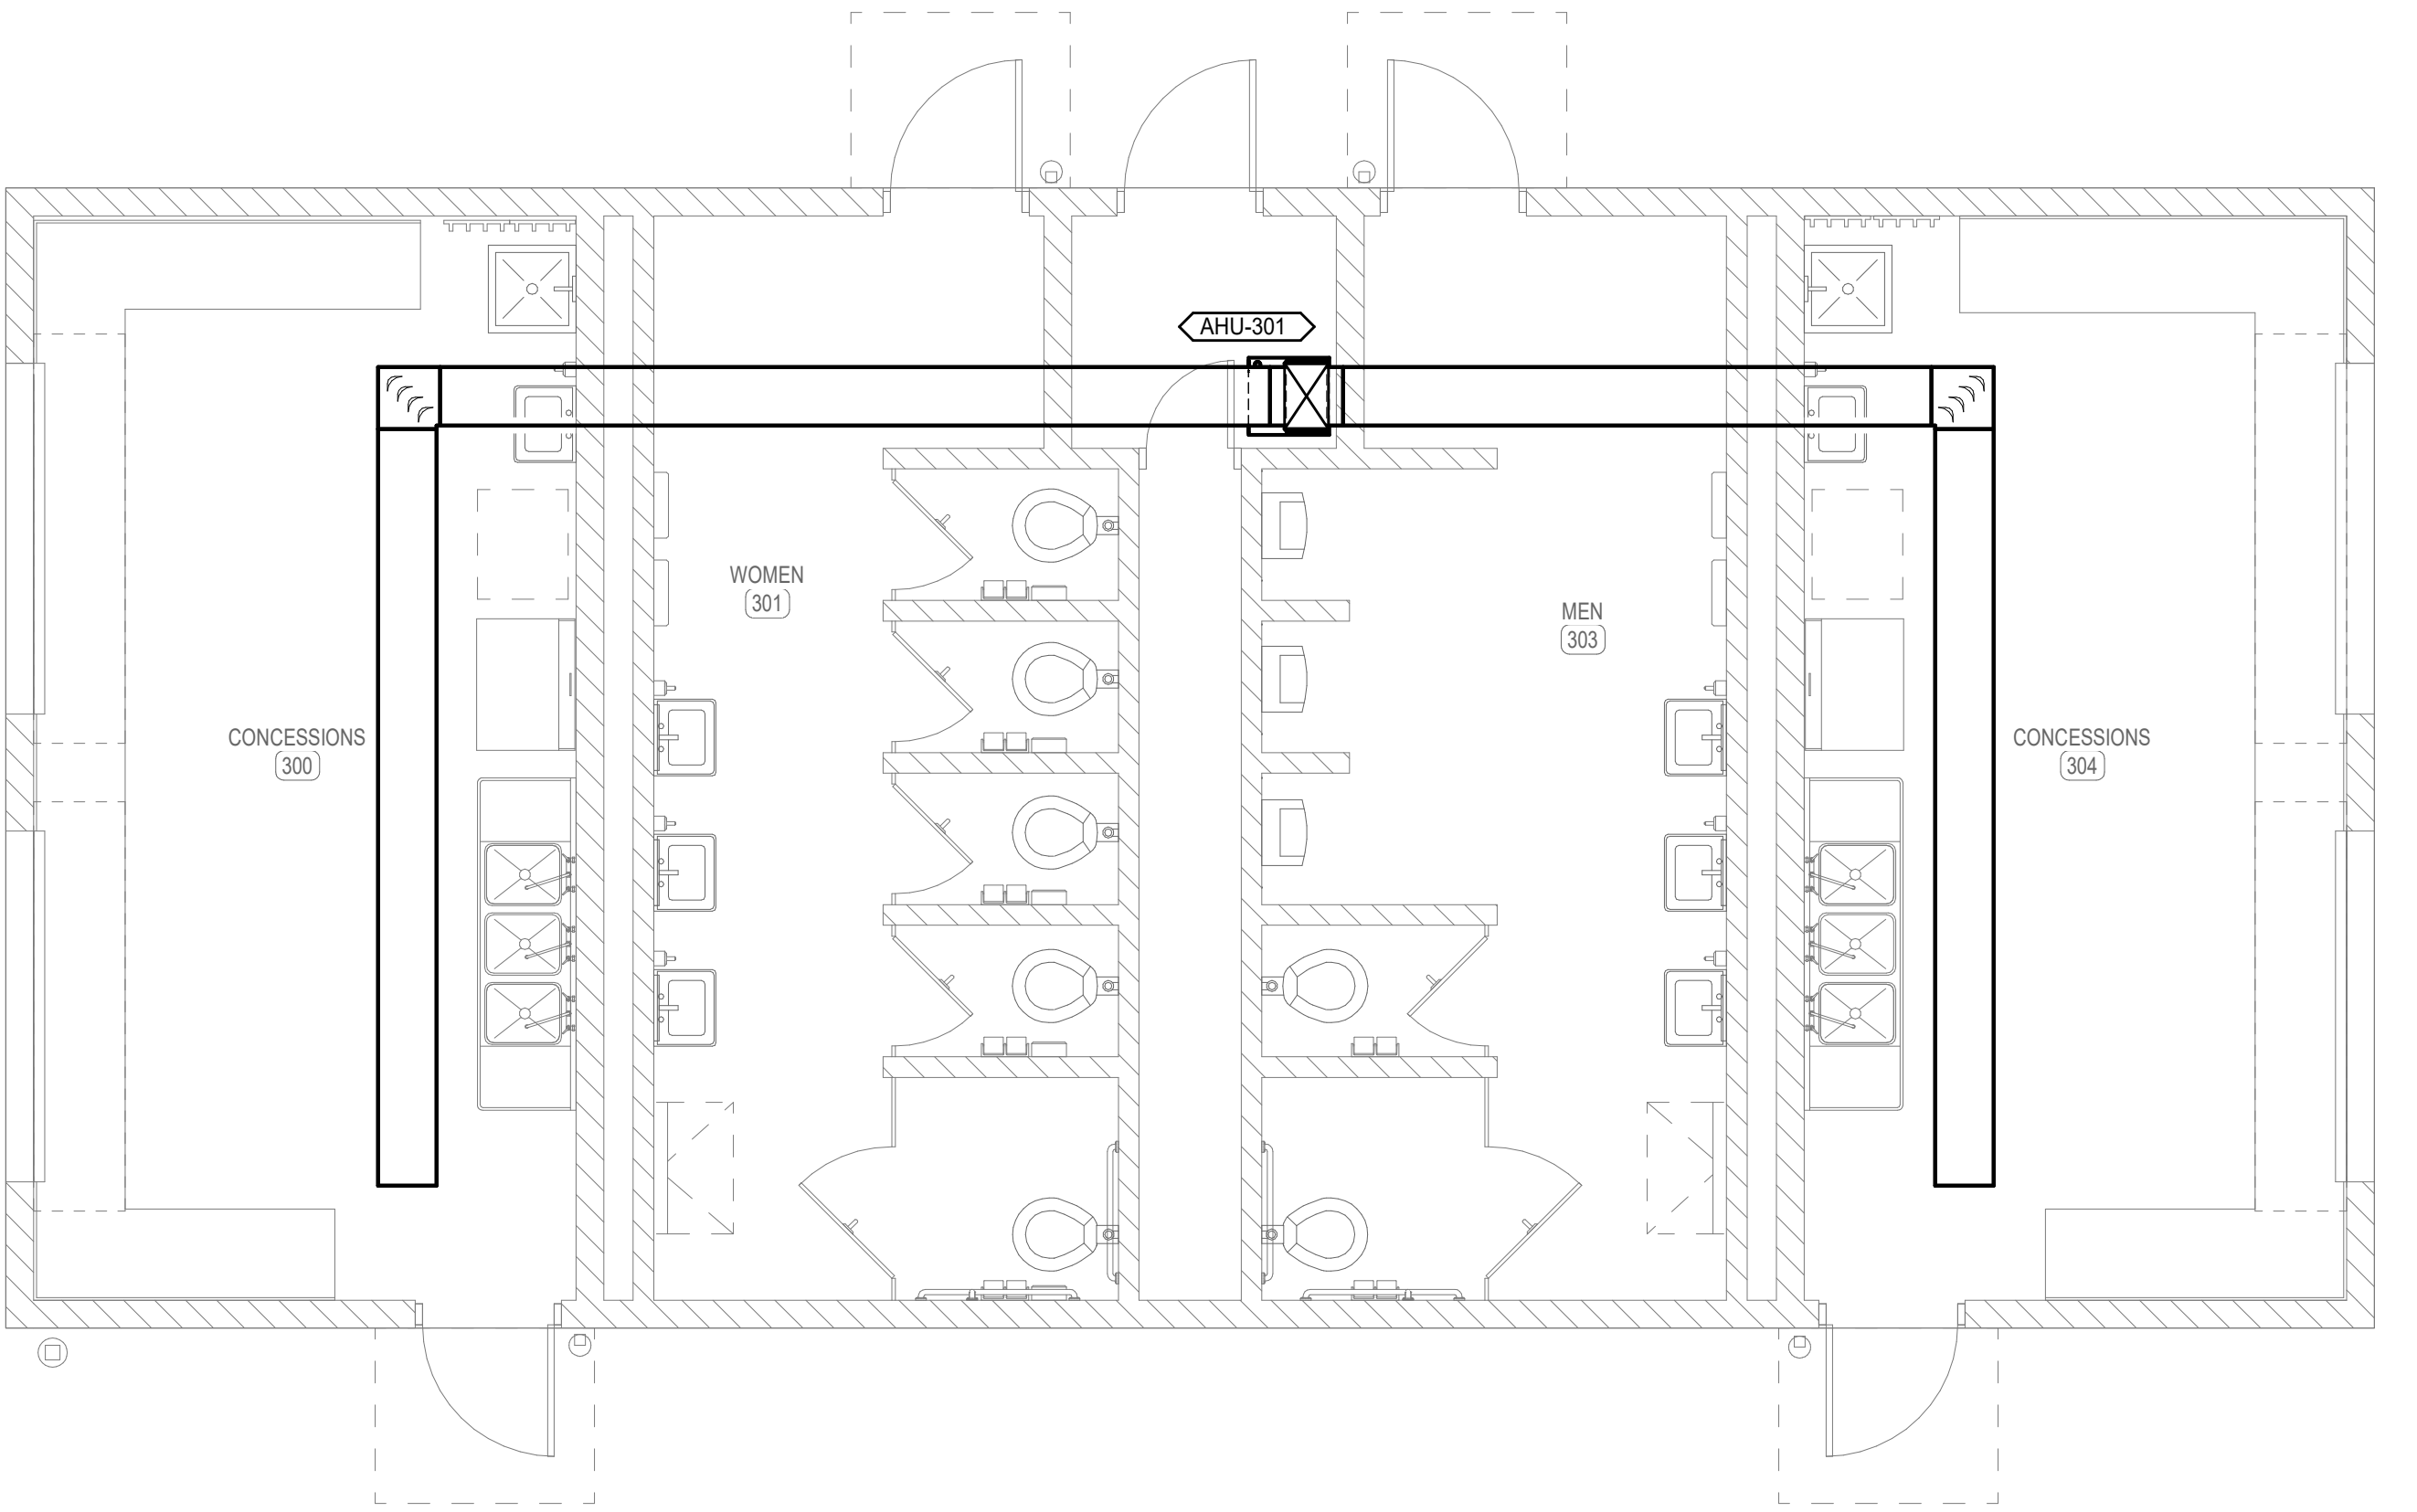


3 FIRST FLOOR PLAN - CONCESSIONS AND RESTROOM - HVAC

SCALE: 1/4" = 1'-0"

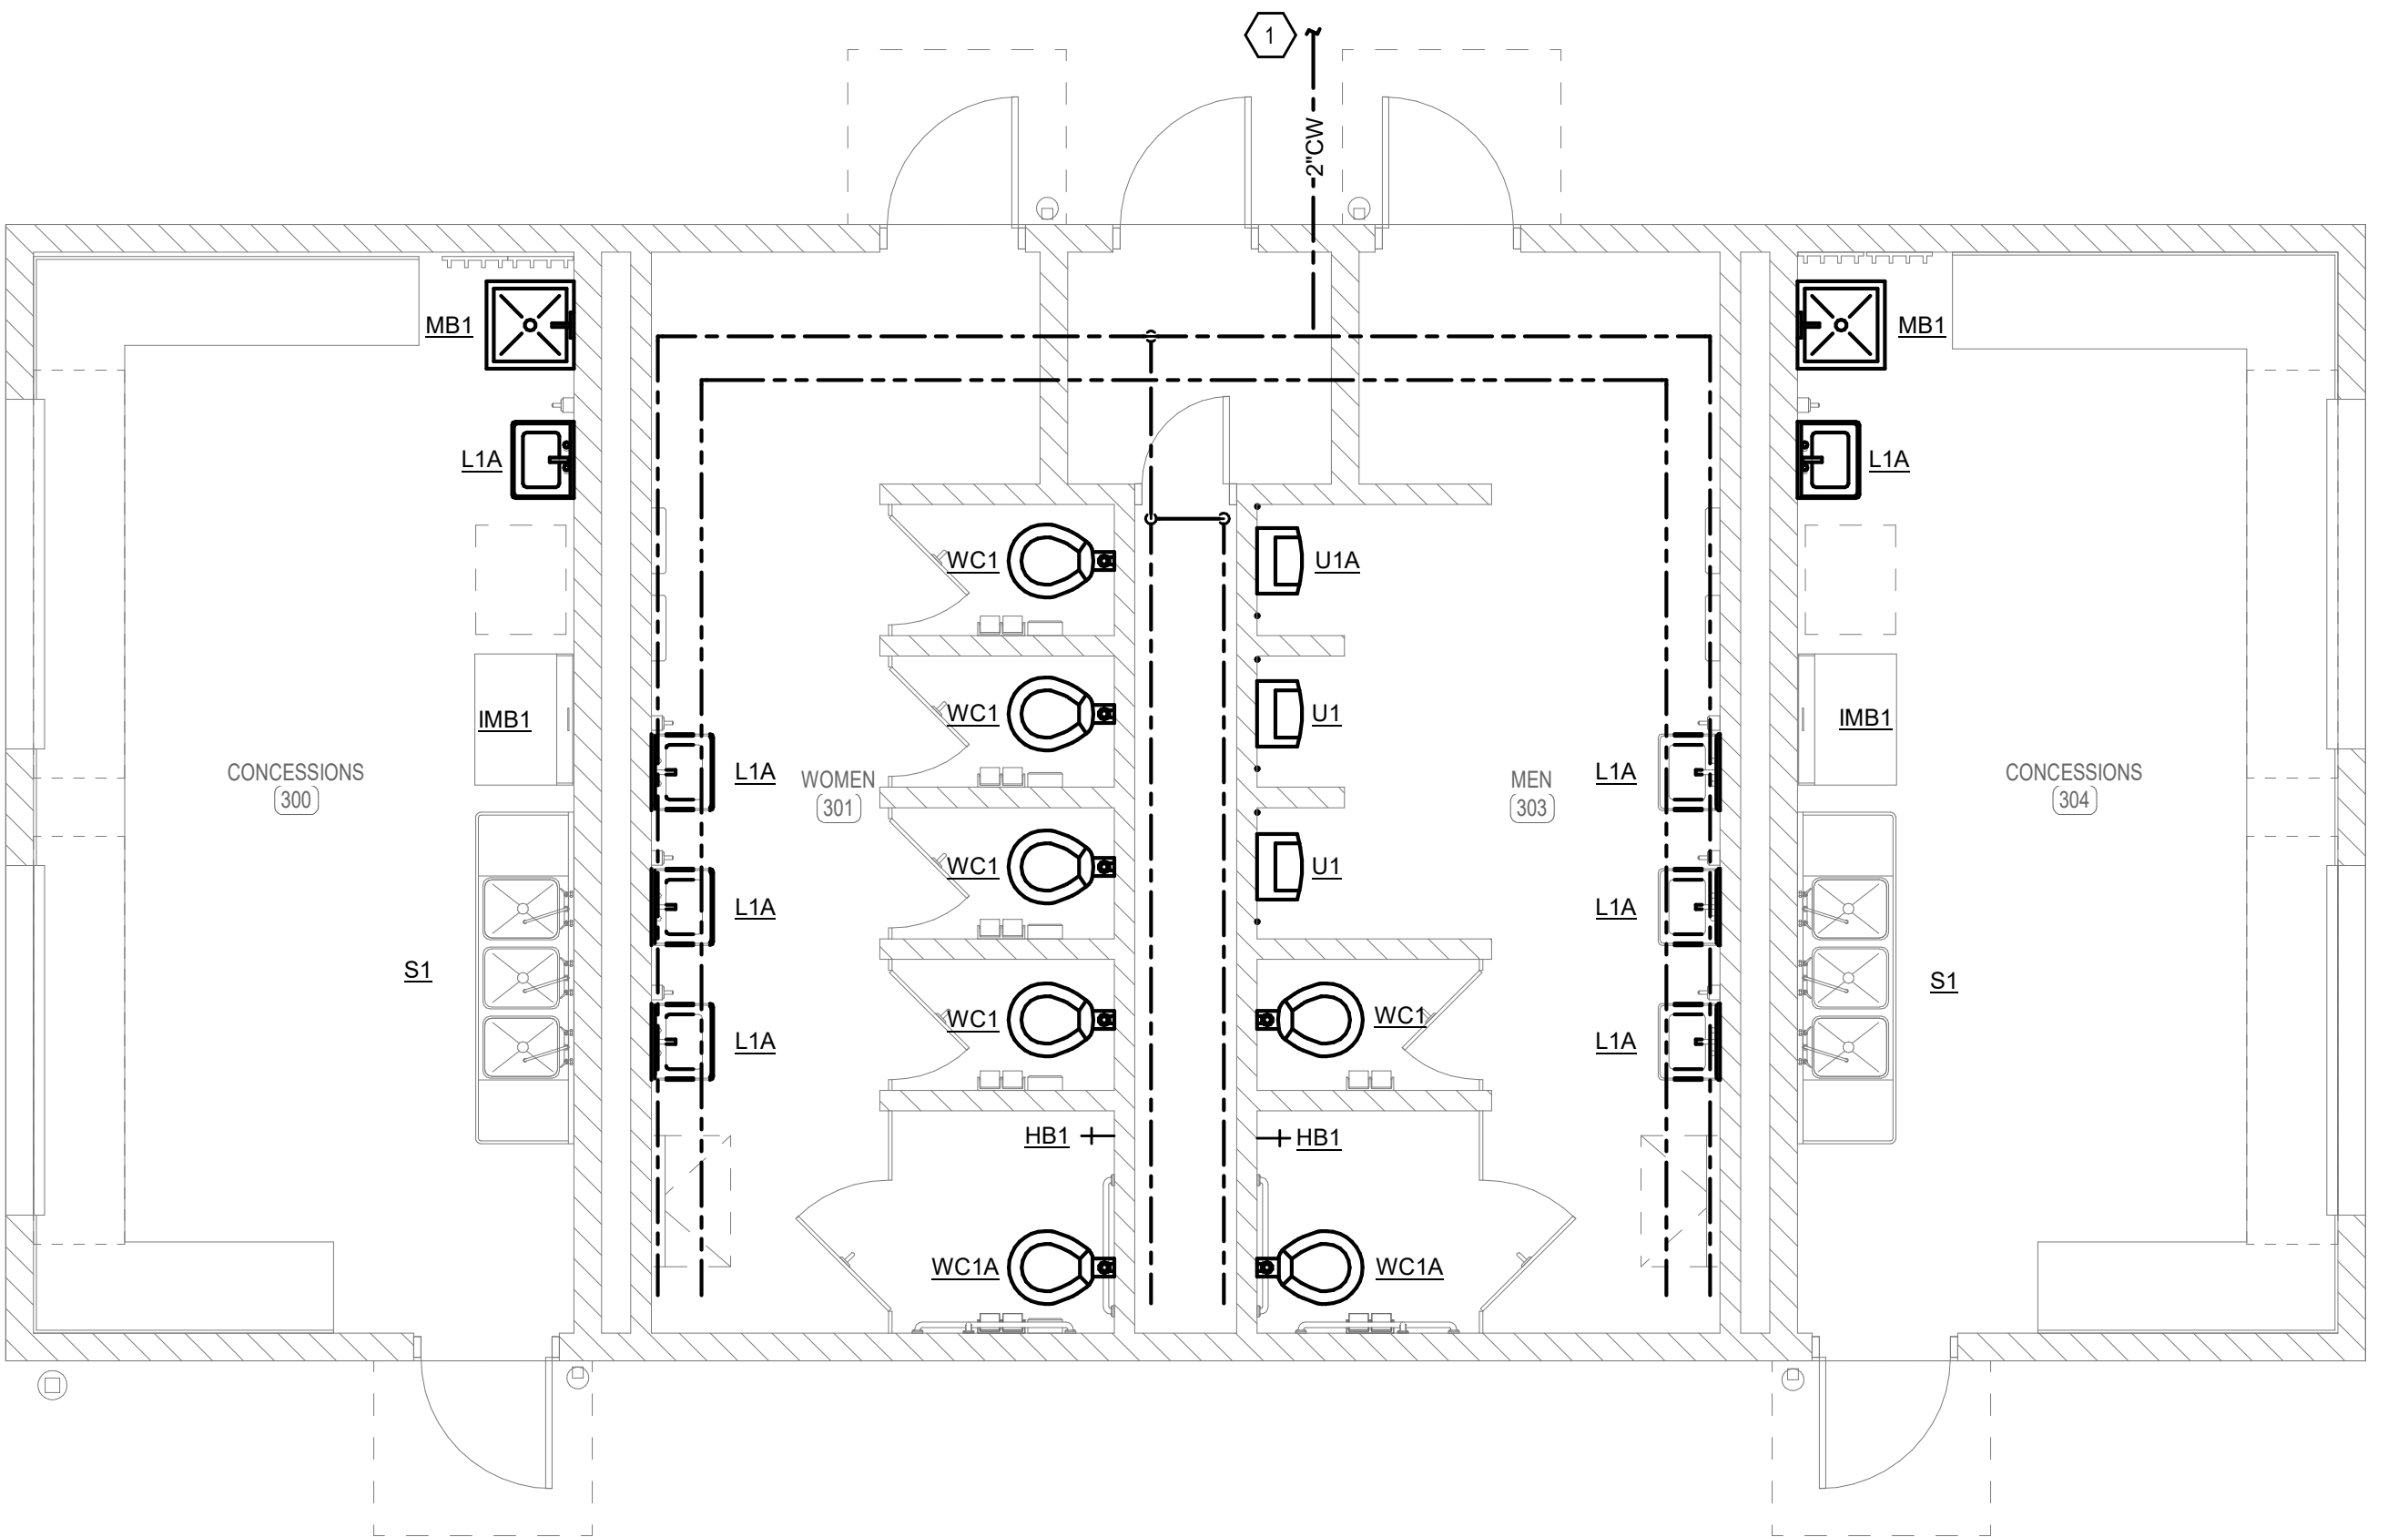


2 FIRST FLOOR PLAN - CONCESSIONS AND RESTROOM - DOMESTIC WATER

SCALE: 1/4" = 1'-0"

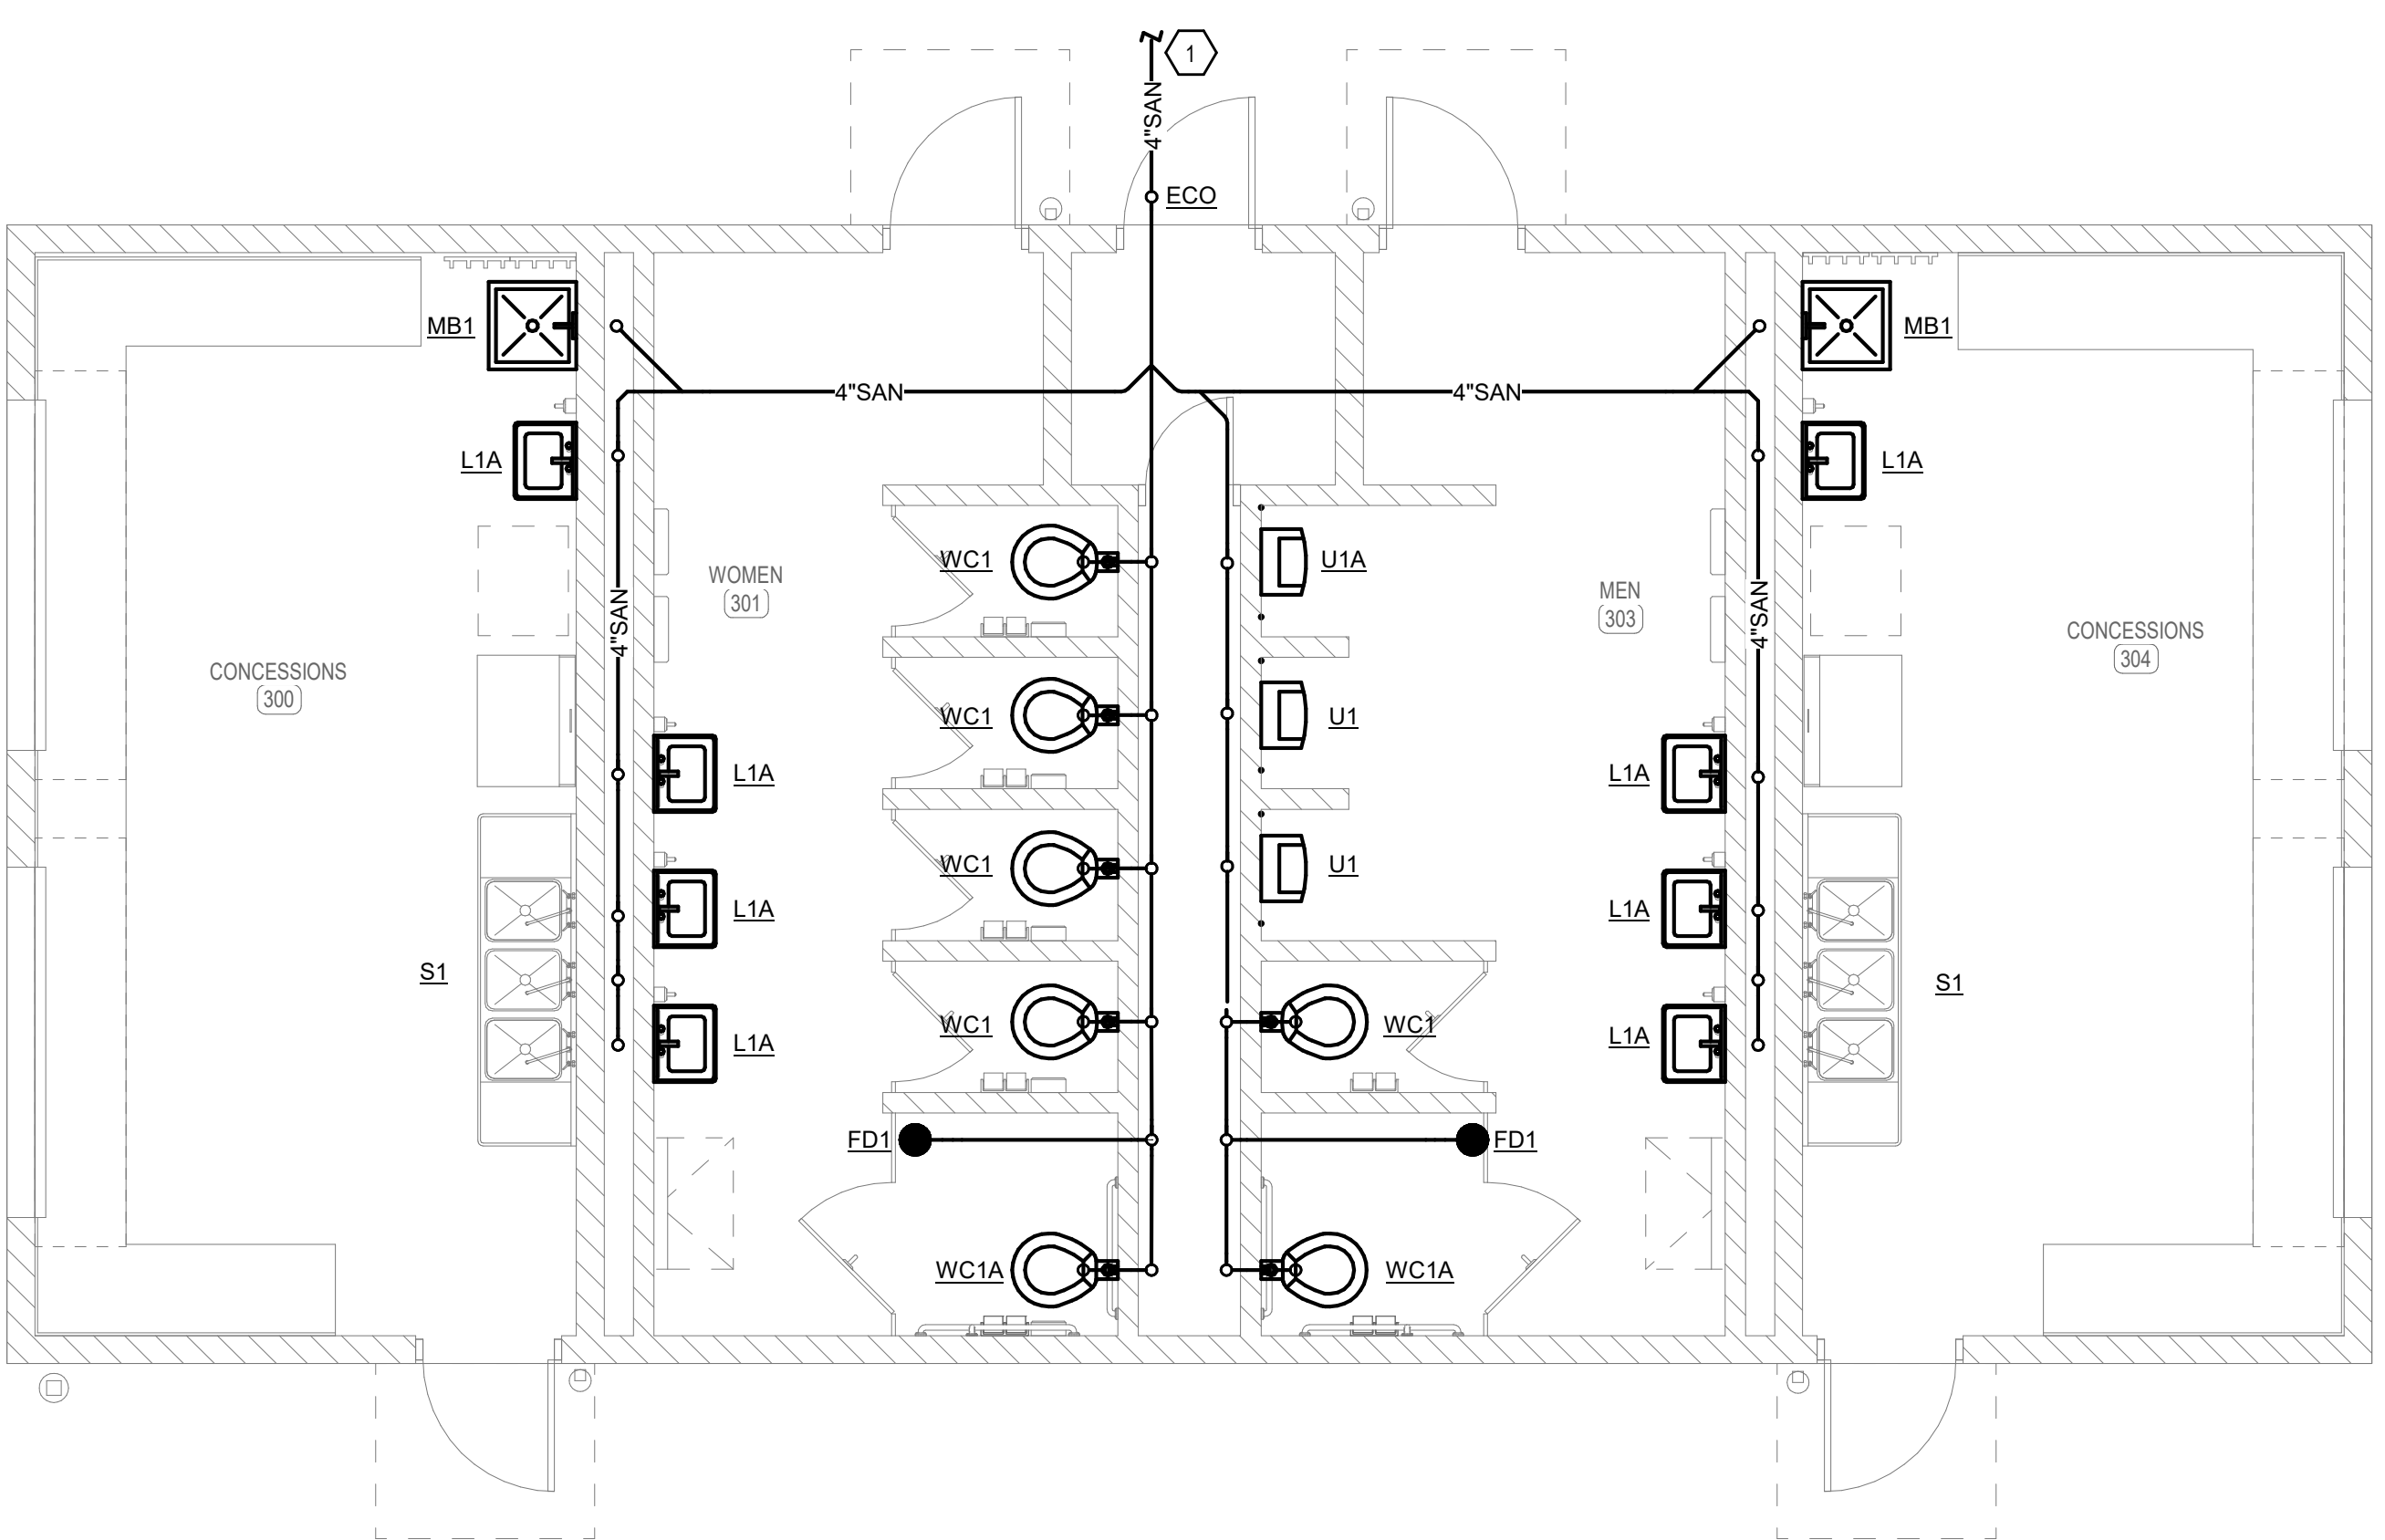


1 FIRST FLOOR PLAN - CONCESSIONS AND RESTROOM - SANITARY SEWER

 
SCALE: 1/4" = 1'-0"



KEY PLAN

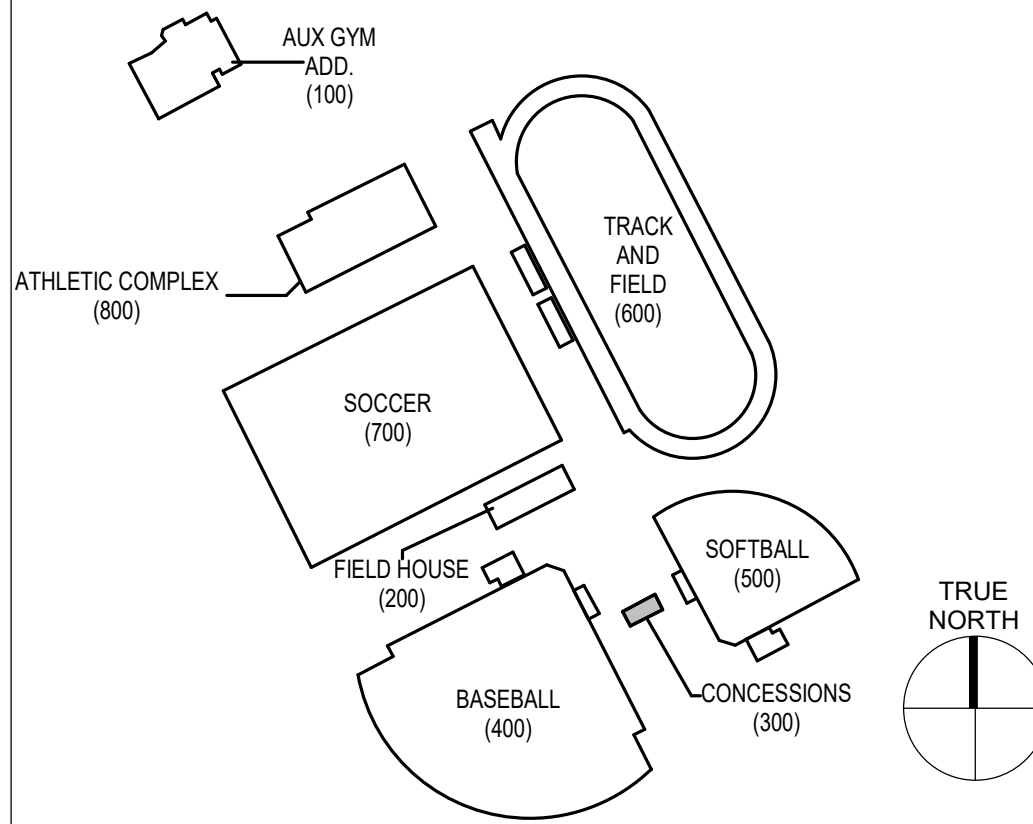


2459 ALLEN COUNTY - SCOTTSVILLE HIGH SCHOOL ATHLETIC COMPLEX
Autodesk Docs 12/25/2025 Allen County Athletic Fields and Facilities/25008-Allen Co. V08 MEP.rvt
11/14/2025 3:04:30 PM

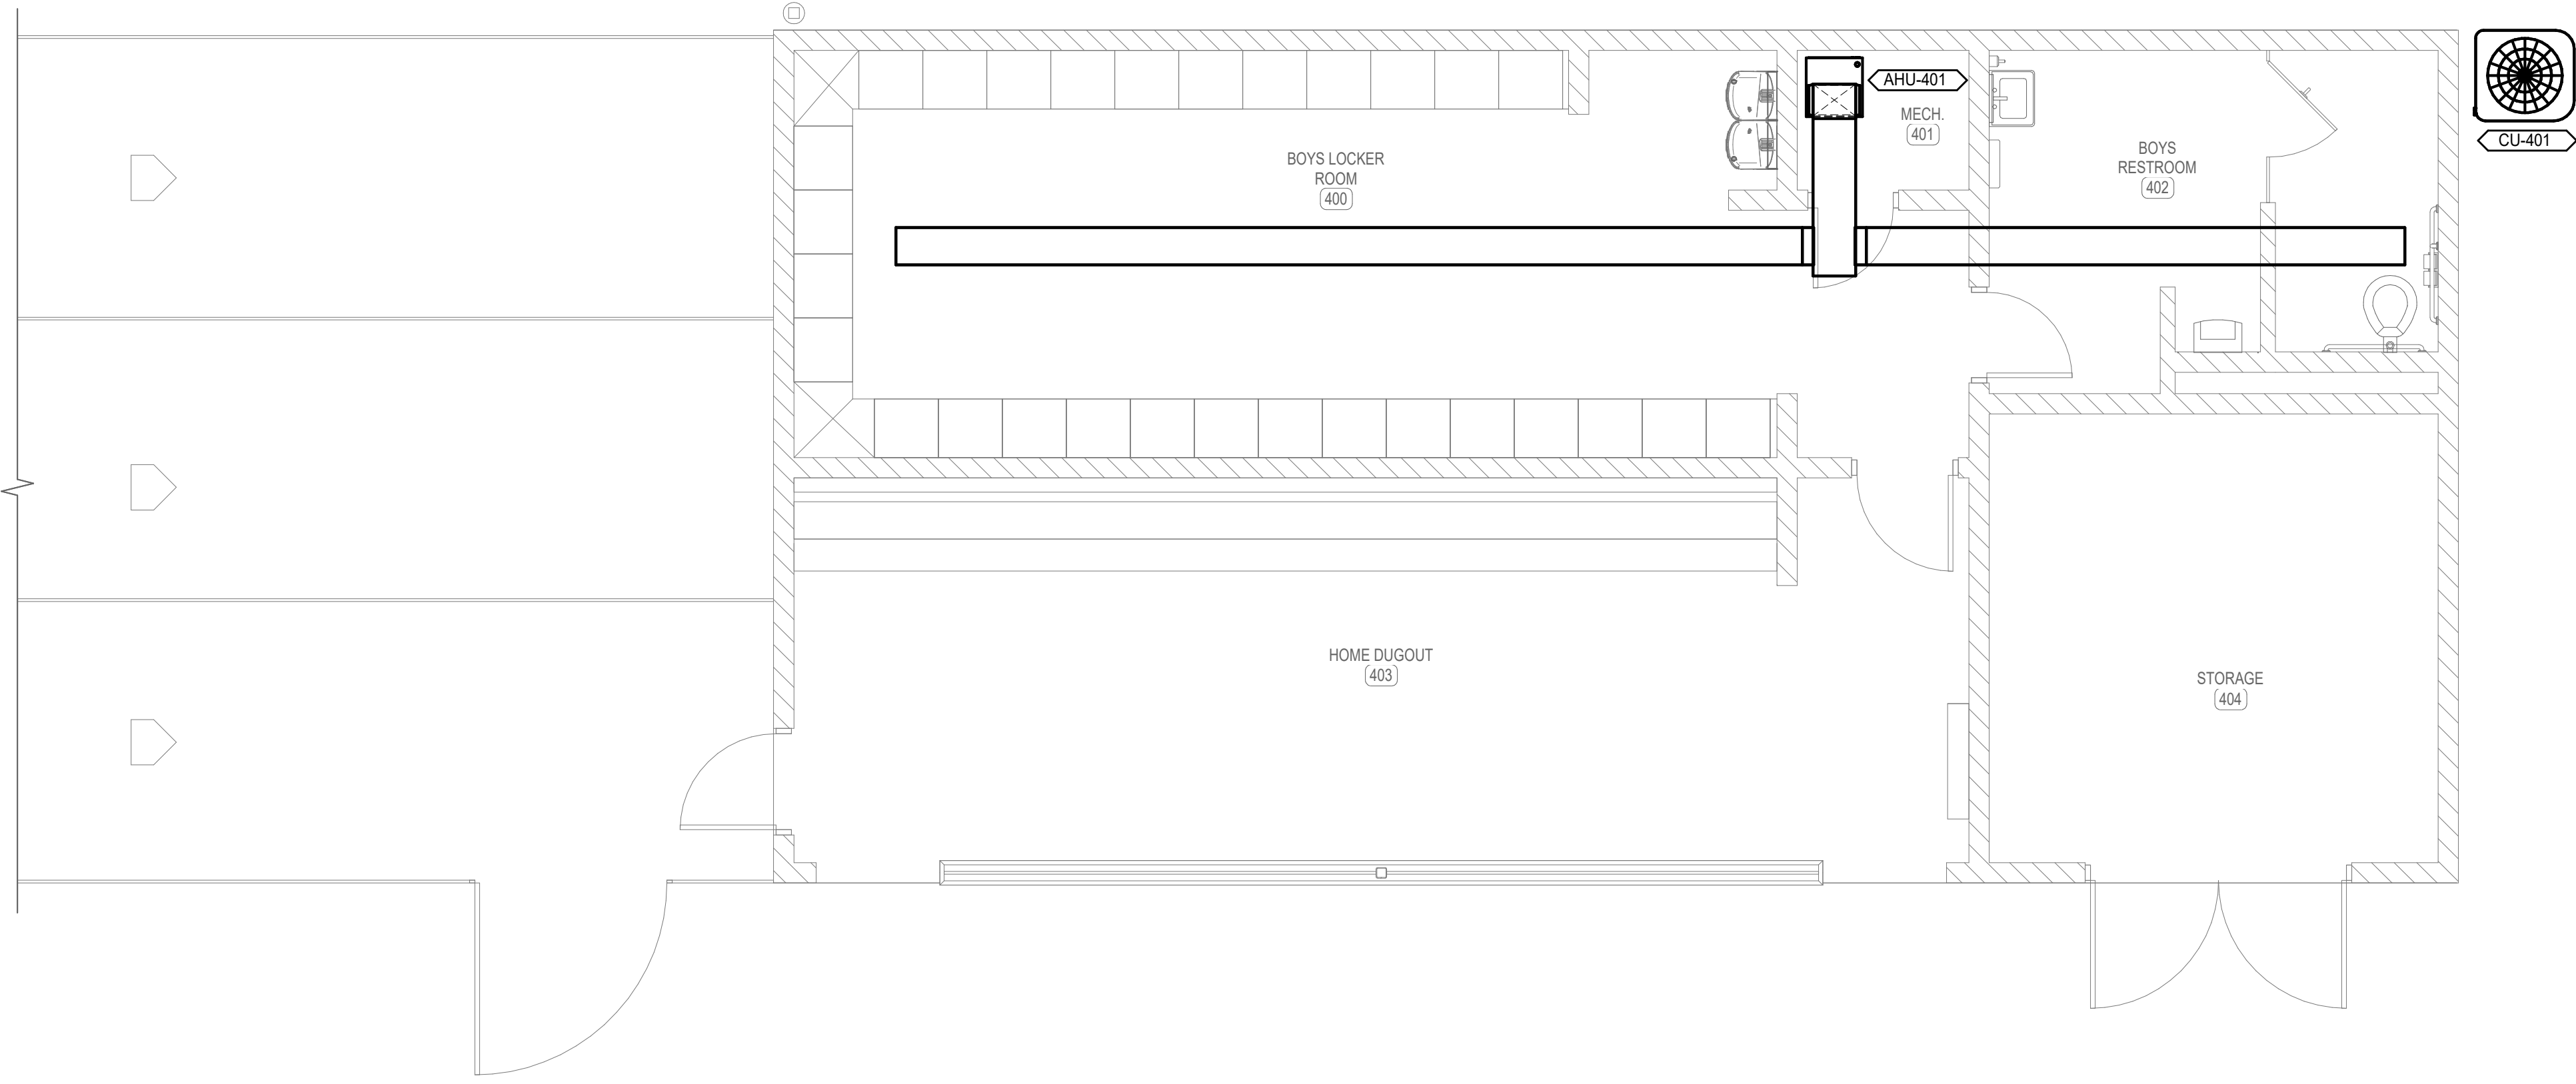


3 FIRST FLOOR PLAN - BOYS LOCKER ROOM AND DUGOUT - HVAC
SCALE: 1/4" = 1'-0"

0 2' 4' 8'

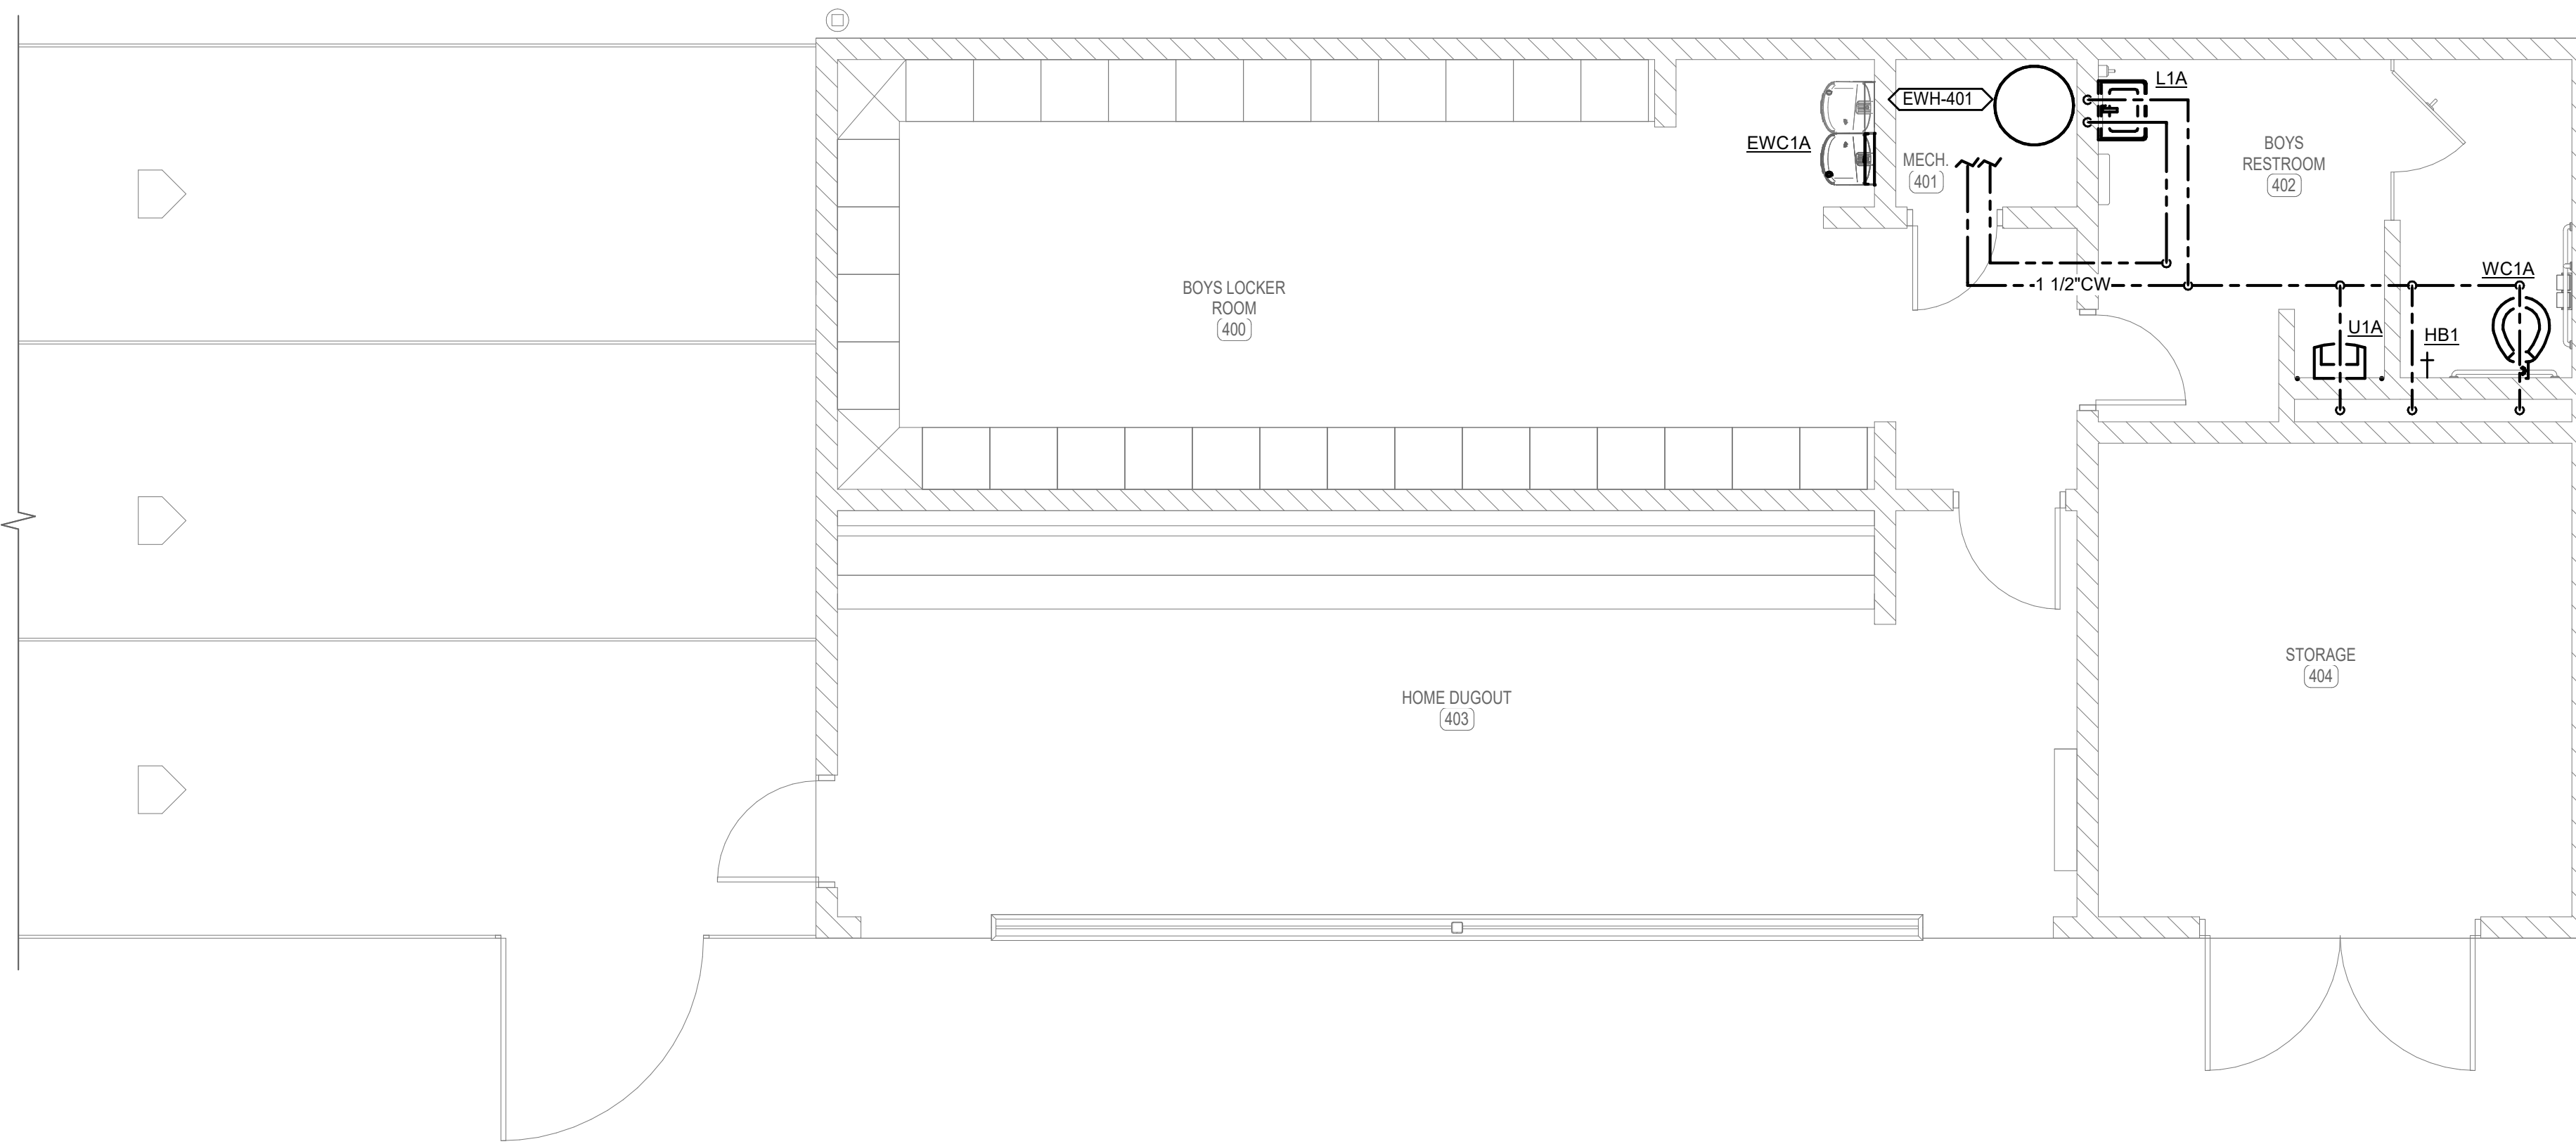

2 FIRST FLOOR PLAN - BOYS LOCKER ROOM AND DUGOUT - DOMESTIC WATER
SCALE: 1/4" = 1'-0"

0 2' 4' 8'

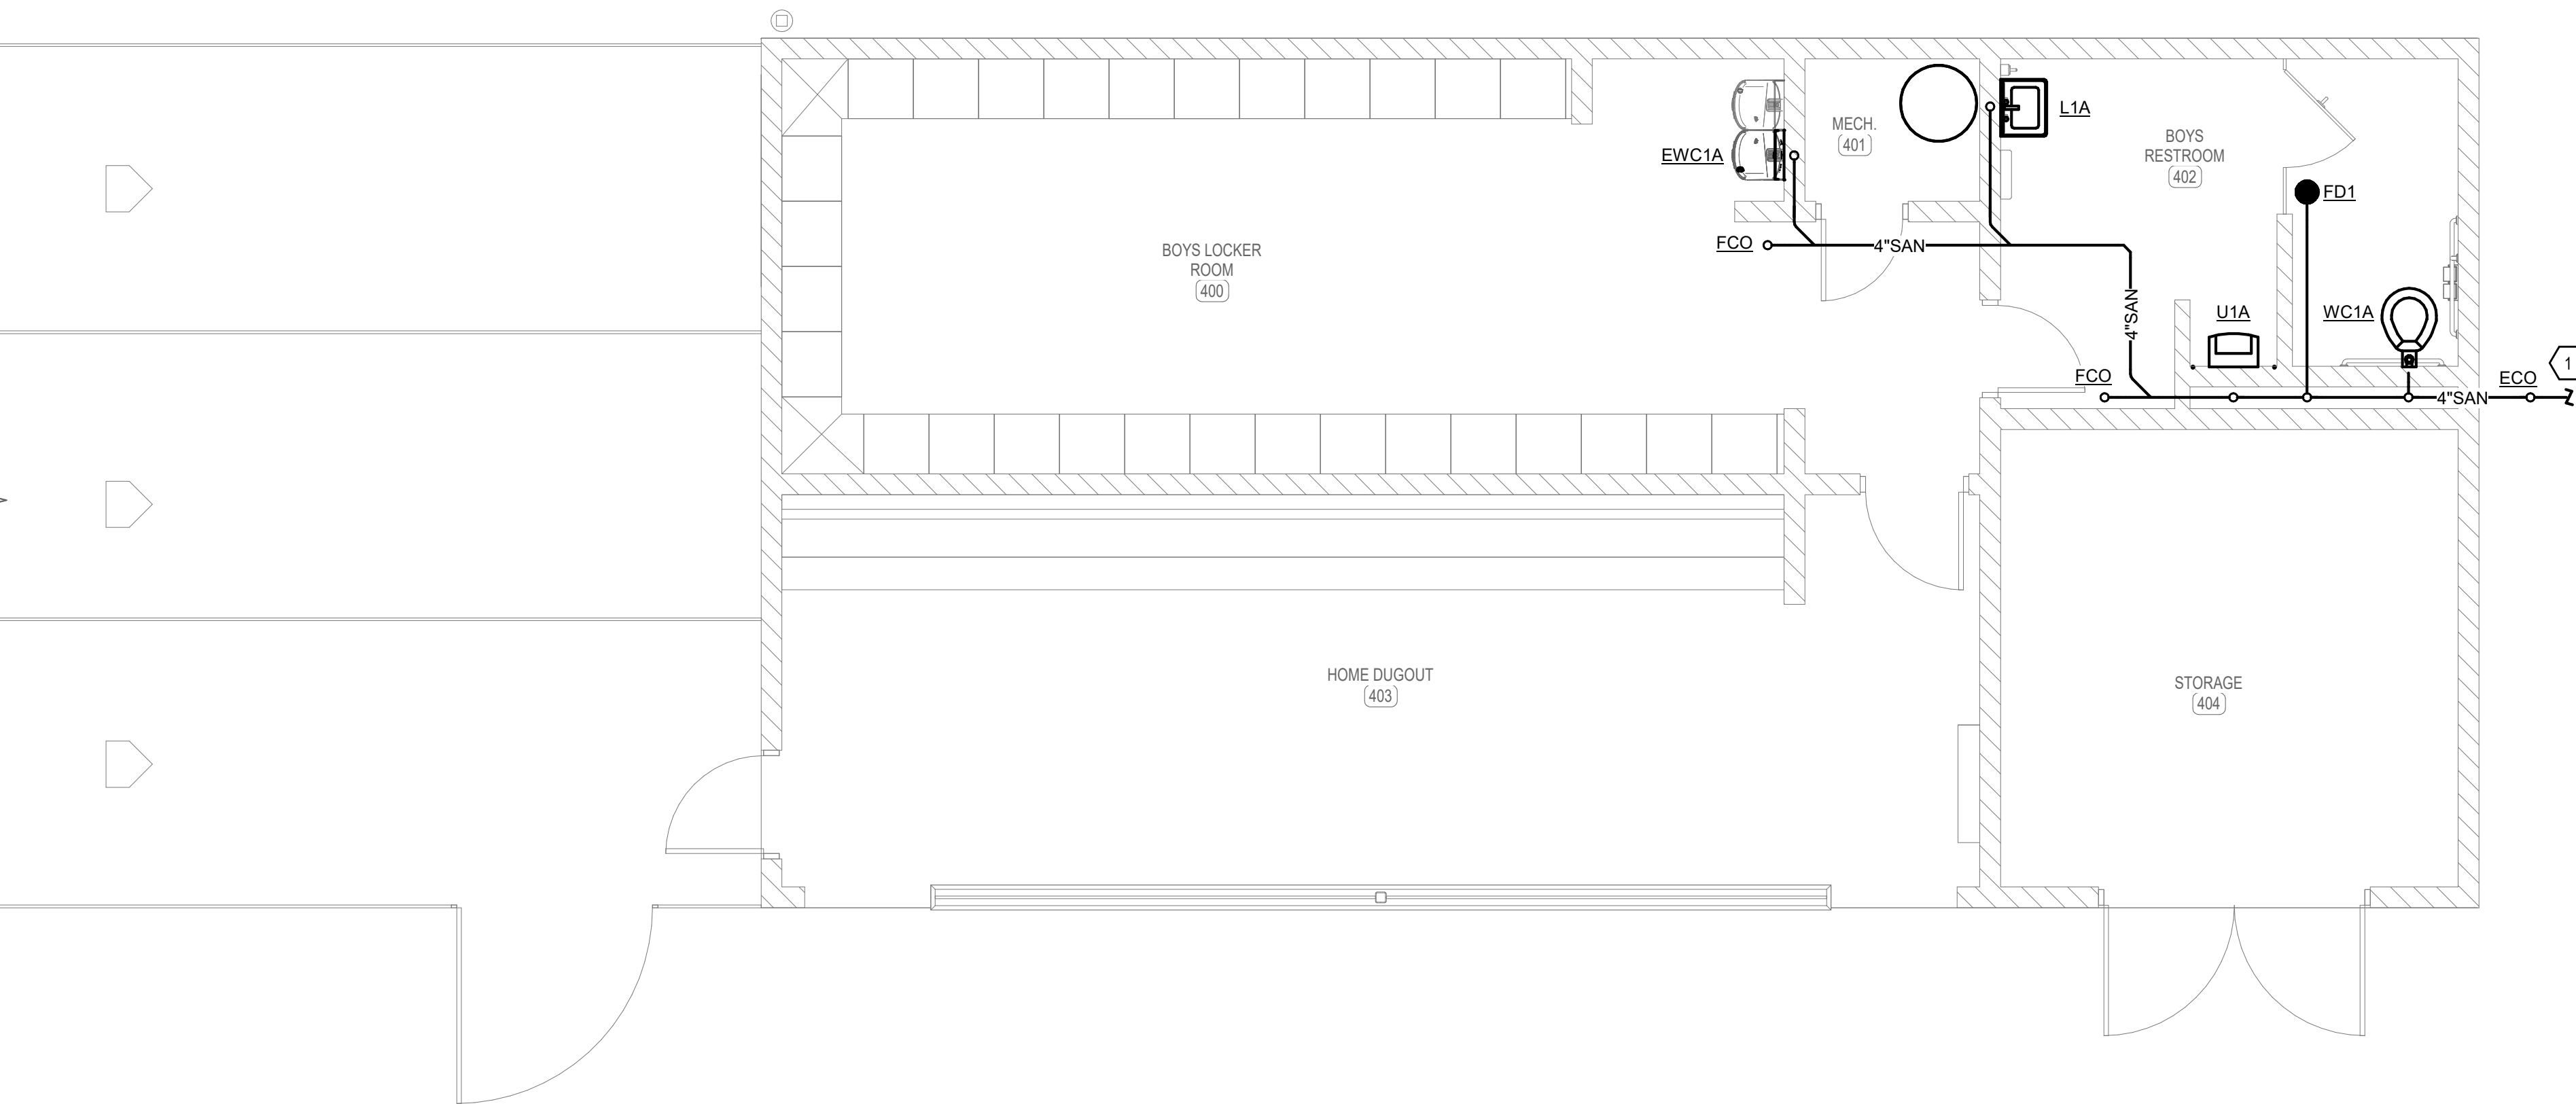

1 FIRST FLOOR PLAN - BOYS LOCKER ROOM AND DUGOUT - SANITARY SEWER
SCALE: 1/4" = 1'-0"


0 2' 4' 8'

GENERAL NOTES


A. REFER TO SHEET P001 AND M001 FOR PLUMBING AND MECHANICAL LEGENDS AND GENERAL NOTES.

SHEET KEYNOTES


1. REFER TO PLUMBING SITE UTILITIES PLAN FOR CONTINUATION.

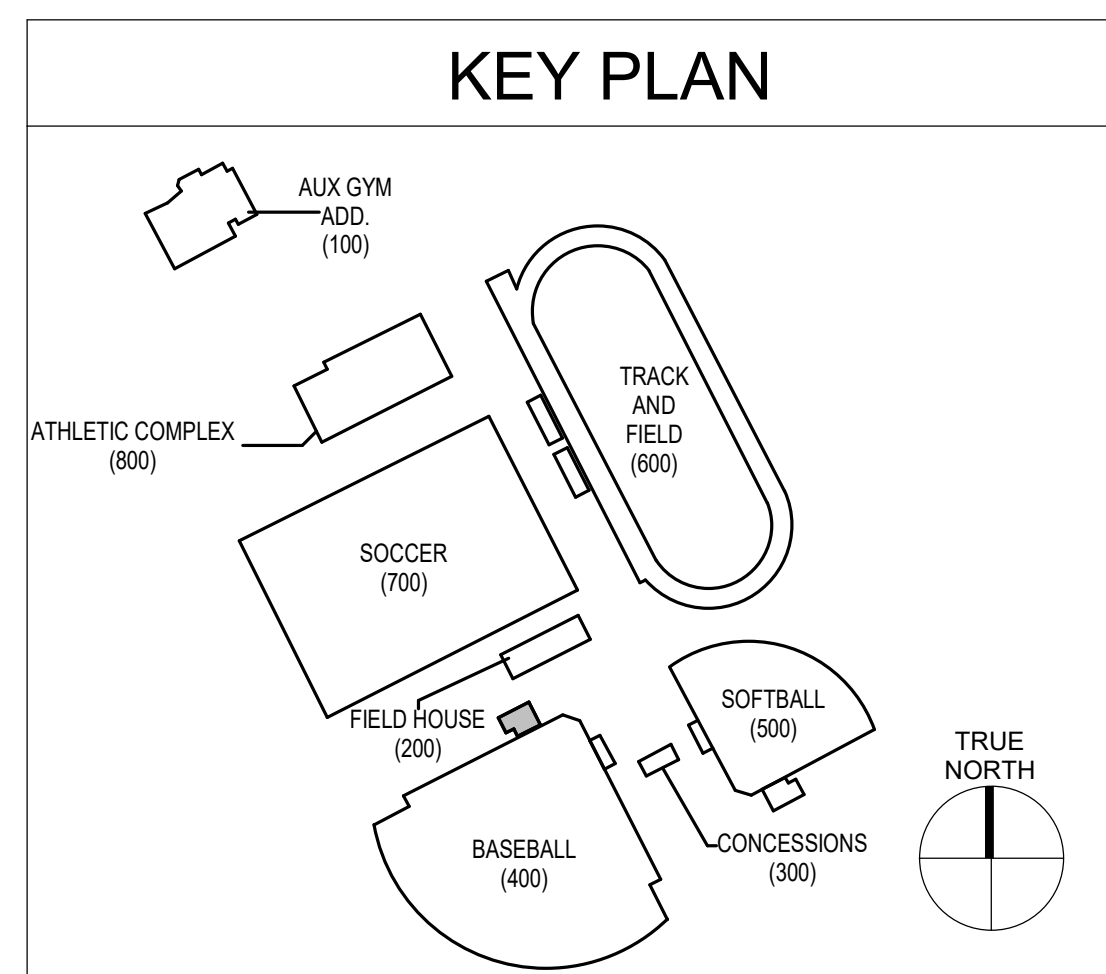


2459 ALLEN COUNTY - SCOTTSVILLE HIGH SCHOOL ATHLETIC COMPLEX
Autodesk Docs/2459 Allen County Athletic Fields and Facilities/25008-Allen Co. V08 MEP.rvt
11/14/2025 3:04:32 PM

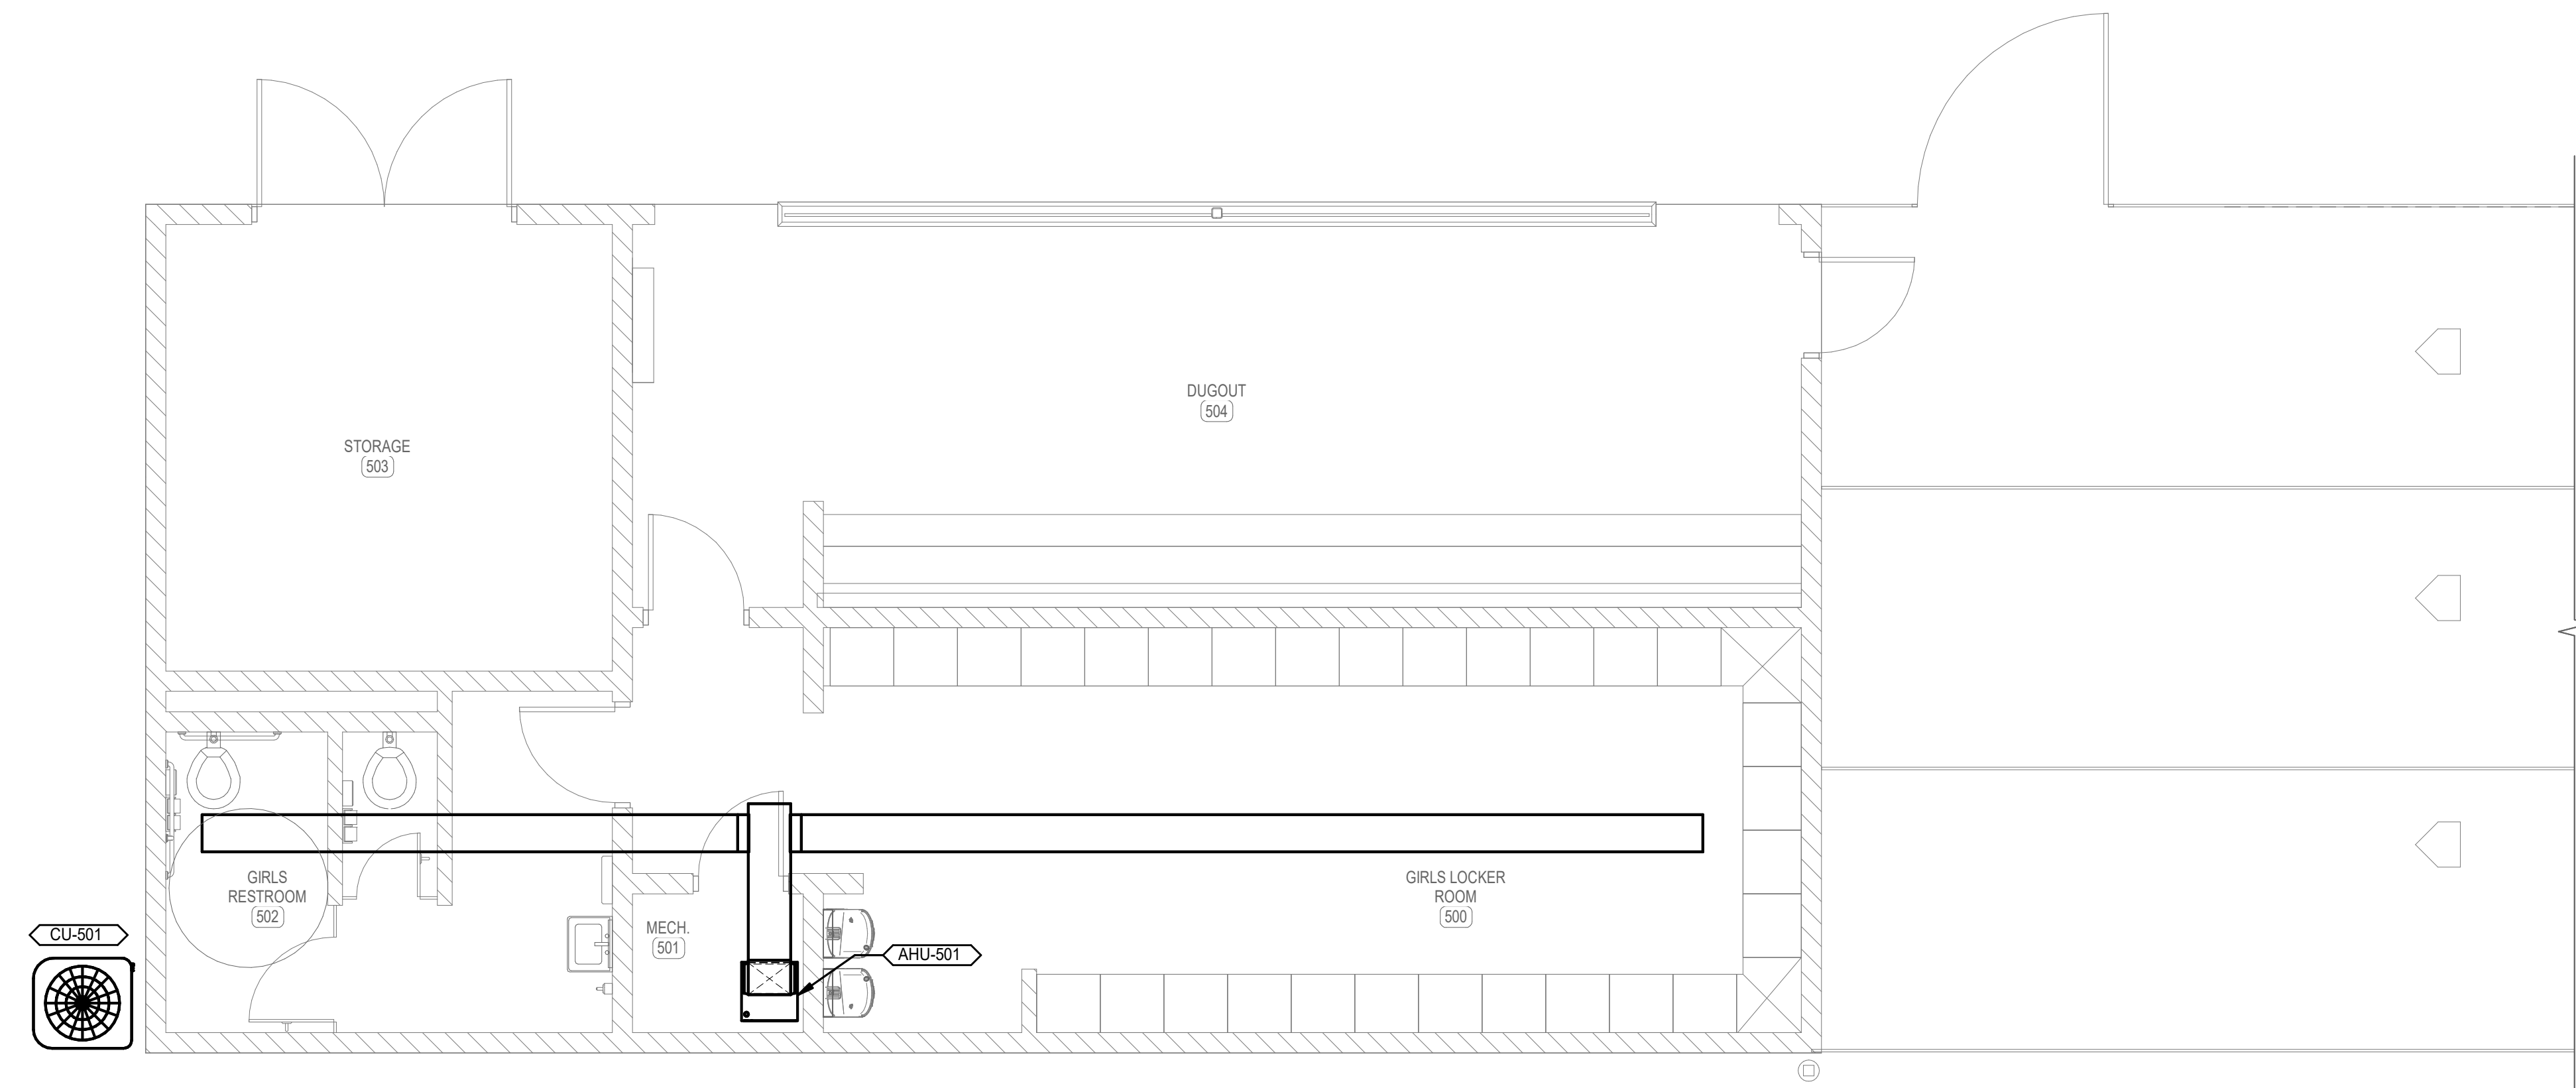

3 FIRST FLOOR PLAN - GIRLS LOCKER ROOM AND DUGOUT - HVAC
SCALE: 1/4" = 1'-0"

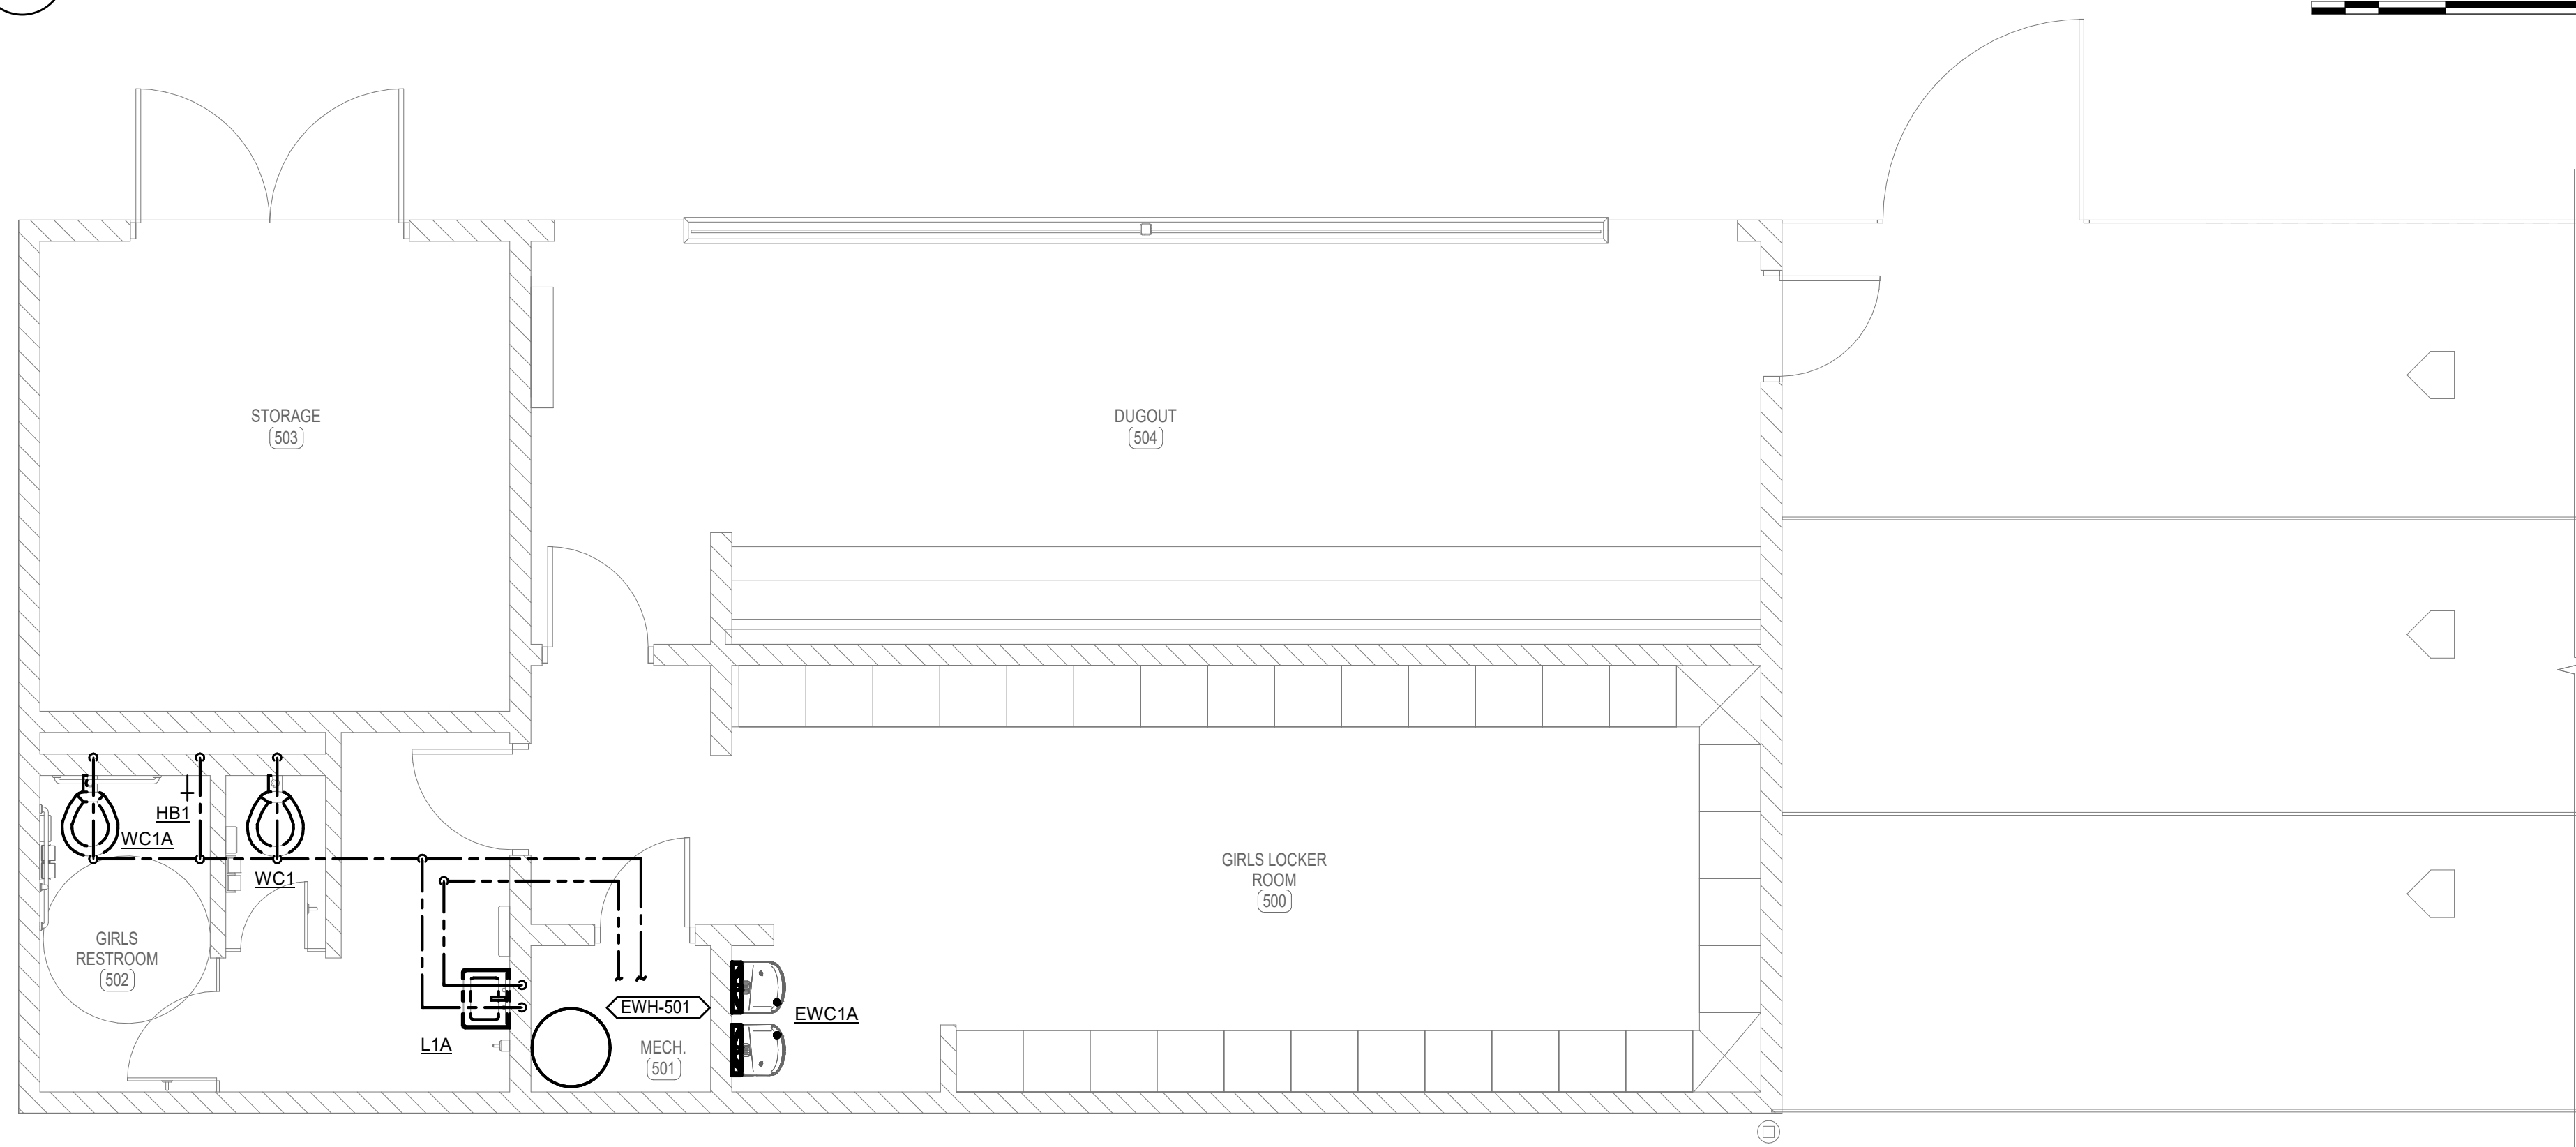

2 FIRST FLOOR PLAN - GIRLS LOCKER ROOM AND DUGOUT - DOMESTIC WATER
SCALE: 1/4" = 1'-0"

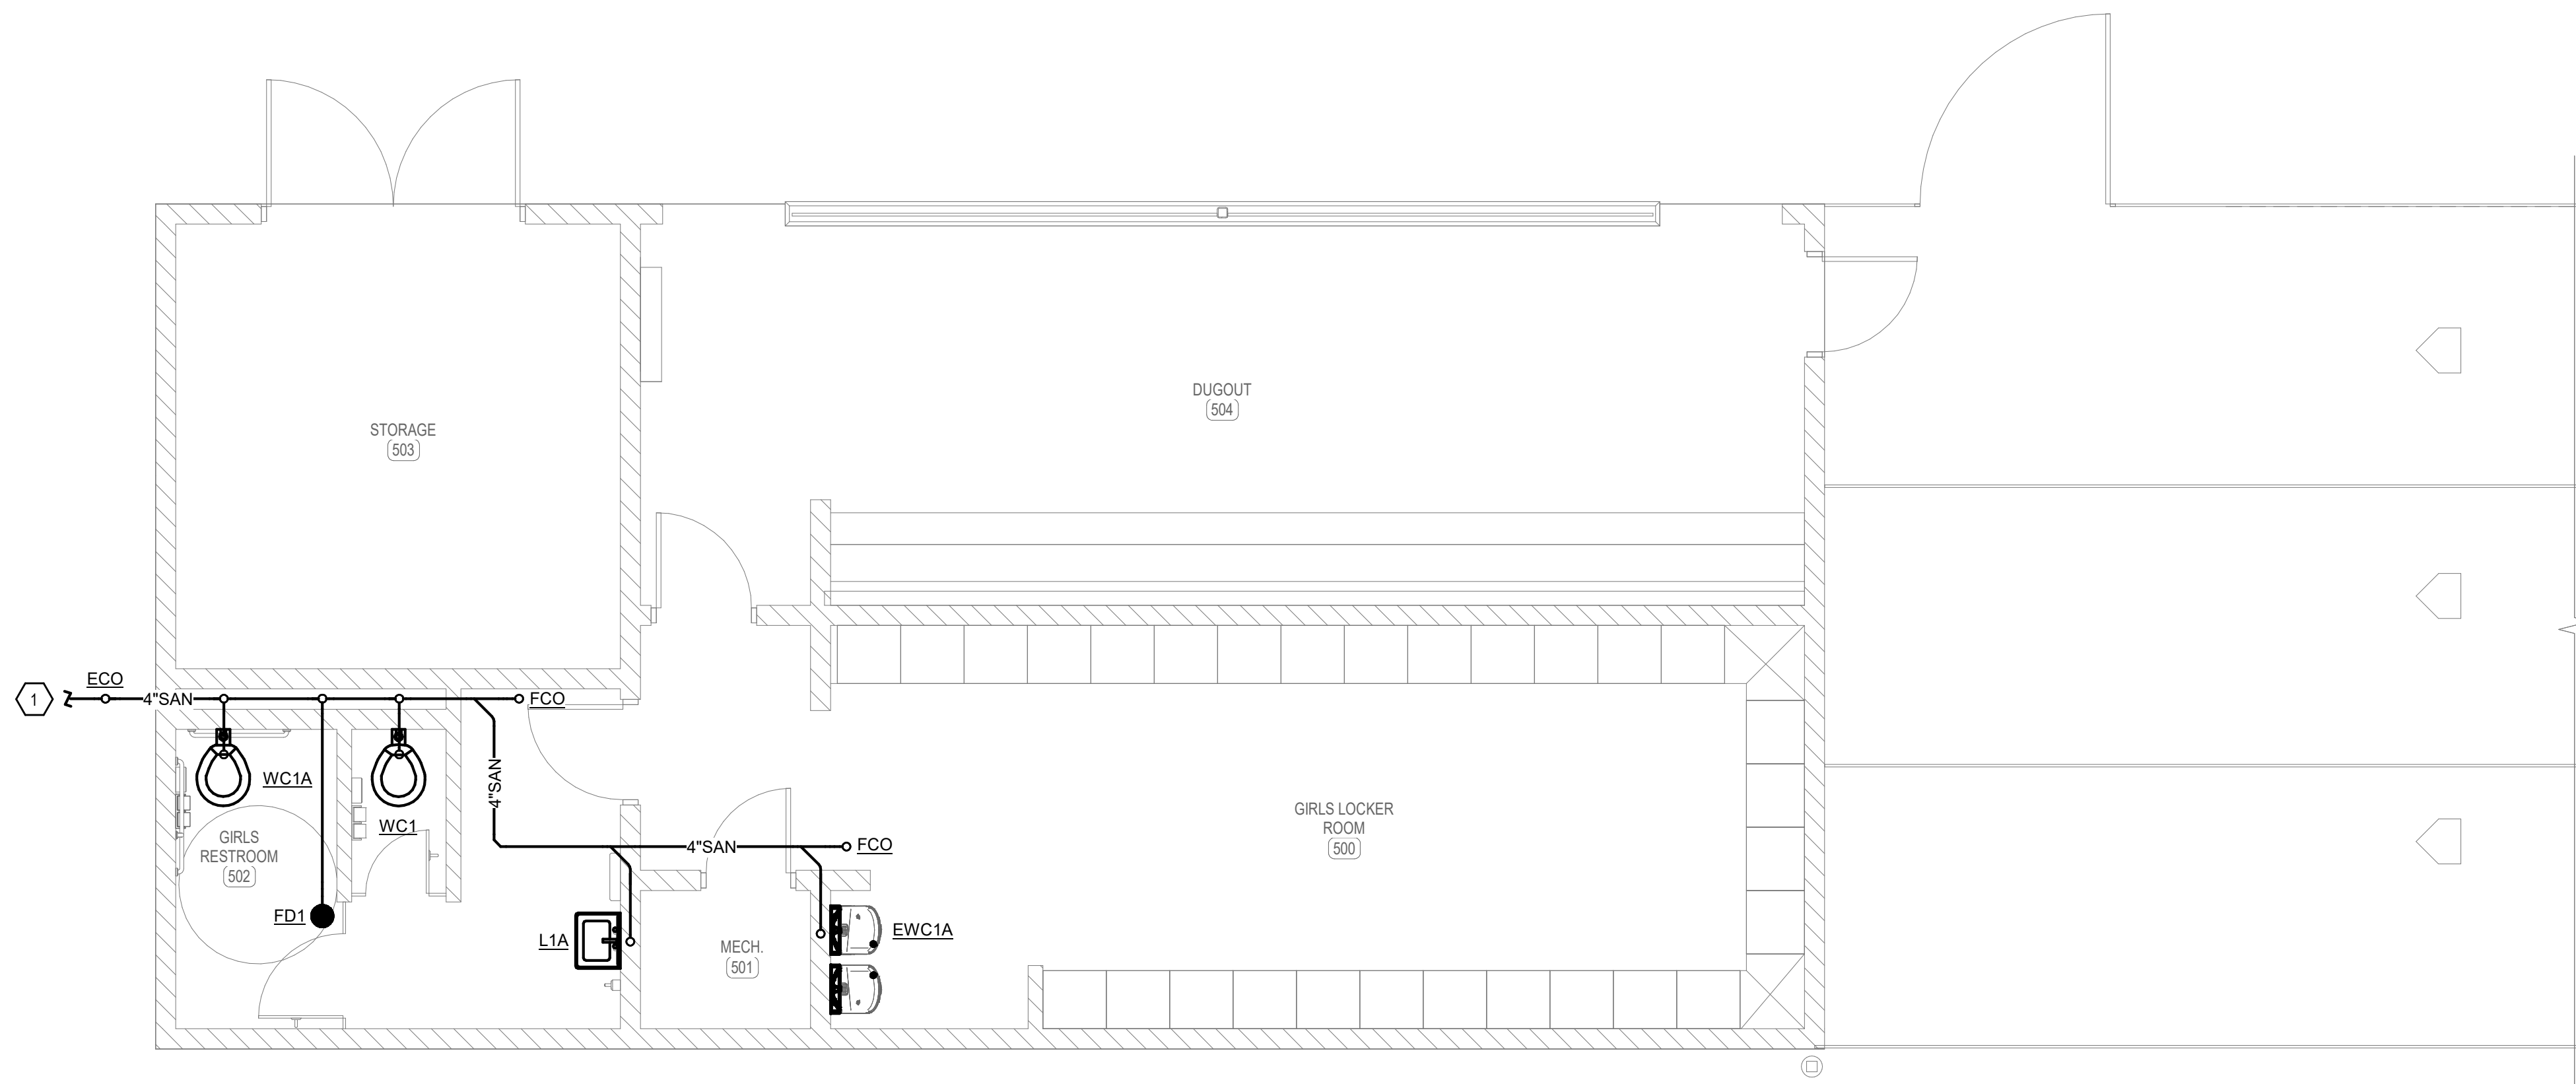


1 FIRST FLOOR PLAN - GIRLS LOCKER ROOM AND DUGOUT - SANITARY SEWER
SCALE: 1/4" = 1'-0"

GENERAL NOTES




A. REFER TO SHEET P001 AND M001 FOR PLUMBING AND MECHANICAL LEGENDS AND GENERAL NOTES.

SHEET KEYNOTES

1. REFER TO PLUMBING SITE UTILITIES PLAN FOR CONTINUATION.

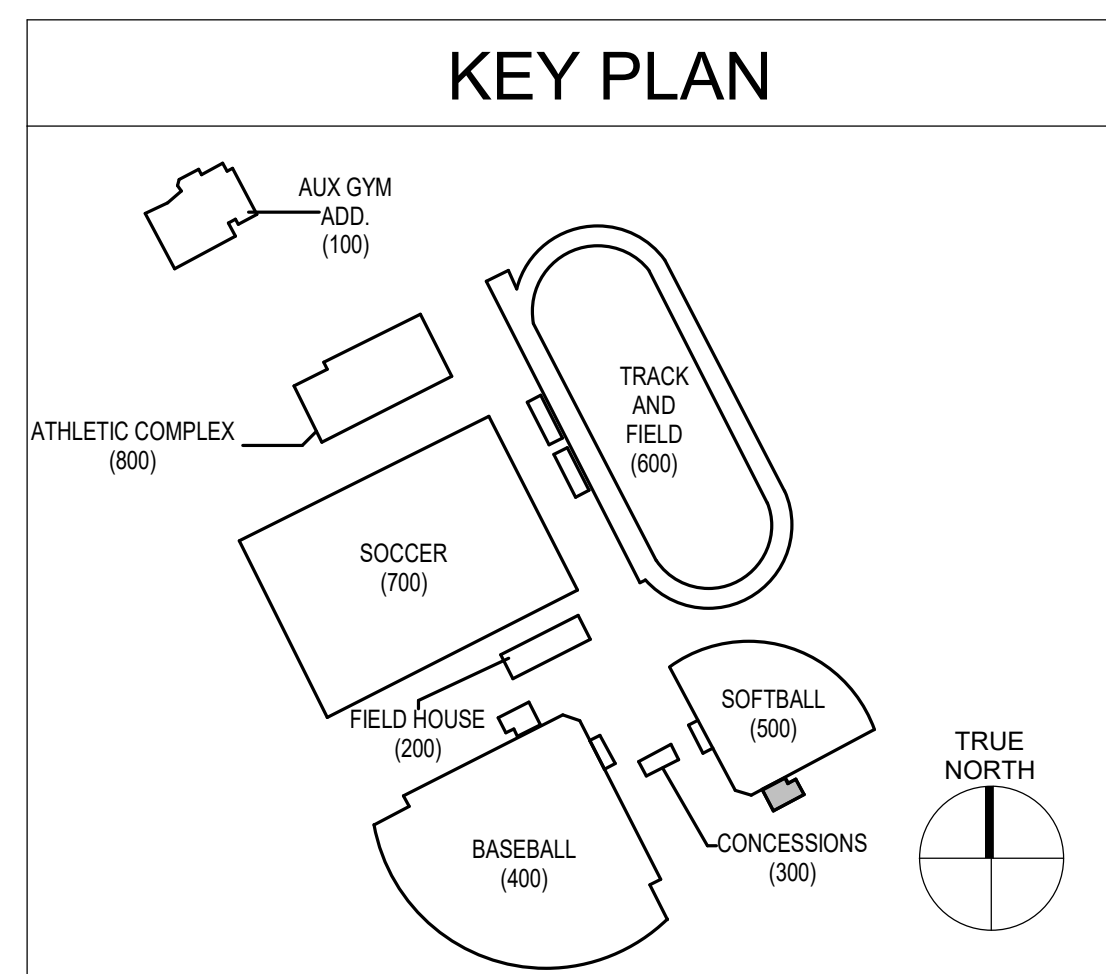

2459 ALLEN COUNTY - SCOTTSVILLE HIGH SCHOOL ATHLETIC COMPLEX
Autodesk Docs (2459 Allen County Athletic Fields and Facilities)25008-Allen Co. V08 MEP.rvt
11/14/2025 3:04:28 PM

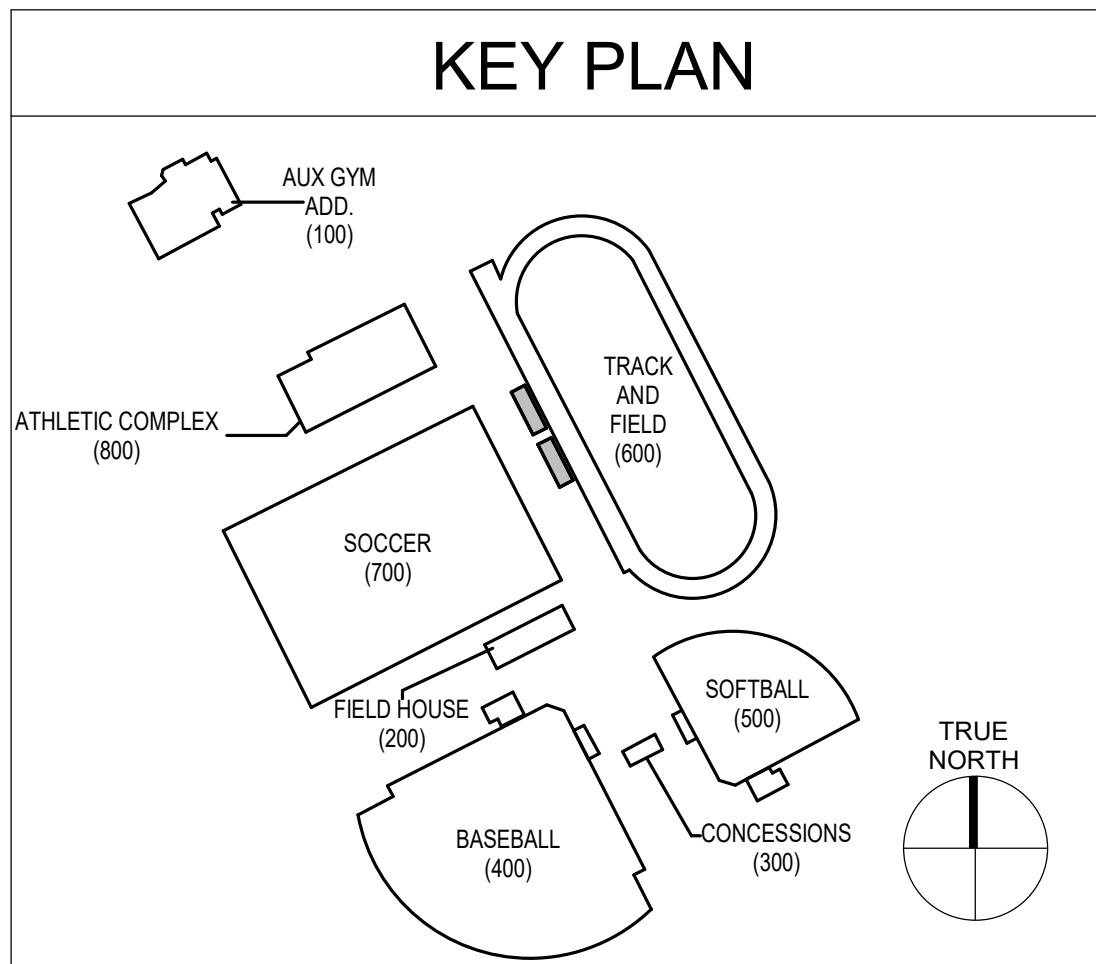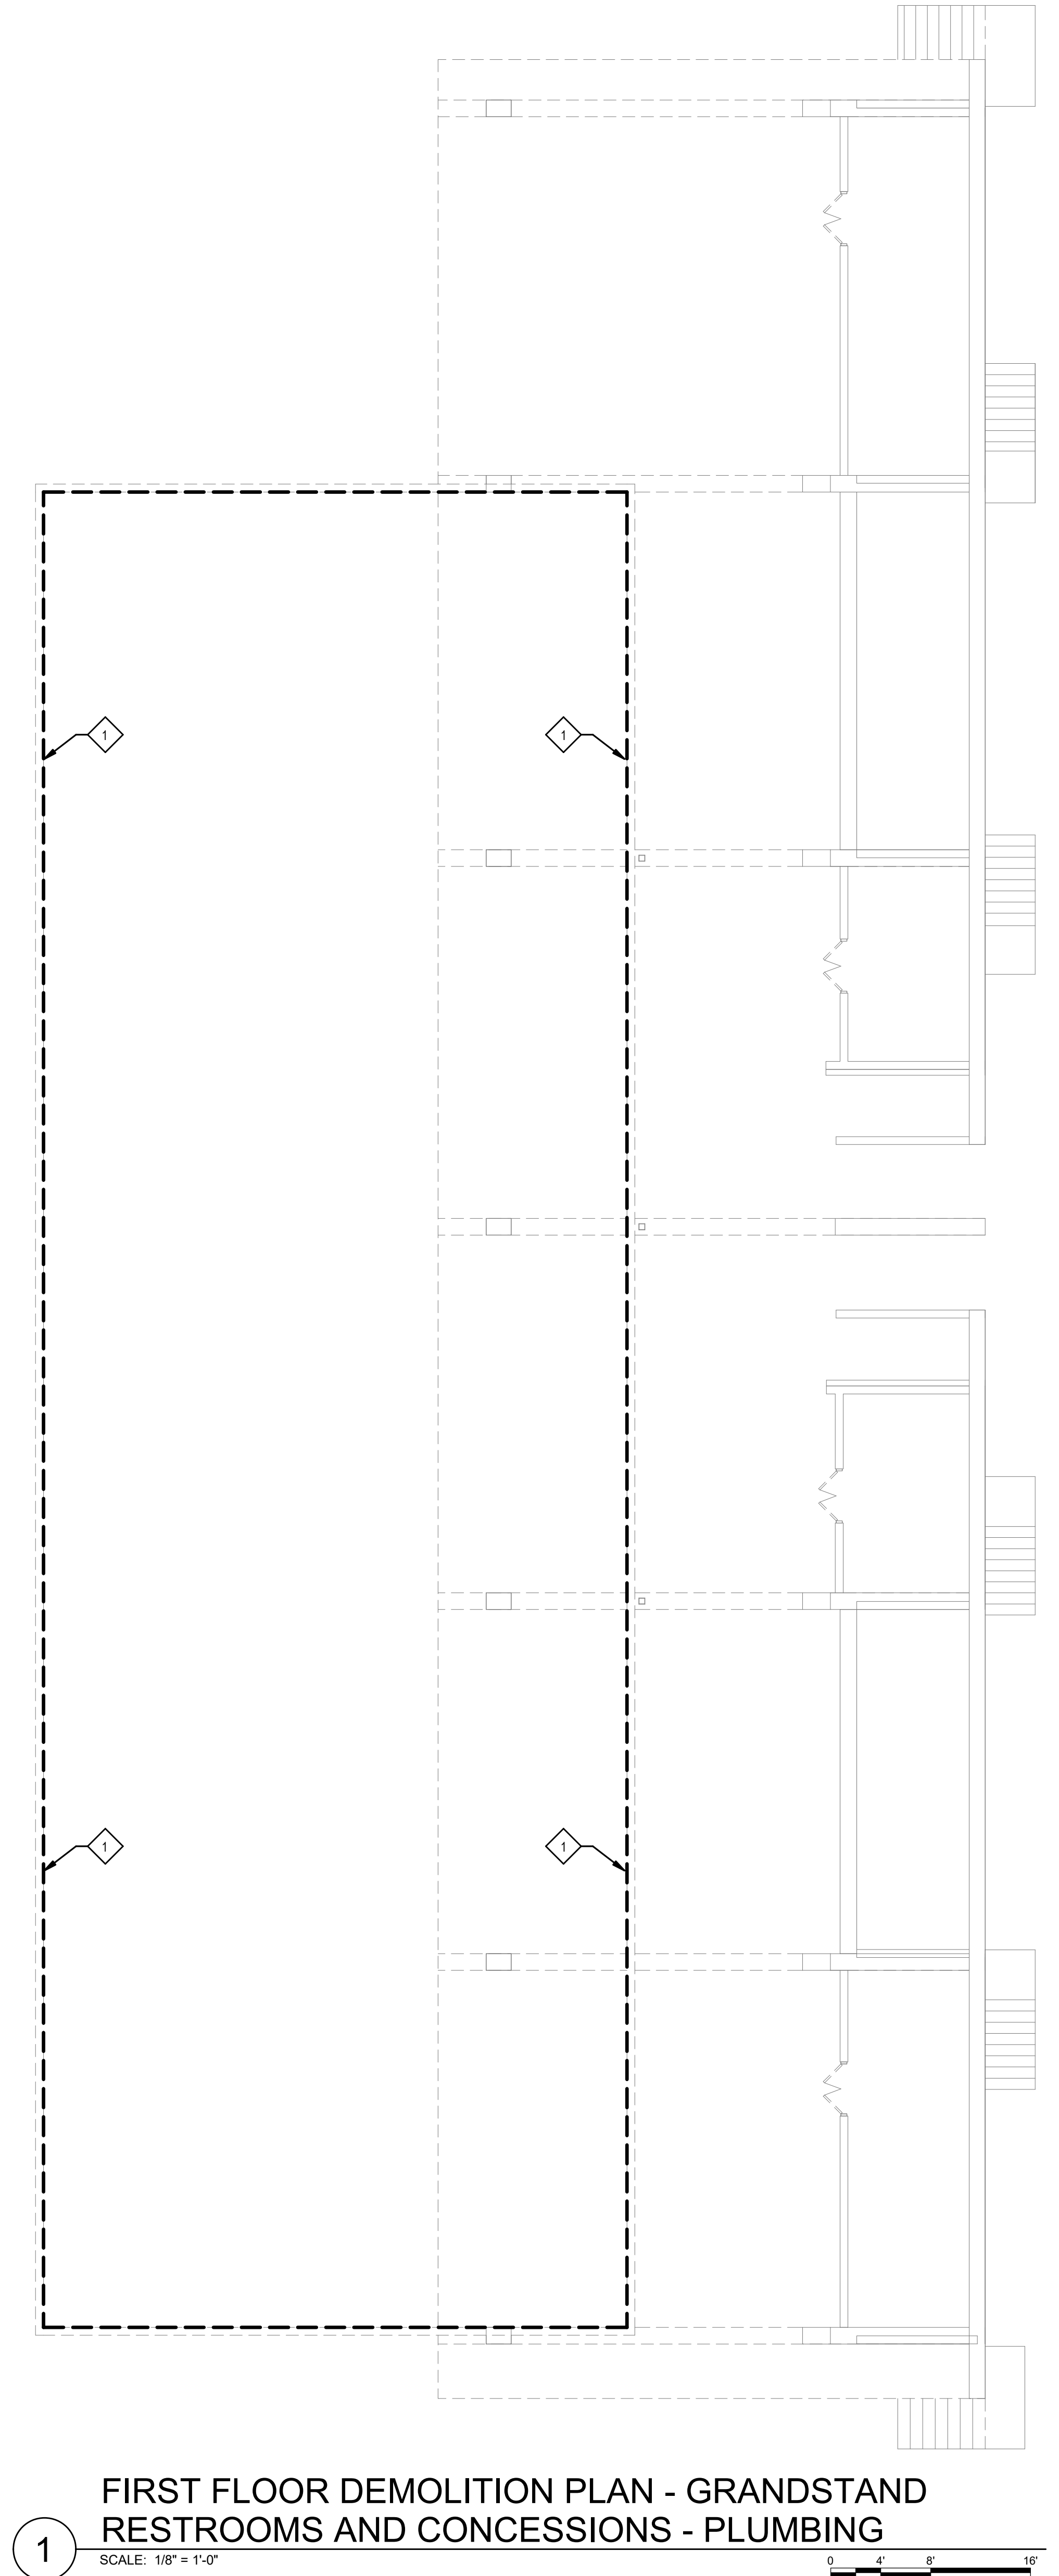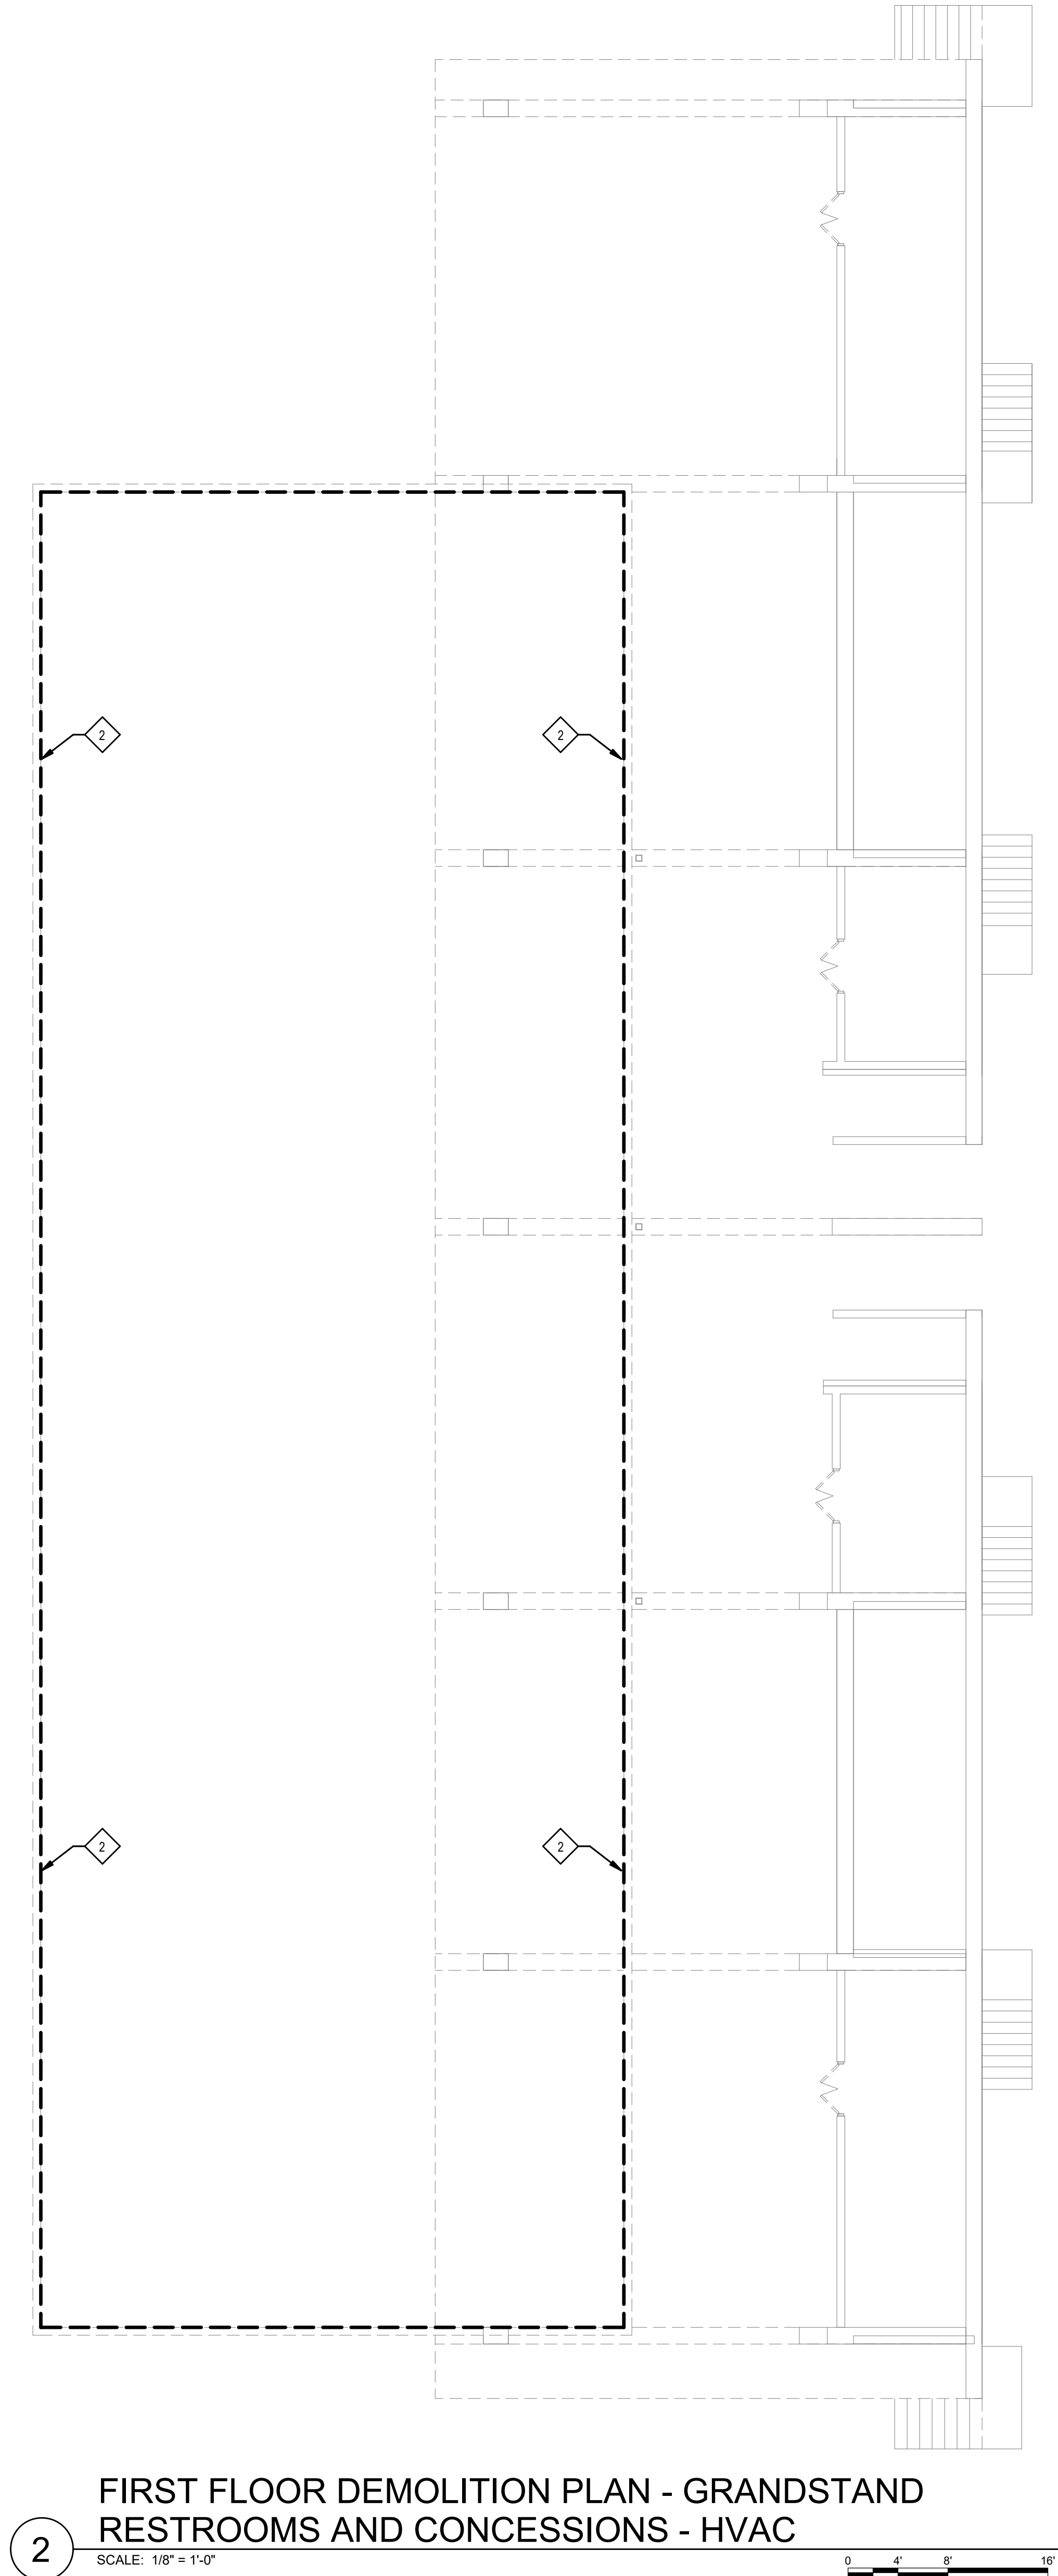

GENERAL NOTES

A. REFER TO SHEET P001 AND M001 FOR PLUMBING AND MECHANICAL LEGENDS AND GENERAL NOTES.

SHEET KEYNOTES

1. EXISTING FOOTBALL FACILITY TO BE FULLY DEMOLISHED. DEMOLISH AND REMOVE ALL PLUMBING FIXTURES. DEMOLISH ALL DOMESTIC WATER PIPING AND CAP FOR FUTURE RECONNECTION. DEMOLISH ALL SANITARY AND VENT PIPING ABOVE AND BELOW SLAB.
2. EXISTING FOOTBALL FACILITY TO BE FULLY DEMOLISHED. DEMOLISH AND REMOVE ALL HVAC EQUIPMENT, DUCTWORK, PIPING, REFRIGERANT, CONDENSATE, AND DEVICES THROUGHOUT BUILDING. TURN OVER TO OWNER ANY NEWER EQUIPMENT AND DEVICES AS DESIRED BY OWNER.



ALLEN COUNTY - SCOTTSVILLE
HIGH SCHOOL ATHLETIC
COMPLEX
SCOTTSVILLE, KENTUCKY

GRANDSTANDS - MECHANICAL &
PLUMBING


JOB NO.	2459
DATE	NOV 17, 2025
DRAWN	BRN
CHECKED	NCM

COPYRIGHT © 2025
SHERMAN CARTER BARNHART
ARCHITECTS, PLLC


REVISIONS		
No.	Description	Date

SHEET
MD610

1. REFER TO PLUMBING SITE UTILITIES PLAN FOR CONTINUATION.

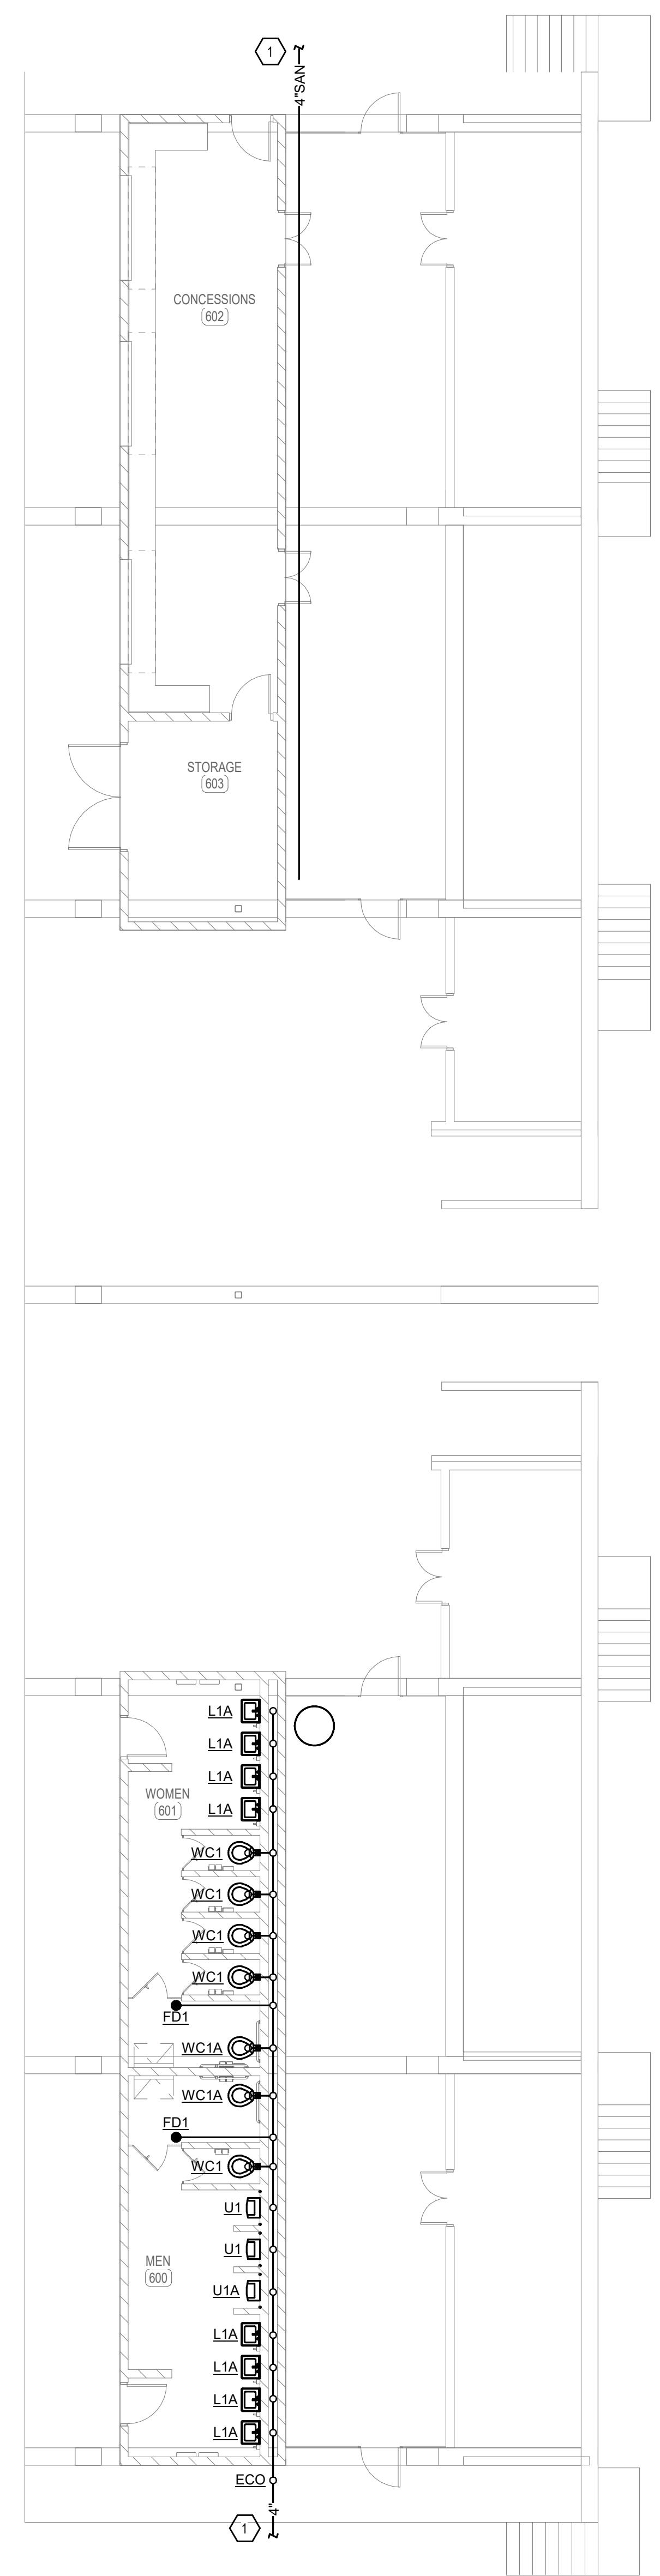

FIRST FLOOR PLAN - GRANDSTAND RESTROOMS AND CONCESSIONS - SANITARY SEWER

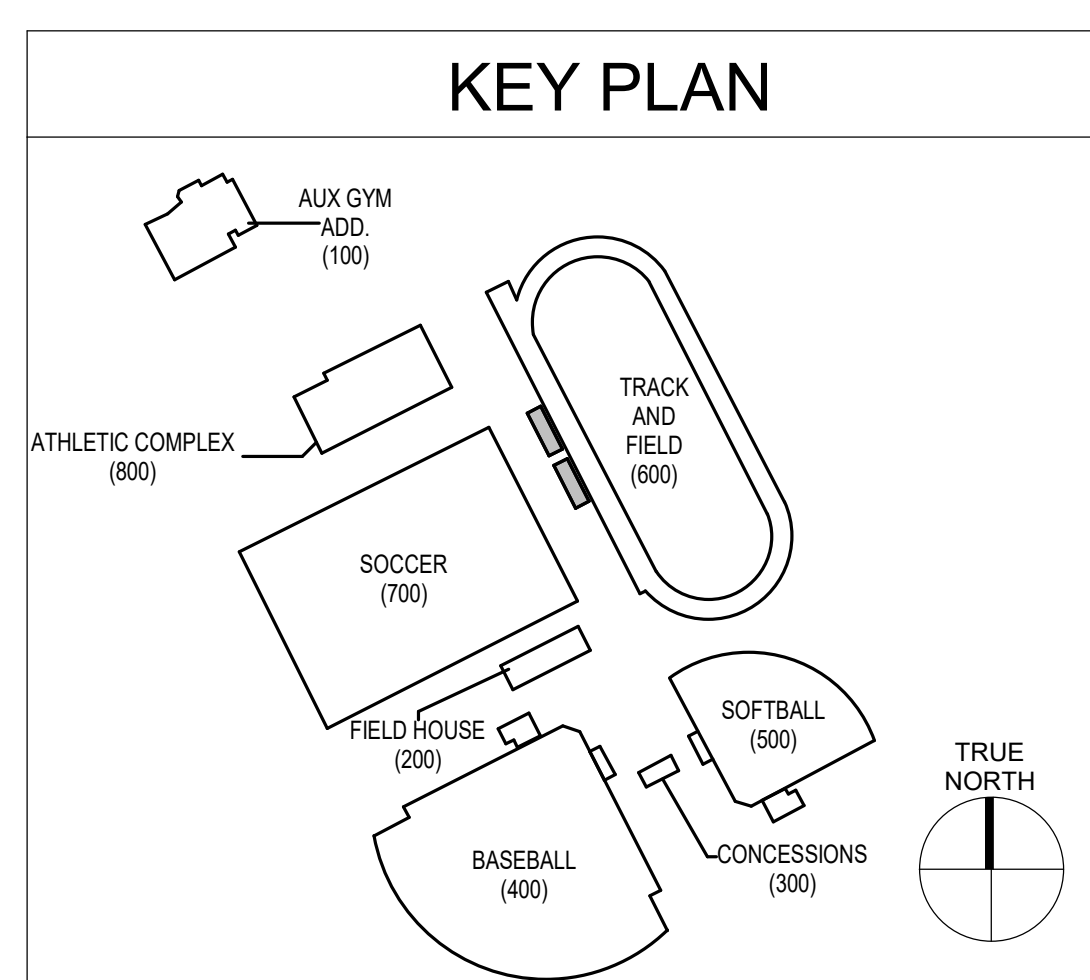


GENERAL NOTES

A. REFER TO SHEET P001 AND M001 FOR PLUMBING AND MECHANICAL LEGENDS AND GENERAL NOTES.


SHEET KEYNOTES

1. SHEET NOTES

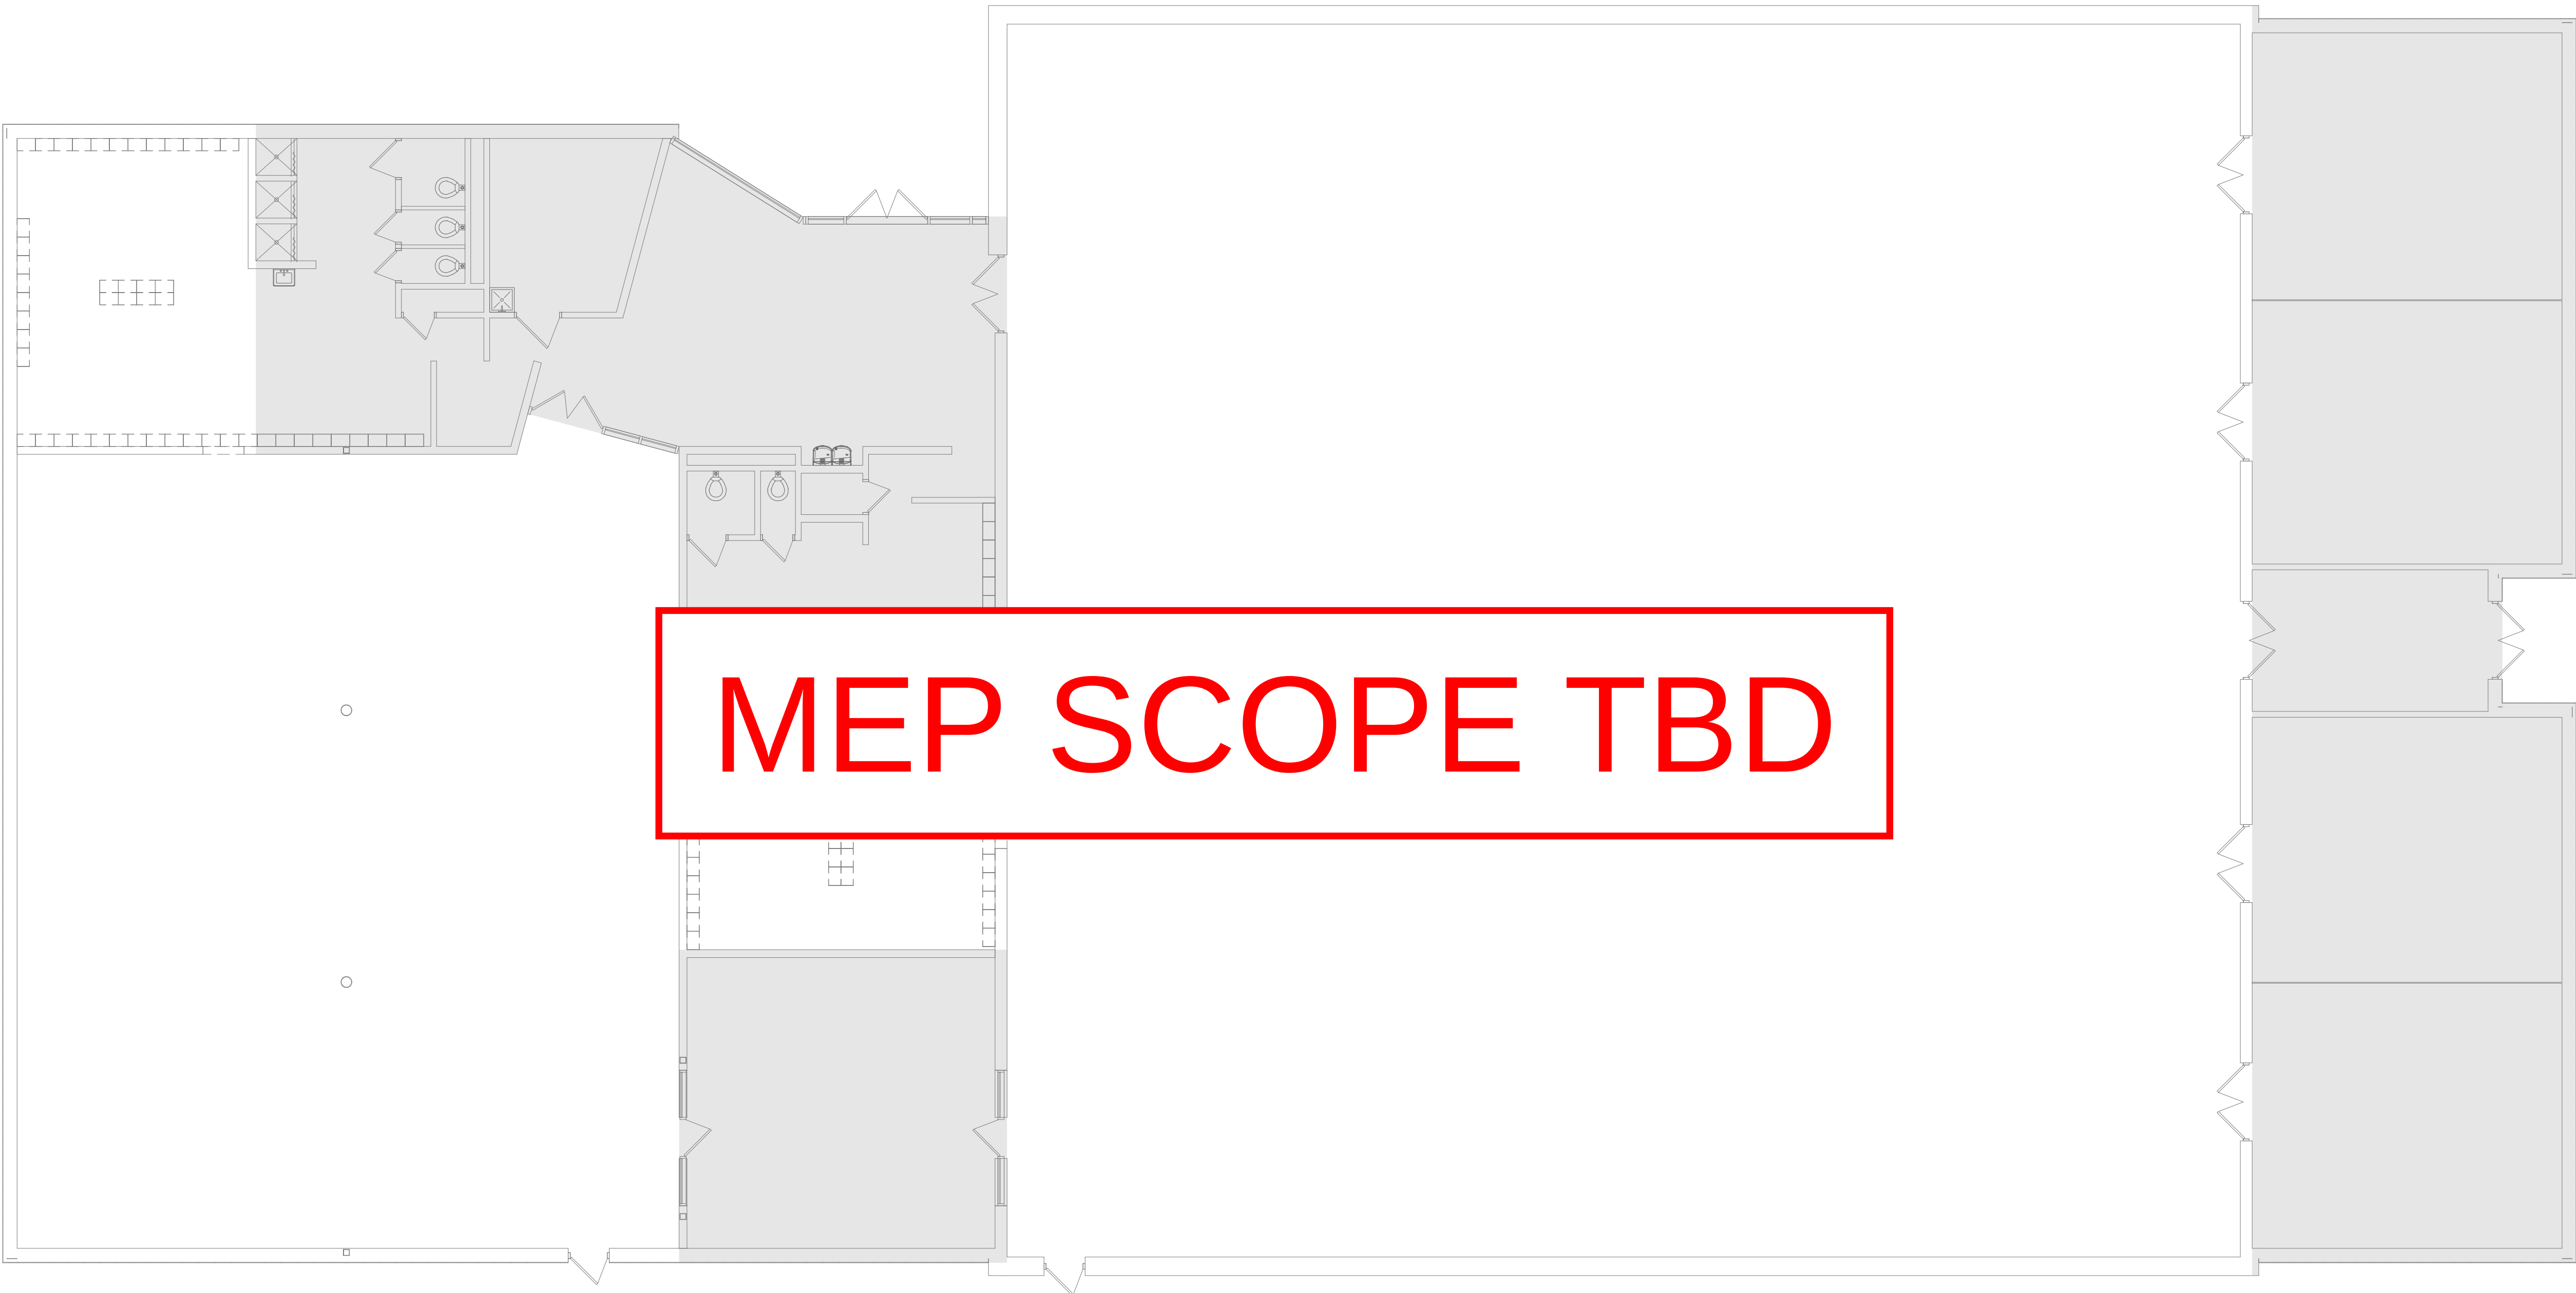


1 FIRST FLOOR DEMOLITON PLAN - ATHLETIC COMPLEX PLAN - MECHANICAL & PLUMBING

 SCALE: 1/8" = 1'-0"



KEY PLAN

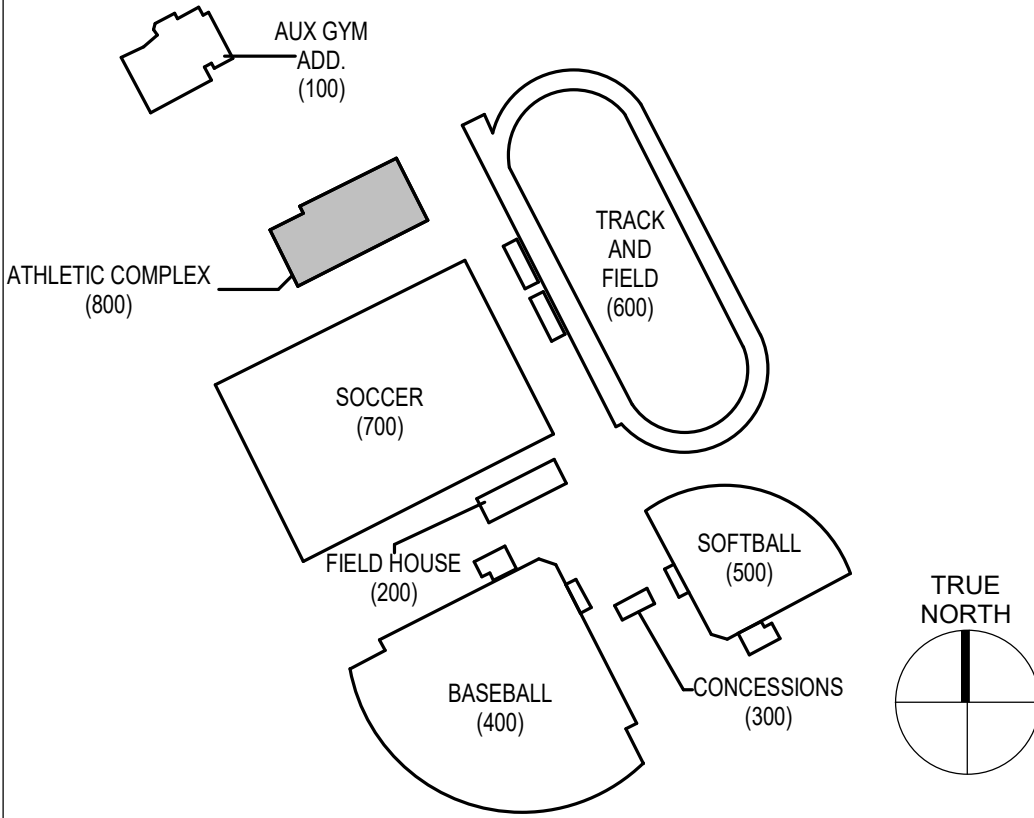


GENERAL NOTES

A. REFER TO SHEET P001 AND M001 FOR PLUMBING AND MECHANICAL LEGENDS AND GENERAL NOTES.

SHEET KEYNOTES

1. SHEET NOTES

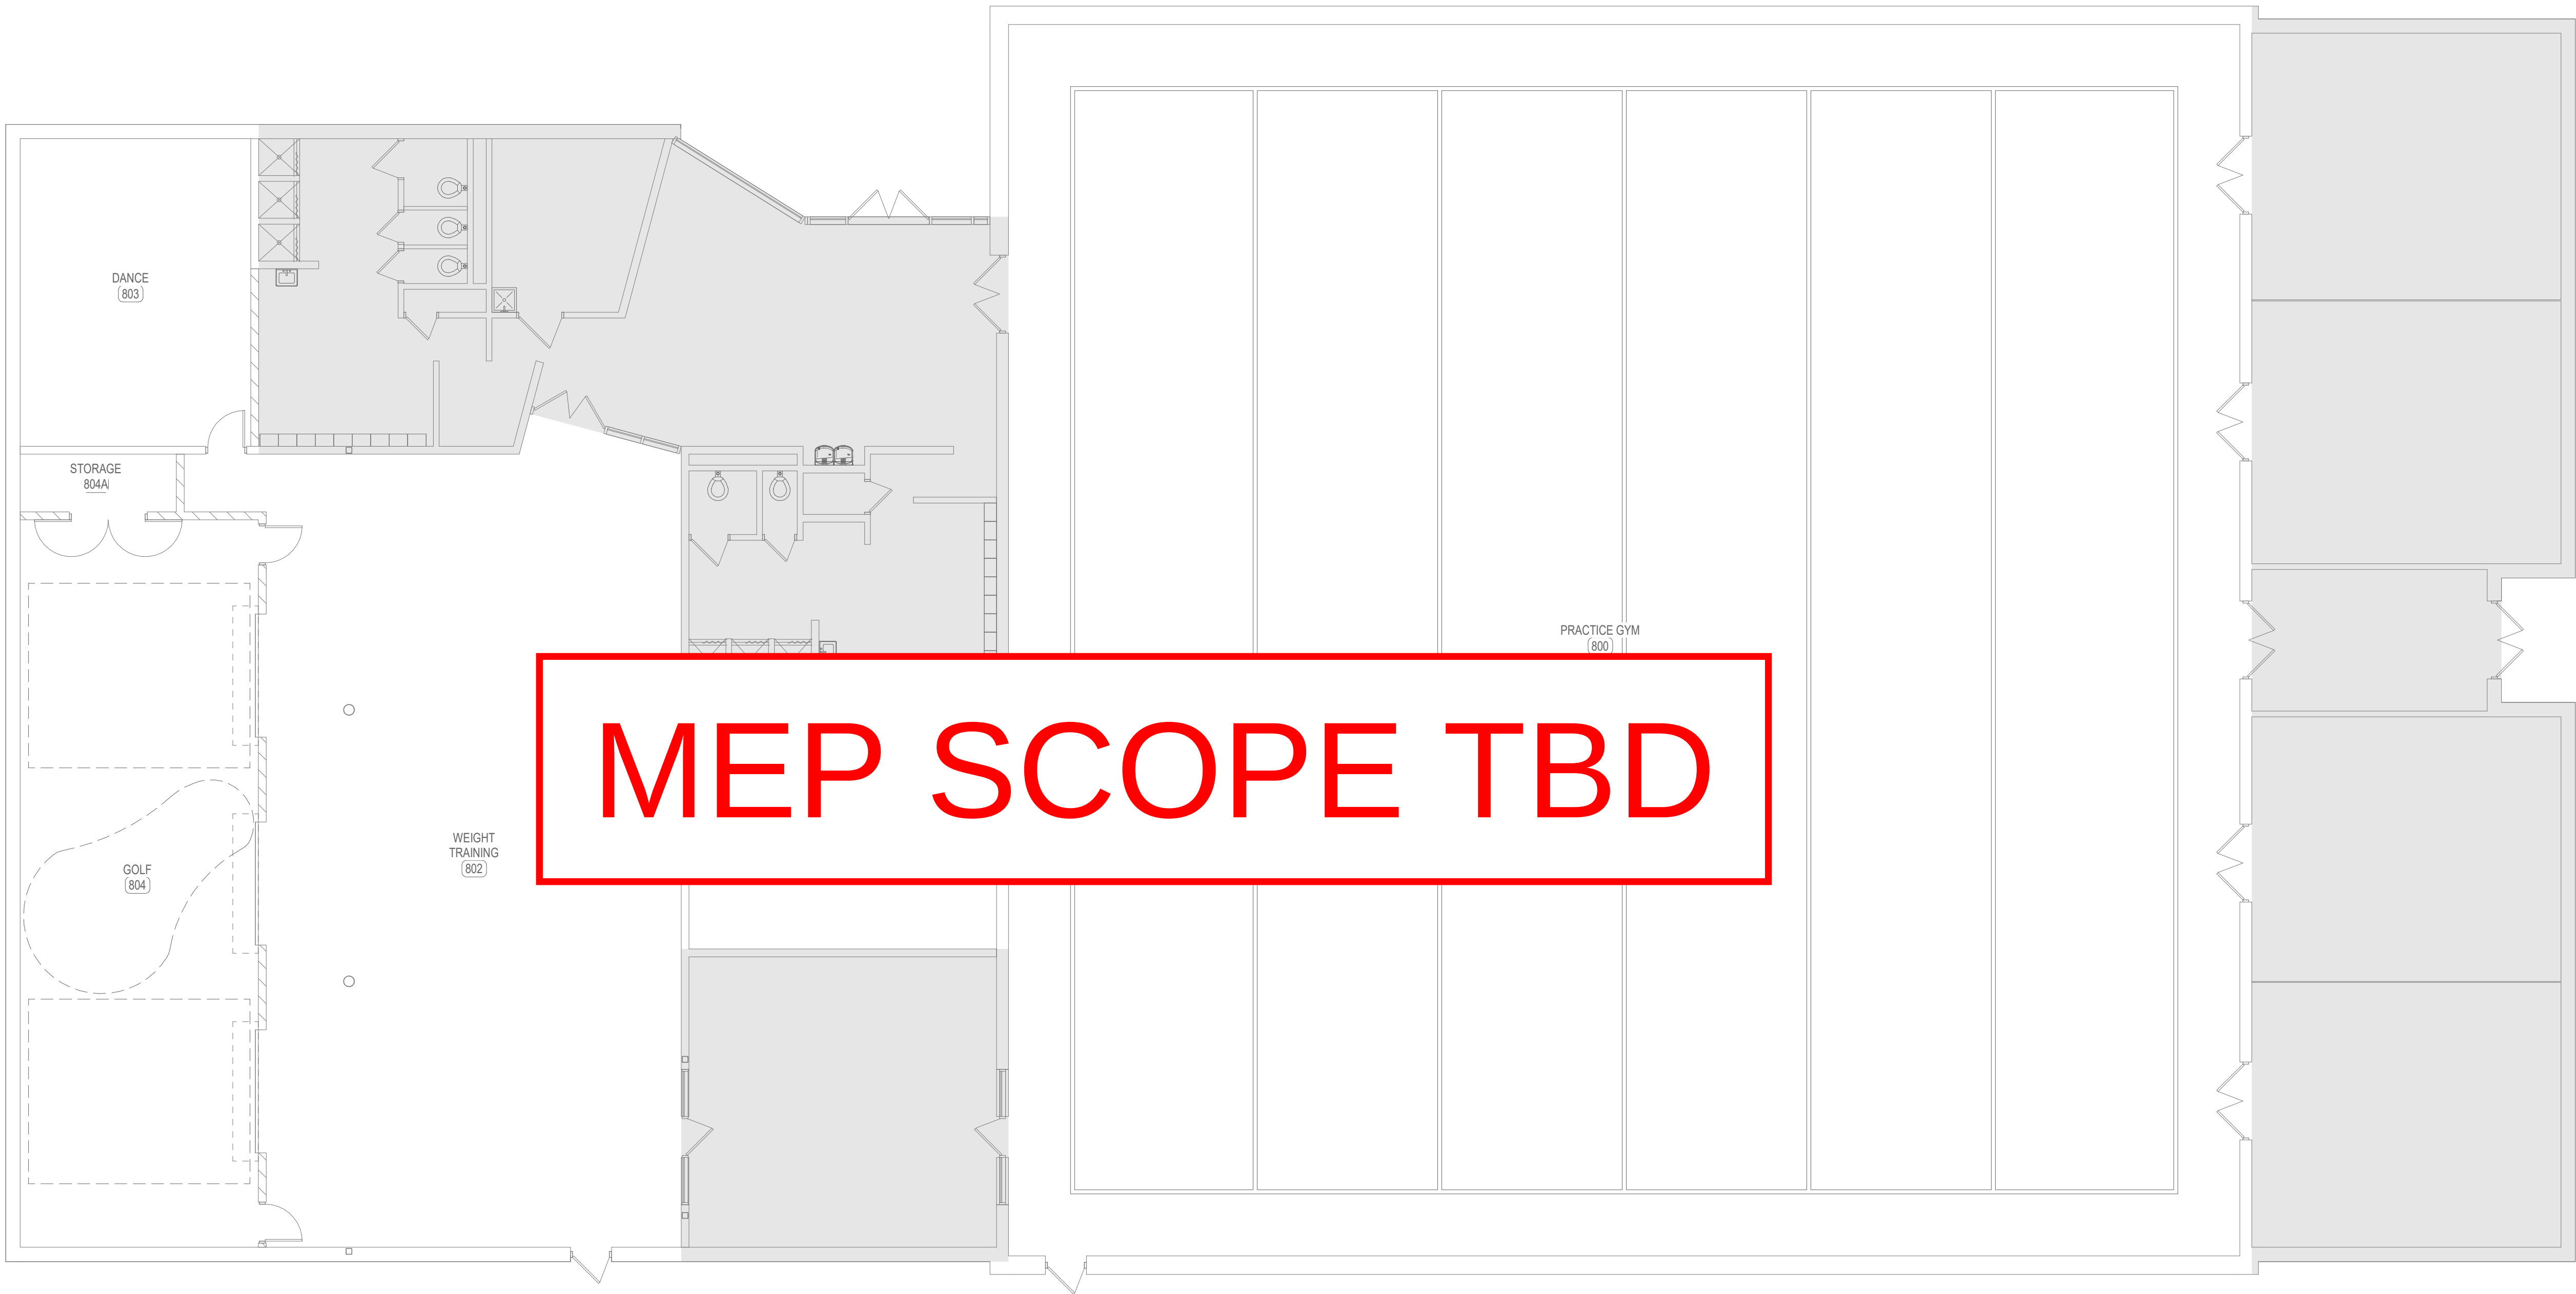


1 FIRST FLOOR PLAN - ATHLETICS COMPLEX PLAN - MECHANICAL & PLUMBING

SCALE: 1/8" = 1'-0"



KEY PLAN

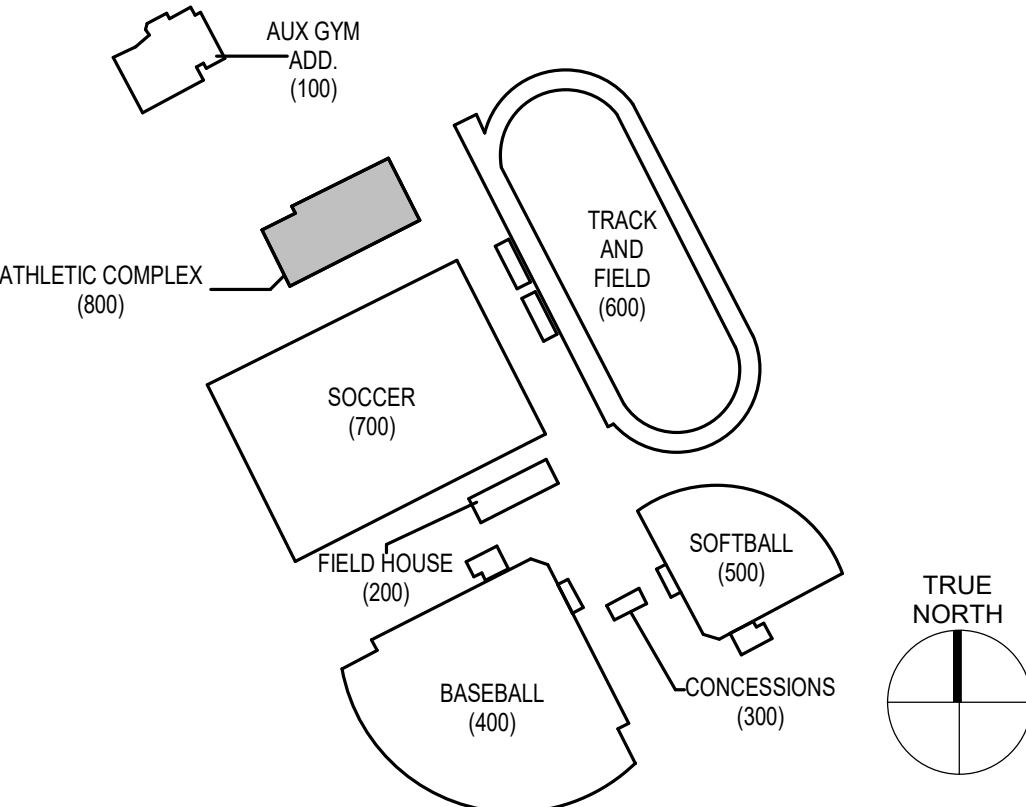

A. THE BUILDING SERVICES AND SYSTEMS SHALL REMAIN OPERATIONAL THROUGHOUT THE DURATION OF THE PROJECT. IF INTERRUPTIONS TO ANY SERVICE OR SYSTEM ARE NECESSARY TO FACILITATE COMPLETING THE PROJECT, THE CONTRACTOR SHALL:

- a. APPRISE THE OWNER OF ANTICIPATED INTERRUPTIONS IN ADVANCE AND SCHEDULE FOR TIMES THAT ARE CONVENIENT TO THE OWNER AND ALL OTHER AFFECTED PARTIES.
- b. COORDINATE AN ACCEPTABLE DURATION AND WORK AS NECESSARY TO MEET THE AGREED UPON SCHEDULE.
- c. NO INTERRUPTIONS SHALL OCCUR PRIOR TO RECEIVING WRITTEN APPROVAL FROM THE OWNER AND ALL OTHER AFFECTED PARTIES.
- d. FOR UNPLANNED INTERRUPTIONS, THE CONTRACTOR SHALL WORK CONTINUOUSLY TO RESTORE THE AFFECTED SERVICE(S) AND SYSTEM(S).

ELECTRICAL LEGEND

LIGHTING	
SYMBOL	DESCRIPTION
	SURFACE MOUNTED LUMINAIRE (NORMAL & EMERGENCY)
	RECESSED LUMINAIRE (NORMAL & EMERGENCY)
	WALL MOUNTED LUMINAIRE (NORMAL AND EMERGENCY)
	RECESSED LUMINAIRE (NORMAL AND EMERGENCY)
	SURFACE MOUNTED LUMINAIRE (NORMAL AND EMERGENCY)
	LINEAR PENDANT LUMINAIRE (NORMAL AND EMERGENCY)
	CIRCULAR LUMINAIRE (NORMAL AND EMERGENCY)
	WALL BRACKET LUMINAIRE (NORMAL AND EMERGENCY)
	INDUSTRIAL STRIP LUMINAIRE (NORMAL AND EMERGENCY)
	TRACK LUMINAIRE
	CEILING FAN
	TWO-HEAD EMERGENCY LIGHTING UNIT
	EMERGENCY REMOTE HEAD (SINGLE OR DOUBLE)
	EMERGENCY EXIT SIGN WITH COMBINATION EMERGENCY LUMINAIRE WALL AND CEILING MOUNT
	EMERGENCY EXIT SIGN - SINGLE FACE WITH ARROWS AS INDICATED WALL AND CEILING MOUNTED
	EMERGENCY EXIT SIGN - DOUBLE FACE
	POLE MOUNTED LUMINAIRE
	FLOOD OR SPOT LUMINAIRE
	BOLLARD OR POST TOP LUMINAIRE
	LIGHTING CONTROL RISER REFERENCE TAG
	PHOTOCELL
	EMERGENCY POWER PACK
	EMERGENCY BYPASS RELAY (UL924)
	EMERGENCY TRANSFER CONTROL (UL1008)
	BATTERY PACK
	LIGHTING CONTROL POWER PACK
	PORT INJECTOR
	LOW VOLTAGE LIGHTING RELAY PANEL
	PLUG LOAD CONTROL PACK
	ROOM CONTROLLER
	NETWORK BRIDGE
	SYSTEM CONTROLLER
	USER CONTROLLER
	POWER SUPPLY
	TIME CLOCK
	CONTACTOR, POLES AS REQUIRED
	R45 CONTROL WIRE SPLITTER
	DAYLIGHT SENSOR
	DUAL TECHNOLOGY LOW VOLTAGE CORNER MOUNTED OCCUPANCY SENSOR WITH POWER PACK AND CEILING MOUNT OR WALL MOUNT BRACKET AS SHOWN.
	DUAL TECHNOLOGY LOW VOLTAGE CEILING MOUNTED, 360° OCCUPANCY SENSOR.
	LIGHTING CONTROL PANEL
	LIGHT SWITCH - SUBSCRIPT INDICATES THE FOLLOWING : 3 - 3 WAY, 4 - 4 WAY, K - KEY OPERATED, D - DIMMER, OS - LINE VOLTAGE OCCUPANCY SENSOR, L - LOW VOLTAGE, M - MANUAL MOTOR STARTER W/ HANDLE GUARD KIT AND PADLOCK. SEE LIGHTING CONTROL DIAGRAM SHEET FOR OTHER SUBSCRIPTS.

ONE LINE DIAGRAM	
SYMBOL	DESCRIPTION
	CIRCUIT BREAKER
	GROUND FAULT PROTECTION
	VARIABLE FREQUENCY DRIVE
	DIGITAL MONITORING METER
	SURGE PROTECTION DEVICE
	DIGITAL METER DISPLAY
	POWER METERING DEVICE
	NON FUSED SWITCH
	FUSED SWITCH
	FUSE
	RELAY (NORMALLY OPEN)
	PANEL
	DOUBLE THROW SWITCH OR TRANSFER SWITCH

POWER	
SYMBOL	DESCRIPTION
	TAMPER RESISTANT DUPLEX RECEPTACLE - SUBSCRIPT INDICATES THE FOLLOWING: C - INSTALL 4 INCHES ABOVE COUNTER OR BACKSPLASH, CM - CEILING MOUNTED, E - EMERGENCY, G - GROUND FAULT CIRCUIT INTERRUPTER, GB - BLANK FACE GROUND FAULT INTERRUPT, IG - ISOLATED GROUND, P - SPLIT-WIRED PLUG LOAD CONTROL, WP - WEATHER PROOF, U - WITH USB PORT
	TAMPER RESISTANT QUADRIPLEX RECEPTACLE
	TAMPER RESISTANT SINGLE RECEPTACLE
	TAMPER RESISTANT SPECIAL PURPOSE RECEPTACLE
	TAMPER RESISTANT PEDESTAL MOUNTED RECEPTACLE
	TAMPER RESISTANT FLOOR MOUNTED RECEPTACLE AND COVERPLATE. SEE PLAN FOR CONFIGURATION.
	POKE THRU BOX
	COMBO POKE THRU BOX
	COMBINATION FLOOR BOX WITH THREE DUPLEX RECEPTACES AND R45 DATA JACKS. PROVIDE WITH COVERPLATE. INSTALL CATEGORY UTP WET LOCATION CABLES IN A 1 INCH CONDUIT FROM THE DATA COMPARTMENT TO THE NEAREST MDF OR IDF (X - INDICATES THE NUMBER OF JACKS AND CABLES)
	EMERGENCY SHUT-OFF BUTTON
	JUNCTION BOX
	HAND DRYER
	SAFETY SWITCH (SIZE/FUSING/POLES/NEMA - OPTIONAL)
	ENCLOSED CIRCUIT BREAKER DISCONNECT (SIZE/POLES/NEMA - OPTIONAL)
	COMBINATION MOTOR STARTER AND DISCONNECT (SIZE/FUSING/POLES/NEMA - OPTIONAL)
	MOTOR STARTER (SIZE/FUSING/POLES/NEMA - OPTIONAL)
	VARIABLE FREQUENCY DRIVE
	MOTOR
	CORD REEL
	CONDUIT TURNED DOWN
	CONDUIT TURNED UP
	CONDUIT WITH END CAP
	EQUIPMENT CONNECTION
	CONDUIT CONTINUATION
	TRANSFORMER, X - INDICATES IDENTIFICATION
	SURFACE MOUNTED PANELBOARD/DISTRIBUTION PANEL/AUTOMATIC TRANSFER SWITCH, X - INDICATES IDENTIFICATION
	FLUSH MOUNTED PANELBOARD, X - INDICATES IDENTIFICATION
	EXISTING SURFACE MOUNTED PANELBOARD/DISTRIBUTION PANEL, X - INDICATES IDENTIFICATION
	EXISTING FLUSH MOUNTED PANELBOARD, X - INDICATES IDENTIFICATION
	GROUND ROD
	LOW-VOLTAGE CIRCUIT WITH CONDUCTOR TYPES AS REQUIRED BY THE MANUFACTURER FOR THE PARTICULAR SYSTEM.
	UTP LIGHTING CONTROL CABLE
	CIRCUIT CONNECTED TO EMERGENCY POWER
	SURFACE MOUNTED RACEWAY
	BRANCH CIRCUIT HOMERUN TO PANELBOARD. THE NUMBER OF TICK MARKS INDICATES THE NUMBER OF CONDUCTORS. LONG TICK MARKS REPRESENT UNGROUNDED CONDUCTORS. SHORT TICK MARKS REPRESENT GROUNDED CONDUCTORS (NEUTRAL). A GROUNDING CONDUCTOR (GROUND) SHALL BE INSTALLED WITH ALL CIRCUITS. TICK MARKS AND CONDUCTOR SIZES ARE ONLY SHOWN ON THE HOMERUN. INSTALL THE REQUIRED QUANTITY AND SIZE CONDUCTORS TO EACH DEVICE ON THE SAME CIRCUIT AS INDICATED ON THE DRAWINGS. MINIMUM CONDUCTOR SIZE = #12. MINIMUM CONDUIT SIZE = 3/4 INCH. SUBSCRIPT EXAMPLE: 4#8 = (3) UNGROUNDED AND (1) NEUTRAL CONDUCTORS SIZE IF OTHER THAN #12. 1#10 = GROUNDING CONDUCTOR SIZE IF OTHER THAN #12. 1" = CONDUIT SIZE. A-1 = PANEL NAME - POLE POSITION IN PANEL.
	ELECTRICAL METER
	EXISTING UTILITY POLE
	NEW UTILITY POLE
	NEW UTILITY POLE WITH POLE MOUNTED TRANSFORMERS
	EXISTING UTILITY POLE WITH POLE MOUNTED TRANSFORMERS

DEMOLITION vs EXISTING LINE WEIGHTS	
DEMO	EXISTING

	3 POSITION SELECTOR SWITCH: LOCAL-OFF-REMOTE HAND-OFF-AUTOMATIC
	GROUND
	ELECTRIC HEATER

FIRE ALARM	
SYMBOL	DESCRIPTION
	FIRE ALARM MANUAL PULL STATION
	FIRE ALARM NOTIFICATION DEVICE (WALL & CEILING) - SUBSCRIPT INDICATES THE FOLLOWING : S - STROBE, SS - SPEAKER STROBE, H - HORN, HS - HORN STROBE, SP - SPEAKER
	FIRE ALARM INITIATION DEVICE (WALL & CEILING) - SUBSCRIPT INDICATES THE FOLLOWING : S - SMOKE, H - HEAT, CO - CARBON MONOXIDE, CS - COMBINATION CARBON MONOXIDE/SMOKE, CH - COMBINATION CARBON MONOXIDE/HEAT
	FIRE ALARM INITIATION AND NOTIFICATION DEVICE (WALL & CEILING) - SUBSCRIPT INDICATES THE FOLLOWING : SS - COMBINATION SMOKE DETECTOR/SOUNDER BASE
	FIRE ALARM DUCT TYPE SMOKE DETECTOR - SUBSCRIPT INDICATES EQUIPMENT IDENTIFICATION TAG
	MAGNETIC DOOR HOLDER (WALL & CEILING)
	FIRE ALARM TAMPER SWITCH
	FIRE ALARM FLOW SWITCH
	FIRE ALARM AIR PRESSURE SWITCH
	FIRE ALARM CONTROL PANEL. PANEL IS RECESSED TYPE WHEN SHOWN WITHIN WALLS ON DRAWING.
	FIRE ALARM ANNUNCIATOR. PANEL IS RECESSED TYPE WHEN SHOWN WITHIN WALLS ON DRAWING.

SYSTEMS	
SYMBOL	DESCRIPTION
	EXISTING COMMUNICATIONS OUTLET
	DATA OUTLET FOR WIRELESS ACCESS POINT WITH TWO RJ45 DATA JACKS WITH TWO UTP CABLES IN SURFACE RACEWAY, 1 INCH CONDUIT, OR CABLE TRAY TO THE NEAREST MDF OR IDF (W - INDICATES THE NUMBER OF VOICE JACKS AND CABLES, #D - INDICATES THE NUMBER OF DATA JACKS AND CABLES), C - INSTALL 4 INCHES ABOVE COUNTER OR BACKSPLASH, CS - CEILING MOUNTED
	PEDESTAL MOUNTED VOICE/DATA OUTLET WITH #VOICE AND # DATA JACKS AND # RJ45 DATA JACKS AND # UTP WET LOCATION CABLES IN A 1 INCH CONDUIT TO THE NEAREST MDF OR IDF (W - INDICATES THE NUMBER OF VOICE JACKS AND CABLES, #D - INDICATES THE NUMBER OF DATA JACKS AND CABLES)
	FLOOR BOX WITH # RJ45 DATA JACKS. PROVIDE WITH COVERPLATE. INSTALL # UTP WET LOCATION CABLES IN A 1 INCH CONDUIT FROM THE DATA COMPARTMENT TO THE NEAREST MDF OR IDF (# - INDICATES THE NUMBER OF JACKS AND CABLES)
	MULTIMEDIA OUTLET. 4-11/16 INCHES OUTLET BOX WITH TWO 1-1/4 INCH CONDUITS TO ABOVE ACCESSIBLE CEILING. (WALL & CEILING)
	VGA/CA OUTLET WITH ONE VGA CONNECTOR AND TWO RCA CONNECTORS. INSTALL CABLES IN SURFACE RACEWAY, 1-1/4 INCH CONDUIT, J-HOOKS OR CABLE TRAY. THE VGA CABLE MUST BE RAPID RUN TYPE WITH REMOVABLE LEADS OR APPROVED EQUAL.
	TELEVISION OUTLET WITH ONE F-TYPE CONNECTOR WITH COAXIAL CABLE IN SURFACE RACEWAY, 3/4 INCH CONDUIT, OR CABLE TRAY TO THE TELEVISION DISTRIBUTION SYSTEM
	PROJECTOR (CEILING & WALL MOUNT)
	ADMINISTRATIVE CONTROL CENTER. CONNECT TO THE INTERCOM SYSTEM AS REQUIRED.
	DOOR RELEASE BUTTON
	INTERCOM SPEAKER (CEILING; RECESSED WALL-MOUNTED; HORN-TYPE WALL MOUNT)
	INTERCOM SPEAKER WITH INTEGRAL VOLUME CONTROL (CEILING & WALL MOUNT)
	SELF-AMPLIFIED SPEAKER (CEILING & WALL MOUNT)
	SOUND SYSTEM SPEAKER (SC - CAFETERIA; SG - GYMNASIUM; SM - MEDIA CENTER)
	SPEAKER VOLUME CONTROL
	SINGLE SIDED CLOCK (DIGITAL & ANALOG)
	DOUBLE SIDED CLOCK (DIGITAL & ANALOG)
	MICROPHONE OUTLET
	AUXILIARY INPUT OUTLET FOR THE LOCAL SOUND SYSTEM
	INTERCOM CALL BUTTON
	CABLE TRAY. MINIMUM DIMENSIONS AS INDICATED ON DRAWINGS.
	J-HOOK PATHWAY
	FLOOR MOUNTED FOUR POST DATA RACK, 84 INCHES TALL, 30 INCHES DEEP, WITH VERTICAL WIRE MANAGEMENT.
	FLOOR MOUNTED TWO POST DATA RACK, 84 INCHES TALL, 30 INCHES DEEP, WITH VERTICAL WIRE MANAGEMENT.
	DOORBELL PUSH BUTTON
	DOORBELL AUDIO/VISUAL NOTIFICATION DEVICE
	SECURITY SYSTEM SIREN
	SECURITY INTERCOM STATION
	SECURITY SYSTEM KEY PAD
	SECURITY SYSTEM CARD READER
	SECURITY SYSTEM AUDIO SENSOR
	SECURITY SYSTEM MOTION DETECTOR (CEILING & WALL); X - DEGREE OF MOTION
	CEILING MOUNTED SECURITY SYSTEM CAMERA
	WALL MOUNTED SECURITY SYSTEM CAMERA
	DOOR CONTACT/POSITION SWITCH
	PRESS PLATE FOR AUTOMATIC DOOR OPERATOR
	ACCESS POINTS WITH ELECTRIFIED DOOR HARDWARE
	SOUND SYSTEM ANTENNA


ABBREVIATIONS	
±10'	+10' INDICATES THE MOUNTING HEIGHT OF THE DEVICE TO BOTTOM.
1Ø	1-PHASE
3Ø	3-PHASE
ATS	AUTOMATIC TRANSFER SWITCH
BTM	BOTTOM
CT	CURRENT TRANSFORMER
EOE	EXISTING OVERHEAD ELECTRIC
EOF	EXISTING OVERHEAD FIBER OPTIC
EOP	EXISTING OVERHEAD PRIMARY
EOS	EXISTING OVERHEAD SECONDARY
EOT	EXISTING OVERHEAD TELEPHONE
EUE	EXISTING UNDERGROUND ELECTRIC
EUF	EXISTING UNDERGROUND FIBER OPTIC
EUP	EXISTING UNDERGROUND PRIMARY
EUS	EXISTING UNDERGROUND SECONDARY
EUT	EXISTING UNDERGROUND TELEPHONE
EOTV	EXISTING OVERHEAD TELEVISION
EUTV	EXISTING UNDERGROUND TELEVISION
GF	GROUND FAULT PROTECTION
GND	GROUND
KWH	KILO WATT HOUR
OE	OVERHEAD ELECTRIC
OF	OVERHEAD FIBER OPTIC
OP	OVERHEAD PRIMARY
OS	OVERHEAD SECONDARY
OT	OVERHEAD TELEPHONE
OTV	OVERHEAD TELEVISION
PT	POTENTIAL TRANSFORMER
SPD	SURGE PROTECTIVE DEVICE
UE	UNDERGROUND ELECTRIC
UF	UNDERGROUND FIBER OPTIC
UP	UNDERGROUND PRIMARY
US	UNDERGROUND SECONDARY
UT	UNDERGROUND TELEPHONE
UTP	UNSHIELDED TWISTED PAIR
UTV	UNDERGROUND TELEVISION
WG	PROVIDE DEVICE WITH MANUFACTURER'S WIREGUARD.
WP	PROVIDE DEVICE WITH WEATHERPROOF COVER. RECEPTACLES TO BE WEATHER-RESISTANT TYPE AND PROVIDED WITH A CAST ALUMINUM, EXTRA DUTY, WHILE-IN-USE COVER.

ELECTRICAL DEVICE MOUNTING HEIGHTS	
SWITCHES	48 INCHES TO TOP
INTERIOR RECEPTACLES	16 INCHES TO BOTTOM
EXTERIOR RECEPTACLES	24 INCHES TO BOTTOM
COMMUNICATIONS / DATA OUTLETS	16 INCHES TO BOTTOM
FIRE ALARM MANUAL PULL STATIONS	48 INCHES TO TOP
FIRE ALARM HORN/STROBE SIGNAL	80 INCHES TO BOTTOM
FIRE ALARM STROBE SIGNAL	80 INCHES TO BOTTOM
WALL TELEPHONES	48 INCHES TO TOP
TELEVISION OUTLETS	72 INCHES TO BOTTOM
CLOCKS	96 INCHES TO TOP
NOTE: MOUNTING HEIGHTS UNLESS OTHERWISE NOTED ON DRAWINGS.	

2459 ALLEN COUNTY - SCOTTSTVILLE HIGH SCHOOL ATHLETIC COMPLEX
Autodesk Docs: 02459 Allen County Athletic Fields and Facilities/2008-Allen Co. V08 MEP.nt
11/14/2025 4:25:42 PM

1 FIRST FLOOR PLAN - AUXILIARY GYMNASIUM ADDITION - DEMOLITION

SCALE: 1/8" = 1'-0"

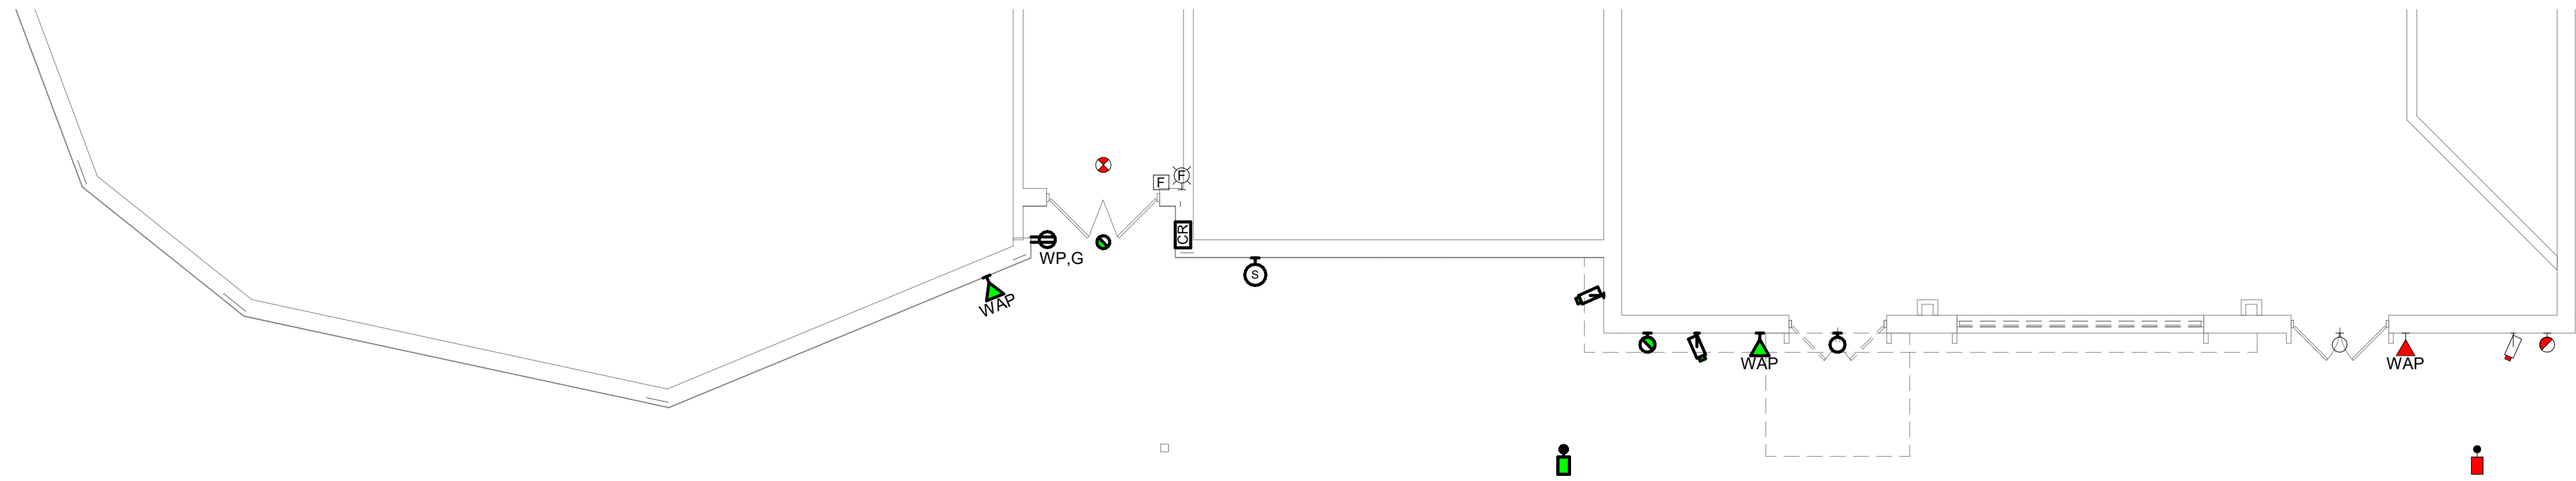


GENERAL NOTES

A. REFER TO SHEET XXX FOR GENERAL NOTES.

SHEET KEYNOTES

1. SHEET NOTES

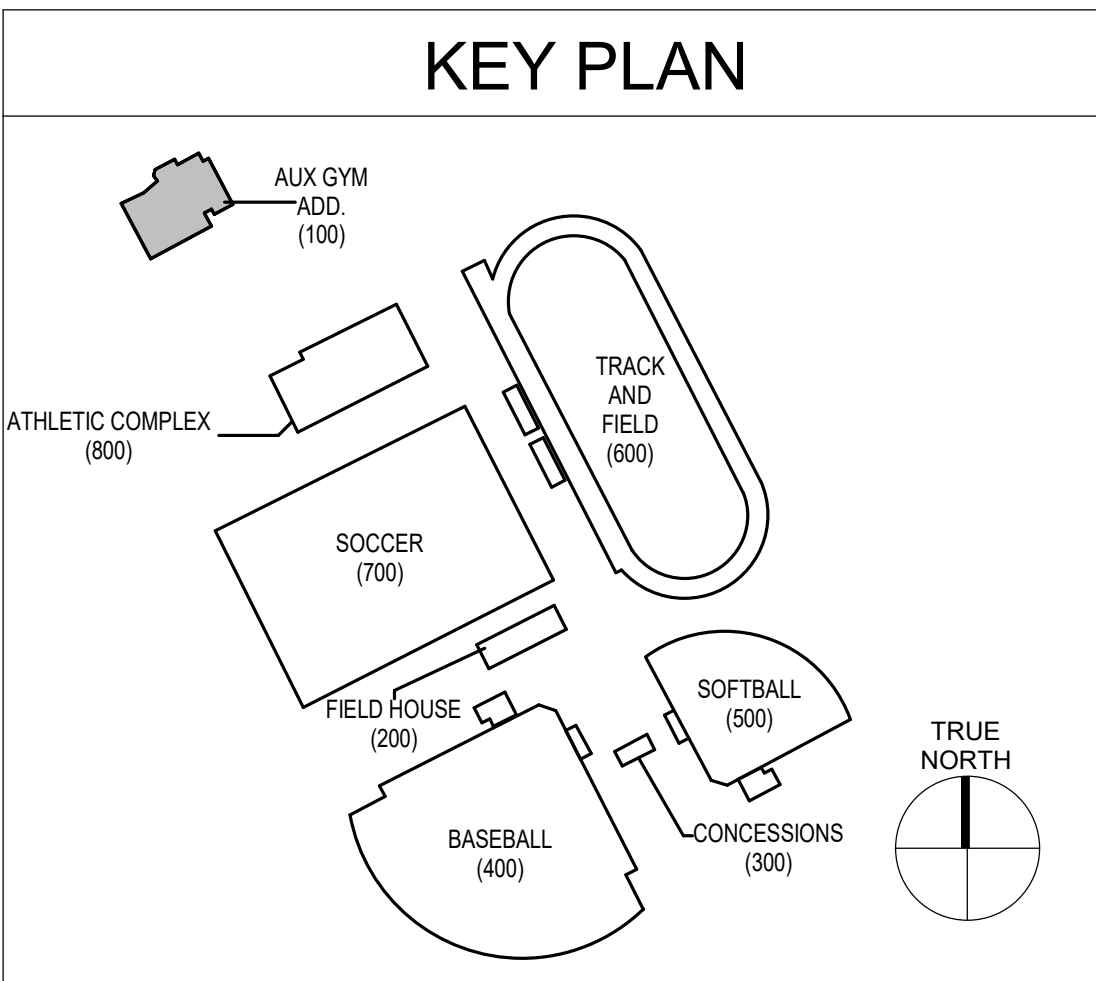

JOB NO.	2459
DATE	NOV 17, 2025
DRAWN	STAFF
CHECKED	JWH

COPYRIGHT © 2025
SHERMAN CARTER BARNHART
ARCHITECTS, PLLC

REVISIONS		
No.	Description	Date


SHEET
ED100



**SHROUT
TATE
MECHANICAL AND
ELECTRICAL ENGINEERS
WILSON**
Lexington - Louisville - Charleston
www.steweg.com

**ALLEN COUNTY - SCOTTSTVILLE
HIGH SCHOOL ATHLETIC
COMPLEX**
SCOTTSTVILLE, KENTUCKY

**AUXILIARY GYMNASIUM ADDITION -
ELECTRICAL DEMOLITION**

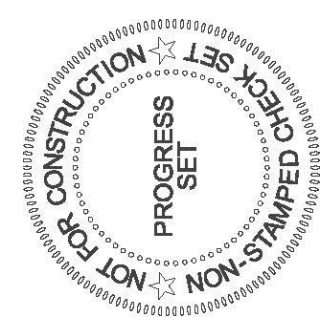


FOR CONSTRUCTION
PROGRESS SET
NON-STAMPED



**SHERMAN
CARTER
BARNHART**
ARCHITECTS

2459 ALLEN COUNTY - SCOTTSTVILLE HIGH SCHOOL ATHLETIC COMPLEX
Autodesk Docs: 2459 Allen County Athletic Fields and Facilities/25008-Allen Co. V08 MEP.rvt
11/14/2025 4:23:44 PM

1 FIRST FLOOR PLAN - AUXILIARY GYMNASIUM ADDITION - LIGHTING
SCALE: 1/8" = 1'-0"

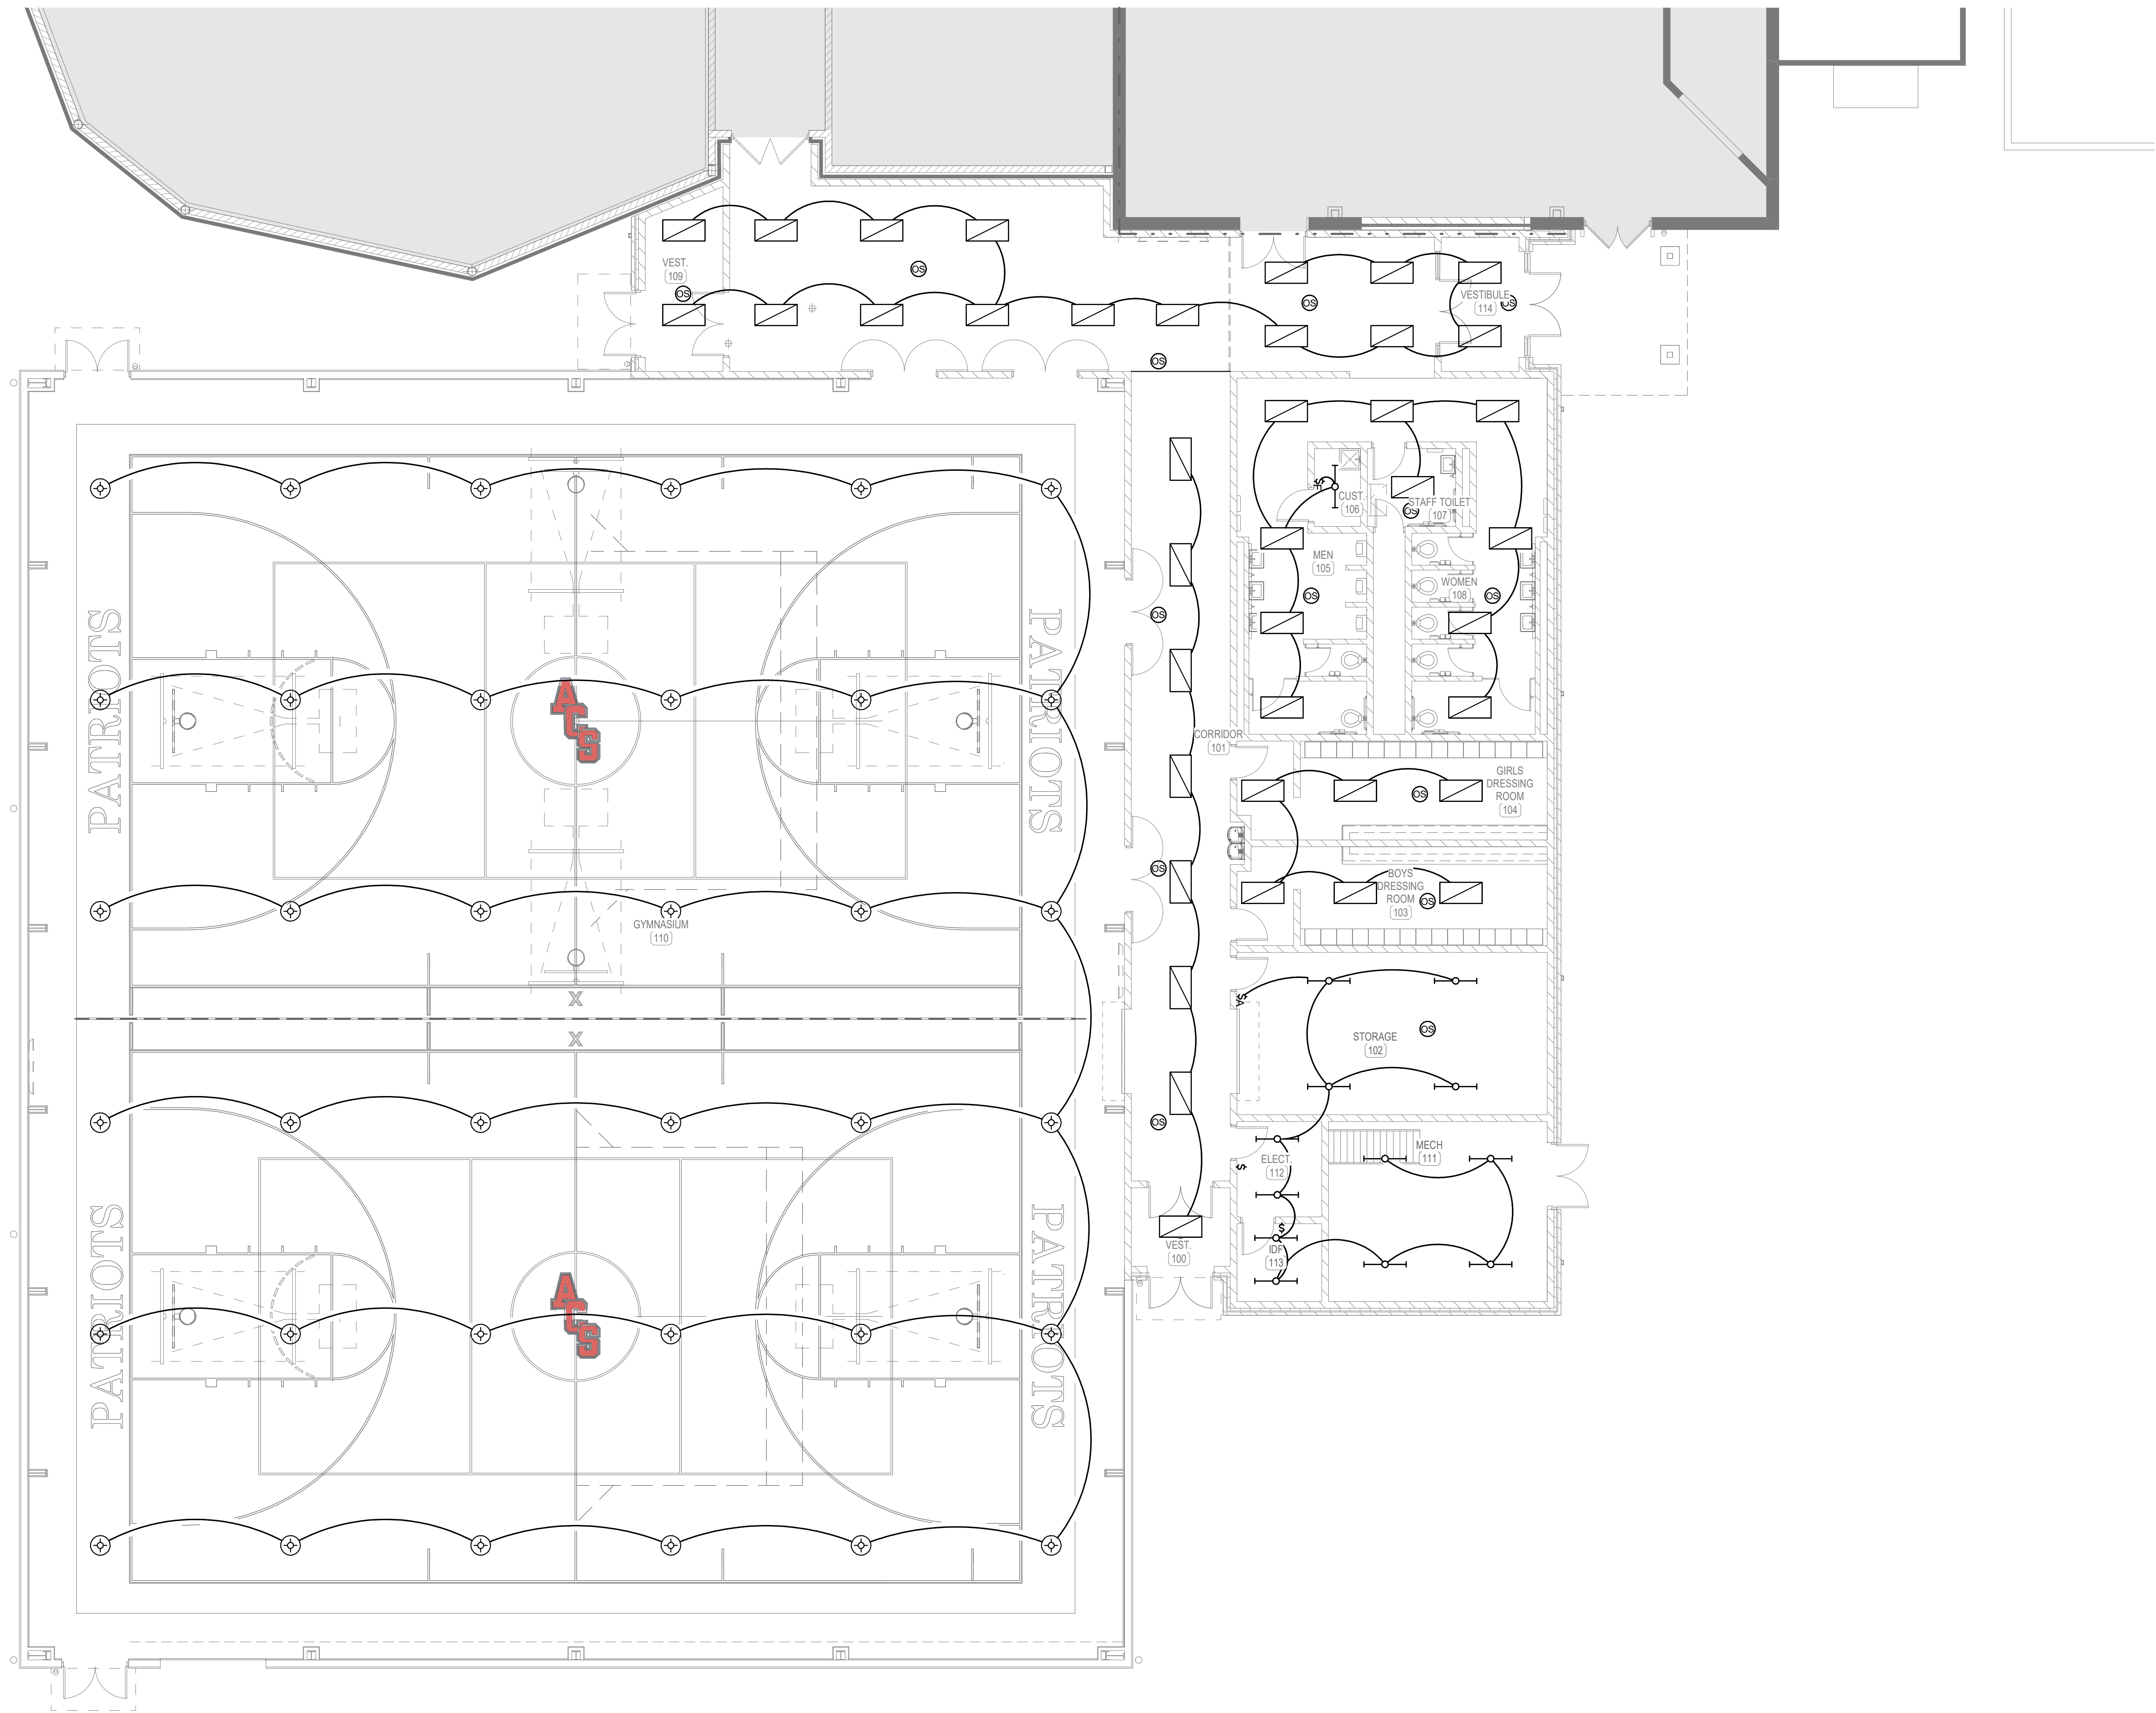

0 4' 8' 16'


GENERAL NOTES

A. REFER TO SHEET XXX FOR GENERAL NOTES.

SHEET KEYNOTES

1. SHEET NOTES


KEY PLAN

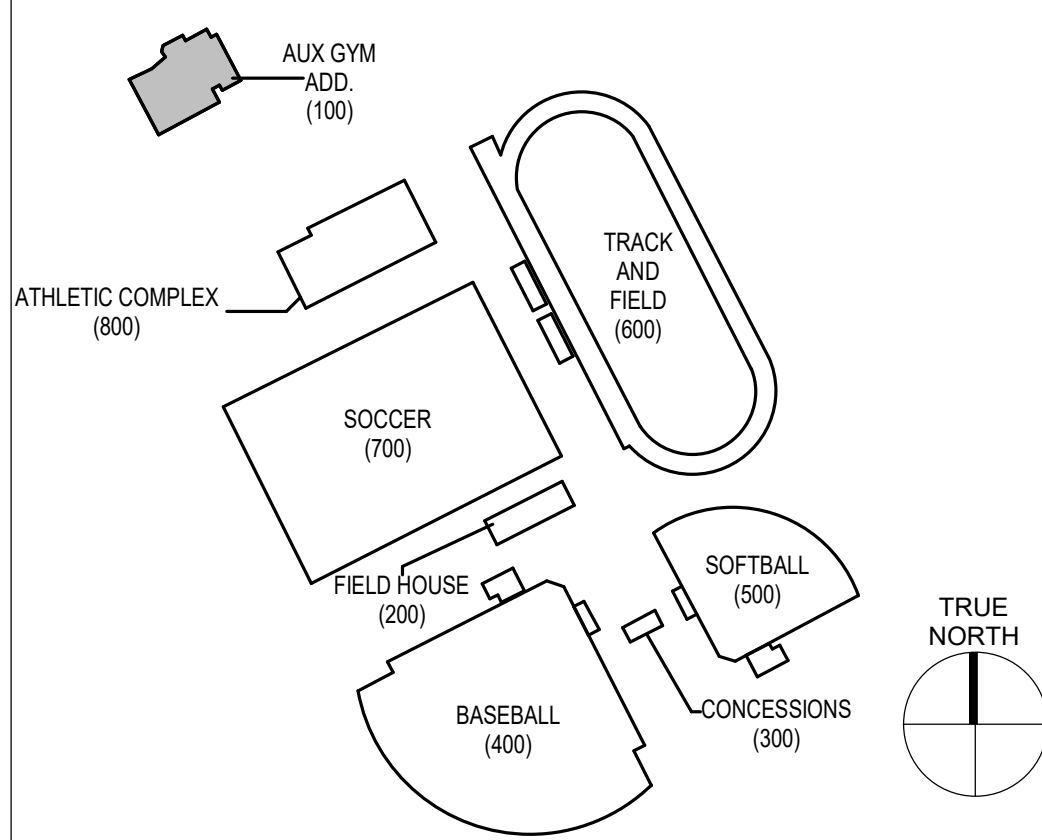

2459 ALLEN COUNTY - SCOTTSTVILLE HIGH SCHOOL ATHLETIC COMPLEX
AutoDesk Docs: 2459 Allen County Athletic Fields and Facilities 2508 Allen Co. V08 MEP.rvt
11/14/2025 4:25:45 PM

1 FIRST FLOOR PLAN - AUXILIARY GYMNASIUM ADDITION - POWER AND SYSTEMS

SCALE: 1/8" = 1'-0"

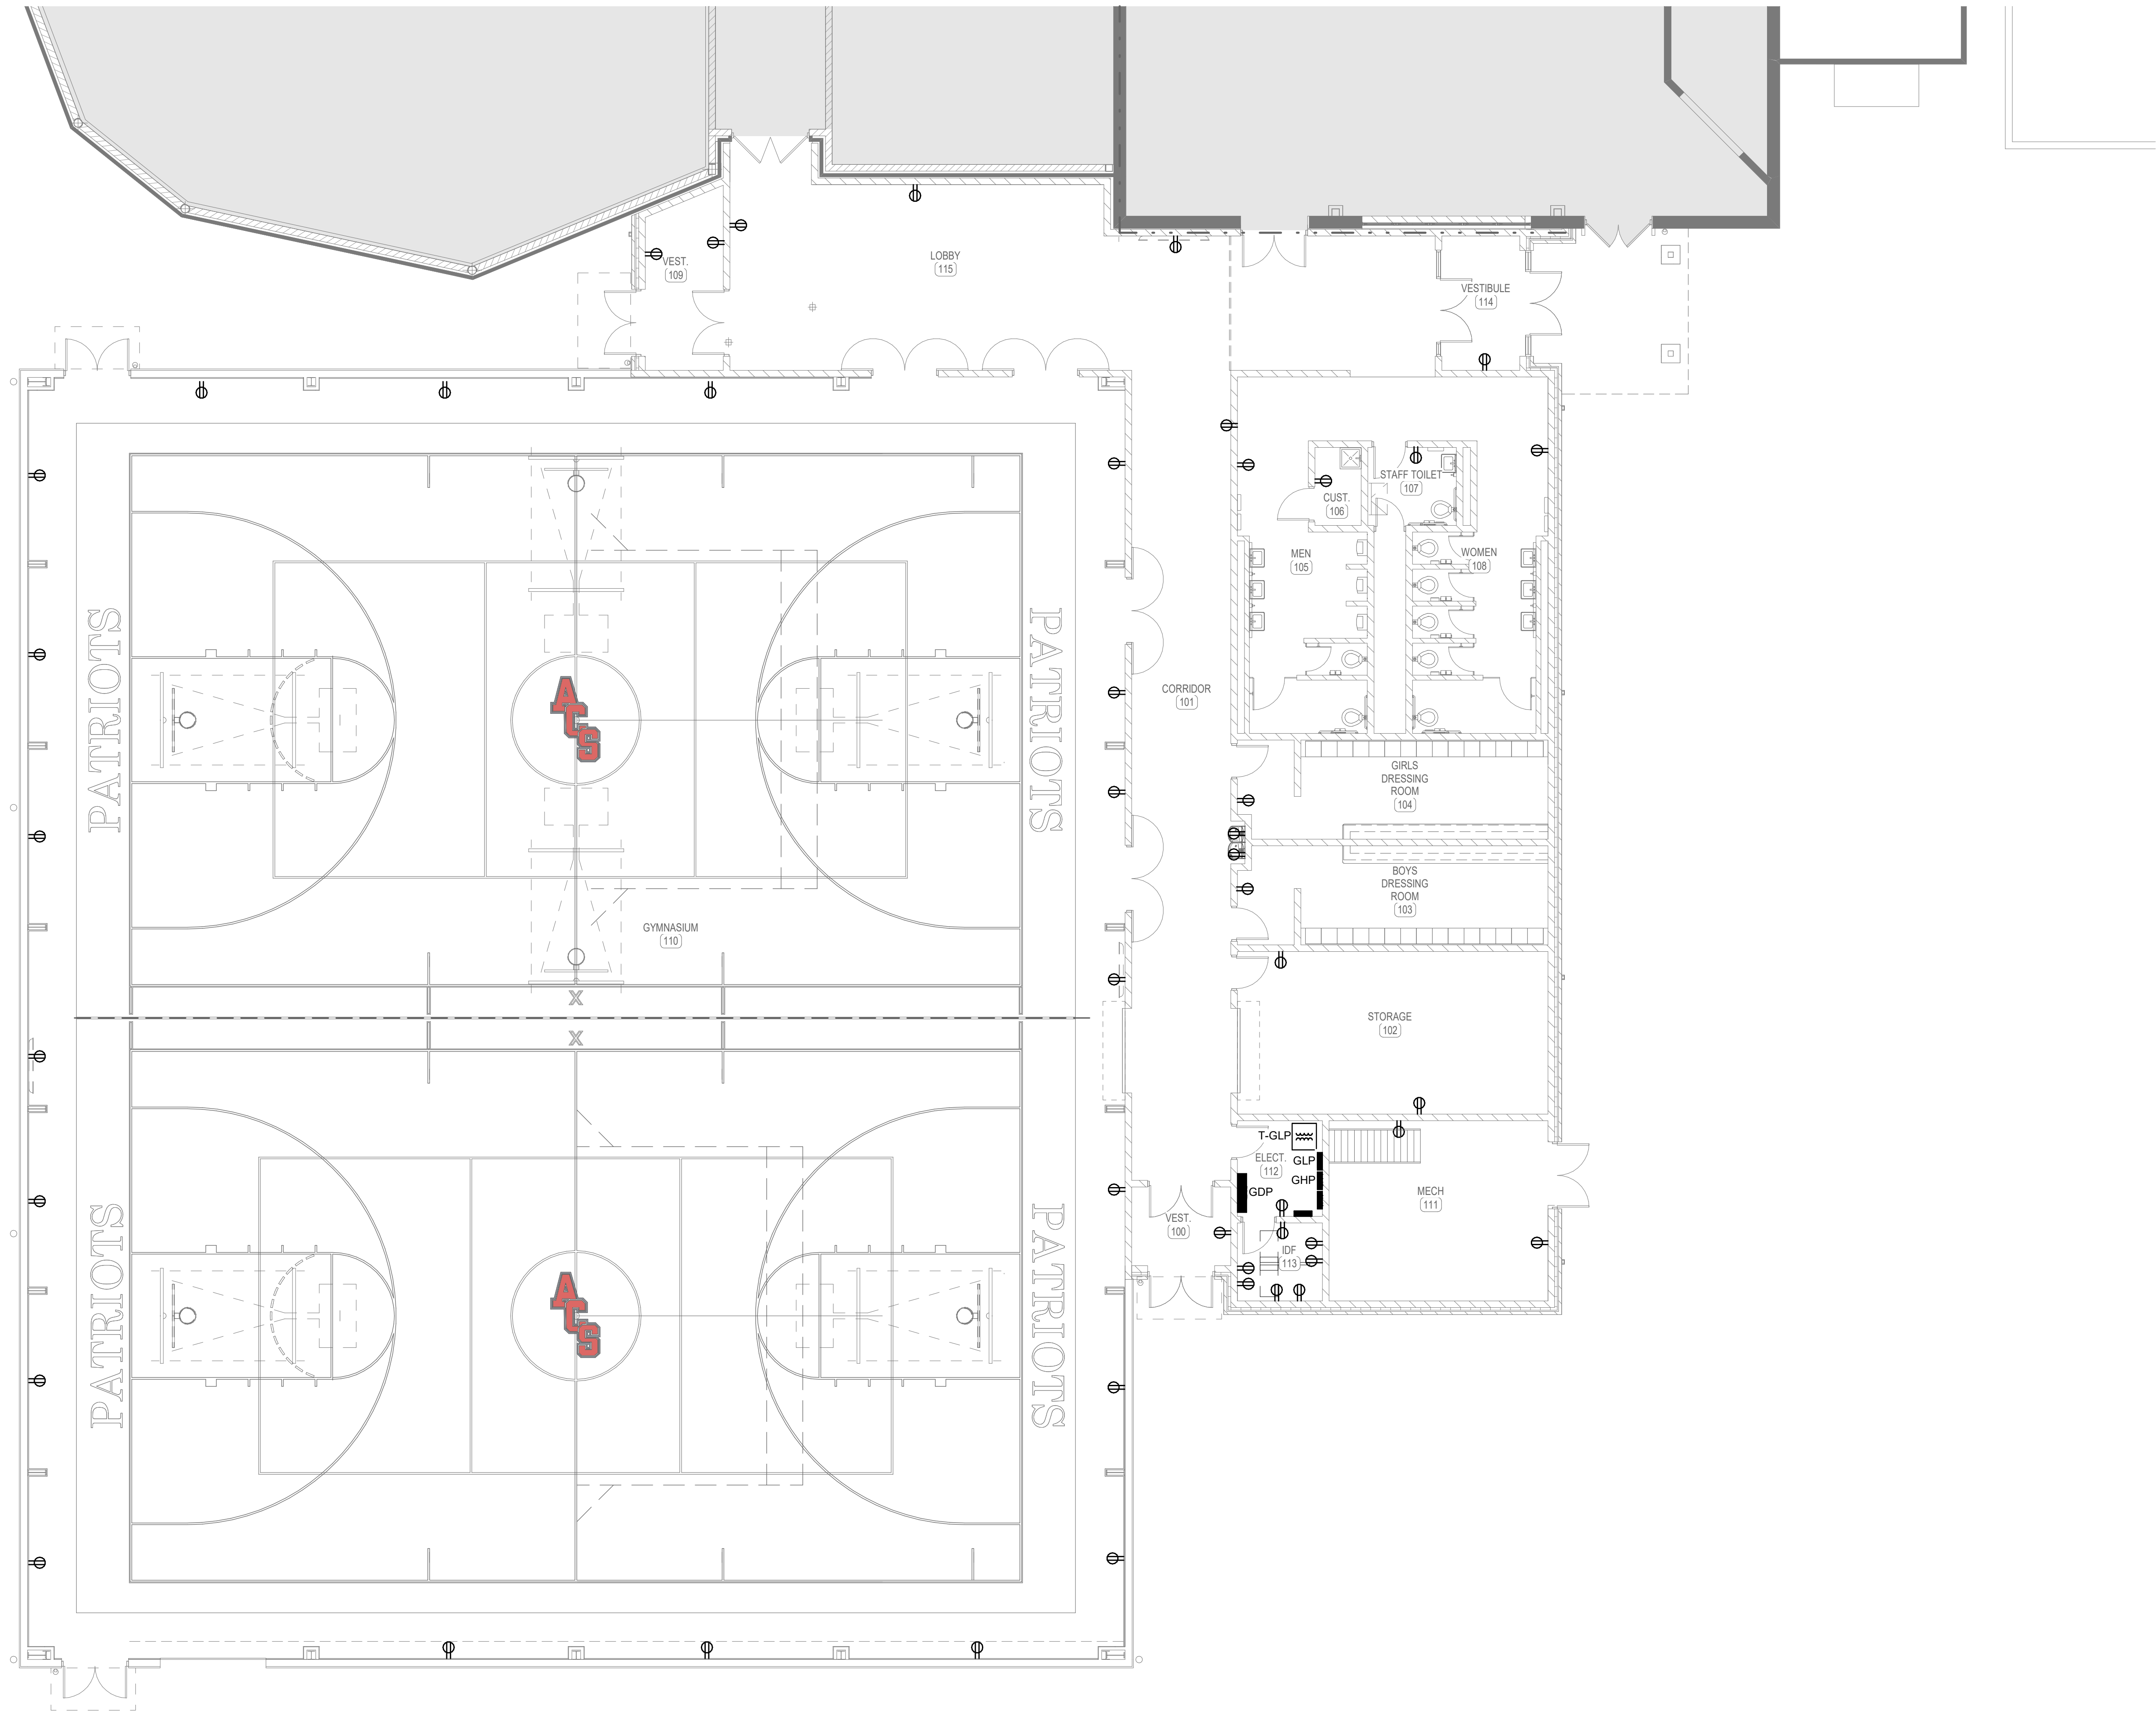

0 4 8 16'


GENERAL NOTES

A. REFER TO SHEET XXX FOR GENERAL NOTES.

SHEET KEYNOTES

1. SHEET NOTES

KEY PLAN

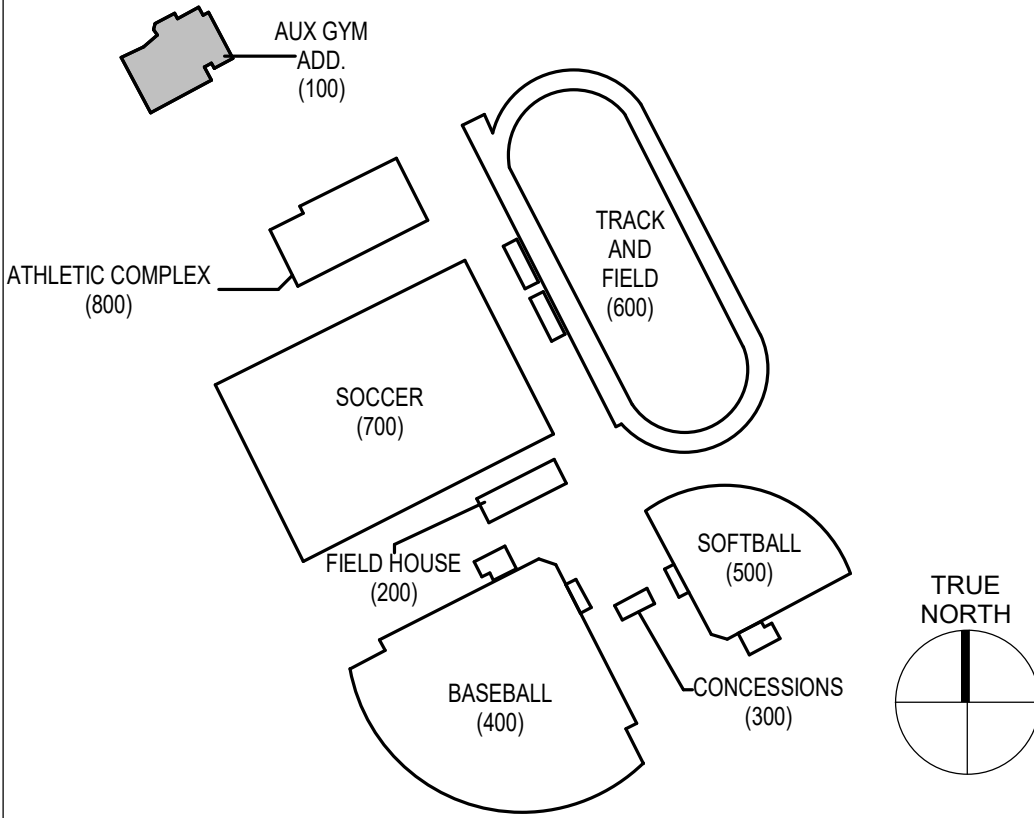

SHERMAN
CARTER
BARNHART
ARCHITECTS

FOR CONSTRUCTION SET
CHECKED BY
PROGRESS SET
NOT STAMPED

SHROUT
TATE
WILSON
MECHANICAL AND
ELECTRICAL ENGINEERS
Lexington - Louisville - Charleston
www.stwg.com

ALLEN COUNTY - SCOTTSTVILLE
HIGH SCHOOL ATHLETIC
COMPLEX
SCOTTSTVILLE, KENTUCKY

AUXILIARY GYMNASIUM ADDITION -
POWER AND SYSTEMS


JOB NO. 2459
DATE NOV 17, 2025
DRAWN STAFF
CHECKED JWH
COPYRIGHT © 2025
SHERMAN CARTER BARNHART
ARCHITECTS, PLLC
REVISIONS
No. Description Date
SHEET
E120

GENERAL NOTES


A. REFER TO SHEET XXX FOR GENERAL NOTES.

SHEET KEYNOTES

1. SHEET NOTES

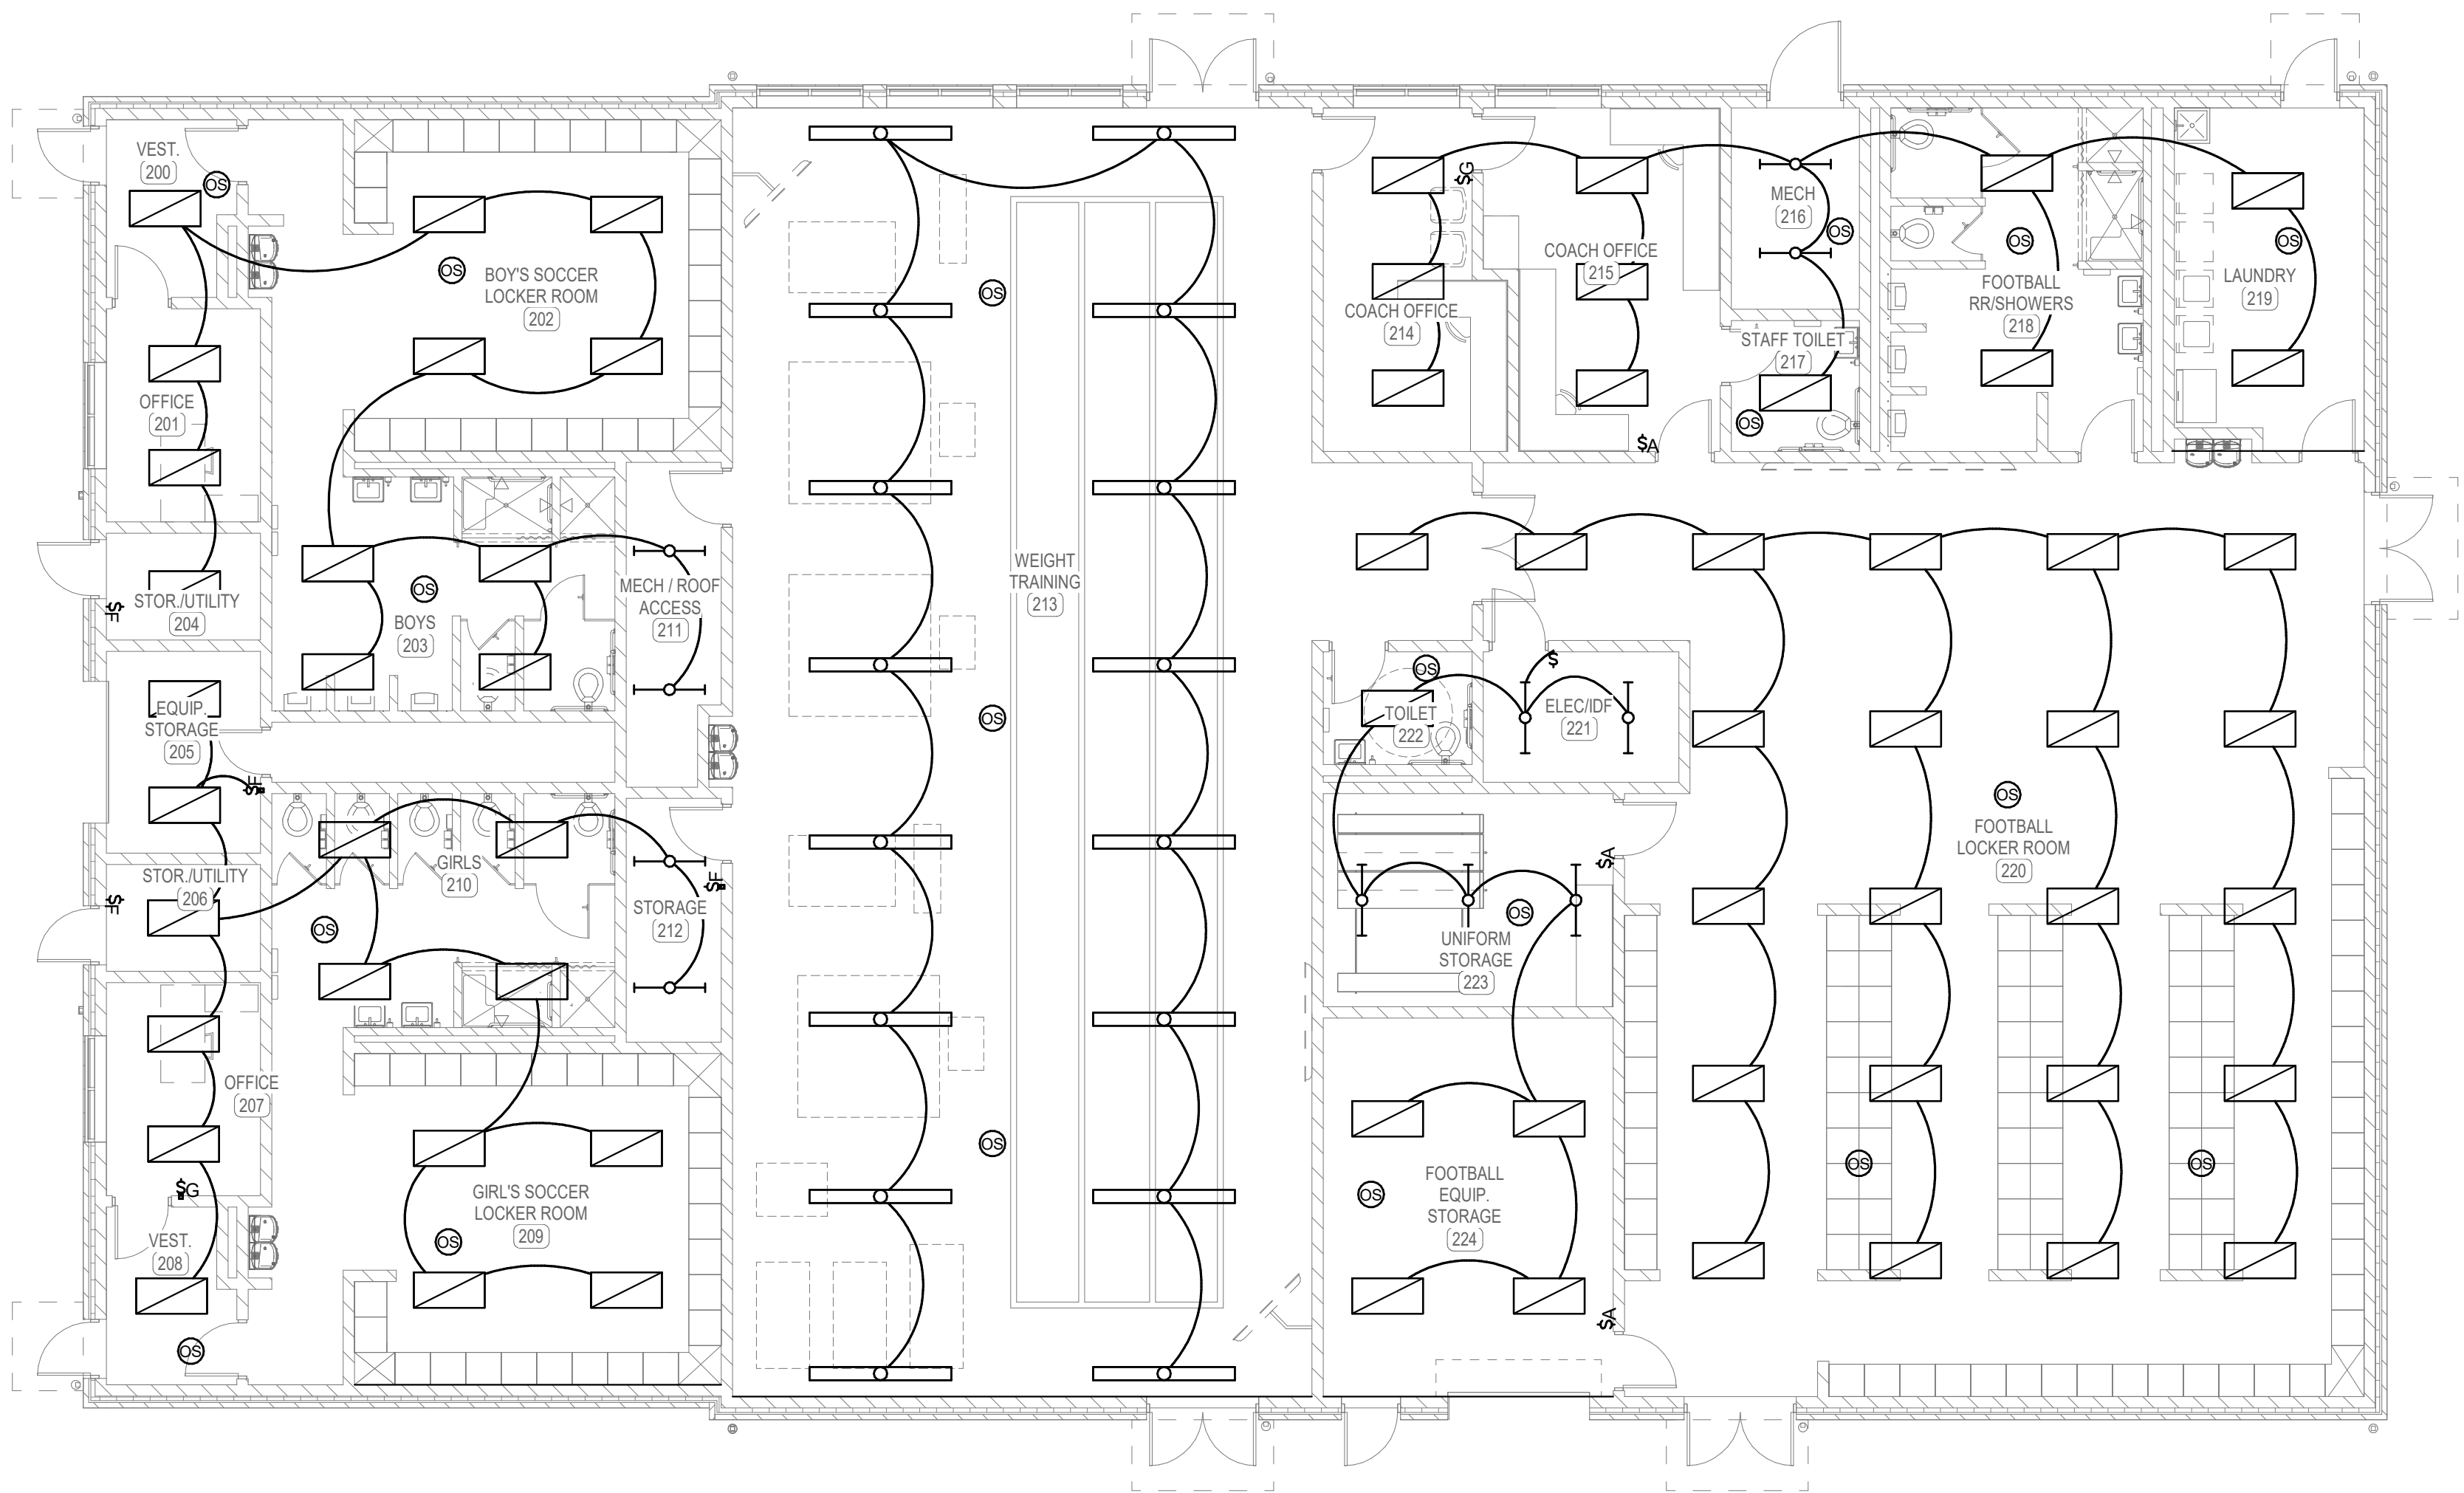


1 FIRST FLOOR PLAN - FIELD HOUSE - LIGHTING
SCALE: 1/8" = 1'-0"

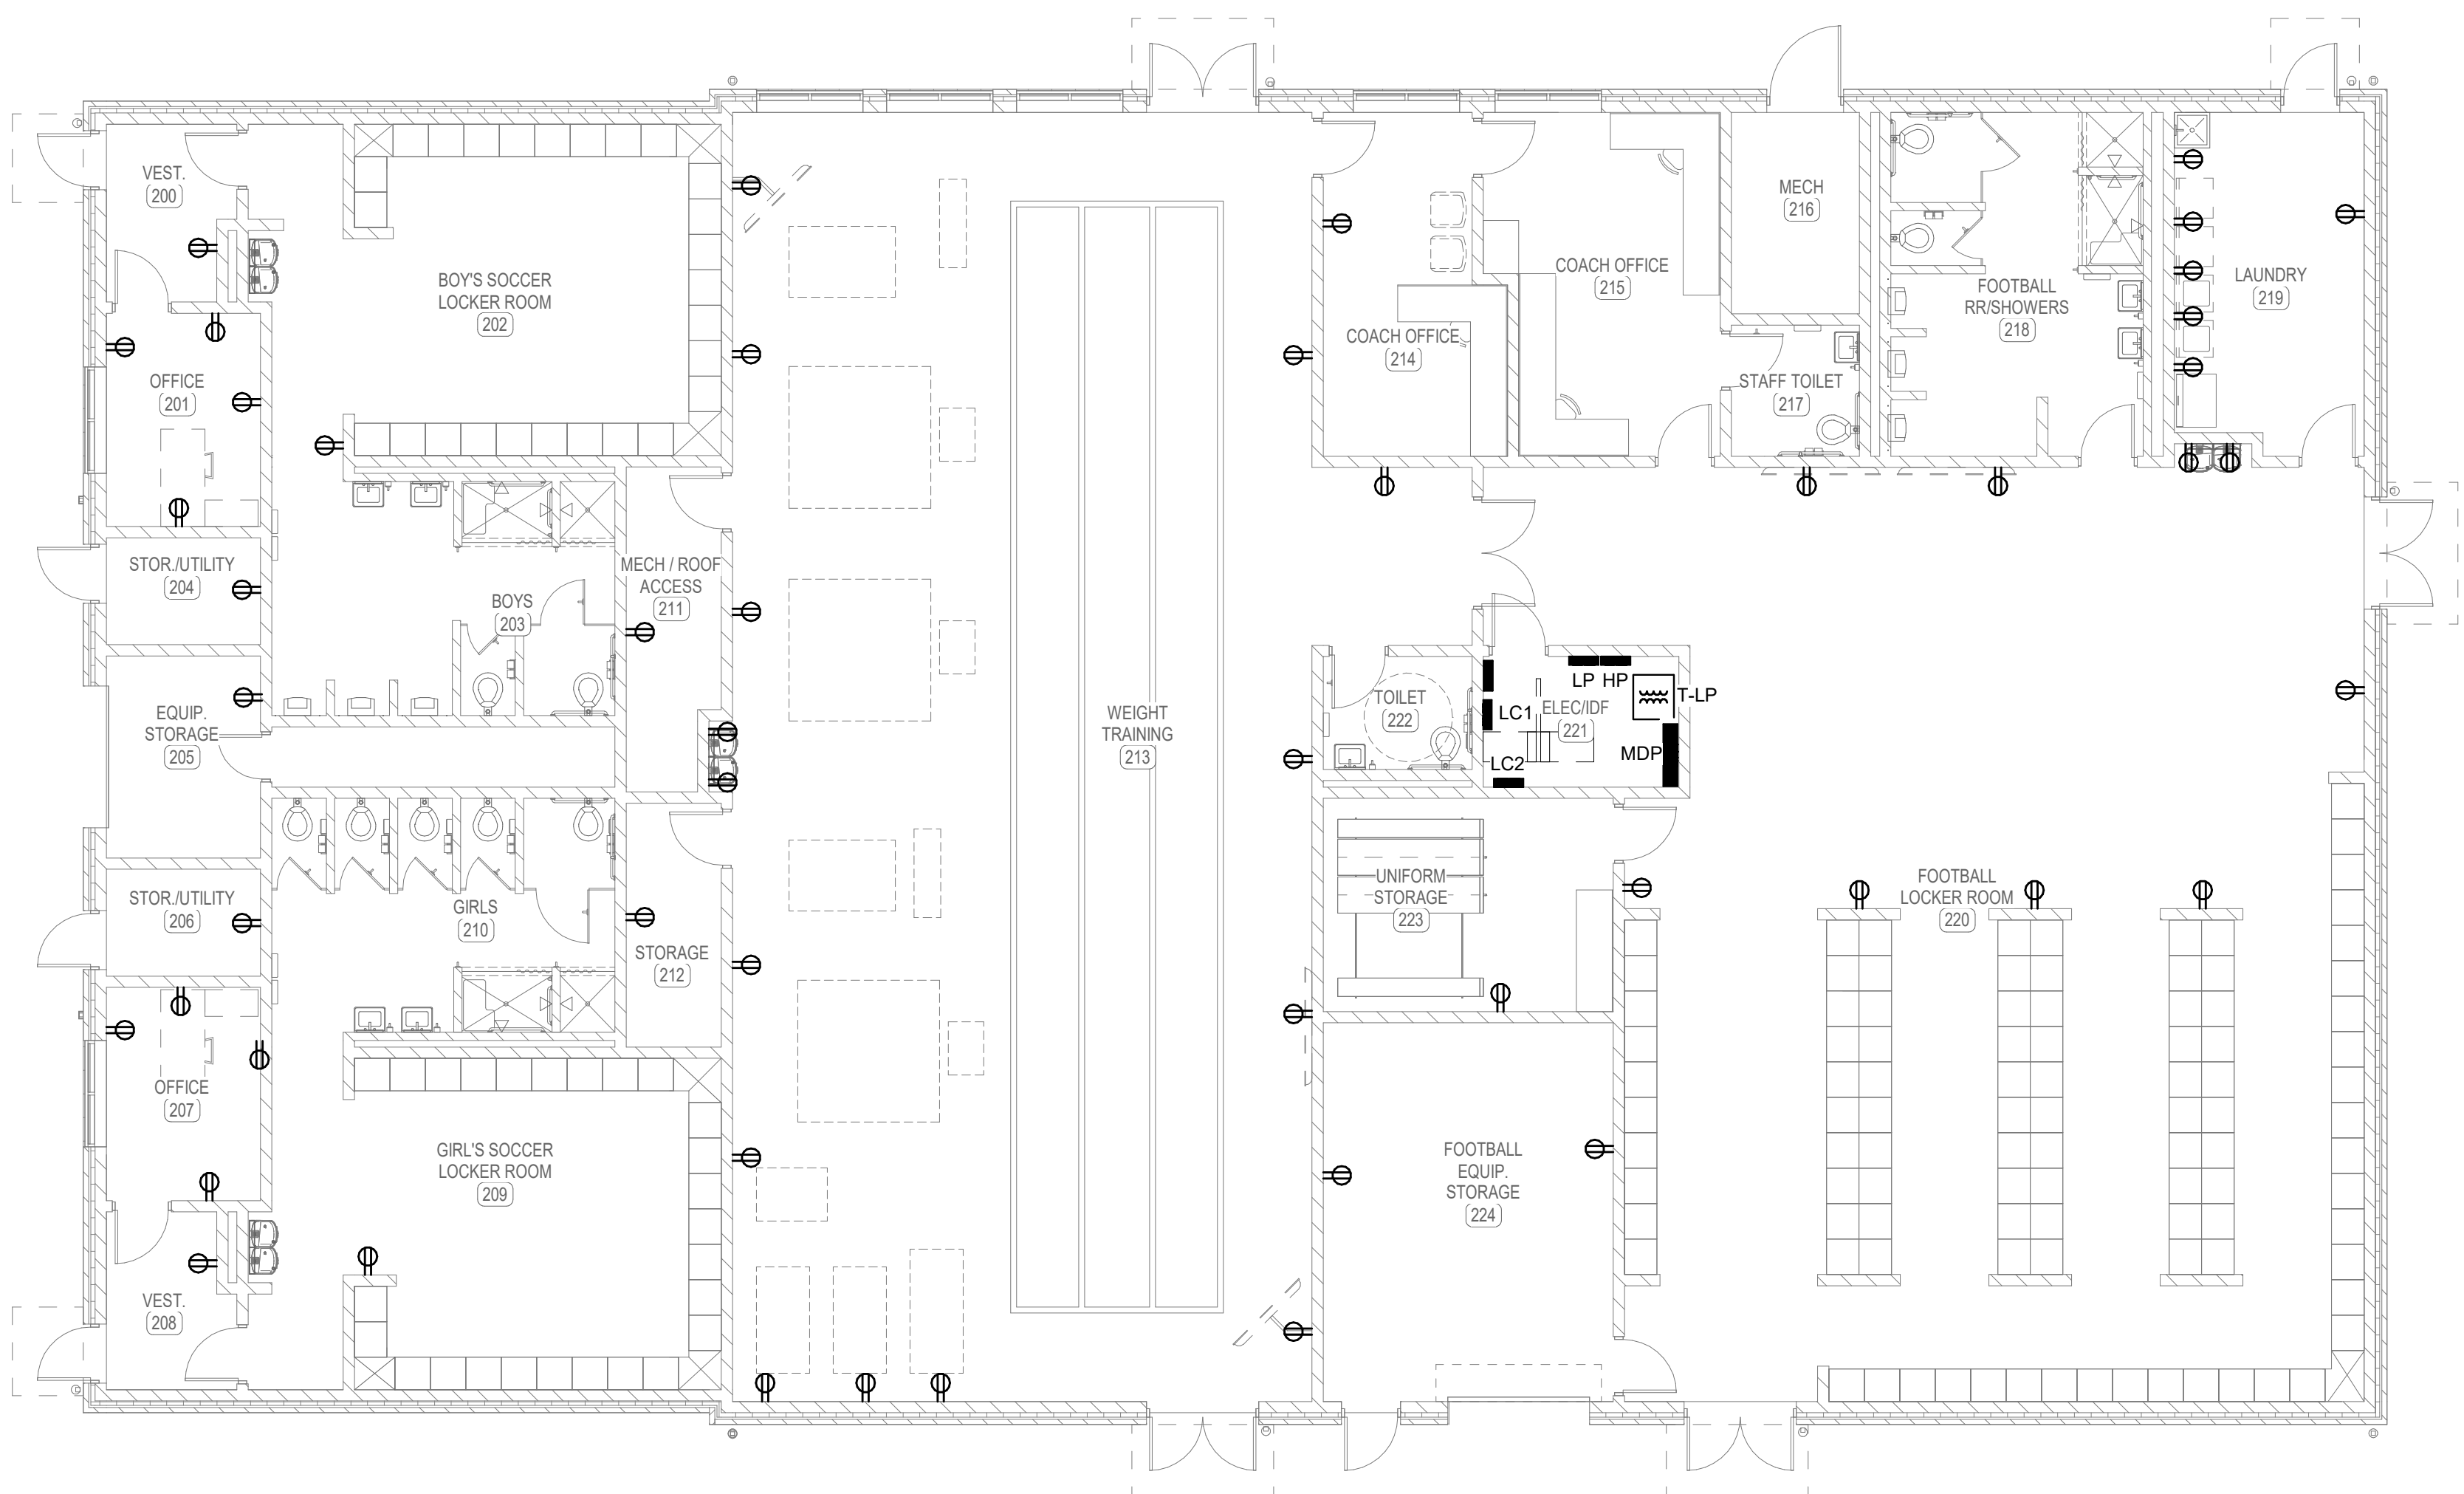

2 FIRST FLOOR PLAN - FIELD HOUSE - POWER AND SYSTEMS
SCALE: 1/8" = 1'-0"

KEY PLAN

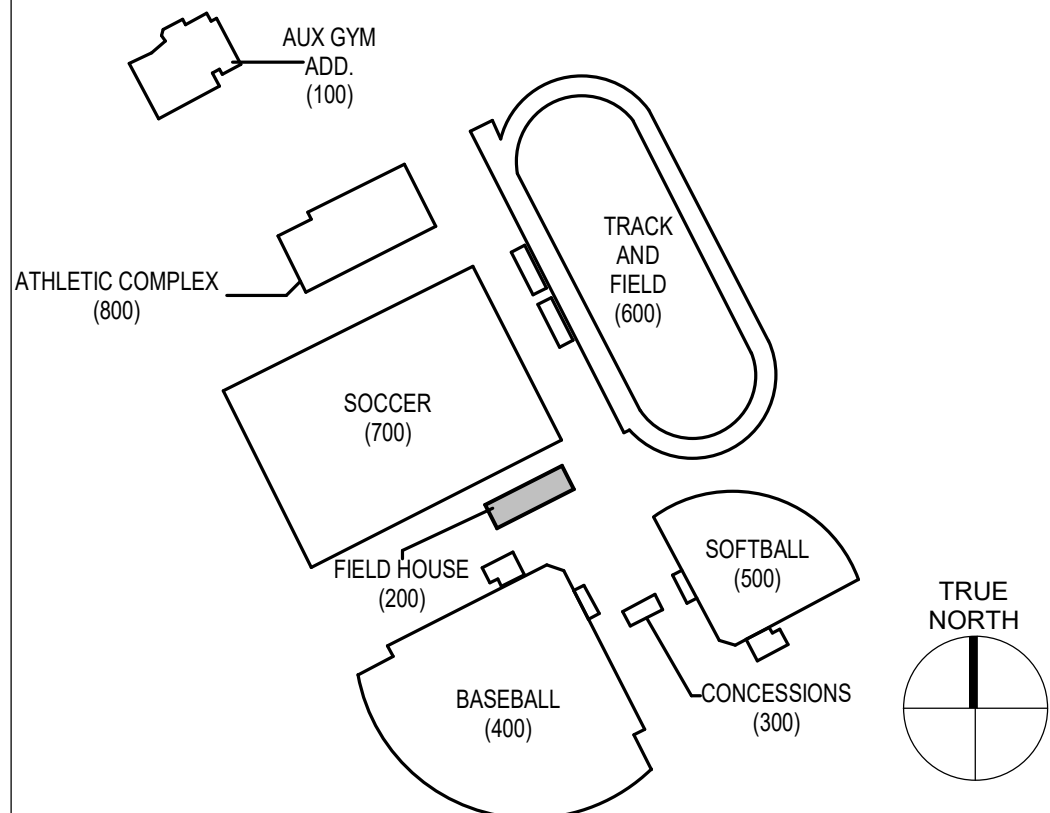


GENERAL NOTES

A. REFER TO SHEET XXX FOR GENERAL NOTES.

SHEET KEYNOTES


1. SHEET NOTES

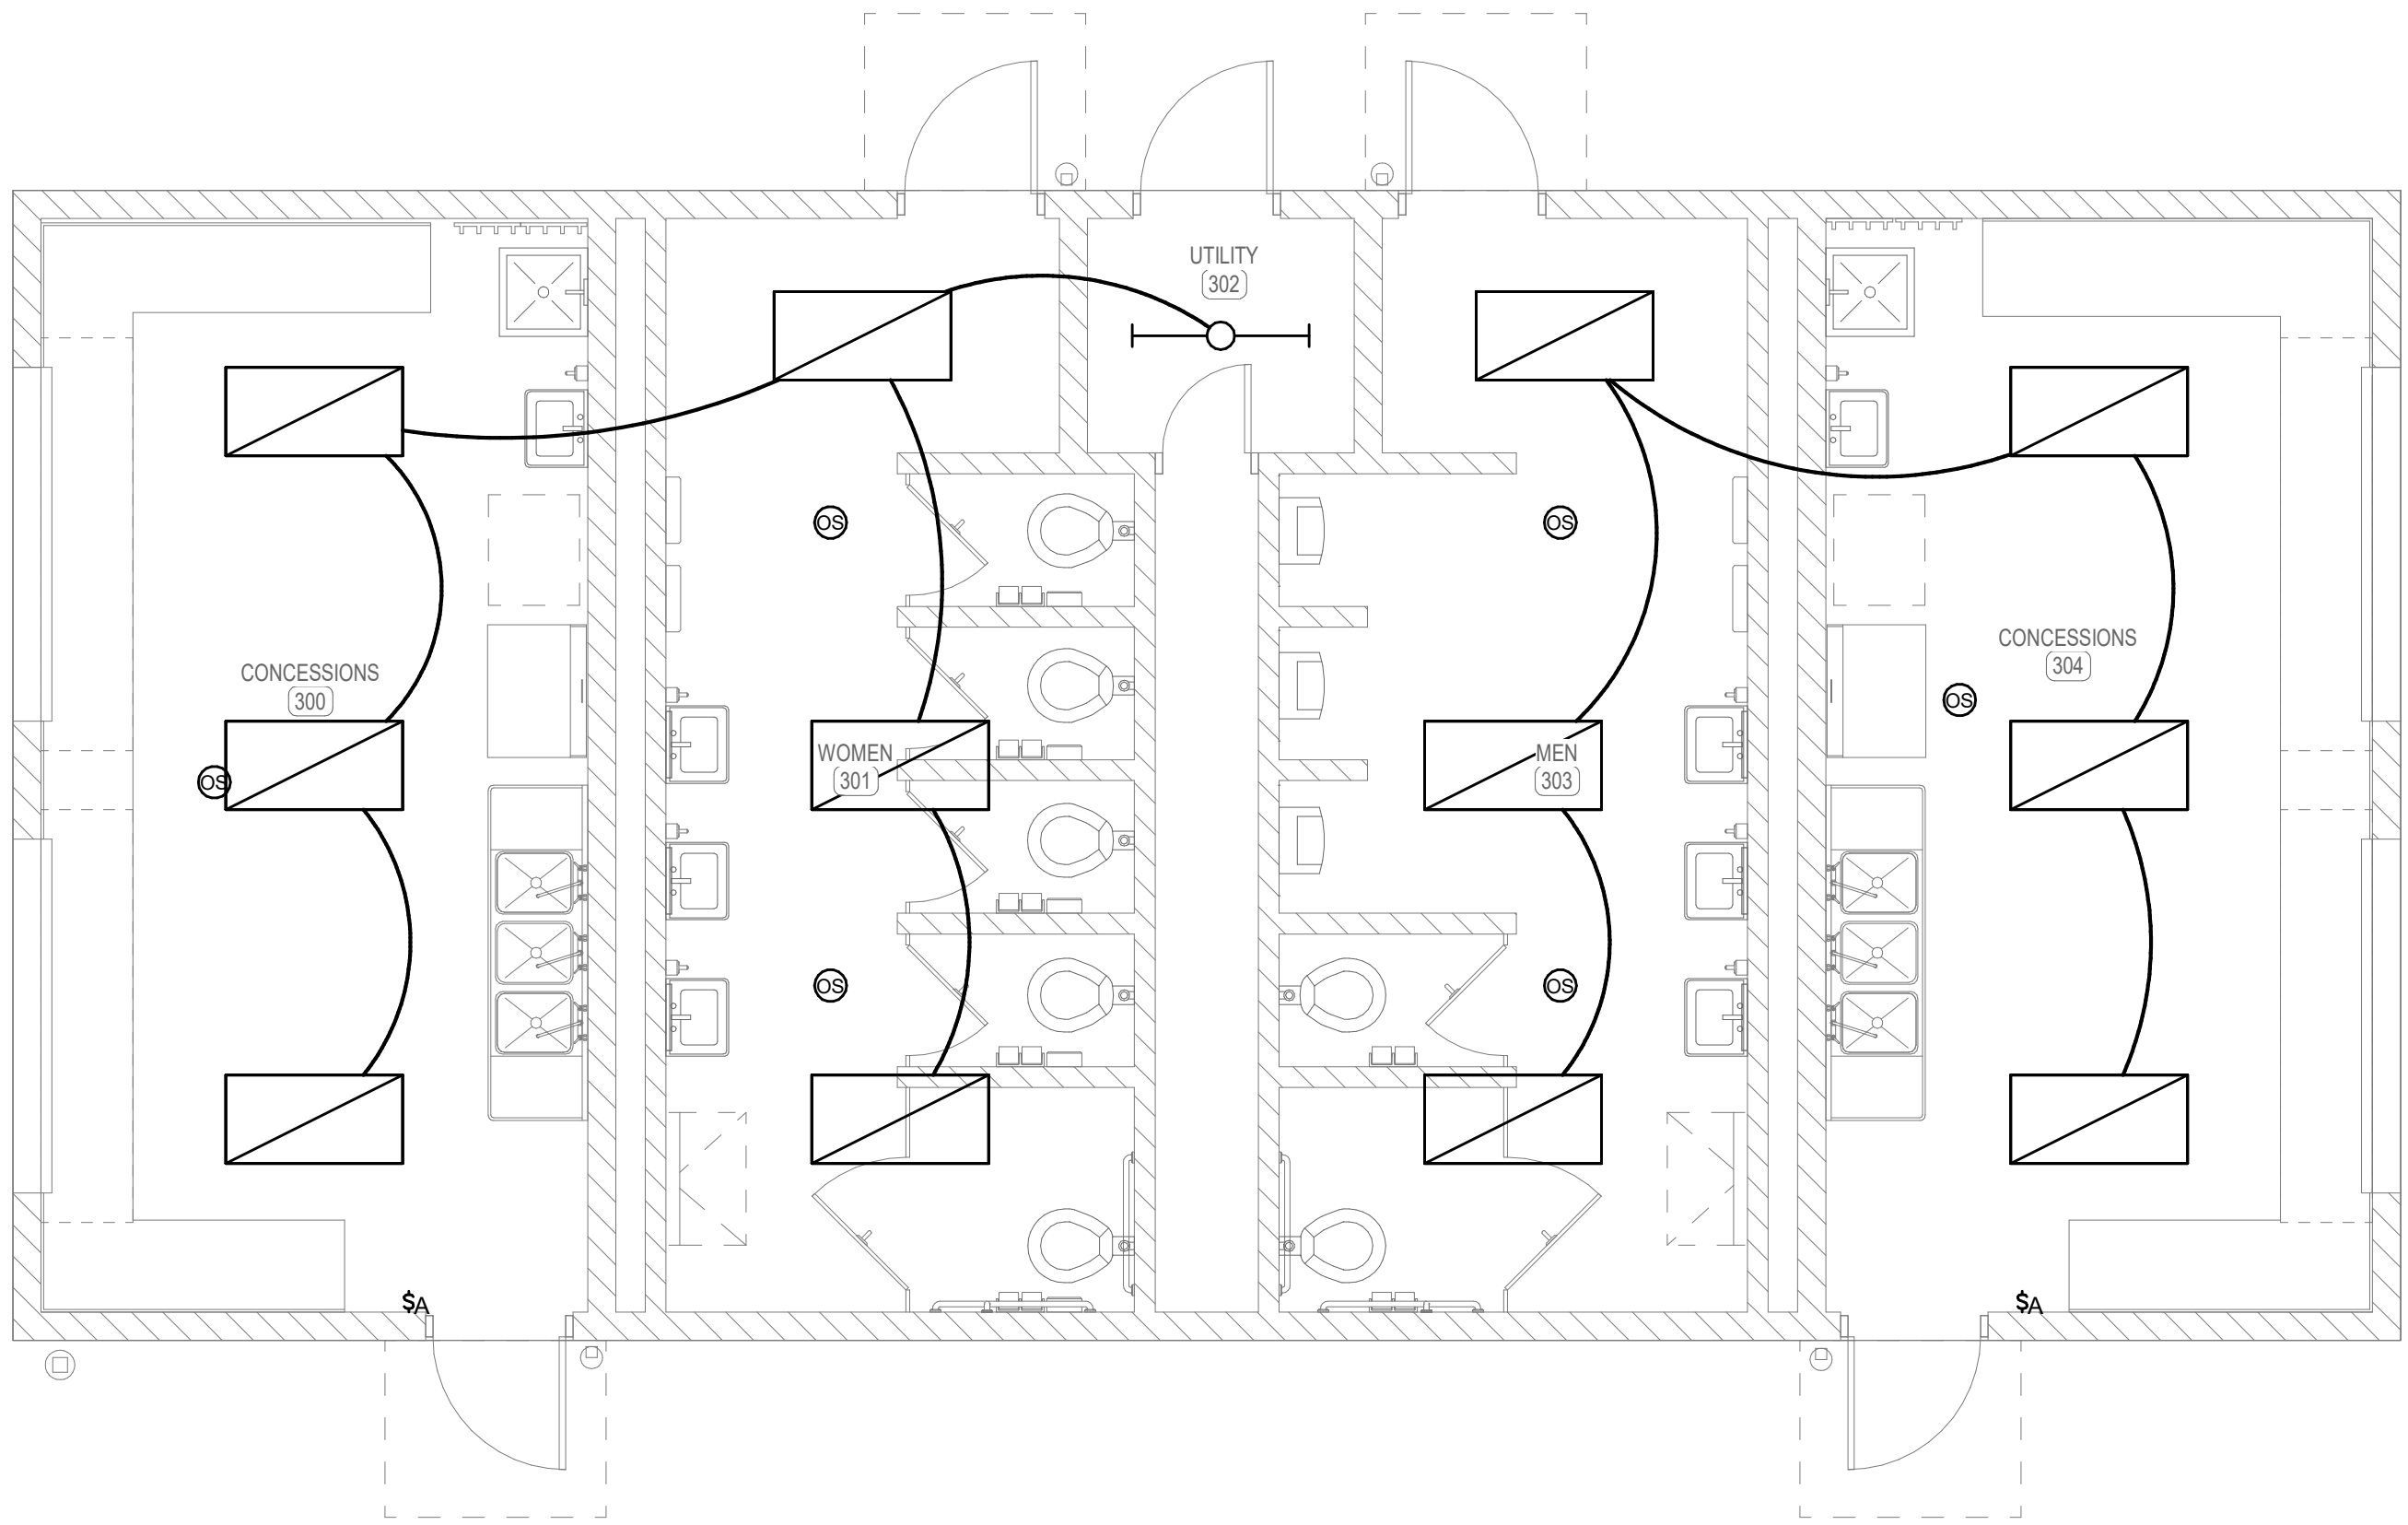

1 FIRST FLOOR PLAN - CONCESSIONS AND RESTROOM - LIGHTING

SCALE: 1/4" = 1'-0"

0 4' 8' 16'

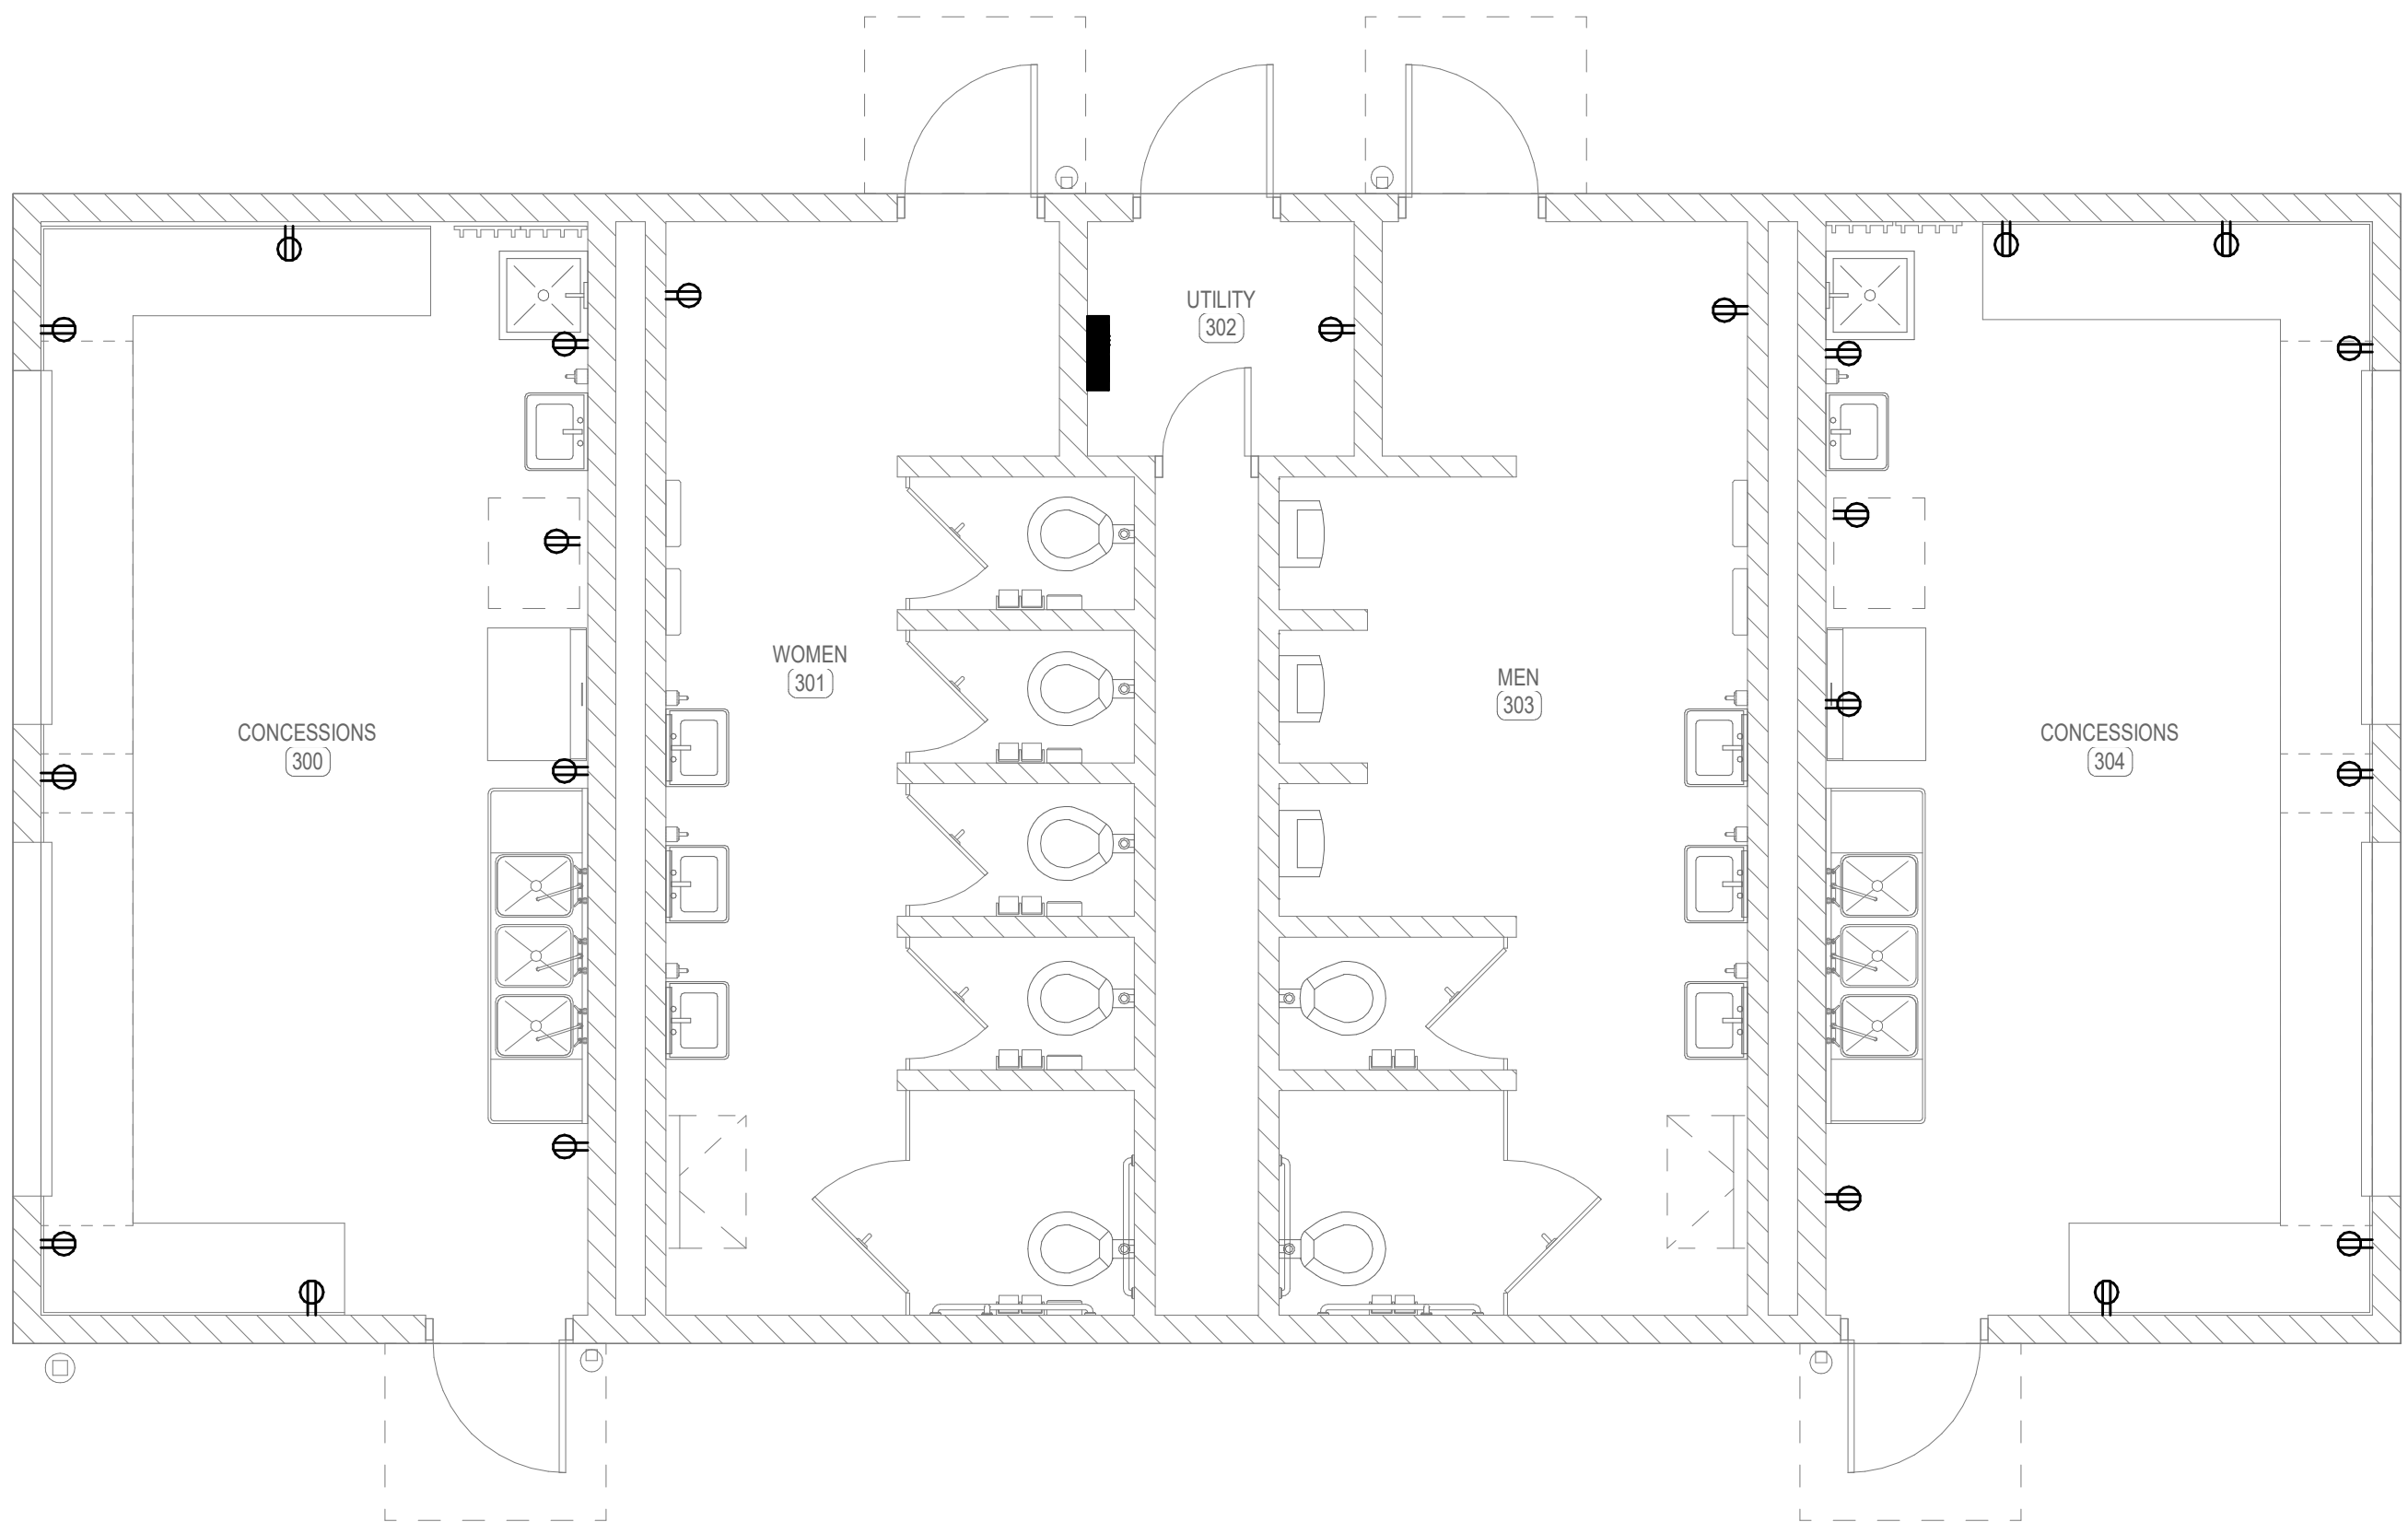


2 FIRST FLOOR PLAN - CONCESSIONS AND RESTROOM - POWER AND SYSTEMS

SCALE: 1/4" = 1'-0"

0 4' 8' 16'

KEY PLAN

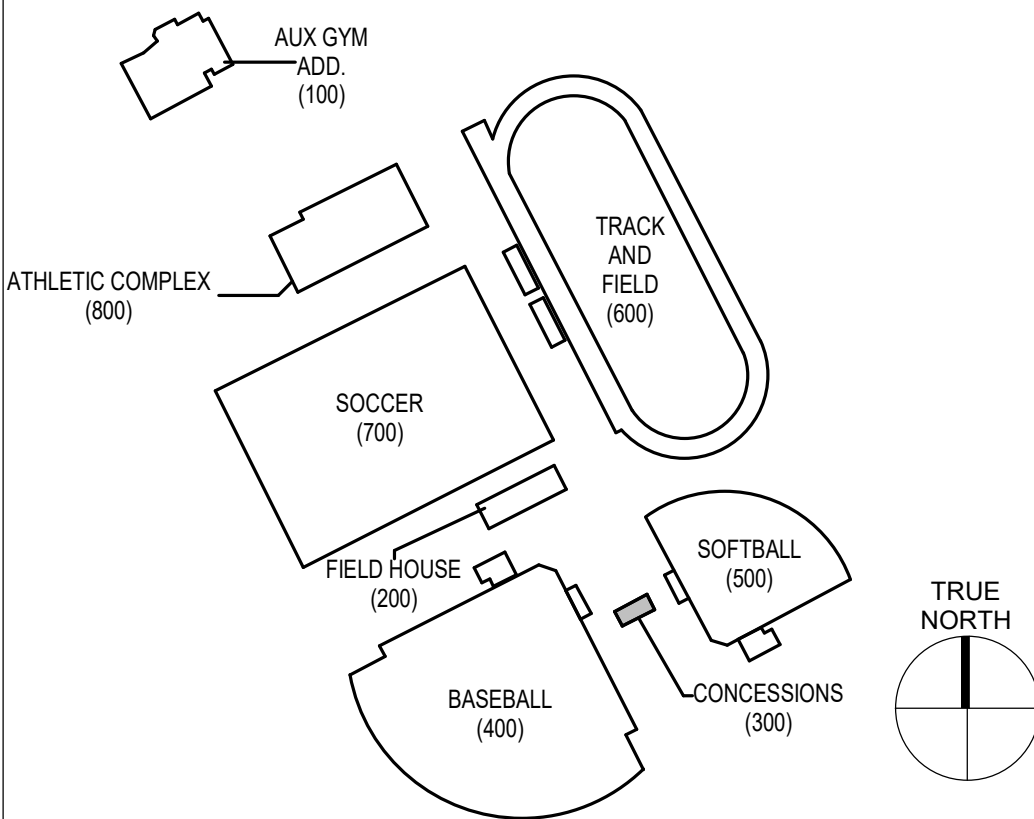


JOB NO.	2459	
DATE	NOV 17, 2025	
DRAWN	STAFF	
CHECKED	JWH	
COPYRIGHT © 2025 SHERMAN CARTER BARNHART ARCHITECTS, PLLC		
REVISIONS		
No.	Description	Date

GENERAL NOTES


A. REFER TO SHEET XXX FOR GENERAL NOTES.

SHEET KEYNOTES

1. SHEET NOTES

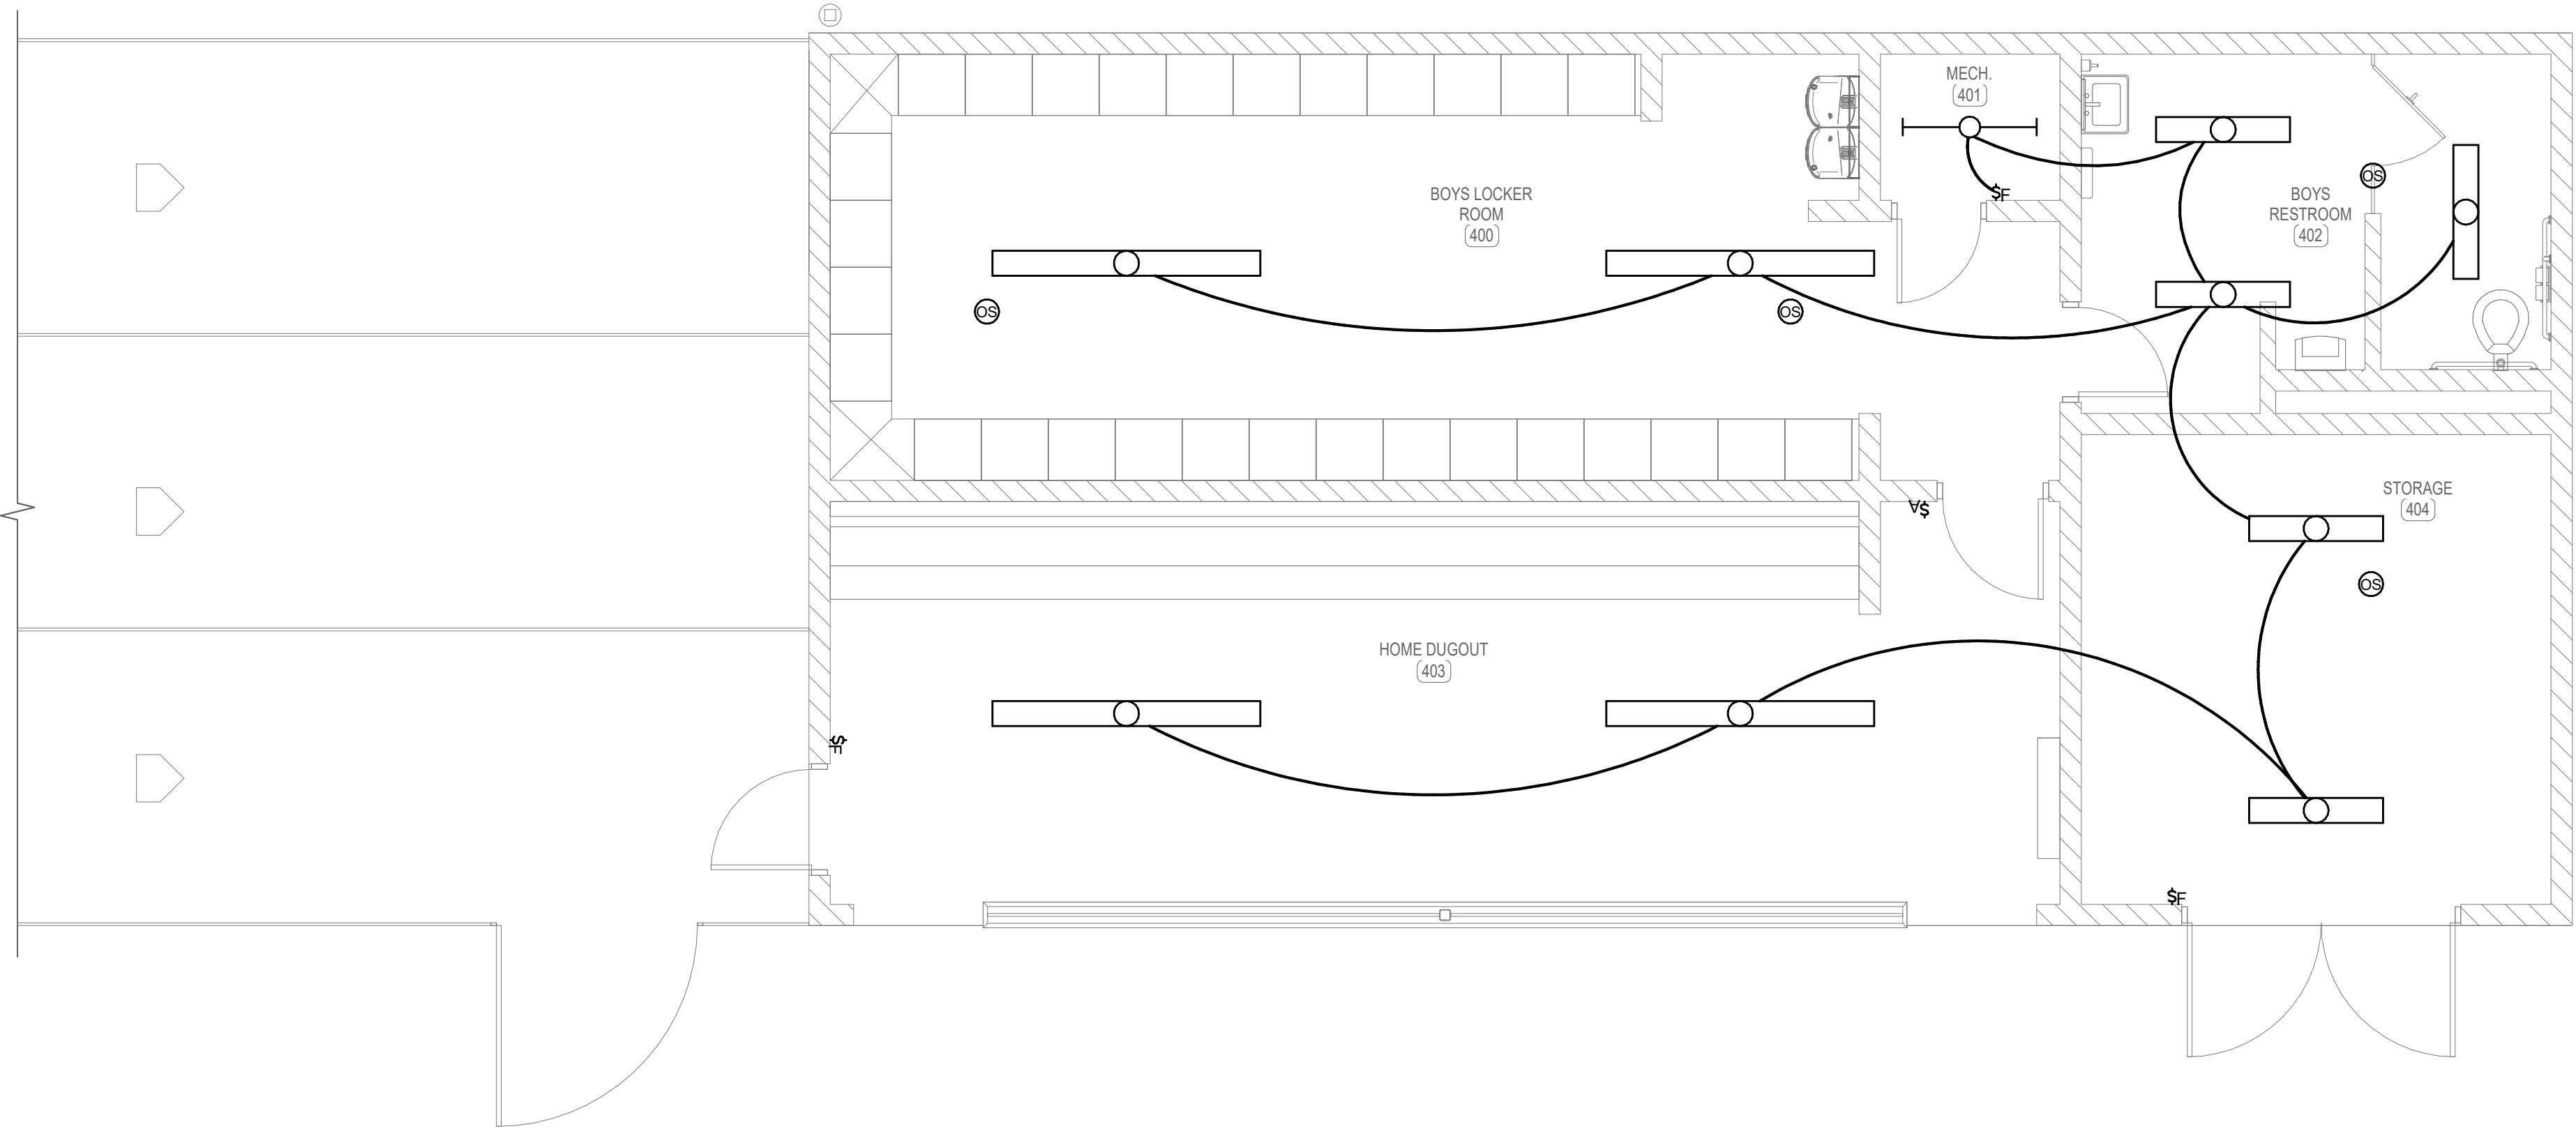


1 FIRST FLOOR PLAN - BOYS LOCKER ROOM AND DUGOUT - LIGHTING
SCALE: 1/4" = 1'-0"

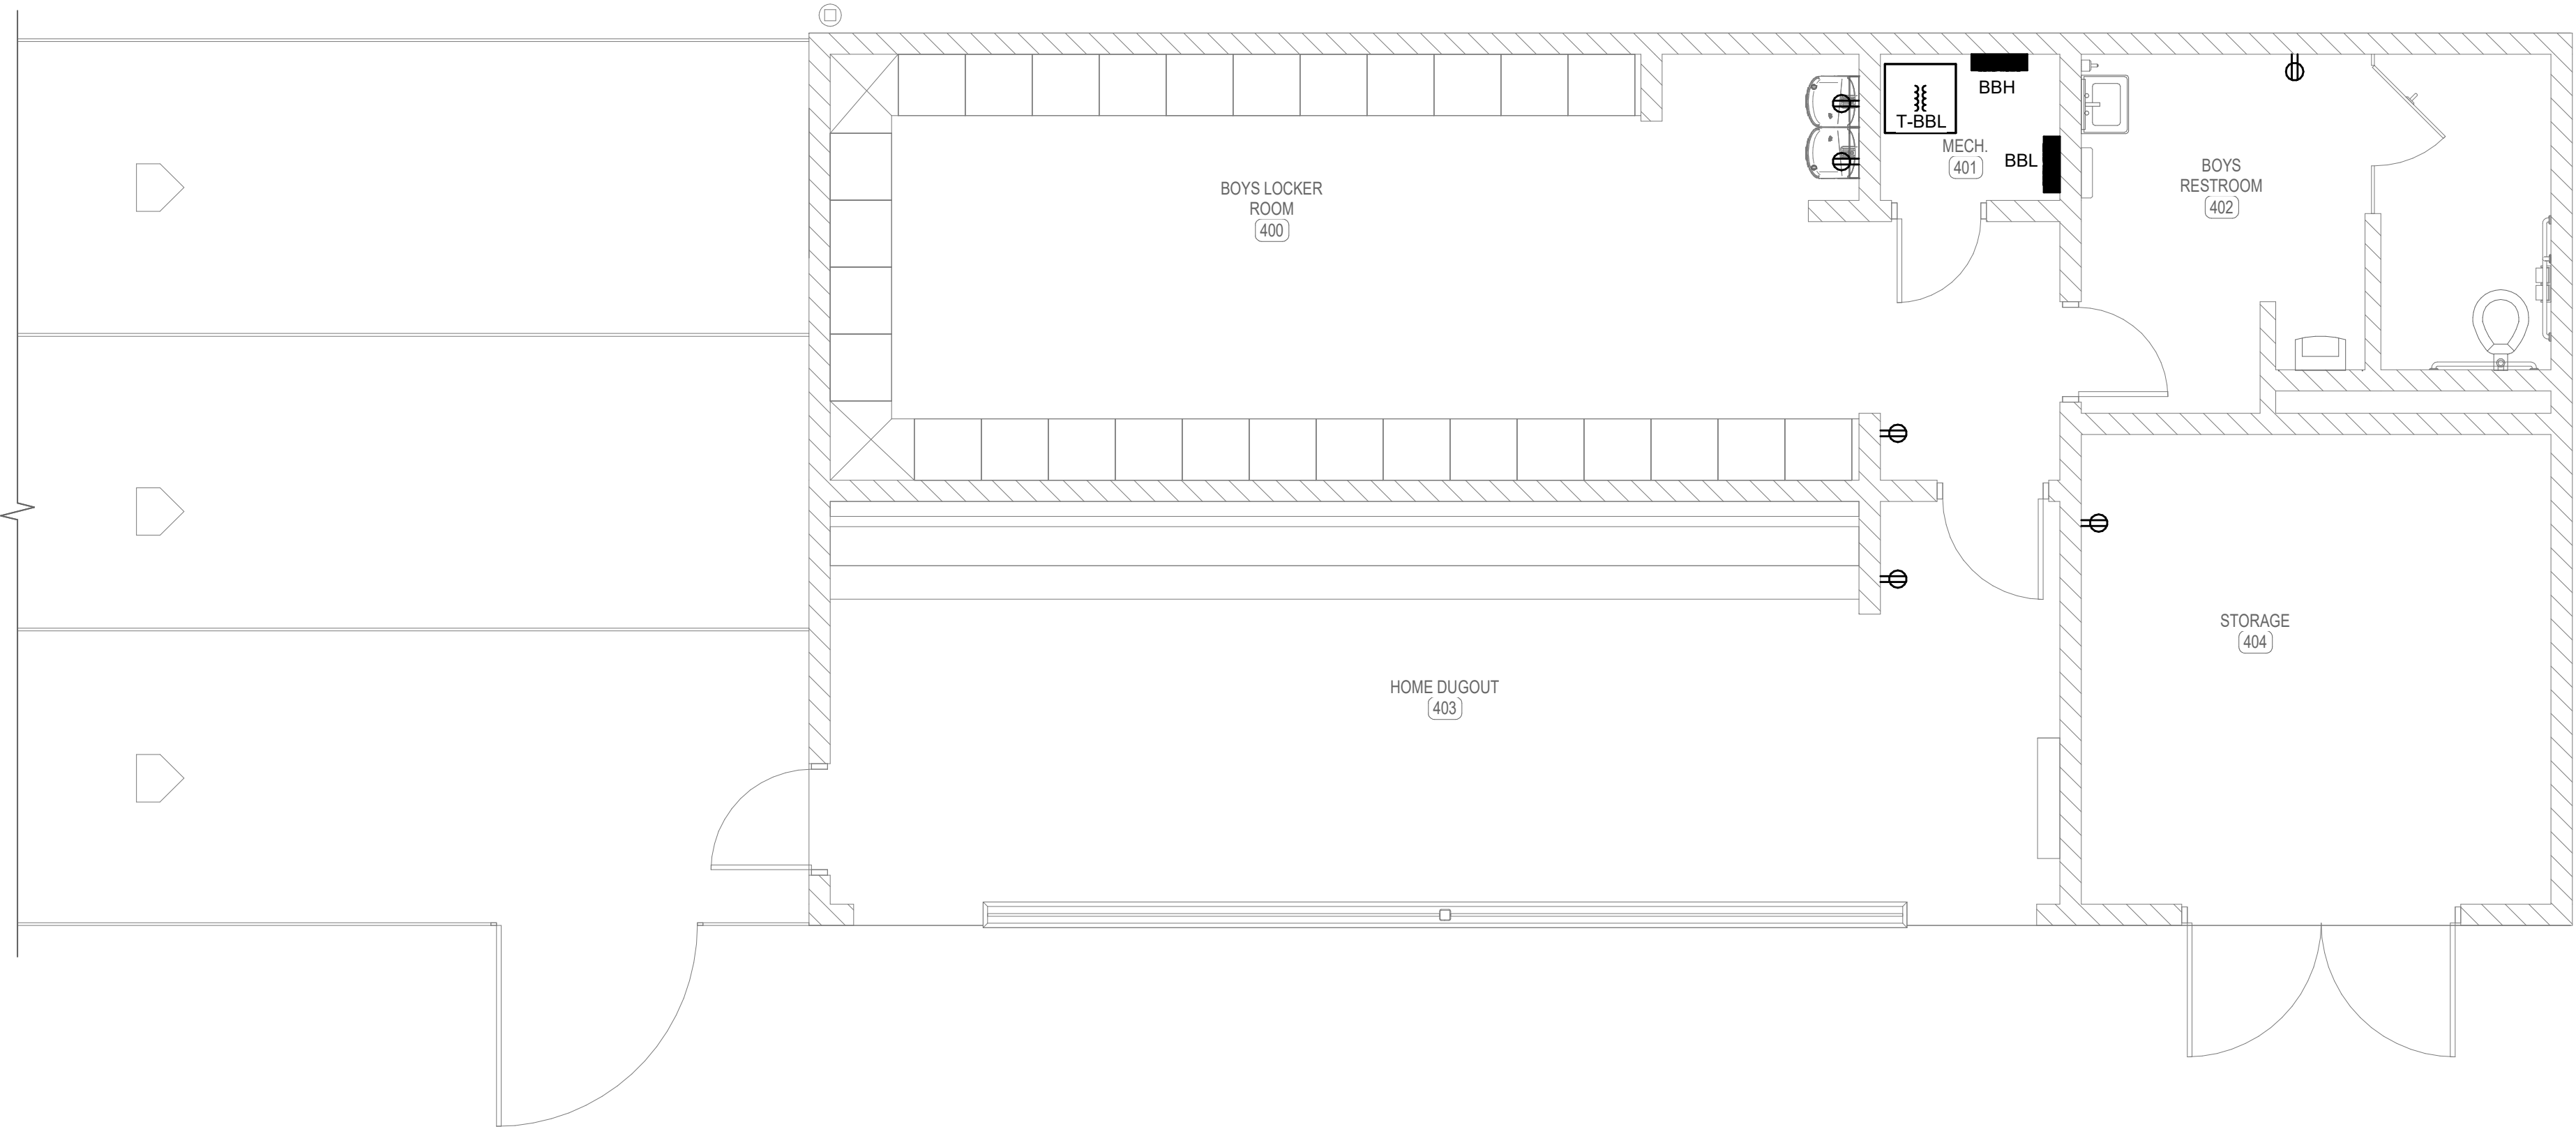

2 FIRST FLOOR PLAN - BOYS LOCKER ROOM AND DUGOUT - POWER AND SYSTEMS
SCALE: 1/4" = 1'-0"

KEY PLAN

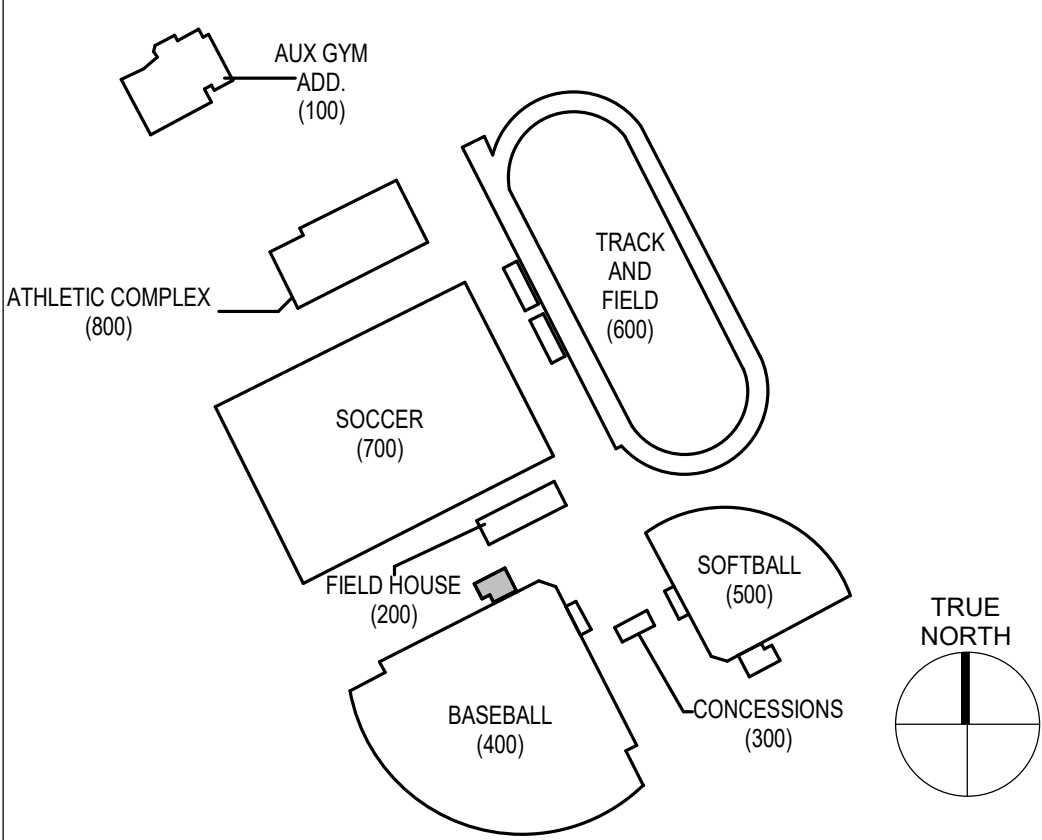


GENERAL NOTES


A. REFER TO SHEET XXX FOR GENERAL NOTES.

SHEET KEYNOTES


1. SHEET NOTES

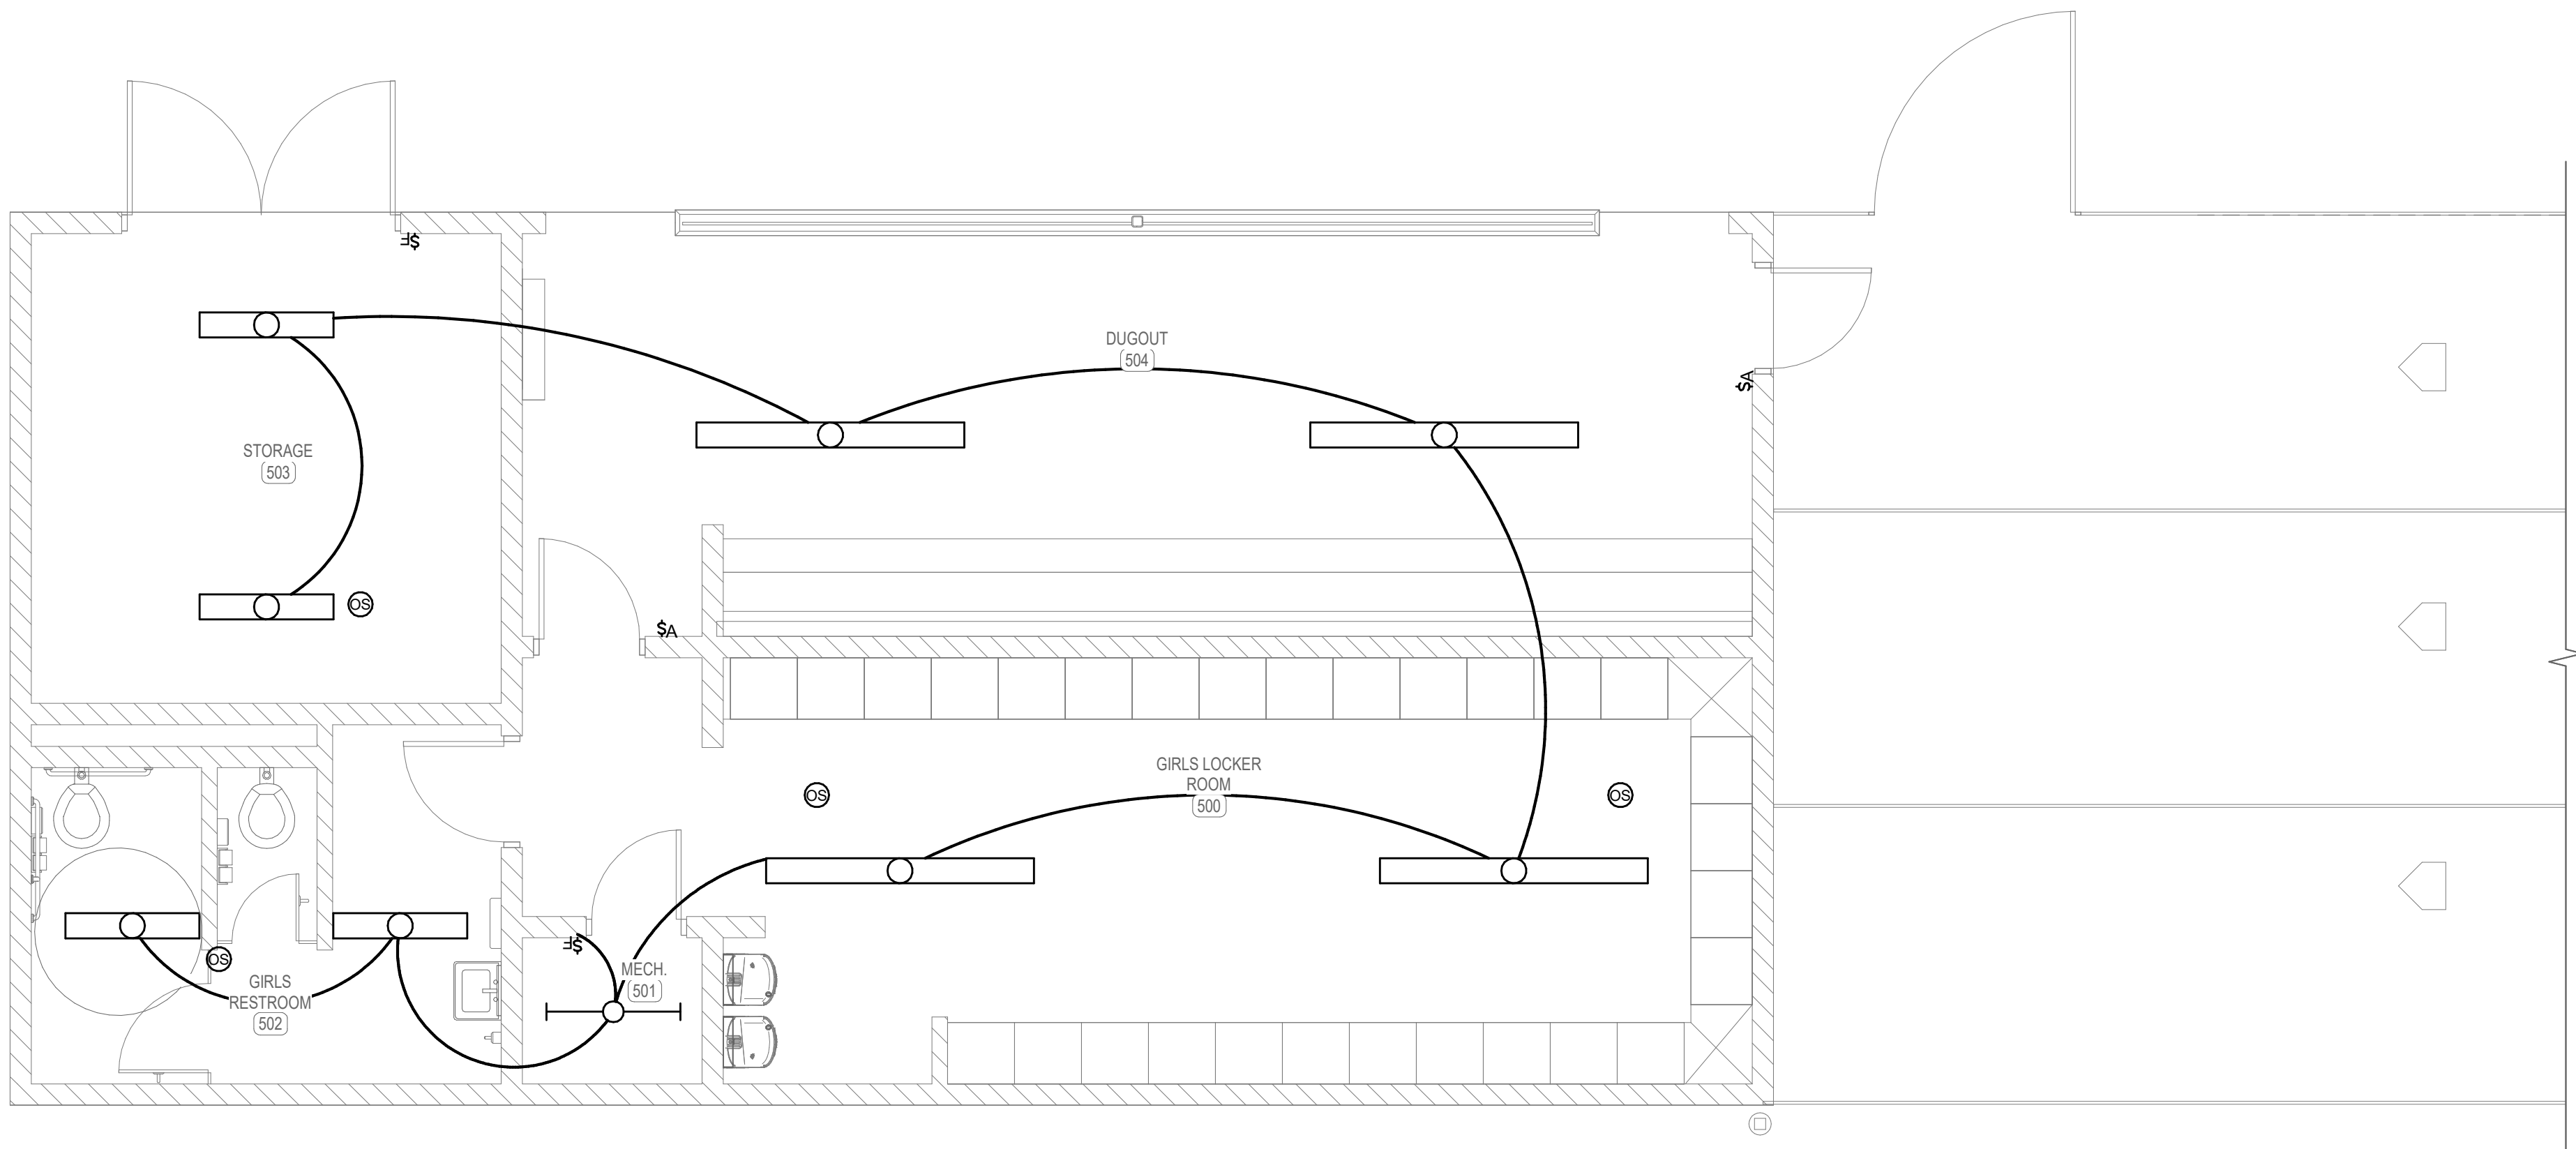


1 FIRST FLOOR PLAN - GIRLS LOCKER ROOM AND DUGOUT - LIGHTING
SCALE: 1/4" = 1'-0"

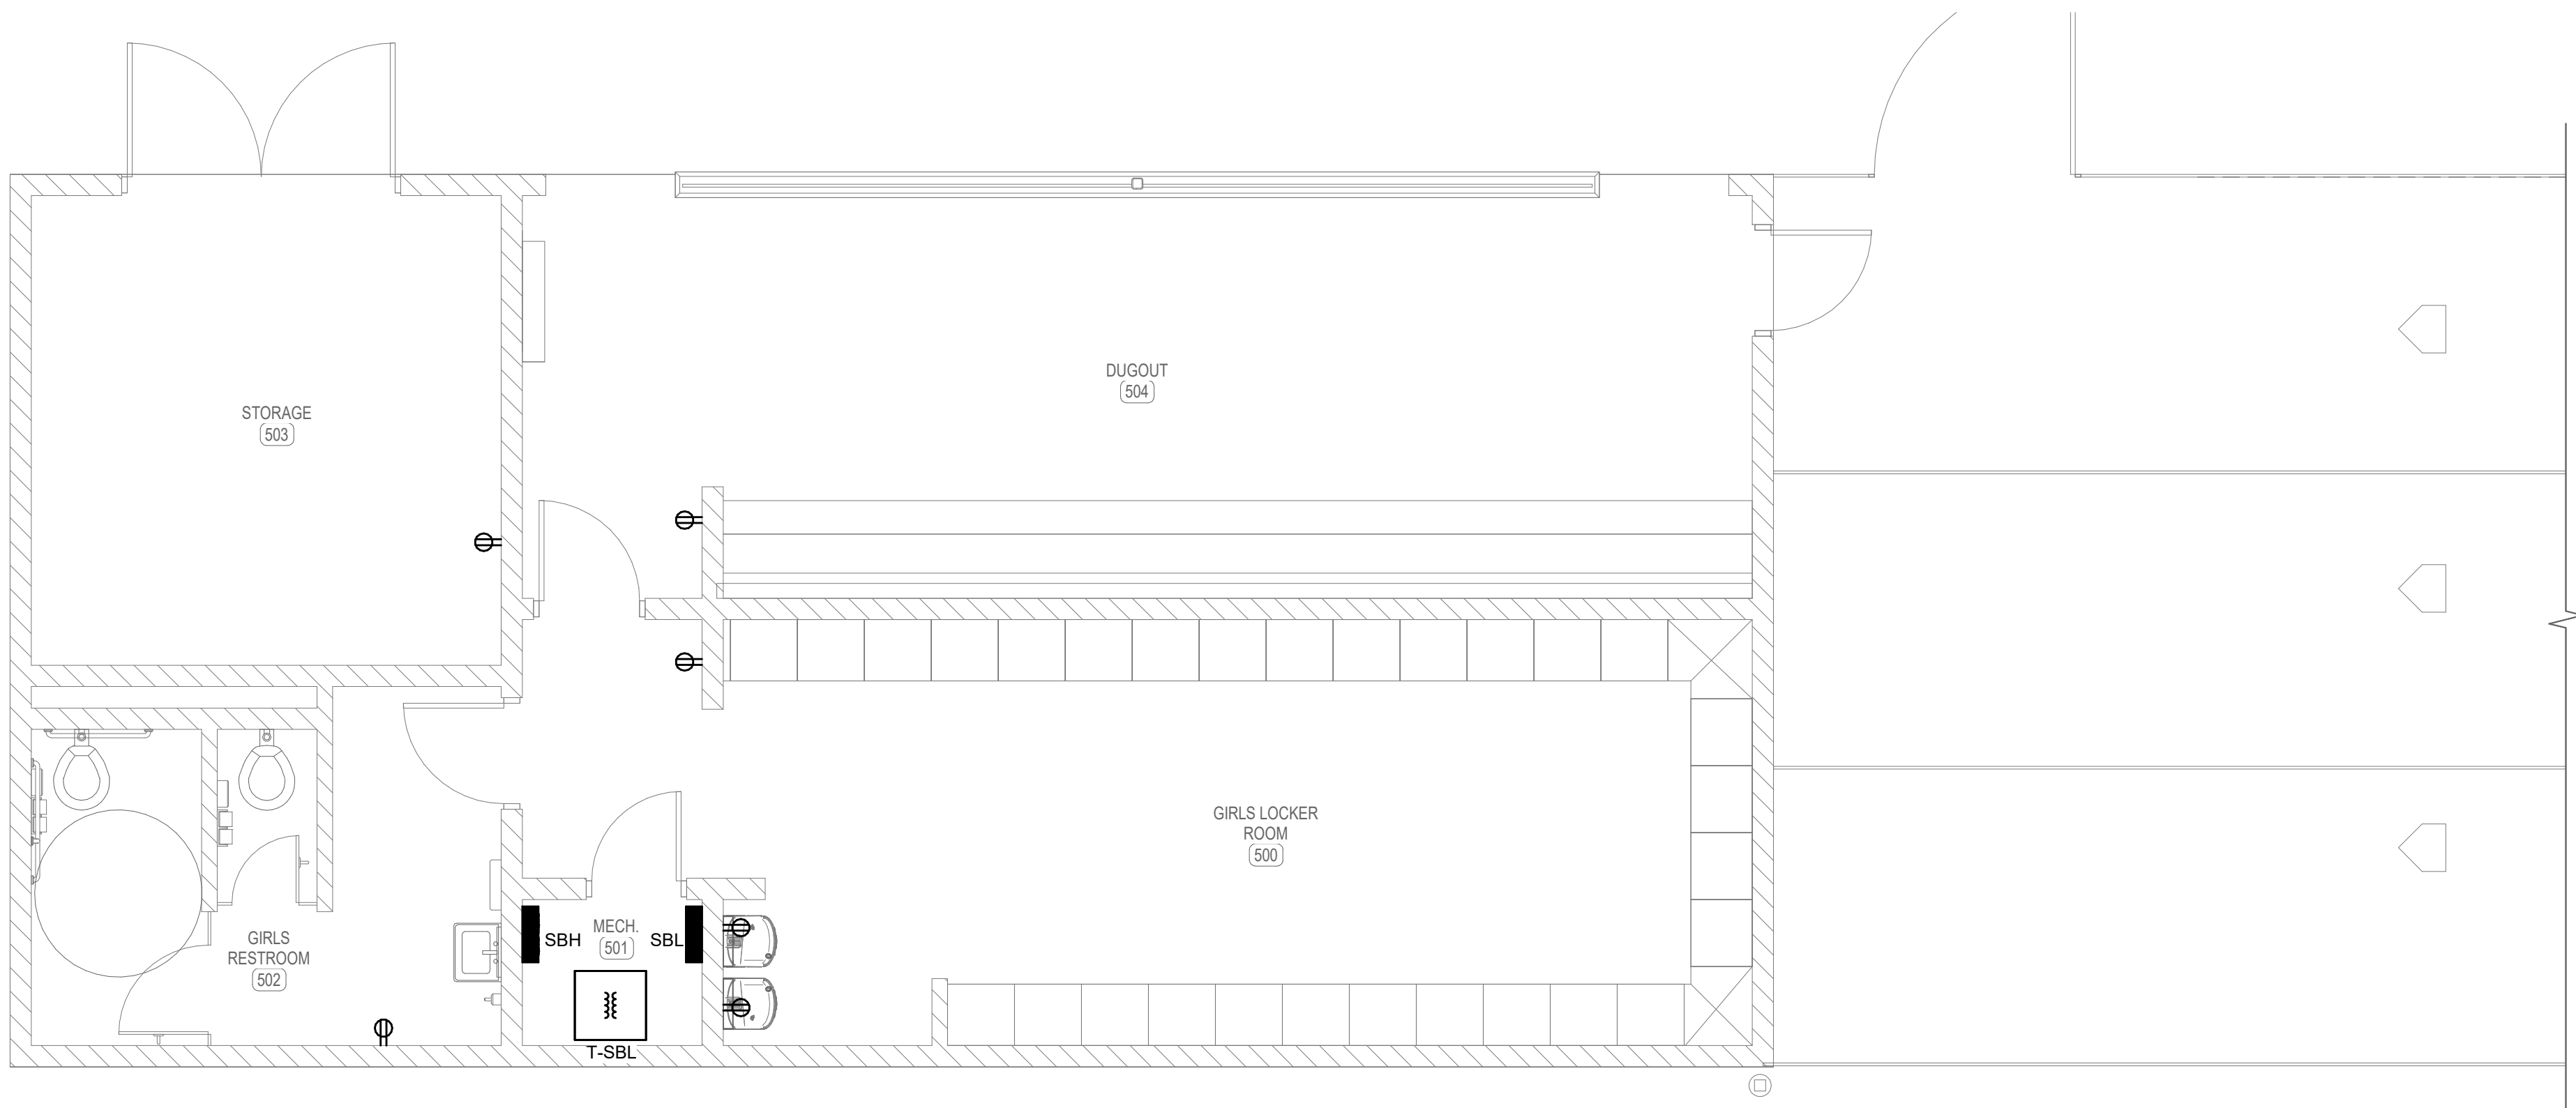

 2 FIRST FLOOR PLAN - GIRLS LOCKER ROOM AND DUGOUT - POWER AND SYSTEMS
SCALE: 1/4" = 1'-0"





KEY PLAN

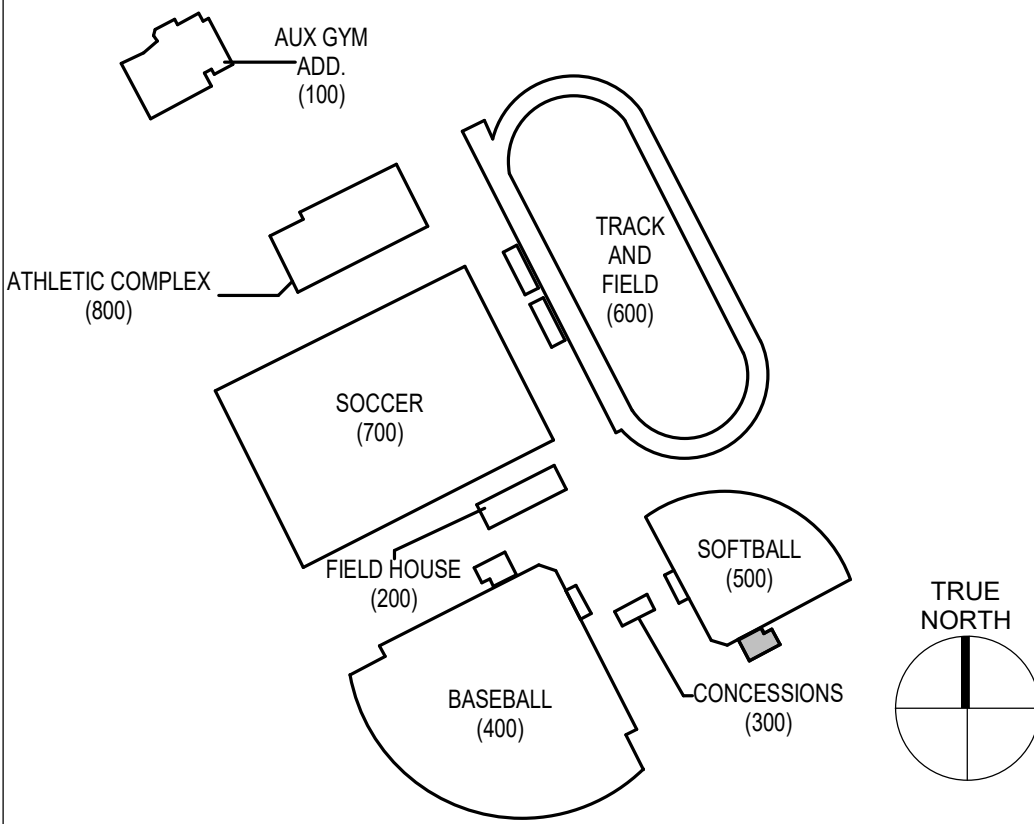

2459 ALLEN COUNTY - SCOTTSVILLE HIGH SCHOOL ATHLETIC COMPLEX
AutoDesk Docs/2459 Allen County Athletic Fields and Facilities/25008-Allen Co. v26 MEP.rvt
11/14/2025 4:23:50 PM



1

 FIRST FLOOR PLAN - GRANDSTAND RESTROOMS AND CONCESSIONS - LIGHTING
SCALE: 1/8" = 1'-0"

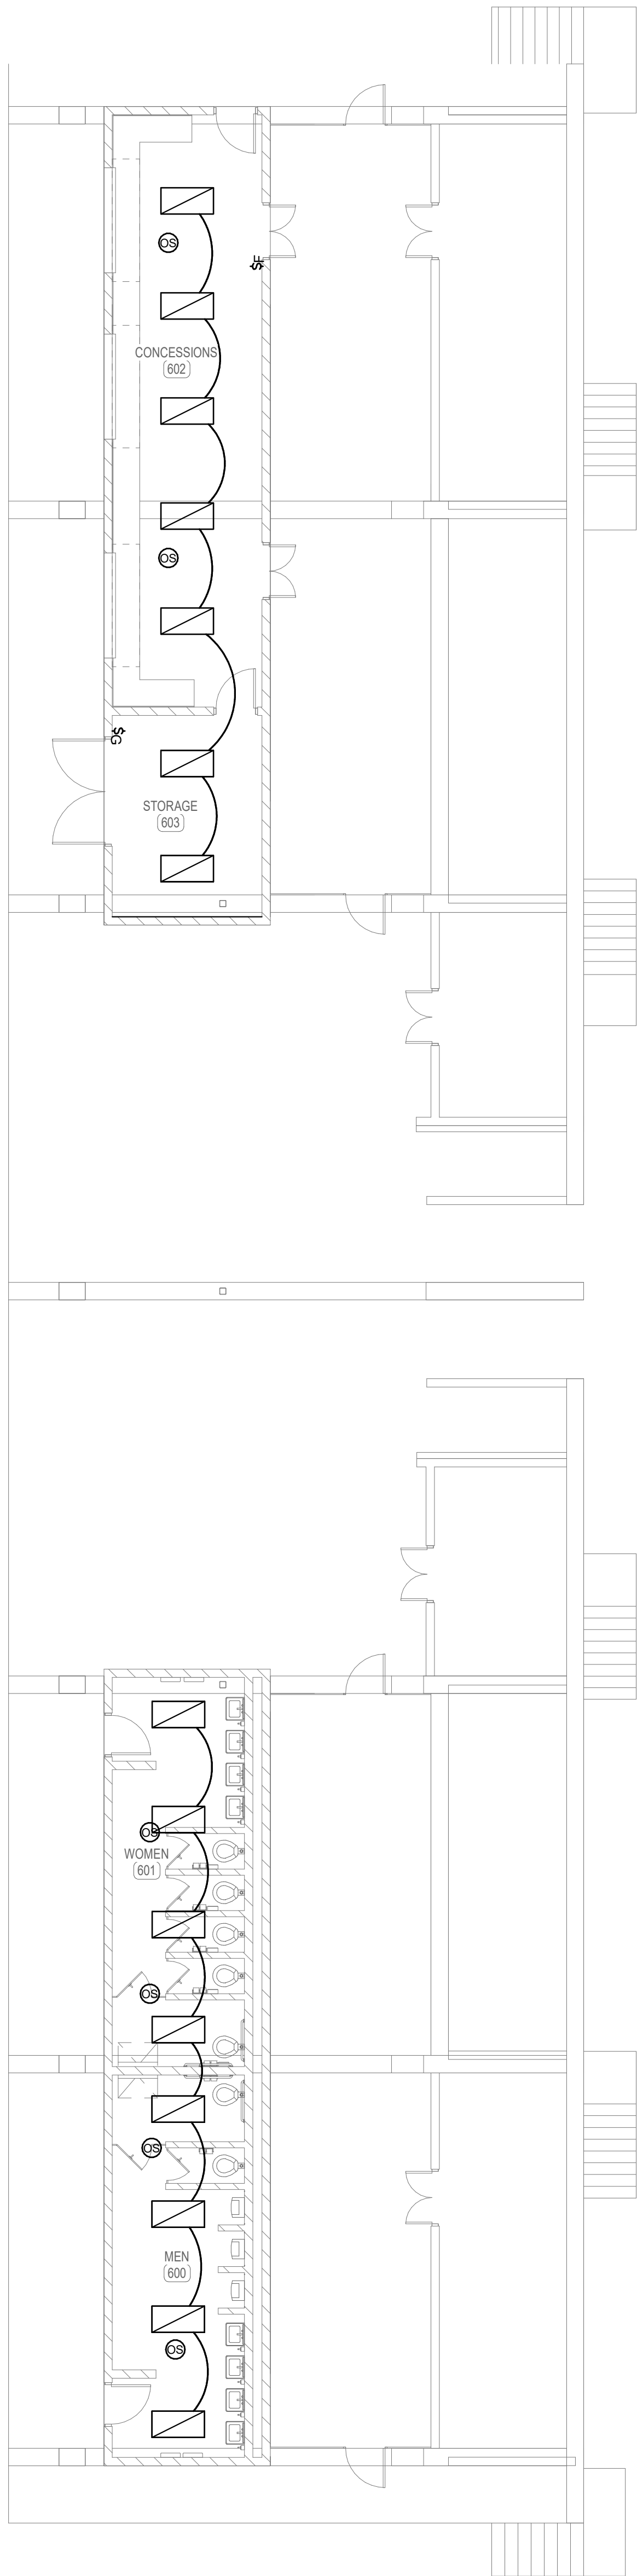

2

 FIRST FLOOR PLAN - GRANDSTAND RESTROOMS AND CONCESSIONS - POWER AND SYSTEMS
SCALE: 1/8" = 1'-0"

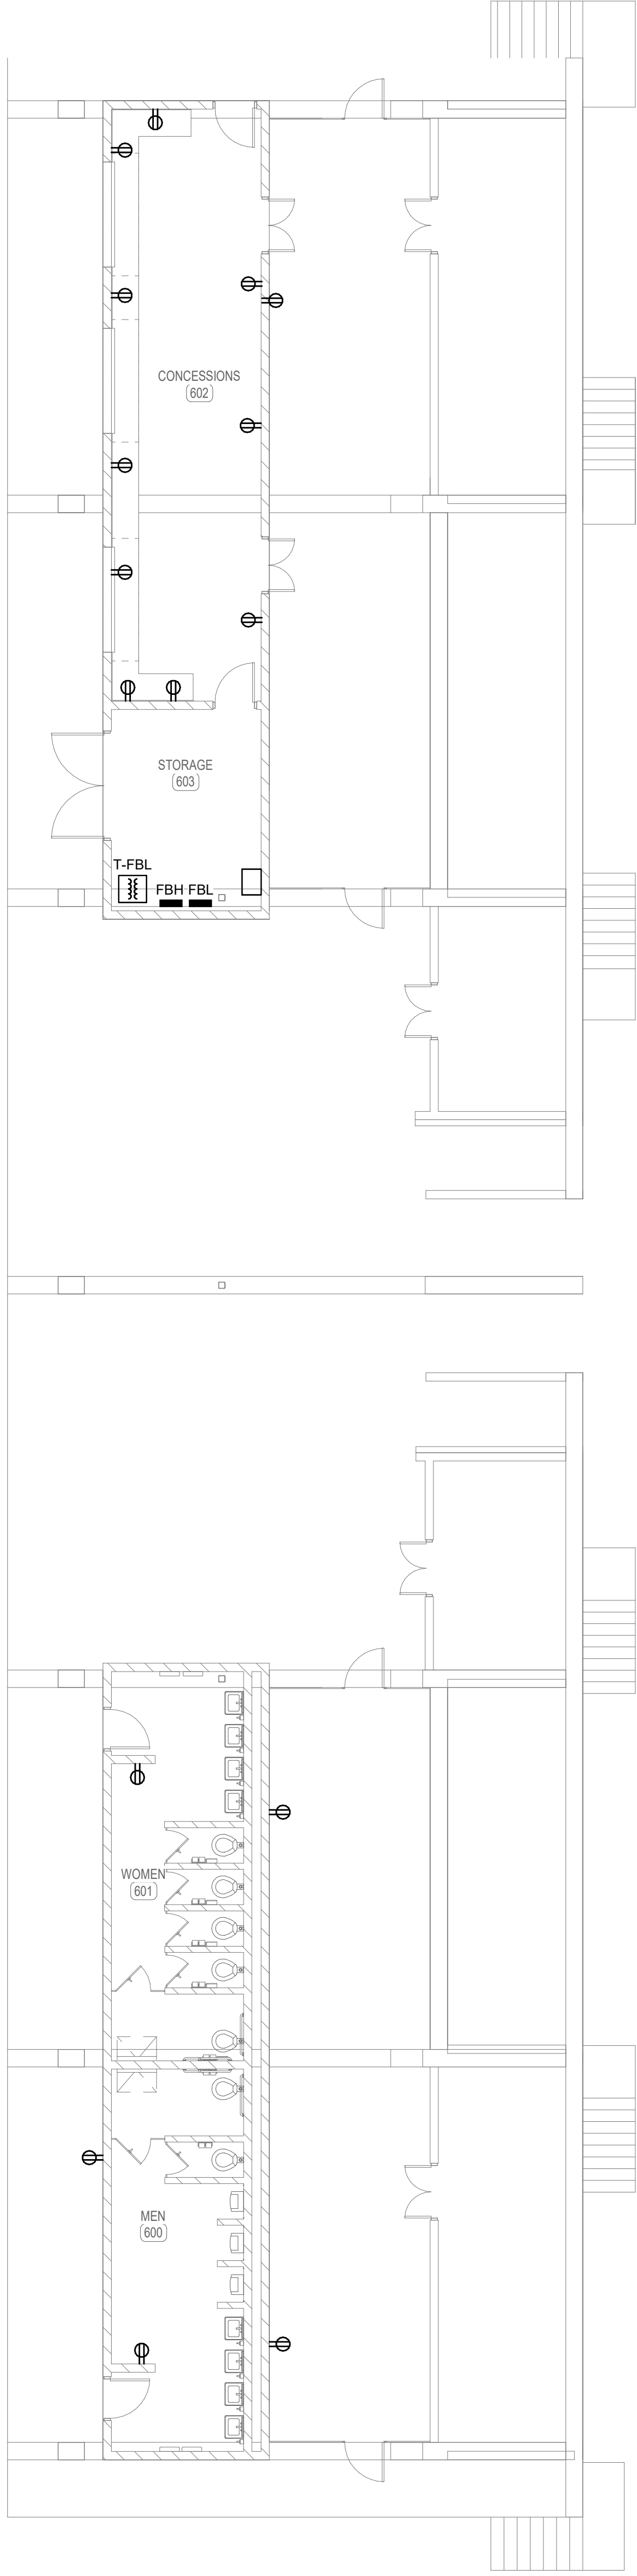


GENERAL NOTES

A. REFER TO SHEET XXX FOR GENERAL NOTES.

SHEET KEYNOTES

1. SHEET NOTES

KEY PLAN

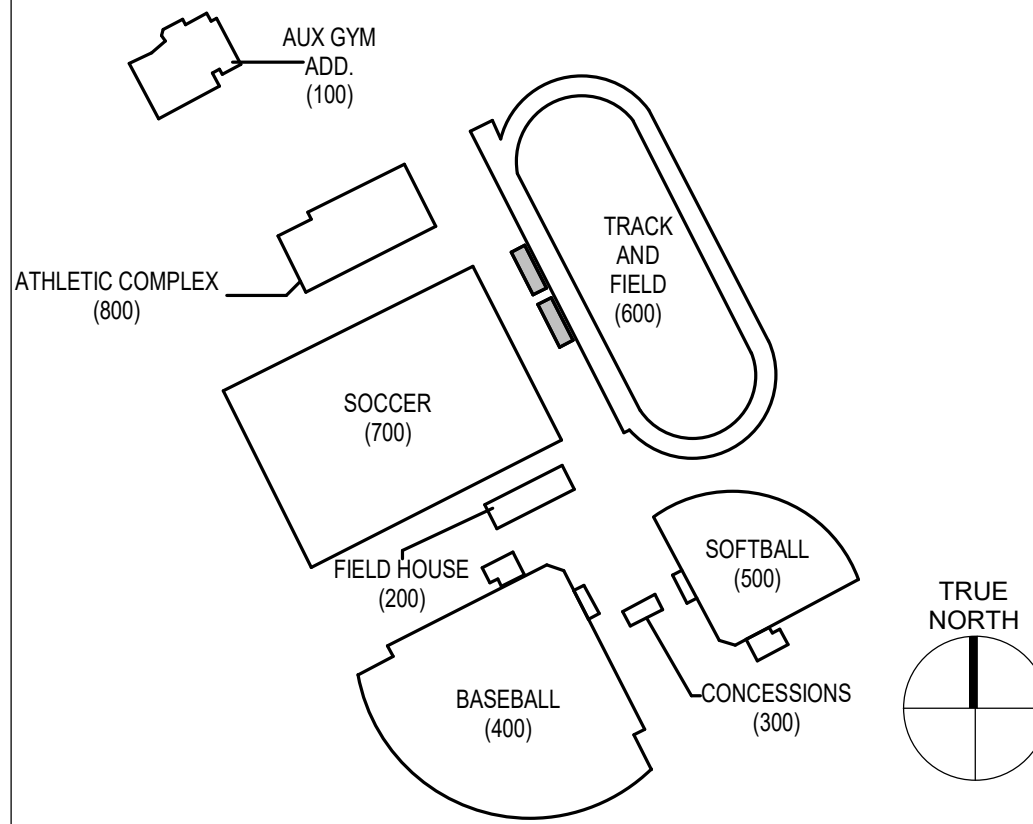

GRANDSTANDS - ELECTRICAL

JOB NO.	2459
DATE	NOV 17, 2025
DRAWN	STAFF
CHECKED	JWH

COPYRIGHT © 2025
SHERMAN CARTER BARNHART
ARCHITECTS, PLLC

REVISIONS

No.	Description	Date


SHEET


E610



ALLEN COUNTY - SCOTTSVILLE
HIGH SCHOOL ATHLETIC
COMPLEX
SCOTTSVILLE, KENTUCKY



SHERMAN
CARTER
BARNHART
ARCHITECTS

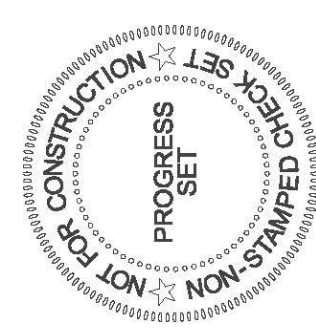

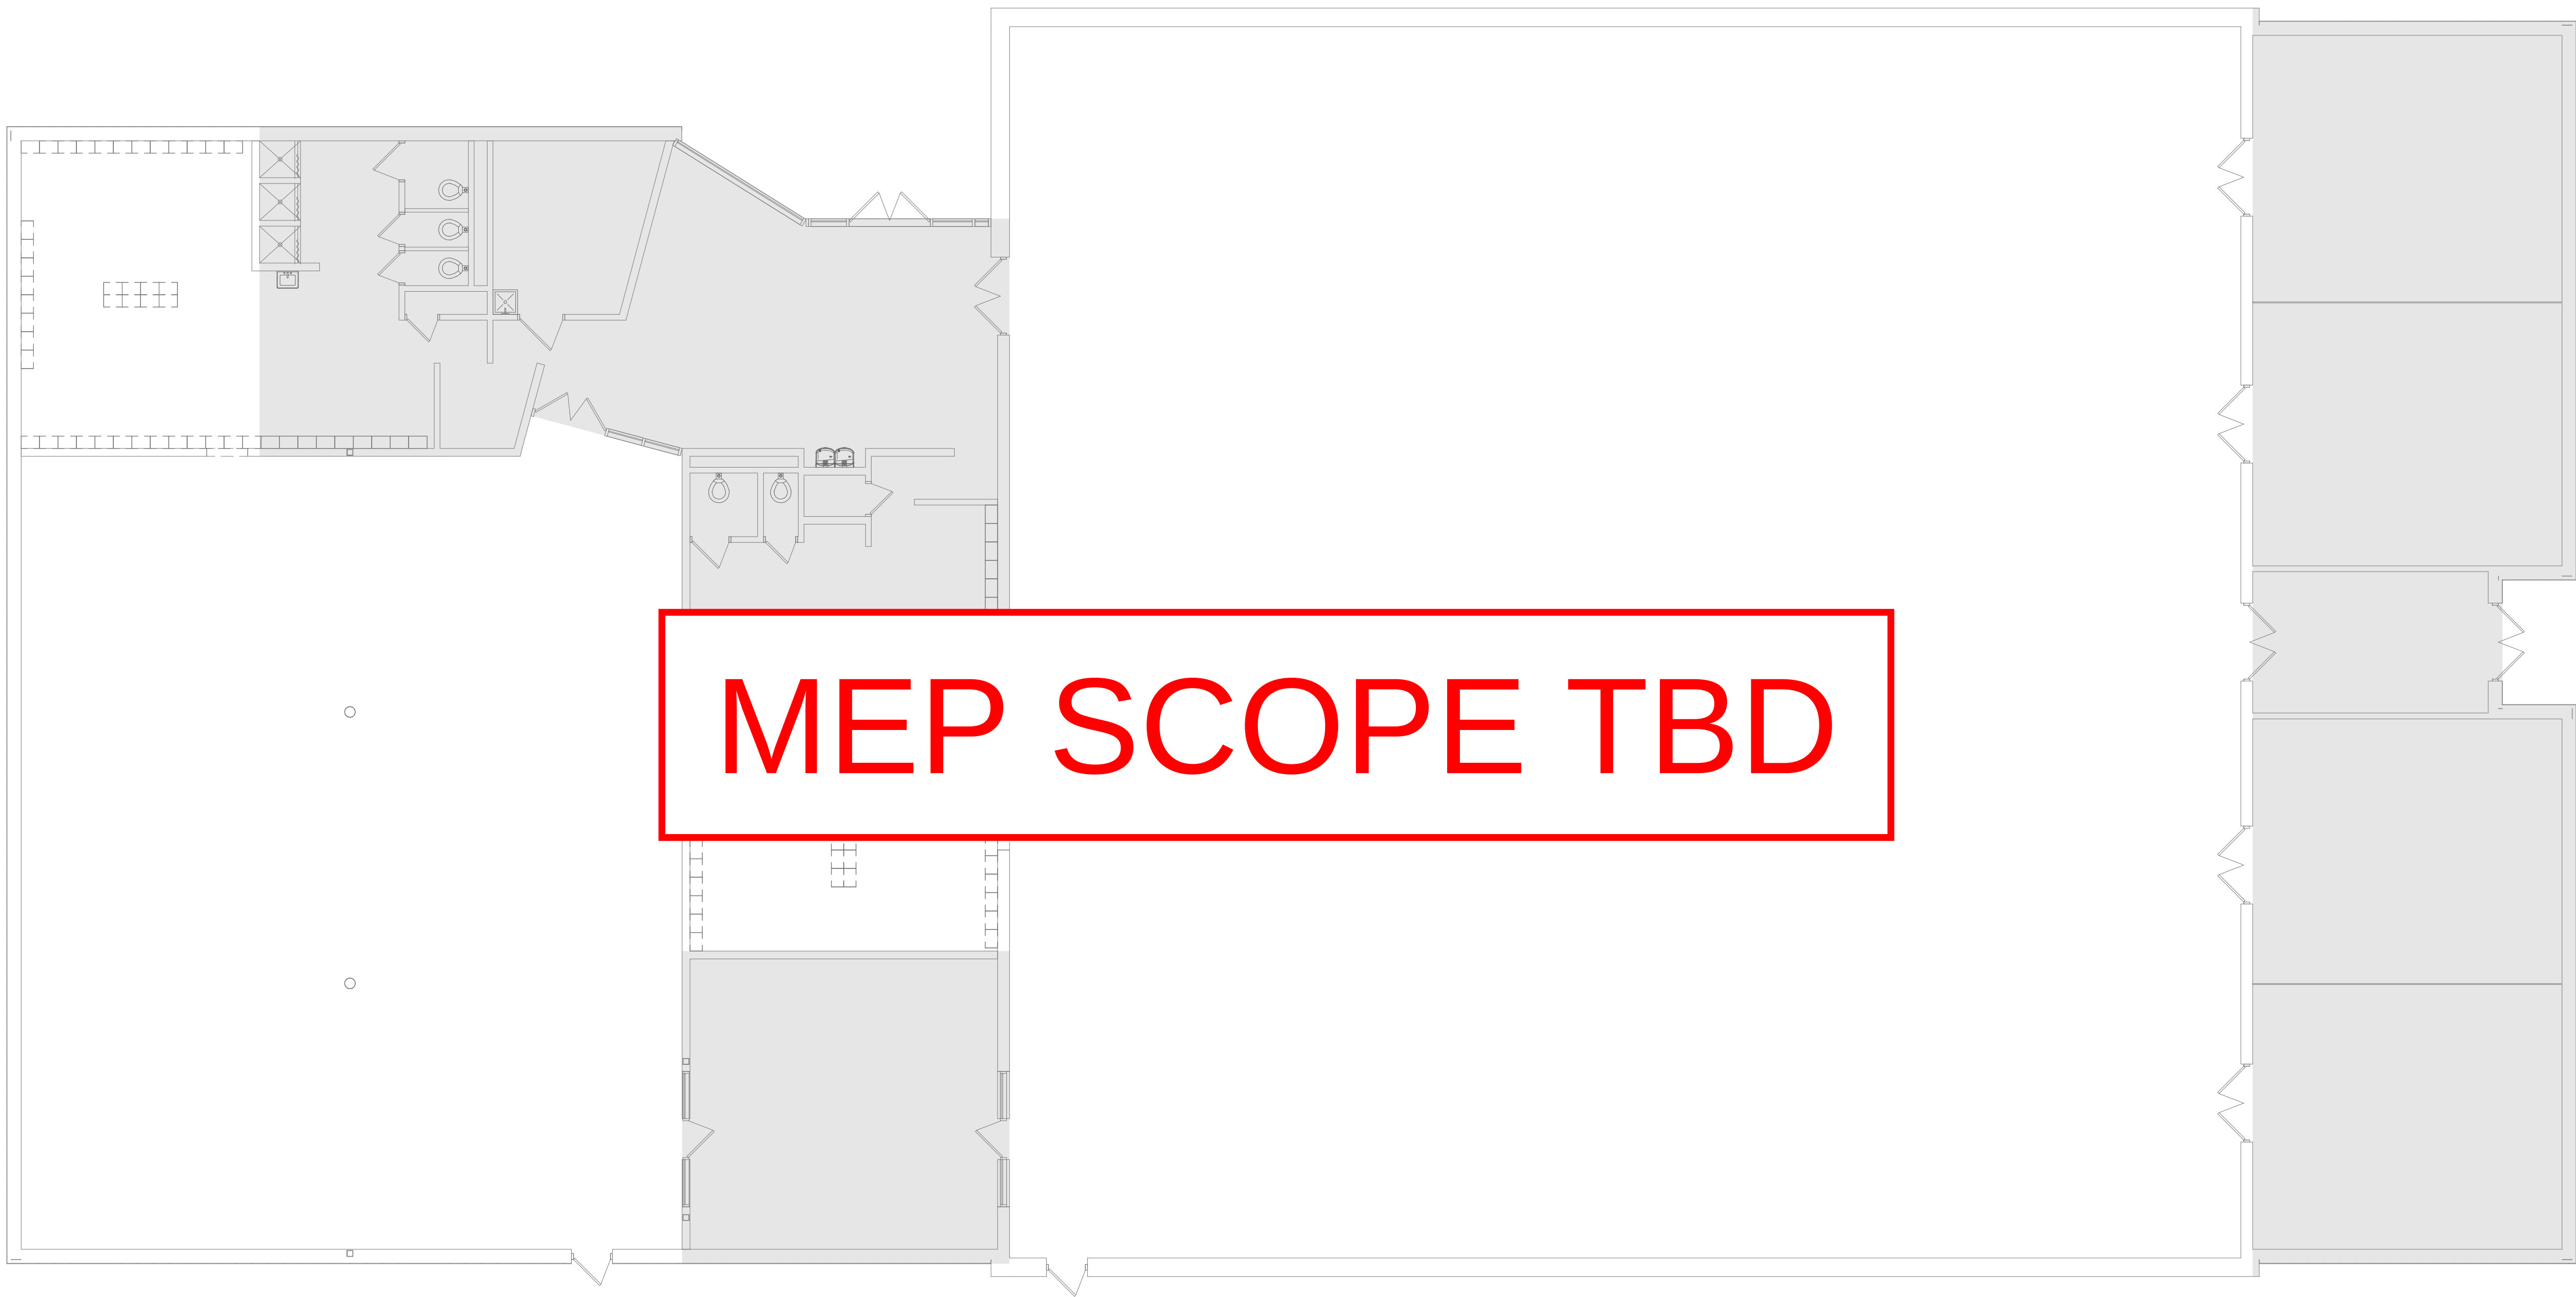

1 FIRST FLOOR DEMOLITON PLAN - ATHLETIC COMPLEX PLAN - ELECTRICAL

 SCALE: 1/8" = 1'-0"

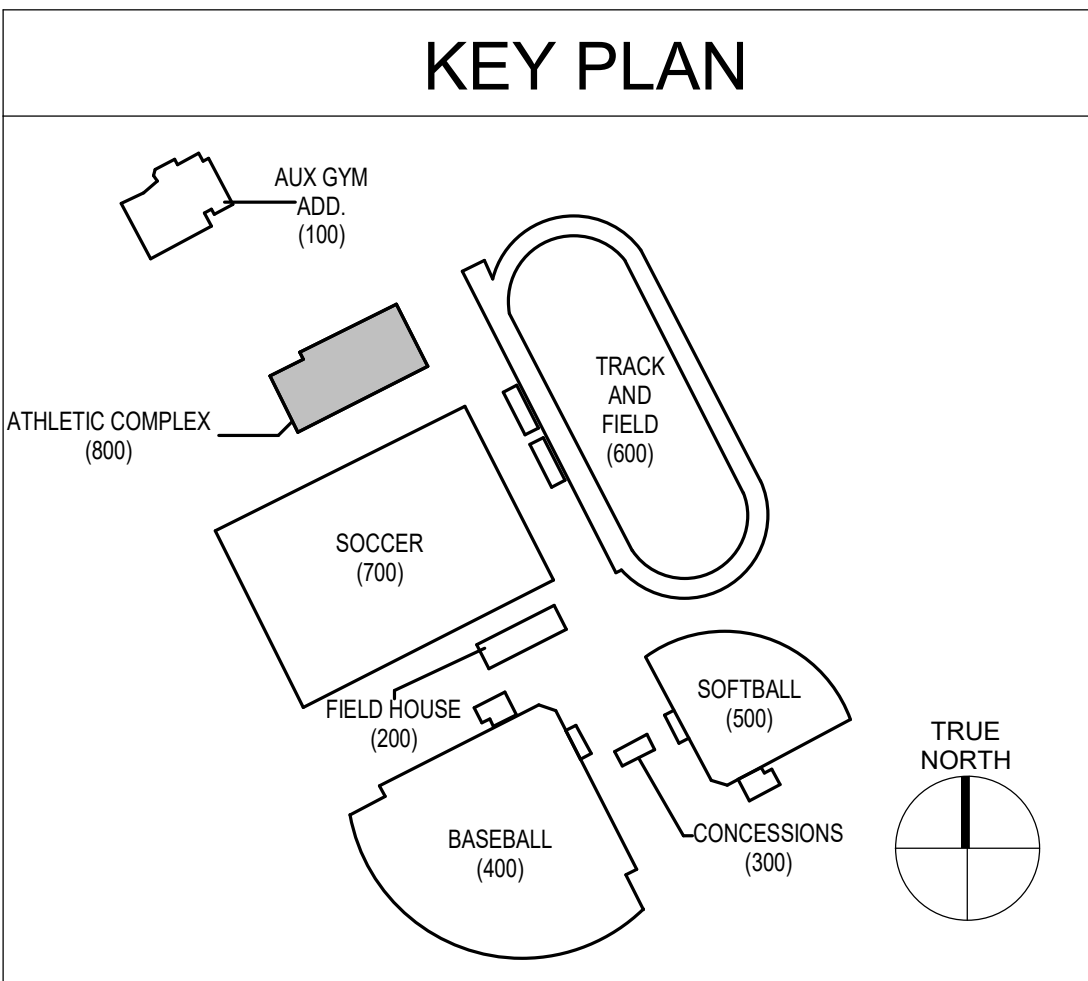

GENERAL NOTES

A. REFER TO SHEET P001 AND M001 FOR PLUMBING AND MECHANICAL LEGENDS AND GENERAL NOTES.

SHEET KEYNOTES


1. SHEET NOTES

GENERAL NOTES

A. REFER TO SHEET P001 AND M001 FOR PLUMBING AND MECHANICAL LEGENDS AND GENERAL NOTES.

SHEET KEYNOTES

1. SHEET NOTES

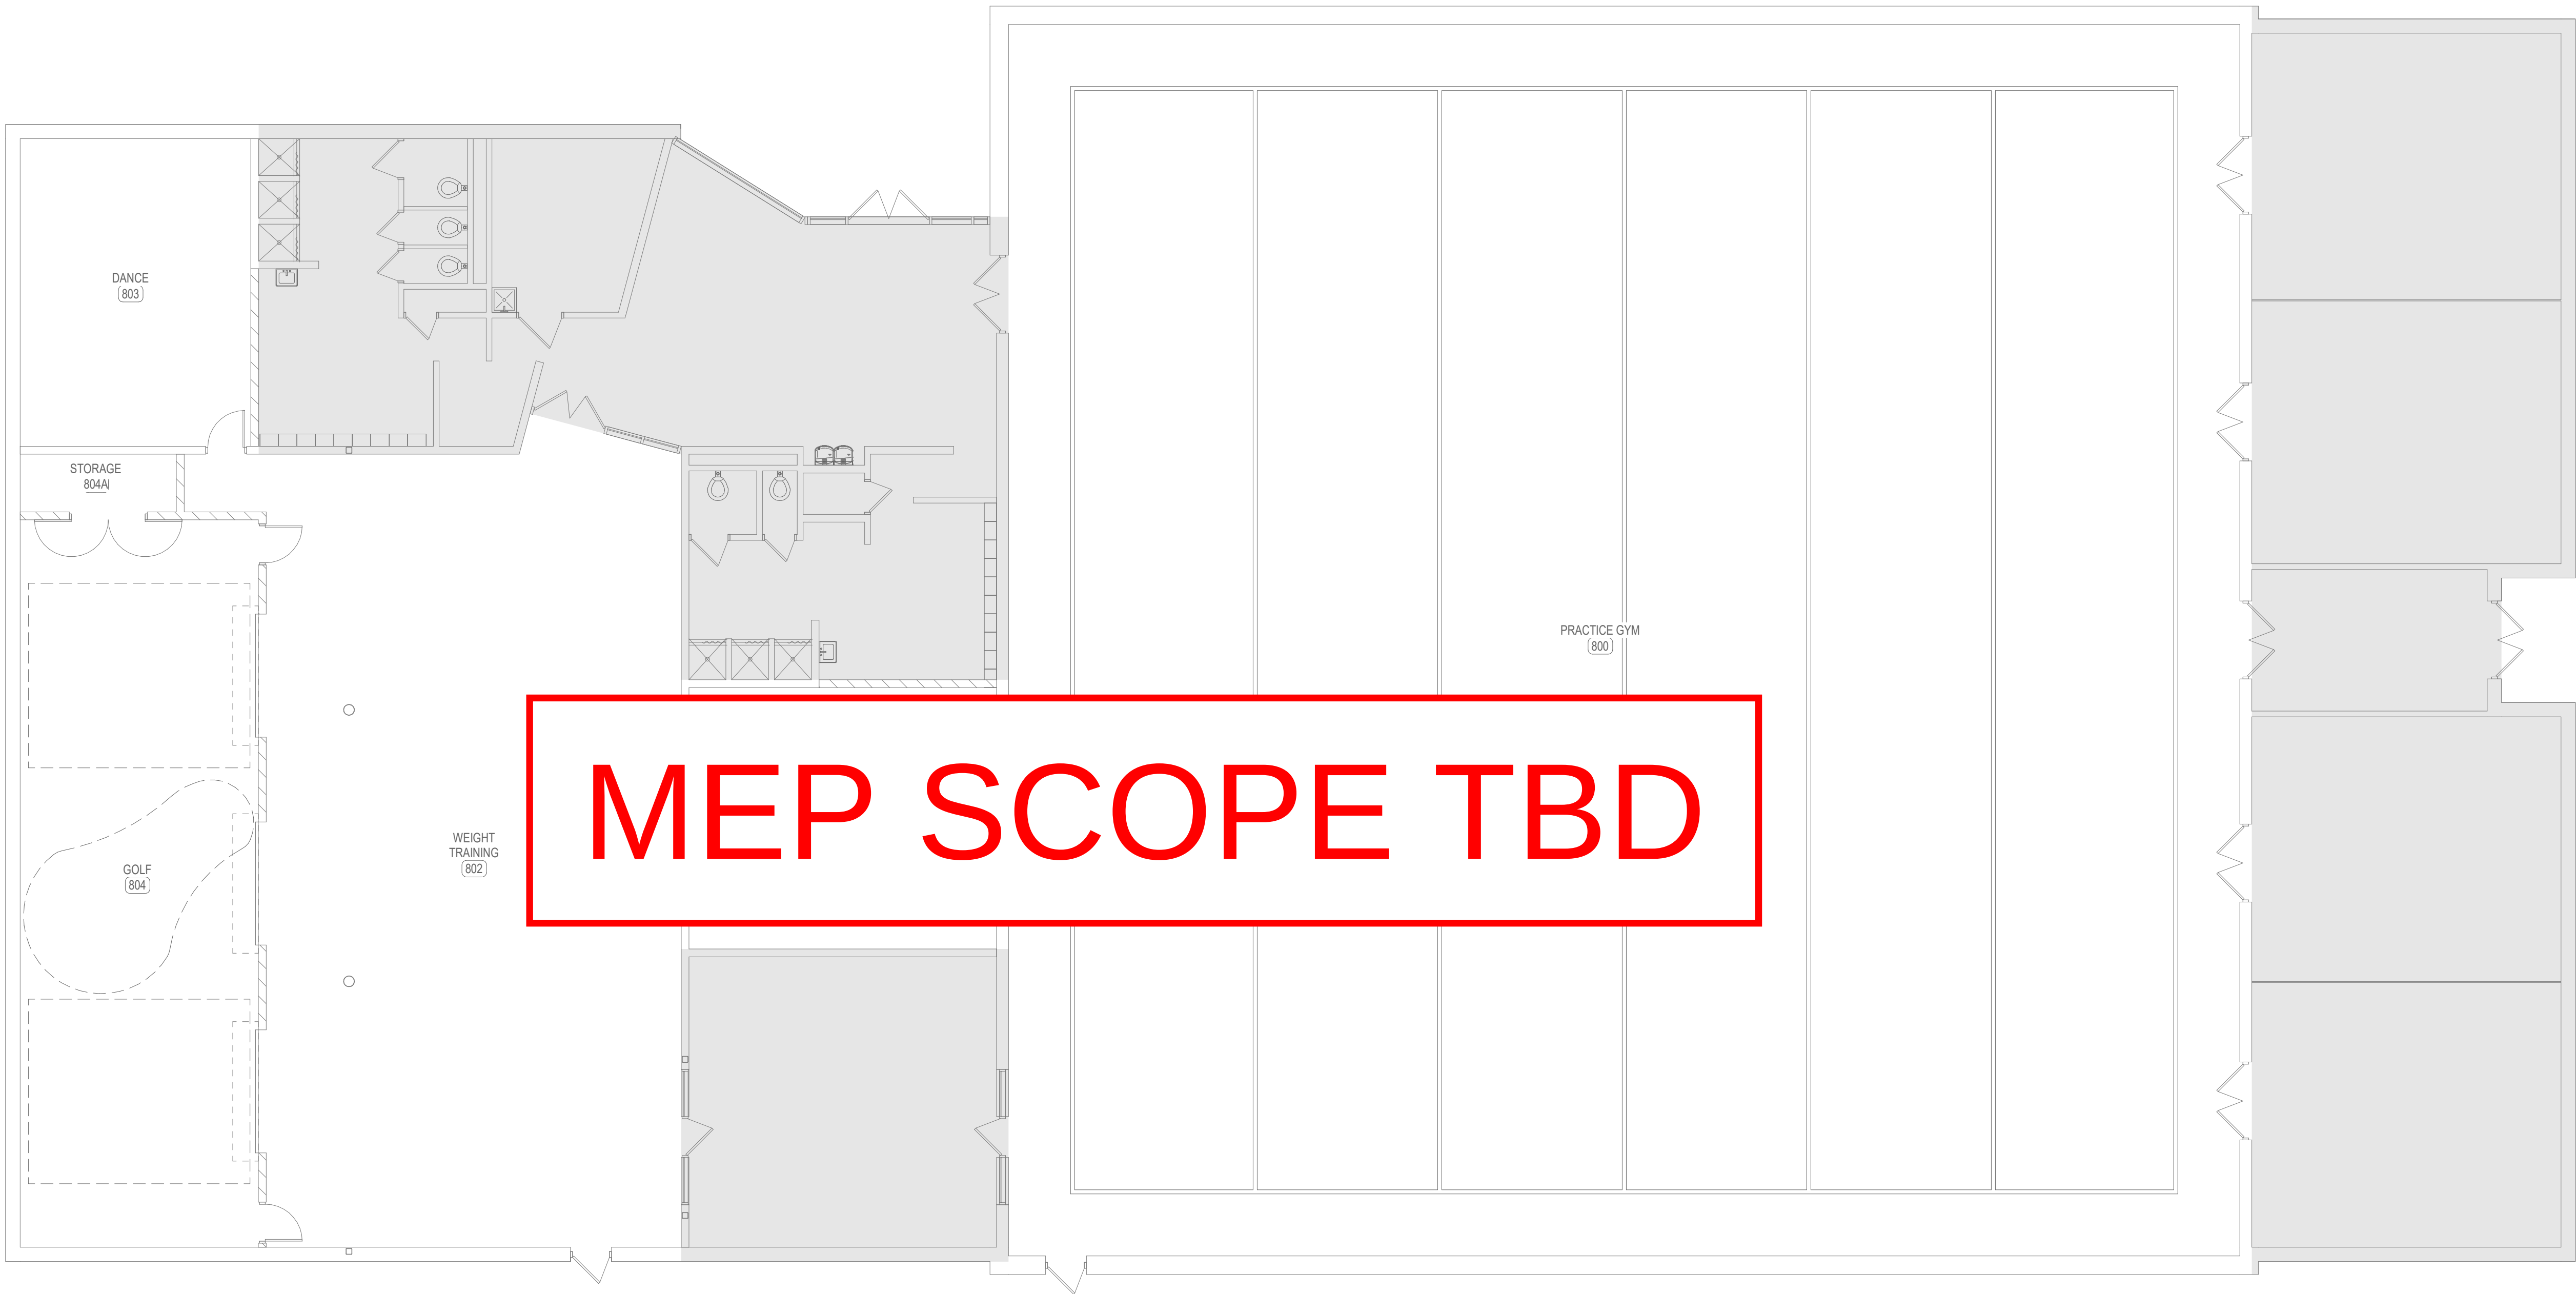


1 FIRST FLOOR PLAN - ATHLETICS COMPLEX PLAN - ELECTRICAL


SCALE: 1/8" = 1'-0"




KEY PLAN

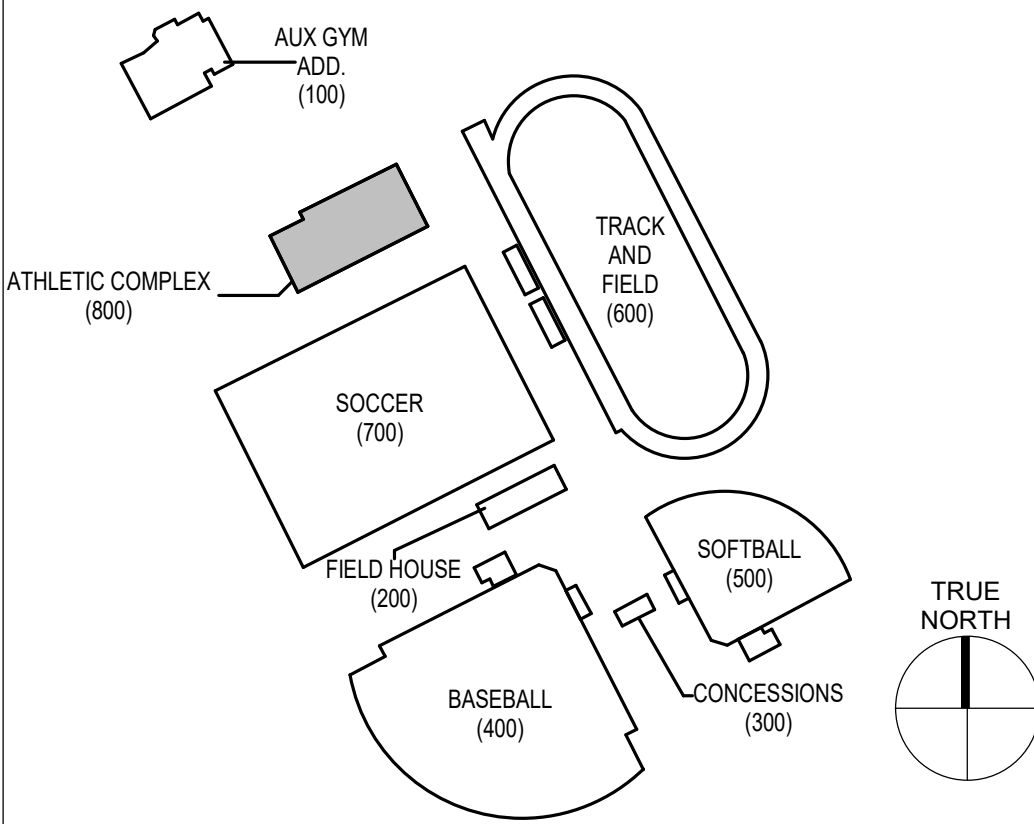


2459 ALLEN COUNTY - SCOTTSVILLE HIGH SCHOOL ATHLETIC COMPLEX
AutoSave: D:\2459 Allen County Athletic Fields and Facilities\25008-Allen Co. V08 MEP.rvt
1/11/2025 4:23:51 PM

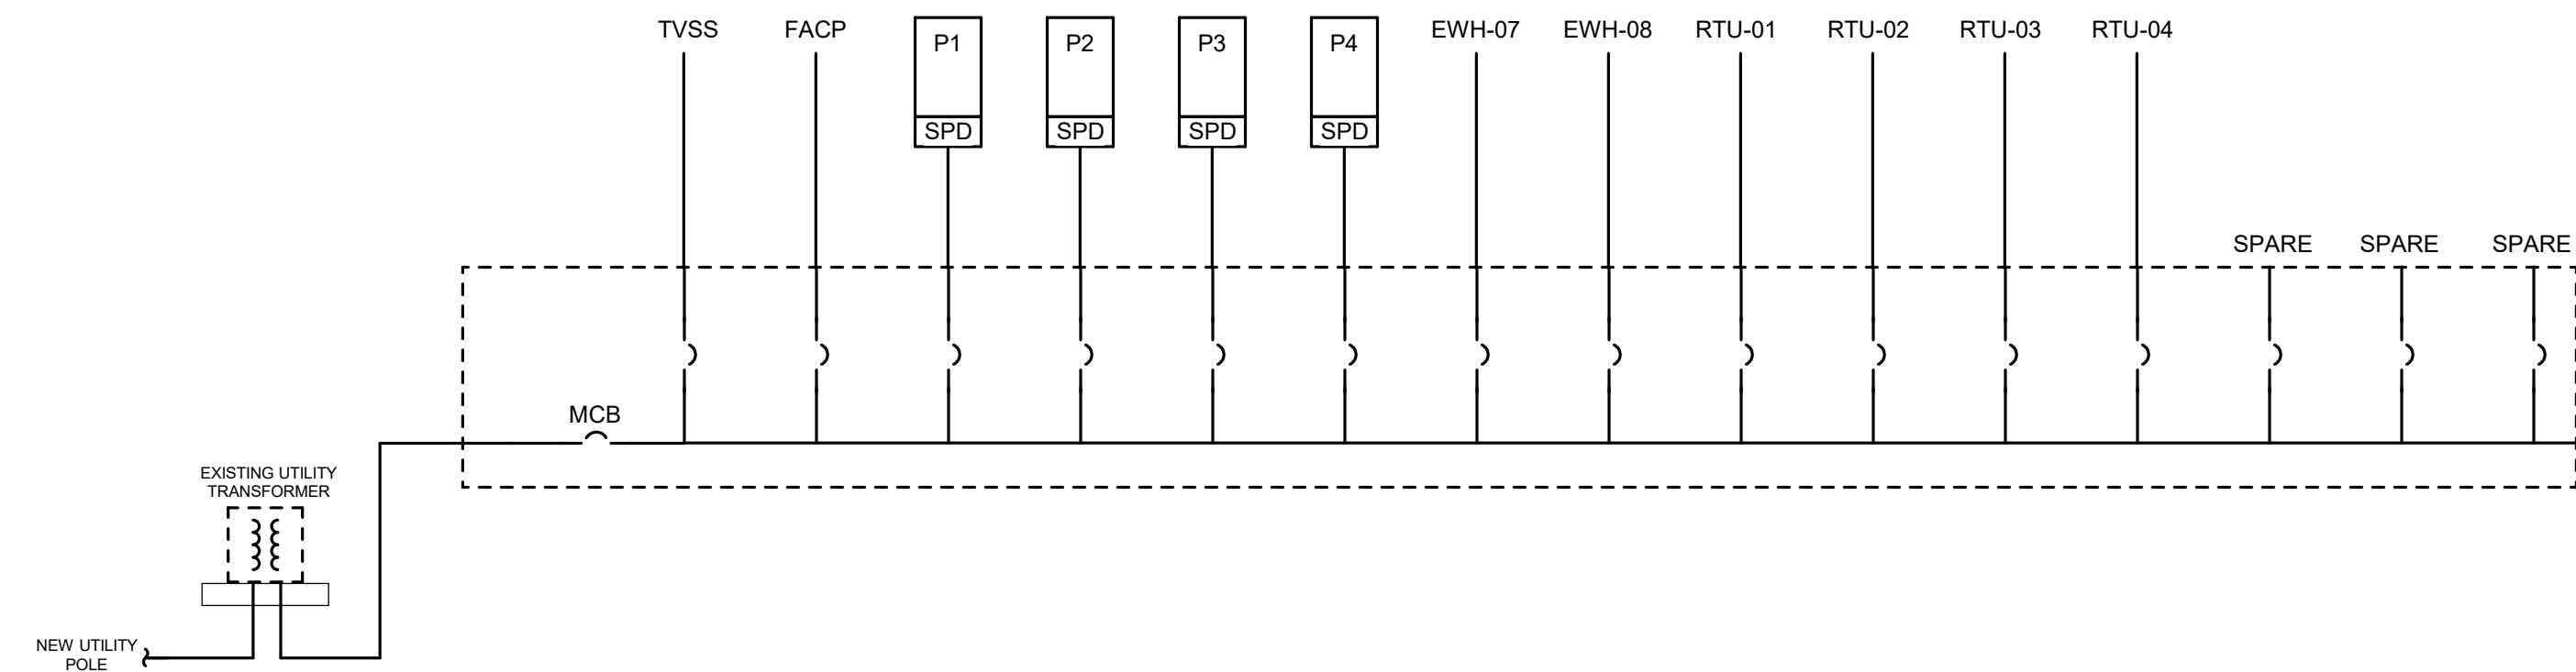


3 ATHLETIC COMPLEX POWER DISTRIBUTION ONE-LINE DIAGRAM
NOT TO SCALE

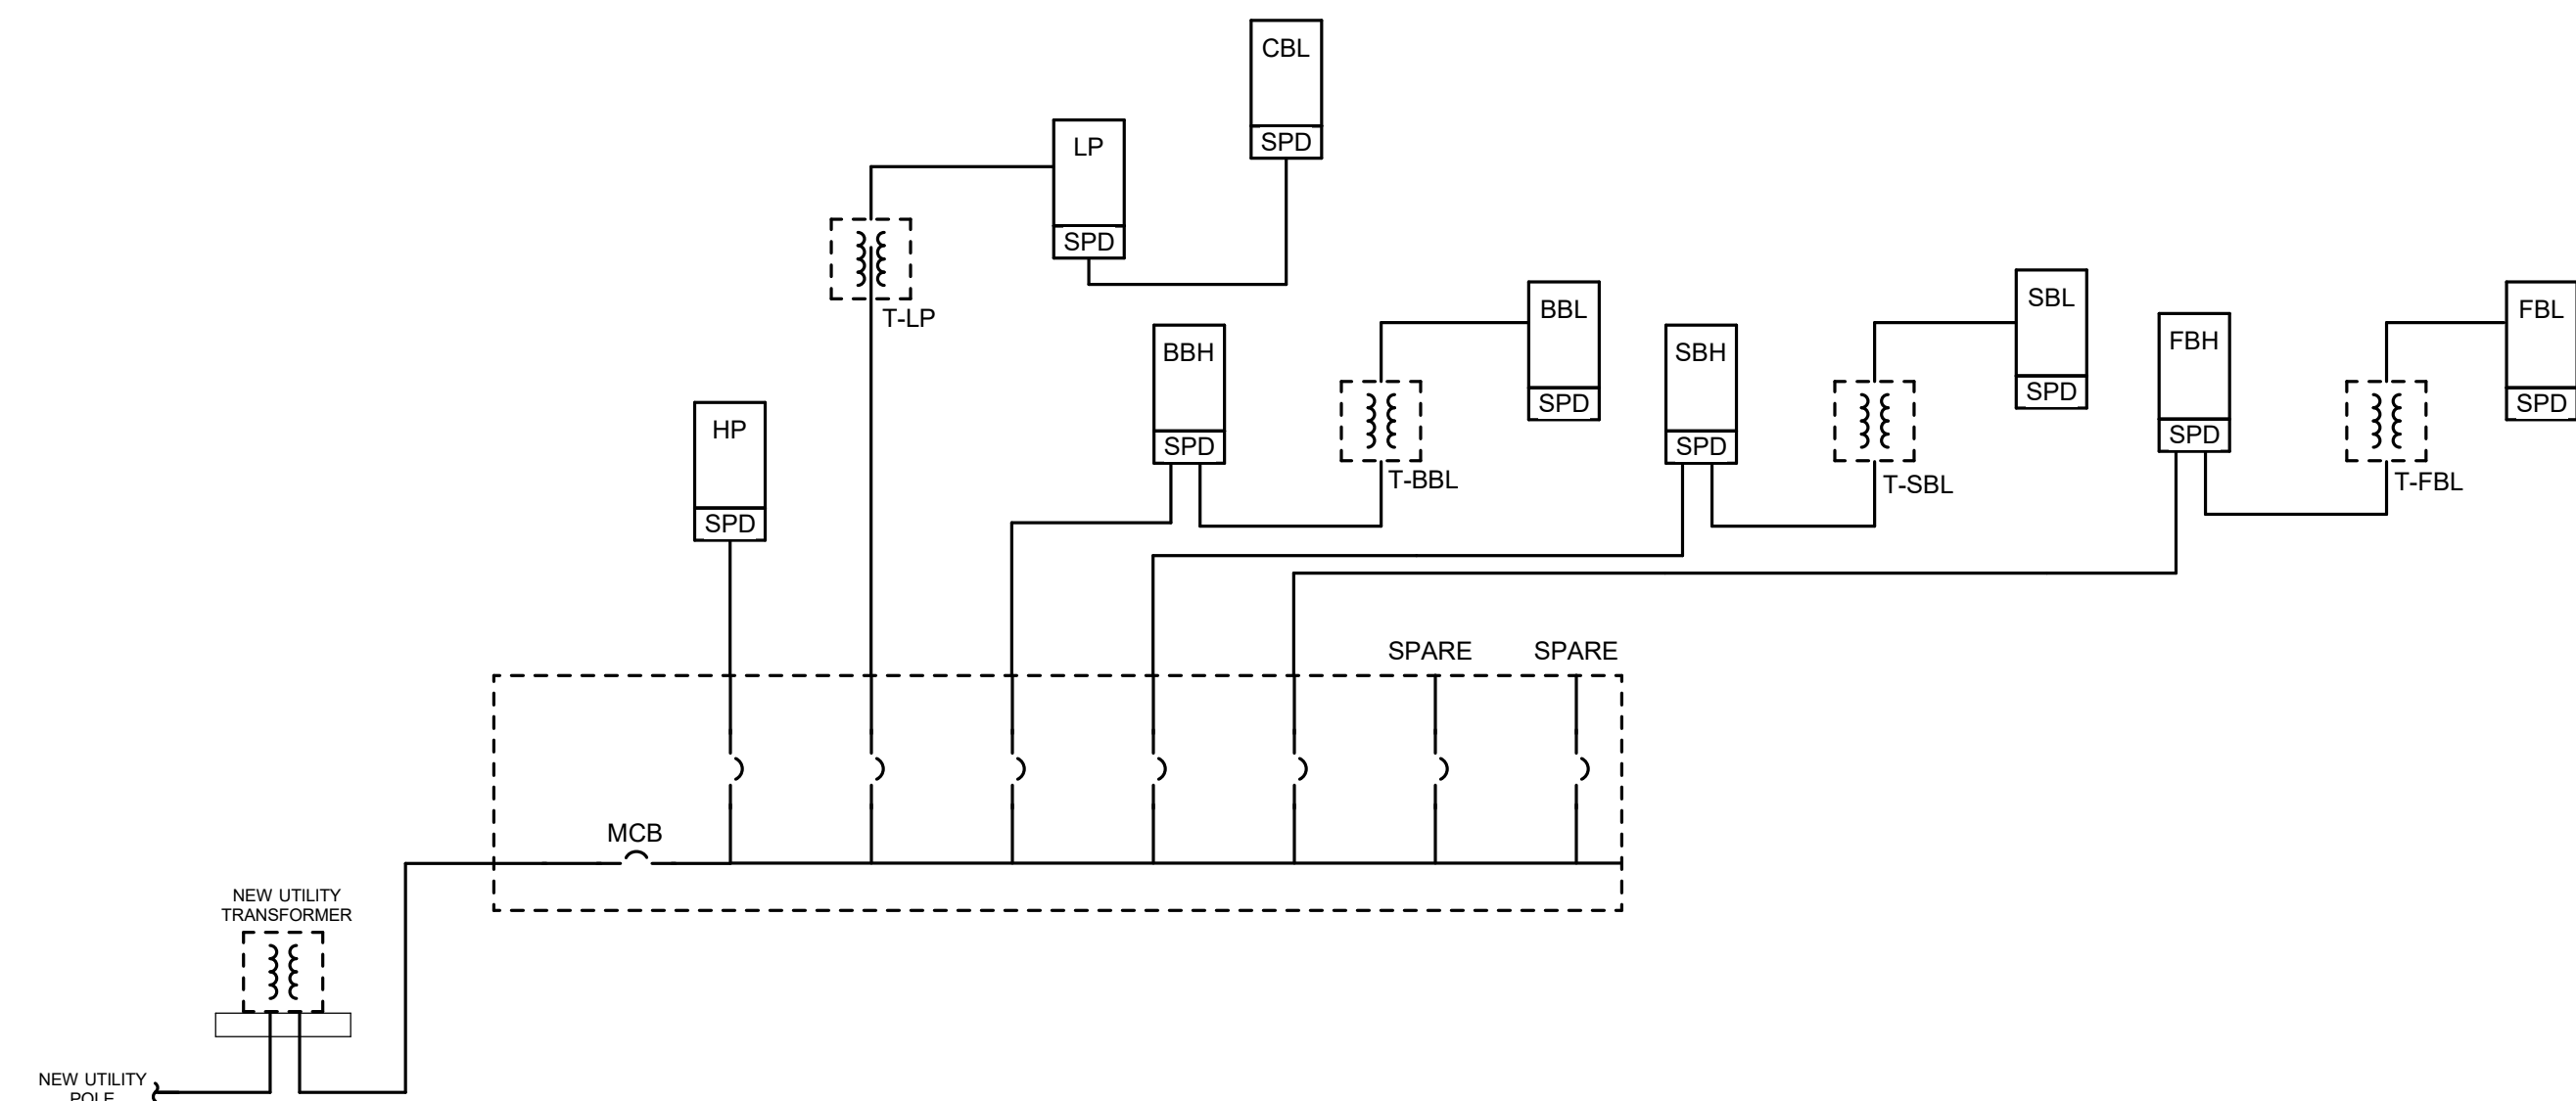

2 FIELDHOUSE POWER DISTRIBUTION ONE-LINE DIAGRAM
NOT TO SCALE

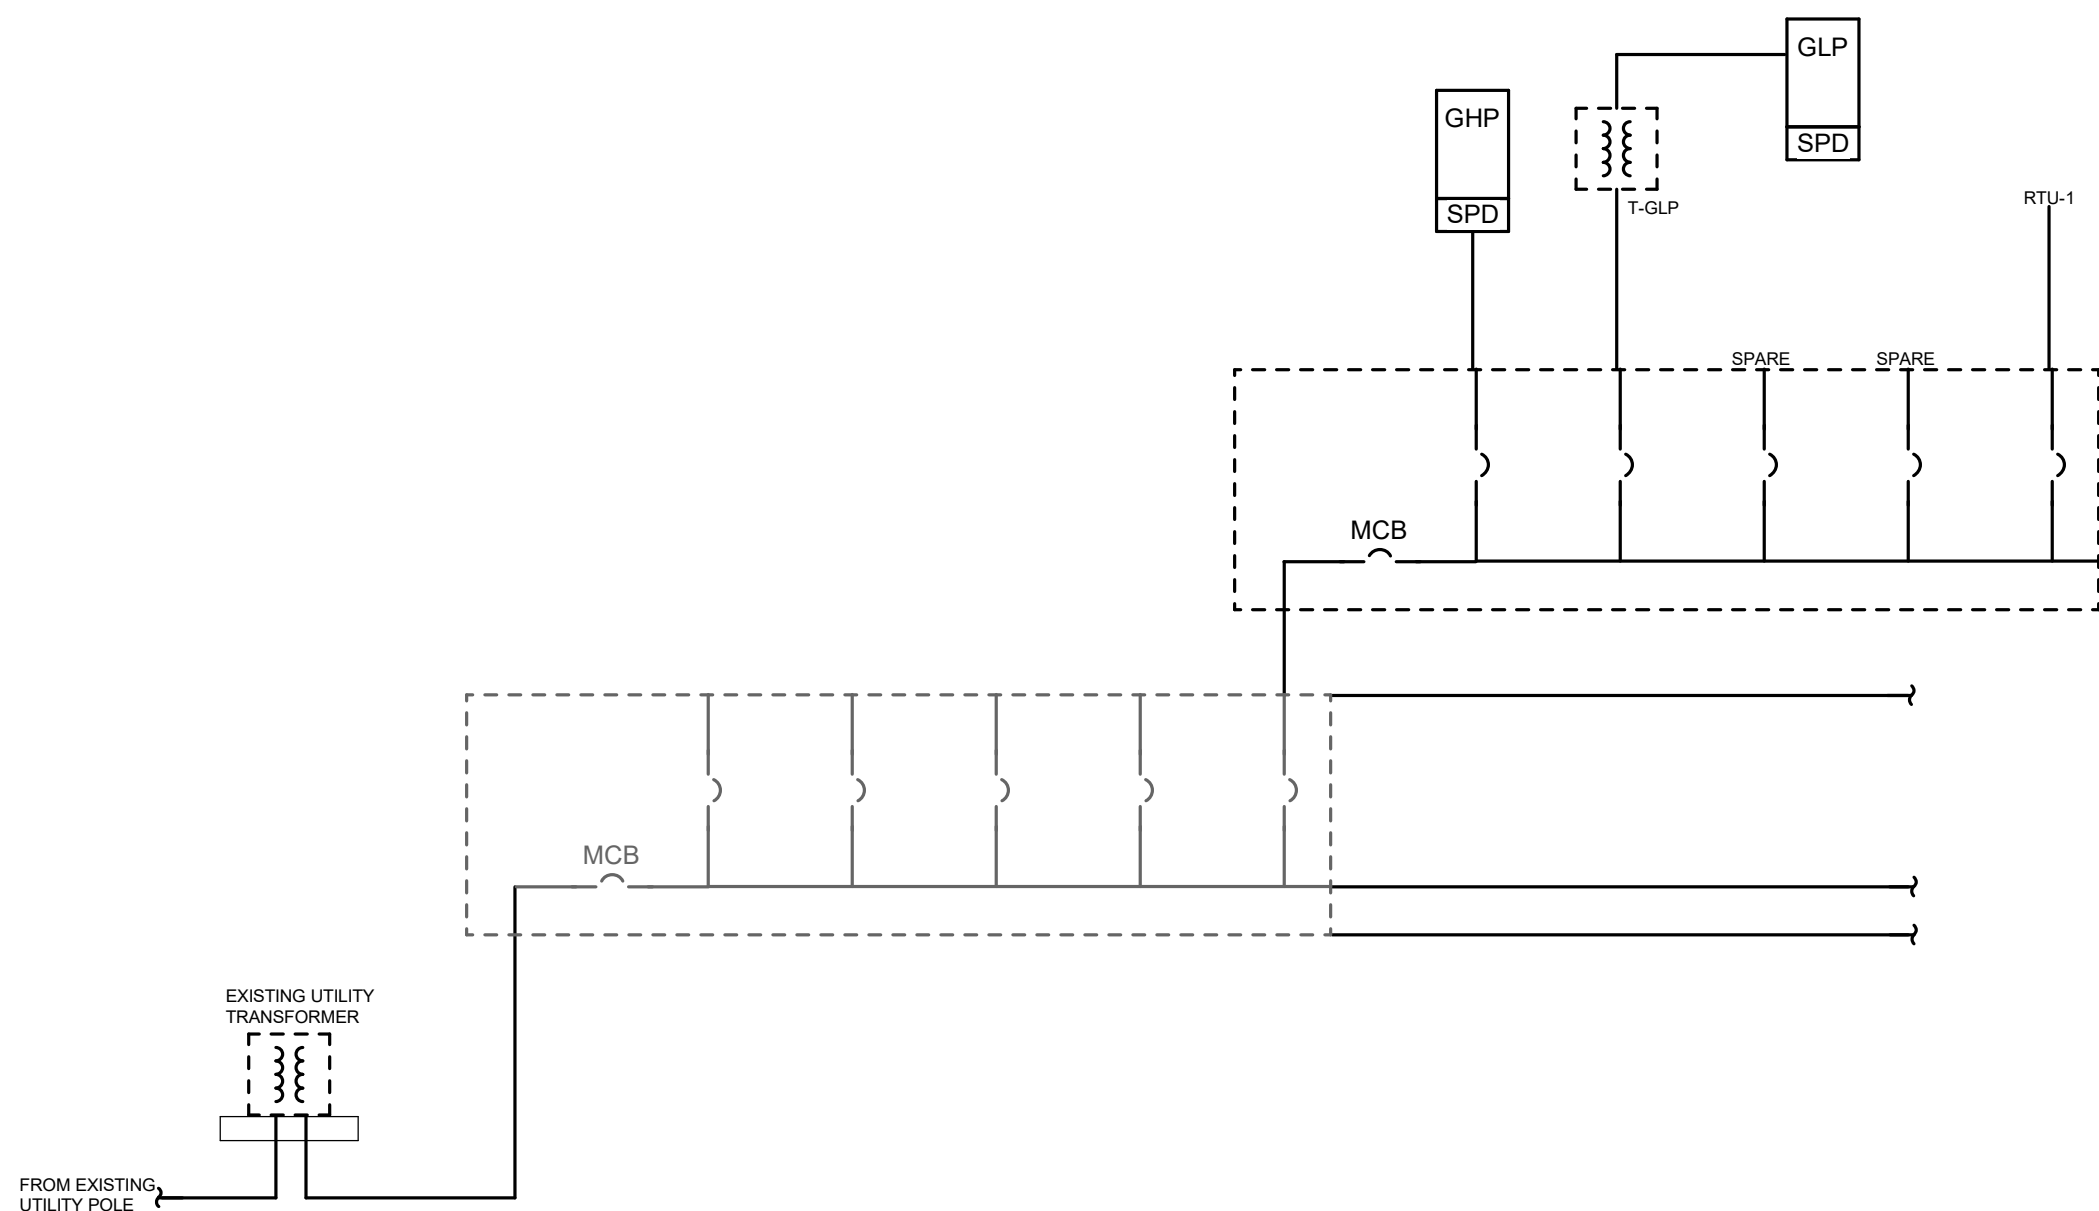

1 HIGHSCHOOL POWER DISTRIBUTION ONE-LINE DIAGRAM
NOT TO SCALE

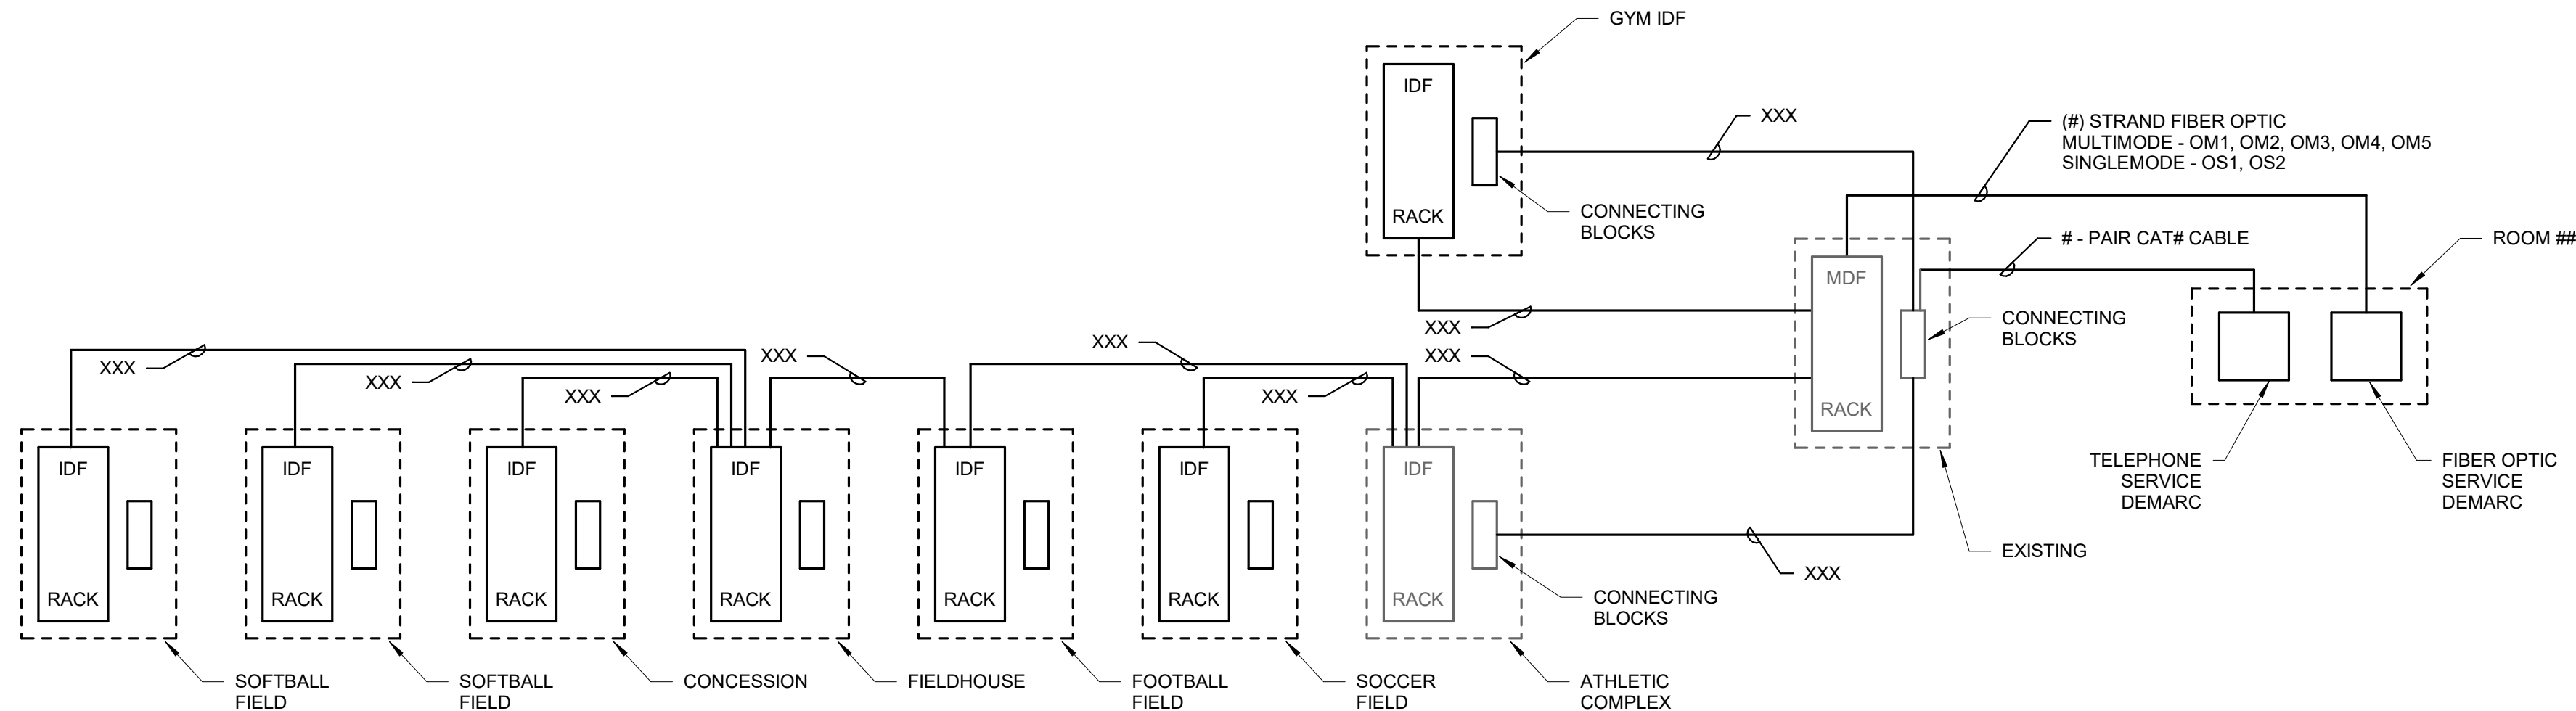


4 COMMUNICATIONS BACKBONE CABLING ONE-LINE DIAGRAM
NOT TO SCALE

GENERAL NOTES

A. REFER TO SHEET XXX FOR GENERAL NOTES.

SHEET KEYNOTES

1. SHEET NOTES

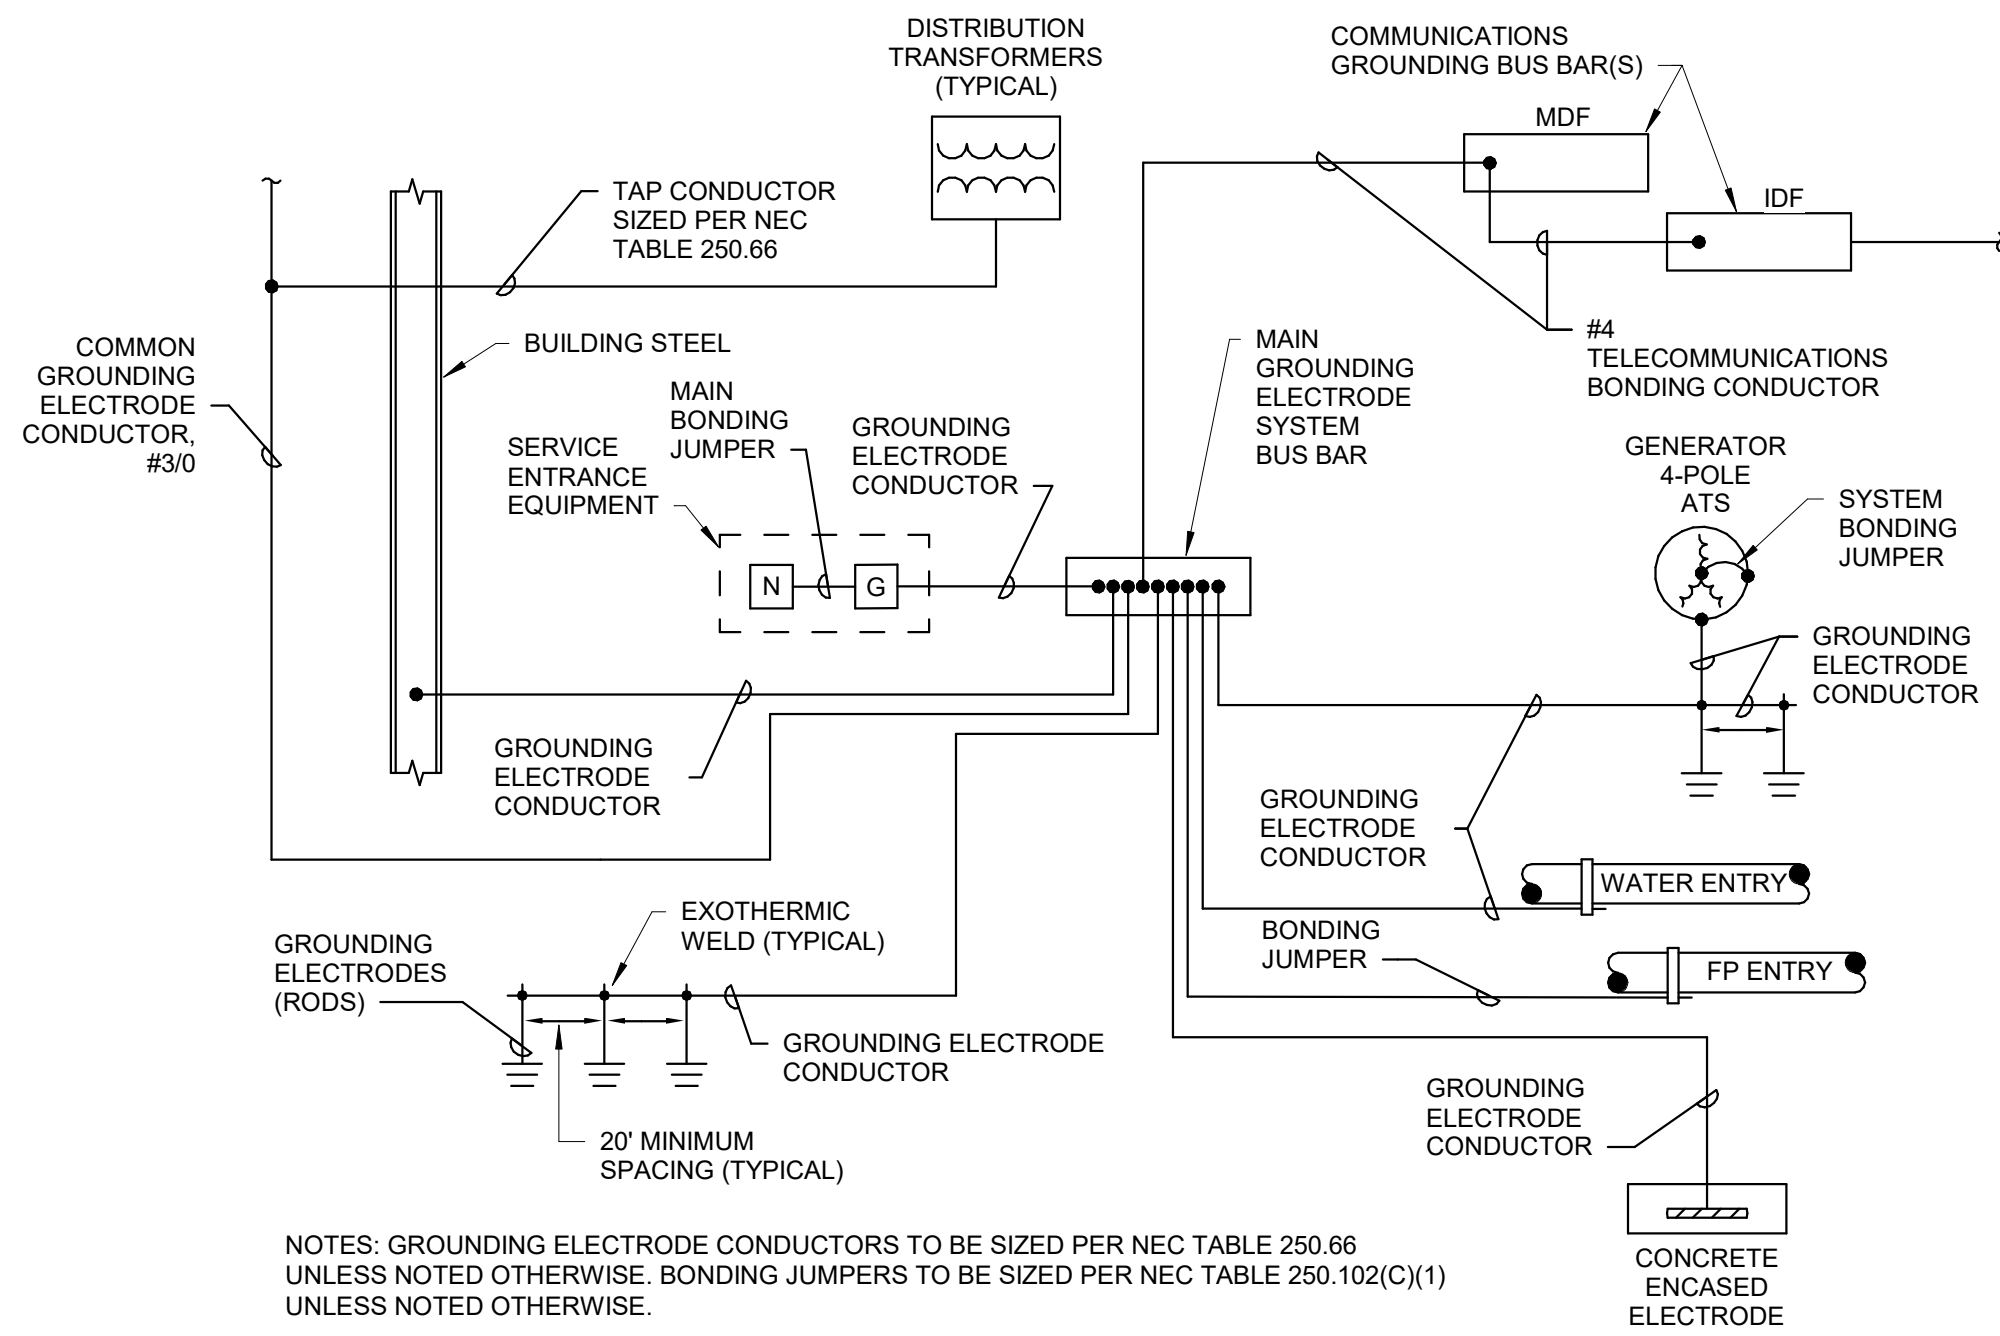


NOTES: GROUNDING ELECTRODE CONDUCTORS TO BE SIZED PER NEC TABLE 250.66 UNLESS NOTED OTHERWISE. BONDING JUMPERS TO BE SIZED PER NEC TABLE 250.102(C)(1) UNLESS NOTED OTHERWISE.

ELECTRICAL SYSTEM GROUNDING DETAIL

NOT TO SCALE

4 Electrical System Grounding Detail

SCALE: 12" = 1'-0"

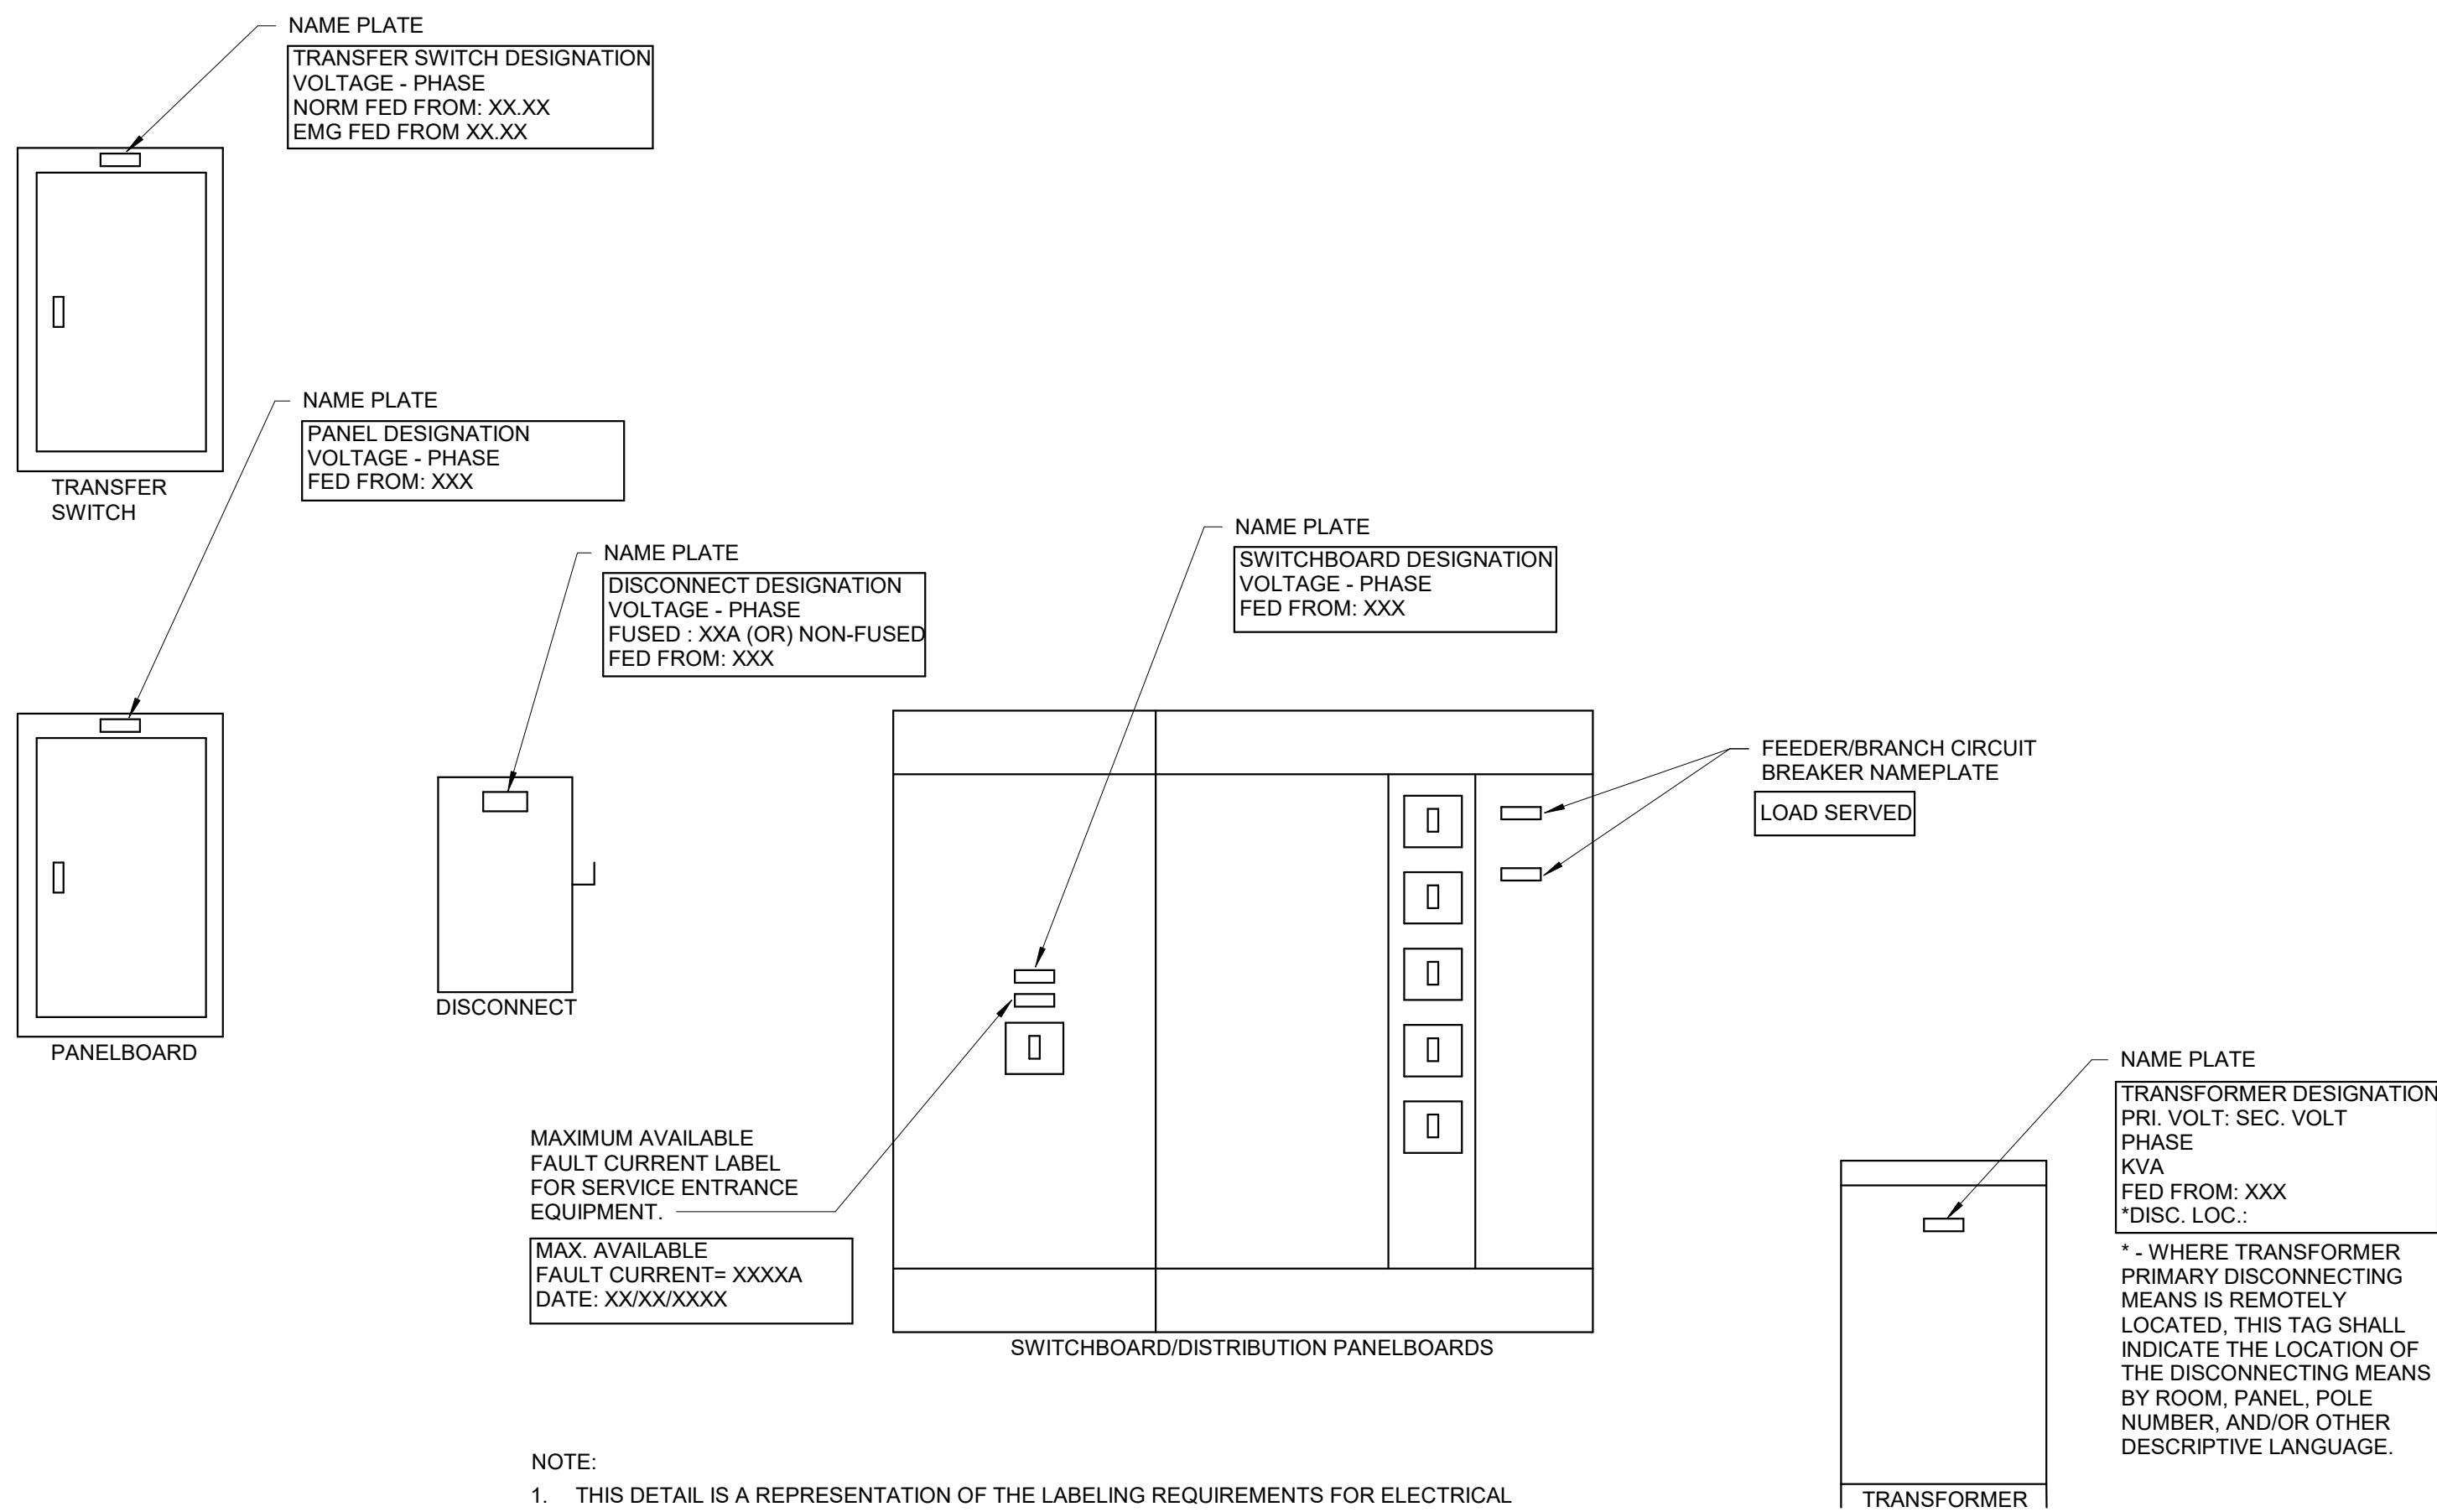

NOTE:


- THIS DETAIL IS A REPRESENTATION OF THE LABELING REQUIREMENTS FOR ELECTRICAL EQUIPMENT. ALL ELECTRICAL EQUIPMENT, WHETHER IT IS EXPLICIT SHOWN OR NOT, SHALL BE LABELED IN A SIMILAR MANNER.
- ALL LABELS SHALL BE ENGRAVED LAMINATED ACRYLIC. THE EQUIPMENT DESIGNATION SHALL HAVE A MINIMUM TEXT HEIGHT OF 3/8". THE REMAINING TEXT SHALL HAVE A MINIMUM HEIGHT OF 1/8".
- LABELS FOR EQUIPMENT CONNECTED TO THE NORMAL POWER SYSTEM SHALL BE BLACK WITH WHITE TEXT. LABELS FOR EQUIPMENT CONNECTED TO THE EMERGENCY POWER SYSTEM SHALL BE RED WITH WHITE TEXT.
- NAMEPLATES FOR EQUIPMENT LOCATED IN THE INTERIOR OF THE BUILDING SHALL BE ATTACHED WITH 3M SELF-ADHESIVES. EQUIPMENT INSTALLED AT EXTERIOR OF THE BUILDING SHALL BE ATTACHED WITH SCREWS AND THE LABEL SHALL HAVE PRE-PUNCHED OR PREDRILLED HOLES.

ELECTRICAL EQUIPMENT IDENTIFICATION

NOT TO SCALE

3 Electrical Equipment Identification Detail

SCALE: 12" = 1'-0"

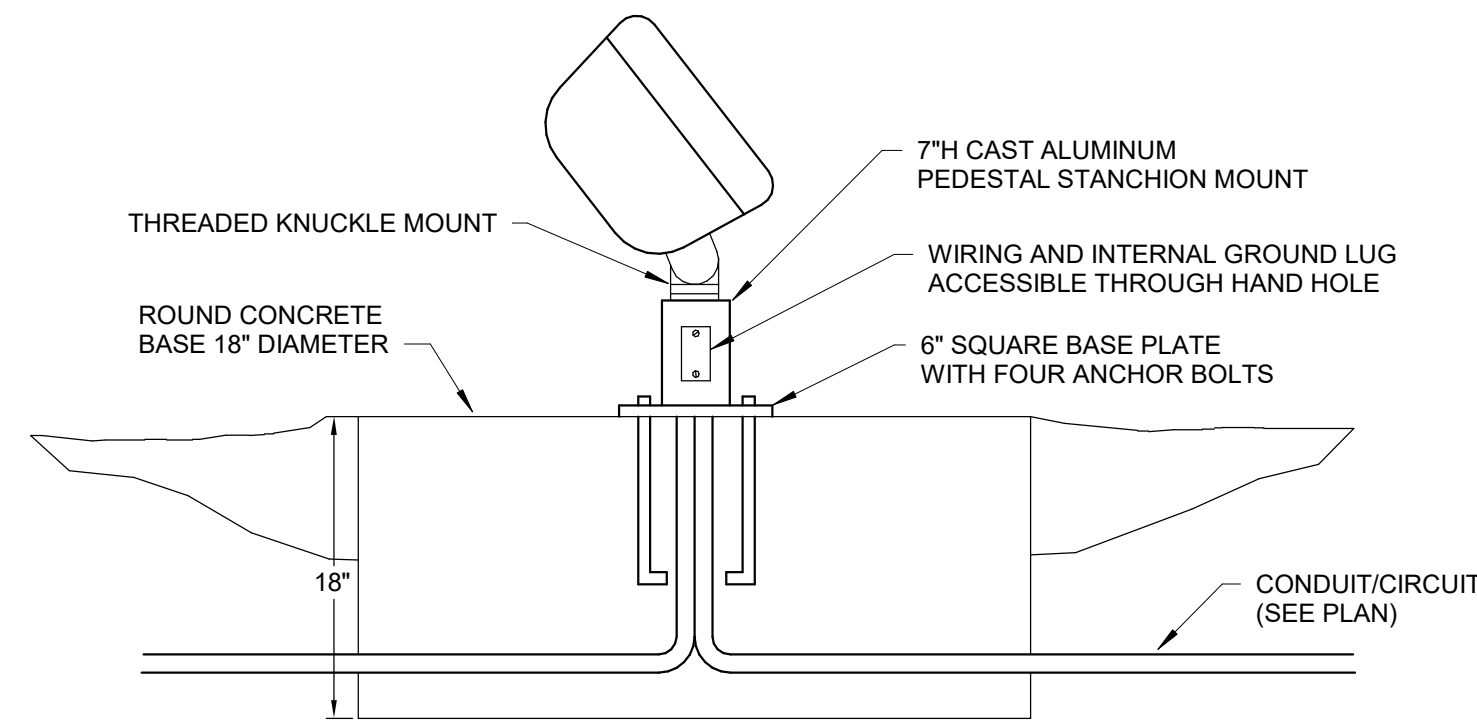


FLOODLIGHT MOUNTING DETAIL

NOT TO SCALE

5 Ground Mounted Floodlight Detail

SCALE: 12" = 1'-0"

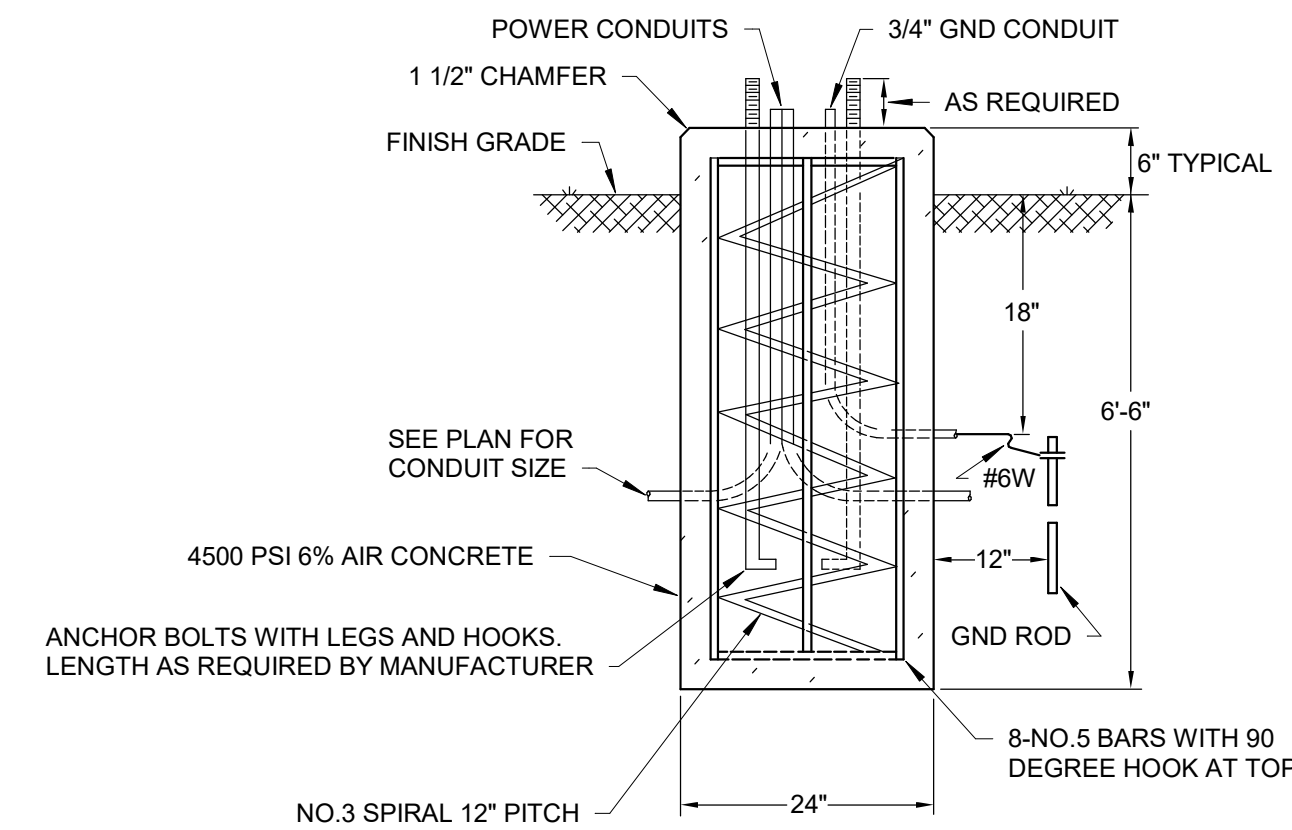


SHORT POLE BASE DETAIL

NOT TO SCALE


2 Light Pole Base Detail (Short)

SCALE: 12" = 1'-0"

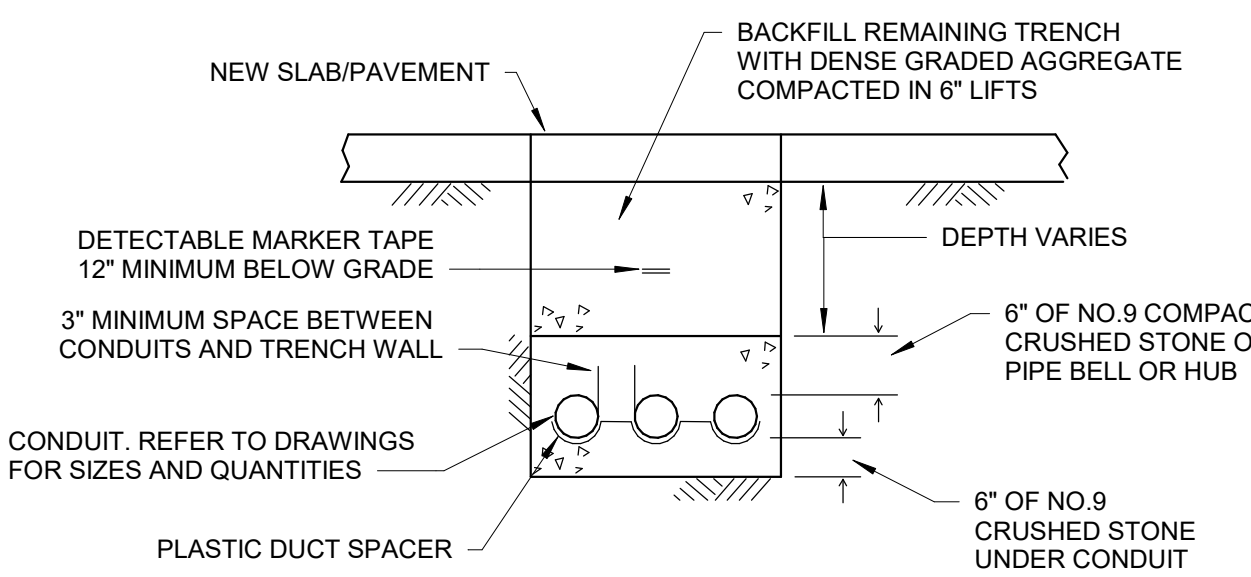

TRENCH DETAIL FOR NEW SLAB/PAVEMENT

NOT TO SCALE

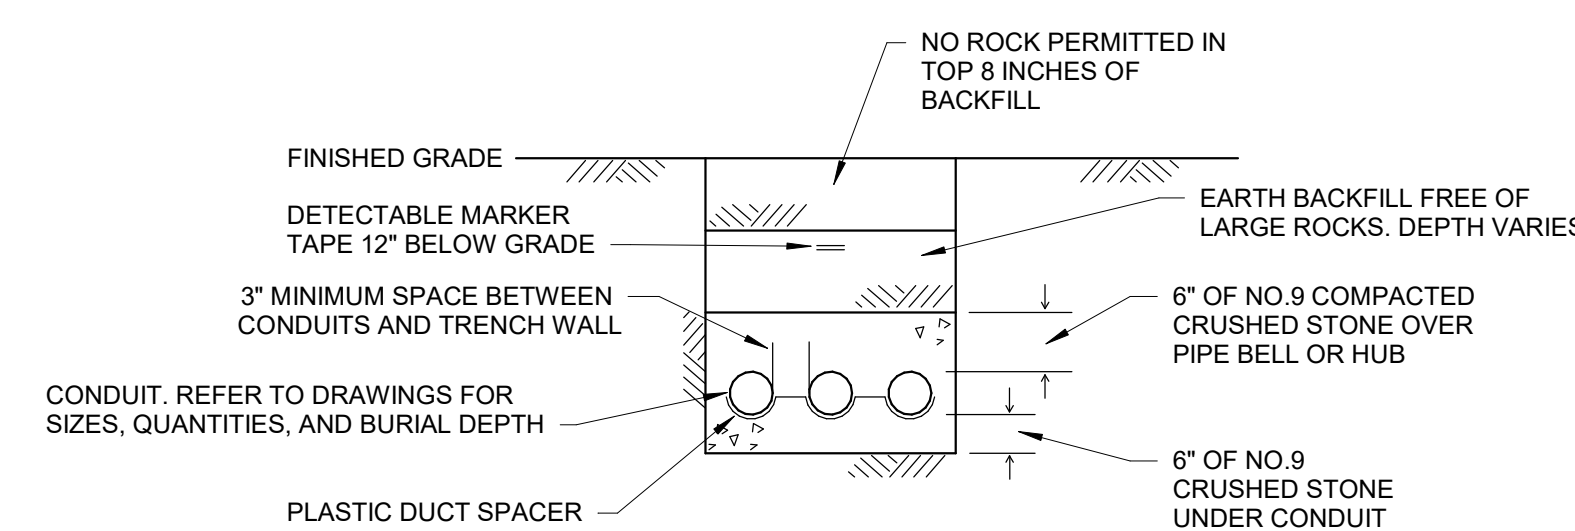

TRENCH DETAIL FOR EARTH COVER

NOT TO SCALE

1 Trench Detail

SCALE: 12" = 1'-0"

GENERAL NOTES

- A. REFER TO SHEET XXX FOR GENERAL NOTES.


SHEET KEYNOTES

1. SHEET NOTES


REVISIONS

No.	Description	Date

 1. SHEET NOTES




NOT TO SCALE

 

NOT TO SCALE

1. CONTROLLED RECEPTACLES SHALL BE PERMANENTLY MARKED FROM THE FACTORY.

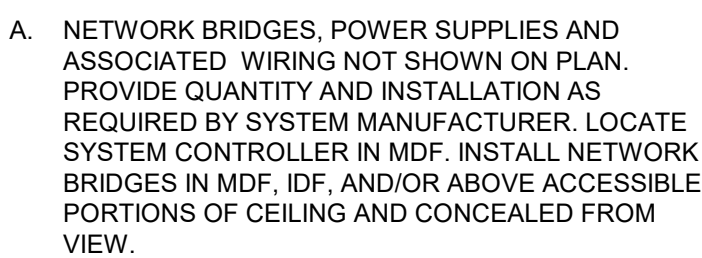

NOT TO SCALE

A. PROVIDE A COMPLETE NETWORKED LIGHTING CONTROL SYSTEM.

B. PROVIDE ALL MATERIAL AND LABOR NECESSARY TO PERFORM THE ZONE CONTROL FUNCTIONS DESCRIBED ABOVE.

C. BOX MARKED WITH 'X' INDICATES THAT ZONE FUNCTION IS REQUIRED.

D. PROVIDE DETAILED LIGHTING CONTROL PLANS, RISERS, ETC. WITH SHOP DRAWING SUBMITTAL.

E. BASIS-OF-DESIGN = nLIGHT; REFER TO SPECIFICATIONS FOR EQUIVALENTS.

F. COORDINATE ALL PROGRAMMED TIME OF DAY SCHEDULES WITH OWNER.

G. POWERPACKS/RELAYS ARE SHOWN ON FLOOR PLANS FOR CLARITY OF CIRCUIT CONNECTIONS; ALL RELAYS SHALL BE INSTALLED ABOVE ACCESSIBLE PORTIONS OF CEILING NEAR MAIN ROOM ENTRY DOOR AND CONCEALED FROM VIEW. FOR CIRCUITS IN HIGH CEILING AREAS, RELAYS SHALL BE LOCATED IN ADJACENT LOWER CEILING SPACES.

H. PROVIDE ALL MATERIAL AND LABOR NECESSARY TO PERFORM THE ZONE CONTROL FUNCTIONS DESCRIBED ABOVE. COORDINATE ALL PROGRAMMED TIME OF DAY SCHEDULES WITH OWNER.

I. COORDINATE ALL PROGRAMMED TIME OF DAY SCHEDULES WITH OWNER.

J. COORDINATE ALL PROGRAMMED TIME OF DAY SCHEDULES WITH OWNER.

K. PROVIDE MOUNTING BRACKETS AND ADDITIONAL SUPPORTS, HARDWARE, ETC. FOR CEILING MOUNTED SENSORS. DEVICES SHALL BE SUPPORTED FROM STRUCTURAL MEMBERS.

L. PROVIDE ADDITIONAL 25 FEET OF CONTROLS CABLING COILED UP ABOVE CEILING AT EACH OCCUPANCY AND DAYLIGHT SENSOR.

M. WALL STATION BUTTONS SHALL BE PROVIDED WITH CUSTOM ENGRAVED LABELS. EXAMPLE: "ON/OFF," "UP/ARROW," VERIFY ENGRAVING WITH OWNER/ENGINEER PRIOR TO RELEASE OF SHOP DRAWINGS.

N. WHERE MULTIPLE CONTROL ZONES ARE PRESENT IN SINGLE ROOM/AREA, PROVIDE ENGRAVING ON EACH WALL STATION INDICATING THE ZONE BEING CONTROLLED. EXAMPLE: "CHECKOUT DESK," "CLASSROOM AREA." VERIFY ENGRAVING WITH OWNER/ENGINEER PRIOR TO RELEASE OF SHOP DRAWINGS. POWER PACKS SHALL BE LABELED WITH CORRESPONDING LETTERING ON PERMANENT LAMACOD LABELS.

1. LIGHTS SHALL AUTOMATICALLY TURN ON AT 50% AND TURN OFF WHEN THE SPACE IS VACANT.
2. LIGHTS SHALL AUTOMATICALLY TURN ON AT 100%, DIM TO 30% WHEN UNOCCUPIED, AND TURN OFF AFTER 5 MINUTES OF ADDITIONAL VACANCY.
3. LIGHTS SHALL TURN ON AT DUSK AND TURN OFF AT CLOSE OF BUSINESS. IN THE MORNING, LIGHTS SHALL TURN ON AT TIME OF EXPECTED OCCUPANCY AND TURN OFF AT DAWN.

IS AVAILABLE ALL BE ADDITIONALLY CONTROLLED BY A DEVICE THAT AUTOMATICALLY TURNS OFF (OR DISABLES) ARTIFICIAL LIGHTING WHEN SUFFICIENT DAYLIGHT